
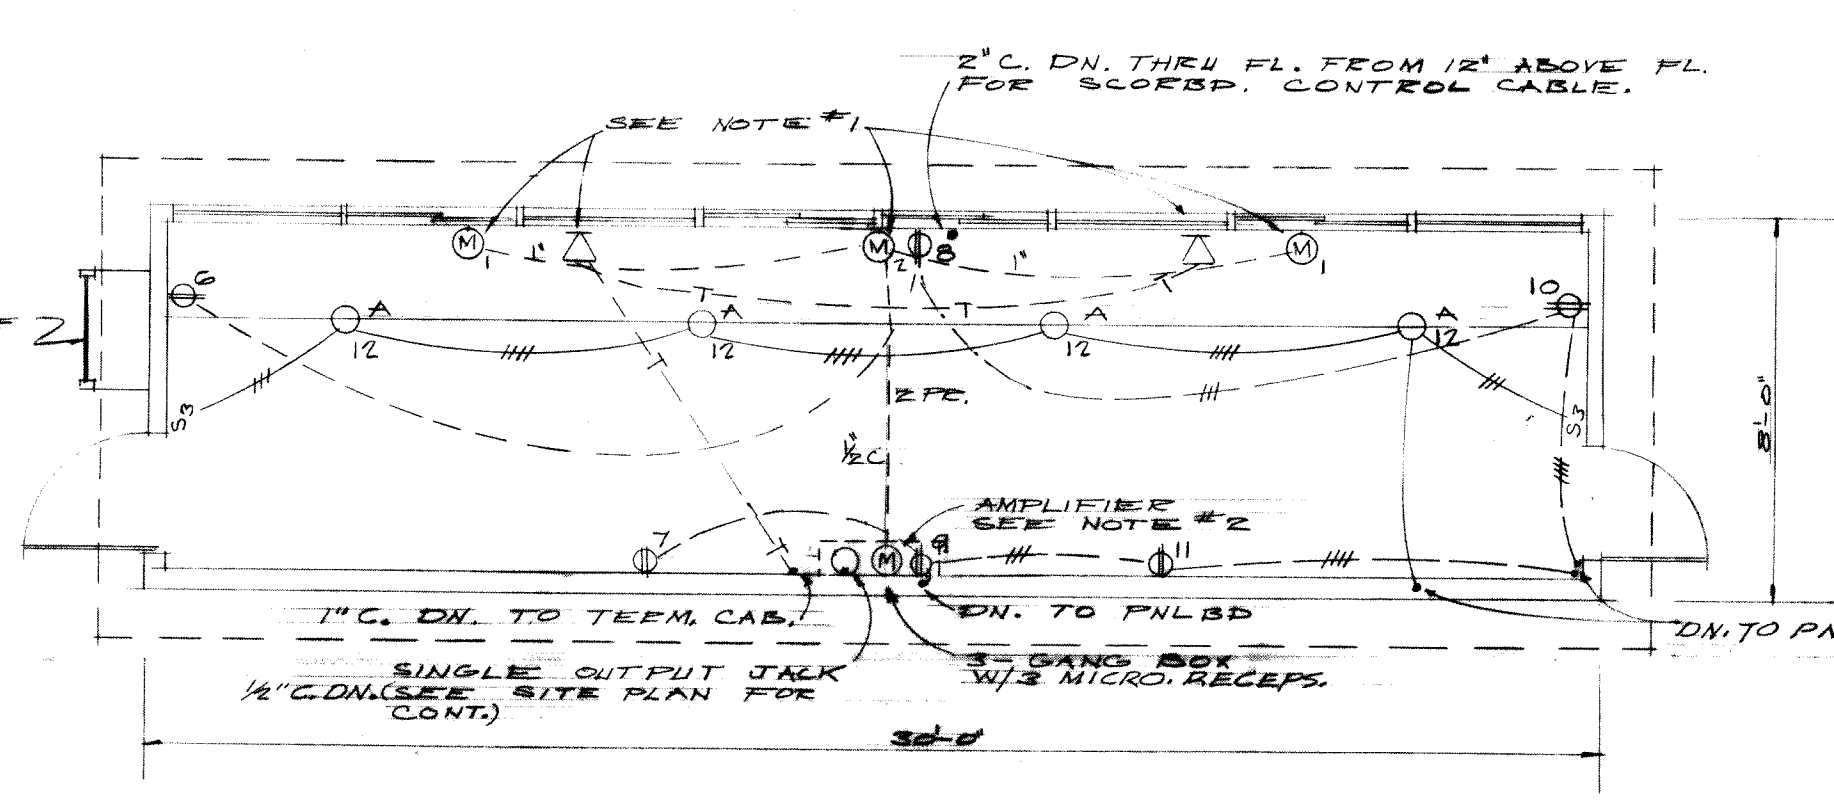


ELECTRICAL SYMBOLS

- INCANDESCENT LIGHT FIXTURE
- SOCKET INCANDESCENT LIGHT FIXTURE
- DUPLEX RECEPTACLE, 120V./15 AMP.
- SPECIAL PURPOSE OUTLET
- SINGLE POLE SWITCH
- CONDUIT IN OR ABOVE CEILING W/NO. WIRES INDICATED
- CONDUIT IN OR BELOW FLOOR
- TELEPHONE CONDUIT
- TELEPHONE OUTLET
- LIGHTING PANEL
- TELEPHONE CABINET
- 3 WAY SWITCH
- DISCONNECT SWITCH
- MICROPHONE OUTLET, WALL MTP.
- MICROPHONE OUTLET
- MOUNTING HEIGHT
- WEATHER PROOF
- JUNCTION BOX
- PULL BOX
- MICROPHONE CIRCUIT
- LOUDSPEAKER CIRCUIT

TYPE DESCRIPTION	CATALOG NO.	LAMPS	MOUNTING
A PRISMATIC PLASTIC SQUARE DOME SHAPE	HOLOPHANE NO C-868	2-75 W.A-19 1/2"	SURFACE
B W.P. INCLAND. BRACKET W/ PRISMATIC GLASS	ART METAL NO 3670	2-00 W. A-25	WALL, 10'-0" M.H.
C PLASTIC ENCLOSED FLOOR W/ ALUMINUM HSG. ON 16' ALUM. POLE	GENERAL ELECTRIC NO C810 0001 W/C.E. NO 35.11073-16 POLE	48" T-17/PG	ON CONCRETE BASE 12" SQX 3'-0" W/TOP 3' ABOVE GR.

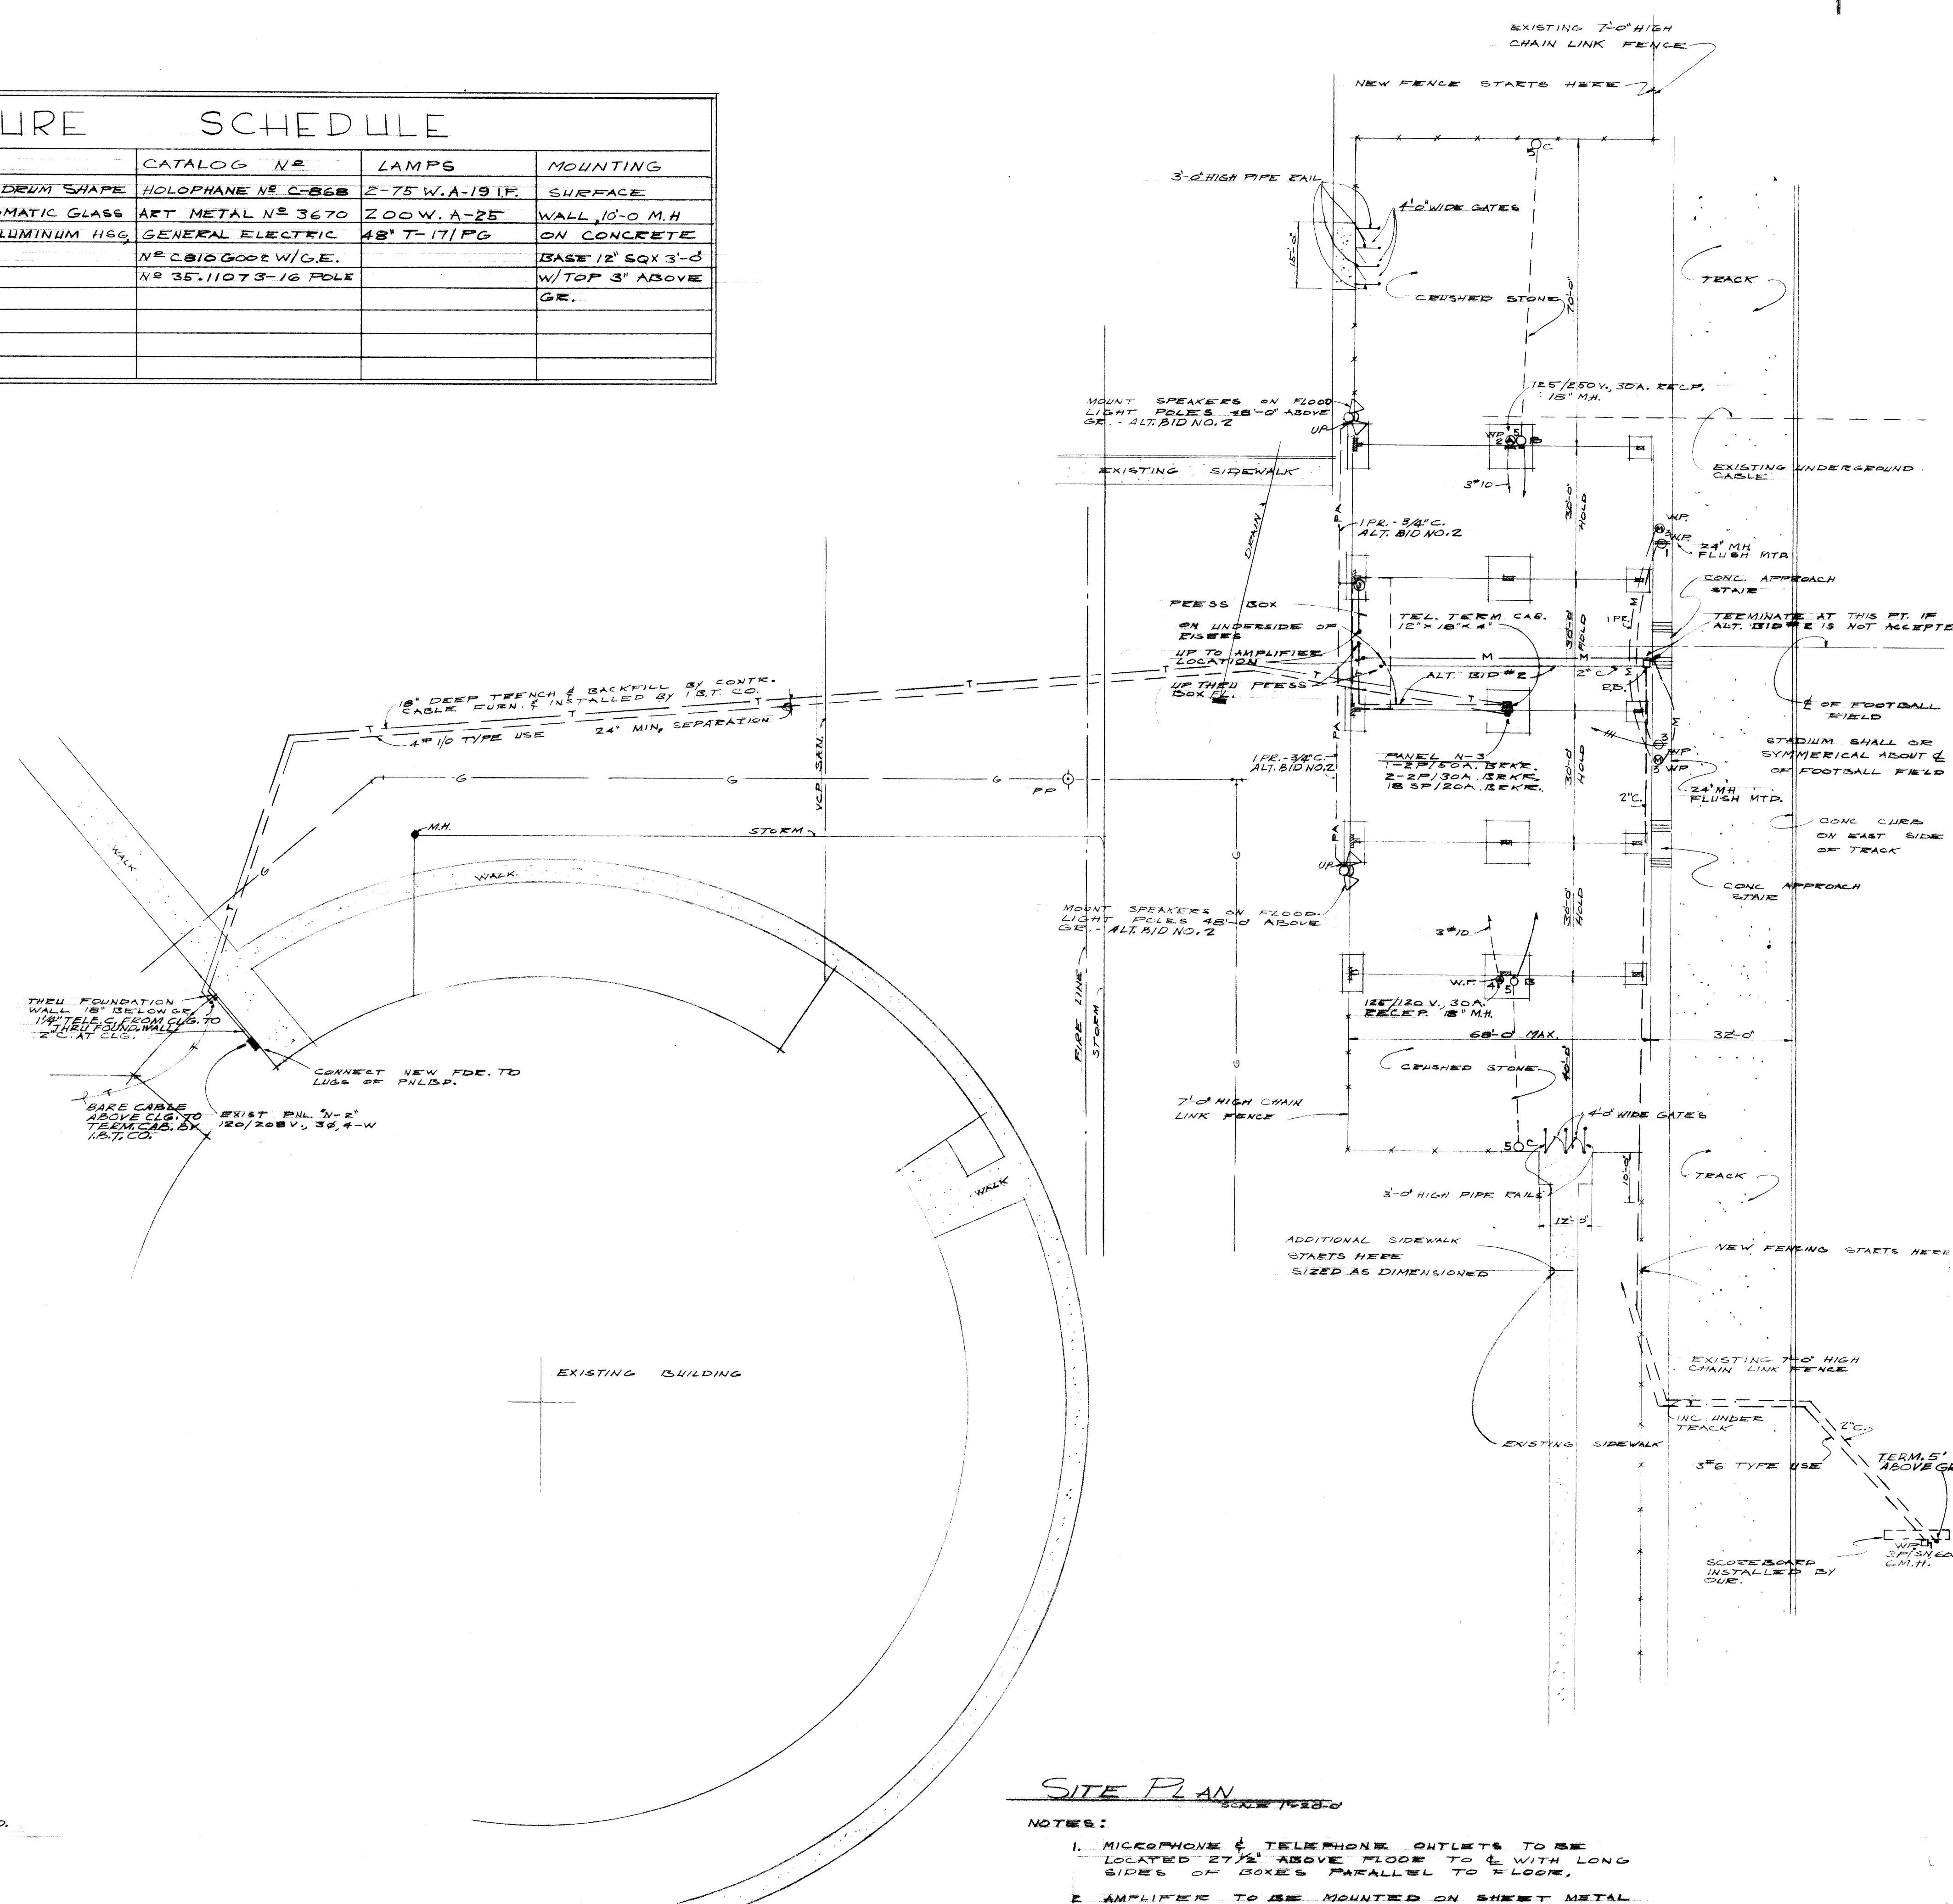

PRESS BOX FLOOR PLAN  
 SCALE 1/4" = 1'-0"

SITE PLAN  
 SCALE 1/8" = 1'-0"

- NOTES:
1. MICROPHONE & TELEPHONE OUTLETS TO BE LOCATED 27 1/2" ABOVE FLOOR TO & WITH LONG SIDES OF BOXES PARALLEL TO FLOOR.
  2. AMPLIFIER TO BE MOUNTED ON SHEET METAL RACK ATTACHED TO WALL 36" ABOVE FLOOR TO BOTTOM. INPUT OUTPUT AND 120V. RECEPTACLE OUTLETS FOR UNIT TO BE LOCATED 7'-0" ABOVE FLOOR TO &.