



LAWRENCE CENTRAL HIGH SCHOOL

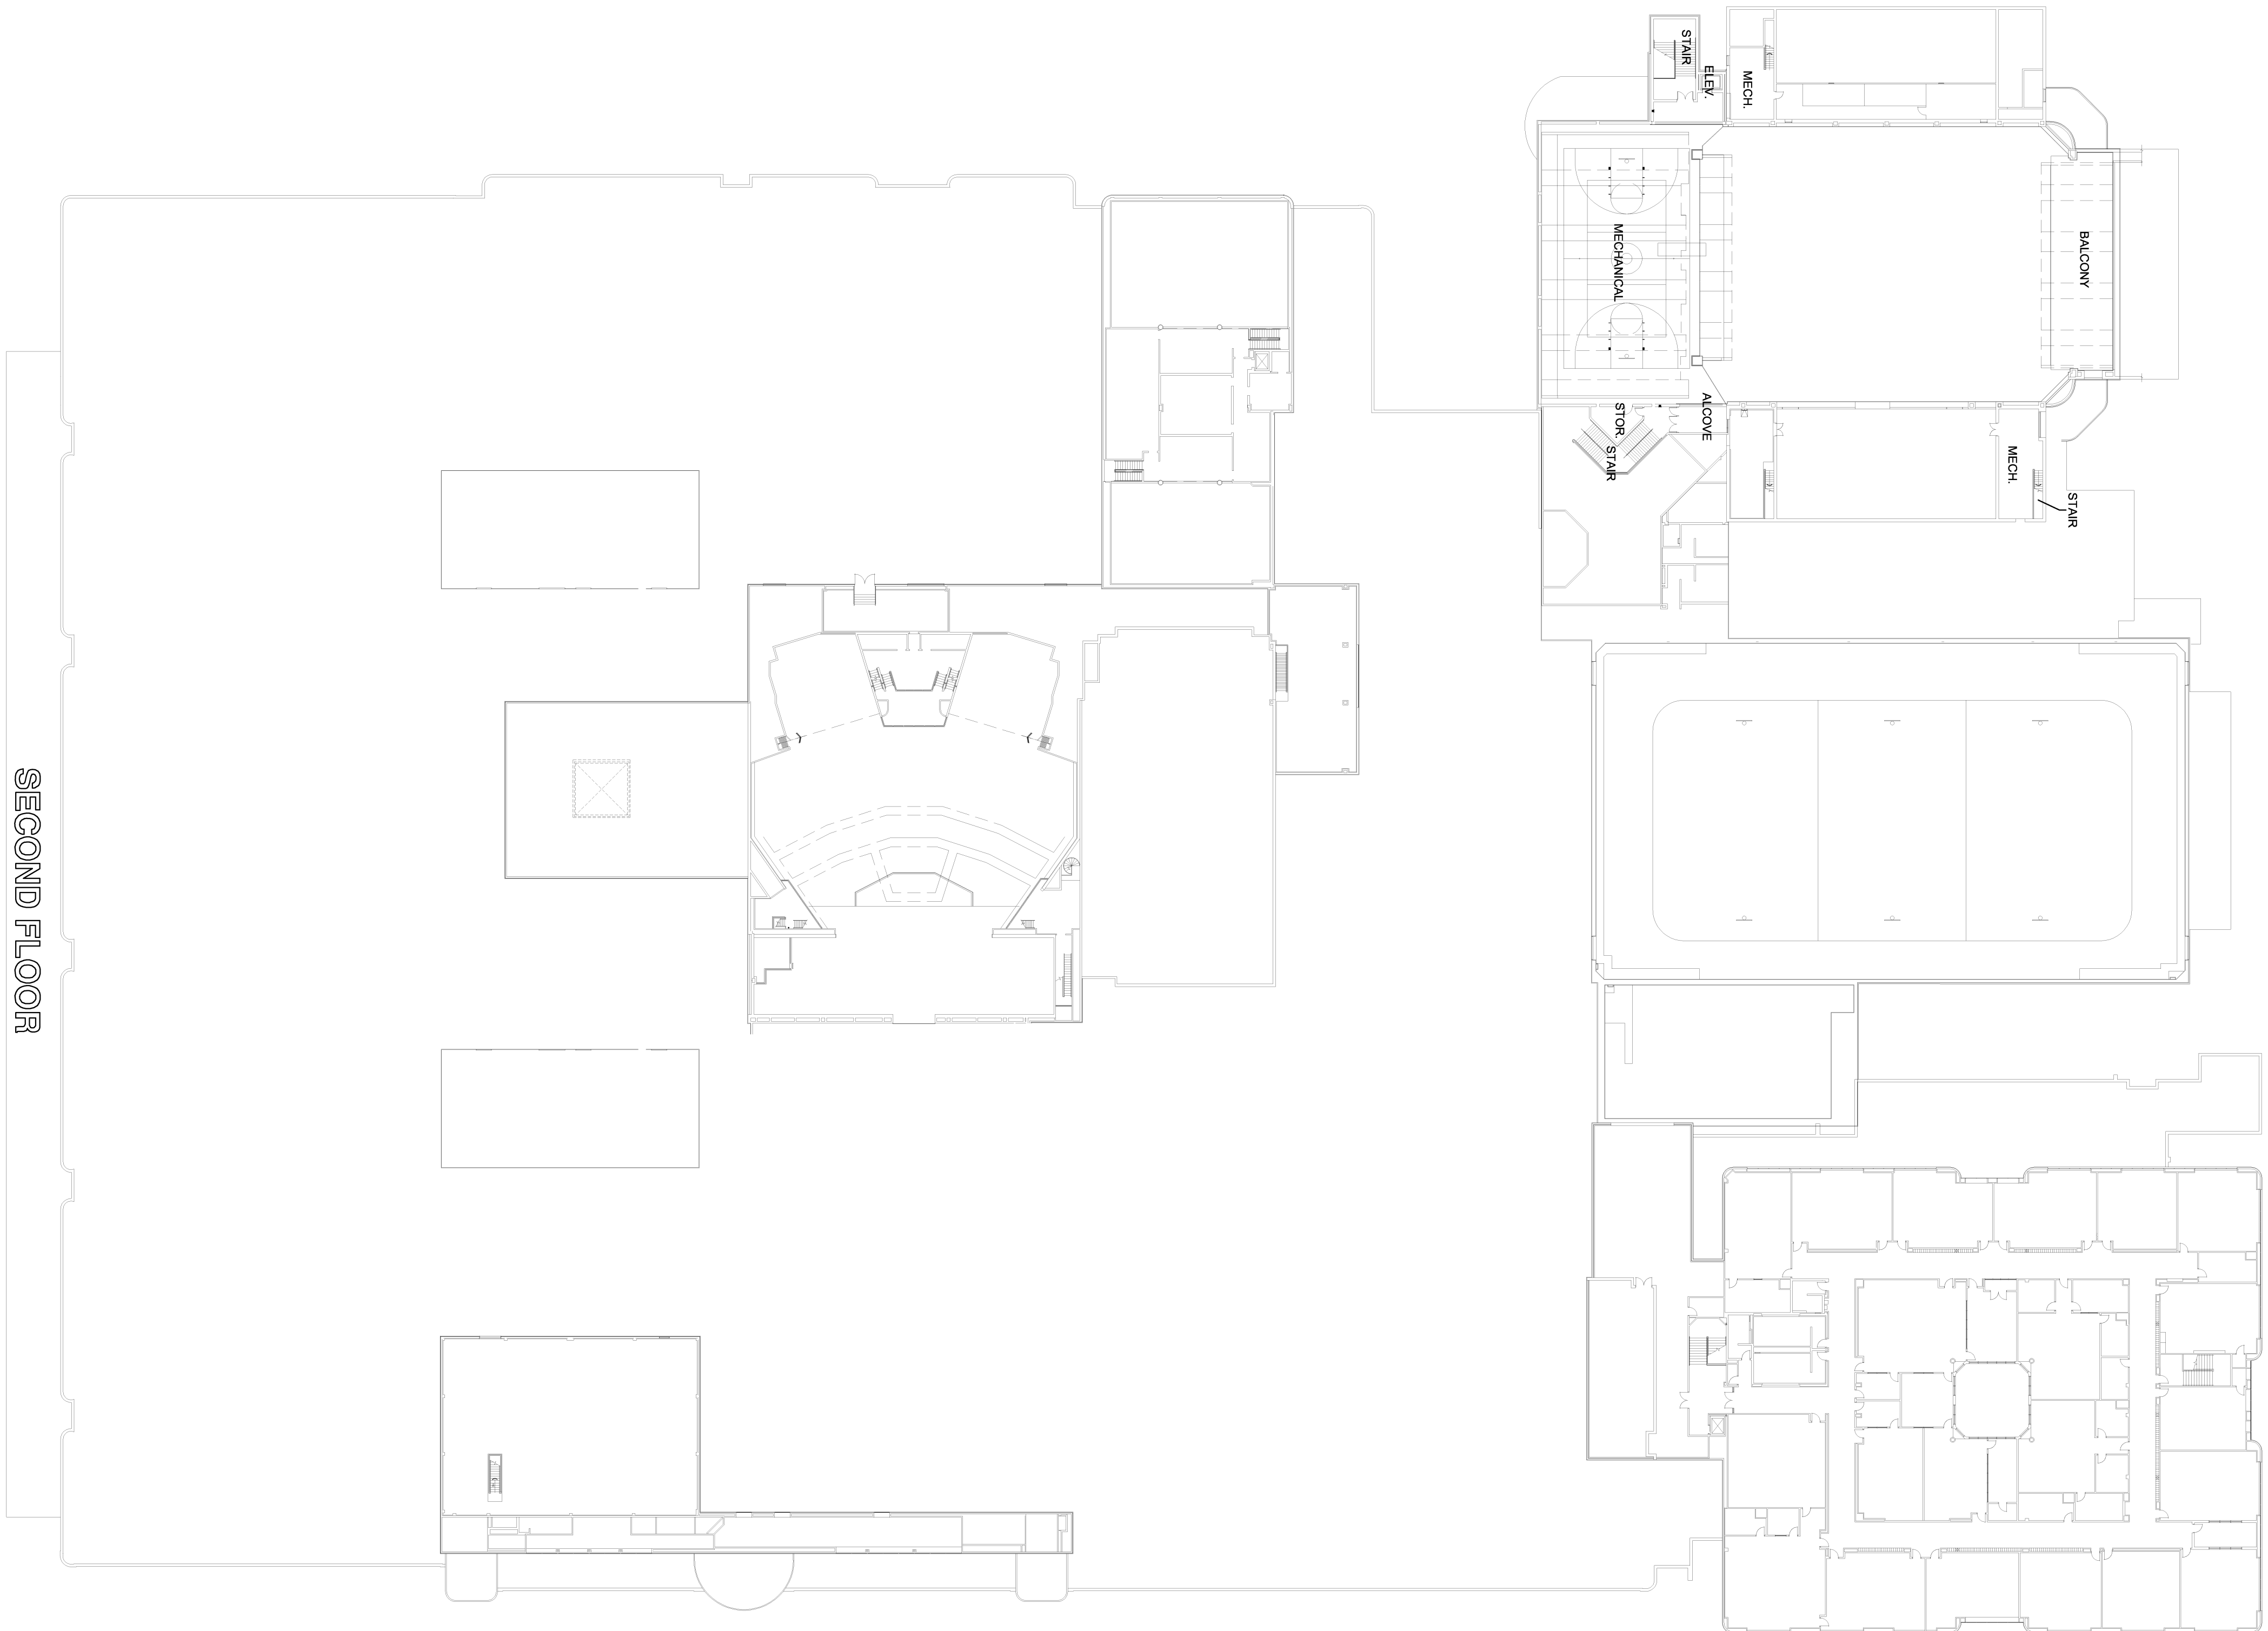

SECOND FLOOR

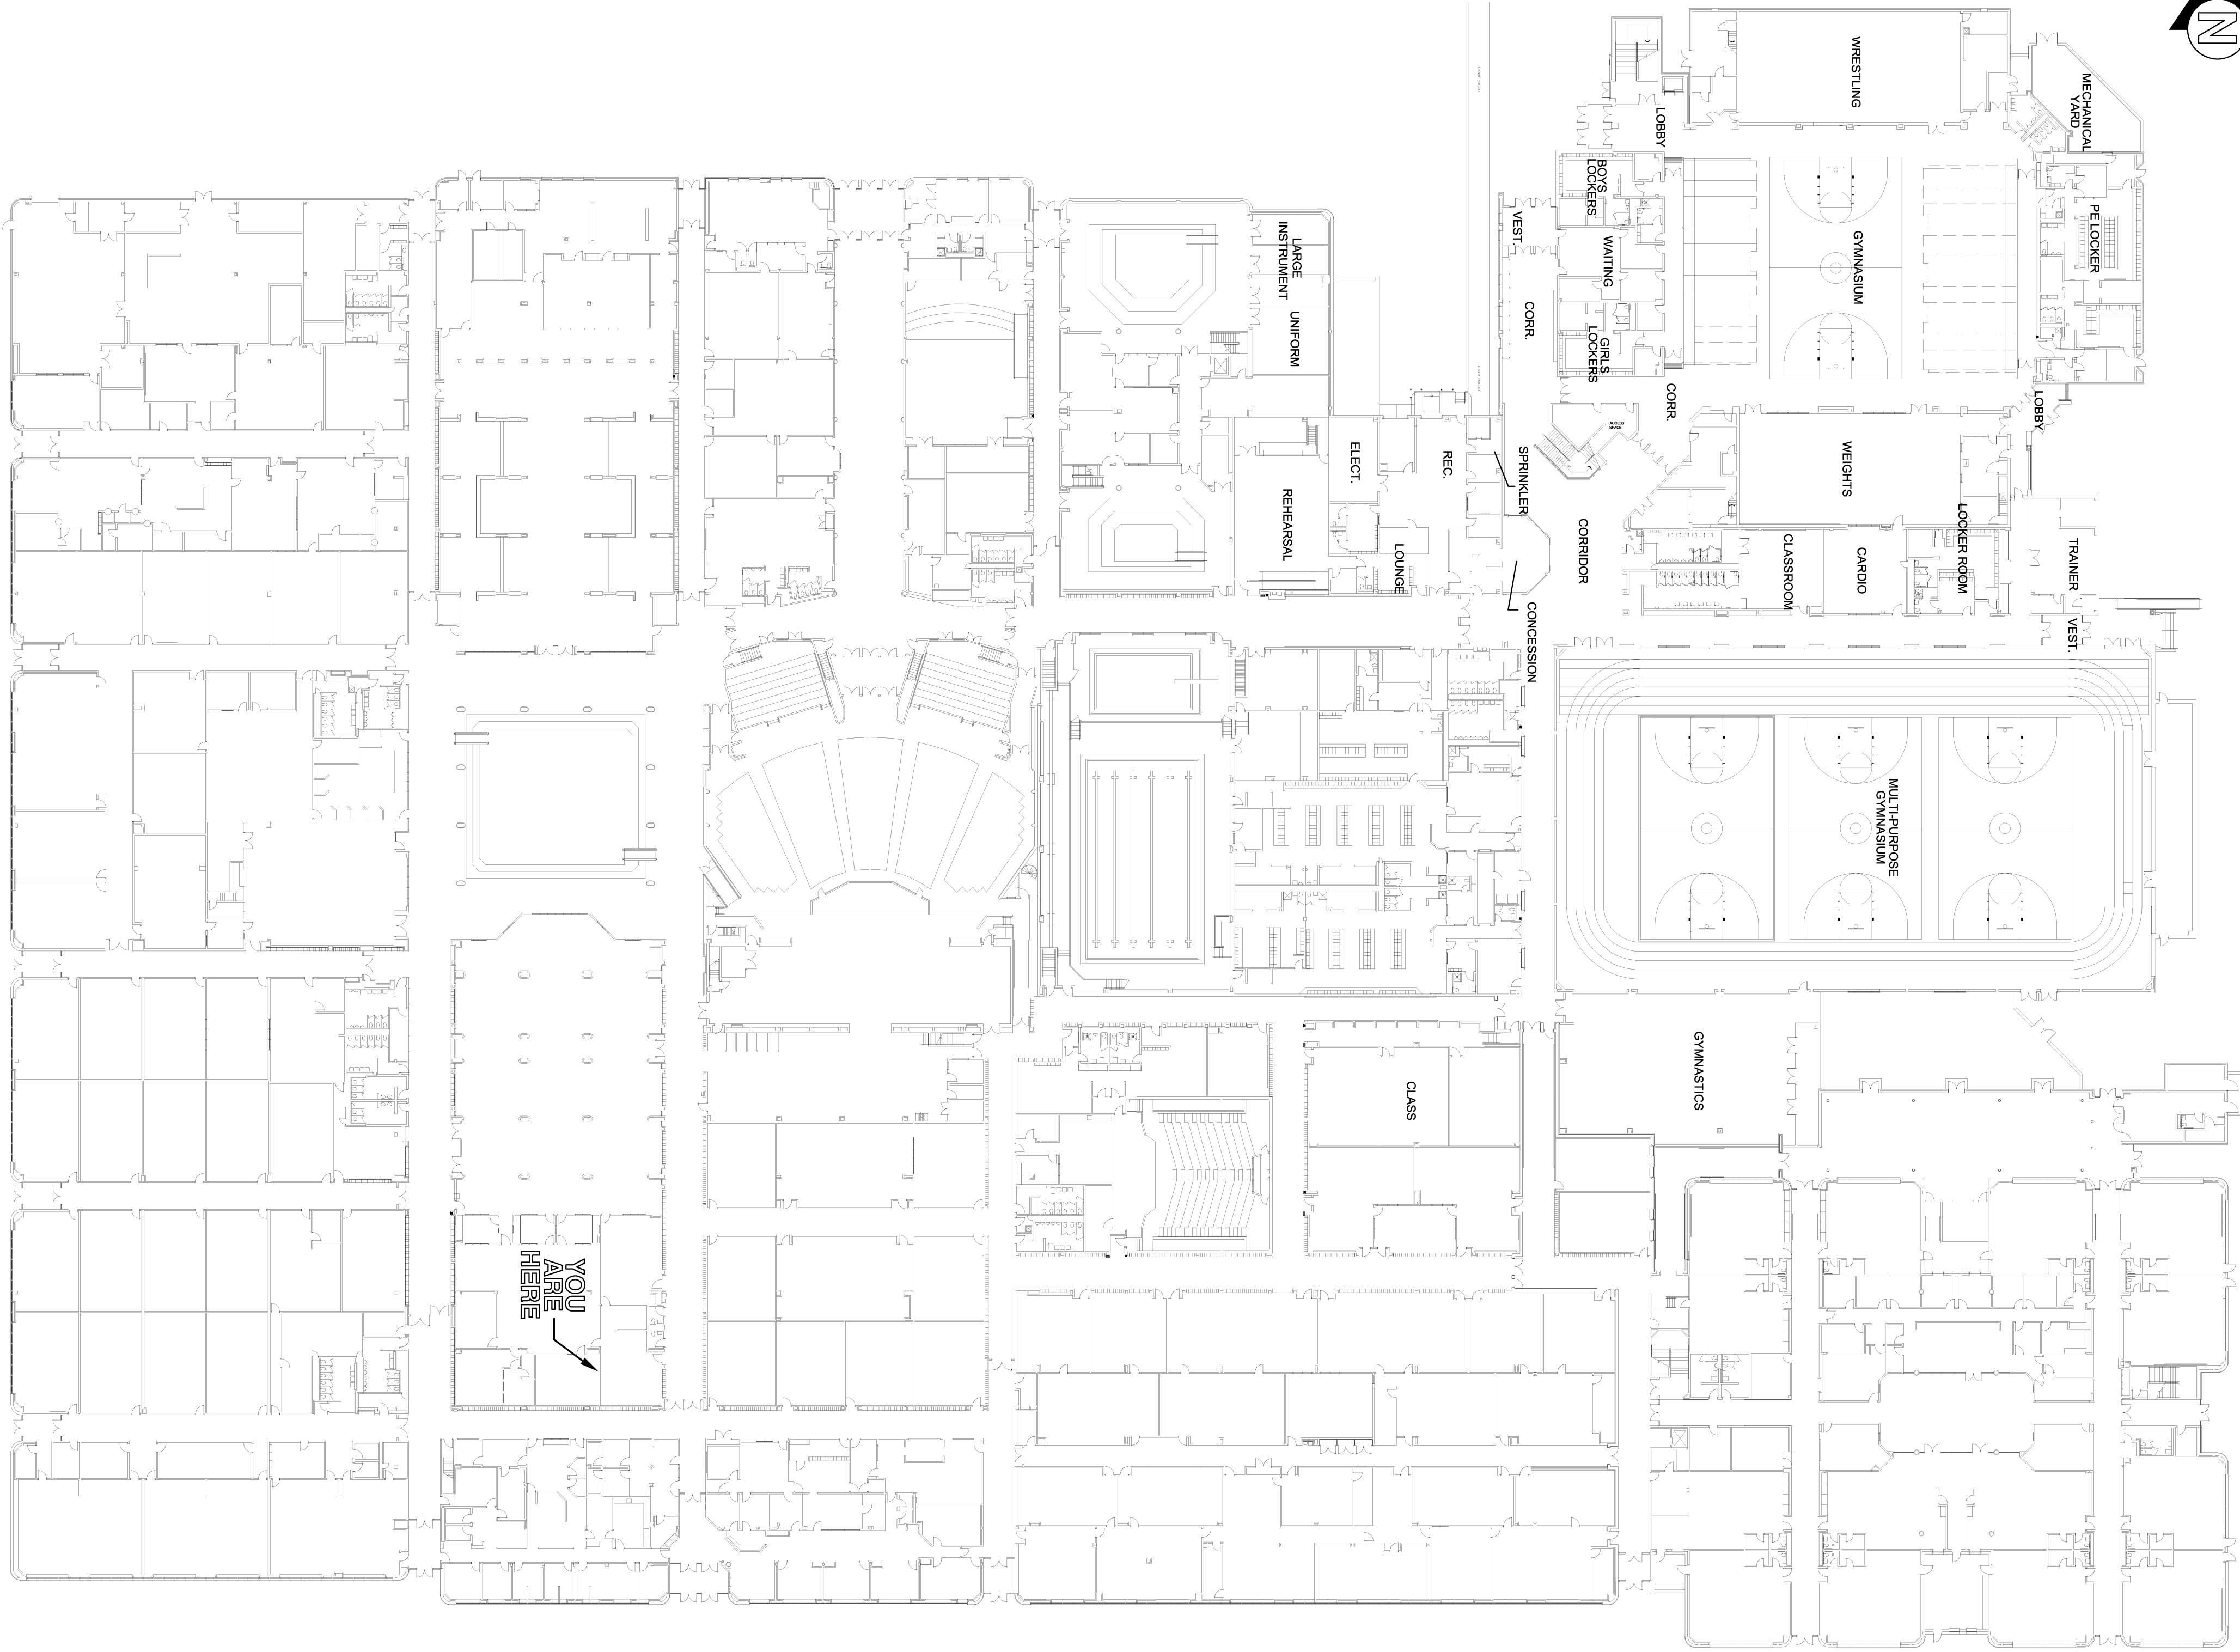

FIRST FLOOR

tyco / Fire & Security **SimplexGrinnell**

REVISION DESCRIPTION			
ENG	CAD	NO.	DATE

tyco / Fire & Security

SimplexGrinnell

11820 PENDLETON PIKE
INDIANAPOLIS, INDIANA 46236

SALES: 317-826-2130
SERVICE: 317-826-2130
FAX: 317-826-2140

©2006 SIMPLEXGRINNELL LP
ALL RIGHTS RESERVED

FIRE ALARM SYSTEM PLAN
GRAPHIC MAP
LAWRENCE CENTRAL HIGH SCHOOL
7300 EAST 56TH STREET
INDIANAPOLIS, IN

DRAWN BY: TC/UNE	DATE: 2/1/08
DESIGNED BY:	DATE:
APPROVED BY: CND	DATE: 5/5/08

PROJECT NUMBER:
928697603

SHEET TITLE:
LAWRENCE CENTRAL HS-11

SHEET NUMBER:
11