


LAWRENCE CENTRAL HIGH SCHOOL

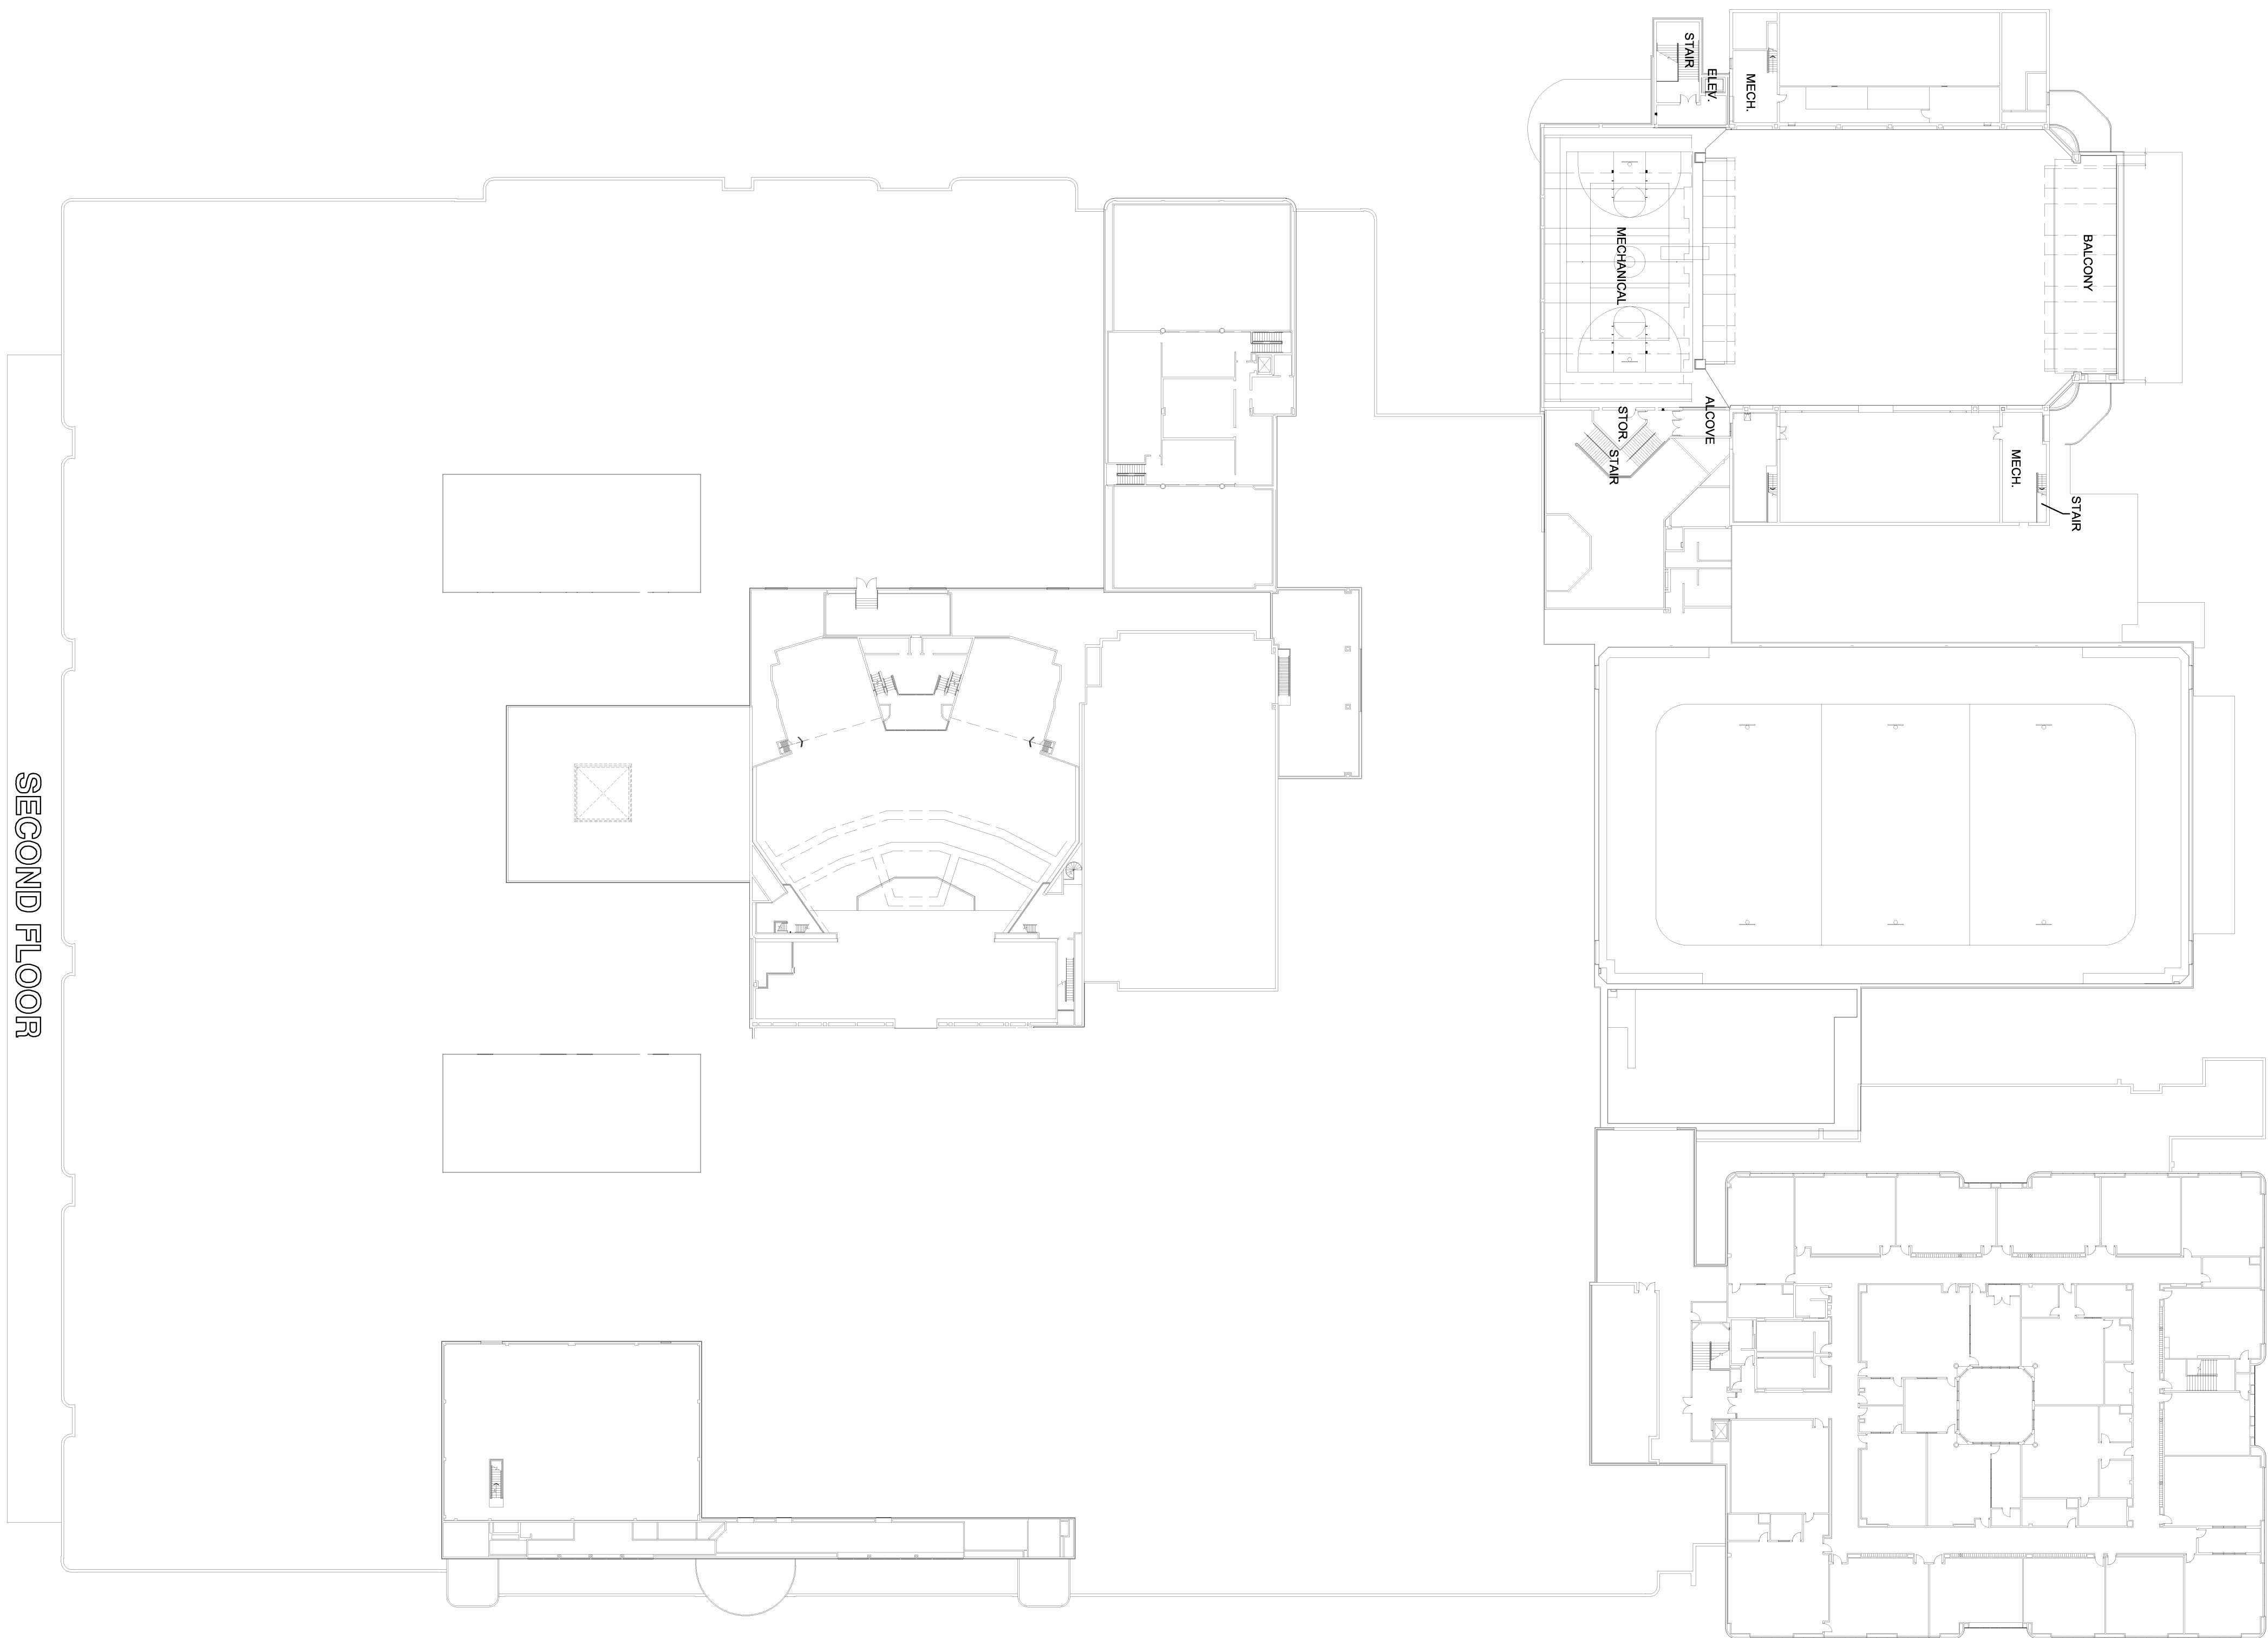

SECOND FLOOR

FIRST FLOOR

tyco | Fire & Security | **SimplexGrinnell**

REVISION DESCRIPTION			
ENG	CAD	NO.	DATE

tyco | Fire & Security | **SimplexGrinnell**

11820 PENDLETON PIKE
INDIANAPOLIS, INDIANA 46236
SALES: 317-826-2130
SERVICE: 317-826-2130
FAX: 317-826-2140

©2006 SIMPLEXGRINNELL LP
ALL RIGHTS RESERVED

FIRE ALARM SYSTEM PLAN
GRAPHIC MAP
LAWRENCE CENTRAL HIGH SCHOOL
7300 EAST 56TH STREET
INDIANAPOLIS, IN

DRAWN BY:	DATE:
TC/UNE	2/1/08
DESIGNED BY:	DATE:
CMO	5/5/08
APPROVED BY:	DATE:
CMO	5/5/08
PROJECT NUMBER:	
928697603	

SHEET TITLE:
LAWRENCE CENTRAL HS--9

SHEET NUMBER:
9