



Preliminary drawings


15' 1 1/2"
3' 9"
15' 1 1/2"
18' 1 1/2"
19' 7"

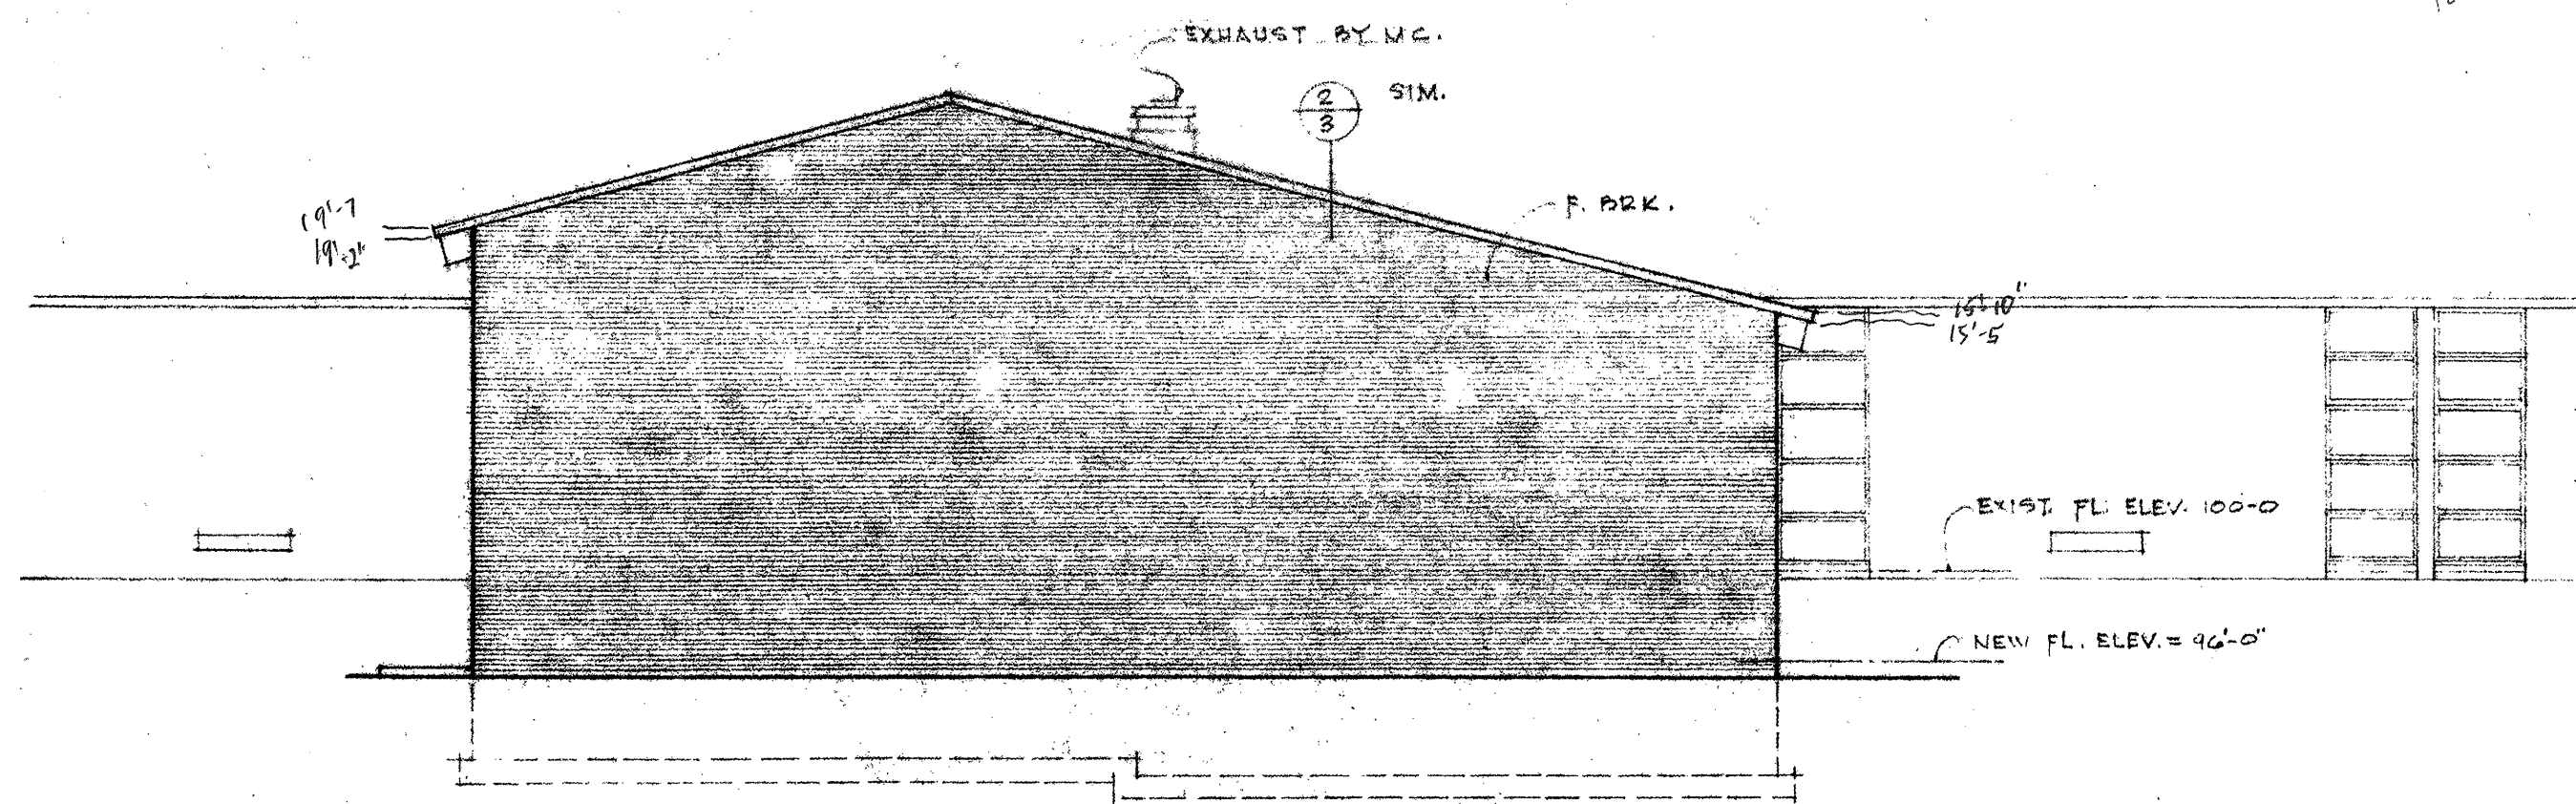


WEST ELEVATION
1/8" = 1'-0"

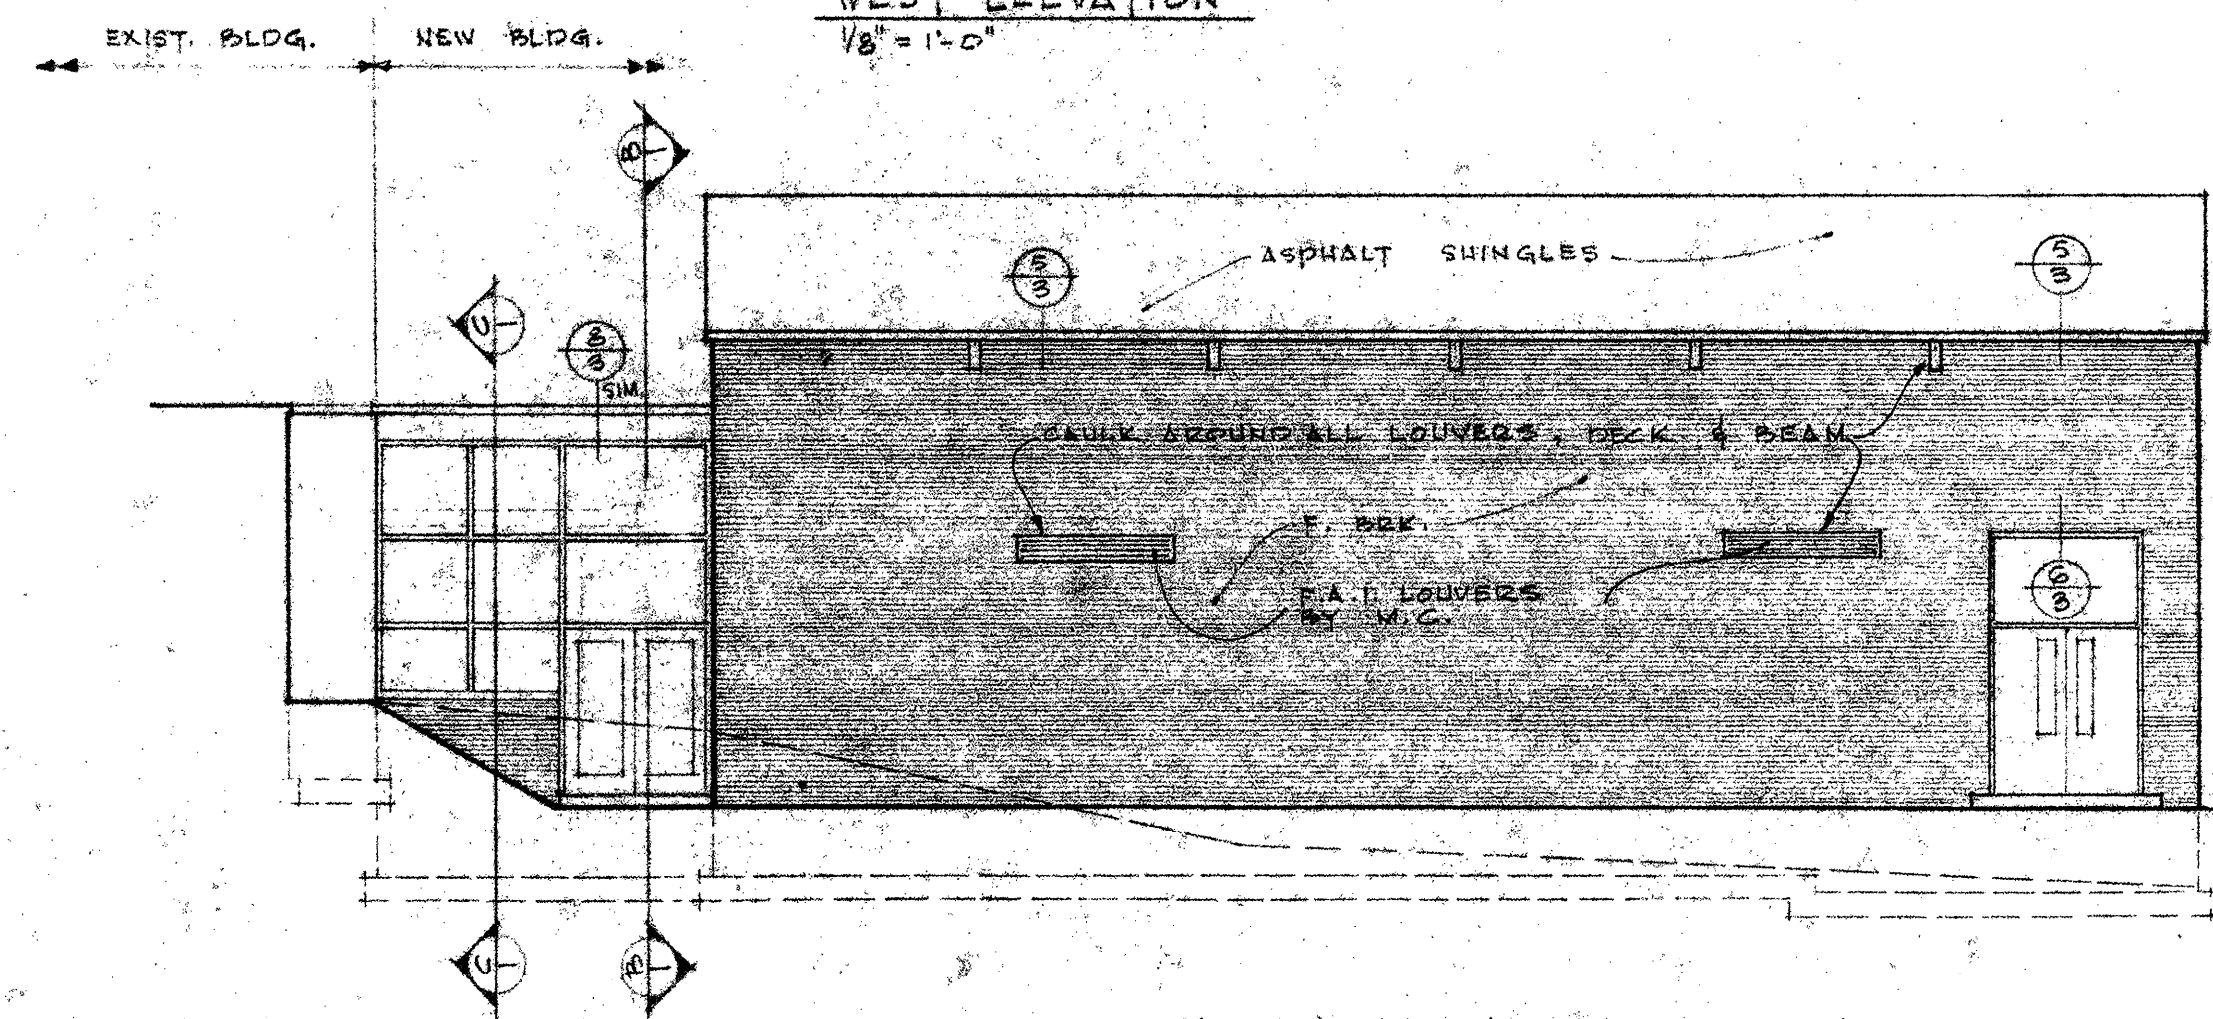


NORTH ELEVATION
1/8" = 1'-0"

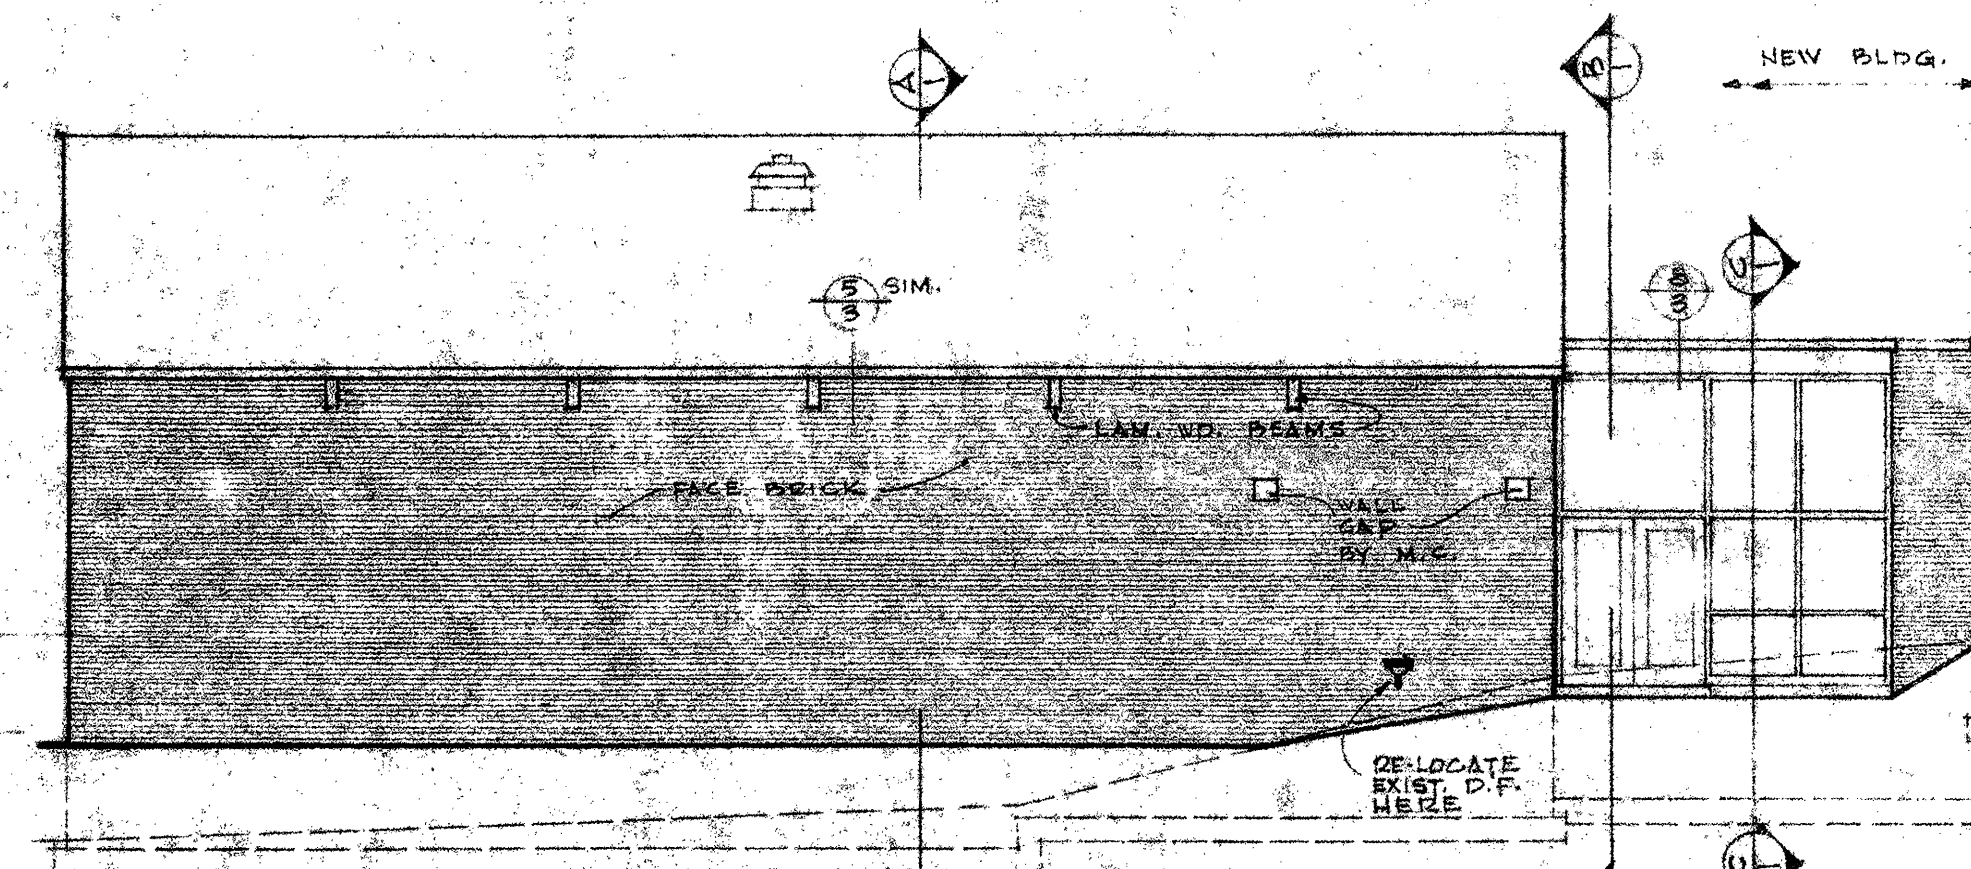


SOUTH ELEVATION
1/8" = 1'-0"

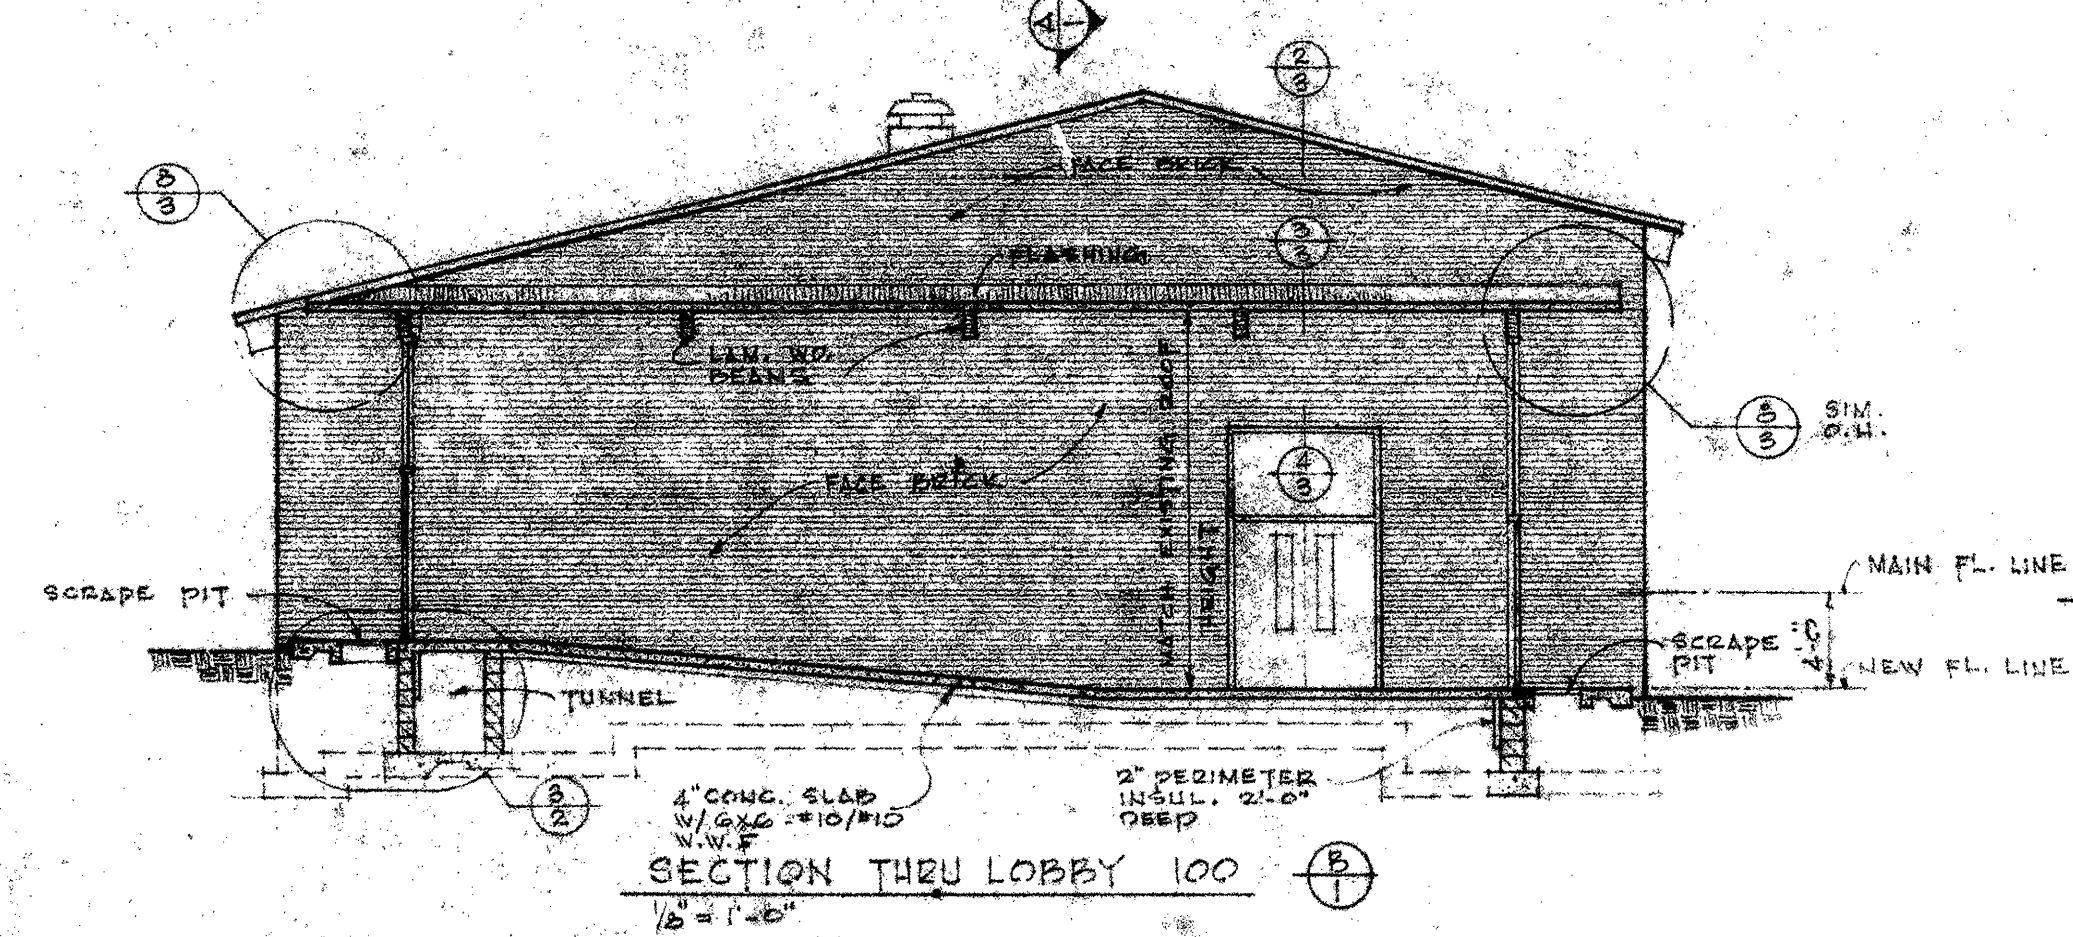


SECTION THRU LOBBY 100
1/8" = 1'-0"

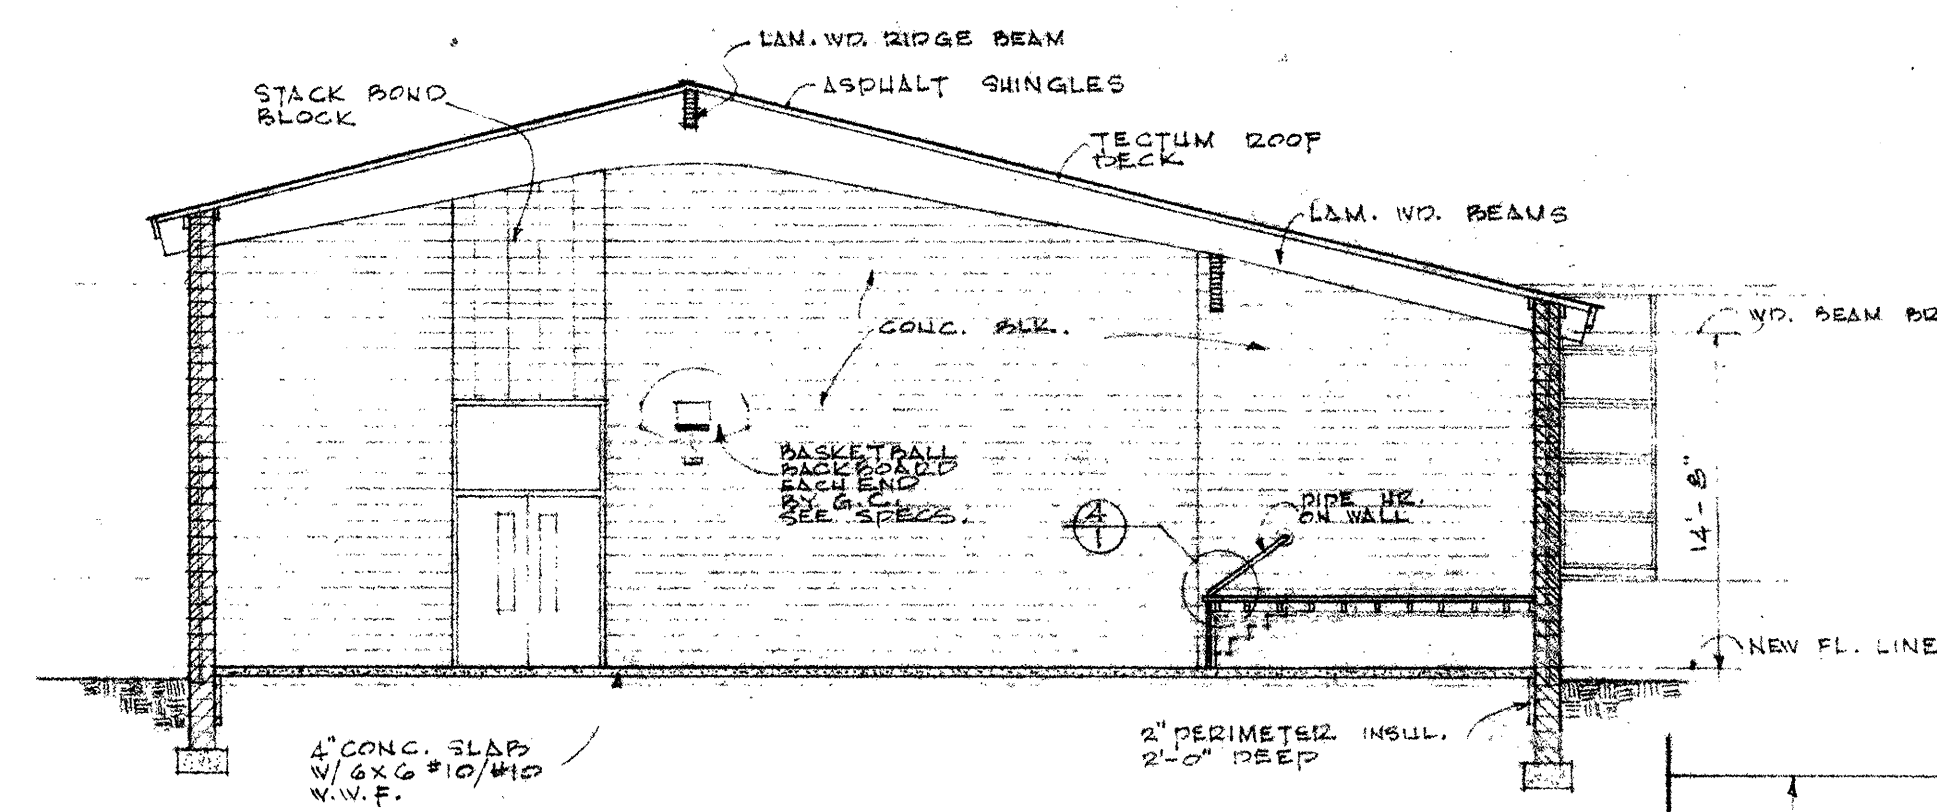


SECTION THRU ALL PURPOSE ROOM
1/8" = 1'-0"

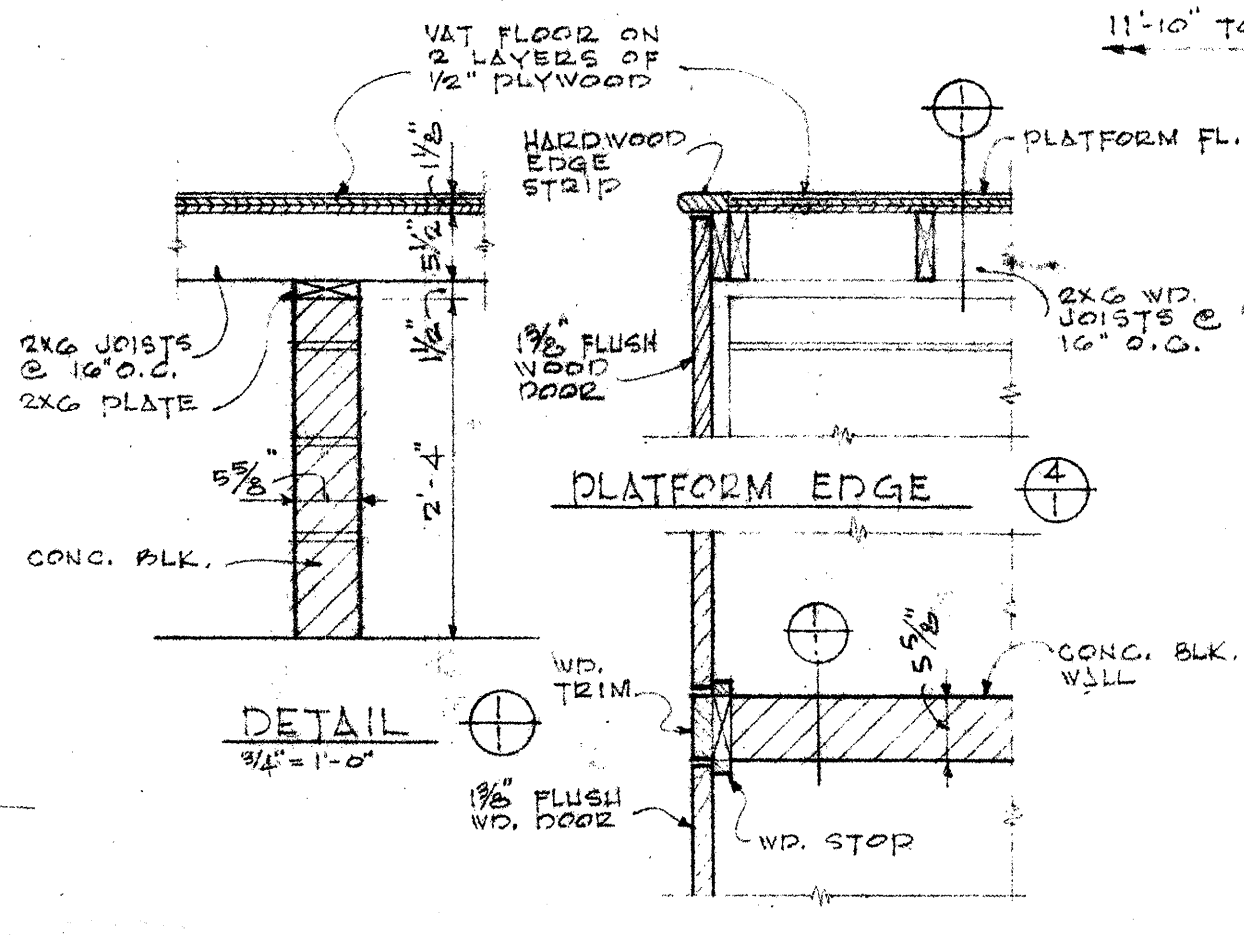


DETAIL
3/4" = 1'-0"

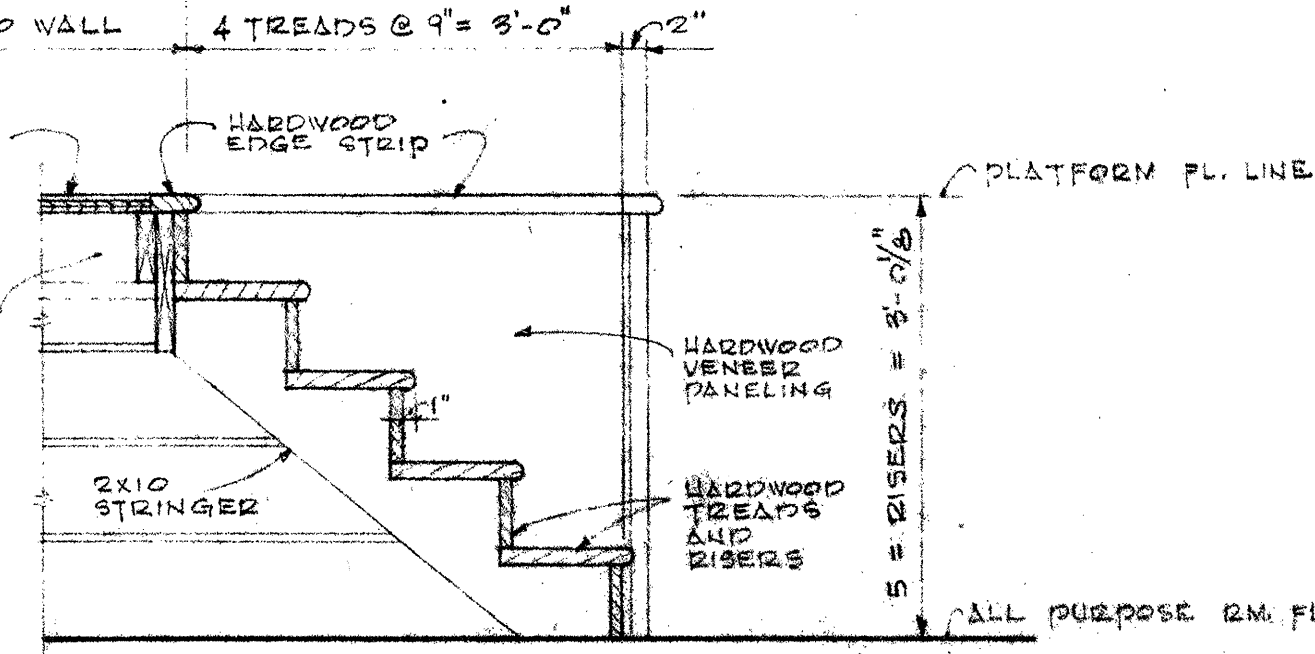


SECTION THRU STAIR & PLATFORM #103
3/4" = 1'-0"

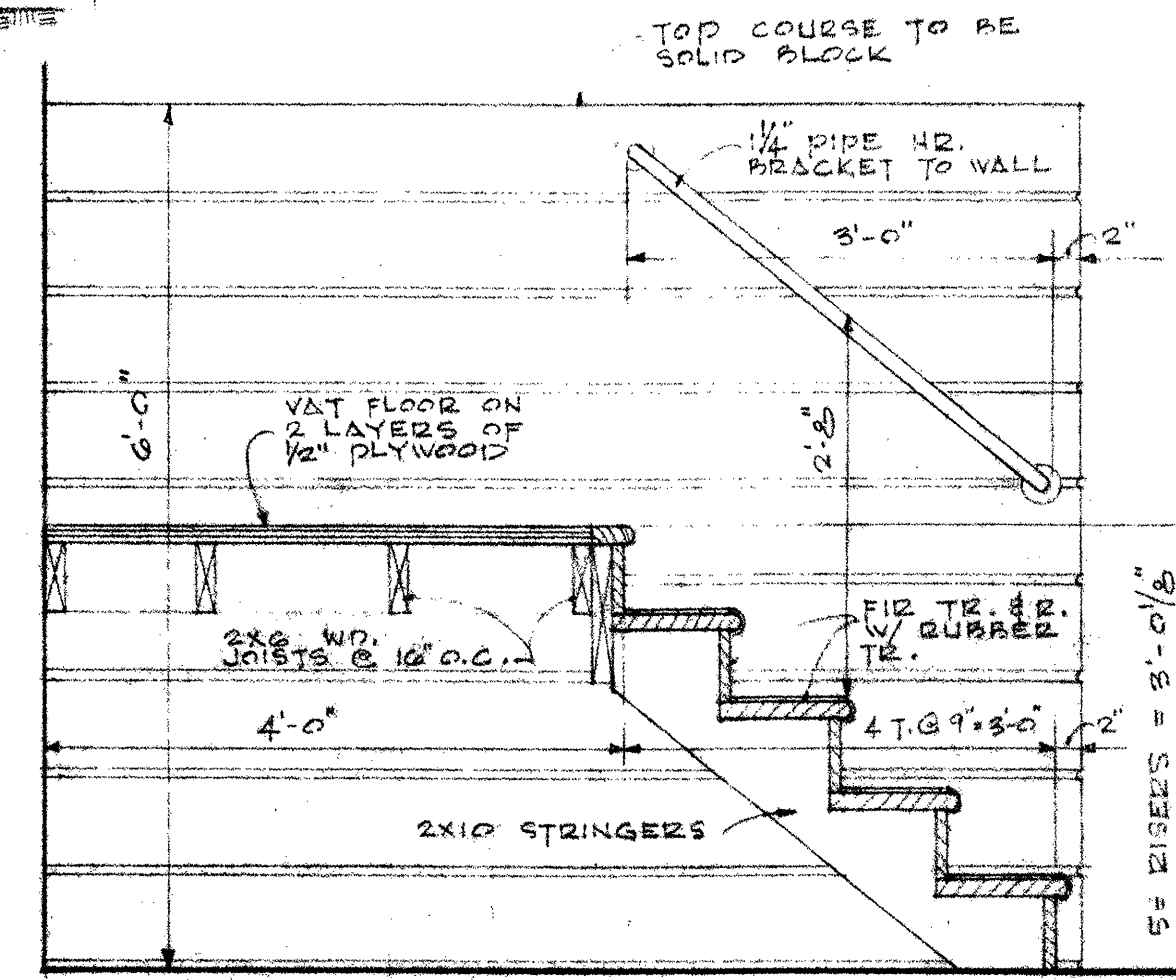


SECTION THRU STAIR & STORAGE #102
3/4" = 1'-0"

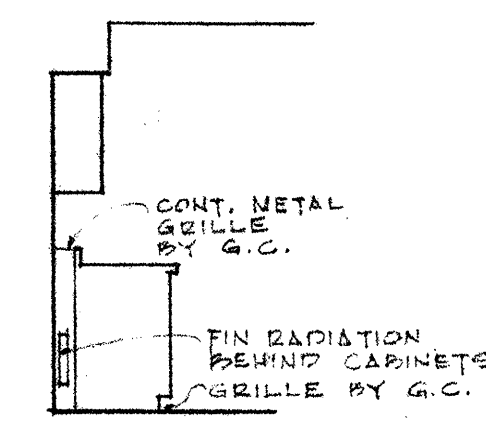


SECTION
3/4" = 1'-0"

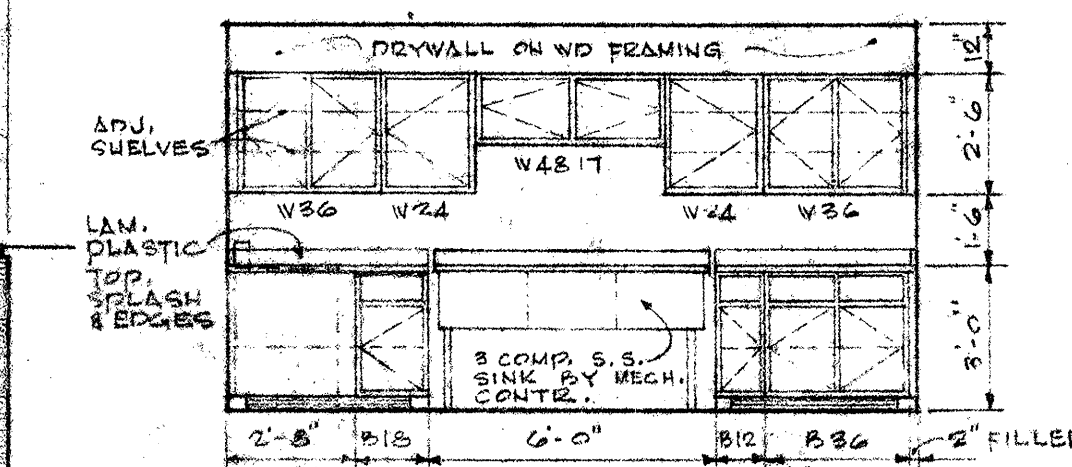


KITCHEN ELEV.
1/4" = 1'-0"

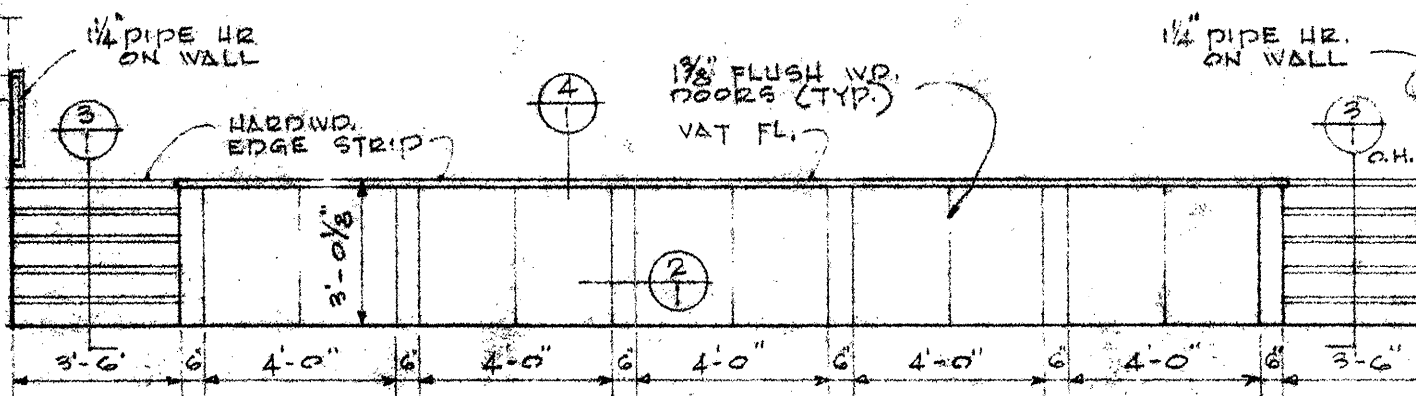


ELEVATION OF PLATFORM 102
1/4" = 1'-0"

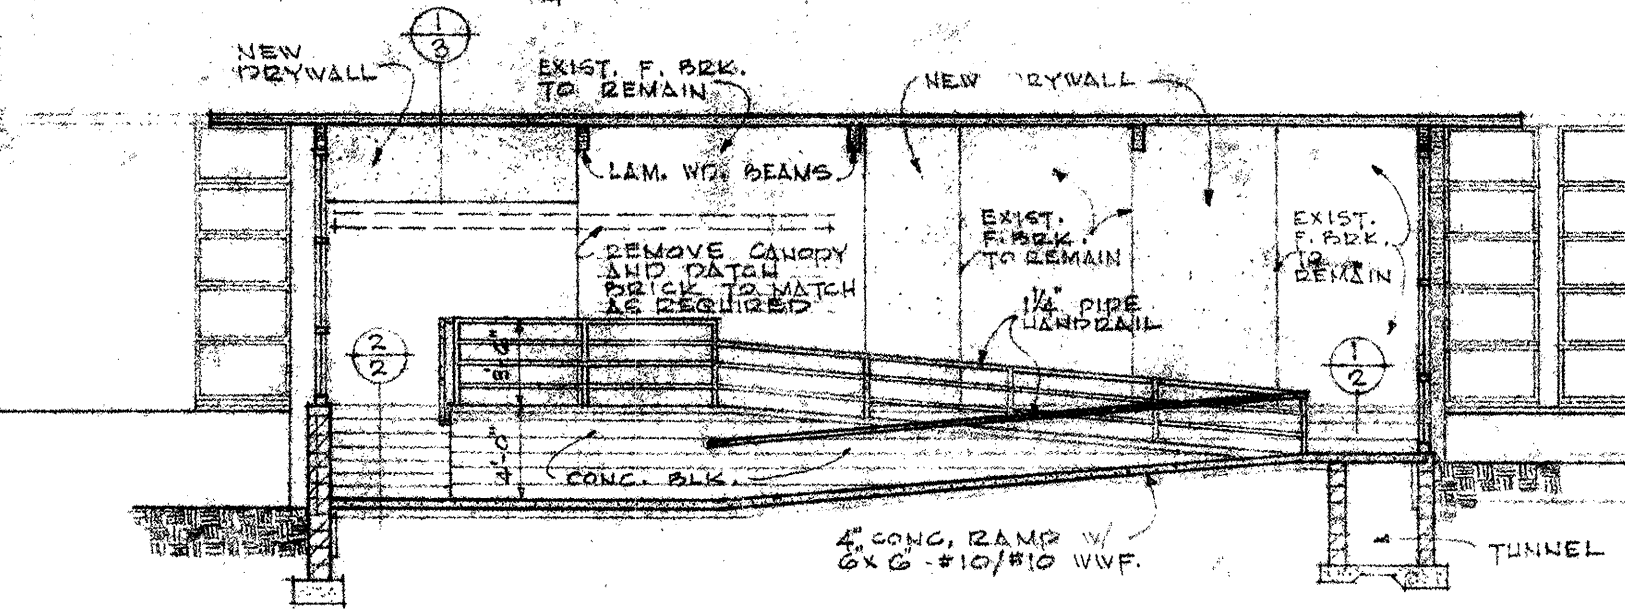


SECTION THRU LOBBY 100
1/8" = 1'-0"

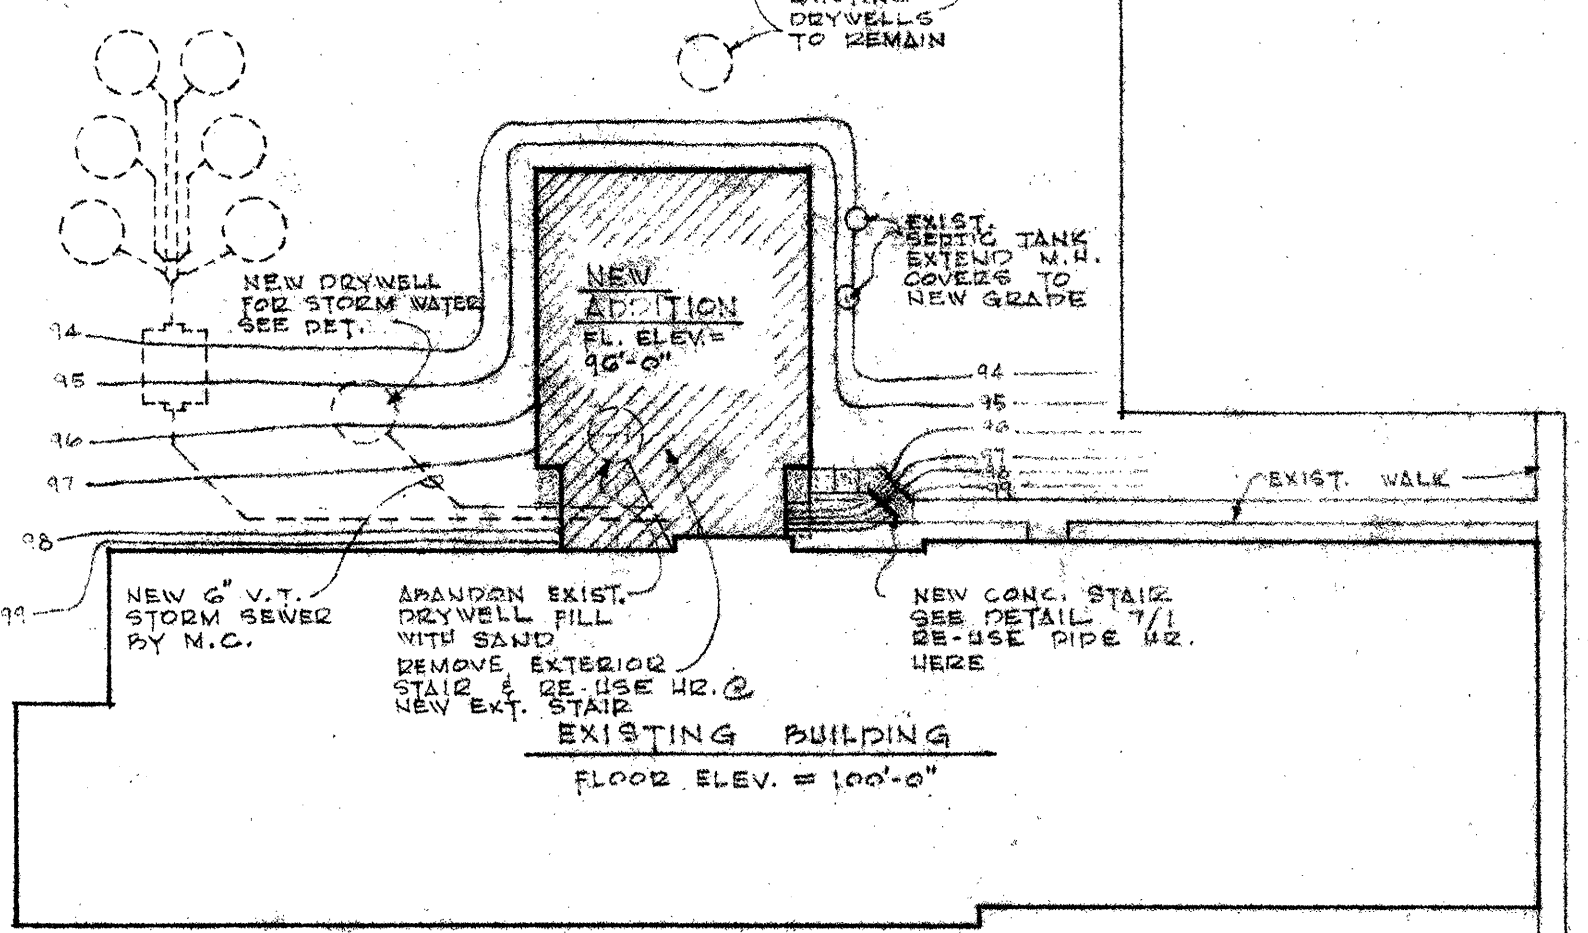


SITE PLAN
1" = 40'-0"

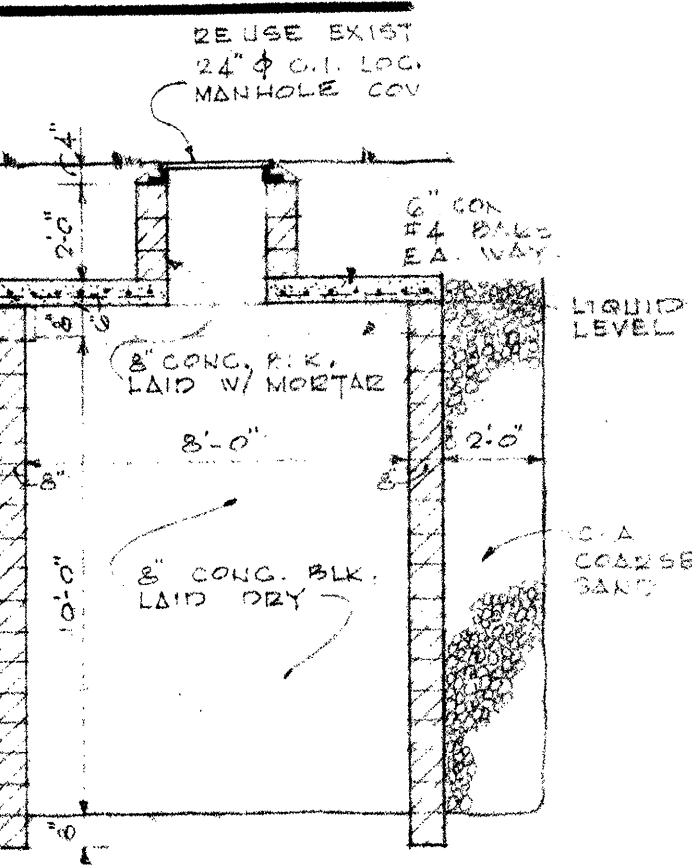

DRYWELL DETAIL
1/4" = 1'-0"





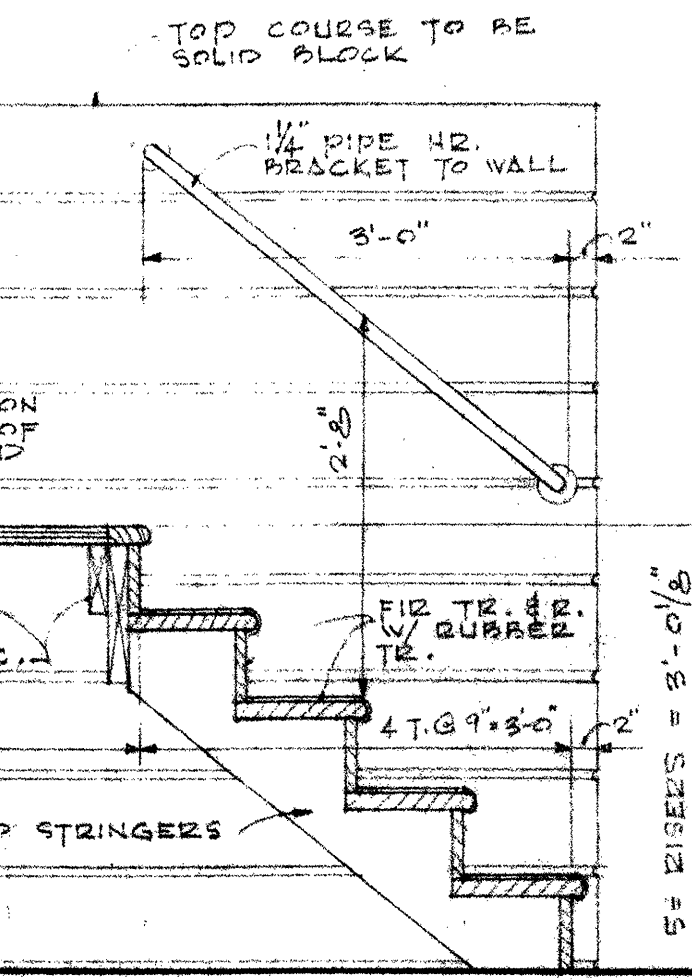


STAIR SECTION
3/4" = 1'-0"

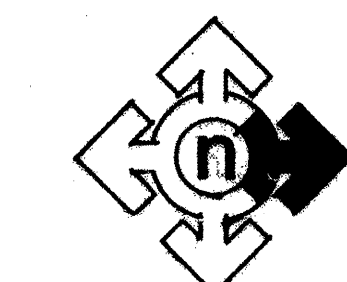

SHEET INDEX	
1	SITE PLAN, EXTERIOR ELEVATIONS, DETAILS
2	FLOOR PLAN, FOUND. PLAN, DETAILS
3	FRAMING PLAN, DETAILS
4	MECHANICAL & ELECTRICAL

PROJECT		ADDITION TO <u>CHIME STREET SCHOOL</u> KALAMAZOO PUBLIC SCHOOLS KALAMAZOO, MICHIGAN		1
DRAWN BY KC		DATE 10/5/78		SHEET NO.
CHECKED BY		REVISED		
G.E. DIEKEMA & ASSOCIATES ARCHITECTS				
4615 WEST MAIN STREET • KALAMAZOO, MICHIGAN				
JOB NO. 7315				
SITE PLAN, EXTERIOR ELEVATIONS, DETAILS				

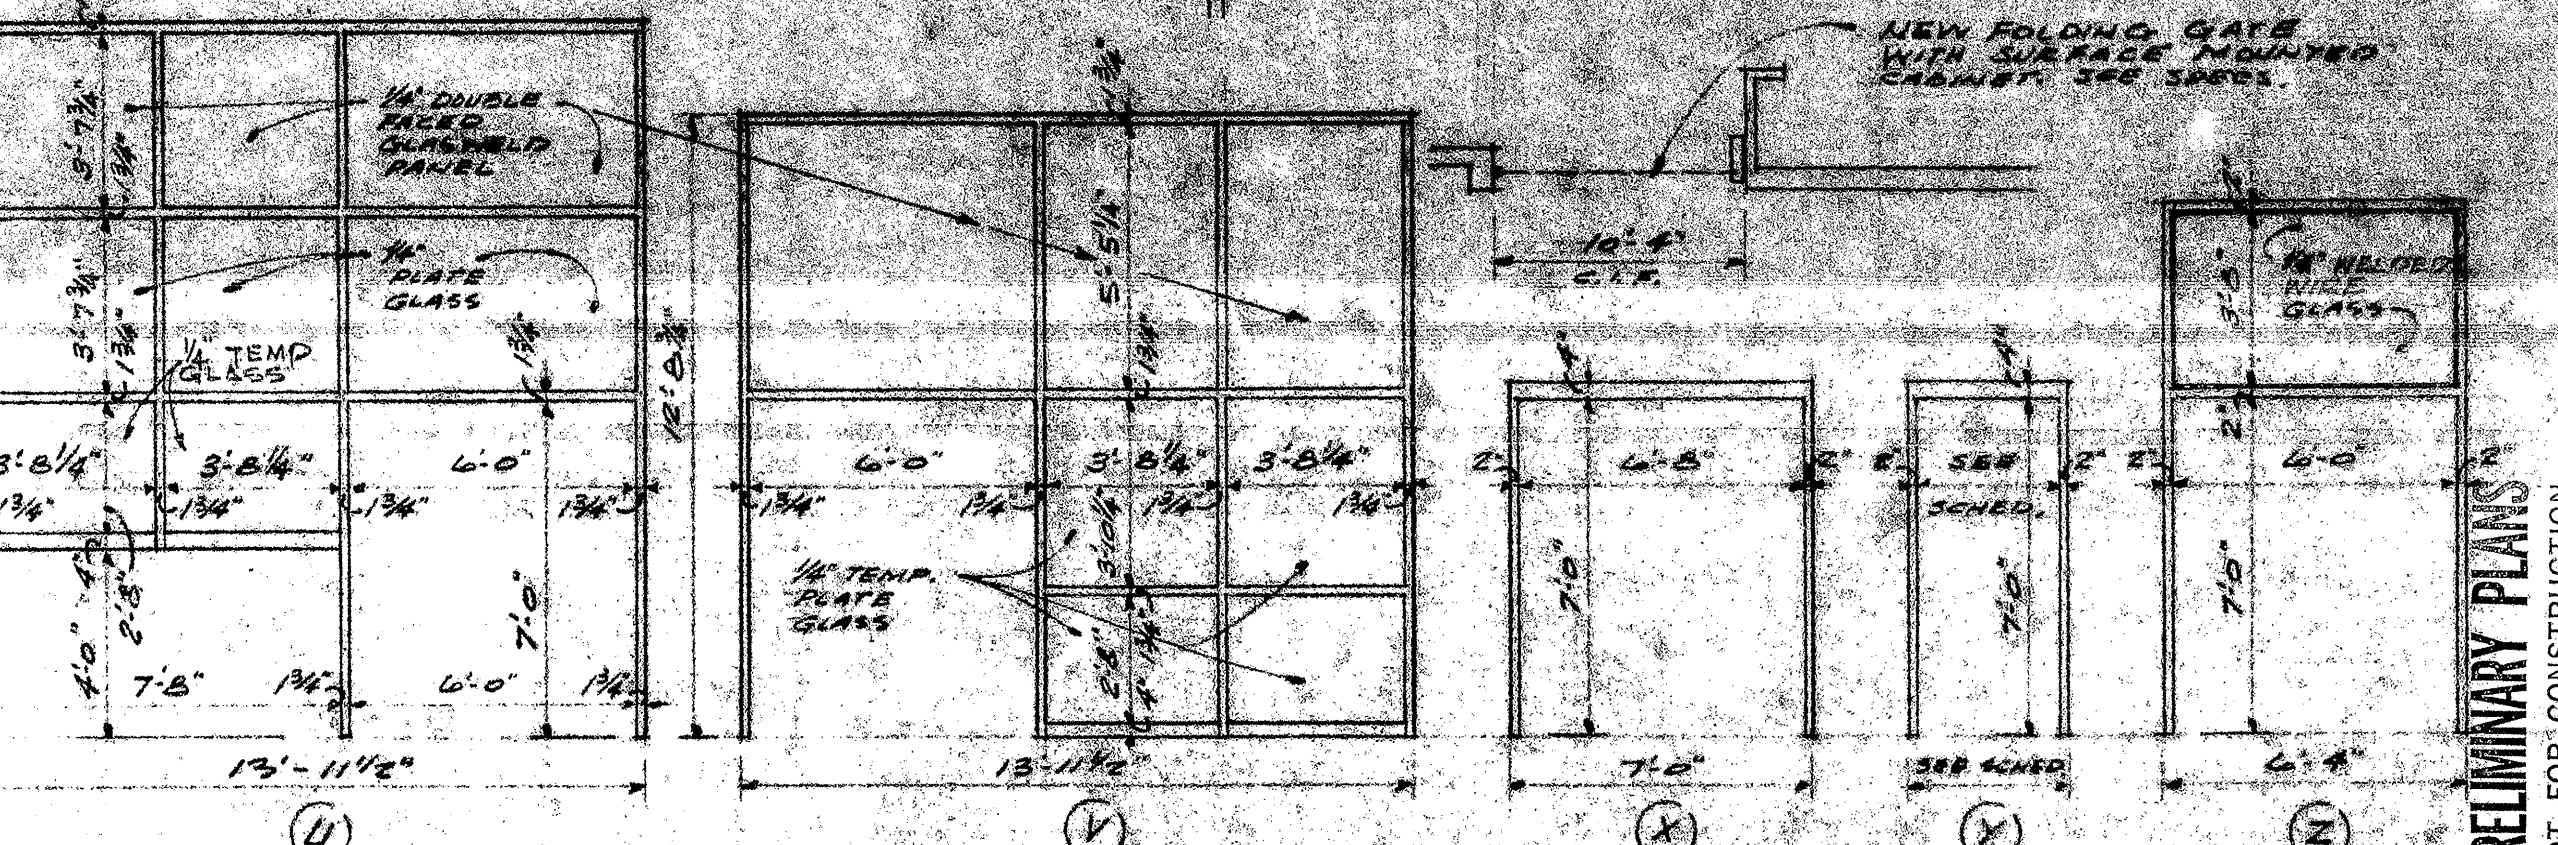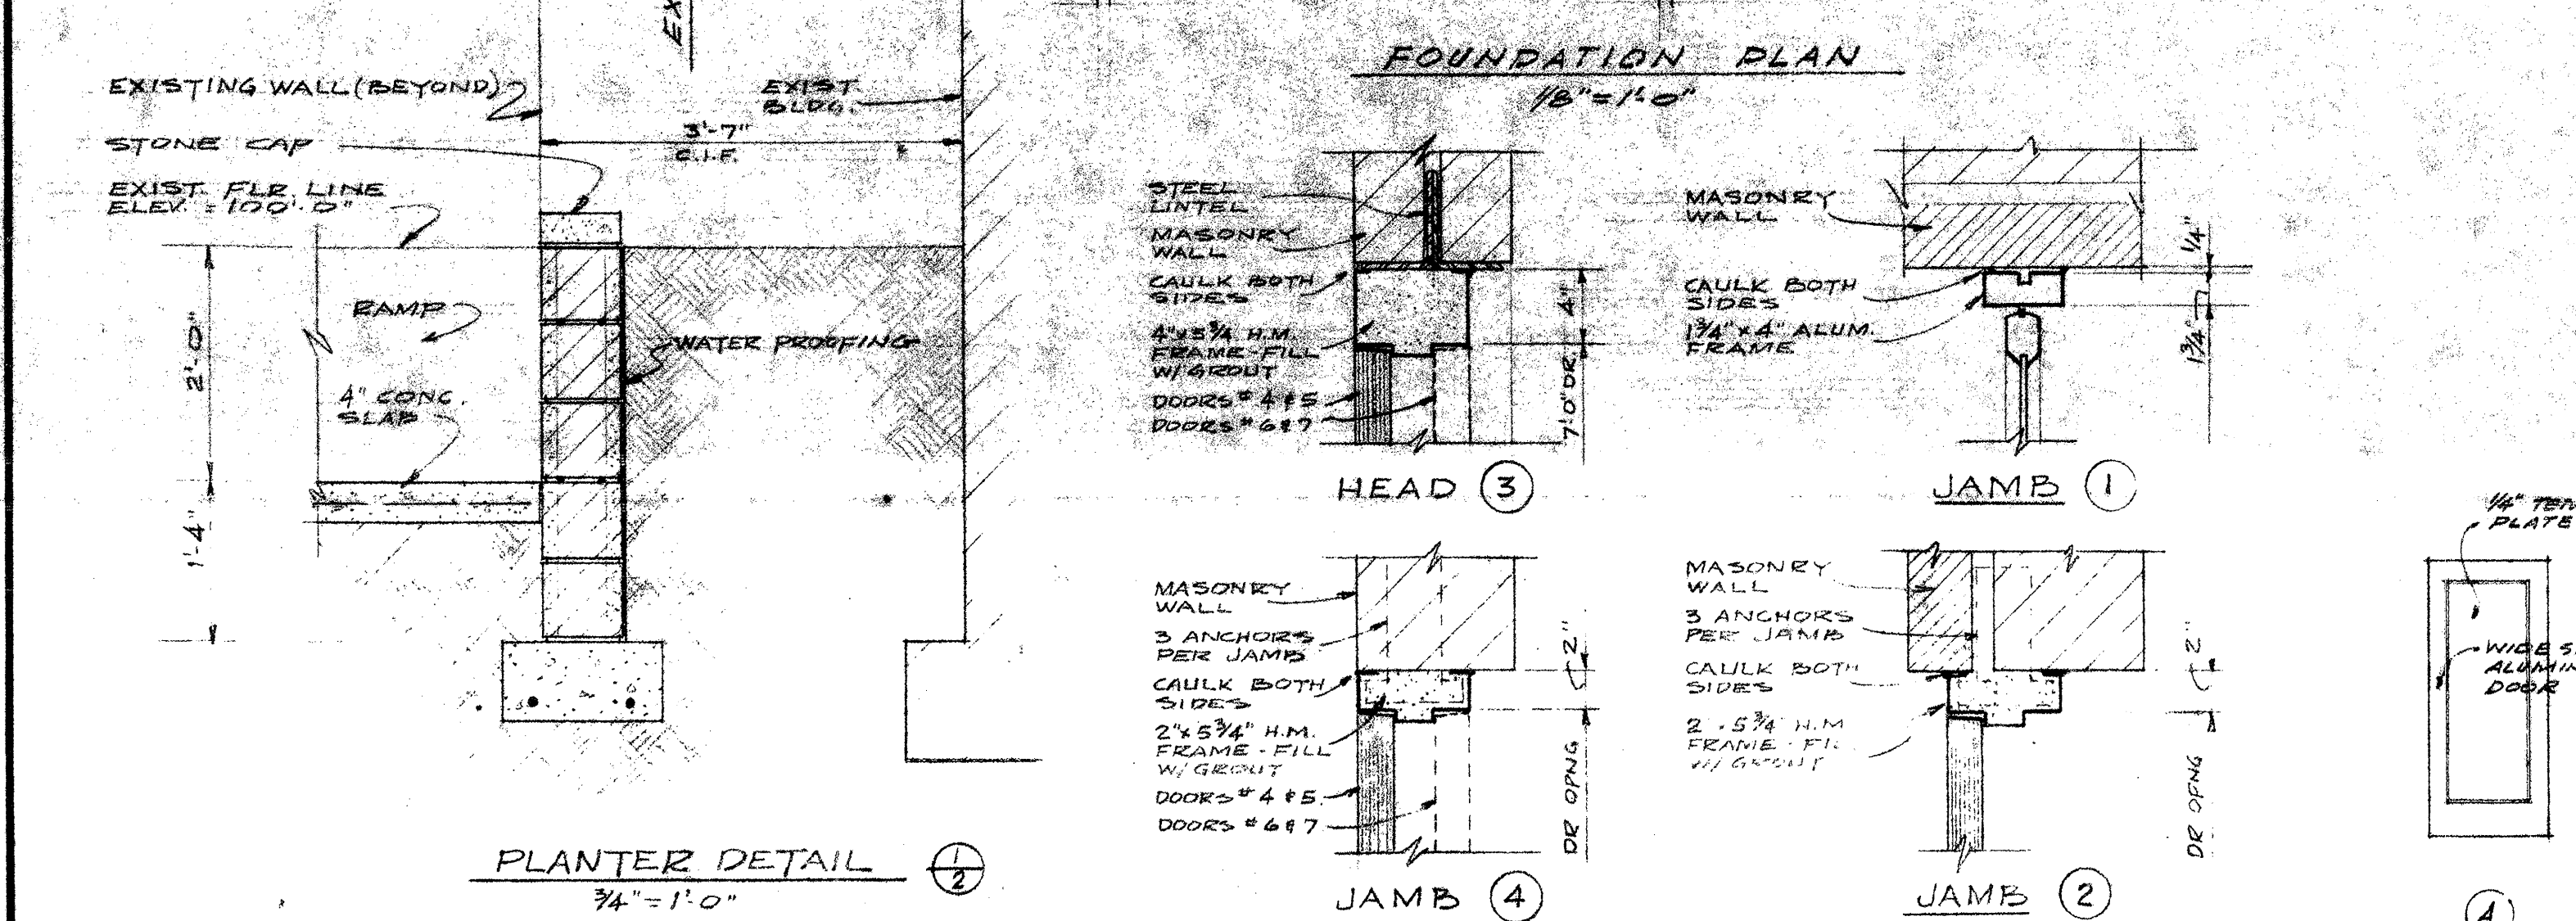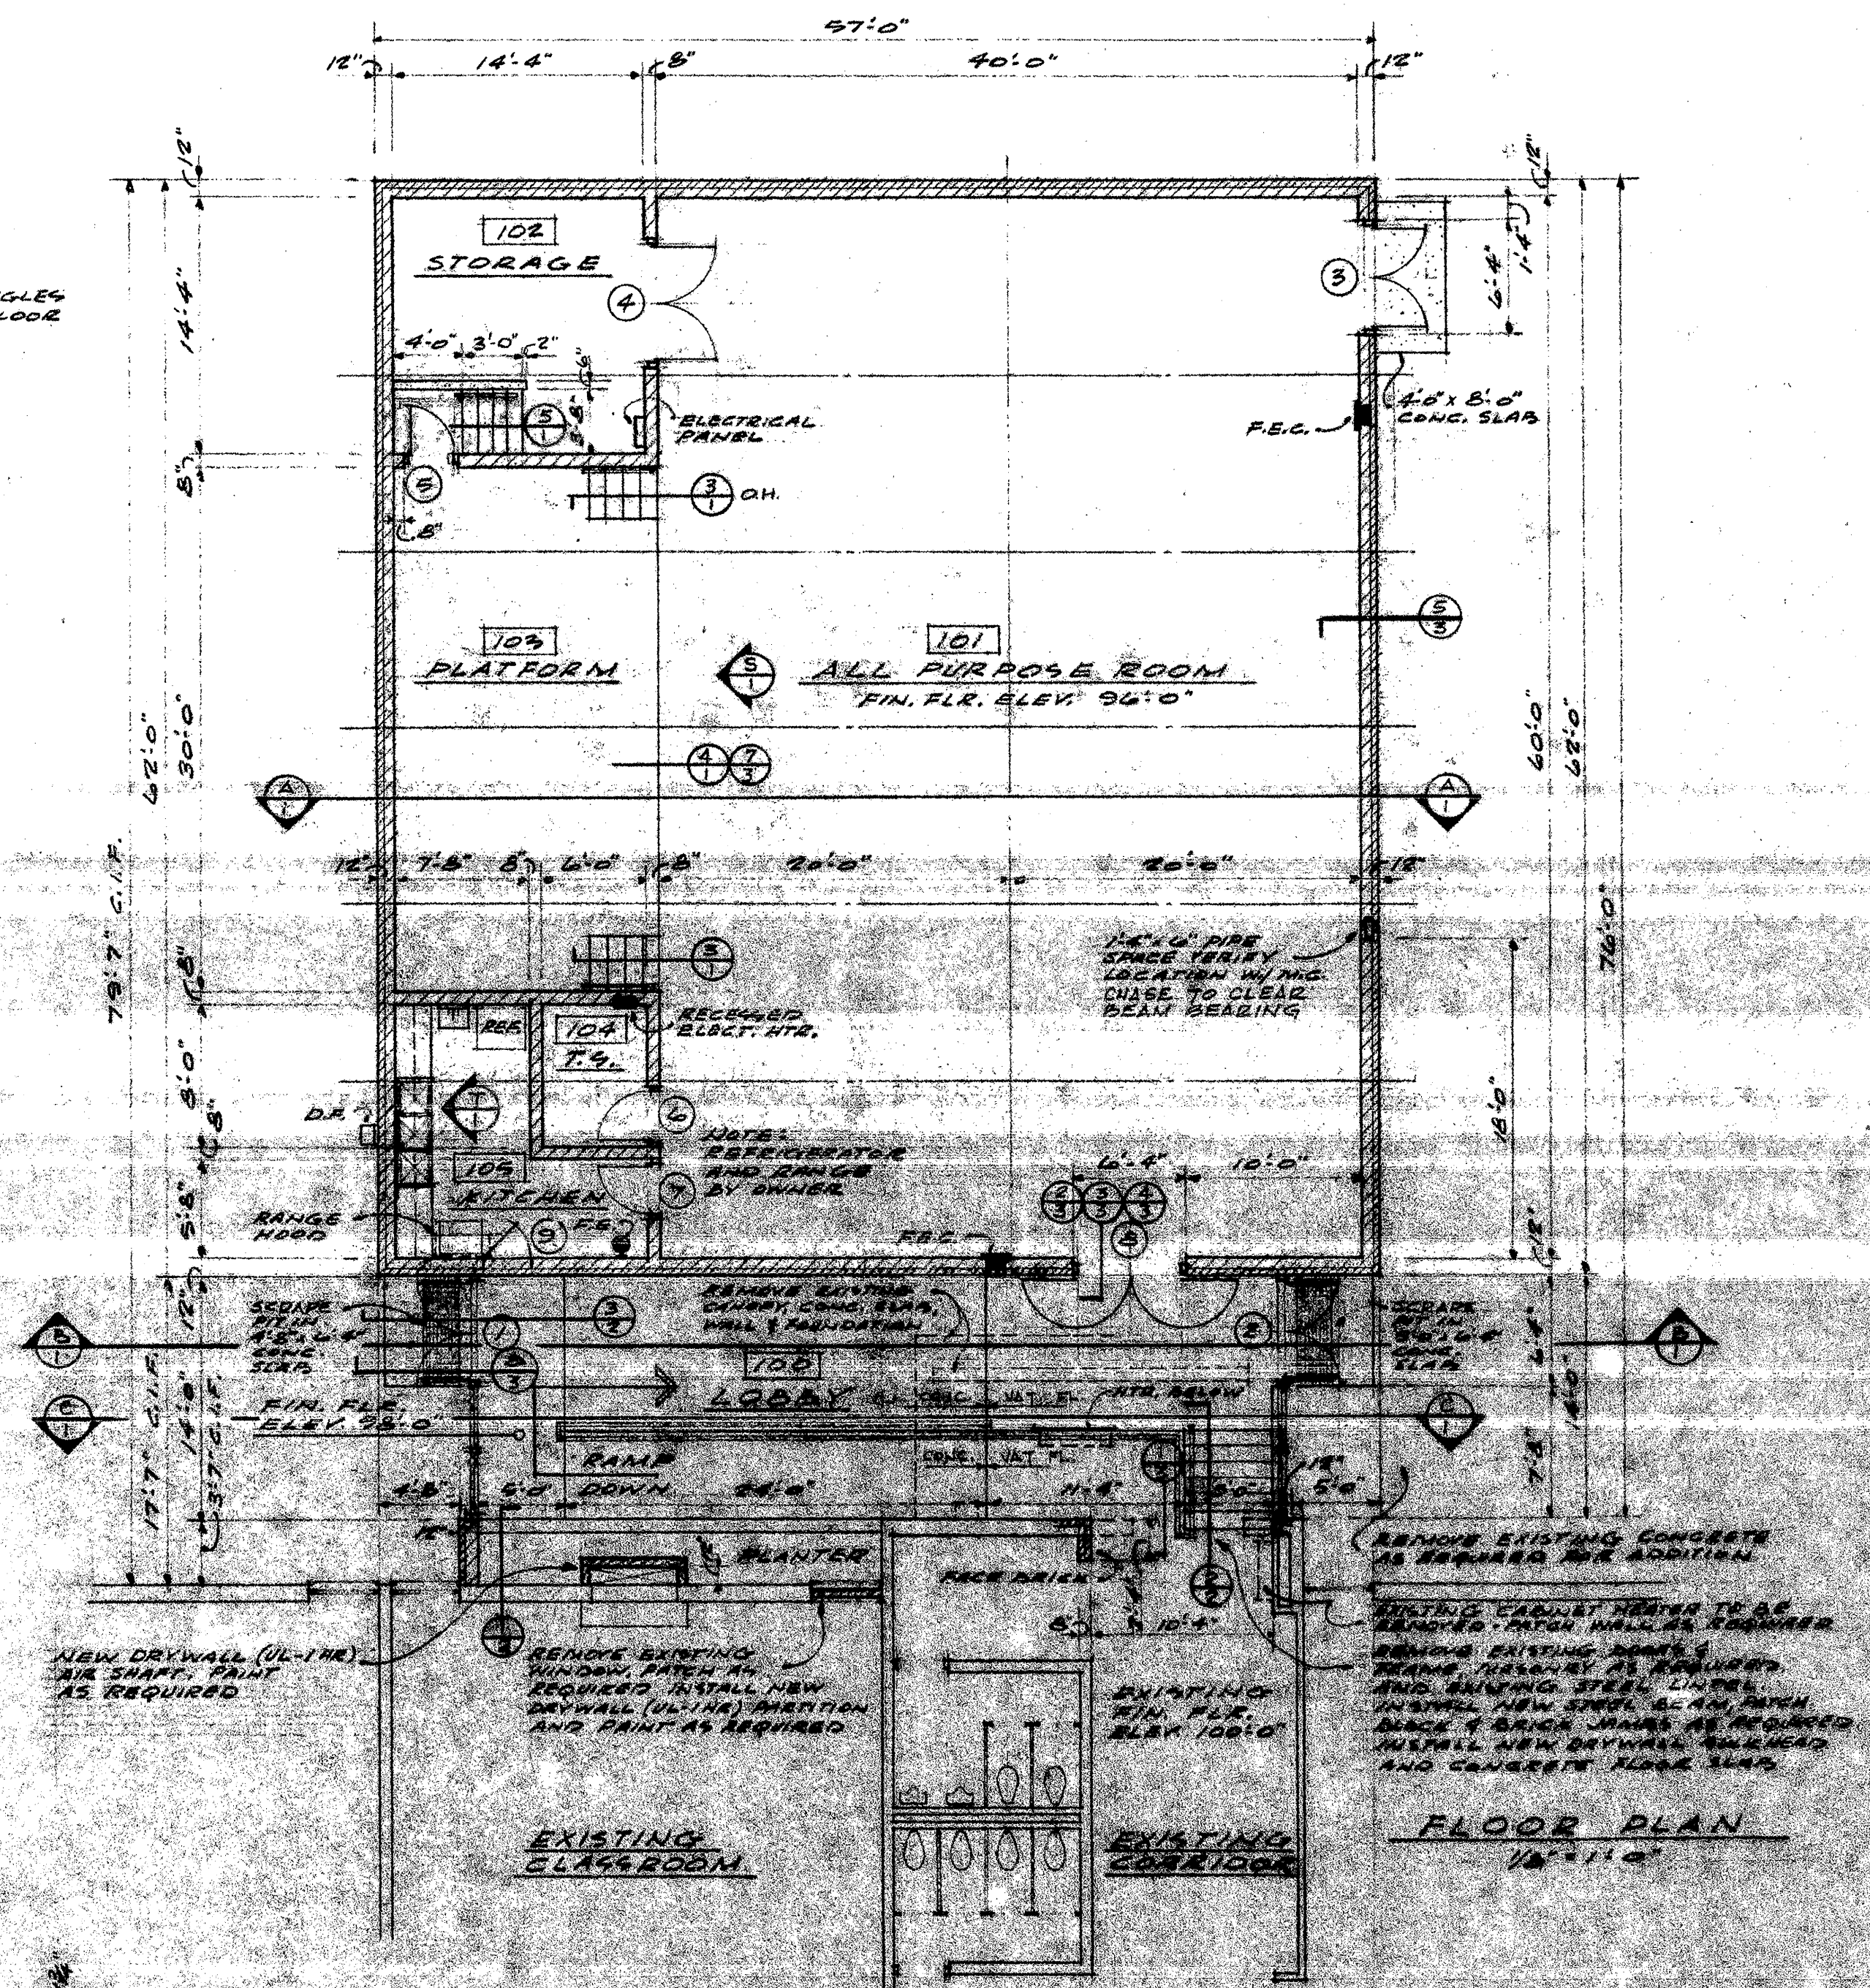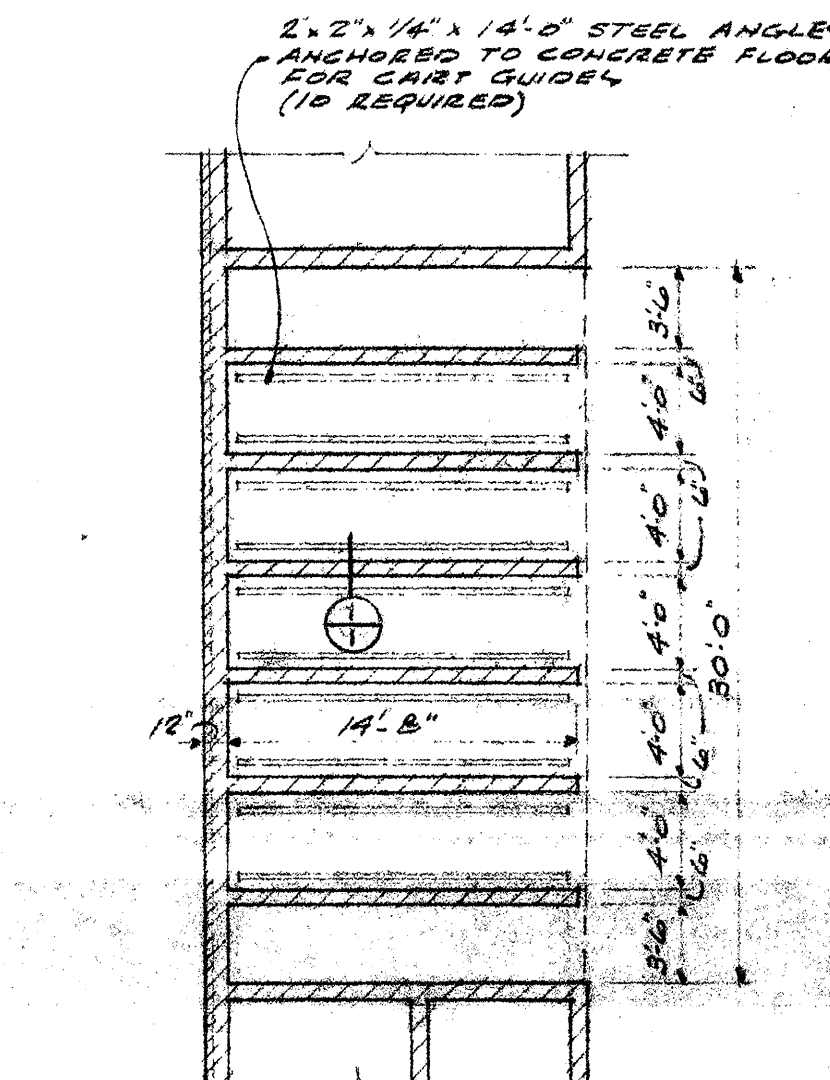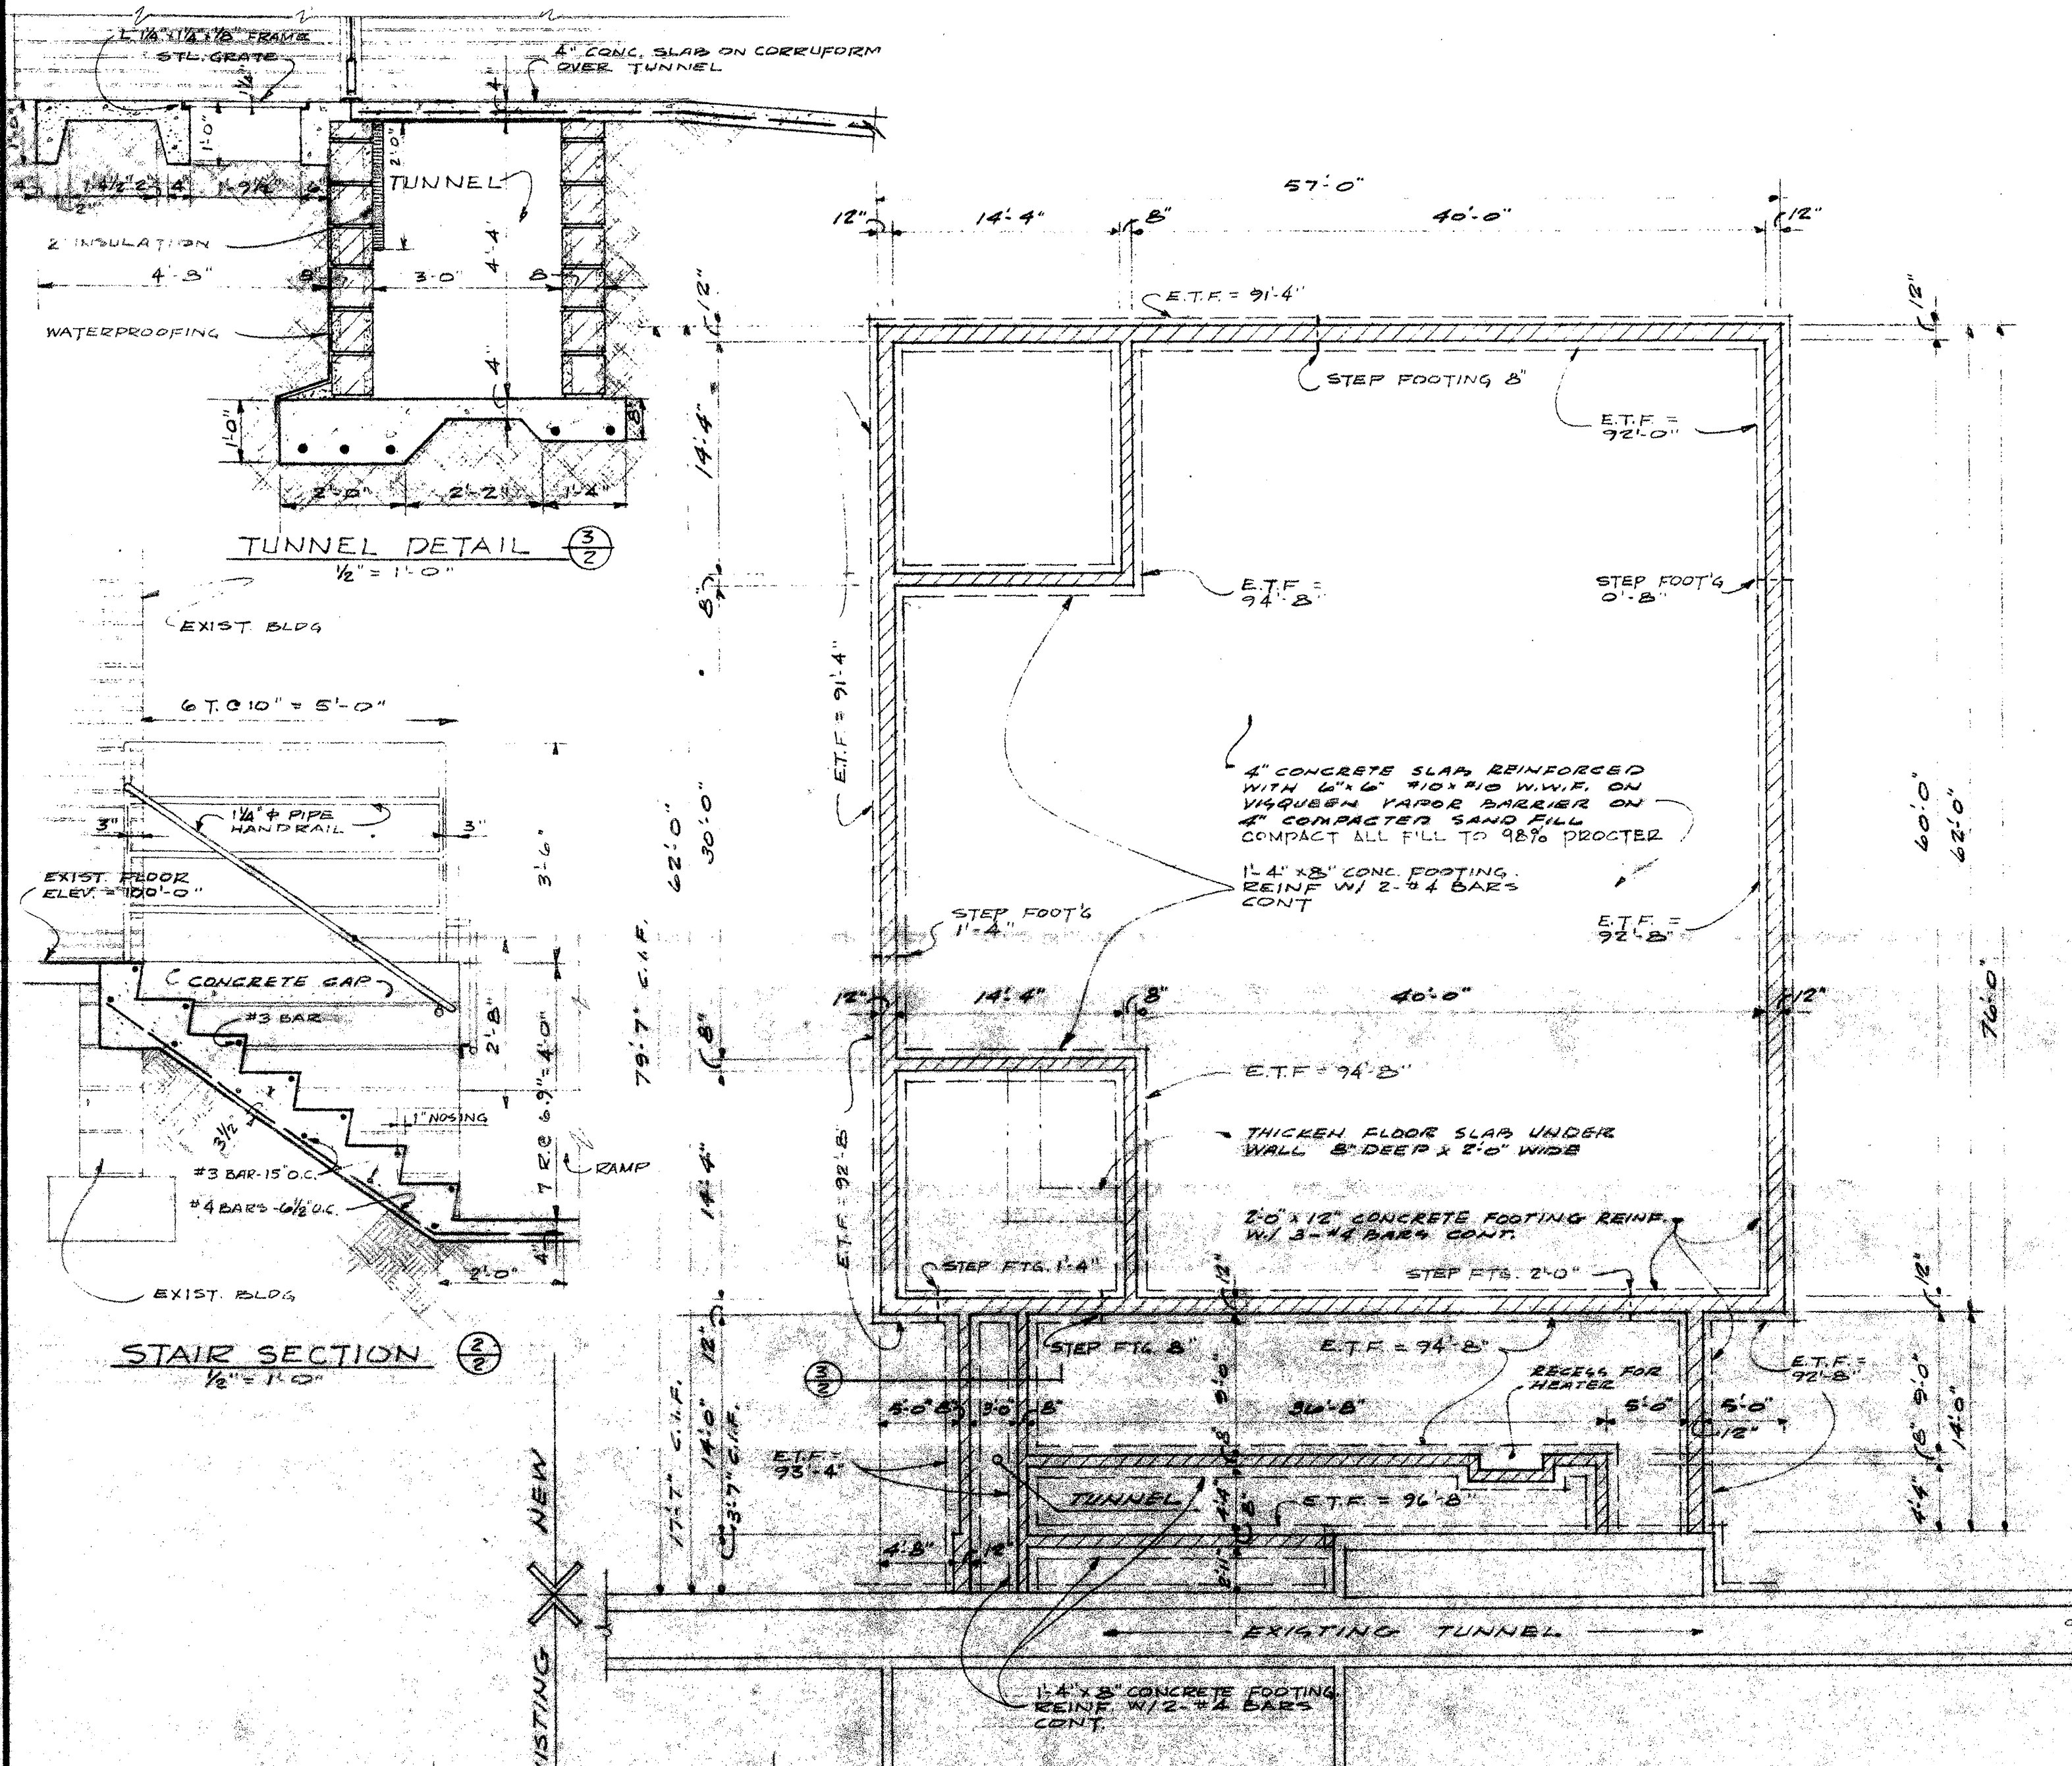


ROOM FINISH SCHEDULE											
NO.	ROOM NAME	FLOOR	BASE	WALLS	CEILING	DOORS	TRIM	REMARKS	CLG. HGT.	CLG. HGT.	CLG. HGT.
100	LOBBY	1	BRICK	BRICK	BRICK	BRICK	BRICK	BRICK	8'-0"	8'-0"	8'-0"
101	ALL PURPOSE ROOM	1	BRICK	BRICK	BRICK	BRICK	BRICK	BRICK	8'-0"	8'-0"	8'-0"
102	STORAGE	1	BRICK	BRICK	BRICK	BRICK	BRICK	BRICK	8'-0"	8'-0"	8'-0"
103	PLATFORM	1	BRICK	BRICK	BRICK	BRICK	BRICK	BRICK	8'-0"	8'-0"	8'-0"
104	TEACHING STATION	1	BRICK	BRICK	BRICK	BRICK	BRICK	BRICK	8'-0"	8'-0"	8'-0"
105	KITCHEN	1	BRICK	BRICK	BRICK	BRICK	BRICK	BRICK	8'-0"	8'-0"	8'-0"

ADDITION TO CHINE STREET SCHOOL
KALAMAZOO PUBLIC SCHOOLS
KALAMAZOO, MICHIGAN


G.E. DIEKEMA & ASSOCIATES ARCHITECTS
4615 WEST MAIN STREET • KALAMAZOO, MICHIGAN

FLOOR PLAN, FOUNDATION PLAN, SCHEDULES & DETAILS


2
NOT FOR CONSTRUCTION

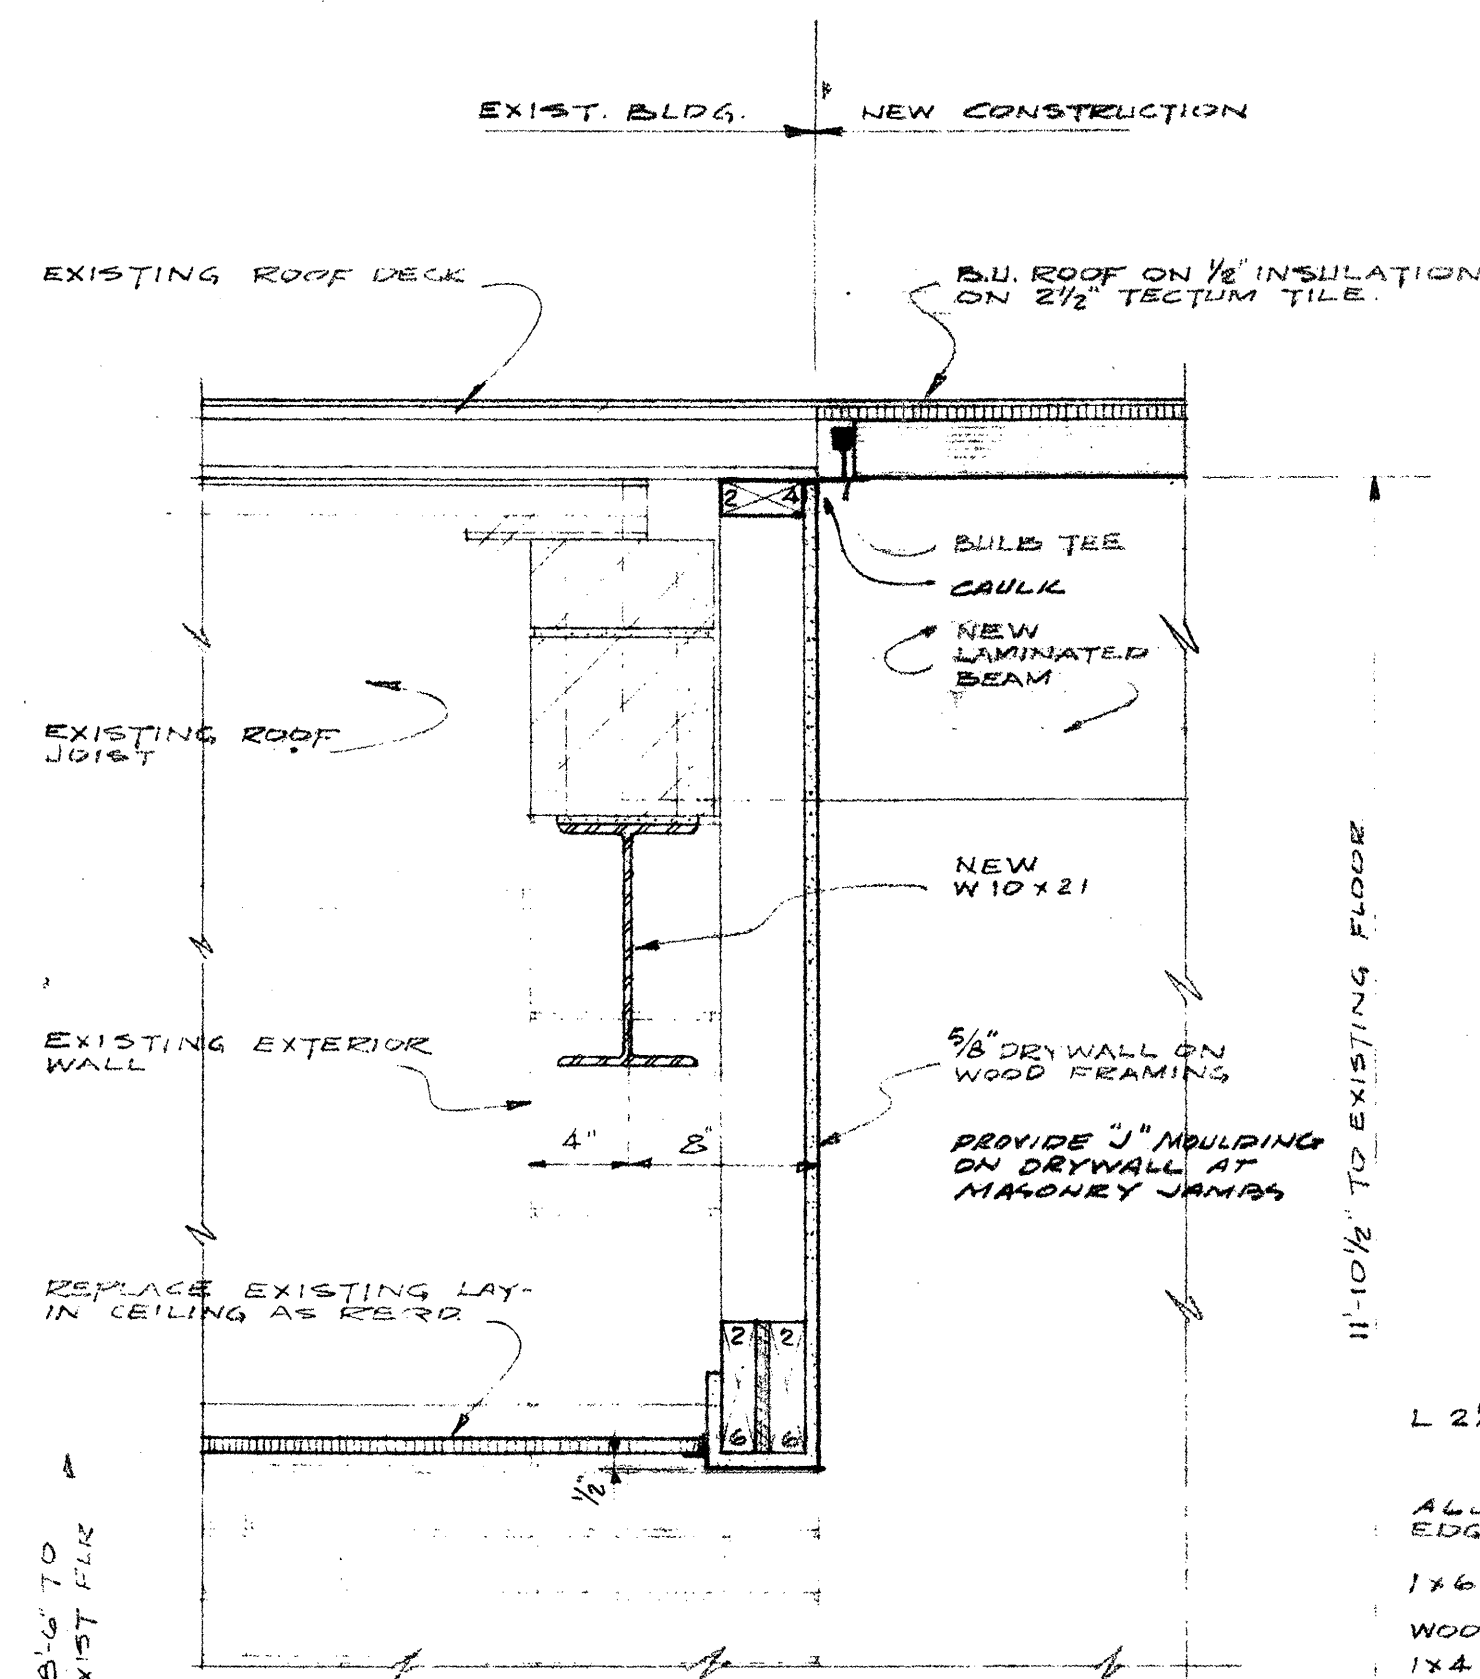


ROOF & CEILING DETAIL
1 1/2" = 1' 0"

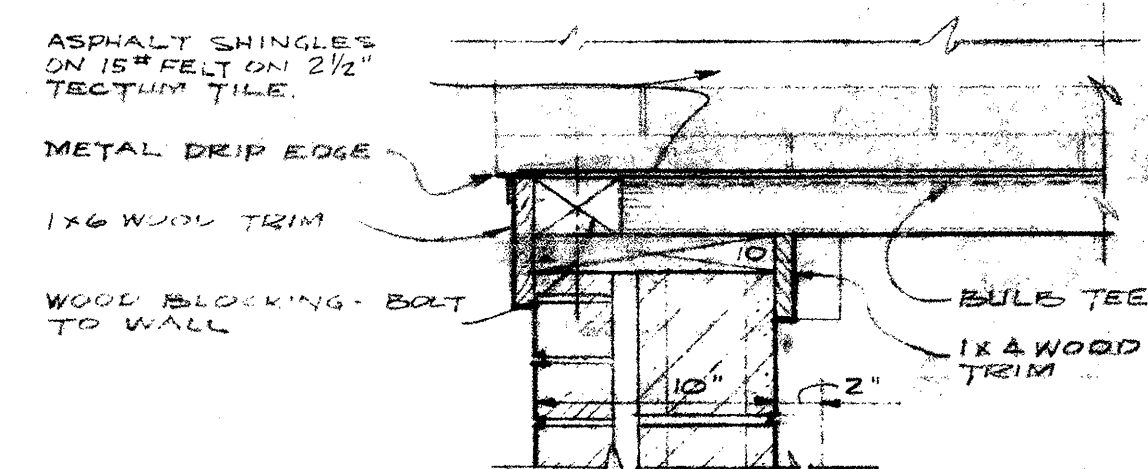


FASCIA DETAIL $\frac{2}{3}$
1 1/2" = 1'-0"

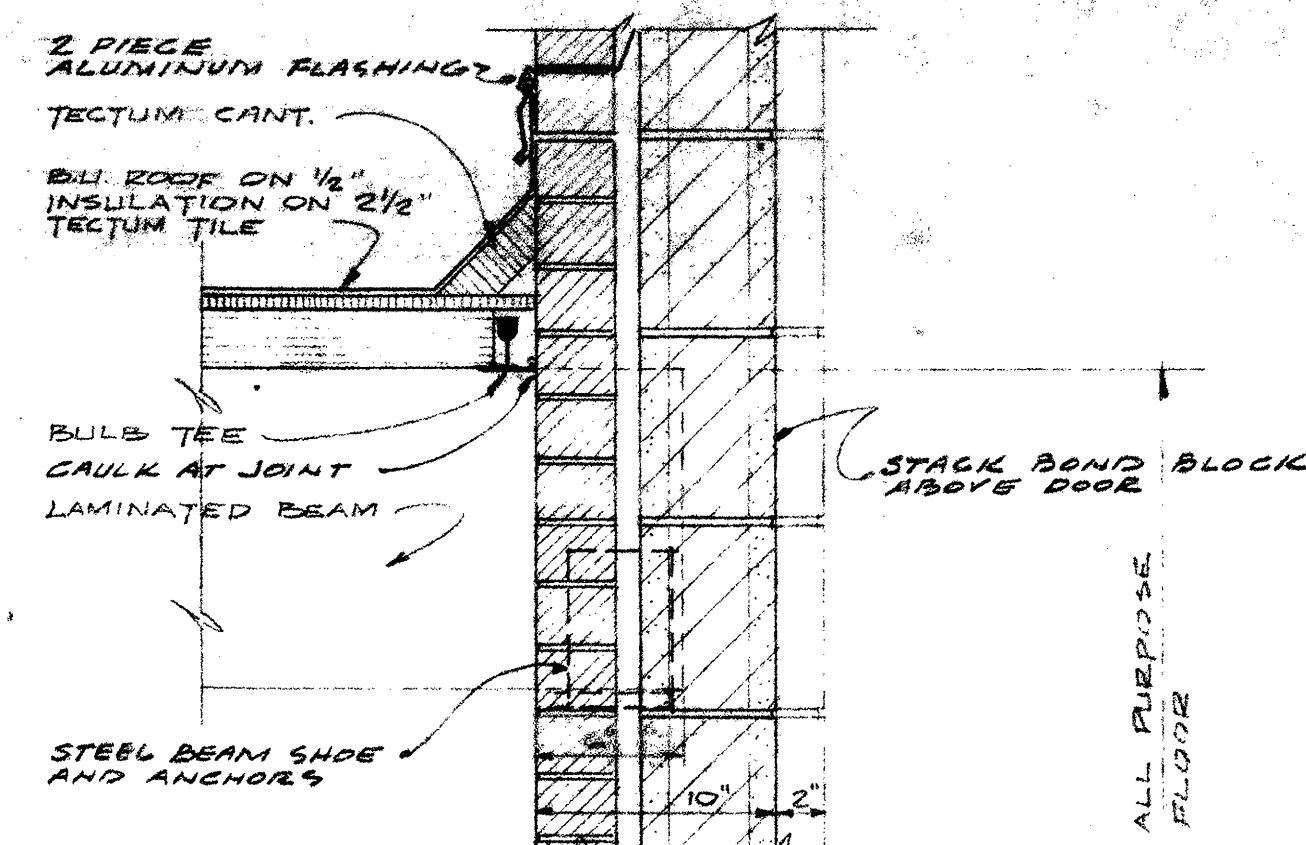


ROOF BRG DETAIL $\frac{3}{3}$

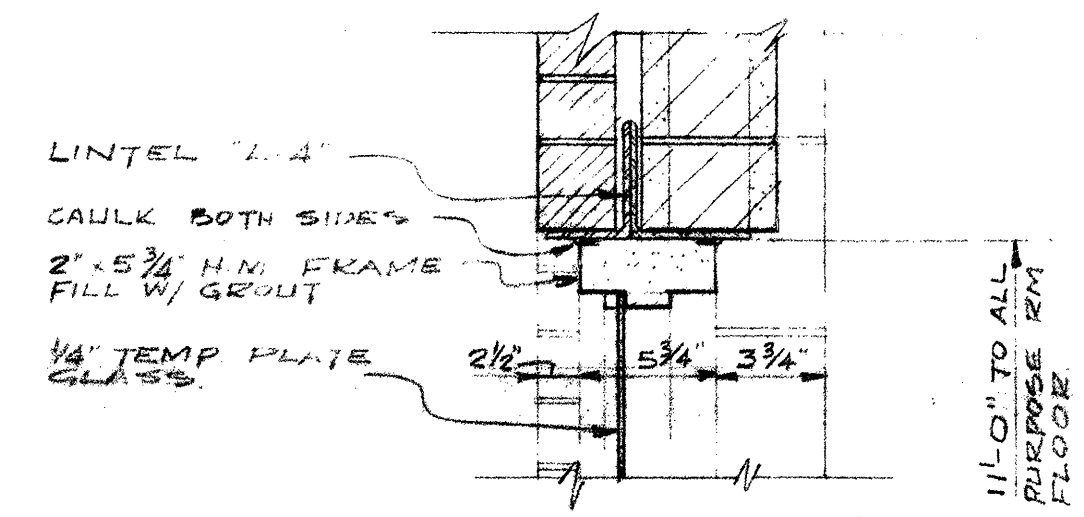


DOOR FRAME HEAD
 $1\frac{1}{2}" = 1'-0"$

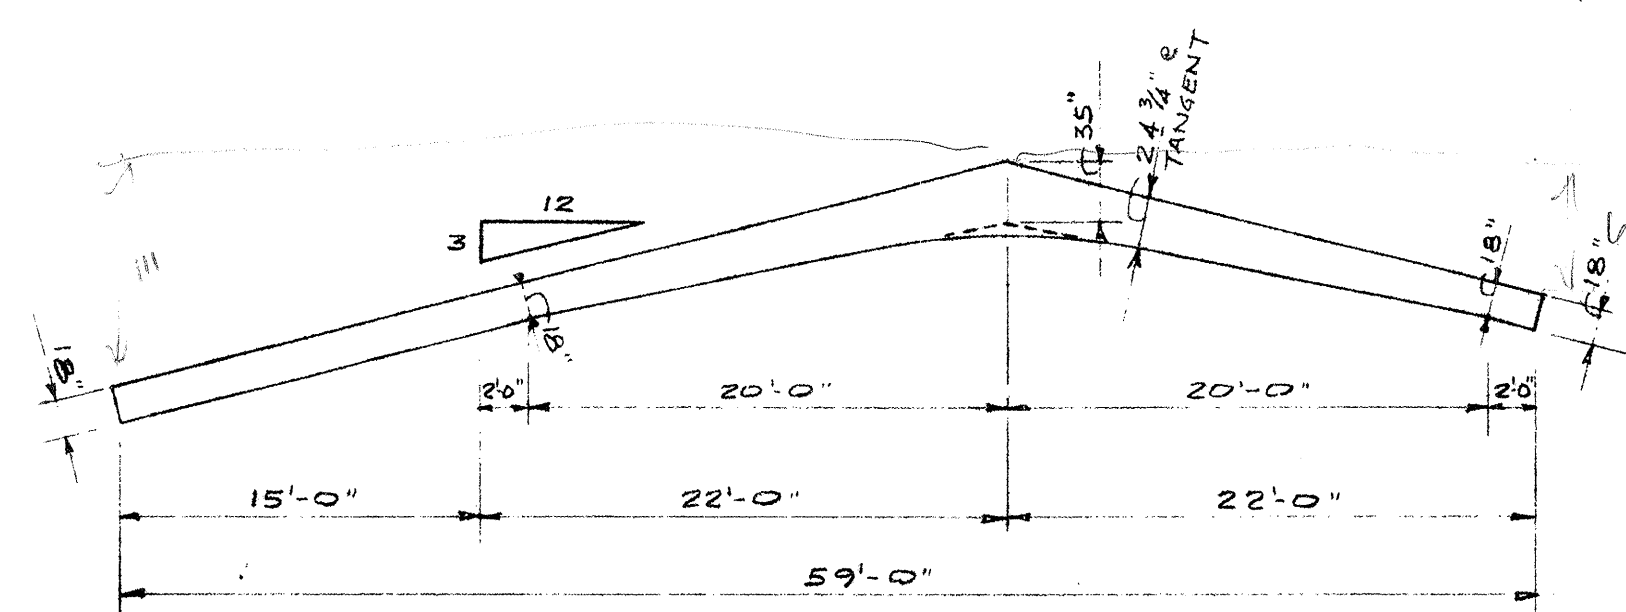


DOUBLE TAPERED / PITCHED BEAM (B-1)
1/8" = 1'-0"
FABRICATE W/ EXTERIOR USE GLUE

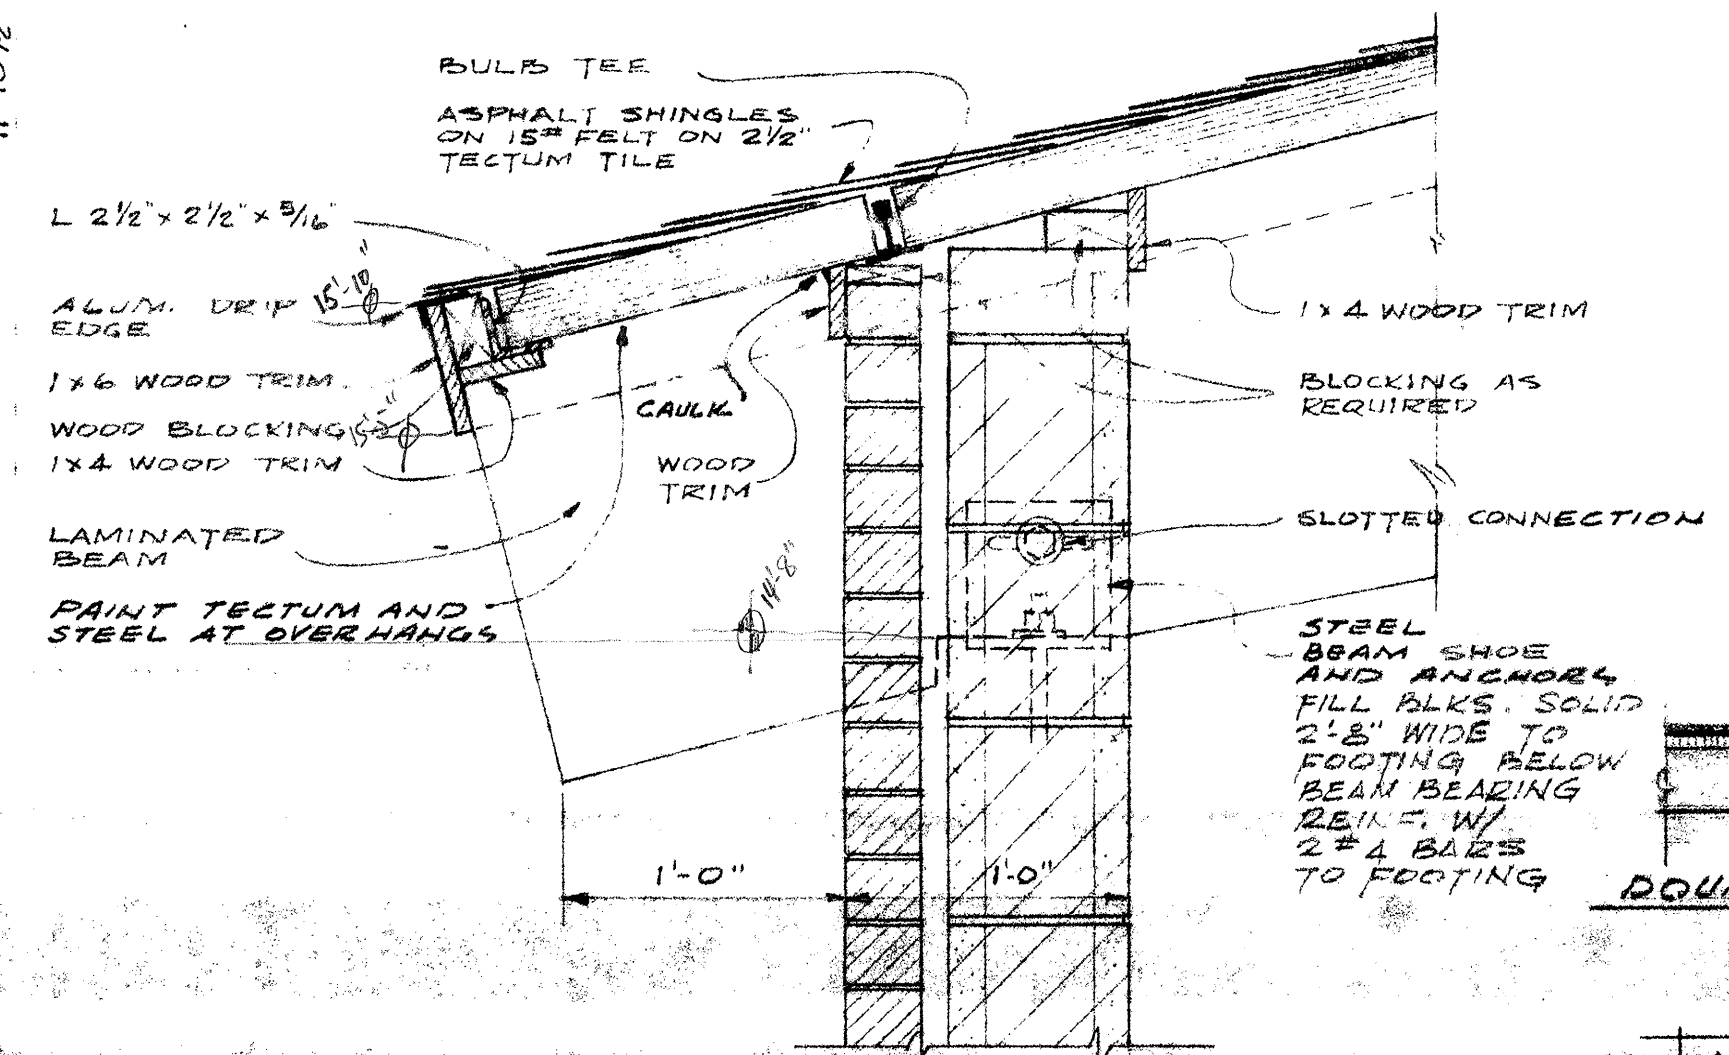


FASCIA DETAIL 5
3

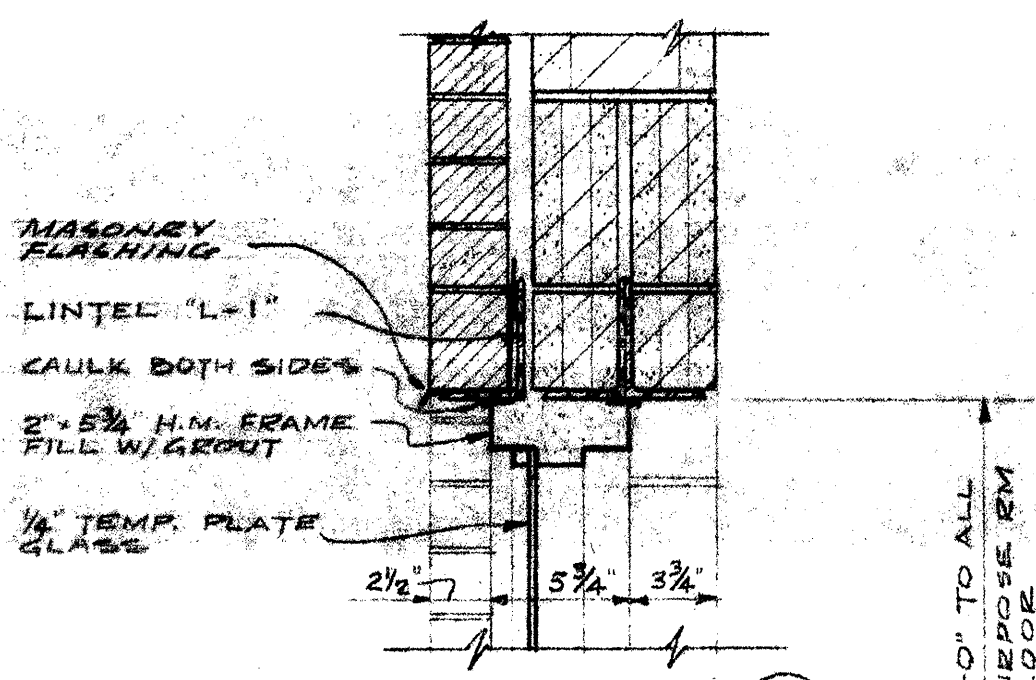

DOOR FRAME $\left(\frac{6}{3} \right)$
HEAD

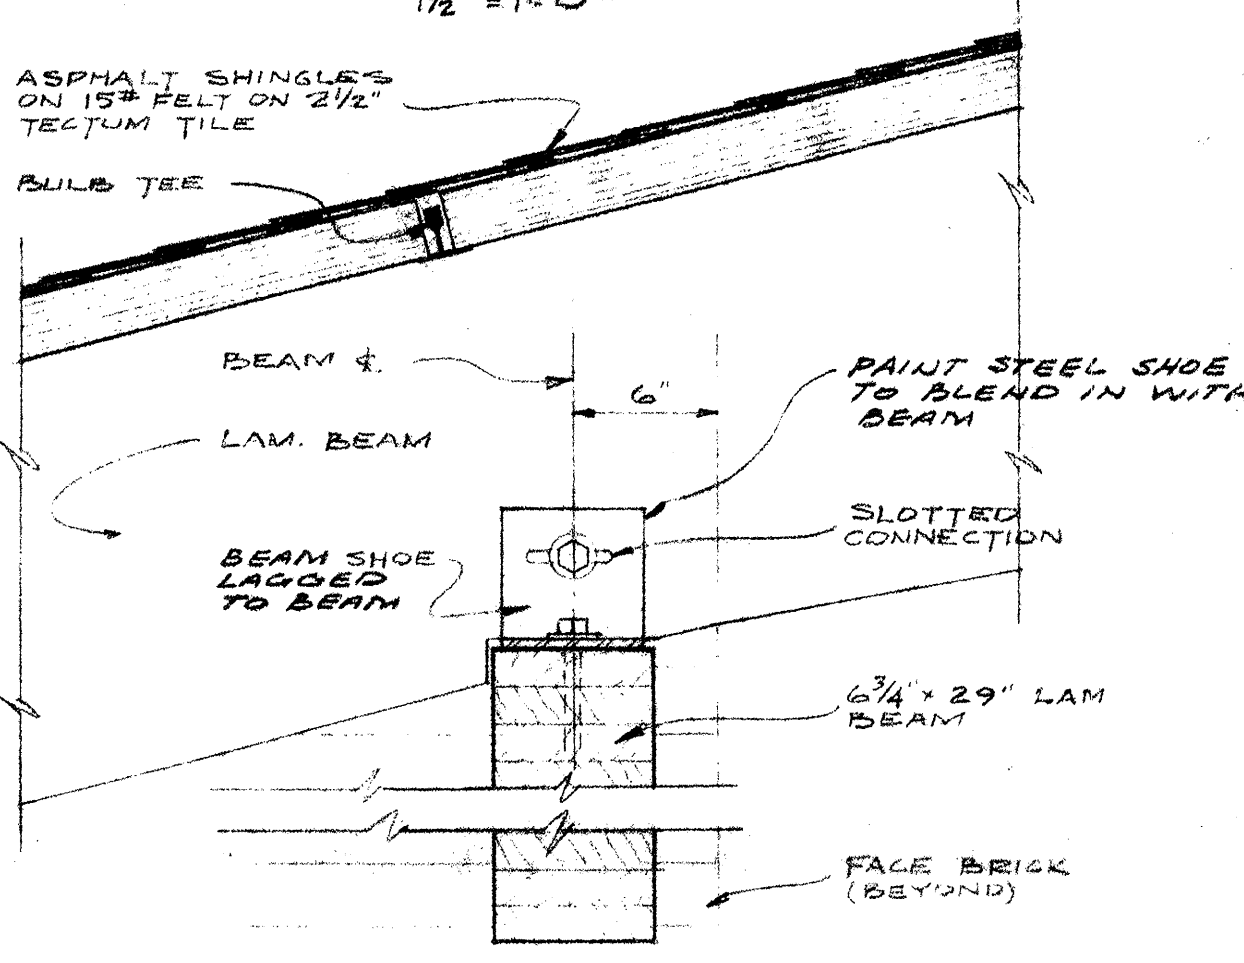


BEAM BEARING (7)
DETAIL (3)

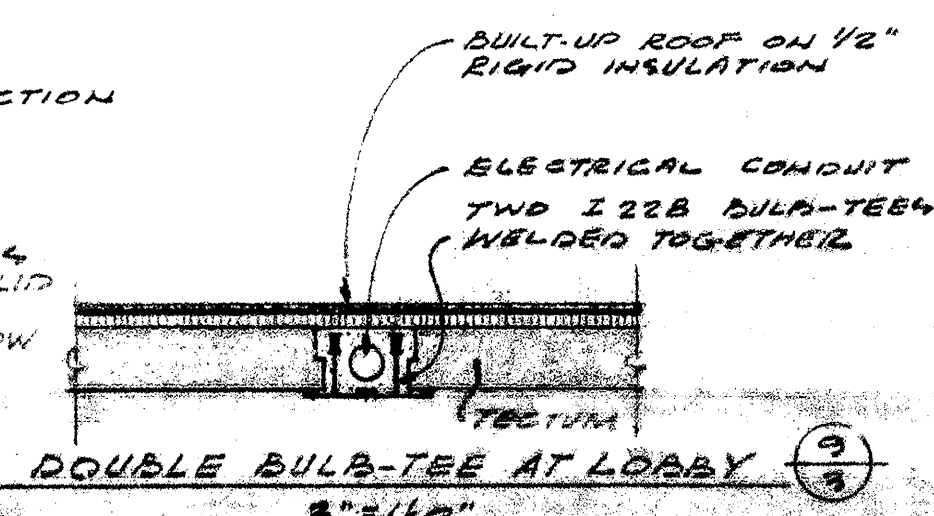


DOUBLE BULB-TEE AT LOBBY

NOTE:
ALL EXTERIOR WOOD TRIM,
TECTUM AND EXPOSED
STEEL TO BE PAINTED.

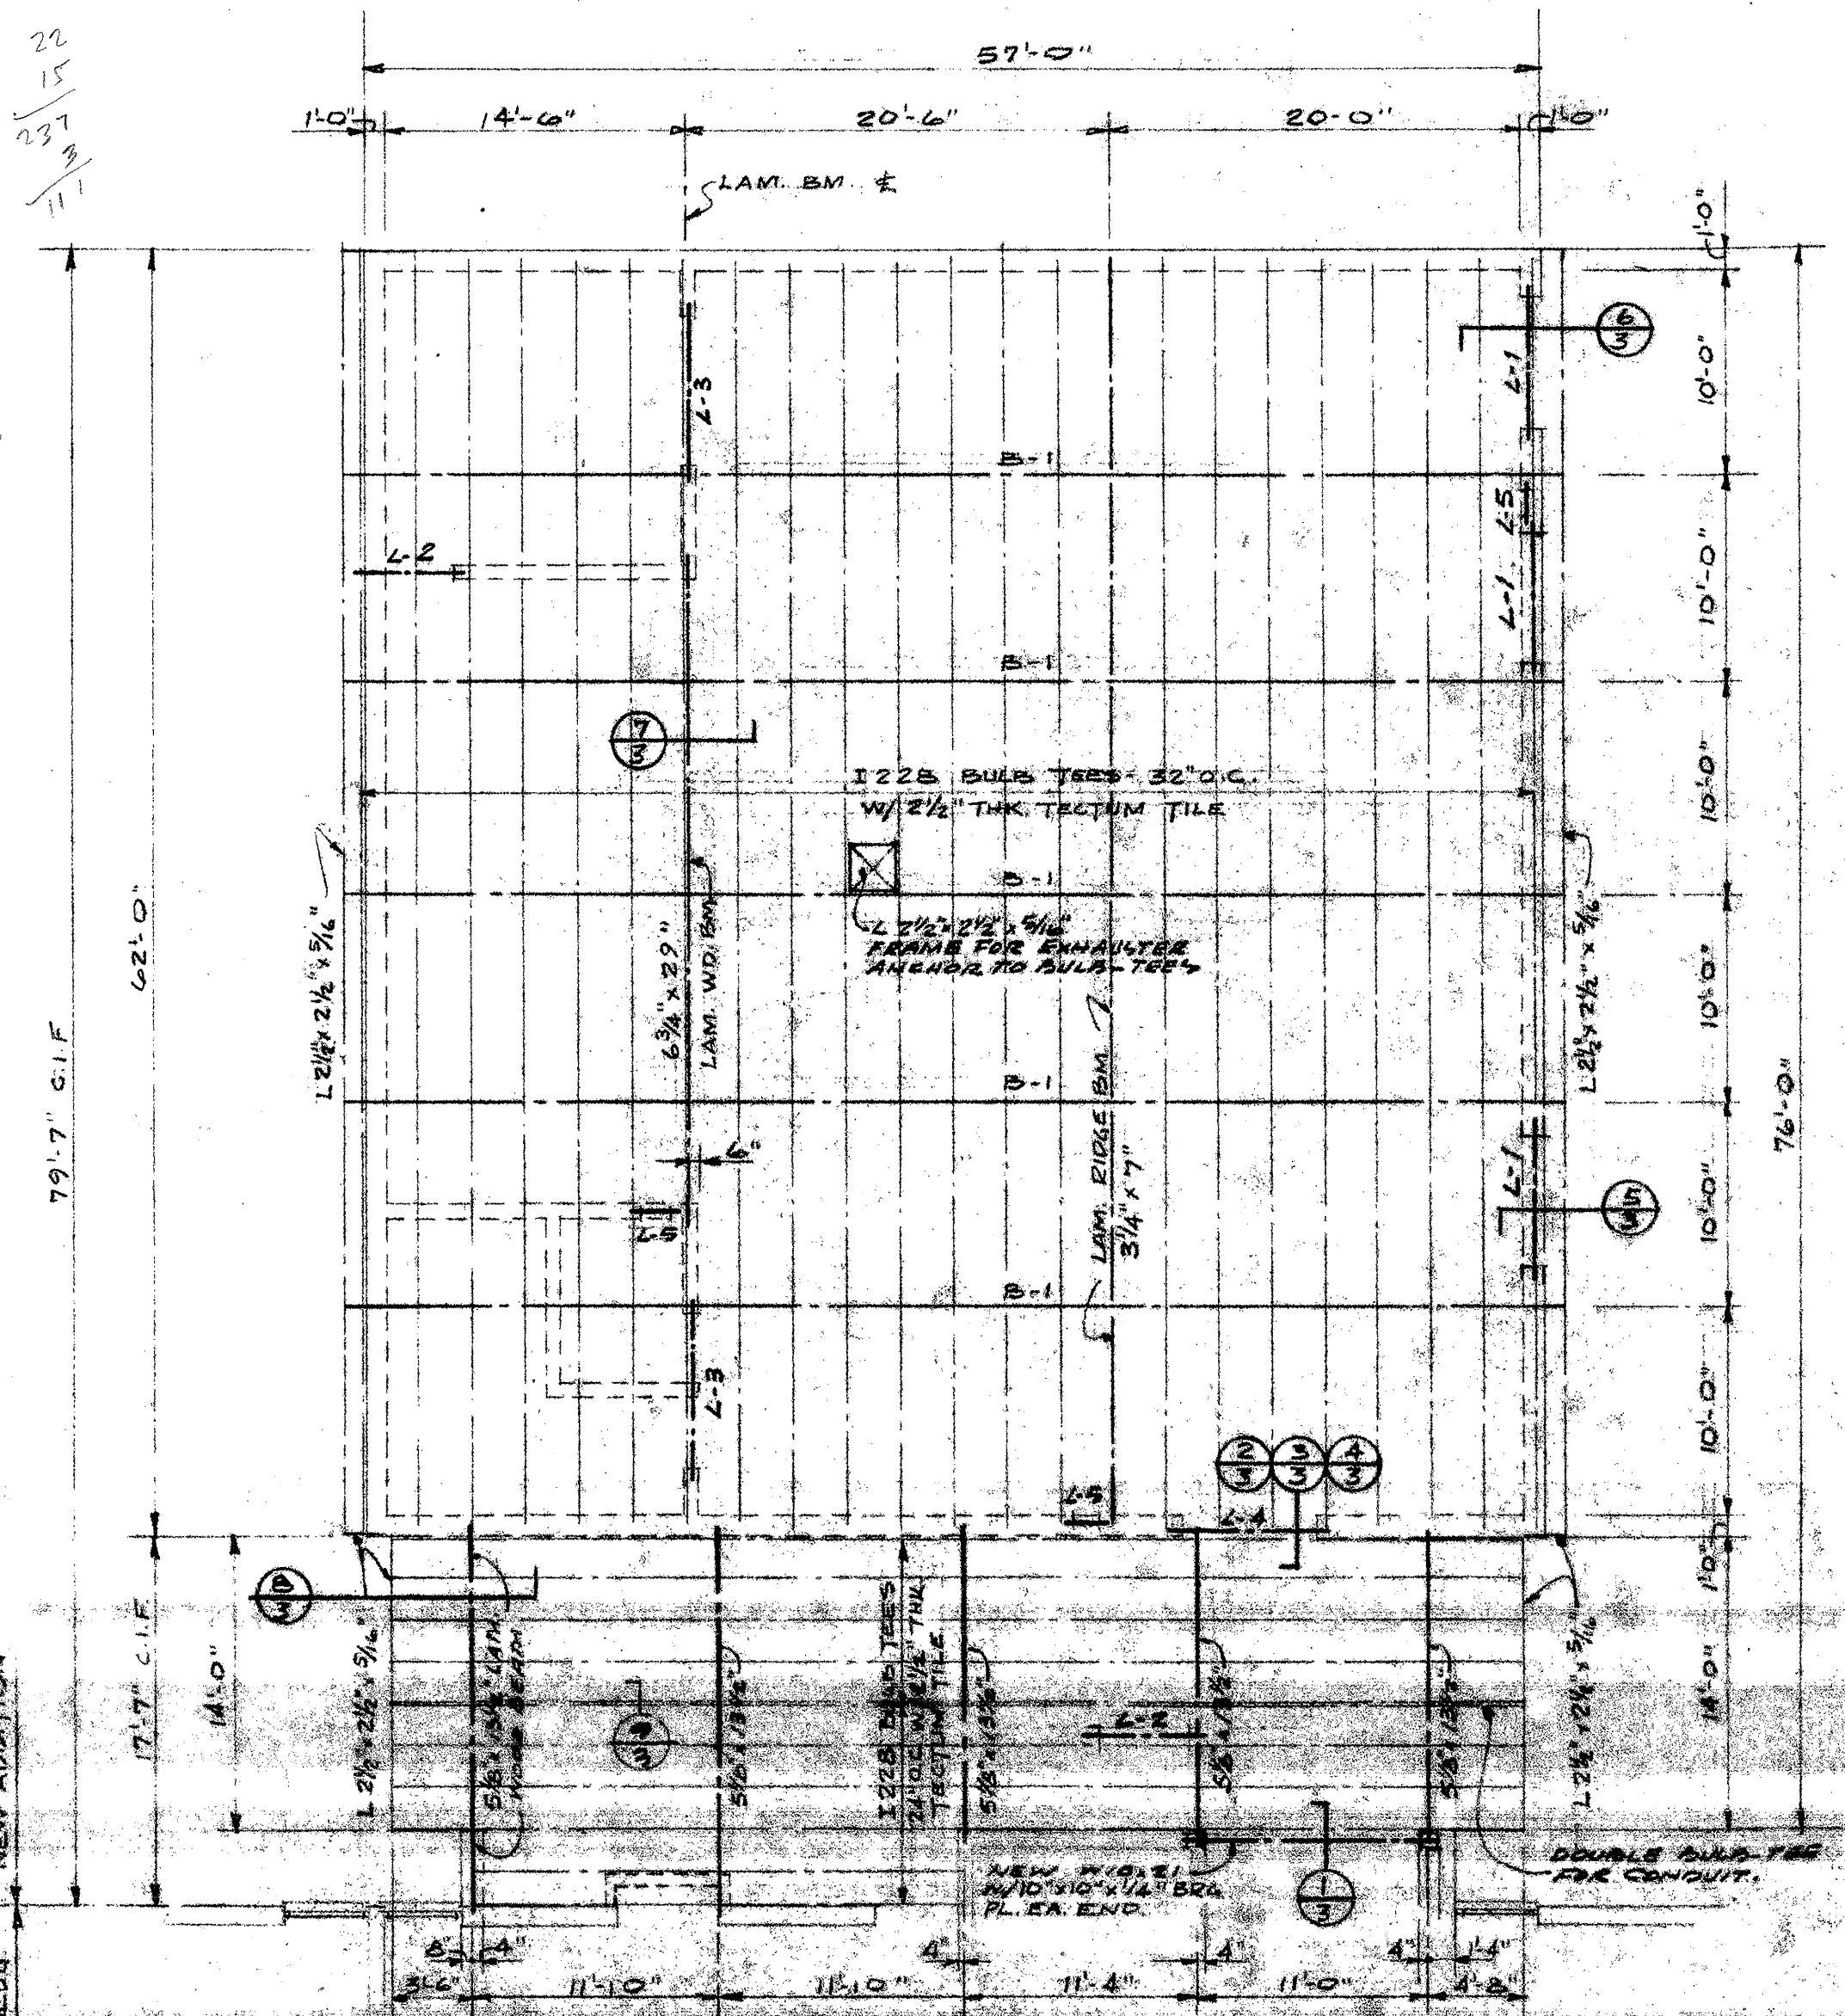

FASCIA DETAIL $\frac{8}{3}$
 $1\frac{1}{2}'' = 1' 10''$

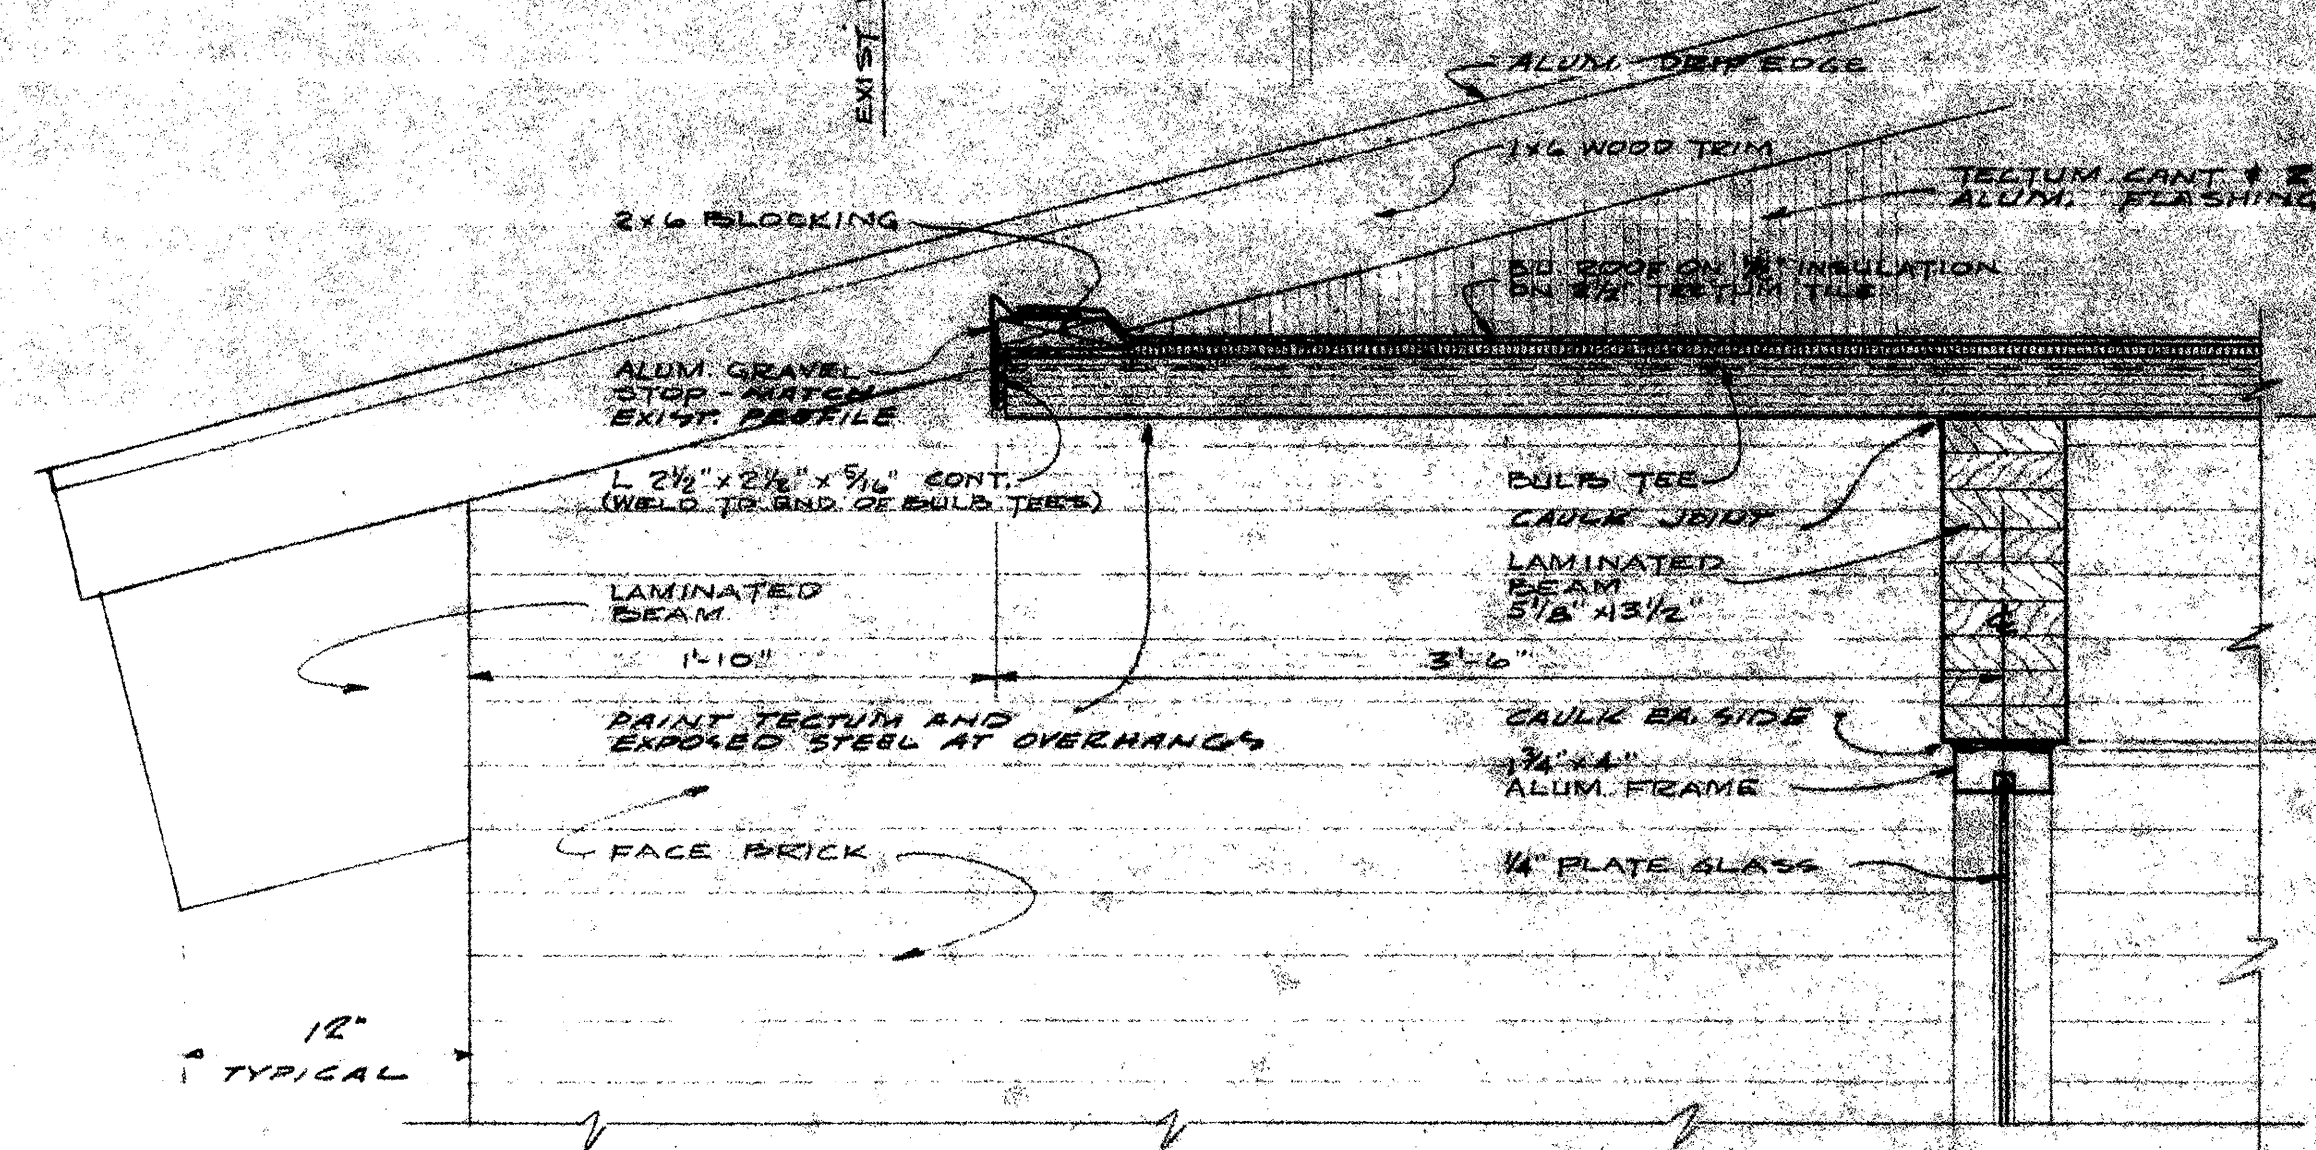

FASCIA DETAIL $\frac{8}{3}$
 $1\frac{1}{2}'' = 1' 10''$

LINTEL SCHEDULE

L-1 3-5 1/2" x 5" x 5/16" L-2 7-8
L-2 2-3 1/4" x 3 1/4" x 5/16" 6-6 x 4-1
L-3 2-3 1/4" x 5" x 5/16" L-3 8-4
L-4 1-3 1/2" x 5" x 5/16" L x 7-8
1-5" x 5" x 5/16" L x 7-8
L-5 1-7 1/2" x 5/16" 12 x 2-0"

PRELIMINARY PLANS
NOT FOR CONSTRUCTION

NORTH

NORTH [

NO SCALE

NO SCALE

MECHANICAL & ELECTRICAL PLANS & DETAILS