

ADDENDUM NO. 04

August 19, 2026

Oak Hill United School Corporation – Multi-School MEP Improvements
405 South Washington St, Swayzee, IN 46986
7760 Delphi Pike, Converse, IN 46919
600 Walnut St, Converse, IN 46919

TO: ALL BIDDERS OF RECORD

This Addendum forms a part of and modifies the Bidding Requirements, Contract Forms, Contract Conditions, the Specifications and the Drawings dated July 20, 2026, by Gibraltar Design. Acknowledge receipt of the Addendum in the space provided on the Bid Form. Failure to do so may subject the Bidder to disqualification.

This Addendum consists of Pages ADD 4-1 through ADD 4-2 and attached Gibraltar Design Addendum No. 03 dated August 14, 2026, consisting of two (2) pages and twenty-two (22) drawings.

A. SPECIFICATION SECTION 01 12 00 – MULTIPLE CONTRACT SUMMARY

1. Paragraph 3.03 Bid Categories

A. BID CATEGORY NO. 1 – GENERAL TRADES

Add the following Specification

Section 07 27 31 Air Infiltration Barrier

Add Specification Section 07 27 31 Air Infiltration Barrier, included in this Addendum to the Project Manual.

B. BID CATEGORY NO. 3 – HVAC and CONTROLS

Add the following Clarification to paragraph 2.09.A.2

Section 23 88 00 Ductwork and Accessories

In addition to Nailor, other acceptable louver manufacturers are Pottorff, Greenheck, NCA, Arrow-United, or Ruskin.

ADDENDUM FOUR

Addendum Four (AD.04) to the drawings and specifications prepared by Gibraltar Design for **Mechanical Improvements Across Three Schools** for Oak Hill United School Corporation Converse, Indiana.

All Contractors bidding on this project shall read all of the items covered below and shall comply with all of the requirements as set forth, including any necessary refinements or additions generated by this Addendum and required by the intent of the original contract documents. All Contractors shall acknowledge on their bid form that they have received this Addendum and include the appropriate content of same within their bid proposal.

SPECIFICATIONS

1. Specification 07 27 31

Air Infiltration Barrier

- A. Add Specification Section 07 27 31 Air Infiltration Barrier, included in this Addendum to the Project Manual.

2. Specification 23 88 00

Ductwork and Accessories

- A. Add the following to paragraph 2.09.A.2:

2.09.A.2

In addition to Nailor, other acceptable louver manufactures are Pottorff, Greenheck, NCA, Arrow-United, or Ruskin.

DRAWINGS

CONVERSE ELEMENTARY SCHOOL

3. Sheets ED101, ED102, and ED103

- A. Refer to revised, full-size drawings, included in this Addendum, for revisions.

4. Sheet EL102

- A. Refer to revised, full-size drawing, included in this Addendum, for revisions.

5. Sheets EP101, EP102, and EP103

- A. Refer to revised, full-size drawings, included in this Addendum, for revisions.

SWAYZEE ELEMENTARY SCHOOL

1. Sheets ED101, ED102, and ED103

- A. Refer to revised, full-size drawings, included in this Addendum, for revisions.

2. Sheets EP101, EP102, and EP103

- A. Refer to revised, full-size drawings, included in this Addendum, for revisions.

OAK HILL JUNIOR HIGH SCHOOL**3. Sheet G-101**

- A. Refer to revised, full-size drawing, included in this Addendum, for revisions.

4. Sheet A-901

- A. Refer to revised, full-size drawing, included in this Addendum, for revisions.

5. Sheets ED101, and ED102

- A. Refer to revised, full-size drawings, included in this Addendum, for revisions.

6. Sheets EP101, and EP102

- A. Refer to revised, full-size drawings, included in this Addendum, for revisions.

7. Sheets EP205, and EP206

- A. Refer to revised, full-size drawings, included in this Addendum, for revisions.

8. Sheet E-601

- A. Refer to revised, full-size drawing, included in this Addendum, for revisions.

Pages 1 through 2, inclusive, One (1) Specification Section, and Twenty-Two (22) Full-Size Drawings, constitute the total makeup of **Addendum Four**.



- ### SHEET NOTES
- REMOVE EXISTING MECHANICAL EQUIPMENT ELECTRICAL CONNECTION AND ALL ASSOCIATED WIRING AND EXPOSED CONDUIT BACK TO SOURCE. GRIND ANY CONDUIT LEFT WITHIN THE FLOOR BELOW THE FLOOR LINE, INFILL WITH CONCRETE, AND FINISH FLUSH WITH FLOOR. COMPLETE AS REQUIRED. ALL WIRING SHALL BE REMOVED. LABEL EXISTING CIRCUIT BREAKER FOR USE WITH NEW EQUIPMENT IN THIS SPACE. REFER TO THE NEW POWER PLANS FOR ADDITIONAL INFORMATION.
 - REMOVE AND REINSTALL EXISTING LIGHTING, PROJECTORS, WIRELESS TERMINALS, OCCUPANCY SENSORS, AND OTHER CEILING MOUNTED DEVICES IN THIS SPACE AS REQUIRED FOR THE INSTALLATION OF THE NEW DUCTWORK, GRILLES, AND BULKHEAD. DEVICE LOCATIONS ARE DIAGRAMMATIC. VERIFY EXACT LOCATION IN FIELD. THE EXISTING LIGHTING LAYOUT SHALL BE MODIFIED AS REQUIRED FOR THE NEW BULKHEAD. COORDINATE LIGHTING LOCATIONS WITH NEW GRILLES IN FIELD. COMPLETE AS REQUIRED.
 - EXISTING MECHANICAL EQUIPMENT TO REMAIN.
 - IN THIS SPACE, REMOVE ALL EXISTING LIGHT FIXTURE ELECTRICAL CONNECTIONS INCLUDING ALL ASSOCIATED CONDUIT AND WIRING BACK TO NEAREST JUNCTION BOX. EXTEND NEW #12 WIRING IN 3/4" FMC FROM EXISTING JUNCTION BOX TO ALL EXISTING LIGHT FIXTURES AND CONNECT. COMPLETE AS REQUIRED. MAXIMUM FMC LENGTH IS 6'. PROVIDE NEW 3/4" EMT AS REQUIRED FOR LENGTHS EXCEEDING 6'.
 - REMOVE AND RELOCATE LIGHT FIXTURES ALONG THE WALL WITH THE NEW VUV. PRIOR TO REMOVAL, COORDINATE WITH THE NEW SCFFIT LOCATION TO DETERMINE IF THE FIXTURES ARE IN CONFLICT WITH THE BULKHEAD. PROVIDE A LIST OF SPACES WHERE THE BULKHEAD AND FIXTURES ARE NOT IN CONFLICT TO THE ARCHITECT/ENGINEER FOR REVIEW PRIOR TO PROCEEDING.
 - ALL FIXTURES IN THIS SPACE SHALL BE PROVIDED WITH SUPPORTS TO SUSPEND THE FIXTURE FROM THE ROOF STRUCTURE, INDEPENDENT OF THE CEILING GRID. PROVIDE A MINIMUM OF FOUR (4) RODS OR WIRES PER FIXTURE, NOT MORE THAN 6" FROM EACH CORNER.
 - REMOVE AND RELOCATE EXISTING WIREMOLD AND OTHER SURFACE MTD DEVICES ONTO NEW WALL.
 - REFER TO THE NEW PLANS FOR THE NEW LOCATION OF UNIT VENTILATOR. ANY EXISTING CONDUIT, WIRING, ETC. SERVING OTHER DEVICES OR EQUIPMENT IN THE NEW UNIT VENTILATOR LOCATION (INTERIOR OR EXTERIOR) SHALL BE MAINTAINED. REROUTE CONDUIT THROUGH, AROUND, OR ABOVE THE NEW UNIT VENTILATOR AS REQUIRED TO MAINTAIN EXISTING CIRCUIT CONTINUITY. ANY DEVICES IN CONFLICT WITH THE NEW LOCATIONS SHALL BE REMOVED AND RELOCATED TO THE SIDE OF THE UNIT. VERIFY THE FINAL LOCATION OF ANY DEVICES IN FIELD.


AD-04

DEMOLITION NOTES

- COORDINATE PHASING OF WORK AND PROVIDE TEMPORARY POWER AND SERVICES AS REQUIRED FOR THE IMPLEMENTATION OF ALL WORK WHILE MAINTAINING SERVICES TO PORTIONS OF BUILDING TO REMAIN OCCUPIED.
- DISCONNECT AND REMOVE EXISTING ELECTRICAL DEVICES, EQUIPMENT, LIGHTING, WIRING, ETC., AS REQUIRED TO FACILITATE DEMOLITION AND RECONSTRUCTION WORK. COORDINATE WITH GENERAL CONSTRUCTION. THE CONTRACTOR IS HEREBY ADVISED THAT THESE DRAWINGS MAY NOT INDICATE ALL EXISTING WIRING AND/OR EQUIPMENT WHICH MUST BE REMOVED, REWORKED, RELOCATED, ETC., TO ACCOMMODATE DEMOLITION AND RECONSTRUCTION WORK IN THE EXISTING BUILDING.
- SCHEDULE ALL WORK TO AVOID DOWNTIME AND INCONVENIENCE TO OWNER. OWNER'S EXISTING FACILITY SHALL REMAIN IN OPERATION AT ALL TIMES, INCLUDING FIA AND OTHER SPECIAL SYSTEMS, ELECTRICAL POWER DISTRIBUTION, ETC. ALL REQUIRED SHUTDOWN OF EXISTING FACILITY UTILITIES SHALL BE SCHEDULED WITH OWNER'S OPERATING PERSONNEL.
- ALL EXISTING EQUIPMENT SHALL REMAIN PROPERTY OF THE OWNER AND OWNER SHALL DETERMINE IF CONTRACTOR IS TO STORE EQUIPMENT ON SITE AT OWNER SELECTED LOCATION OR IF CONTRACTOR IS TO ABANDON OR REMOVE EQUIPMENT FROM SITE.
- CONTRACTOR TO FIELD VERIFY IF EXISTING ASBESTOS WILL BE ENCOUNTERED PRIOR TO STARTING ANY WORK. IF ASBESTOS IS PRESENT, THE OWNER WILL PROVIDE FOR THE REMOVAL OF ANY MATERIAL CONTAINING ASBESTOS. SEE SPECIFICATIONS FOR FURTHER REQUIREMENTS.
- ANY HIDDEN CONDITIONS IDENTIFIED THROUGH THE COURSE OF CONSTRUCTION SHALL BE IMMEDIATELY BROUGHT TO THE ATTENTION OF THE ARCHITECT IN WRITTEN FORM FOR REVIEW AND DIRECTION. FAILURE TO DO SO SHALL MAKE THE CONTRACTOR RESPONSIBLE FOR ANY AND ALL REQUIRED CHANGES AND COSTS TO CORRECT SAID HIDDEN CONDITION.
- EXISTING INFORMATION IDENTIFIED ON THE CONTRACT DOCUMENTS IS SCHEMATIC ONLY AS AN AID TO THE CONTRACTOR. CONTRACTOR SHALL BE RESPONSIBLE TO PROPERLY ADDRESS ALL EXISTING CONDITIONS FOR A COMPLETE AND PROPER INSTALLATION OF NEW SYSTEMS. ALL EXISTING EQUIPMENT NOT IDENTIFIED SHALL BE BROUGHT TO THE ATTENTION OF THE ARCHITECT/ENGINEER FOR REVIEW AS TO WHETHER THE EQUIPMENT SHALL REMAIN AND BE RECONNECTED TO THE NEW SERVICES, BE RELOCATED, BE ABANDONED, ETC.
- DISCONNECT AND REMOVE EXISTING LIGHTING FIXTURES AND ANY OTHER CEILING DEVICES AS REQUIRED FOR INSTALLATION OF WORK (ALL TRADES). REINSTALL UPON COMPLETION OF WORK. REPAIR ALL DAMAGED FIXTURES AND DEVICES.
- VISIT SITE PRIOR TO BIDDING TO DETERMINE ALL FIELD CONDITIONS. VERIFY ALL EXISTING INTERIOR AND EXTERIOR ELECTRICAL SYSTEMS TO VERIFY QUANTITIES AND LOCATIONS OF EXISTING SYSTEMS TO DETERMINE FULL EXTENT OF DEMOLITION WORK.
- ALL EXISTING LIGHTING FIXTURES, ELECTRICAL DEVICES, CONDUIT, ETC., SHALL BE REMOVED AS NOTED ON DRAWINGS AND AS REQUIRED TO MEET NEW SCOPE OF WORK. ALL EXISTING ELECTRICAL EQUIPMENT SHALL REMAIN PROPERTY OF THE OWNER AND SHALL BE PROPERLY STORED ON SITE, OR DESIGNATED TO BE ABANDONED AND REMOVED FROM SITE AS DIRECTED BY OWNER.
- EXISTING ELECTRICAL DEVICES (RECEPTACLES, SWITCHES, OUTLET BOXES, CONDUIT, ETC.) WITHIN WALLS TO BE REMOVED SHALL BE DISCONNECTED COMPLETELY. REROUTE CIRCUITRY AS REQUIRED TO MAINTAIN CIRCUIT CONTINUITY FOR ALL REMAINING DEVICES/EQUIPMENT. VERIFY EXACT CONDITIONS AND QUANTITIES IN FIELD.
- PATCH ALL EXISTING CEILING, FLOOR, WALL AND ROOF OPENINGS AND SURROUNDING FINISHES RESULTING FROM REMOVAL OF EXISTING MATERIALS AND EQUIPMENT. SO THAT FINISH WILL MATCH EXISTING IN SURROUNDING AREAS.

GENERAL NOTES

- REFER TO THE ARCHITECTURAL RCP FOR FINAL CONFIRMATION OF CEILING WORK SCOPE. ROOMS ARE TAGGED ON THIS SHEET (SEE SHEET NOTE "2") FOR CONVENIENCE, BUT FINAL SCOPE SHALL BE VERIFIED WITH THE ARCHITECTURAL RCP.

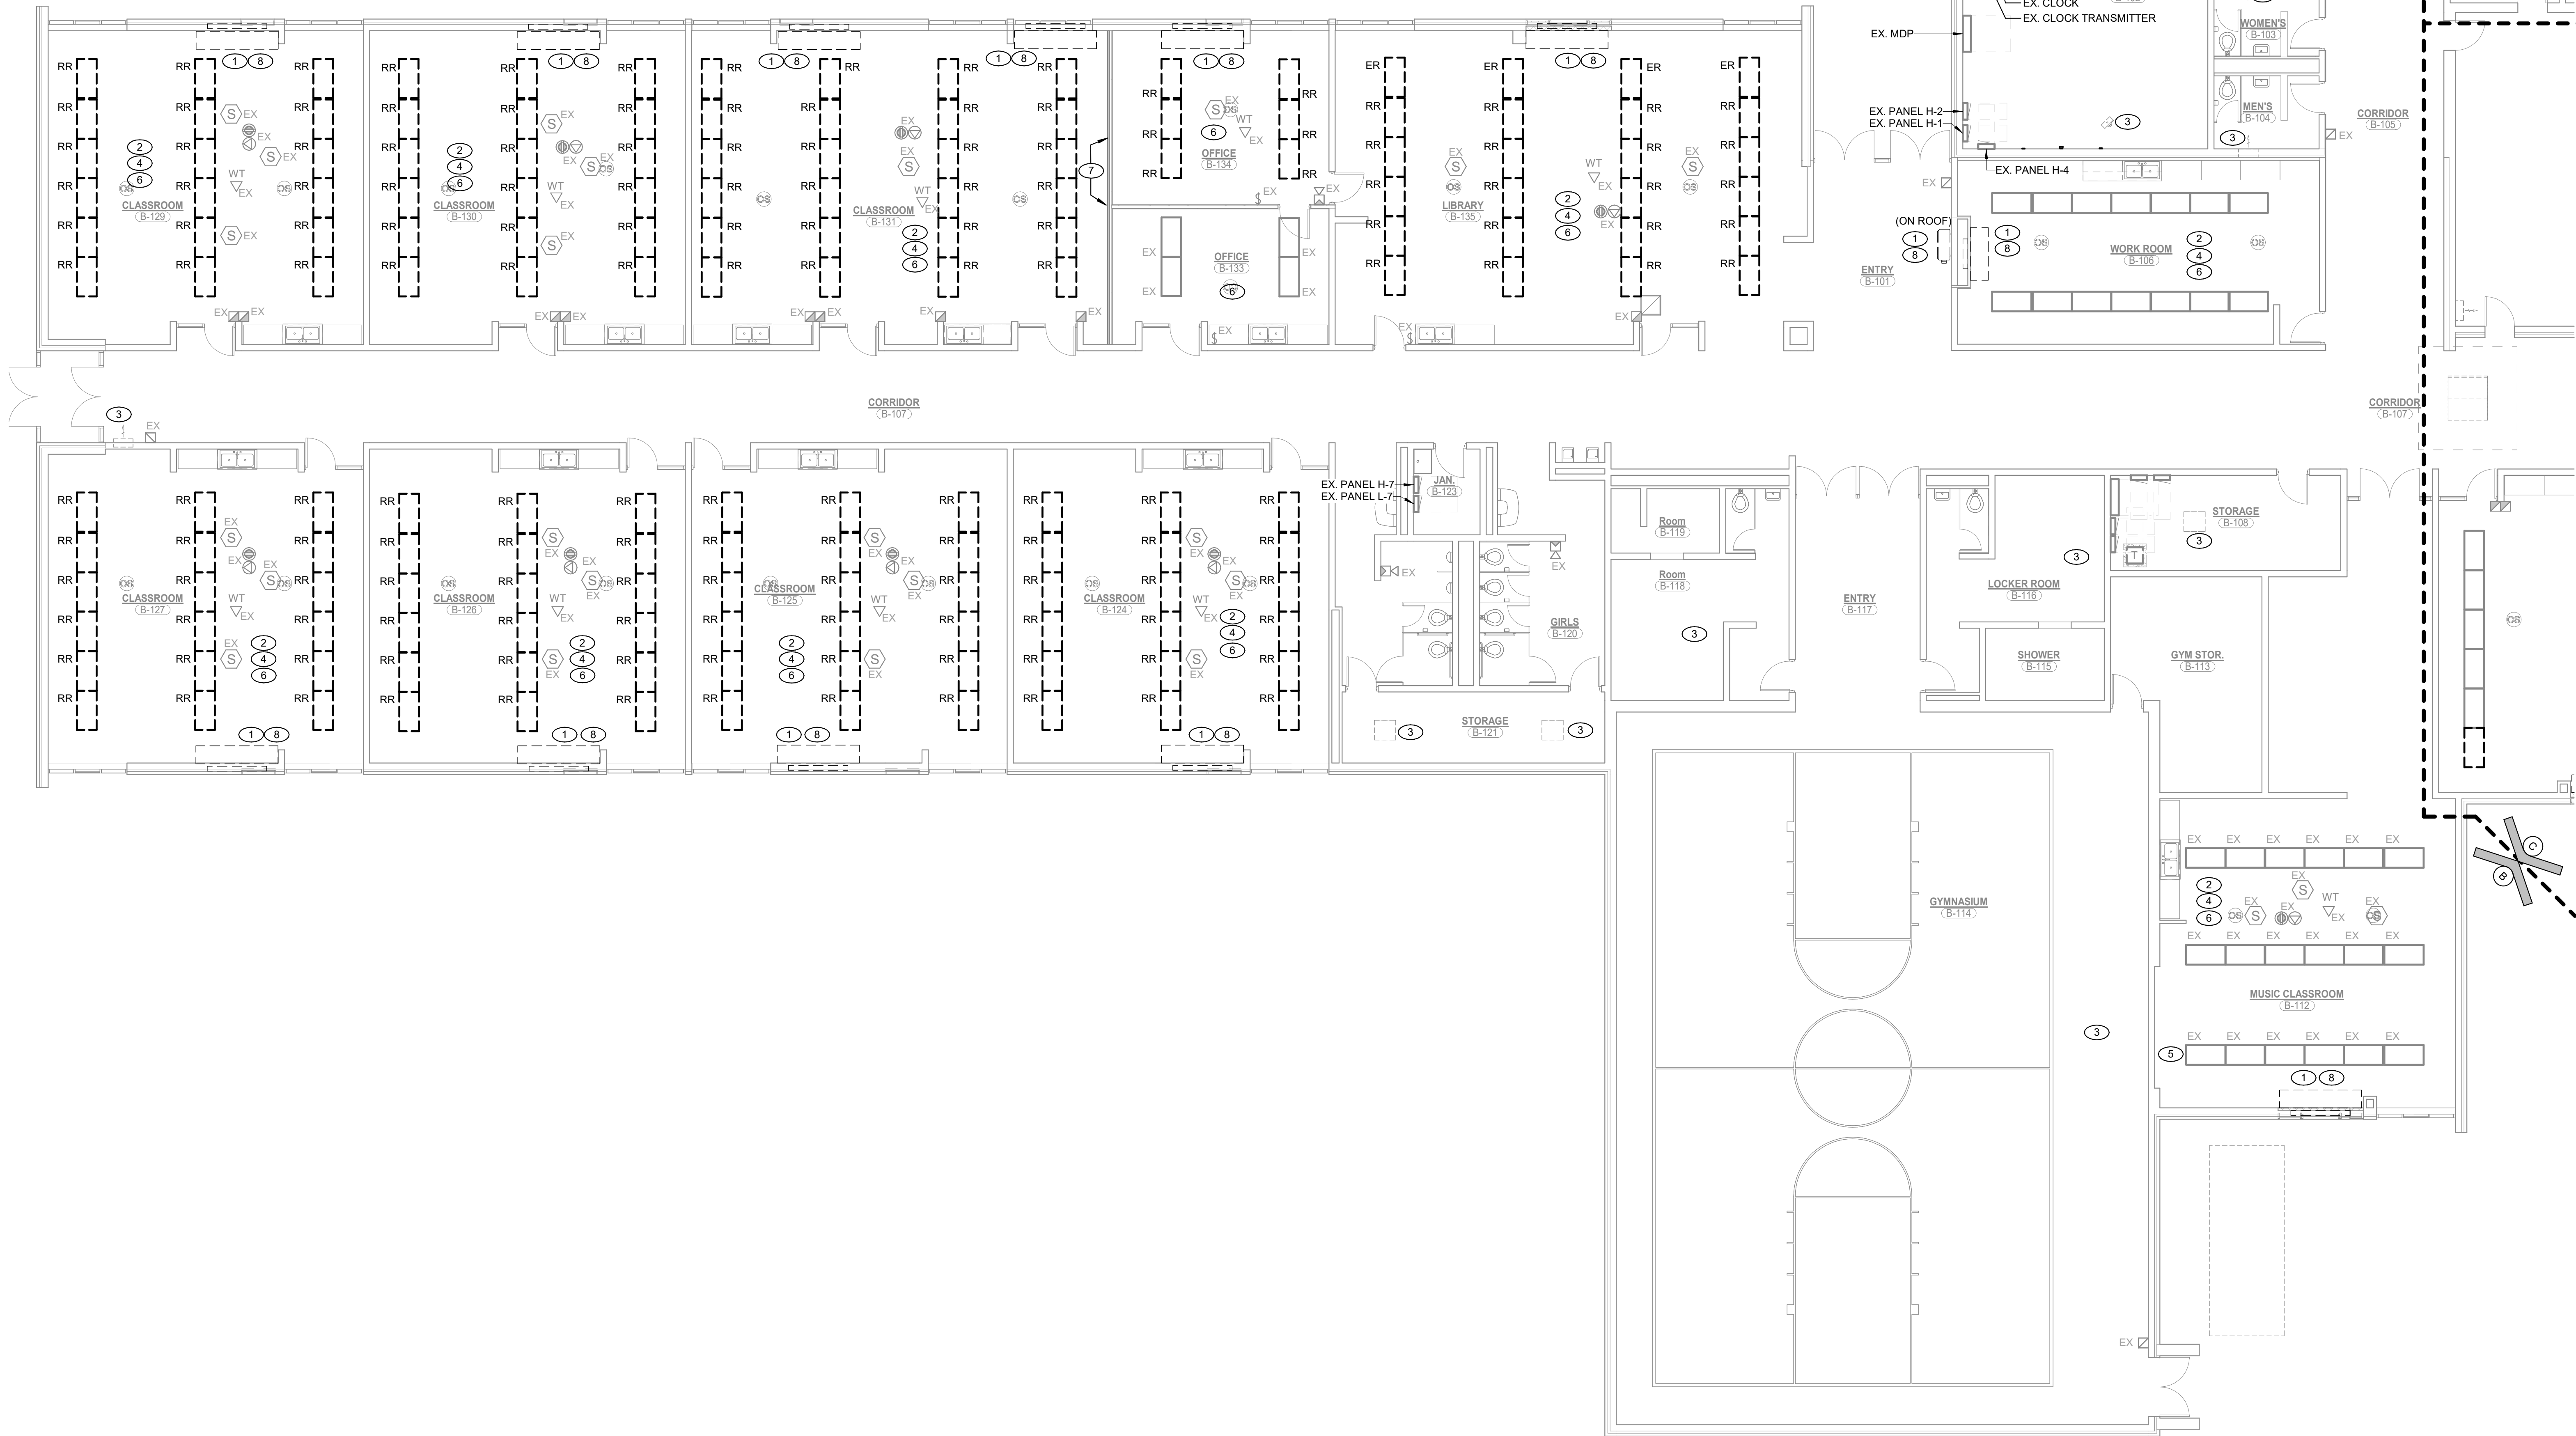


PROJECT:

CONVERSE ES - MECHANICAL IMPROVEMENTS

OAK HILL UNITED SCHOOL
CORPORATION

600 WALNUT ST,
CONVERSE, IN, 46919

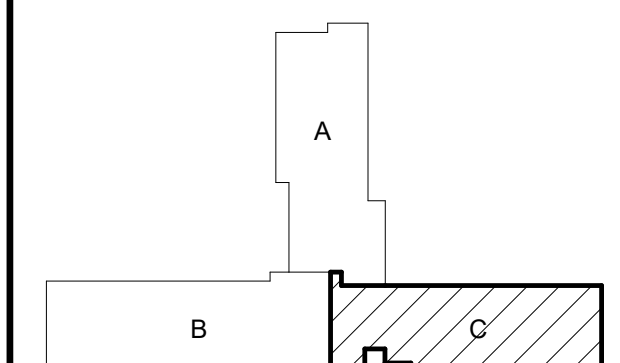

KEY PLAN

100% CONSTRUCTION
DOCUMENTS

GIBRALTAR DESIGN

9102 N. Meridian St., Ste. 300
Indianapolis, IN 46260
Homepage: www.GibraltarDesign.com
Email: info@GibraltarDesign.com
Phone 317.580.5777 Fax 317.580.5778

PROJECT

25-173
DATE:DATE
07/20/26

COORDIN

RH
DRAWN BY

BR/MH

CHECKED
D.J.

COPYRIGHT NOTICE:

THE CONCEPTS, DESIGNS, PLANS, DETAILS, ETC. SHOWN ON THIS DOCUMENT ARE THE PROPERTY OF GIBRALTAR DESIGN AND WERE CREATED FOR USE ON THIS SPECIFIC PROJECT. NONE OF THIS INFORMATION SHALL BE USED BY ANY PERSON OR FIRM FOR ANY PURPOSE WITHOUT THE EXPRESS WRITTEN CONSENT OF GIBRALTAR DESIGN. THE OWNER MAY RETAIN COPIES FOR INFORMATION AND REFERENCE IN CONNECTION ONLY WITH THIS PROJECT.

REVISIONS

MARK	DATE	ISSUED FOR
AD-02	08/07/26	ADDENDUM 0
AD-04	08/19/26	ADDENDUM 0

DRAWING
PARTIAL FIRST FLOOR
ELECTRICAL DEMOLITION PLAN

PROJECT
CONVERSE ES - MECHANICAL
IMPROVEMENTS

© GIBALTAR
DESIGN

SHEET

C

ED103

Copyright © 2016, Morgan Kaufmann Publishers, Inc.

SHEET NOTES


1. REMOVE EXISTING MECHANICAL EQUIPMENT ELECTRICAL CONNECTION AND ALL ASSOCIATED WIRING AND EXPOSED CONDUIT BACK TO SOURCE. GRIND ANY CONDUIT LEFT UNDER THE FLOOR BELOW THE FLOOR LINE. INFILL WITH CONCRETE, AND FINISH WITH FLOOR. COMPLETE AS REQUIRED. ANY REMAINING WIRING SHALL BE REMOVED. LABEL EXISTING CIRCUIT BREAKER FOR USE WITH NEW EQUIPMENT IN THIS SPACE. REFER TO THE NEW POWER PLANS FOR ADDITIONAL INFORMATION.
2. REMOVE AND REINSTALL EXISTING LIGHTING, PROJECTORS, WIRELESS TERMINALS, OCCUPANCY SENSORS, AND OTHER CEILING MOUNTED DEVICES IN THIS SPACE AS REQUIRED FOR THE INSTALLATION OF THE NEW DUCTWORK, GRILLES, AND BULKHEAD. DEVICE LOCATIONS ARE DIAGRAMMATIC. VERIFY EXISTING LOCATION IN FIELD. VERIFY NEW LOCATION IN FIELD. MODIFIED AS REQUIRED FOR THE NEW BULKHEAD. COORDINATE LIGHTING LOCATIONS WITH NEW GRILLES IN FIELD. COMPLETE AS REQUIRED.
3. EXISTING MECHANICAL EQUIPMENT TO REMAIN.
4. IN THIS SPACE, REMOVE ALL EXISTING LIGHT FIXTURE ELECTRICAL CONNECTIONS INCLUDING ALL ASSOCIATED CONDUIT AND WIRING BACK TO NEAREST JUNCTION BOX. EXTEND NEW #12 WIRING IN 3/4" FMC FROM EXISTING JUNCTION BOX TO ALL NEW LIGHT FIXTURES. CONDUIT SHALL BE COMPLETE AS REQUIRED. MAXIMUM FMC LENGTH IS 6'. PROVIDE NEW 3/4" EMT AS REQUIRED FOR LENGTHS EXCEEDING 6'.
5. ALL FIXTURES IN THIS SPACE SHALL BE PROVIDED WITH SUPPORTS TO SUSPEND THE FIXTURE FROM THE ROOF STRUCTURE. INDEPENDENT OF THE CEILING GRID. PROVIDE A MINIMUM OF FOUR (4) ROUNDS OF WIRES PER FIXTURE. PROVIDE A MINIMUM OF FOUR (4) ROUNDS OF WIRES PER FIXTURE.
6. REFER TO THE NEW PLANS FOR THE NEW LOCATION OF UNIT VENTILATOR. ANY EXISTING CONDUIT, WIRING, ETC. SERVING OTHER DEVICES OR EQUIPMENT IN THE NEW UNIT VENTILATOR LOCATION (INTERIOR OR EXTERIOR) SHALL BE REMOVED. REMOVE ALL EXISTING WIRING AND CONDUIT FROM THE NEW UNIT VENTILATOR AS REQUIRED TO MAINTAIN EXISTING CIRCUIT CONTINUITY. ANY DEVICES IN CONFLICT WITH THE NEW LOCATIONS SHALL BE REMOVED AND DISPOSED TO THE SIDE OF THE UNIT. VERIFY THE FINAL LOCATION OF ANY DEVICES IN FIELD.

GENERAL NOTES


1. REFER TO THE ARCHITECTURAL RCP FOR FINAL CONFIRMATION OF CEILING WORK SCOPE. ROOMS ARE TAGGED ON THIS SHEET (SEE SHEET NOTE "2") FOR CONVENIENCE, BUT FINAL SCOPE SHALL BE VERIFIED WITH THE ARCHITECTURAL RCP.

DEMOLITION NOTES

- A. COORDINATE PHASING OF WORK AND PROVIDE TEMPORARY POWER AND SERVICES AS REQUIRED FOR THE IMPLEMENTATION OF ALL WORK WHILE MAINTAINING SERVICES TO PORTIONS OF BUILDING TO REMAIN OCCUPIED.
- B. DISCONNECT AND REMOVE EXISTING ELECTRICAL DEVICES, EQUIPMENT, LIGHTING, WIRING, ETC., AS REQUIRED TO FACILITATE DEMOLITION AND RECONSTRUCTION OF WORK WITH GENERAL CONSTRUCTION. THE CONTRACTOR IS HEREBY ADVISED THAT THESE DRAWINGS MAY NOT INDICATE ALL EXISTING WIRING AND/OR EQUIPMENT WHICH MUST BE REMOVED, REWORKED, RELOCATED, ETC., TO ACCOMMODATE DEMOLITION AND RECONSTRUCTION WORK IN THE EXISTING BUILDING.
- C. SCHEDULE ALL WORK TO AVOID DOWNTIME AND INCONVENIENCE TO OWNER. OWNER'S EXISTING FACILITY SHALL REMAIN IN OPERATION AT ALL TIMES, INCLUDING FIA AND OTHER SPECIAL SYSTEMS, ELECTRICAL POWER DISTRIBUTION, ETC.. ALL REQUIRED SHUTDOWN OF EXISTING FACILITY UTILITIES SHALL BE SCHEDULED WITH OWNER'S OPERATING PERSONNEL.
- D. ALL EXISTING EQUIPMENT SHALL REMAIN PROPERTY OF THE OWNER AND OWNER SHALL DETERMINE IF CONTRACTOR IS TO STORE EQUIPMENT ON SITE AT OWNER SELECTED LOCATION OR IF CONTRACTOR IS TO ABANDON OR REMOVE EQUIPMENT FROM SITE.
- E. CONTRACTOR TO FIELD VERIFY IF EXISTING ASBESTOS WILL BE ENCOUNTERED PRIOR TO STARTING ANY WORK. IF ASBESTOS IS PRESENT, THE OWNER WILL PROVIDE FOR THE REMOVAL OF ANY MATERIAL CONTAINING ASBESTOS. SEE SPECIFICATIONS FOR FURTHER REQUIREMENTS.
- F. ANY HIDDEN CONDITIONS IDENTIFIED THROUGH THE COURSE OF CONSTRUCTION SHALL BE IMMEDIATELY BROUGHT TO THE ATTENTION OF THE ARCHITECT IN WRITTEN FORM FOR REVIEW AND DIRECTION. FAILURE TO DO SO SHALL MAKE THE CONTRACTOR RESPONSIBLE FOR ANY AND ALL REQUIRED CHANGES AND COSTS TO CORRECT SAID HIDDEN CONDITIONS.
- G. EXISTING INFORMATION IDENTIFIED ON THE CONTRACT DOCUMENTS IS SCHEMATIC ONLY AS AN AID TO THE CONTRACTOR. CONTRACTOR SHALL BE RESPONSIBLE TO PROPERLY ADDRESS EXISTING CONDITIONS FOR COMPLETE AND PROPER INSTALLATION OF NEW SYSTEMS. ALL EXISTING EQUIPMENT NOT IDENTIFIED SHALL BE BROUGHT TO THE ATTENTION OF THE ARCHITECT/ENGINEER FOR REVIEW AS TO WHETHER THE EQUIPMENT SHALL REMAIN AND BE RECONNECTED TO THE NEW SERVICES, BE RELOCATED, BE ABANDONED, ETC.
- H. DISCONNECT AND REMOVE EXISTING LIGHTING FIXTURES AND ANY OTHER CEILING DEVICES AS REQUIRED FOR INSTALLATION OF WORK (ALL TRADES). REINSTALL UPON COMPLETION OF WORK. REPAIR ALL DAMAGED FIXTURES AND DEVICES.
- I. VISIT SITE PRIOR TO BIDDING TO DETERMINE ALL FIELD CONDITIONS. VERIFY ALL EXISTING INTERIOR AND EXTERIOR ELECTRICAL SYSTEMS TO VERIFY QUANTITIES AND LOCATIONS OF EXISTING SYSTEMS TO DETERMINE FULL EXTENT OF DEMOLITION WORK.
- J. ALL EXISTING LIGHTING FIXTURES, ELECTRICAL DEVICES, CONDUIT, ETC., SHALL BE REMOVED AS NOTED ON DRAWINGS AND AS REQUIRED TO MEET NEW SCOPE OF WORK. ALL EXISTING ELECTRICAL EQUIPMENT SHALL REMAIN PROPERTY OF THE OWNER AND SHALL BE PROPERLY STORED ON SITE, OR DESIGNATED TO BE ABANDONED AND REMOVED FROM SITE AS DIRECTED BY OWNER.
- EXISTING ELECTRICAL DEVICES (RECEPTACLES, SWITCHES, OUTLET BOXES, CONDUIT, ETC.) WITHIN WALLS TO BE REMOVED SHALL BE DISCONNECTED COMPLETELY. REROUTE CIRCUITRY AS REQUIRED TO MAINTAIN CIRCUIT CONTINUITY FOR ALL REMAINING DEVICES/EQUIPMENT. VERIFY EXACT CONDITIONS AND QUANTITIES IN FIELD.
- PATCH ALL EXISTING CEILING, FLOOR, WALL AND ROOF OPENINGS AND SURROUNDING FINISHES RESULTING FROM REMOVAL OF EXISTING MATERIALS AND EQUIPMENT. SO THAT FINISH WILL MATCH EXISTING IN SURROUNDING AREAS.

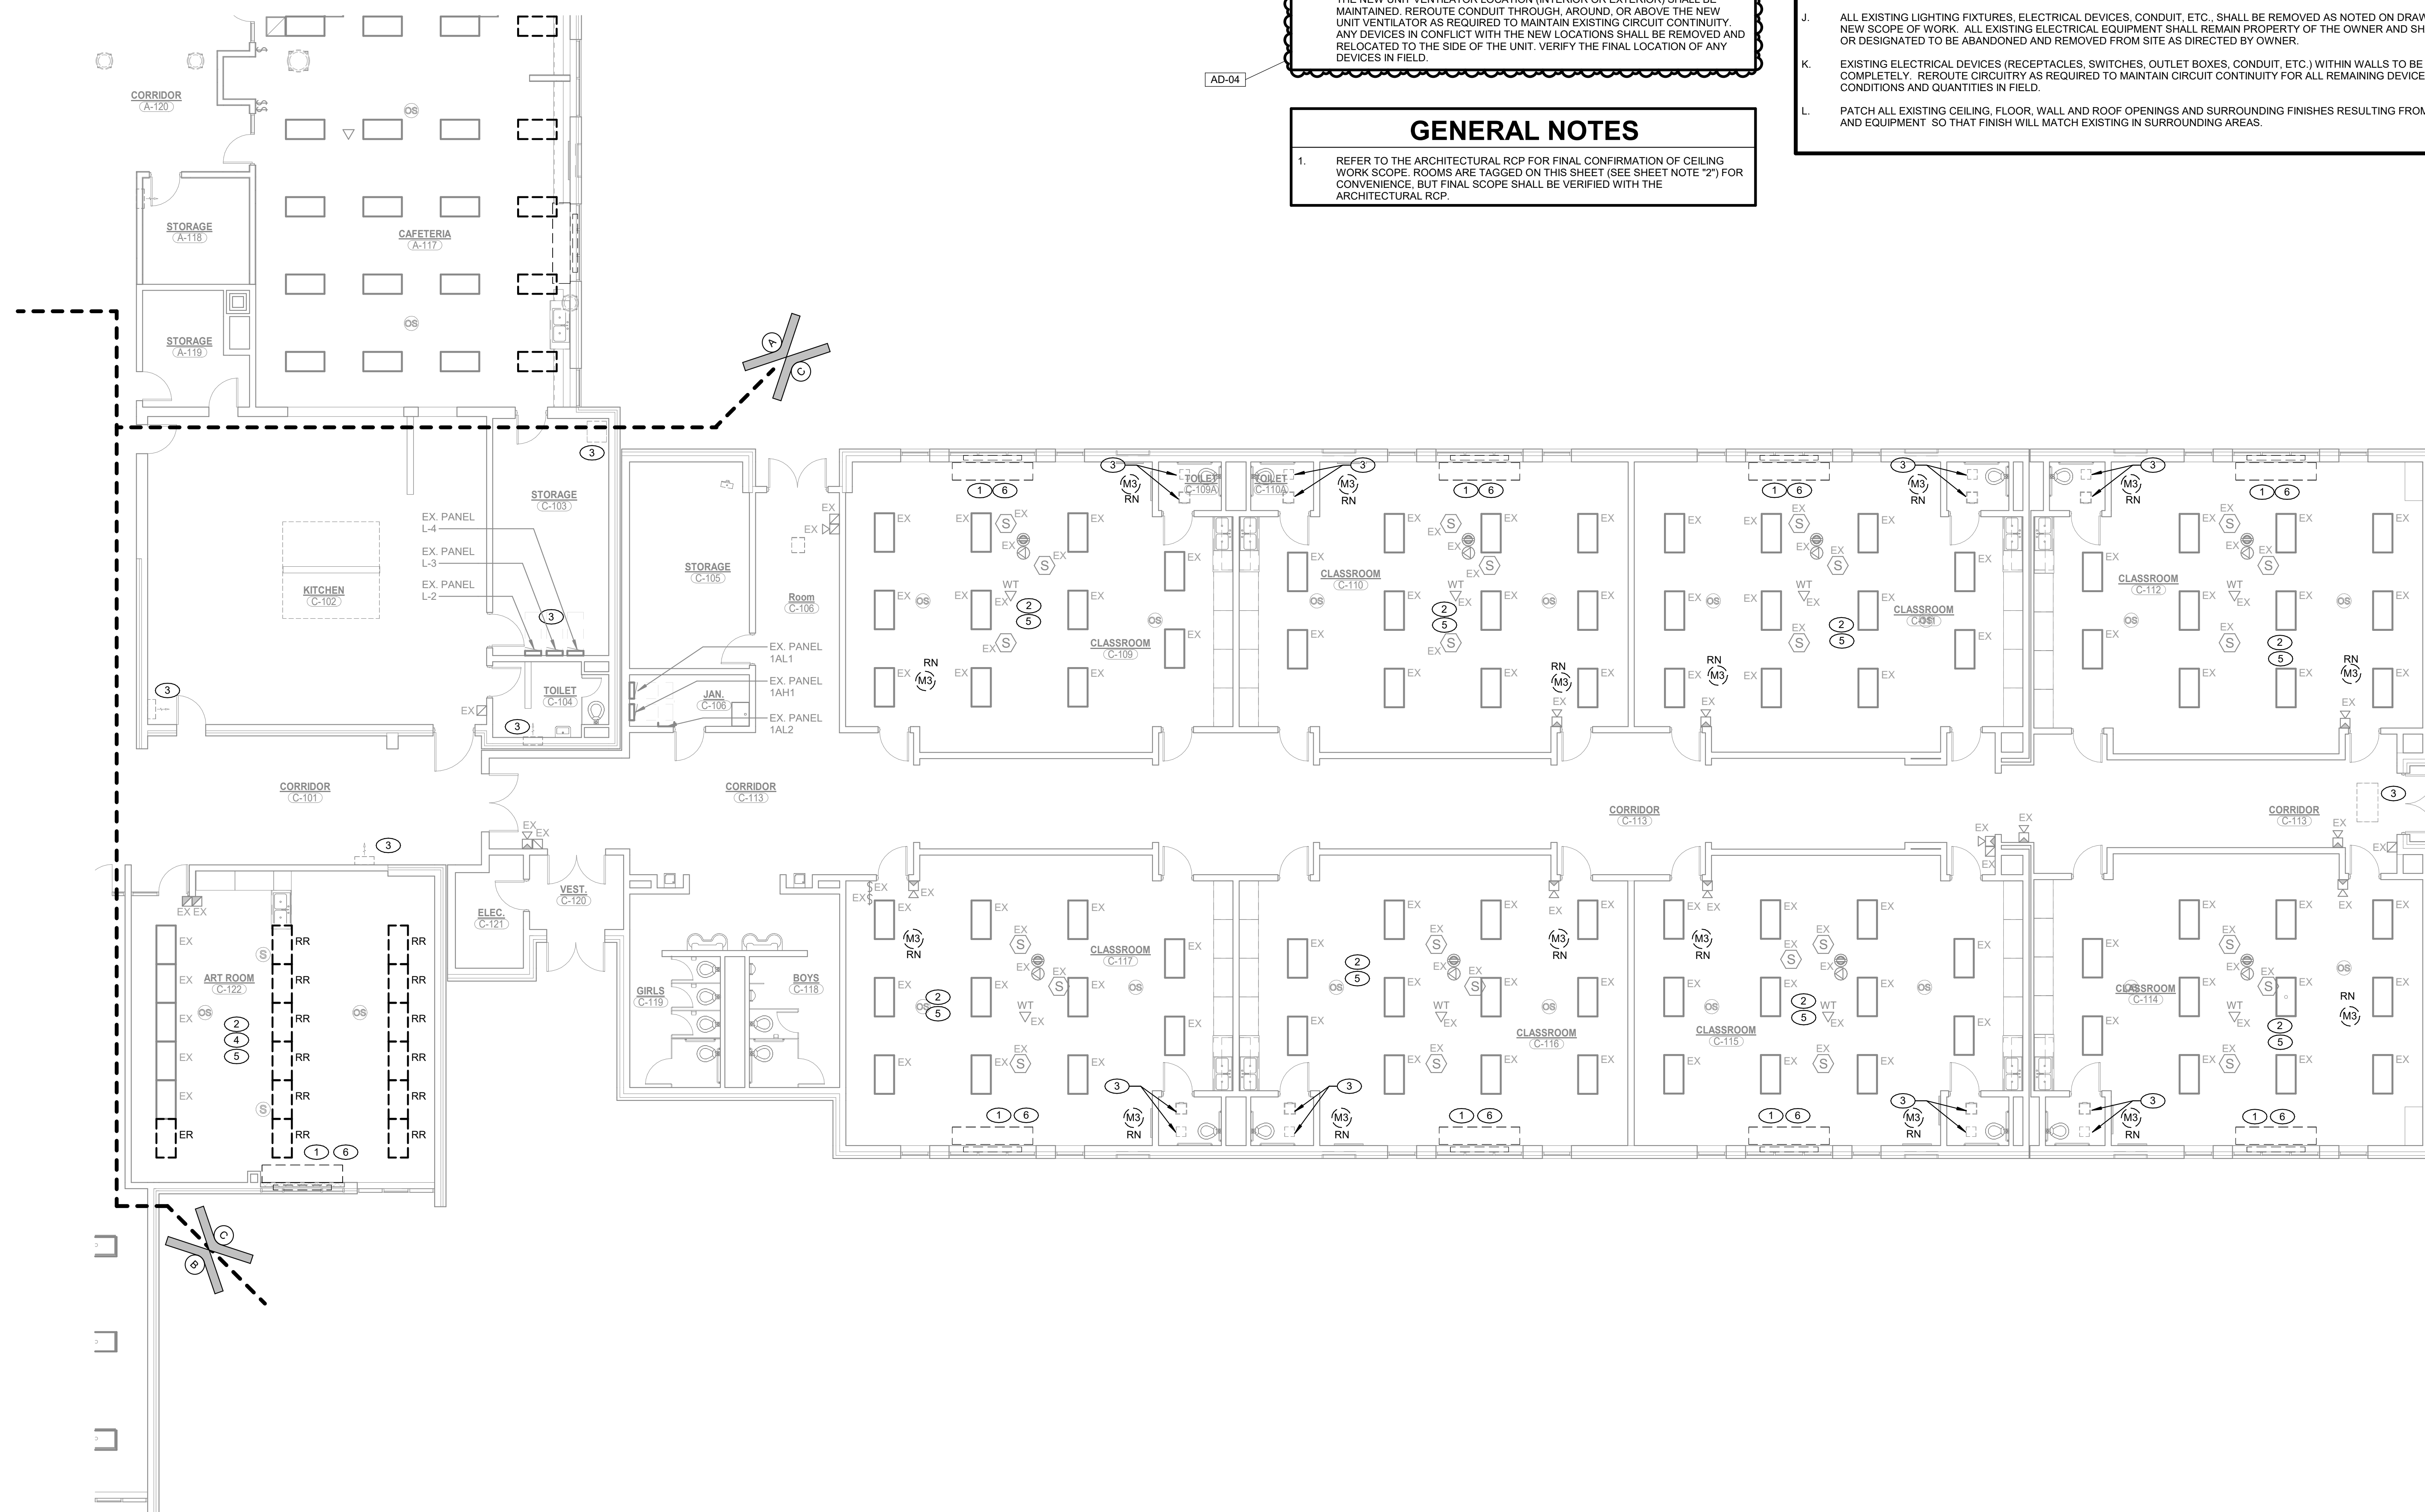

UNIT "C" FIRST FLOOR ELECTRICAL DEMOLITION PLAN

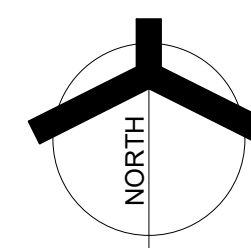



GIBRALTAR
DESIGN


ARCHITECTURE • ENGINEERING • INTERIOR DESIGN



PROJECT:

CONVERSE ES - MECHANICAL IMPROVEMENTS

OAK HILL UNITED SCHOOL
CORPORATION
600 WALNUT ST.,
CONVERSE, IN, 46919

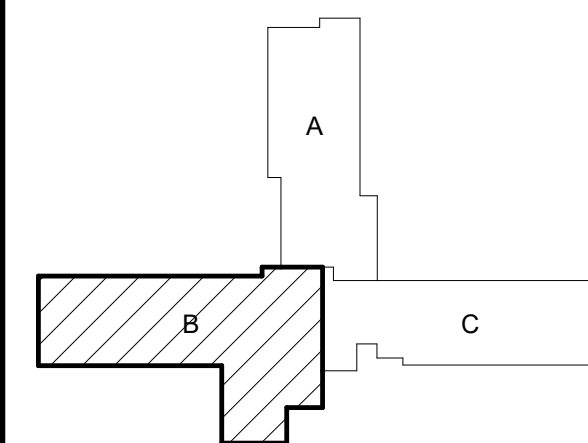

KEY PLAN



100% CONSTRUCTION
DOCUMENTS

GIBRALTAR DESIGN

9102 N. Meridian St., Ste. 300
Indianapolis, IN 46260
Homepage: www.GibraltarDesign.com
Email: info@GibraltarDesign.com
Phone 317.580.5777 Fax 317.580.5778

PROJECT

25-173

DATE

07/20/26

COORDINATED BY

RH

DRAWN BY

BR/MH

CHECKED BY

DJ



COPYRIGHT NOTICE:
THE CONCEPTS, DESIGNS, PLANS, DETAILS, ETC. SHOWN ON
THIS DOCUMENT ARE THE PROPERTY OF GIBRALTAR DESIGN
AND WERE CREATED FOR USE ON THIS SPECIFIC PROJECT.
NONE OF THIS INFORMATION SHALL BE USED BY ANY
PERSON OR FIRM FOR ANY PURPOSE WITHOUT THE EXPRESS
WRITTEN CONSENT OF GIBRALTAR DESIGN. THE OWNER MAY
RETAIN COPIES FOR INFORMATION AND REFERENCE IN
CONNECTION ONLY WITH THIS PROJECT.

REVISIONS

MARK	DATE	ISSUED FOR
AD-01	07/31/26	ADDENDUM 01
AD-02	08/07/26	ADDENDUM 02
AD-04	08/19/26	ADDENDUM 04

DRAWING

UNIT "B" FIRST FLOOR
ELECTRICAL LIGHTING PLAN

PROJECT

CONVERSE ES - MECHANICAL
IMPROVEMENTS

© GIBRALTAR
DESIGN

SHEET

B


EL102


SHEET NOTES

- ALL FIXTURES IN THIS SPACE SHALL BE PROVIDED WITH SUPPORTS TO SUSPEND THE FIXTURE FROM THE ROOF STRUCTURE, INDEPENDENT OF THE CEILING GRID. PROVIDE A MINIMUM OF FOUR (4) RODS OR WIRES PER FIXTURE, NOT MORE THAN 6" FROM EACH CORNER.
- PROVIDE NEW OCCUPANCY SENSORS IN THIS SPACE AS SHOWN. VERIFY THE EXISTING SWITCHING CONFIGURATION AND DIMMING CAPABILITIES IN THIS SPACE PRIOR TO ORDERING THE NEW EQUIPMENT. REFER TO THE OCCUPANCY SENSOR DETAILS FOR ADDITIONAL INFORMATION.

GENERAL NOTES

- REMOVE AND REINSTALL EXISTING LIGHTING, PROJECTORS, WIRELESS TERMINALS, OCCUPANCY SENSORS, AND OTHER CEILING MOUNTED DEVICES IN THIS SPACE AS REQUIRED FOR THE INSTALLATION OF THE NEW DUCTWORK, GRILLES, AND BULKHEAD. THE EXISTING LIGHTING LAYOUT SHALL BE MODIFIED AS REQUIRED FOR THE NEW BULKHEAD. COORDINATE LIGHTING LOCATIONS WITH NEW GRILLES IN FIELD. COMPLETE AS REQUIRED.
- REFER TO THE ARCHITECTURAL RCP FOR FINAL CONFIRMATION OF CEILING WORK SCOPE.

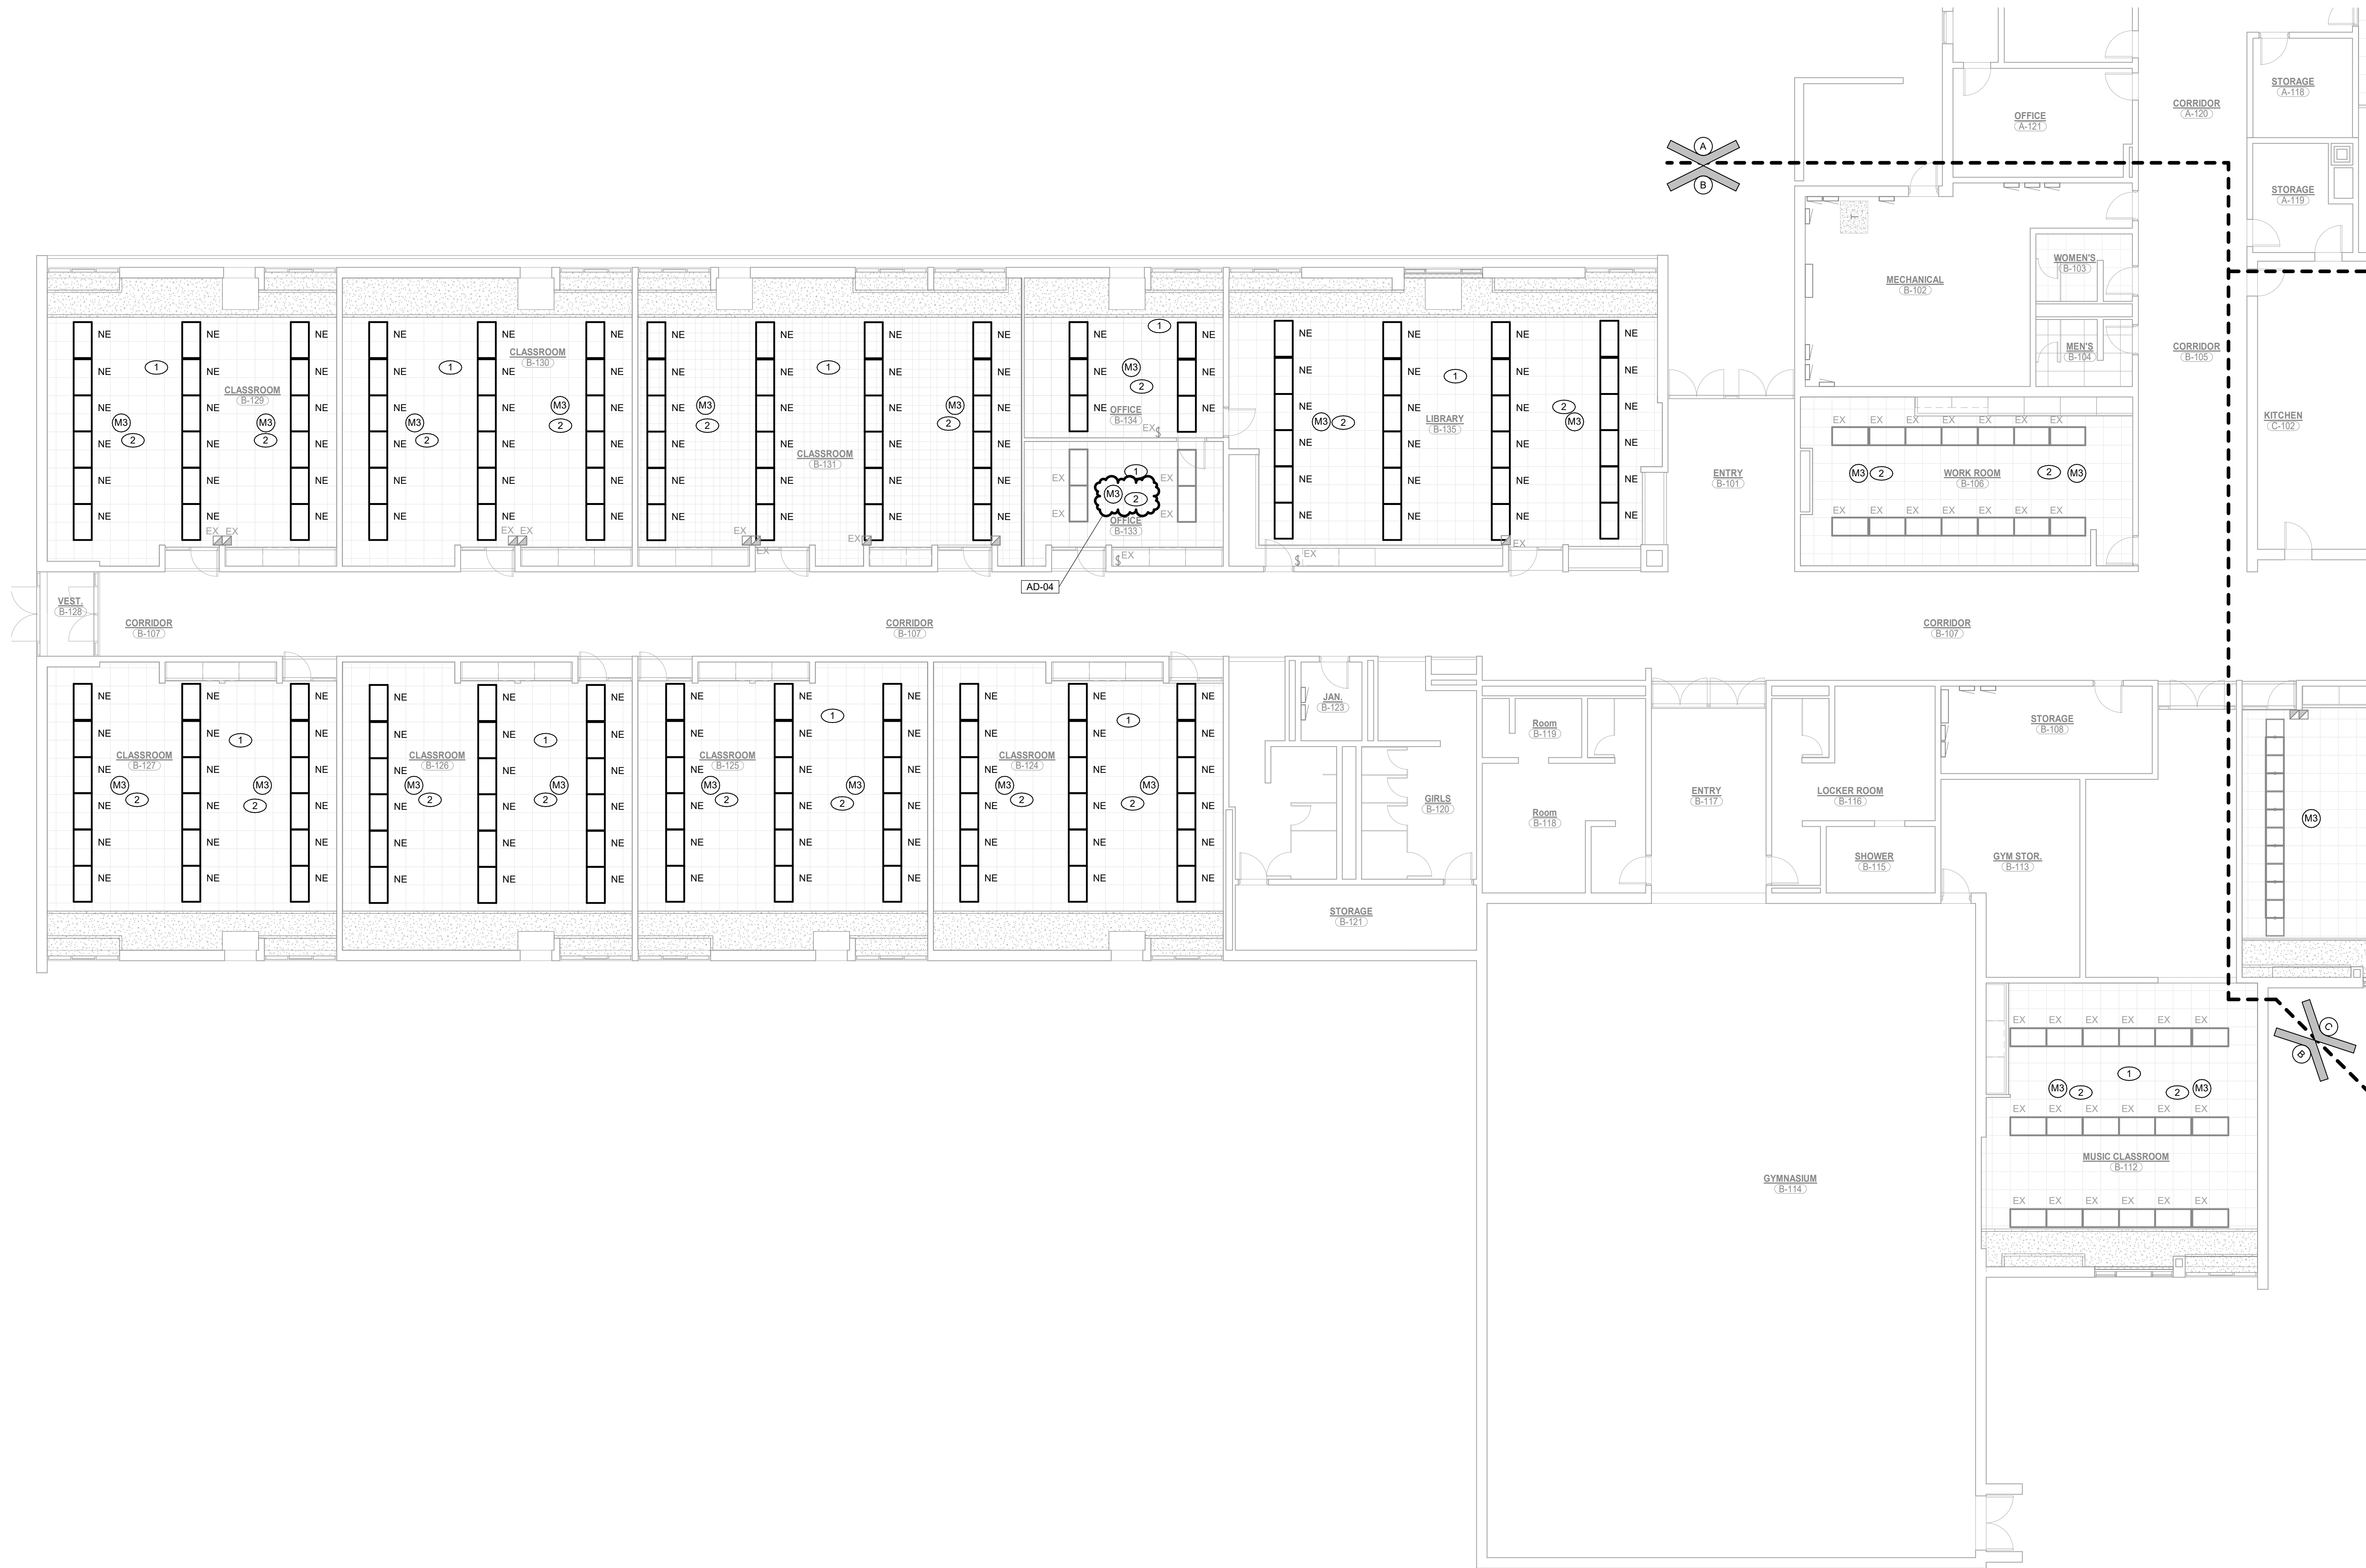

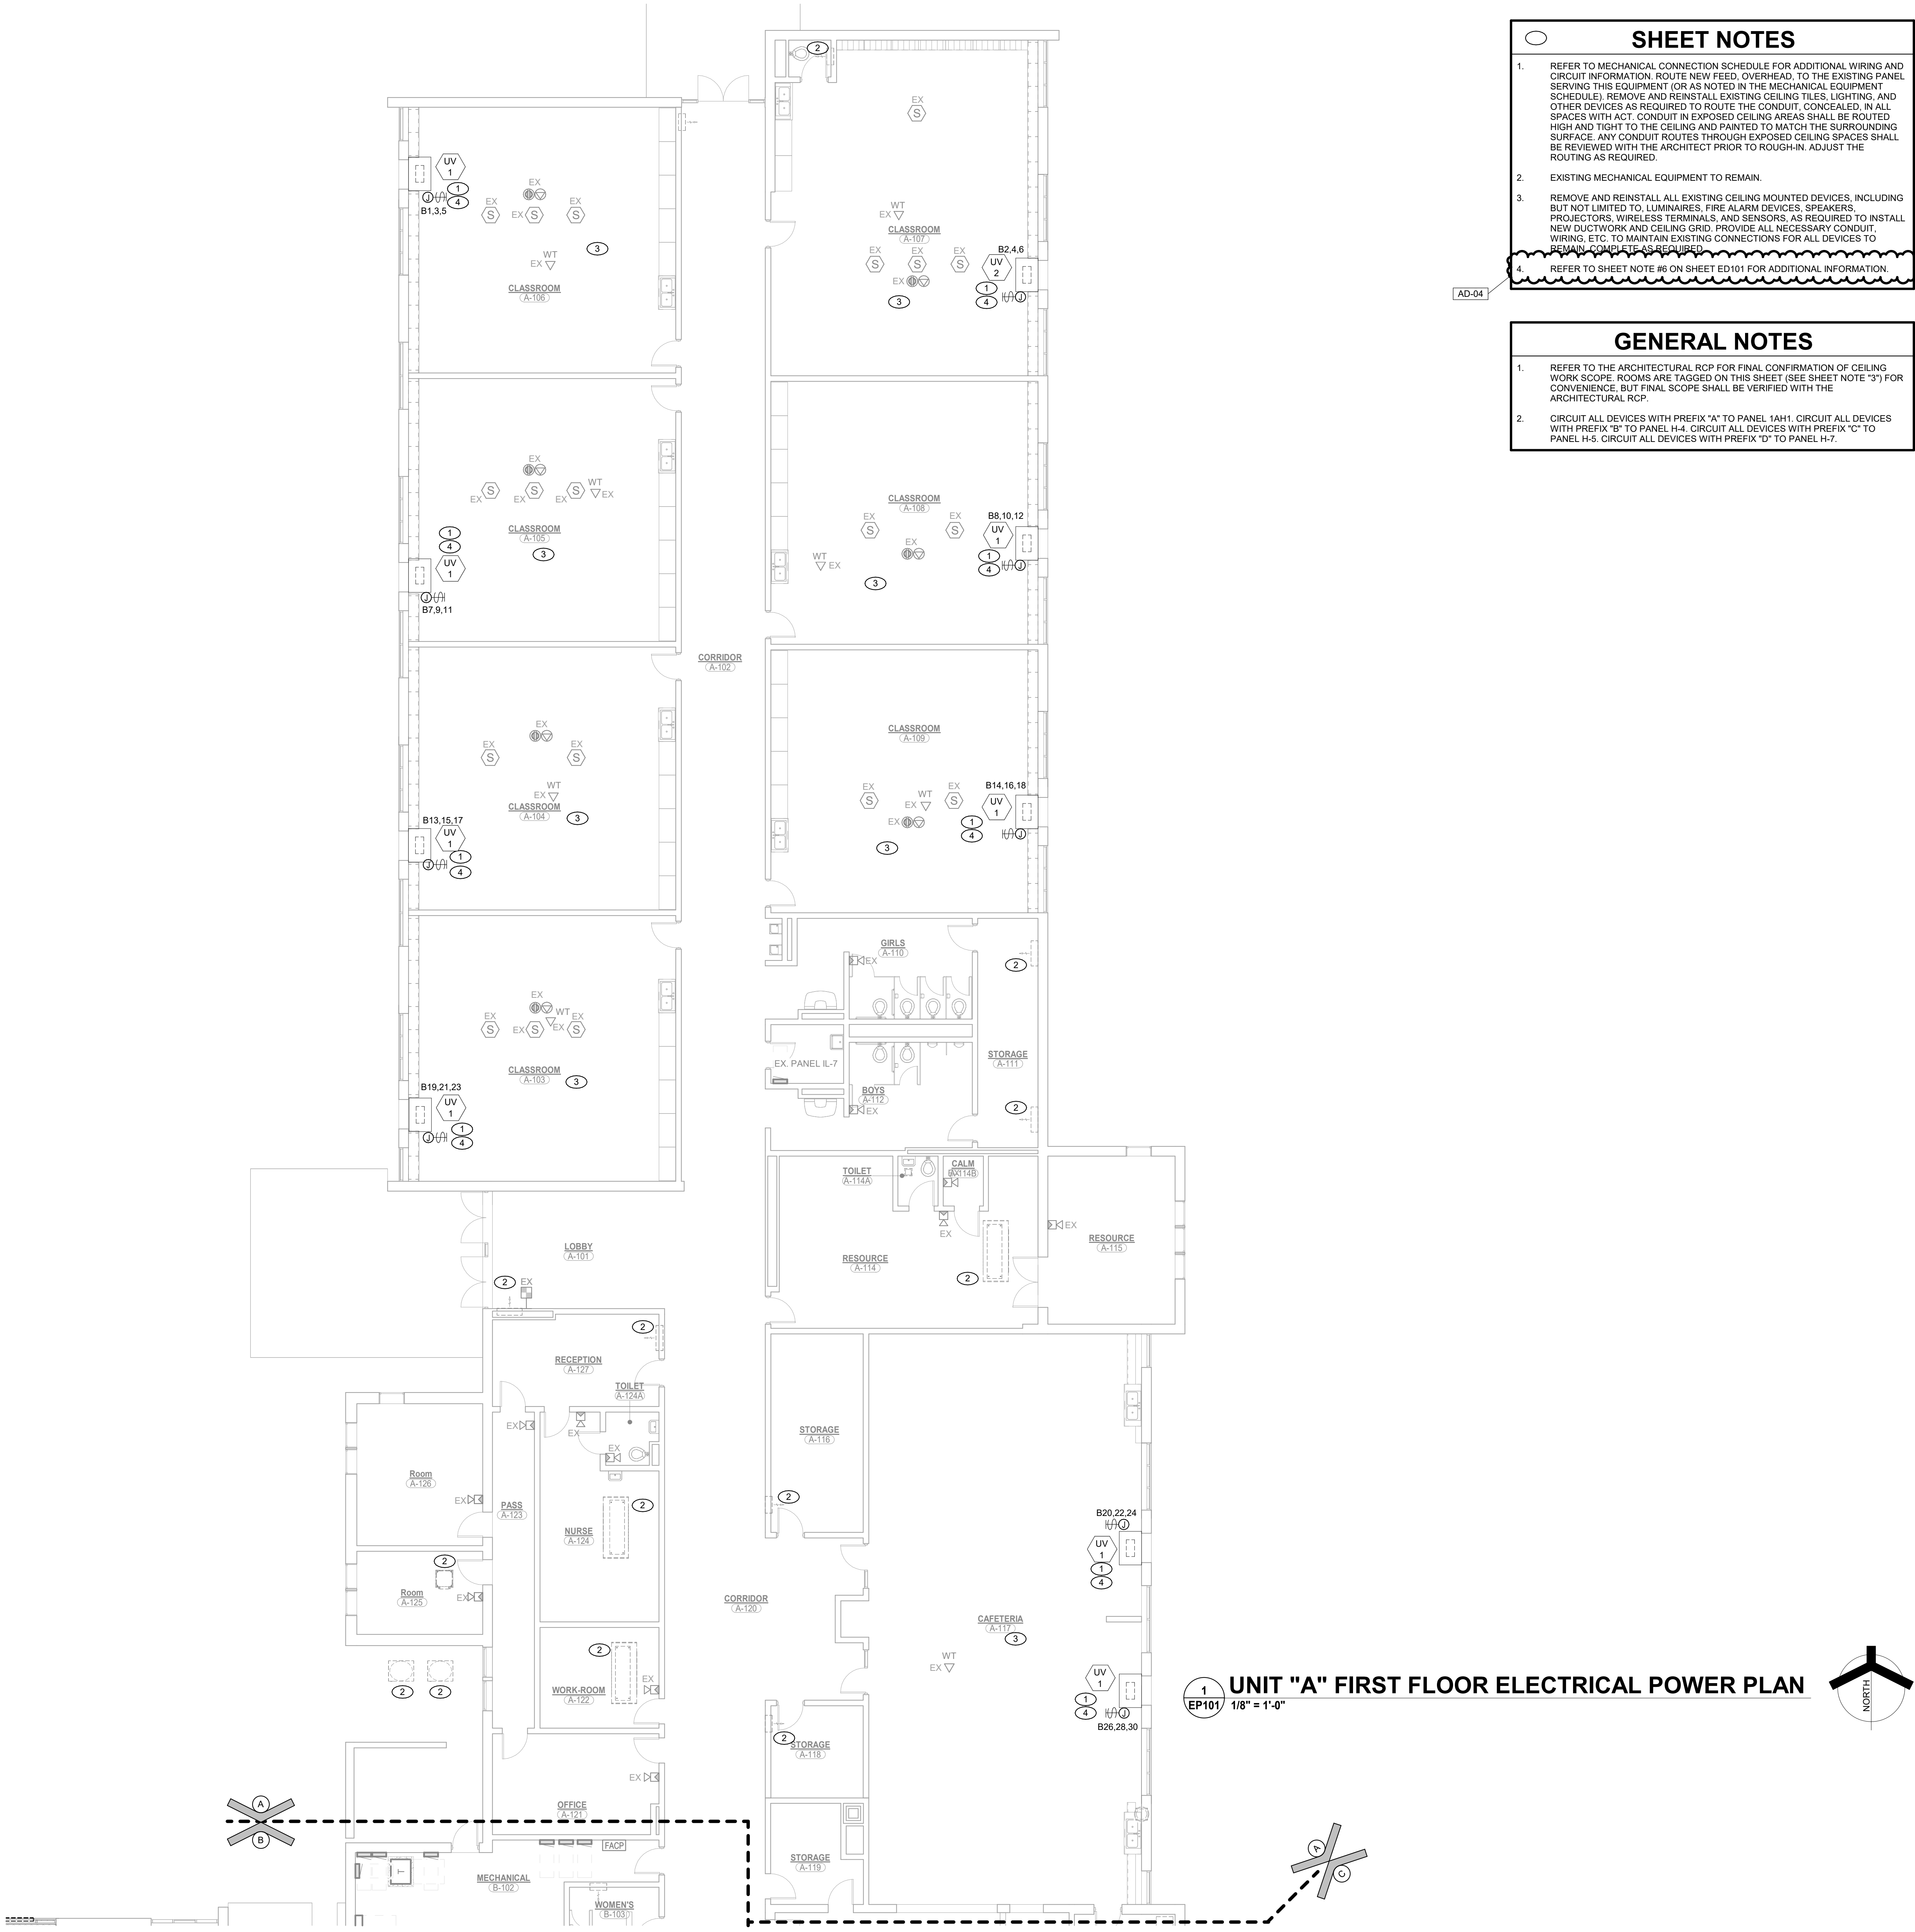

SHEET NOTES

1.

REFER TO MECHANICAL CONNECTION SCHEDULE FOR ADDITIONAL WIRING AND CIRCUIT INFORMATION. ROUTE NEW FEED, OVERHEAD, TO THE EXISTING PANEL SERVING THIS EQUIPMENT (OR AS NOTED IN THE MECHANICAL EQUIPMENT SCHEDULE). REMOVE AND REINSTALL EXISTING CEILING TILES, LIGHTING, AND OTHER DEVICES AS REQUIRED TO ROUTE THE CONDUIT, CONCEALED, IN ALL SPACES WITH AC7. CONDUIT IN EXPOSED CEILING AREAS SHALL BE ROUTED HIGH AND TIGHT TO THE CEILING AND PAINTED TO MATCH THE SURROUNDING SURFACE. ANY CONDUIT ROUTES THROUGH EXPOSED CEILING SPACES SHALL BE REVIEWED WITH THE ARCHITECT PRIOR TO ROUGH-IN. ADJUST THE ROUTING AS REQUIRED.

2.

EXISTING MECHANICAL EQUIPMENT TO REMAIN.

3.

REMOVE AND REINSTALL ALL EXISTING CEILING MOUNTED DEVICES, INCLUDING BUT NOT LIMITED TO, LUMINAIRES, FIRE ALARM DEVICES, SPEAKERS, PROJECTORS, WIRELESS TERMINALS, AND SENSORS, AS REQUIRED TO INSTALL NEW DUCTWORK AND CEILING GRID. PROVIDE ALL NECESSARY CONDUIT, WIRING, ETC. TO MAINTAIN EXISTING CONNECTIONS FOR ALL DEVICES TO REMAIN COMPLETE AS REQUIRED.

4.

REFER TO SHEET NOTE #6 ON SHEET ED101 FOR ADDITIONAL INFORMATION.

GENERAL NOTES

1.

REFER TO THE ARCHITECTURAL RCP FOR FINAL CONFIRMATION OF CEILING WORK SCOPE. ROOMS ARE TAGGED ON THIS SHEET (SEE SHEET NOTE "3") FOR CONVENIENCE, BUT FINAL SCOPE SHALL BE VERIFIED WITH THE ARCHITECTURAL RCP.

2.

CIRCUIT ALL DEVICES WITH PREFIX "A" TO PANEL 1AH1. CIRCUIT ALL DEVICES WITH PREFIX "B" TO PANEL H-4. CIRCUIT ALL DEVICES WITH PREFIX "C" TO PANEL H-5. CIRCUIT ALL DEVICES WITH PREFIX "D" TO PANEL H-7.

GIBRALTAR
DESIGN

ARCHITECTURE • ENGINEERING • INTERIOR DESIGN

MILLIES

ENGINEERING GROUP
©191 994-8400
www.milliesengineeringgroup.com

PROJECT:

CONVERSE ES -
MECHANICAL
IMPROVEMENTS

OAK HILL UNITED SCHOOL
CORPORATION

600 WALNUT ST.,
CONVERSE, IN, 46919

KEY PLAN

NORTH

100% CONSTRUCTION
DOCUMENTS

GIBRALTAR DESIGN

9102 N. Meridian St., Ste. 300
Indianapolis, IN 46250
Homepage: www.GibraltarDesign.com
Email: info@GibraltarDesign.com
Phone 317.580.5777 Fax 317.580.5778

PROJECT
25-173

DATE
07/20/26

COORDINATED BY
RH

DRAWN BY
BR/MH

CHECKED BY
DJ

DAVID G. JANNEY
N.E. REGISTERED
NO. 10302590
STATE OF INDIANA
PROFESSIONAL ENGINEER

COPYRIGHT NOTICE:
THE CONCEPTS, DESIGNS, PLANS, DETAILS, ETC. SHOWN ON THIS DOCUMENT ARE THE PROPERTY OF GIBRALTAR DESIGN AND WERE CREATED FOR USE ON THIS SPECIFIC PROJECT. NONE OF THIS INFORMATION SHALL BE USED BY ANY PERSON OR FIRM FOR ANY PURPOSE WITHOUT THE EXPRESS WRITTEN CONSENT OF GIBRALTAR DESIGN. THE OWNER MAY RETAIN COPIES FOR INFORMATION AND REFERENCE IN CONNECTION ONLY WITH THIS PROJECT.

REVISIONS		
MARK	DATE	ISSUED FOR
AD-01	07/31/26	ADDENDUM 01
AD-04	08/19/26	ADDENDUM 04


DRAWING
UNIT "A" FIRST FLOOR
ELECTRICAL POWER PLAN

PROJECT
CONVERSE ES - MECHANICAL
IMPROVEMENTS

GIBRALTAR
DESIGN

SHEET
A
EP101


Copyright © 2020 Millies Engineering Group

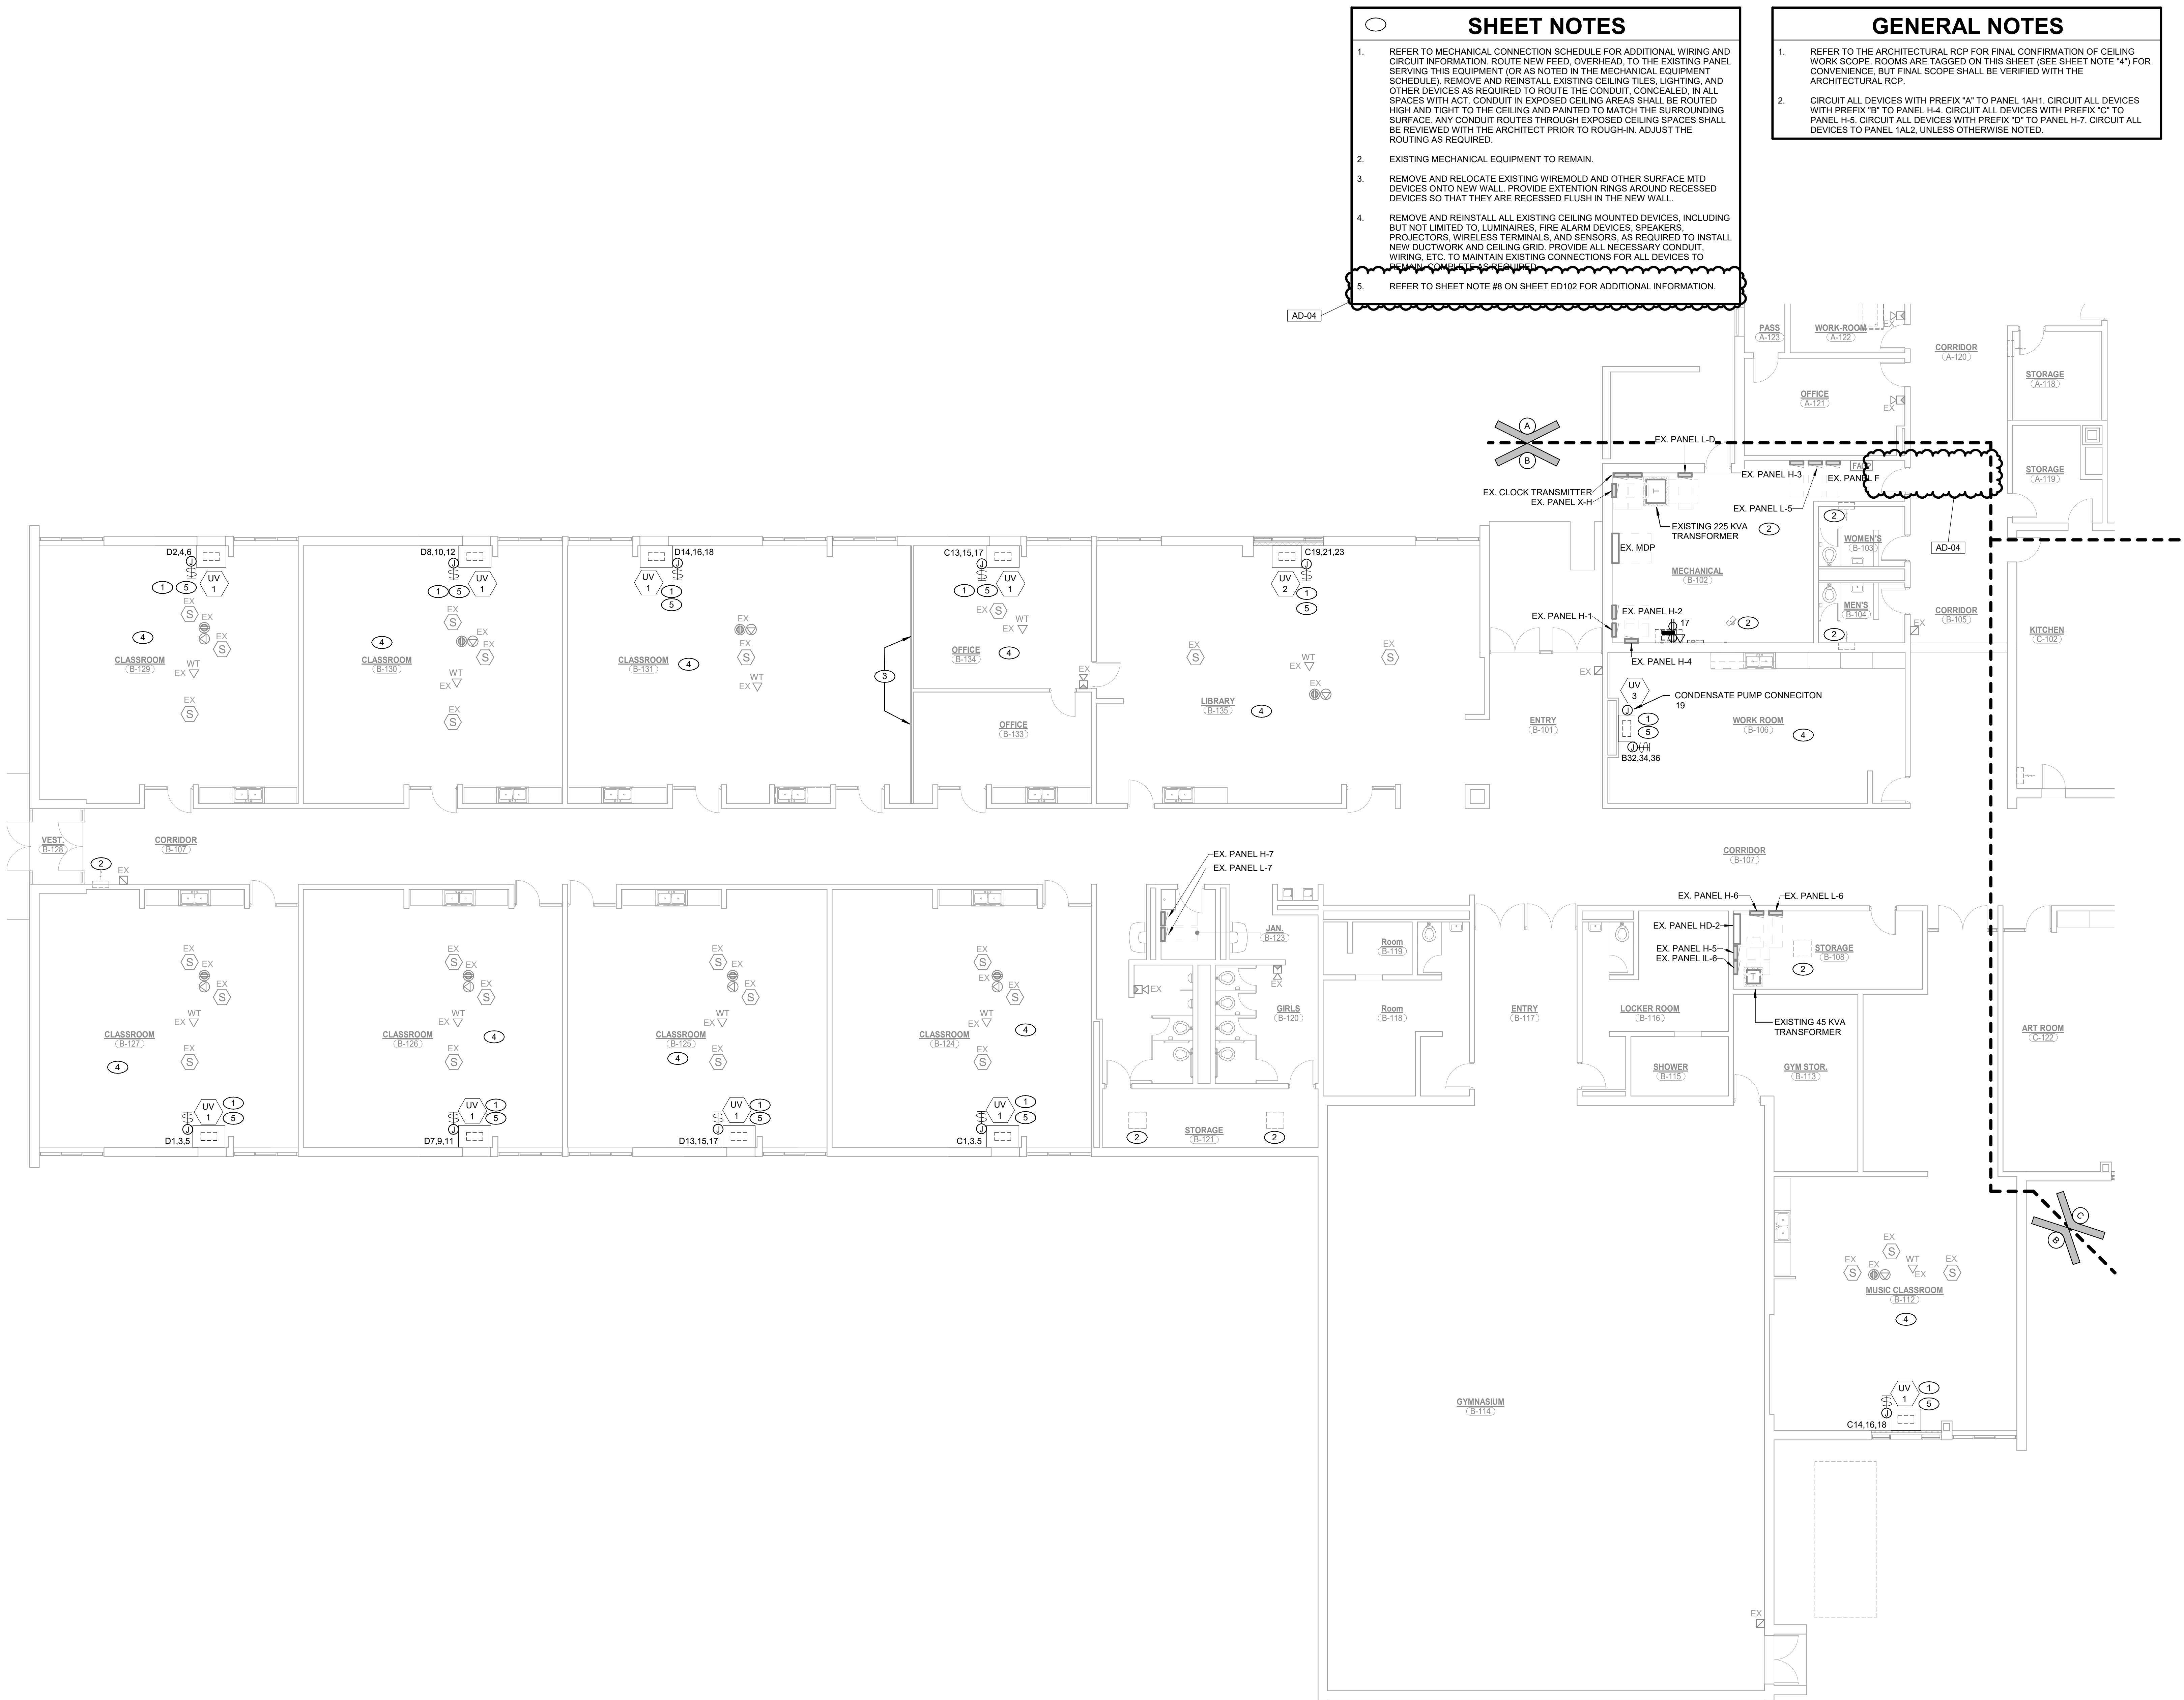


- ### SHEET NOTES
- REFER TO MECHANICAL CONNECTION SCHEDULE FOR ADDITIONAL WIRING AND CIRCUIT INFORMATION. ROUTE NEW FEED, OVERHEAD, TO THE EXISTING PANEL SERVING THIS EQUIPMENT (OR AS NOTED IN THE MECHANICAL EQUIPMENT SCHEDULES). REMOVE AND REINSTALL EXISTING CEILING TILES, LIGHTING, AND OTHER DEVICES AS REQUIRED TO ROUTE THE CONDUIT, CONCEALED, IN ALL SPACES WITH ACT. CONDUIT IN EXPOSED CEILING AREAS SHALL BE ROUTED HIGH AND TIGHT TO THE CEILING AND PAINTED TO MATCH THE SURROUNDING SURFACE. ANY CONDUIT ROUTES THROUGH EXPOSED CEILING SPACES SHALL BE REVIEWED WITH THE ARCHITECT PRIOR TO ROUGH-IN. ADJUST THE ROUTING AS REQUIRED.
 - EXISTING MECHANICAL EQUIPMENT TO REMAIN.
 - REMOVE AND RELOCATE EXISTING WIREMOLD AND OTHER SURFACE MTD DEVICES ONTO NEW WALL. PROVIDE EXTENTION RINGS AROUND RECESSED DEVICES SO THAT THEY ARE RECESSED FLUSH IN THE NEW WALL.
 - REMOVE AND REINSTALL ALL EXISTING CEILING MOUNTED DEVICES, INCLUDING BUT NOT LIMITED TO, LUMINAIRES, FIRE ALARM DEVICES, SPEAKERS, PROJECTORS, WIRELESS TERMINALS, AND SENSORS, AS REQUIRED TO INSTALL NEW DUCTWORK AND CEILING GRID. PROVIDE ALL NECESSARY CONDUIT, WIRING, ETC. TO MAINTAIN EXISTING CONNECTIONS FOR ALL DEVICES TO REMAIN. CONDUIT IS REQUIRED.
 - REFER TO SHEET NOTE #8 ON SHEET ED102 FOR ADDITIONAL INFORMATION.

- ### GENERAL NOTES
- REFER TO THE ARCHITECTURAL RCP FOR FINAL CONFIRMATION OF CEILING WORK SCOPE. ROOMS ARE TAGGED ON THIS SHEET (SEE SHEET NOTE "4") FOR CONVENIENCE, BUT FINAL SCOPE SHALL BE VERIFIED WITH THE ARCHITECTURAL RCP.
 - CIRCUIT ALL DEVICES WITH PREFIX "A" TO PANEL 1AH1. CIRCUIT ALL DEVICES WITH PREFIX "B" TO PANEL H-4. CIRCUIT ALL DEVICES WITH PREFIX "C" TO PANEL H-5. CIRCUIT ALL DEVICES WITH PREFIX "D" TO PANEL H-7. CIRCUIT ALL DEVICES TO PANEL 1AL2, UNLESS OTHERWISE NOTED.

1
EP102
UNIT "B" FIRST FLOOR ELECTRICAL POWER PLAN
1/8" = 1'-0"

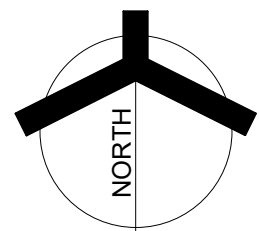

PROJECT:
**CONVERSE ES -
MECHANICAL
IMPROVEMENTS**
OAK HILL UNITED SCHOOL
CORPORATION
600 WALNUT ST.
CONVERSE, IN, 46919

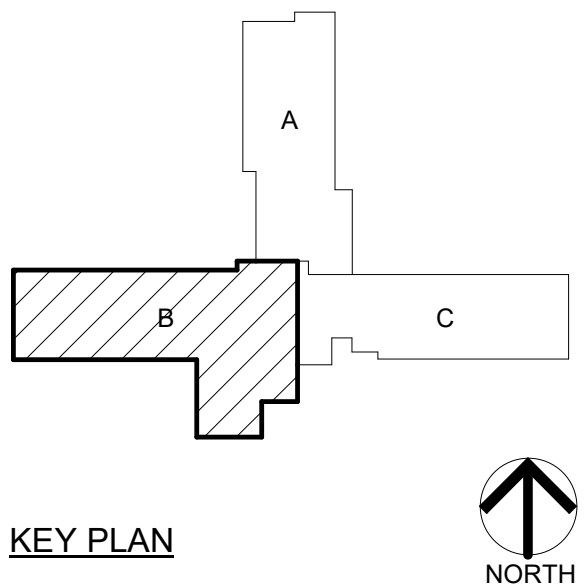

100% CONSTRUCTION
DOCUMENTS

GIBRALTAR DESIGN
9102 N. Meridian St., Ste. 300
Indianapolis, IN 46250
Homepage: www.GibraltarDesign.com
Email: info@GibraltarDesign.com
Phone 317.580.5777 Fax 317.580.5778

PROJECT
25-173
DATE
07/20/26
COORDINATED BY
RH
DRAWN BY
BR/MH
CHECKED BY
DJ




COPYRIGHT NOTICE:
THE CONCEPTS, DESIGNS, PLANS, DETAILS, ETC. SHOWN ON THIS DOCUMENT ARE THE PROPERTY OF GIBRALTAR DESIGN AND WERE CREATED FOR USE ON THIS SPECIFIC PROJECT. NONE OF THIS INFORMATION SHALL BE USED BY ANY PERSON OR FIRM FOR ANY PURPOSE WITHOUT THE EXPRESS WRITTEN CONSENT OF GIBRALTAR DESIGN. THE OWNER MAY RETAIN COPIES FOR INFORMATION AND REFERENCE IN CONNECTION ONLY WITH THIS PROJECT.

MARK	DATE	ISSUED FOR
AD-01	07/31/26	ADDENDUM 01
AD-04	08/19/26	ADDENDUM 04

DRAWING
UNIT "B" FIRST FLOOR
ELECTRICAL POWER PLAN

PROJECT
CONVERSE ES - MECHANICAL
IMPROVEMENTS

8/18/2026 1:36:38 PM
Autodesk Docs://2504056 Oak Hill SC - 2026 Construction Projects/MEG_Oak Hill - Converse ES - MEP-R25.rvt

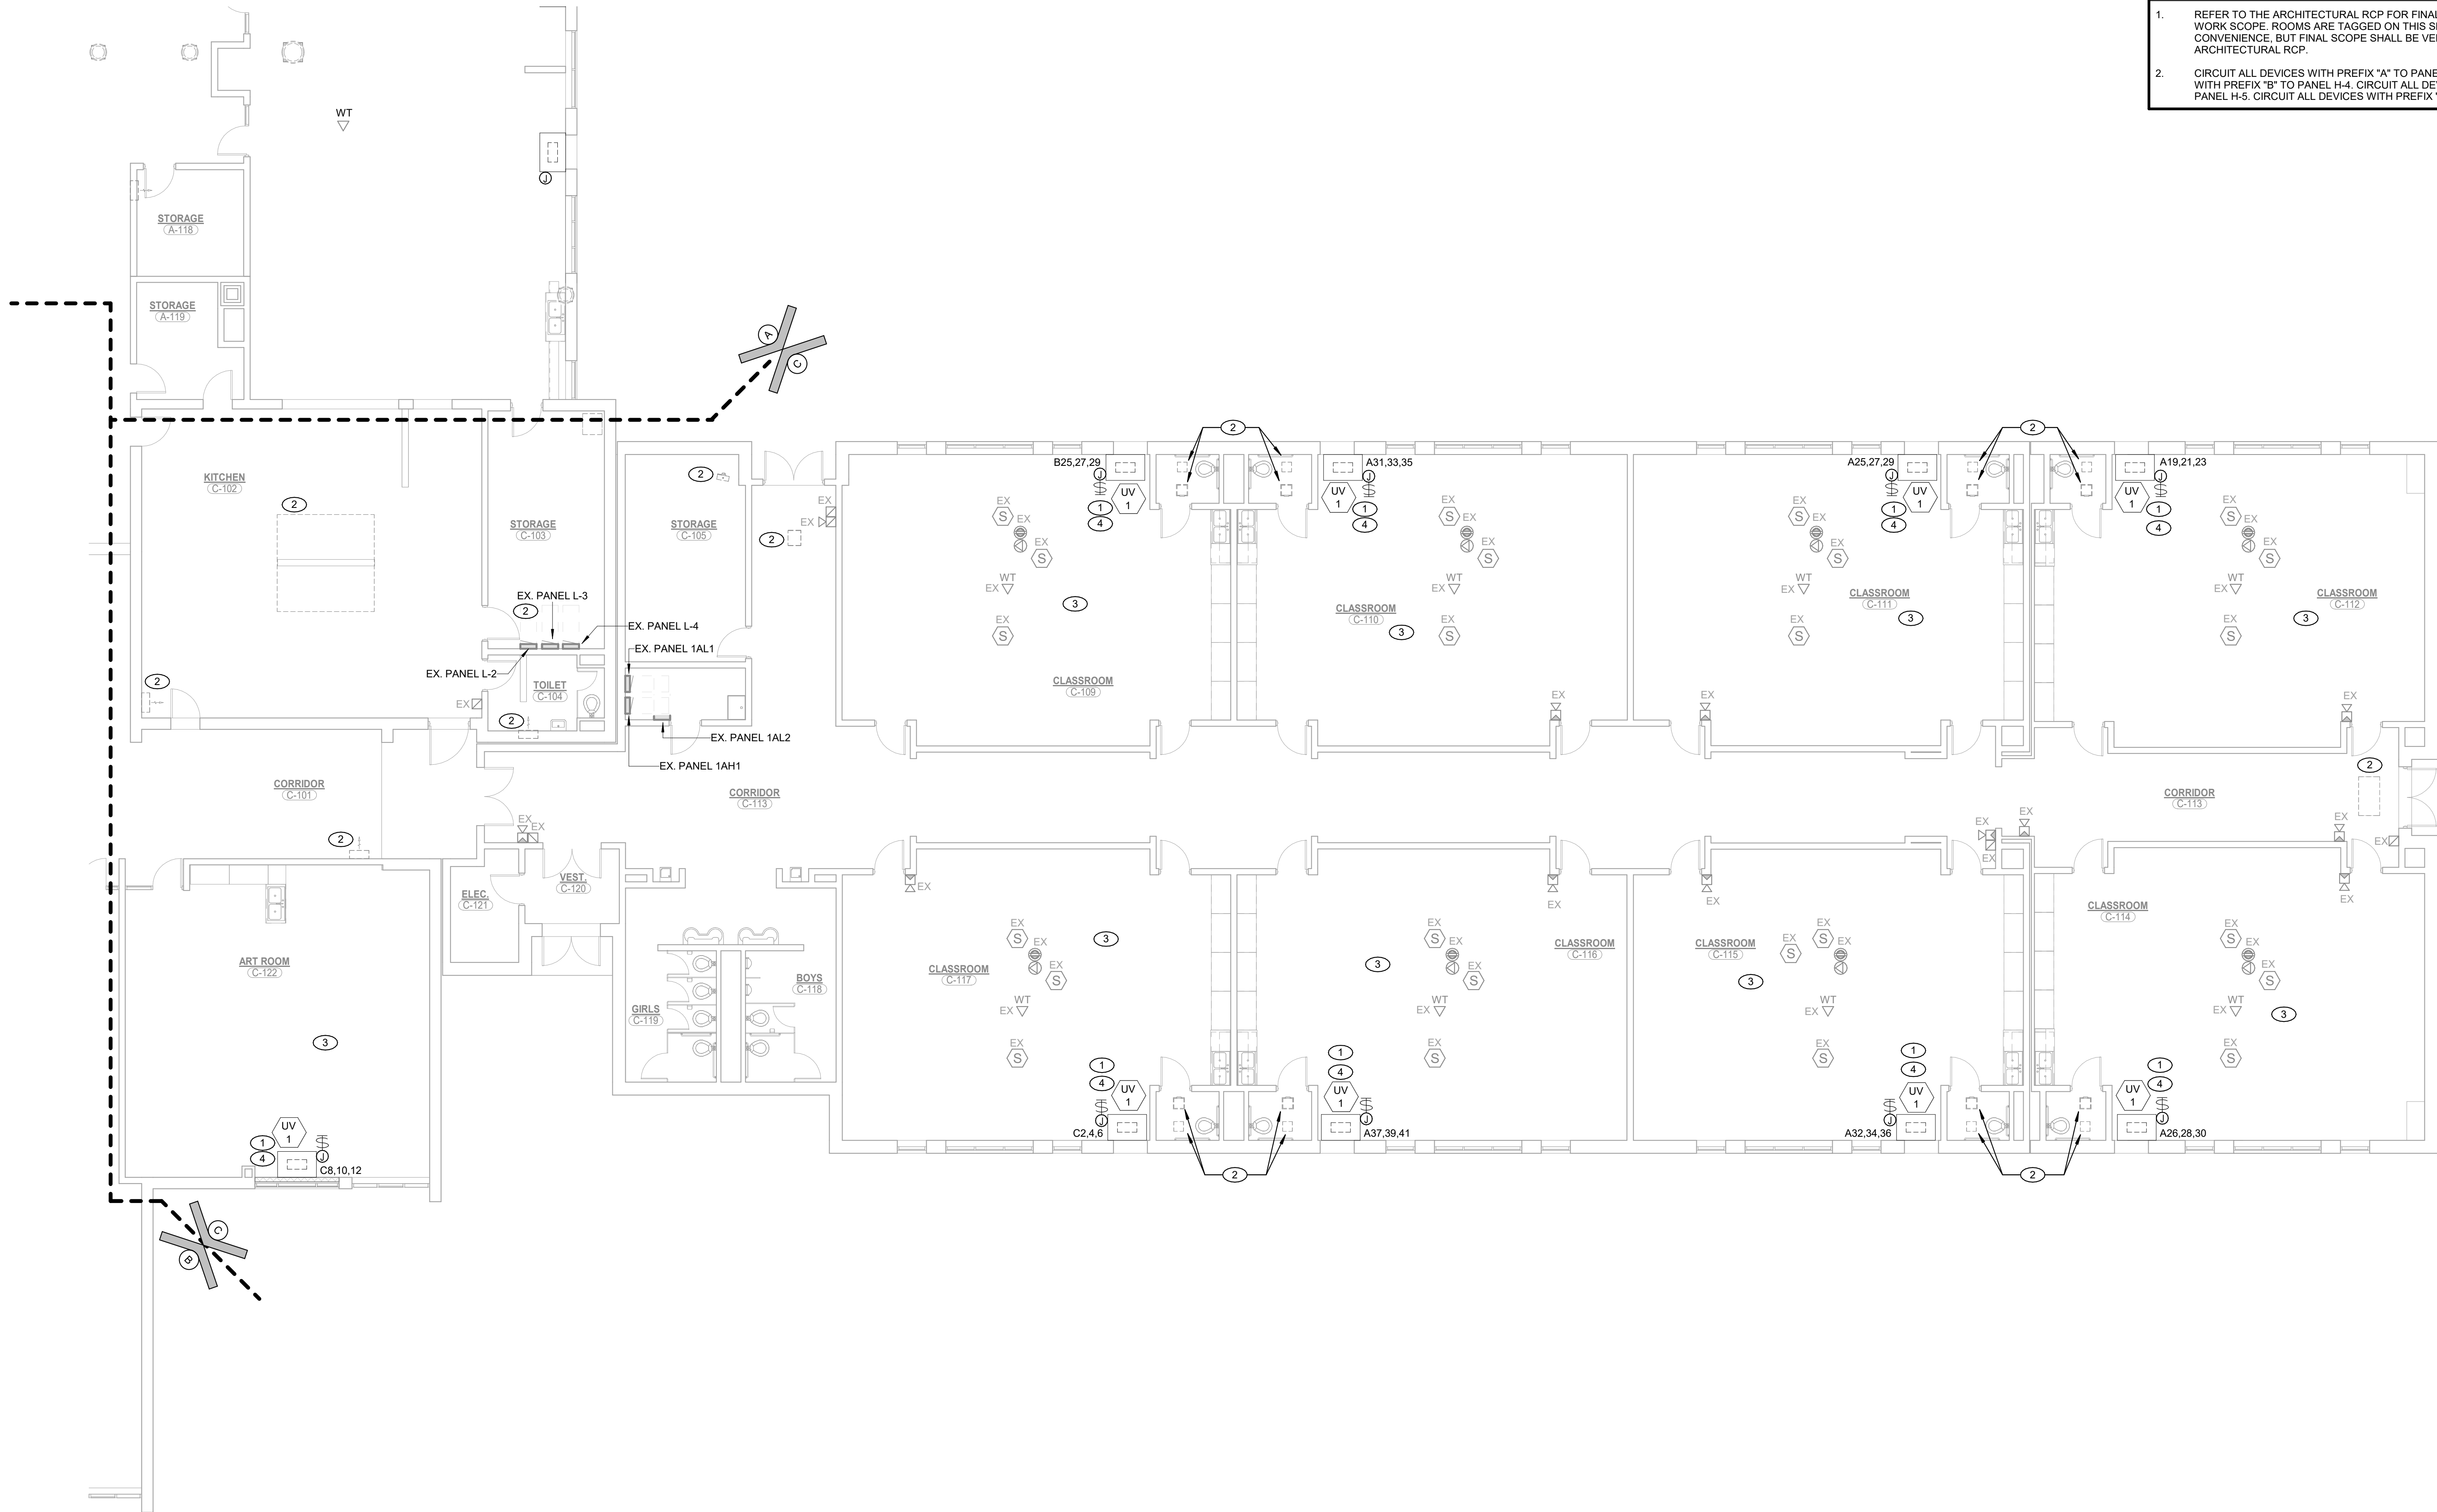

1
EP103 **UNIT "C" FIRST FLOOR ELECTRICAL POWER PLAN**
1/8" = 1'-0"

SHEET NOTES

- REFER TO MECHANICAL CONNECTION SCHEDULE FOR ADDITIONAL WIRING AND CIRCUIT INFORMATION. ROUTE NEW FEED, OVERHEAD, TO THE EXISTING PANEL SERVING THIS EQUIPMENT (OR AS NOTED IN THE MECHANICAL EQUIPMENT SCHEDULE). REMOVE AND REINSTALL EXISTING CEILING TILES, LIGHTING, AND OTHER DEVICES AS REQUIRED TO ROUTE THE CONDUIT, CONCEALED, IN ALL SPACES WITH AC. CONDUIT IN EXPOSED CEILING AREAS SHALL BE ROUTED HIGH AND TIGHT TO THE CEILING AND PAINTED TO MATCH THE SURROUNDING SURFACE. ANY CONDUIT ROUTES THROUGH EXPOSED CEILING SPACES SHALL BE REVIEWED WITH THE ARCHITECT PRIOR TO ROUGH-IN. ADJUST THE ROUTING AS REQUIRED.
- EXISTING MECHANICAL EQUIPMENT TO REMAIN.
- REMOVE AND REINSTALL ALL EXISTING CEILING MOUNTED DEVICES, INCLUDING BUT NOT LIMITED TO, LUMINAIRES, FIRE ALARM DEVICES, SPEAKERS, PROJECTORS, WIRELESS TERMINALS, AND SENSORS, AS REQUIRED TO INSTALL NEW DUCTWORK AND CEILING GRID. PROVIDE ALL NECESSARY CONDUIT, WIRING, ETC. TO MAINTAIN EXISTING CONNECTIONS FOR ALL DEVICES TO REMAIN COMPLETE AS REQUIRED.
- REFER TO SHEET NOTE #6 ON SHEET ED103 FOR ADDITIONAL INFORMATION.

AD-04

GENERAL NOTES

- REFER TO THE ARCHITECTURAL RCP FOR FINAL CONFIRMATION OF CEILING WORK SCOPE. ROOMS ARE TAGGED ON THIS SHEET (SEE SHEET NOTE "3") FOR CONVENIENCE, BUT FINAL SCOPE SHALL BE VERIFIED WITH THE ARCHITECTURAL RCP.
- CIRCUIT ALL DEVICES WITH PREFIX "A" TO PANEL 1AH1. CIRCUIT ALL DEVICES WITH PREFIX "B" TO PANEL H-4. CIRCUIT ALL DEVICES WITH PREFIX "C" TO PANEL H-5. CIRCUIT ALL DEVICES WITH PREFIX "D" TO PANEL H-7.




GIBRALTAR
DESIGN
ARCHITECTURE • ENGINEERING • INTERIOR DESIGN



MILLIES
ENGINEERING GROUP
©2019 9945400
www.milliesengineeringgroup.com

PROJECT:
**CONVERSE ES -
MECHANICAL
IMPROVEMENTS**
OAK HILL UNITED SCHOOL
CORPORATION
600 WALNUT ST.,
CONVERSE, IN, 46919

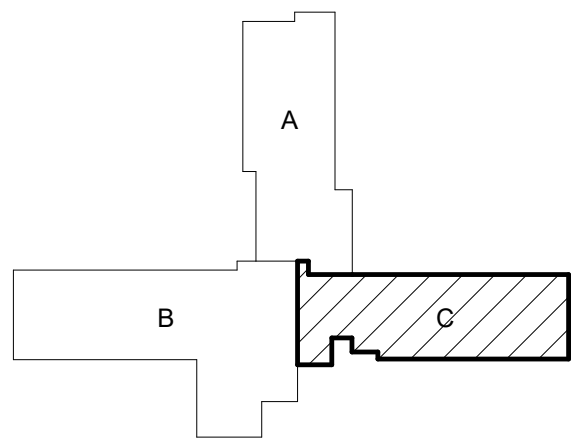

KEY PLAN

100% CONSTRUCTION
DOCUMENTS



NORTH

GIBRALTAR DESIGN
9102 N. Meridian St., Ste. 300
Indianapolis, IN 46250
Homepage: www.GibraltarDesign.com
Email: info@GibraltarDesign.com
Phone 317.580.5777 Fax 317.580.5778

PROJECT
25-173
DATE
07/20/26
COORDINATED BY
RH
DRAWN BY
BR/MH
CHECKED BY
DJ



COPYRIGHT NOTICE:
THE CONCEPTS, DESIGNS, PLANS, DETAILS, ETC. SHOWN ON THIS DOCUMENT ARE THE PROPERTY OF GIBRALTAR DESIGN AND WERE CREATED FOR USE ON THIS SPECIFIC PROJECT. NONE OF THIS INFORMATION SHALL BE USED BY ANY PERSON OR FIRM FOR ANY PURPOSE WITHOUT THE EXPRESS WRITTEN CONSENT OF GIBRALTAR DESIGN. THE OWNER MAY RETAIN COPIES FOR INFORMATION AND REFERENCE IN CONNECTION ONLY WITH THIS PROJECT.

MARK	DATE	ISSUED FOR
AD-01	07/31/26	ADDENDUM 01
AD-04	08/19/26	ADDENDUM 04


DRAWING
UNIT "C" FIRST FLOOR
ELECTRICAL POWER PLAN

PROJECT
CONVERSE ES - MECHANICAL
IMPROVEMENTS

© GIBRALTAR
DESIGN

C

SHEET
EP103

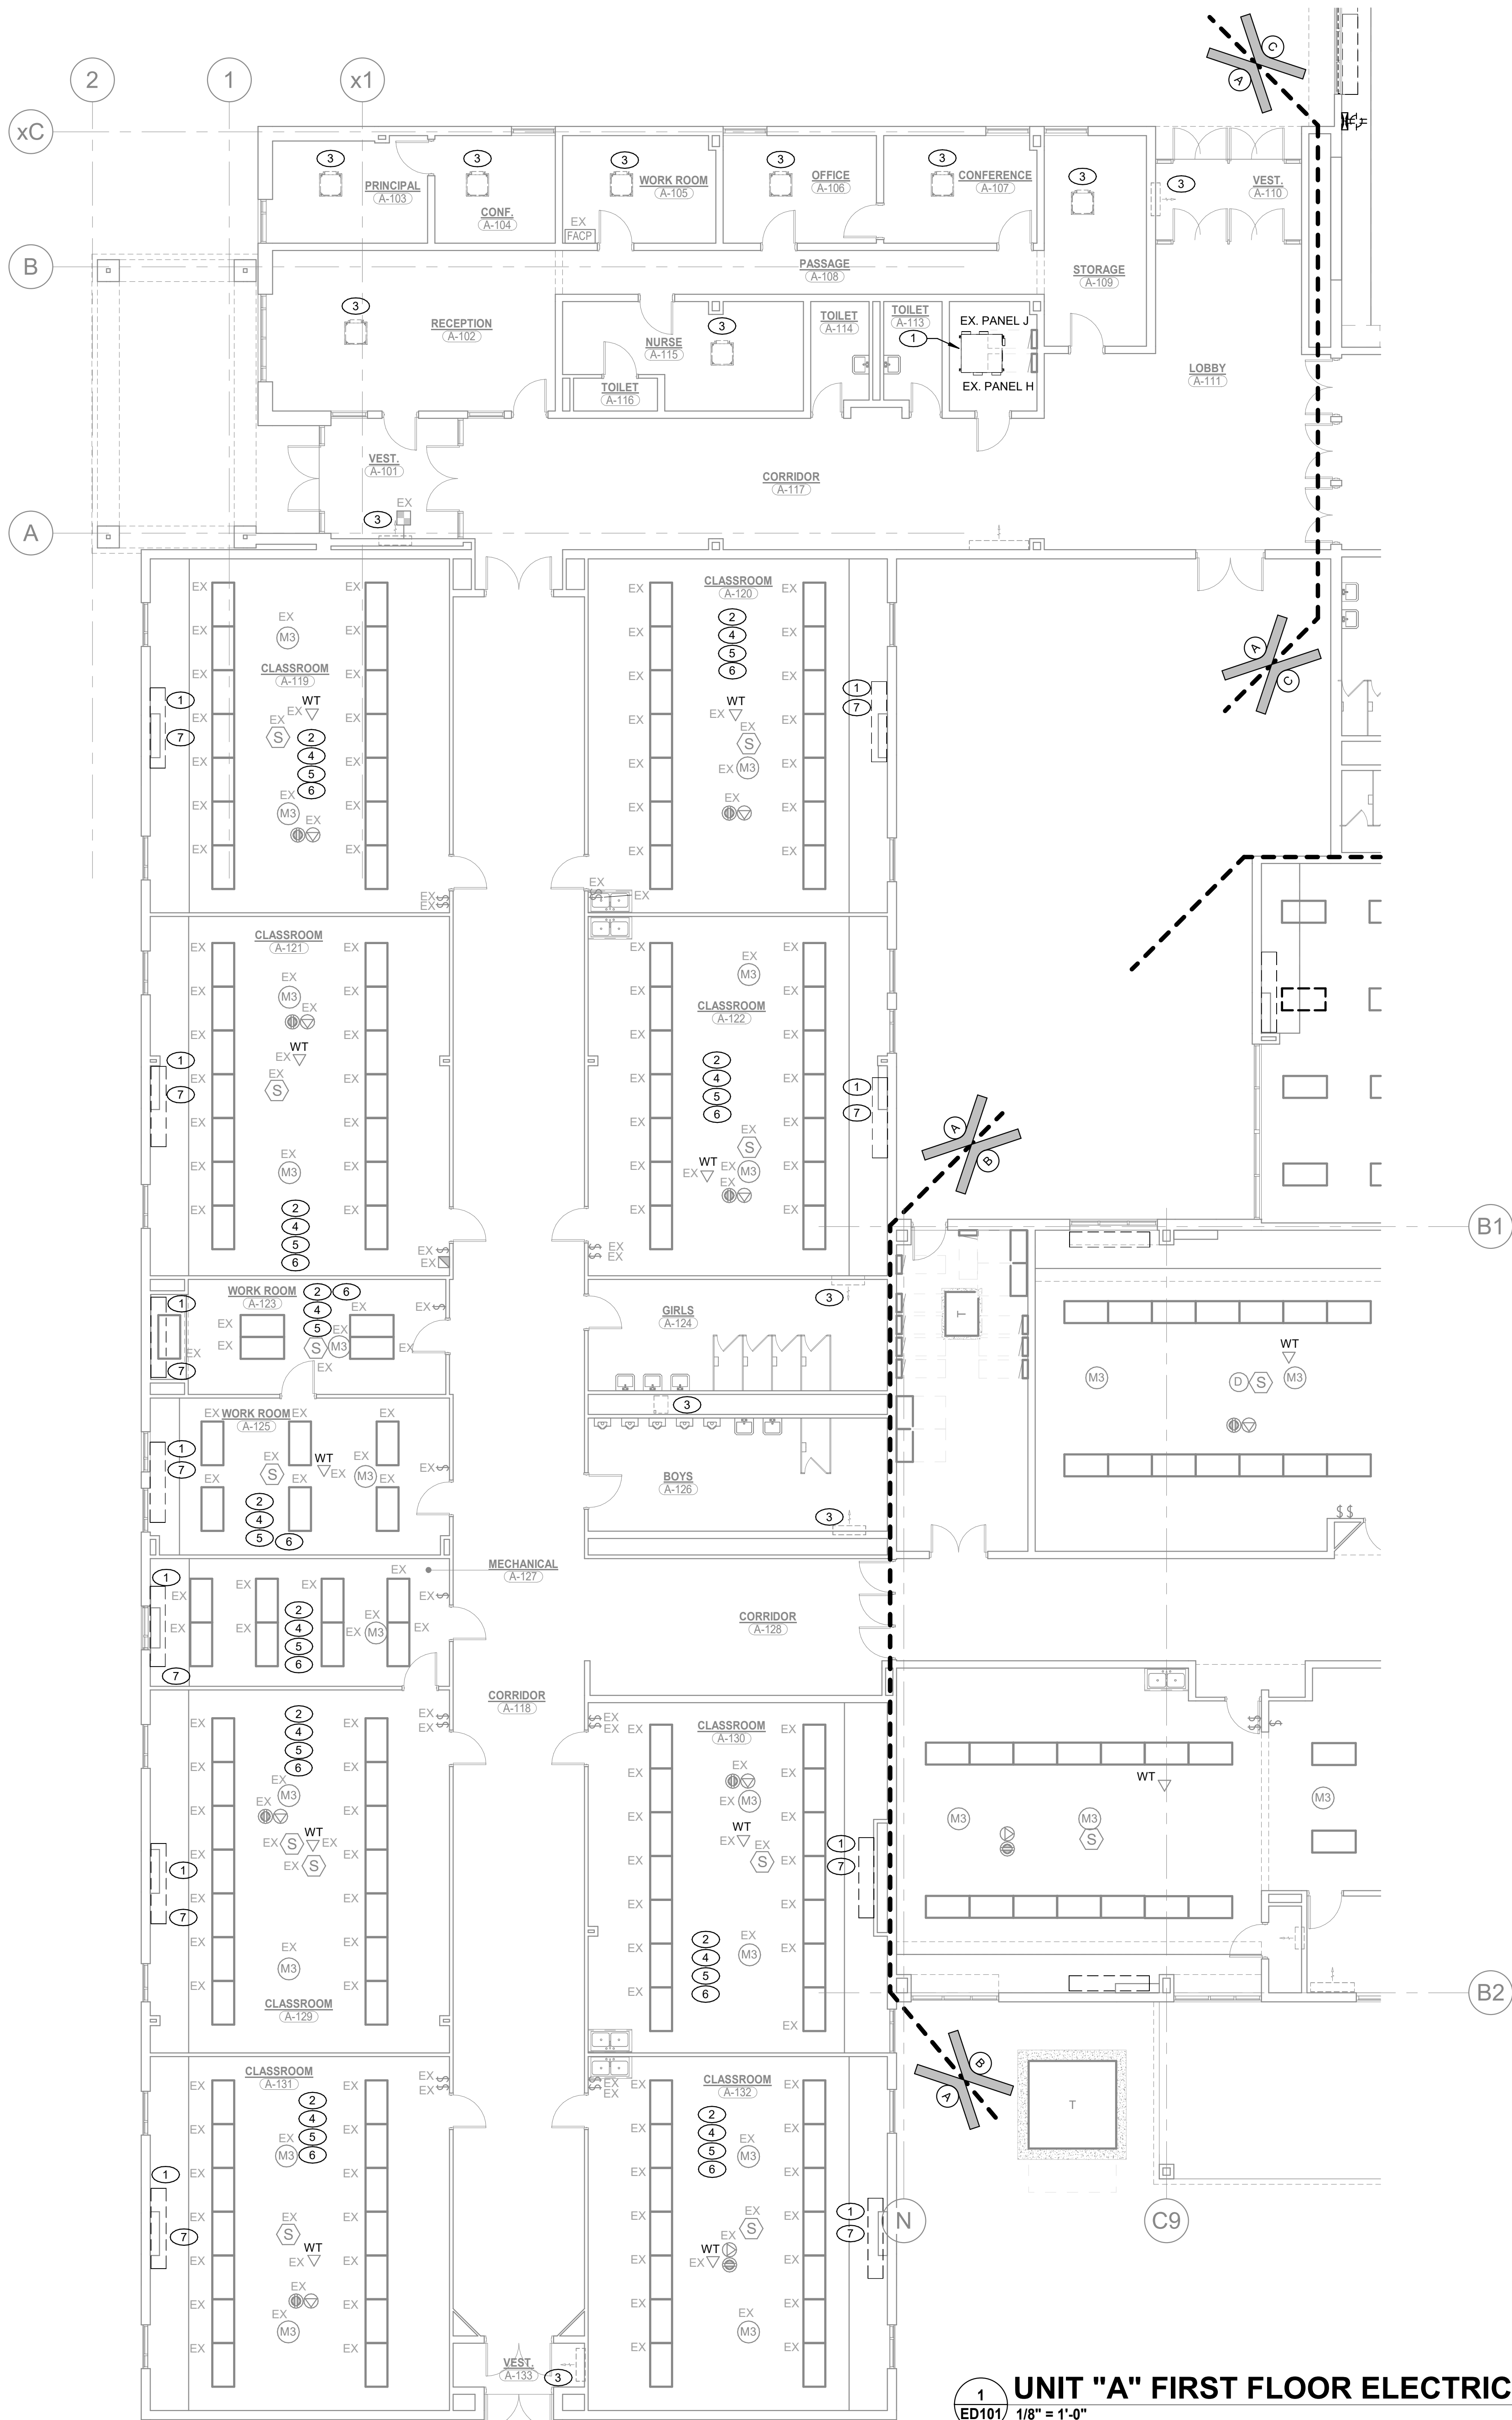

1
ED101 1/8" = 1'-0"

UNIT "A" FIRST FLOOR ELECTRICAL DEMOLITION PLAN

DEMOLITION NOTES

- COORDINATE PHASING OF WORK AND PROVIDE TEMPORARY POWER AND SERVICES AS REQUIRED FOR THE IMPLEMENTATION OF ALL WORK WHILE MAINTAINING SERVICES TO PORTIONS OF BUILDING TO REMAIN OCCUPIED.
- DISCONNECT AND REMOVE EXISTING ELECTRICAL DEVICES, EQUIPMENT, LIGHTING, WIRING, ETC., AS REQUIRED TO FACILITATE DEMOLITION AND RECONSTRUCTION WORK. COORDINATE WITH GENERAL CONSTRUCTION. THE CONTRACTOR IS HEREBY ADVISED THAT THE DRAWINGS MAY NOT INDICATE ALL EXISTING WIRING AND/OR EQUIPMENT WHICH MUST BE REMOVED, REWORKED, RELOCATED, ETC., TO ACCOMMODATE DEMOLITION AND RECONSTRUCTION WORK IN THE EXISTING BUILDING.
- SCHEDULE ALL WORK TO AVOID DOWNTIME AND INCONVENIENCE TO OWNER. OWNERS EXISTING FACILITY SHALL REMAIN IN OPERATION AT ALL TIMES, INCLUDING F/A AND OTHER SPECIAL SYSTEMS, ELECTRICAL POWER DISTRIBUTION, ETC. ALL REQUIRED SHUTDOWN OF EXISTING FACILITY UTILITIES SHALL BE SCHEDULED WITH OWNERS OPERATING PERSONNEL.
- ALL EXISTING EQUIPMENT SHALL REMAIN PROPERTY OF THE OWNER AND OWNER SHALL DETERMINE IF CONTRACTOR IS TO STORE EQUIPMENT ON SITE AT OWNER SELECTED LOCATION OR IF CONTRACTOR IS TO ABANDON OR REMOVE EQUIPMENT FROM SITE.
- CONTRACTOR TO FIELD VERIFY IF EXISTING ASBESTOS WILL BE ENCOUNTERED PRIOR TO STARTING ANY WORK. IF ASBESTOS IS PRESENT, THE OWNER WILL PROVIDE FOR THE REMOVAL OF ANY MATERIAL CONTAINING ASBESTOS. SEE SPECIFICATIONS FOR FURTHER REQUIREMENTS.
- ANY HIDDEN CONDITIONS IDENTIFIED THROUGH THE COURSE OF CONSTRUCTION SHALL BE IMMEDIATELY BROUGHT TO THE ATTENTION OF THE ARCHITECT IN WRITTEN FORM FOR REVIEW AND DIRECTION. FAILURE TO DO SO SHALL MAKE THE CONTRACTOR RESPONSIBLE FOR ANY AND ALL REQUIRED CHANGES AND COSTS TO CORRECT SAID HIDDEN CONDITION.
- EXISTING INFORMATION IDENTIFIED ON THE CONTRACT DOCUMENTS IS SCHEMATIC ONLY AS AN AID TO THE CONTRACTOR. CONTRACTOR SHALL BE RESPONSIBLE TO PROPERLY ADDRESS ALL EXISTING CONDITIONS FOR A COMPLETE AND PROPER INSTALLATION OF NEW SYSTEMS. ALL EXISTING EQUIPMENT NOT IDENTIFIED SHALL BE BROUGHT TO THE ATTENTION OF THE ARCHITECT/ENGINEER FOR REVIEW AS TO WHETHER THE EQUIPMENT SHALL REMAIN AND BE RECONNECTED TO THE NEW SERVICES, BE RELOCATED, BE ABANDONED, ETC.
- DISCONNECT AND REMOVE EXISTING LIGHTING FIXTURES AND ANY OTHER CEILING DEVICES AS REQUIRED FOR INSTALLATION OF WORK (ALL TRADES). REINSTALL UPON COMPLETION OF WORK. REPAIR ALL DAMAGED FIXTURES AND DEVICES.
- VISIT SITE PRIOR TO BIDDING TO DETERMINE ALL FIELD CONDITIONS. VERIFY ALL EXISTING INTERIOR AND EXTERIOR ELECTRICAL SYSTEMS TO VERIFY QUANTITIES AND LOCATIONS OF EXISTING SYSTEMS TO DETERMINE FULL EXTENT OF DEMOLITION WORK.
- ALL EXISTING LIGHTING FIXTURES, ELECTRICAL DEVICES, CONDUIT, ETC., SHALL BE REMOVED AS NOTED ON DRAWINGS AND AS REQUIRED TO MEET NEW SCOPE OF WORK. ALL EXISTING ELECTRICAL EQUIPMENT SHALL REMAIN PROPERTY OF THE OWNER AND SHALL BE PROPERLY STORED ON SITE, OR DESIGNATED TO BE ABANDONED AND REMOVED FROM SITE AS DIRECTED BY OWNER.
- EXISTING ELECTRICAL DEVICES (RECEPTACLES, SWITCHES, OUTLET BOXES, CONDUIT, ETC.) WITHIN WALLS TO BE REMOVED SHALL BE DISCONNECTED COMPLETELY. REROUTE CIRCUITRY AS REQUIRED TO MAINTAIN CIRCUIT CONTINUITY FOR ALL REMAINING DEVICES/EQUIPMENT. VERIFY EXACT CONDITIONS AND QUANTITIES IN FIELD.
- PATCH ALL EXISTING CEILING, FLOOR, WALL AND ROOF OPENINGS AND SURROUNDING FINISHES RESULTING FROM REMOVAL OF EXISTING MATERIALS AND EQUIPMENT SO THAT FINISH WILL MATCH EXISTING IN SURROUNDING AREAS.

SHEET NOTES

- REMOVE EXISTING MECHANICAL EQUIPMENT ELECTRICAL CONNECTION AND ALL ASSOCIATED WIRING AND EXPOSED CONDUIT BACK TO SOURCE. GRIND ANY CONDUIT LEFT WITHIN THE FLOOR BELOW THE FLOOR LINE, INFILL WITH CONCRETE, AND FINISH FLUSH WITH FLOOR. COMPLETE AS REQUIRED. ALL WIRING SHALL BE REMOVED. LABEL EXISTING CIRCUIT BREAKER FOR USE WITH NEW EQUIPMENT IN THIS SPACE. REFER TO THE NEW POWER PLANS FOR ADDITIONAL INFORMATION.
- REMOVE AND REINSTALL EXISTING LIGHTING, PROJECTORS, WIRELESS TERMINALS, OCCUPANCY SENSORS, AND OTHER CEILING MOUNTED DEVICES IN THIS SPACE AS REQUIRED FOR THE INSTALLATION OF THE NEW DUCTWORK, GRILLES, AND BULKHEAD. THE EXISTING LIGHTING LAYOUT SHALL BE MODIFIED AS REQUIRED FOR THE NEW BULKHEAD. COORDINATE LIGHTING LOCATIONS WITH NEW GRILLES IN FIELD. COMPLETE AS REQUIRED.
- EXISTING MECHANICAL EQUIPMENT TO REMAIN.
- IN THIS SPACE, REMOVE ALL EXISTING LIGHT FIXTURE ELECTRICAL CONNECTIONS INCLUDING ALL ASSOCIATED CONDUIT AND WIRING BACK TO NEAREST JUNCTION BOX. EXTEND NEW #12 WIRING IN 3/4" FMC FROM EXISTING JUNCTION BOX TO ALL EXISTING LIGHT FIXTURES AND CONNECT. COMPLETE AS REQUIRED. MAXIMUM FMC LENGTH IS 6'. PROVIDE NEW 3/4" EMT AS REQUIRED FOR LENGTHS EXCEEDING 6'.
- REMOVE EXISTING, ABANDONED LIGHT FIXTURES LOCATED ABOVE THE CEILING GRID IN THIS SPACE. REMOVE ALL ASSOCIATED WIRING AND CONDUIT BACK TO THE NEAREST JUNCTION BOX. WHERE THE EXISTING FIXTURES WERE USED AS WIREWAY TO SERVE THE FIXTURES IN THE CEILING GRID BELOW, PROVIDE NEW CONDUIT AND WIRING WITHIN THE SPACE TO SERVE THE EXISTING FIXTURES AFTER THE REMOVAL OF THE ABANDONED FIXTURES IN THE CEILING.
- ALL FIXTURES IN THIS SPACE SHALL BE PROVIDED WITH SUPPORTS TO SUSPEND THE FIXTURE FROM THE ROOF STRUCTURE, INDEPENDENT OF THE CEILING GRID. PROVIDE A MINIMUM OF FOUR (4) RODS OR WIRES PER FIXTURE. NOT MORE THAN 18" FROM EACH CORNER.
- REFER TO THE NEW PLANS FOR THE NEW LOCATION OF UNIT VENTILATOR. ANY EXISTING CONDUIT, WIRING, ETC. SERVING OTHER DEVICES OR EQUIPMENT IN THE NEW UNIT VENTILATOR LOCATION (INTERIOR OR EXTERIOR) SHALL BE MAINTAINED. REROUTE CONDUIT THROUGH, AROUND, OR ABOVE THE NEW UNIT VENTILATOR AS REQUIRED TO MAINTAIN EXISTING CIRCUIT CONTINUITY. ANY DEVICES IN CONFLICT WITH THE NEW LOCATIONS SHALL BE REMOVED AND RELOCATED TO THE SIDE OF THE UNIT. VERIFY THE FINAL LOCATION OF ANY DEVICES IN FIELD.

GENERAL NOTES

- REFER TO THE ARCHITECTURAL RCP FOR FINAL CONFIRMATION OF CEILING WORK SCOPE. ROOMS ARE TAGGED ON THIS SHEET (SEE SHEET NOTE "2") FOR CONVENIENCE, BUT FINAL SCOPE SHALL BE VERIFIED WITH THE ARCHITECTURAL RCP.



GIBALTAR

DESIGN

ARCHITECTURE • ENGINEERING • INTERIOR DESIGN




PROJECT:

**SWAYZEE ES
MECHANICAL
IMPROVEMENTS**

OAK HILL UNITED SCHOOL
CORPORATION

405 S WASHINGTON ST,
SWAYZEE IN, 46986

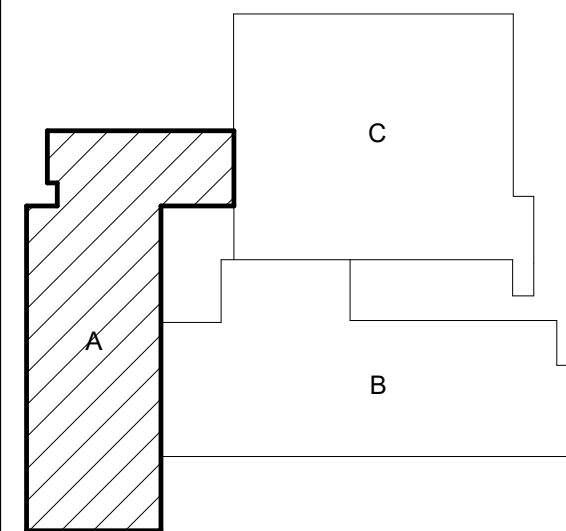

KEY PLAN



100% CONSTRUCTION
DOCUMENTS

GIBALTAR DESIGN

9102 N. Meridian St., Ste. 300
Indianapolis, IN 46260
Homepage: www.GibraltarDesign.com
Email: info@GibraltarDesign.com
Phone 317.580.5777 Fax 317.580.5778

PROJECT

25-174

DATE

07/20/26

COORDINATED BY

RH

DRAWN BY

BR/MH

CHECKED BY

DJ



COPYRIGHT NOTICE:

THE CONCEPTS, DESIGNS, PLANS, DETAILS, ETC., SHOWN ON THIS DOCUMENT ARE THE PROPERTY OF GIBALTAR DESIGN AND WERE CREATED FOR USE ON THIS SPECIFIC PROJECT. NONE OF THIS INFORMATION SHALL BE USED BY ANY PERSON OR FIRM FOR ANY PURPOSE WITHOUT THE EXPRESS WRITTEN CONSENT OF GIBALTAR DESIGN. THE OWNER MAY NOT REPRODUCE OR TRANSMIT THIS INFORMATION OR ANY REFERENCE IN CONNECTION ONLY WITH THIS PROJECT.

REVISIONS

MARK	DATE	ISSUED FOR
AD-04	08/19/26	ADDENDUM 04

DRAWING
UNIT "A" FIRST FLOOR
ELECTRICAL DEMOLITION PLAN

PROJECT
SWAYZEE ES MECHANICAL
IMPROVEMENTS

© GIBALTAR
DESIGN

SHEET

A

ED101

8/18/2026 1:47:05 PM
Autodesk Docs\\2504056 Oak Hill SC - 2028 Construction Projects\\MEG_Oak Hill - Swayzee ES MEP-R25.rvt

GENERAL NOTES

1. REFER TO THE ARCHITECTURAL RCP FOR FINAL CONFIRMATION OF CEILING WORK SCOPE. ROOMS ARE TAGGED ON THIS SHEET (SEE SHEET NOTE "2") FOR CONVENIENCE, BUT FINAL SCOPE SHALL BE VERIFIED WITH THE ARCHITECTURAL RCP.


SHEET NOTES

1. REMOVE EXISTING MECHANICAL EQUIPMENT ELECTRICAL CONNECTION AND ALL ASSOCIATED WIRING AND EXPOSED CONDUIT BACK TO SOURCE. GRIND ANY CONDUIT LEFT WITHIN THE FLOOR BELOW THE FLOOR LINE, INFILL WITH CONCRETE, AND FINISH FLUSH WITH FLOOR. COMPLETE AS REQUIRED. ALL WIRING SHALL BE REMOVED. LABEL EXISTING CIRCUIT BREAKER FOR USE WITH NEW EQUIPMENT IN THIS SPACE. REFER TO THE NEW POWER PLANS FOR ADDITIONAL INFORMATION.
2. REMOVE AND REINSTALL EXISTING LIGHTING, PROJECTORS, WIRELESS TERMINALS, OCCUPANCY SENSORS, AND OTHER CEILING MOUNTED DEVICES IN THIS SPACE AS REQUIRED FOR THE INSTALLATION OF THE NEW DUCTWORK, GRILLES, AND BULKHEAD. THE EXISTING LIGHTING LAYOUT SHALL BE MODIFIED AS REQUIRED FOR THE NEW BULKHEAD. COORDINATE LIGHTING LOCATIONS WITH NEW GRILLES IN FIELD. COMPLETE AS REQUIRED.
3. EXISTING MECHANICAL EQUIPMENT TO REMAIN.
4. IN THIS SPACE, REMOVE ALL EXISTING LIGHT FIXTURE ELECTRICAL CONNECTIONS INCLUDING ALL ASSOCIATED CONDUIT AND WIRING BACK TO NEAREST JUNCTION BOX. EXTEND NEW #12 WIRING IN 3/4" TMC FROM EXISTING JUNCTION BOX TO ALL EXISTING LIGHT FIXTURES AND CONNECT. COMPLETE AS REQUIRED. MAXIMUM FMC LENGTH IS 6'. PROVIDE NEW 3/4" EMT AS REQUIRED FOR LENGTHS EXCEEDING 6'.
5. REMOVE AND RELOCATE LIGHT FIXTURES ALONG THE WALL WITH THE NEW VUV. PRIOR TO REMOVAL, COORDINATE WITH THE NEW SOFFIT LOCATION TO DETERMINE IF THE FIXTURES ARE IN CONFLICT WITH THE BULKHEAD. PROVIDE A LIST OF SPACES WHERE THE BULKHEAD AND FIXTURES ARE NOT IN CONFLICT TO THE ARCHITECT/ENGINEER FOR REVIEW PRIOR TO PROCEEDING.
6. ALL FIXTURES IN THIS SPACE SHALL BE PROVIDED WITH SUPPORTS TO SUSPEND THE FIXTURE FROM THE ROOF STRUCTURE, INDEPENDENT OF THE CEILING GRID. PROVIDE A MINIMUM OF FOUR (4) RODS OR WIRES PER FIXTURE, NOT MORE THAN 6" FROM EACH CORNER.
7. REFER TO THE NEW PLANS FOR THE NEW LOCATION OF UNIT VENTILATOR. ANY EXISTING CONDUIT, WIRING, ETC. SERVING OTHER DEVICES OR EQUIPMENT IN THE NEW UNIT VENTILATOR LOCATION (INTERIOR OR EXTERIOR) SHALL BE MAINTAINED. REROUTE CONDUIT THROUGH, AROUND, OR ABOVE THE NEW UNIT VENTILATOR AS REQUIRED TO MAINTAIN EXISTING CIRCUIT CONTINUITY. ANY DEVICES IN CONFLICT WITH THE NEW LOCATIONS SHALL BE REMOVED AND RELOCATED TO THE SIDE OF THE UNIT. VERIFY THE FINAL LOCATION OF ANY DEVICES IN FIELD.


AD-04

DEMOLITION NOTES

- A. COORDINATE PHASING OF WORK AND PROVIDE TEMPORARY POWER AND SERVICES AS REQUIRED FOR THE IMPLEMENTATION OF ALL WORK WHILE MAINTAINING SERVICES TO PORTIONS OF BUILDING TO REMAIN OCCUPIED.
- B. DISCONNECT AND REMOVE EXISTING ELECTRICAL DEVICES, EQUIPMENT, LIGHTING, WIRING, ETC., AS REQUIRED TO FACILITATE DEMOLITION AND RECONSTRUCTION WORK. COORDINATE WITH GENERAL CONSTRUCTION. THE CONTRACTOR IS HEREBY ADVISED THAT THESE DRAWINGS MAY NOT INDICATE ALL EXISTING WIRING AND/OR EQUIPMENT WHICH MUST BE REMOVED, REWORKED, RELOCATED, ETC., TO ACCOMMODATE DEMOLITION AND RECONSTRUCTION WORK IN THE EXISTING BUILDING.
- C. SCHEDULE ALL WORK TO AVOID DOWNTIME AND INCONVENIENCE TO OWNER. OWNER'S EXISTING FACILITY SHALL REMAIN IN OPERATION AT ALL TIMES, INCLUDING FIA AND OTHER SPECIAL SYSTEMS. ELECTRICAL POWER DISTRIBUTION, ETC. ALL REQUIRED SHUTDOWN OF EXISTING FACILITY UTILITIES SHALL BE SCHEDULED WITH OWNER'S OPERATING PERSONNEL.
- D. ALL EXISTING EQUIPMENT SHALL REMAIN PROPERTY OF THE OWNER AND OWNER SHALL DETERMINE IF CONTRACTOR IS TO STORE EQUIPMENT ON SITE AT OWNER SELECTED LOCATION OR IF CONTRACTOR IS TO ABANDON OR REMOVE EQUIPMENT FROM SITE.
- E. CONTRACTOR TO FIELD VERIFY IF EXISTING ASBESTOS WILL BE ENCOUNTERED PRIOR TO STARTING ANY WORK. IF ASBESTOS IS PRESENT, THE OWNER WILL PROVIDE FOR THE REMOVAL OF ANY MATERIAL CONTAINING ASBESTOS. SEE SPECIFICATIONS FOR FURTHER REQUIREMENTS.
- F. ANY HIDDEN CONDITIONS IDENTIFIED THROUGH THE COURSE OF CONSTRUCTION SHALL BE IMMEDIATELY BROUGHT TO THE ATTENTION OF THE ARCHITECT IN WRITTEN FORM FOR REVIEW AND DIRECTION. FAILURE TO DO SO SHALL MAKE THE CONTRACTOR RESPONSIBLE FOR ANY AND ALL REQUIRED CHANGES AND COSTS TO CORRECT SAID HIDDEN CONDITION.
- G. EXISTING INFORMATION IDENTIFIED ON THE CONTRACT DOCUMENTS IS SCHEMATIC ONLY AS AN AID TO THE CONTRACTOR. CONTRACTOR SHALL BE RESPONSIBLE TO PROPERLY ADDRESS ALL EXISTING CONDITIONS FOR A COMPLETE AND PROPER INSTALLATION OF NEW SYSTEMS. ALL EXISTING EQUIPMENT NOT IDENTIFIED SHALL BE BROUGHT TO THE ATTENTION OF THE ARCHITECT/ENGINEER FOR REVIEW AS TO WHETHER THE EQUIPMENT SHALL REMAIN AND BE RECONNECTED TO THE NEW SERVICES, BE RELOCATED, BE ABANDONED, ETC.
- H. DISCONNECT AND REMOVE EXISTING LIGHTING FIXTURES AND ANY OTHER CEILING DEVICES AS REQUIRED FOR INSTALLATION OF WORK (ALL TRADES). REINSTALL UPON COMPLETION OF WORK. REPAIR ALL DAMAGED FIXTURES AND DEVICES.
- I. VISIT SITE PRIOR TO BIDDING TO DETERMINE ALL FIELD CONDITIONS. VERIFY ALL EXISTING INTERIOR AND EXTERIOR ELECTRICAL SYSTEMS TO VERIFY QUANTITIES AND LOCATIONS OF EXISTING SYSTEMS TO DETERMINE FULL EXTENT OF DEMOLITION WORK.
- J. ALL EXISTING LIGHTING FIXTURES, ELECTRICAL DEVICES, CONDUIT, ETC., SHALL BE REMOVED AS NOTED ON DRAWINGS AND AS REQUIRED TO MEET NEW SCOPE OF WORK. ALL EXISTING ELECTRICAL EQUIPMENT SHALL REMAIN PROPERTY OF THE OWNER AND SHALL BE PROPERLY STORED ON SITE, OR DESIGNATED TO BE ABANDONED AND REMOVED FROM SITE AS DIRECTED BY OWNER.
- K. EXISTING ELECTRICAL DEVICES (RECEPTACLES, SWITCHES, OUTLET BOXES, CONDUIT, ETC.) WITHIN WALLS TO BE REMOVED SHALL BE DISCONNECTED COMPLETELY. REROUTE CIRCUITRY AS REQUIRED TO MAINTAIN CIRCUIT CONTINUITY FOR ALL REMAINING DEVICES/EQUIPMENT. VERIFY EXACT CONDITIONS AND QUANTITIES IN FIELD.
- L. PATCH ALL EXISTING CEILING, FLOOR, WALL AND ROOF OPENINGS AND SURROUNDING FINISHES RESULTING FROM REMOVAL OF EXISTING MATERIALS AND EQUIPMENT SO THAT FINISH WILL MATCH EXISTING IN SURROUNDING AREAS.

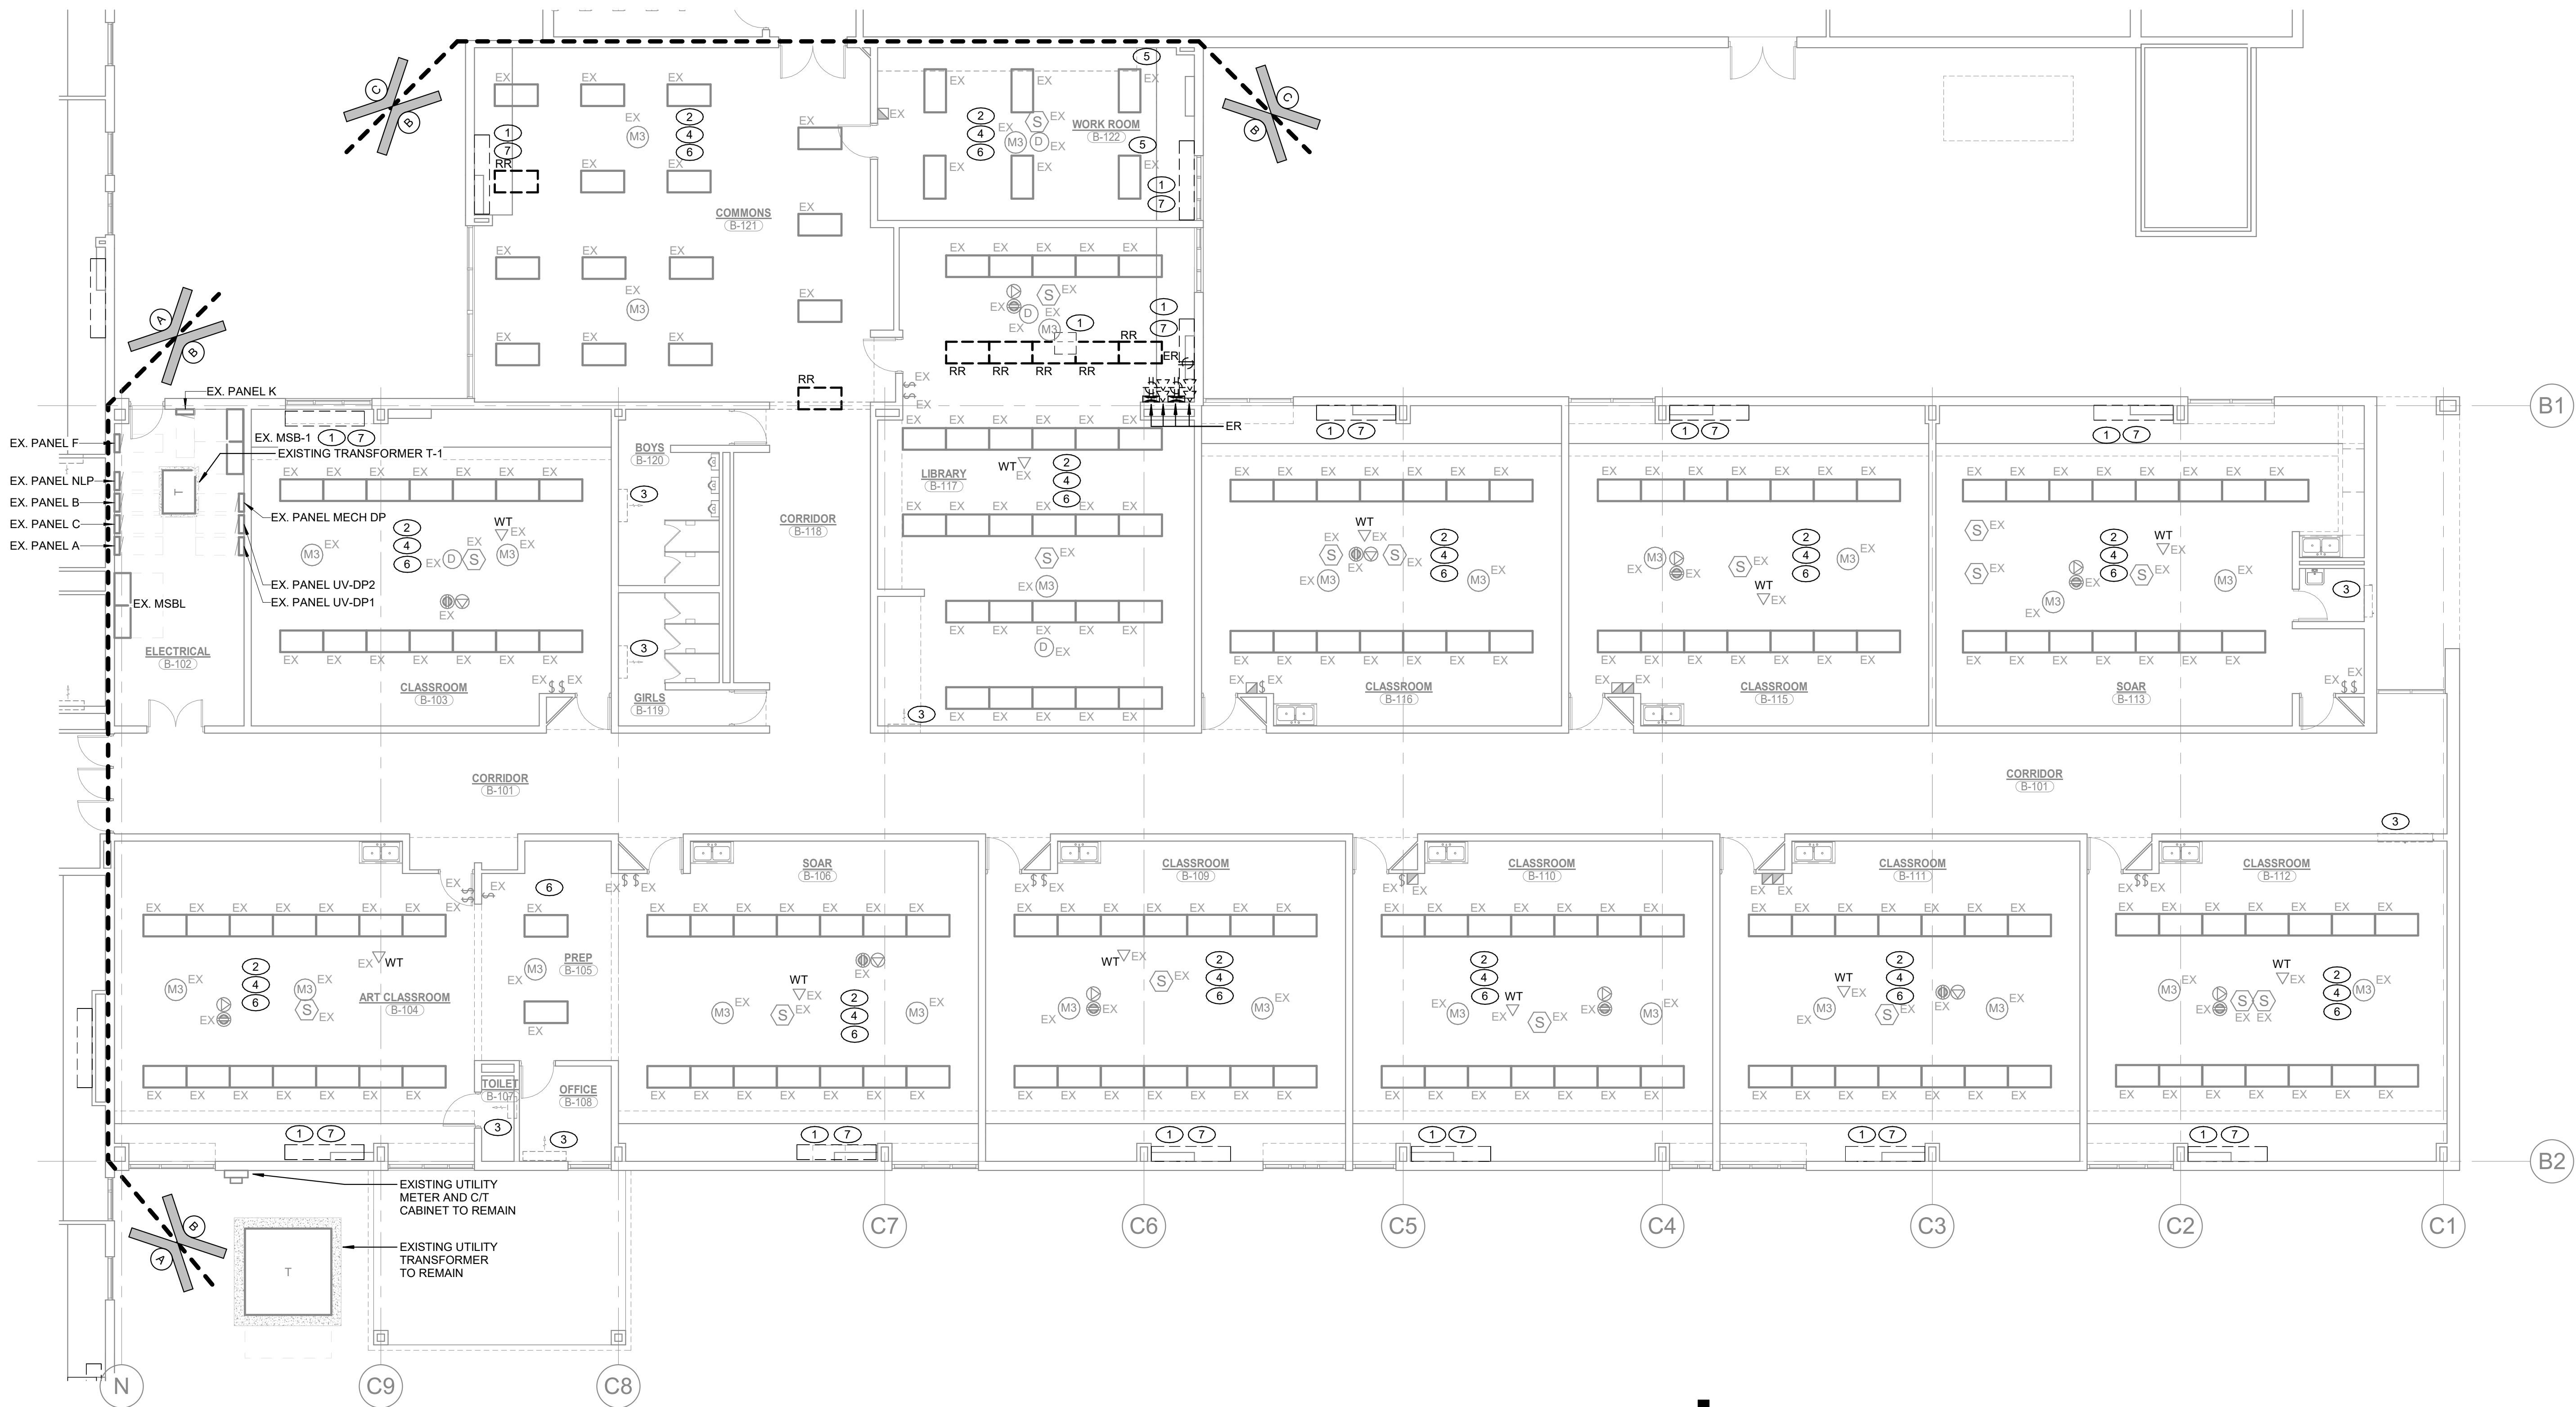

1
ED102/ 1/8" = 1'-0"

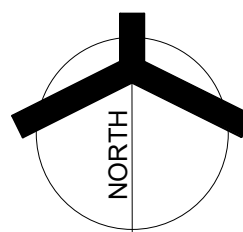

GIBALTAR

DESIGN

ARCHITECTURE • ENGINEERING • INTERIOR DESIGN



MILLIES

ENGINEERING GROUP
(202) 924-6400
www.milliesengineeringgroup.com

PROJECT:

**SWAYZEE ES
MECHANICAL
IMPROVEMENTS**

OAK HILL UNITED SCHOOL
CORPORATION

405 S WASHINGTON ST.,
SWAYZEE IN, 46986



KEY PLAN



100% CONSTRUCTION
DOCUMENTS

GIBALTAR DESIGN

9102 N. Meridian St., Ste. 300
Indianapolis, IN 46260
Homepage: www.GibraltarDesign.com
Email: info@GibraltarDesign.com
Phone 317.580.5777 Fax 317.580.5778

PROJECT

25-174

DATE

07/20/26

COORDINATED BY


RH

DRAWN BY

BR/MH

CHECKED BY

DJ

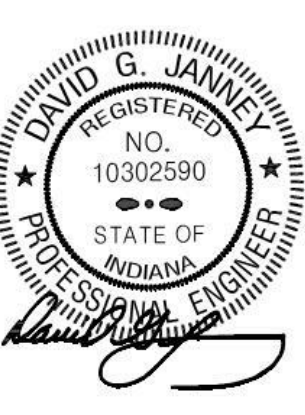

COPYRIGHT NOTICE:

THE CONCEPTS, DESIGNS, PLANS, DETAILS, ETC., SHOWN ON THIS DOCUMENT ARE THE PROPERTY OF GIBALTAR DESIGN AND WERE CREATED FOR USE ON THIS SPECIFIC PROJECT. NONE OF THIS INFORMATION SHALL BE USED BY ANY PERSON OR FIRM FOR ANY PURPOSE WITHOUT THE EXPRESS WRITTEN CONSENT OF GIBALTAR DESIGN. THE OWNER MAY RETAIN COPIES FOR INFORMATION AND REFERENCE IN CONNECTION ONLY WITH THIS PROJECT.

REVISIONS

MARK	DATE	ISSUED FOR
AD-01	07/31/26	ADDENDUM 01
AD-04	08/19/26	ADDENDUM 04

DRAWING
UNIT "B" FIRST FLOOR
ELECTRICAL DEMOLITION PLAN


PROJECT
SWAYZEE ES MECHANICAL
IMPROVEMENTS

© GIBALTAR
DESIGN

SHEET

B


ED102

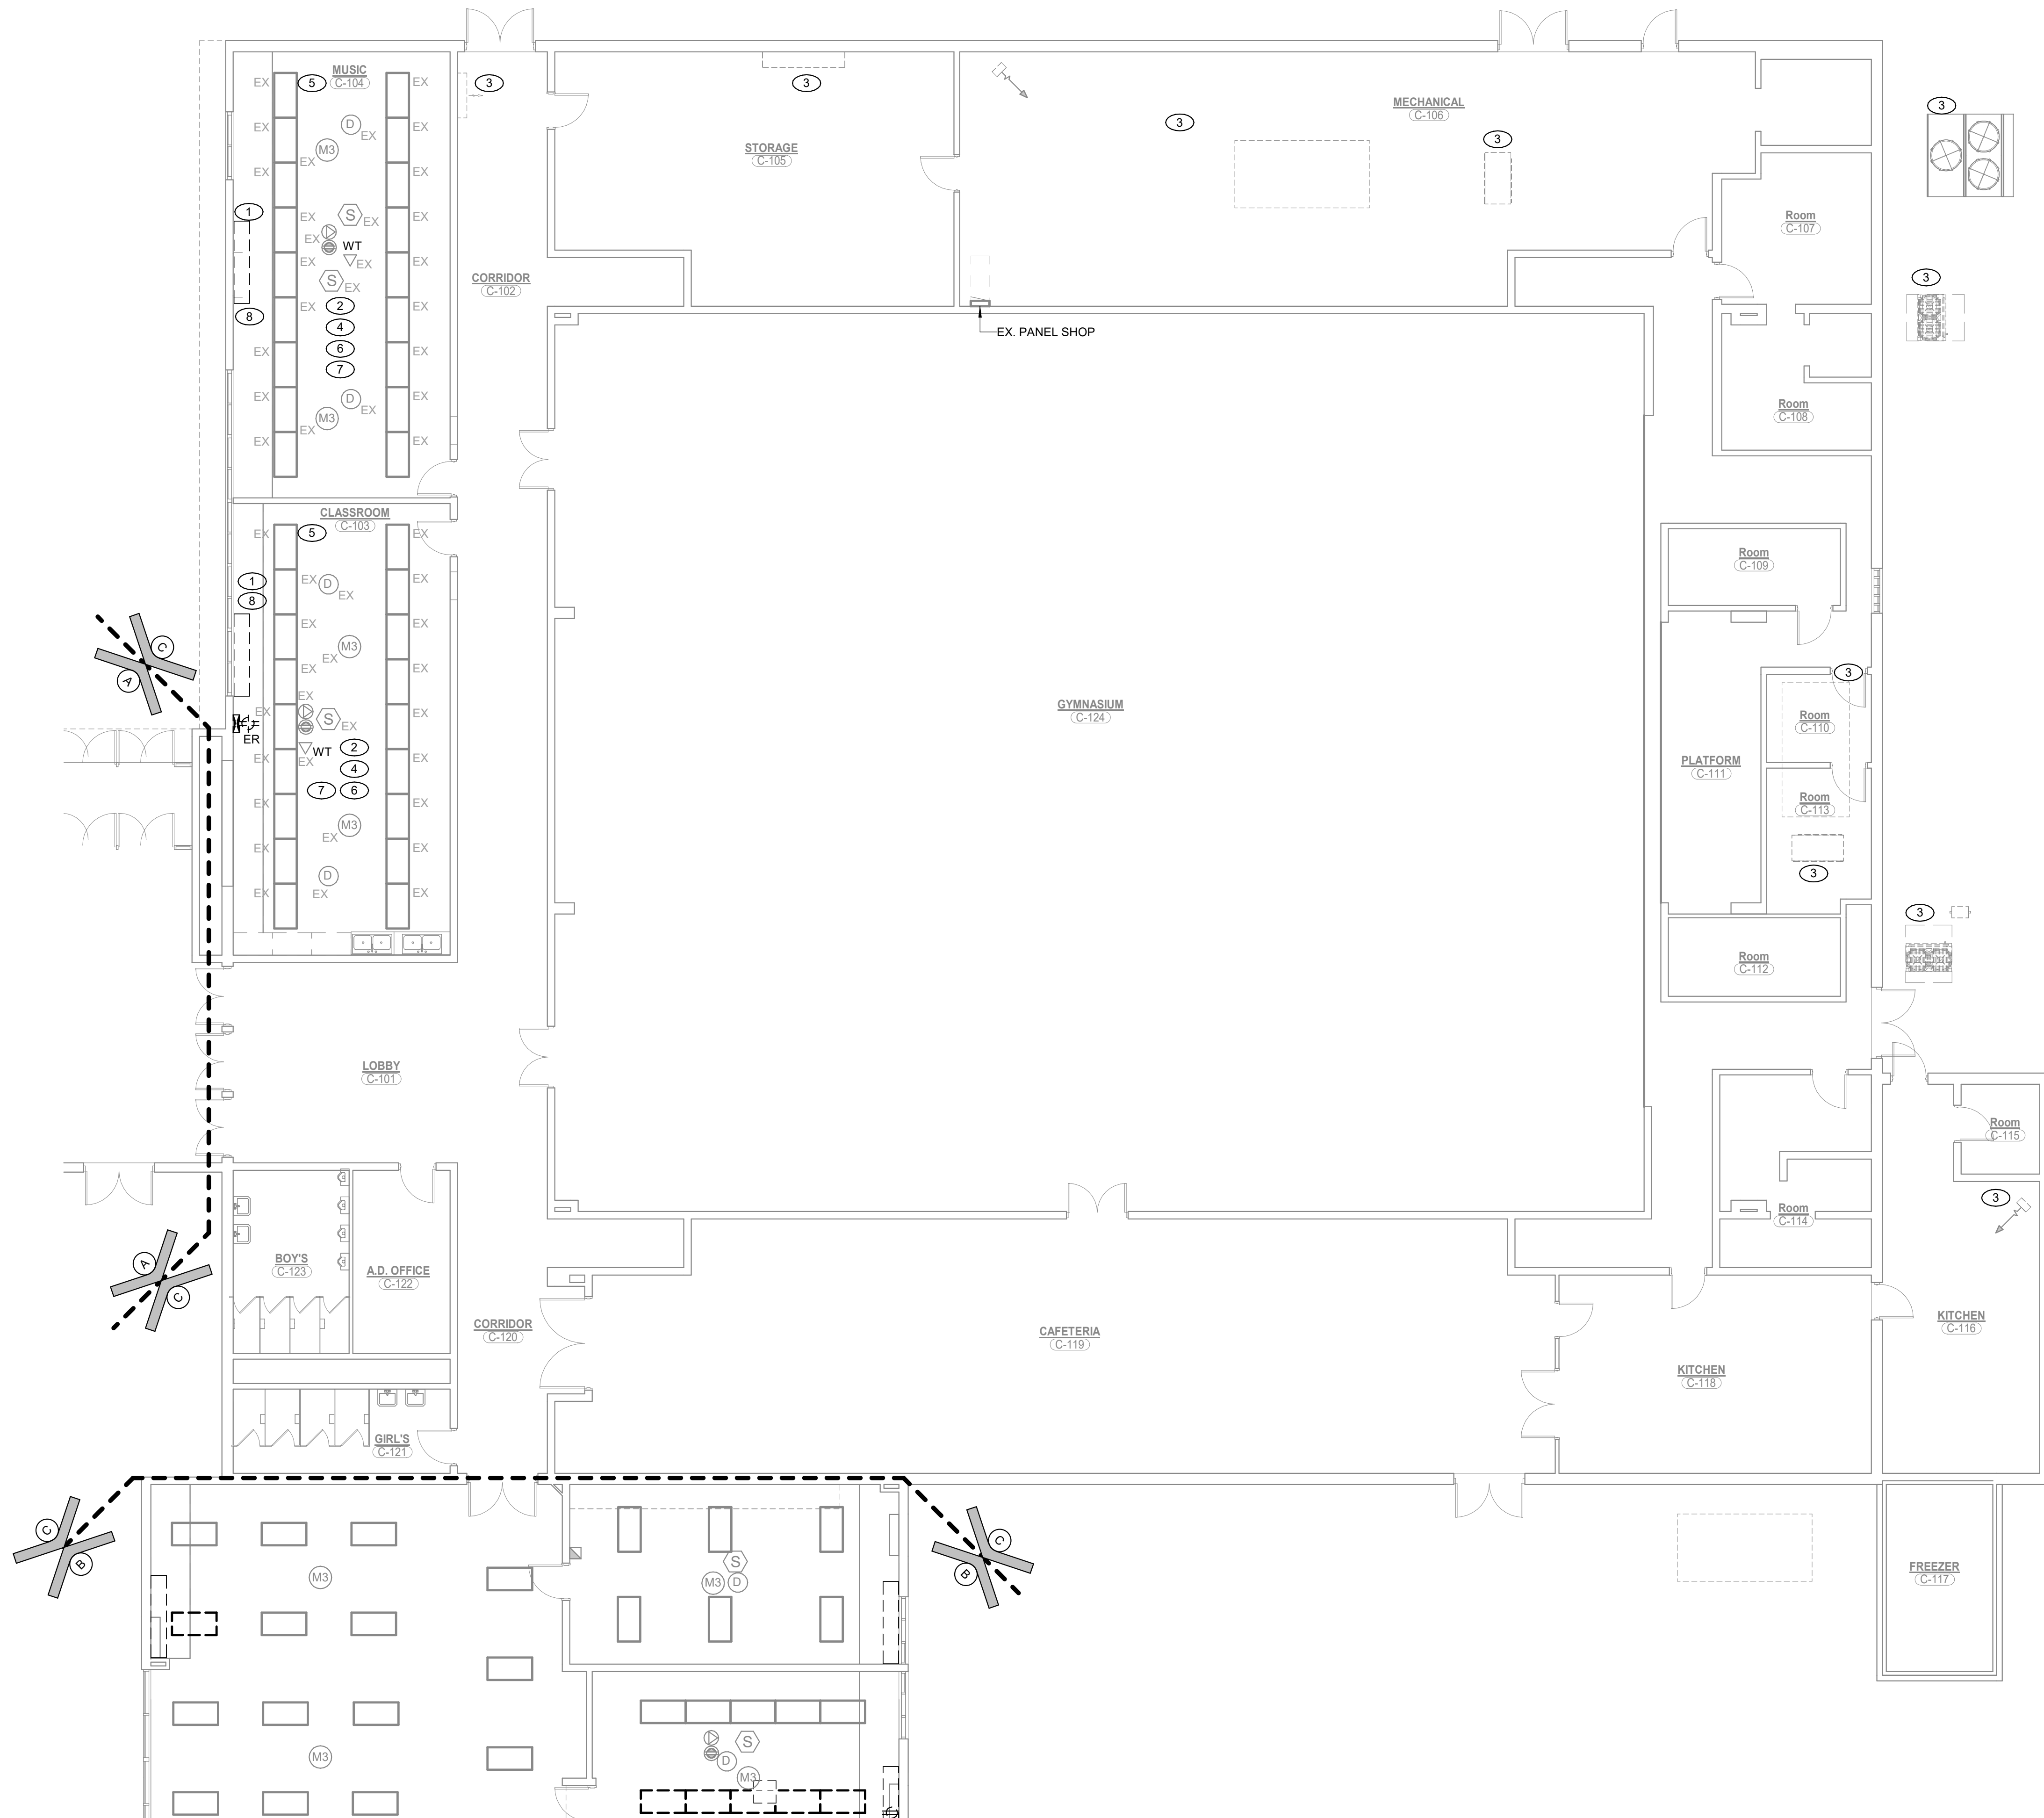

1
ED103

UNIT "C" FIRST FLOOR ELECTRICAL DEMOLITION PLAN

1/8" = 1'-0"

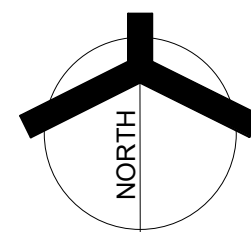

DEMOLITION NOTES

- COORDINATE PHASING OF WORK AND PROVIDE TEMPORARY POWER AND SERVICES AS REQUIRED FOR THE IMPLEMENTATION OF ALL WORK WHILE MAINTAINING SERVICES TO PORTIONS OF BUILDING TO REMAIN OCCUPIED.
- DISCONNECT AND REMOVE EXISTING ELECTRICAL DEVICES, EQUIPMENT, LIGHTING, WIRING, ETC., AS REQUIRED TO FACILITATE DEMOLITION AND RECONSTRUCTION WORK. COORDINATE WITH GENERAL CONSTRUCTION. THE CONTRACTOR IS HEREBY ADVISED THAT THESE DRAWINGS MAY NOT INDICATE ALL EXISTING WIRING AND/OR EQUIPMENT WHICH MUST BE REMOVED, REWORKED, RELOCATED, ETC., TO ACCOMMODATE DEMOLITION AND RECONSTRUCTION WORK IN THE EXISTING BUILDING.
- SCHEDULE ALL WORK TO AVOID DOWNTIME AND INCONVENIENCE TO OWNER. OWNER'S EXISTING FACILITY SHALL REMAIN IN OPERATION AT ALL TIMES, INCLUDING F/A AND OTHER SPECIAL SYSTEMS, ELECTRICAL POWER DISTRIBUTION, ETC. ALL REQUIRED SHUTDOWN OF EXISTING FACILITY UTILITIES SHALL BE SCHEDULED WITH OWNER'S OPERATING PERSONNEL.
- ALL EXISTING EQUIPMENT SHALL REMAIN PROPERTY OF THE OWNER AND OWNER SHALL DETERMINE IF CONTRACTOR IS TO STORE EQUIPMENT ON SITE AT OWNER SELECTED LOCATION OR IF CONTRACTOR IS TO ABANDON OR REMOVE EQUIPMENT FROM SITE.
- CONTRACTOR TO FIELD VERIFY IF EXISTING ASBESTOS WILL BE ENCOUNTERED PRIOR TO STARTING ANY WORK. IF ASBESTOS IS PRESENT, THE OWNER WILL PROVIDE FOR THE REMOVAL OF ANY MATERIAL CONTAINING ASBESTOS. SEE SPECIFICATIONS FOR FURTHER REQUIREMENTS.
- ANY HIDDEN CONDITIONS IDENTIFIED THROUGH THE COURSE OF CONSTRUCTION SHALL BE IMMEDIATELY BROUGHT TO THE ATTENTION OF THE ARCHITECT IN WRITTEN FORM FOR REVIEW AND DIRECTION. FAILURE TO DO SO SHALL MAKE THE CONTRACTOR RESPONSIBLE FOR ANY AND ALL REQUIRED CHANGES AND COSTS TO CORRECT SAID HIDDEN CONDITION.
- EXISTING INFORMATION IDENTIFIED ON THE CONTRACT DOCUMENTS IS SCHEMATIC ONLY AS AN AID TO THE CONTRACTOR. CONTRACTOR SHALL BE RESPONSIBLE TO PROPERLY ADDRESS ALL EXISTING CONDITIONS FOR A COMPLETE AND PROPER INSTALLATION OF NEW SYSTEMS. ALL EXISTING EQUIPMENT NOT IDENTIFIED SHALL BE BROUGHT TO THE ATTENTION OF THE ARCHITECT/ENGINEER FOR REVIEW AS TO WHETHER THE EQUIPMENT SHALL REMAIN AND BE RECONNECTED TO THE NEW SERVICES, BE RELOCATED, BE ABANDONED, ETC.
- DISCONNECT AND REMOVE EXISTING LIGHTING FIXTURES AND ANY OTHER CEILING DEVICES AS REQUIRED FOR INSTALLATION OF WORK. REPAIR ALL DAMAGED FIXTURES AND DEVICES.
- VISIT SITE PRIOR TO BIDDING TO DETERMINE ALL FIELD CONDITIONS. VERIFY ALL EXISTING INTERIOR AND EXTERIOR ELECTRICAL SYSTEMS TO VERIFY QUANTITIES AND LOCATIONS OF EXISTING SYSTEMS TO DETERMINE FULL EXTENT OF DEMOLITION WORK.
- ALL EXISTING LIGHTING FIXTURES, ELECTRICAL DEVICES, CONDUIT, ETC., SHALL BE REMOVED AS NOTED ON DRAWINGS AND AS REQUIRED TO MEET NEW SCOPE OF WORK. ALL EXISTING ELECTRICAL EQUIPMENT SHALL REMAIN PROPERTY OF THE OWNER AND SHALL BE PROPERLY STORED ON SITE, OR DESIGNATED TO BE ABANDONED AND REMOVED FROM SITE AS DIRECTED BY OWNER.
- EXISTING ELECTRICAL DEVICES (RECEPTACLES, SWITCHES, OUTLET BOXES, CONDUIT, ETC.) WITHIN WALLS TO BE REMOVED SHALL BE DISCONNECTED COMPLETELY. REROUTE CIRCUITRY AS REQUIRED TO MAINTAIN CIRCUIT CONTINUITY FOR ALL REMAINING DEVICES/EQUIPMENT. VERIFY EXACT CONDITIONS AND QUANTITIES IN FIELD.
- PATCH ALL EXISTING CEILING, FLOOR, WALL AND ROOF OPENINGS AND SURROUNDING FINISHES RESULTING FROM REMOVAL OF EXISTING MATERIALS AND EQUIPMENT SO THAT FINISH WILL MATCH EXISTING IN SURROUNDING AREAS.

SHEET NOTES

- REMOVE EXISTING MECHANICAL EQUIPMENT ELECTRICAL CONNECTION AND ALL ASSOCIATED WIRING AND EXPOSED CONDUIT BACK TO SOURCE. GRIND ANY CONDUIT LEFT WITHIN THE FLOOR BELOW THE FLOOR LINE, INFILL WITH CONCRETE, AND FINISH FLUSH WITH FLOOR. COMPLETE AS REQUIRED. ALL WIRING SHALL BE REMOVED. LABEL EXISTING CIRCUIT BREAKER FOR USE WITH NEW EQUIPMENT IN THIS SPACE. REFER TO THE NEW POWER PLANS FOR ADDITIONAL INFORMATION.
- REMOVE AND REINSTALL EXISTING LIGHTING, PROJECTORS, WIRELESS TERMINALS, OCCUPANCY SENSORS, AND OTHER CEILING MOUNTED DEVICES IN THIS SPACE AS REQUIRED FOR THE INSTALLATION OF THE NEW DUCTWORK, GRILLES, AND BULKHEAD. THE EXISTING LIGHTING LAYOUT SHALL BE MODIFIED AS REQUIRED FOR THE NEW BULKHEAD. COORDINATE LIGHTING LOCATIONS WITH NEW GRILLES IN FIELD. COMPLETE AS REQUIRED.
- EXISTING MECHANICAL EQUIPMENT TO REMAIN.
- IN THIS SPACE, REMOVE ALL EXISTING LIGHT FIXTURE ELECTRICAL CONNECTIONS INCLUDING ALL ASSOCIATED CONDUIT AND WIRING BACK TO NEAREST JUNCTION BOX. EXTEND NEW #12 WIRING IN 3/4" FMC FROM EXISTING JUNCTION BOX TO ALL EXISTING LIGHT FIXTURES AND CONNECT. COMPLETE AS REQUIRED. MAXIMUM FMC LENGTH IS 6'. PROVIDE NEW 3/4" EMT AS REQUIRED FOR LENGTHS EXCEEDING 6'.
- REMOVE AND RELOCATE LIGHT FIXTURES ALONG THE WALL WITH THE NEW VUV. PRIOR TO REMOVAL, COORDINATE WITH THE NEW SOFFIT LOCATION TO DETERMINE IF THE FIXTURES ARE IN CONFLICT WITH THE BULKHEAD. PROVIDE A LIST OF SPACES WHERE THE BULKHEAD AND FIXTURES ARE NOT IN CONFLICT TO THE ARCHITECT/ENGINEER FOR REVIEW PRIOR TO PROCEEDING.
- REMOVE AND REINSTALL EXISTING BRANCH CIRCUITRY INSTALLED ABOVE THE CEILING GRID THAT IS NOT PROPERLY CONNECTED TO THE CEILING STRUCTURE BY CODE. THESE BRANCH CIRCUITS SHALL BE RAISED TO THE BOTTOM CHORD OF THE CEILING STRUCTURE AND PROPERLY SUPPORTED. PROVIDE NEW CONDUIT AND WIRING (MATCHING EXISTING) TO EXTEND THE EXISTING ELECTRICAL CONNECTIONS TO THE NEW BRANCH CIRCUIT ROUTING AND CONNECT. COMPLETE AS REQUIRED.
- ALL FIXTURES IN THIS SPACE SHALL BE PROVIDED WITH SUPPORTS TO SUSPEND THE FIXTURE FROM THE ROOF STRUCTURE, INDEPENDENT OF THE CEILING GRID. PROVIDE A MINIMUM OF FOUR (4) RODS OR WIRES PER FIXTURE. NOT MORE THAN 6" FROM EACH CORNER.
- REFER TO THE NEW PLANS FOR THE NEW LOCATION OF UNIT VENTILATOR. ANY EXISTING CONDUIT, WIRING, ETC. SERVING OTHER DEVICES OR EQUIPMENT IN THE NEW UNIT VENTILATOR LOCATION (INTERIOR OR EXTERIOR) SHALL BE MAINTAINED. REROUTE CONDUIT THROUGH, AROUND, OR ABOVE THE NEW UNIT VENTILATOR AS REQUIRED TO MAINTAIN EXISTING CIRCUIT CONTINUITY. ANY DEVICES IN CONFLICT WITH THE NEW LOCATIONS SHALL BE REMOVED AND RELOCATED TO THE SIDE OF THE UNIT. VERIFY THE FINAL LOCATION OF ANY DEVICES IN FIELD.

GENERAL NOTES

- REFER TO THE ARCHITECTURAL RCP FOR FINAL CONFIRMATION OF CEILING WORK SCOPE. ROOMS ARE TAGGED ON THIS SHEET (SEE SHEET NOTE "2") FOR CONVENIENCE, BUT FINAL SCOPE SHALL BE VERIFIED WITH THE ARCHITECTURAL RCP.



GIBALTAR
DESIGN

ARCHITECTURE • ENGINEERING • INTERIOR DESIGN




PROJECT:

SWAYZEE ES MECHANICAL IMPROVEMENTS

OAK HILL UNITED SCHOOL
CORPORATION

405 S WASHINGTON ST.,
SWAYZEE IN, 46986

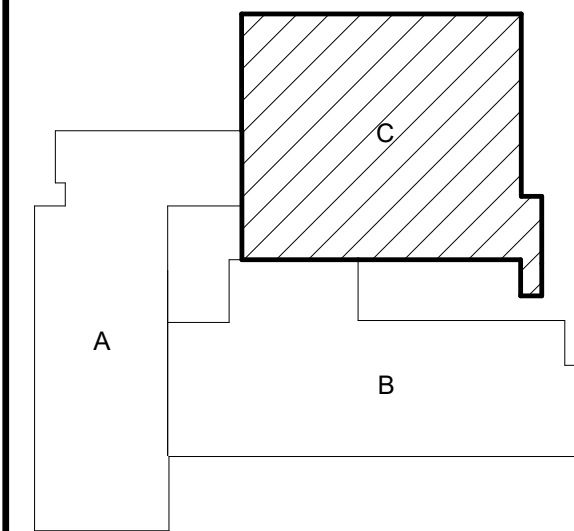

KEY PLAN



100% CONSTRUCTION
DOCUMENTS

GIBALTAR DESIGN

9102 N. Meridian St., Ste. 300
Indianapolis, IN 46260
Homepage: www.GibraltarDesign.com
Email: info@GibraltarDesign.com
Phone 317.580.5777 Fax 317.580.5778

PROJECT

25-174

DATE

07/20/26

COORDINATED BY

RH

DRAWN BY

BR/MH

CHECKED BY

DJ



COPYRIGHT NOTICE:

THE CONCEPTS, DESIGNS, PLANS, DETAILS, ETC., SHOWN ON THIS DOCUMENT ARE THE PROPERTY OF GIBALTAR DESIGN AND WERE CREATED FOR USE ON THIS SPECIFIC PROJECT. NONE OF THIS INFORMATION SHALL BE USED BY ANY PERSON OR FIRM FOR ANY PURPOSE WITHOUT THE EXPRESS WRITTEN CONSENT OF GIBALTAR DESIGN. THE OWNER MAY NOT REPRODUCE OR TRANSMIT THIS INFORMATION OR ANY CONNECTION ONLY WITH THIS PROJECT.

REVISIONS

MARK	DATE	ISSUED FOR
AD-04	08/19/26	ADDENDUM 04

DRAWING
UNIT "C" FIRST FLOOR
ELECTRICAL DEMOLITION PLAN

PROJECT
SWAYZEE ES MECHANICAL
IMPROVEMENTS


© GIBALTAR
DESIGN

SHEET

C

ED103

8/18/2026 1:47:12 PM
Autodesk Docs://2504056 Oak Hill SC - 2026 Construction Projects/MEG_Oak Hill - Swayzee ES MEP-R25.rvt

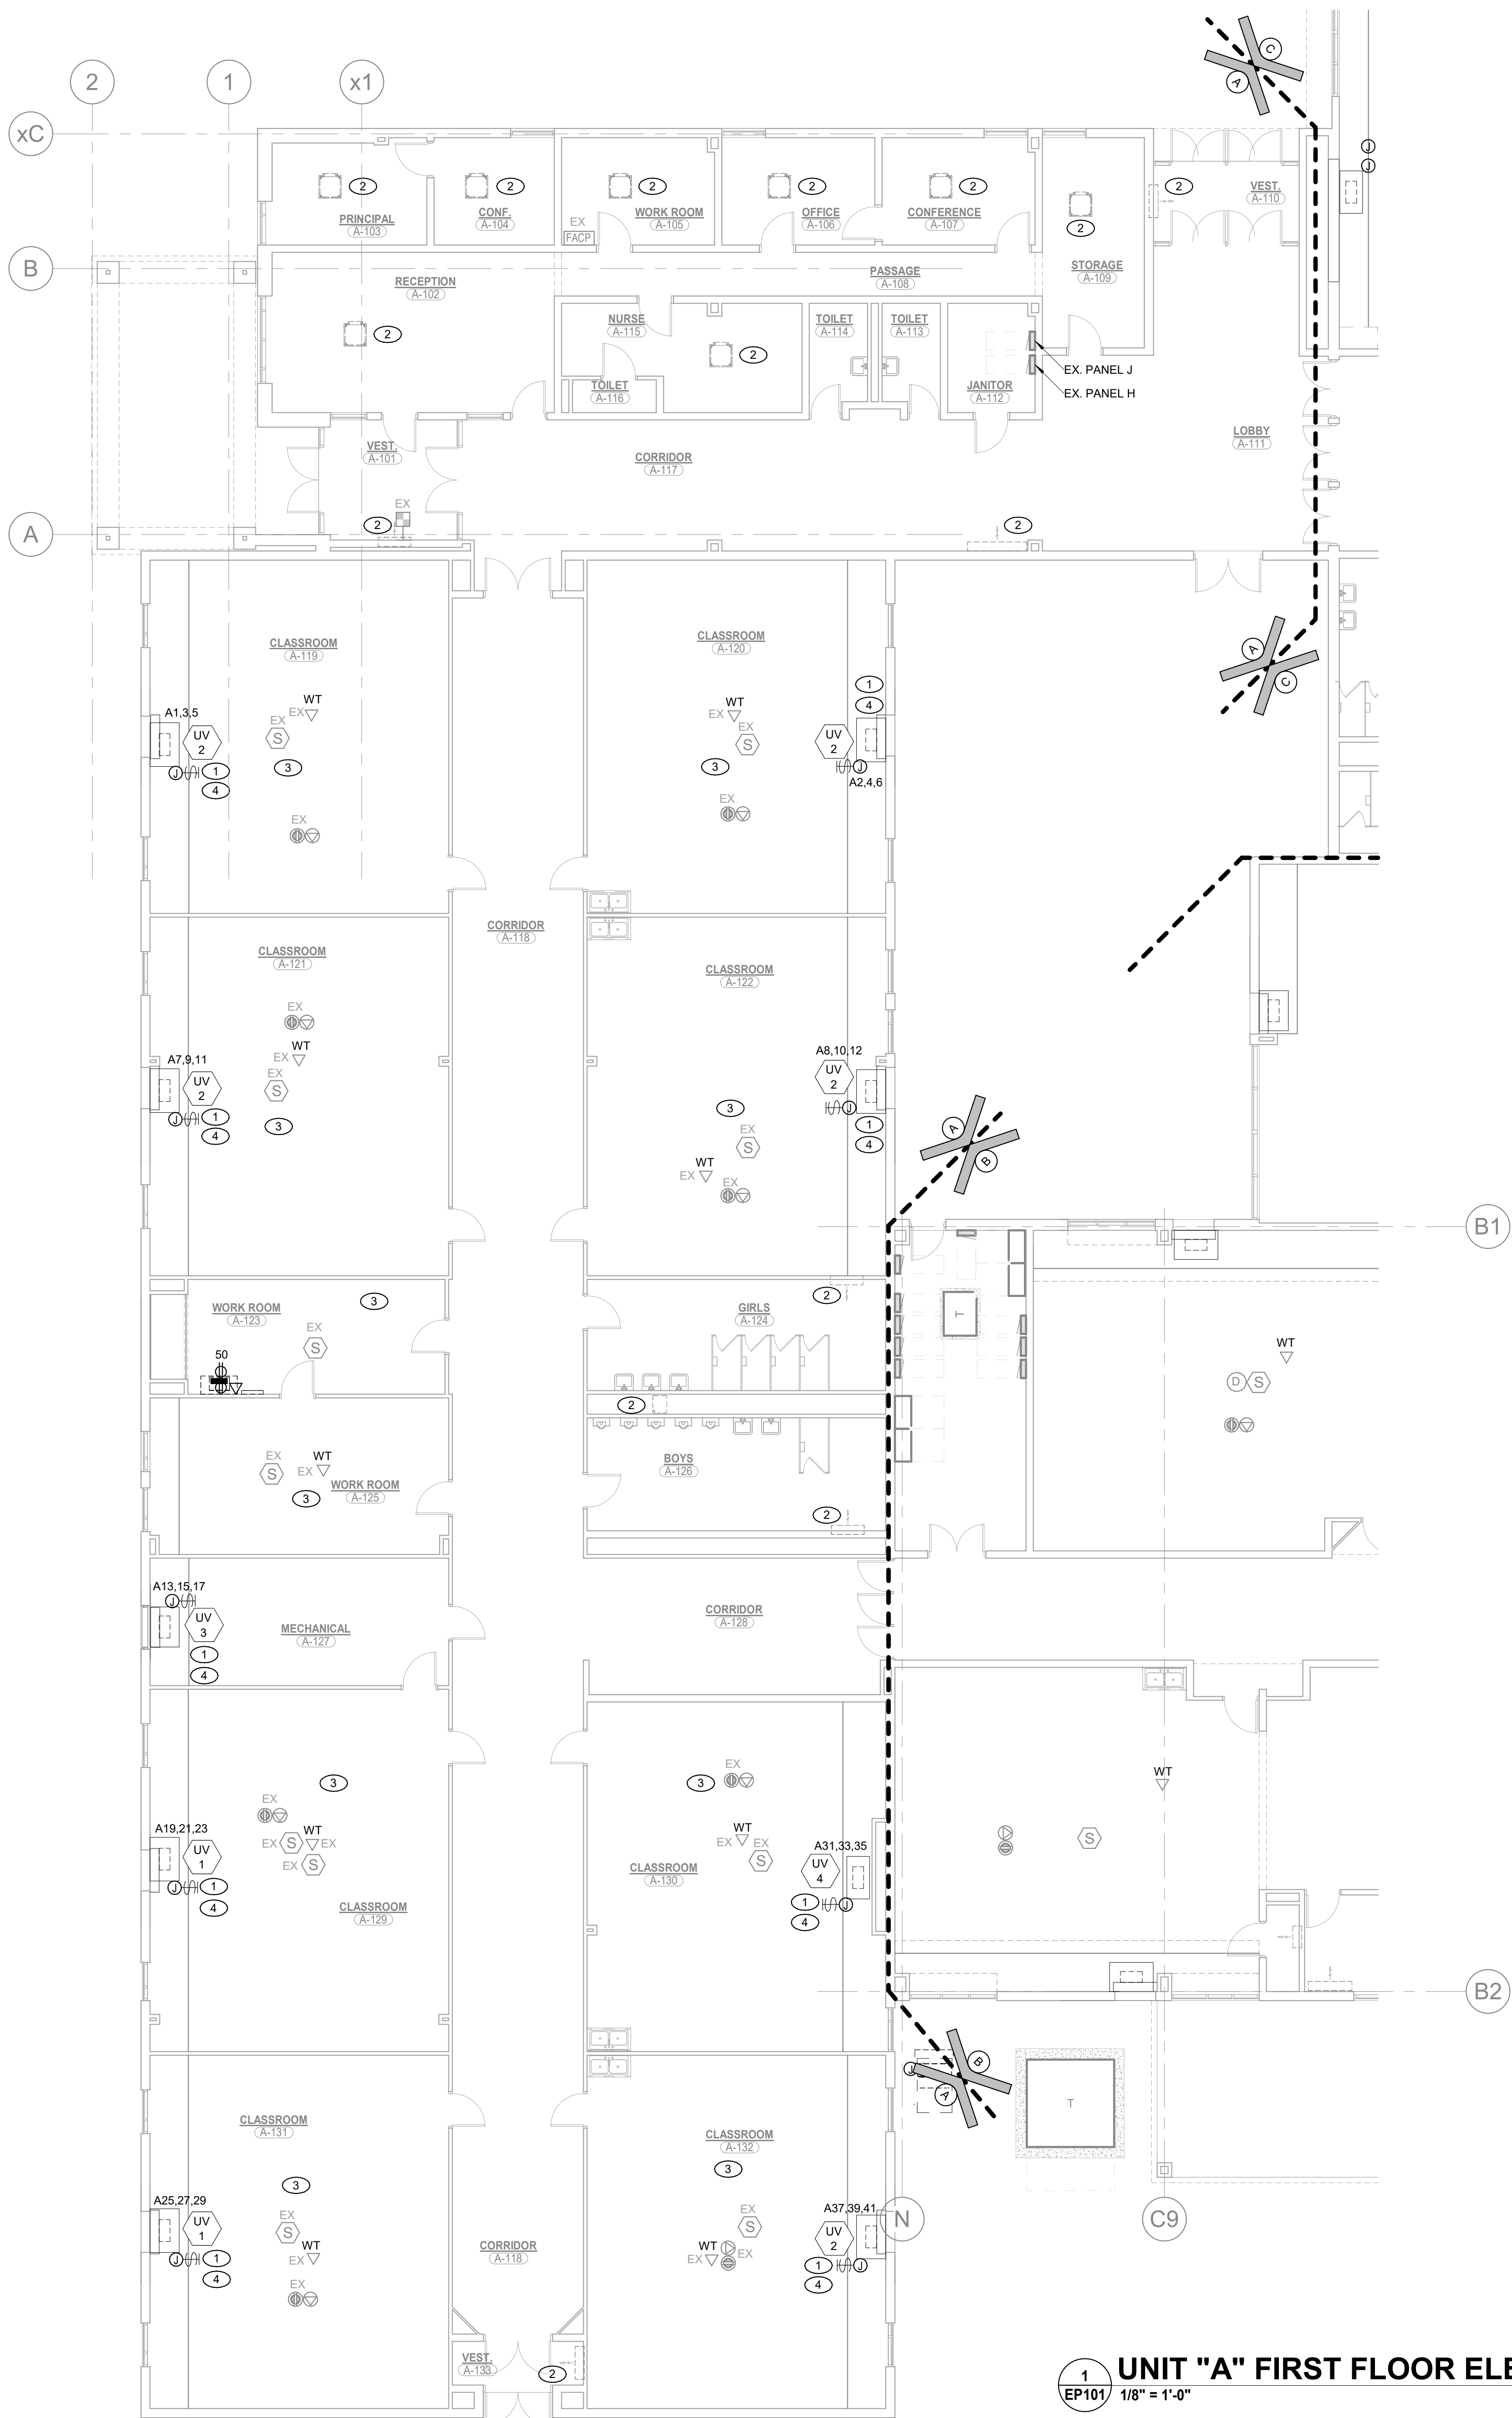


1 UNIT "A" FIRST FLOOR ELECTRICAL POWER PLAN
EP101 1/8" = 1'-0"

- ### SHEET NOTES
1. REFER TO MECHANICAL CONNECTION SCHEDULE FOR ADDITIONAL WIRING AND CIRCUIT INFORMATION. ROUTE NEW FEED OVERHEAD TO THE EXISTING PANEL SERVING THIS EQUIPMENT (OR AS NOTED IN THE MECHANICAL EQUIPMENT SCHEDULE). REMOVE AND REINSTALL EXISTING CEILING TILES, LIGHTING, AND OTHER DEVICES AS REQUIRED TO ROUTE THE CONDUIT, CONCEALED, IN ALL SPACES WITH ACT. CONDUIT IN EXPOSED CEILING AREAS SHALL BE ROUTED HIGH AND TIGHT TO THE CEILING AND PAINTED TO MATCH THE SURROUNDING SURFACE. ANY CONDUIT ROUTES THROUGH EXPOSED CEILING SPACES SHALL BE REVIEWED WITH THE ARCHITECT PRIOR TO ROUGH-IN. ADJUST THE ROUTING AS REQUIRED.
 2. EXISTING MECHANICAL EQUIPMENT TO REMAIN.
 3. REMOVE AND REINSTALL ALL EXISTING CEILING MOUNTED DEVICES, INCLUDING BUT NOT LIMITED TO, LUMINAIRES, FIRE ALARM DEVICES, SPEAKERS, PROJECTORS, WIRELESS TERMINALS, AND SENSORS, AS REQUIRED TO INSTALL NEW DUCTWORK AND CEILING GRID. PROVIDE ALL NECESSARY CONDUIT, WIRING, ETC. TO MAINTAIN EXISTING CONNECTIONS FOR ALL DEVICES TO REMAIN COMPLETE AS REQUIRED.
 4. REFER TO SHEET NOTE #7 ON SHEET ED101 FOR ADDITIONAL INFORMATION.

- ### GENERAL NOTES
1. REFER TO THE ARCHITECTURAL RCP FOR FINAL CONFIRMATION OF CEILING WORK SCOPE. ROOMS ARE TAGGED ON THIS SHEET (SEE SHEET NOTE "3") FOR CONVENIENCE, BUT FINAL SCOPE SHALL BE VERIFIED WITH THE ARCHITECTURAL RCP.
 2. CIRCUIT ALL DEVICES WITH PREFIX "A" TO PANEL UV-0P1. CIRCUIT ALL DEVICES WITH PREFIX "B" TO PANEL UV-0P2. CIRCUIT ALL OTHER DEVICES TO PANEL NLP UNLESS OTHERWISE NOTED.




PROJECT:
SWAYZEE ES MECHANICAL IMPROVEMENTS
OAK HILL UNITED SCHOOL CORPORATION
405 S WASHINGTON ST.,
SWAYZEE IN, 46986

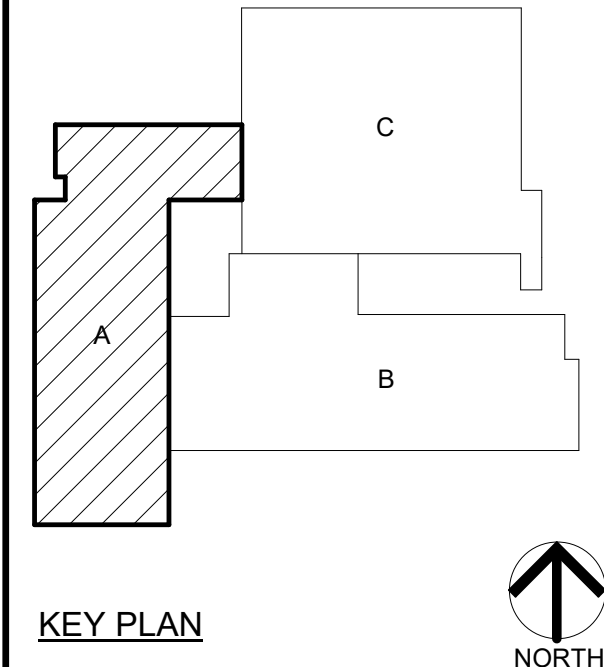

100% CONSTRUCTION DOCUMENTS

GIBALTAR DESIGN
9102 N. Meridian St., Ste. 300
Indianapolis, IN 46260
Homepage: www.GibraltarDesign.com
Email: info@GibraltarDesign.com
Phone 317.580.5777 Fax 317.580.5778

PROJECT
25-174
DATE
07/20/26
COORDINATED BY
RH
DRAWN BY
BR/MH
CHECKED BY
DJ

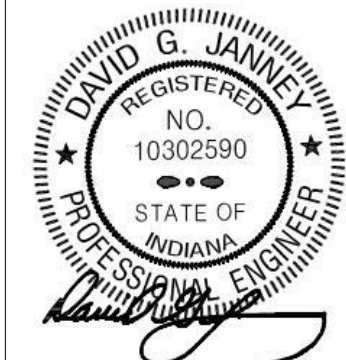

COPYRIGHT NOTICE:
THE CONCEPTS, DESIGNS, PLANS, DETAILS, ETC., SHOWN ON THIS DOCUMENT ARE THE PROPERTY OF GIBALTAR DESIGN AND WERE CREATED FOR USE ON THIS SPECIFIC PROJECT. NONE OF THIS INFORMATION SHALL BE USED BY ANY PERSON OR FIRM FOR ANY PURPOSE WITHOUT THE EXPRESS WRITTEN CONSENT OF GIBALTAR DESIGN. THE OWNER MAY RETAIN COPIES FOR INFORMATION AND REFERENCE IN CONNECTION ONLY WITH THIS PROJECT.


REVISIONS	
MARK	DATE
AD-01	07/31/26
AD-04	08/19/26

ISSUED FOR
ADDENDUM 01
ADDENDUM 04

DRAWING
UNIT "A" FIRST FLOOR
ELECTRICAL POWER PLAN

PROJECT
SWAYZEE ES MECHANICAL
IMPROVEMENTS

© GIBALTAR DESIGN
SHEET
A EP101

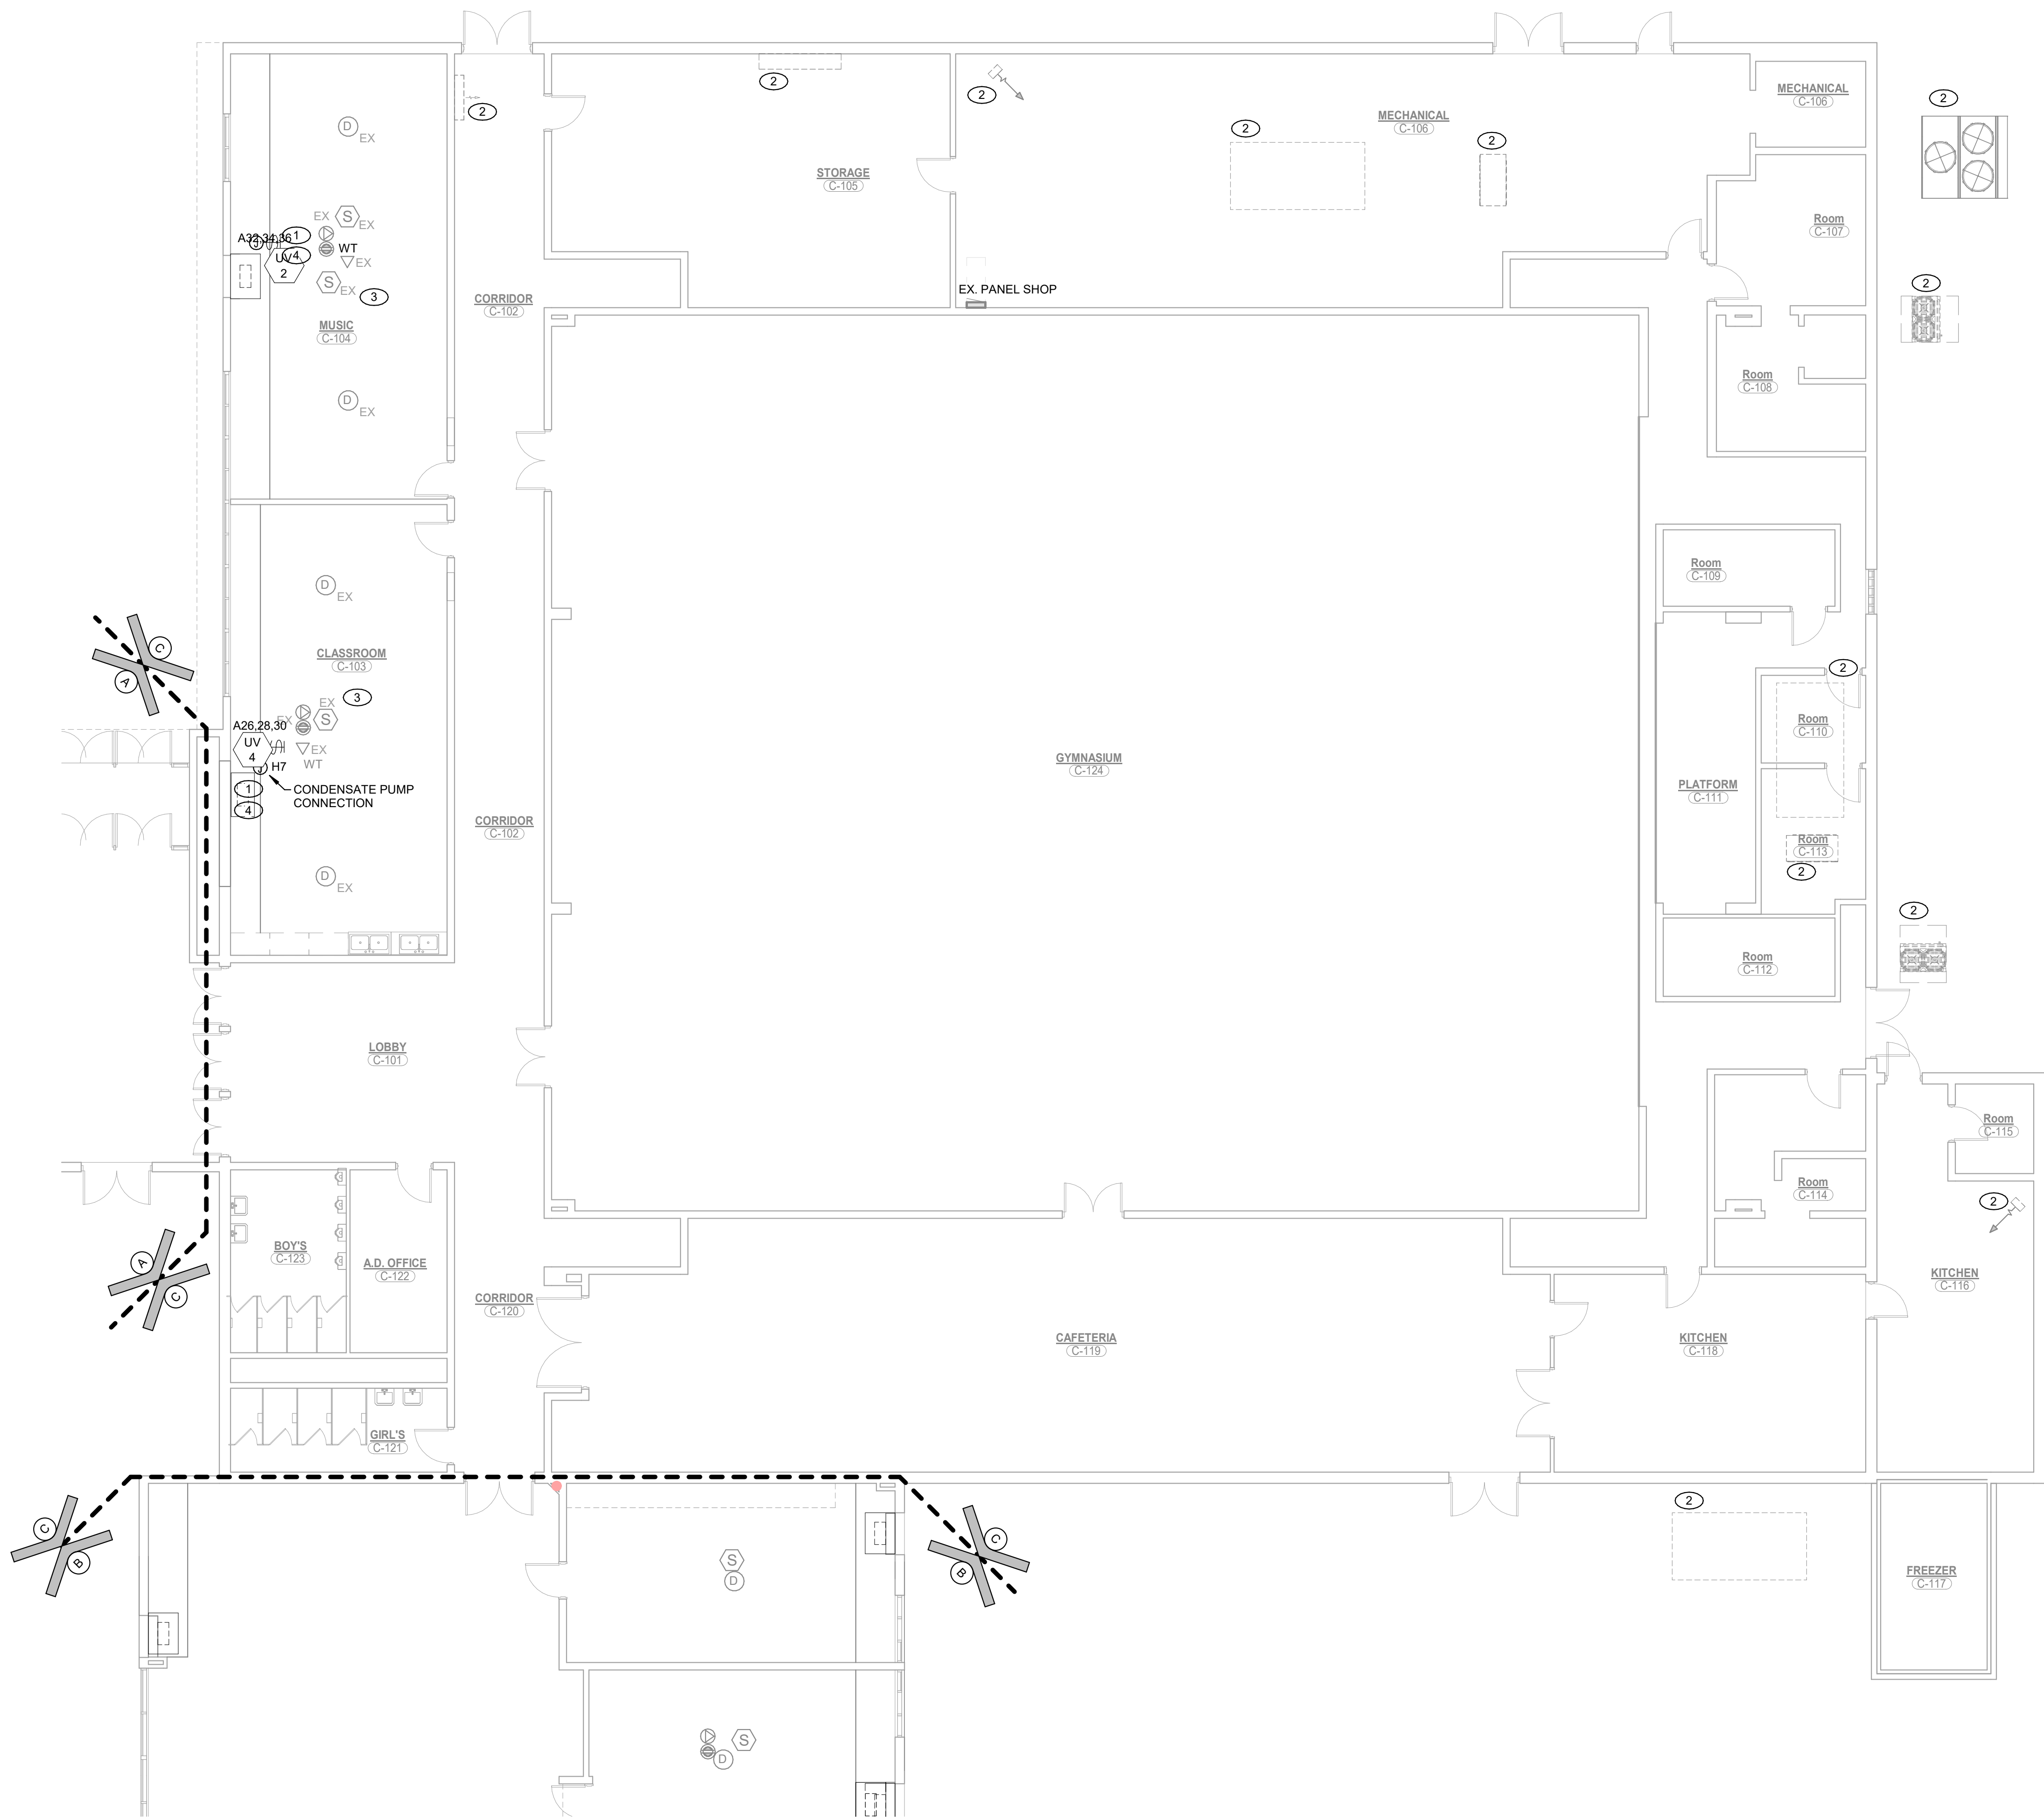

SHEET NOTES

1.

REFER TO MECHANICAL CONNECTION SCHEDULE FOR ADDITIONAL WIRING AND CIRCUIT INFORMATION. ROUTE NEW FEED OVERHEAD TO THE EXISTING PANEL SERVING THIS EQUIPMENT (OR AS NOTED IN THE MECHANICAL EQUIPMENT SCHEDULE). REMOVE AND REINSTALL EXISTING CEILING TILES, LIGHTING, AND OTHER DEVICES AS REQUIRED TO ROUTE THE CONDUIT. CONCEALED, IN ALL SPACES WITH ACT. CONDUIT IN EXPOSED CEILING AREAS SHALL BE ROUTED HIGH AND TIGHT TO THE CEILING AND PAINTED TO MATCH THE SURROUNDING SURFACE. ANY CONDUIT ROUTES THROUGH EXPOSED CEILING SPACES SHALL BE REVIEWED WITH THE ARCHITECT PRIOR TO ROUGH-IN. ADJUST THE ROUTING AS REQUIRED.

2.

EXISTING MECHANICAL EQUIPMENT TO REMAIN.

3.

REMOVE AND REINSTALL ALL EXISTING CEILING MOUNTED DEVICES, INCLUDING BUT NOT LIMITED TO, LUMINAIRES, FIRE ALARM DEVICES, SPEAKERS, PROJECTORS, WIRELESS TERMINALS, AND SENSORS, AS REQUIRED TO INSTALL NEW DUCTWORK AND CEILING GRID. PROVIDE ALL NECESSARY CONDUIT, WIRING, ETC. TO MAINTAIN EXISTING CONNECTIONS FOR ALL DEVICES TO REMAIN. CONDUIT SHALL BE REQUIRED.

4.

REFER TO SHEET NOTE #8 ON SHEET ED103 FOR ADDITIONAL INFORMATION.

GENERAL NOTES

1.

REFER TO THE ARCHITECTURAL RCP FOR FINAL CONFIRMATION OF CEILING WORK SCOPE. ROOMS ARE TAGGED ON THIS SHEET (SEE SHEET NOTE "3") FOR CONVENIENCE, BUT FINAL SCOPE SHALL BE VERIFIED WITH THE ARCHITECTURAL RCP.

2.

CIRCUIT ALL DEVICES WITH PREFIX "A" TO PANEL UV-DP1. CIRCUIT ALL DEVICES WITH PREFIX "B" TO PANEL UV-DP2. CIRCUIT ALL DEVICES TO PANEL H, UNLESS OTHERWISE NOTED.

AD-04



GIBALTAR

DESIGN

ARCHITECTURE • ENGINEERING • INTERIOR DESIGN




PROJECT:

**SWAYZEE ES
MECHANICAL
IMPROVEMENTS**

OAK HILL UNITED SCHOOL
CORPORATION

405 S WASHINGTON ST.,
SWAYZEE IN, 46986

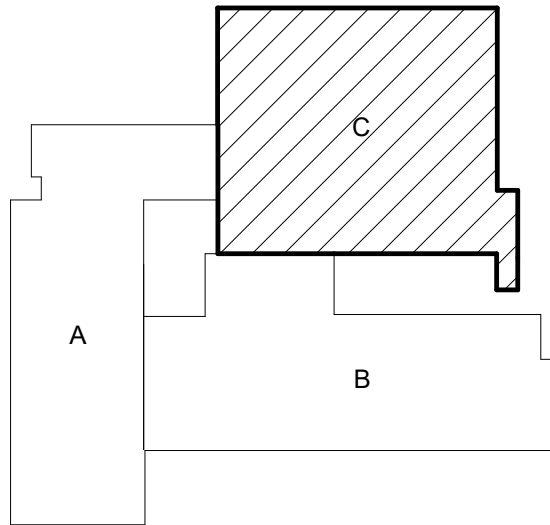

KEY PLAN



100% CONSTRUCTION
DOCUMENTS

GIBALTAR DESIGN

9102 N. Meridian St., Ste. 300
Indianapolis, IN 46260
Homepage: www.GibraltarDesign.com
Email: info@GibraltarDesign.com
Phone 317.580.5777 Fax 317.580.5778

PROJECT

25-174

DATE

07/20/26

COORDINATED BY

RH

DRAWN BY

BR/MH

CHECKED BY

DJ



COPYRIGHT NOTICE:

THE CONCEPTS, DESIGNS, PLANS, DETAILS, ETC., SHOWN ON THIS DOCUMENT ARE THE PROPERTY OF GIBALTAR DESIGN AND WERE CREATED FOR USE ON THIS SPECIFIC PROJECT. NONE OF THIS INFORMATION SHALL BE USED BY ANY PERSON OR FIRM FOR ANY PURPOSE WITHOUT THE EXPRESS WRITTEN CONSENT OF GIBALTAR DESIGN. THE OWNER MAY RETAIN COPIES FOR INFORMATION AND REFERENCE IN CONNECTION ONLY WITH THIS PROJECT.

REVISIONS

MARK	DATE	ISSUED FOR
AD-01	07/31/26	ADDENDUM 01
AD-04	08/19/26	ADDENDUM 04

DRAWING

UNIT "C" FIRST FLOOR
ELECTRICAL POWER PLAN

PROJECT

SWAYZEE ES MECHANICAL
IMPROVEMENTS

© GIBALTAR
DESIGN

SHEET

C

EP103



UNIT "C" FIRST FLOOR ELECTRICAL POWER PLAN
1/8" = 1'-0"

PROJECT:

OAK HILL JUNIOR HIGH SCHOOL - MECHANICAL IMPROVEMENTS

OAK HILL UNITED SCHOOL CORPORATION
7760 DELPHI PIKE,
CONVERSE, IN, 46919

100% CONSTRUCTION DOCUMENTS



PROJECT:
OAK HILL JR HS
MECHANICAL
IMPROVEMENTS
OAK HILL UNITED SCHOOL
CORPORATION
7760 DELPHI PIKE,
CONVERSE, IN, 46919

SHEET INDEX

G GENERAL
G-101 COVER SHEET & SHEET INDEX
G-201 JUNIOR HIGH FIRST FLOOR FIRE AND LIFE SAFETY PLAN
G-202 HIGH SCHOOL FIRST FLOOR FIRE AND LIFE SAFETY PLAN
G-203 HIGH SCHOOL SECOND FLOOR FIRE AND LIFE SAFETY PLAN

A ARCHITECTURAL
AD101 UNIT "A" ARCHITECTURAL FIRST FLOOR DEMOLITION PLAN
AD102 UNIT "B" ARCHITECTURAL FIRST FLOOR DEMOLITION PLAN
A-101 UNIT "A" ARCHITECTURAL FIRST FLOOR PLAN
A-102 UNIT "B" ARCHITECTURAL FIRST FLOOR PLAN
A-310 EXTERIOR ELEVATIONS
A-410 WALL SECTIONS & DETAILS
A-501 DETAILS
A-801 UNIT "A" FIRST FLOOR FINISH PLAN
A-802 UNIT "B" FIRST FLOOR FINISH PLAN & FINISH LEGEND
A-901 UNIT "A" FIRST FLOOR REFLECTED CEILING PLAN
A-902 UNIT "B" FIRST FLOOR REFLECTED CEILING PLAN

M MECHANICAL
M-001 MECHANICAL NOTES, SYMBOLS, & ABBREVIATIONS
MD101 UNIT "A" FIRST FLOOR MECHANICAL DEMOLITION PLAN
MD102 UNIT "B" FIRST FLOOR MECHANICAL DEMOLITION PLAN
MD201 UNITS "D" & "G" ROOF MECHANICAL DEMOLITION PLAN
M-101 UNIT "A" FIRST FLOOR MECHANICAL HVAC FLOOR PLAN
M-102 UNIT "B" FIRST FLOOR MECHANICAL HVAC FLOOR PLAN
M-103 UNITS "D" & "G" FIRST FLOOR MECHANICAL HVAC PLAN
M-105 PARTIAL FIRST FLOOR MECHANICAL TC PLAN - JR HIGH SCHOOL
M-106 PARTIAL UPPER LEVEL MECHANICAL TC PLAN - SR HIGH SCHOOL
M-107 PARTIAL FIRST FLOOR MECHANICAL TC PLAN - SR HIGH SCHOOL
M-201 UNIT "C" ROOF MECHANICAL HVAC PLAN
M-202 UNITS "D" & "G" ROOF MECHANICAL HVAC PLAN
M-203 UNIT "E" ROOF MECHANICAL HVAC PLAN
M-204 UNIT "F" ROOF MECHANICAL HVAC PLAN
M-205 UNIT "A" ROOF MECHANICAL HVAC PLAN
M-206 UNIT "B" ROOF MECHANICAL HVAC PLAN
M-501 MECHANICAL SCHEDULES

E ELECTRICAL
E-001 ELECTRICAL NOTES, SYMBOLS, & ABBREVIATIONS
ED101 UNIT "A" FIRST FLOOR ELECTRICAL DEMOLITION PLAN
ED102 UNIT "B" FIRST FLOOR ELECTRICAL DEMOLITION PLAN
ED201 UNITS "D" & "G" ROOF ELECTRICAL DEMOLITION PLAN
EL101 UNIT "A" FIRST FLOOR ELECTRICAL LIGHTING PLAN
EL102 UNIT "B" FIRST FLOOR ELECTRICAL LIGHTING PLAN
EP101 UNIT "A" FIRST FLOOR ELECTRICAL POWER PLAN
EP102 UNIT "B" FIRST FLOOR ELECTRICAL POWER PLAN
EP202 UNITS "D" & "G" ROOF ELECTRICAL POWER PLAN
EP205 UNIT "A" ROOF ELECTRICAL POWER PLAN
EP206 UNIT "B" ROOF ELECTRICAL POWER PLAN
E-501 ELECTRICAL SCHEDULES
E-502 ELECTRICAL SCHEDULES
E-601 ELECTRICAL DETAILS & DIAGRAMS

AD-04

100% CONSTRUCTION
DOCUMENTS
GIBRALTAR DESIGN
4030 Vincennes Rd., Ste. 100
Indianapolis, IN 46226
Homepage: www.GibraltarDesign.com
Phone 317.580.5777

PROJECT
25-176
DATE
07/20/26
COORDINATED BY
DJW
DRAWN BY
CND
CHECKED BY
CND DJW


COPYRIGHT NOTICE:
THE CONCEPTS, DESIGN, PLANS, DETAILS, ETC. SHOWN ON
THIS DOCUMENT ARE THE PROPERTY OF GIBRALTAR DESIGN
AND WERE CREATED FOR USE ON THIS SPECIFIC PROJECT.
NONE OF THIS INFORMATION SHALL BE USED BY ANY
PERSON OR FIRM FOR ANY PURPOSE WITHOUT THE EXPRESS
WRITTEN CONSENT OF GIBRALTAR DESIGN. THE OWNER MAY
RETAIL COPIES FOR INFORMATION AND REFERENCE IN
CONNECTION ONLY WITH THIS PROJECT.


REVISIONS		
MARK	DATE	ISSUED FOR
AD-03	08/14/26	ADDENDUM 03
AD-04	08/19/26	ADDENDUM 04

DRAWING
COVER SHEET

PROJECT
OAK HILL JR HS MECHANICAL
IMPROVEMENTS

© GIBRALTAR
DESIGN SHEET
G-101

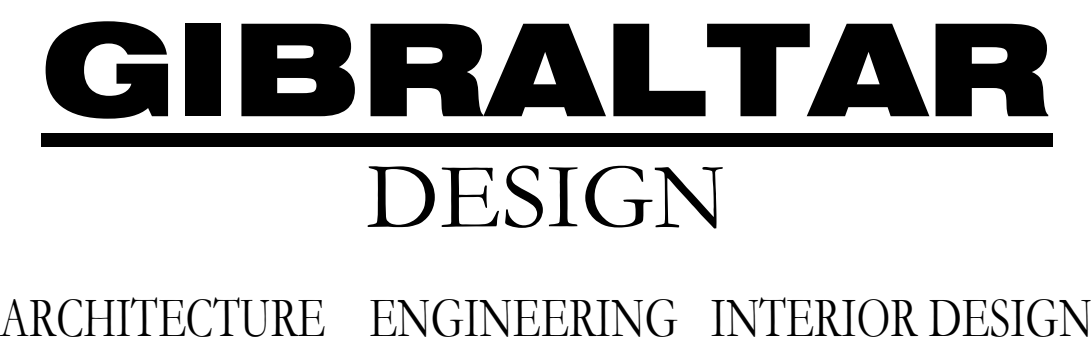

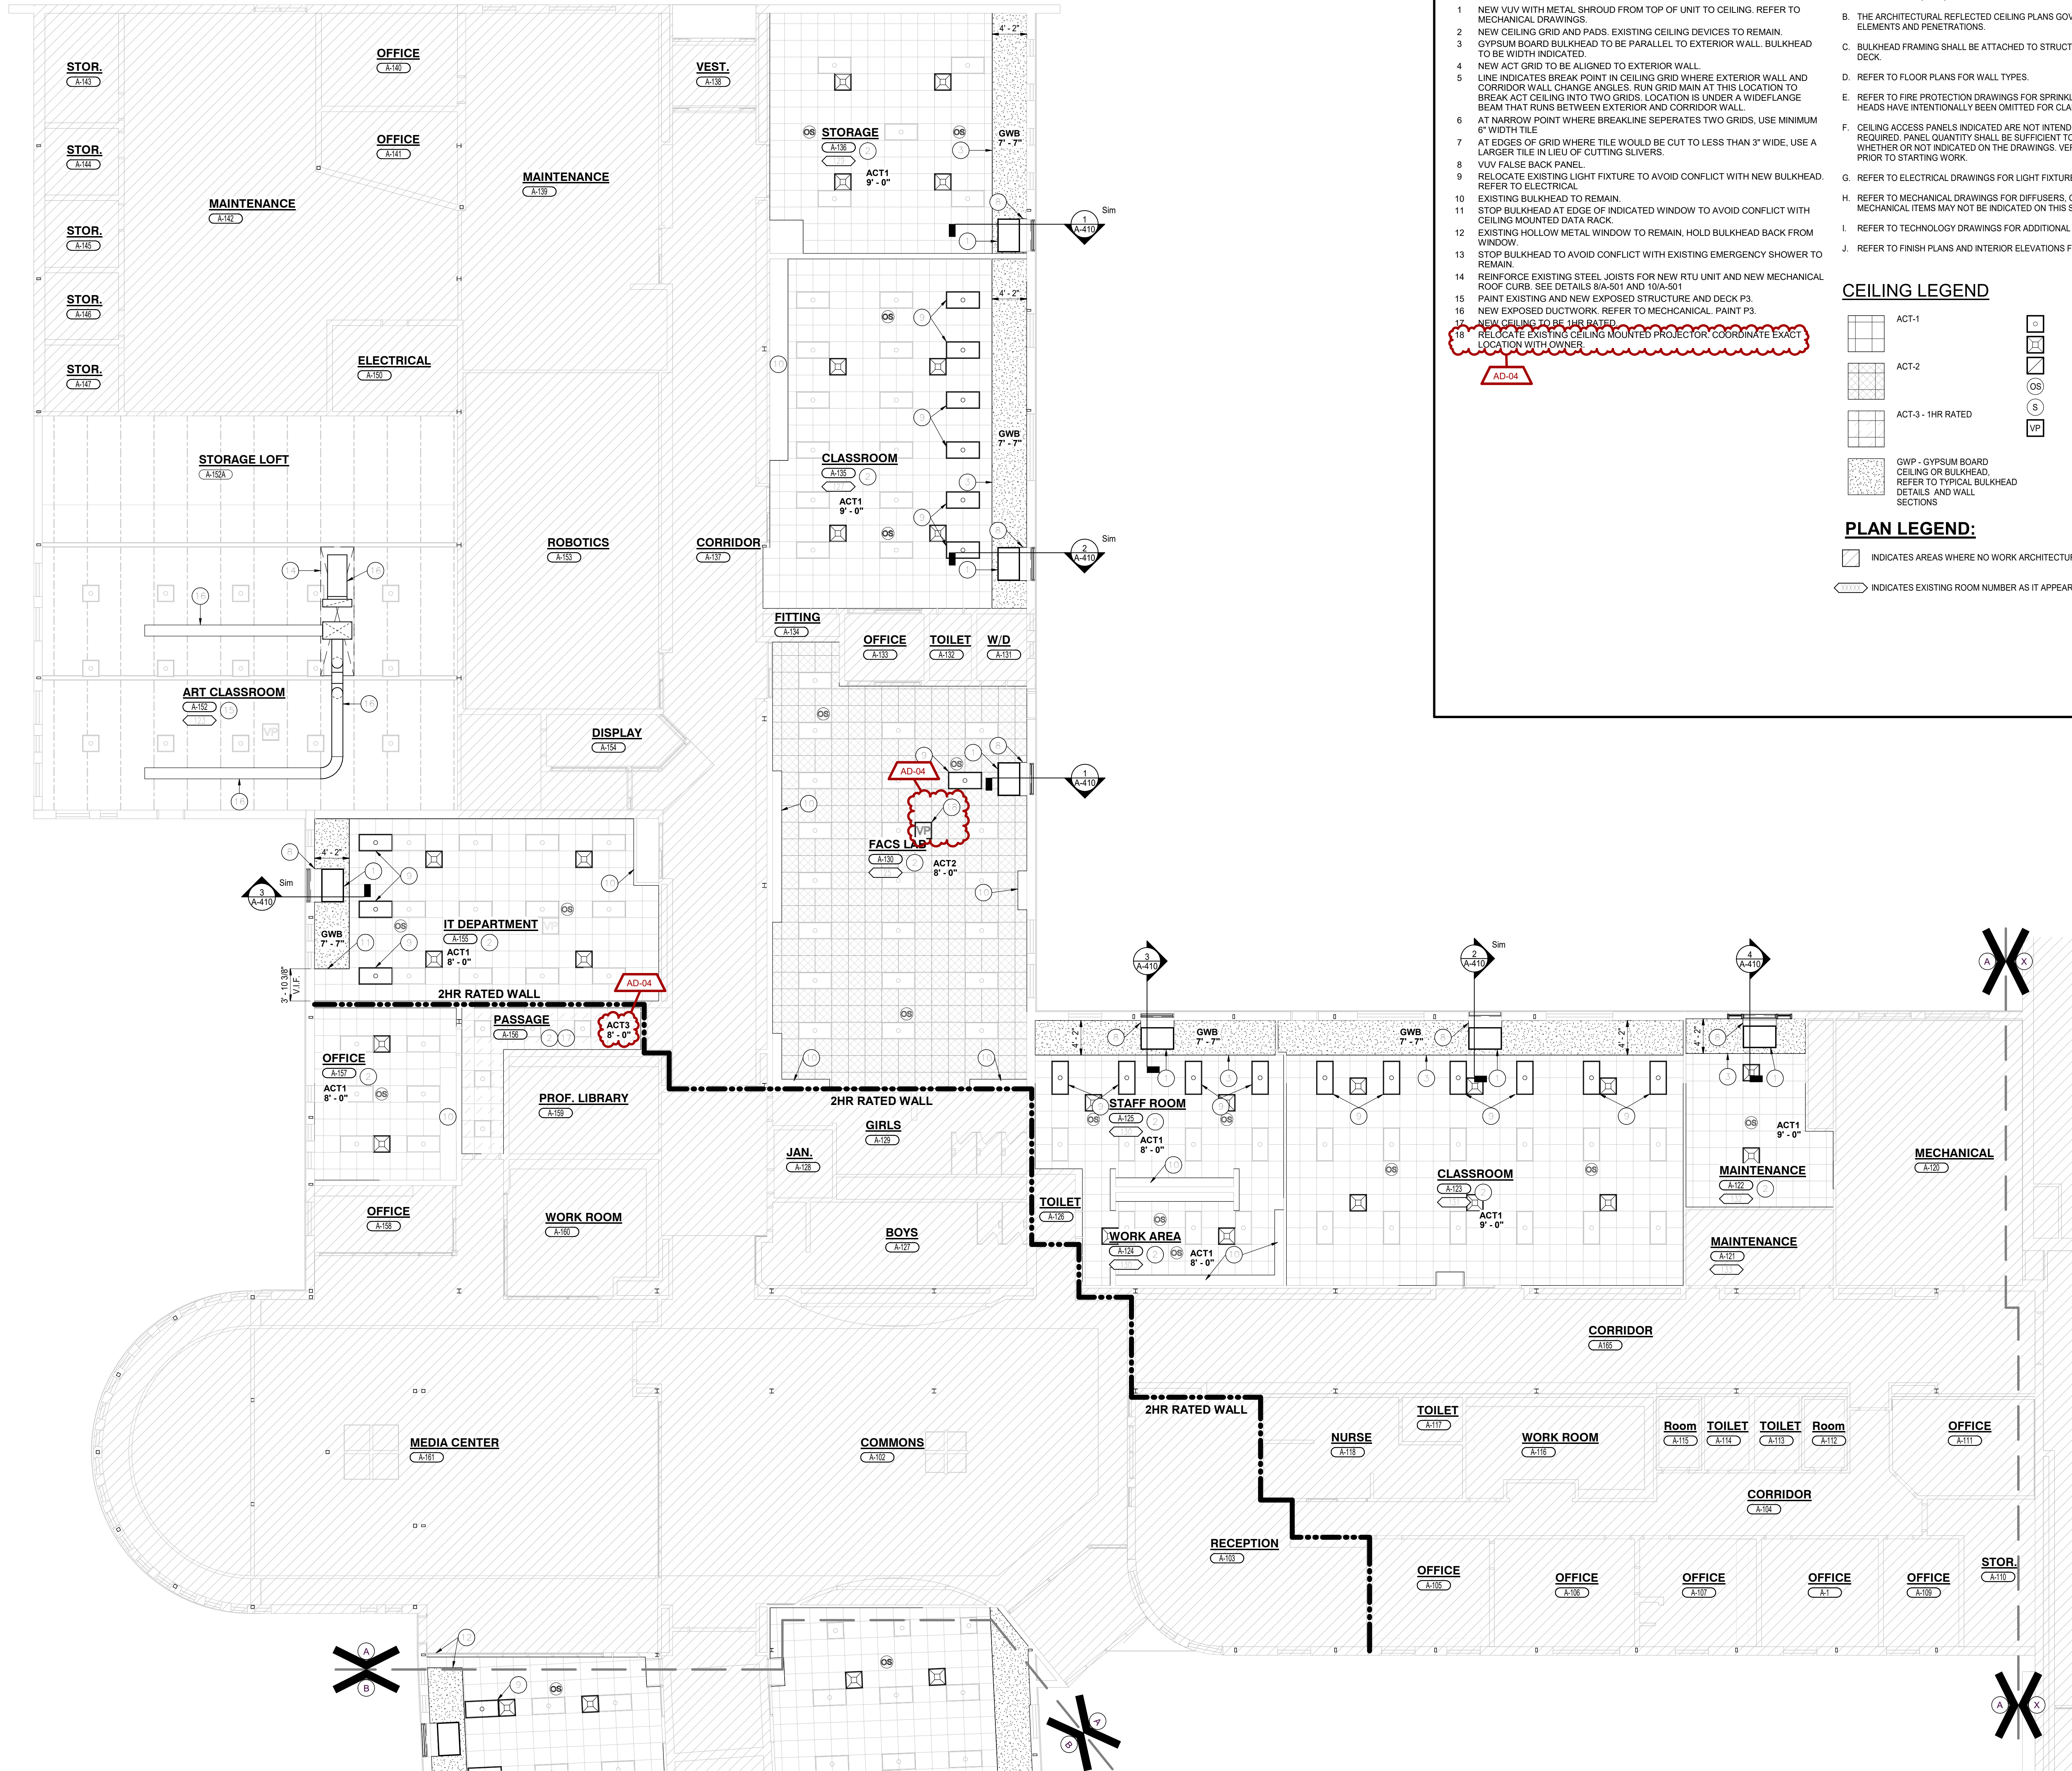

REFLECTED CEILING PLAN NOTES:

(ALL PLAN NOTES MAY NOT BE INDICATED ON THIS SHEET.)

- 1 NEW VUV WITH METAL SHROUD FROM TOP OF UNIT TO CEILING. REFER TO MECHANICAL DRAWINGS.
- 2 NEW CEILING GRID AND PADS. EXISTING CEILING DEVICES TO REMAIN.
- 3 GYPSUM BOARD BULKHEAD TO BE PARALLEL TO EXTERIOR WALL. BULKHEAD TO BE WIDTH INDICATED.
- 4 NEW ACT GRID TO BE ALIGNED TO EXTERIOR WALL.
- 5 LINE INDICATES BREAK POINT IN CEILING GRID WHERE EXTERIOR WALL AND CORRIDOR WALL CHANGE ANGLES. RUN GRID MAIN AT THIS LOCATION TO BREAK ACT CEILING INTO TWO GRIDS. LOCATION IS UNDER A WIDE FLANGE BEAM THAT RUNS BETWEEN EXTERIOR AND CORRIDOR WALL.
- 6 AT NARROW POINT WHERE BREAKLINE SEPARATES TWO GRIDS, USE MINIMUM 6" WIDTH TILE.
- 7 AT EDGES OF GRID WHERE TILE WOULD BE CUT TO LESS THAN 3" WIDE, USE A LARGER TILE IN LIEU OF CUTTING SLIVERS.
- 8 VUV FALSE BACK PANEL.
- 9 RELOCATE EXISTING LIGHT FIXTURE TO AVOID CONFLICT WITH NEW BULKHEAD. REFER TO ELECTRICAL.
- 10 EXISTING BULKHEAD TO REMAIN.
- 11 STOP BULKHEAD AT EDGE OF INDICATED WINDOW TO AVOID CONFLICT WITH CEILING MOUNTED DATA RACK.
- 12 EXISTING HOLLOW METAL WINDOW TO REMAIN. HOLD BULKHEAD BACK FROM WINDOW.
- 13 STOP BULKHEAD TO AVOID CONFLICT WITH EXISTING EMERGENCY SHOWER TO REMAIN.
- 14 REINFORCE EXISTING STEEL JOISTS FOR NEW RTU UNIT AND NEW MECHANICAL ROOF CURB. SEE DETAILS 8A-501 AND 10A-501.
- 15 PAINT EXISTING AND NEW EXPOSED STRUCTURE AND DECK P3.
- 16 NEW EXPOSED DUCTWORK. REFER TO MECHANICAL. PAINT P3.
- 17 NEW CEILING TO BE 1HR RATED.
- 18 RELOCATE EXISTING CEILING MOUNTED PROJECTOR. COORDINATE EXACT LOCATION WITH OWNER.

AD-04

GENERAL REFLECTED CEILING NOTES:

- A. FOR GENERAL PROJECT NOTES, MATERIAL INDICATIONS LEGEND, SYMBOL LEGEND, ABBREVIATIONS, ETC., REFER TO SHEET G-301.
- B. THE ARCHITECTURAL REFLECTED CEILING PLANS GOVERN THE LAYOUT OF ALL CEILING ELEMENTS AND PENETRATIONS.
- C. BULKHEAD FRAMING SHALL BE ATTACHED TO STRUCTURAL SUPPORTS AND NOT THE ROOF DECK.
- D. REFER TO FLOOR PLANS FOR WALL TYPES.
- E. REFER TO FIRE PROTECTION DRAWINGS FOR SPRINKLER HEAD TYPES AND QUANTITIES. HEADS HAVE INTENTIONALLY BEEN OMITTED FOR CLARITY.
- F. CEILING ACCESS PANELS INDICATED ARE NOT INTENDED TO LIMIT NUMBER OF PANELS REQUIRED. PANEL QUANTITY SHALL BE SUFFICIENT TO PROVIDE REQUIRED ACCESS WHETHER OR NOT INDICATED ON THE DRAWINGS. VERIFY FINAL LOCATIONS WITH ARCHITECT PRIOR TO STARTING WORK.
- G. REFER TO ELECTRICAL DRAWINGS FOR LIGHT FIXTURE TYPE AND QUANTITIES.
- H. REFER TO MECHANICAL DRAWINGS FOR DIFFUSERS, GRILL TYPES AND QUANTITIES - ALL MECHANICAL ITEMS MAY NOT BE INDICATED ON THIS SHEET.
- I. REFER TO TECHNOLOGY DRAWINGS FOR ADDITIONAL CEILING MOUNTED TECHNOLOGY ITEMS.
- J. REFER TO FINISH PLANS AND INTERIOR ELEVATIONS FOR PAINT COLORS.

CEILING LEGEND


- | | | | |
|--|---|--|--------------------------|
| | ACT-1 | | LIGHT FIXTURE |
| | ACT-2 | | SUPPLY AIR DIFFUSER |
| | ACT-3 - 1HR RATED | | RETURN / RELIEF REGISTER |
| | GWP - GYPSUM BOARD CEILING OR BULKHEAD, REFER TO TYPICAL BULKHEAD DETAILS AND WALL SECTIONS | | OCCUPANCY SENSOR |
| | | | CEILING SPEAKER |
| | | | CEILING VIDEO PROJECTOR |

PLAN LEGEND:

- INDICATES AREAS WHERE NO WORK ARCHITECTURAL WORK IS TO OCCUR.
- INDICATES EXISTING ROOM NUMBER AS IT APPEARS ON EXISTING DOOR OR WALL.



PROJECT:
**OAK HILL JR HS
MECHANICAL
IMPROVEMENTS**
OAK HILL UNITED SCHOOL
CORPORATION
7760 DELPHI PIKE,
CONVERSE, IN, 46919

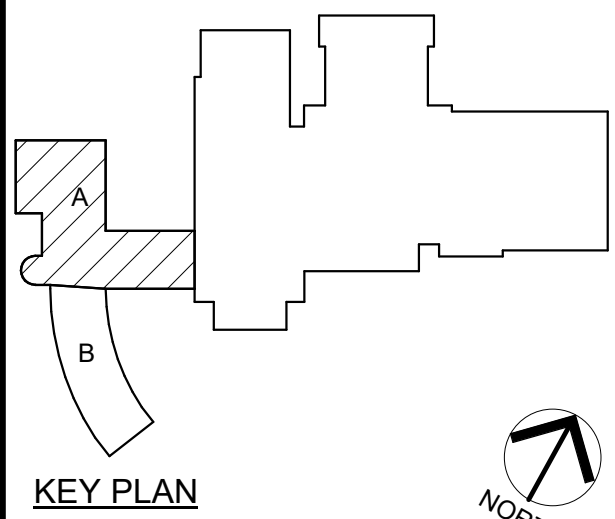

100% CONSTRUCTION
DOCUMENTS

GIBRALTAR DESIGN
4030 Vincennes Rd., Ste. 100
Indianapolis, IN 46226
Homepage: www.GibraltarDesign.com
Phone 317.580.5777

PROJECT
25-176
DATE
07/20/26
COORDINATED BY
DJW
DRAWN BY
CND
CHECKED BY
DJW CND

COPYRIGHT NOTICE:
THE CONCEPTS, DESIGN, PLANS, DETAILS, ETC. SHOWN ON THIS DOCUMENT ARE THE PROPERTY OF GIBRALTAR DESIGN AND VISIBLE OR INVISIBLE USE ON THIS SPECIFIC PROJECT WITHOUT THE WRITTEN CONSENT OF GIBRALTAR DESIGN. THE OWNER MAY NOT REPRODUCE OR TRANSMIT THIS INFORMATION OR REFERENCE IN CONNECTION ONLY WITH THIS PROJECT.

REVISIONS

MARK	DATE	ISSUED FOR
AD-01	07/31/26	ADDENDUM 01
AD-02	08/07/26	ADDENDUM 02
AD-03	08/14/26	ADDENDUM 03
AD-04	08/19/26	ADDENDUM 04

DRAWING
UNIT "A" ARCHITECTURAL
FIRST FLOOR PLAN


PROJECT
OAK HILL JR HS MECHANICAL
IMPROVEMENTS

© GIBRALTAR
DESIGN

SHEET

A

A-901

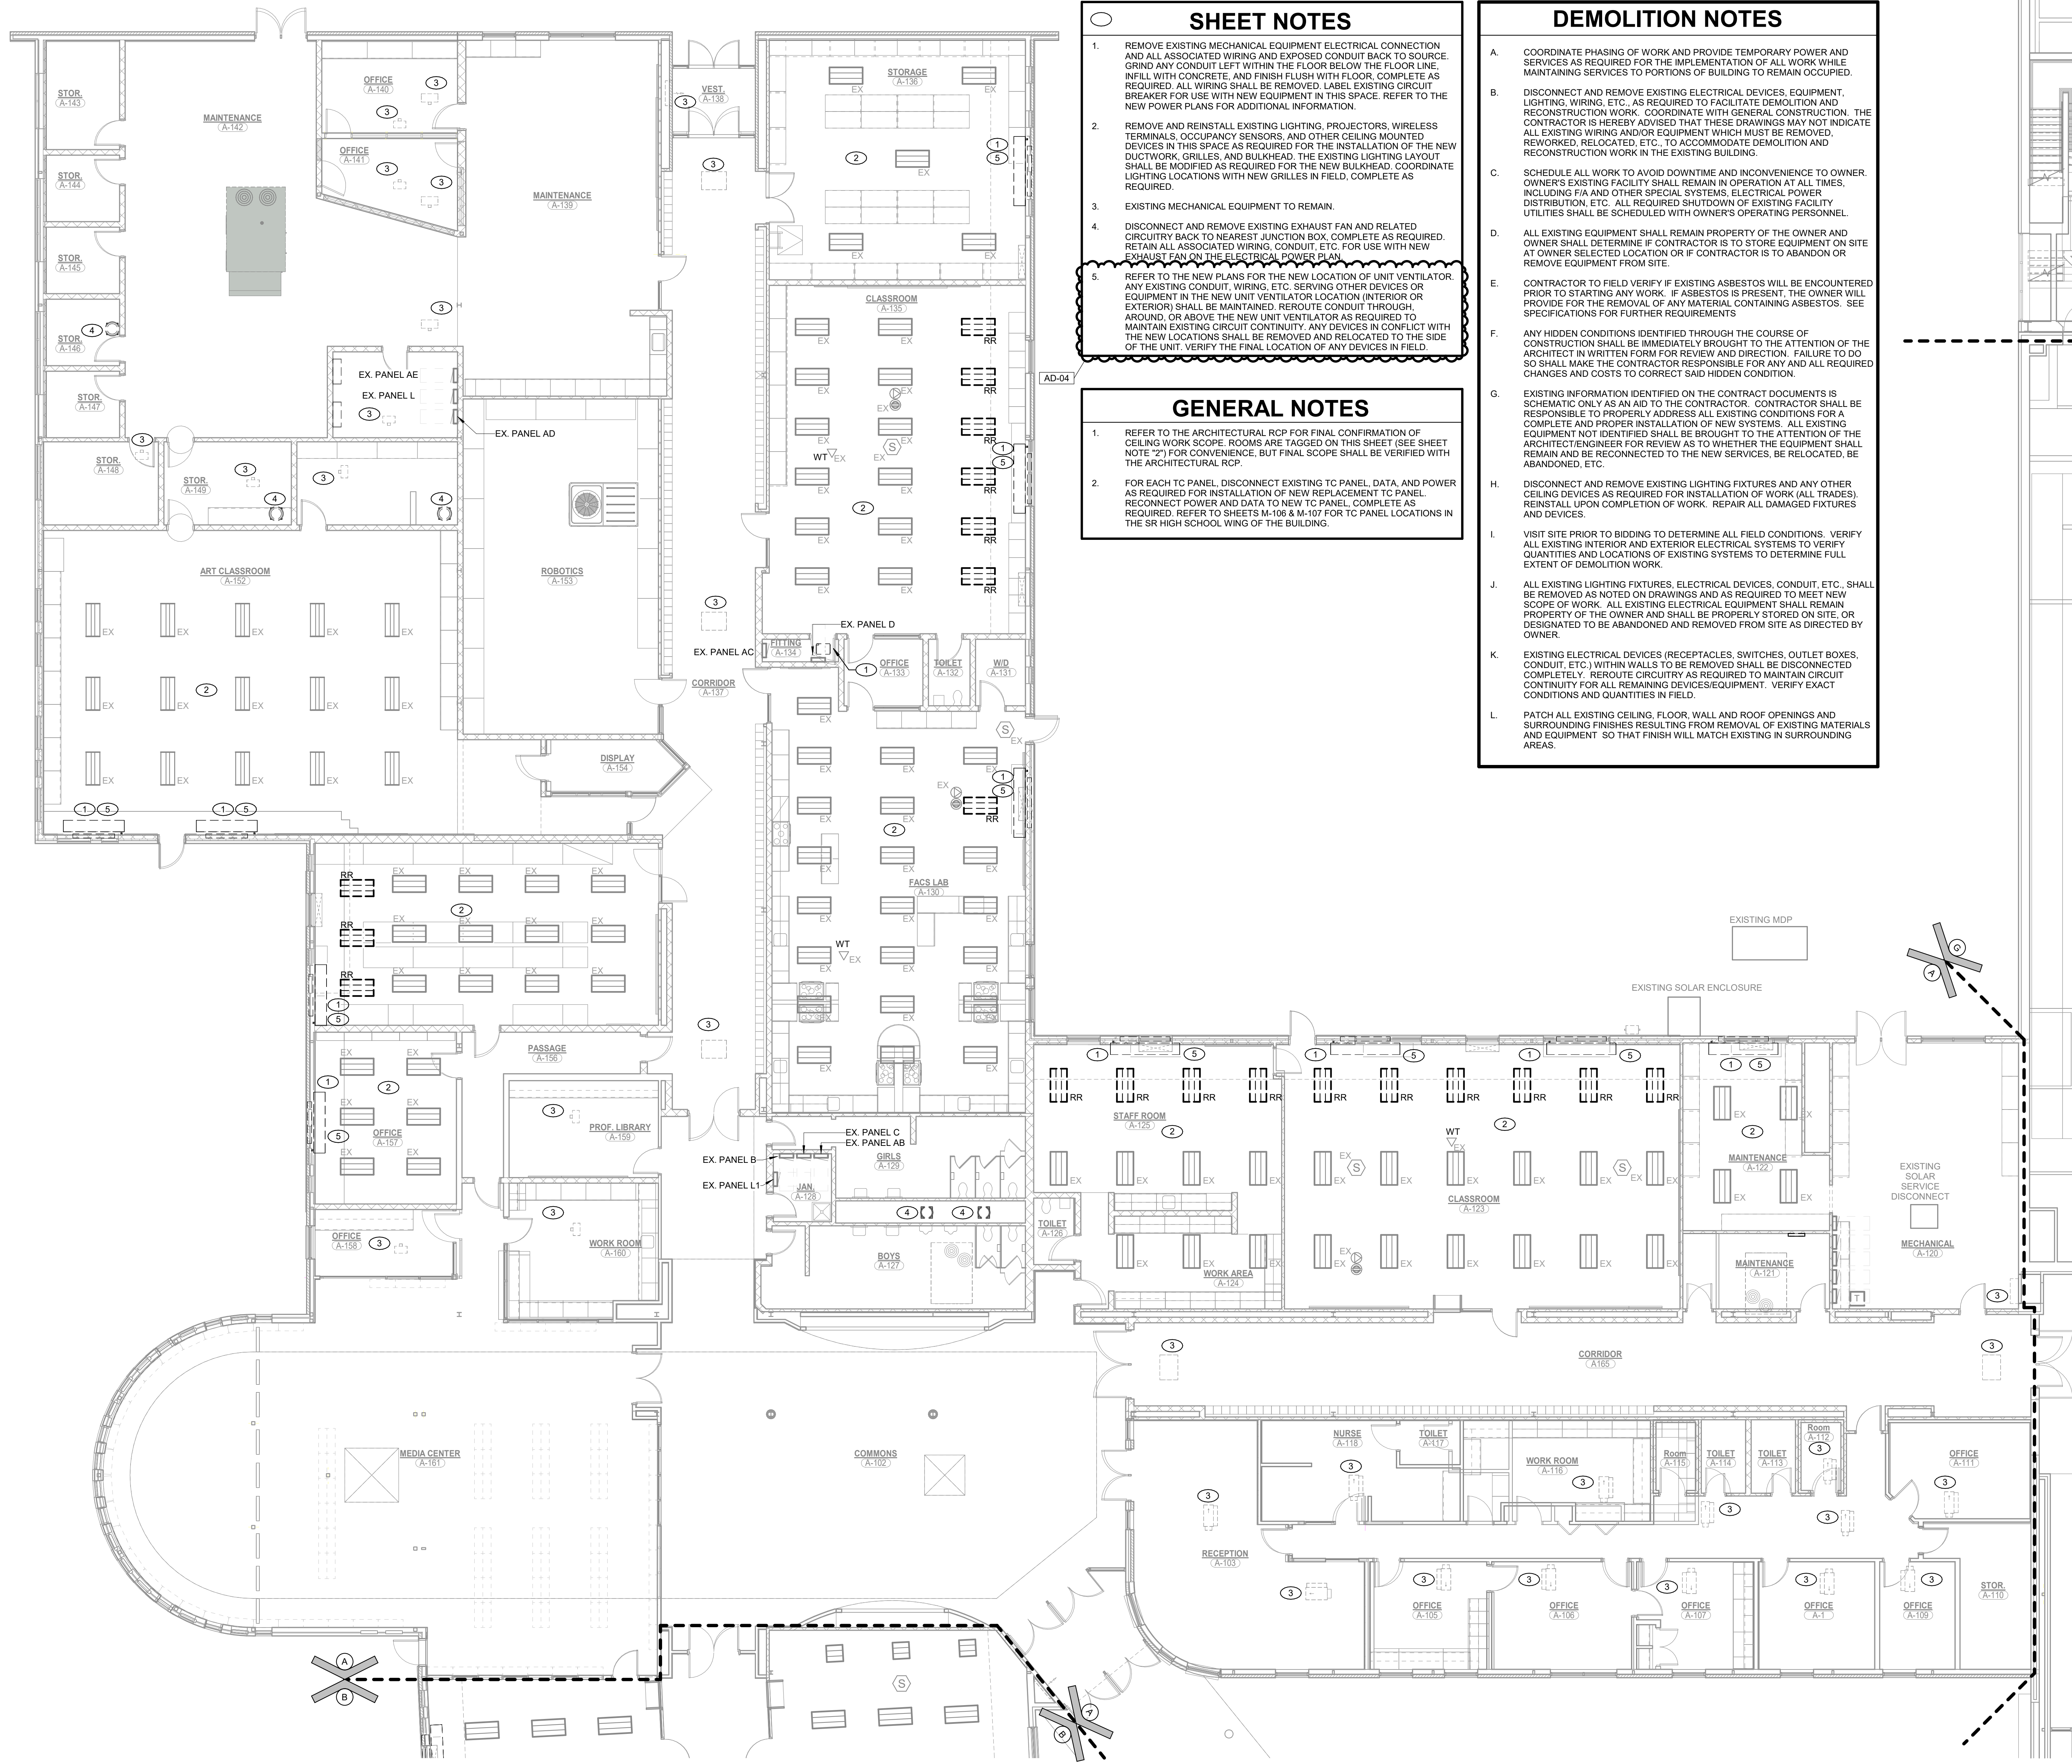

SHEET NOTES

1. REMOVE EXISTING MECHANICAL EQUIPMENT ELECTRICAL CONNECTION AND ALL ASSOCIATED WIRING AND EXPOSED CONDUIT BACK TO SOURCE. GRIND ANY CONDUIT LEFT WITHIN THE FLOOR BELOW THE FLOOR LINE. INFILL WITH CONCRETE, AND FINISH FLUSH WITH FLOOR, COMPLETE AS REQUIRED. ALL WIRING SHALL BE REMOVED. LABEL EXISTING CIRCUIT BREAKER FOR USE WITH NEW EQUIPMENT IN THIS SPACE. REFER TO THE NEW POWER PLANS FOR ADDITIONAL INFORMATION.
2. REMOVE AND REINSTALL EXISTING LIGHTING, PROJECTORS, WIRELESS TERMINALS, OCCUPANCY SENSORS, AND OTHER CEILING MOUNTED DEVICES IN THIS SPACE AS REQUIRED FOR THE INSTALLATION OF THE NEW DUCTWORK, GRILLES, AND BULKHEAD. THE EXISTING LIGHTING LAYOUT SHALL BE MODIFIED AS REQUIRED FOR THE NEW BULKHEAD. COORDINATE LIGHTING LOCATIONS WITH NEW GRILLES IN FIELD. COMPLETE AS REQUIRED.
3. EXISTING MECHANICAL EQUIPMENT TO REMAIN.
4. DISCONNECT AND REMOVE EXISTING EXHAUST FAN AND RELATED CIRCUITRY BACK TO NEAREST JUNCTION BOX. COMPLETE AS REQUIRED. RETAIN ALL ASSOCIATED WIRING, CONDUIT, ETC. FOR USE WITH NEW EXHAUST FAN ON THE ELECTRICAL POWER PLAN.
5. REFER TO THE NEW PLANS FOR THE NEW LOCATION OF UNIT VENTILATOR. ANY EXISTING CONDUIT, WIRING, ETC. SERVING OTHER DEVICES OR EQUIPMENT IN THE NEW UNIT VENTILATOR LOCATION (INTERIOR OR EXTERIOR) SHALL BE MAINTAINED. REROUTE CONDUIT THROUGH AROUND, OR ABOVE THE NEW UNIT VENTILATOR AS REQUIRED TO MAINTAIN EXISTING CIRCUIT CONTINUITY. ANY DEVICES IN CONFLICT WITH THE NEW LOCATIONS SHALL BE REMOVED AND RELOCATED TO THE SIDE OF THE UNIT. VERIFY THE FINAL LOCATION OF ANY DEVICES IN FIELD.


GENERAL NOTES

1. REFER TO THE ARCHITECTURAL RCP FOR FINAL CONFIRMATION OF CEILING WORK SCOPE. ROOMS ARE TAGGED ON THIS SHEET (SEE SHEET NOTE "2") FOR CONVENIENCE, BUT FINAL SCOPE SHALL BE VERIFIED WITH THE ARCHITECTURAL RCP.
2. FOR EACH TC PANEL, DISCONNECT EXISTING TC PANEL DATA, AND POWER AS REQUIRED FOR INSTALLATION OF NEW REPLACEMENT TC PANEL. RECONNECT POWER AND DATA TO NEW TC PANEL. COMPLETE AS REQUIRED. REFER TO SHEETS M-106 & M-107 FOR TC PANEL LOCATIONS IN THE SR HIGH SCHOOL WING OF THE BUILDING.

DEMOLITION NOTES

- A. COORDINATE PHASING OF WORK AND PROVIDE TEMPORARY POWER AND SERVICES AS REQUIRED FOR THE IMPLEMENTATION OF ALL WORK WHILE MAINTAINING SERVICES TO PORTIONS OF BUILDING TO REMAIN OCCUPIED.
- B. DISCONNECT AND REMOVE EXISTING ELECTRICAL DEVICES, EQUIPMENT, LIGHTING, WIRING, ETC., AS REQUIRED TO FACILITATE DEMOLITION AND RECONSTRUCTION WORK. COORDINATE WITH GENERAL CONSTRUCTION. THE CONTRACTOR IS HEREBY ADVISED THAT THESE DRAWINGS MAY NOT INDICATE ALL EXISTING WIRING AND/OR EQUIPMENT WHICH MUST BE REMOVED, REWORKED, RELOCATED, ETC., TO ACCOMMODATE DEMOLITION AND RECONSTRUCTION WORK IN THE EXISTING BUILDING.
- C. SCHEDULE ALL WORK TO AVOID DOWNTIME AND INCONVENIENCE TO OWNER. OWNER'S EXISTING FACILITY SHALL REMAIN IN OPERATION AT ALL TIMES, INCLUDING FIA AND OTHER SPECIAL SYSTEMS, ELECTRICAL POWER DISTRIBUTION, ETC. ALL REQUIRED SHUTDOWN OF EXISTING FACILITY UTILITIES SHALL BE SCHEDULED WITH OWNER'S OPERATING PERSONNEL.
- D. ALL EXISTING EQUIPMENT SHALL REMAIN PROPERTY OF THE OWNER AND OWNER SHALL DETERMINE IF CONTRACTOR IS TO STORE EQUIPMENT ON SITE AT OWNER SELECTED LOCATION OR IF CONTRACTOR IS TO ABANDON OR REMOVE EQUIPMENT FROM SITE.
- E. CONTRACTOR TO FIELD VERIFY IF EXISTING ASBESTOS WILL BE ENCOUNTERED PRIOR TO STARTING ANY WORK. IF ASBESTOS IS PRESENT, THE OWNER WILL PROVIDE FOR THE REMOVAL OF ANY MATERIAL CONTAINING ASBESTOS. SEE SPECIFICATIONS FOR FURTHER REQUIREMENTS.
- F. ANY HIDDEN CONDITIONS IDENTIFIED THROUGH THE COURSE OF CONSTRUCTION SHALL BE IMMEDIATELY BROUGHT TO THE ATTENTION OF THE ARCHITECT IN WRITTEN FORM FOR REVIEW AND DIRECTION. FAILURE TO DO SO SHALL MAKE THE CONTRACTOR RESPONSIBLE FOR ANY AND ALL REQUIRED CHANGES AND COSTS TO CORRECT SAID HIDDEN CONDITION.
- G. EXISTING INFORMATION IDENTIFIED ON THE CONTRACT DOCUMENTS IS SCHEMATIC ONLY AS AN AID TO THE CONTRACTOR. CONTRACTOR SHALL BE RESPONSIBLE TO PROPERLY ADDRESS ALL EXISTING CONDITIONS FOR A COMPLETE AND PROPER INSTALLATION OF NEW SYSTEMS. ALL EXISTING EQUIPMENT NOT IDENTIFIED SHALL BE BROUGHT TO THE ATTENTION OF THE ARCHITECT/ENGINEER FOR REVIEW AS TO WHETHER THE EQUIPMENT SHALL REMAIN AND BE RECONNECTED TO THE NEW SERVICES, BE RELOCATED, BE ABANDONED, ETC.
- H. DISCONNECT AND REMOVE EXISTING LIGHTING FIXTURES AND ANY OTHER CEILING DEVICES AS REQUIRED FOR INSTALLATION OF WORK (ALL TRADES). REINSTALL UPON COMPLETION OF WORK. REPAIR ALL DAMAGED FIXTURES AND DEVICES.
- I. VISIT SITE PRIOR TO BIDDING TO DETERMINE ALL FIELD CONDITIONS. VERIFY ALL EXISTING INTERIOR AND EXTERIOR ELECTRICAL SYSTEMS TO DETERMINE FULL EXTENT OF DEMOLITION WORK.
- J. ALL EXISTING LIGHTING FIXTURES, ELECTRICAL DEVICES, CONDUIT, ETC., SHALL BE REMOVED AS NOTED ON DRAWINGS AND AS REQUIRED TO MEET NEW SCOPE OF WORK. ALL EXISTING ELECTRICAL EQUIPMENT SHALL REMAIN PROPERTY OF THE OWNER AND SHALL BE PROPERLY STORED ON SITE, OR DESIGNATED TO BE ABANDONED AND REMOVED FROM SITE AS DIRECTED BY OWNER.
- K. EXISTING ELECTRICAL DEVICES (RECEPTACLES, SWITCHES, OUTLET BOXES, CONDUIT, ETC.) WITHIN WALLS TO BE REMOVED SHALL BE DISCONNECTED COMPLETELY. REROUTE CIRCUITRY AS REQUIRED TO MAINTAIN CIRCUIT CONTINUITY FOR ALL REMAINING DEVICES/EQUIPMENT. VERIFY EXACT CONDITIONS AND QUANTITIES IN FIELD.
- L. PATCH ALL EXISTING CEILING, FLOOR, WALL AND ROOF OPENINGS AND SURROUNDING FINISHES RESULTING FROM REMOVAL OF EXISTING MATERIALS AND EQUIPMENT SO THAT FINISH WILL MATCH EXISTING IN SURROUNDING AREAS.

1 UNIT "A" FIRST FLOOR ELECTRICAL DEMOLITION PLAN
ED101 1/8" = 1'-0"

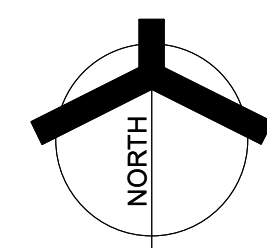

GIBALTAR
DESIGN


ARCHITECTURE • ENGINEERING • INTERIOR DESIGN



PROJECT:

**OAK HILL JR HS
MECHANICAL
IMPROVEMENTS**

OAK HILL UNITED SCHOOL
CORPORATION
7760 DELPHI PIKE,
CONVERSE, IN, 46919

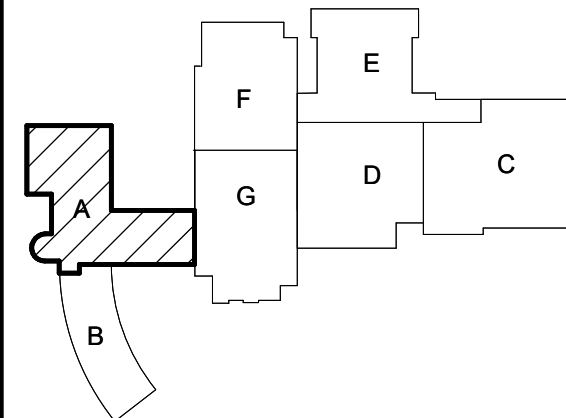

KEY PLAN



100% CONSTRUCTION
DOCUMENTS

GIBALTAR DESIGN

9102 N. Meridian St., Ste. 300
Indianapolis, IN 46260
Homepage: www.GibraltarDesign.com
Email: info@GibraltarDesign.com
Phone 317.580.5777 Fax 317.580.5778

PROJECT

25-176

DATE

07/20/26

COORDINATED BY


RH

DRAWN BY

BR/MH

CHECKED BY

DJ

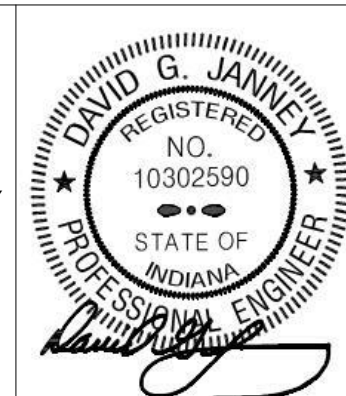

COPYRIGHT NOTICE:

THE CONCEPTS, DESIGN PLANS, DETAILS, ETC. SHOWN ON THIS DOCUMENT ARE THE PROPERTY OF GIBALTAR DESIGN AND ARE NOT TO BE REPRODUCED OR USED FOR ANY OTHER PROJECT WITHOUT THE EXPRESS WRITTEN CONSENT OF GIBALTAR DESIGN. THE OWNER MAY RETAIN COPIES FOR INFORMATION AND REFERENCE IN CONNECTION ONLY WITH THIS PROJECT.

REVISIONS

MARK	DATE	ISSUED FOR
AD-01	07/31/26	ADDENDUM 01
AD-04	08/19/26	ADDENDUM 04

DRAWING

UNIT "A" FIRST FLOOR
ELECTRICAL DEMOLITION PLAN

PROJECT


OAK HILL JR HS MECHANICAL
IMPROVEMENTS

© GIBALTAR
DESIGN

SHEET

A

ED101

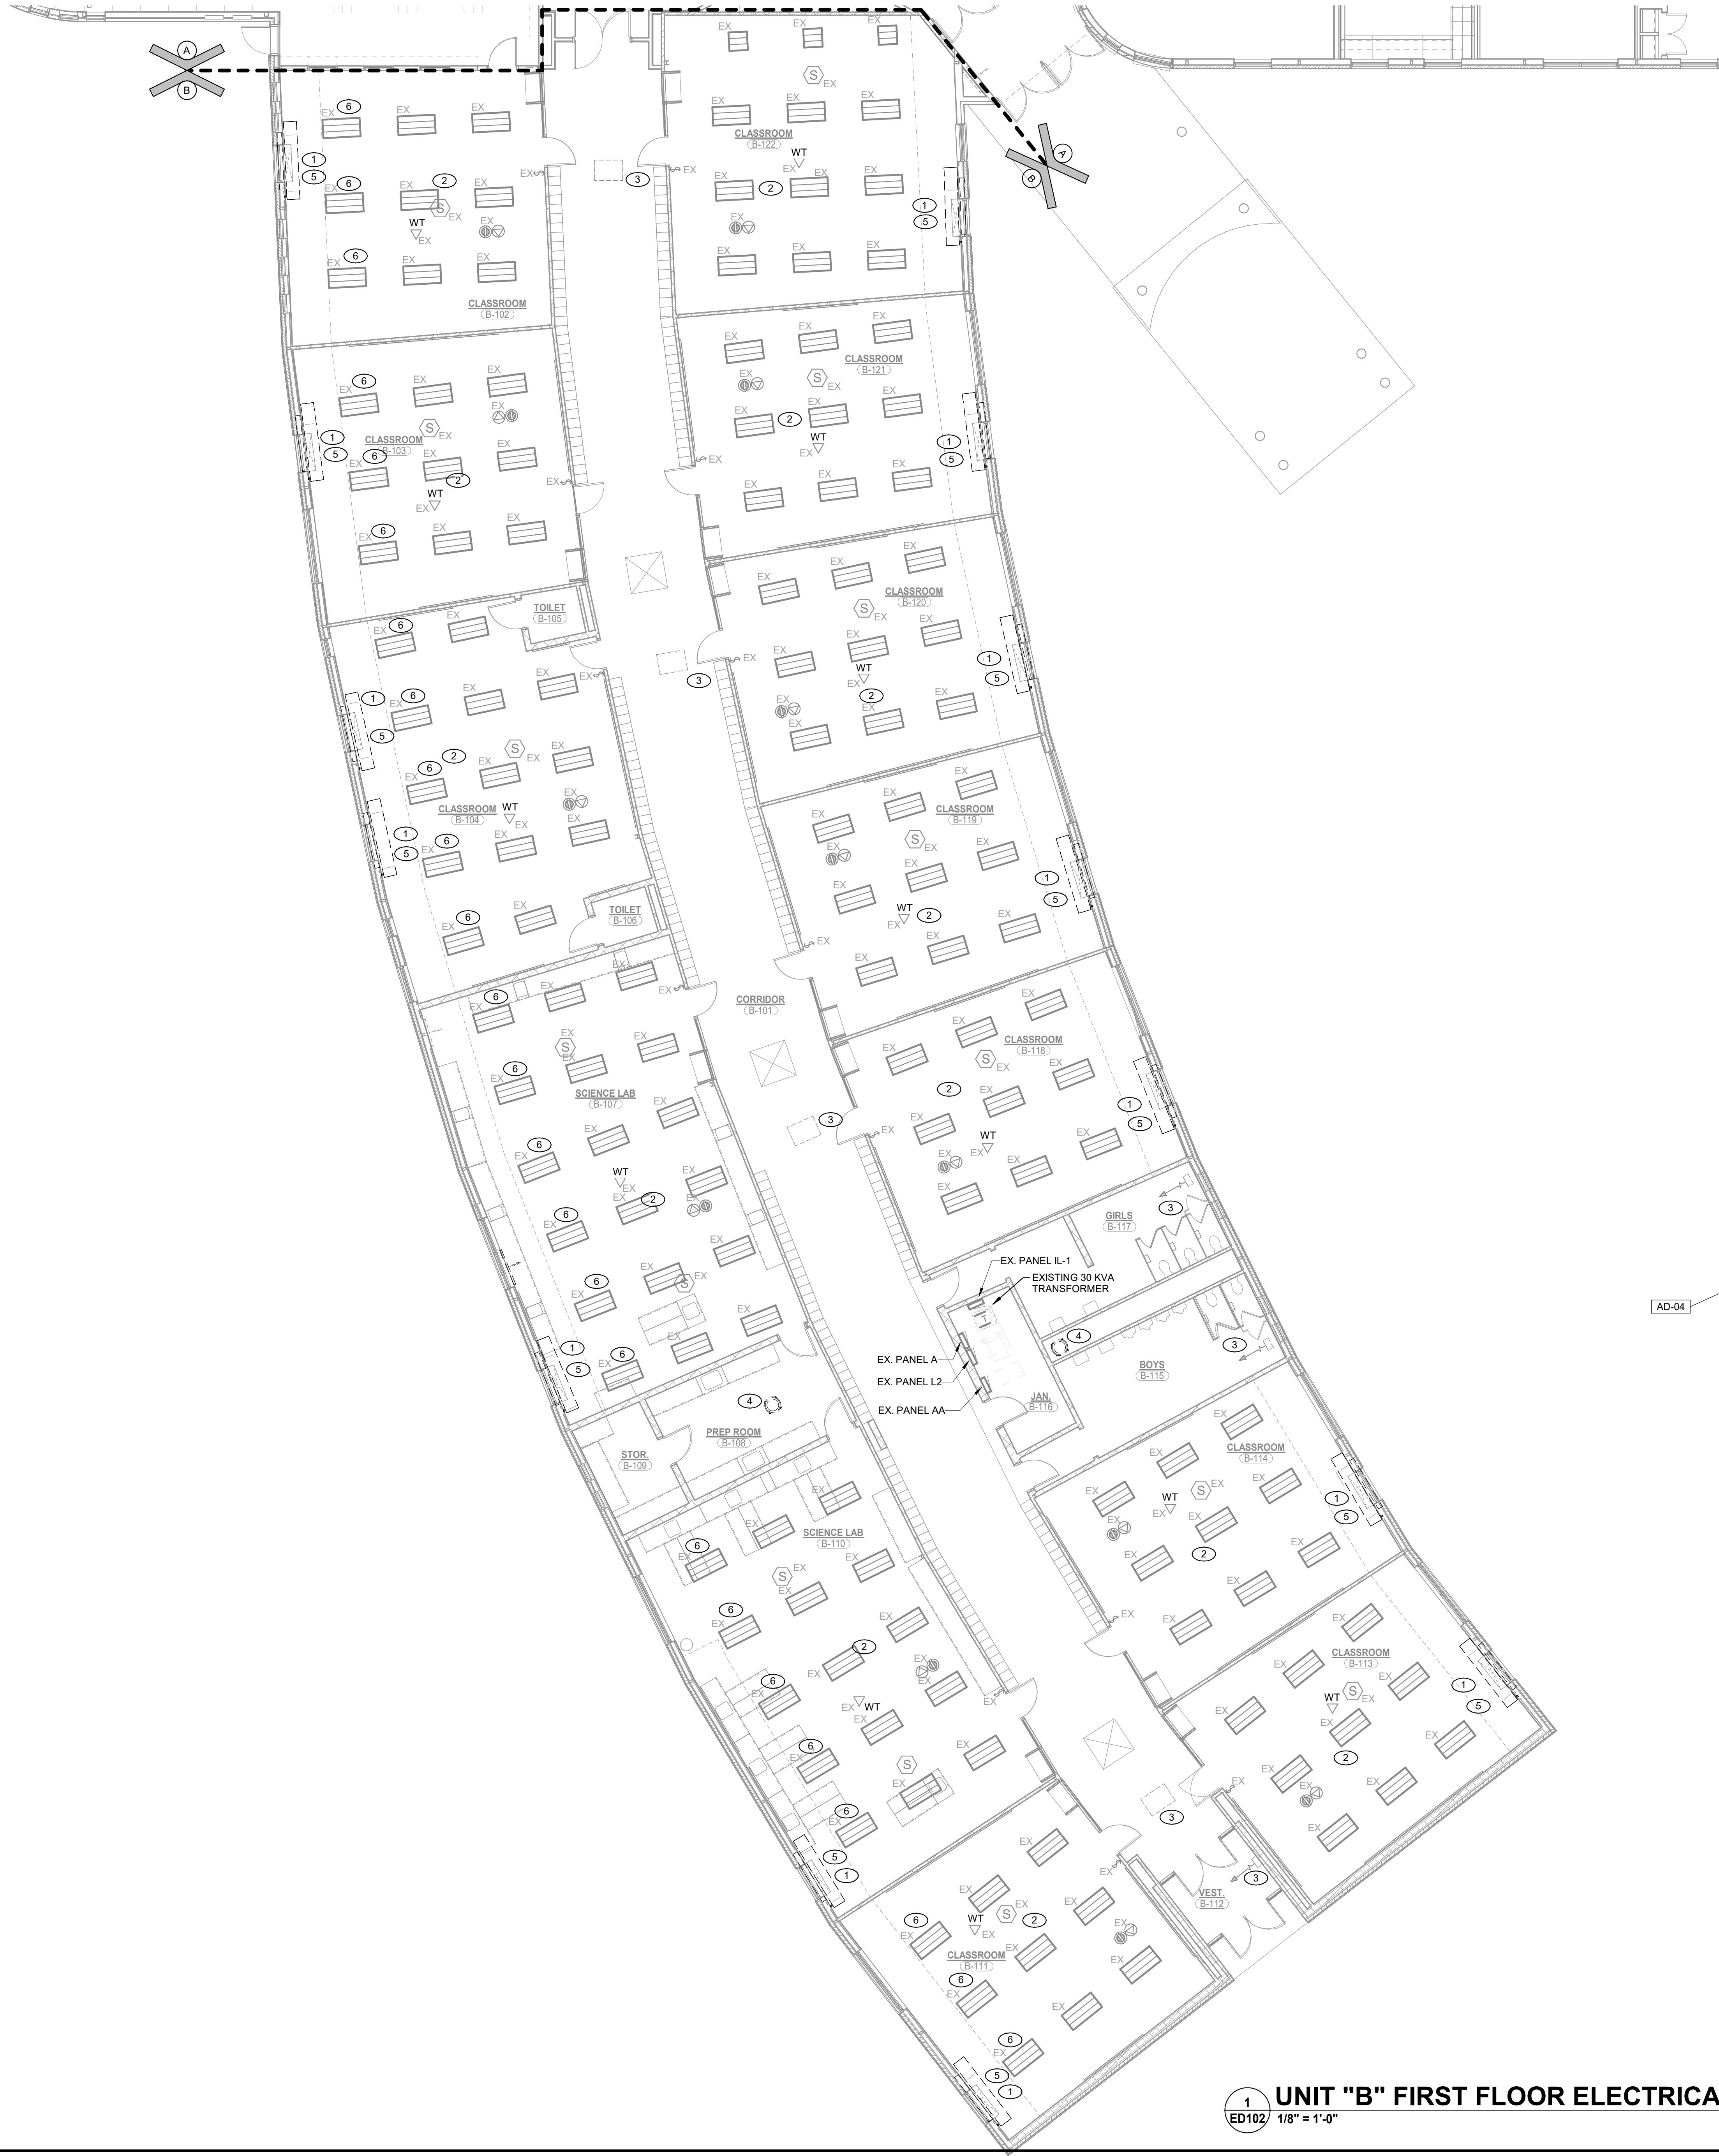

DEMOLITION NOTES

- COORDINATE PHASING OF WORK AND PROVIDE TEMPORARY POWER AND SERVICES AS REQUIRED FOR THE IMPLEMENTATION OF ALL WORK WHILE MAINTAINING SERVICES TO PORTIONS OF BUILDING TO REMAIN OCCUPIED.
- DISCONNECT AND REMOVE EXISTING ELECTRICAL DEVICES, EQUIPMENT, LIGHTING, WIRING, ETC., AS REQUIRED TO FACILITATE DEMOLITION AND RECONSTRUCTION WORK. COORDINATE WITH GENERAL CONSTRUCTION. THE CONTRACTOR IS HEREBY ADVISED THAT THESE DRAWINGS MAY NOT INDICATE ALL EXISTING WIRING AND/OR EQUIPMENT WHICH MUST BE REMOVED. REMOVED, RELOCATED, ETC., TO ACCOMMODATE DEMOLITION AND RECONSTRUCTION WORK IN THE EXISTING BUILDING.
- SCHEDULE ALL WORK TO AVOID DOWNTIME AND INCONVENIENCE TO OWNER. OWNER'S EXISTING FACILITY SHALL REMAIN IN OPERATION AT ALL TIMES, INCLUDING FIA AND OTHER SPECIAL SYSTEMS. ELECTRICAL POWER DISTRIBUTION, ETC., ALL REQUIRED SHUTDOWN OF EXISTING FACILITY UTILITIES SHALL BE SCHEDULED WITH OWNER'S OPERATING PERSONNEL.
- ALL EXISTING EQUIPMENT SHALL REMAIN PROPERTY OF THE OWNER AND OWNER SHALL DETERMINE IF CONTRACTOR IS TO STORE EQUIPMENT ON SITE AT OWNER SELECTED LOCATION OR IF CONTRACTOR IS TO ABANDON OR REMOVE EQUIPMENT FROM SITE.
- CONTRACTOR TO FIELD VERIFY IF EXISTING ASBESTOS WILL BE ENCOUNTERED PRIOR TO STARTING ANY WORK. IF ASBESTOS IS PRESENT, THE OWNER WILL PROVIDE FOR THE REMOVAL OF ANY MATERIAL CONTAINING ASBESTOS. SEE SPECIFICATIONS FOR FURTHER REQUIREMENTS.
- ANY HIDDEN CONDITIONS IDENTIFIED THROUGH THE COURSE OF CONSTRUCTION SHALL BE IMMEDIATELY BROUGHT TO THE ATTENTION OF THE ARCHITECT IN WRITTEN FORM FOR REVIEW AND DIRECTION. FAILURE TO DO SO SHALL MAKE THE CONTRACTOR RESPONSIBLE FOR ANY AND ALL REQUIRED CHANGES AND COSTS TO CORRECT SAID HIDDEN CONDITION.
- EXISTING INFORMATION IDENTIFIED ON THE CONTRACT DOCUMENTS IS SCHEMATIC ONLY AS AN AID TO THE CONTRACTOR. CONTRACTOR SHALL BE RESPONSIBLE TO PROPERLY ADDRESS ALL EXISTING CONDITIONS FOR A COMPLETE AND PROPER INSTALLATION OF NEW SYSTEMS. ALL EXISTING EQUIPMENT NOT IDENTIFIED SHALL BE BROUGHT TO THE ATTENTION OF THE ARCHITECT/ENGINEER FOR REVIEW AS TO WHETHER THE EQUIPMENT SHALL REMAIN AND BE RECONNECTED TO THE NEW SERVICES, BE RELOCATED, BE ABANDONED, ETC.
- DISCONNECT AND REMOVE EXISTING LIGHTING FIXTURES AND ANY OTHER CEILING DEVICES AS REQUIRED FOR INSTALLATION OF WORK (ALL TRADES). REINSTALL UPON COMPLETION OF WORK. REPAIR ALL DAMAGED FIXTURES AND DEVICES.
- VISIT SITE PRIOR TO BIDDING TO DETERMINE ALL FIELD CONDITIONS. VERIFY ALL EXISTING INTERIOR AND EXTERIOR ELECTRICAL SYSTEMS TO VERIFY QUANTITIES AND LOCATIONS OF EXISTING SYSTEMS TO DETERMINE FULL EXTENT OF DEMOLITION WORK.
- ALL EXISTING LIGHTING FIXTURES, ELECTRICAL DEVICES, CONDUIT, ETC., SHALL BE REMOVED AS NOTED ON DRAWINGS AND AS REQUIRED TO MEET NEW SCOPE OF WORK. ALL EXISTING ELECTRICAL EQUIPMENT SHALL REMAIN PROPERTY OF THE OWNER AND SHALL BE PROPERLY STORED ON SITE, OR DESIGNATED TO BE ABANDONED AND REMOVED FROM SITE AS DIRECTED BY OWNER.
- EXISTING ELECTRICAL DEVICES (RECEPTACLES, SWITCHES, OUTLET BOXES, CONDUIT, ETC.) WITHIN WALLS TO BE REMOVED SHALL BE DISCONNECTED COMPLETELY. REROUTE CIRCUITRY AS REQUIRED TO MAINTAIN CIRCUIT CONTINUITY FOR ALL REMAINING DEVICES/EQUIPMENT. VERIFY EXACT CONDITIONS AND QUANTITIES IN FIELD.
- PATCH ALL EXISTING CEILING, FLOOR, WALL AND ROOF OPENINGS AND SURROUNDING FINISHES RESULTING FROM REMOVAL OF EXISTING MATERIALS AND EQUIPMENT SO THAT FINISH WILL MATCH EXISTING IN SURROUNDING AREAS.

SHEET NOTES

- REMOVE EXISTING MECHANICAL EQUIPMENT ELECTRICAL CONNECTION AND ALL ASSOCIATED WIRING AND EXPOSED CONDUIT BACK TO SOURCE. GRIND ANY CONDUIT LEFT WITHIN THE FLOOR LINE. INFILL WITH CONCRETE, AND FINISH FLUSH WITH FLOOR. COMPLETE AS REQUIRED. ALL WIRING SHALL BE REMOVED. LABEL EXISTING CIRCUIT BREAKER FOR USE WITH NEW EQUIPMENT IN THIS SPACE. REFER TO THE NEW POWER PLANS FOR ADDITIONAL INFORMATION.
- REMOVE AND REINSTALL EXISTING LIGHTING, PROJECTORS, WIRELESS TERMINALS, OCCUPANCY SENSORS, AND OTHER CEILING MOUNTED DEVICES IN THIS SPACE AS REQUIRED FOR THE INSTALLATION OF THE NEW DUCTWORK, GRILLES, AND BULKHEAD. THE EXISTING LIGHTING LAYOUT SHALL BE MODIFIED AS REQUIRED FOR THE NEW BULKHEAD. COORDINATE LIGHTING LOCATIONS WITH NEW GRILLES IN FIELD. COMPLETE AS REQUIRED.
- EXISTING MECHANICAL EQUIPMENT TO REMAIN.
- DISCONNECT AND REMOVE EXISTING EXHAUST FAN AND RELATED CIRCUITRY BACK TO NEAREST JUNCTION BOX. COMPLETE AS REQUIRED. RETAIN ALL ASSOCIATED WIRING, CONDUIT, ETC. FOR USE WITH NEW EXHAUST FAN ON UNIT.
- REFER TO THE NEW PLANS FOR THE NEW LOCATION OF UNIT VENTILATOR. ANY EXISTING CONDUIT, WIRING, ETC. SERVING OTHER DEVICES OR EQUIPMENT IN THE NEW UNIT VENTILATOR LOCATION (INTERIOR OR EXTERIOR) SHALL BE MAINTAINED. REROUTE CONDUIT THROUGH, AROUND, OR ABOVE THE NEW UNIT VENTILATOR AS REQUIRED TO MAINTAIN EXISTING CIRCUIT CONTINUITY. ANY DEVICES IN CONFLICT WITH THE NEW LOCATIONS SHALL BE REMOVED AND RELOCATED TO THE SIDE OF THE UNIT. VERIFY THE FINAL LOCATION OF ANY DEVICES IN FIELD.
- REMOVE AND RELOCATE LIGHT FIXTURES ALONG WITH THE NEW VENT. PRIOR TO REMOVAL, COORDINATE WITH THE NEW SOFFIT LOCATION TO DETERMINE IF THE FIXTURES ARE IN CONFLICT WITH THE BULKHEAD. PROVIDE A LIST OF SPACES WHERE THE BULKHEAD AND FIXTURES ARE NOT IN CONFLICT TO THE ARCHITECT/ENGINEER FOR REVIEW PRIOR TO PROCEEDING.

GENERAL NOTES

- REFER TO THE ARCHITECTURAL RCP FOR FINAL CONFIRMATION OF CEILING WORK SCOPE. ROOMS ARE TAGGED ON THIS SHEET (SEE SHEET NOTE "2") FOR CONVENIENCE, BUT FINAL SCOPE SHALL BE VERIFIED WITH THE ARCHITECTURAL RCP.
- FOR EACH TC PANEL, DISCONNECT EXISTING TO PANEL DATA, AND POWER AS REQUIRED FOR INSTALLATION OF NEW REPLACEMENT TO PANEL. RECONNECT POWER AND DATA TO NEW TC PANEL, COMPLETE AS REQUIRED. REFER TO SHEETS M-106 & M-107 FOR TC PANEL LOCATIONS IN THE SR HIGH SCHOOL WING OF THE BUILDING.



GIBALTAR
DESIGN


ARCHITECTURE • ENGINEERING • INTERIOR DESIGN



PROJECT:

**OAK HILL JR HS
MECHANICAL
IMPROVEMENTS**

OAK HILL UNITED SCHOOL
CORPORATION
7760 DELPHI PIKE,
CONVERSE, IN, 46919

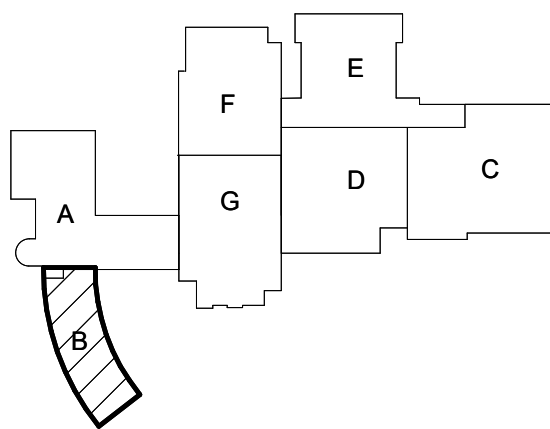

KEY PLAN



100% CONSTRUCTION
DOCUMENTS

GIBALTAR DESIGN

9102 N. Meridian St., Ste. 300
Indianapolis, IN 46260
Homepage: www.GibraltarDesign.com
Email: info@GibraltarDesign.com
Phone 317.580.5777 Fax 317.580.5778

PROJECT
25-176

DATE
07/20/26

COORDINATED BY
RH

DRAWN BY
BR/MH

CHECKED BY
DJ



COPYRIGHT NOTICE:

THE CONCEPT, DESIGN, PLANS, DETAILS, ETC. SHOWN ON THIS DOCUMENT ARE THE PROPERTY OF GIBALTAR DESIGN AND WERE CREATED FOR USE ON THIS SPECIFIC PROJECT. NONE OF THIS INFORMATION SHALL BE USED BY ANY PERSON OR FIRM FOR ANY PURPOSE WITHOUT THE EXPRESS WRITTEN CONSENT OF GIBALTAR DESIGN. THE OWNER MAY RETAIN COPIES FOR INFORMATION AND REFERENCE IN CONNECTION ONLY WITH THIS PROJECT.

REVISIONS

MARK	DATE	ISSUED FOR
AD-01	07/31/26	ADDENDUM 01
AD-02	08/07/26	ADDENDUM 02
AD-04	08/19/26	ADDENDUM 04

DRAWING

**UNIT "B" FIRST FLOOR
ELECTRICAL DEMOLITION PLAN**

PROJECT

**OAK HILL JR HS MECHANICAL
IMPROVEMENTS**


© GIBALTAR
DESIGN

SHEET

B

SHEET

ED102

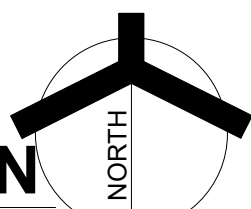


1
ED102

UNIT "B" FIRST FLOOR ELECTRICAL DEMOLITION PLAN

1/8" = 1'-0"

8/18/2026 1:40:48 PM
Autodesk Docs://2504056 Oak Hill SC - 2026 Construction Projects/MEG_Oak Hill- Jr High School_MEP-R05.vt

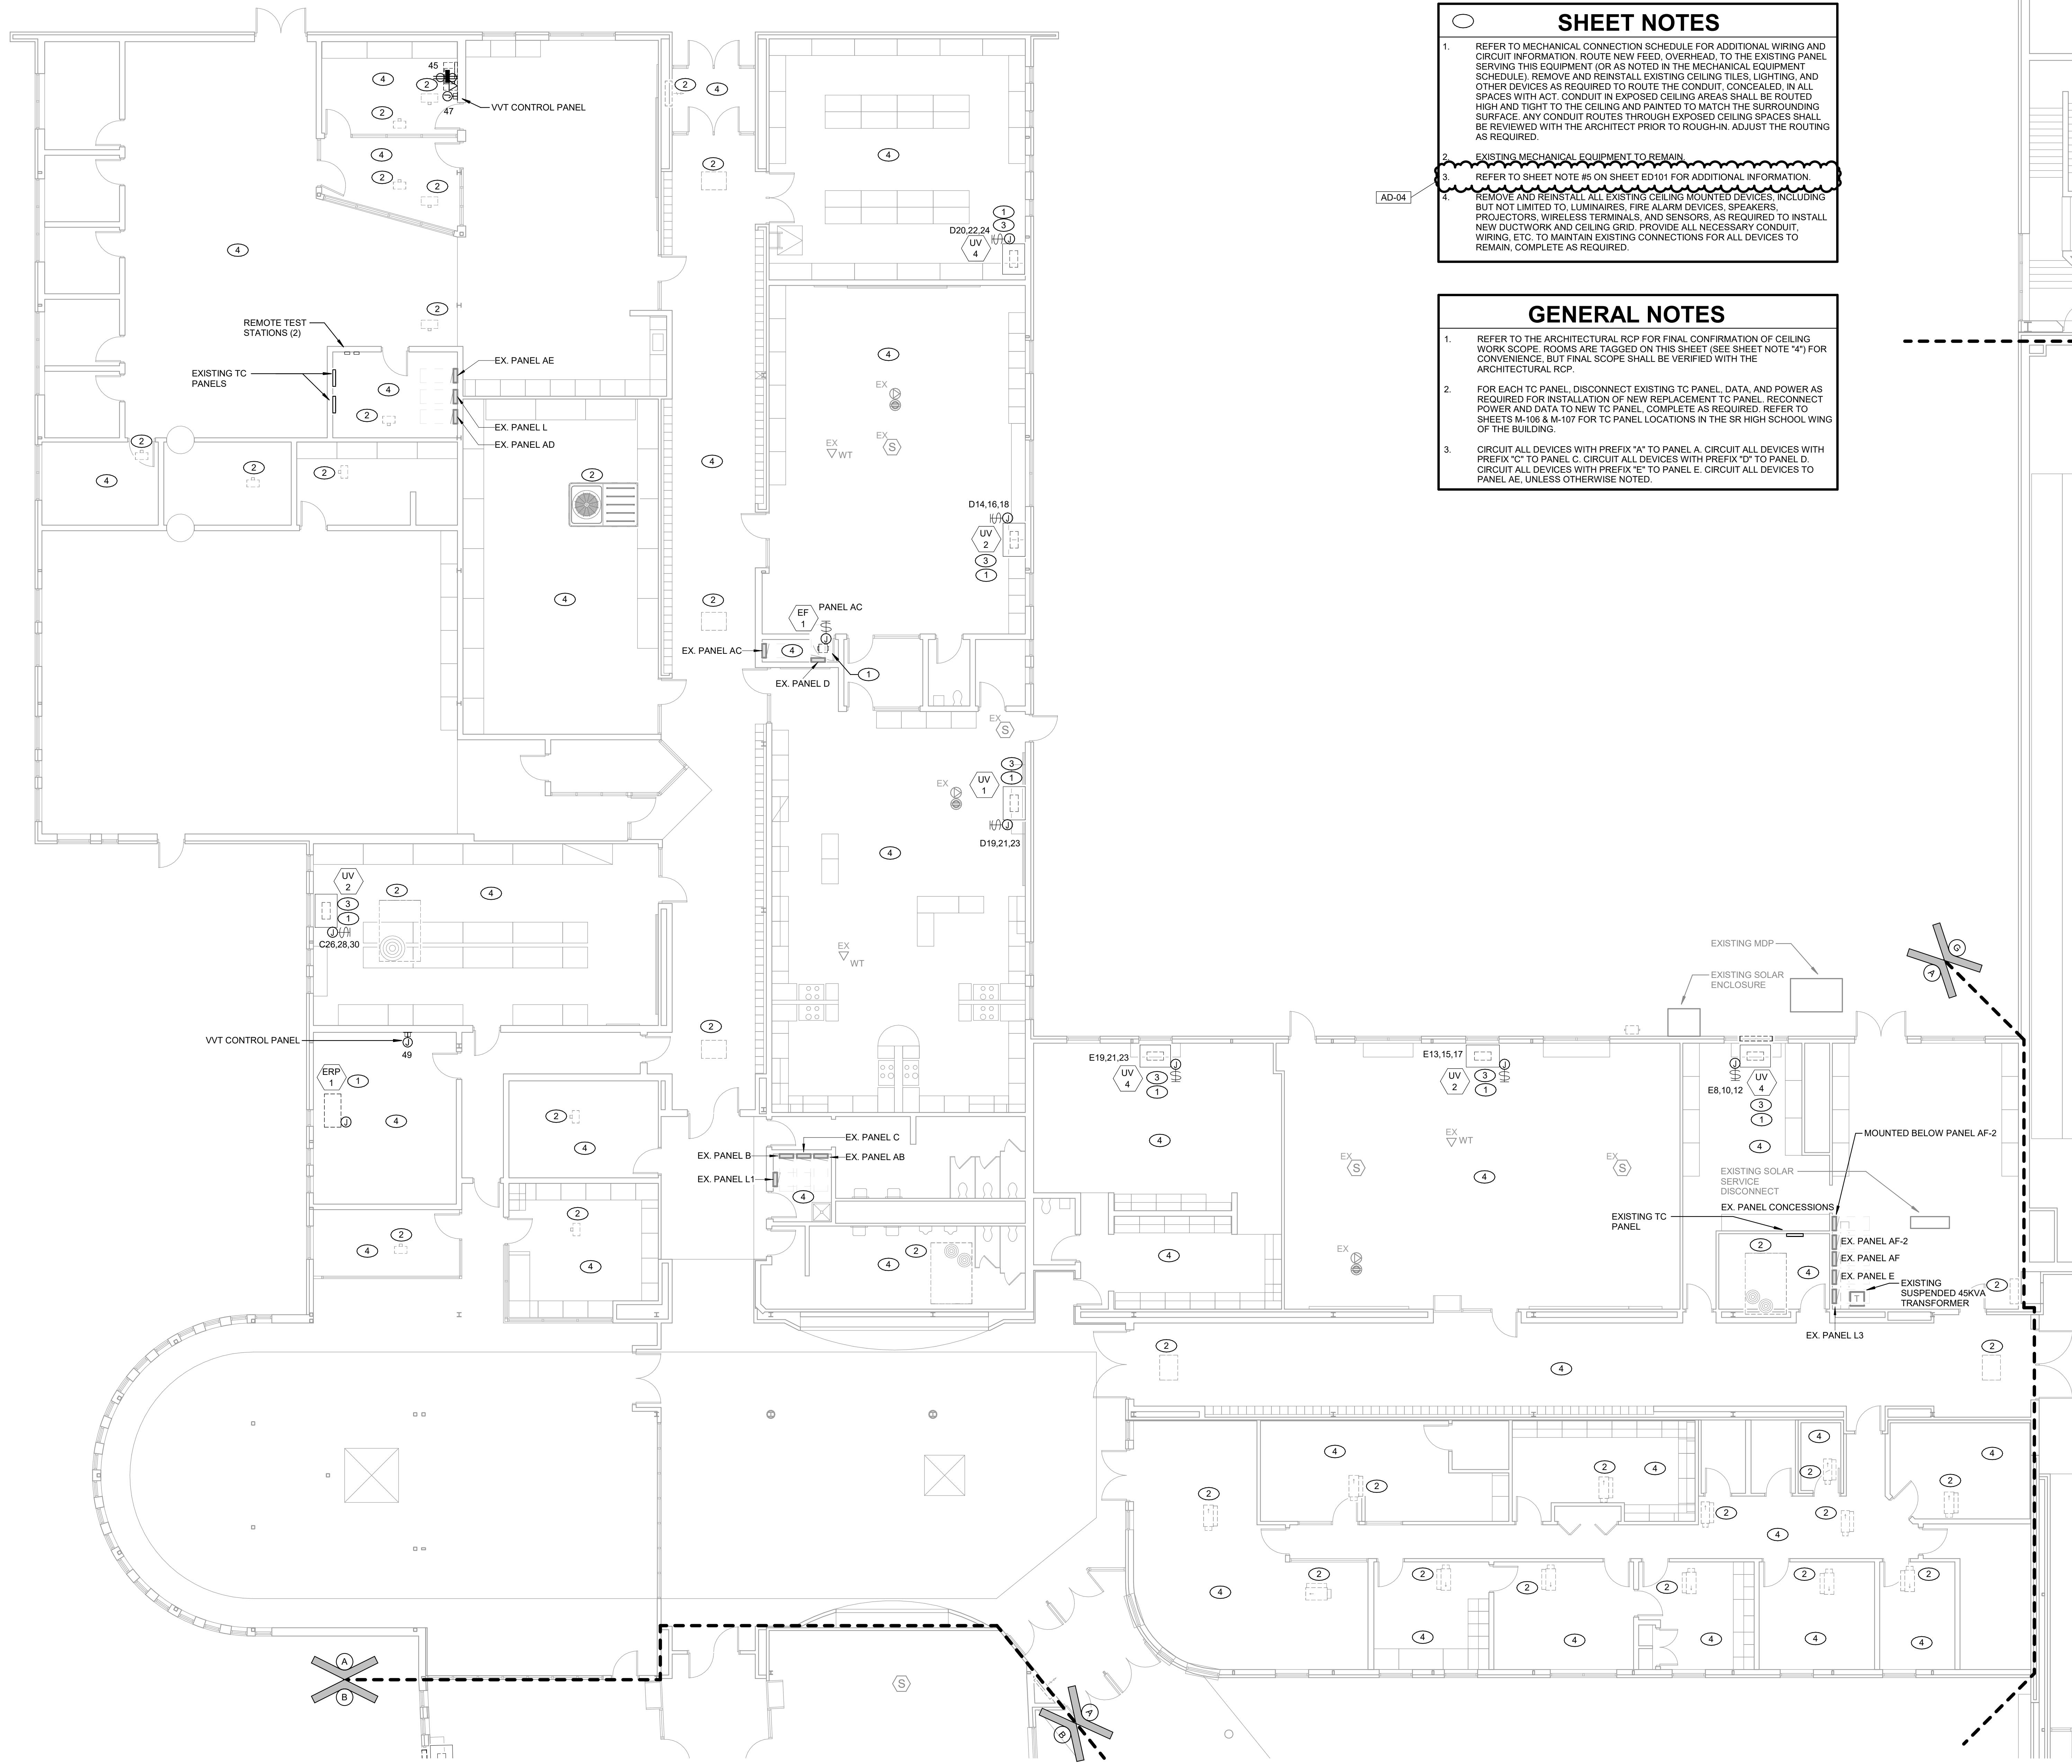


SHEET NOTES

- REFER TO MECHANICAL CONNECTION SCHEDULE FOR ADDITIONAL WIRING AND CIRCUIT INFORMATION. ROUTE NEW FEED, OVERHEAD, TO THE EXISTING PANEL SERVING THIS EQUIPMENT (OR AS NOTED IN THE MECHANICAL EQUIPMENT SCHEDULE). REMOVE AND REINSTALL EXISTING CEILING TILES, LIGHTING, AND OTHER DEVICES AS REQUIRED TO ROUTE THE CONDUIT, CONCEALED, IN ALL SPACES WITH ACCT. CONDUIT IN EXPOSED CEILING AREAS SHALL BE ROUTED HIGH AND TIGHT TO THE CEILING AND PAINTED TO MATCH THE SURROUNDING SURFACE. ANY CONDUIT ROUTES THROUGH EXPOSED CEILING SPACES SHALL BE REVIEWED WITH THE ARCHITECT PRIOR TO ROUGH-IN. ADJUST THE ROUTING AS REQUIRED.
- EXISTING MECHANICAL EQUIPMENT TO REMAIN.
- REFER TO SHEET NOTE #5 ON SHEET ED101 FOR ADDITIONAL INFORMATION.
- REMOVE AND REINSTALL ALL EXISTING CEILING MOUNTED DEVICES, INCLUDING BUT NOT LIMITED TO, LUMINAIRES, FIRE ALARM DEVICES, SPEAKERS, PROJECTORS, WIRELESS TERMINALS, AND SENSORS, AS REQUIRED TO INSTALL NEW DUCTWORK AND CEILING GRID. PROVIDE ALL NECESSARY CONDUIT, WIRING, ETC. TO MAINTAIN EXISTING CONNECTIONS FOR ALL DEVICES TO REMAIN, COMPLETE AS REQUIRED.

GENERAL NOTES

- REFER TO THE ARCHITECTURAL RCP FOR FINAL CONFIRMATION OF CEILING WORK SCOPE. ROOMS ARE TAGGED ON THIS SHEET (SEE SHEET NOTE '4') FOR CONVENIENCE, BUT FINAL SCOPE SHALL BE VERIFIED WITH THE ARCHITECTURAL RCP.
- FOR EACH TC PANEL, DISCONNECT EXISTING TC PANEL, DATA, AND POWER AS REQUIRED FOR INSTALLATION OF NEW REPLACEMENT TC PANEL. RECONNECT POWER AND DATA TO NEW TC PANEL, COMPLETE AS REQUIRED. REFER TO SHEETS M-106 & M-107 FOR TC PANEL LOCATIONS IN THE SR HIGH SCHOOL WING OF THE BUILDING.
- CIRCUIT ALL DEVICES WITH PREFIX 'A' TO PANEL A, CIRCUIT ALL DEVICES WITH PREFIX 'C' TO PANEL C, CIRCUIT ALL DEVICES WITH PREFIX 'D' TO PANEL D, CIRCUIT ALL DEVICES WITH PREFIX 'E' TO PANEL E, CIRCUIT ALL DEVICES TO PANEL AE, UNLESS OTHERWISE NOTED.

1 UNIT "A" FIRST FLOOR ELECTRICAL POWER PLAN
EP101 1/8" = 1'-0"

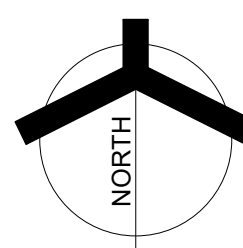

GIBALTAR
DESIGN

ARCHITECTURE • ENGINEERING • INTERIOR DESIGN




PROJECT:

**OAK HILL JR HS
MECHANICAL
IMPROVEMENTS**

OAK HILL UNITED SCHOOL
CORPORATION
7760 DELPHI PIKE,
CONVERSE, IN. 46919

APPROXIMATE
LOCATION OF
EXISTING
NOTIFIER FACP

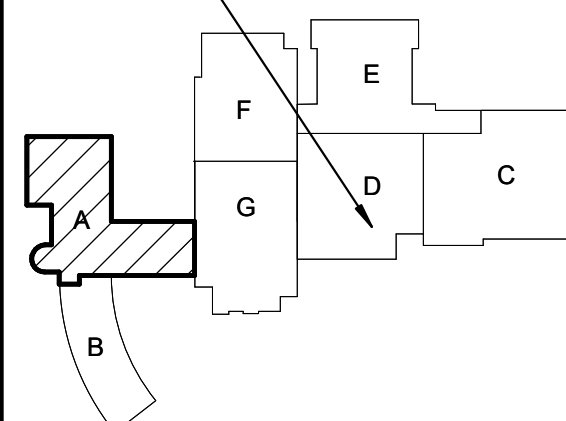

KEY PLAN



100% CONSTRUCTION
DOCUMENTS

GIBALTAR DESIGN

9102 N. Meridian St., Ste. 300
Indianapolis, IN 46260
Homepage: www.GibraltarDesign.com
Email: info@GibraltarDesign.com
Phone 317.580.5777 Fax 317.580.5778

PROJECT

25-176

DATE

07/20/26

COORDINATED BY


RH

DRAWN BY

BR/MH

CHECKED BY

DJ

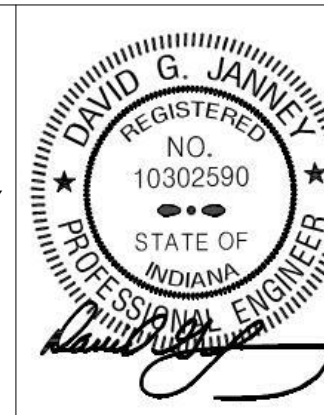

COPYRIGHT NOTICE:

THE CONCEPTS, DESIGN, PLANS, DETAILS, ETC. SHOWN ON THIS DOCUMENT ARE THE PROPERTY OF GIBALTAR DESIGN AND WERE CREATED FOR USE ON THIS SPECIFIC PROJECT. NONE OF THIS INFORMATION SHALL BE USED BY ANY PERSON OR FOR ANY PURPOSE WITHOUT THE EXPRESS WRITTEN CONSENT OF GIBALTAR DESIGN. THE OWNER MAY RETAIN COPIES FOR INFORMATION AND REFERENCE IN CONNECTION ONLY WITH THIS PROJECT.

REVISIONS

MARK	DATE	ISSUED FOR
AD-01	07/31/26	ADDENDUM 01
AD-04	08/19/26	ADDENDUM 04

DRAWING

UNIT "A" FIRST FLOOR
ELECTRICAL POWER PLAN

PROJECT

OAK HILL JR HS MECHANICAL
IMPROVEMENTS


© GIBALTAR
DESIGN

SHEET

A

EP101

Copyright © 2026 Millies Engineering Group

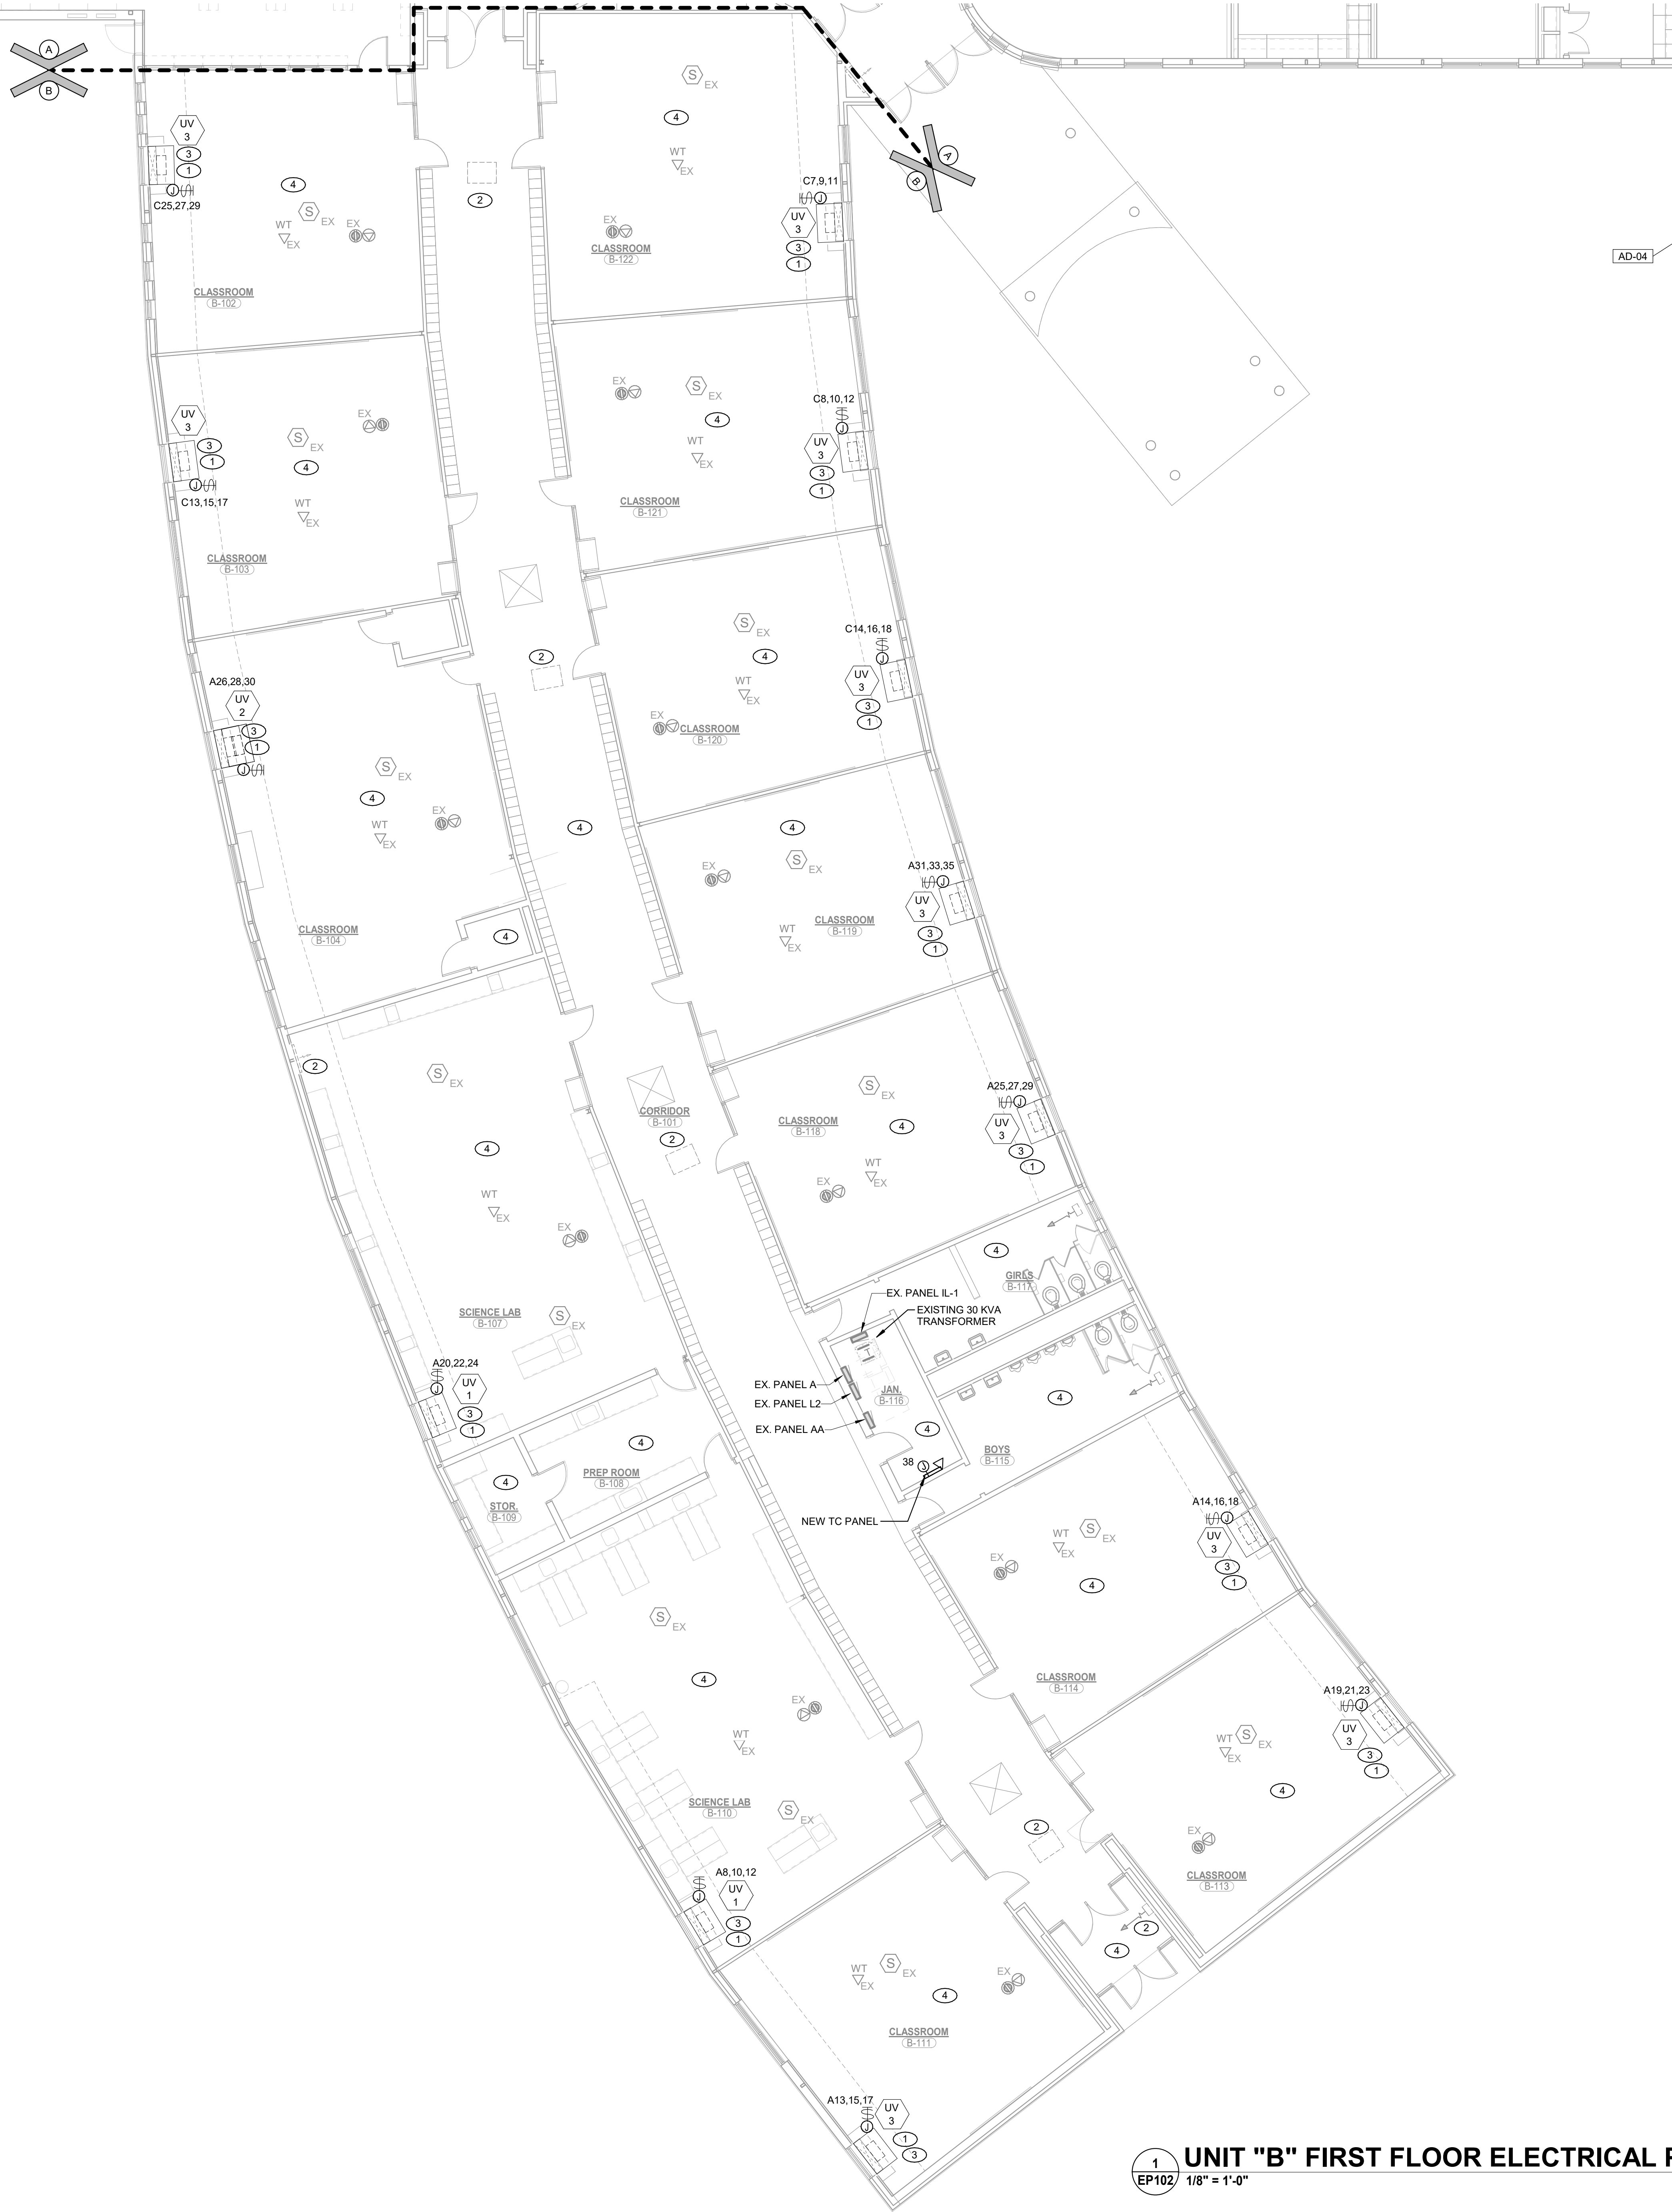

SHEET NOTES

1.

REFER TO MECHANICAL CONNECTION SCHEDULE FOR ADDITIONAL WIRING AND CIRCUIT INFORMATION. ROUTE NEW FEED, OVERHEAD, TO THE EXISTING PANEL SERVING THIS EQUIPMENT (OR AS NOTED IN THE MECHANICAL EQUIPMENT SCHEDULE). REMOVE AND REINSTALL EXISTING CEILING TILES, LIGHTING, AND OTHER DEVICES AS REQUIRED TO ROUTE THE CONDUIT. CONCEALED, IN ALL SPACES WITH ACT. CONDUIT IN EXPOSED CEILING AREAS SHALL BE ROUTED HIGH AND TIGHT TO THE CEILING AND PAINTED TO MATCH THE SURROUNDING SURFACE. ANY CONDUIT ROUTES THROUGH EXPOSED CEILING SPACES SHALL BE REVIEWED WITH THE ARCHITECT PRIOR TO ROUGH-IN. ADJUST THE ROUTING AS REQUIRED.

2.

EXISTING MECHANICAL EQUIPMENT TO REMAIN.

3.

REFER TO SHEET NOTE #5 ON SHEET ED102 FOR ADDITIONAL INFORMATION.

4.

REMOVE AND REINSTALL ALL EXISTING CEILING MOUNTED DEVICES, INCLUDING BUT NOT LIMITED TO, LUMINAIRES, FIRE ALARM DEVICES, SPEAKERS, PROJECTORS, WIRELESS TERMINALS, AND SENSORS, AS REQUIRED TO INSTALL NEW DUCTWORK AND CEILING GRID. PROVIDE ALL NECESSARY CONDUIT, WIRING, ETC. TO MAINTAIN EXISTING CONNECTIONS FOR ALL DEVICES TO REMAIN, COMPLETE AS REQUIRED.

GENERAL NOTES

1.

REFER TO THE ARCHITECTURAL RCP FOR FINAL CONFIRMATION OF CEILING WORK SCOPE. ROOMS ARE TAGGED ON THIS SHEET (SEE SHEET NOTE 4*) FOR CONVENIENCE, BUT FINAL SCOPE SHALL BE VERIFIED WITH THE ARCHITECTURAL RCP.

2.

FOR EACH TC PANEL, DISCONNECT EXISTING TC PANEL, DATA, AND POWER AS REQUIRED FOR INSTALLATION OF NEW REPLACEMENT TC PANEL. RECONNECT POWER AND DATA TO NEW TC PANEL, COMPLETE AS REQUIRED. REFER TO SHEETS M-106 & M-107 FOR TC PANEL LOCATIONS IN THE SENIOR HIGH SCHOOL WING OF THE BUILDING.

3.

CIRCUIT ALL DEVICES WITH PREFIX "A" TO PANEL A. CIRCUIT ALL DEVICES WITH PREFIX "C" TO PANEL C. CIRCUIT ALL DEVICES WITH PREFIX "D" TO PANEL D. CIRCUIT ALL DEVICES WITH PREFIX "E" TO PANEL E. CIRCUIT ALL DEVICES TO PANEL AA, UNLESS OTHERWISE NOTED.

APPROXIMATE
LOCATION OF
EXISTING
NOTIFIER FACE

GIBALTAR
DESIGN


ARCHITECTURE • ENGINEERING • INTERIOR DESIGN

MILLIES

ENGINEERING GROUP
0791 924440
www.milliesengineeringgroup.com

PROJECT:
**OAK HILL JR HS
MECHANICAL
IMPROVEMENTS**

OAK HILL UNITED SCHOOL
CORPORATION
7760 DELPHI PIKE,
CONVERSE, IN. 46919

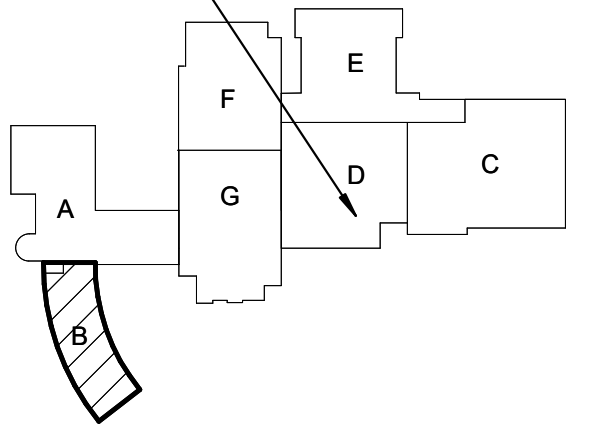

KEY PLAN



100% CONSTRUCTION
DOCUMENTS

GIBALTAR DESIGN

9102 N. Meridian St., Ste. 300
Indianapolis, IN 46260
Homepage: www.GibraltarDesign.com
Email: info@GibraltarDesign.com
Phone 317.580.5777 Fax 317.580.5778

PROJECT
25-176
DATE
07/20/26
COORDINATED BY
RH
DRAWN BY
BR/MH
CHECKED BY
DJ



COPYRIGHT NOTICE:
THE CONCEPTS, DESIGN, PLANS, DETAILS, ETC. SHOWN ON THIS DOCUMENT ARE THE PROPERTY OF GIBALTAR DESIGN AND WERE CREATED FOR USE ON THIS SPECIFIC PROJECT. NONE OF THIS INFORMATION SHALL BE USED BY ANY PERSON OR FIRM FOR ANY PURPOSE WITHOUT THE EXPRESS WRITTEN CONSENT OF GIBALTAR DESIGN. THE OWNER MAY RETAIN COPIES FOR INFORMATION AND REFERENCE IN CONNECTION ONLY WITH THIS PROJECT.

REVISIONS		
MARK	DATE	ISSUED FOR
AD-01	07/31/26	ADDENDUM 01
AD-04	08/19/26	ADDENDUM 04


DRAWING
**UNIT "B" FIRST FLOOR
ELECTRICAL POWER PLAN**

PROJECT
**OAK HILL JR HS MECHANICAL
IMPROVEMENTS**


© GIBALTAR
DESIGN
B

SHEET
EP102

1 UNIT "B" FIRST FLOOR ELECTRICAL POWER PLAN
EP102 1/8" = 1'-0"

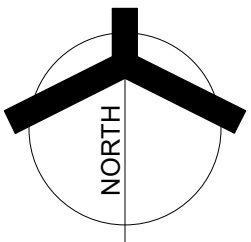

8/18/2026 1:40:49 PM
Autodesk Docs://2504055 Oak Hill SC - 2026 Construction Projects/MEG_Oak Hill- Jr High School_MEP-R05.rvt

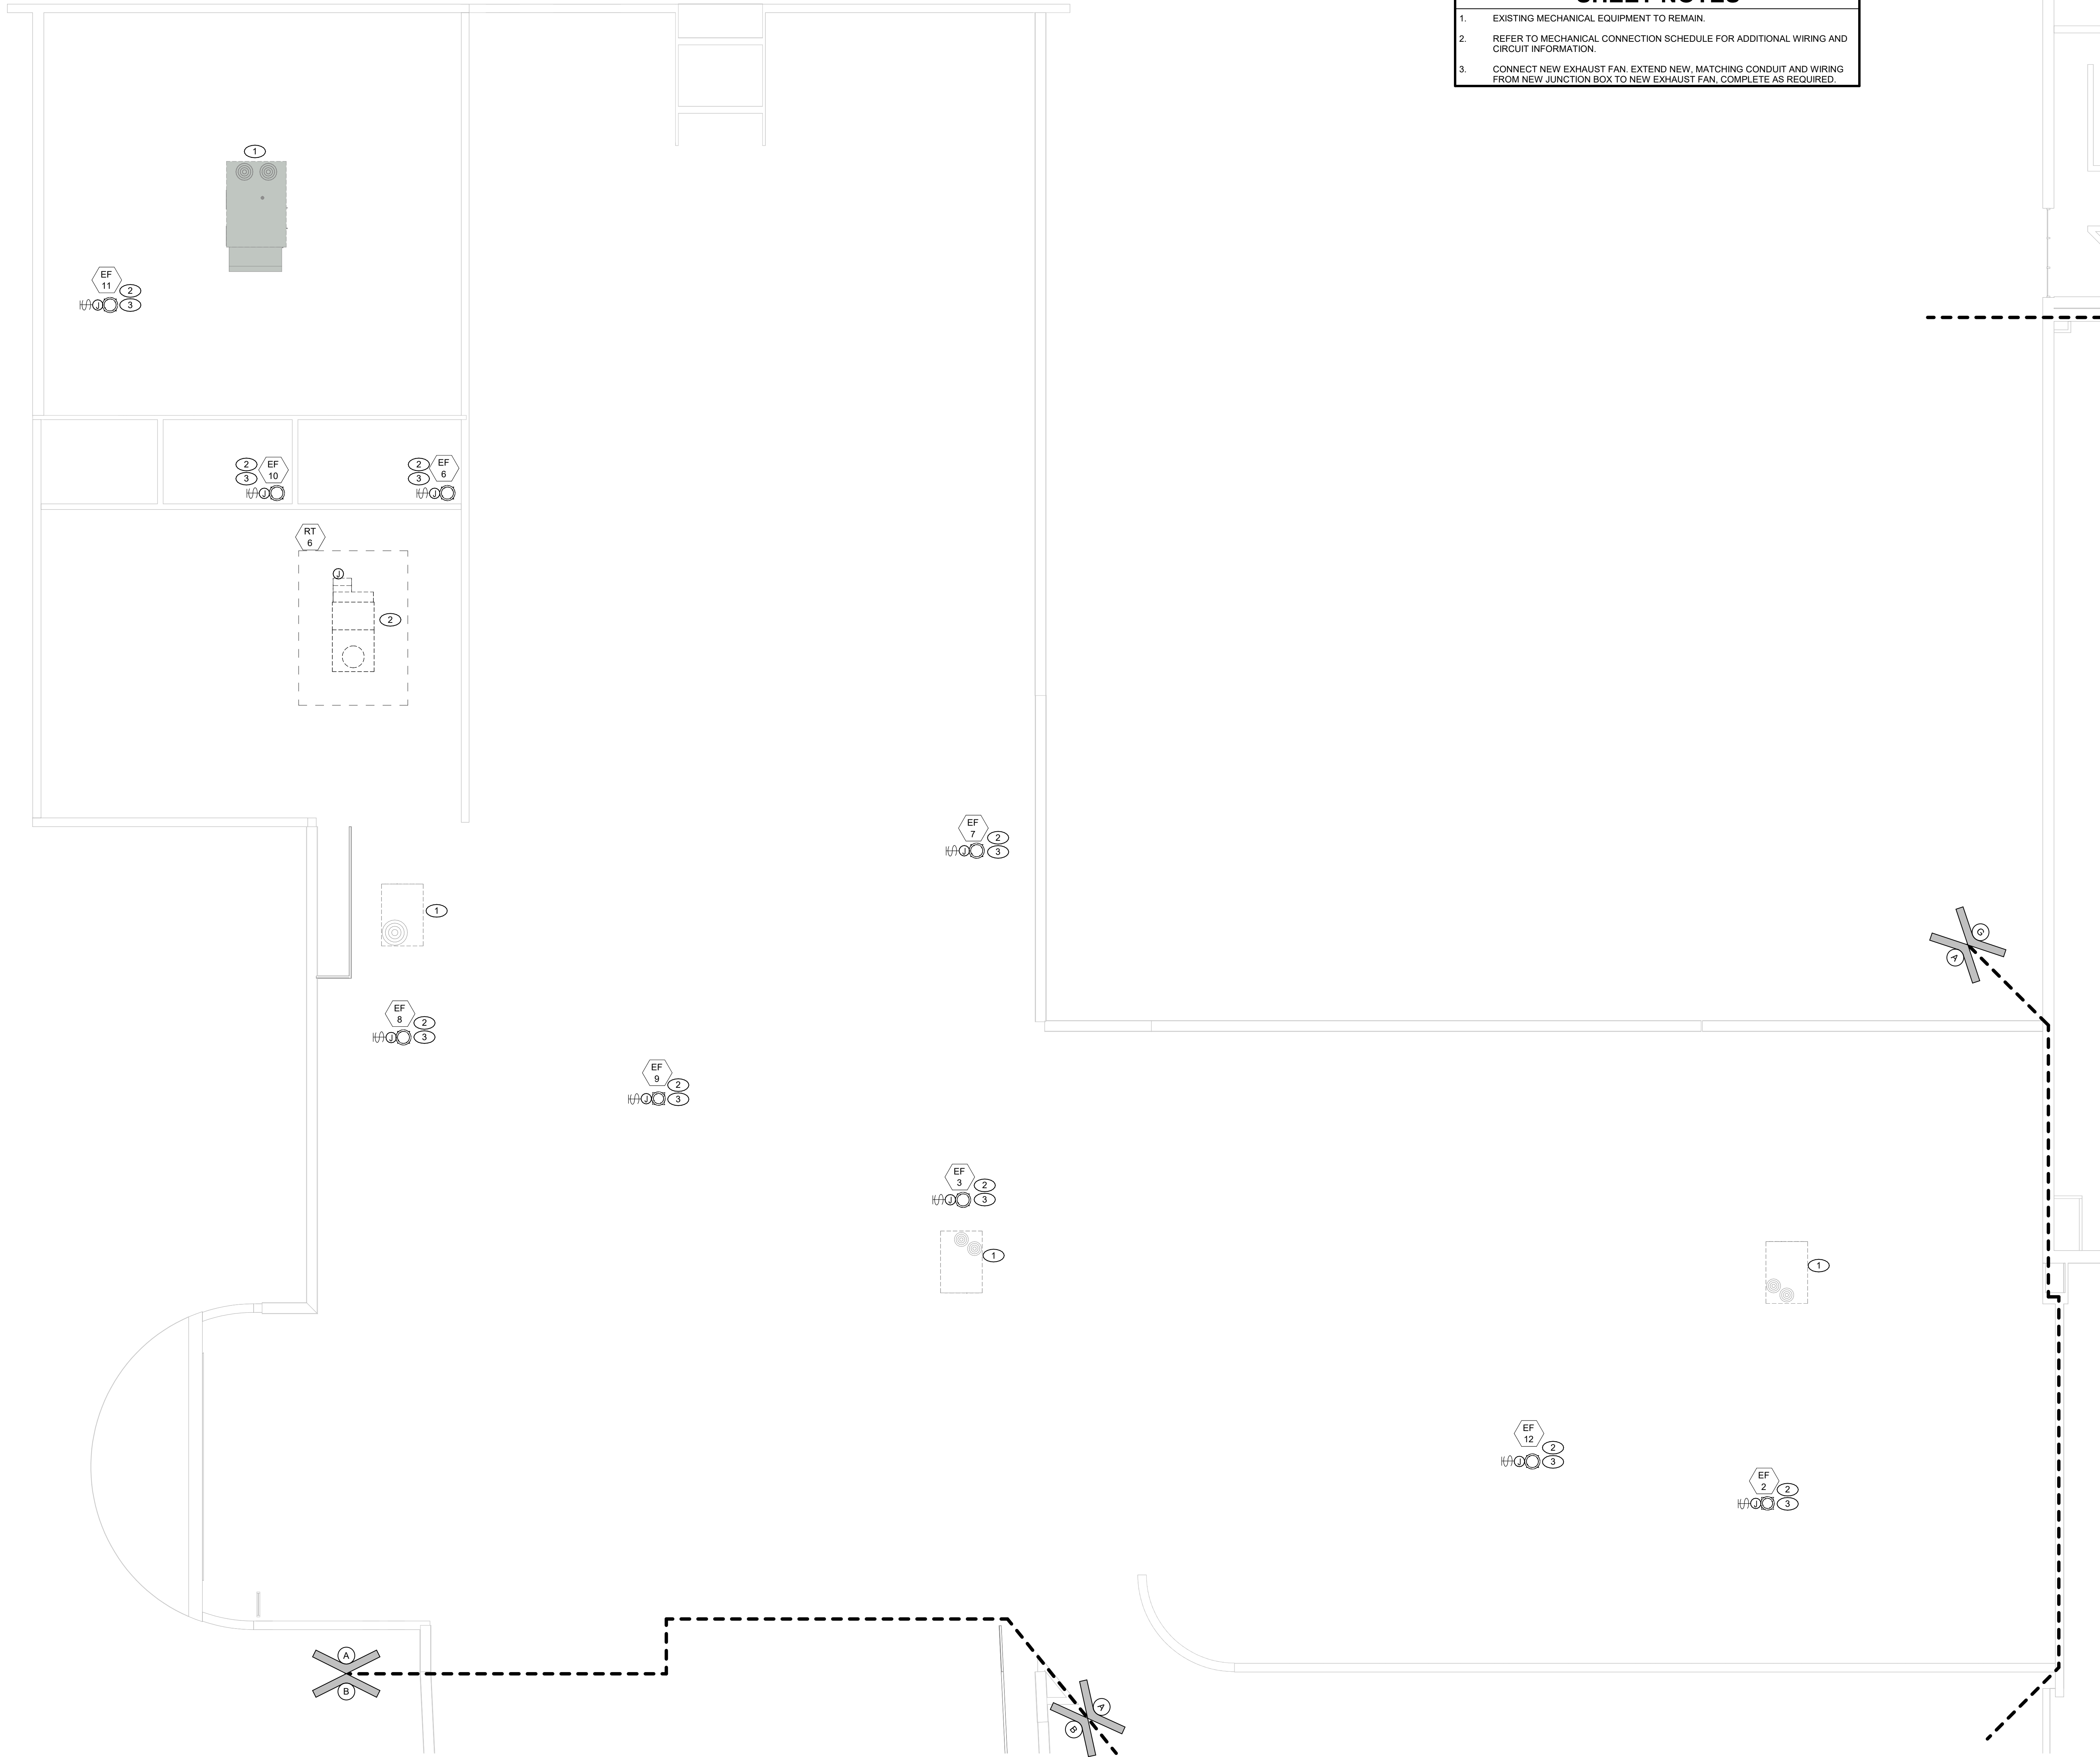

SHEET NOTES

1.

EXISTING MECHANICAL EQUIPMENT TO REMAIN.

2.

REFER TO MECHANICAL CONNECTION SCHEDULE FOR ADDITIONAL WIRING AND CIRCUIT INFORMATION.

3.


CONNECT NEW EXHAUST FAN. EXTEND NEW, MATCHING CONDUIT AND WIRING FROM NEW JUNCTION BOX TO NEW EXHAUST FAN, COMPLETE AS REQUIRED.

1

EP205

1/8" = 1'-0"

UNIT "A" ROOF ELECTRICAL POWER PLAN

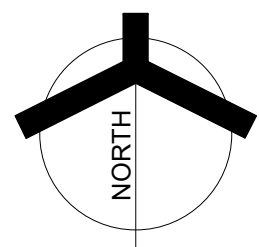


GIBRALTAR
DESIGN
ARCHITECTURE • ENGINEERING • INTERIOR DESIGN

MILLIES
ENGINEERING GROUP
©2019 0245402
www.milliesengineeringgroup.com

PROJECT:
**OAK HILL JR HS
MECHANICAL
IMPROVEMENTS**

OAK HILL UNITED SCHOOL
CORPORATION
7760 DELPHI PIKE,
CONVERSE, IN, 46919

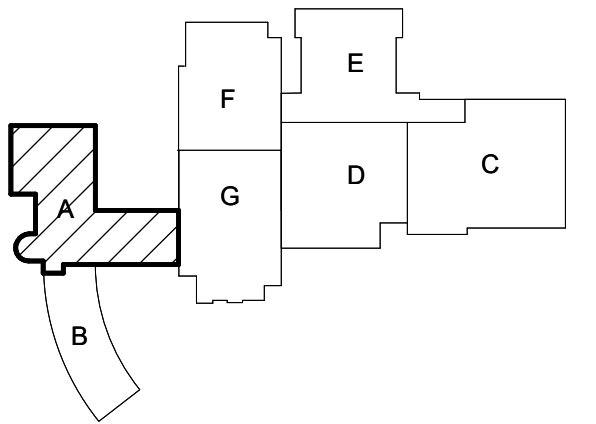

KEY PLAN

NORTH

100% CONSTRUCTION
DOCUMENTS

GIBRALTAR DESIGN

9102 N. Meridian St., Ste. 300
Indianapolis, IN 46260
Homepage: www.GibraltarDesign.com
Email: info@GibraltarDesign.com
Phone: 317-580.5777 Fax: 317-580.5778

PROJECT
25-176
DATE
07/20/26
COORDINATED BY
RH
DRAWN BY
BR/MH
CHECKED BY
DJ

COPYRIGHT NOTICE:
THE CONCEPTS, DESIGN, PLANS, DETAILS, ETC. SHOWN ON THIS DOCUMENT ARE THE PROPERTY OF GIBRALTAR DESIGN AND WERE CREATED FOR USE ON THIS SPECIFIC PROJECT. NONE OF THIS INFORMATION SHALL BE USED BY ANY PERSON OR FIRM FOR ANY PURPOSE WITHOUT THE EXPRESS WRITTEN CONSENT OF GIBRALTAR DESIGN. THE OWNER MAY RETAIN COPIES FOR INFORMATION AND REFERENCE IN CONNECTION ONLY WITH THIS PROJECT.

REVISIONS		
MARK	DATE	ISSUED FOR
AD-04	08/19/26	ADDENDUM 04

DRAWING
**UNIT "A" ROOF ELECTRICAL
POWER PLAN**

PROJECT
OAK HILL JR HS MECHANICAL
IMPROVEMENTS










© GIBRALTAR
DESIGN

AD-04

SHEET
A

EP205

  8/18/2026 1:40:50 PM
Autodesk Docs://2504055 Oak Hill SC - 2026 Construction Projects/MEG_Oak Hill- Jr High School_MEP-R25.rvt

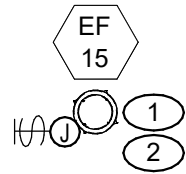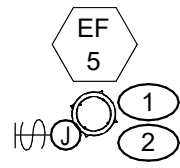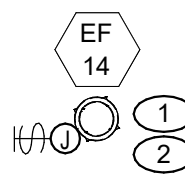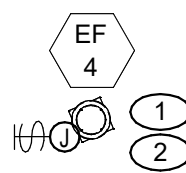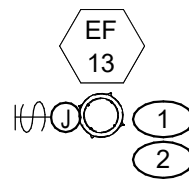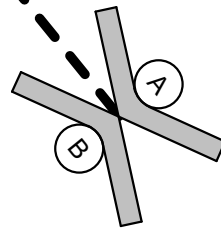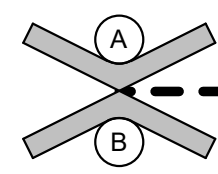

SHEET NOTES

1.

REFER TO MECHANICAL CONNECTION SCHEDULE FOR ADDITIONAL WIRING AND CIRCUIT INFORMATION.

2.

CONNECT NEW EXHAUST FAN. EXTEND NEW, MATCHING CONDUIT AND WIRING FROM NEW JUNCTION BOX TO NEW EXHAUST FAN, COMPLETE AS REQUIRED.



GIBRALTAR
DESIGN

ARCHITECTURE • ENGINEERING • INTERIOR DESIGN




PROJECT:

OAK HILL JR HS
MECHANICAL
IMPROVEMENTS

OAK HILL UNITED SCHOOL
CORPORATION

7760 DELPHI PIKE,
CONVERSE, IN, 46919

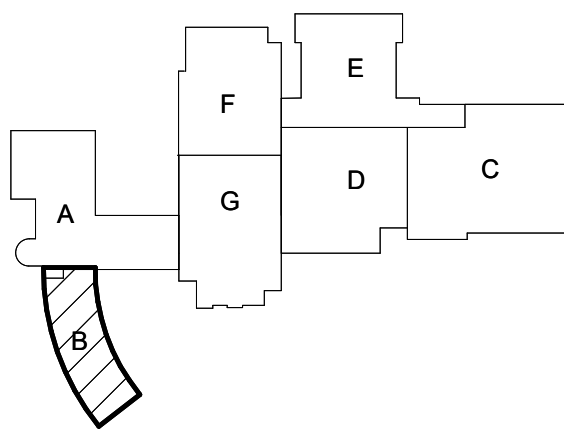

KEY PLAN



100% CONSTRUCTION
DOCUMENTS

GIBRALTAR DESIGN

9102 N. Meridian St., Ste. 300
Indianapolis, IN 46260
Homepage: www.GibraltarDesign.com
Email: info@GibraltarDesign.com
Phone: 317-580.5777 Fax: 317-580.5778

PROJECT

25-176

DATE

07/20/26

COORDINATED BY

RH

DRAWN BY

BR/MH

CHECKED BY

DJ



COPYRIGHT NOTICE:

THE CONCEPTS, DESIGN, PLANS, DETAILS, ETC., SHOWN ON THIS DOCUMENT ARE THE PROPERTY OF GIBRALTAR DESIGN AND WERE CREATED FOR USE ON THIS SPECIFIC PROJECT. NONE OF THIS INFORMATION SHALL BE USED BY ANY PERSON OR FIRM FOR ANY PURPOSE WITHOUT THE EXPRESS WRITTEN CONSENT OF GIBRALTAR DESIGN. THE OWNER MAY RETAIN COPIES FOR INFORMATION AND REFERENCE IN CONNECTION ONLY WITH THIS PROJECT.

REVISIONS

MARK	DATE	ISSUED FOR
AD-04	08/19/26	ADDENDUM 04

DRAWING

UNIT "B" ROOF ELECTRICAL
POWER PLAN

PROJECT

OAK HILL JR HS MECHANICAL
IMPROVEMENTS

© GIBRALTAR
DESIGN


AD-04

B

SHEET

EP206

1
EP206
UNIT "B" ROOF ELECTRICAL POWER PLAN
1/8" = 1'-0"

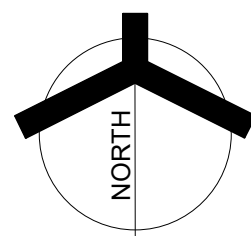

AD-04

B

SHEET

EP206



MILLIES
ENGINEERING GROUP
(279) 924-8400
www.milliesenineeringgroup.com

OAK HILL JR HS MECHANICAL IMPROVEMENTS

100% CONSTRUCTION DOCUMENTS

9102 N. Meridian St., Ste. 300
Indianapolis, IN 46260
Homepage: www.GibraltarDesign.com
Email: info@GibraltarDesign.com
Phone 317.580.5777 Fax 317.580.5778

© GIBRAL
DESIGN

OAK HILL JR HS MECHANICAL IMPROVEMENTS

© GIBRAL
DESIGN


SHEET

E-601

Copyright © 2006 Miller Engineering Co.

○ **DETAIL NOTES**

1. PANEL HAS REVISED BREAKERS. REFER TO PANEL SCHEDULES FOR ADDITIONAL INFORMATION.

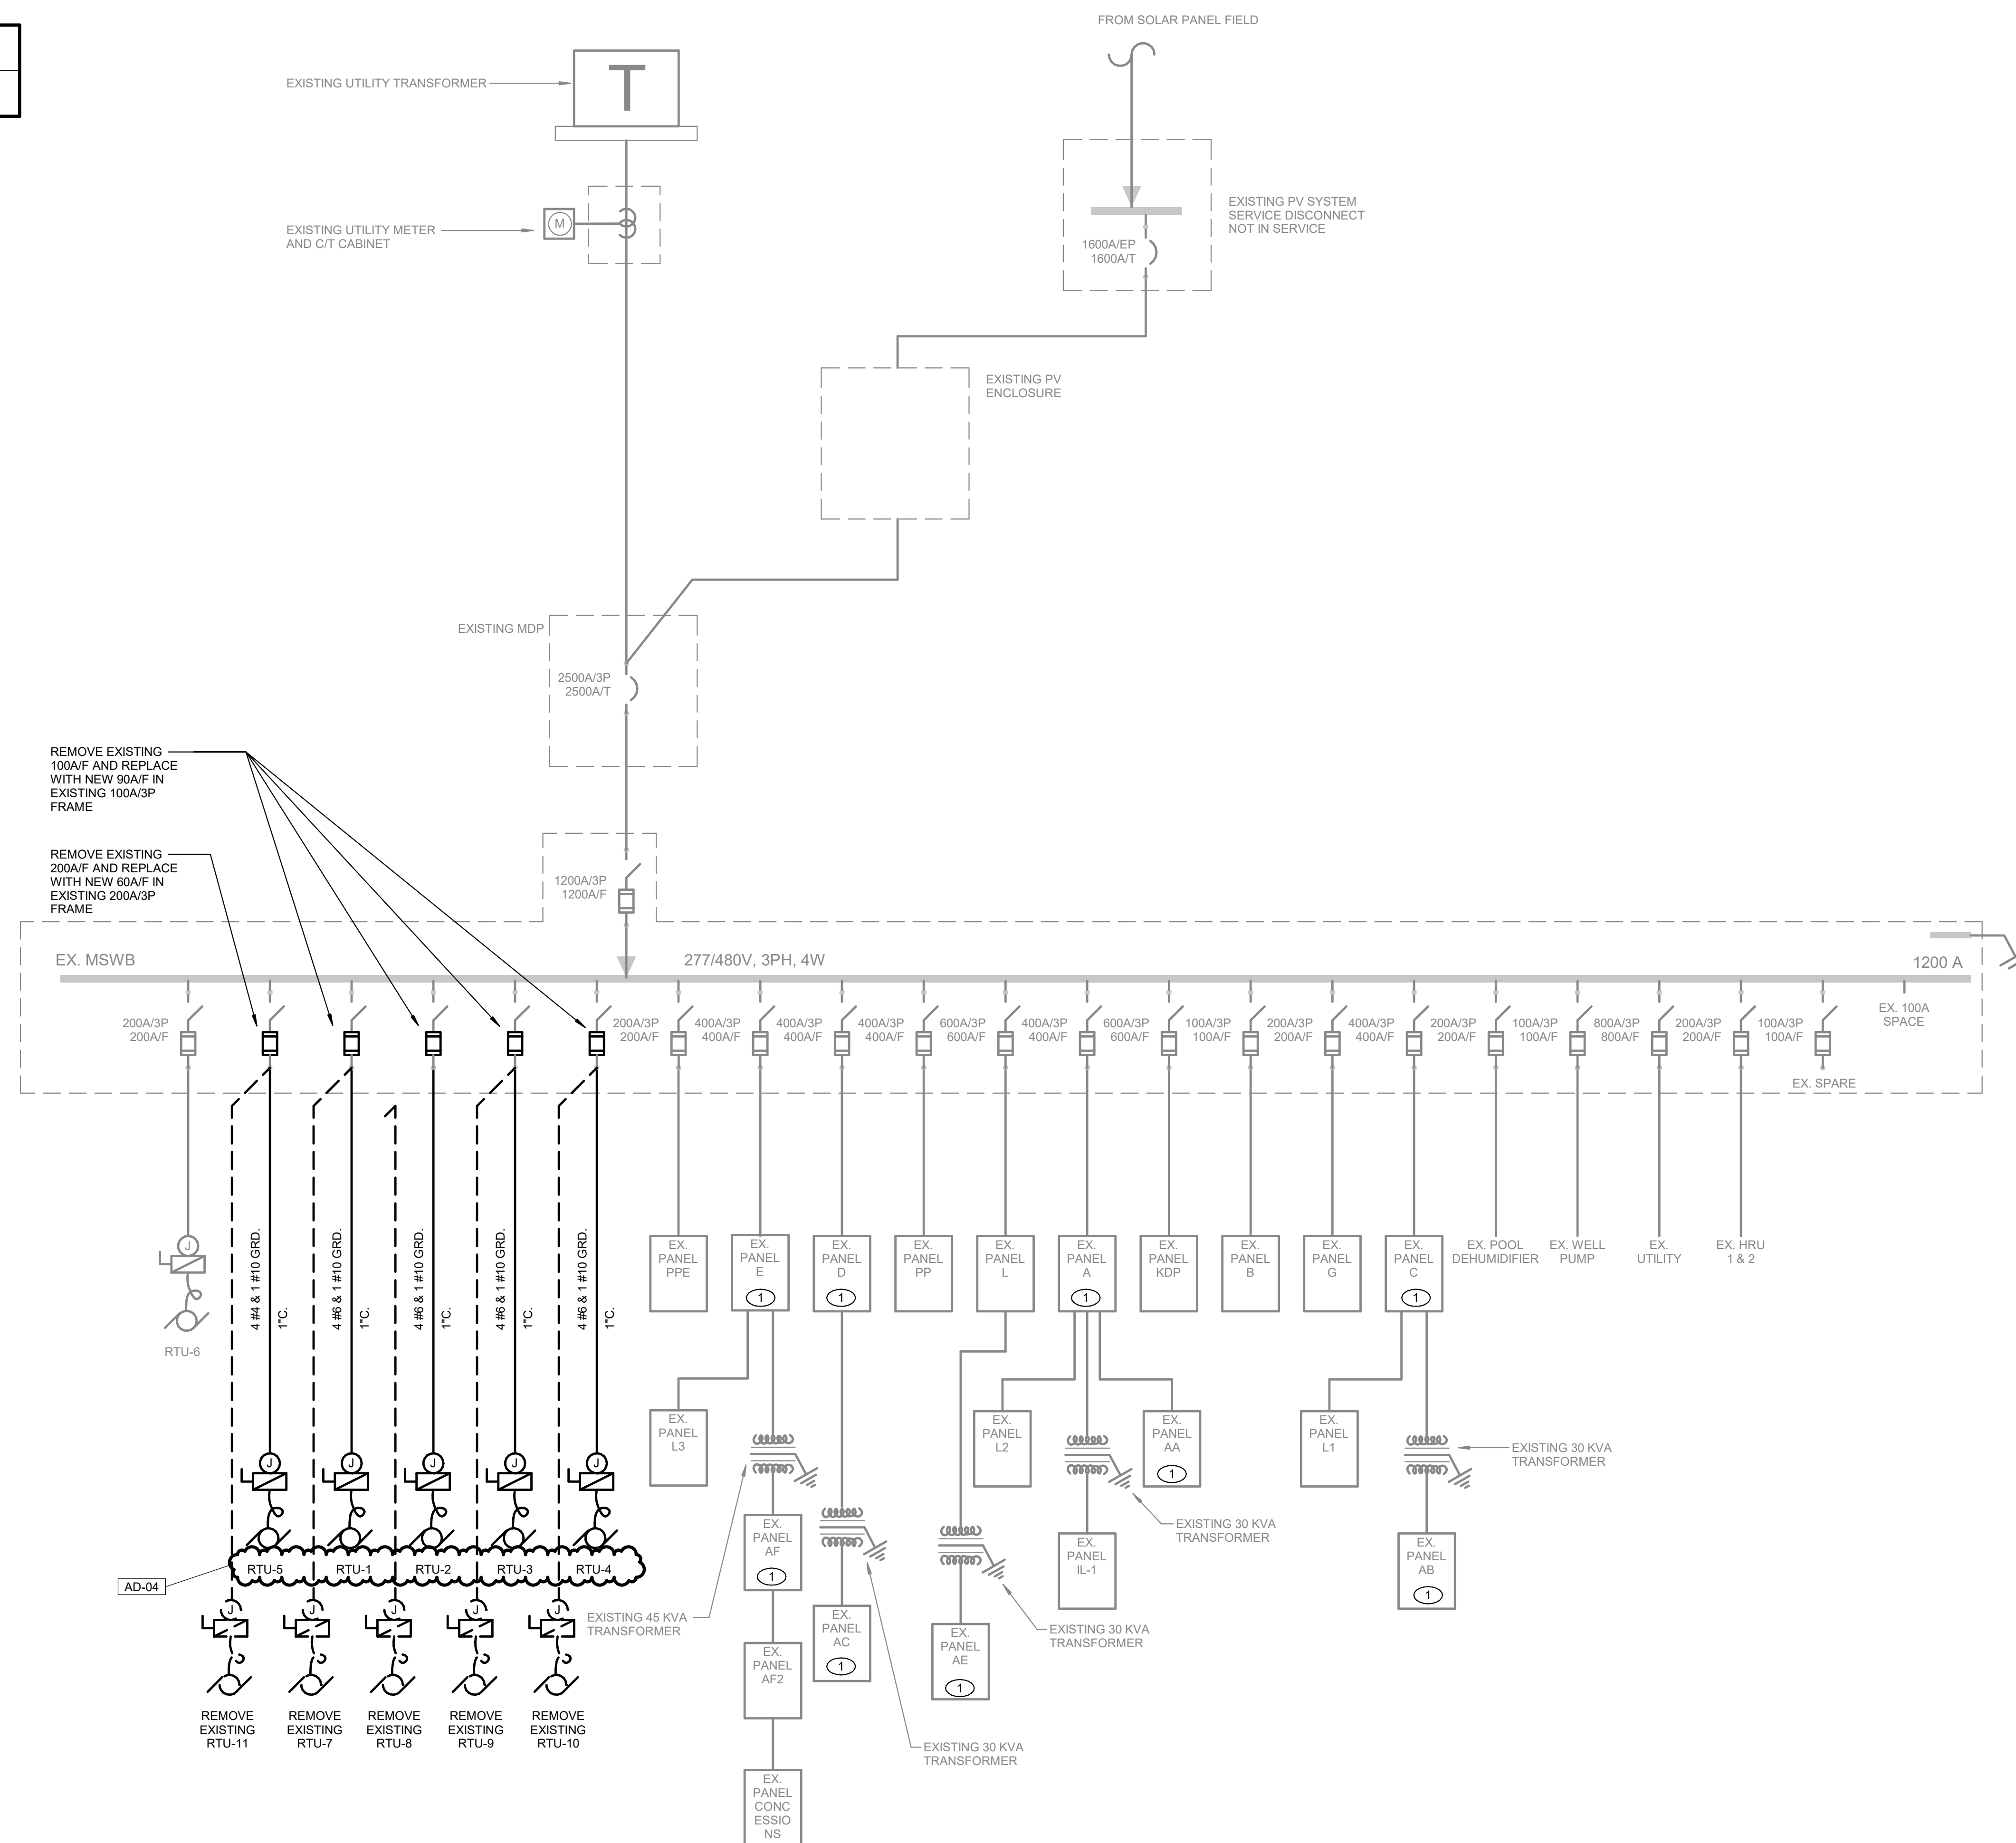

The diagram illustrates the fire alarm system architecture. At the center is the **EXISTING NOTIFIER FACP**. To its left, two **EXISTING ROOF-TOP UNIT**s are connected via **RT** (Roof Top) and **SD** (Sounder) terminals to a common bus. Below this, a line with **SD** and **RT** terminals connects to a series of **SD** and **RT** terminals, which then connect to a series of **SD** and **RT** terminals. To the right of the FACP, two **NEW ROOF-TOP UNIT**s are connected via **SD** and **RT** terminals to a common bus. Below this, a line with **SD** and **RT** terminals connects to a series of **SD** and **RT** terminals, which then connect to a series of **SD** and **RT** terminals. A note at the bottom right states: **REFER TO THE KEY PLAN ON SHEETS EP101 & EP102 FOR EXACT LOCATION IN UNIT D**.

NOTES:

1. THIS DIAGRAM IS SCHEMATIC ONLY AND DOES NOT SHOW ALL FIRE ALARM DEVICES, AIR HANDLING UNITS, ROOF-TOP UNITS OR FIRE PROTECTION DEVICES - REFER TO ALL PLANS AND SPECIFICATIONS FOR QUANTITIES, LOCATION, ACCEPTABLE MANUFACTURERS, ETC.
2. ELECTRICAL CONTRACTOR SHALL FURNISH DUCT SMOKE DETECTORS. MECHANICAL CONTRACTOR SHALL INSTALL DUCT SMOKE DETECTOR AND ELECTRICAL CONTRACTOR SHALL MAKE FINAL WIRING CONNECTIONS AS REQUIRED. REFER TO MECHANICAL DRAWINGS FOR EXACT LOCATIONS AND QUANTITIES OF DUCT SMOKE DETECTORS.
3. ELECTRICAL CONTRACTOR SHALL PROVIDE INTERLOCKING BETWEEN DUCT SMOKE DETECTORS, FIRE ALARM CONTROL PANEL, AIR HANDLING UNITS, ROOF-TOP UNITS, ANSUL SYSTEM AND FAN SHUT DOWN RELAYS SO THAT UPON ACTIVATION OF FIRE ALARM SYSTEM, ALL AIR HANDLING EQUIPMENT AND SMOKE/FIRE DAMPER SHALL SHUT DOWN. ALL AIR HANDLING EQUIPMENT SHALL START AUTOMATICALLY AND BE SEQUENTIALLY RESECUED BY THE FIRE ALARM SYSTEM.
4. AS PROVIDED ADDITIONAL PARTS, ACCESSORIES, CARDS, ETC. AS REQUIRED TO COMPLETE THE WORK, FIRE ALARM DEVICES SHALL BE CONNECTED TO THE FIRE ALARM POWER SUPPLY AND BATTERIES OF THE SYSTEM AND NOT BE CONNECTED TO NORMAL POWER.