

# ADDENDUM NO. 3

**September 24, 2026**

**Perry Meridian High School Phase 2 Renovations  
401 W. Meridian School Road  
Indianapolis, IN 46217**

**TO: ALL BIDDERS OF RECORD**

This Addendum forms a part of and modifies the Bidding Requirements, Contract Forms, Contract Conditions, the Specifications, and the Drawings dated August 21, 2026, by Lancer Associates Architecture. Acknowledge receipt of the Addendum in the space provided on the Bid Form. Failure to do so may subject the Bidder to disqualification.

This Addendum consists of Pages ADD 3-1, Lancer Associates Architecture Addendum No. 3, dated September 17, 2026, consisting of six (6) pages, and Addendum 3 Drawings: C-7.1, C-7.3, C-7.4, PF101, PP101, P-601, P-901, P-903, ED108, EP101, EP108, E-701, A202, A751, & A753

**A. SPECIFICATION SECTION 01 12 00 MULTIPLE CONTRACT SUMMARY**

**1. Paragraph 3.03 Bid Categories**

**A. Bid Category No. 2 – MASONRY**

Add the following Clarification:

6. Include selective demolition required to complete the scope of work identified within specification section 04 90 10 Masonry Restoration and exterior elevations. The general trades contractor shall include selective demolition for existing building façade openings for new construction.

**ADDENDUM NO. THREE**

**PROJECT: PERRY MERIDIAN HS PHASE 2**

**PROJECT NUMBER: 24173P**

**DATE OF ADDENDUM: September 17, 2026**



**THIS ADDENDUM FORMS A PART OF THE CONTRACT DOCUMENTS AND IS ISSUED IN ACCORDANCE WITH THE INSTRUCTIONS TO BIDDERS. ACKNOWLEDGE RECEIPT OF THIS ADDENDUM BY SIGNING THE ADDENDUM ACKNOWLEDGMENT SECTION OF THE BID FORM.**

**QUESTIONS & ANSWERS:**

1. **Q:** Panel 2RP-3(B) Feeder
  - a. Panel 2RP-3(B) (200A MLO, Storage 379) has no feeder shown on the one-line. What are the feeder and the source?
  - b. What is the conduit and conductor size?
  - c. E-602 shows the supply as "EX. 2RP-3." What size is the source breaker, and is there space for it in 2RP-3?
  - d. Or is 2RP-3(B) meant to be a feed-through or sub-feed section of 2RP-3?

**A:** Panel replaces existing sub panel of same name to add breaker space. See addendum 3 for additional information

2. **Q:** Kiln Receptacles, 3D Art 12EC

- a. The plans show NEMA 15-50R (3-phase) receptacles on 2-pole circuits 1RP-6-56,58 and 1RP-6-60,62. What are the kiln electrical requirements?
- b. Voltage and phase
- c. Receptacle configuration
- d. Breaker poles and size
- e. Number of kilns (two receptacles are shown)

**A:** 3-pole circuit correction in addendum 3.

**3. Q:** Short-Circuit / Coordination / Arc-Flash Study

- a. Is a short-circuit, coordination and arc-flash study required on this project?
- b. E-602 note E references section 26 05 74.99, which is not in the project manual. Please issue that section if it applies.
- c. If a study is required, what equipment does it cover: the new panels only, or also the existing MSB-1 and distribution upstream?

**A:** Required only for new equipment. Note E on E-602 to be removed in addendum 3.

**4. Q:** Motor Controllers

- a. The mechanical and electrical schedules conflict on EF-A2, EF-A3, EF-B1 and EF-K1. Which schedule governs?
- b. The mechanical schedule lists combination magnetic starter/BMS. E-601 shows HP-rated toggle switches with overloads.
- c. Who furnishes the starters?
- d. Who does the BMS interlock and control wiring?

**A:** Motor starters furnished and installed by division 26. Control wiring and BMS programming by division 23.

**5. Q:** RTU-G1 / RTU-G2 Power

- a. RTU-G1 and RTU-G2 (460V/3Ø, MCA 20.9, MOP 30) need power. What is the source?
- b. Is existing panel 2PP5 480V, and does it have space for (2) new 30A/3P breakers?
- c. Who furnishes the disconnects?
- d. Do these units replace existing equipment? If so, can the existing feeders be reused?

**A:** Refer to electrical roof plan ER103.

**6. Q:** AHU-D2 and AHU-F2 VFD Circuits

- a. The new AHU-D2 and AHU-F2 reuse the existing circuits from 2PP3 and 2PP4. Are the existing breakers and conductors adequate for the new units?
- b. AHU-F2 (15 HP) lists MOCP 40A. AHU-D2 lists MOCP 25A.

- c. If the existing breakers and conductors are not adequate, what are the new sizes?
- d. Where do the VFDs mount?

**A:** Units are direct replacements. Existing circuits are to be re-used per drawings. Mount VFDs at locations where existing VFDs are replaced.

**7. Q:** Access Control Scope

- a. Section 28 13 00 Access Control is listed under BC 11, but the T000 responsibility matrix gives the full access control scope to the owner's vendor. Where is the BC 11 scope boundary?

**A:** The owner and bidder responsibilities are listed in the responsibility matrix

**8. Q:** Replacement Panels 1RP-15, 1RP-16 and 1LP-16

- a. Are the existing feeders to replacement panels 1RP-15, 1RP-16 and 1LP-16 reused, or replaced?
- b. 1RP-16 is scheduled as 225A MLO, but the one-line shows an F100 feeder from T-5. Which is correct?
- c. Where are MSB-1 and Distribution Panel T-5?

**A:** Replace feeders per E-701. Feeder for 1RP-16 corrected to 200A in addendum 3. MSB-1 in main electrical room unit B (refer to addendum 3). T-5 located on mezzanine deck above panels, refer to ER103.

**9. Q:** Surge Protection

Section 26 24 16 calls for integral SPD on "indicated panelboards," but none are indicated on E-602. Which panelboards need integral SPD?

**A:** No surge protection required for panelboards on this project.

**10. Q:** "1RP-2-SUB" Reference

- a. E-701 note 3 relocates circuits to "1RP-2-SUB." Is this panel 1RP-2A?

**A:** Correct. Note 3 reference updated in addendum 3.

**11. Q:** MC Cable

Can MC cable be used for 20A branch circuits concealed in walls and above accessible ceilings?

**A:** No

**12. Q:** Site

Please provide a section of the flared ADA ramp indicated by Plan Note 7 on C-6.3

**A:** there are no flared ADA ramps in Phase 2 and the note they are referencing is for Phase 1 work only.

**13. Q:** Specs list 1 and 2 tier lockers but plan page A753 shows a “Z” tier locker. Please confirm if the 2 tier are actually Z tier lockers.

**A:** Provide Z-tier lockers in the pool locker rooms, provide 2 tier in the other locker rooms

**14. Q:** Specs list the material must meet the NFPA 286 standard for Fire Rating. This will be significantly more expensive and is typically not needed unless mandated by local Fire Code. Please confirm if this is intended/required.

**A:** No need for fire NFPA 286 Fire Rating on this project

**15. Q:** Specs list Aluminum hinges. Currently Stainless Steel hinges are less costly and are also a superior component. Please let me know if SS hinges would be acceptable.

**A:** It is acceptable to use stainless steel hinges in the regular locker rooms. Provide aluminum in the pool locker rooms

**16. Q:** *Will brick ties and crack stitching apply to whole wall (all 3 sections), per structural drawings or will all brick be removed and replaced per architectural drawings, or will it be a combination of both methods?*

**A:** The repairs noted on the structural drawings apply to all three walls.

**17. Q:** *Are photos of the wall area available or do we need to schedule a jobsite visit to be able to see and photograph the wall?*

**A:** Site walk is highly recommended.

### **SPECIFICATIONS:**

1. 238126 – SPLIT SYSTEM AIR CONDITIONERS
  - a. Add paragraph 2.1.A.4 to read as follows.  
“4. Daikin.”
2. 238239.13 – CABINET UNIT HEATERS
  - a. Add paragraph 2.1.A.10 to read as follows.  
“4. Daikin.”

### **DRAWINGS:**

1. Sheet C-7.1

- Spot elevations for the proposed sidewalk have been updated.
- 2. Sheet C-7.3
  - Spot elevations for the proposed sidewalk have been updated.
- 3. Sheet C-7.4
  - Spot elevations for the proposed sidewalk have been updated
- 3. PF101 – plumbing foundation plan – unit A
  - a. Delete and replace in its entirety
- 4. PP101 – plumbing first floor plan – unit a
  - a. Delete and replace in its entirety
- 5. P-601 – plumbing schedules and details
  - a. Delete and replace in its entirety
- 6. P-901 – plumbing domestic water isometrics
  - a. Delete and replace in its entirety
- 7. P-903 – plumbing waste and vent isometrics
  - a. Delete and replace in its entirety
- 8. ED108 – electrical demolition second floor plan – unit F
  - a. Delete and replace in its entirety
- 9. EP101 – electrical power & systems first floor plan – unit A
  - a. Delete and replace in its entirety
- 10. EP108 – electrical power & systems second floor plan – unit F
  - a. Delete and replace in its entirety
- 11. E-701 – electrical one-line diagrams
  - a. Delete and replace in its entirety
- 12. Sheet A202
  - a. On Detail 4/A202 the amount of brick to be replaced has been reduced
- 13. Sheet A751
  - a. Added acoustical wall panel fabric finish to 1/A751, 2/A751, 4/A751, and 5/A751.
- 14. Sheet A753
  - a. Added acoustical wall panel fabric finish to 2/A753, 3/A753, 5/A753, and 6/A753

**Attachments:**

(Specs)

(CIVIL Drawings)  
C-7.1, C-7.3, C-7.4

(STRUCTURAL Drawings)

(ARCHITECTURE Drawings)  
A202, A751, A753



Project # 24173P, PERRY MERIDIAN HS  
PHASE 1


(PLUMBING Drawings)  
PF101, PP101, P601, P901, P903

(MECHANICAL Drawings)

(ELECTRICAL Drawings)  
ED101, EP101, EP108, E701

(FOOD SERVICE Drawings)

END OF ADDENDUM NO. THREE

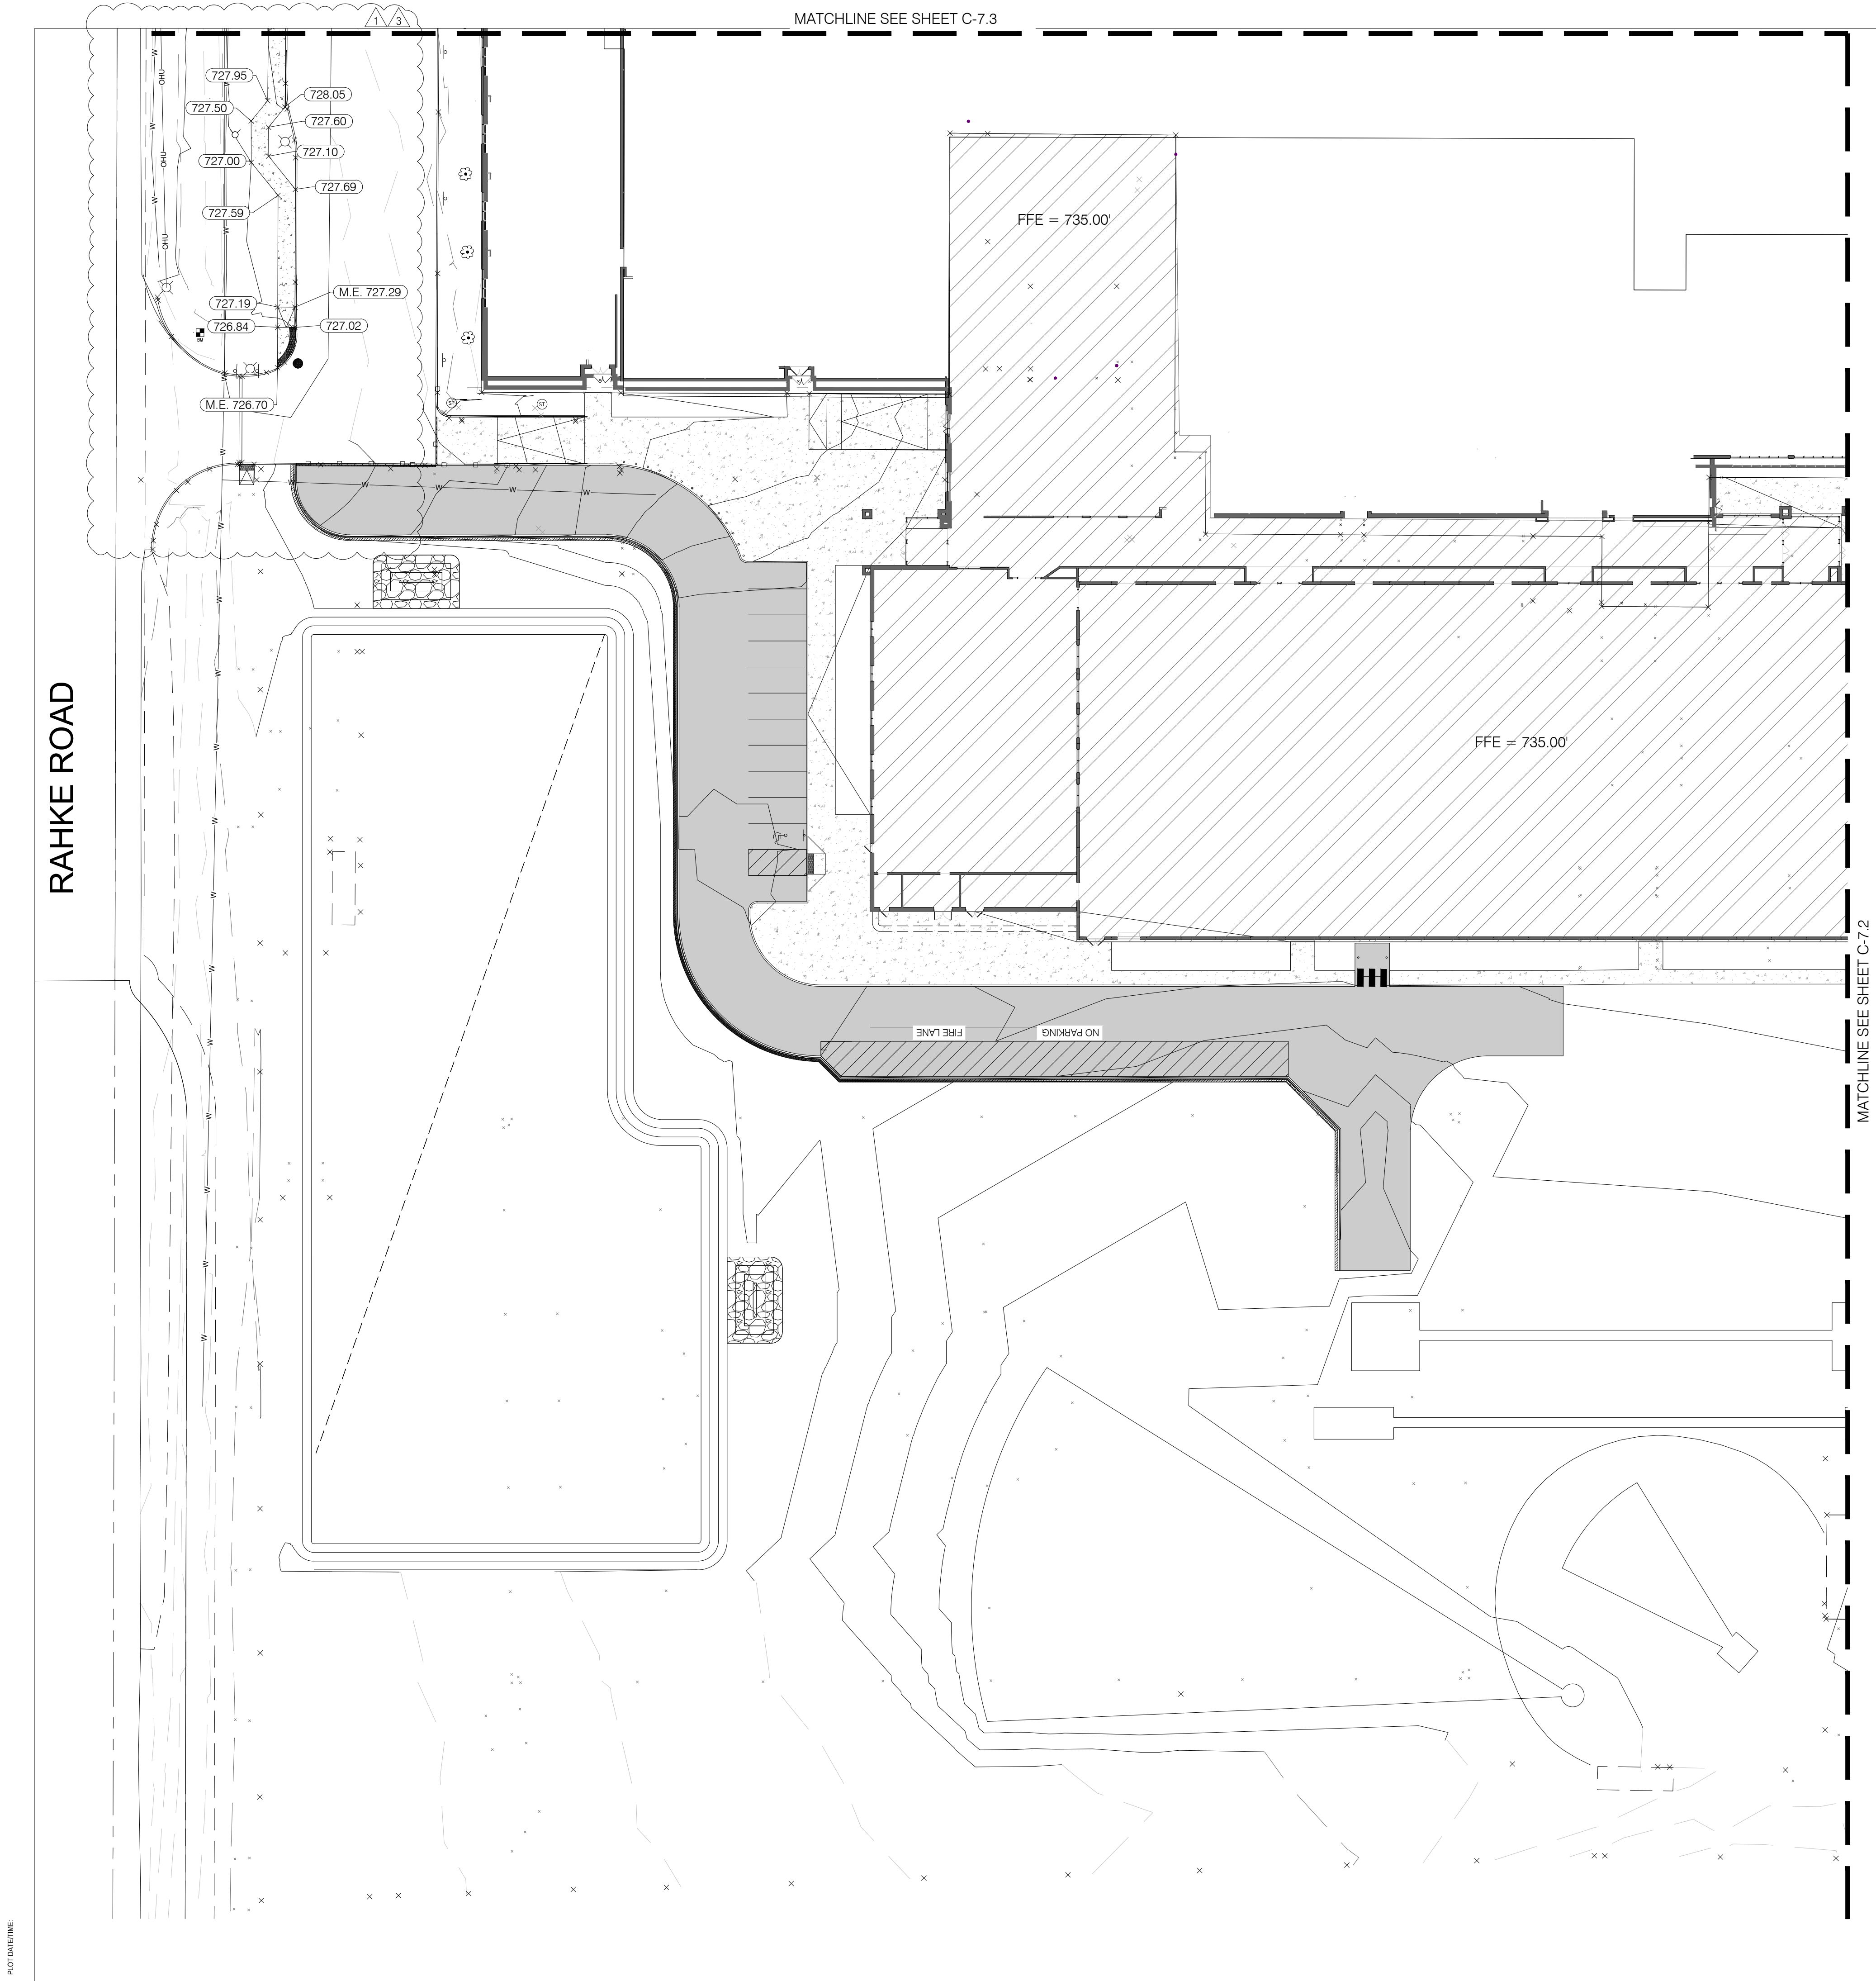

GRADING PLAN LEGEND:

|                                             |                            |
|---------------------------------------------|----------------------------|
| EXISTING CONTOUR                            | ---                        |
| PROPOSED CONTOUR                            | ---                        |
| PROPOSED GRADE SPOT ELEVATION               | XXX                        |
| TOP OF CURB / BOTTOM OF CURB SPOT ELEVATION | T.C. XXX.XX<br>B.C. XXX.XX |
| FLOW LINE SPOT ELEVATION                    | F.L. XXX.XX                |
| MATCH EXISTING SPOT ELEVATION               | M.E. XXX.XX                |
| TOP OF WALL SPOT ELEVATION                  | T.W. XXX.XX                |
| BOTTOM OF WALL SPOT ELEVATION               | B.W. XXX.XX                |
| FINISHED FLOOR SPOT ELEVATION               | F.F. XXX.XX                |
| RIM ELEVATION                               | R. XXX.XX                  |
| INVERT ELEVATION                            | INV. XXX.XX                |
| LIMITS OF DISTURBANCE                       | LOD                        |

LANCER ASSOCIATES ARCHITECTURE

145 NORTH EAST STREET  
INDIANAPOLIS, IN 46204

JQOL  
QUALITY OF LIFE

creative engineering solutions  
mechanical • electrical • plumbing  
402 N. Capitol Ave., Suite 200  
Indianapolis, IN 46204 • 463-231-9799  
www.jqolinc.com

PERRY TOWNSHIP SCHOOLS  
PERRY MERIDIAN HIGH SCHOOL  
401 W. MERIDIAN SCHOOL ROAD  
INDIANAPOLIS, IN 46217

DANIEL J. O'TOOLE  
REGISTERED  
No. 10200269  
STATE OF INDIANA  
PROFESSIONAL ENGINEER

REVISIONS:

| # | DATE     | DESC.       |
|---|----------|-------------|
| 1 | 09/11/26 | ADDENDUM #1 |
| 3 | 09/23/26 | ADDENDUM #3 |

100% CONSTRUCTION DOCUMENTS


PROJECT: 2025.148  
DATE: 09/23/2026  
DRAWN BY: AKD

GRADING PLAN

C-7.1

GRAPHIC SCALE  
0' 30' 60' 90'  
(IN FEET)

TRUE NORTH

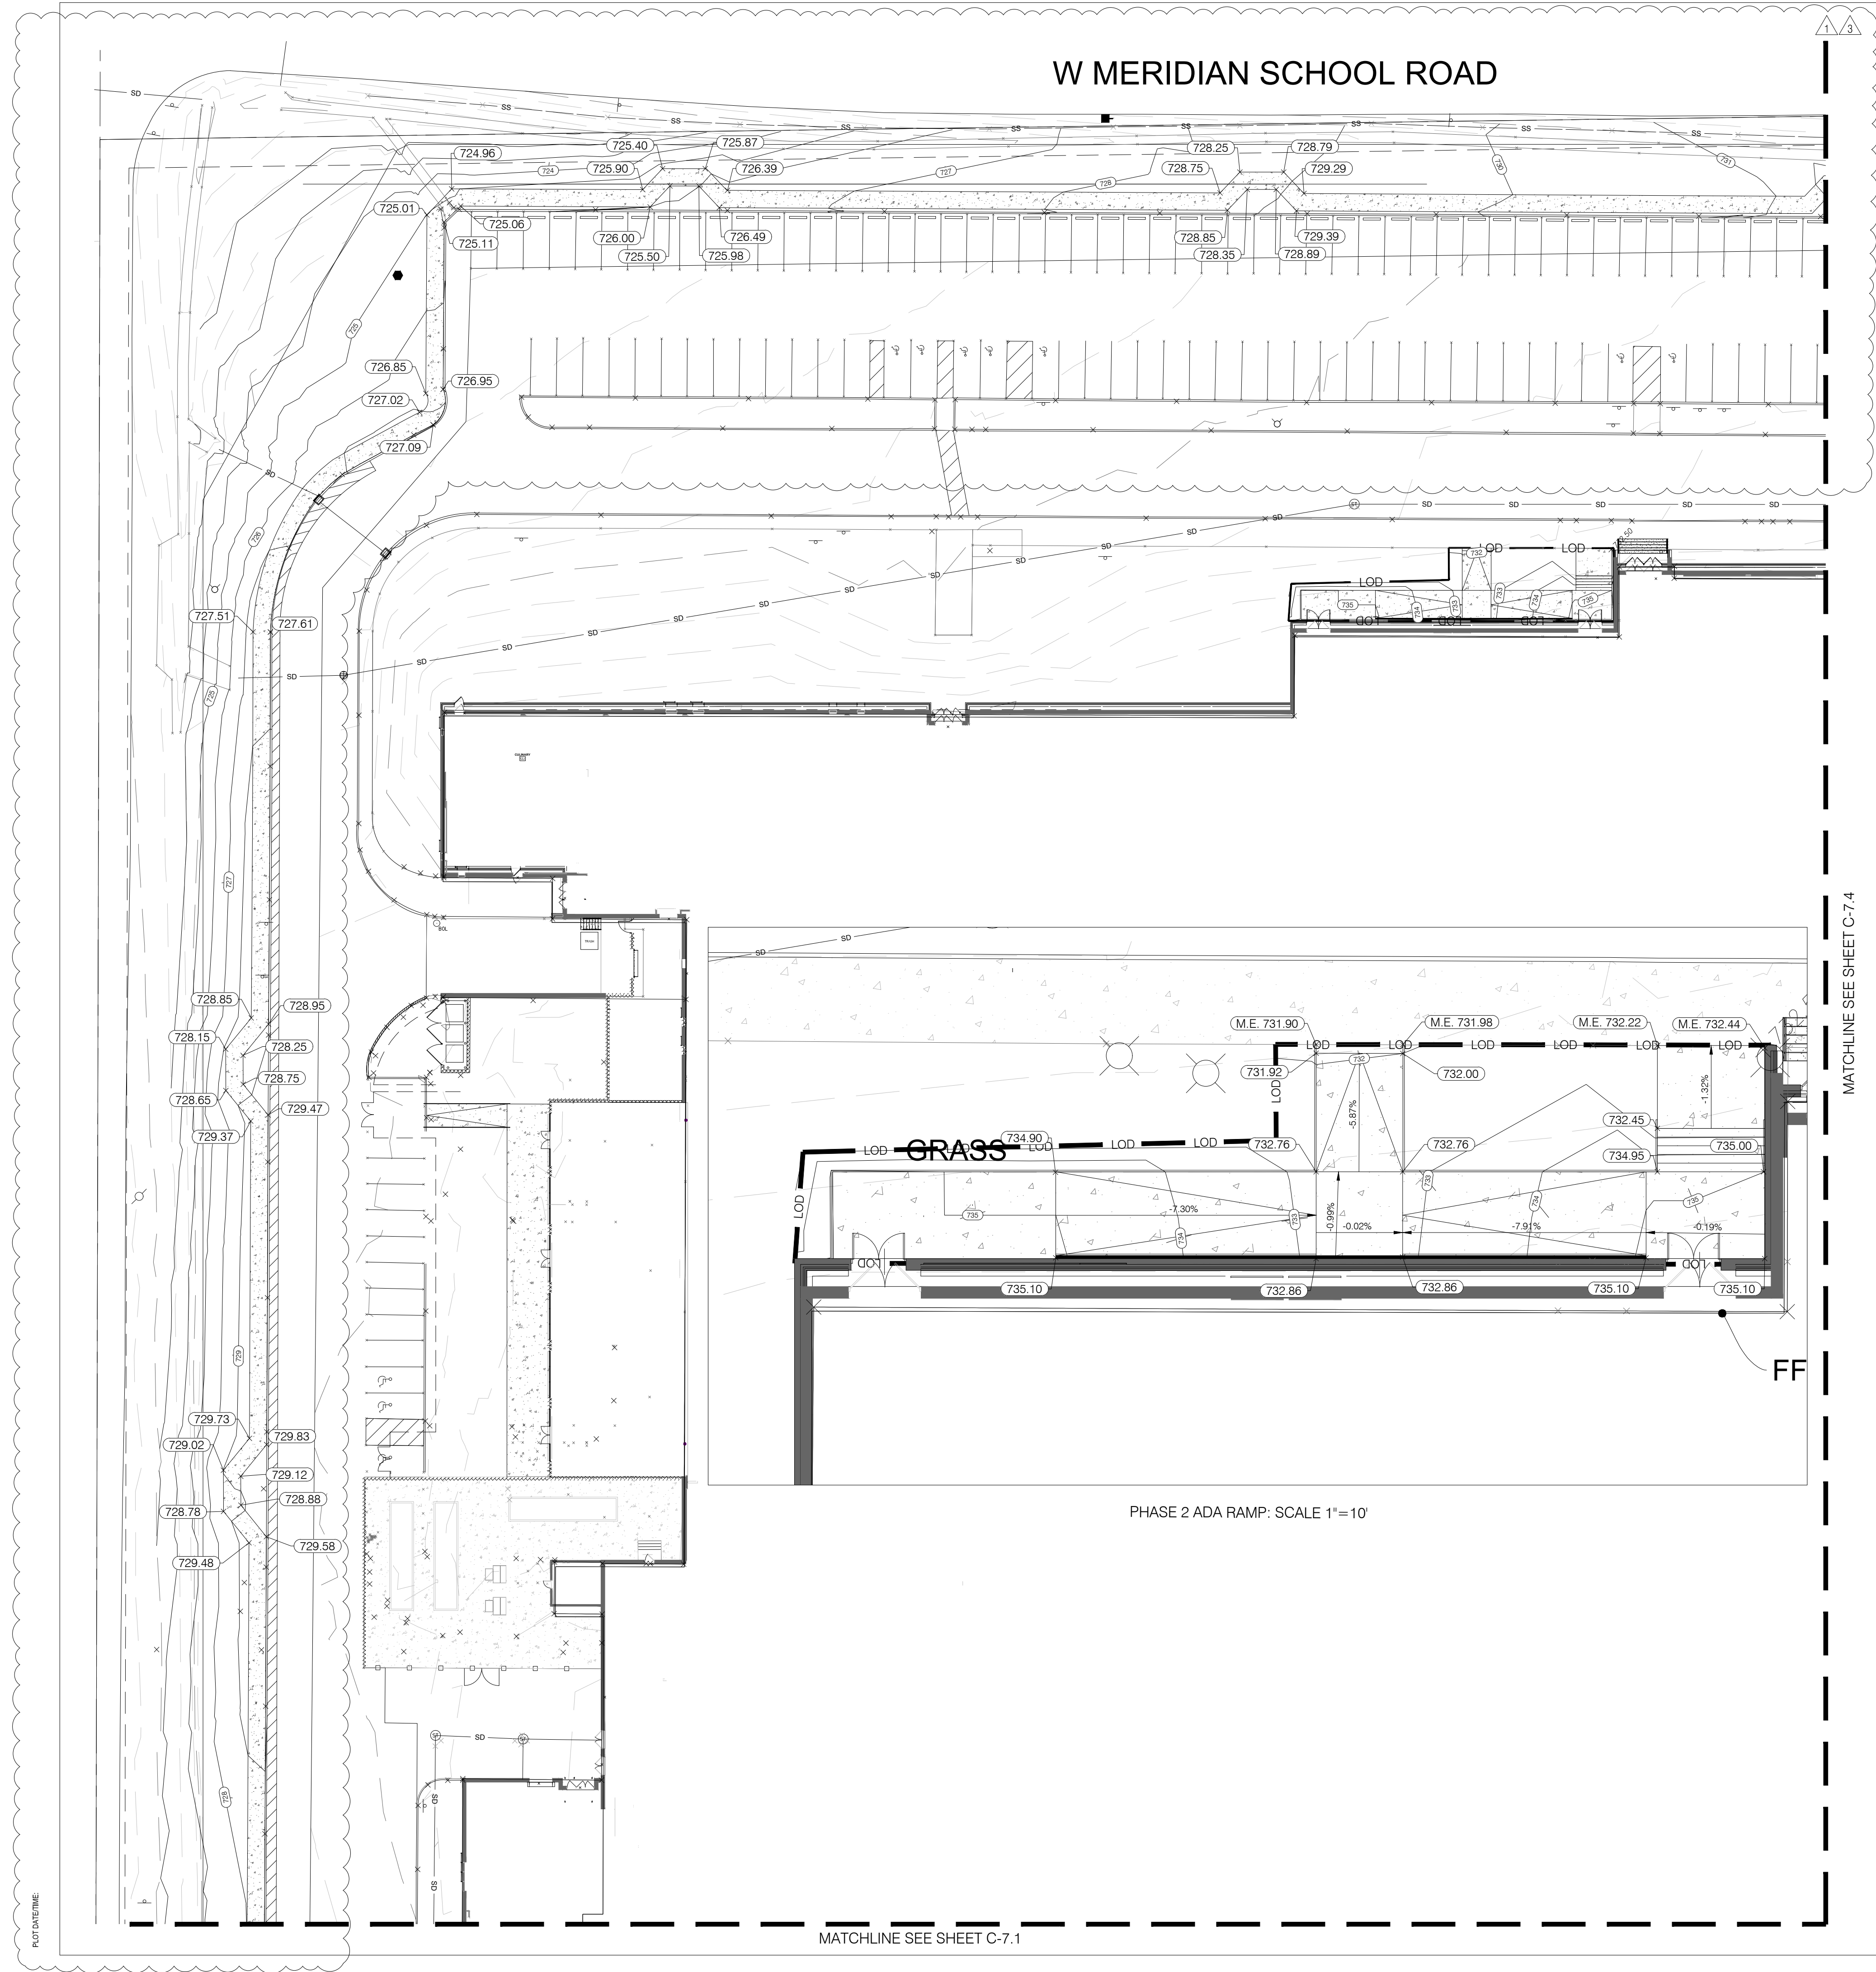

GRADING PLAN LEGEND:

- EXISTING CONTOUR
- PROPOSED CONTOUR
- PROPOSED GRADE SPOT ELEVATION
- TOP OF CURB / BOTTOM OF CURB SPOT ELEVATION
- FLOW LINE SPOT ELEVATION
- MATCH EXISTING SPOT ELEVATION
- TOP OF WALL SPOT ELEVATION
- BOTTOM OF WALL SPOT ELEVATION
- FINISHED FLOOR SPOT ELEVATION
- RIM ELEVATION
- INVERT ELEVATION
- LIMITS OF DISTURBANCE


| # | DATE     | DESC.       |
|---|----------|-------------|
| 1 | 09/11/26 | ADDENDUM #1 |
| 3 | 09/23/26 | ADDENDUM #3 |

100% CONSTRUCTION DOCUMENTS

PROJECT: 2025.148  
DATE: 09/23/2026  
DRAWN BY: AKD

GRADING PLAN

PERRY TOWNSHIP SCHOOLS  
PERRY MERIDIAN HIGH SCHOOL  
401 W. MERIDIAN SCHOOL ROAD  
INDIANAPOLIS, IN 46217

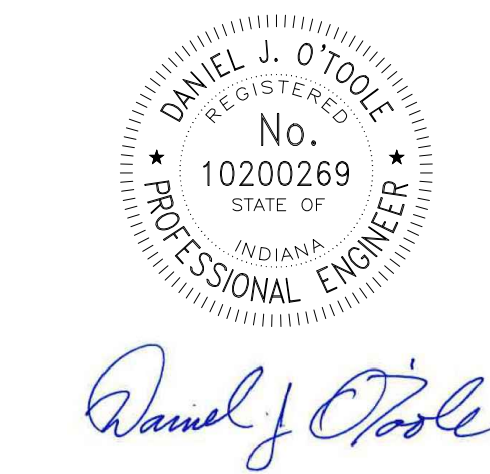

REVISIONS:

| # | DATE     | DESC.       |
|---|----------|-------------|
| 1 | 09/11/26 | ADDENDUM #1 |
| 3 | 09/23/26 | ADDENDUM #3 |

100% CONSTRUCTION DOCUMENTS




|           |            |
|-----------|------------|
| PROJECT:  | 2025.148   |
| DATE:     | 09/23/2026 |
| DRAWN BY: | AKD        |


GRADING PLAN

C-7.4

GRADING PLAN LEGEND:

- EXISTING CONTOUR  
PROPOSED CONTOUR  
PROPOSED GRADE SPOT ELEVATION  
TOP OF CURB / BOTTOM OF CURB SPOT ELEVATION  
FLOW LINE SPOT ELEVATION  
MATCH EXISTING SPOT ELEVATION  
TOP OF WALL SPOT ELEVATION  
BOTTOM OF WALL SPOT ELEVATION  
FINISHED FLOOR SPOT ELEVATION  
RIM ELEVATION  
INVERT ELEVATION  
LIMITS OF DISTURBANCE

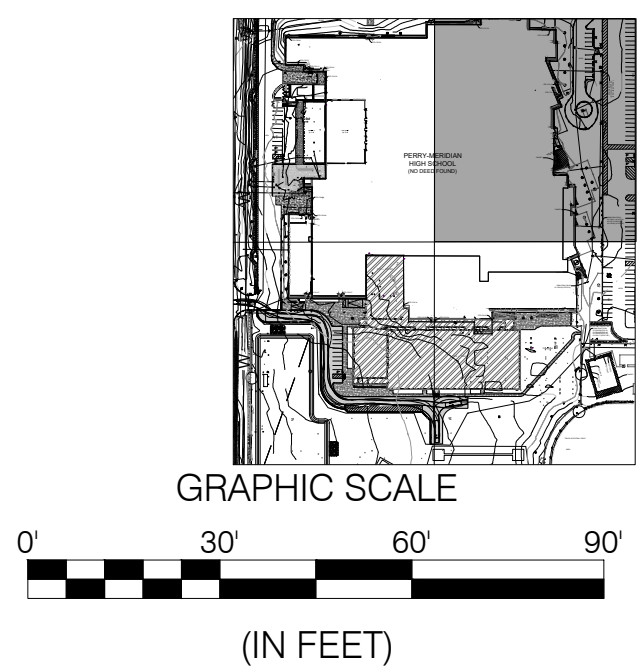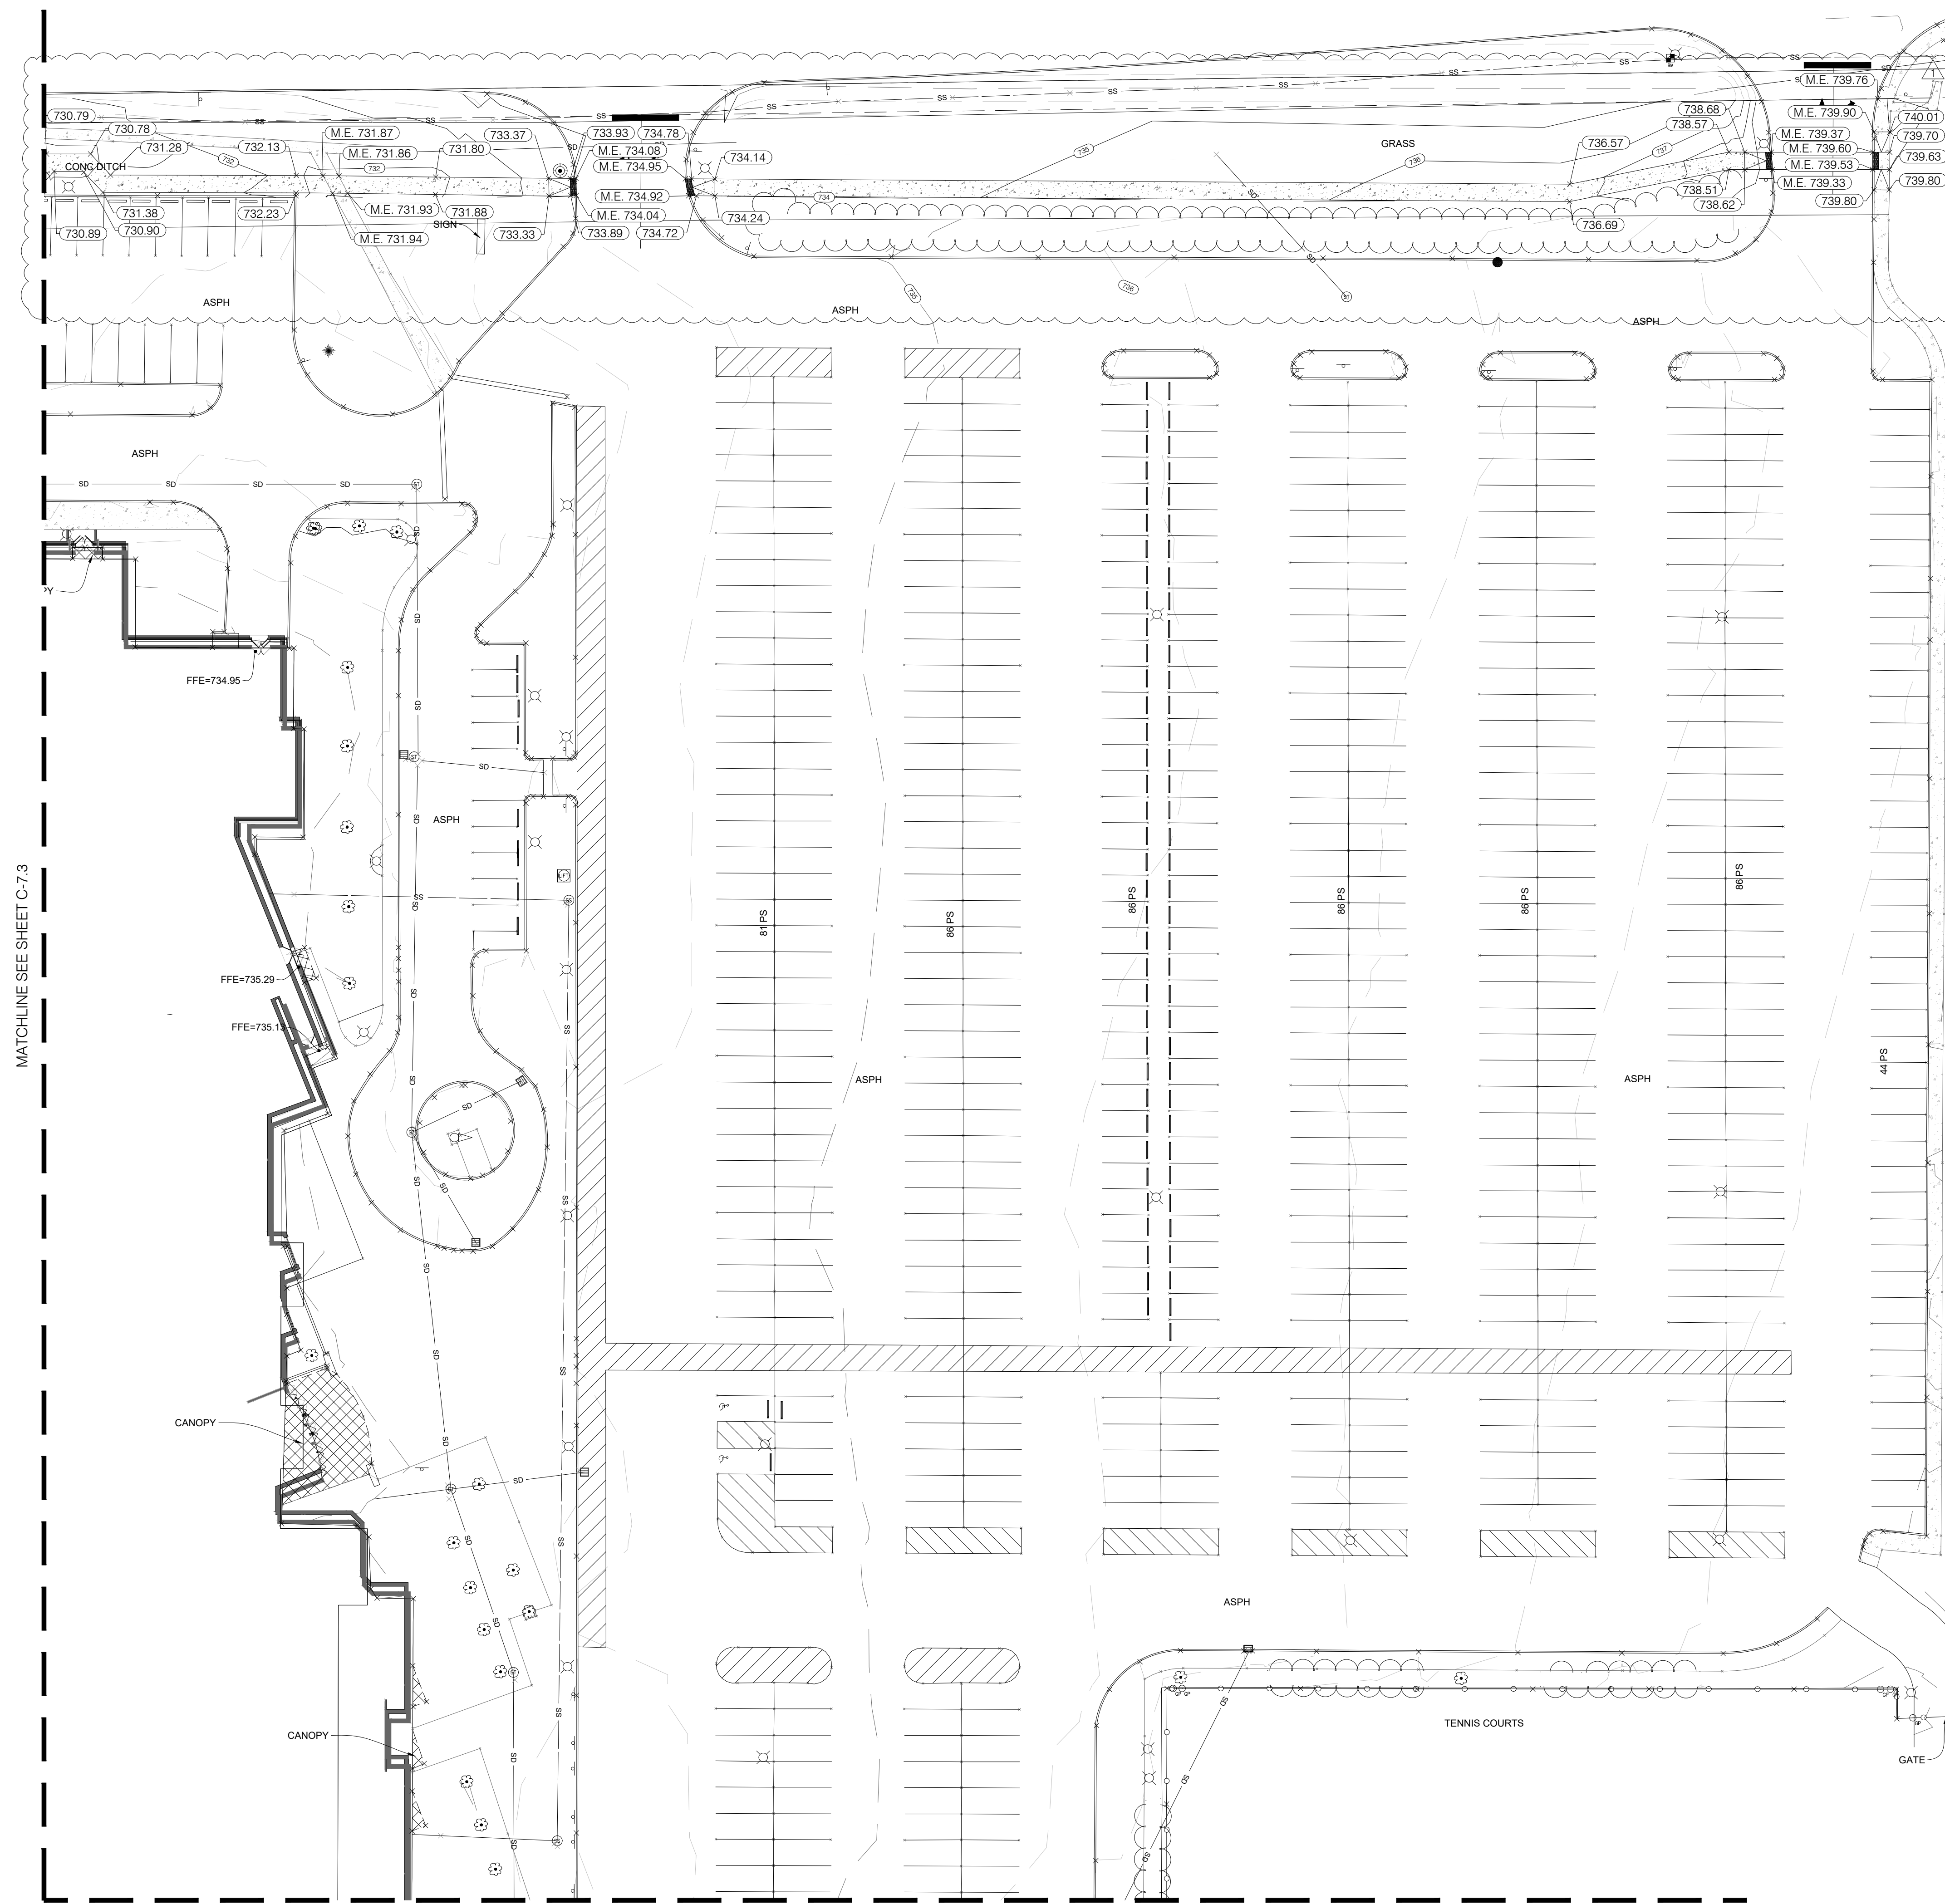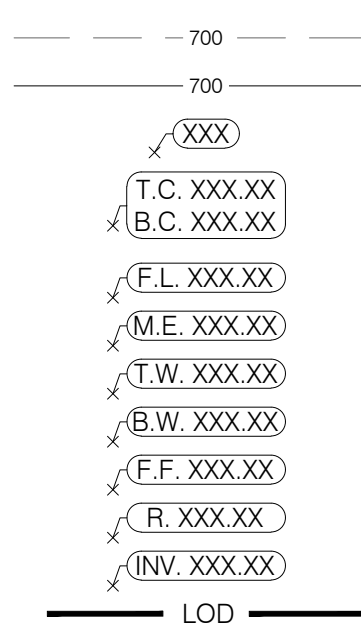

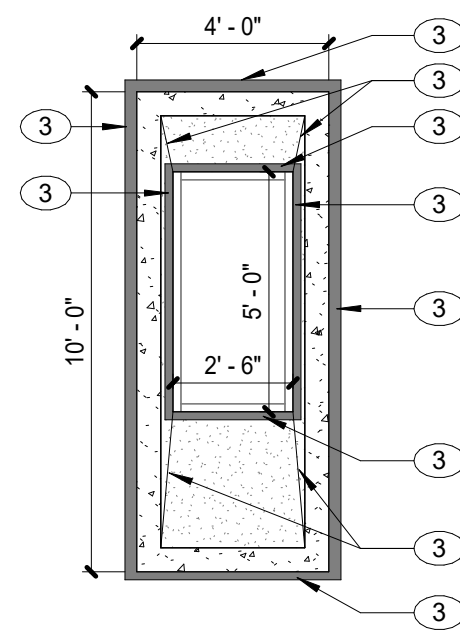


7 ENLARGED WINDOW DETAIL, TYP.  
SCALE: 1/4" = 1'-0"

### ELEVATION NOTES - EXTERIOR


- 1 REPLACE DAMAGED BRICK TO MATCH EXISTING. FIELD VERIFY
- 2 REPAIR DAMAGED MORTAR TO MATCH EXISTING. FIELD VERIFY
- 3 REPLACE CAULK CONTROL JOINT. FIELD VERIFY
- 4 CLEAN RUST ON METAL SOFFIT. PREP SURFACE, APPLY NEW PAINT TO MATCH EXISTING. FIELD VERIFY
- 5 DEMO EXISTING METAL PANEL. PATCH, CLEAN, AND ADD NEW METAL PANEL TO MATCH EXISTING. FIELD VERIFY
- 6 PATCH, CLEAN, AND PREP CONCRETE PANEL FOR REPAIR. APPLY NEW CONCRETE TO MATCH EXISTING. REFER TO SPEC SECTION 03 01 00 CONCRETE REHABILITATION.
- 7 REPLACE CAULK JOINT. FIELD VERIFY
- 8 INFILL EXISTING WINDOW OPENING. MATCH EXISTING BRICK
- 9 REMOVE EXISTING BRICK FACADE AND REPLACE WITH NEW BRICK TO MATCH EXISTING. SEE STRUCTURAL

### GENERAL NOTES - EXTERIOR ELEVATIONS

A. REPLACE ALL CAULK CONTROL JOINTS AT BRICK AND PRECAST PANELS, FIELD VERIFY.

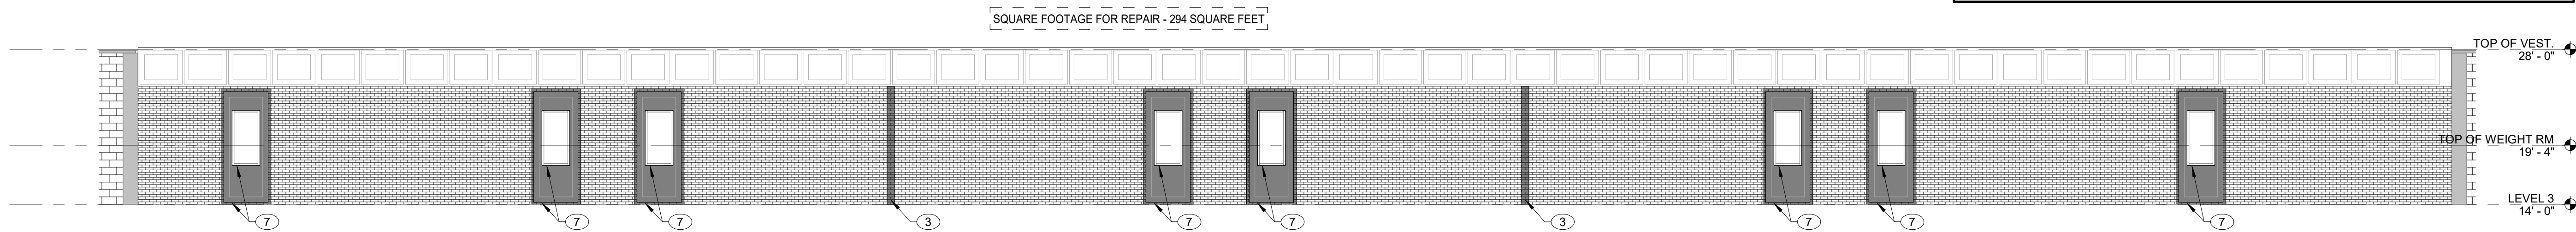


6 EXTERIOR ELEVATION - SECOND FLOOR EAST WALL  
SCALE: 1/8" = 1'-0" REF. 1 / A102D

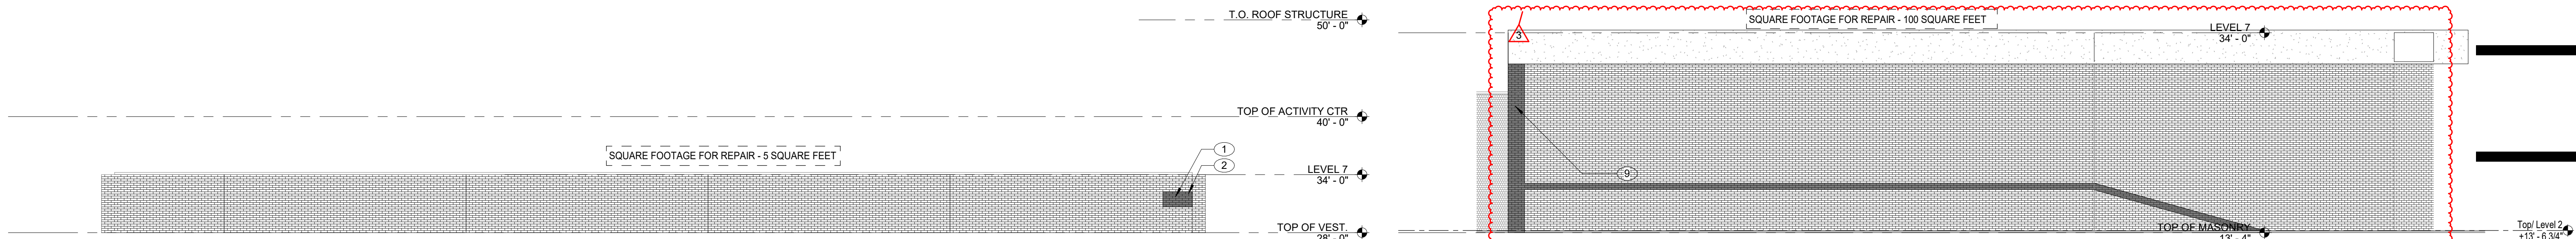


5 EXTERIOR ELEVATION - SOUTH GYM - NORTH WALL  
SCALE: 1/8" = 1'-0" REF. 1 / A141


4 EXTERIOR ELEVATION - AUD. SOUTH WALL  
SCALE: 1/8" = 1'-0" REF. 1 / A102D

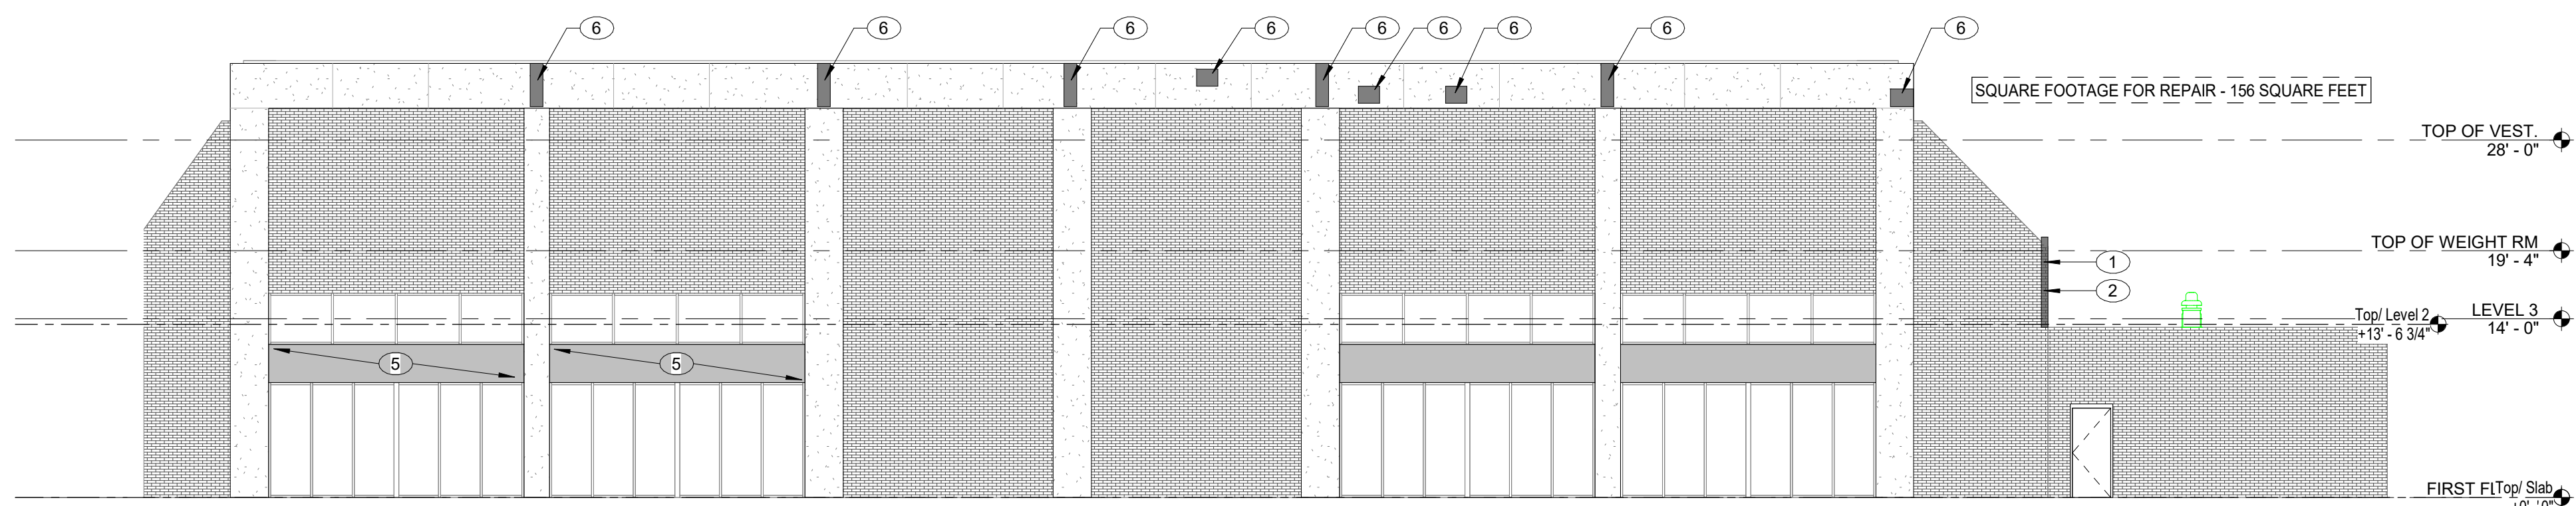

3 EXTERIOR ELEVATION - SOUTH  
SCALE: 1" = 10'-0" REF. 1 / A101K

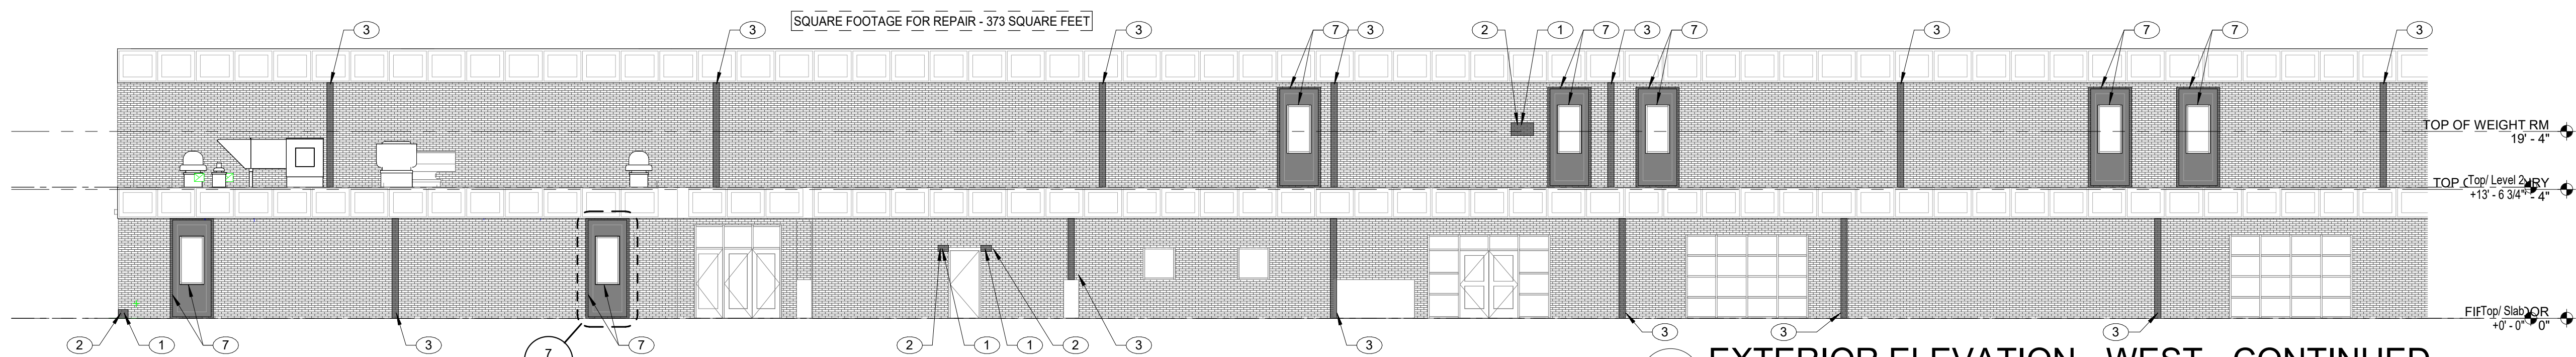

2 EXTERIOR ELEVATION - WEST - CONTINUED  
SCALE: 1" = 10'-0" REF. 1 / A101A

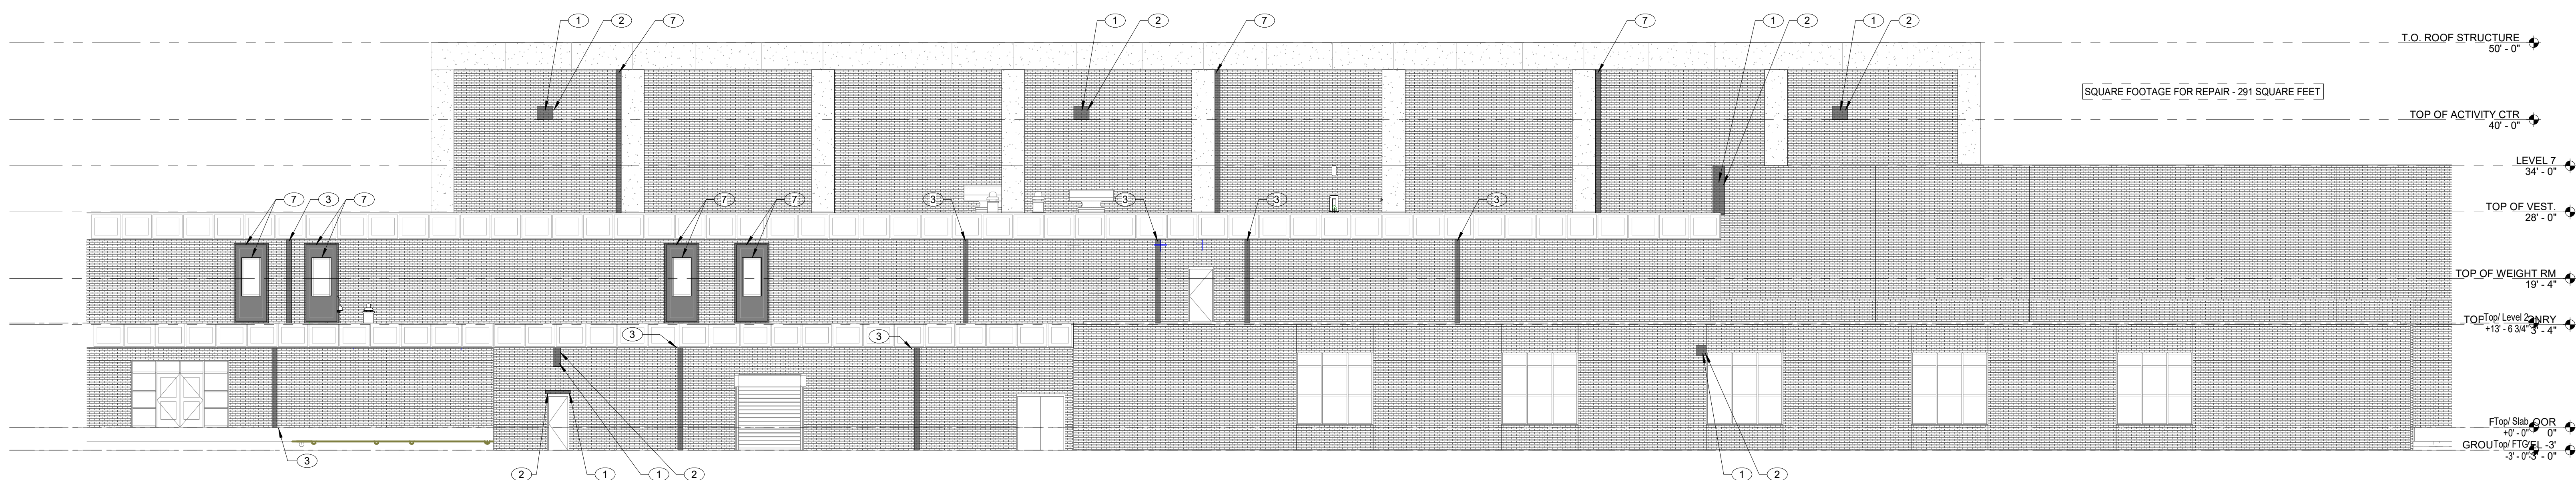

1 EXTERIOR ELEVATION - WEST  
SCALE: 1" = 10'-0" REF. 1 / A101B

PERRY TOWNSHIP SCHOOLS

PERRY MERIDIAN HS PHASE II RENO (VOL 2)

401 W MERIDIAN SCHOOL RD,  
INDIANAPOLIS, IN 46217




| # | Date       | Desc.       |
|---|------------|-------------|
| 1 | 09-11-2026 | Adendum 001 |
| 2 | 09-21-2026 | Adendum 002 |
| 3 | 09-23-2026 | Adendum 003 |

100% CONSTRUCTION DOCUMENTS


PROJECT: #24173P  
DATE: 09-21-2026  
DRAWN BY: Author

EXTERIOR ELEVATIONS


A202

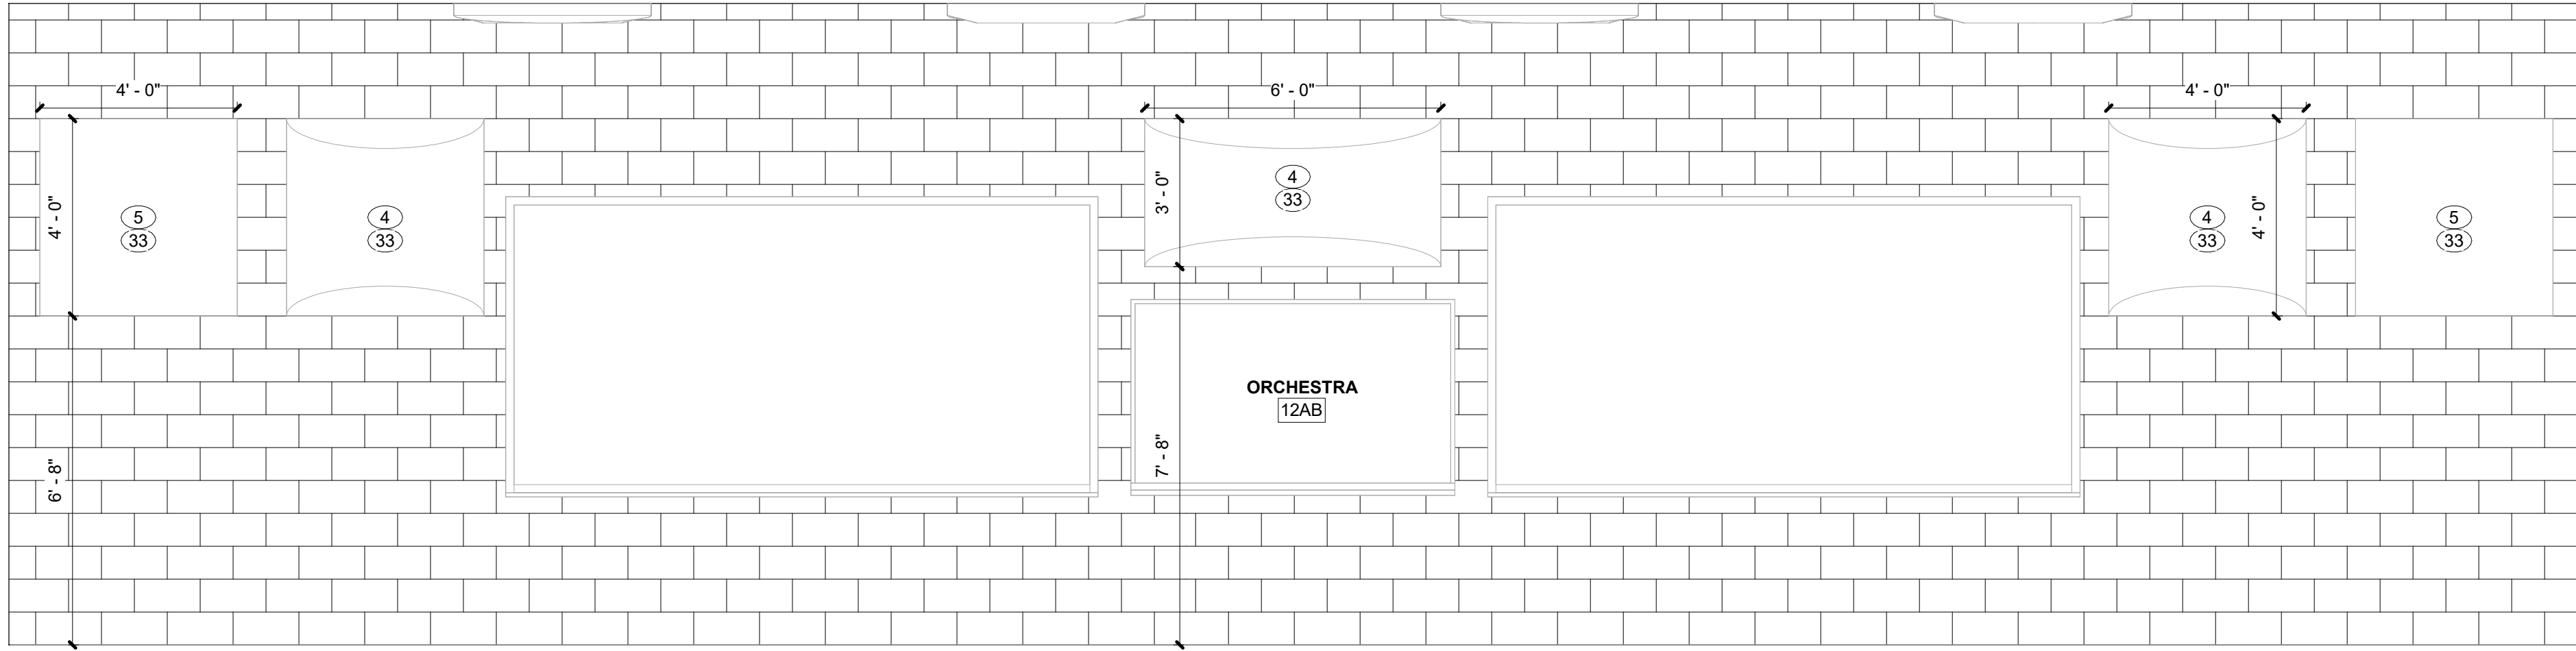


9 INT. ELEV. - ORCHESTRA 12AB W  
SCALE: 3/8" = 1'-0" REF. 1 / A721D

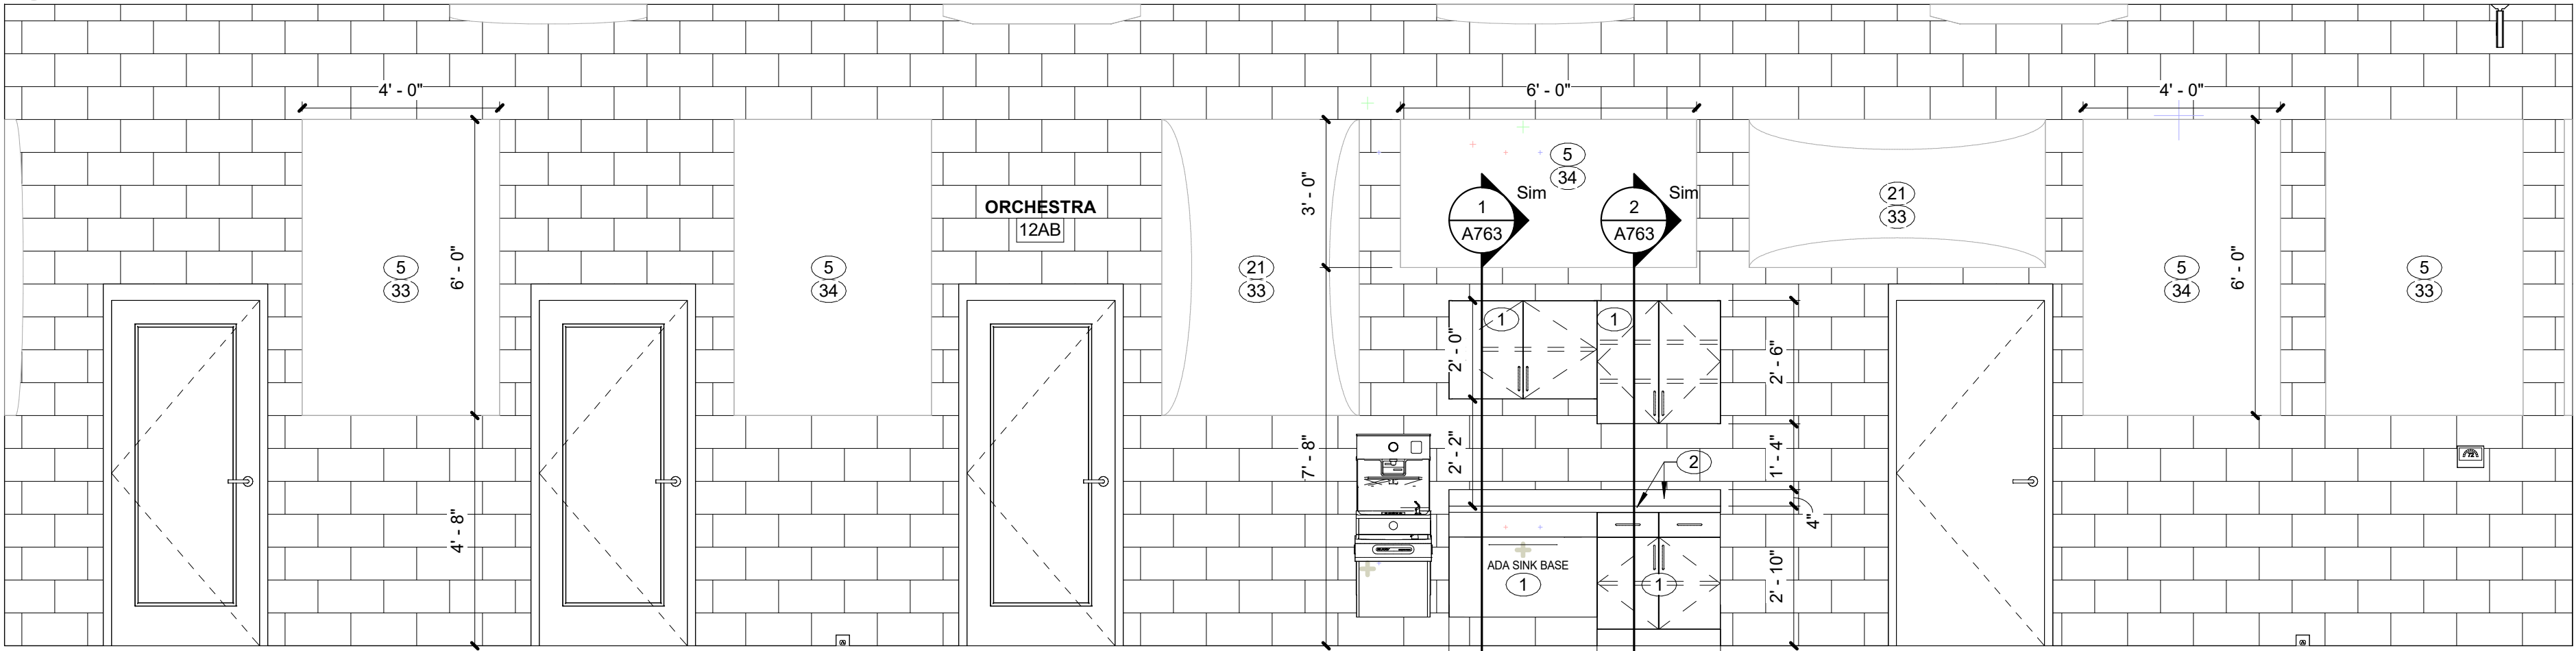


8 INT. ELEV. - ORCHESTRA 12AB E  
SCALE: 3/8" = 1'-0" REF. 1 / A721D

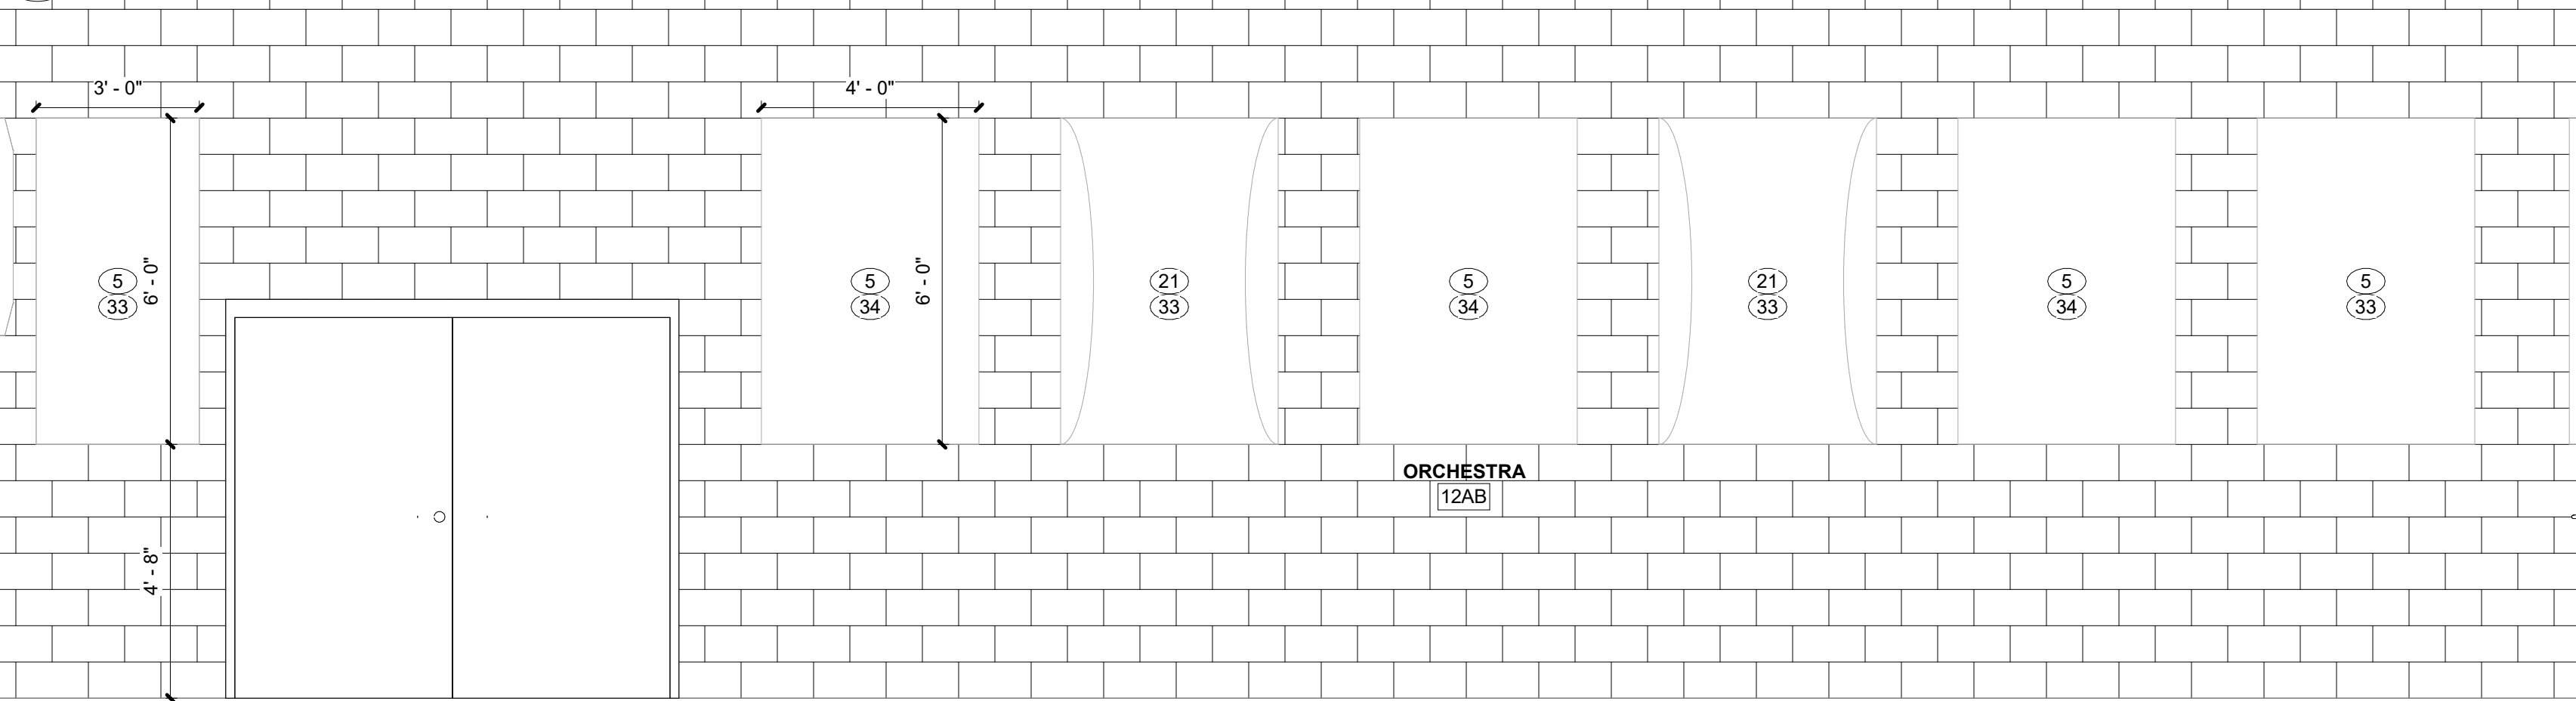


7 INT. ELEV. - ORCHESTRA 12AB N  
SCALE: 3/8" = 1'-0" REF. 1 / A721D

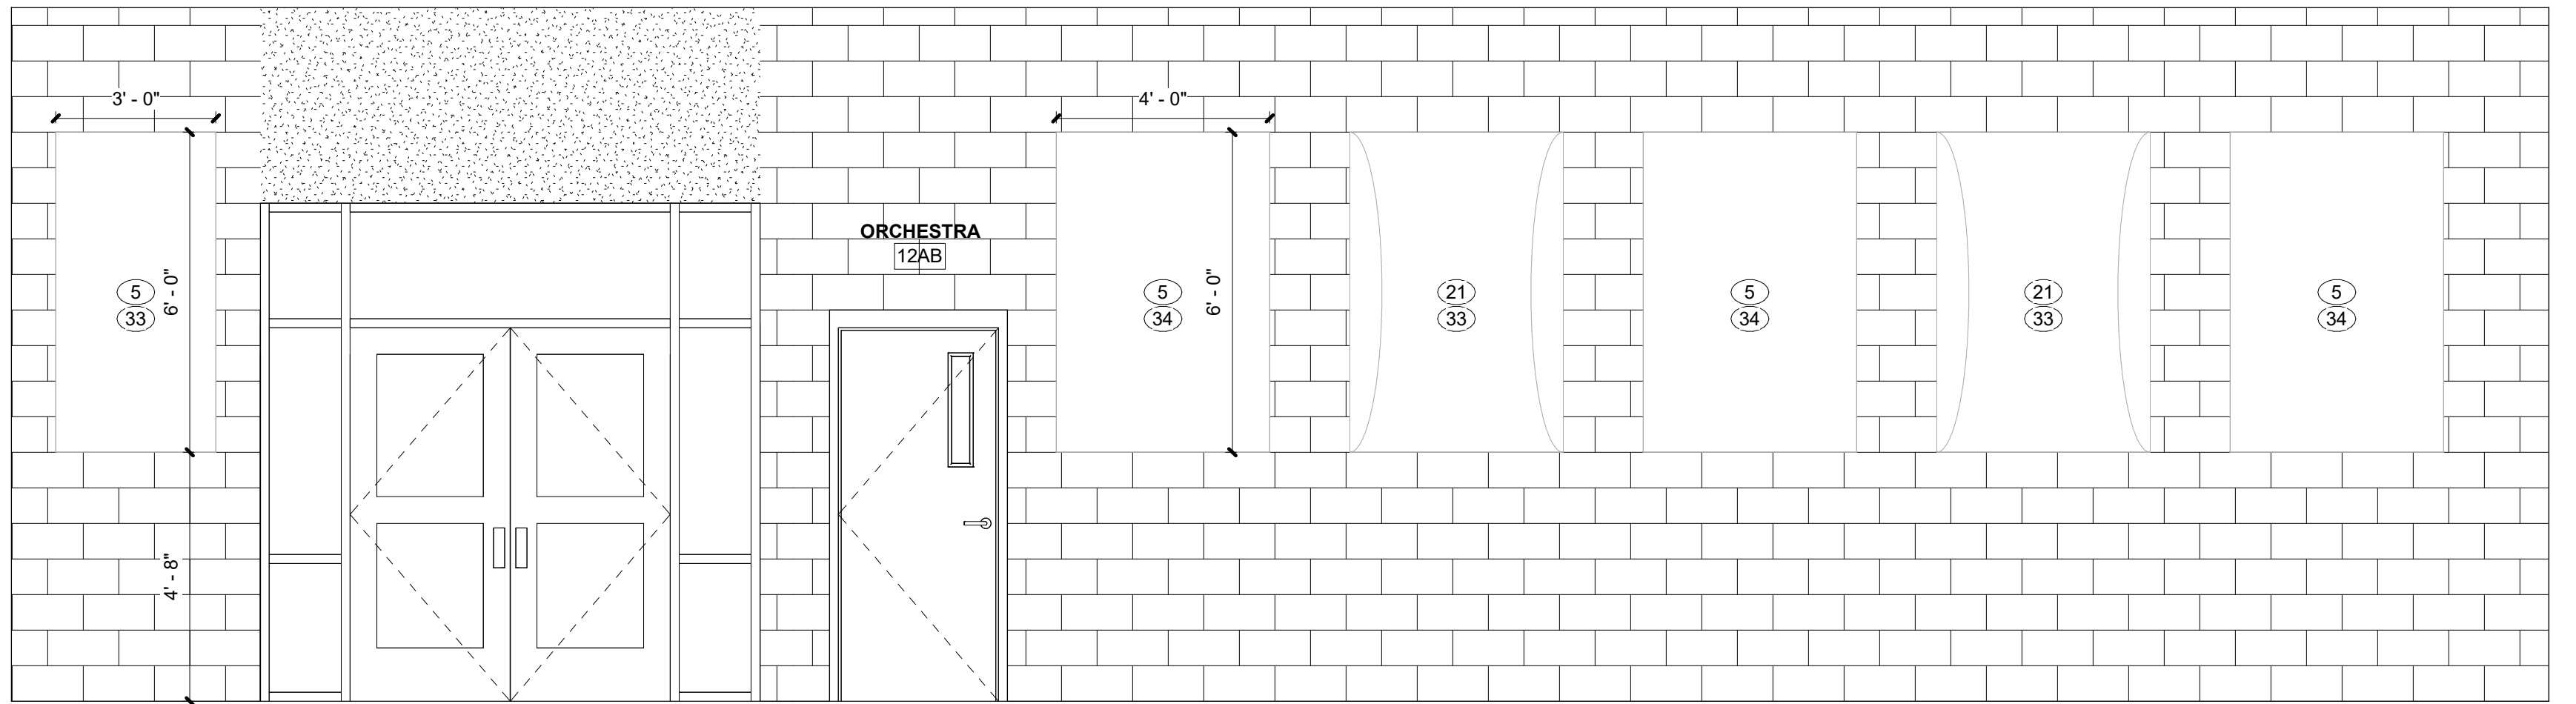


6 INT. ELEV. - ORCHESTRA 12AB S  
SCALE: 3/8" = 1'-0" REF. 1 / A721D

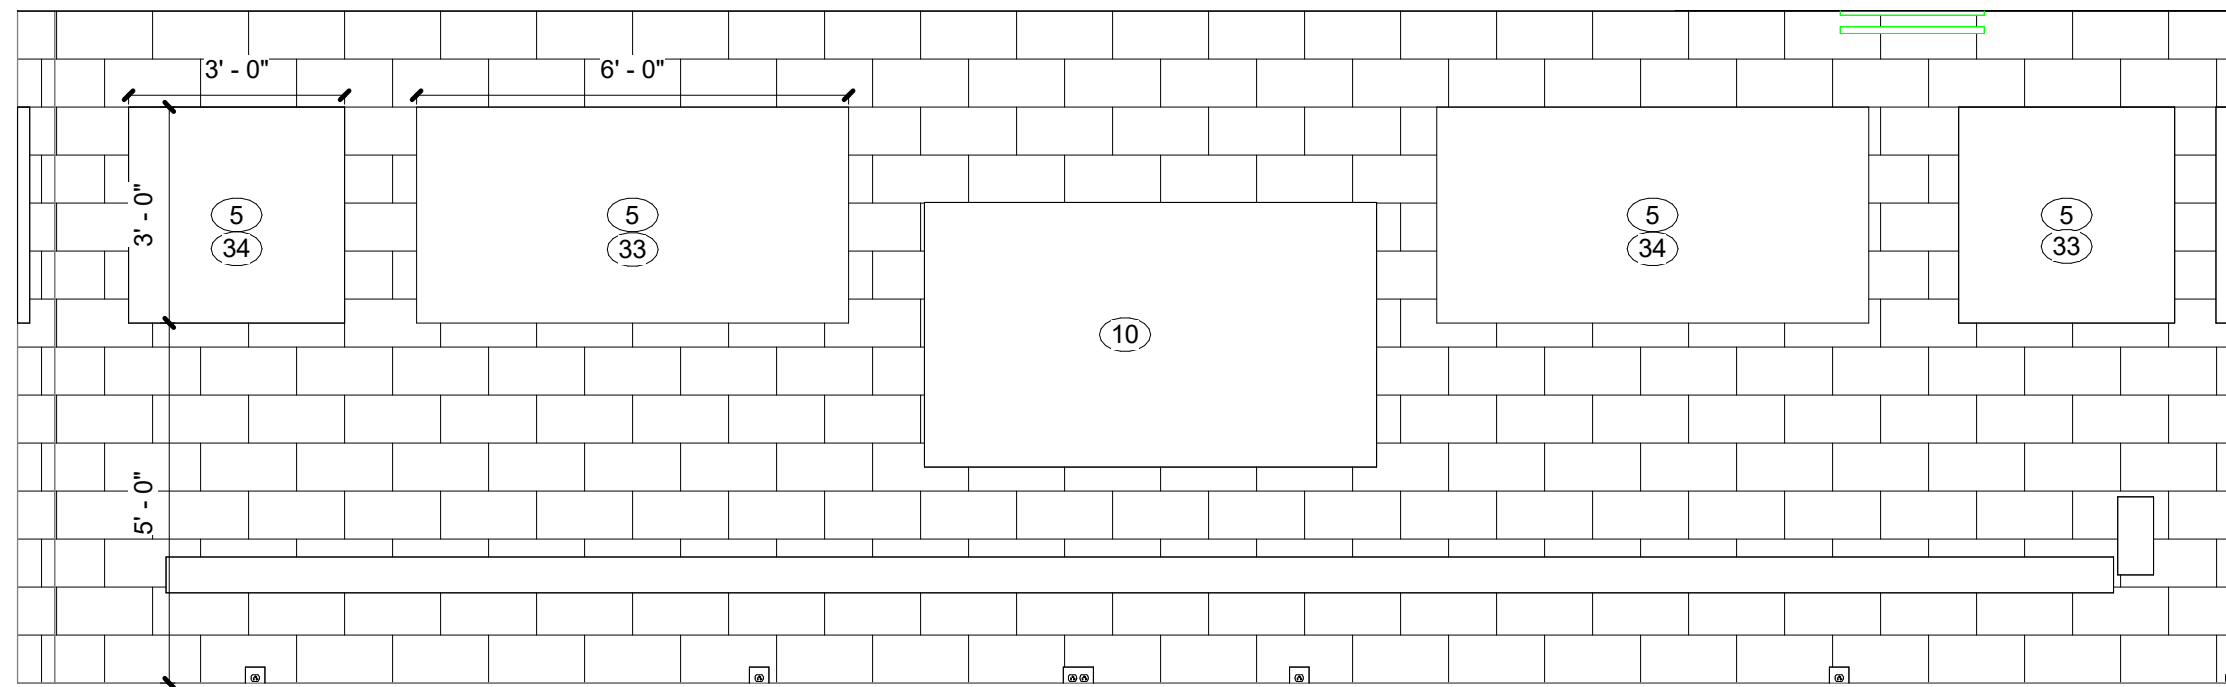


5 INT. ELEV. - ENSEMBLE 12A W  
SCALE: 3/8" = 1'-0" REF. 1 / A721D

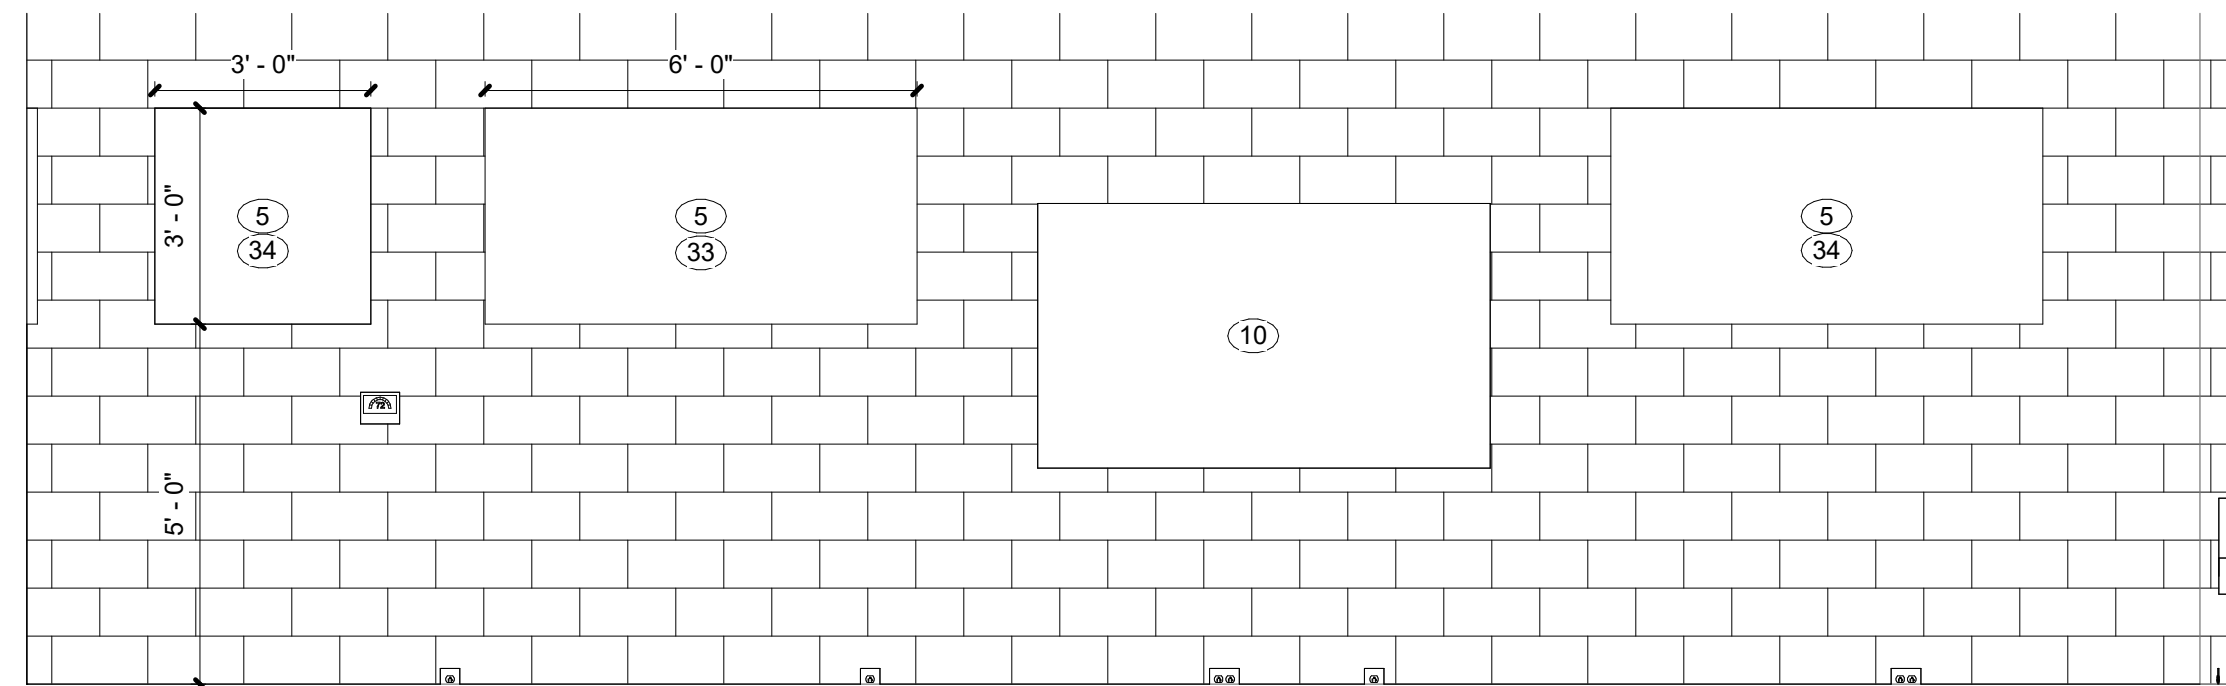

2 INT. ELEV. - ENSEMBLE 12A E  
SCALE: 3/8" = 1'-0" REF. 1 / A721D

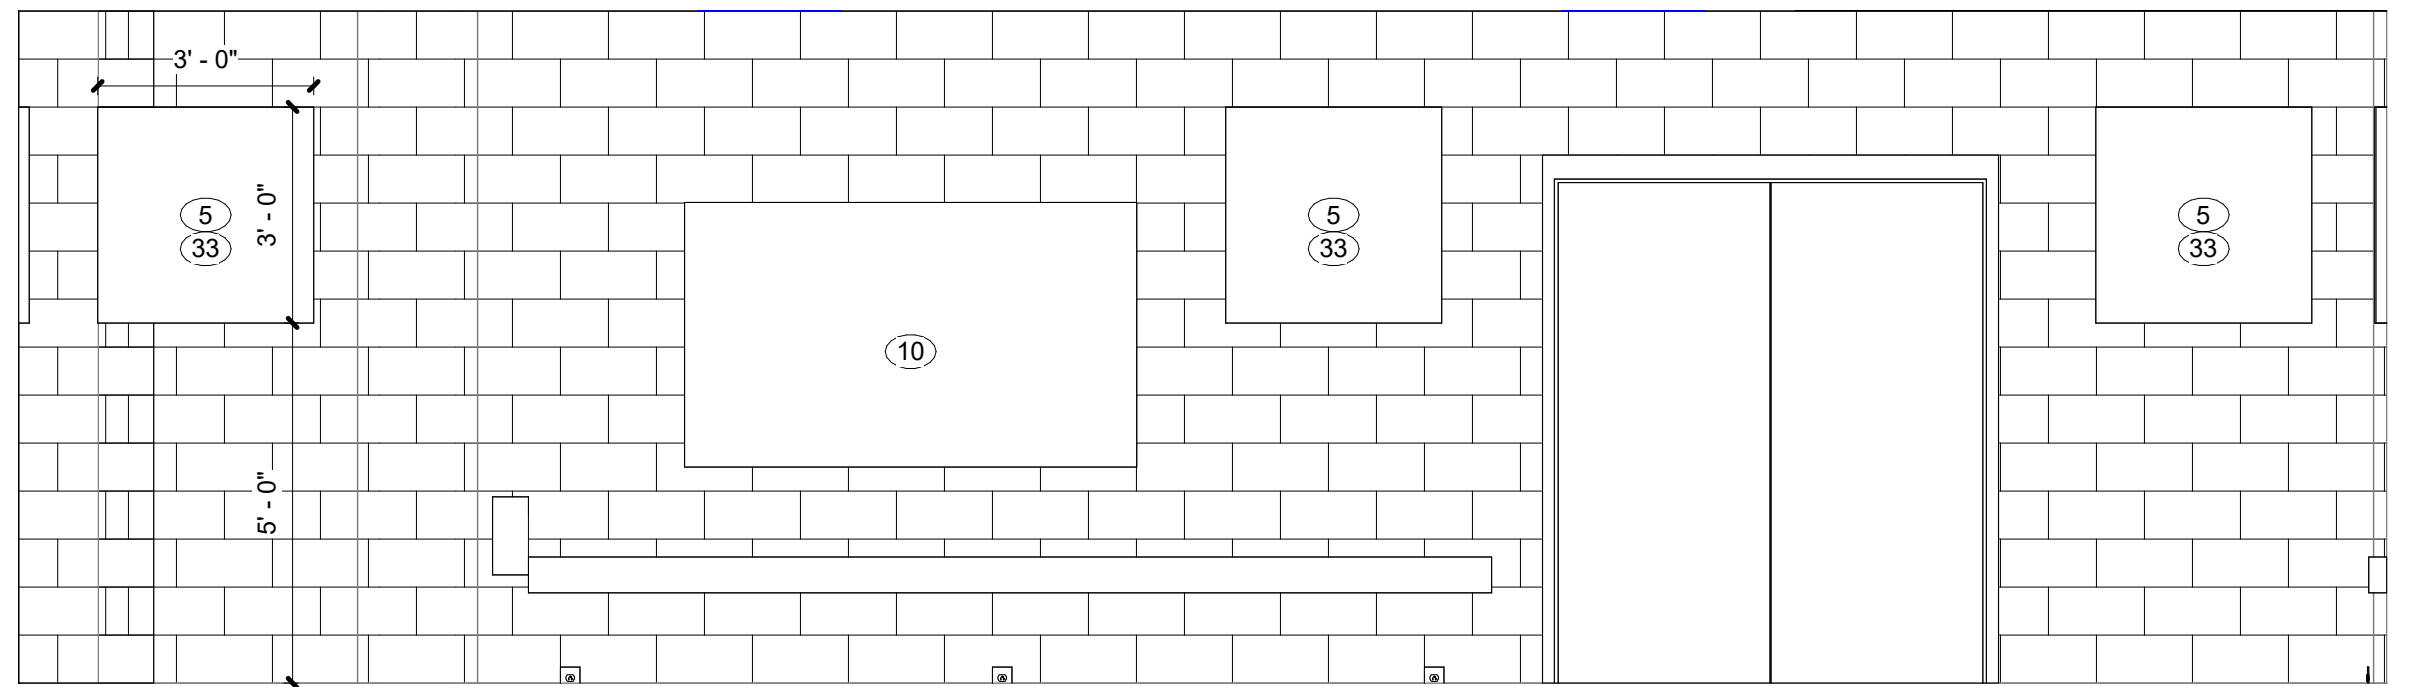

4 INT. ELEV. - ENSEMBLE 12A S  
SCALE: 3/8" = 1'-0" REF. 1 / A721D

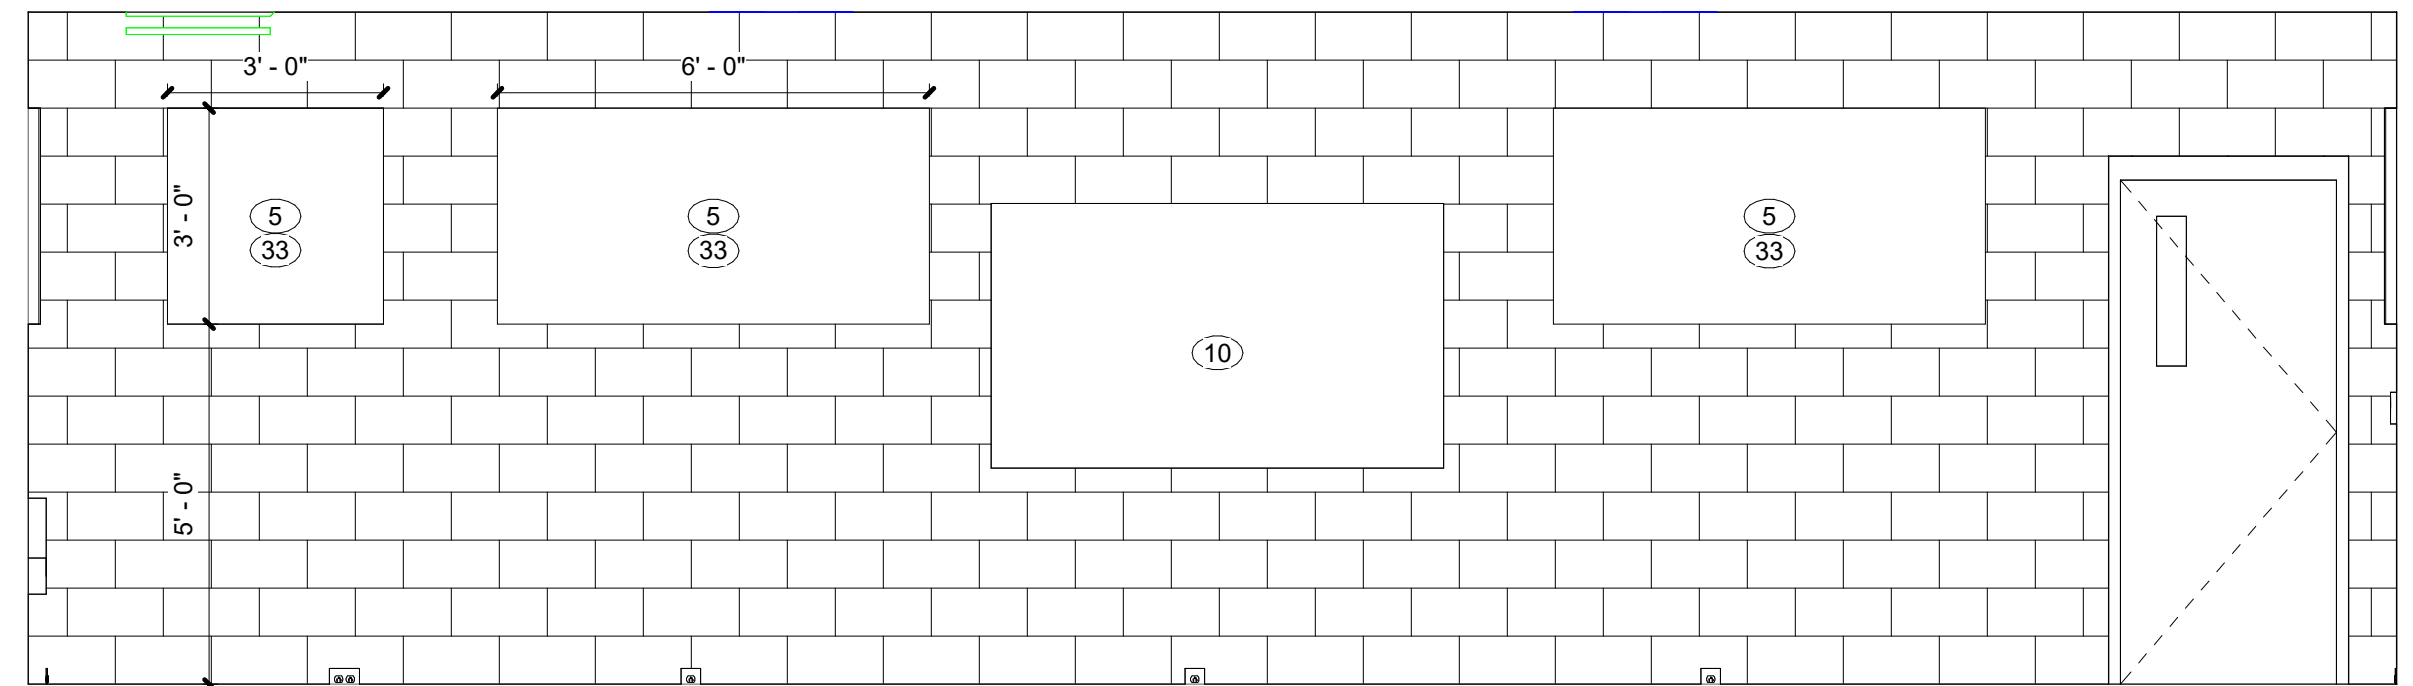

1 INT. ELEV. - ENSEMBLE 12A N  
SCALE: 3/8" = 1'-0" REF. 1 / A721D

**GENERAL NOTES - INTERIOR ELEVATIONS**

A. CONTRACTOR TO PROVIDE SCHLUTER EDGE WHERE TILE MEETS DISSIMILAR MATERIALS. REFER TO FINISH MATERIAL LEGEND AND INTERIOR ELEVATIONS FOR FURTHER DETAILS.

B. DO NOT INSTALL GYPSUM BOARD BEHIND TILE BACKER BOARD LOCATIONS.

C. CONTRACTOR TO PROVIDE DRYWALL REVEAL JOINT WHERE DRYWALL MEETS DISSIMILAR MATERIALS.

D. CONTRACTOR TO PROVIDE SCHLUTER EDGE WHERE TILE MEETS DISSIMILAR MATERIALS. REFER TO FINISH MATERIAL LEGEND AND INTERIOR ELEVATIONS FOR FURTHER DETAILS.

E. IF ONLY PAINT IS INDICATED AS THE FINISH, REFER TO ARCHITECTURAL FLOOR PLANS FOR SUBSTRATE INFORMATION.

F. CONTRACTOR SHALL BE RESPONSIBLE FOR VERIFICATION OF DIMENSIONS AND JOB CONDITIONS. ANY DEVIATION FROM WHAT IS INDICATED ON THE FINISH PLANS SHALL BE BROUGHT TO THE ATTENTION OF THE ARCHITECTS AND DESIGNERS.

G. ALL DIMENSIONS SHOWN ARE TO FACE OF FINISH MATERIAL, UNLESS INDICATED OTHERWISE ON PLANS.

H. ALL EXPOSED METAL SURFACES, SUCH AS GRILLES, FIRE EXTINGUISHER CABINETS, ETC., THAT ARE NOTED TO BE PAINTED ARE TO BE PAINTED MATCH WALL COLOR.

I. ALL WALLS TO BE PAINTED PT-1, UNLESS NOTED OTHERWISE.


- ELEVATION NOTES - INTERIOR**
- 1 PLASTIC LAMINATE PL-1
  - 2 SOLID SURFACE SS-1
  - 3 TALL CABINET WITH (5) ADJUSTABLE SHELVES
  - 4 ACOUSTICAL WALL DIFFUSER PANEL
  - 5 ACOUSTICAL WALL ABSORBER PANEL
  - 6 INDUSTRIAL DEEP BASIN SINK WITH CLAY TRAP
  - 7 SPRAY BOOTH
  - 8 WARDROBE CABINET WITH ROD AND SHELF
  - 9 MUSICAL INSTRUMENT STORAGE SIMILAR TO WENGER ULTRASTOR STORAGE CABINETS, PLASTIC LAMINATE PL-1 (REFER TO FINISH LEGEND)
  - 10 WALL MOUNTED MONITOR
  - 11 EPOXY SURFACE TOP AND BACKSPLASH, SS-2
  - 12 PAINT WALL TO MATCH EXISTING WALL FINISH
  - 13 PROVIDE FINISHED EDGE PANEL TO MATCH INSTRUMENT STORAGE, PLASTIC LAMINATE PL-1 (REFER TO FINISH LEGEND)
  - 14 WALL TILE WT-1 AT THIS LOCATION. FINISH ALL EDGES WITH SCHLUTER JOLLY TRIM. REFER TO FINISH LEGEND.
  - 15 SLAT WALL PANELS
  - 16 LARGE DRYING CABINET - STEEL FRAME WITH STEEL MESH
  - 17 LARGE DAMP-PROOF CABINET
  - 18 RANGE, OWNER FURNISHED, CONTRACTOR INSTALLED
  - 19 WALL MOUNTED MICROWAVE OVEN WITH EXHAUST HOOD, OWNER FURNISHED, CONTRACTOR INSTALLED
  - 20 DISHWASHER - OWNER FURNISHED, CONTRACTOR INSTALLED
  - 21 TYPE II ACOUSTICAL WALL DIFFUSER PANEL
  - 22 PLASTIC LAMINATE PL-1 FINISHED EDGE PANEL
  - 23 VENT HOOD ABOVE RANGE
  - 24 PROVIDE FINISHED PL-1 FILLER, WRAP SIDES AS NECESSARY.
  - 25 SOLID SURFACE SS-3, EASED AND MITERED EDGES. REFER TO FINISH LEGEND.
  - 26 STAINLESS STEEL, COUNTERTOP, STS-1, REFER TO FINISH LEGEND.
  - 27 PLASTIC LAMINATE PL-2
  - 28 4'-0" W X 7'-0" H INSTALLED MIRRORS.
  - 29 FREE STANDING MICROWAVE, OWNER PROVIDED, OWNER INSTALLED
  - 30 REFRIGERATOR, OWNER FURNISHED, CONTRACTOR INSTALLED
  - 31 UNDER CABINET RANGE HOOD, OWNER FURNISHED, CONTRACTOR INSTALLED
  - 32 NEW WINDOW SOLID SURFACE WINDOW SILL, SS-1
  - 33 AWP-1 FINISH
  - 34 AWP-2 FINISH

PERRY TOWNSHIP SCHOOLS  
PERRY MERIDIAN HS PHASE II RENO (VOL 2)  
401 W MERIDIAN SCHOOL RD,  
INDIANAPOLIS, IN 46217




| REVISONS: | # | Date       | Desc:        |
|-----------|---|------------|--------------|
|           | 3 | 09-23-2026 | Addendum 003 |


100% CONSTRUCTION DOCUMENTS  
PROJECT: #24173P  
DATE: 09-21-2026  
DRAWN BY: Author  
INTERIOR ELEVATIONS

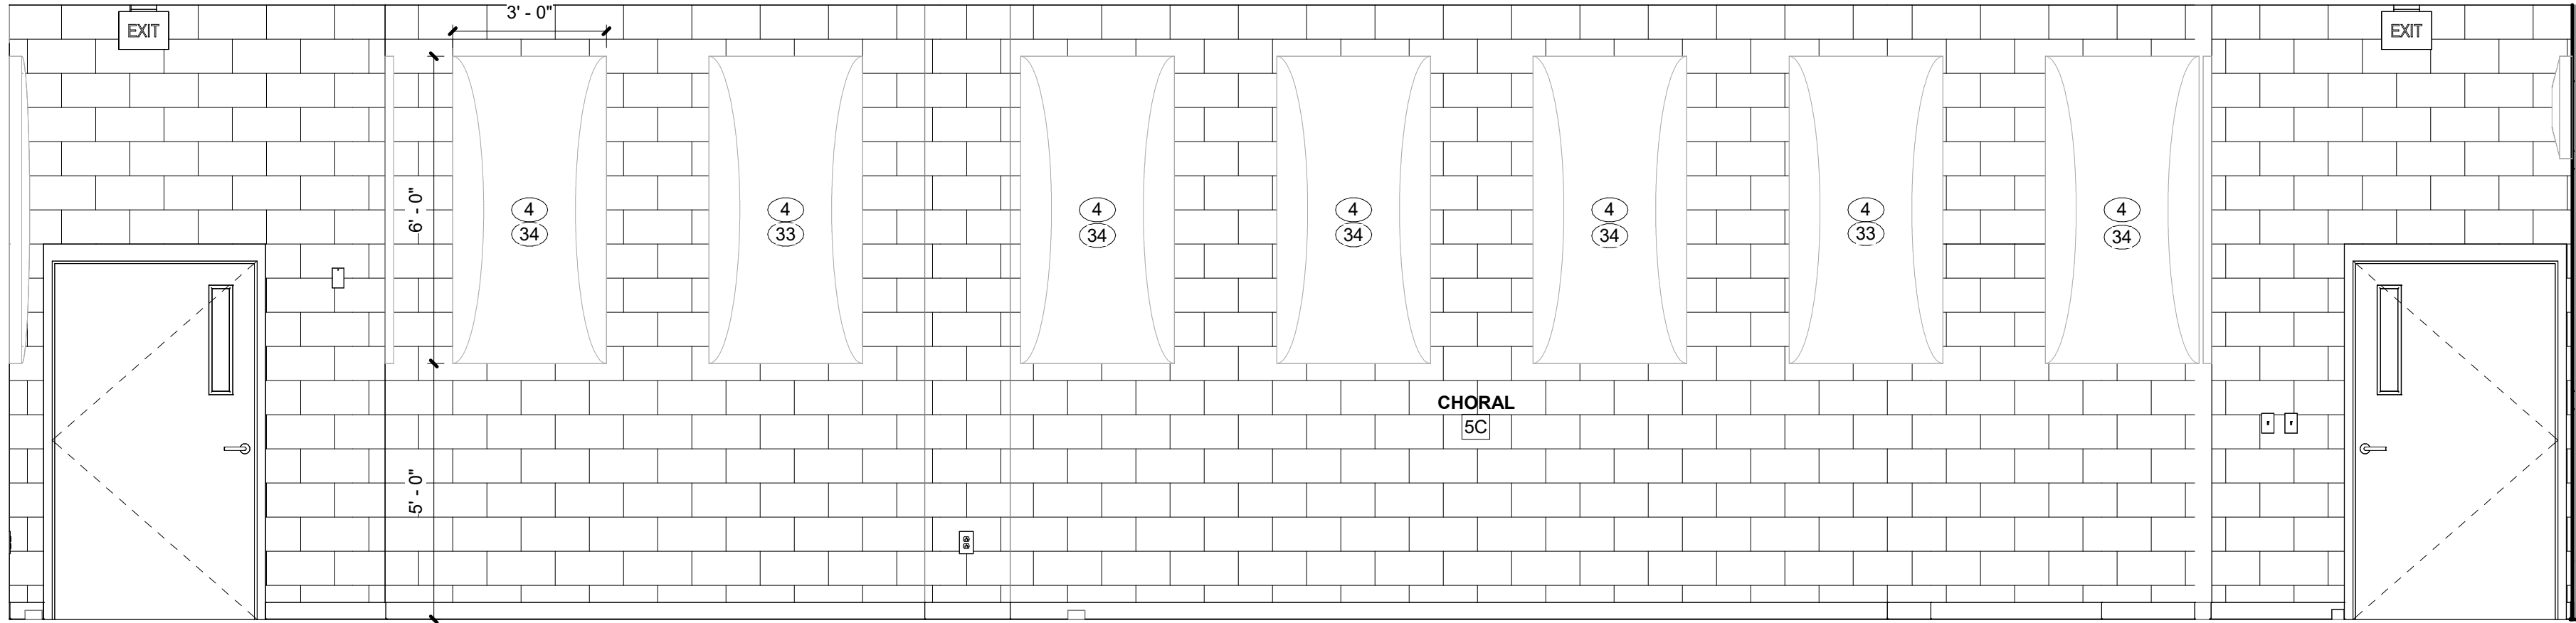


6 INT. ELEV. - CHORAL 5C W  
SCALE: 3/8" = 1'-0" REF. 1 / A721H

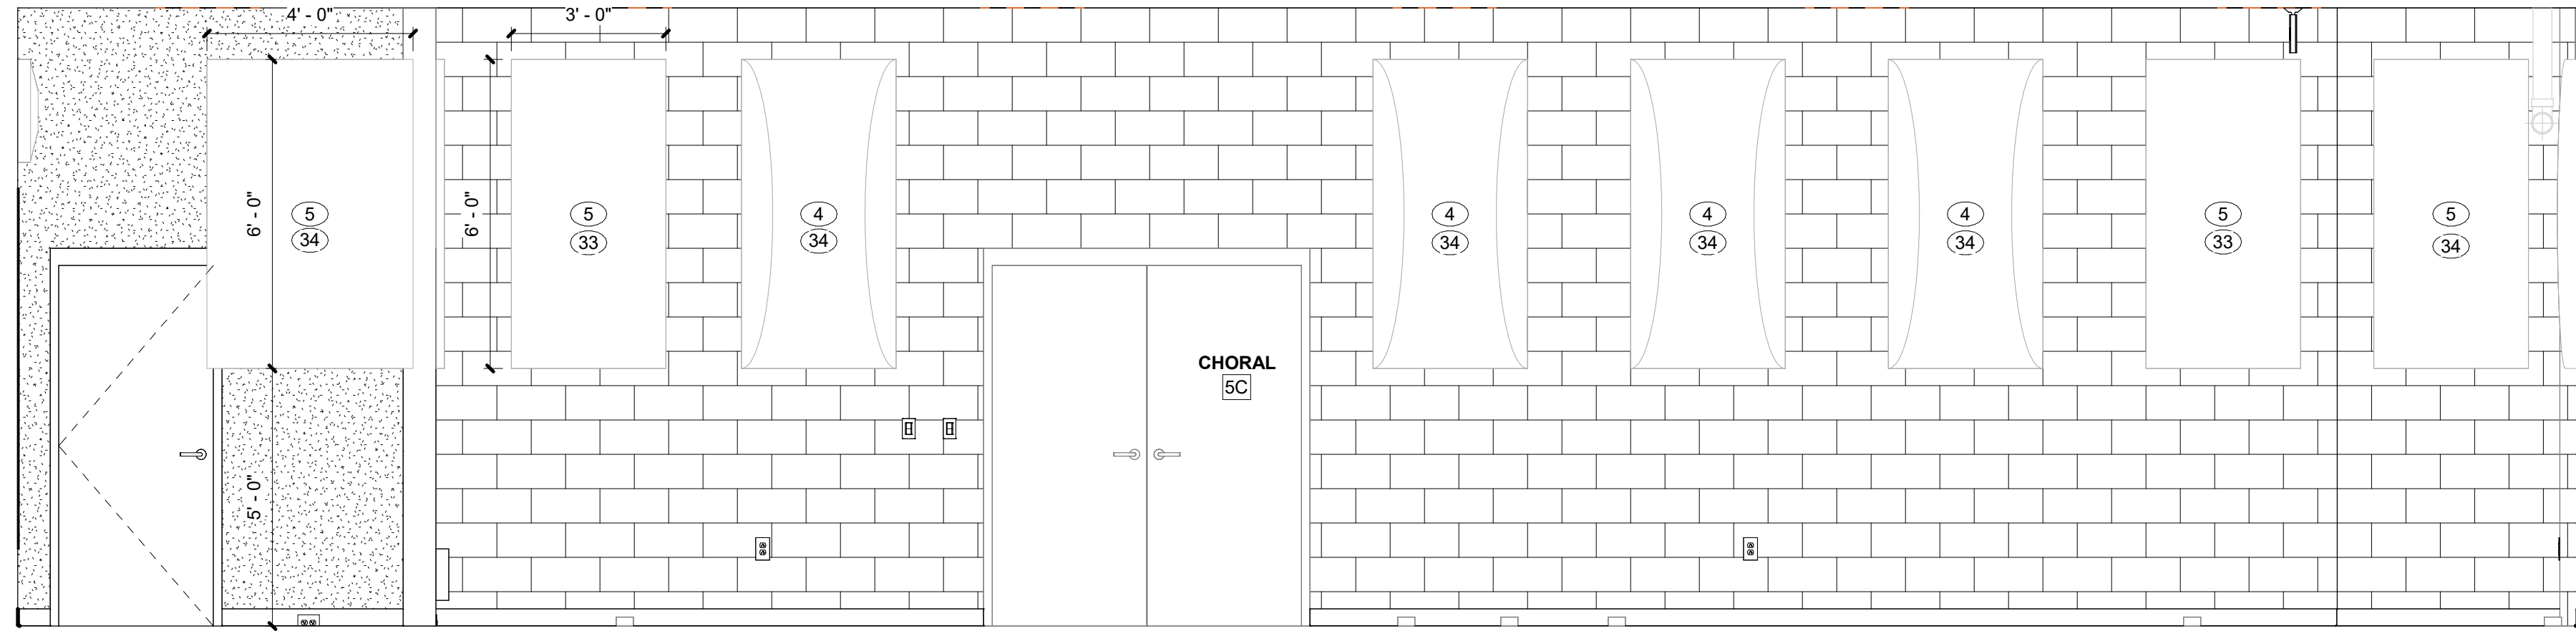

5 INT. ELEV. - CHORAL 5C S  
SCALE: 3/8" = 1'-0" REF. 1 / A721H

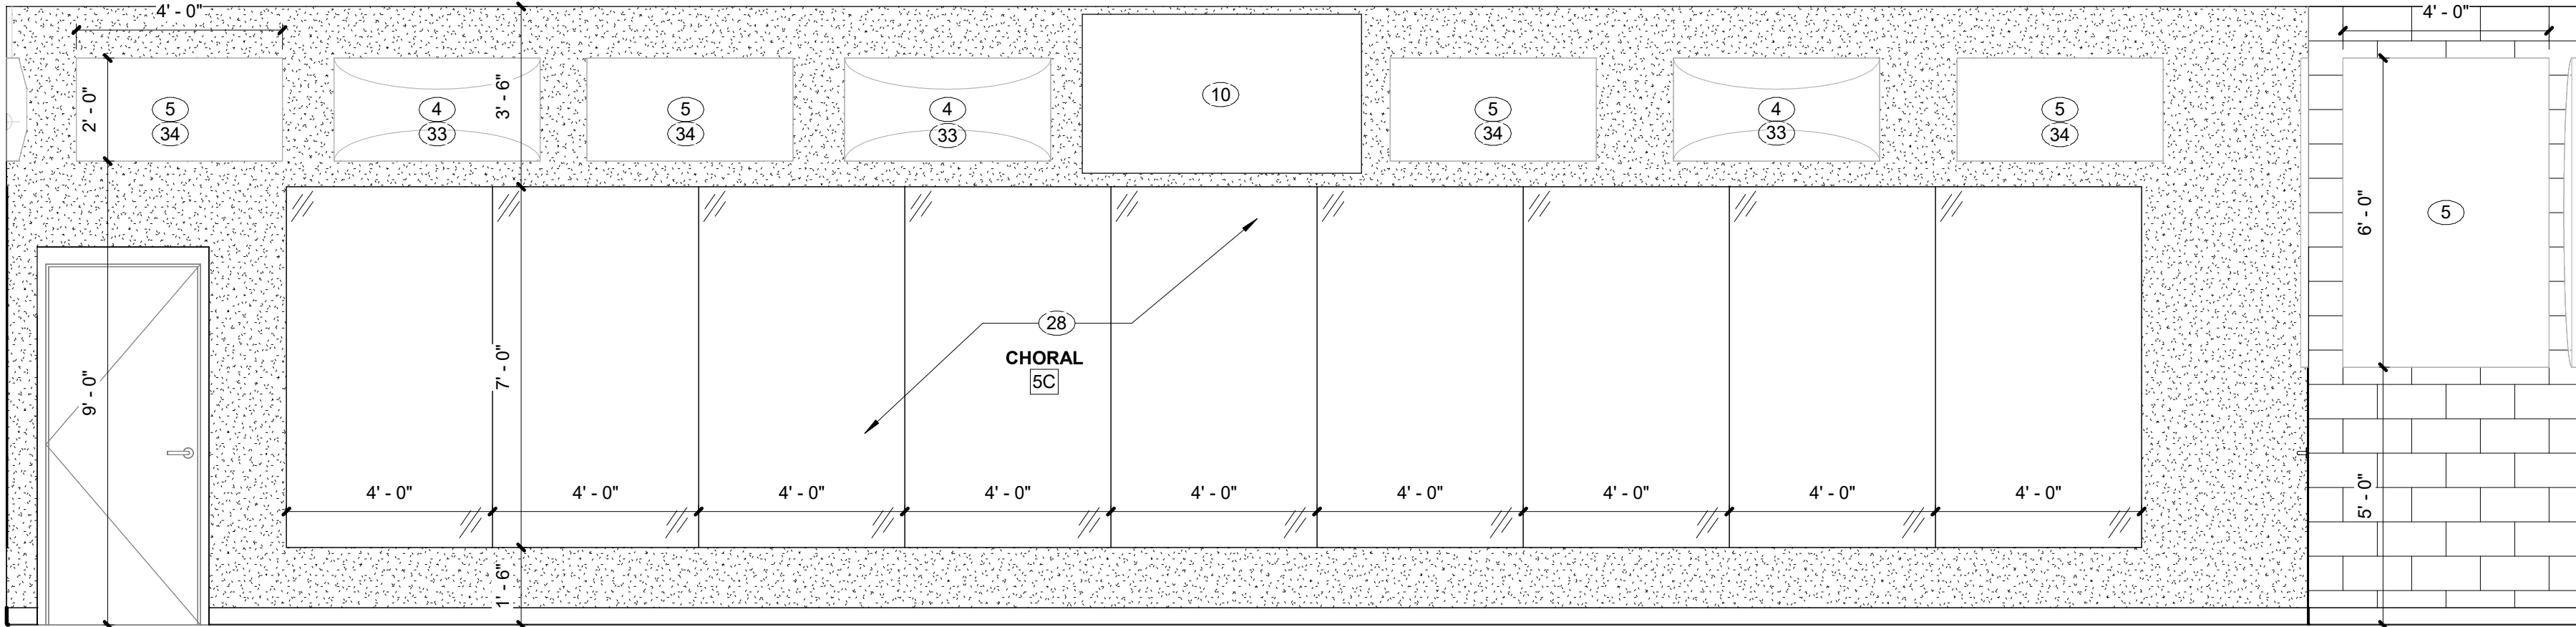

3 INT. ELEV. - CHORAL 5C E  
SCALE: 3/8" = 1'-0" REF. 1 / A721H

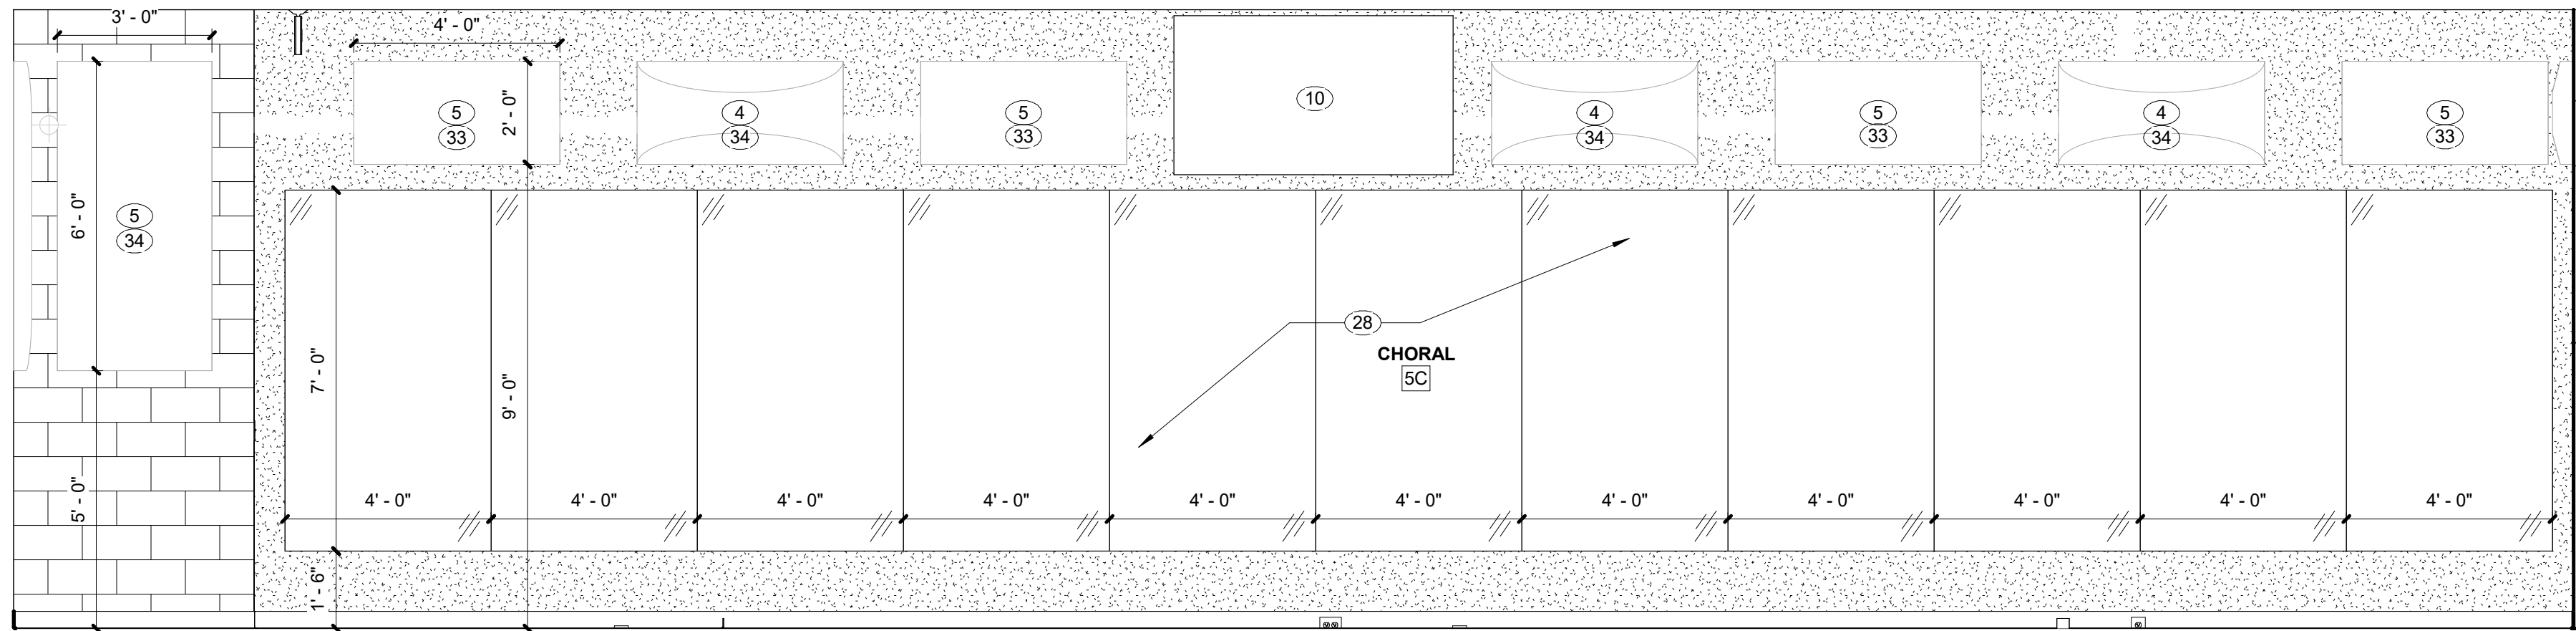


2 INT. ELEV. - CHORAL 5C N  
SCALE: 3/8" = 1'-0" REF. 1 / A721H

## GENERAL NOTES - INTERIOR ELEVATIONS


- CONTRACTOR TO PROVIDE SCHLUTER EDGE WHERE TILE MEETS DISSIMILAR MATERIALS. REFER TO FINISH MATERIAL LEGEND AND INTERIOR ELEVATIONS FOR FURTHER DETAILS.
- DO NOT INSTALL GYPSUM BOARD BEHIND TILE BACKER BOARD LOCATIONS.
- CONTRACTOR TO PROVIDE DRYWALL REVEAL JOINT WHERE DRYWALL MEETS DISSIMILAR MATERIALS.
- CONTRACTOR TO PROVIDE SCHLUTER EDGE WHERE TILE MEETS DISSIMILAR MATERIALS. REFER TO FINISH MATERIAL LEGEND AND INTERIOR ELEVATIONS FOR FURTHER DETAILS.
- IF ONLY PAINT IS INDICATED AS THE FINISH, REFER TO ARCHITECTURAL FLOOR PLANS FOR SUBSTRATE INFORMATION.
- CONTRACTOR SHALL BE RESPONSIBLE FOR VERIFICATION OF DIMENSIONS AND JOB CONDITIONS. ANY DEVIATION FROM WHAT IS INDICATED ON THE FINISH PLANS SHALL BE BROUGHT TO THE ATTENTION OF THE ARCHITECTS AND DESIGNERS.
- ALL DIMENSIONS SHOWN ARE TO FACE OF FINISH MATERIAL, UNLESS INDICATED OTHERWISE ON PLANS.
- ALL EXPOSED METAL SURFACES, SUCH AS GRILLES, FIRE EXTINGUISHER CABINETS, ETC., THAT ARE NOTED TO BE PAINTED ARE TO BE PAINTED MATCH WALL COLOR.
- ALL WALLS TO BE PAINTED PT-1, UNLESS NOTED OTHERWISE.

## ELEVATION NOTES - INTERIOR

- PLASTIC LAMINATE PL-1
- SOLID SURFACE SS-1
- TALL CABINET WITH (S) ADJUSTABLE SHELVES
- ACOUSTICAL WALL DIFFUSER PANEL
- ACOUSTICAL WALL ABSORBER PANEL
- INDUSTRIAL DEEP BASIN SINK WITH CLAY TRAP
- SPRAY BOOTH
- WARDROBE CABINET WITH ROD AND SHELF
- MUSICAL INSTRUMENT STORAGE SIMILAR TO WENGER ULTRASTOR STORAGE CABINETS, PLASTIC LAMINATE PL-1 (REFER TO FINISH LEGEND)
- WALL-MOUNTED MONITOR
- EPOXY SURFACE TOP AND BACKSPLASH, SS-2
- PAINT WALL TO MATCH EXISTING WALL FINISH
- PROVIDE FINISHED EDGE PANEL TO MATCH INSTRUMENT STORAGE, PLASTIC LAMINATE PL-1 (REFER TO FINISH LEGEND)
- WALL TILE WT-1 AT THIS LOCATION. FINISH ALL EDGES WITH SCHLUTER JOLLY TRIM. REFER TO FINISH LEGEND.
- SLAT WALL PANELS
- LARGE DRYING CABINET - STEEL FRAME WITH STEEL MESH
- LARGE DAMP-PROOF CABINET
- RANGE, OWNER FURNISHED, CONTRACTOR INSTALLED
- WALL MOUNTED MICROWAVE OVEN WITH EXHAUST HOOD, OWNER FURNISHED, CONTRACTOR INSTALLED
- DISHWASHER - OWNER FURNISHED, CONTRACTOR INSTALLED
- TYPE II ACOUSTICAL WALL DIFFUSER PANEL
- PLASTIC LAMINATE PL-1 FINISHED EDGE PANEL.
- VENT HOOD ABOVE RANGE.
- PROVIDE FINISHED PL-1 FILLER, WRAP SIDES AS NECESSARY.
- SOLID SURFACE SS-3, EASED AND MITERED EDGES. REFER TO FINISH LEGEND.
- STAINLESS STEEL COUNTERTOP, STS-1. REFER TO FINISH LEGEND.
- PLASTIC LAMINATE PL-2
- 4'-0" W X 7'-0" H INSTALLED MIRRORS.
- FREE STANDING MICROWAVE, OWNER PROVIDED, OWNER INSTALLED
- REFRIGERATOR, OWNER FURNISHED, CONTRACTOR INSTALLED
- UNDER CABINET RANGE HOOD, OWNER FURNISHED, CONTRACTOR INSTALLED
- NEW WINDOW SOLID SURFACE WINDOW SILL SS-1
- AWP-1 FINISH
- AWP-2 FINISH

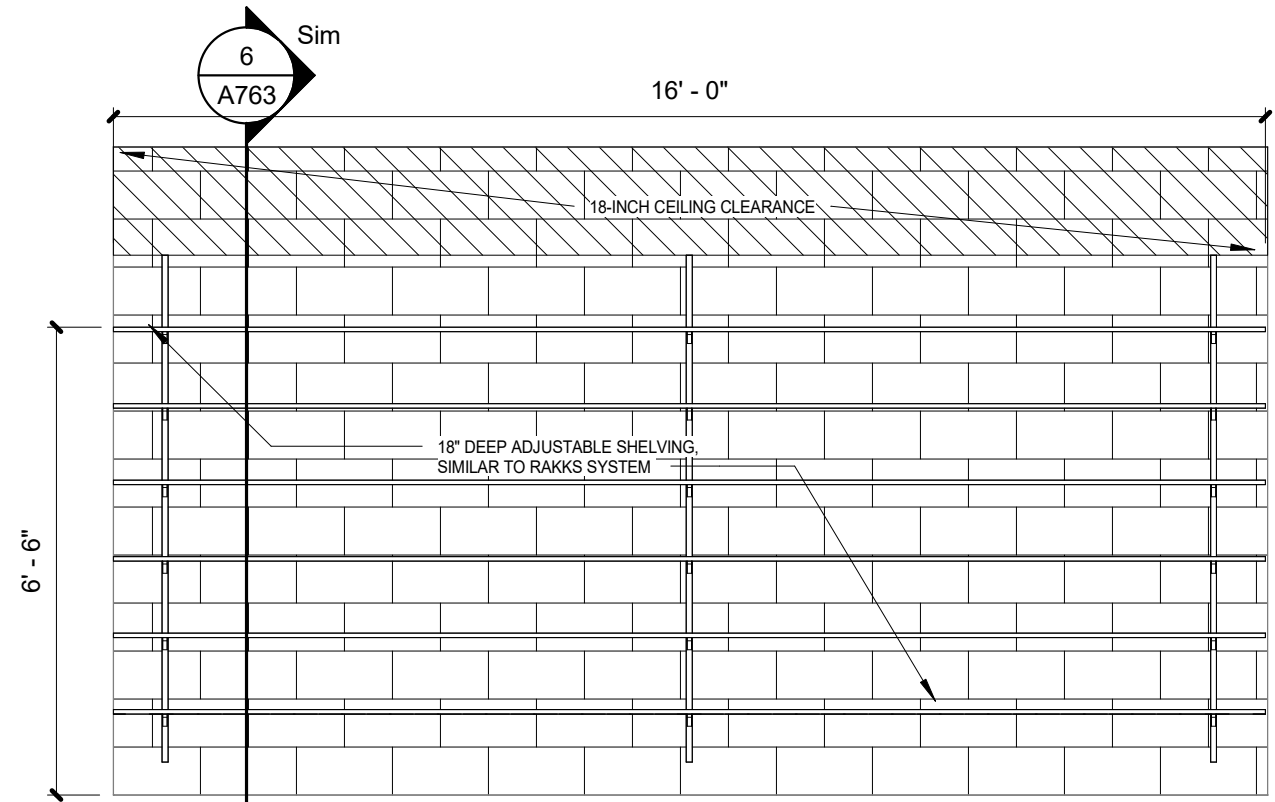


4 INT. ELEV. - STORAGE D110 W  
SCALE: 3/8" = 1'-0" REF. 1 / A721D


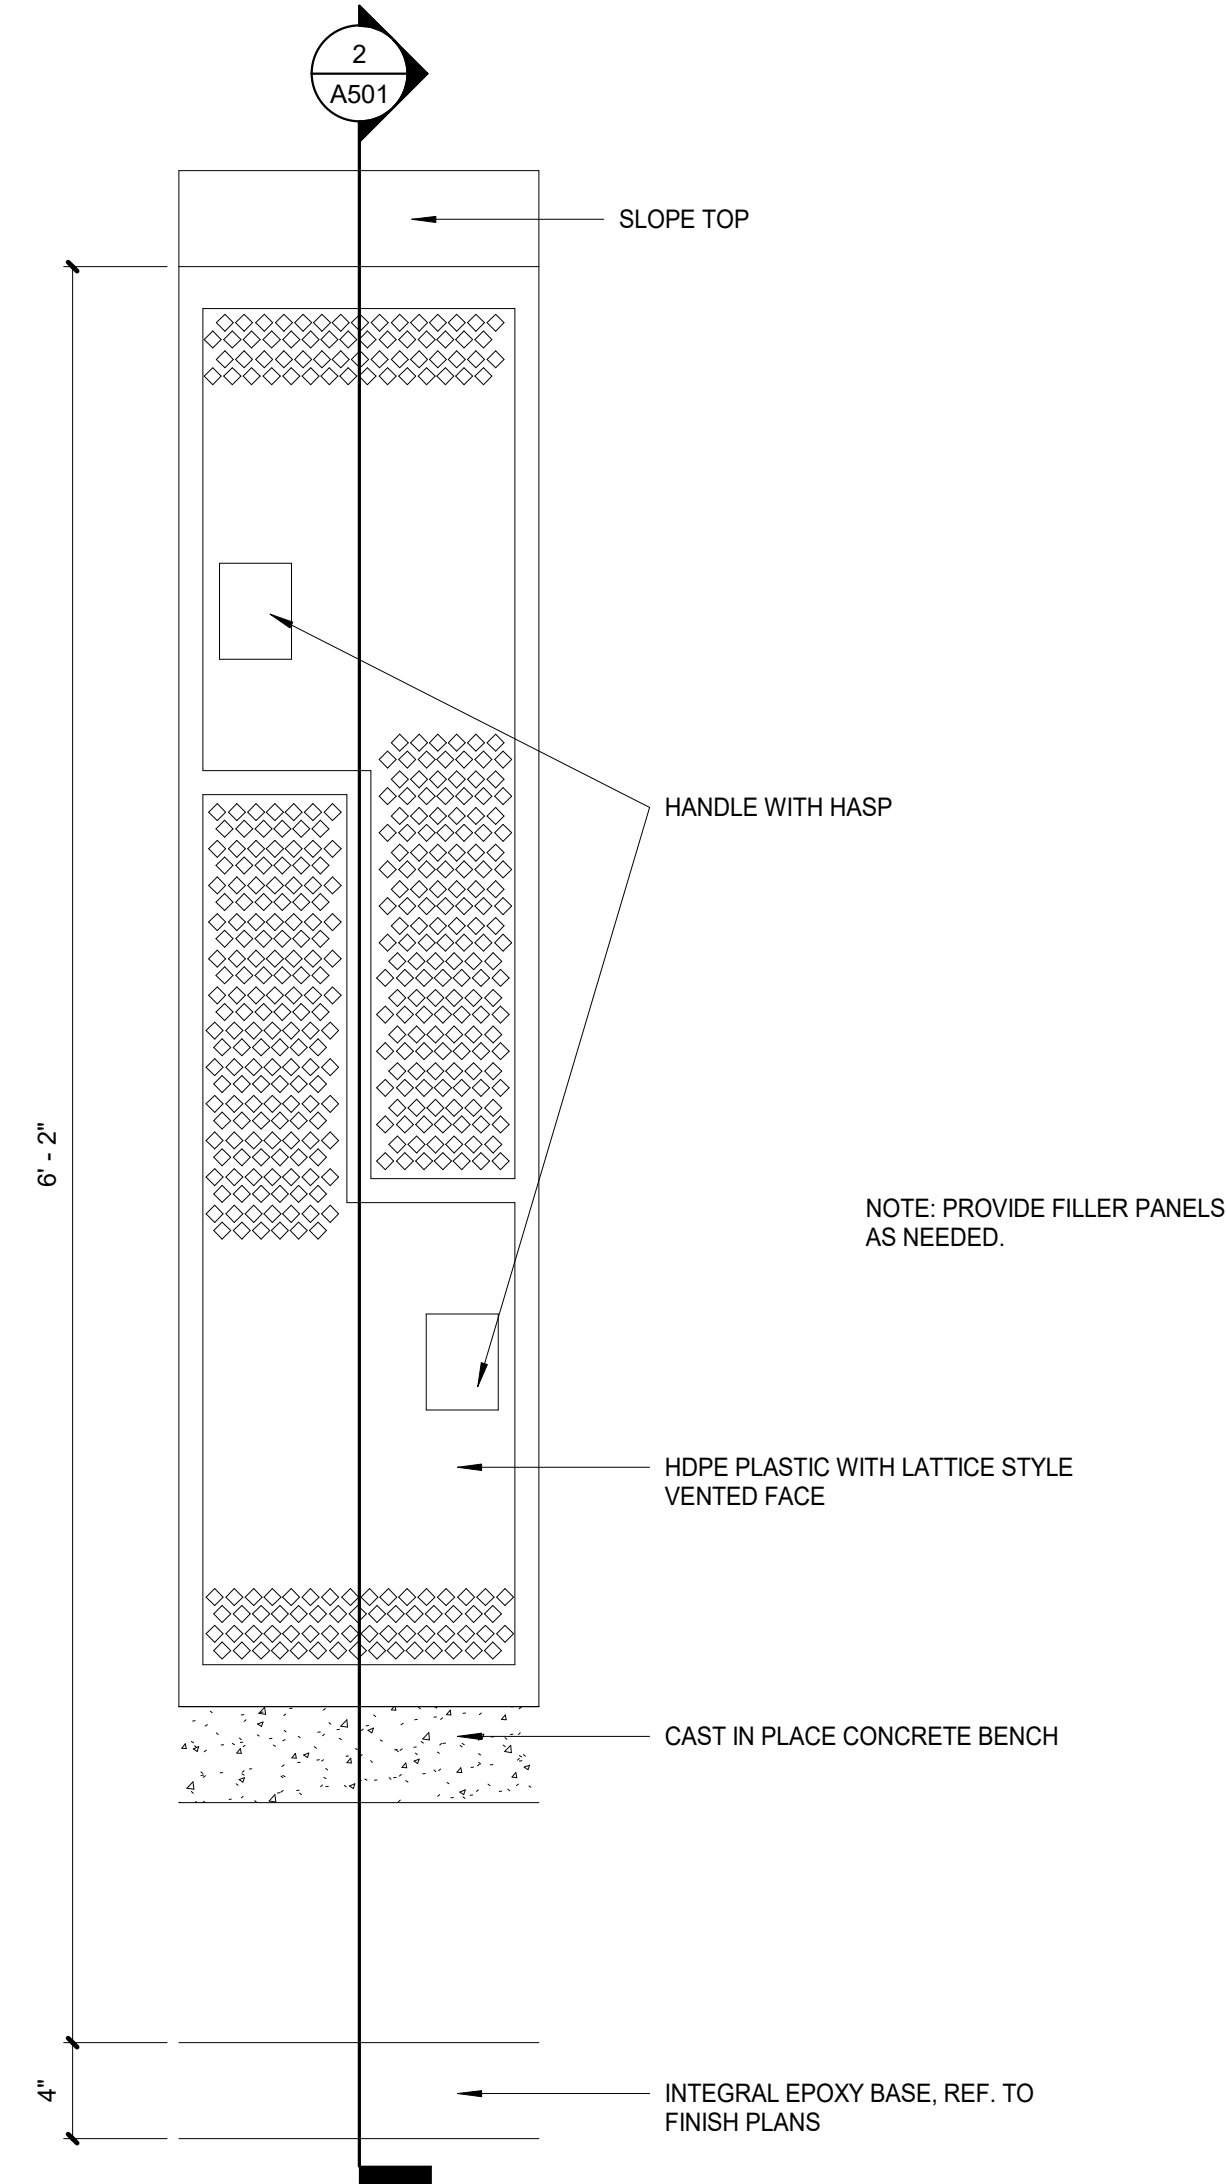


1 DOUBLE TIER PLASTIC LOCKER  
SCALE: 1 1/2" = 1'-0"

PLOT DATE/TIME: 8/22/2026 12:40:10 PM

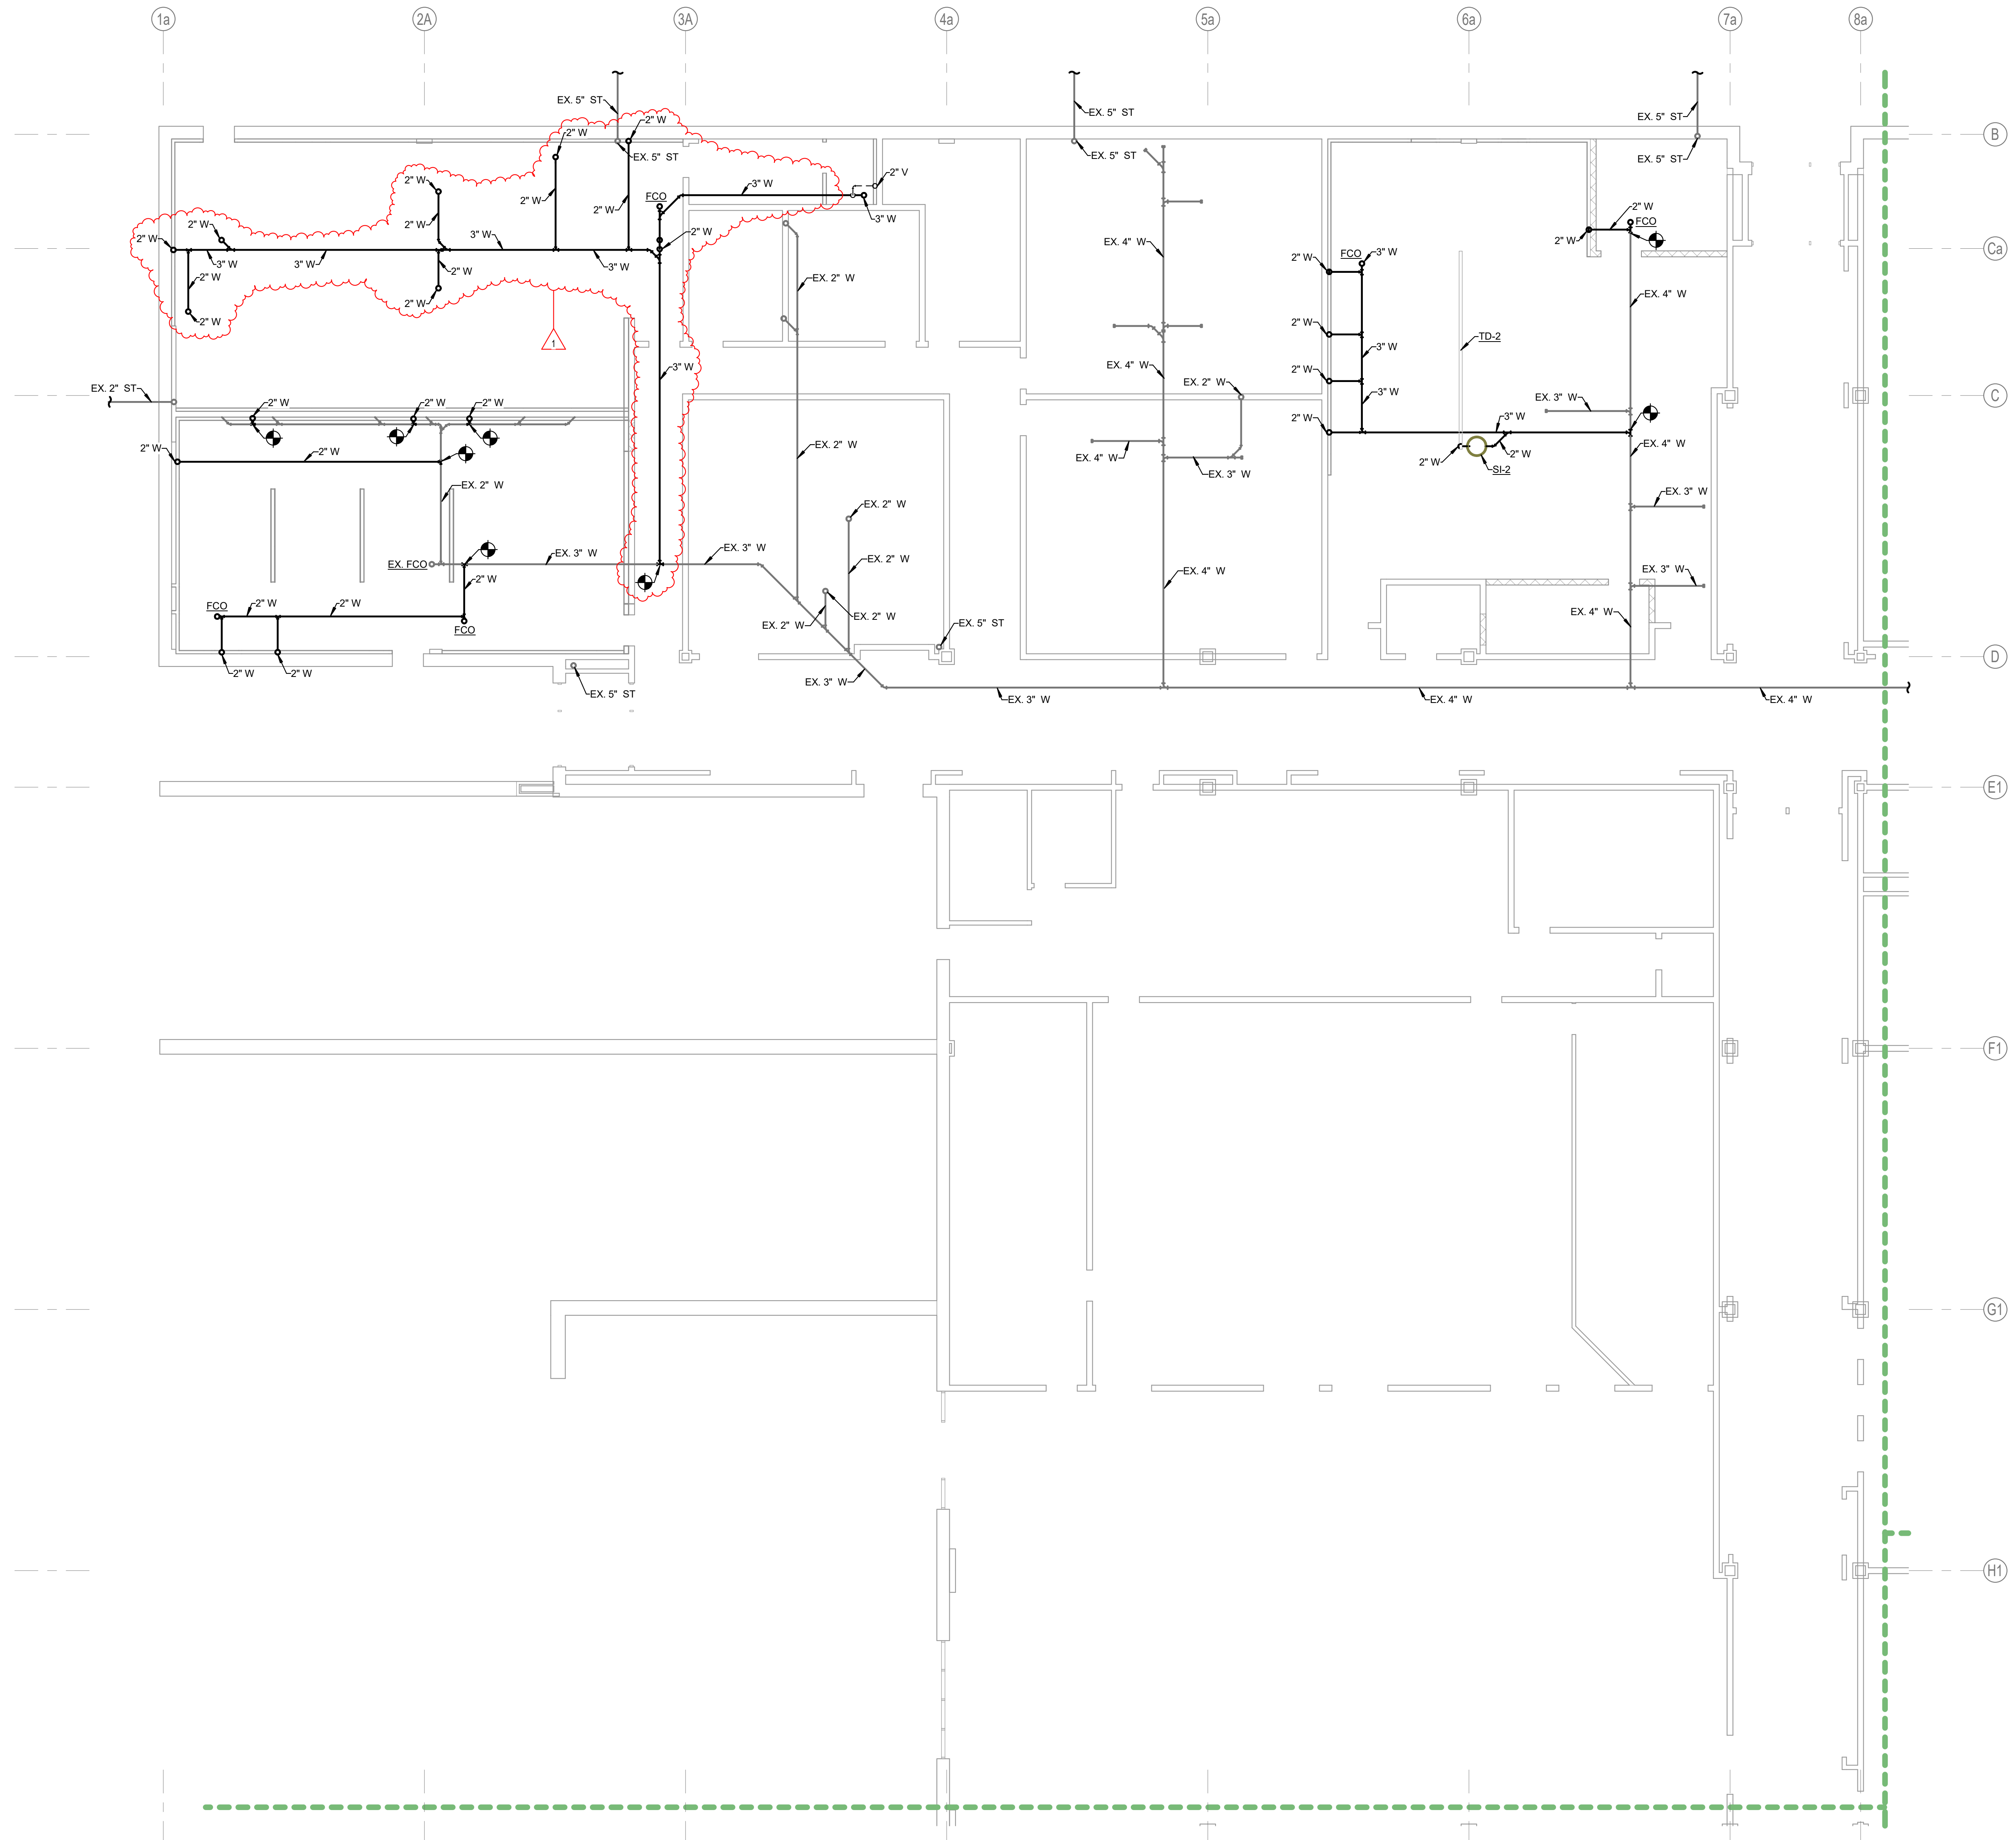

1 PLUMBING FOUNDATION PLAN - UNIT A  
1/8" = 1'-0"

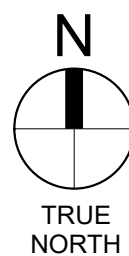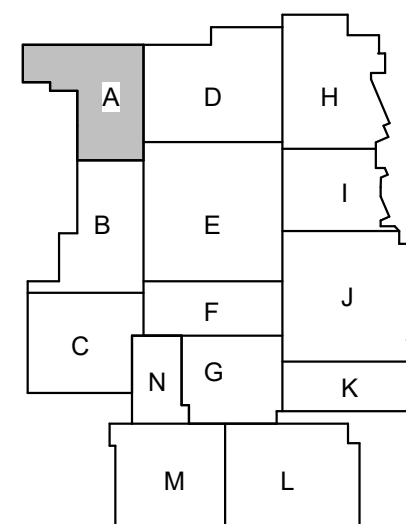


| REVISIONS: | Date       | Desc.        |
|------------|------------|--------------|
| #          |            |              |
| 1          | 09-23-2026 | Addendum #03 |

100% CONSTRUCTION DOCUMENTS  
PROJECT: #24173P  
DATE: 08-21-2026  
DRAWN BY: IOP



PLUMBING  
FOUNDATION  
PLAN - UNIT A

PF101

PLOT DATE/TIME: 8/22/2024 4:55:04 PM

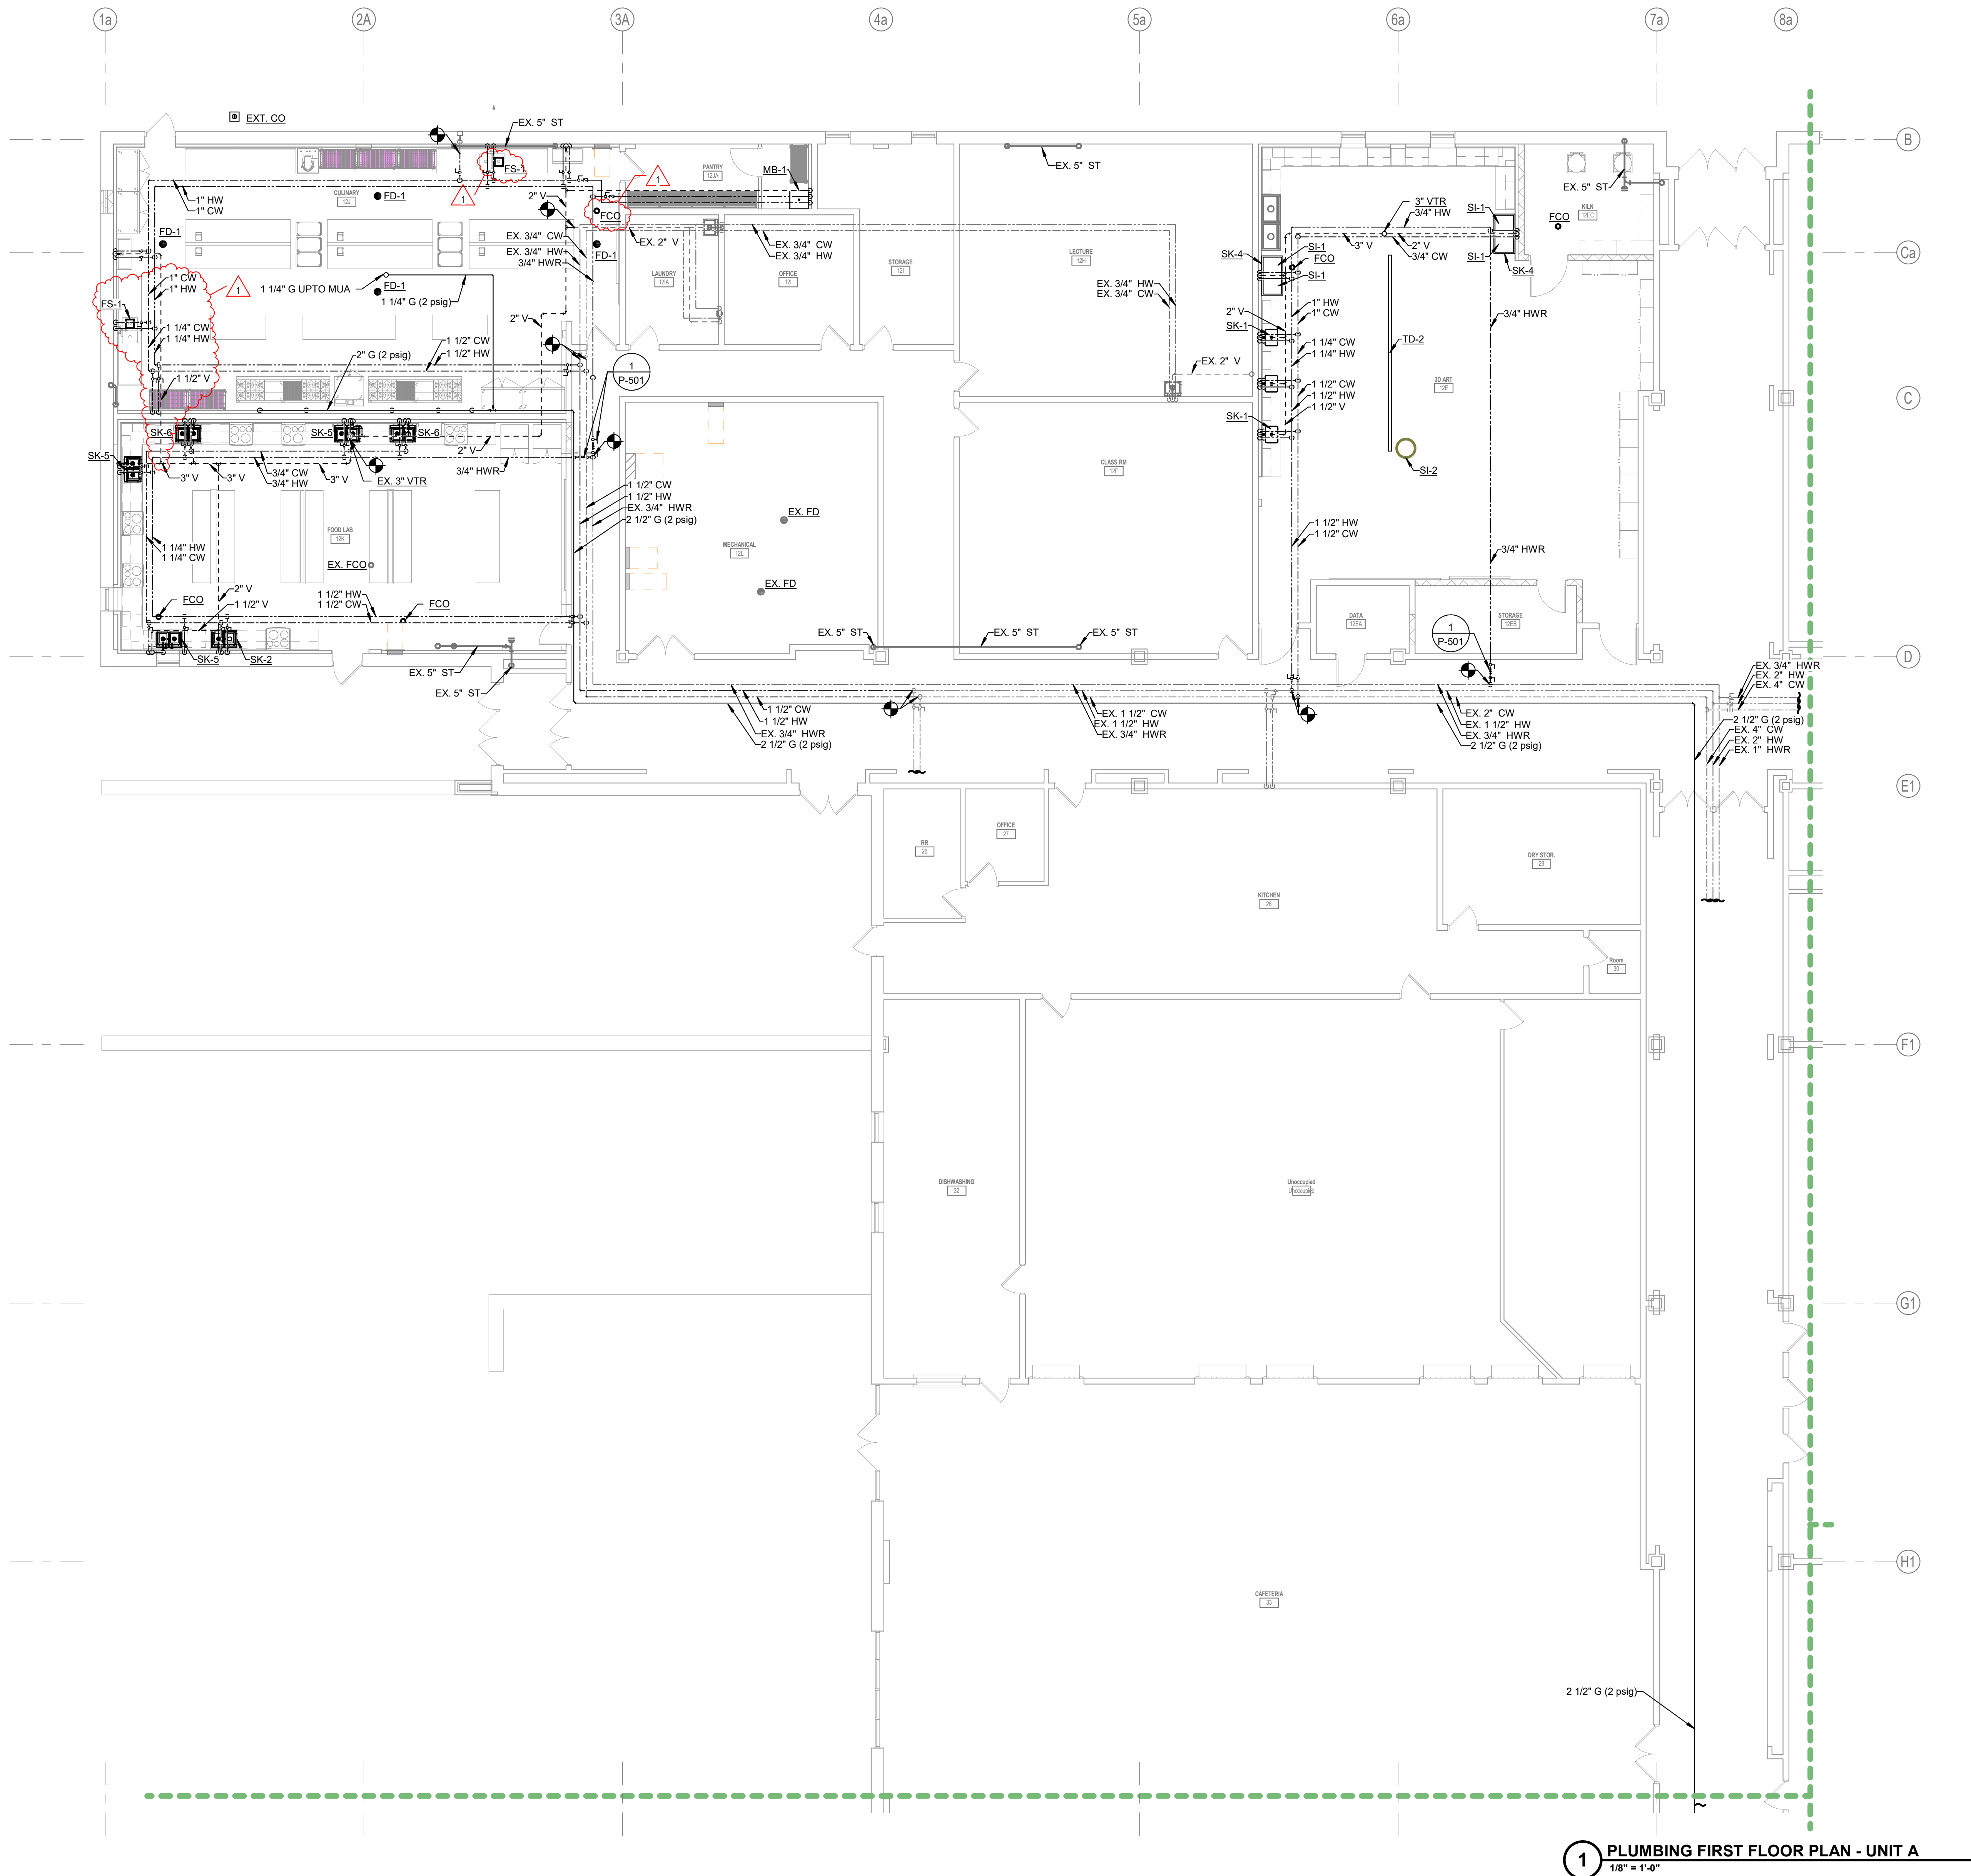

1 PLUMBING FIRST FLOOR PLAN - UNIT A  
1/8" = 1'-0"

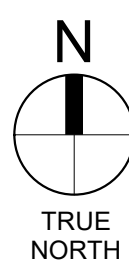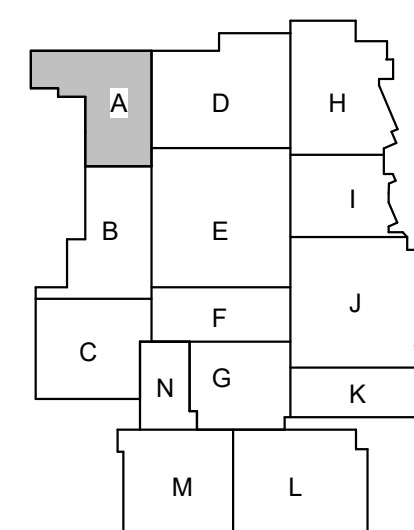

PERRY TOWNSHIP SCHOOLS  
PERRY MERIDIAN HS PHASE II RENOVATIONS (VOL 1)  
401 W MERIDIAN SCHOOL RD,  
INDIANAPOLIS, IN 46217



| REVISIONS: | Date       | Desc:        |
|------------|------------|--------------|
| #          |            |              |
| 1          | 09-23-2026 | Addendum #03 |


100% CONSTRUCTION DOCUMENTS


PROJECT: #24173P  
DATE: 08-21-2026  
DRAWN BY: JOP

PLUMBING  
FIRST FLOOR  
PLAN - UNIT A


PP101

LANCER ASSOCIATES  
ARCHITECTURE  
145 N EAST ST.  
INDIANAPOLIS, IN 46204

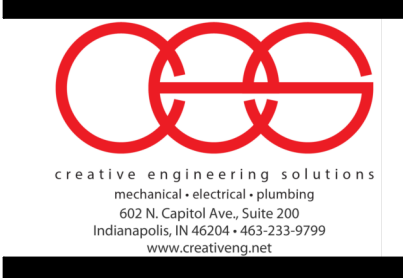

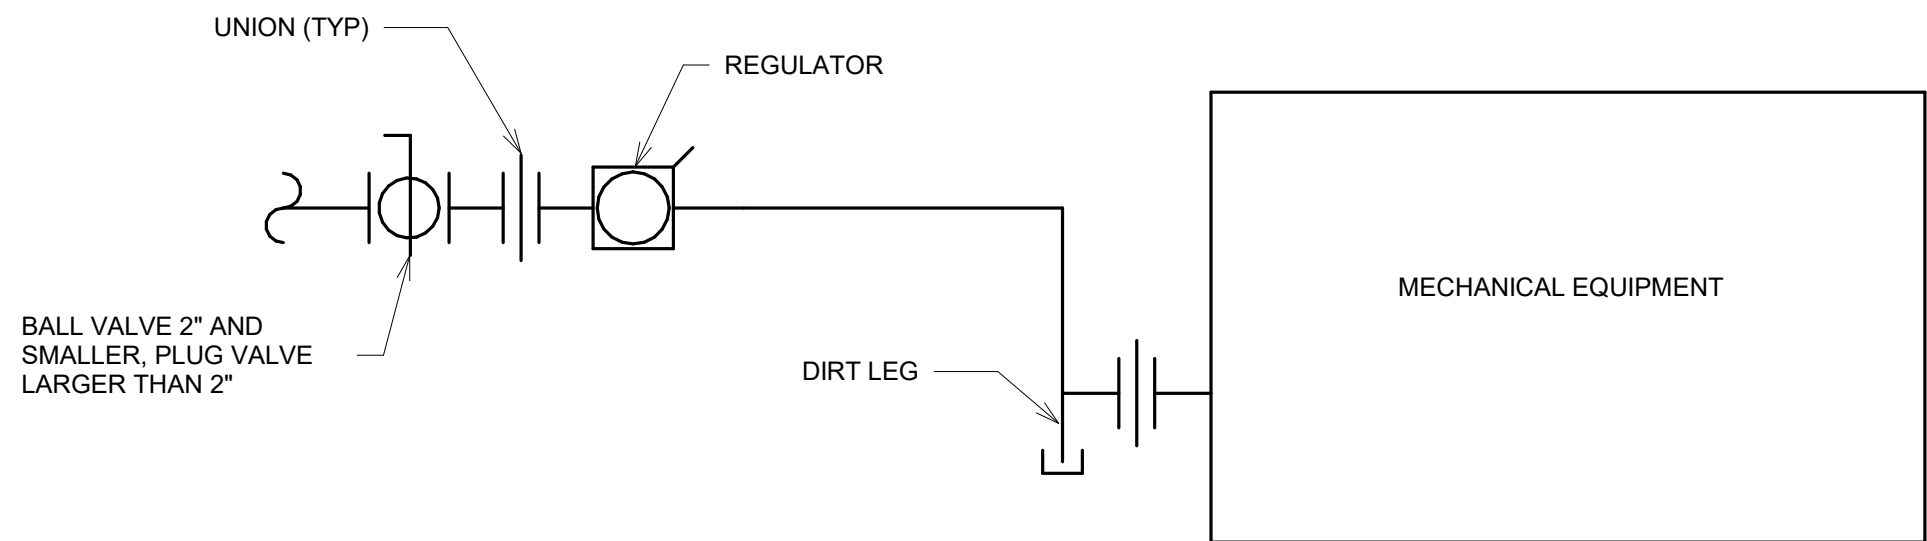

**2** GAS CONNECTION TO MECHANICAL EQUIPMENT DETAIL  
NOT TO SCALE

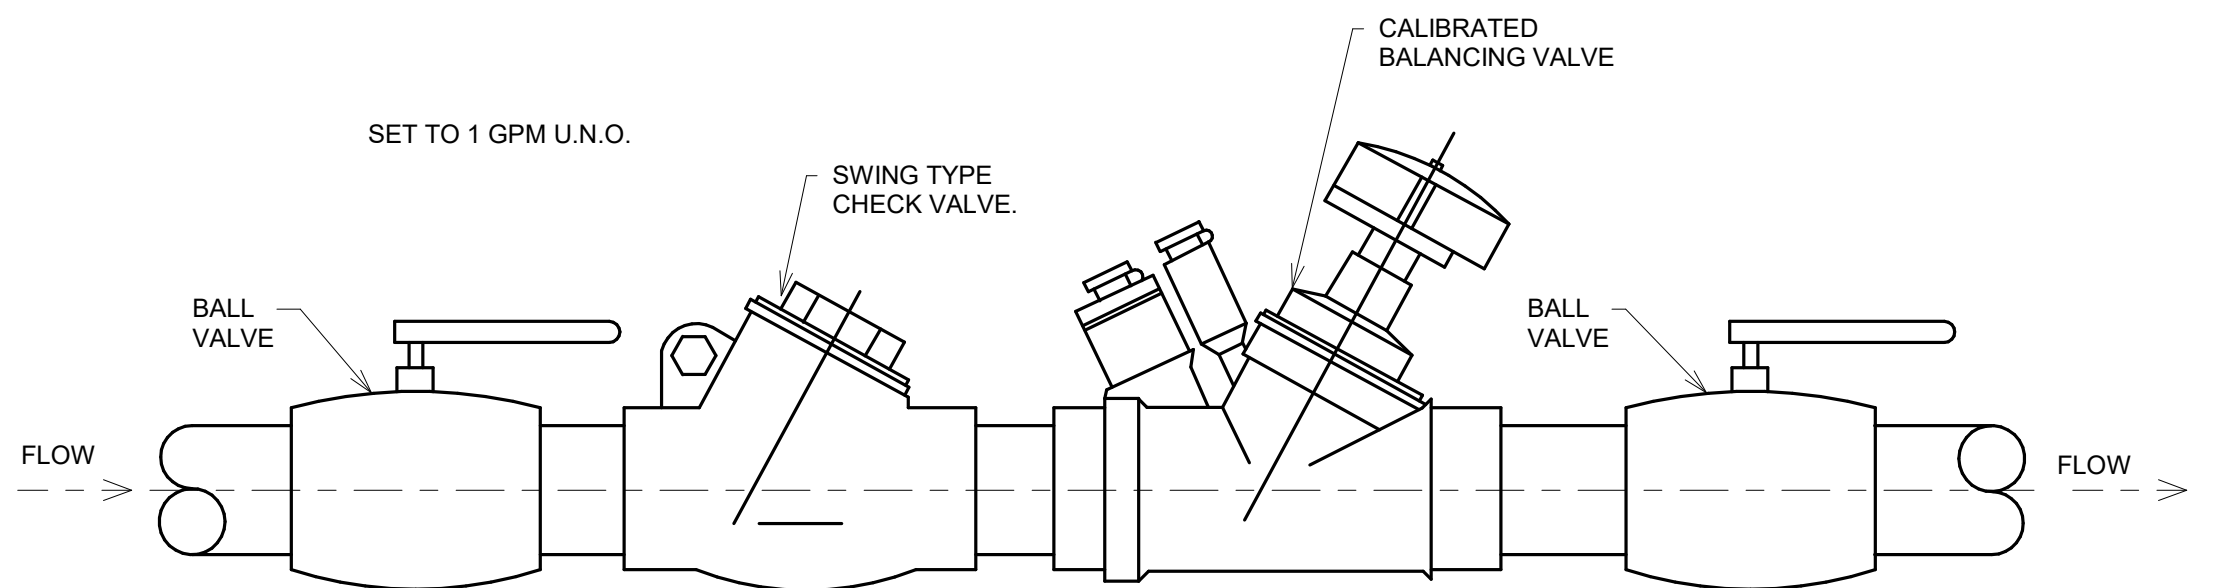

**1** BALANCING STATION  
3/4" = 1'-0"

| PLUMBING EQUIPMENT SCHEDULE |              |          |                                          |             |                                                  |
|-----------------------------|--------------|----------|------------------------------------------|-------------|--------------------------------------------------|
| IDENTITY DATA               |              |          |                                          |             |                                                  |
| MARK                        | MANUFACTURER | MODEL    | DESCRIPTION                              | LOCATION    | CAPACITY                                         |
| SI-1                        | STRIEM       | SIDEKICK | POINT OF USE SOLIDS INTERCEPTOR          | 3D ART #12E | MAX FLOW RATE: 23 GPM, SOLIDS CAPACITY: 0.17 GAL |
| SI-2                        | STRIEM       | AA-2     | AARDVARK BASKET STYLE SOLIDS INTERCEPTOR | 3D ART #12E | MAX FLOW RATE: 35 GPM, SOLIDS CAPACITY: 7 GAL    |

| COMMERCIAL WATER CLOSET SCHEDULE (224213.13) |                   |           |                                                 |              |                 |             |                         |                    |    |    |
|----------------------------------------------|-------------------|-----------|-------------------------------------------------|--------------|-----------------|-------------|-------------------------|--------------------|----|----|
| FIXTURE                                      |                   |           | FLUSHOMETER                                     |              |                 | TOILET SEAT |                         | FIXTURE CONNECTION |    |    |
| MARK                                         | MANUFACTURER      | MODEL     | DESCRIPTION                                     | MANUFACTURER | MODEL           | OPERATION   |                         | CW                 | W  | V  |
| WC-1                                         | AMERICAN STANDARD | #2257.101 | WALL-MOUNTED, TOP SPUD WATER CLOSET             | SLOAN        | REGAL #1111.1.6 | MANUAL      | CLOSED BACK, OPEN FRONT | 1"                 | 4" | 2" |
| WC-2                                         | AMERICAN STANDARD | #2257.101 | WALL-MOUNTED, TOP SPUD, ACCESSIBLE WATER CLOSET | SLOAN        | REGAL #1111.1.6 | MANUAL      | CLOSED BACK, OPEN FRONT | 1"                 | 4" | 2" |

| COMMERCIAL URINAL SCHEDULE (224213.16) |                   |           |                                             |              |                |             |                         |                    |    |        |
|----------------------------------------|-------------------|-----------|---------------------------------------------|--------------|----------------|-------------|-------------------------|--------------------|----|--------|
| FIXTURE                                |                   |           | FLUSHOMETER                                 |              |                | TOILET SEAT |                         | FIXTURE CONNECTION |    |        |
| MARK                                   | MANUFACTURER      | MODEL     | DESCRIPTION                                 | MANUFACTURER | MODEL          | OPERATION   |                         | CW                 | W  | V      |
| UR-1                                   | AMERICAN STANDARD | #6590.001 | WALL-HUNG, BACK OUTLET, WASHOUT, ACCESSIBLE | SLOAN        | REGAL #186.1.0 | MANUAL      | CLOSED BACK, OPEN FRONT | 3/4"               | 2" | 1 1/2" |
| UR-2                                   | AMERICAN STANDARD | #6590.001 | WALL-HUNG, BACK OUTLET, WASHOUT, ACCESSIBLE | SLOAN        | REGAL #186.1.0 | MANUAL      | CLOSED BACK, OPEN FRONT | 3/4"               | 2" | 1 1/2" |

| COMMERCIAL LAVATORY SCHEDULE (224216.13) |                   |                   |                                         |                |                 |             |  |                    |      |        |
|------------------------------------------|-------------------|-------------------|-----------------------------------------|----------------|-----------------|-------------|--|--------------------|------|--------|
| FIXTURE                                  |                   |                   | FAUCET                                  |                |                 | TOILET SEAT |  | FIXTURE CONNECTION |      |        |
| MARK                                     | MANUFACTURER      | MODEL             | DESCRIPTION                             | MANUFACTURER   | MODEL           | OPERATION   |  | CW                 | HW   | W      |
| L-1                                      | AMERICAN STANDARD | LUCERNE #0355.012 | VITREOUS CHINA, WALL MOUNTED, WITH BACK | CHICAGO FAUCET | #802-VE66XXABCP | MANUAL      |  | 1/2"               | 1/2" | 1 1/2" |

| COMMERCIAL SINK SCHEDULE (224216.16) |              |               |                                                                          |                |                   |             |  |                    |      |        |
|--------------------------------------|--------------|---------------|--------------------------------------------------------------------------|----------------|-------------------|-------------|--|--------------------|------|--------|
| FIXTURE                              |              |               | FAUCET                                                                   |                |                   | TOILET SEAT |  | FIXTURE CONNECTION |      |        |
| MARK                                 | MANUFACTURER | MODEL         | DESCRIPTION                                                              | MANUFACTURER   | MODEL             | OPERATION   |  | CW                 | HW   | W      |
| MB-1                                 | ZURN         | #Z1996-24     | MOLDED STONE, FLOOR MOUNTED (RECESSED), MOP BASIN                        | CHICAGO FAUCET | #891-ABRCF        |             |  | 3/4"               | 3/4" | 3"     |
| SK-1                                 | N/A          | N/A           | N/A                                                                      | CHICAGO FAUCET | #786-GN8AE3XXABCP |             |  | 1/2"               | 1/2" | 0"     |
| SK-2                                 | ELKAY        | #LRAD332265   | STAINLESS STEEL, TWO BOWLS, COUNTER MOUNTED SINK                         | CHICAGO FAUCET | #786-GN8AE3XXABCP |             |  | 1/2"               | 1/2" | 1 1/2" |
| SK-3                                 | ELKAY        | #DXUH2115     | SINGLE BOWL, UNDERMOUNT, ADA COMPLIANT                                   | CHICAGO FAUCET | #786-GN8AE3XXABCP |             |  | 1/2"               | 1/2" | 0"     |
| SK-4                                 | ELKAY        | #14-2C2A24-0X | STAINLESS STEEL, 16 GAUGE TWO COMPARTMENT SINK WITH STAINLESS STEEL LEGS | CHICAGO FAUCET | #631-L12ES5ABCP   |             |  | 1/2"               | 1/2" | 1 1/2" |
| SK-5                                 | ELKAY        | #LR3322       | STAINLESS STEEL, TWO BOWLS, COUNTER MOUNTED SINK                         | CHICAGO FAUCET | #786-GN8AE3XXABCP |             |  | 1/2"               | 1/2" | 1 1/2" |
| SK-6                                 | ELKAY        | #LR3322       | STAINLESS STEEL, TWO BOWLS, COUNTER MOUNTED SINK                         | CHICAGO FAUCET | #786-GN8AE3XXABCP |             |  | 1/2"               | 1/2" | 1 1/2" |

| DOMESTIC WATER PIPING SPECIALTIES SCHEDULE (221119) |                 |           |                            |              |       |             |  |                    |      |    |
|-----------------------------------------------------|-----------------|-----------|----------------------------|--------------|-------|-------------|--|--------------------|------|----|
| IDENTITY DATA                                       |                 |           | FAUCET                     |              |       | TOILET SEAT |  | FIXTURE CONNECTION |      |    |
| MARK                                                | MANUFACTURER    | MODEL     | DESCRIPTION                | MANUFACTURER | MODEL | OPERATION   |  | CW                 | HW   | W  |
| IS-1                                                | ZURN            | #Z1330-AL | HOSE BIB WITH RECESSED BOX |              |       |             |  | 3/4"               |      |    |
| IMB-1                                               | GLY GRAY        | #SSIB2AB  | ICE MAKER OUTLET BOX       |              |       |             |  | 1/2"               |      |    |
| WMB-1                                               | IPS CORPORATION | #SSWB2    | CLOTHES WASHER OUTLET BOX  |              |       |             |  | 3/4"               | 3/4" | 2" |

| PRESSURE WATER COOLER SCHEDULE (224716) |              |              |                                                                                                                                                                                                                                                                                                      |              |       |             |  |                    |        |        |
|-----------------------------------------|--------------|--------------|------------------------------------------------------------------------------------------------------------------------------------------------------------------------------------------------------------------------------------------------------------------------------------------------------|--------------|-------|-------------|--|--------------------|--------|--------|
| IDENTITY DATA                           |              |              | FAUCET                                                                                                                                                                                                                                                                                               |              |       | TOILET SEAT |  | FIXTURE CONNECTION |        |        |
| MARK                                    | MANUFACTURER | MODEL        | DESCRIPTION                                                                                                                                                                                                                                                                                          | MANUFACTURER | MODEL | OPERATION   |  | CW                 | HW     | W      |
| EW-1                                    | ELKAY        | #LVRGCRNBWSK | REFRIGERATED ELECTRIC WATER COOLER/BOTTLE FILLER, SATIN FINISHED STAINLESS STEEL BOWL AND CABINET, BOTTLE FILLING UNIT INCLUDES AN ELECTRONIC SENSOR FOR NO-TOUCH ACTIVATION, FILTERED, TRIM ADJUSTABLE P-TRAP WITH CLEANOUT, 1/2" ANGLE STOP WITH LOOSE KEY HANDLE, 1/2" O.D. CHROME PLATED SUPPLY. |              |       |             |  | 3/4"               | 1 1/2" | 1 1/2" |

| SHOWER SCHEDULE (224223) |              |                               |                                                                      |              |       |             |  |                    |      |   |
|--------------------------|--------------|-------------------------------|----------------------------------------------------------------------|--------------|-------|-------------|--|--------------------|------|---|
| IDENTITY DATA            |              |                               | FAUCET                                                               |              |       | TOILET SEAT |  | FIXTURE CONNECTION |      |   |
| MARK                     | MANUFACTURER | MODEL                         | DESCRIPTION                                                          | MANUFACTURER | MODEL | OPERATION   |  | CW                 | HW   | W |
| SH-1                     | BRADLEY      | #WS-1WCA-EF-ES-ST-RSD-VS      | SURFACE MOUNTED SHOWER VALVE AND HEAD                                |              |       |             |  | 3/4"               | 3/4" |   |
| SH-2                     | BRADLEY      | #WS-1X-HN-EF-ST-S20-RSD-SL-VS | SURFACE MOUNTED SHOWER VALVE AND HEAD WITH HAND HELD SHOWER AND TRIM |              |       |             |  | 3/4"               | 3/4" |   |

| WATER HAMMER ARRESTER (221119) |      |             |                |          |          |
|--------------------------------|------|-------------|----------------|----------|----------|
| MARK                           | IPS  | F.U. RATING | J.R. SMITH NO. | WADE NO. | ZURN NO. |
| A                              | 3/4" | 1-11        | 5005           | W-5      | 100      |
| B                              | 1"   | 12-32       | 5010           | W-10     | 200      |
| C                              | 1"   | 33-60       | 5020           | W-20     | 300      |
| D                              | 1"   | 61-113      | 5030           | W-30     | 400      |
| E                              | 1"   | 114-154     | 5040           | W-75     | 500      |

| SANITARY WASTE PIPING SPECIALTIES SCHEDULE (221319) |              |                   |                                                                                                                                                                 |                          |        |                                                                                                                                                                   |  |                    |    |   |
|-----------------------------------------------------|--------------|-------------------|-----------------------------------------------------------------------------------------------------------------------------------------------------------------|--------------------------|--------|-------------------------------------------------------------------------------------------------------------------------------------------------------------------|--|--------------------|----|---|
| IDENTITY DATA                                       |              |                   | FAUCET                                                                                                                                                          |                          |        | TOILET SEAT                                                                                                                                                       |  | FIXTURE CONNECTION |    |   |
| MARK                                                | MANUFACTURER | MODEL             | DESCRIPTION                                                                                                                                                     | MANUFACTURER             | MODEL  | OPERATION                                                                                                                                                         |  | CW                 | HW | W |
| FD-1                                                | ZURN         | #Z415B-2B         | DUOCO CAST IRON BODY WITH FLASHING COLLAR, ADJUSTABLE ROUND STRAINER HEAD, POLISHED BRONZE STRAINER                                                             |                          |        |                                                                                                                                                                   |  | 2"                 |    |   |
| FS-1                                                | J.R. SMITH   | #3003-09-12-SBR-C | STAINLESS STEEL, 1/2" STAINLESS STEEL GRATE AND SEDIMENT BUCKET                                                                                                 |                          |        |                                                                                                                                                                   |  | 2"                 |    |   |
| TD-1                                                | ZURN         | #Z588B-36         | 36" STAINLESS STEEL LINEAR SHOWER DRAIN, TYPE 304 SS, COMPLETE WITH VERTICAL ADJUSTABLE ANCHORING SUPPORT LEGS, NO HUB CENTER OUTLET AND STANDARD SLOTTED GRATE |                          |        |                                                                                                                                                                   |  | 2"                 |    |   |
| TD-2                                                | DURA TRENCH  | #STD3V04          | 4" WIDE PRESLOPED POLYESTER FIBER REINFORCED POLYMER CONCRETE TRENCH BODY, PROVIDE THE FOLLOWING                                                                |                          |        |                                                                                                                                                                   |  | 2"                 |    |   |
|                                                     |              |                   | PART NAME: FRAME                                                                                                                                                | PART NUMBER: #337G31V03B | QTY: 8 | DESCRIPTION: GRAY THERMOPLASTIC GRATE SUPPORT FRAME FOR 3/4" THICK GRATES, 8' LONG Z PROFILE WITH CONTINUOUS ANCHORING RIB AND RIGID METAL INSTALLATION BRACKETS. |  |                    |    |   |
|                                                     |              |                   | GRATE                                                                                                                                                           | #05SLHM24TGA             | 11     | GRAY PLASTIC ADA COMPLIANT AND HEEL PROOF GRATE - 5" WIDE x 24" LONG x 0.75" THICK.                                                                               |  |                    |    |   |
|                                                     |              |                   | LOCK                                                                                                                                                            | #C2.06                   | 11     | TWO STAINLESS STEEL NON-RIGID CLIP LOCKS PER GRATE WITH #5-32 x 1/4" ROUND HEAD STAINLESS STEEL THREAD CUTTING SCREW.                                             |  |                    |    |   |




| REVISIONS:                  |  | Date       | Desc:        |
|-----------------------------|--|------------|--------------|
| #                           |  |            |              |
| 1                           |  | 09-25-2026 | Addendum #03 |
| 100% CONSTRUCTION DOCUMENTS |  |            |              |
| PROJECT: #24173P            |  |            |              |
| DATE: 08-21-2026            |  |            |              |
| DRAWN BY: IOP               |  |            |              |


PLUMBING  
SCHEDULES  
AND DETAILS

PLUMBING ISOMETRIC PLAN NOTES


1 SEE FOOD SERVICE DRAWINGS FOR FIXTURES AND FINAL CONNECTION INFORMATION.

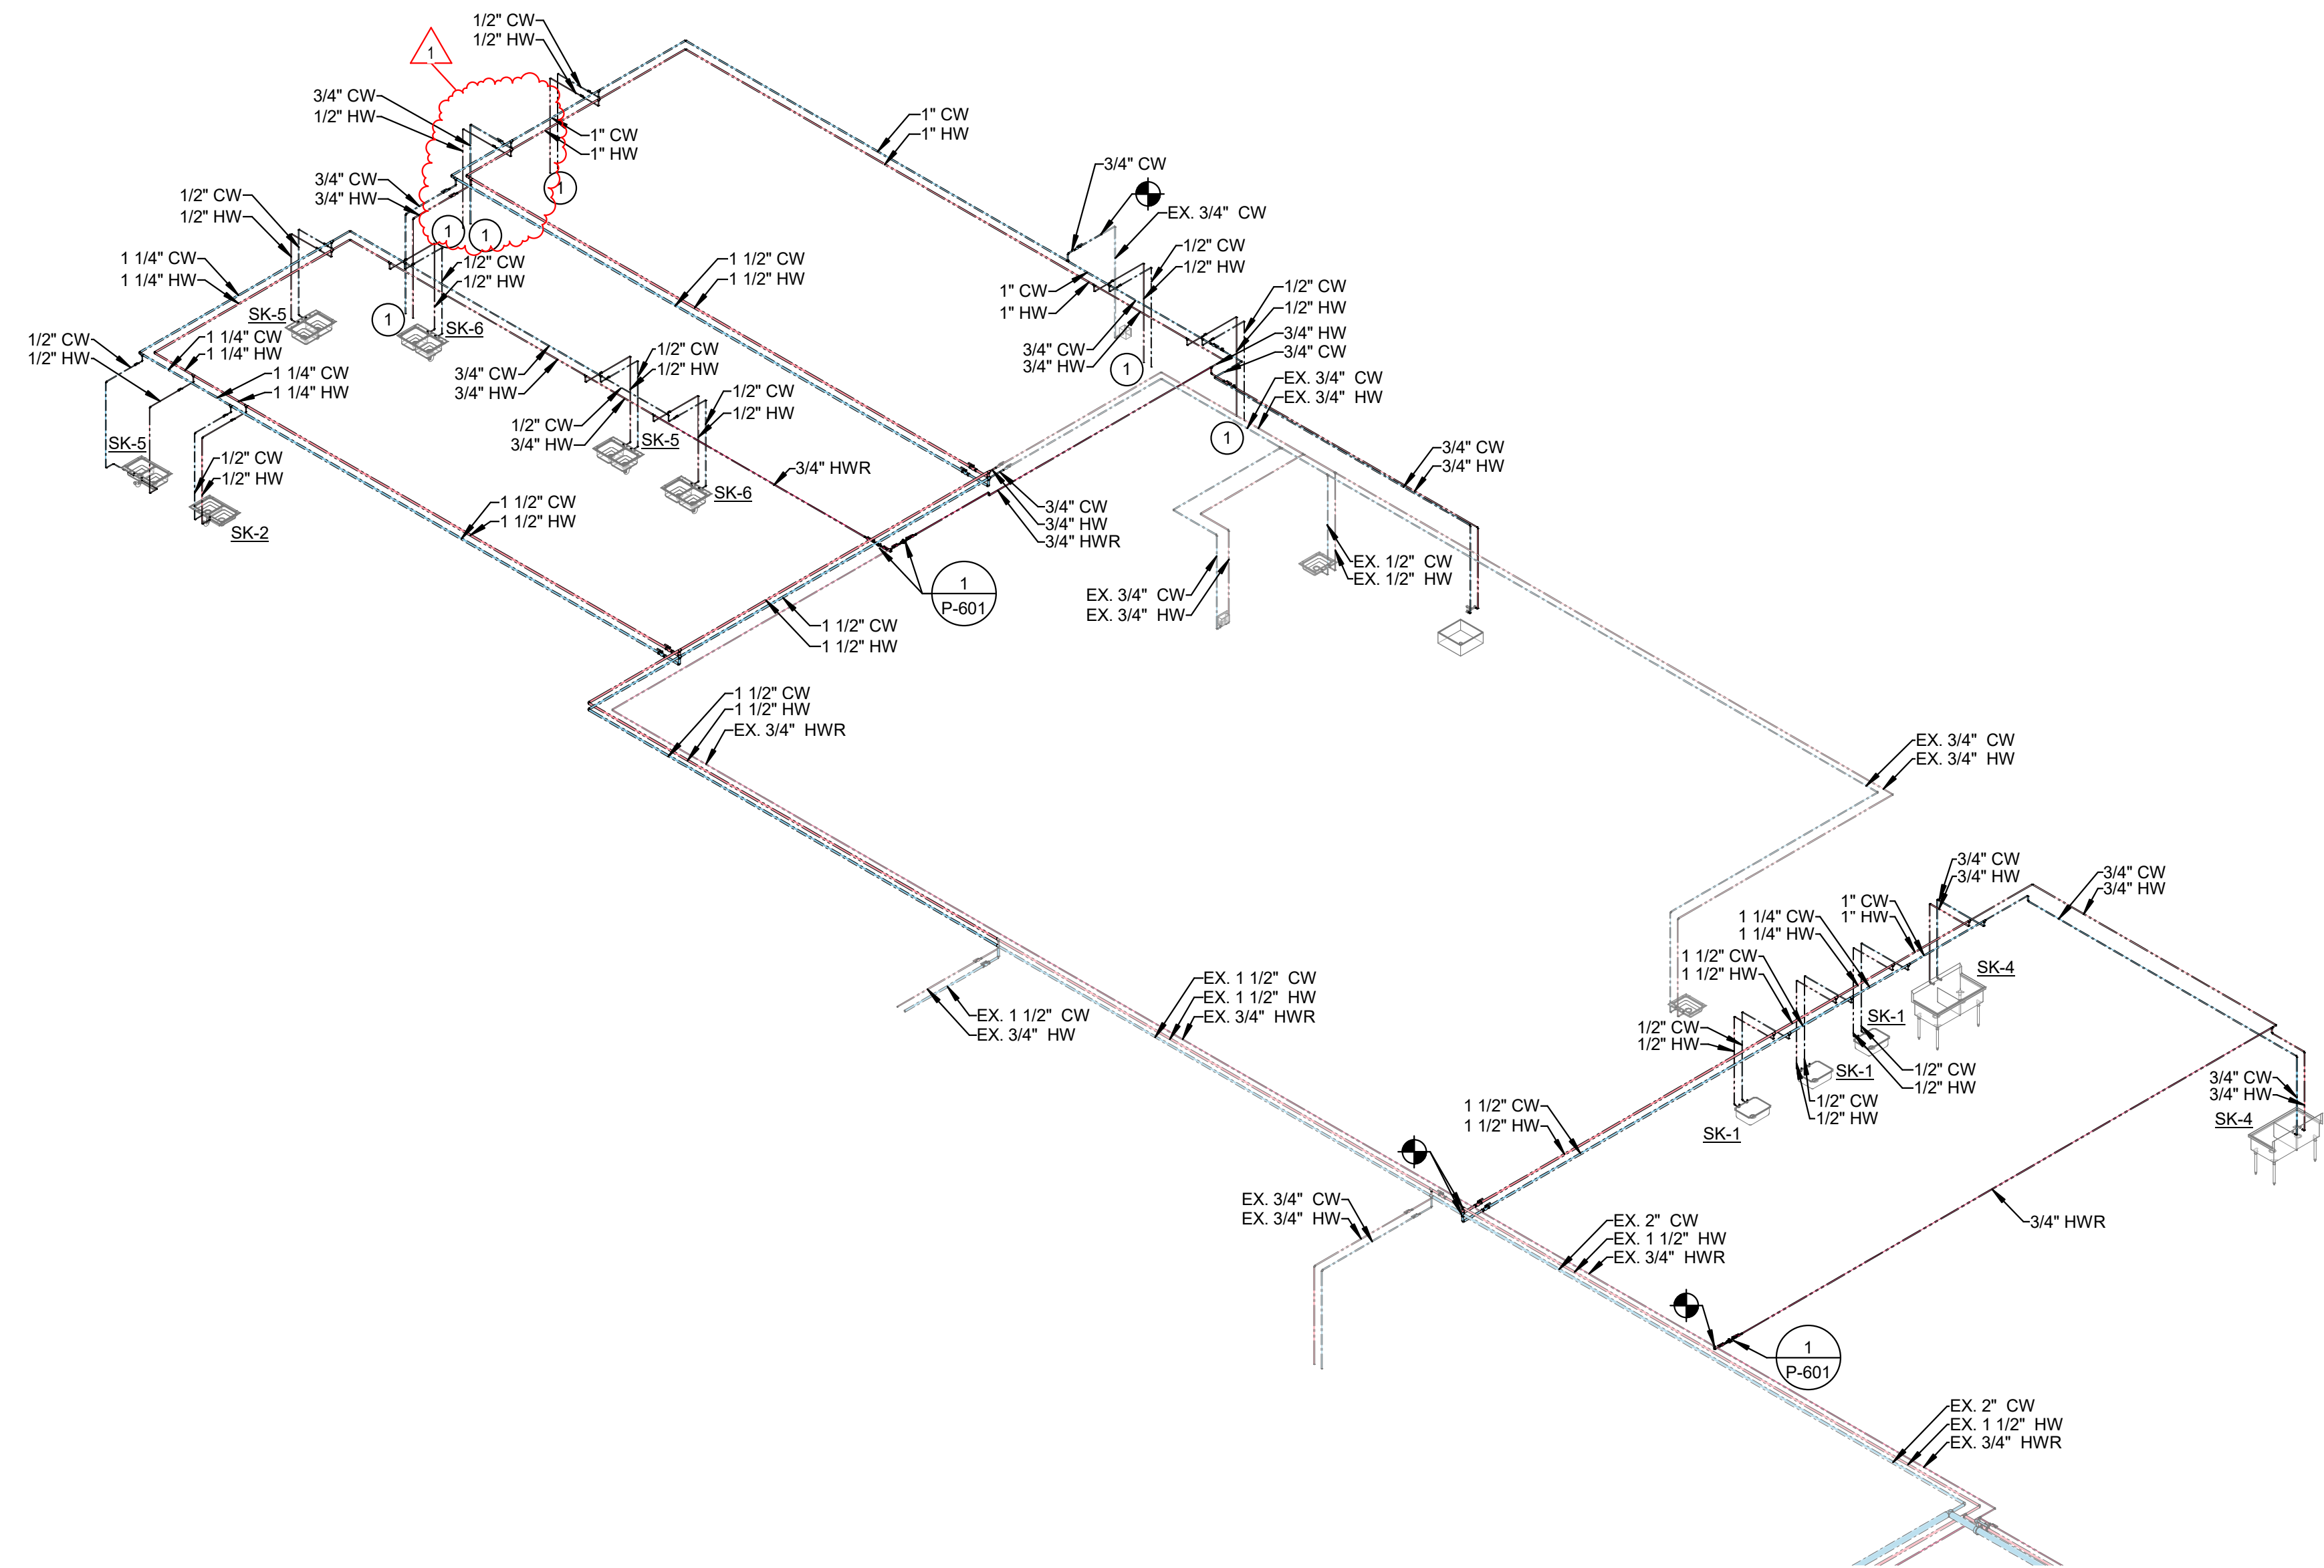



3 DOMESTIC WATER ISOMETRIC - UNIT A

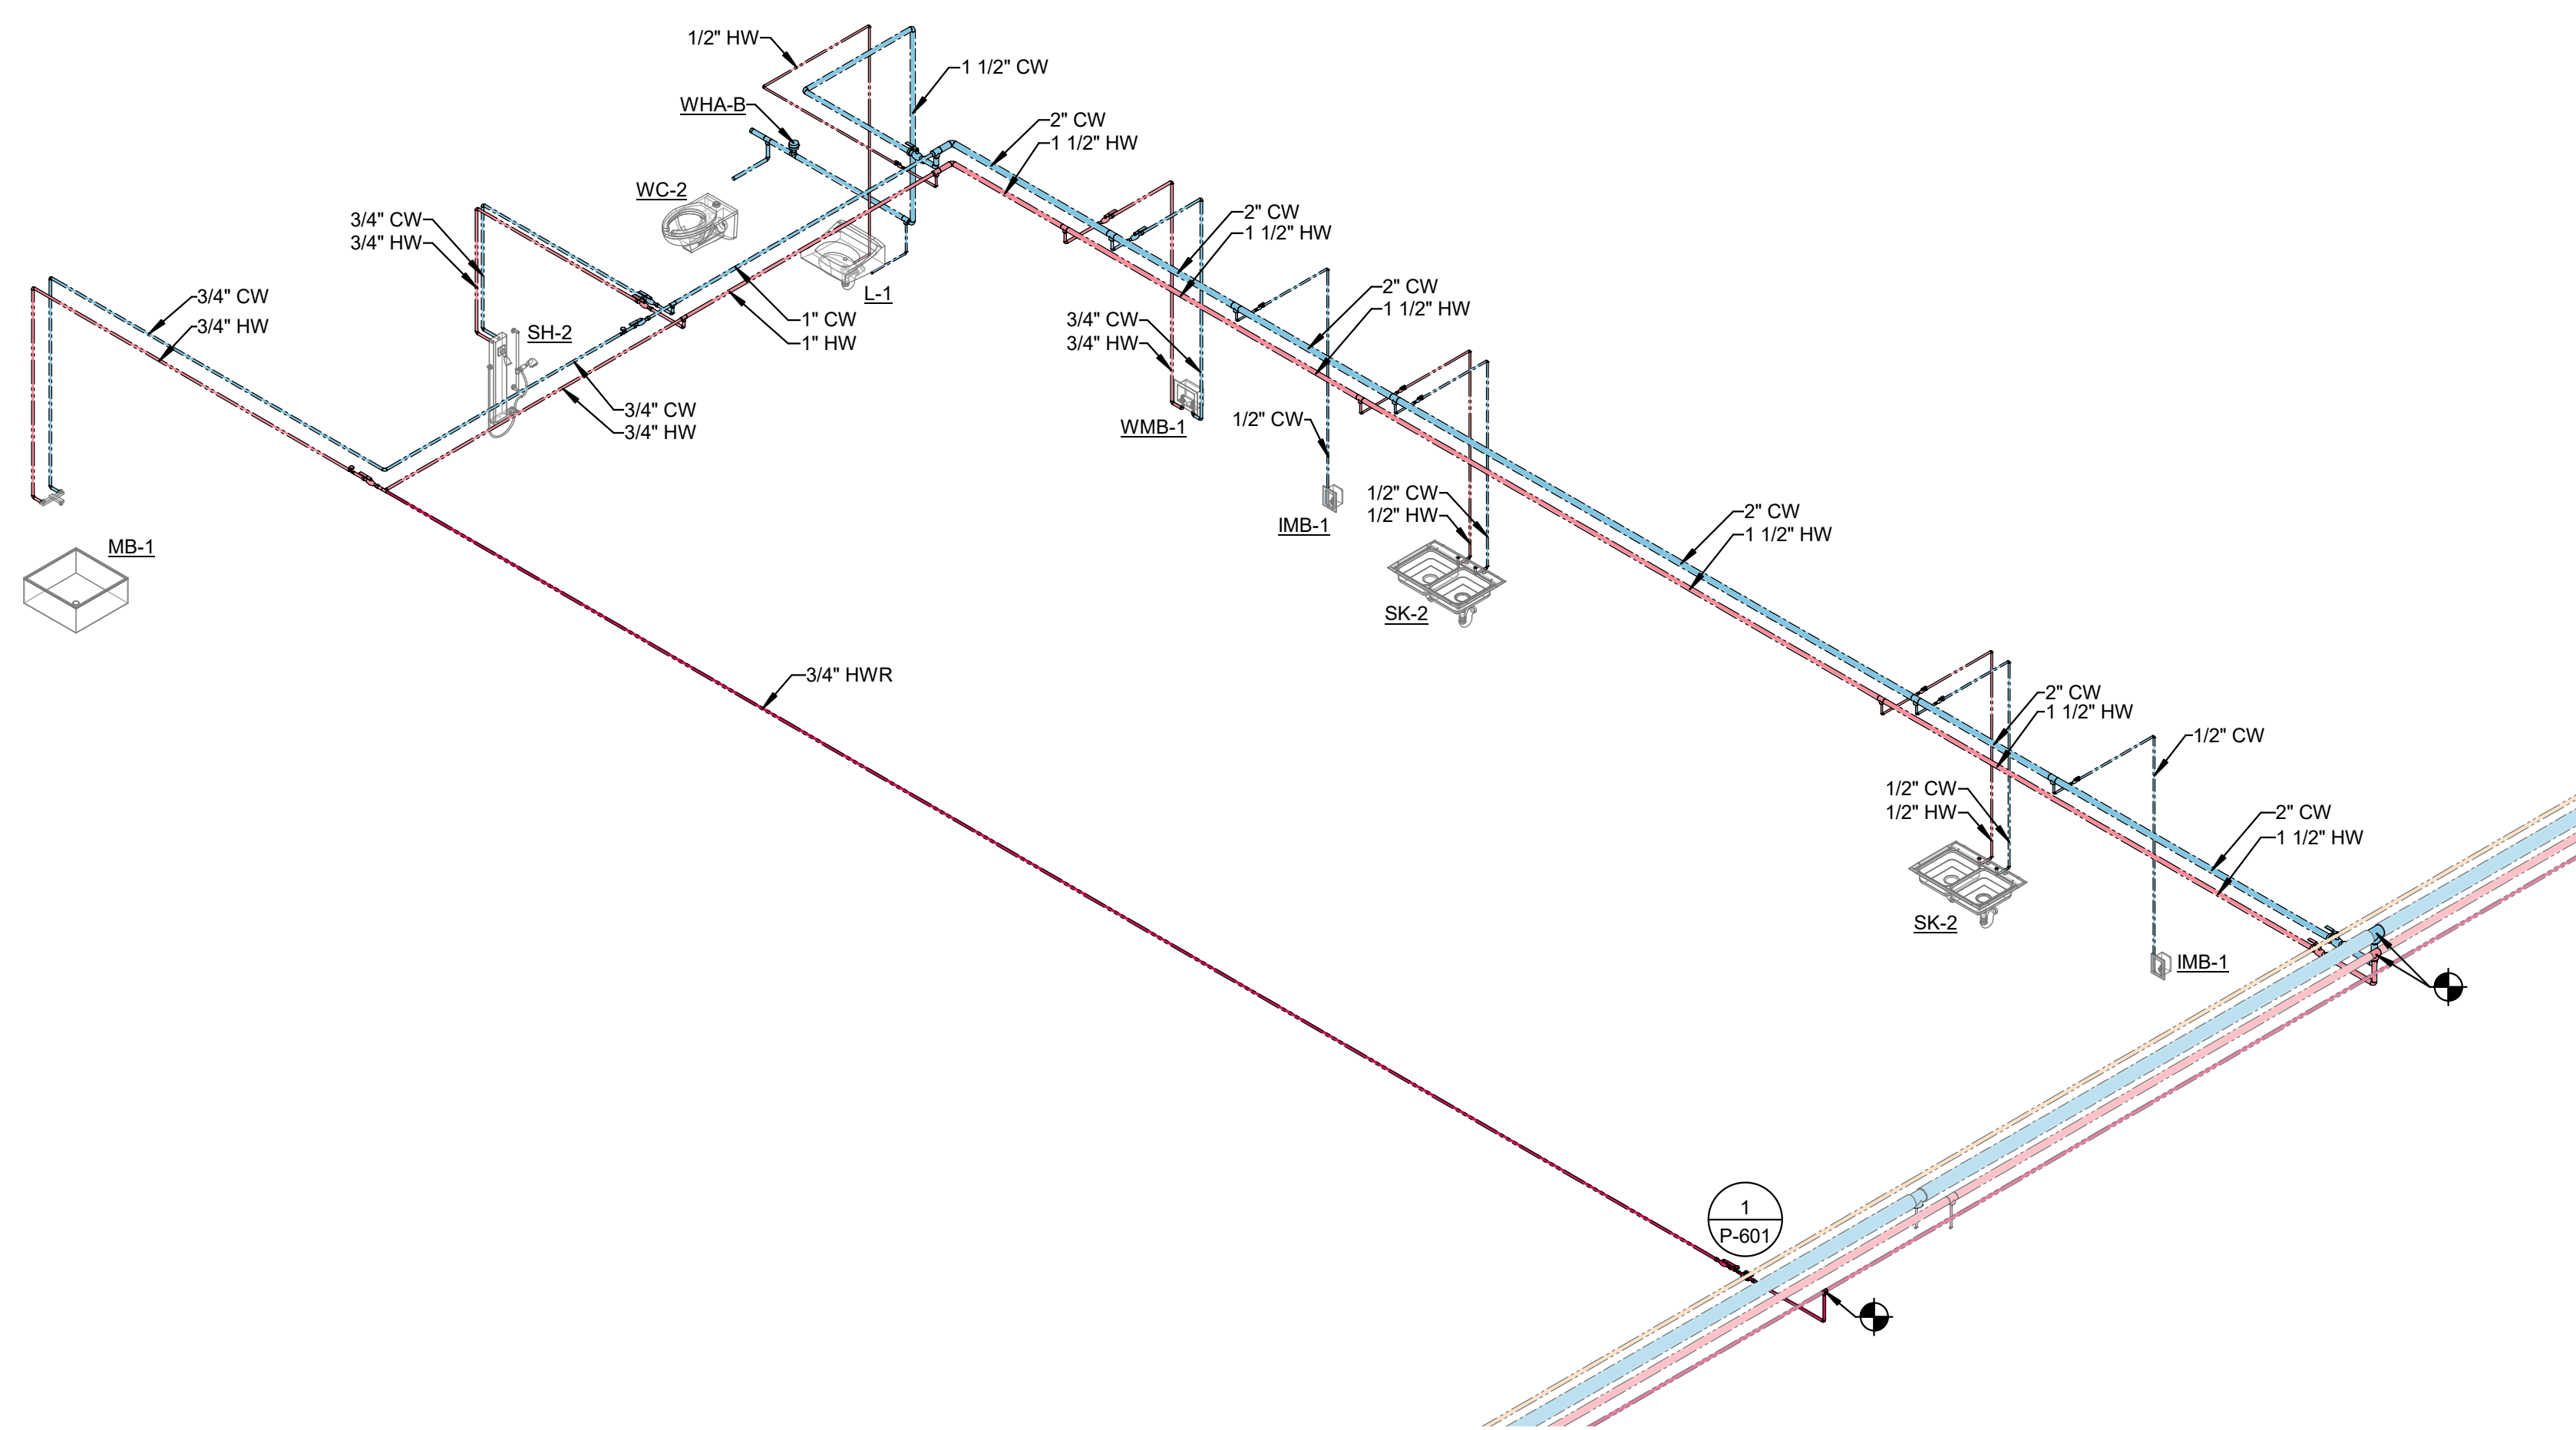

2 DOMESTIC WATER ISOMETRIC - UNIT B

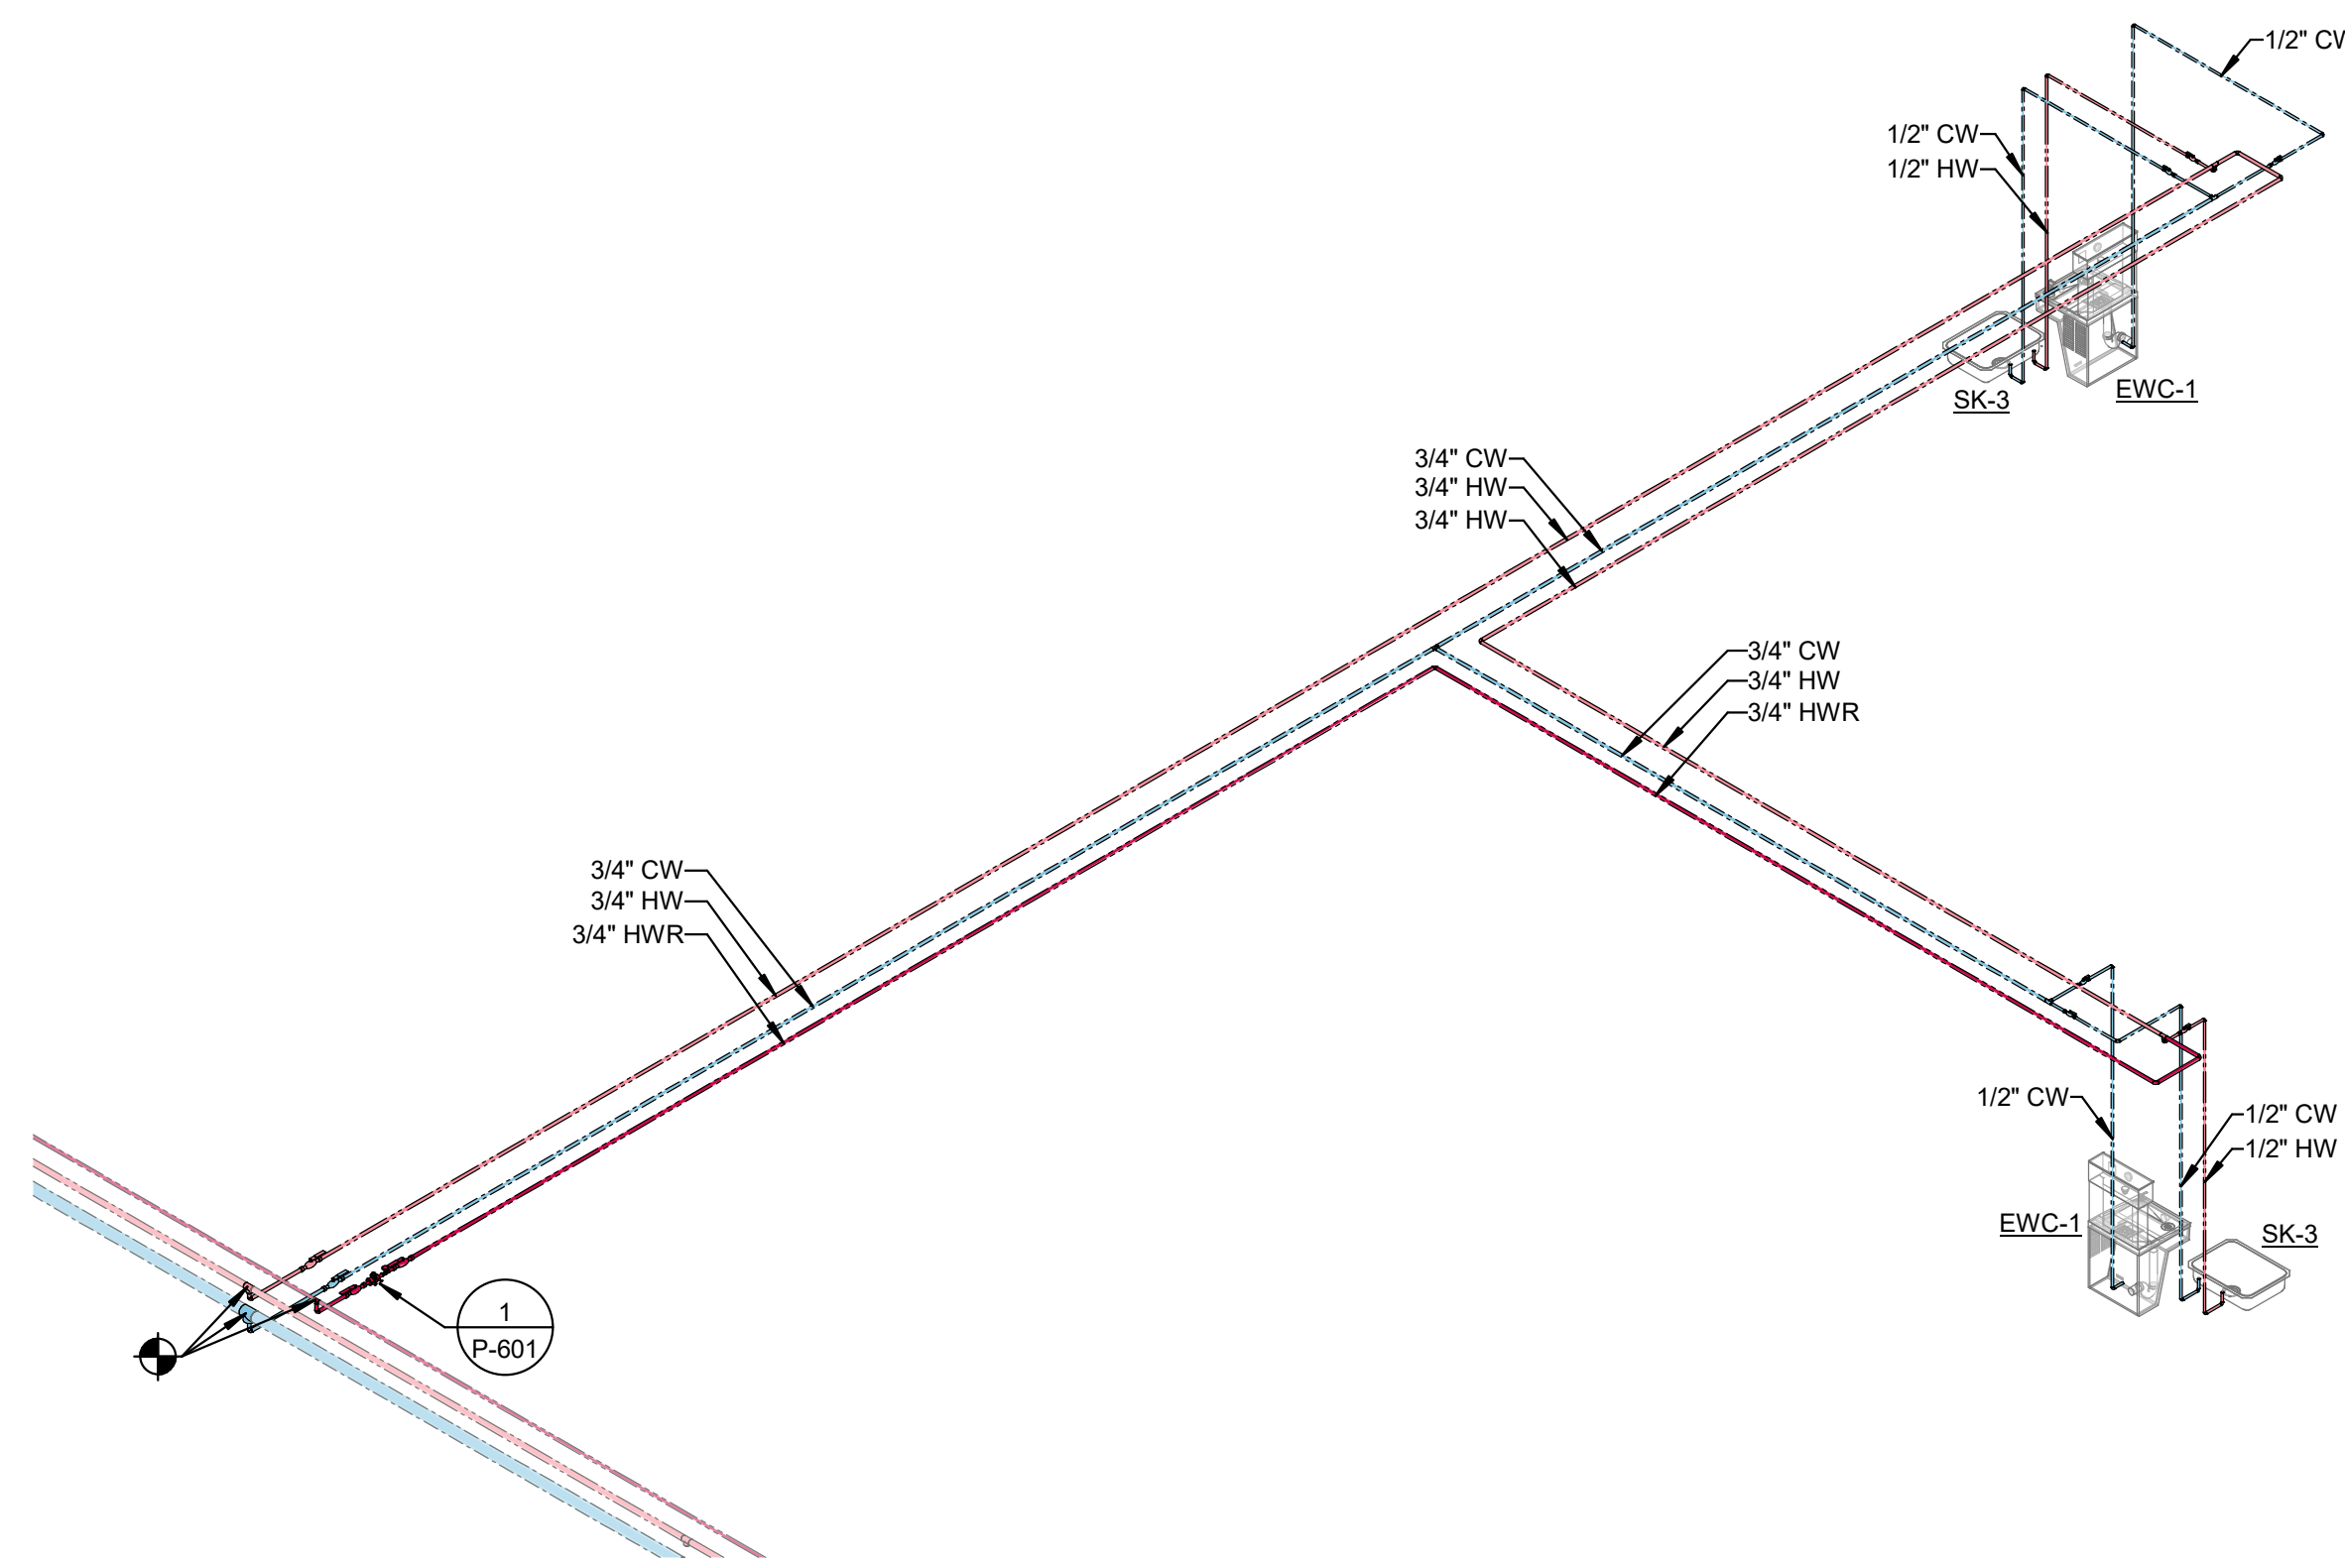

1 DOMESTIC WATER ISOMETRIC - UNIT D

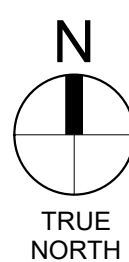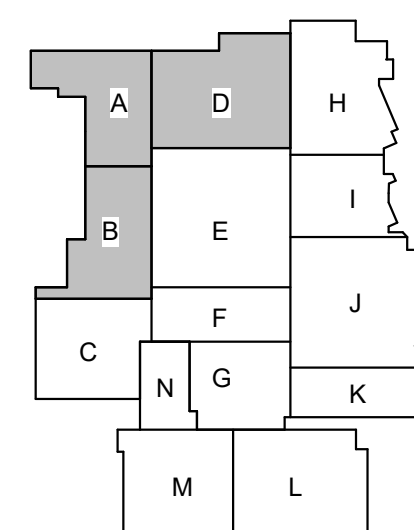

PERRY TOWNSHIP SCHOOLS  
PERRY MERIDIAN HS PHASE II RENOVATIONS (VOL 1)  
401 W MERIDIAN SCHOOL RD,  
INDIANAPOLIS, IN 46217



| REVISE | DATE       | BY           | DESC |
|--------|------------|--------------|------|
| 1      | 09-23-2026 | ADDENDUM #03 |      |

100% CONSTRUCTION DOCUMENTS

PROJECT: #24173P  
DATE: 08-21-2026  
DRAWN BY: IOP


PLUMBING  
DOMESTIC  
WATER  
ISOMETRICS

P-901


LANCER ASSOCIATES  
ARCHITECTURE




145 N EAST ST.  
INDIANAPOLIS, IN 46204

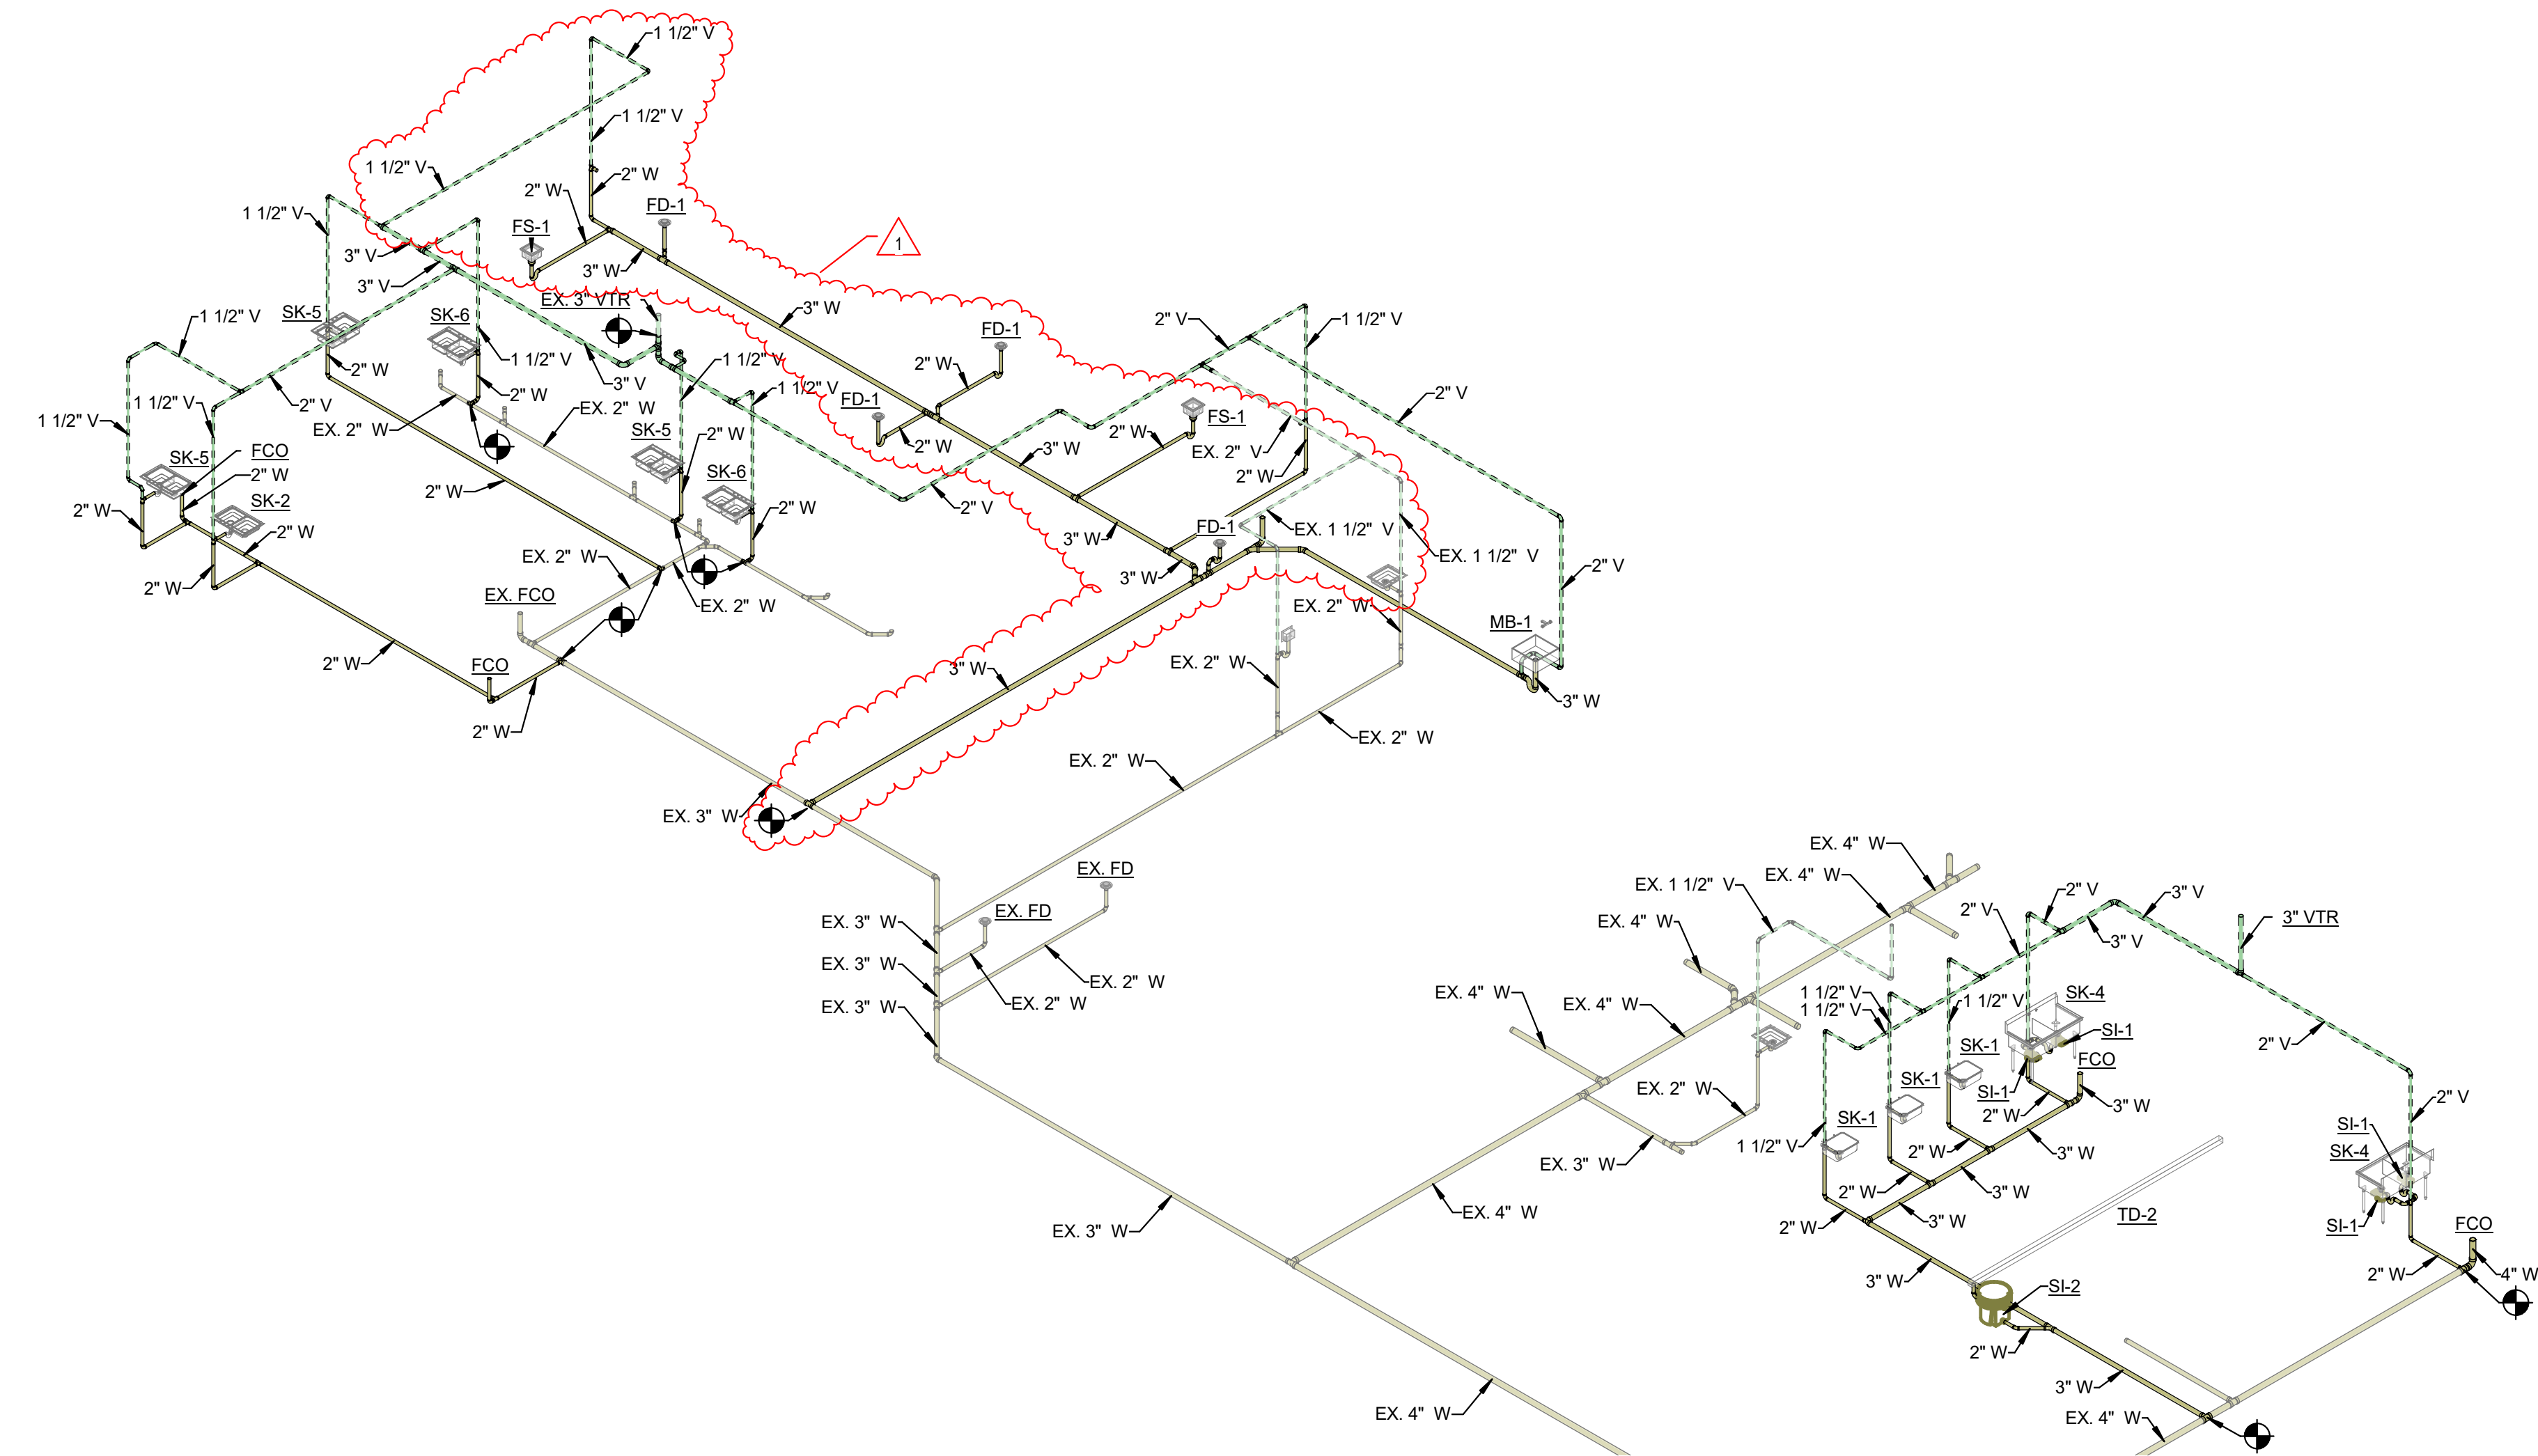



3 WASTE AND VENT ISOMETRIC - UNIT A

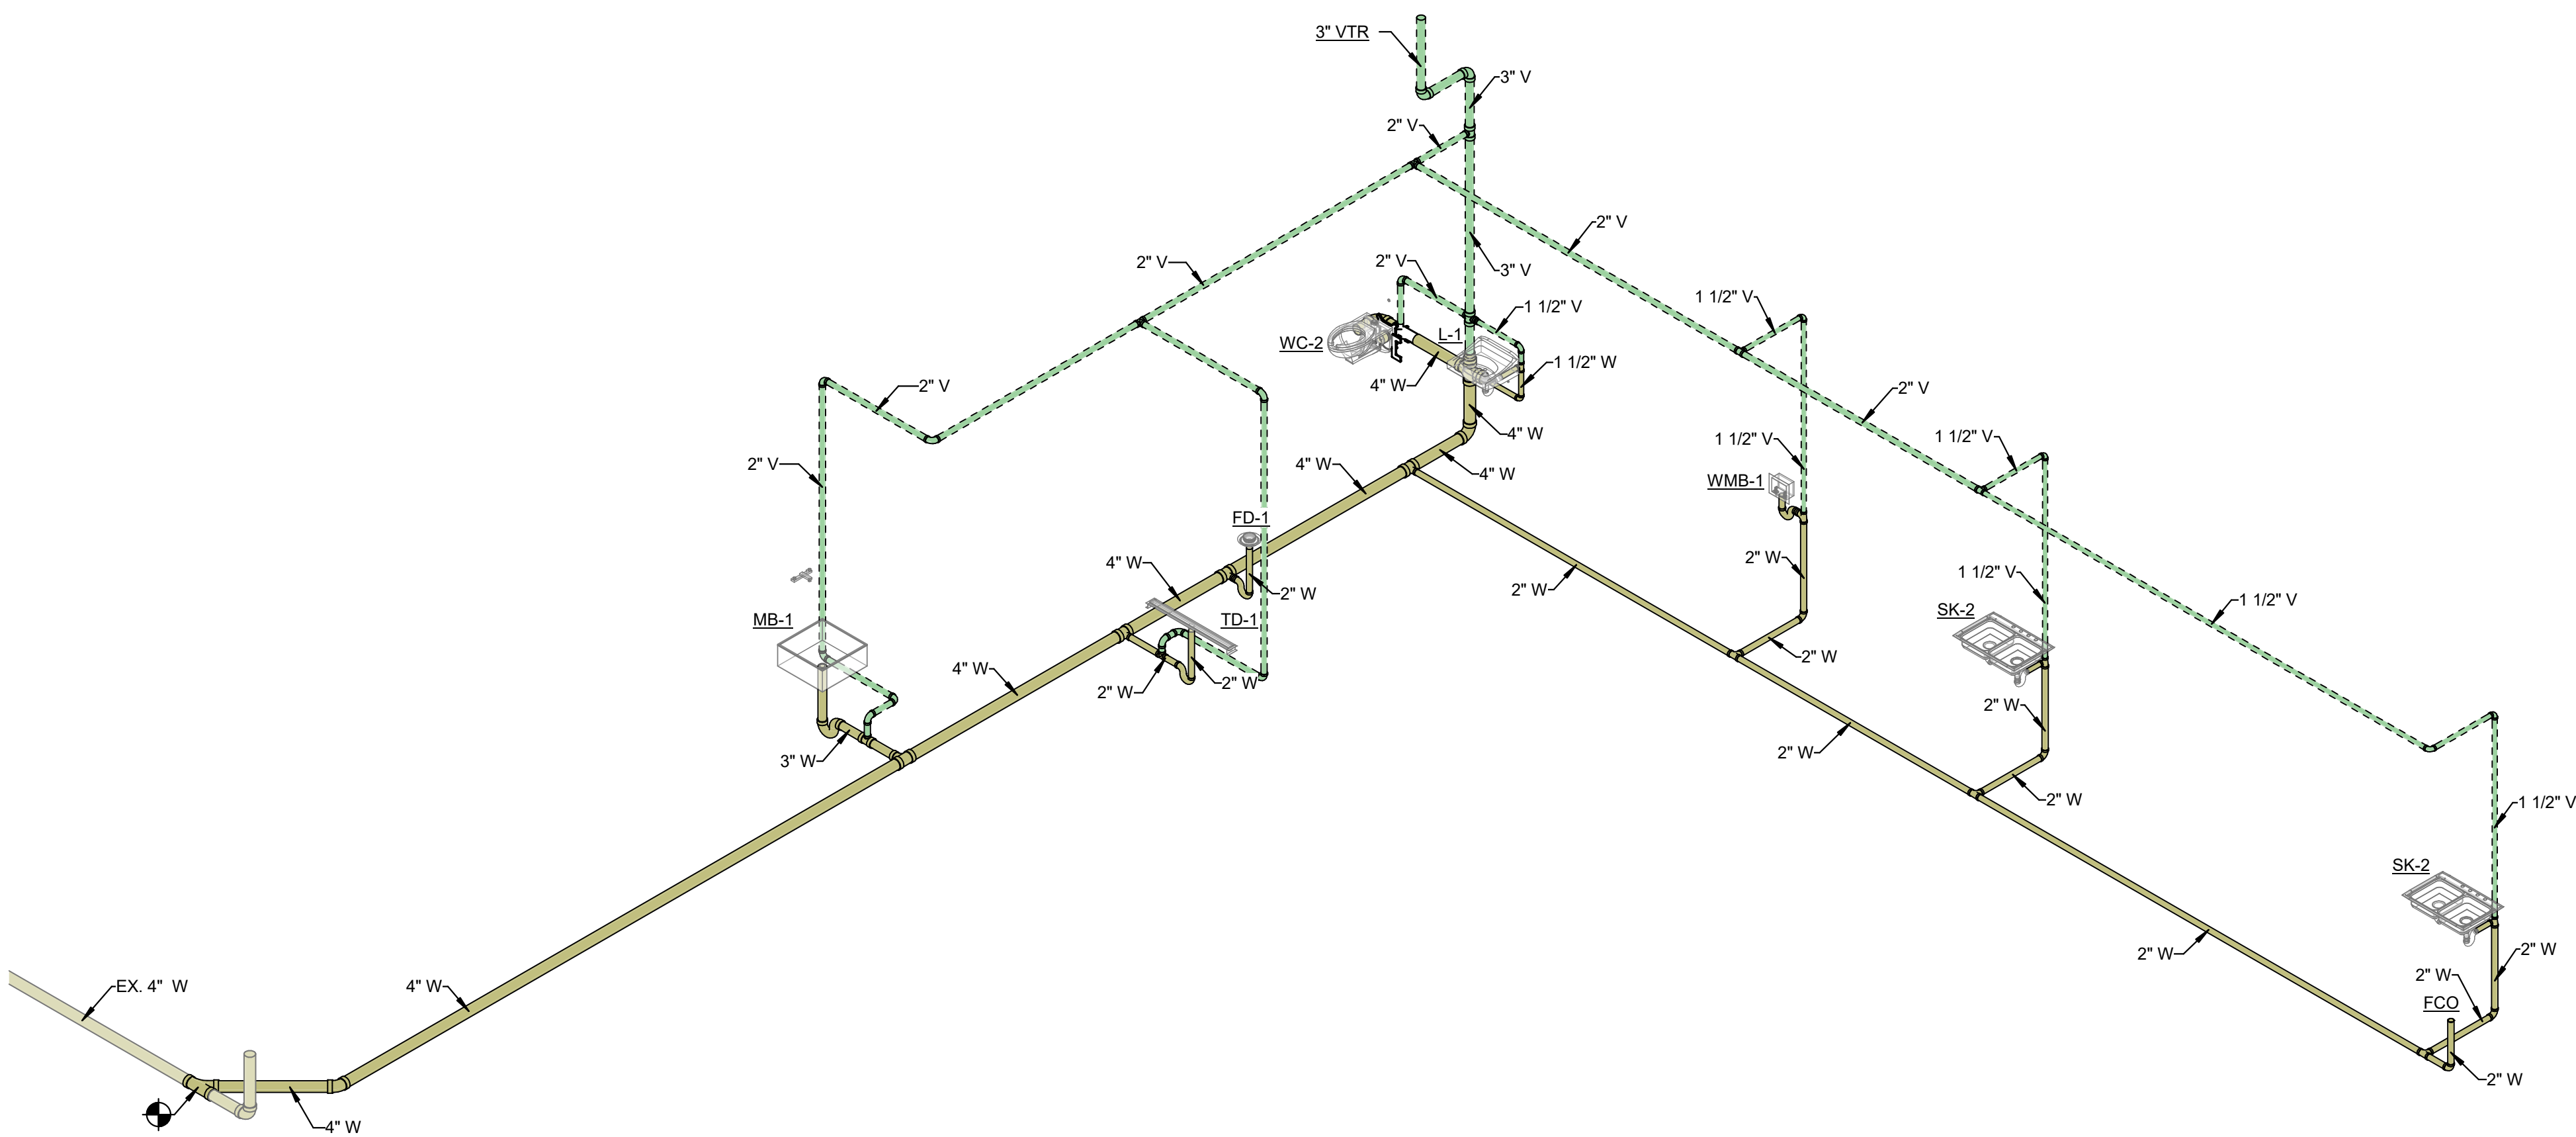

2 WASTE AND VENT ISOMETRIC - UNIT B

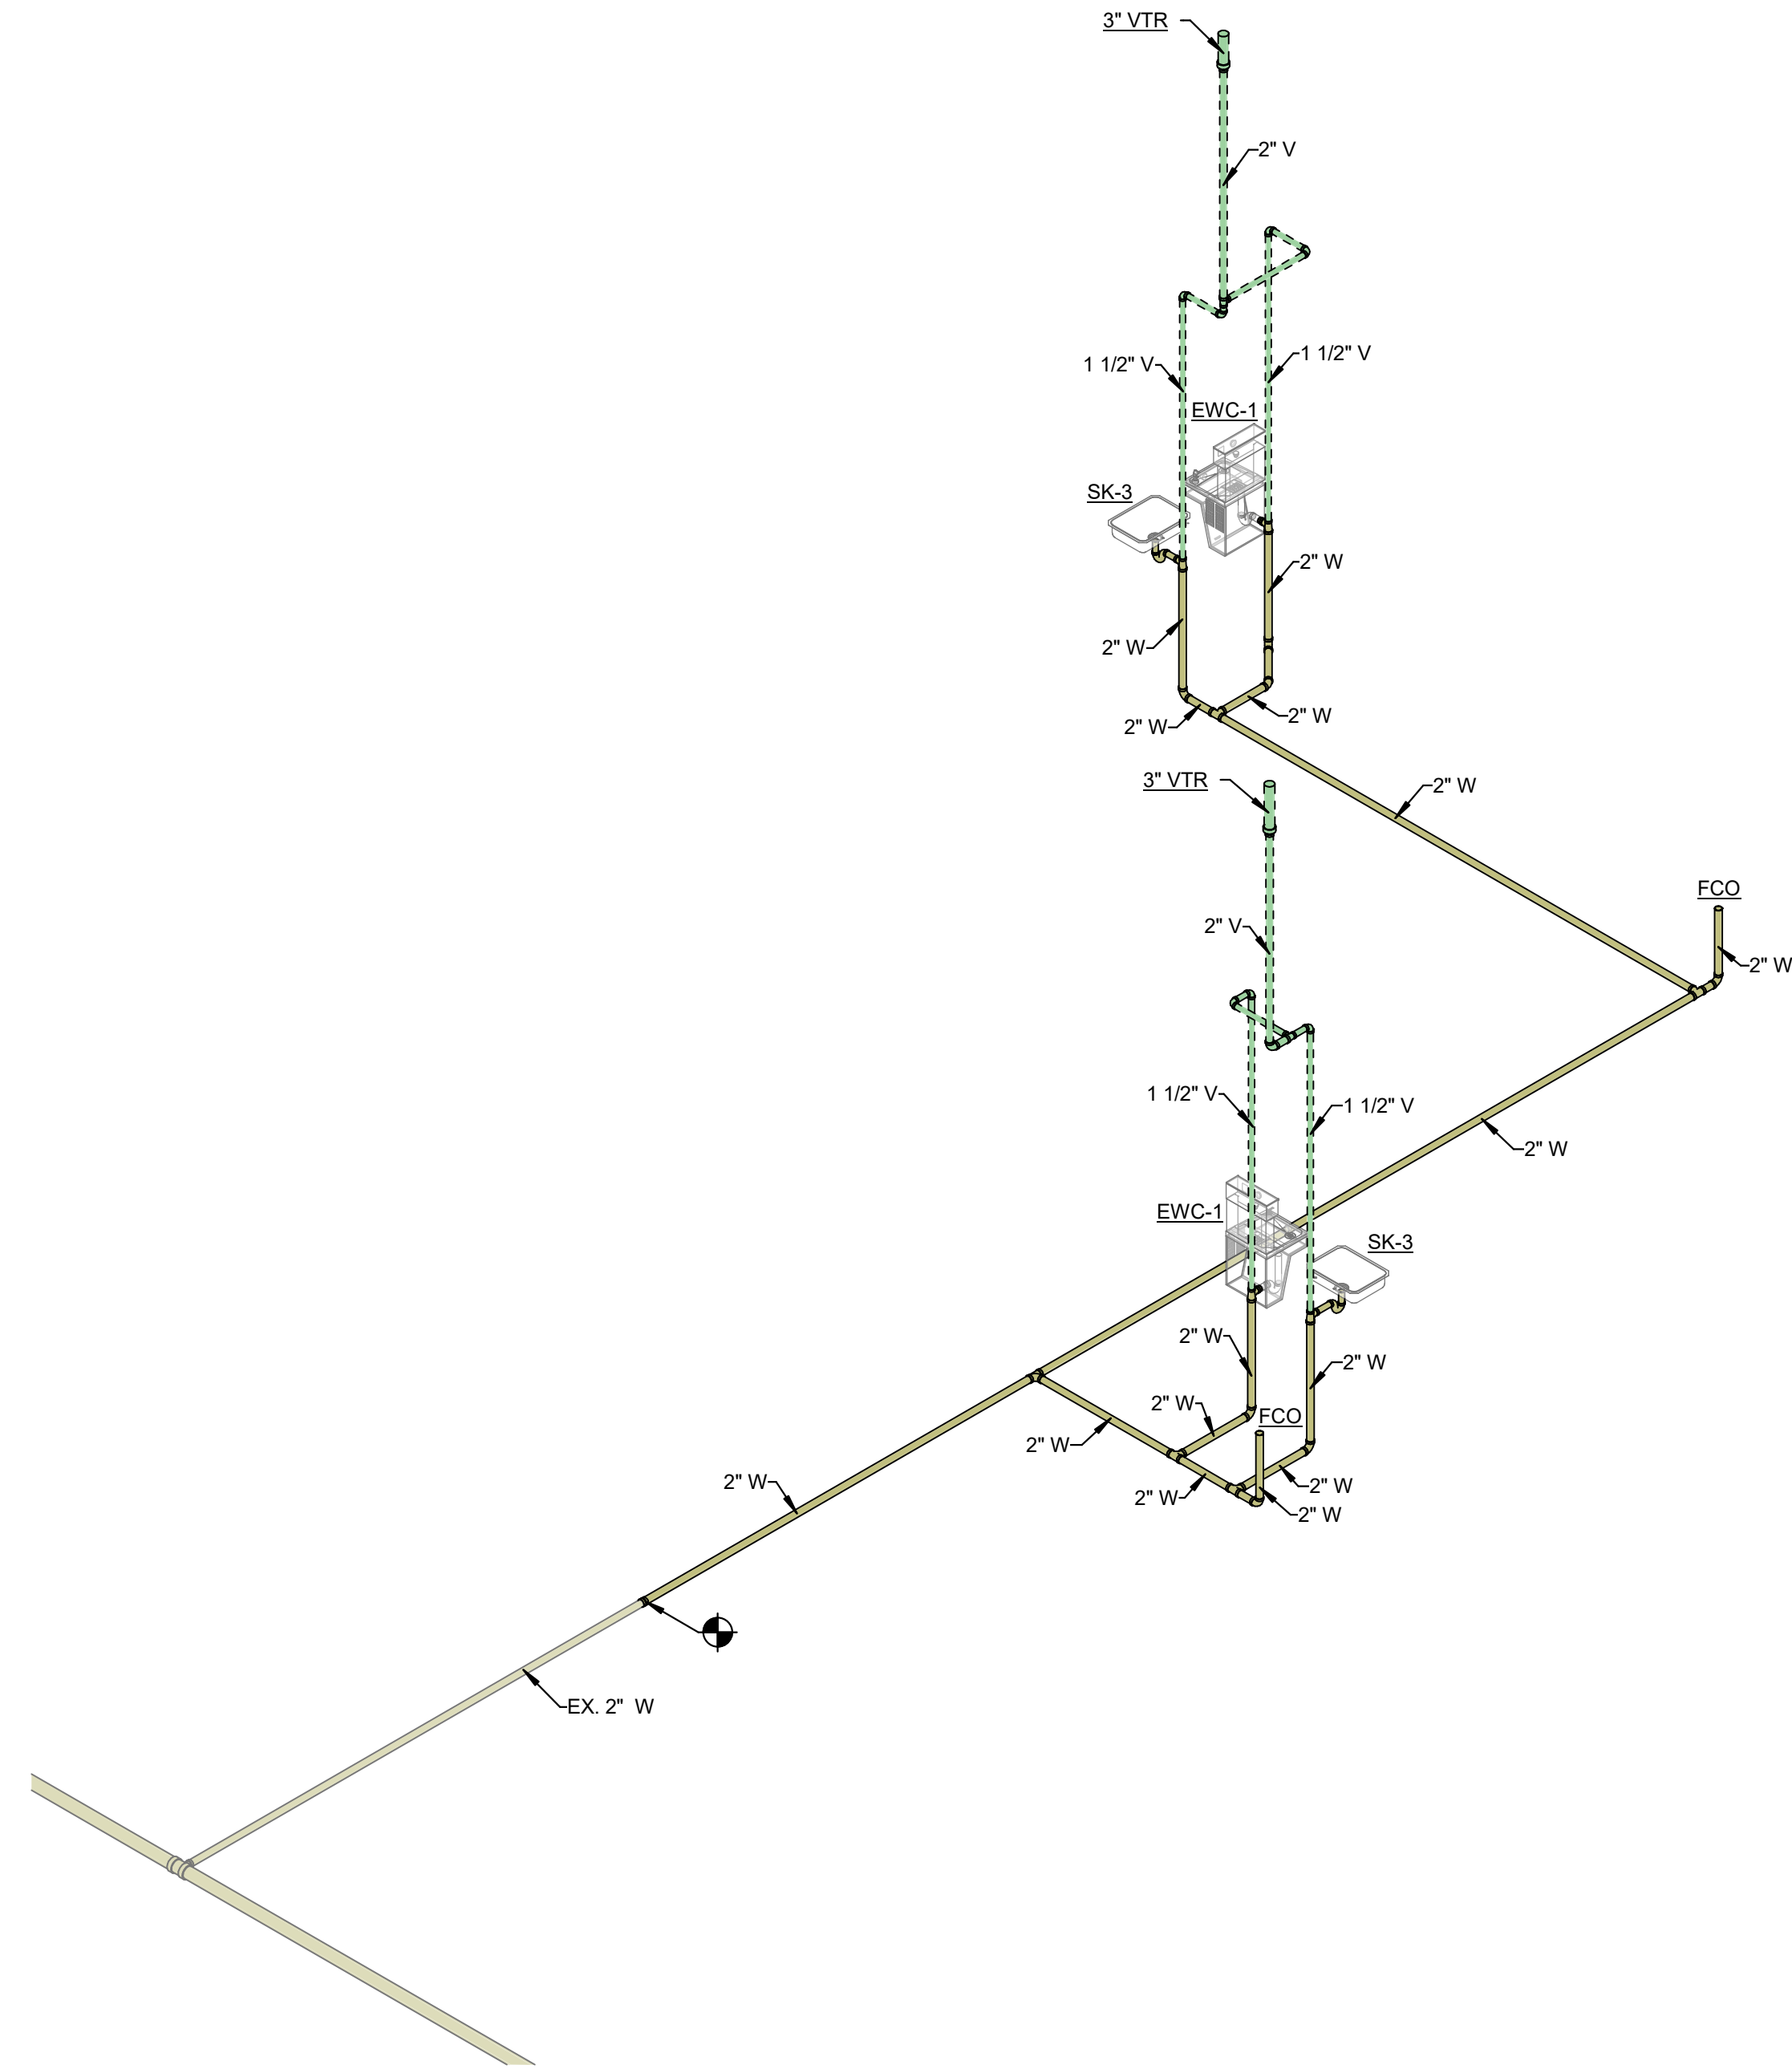

1 WASTE AND VENT ISOMETRIC - UNIT D

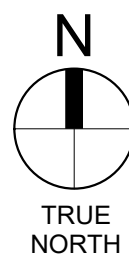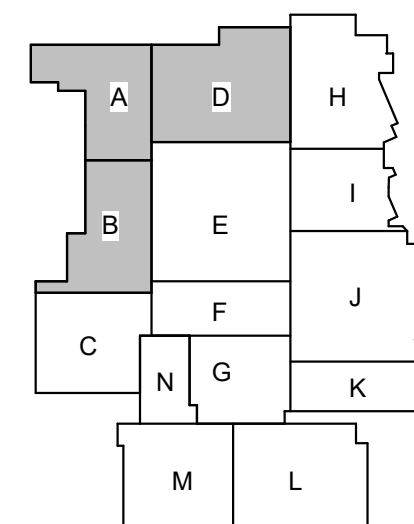

PERRY TOWNSHIP SCHOOLS  
PERRY MERIDIAN HS PHASE II RENOVATIONS (VOL 1)  
401 W MERIDIAN SCHOOL RD,  
INDIANAPOLIS, IN 46217



| REVISIONS: | Date       | Desc:        |
|------------|------------|--------------|
| #          |            |              |
| 1          | 09-25-2026 | Addendum #03 |

100% CONSTRUCTION DOCUMENTS

PROJECT: #24173P  
DATE: 08-21-2026  
DRAWN BY: IOP


PLUMBING  
WASTE AND  
VENT  
ISOMETRICS

P-903

LANCER ASSOCIATES  
ARCHITECTURE




145 N EAST ST.  
INDIANAPOLIS, IN 46204

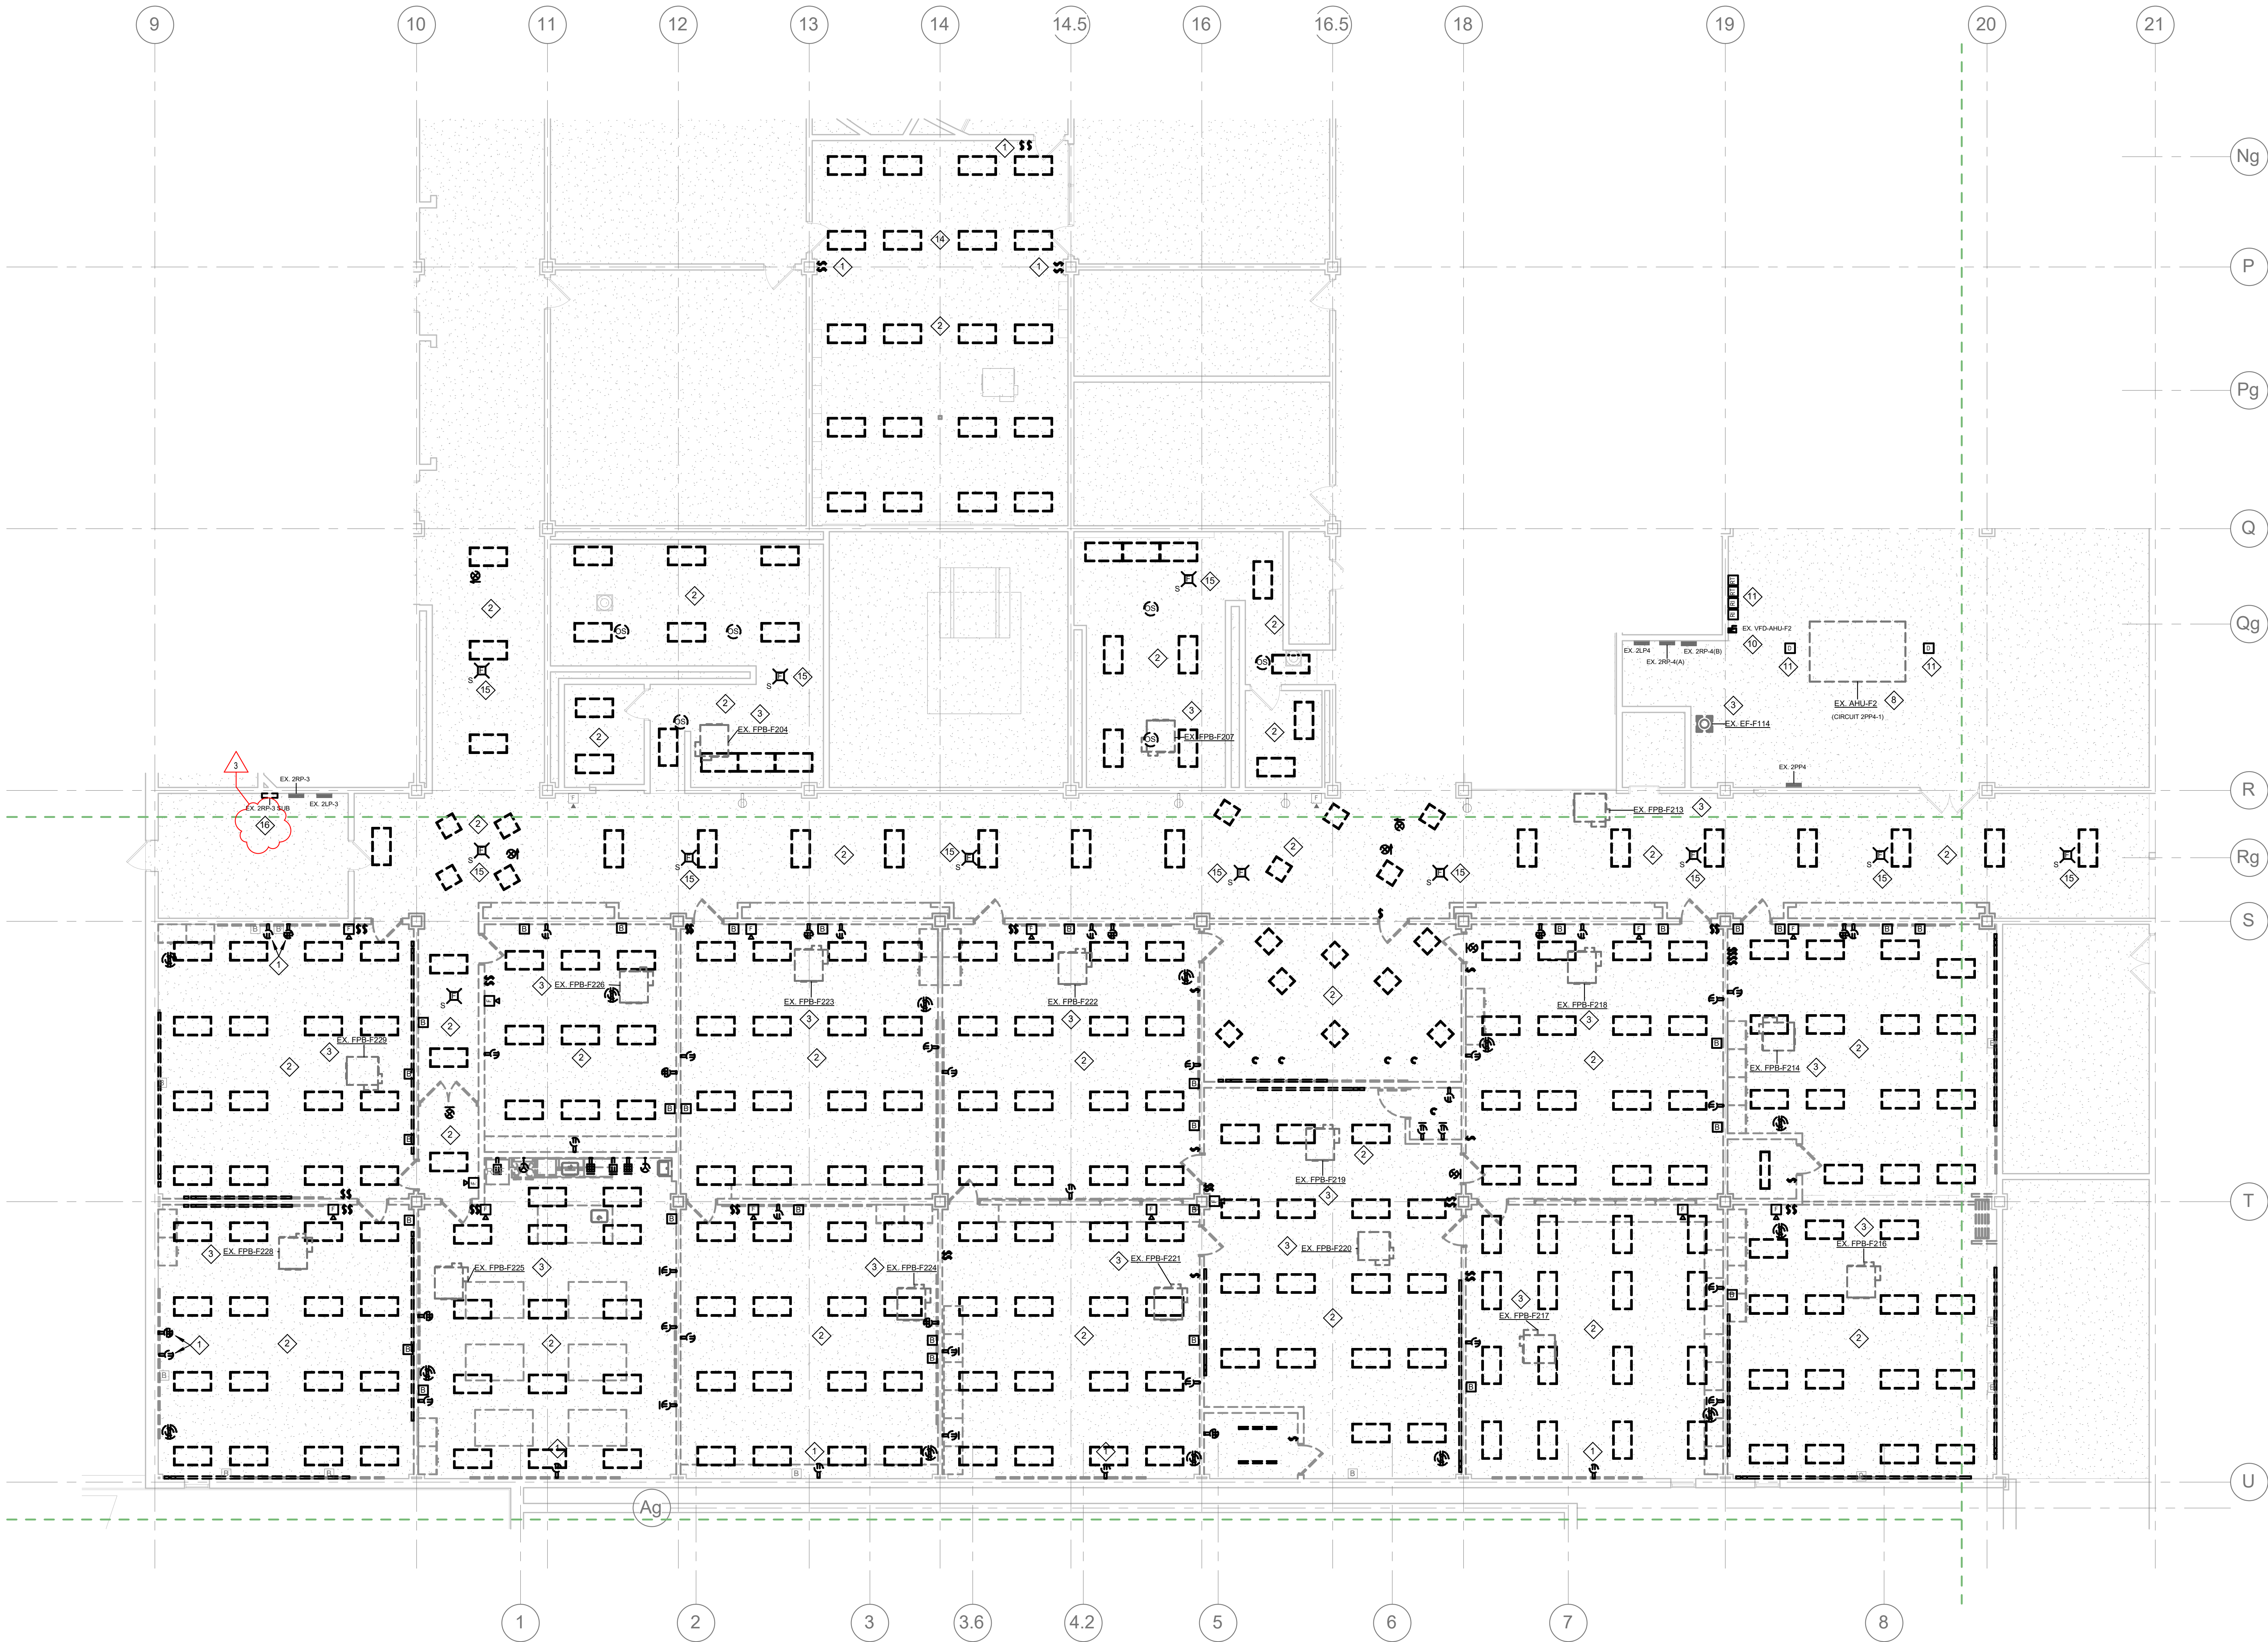


- GENERAL DEMOLITION NOTES**
- REFER TO ELECTRICAL SYMBOLS AND ABBREVIATIONS SHEET E-001 FOR ADDITIONAL INFORMATION.
  - THIS DRAWING REPRESENTS INFORMATION OBTAINED FROM ORIGINAL CONTRACT DRAWINGS AND FIELD SURVEY. VERIFY BY ON-SITE OBSERVATION THE EXTENT OF WORK PRIOR TO SUBMISSION OF BID.
  - CONTRACT DOCUMENTS CONSIST OF BOTH PROJECT MANUAL AND DRAWINGS AND ARE MEANT TO BE COMPLEMENTARY. ANYTHING APPEARING ON EITHER MUST BE EXECUTED THE SAME AS IF SHOWN ON BOTH.
  - THOROUGHLY EXAMINE THE WORK OF OTHER CONTRACTORS AND PROPERLY DEMOLISH ALL WORK REQUIRED FOR THE PROJECT.
  - THE OWNER HOLDS RIGHT OF FIRST REFUSAL FOR ALL DEMOLISHED ELECTRICAL EQUIPMENT.
  - ALL ELECTRICAL ITEMS SHOWN WITH LIGHT LINEWORK ARE EXISTING TO REMAIN. COORDINATE AND DISCONNECT ALL ARCHITECTURAL, MECHANICAL, AND PLUMBING EQUIPMENT AS NOTED FOR REMOVAL BY OTHERS. REMOVE ALL ASSOCIATED ELECTRICAL EQUIPMENT, RACEWAYS, CONDUCTORS, ETC. SERVING THE EQUIPMENT.
  - PROVIDE ALL CUTTING AND PATCHING AS REQUIRED FOR THE REMOVAL OF EXISTING ELECTRICAL EQUIPMENT. REFER TO SPECIFICATIONS.
  - PROVIDE A BLANK COVERPLATE FOR ALL EXISTING WALL OPENINGS WHERE ELECTRICAL EQUIPMENT HAS BEEN REMOVED AND NOT REPLACED. IN AREAS RECEIVING NEW WALL TREATMENTS, PATCH THE EXISTING OPENING.
  - REFER TO A, M, AND P-SERIES DRAWINGS FOR AREAS WITH ABOVE CEILING WORK AND/OR CEILING REMOVAL. TEMPORARILY SUPPORT ALL ELECTRICAL DEVICES, FIXTURES, ETC. AS REQUIRED. RE-INSTALL ELECTRICAL ITEMS FOLLOWING THE COMPLETION OF WORK IN THE NEW OR EXISTING CEILINGS.
  - PROVIDE A COMPLETE FIRE ALARM SYSTEM TEST PRIOR TO DEMOLITION.
  - NOT ALL PLAN NOTES ARE USED ON THIS SHEET.
- DEMOLITION PLAN NOTES**
- MAINTAIN EXISTING CONDUIT AND BOX FOR REUSE.
  - DISCONNECT LIGHTING AND LIGHTING CONTROLS TO BE REMOVED IN THIS SPACE. MAINTAIN CIRCUITS FOR REUSE.
  - DISCONNECT MECHANICAL EQUIPMENT TO BE REMOVED. REMOVE CONDUIT AND WIRE BACK TO SOURCE.
  - REMOVE RECEPTACLE AND DISCONNECT SWITCH FOR KILN. REMOVE CONDUIT AND WIRE BACK TO SOURCE.
  - REMOVE RECEPTACLE AND SWITCH FOR KILN EXHAUST FAN. REMOVE CONDUIT AND WIRE BACK TO SOURCE.
  - DISCONNECT KILN HOOD AND REMOVE PUSHBUTTON. REMOVE CONDUIT AND WIRE BACK TO SOURCE.
  - MAINTAIN EXISTING CONDUIT, WIRING, AND BOX FOR REUSE.
  - DISCONNECT MECHANICAL EQUIPMENT TO BE REMOVED. MAINTAIN CIRCUIT FOR REUSE.
  - MAINTAIN HANDHAIR DRYER CIRCUIT ABOVE CEILING FOR REUSE.
  - DISCONNECT MECHANICAL EQUIPMENT VFD AND DISCONNECT. MAINTAIN CIRCUIT FOR REUSE.
  - DISCONNECT AND REMOVE FIRE ALARM DUCT DETECTOR AND ASSOCIATED BASE, INDICATORS AND TEST SWITCHES. MAINTAIN CIRCUIT FOR REUSE.
  - DISCONNECT MOTORIZED SCREEN TO BE REMOVED IN THIS SPACE. REMOVE CONDUIT AND WIRE BACK TO SOURCE.
  - DISCONNECT ACCESS CONTROL POWER SUPPLY TO BE REMOVED. MAINTAIN CIRCUIT FOR REUSE.
  - DISCONNECT POWER POLE TO BE REMOVED. REMOVE CONDUIT AND WIRE BACK TO SOURCE.
  - DISCONNECT AND SALVAGE SMOKE DETECTOR FOR REUSE. MAINTAIN CIRCUIT FOR REUSE.
  - MAINTAIN BRANCH CIRCUITS FOR PANEL TO BE REPLACED.

1 ELECTRICAL DEMOLITION SECOND FLOOR PLAN - UNIT F  
1/8" = 1'-0"

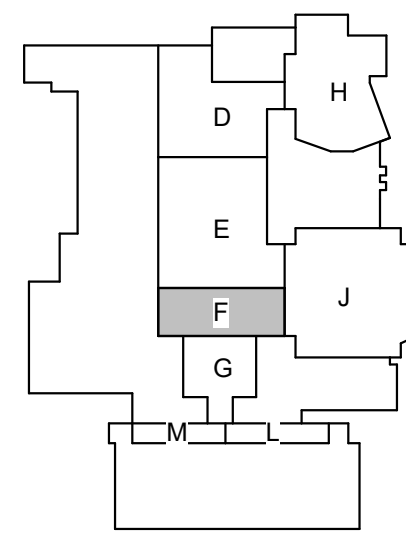

PERRY TOWNSHIP SCHOOLS  
PERRY MERIDIAN HS PHASE II RENOVATIONS  
401 W MERIDIAN SCHOOL RD,  
INDIANAPOLIS, IN 46217

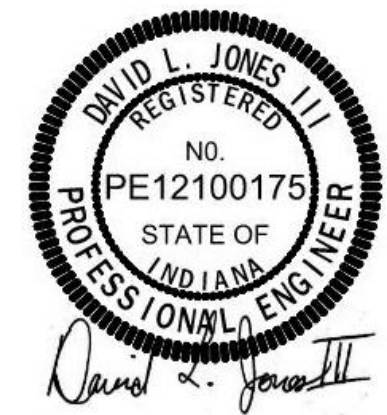

| REVISONS: | #          | Date        | Desc. |
|-----------|------------|-------------|-------|
| 1         | 09/17/2026 | ADDENDUM #1 |       |
| 2         | 09/23/2026 | ADDENDUM #3 |       |


100% CONSTRUCTION DOCUMENTS  
PROJECT: #24173P  
DATE: 09-21-2026  
DRAWN BY: AMN

ELECTRICAL DEMOLITION  
SECOND FLOOR PLAN - UNIT F

ED108

LANCER ASSOCIATES  
ARCHITECTURE  
145 N EAST ST.  
INDIANAPOLIS, IN 46204



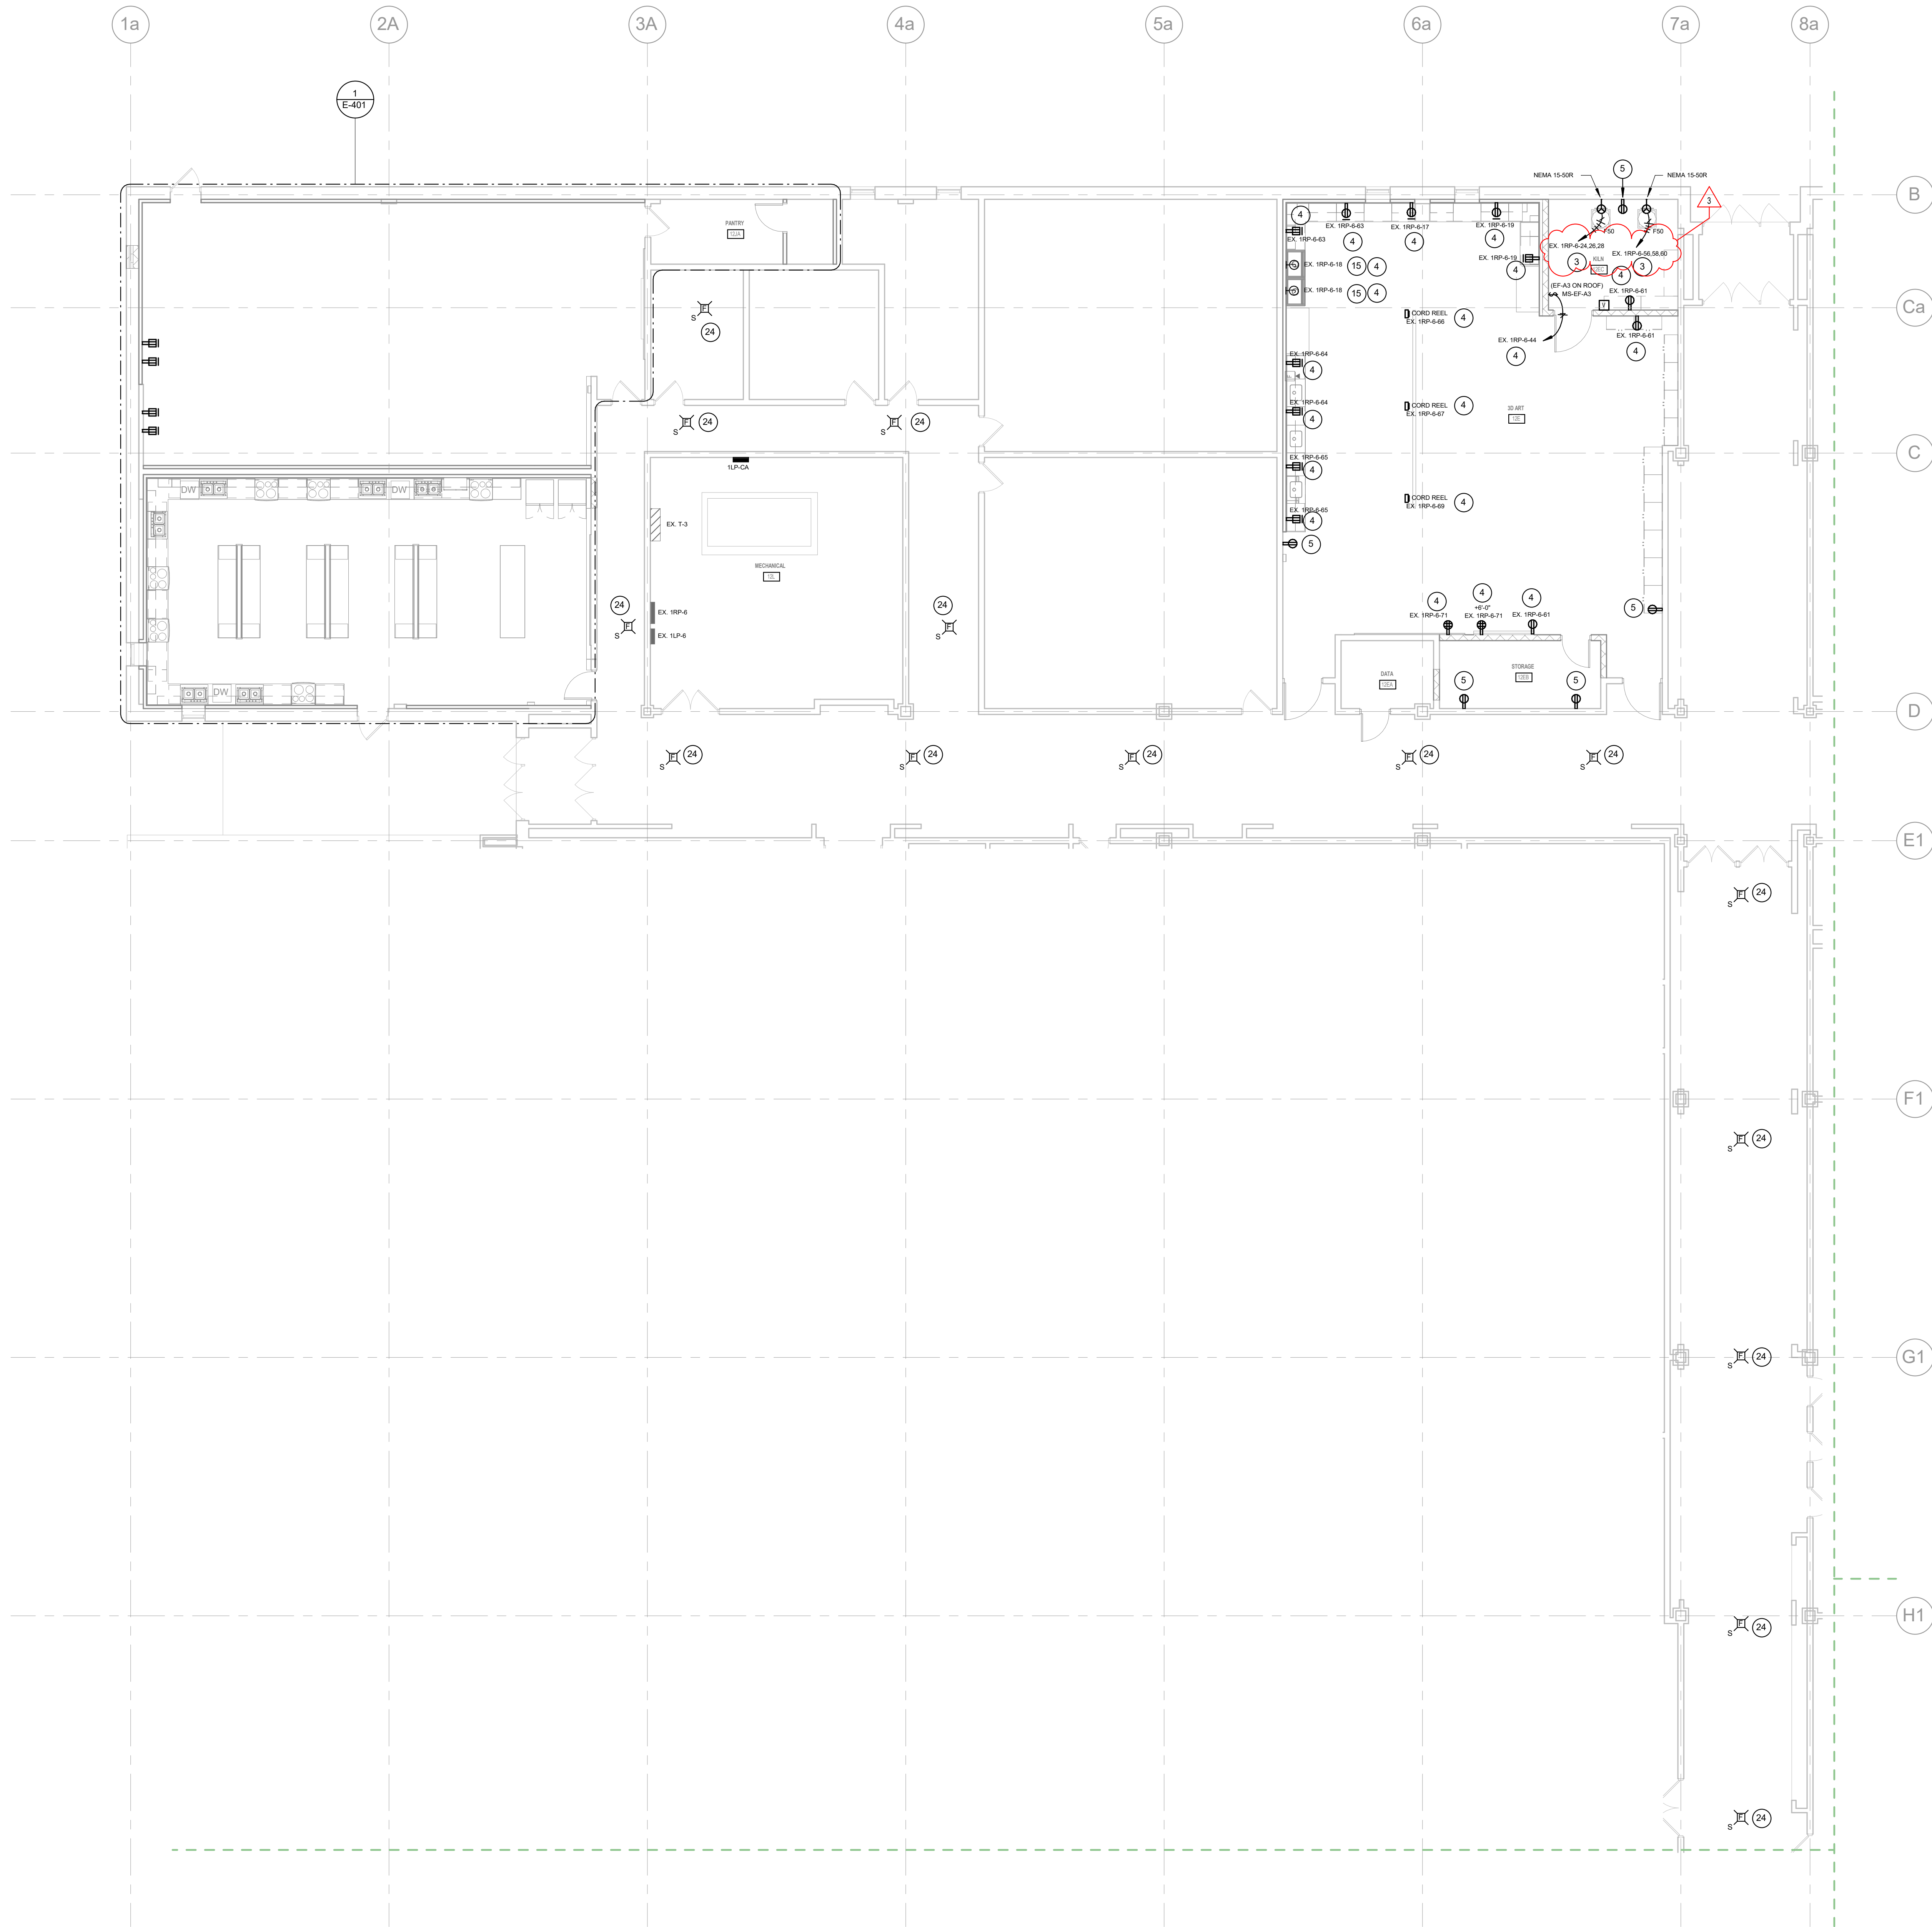

### GENERAL POWER NOTES

- REFER TO ELECTRICAL SYMBOLS AND ABBREVIATIONS SHEET E-001 FOR ADDITIONAL INFORMATION.
- PROVIDE A GEAR SUBMITTAL FOR GENERAL APPROVAL PRIOR TO CONDUCTING STUDIES. IMPLEMENT RECOMMENDATIONS TO ELECTRICAL GEAR FOR FINAL APPROVAL AFTER STUDIES ARE COMPLETED AND APPROVED.
- COORDINATE ALL DEVICE LOCATIONS WITH ARCHITECT AND INTERIOR DESIGNER.
- PROVIDE LABELS ON ALL EQUIPMENT MODIFIED BY THIS PROJECT. PROVIDE LABELS ON ALL JUNCTION BOXES AND CONDUITS MODIFIED OR PROVIDED BY THIS PROJECT. PROVIDE UPDATED PANELBOARD DIRECTORIES ON ALL PANELBOARDS MODIFIED BY THIS PROJECT.
- NOT ALL PLAN NOTES ARE USED ON THIS SHEET.

### POWER PLAN NOTES

- PROVIDE NEW RECEPTACLE IN EXISTING BOX.
- PROVIDE GROUNDING BUSBAR, CABLES, AND CONNECTIONS PER TECHNOLOGY DRAWINGS. CONNECT GROUNDING BUSBAR TO NEAREST PANELBOARD GROUNDING BUS.
- REMOVE EXISTING BREAKERS AT CIRCUIT LOCATION INDICATED AND PROVIDE A 50A 3-POLE BREAKER FOR KILN.
- UTILIZE EXISTING SPARE 20A CIRCUIT BREAKER IN PANEL FOR CIRCUIT INDICATED.
- PROVIDE NEW RECEPTACLE AND FACEPLATE IN EXISTING BOX AND CONNECT TO EXISTING CIRCUIT.
- CONNECT NEW RECEPTACLE TO EXISTING RECEPTACLE CIRCUIT IN THIS SPACE.
- CONNECT NEW RECEPTACLE TO NEAREST AVAILABLE RECEPTACLE CIRCUIT.
- COORDINATE HAIR DRYER MOUNTING HEIGHT IN THE FIELD. CONNECT TO EXISTING DEDICATED HANDHAIR DRYER CIRCUIT MAINTAINED DURING DEMOLITION. EXTEND TO THIS LOCATION WITH 2#12, #125 IN 3/4". REPLACE EXISTING CIRCUIT BREAKER WITH A LOCKABLE BREAKER IF REQUIRED.
- INSTALL RECEPTACLE HORIZONTALLY WITH THE BOTTOM EDGE OF THE BOX AT +4" ABOVE FINISHED FLOOR.
- CONNECT NEW CABINET UNIT HEATER TO EXISTING CIRCUIT MAINTAINED DURING DEMOLITION. EXTEND TO NEW UNIT MATCHING EXISTING CONDUIT AND WIRE SIZES.
- CONNECT NEW EXHAUST FAN ON ROOF TO EXISTING CIRCUIT MAINTAINED DURING DEMOLITION. EXTEND TO NEW UNIT MATCHING EXISTING CONDUIT AND WIRE SIZES.
- CONNECT AHU-D2 TO NEW VFD AND NEW VFD TO EXISTING AHU CIRCUIT FROM PANEL 2PP3 UTILIZING EXISTING CIRCUIT CONDUIT AND WIRING.
- PROVIDE FIRE ALARM DUCT DETECTOR AND BASE IN DUCT. COORDINATE INSTALLATION LOCATION WITH DIVISION 23. PROVIDE REMOTE INDICATOR AND REMOTE TEST SWITCH AT LOCATION SHOWN.
- CONNECT AHU-F2 TO NEW VFD AND NEW VFD TO EXISTING AHU CIRCUIT FROM PANEL 2PP4 UTILIZING EXISTING CIRCUIT CONDUIT AND WIRING.
- COORDINATE JUNCTION BOX MOUNTING HEIGHT AND PAINT BOOTH CONNECTION WITH MANUFACTURE REQUIREMENTS.
- MOUNT MOTOR STARTER ABOVE CEILING. CONNECT EXHAUST FAN EF-K1 THROUGH THIS MOTOR STARTER. COORDINATE WITH OWNER TO MARK CEILING FOR MOTOR STARTER LOCATION.
- CONNECT EXHAUST FAN CIRCUIT THROUGH THIS MOTOR STARTER.
- PROVIDE NEW 20A 1-POLE CIRCUIT BREAKER IN PANEL FOR CIRCUIT INDICATED.
- INDOOR SPLIT SYSTEM UNIT IS POWERED BY CONDENSING UNIT CU-F1 ON THE ROOF. PROVIDE ALL NECESSARY WIRING AND CONNECTIONS TO THE INDOOR UNIT.
- PROVIDE SINGLE CHANNEL SURFACE RACEWAY FOR NEW DEVICE(S).
- PROVIDE DUAL CHANNEL SURFACE RACEWAY FOR NEW DEVICE(S).
- PROVIDE DUAL CHANNEL SURFACE RACEWAY FOR CLOCK RECEPTACLE. MOUNT RECEPTACLE ONE FOOT BELOW THE CEILING.
- CONNECT NEW ACCESS CONTROL POWER SUPPLY TO EXISTING CIRCUIT MAINTAINED IN THIS AREA. EXTEND CIRCUIT TO NEW LOCATION MATCHING EXISTING CONDUIT AND WIRE SIZES.
- INSTALL SALVAGED SMOKE DETECTOR IN NEW CEILING. CONNECT TO EXISTING CIRCUIT MAINTAINED DURING DEMOLITION.
- PROVIDE FIRE ALARM RELAY FOR AV SYSTEM. CONNECT TO EXISTING FIRE ALARM SYSTEM AND PROGRAM TO SILENCE AV SYSTEM UPON SYSTEM ACTIVATION.
- CONNECT EXISTING BRANCH CIRCUITS MAINTAINED DURING DEMOLITION TO NEW PANEL AT THIS LOCATION.

PERRY TOWNSHIP SCHOOLS  
PERRY MERIDIAN HS PHASE II RENOVATIONS  
401 W MERIDIAN SCHOOL RD,  
INDIANAPOLIS, IN 46217




| REVISIONS: | Date       | Disc:       |
|------------|------------|-------------|
| #          |            |             |
| 1          | 09/23/2026 | ADDENDUM #3 |


100% CONSTRUCTION DOCUMENTS  
PROJECT: #24173P  
DATE: 09-21-2026  
DRAWN BY: AMN

ELECTRICAL  
POWER &  
SYSTEMS FIRST  
FLOOR PLAN -  
UNIT A

EP101

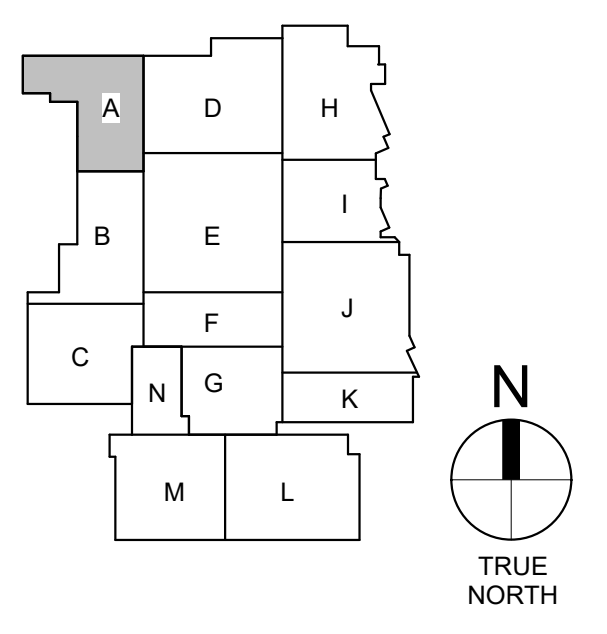

1 ELECTRICAL POWER & SYSTEMS FIRST FLOOR PLAN - UNIT A  
1/8" = 1'-0"

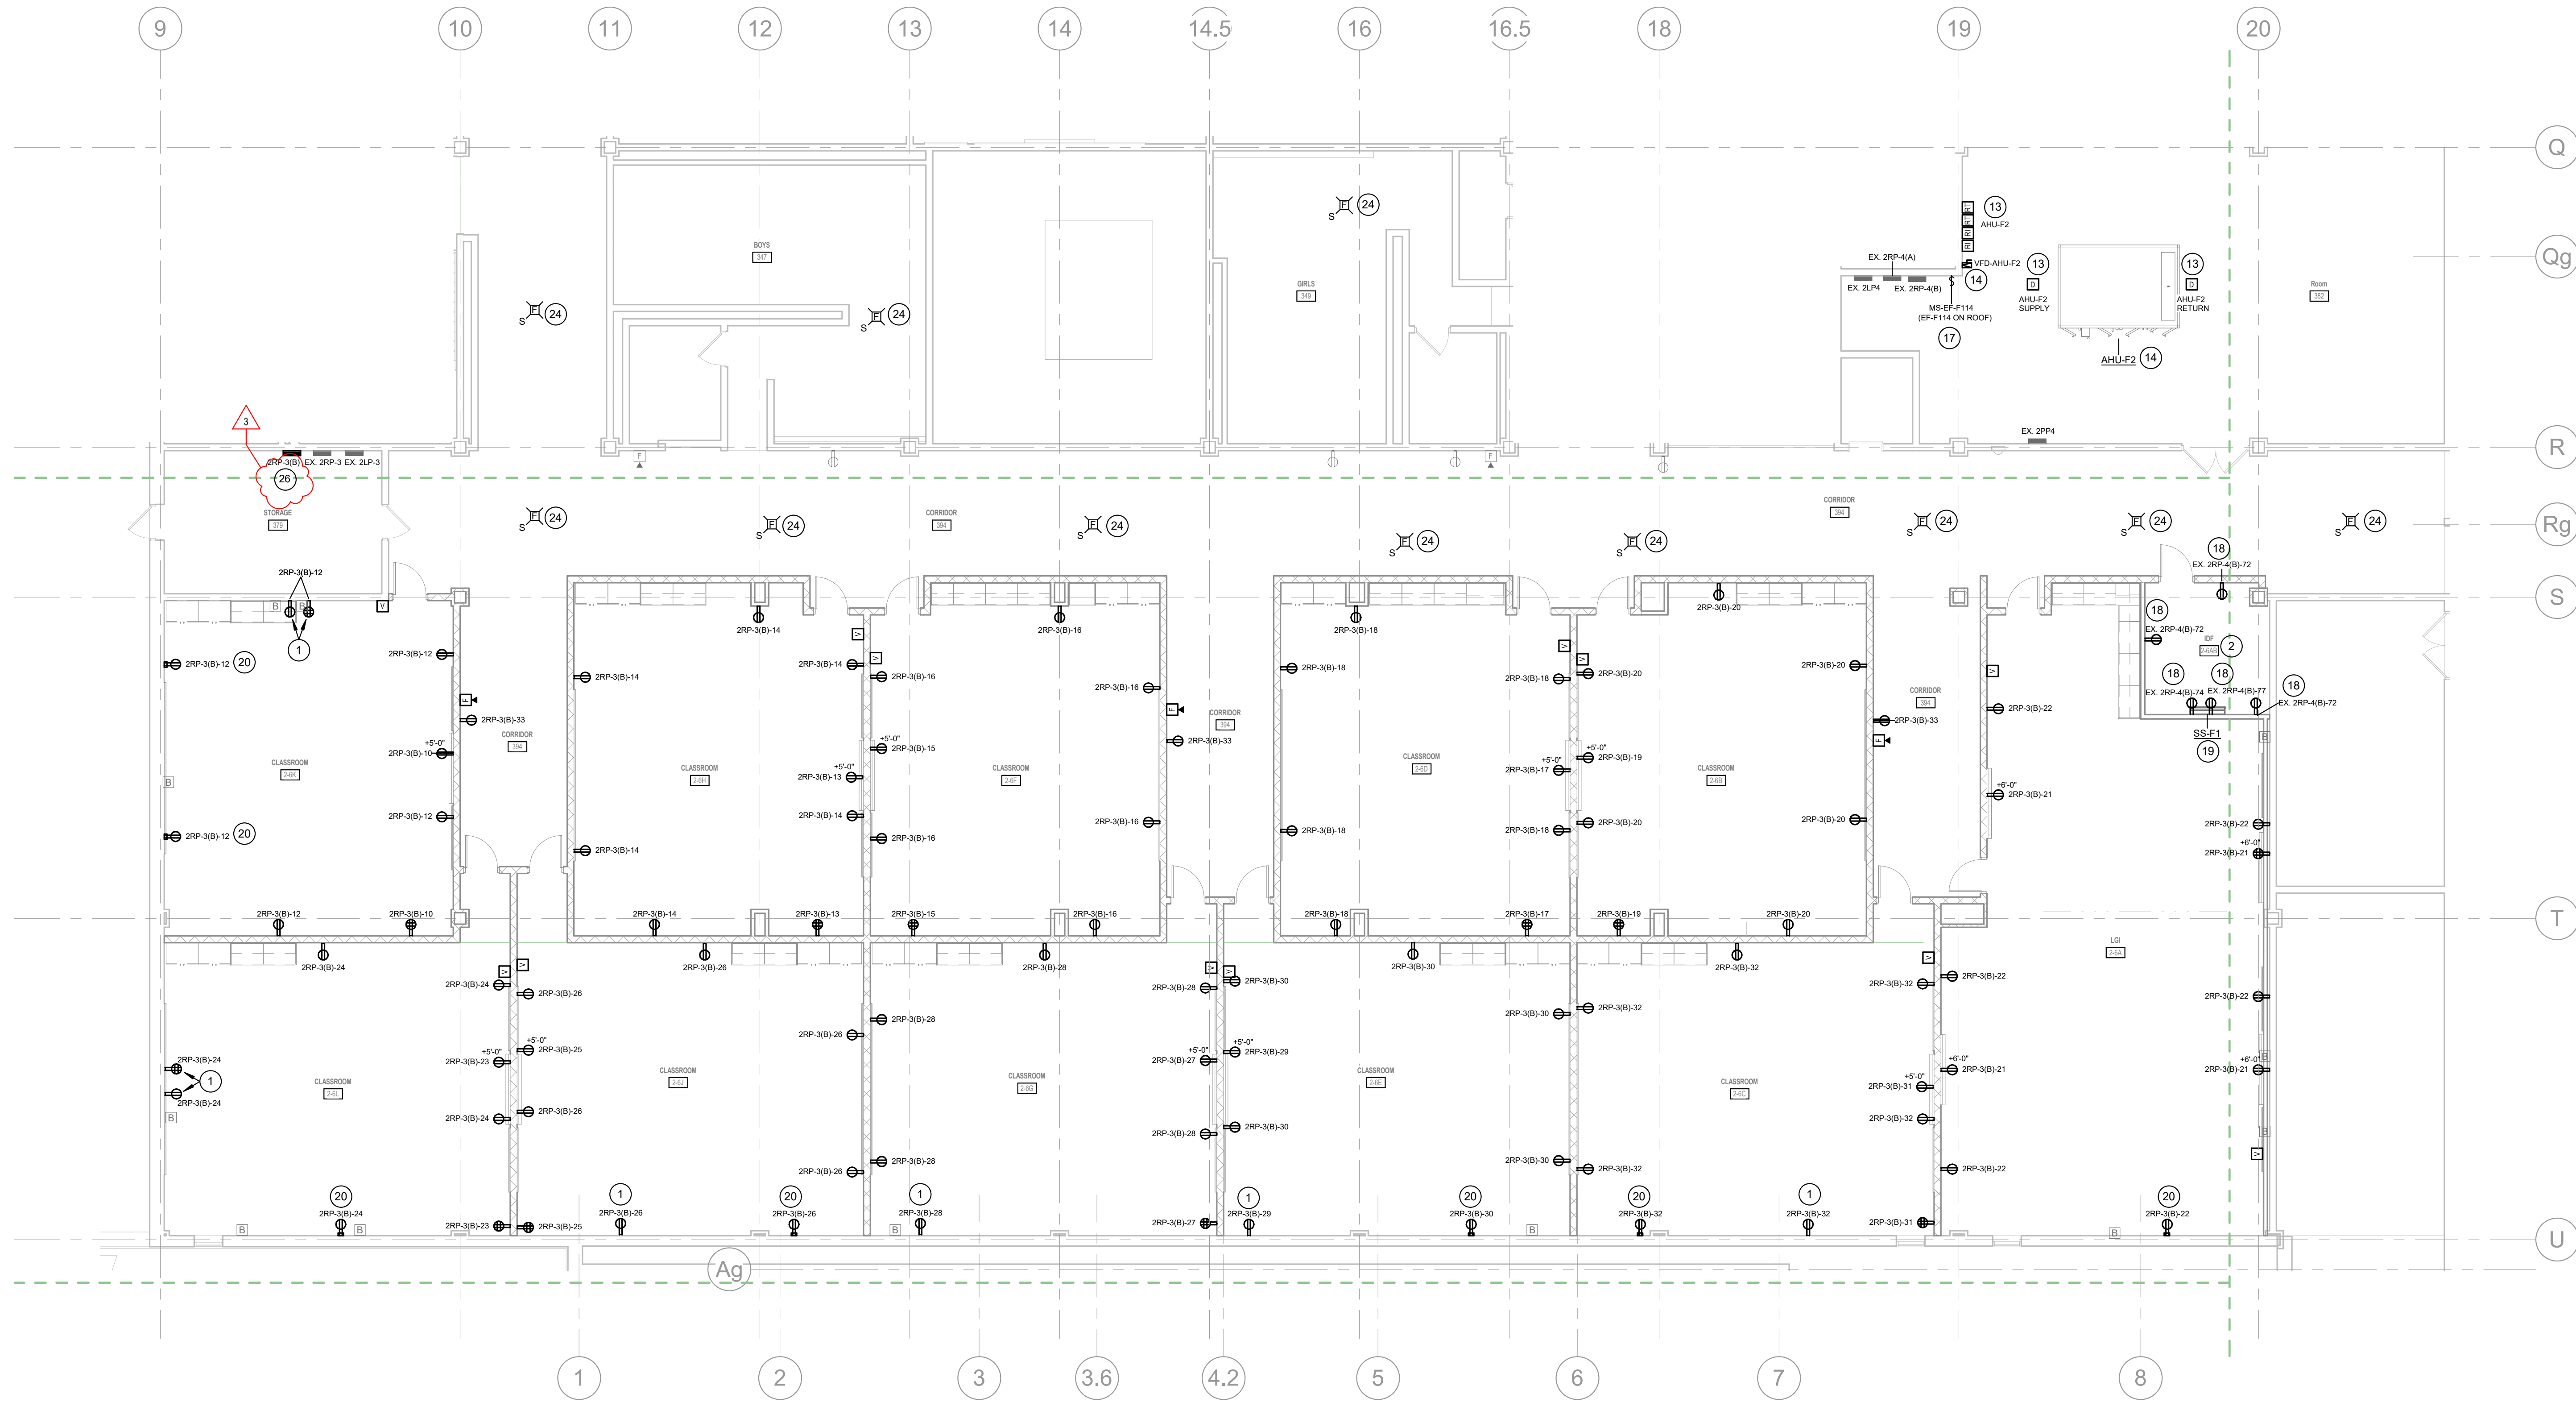

1 ELECTRICAL POWER & SYSTEMS SECOND FLOOR PLAN - UNIT F  
1/8" = 1'-0"

### GENERAL POWER NOTES

- REFER TO ELECTRICAL SYMBOLS AND ABBREVIATIONS SHEET E-001 FOR ADDITIONAL INFORMATION.
- PROVIDE A GEAR SUBMITTAL FOR GENERAL APPROVAL PRIOR TO CONDUCTING STUDIES. IMPLEMENT RECOMMENDATIONS TO ELECTRICAL GEAR FOR FINAL APPROVAL AFTER STUDIES ARE COMPLETED AND APPROVED.
- COORDINATE ALL DEVICE LOCATIONS WITH ARCHITECT AND INTERIOR DESIGNER.
- PROVIDE LABELS ON ALL EQUIPMENT MODIFIED BY THIS PROJECT. PROVIDE LABELS ON ALL JUNCTION BOXES AND CONDUITS MODIFIED OR PROVIDED BY THIS PROJECT. PROVIDE UPDATED PANELBOARD DIRECTORIES ON ALL PANELBOARDS MODIFIED BY THIS PROJECT.
- NOT ALL PLAN NOTES ARE USED ON THIS SHEET.

### POWER PLAN NOTES

- PROVIDE NEW RECEPTACLE IN EXISTING BOX.
- PROVIDE GROUNDING BUSBAR, CABLES, AND CONNECTIONS PER TECHNOLOGY DRAWINGS. CONNECT GROUNDING BUSBAR TO NEAREST PANELBOARD GROUNDING BUS.
- REMOVE EXISTING BREAKERS AT CIRCUIT LOCATION INDICATED AND PROVIDE A 50A 3-POLE BREAKER FOR KILN.
- UTILIZE EXISTING SPARE 20A CIRCUIT BREAKER IN PANEL FOR CIRCUIT INDICATED.
- PROVIDE NEW RECEPTACLE AND FACEPLATE IN EXISTING BOX AND CONNECT TO EXISTING CIRCUIT.
- CONNECT NEW RECEPTACLE TO EXISTING RECEPTACLE CIRCUIT IN THIS SPACE.
- CONNECT NEW RECEPTACLE TO NEAREST AVAILABLE RECEPTACLE CIRCUIT.
- COORDINATE HAIR DRYER MOUNTING HEIGHT IN THE FIELD. CONNECT TO EXISTING DEDICATED HANDHAIR DRYER CIRCUIT MAINTAINED DURING DEMOLITION. EXTEND TO THIS LOCATION WITH 2#12, #125 IN 3/4" C. REPLACE EXISTING CIRCUIT BREAKER WITH A LOCKABLE BREAKER IF REQUIRED.
- INSTALL RECEPTACLE HORIZONTALLY WITH THE BOTTOM EDGE OF THE BOX AT +4" ABOVE FINISHED FLOOR.
- CONNECT NEW CABINET UNIT HEATER TO EXISTING CIRCUIT MAINTAINED DURING DEMOLITION. EXTEND TO NEW UNIT MATCHING EXISTING CONDUIT AND WIRE SIZES.
- CONNECT NEW EXHAUST FAN ON ROOF TO EXISTING CIRCUIT MAINTAINED DURING DEMOLITION. EXTEND TO NEW UNIT MATCHING EXISTING CONDUIT AND WIRE SIZES.
- CONNECT AHU-D2 TO NEW VFD AND NEW VFD TO EXISTING AHU CIRCUIT FROM PANEL 2PP3 UTILIZING EXISTING CIRCUIT CONDUIT AND WIRING.
- PROVIDE FIRE ALARM DUCT DETECTOR AND BASE IN DUCT. COORDINATE INSTALLATION LOCATION WITH DIVISION 23. PROVIDE REMOTE INDICATOR AND REMOTE TEST SWITCH AT LOCATION SHOWN.
- CONNECT AHU-F2 TO NEW VFD AND NEW VFD TO EXISTING AHU CIRCUIT FROM PANEL 2PP4 UTILIZING EXISTING CIRCUIT CONDUIT AND WIRING.
- COORDINATE JUNCTION BOX MOUNTING HEIGHT AND PAINT BOOTH CONNECTION WITH MANUFACTURE REQUIREMENTS.
- MOUNT MOTOR STARTER ABOVE CEILING. CONNECT EXHAUST FAN EF-K1 THROUGH THIS MOTOR STARTER. COORDINATE WITH OWNER TO MARK CEILING FOR MOTOR STARTER LOCATION.
- CONNECT EXHAUST FAN CIRCUIT THROUGH THIS MOTOR STARTER.
- PROVIDE NEW 20A 1-POLE CIRCUIT BREAKER IN PANEL FOR CIRCUIT INDICATED. INDOOR SPLIT SYSTEM UNIT IS POWERED BY CONDENSING UNIT CU-F1 ON THE ROOF. PROVIDE ALL NECESSARY WIRING AND CONNECTIONS TO THE INDOOR UNIT.
- PROVIDE SINGLE CHANNEL SURFACE RACEWAY FOR NEW DEVICE(S).
- PROVIDE DUAL CHANNEL SURFACE RACEWAY FOR NEW DEVICE(S).
- PROVIDE DUAL CHANNEL SURFACE RACEWAY FOR CLOCK RECEPTACLE. MOUNT RECEPTACLE ONE FOOT BELOW THE CEILING.
- CONNECT NEW ACCESS CONTROL POWER SUPPLY TO EXISTING CIRCUIT MAINTAINED IN THIS AREA. EXTEND CIRCUIT TO NEW LOCATION MATCHING EXISTING CONDUIT AND WIRE SIZES.
- INSTALL SALVAGED SMOKE DETECTOR IN NEW CEILING. CONNECT TO EXISTING CIRCUIT MAINTAINED DURING DEMOLITION.
- PROVIDE FIRE ALARM RELAY FOR AV SYSTEM. CONNECT TO EXISTING FIRE ALARM SYSTEM AND PROGRAM TO SILENCE AV SYSTEM UPON SYSTEM ACTIVATION.
- CONNECT EXISTING BRANCH CIRCUITS MAINTAINED DURING DEMOLITION TO NEW PANEL AT THIS LOCATION.

PERRY TOWNSHIP SCHOOLS  
PERRY MERIDIAN HS PHASE II RENOVATIONS  
401 W MERIDIAN SCHOOL RD,  
INDIANAPOLIS, IN 46217




| REVISONS: | # | Date       | Desc:       |
|-----------|---|------------|-------------|
|           | 1 | 09/17/2026 | ADDENDUM #1 |
|           | 2 | 09/23/2026 | ADDENDUM #3 |

100% CONSTRUCTION DOCUMENTS

PROJECT: #24173P  
DATE: 09-21-2026  
DRAWN BY: AMN

ELECTRICAL  
POWER &  
SYSTEMS  
SECOND FLOOR  
PLAN - UNIT F

EP108

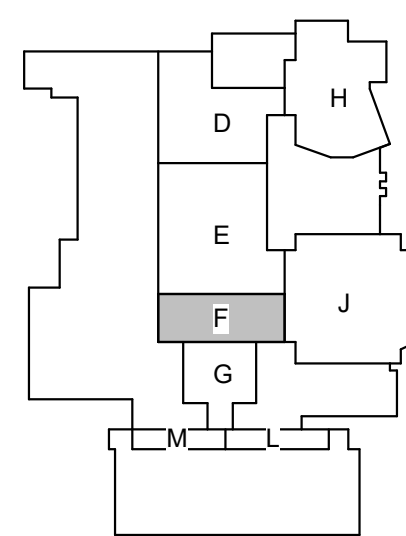

GENERAL DEMOLITION ONE-LINE DIAGRAM NOTES


A REFER TO ELECTRICAL SYMBOLS AND ABBREVIATIONS SHEET E-001 FOR ADDITIONAL INFORMATION.

GENERAL ONE-LINE DIAGRAM NOTES


A REFER TO ELECTRICAL SYMBOLS AND ABBREVIATIONS SHEET E-001 FOR ADDITIONAL INFORMATION.  
B PROVIDE LABELS ON ALL EQUIPMENT MODIFIED BY THIS PROJECT. PROVIDE LABELS ON ALL JUNCTION BOXES AND CONDUITS MODIFIED OR PROVIDED BY THIS PROJECT. PROVIDE UPDATED PANELBOARD DIRECTORIES ON ALL PANELBOARDS MODIFIED BY THIS PROJECT.

ONE-LINE DIAGRAM NOTES

- 1 PROVIDE 100A 3-POLE BREAKER IN AVAILABLE SPACE IN EXISTING PANEL FOR NEW PANEL FEEDER.
- 2 UTILIZE (2) EXISTING SPARE 100A 3-POLE BREAKERS IN EXISTING PANEL FOR NEW PANEL FEEDERS.
- 3 RELOCATE (3) 20A BRANCH CIRCUIT FROM EXISTING PANEL TO NEW PANEL 1RP-2A TO CREATE SPACE FOR NEW 3-POLE BREAKER. PROVIDE 60A 3-POLE BREAKER IN AVAILABLE SPACE IN EXISTING PANEL FOR NEW PANEL FEEDER.
- 4 PROVIDE 60A 3-POLE BREAKER IN AVAILABLE SPACE IN EXISTING PANEL FOR NEW PANEL FEEDER.

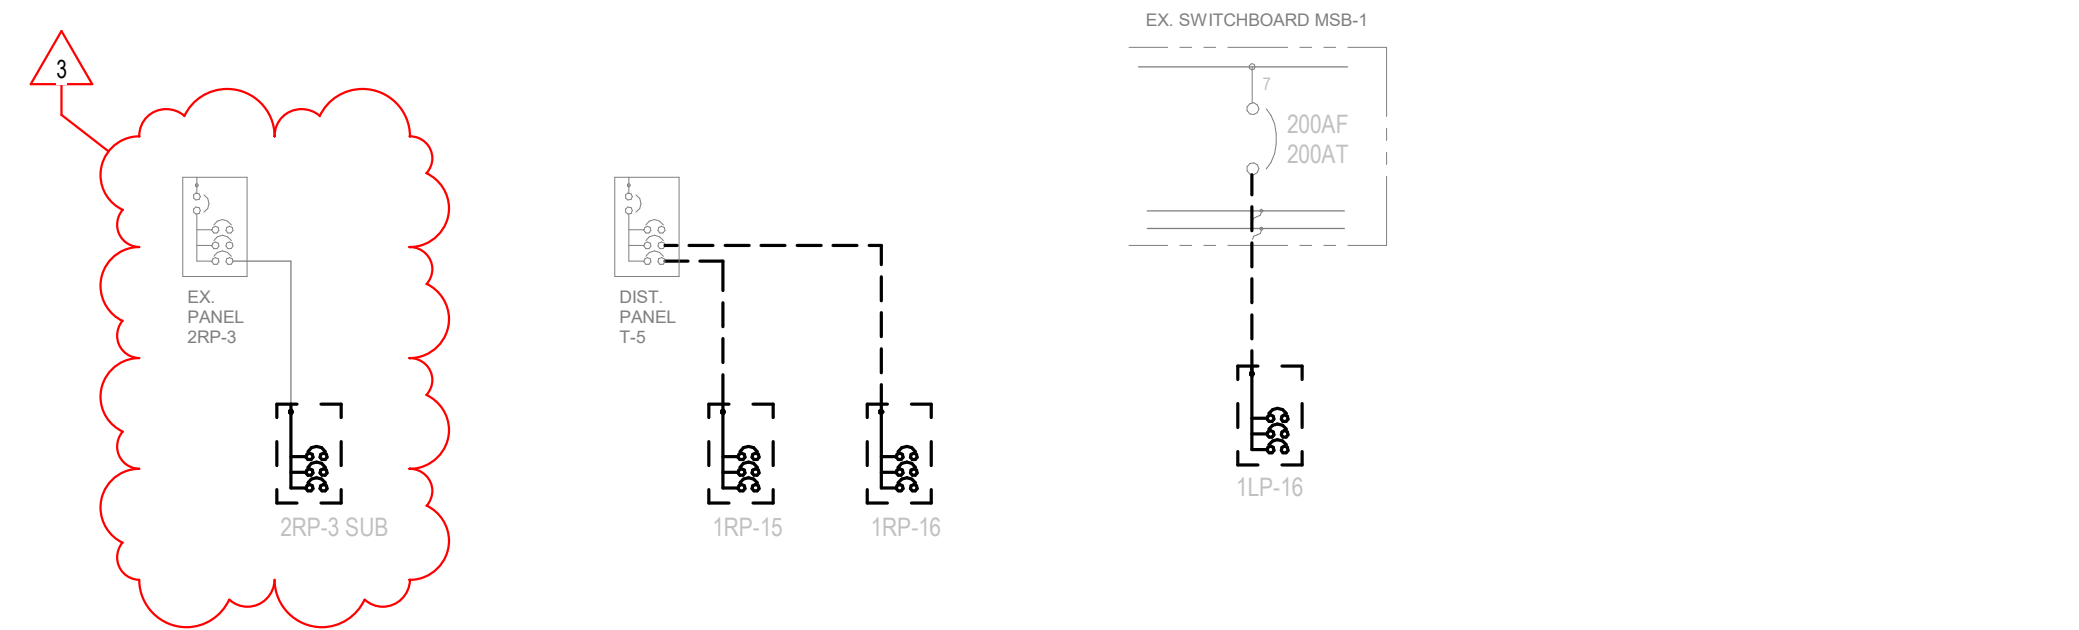


2 PARTIAL DEMOLITION ONE-LINE DIAGRAMS  
NOT TO SCALE

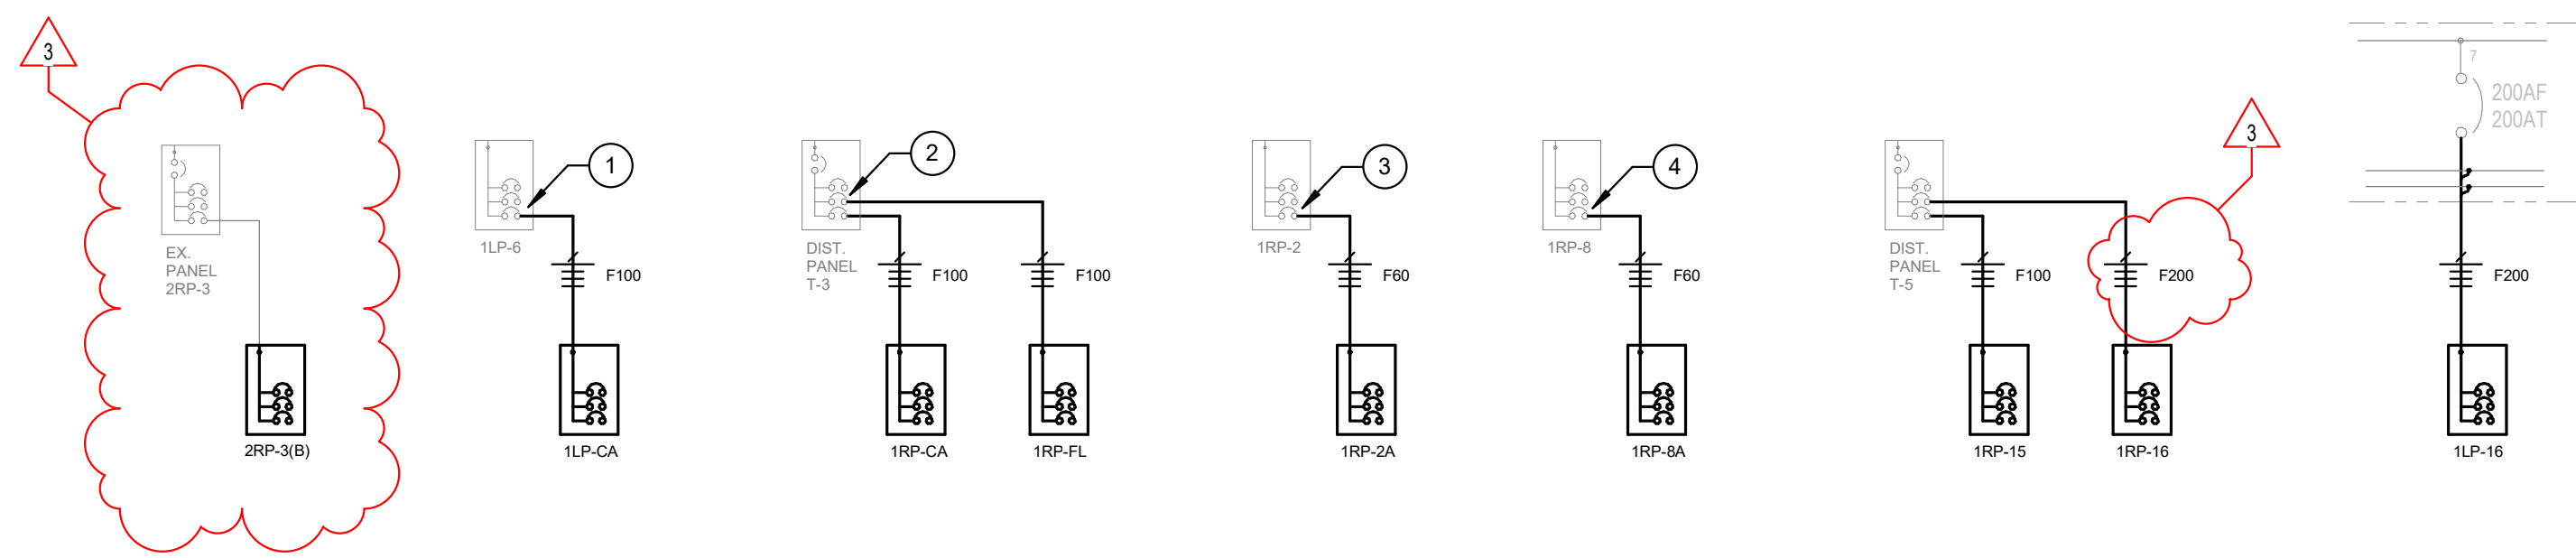

1 PARTIAL ONE-LINE DIAGRAMS  
NOT TO SCALE

PERRY TOWNSHIP SCHOOLS  
PERRY MERIDIAN HS PHASE II RENOVATIONS  
401 W MERIDIAN SCHOOL RD,  
INDIANAPOLIS, IN 46217

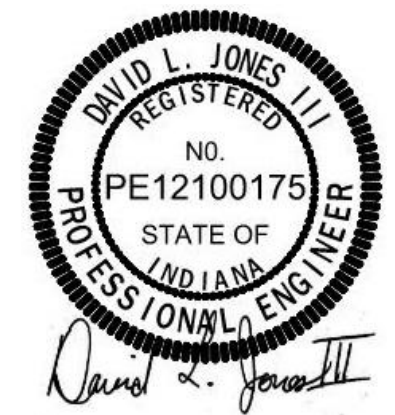

| REVISIONS: | Date       | Desc:       |
|------------|------------|-------------|
| #          |            |             |
| 1          | 09/23/2026 | ADDENDUM #3 |

100% CONSTRUCTION DOCUMENTS

|                  |
|------------------|
| PROJECT: #24173P |
| DATE: 08-21-2026 |
| DRAWN BY: AMN    |

ELECTRICAL  
ONE-LINE  
DIAGRAMS

E-701

LANCER ASSOCIATES  
ARCHITECTURE



145 N EAST ST.  
INDIANAPOLIS, IN 46204