




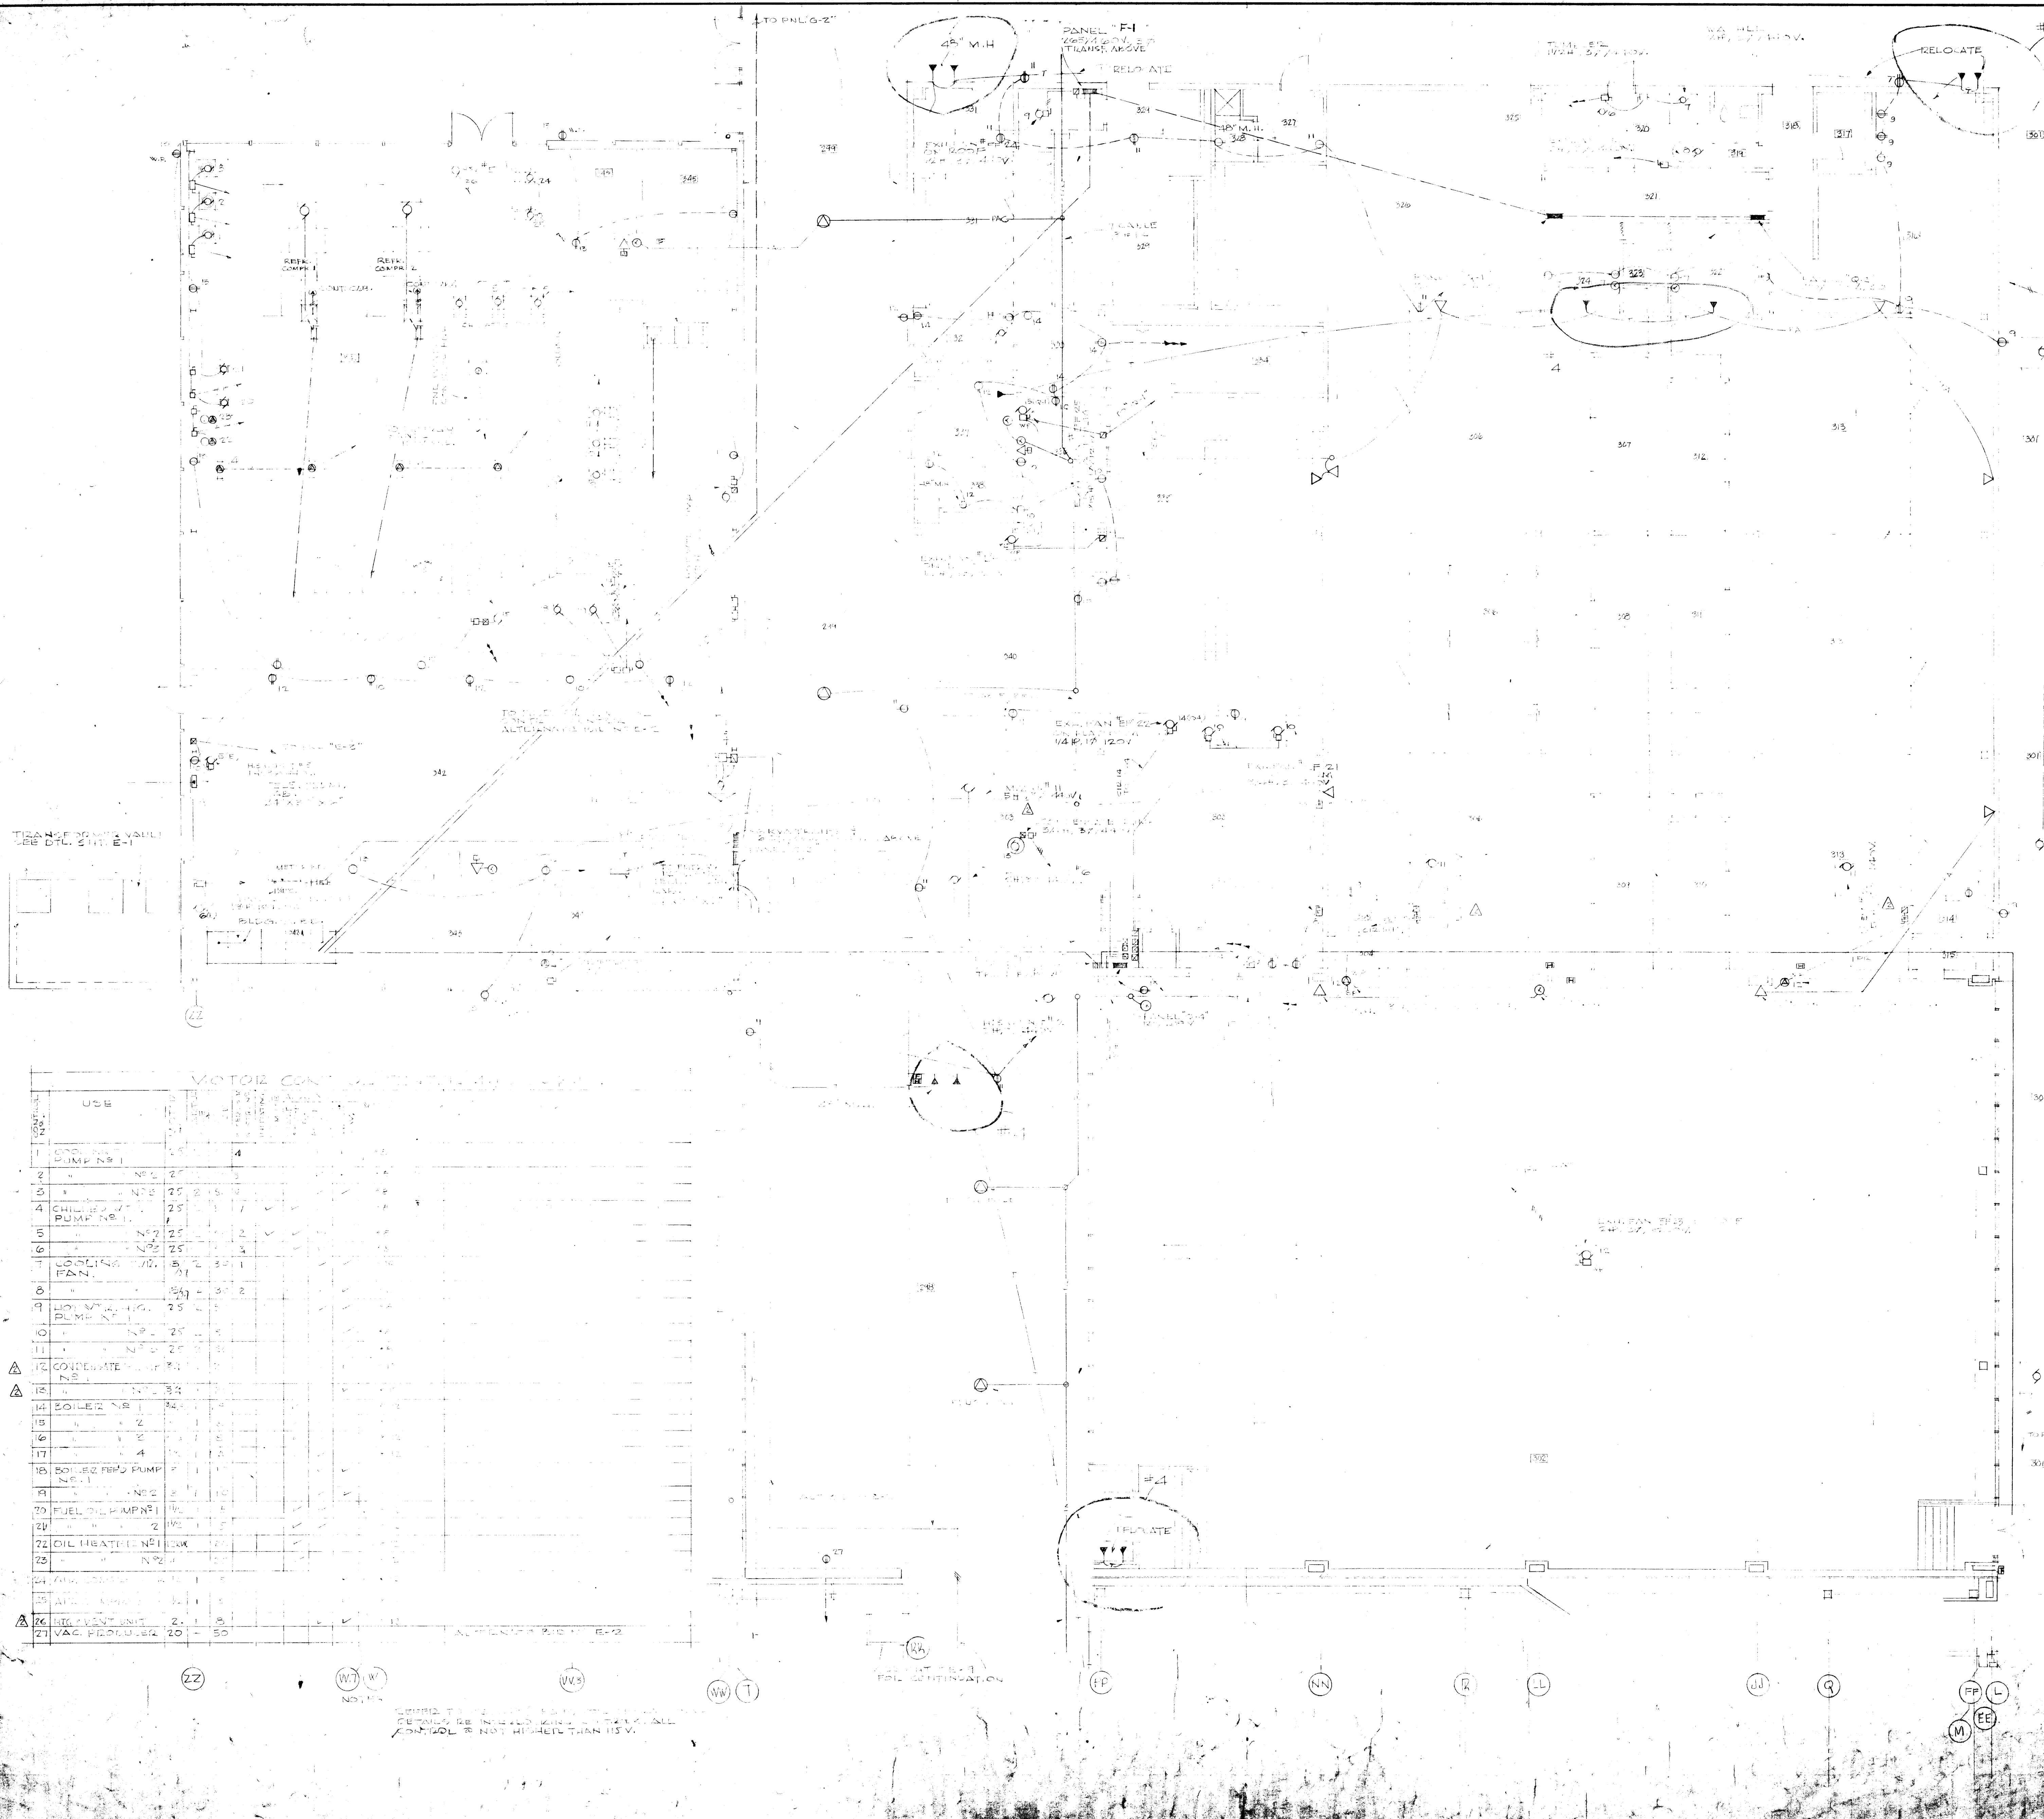


EQUIPMENT DATA			
NO.	DESCRIPTION	QTY	REMARKS
1	CONDENSATE PUMP NO. 1	1	
2	"	1	
3	"	1	
4	CHILLER NO. 1	1	
5	"	1	
6	"	1	
7	COOLING TOWER FAN	1	
8	"	1	
9	DO. V. H. P. NO. 1	1	
10	"	1	
11	"	1	
12	CONDENSATE PUMP NO. 2	1	
13	"	1	
14	SOLENOID VALVE NO. 1	1	
15	"	1	
16	"	1	
17	"	1	
18	SOLENOID VALVE PUMP NO. 1	1	
19	"	1	
20	FUEL OIL PUMP NO. 1	1	
21	"	1	
22	OIL HEATER NO. 1	1	
23	"	1	
24	"	1	
25	"	1	
26	REC. VOLT. UNIT	1	
27	VAC. FLOOR BOX	10	

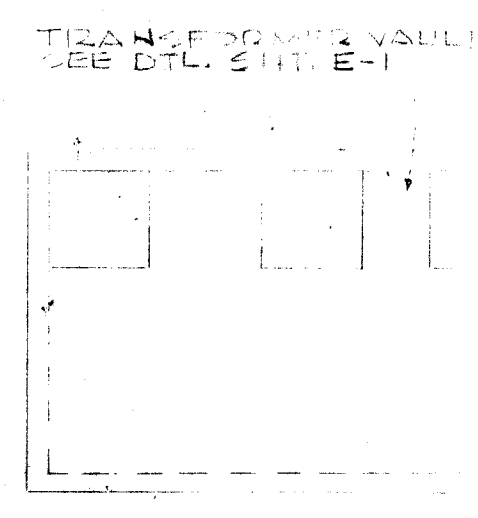

- 1. MOUNTING HT. OF ALL CONVENIENCE OUTLETS TO BE 4' TO 6' UNLESS OTHERWISE NOTED ON PLANS.
- 2. ALL FLOOR OUTLETS TO CONSIST OF FLOOR BOX EXTENSION FITTING (RESEPTABLE) AS NOTED.
- 3. ALL DUPLEX RECEPTACLES IN MOVABLE TYPE PARTITIONS TO BE TWO "DESPARD" TYPE RECEPTACLES IN ONE BOX.
- 4. MOUNTING HT. OF ALL MICROPHONE OUTLETS TO 20' TO 6' UNLESS OTHERWISE NOTED.
- 5. MOUNTING HT. OF ALL CLOCKS & LOGSPEAKERS TO BE 60" TO 6' UNLESS BOTH DEVICES ARE MOUNTED ON SAME PARTITION POST PER ELEVATION NO. 1.

UNIT HT. 10' 1/2" 1/2" SUSP. ABOVE C.L.G.

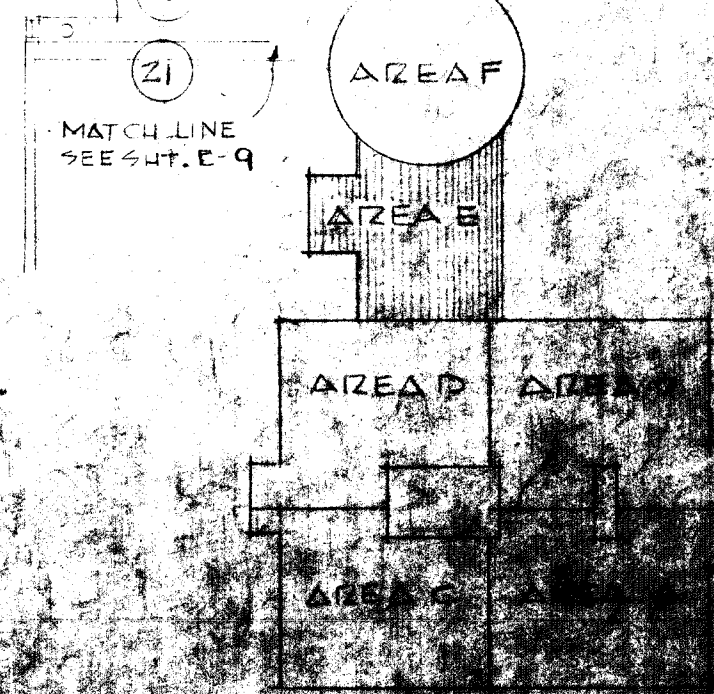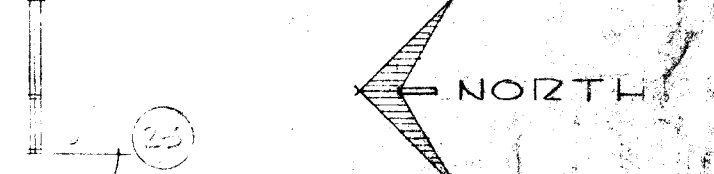

943
DATE 7/24/41
REV. 062

SHEET NUMBER
E-11
OF SHEETS

FLOOR PLAN AREA "E"

LAWRENCE CENTRAL SENIOR HIGH SCHOOL
MARION COUNTY, INDIANA

9719 MEADOWS DRIVE
INDIANAPOLIS 5, INDIANA

West Equipt