


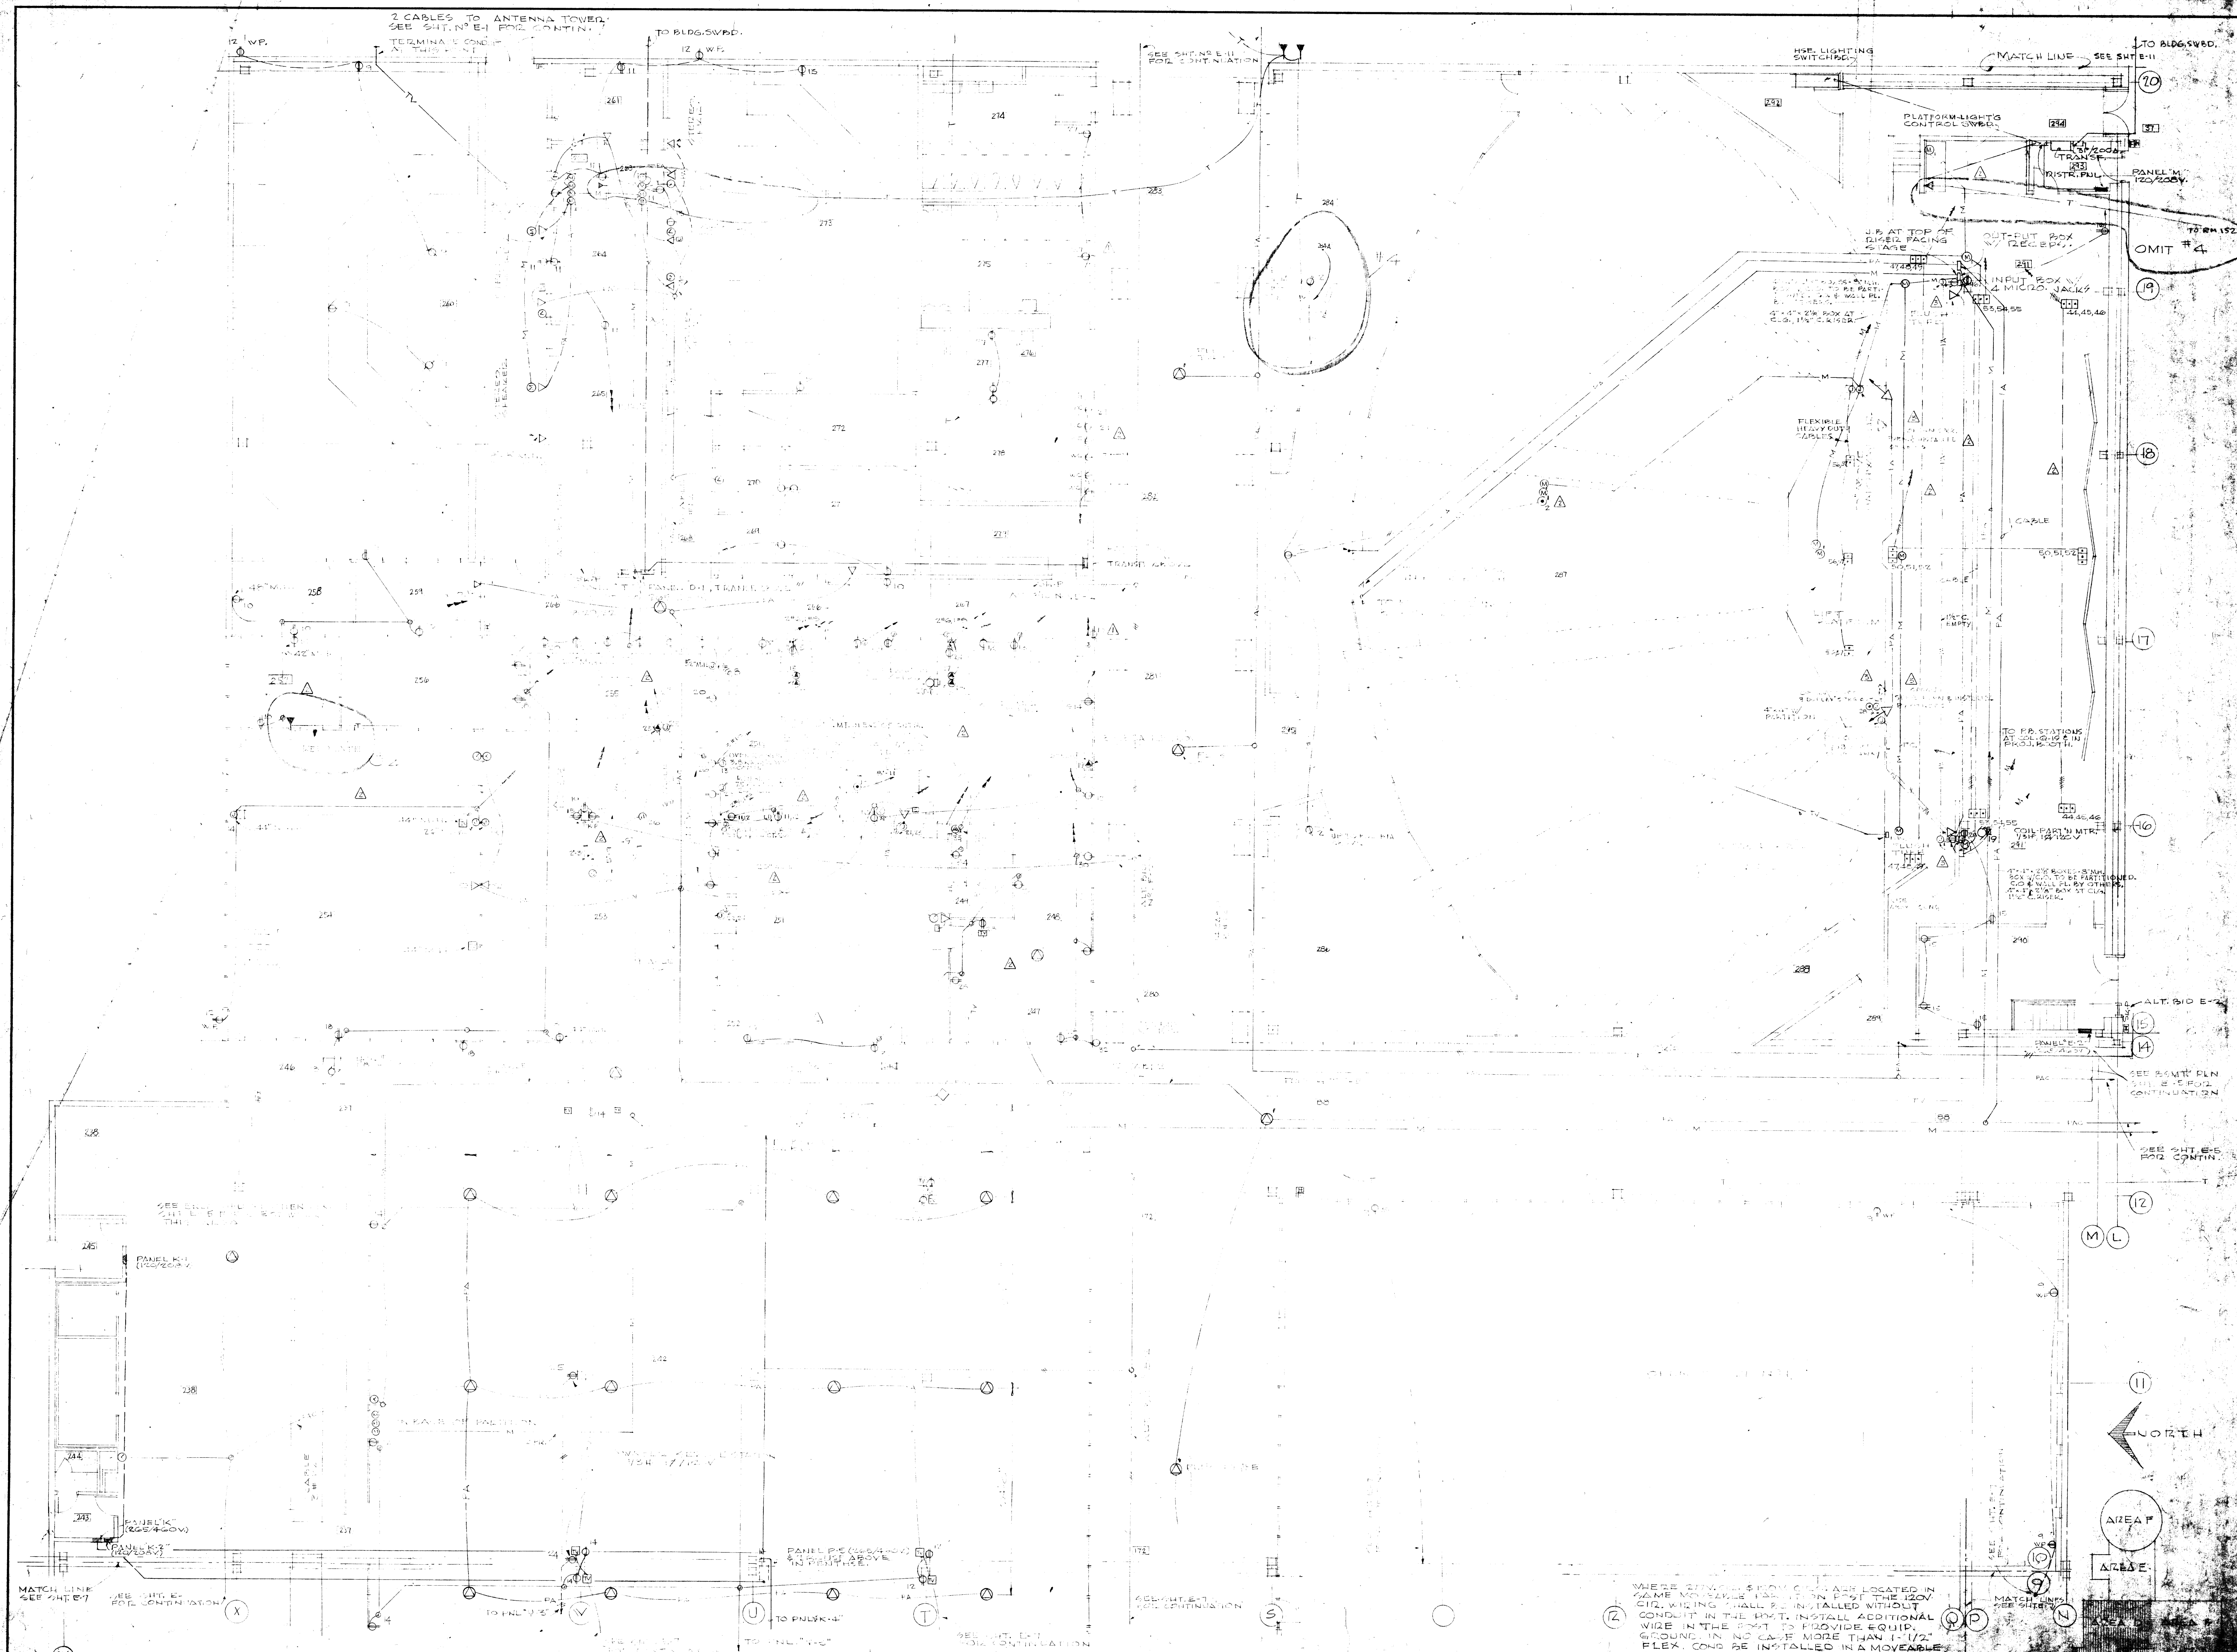

FLOOR PLAN AREA D

WHERE 27" MOVABLE PARALLEL TRACKS ARE LOCATED IN SAME MOVABLE PARALLEL TRACK THE 120V CIRCUIT WIRING SHALL BE INSTALLED WITHOUT CONDUIT IN THE RAIL. INSTALL ADDITIONAL WIRE IN THE RAIL TO PROVIDE EQUIP. GROUND IN NO CASE MORE THAN 1-1/2' FLEX. COND. BE INSTALLED IN A MOVABLE PARALLEL TRACK.

FILE NO. 214C
DRAWN BY JHE
DATE 1/2/64
REV. 002

SHEET NUMBER
F-9
OF SHEETS

PROJECT
LAWRENCE CENTRAL SENIOR HIGH SCHOOL
MARION COUNTY, INDIANA

1989 MEADOWS DRIVE
INDIANAPOLIS, INDIANA

NO.	DESCRIPTION	DATE	BY	CHKD.	
1	REV. TYPING ON LINES 1, 2, 3, 99, 100				