

REMODELING OF

LAWRENCE CENTRAL HIGH SCHOOL AND

CRAIG JUNIOR HIGH SCHOOL

FOR THE

METROPOLITAN SCHOOL DISTRICT OF LAWRENCE TOWNSHIP

MARION COUNTY, INDIANA

THESE SPECIFICATIONS ARE HEREBY APPROVED AND ADOPTED THIS 18th DAY OF APRIL, 1978, BY THE FOLLOWING MEMBERS OF THE METROPOLITAN SCHOOL DISTRICT OF LAWRENCE TOWNSHIP, MARION COUNTY, INDIANA:

BOARD OF EDUCATION

MRS. EDITH MESSERSMITH
VICE PRESIDENT

KENNETH McGLOTHIN
PRESIDENT

DR. ROBERT W. PALMER
MEMBER

FREDERICK J. MILLER
SECRETARY


SMYSOR O. BRUCE
MEMBER


ADMINISTRATIVE STAFF

JOHN NEWKIRK
ADMINISTRATIVE ASSISTANT
FOR BUSINESS AFFAIRS


DR. BERNARD K. MCKENZIE
SUPERINTENDENT OF SCHOOLS

JACK OKEY
ENGINEER FOR PLANT
FACILITIES

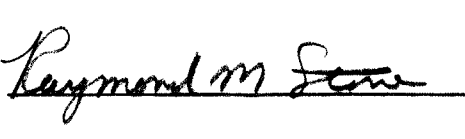
RAYMOND M. STONE
REGISTERED ENGINEER NO. 6143

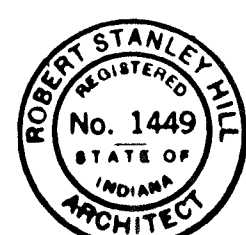


ROBERT S. HILL
REGISTERED ARCHITECT NO. 1449

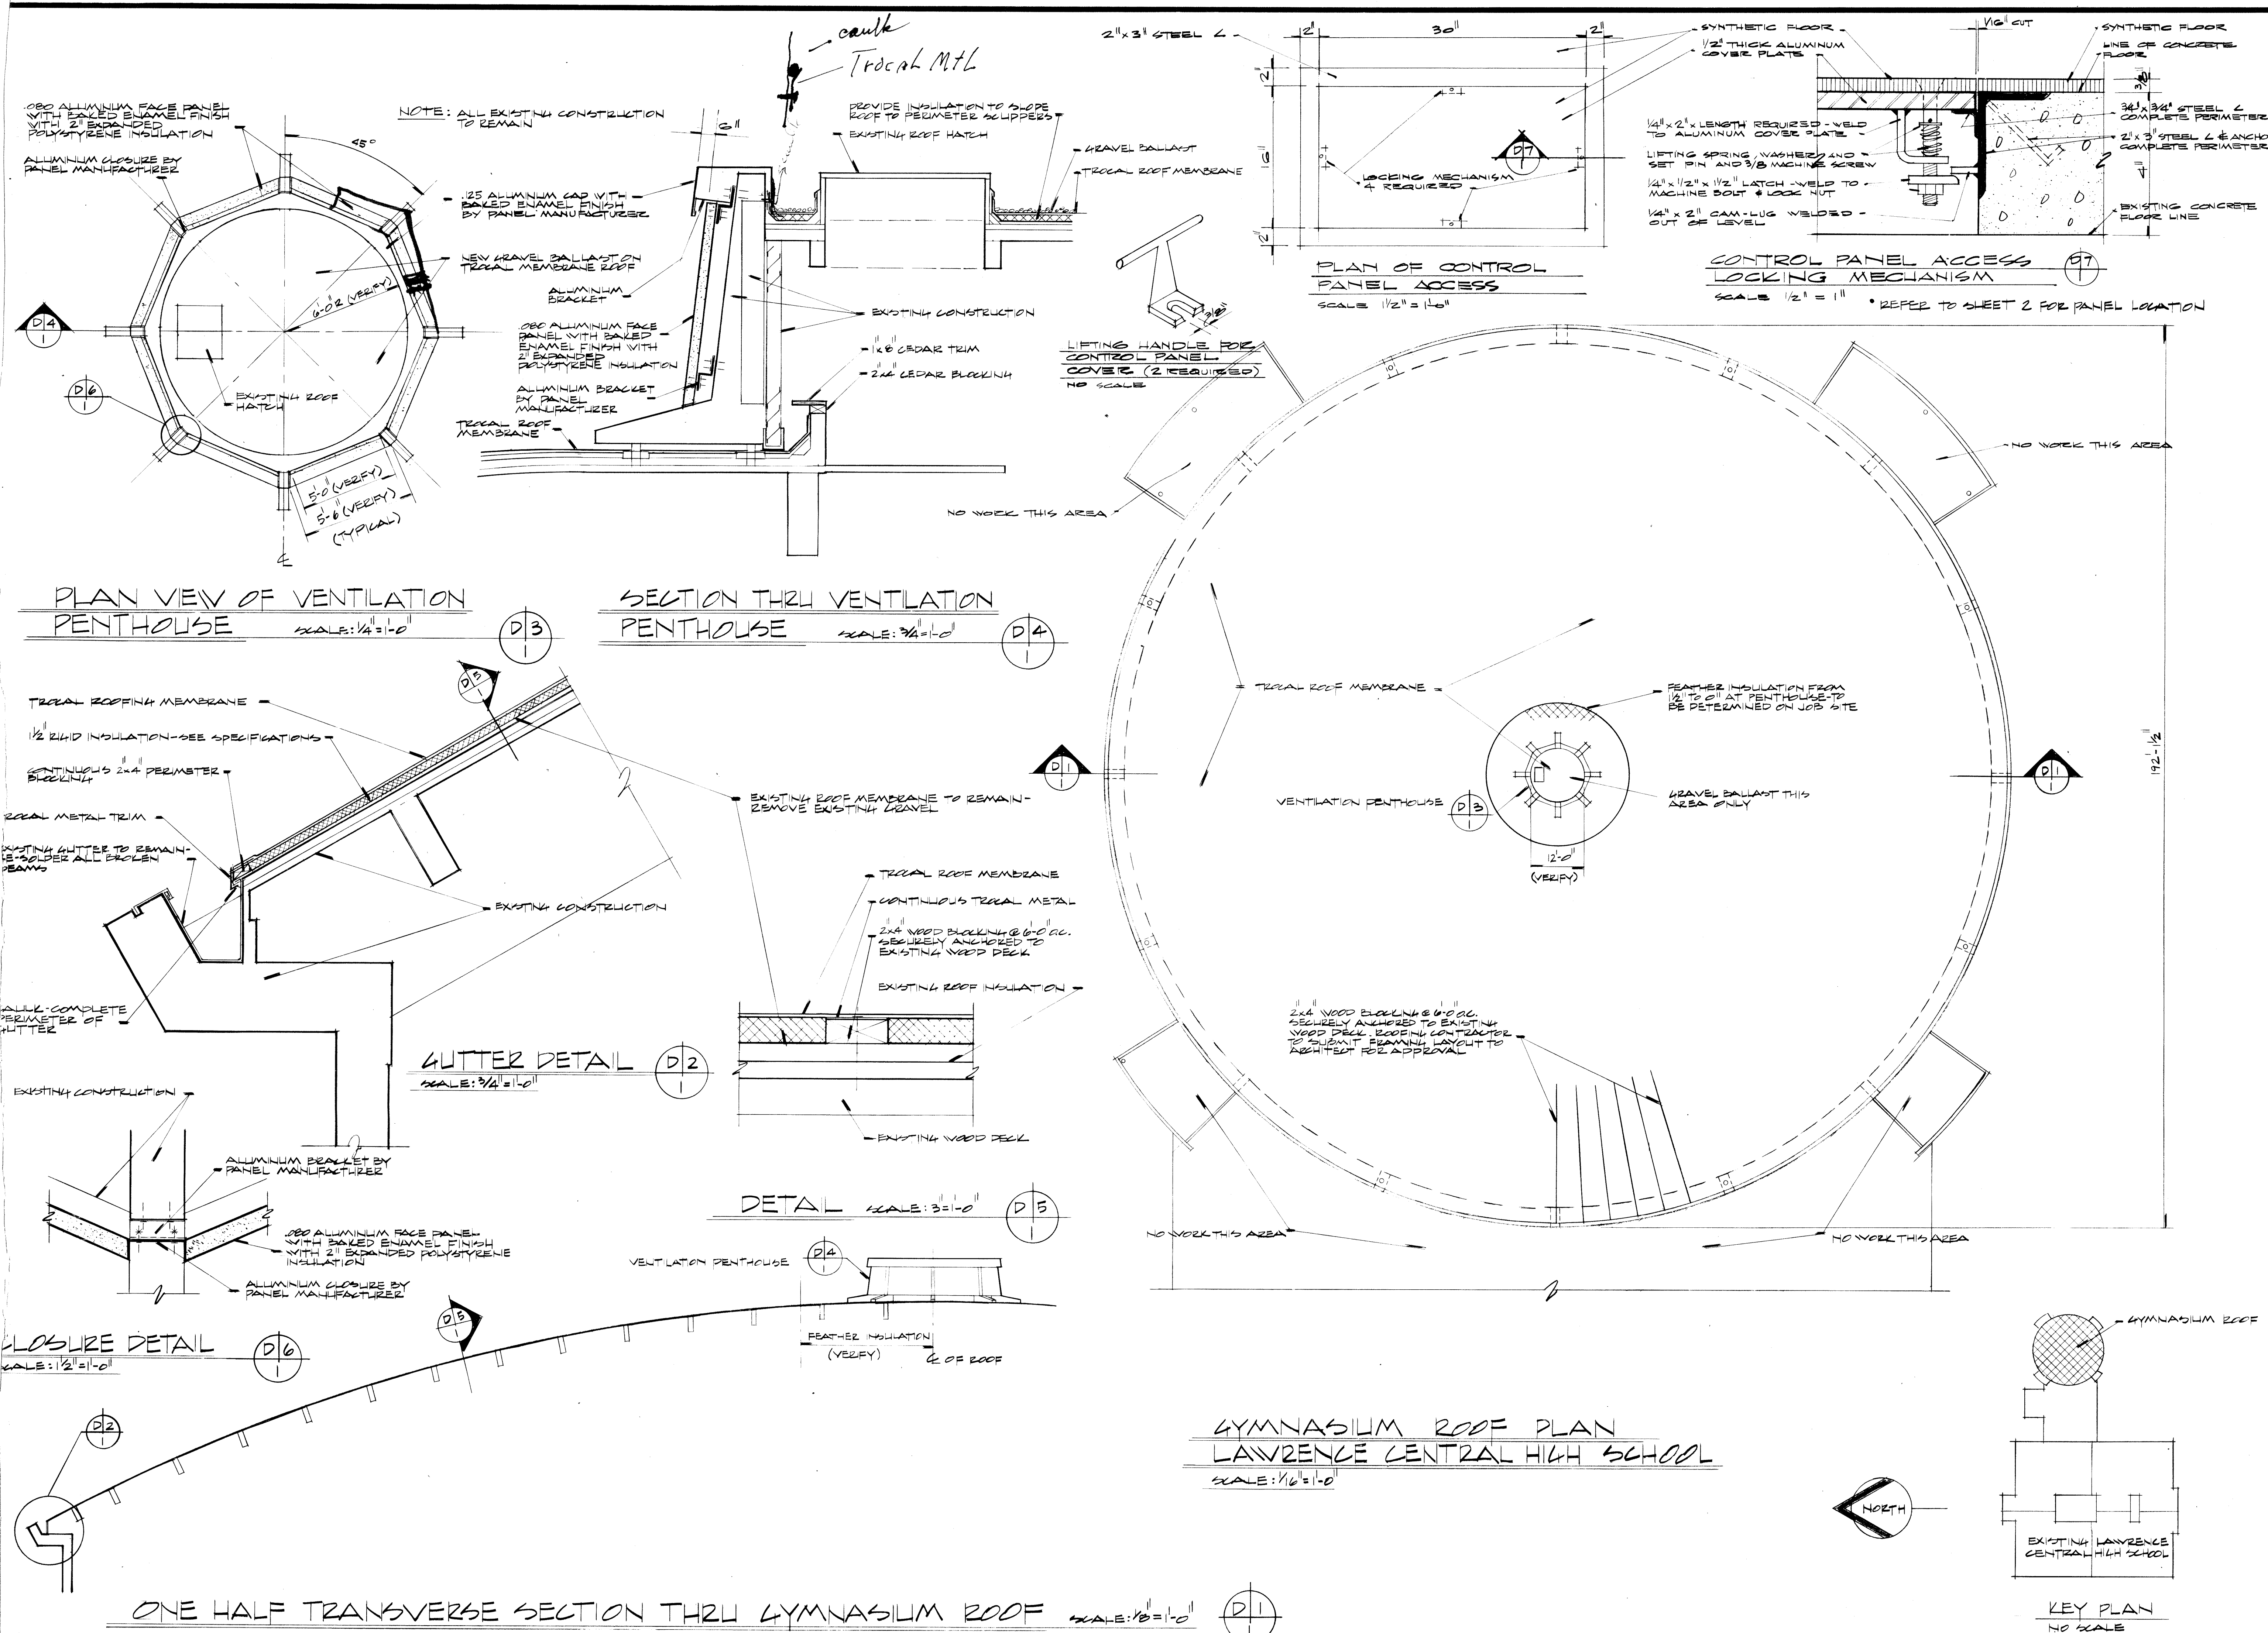

ARCHITECTS
EVERETT · I · BROWN COMPANY
ENGINEERS
INDIANAPOLIS, INDIANA · 46241
· PARK FLETCHER ·

PROJECT 678


DATE MAY 1, 1978

REVISED


NO. 1

OF 4

LAWRENCE CENTRAL HIGH SCHOOL

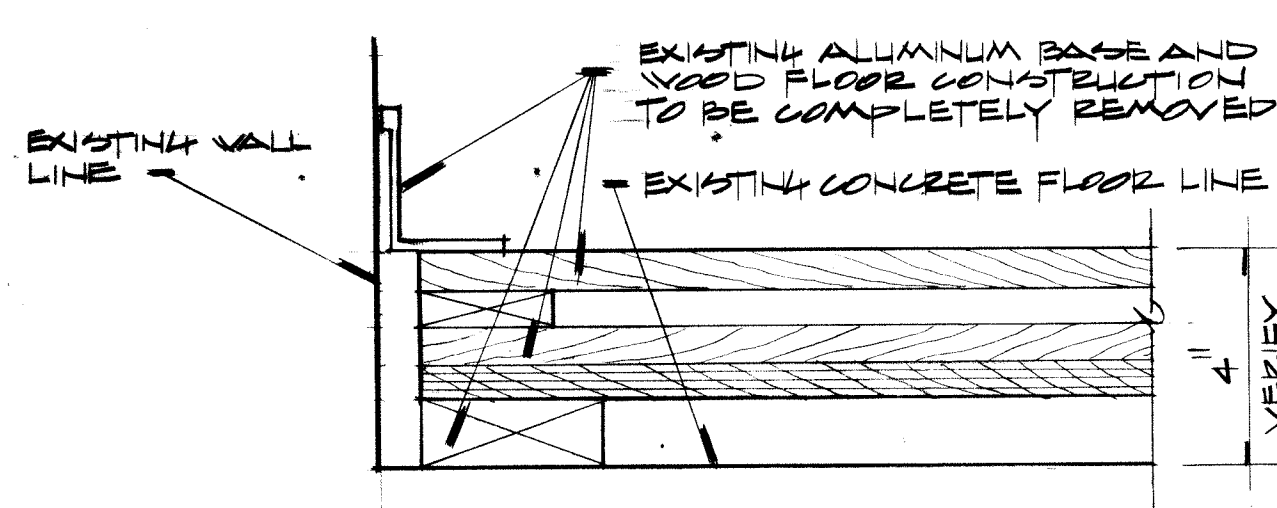


EXISTING GYMNASIUM FLOOR
CONSTRUCTION SCALE: 3/8"=1'-0"
(VERIFY ALL EXISTING DIMENSIONS & CONDITIONS)

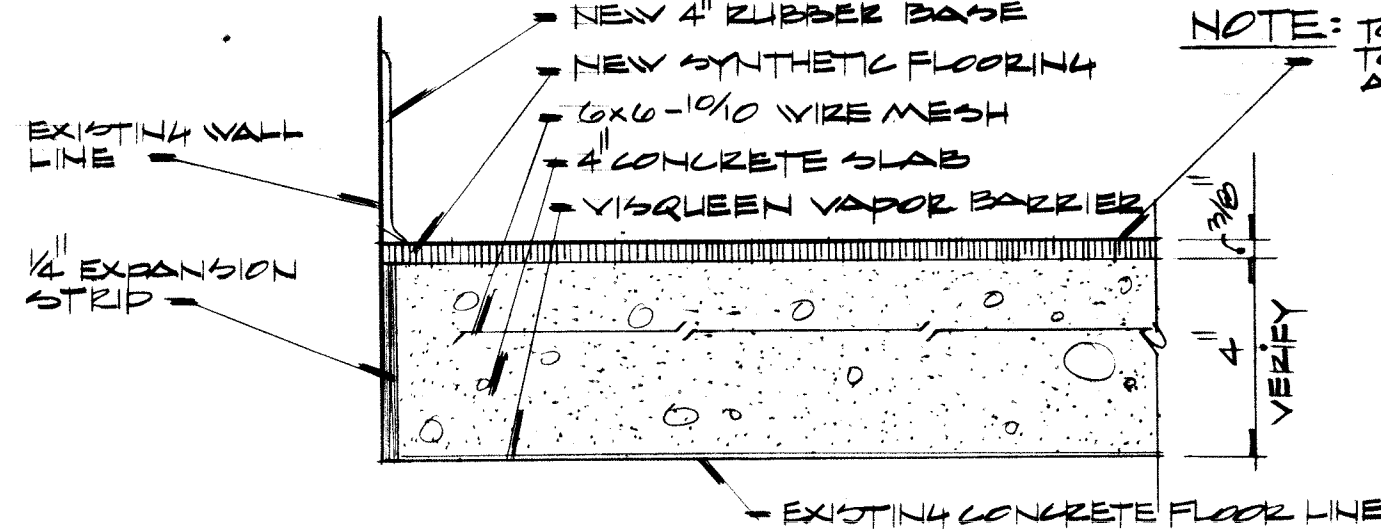


NEW GYMNASIUM FLOOR
CONSTRUCTION SCALE: 3/8"=1'-0"


NOTE: TOP OF SYNTHETIC FLOOR TO FINISH FLUSH WITH ALL ADJOINING FLOORS

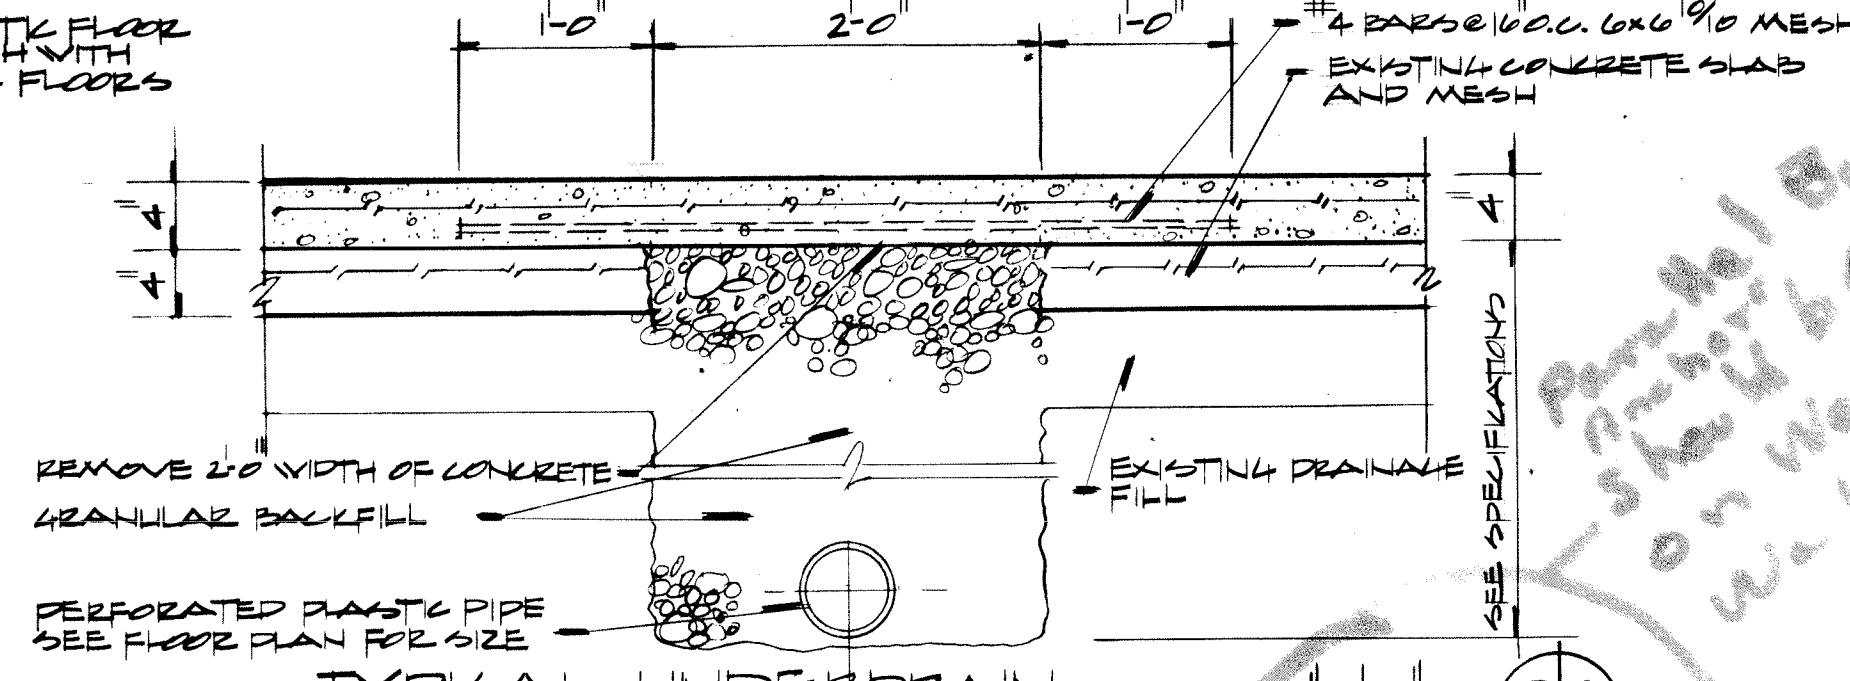

TYPICAL UNDERDRAIN SCALE: 1/2"=1'-0"

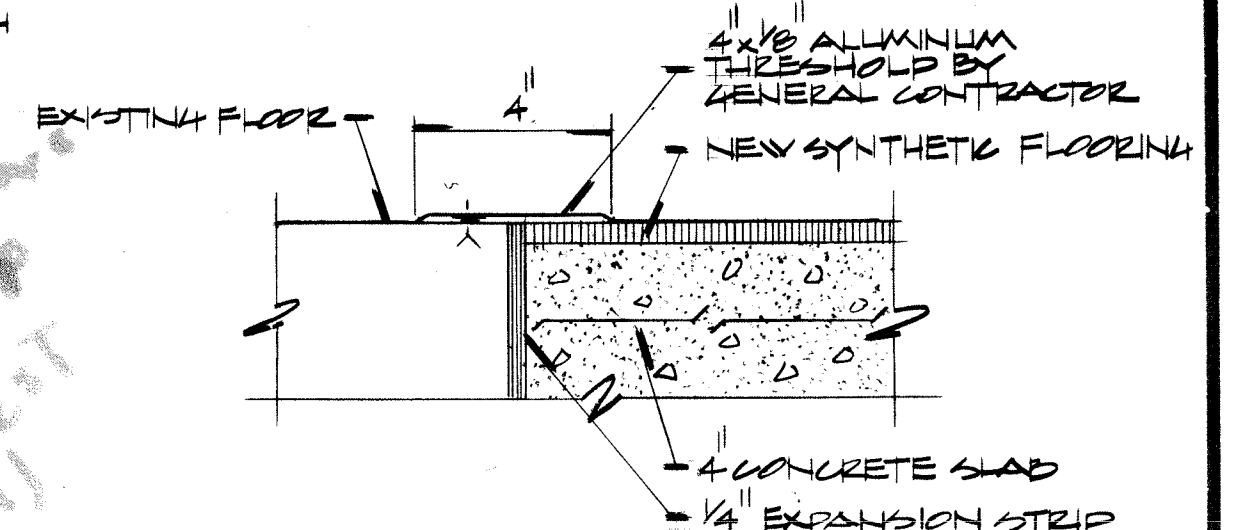


THRESHOLD DETAIL SCALE: 3/8"=1'-0"

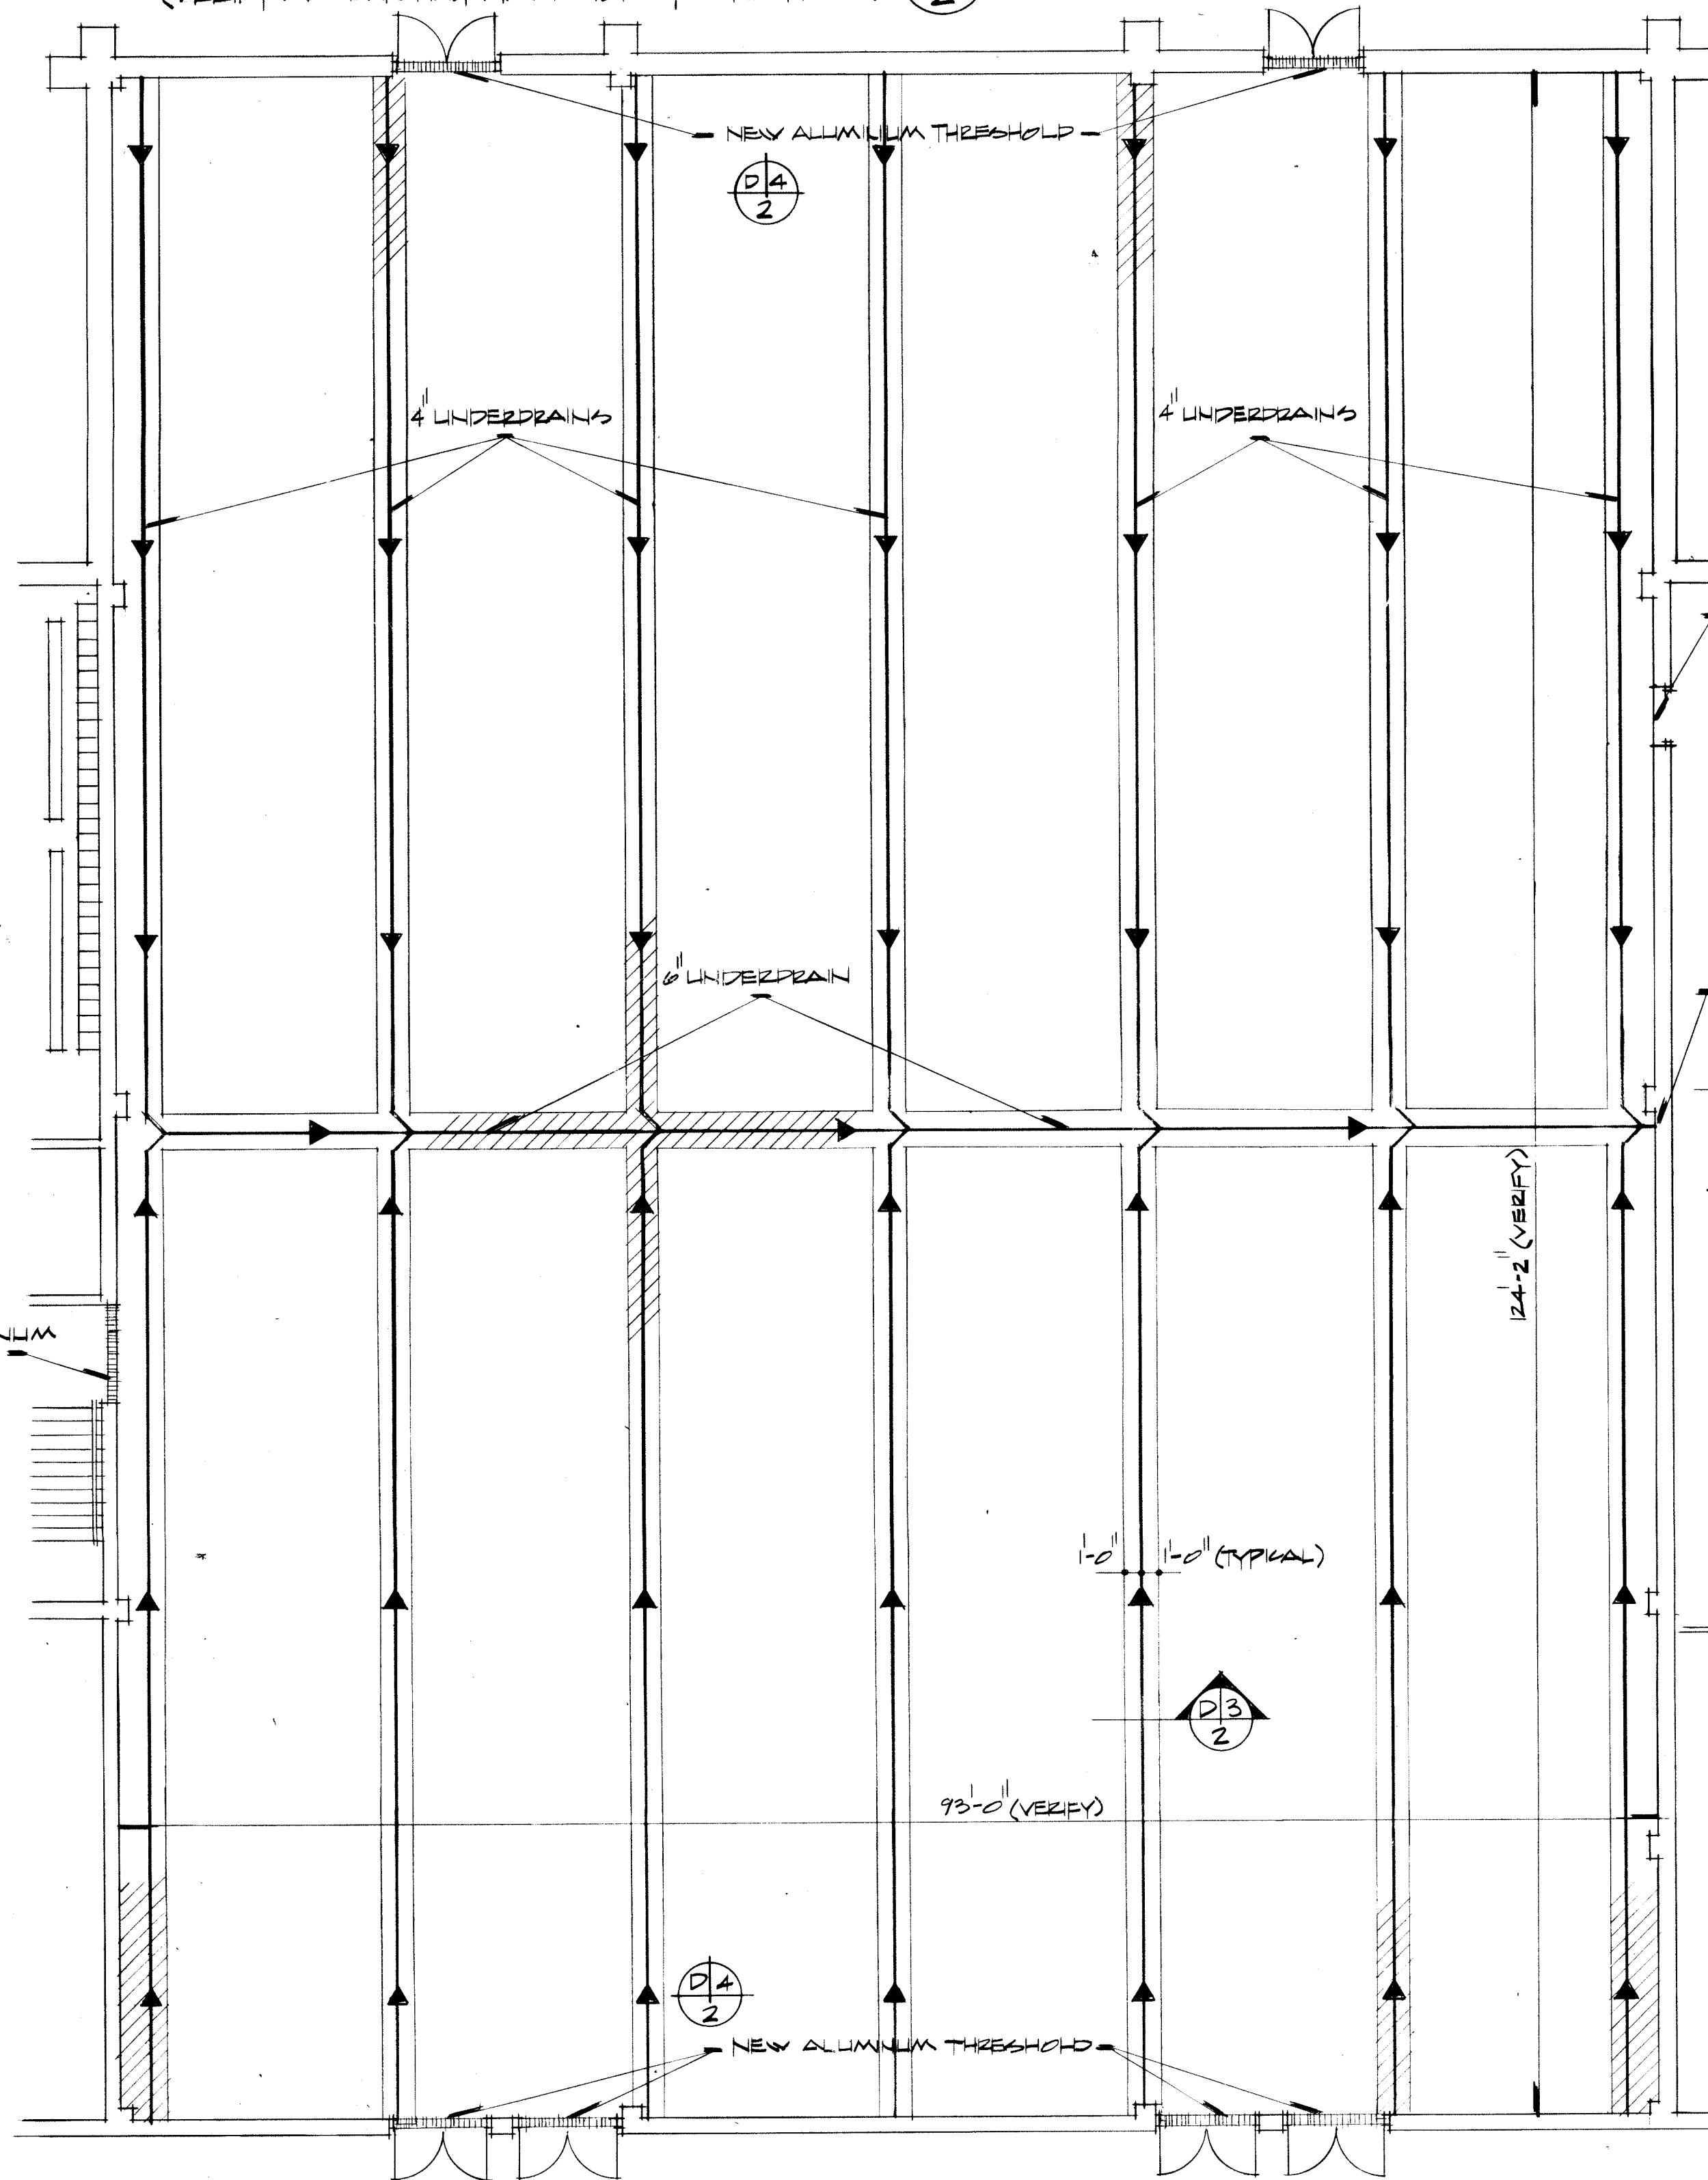


FLOOR PLAN OF EXISTING GYMNASIUM
SHOWING UNDERDRAIN LOCATION
SCALE: 1/8"=1'-0"

NOTE: → DIRECTION OF SLOPE FOR DRAINAGE


PLAN NOTE 1
DOOR CONCRETE SLAB
BEFORE BLEACHER SECTION
PRIOR TO POURING NEW
GYMNASIUM CONCRETE FLOOR
SLAB. TOP OF BLEACHER SLAB
TO BE FLUSH WITH TOP OF NEW
GYMNASIUM FLOOR.

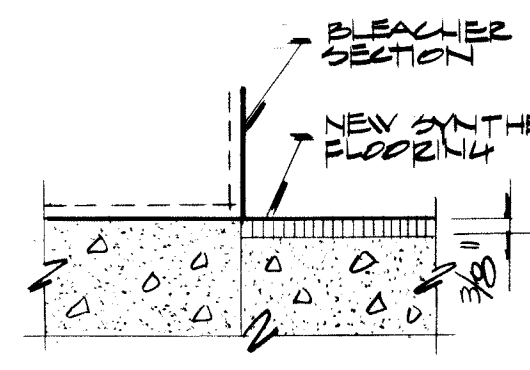

DETAIL SCALE: 3/8"=1'-0"

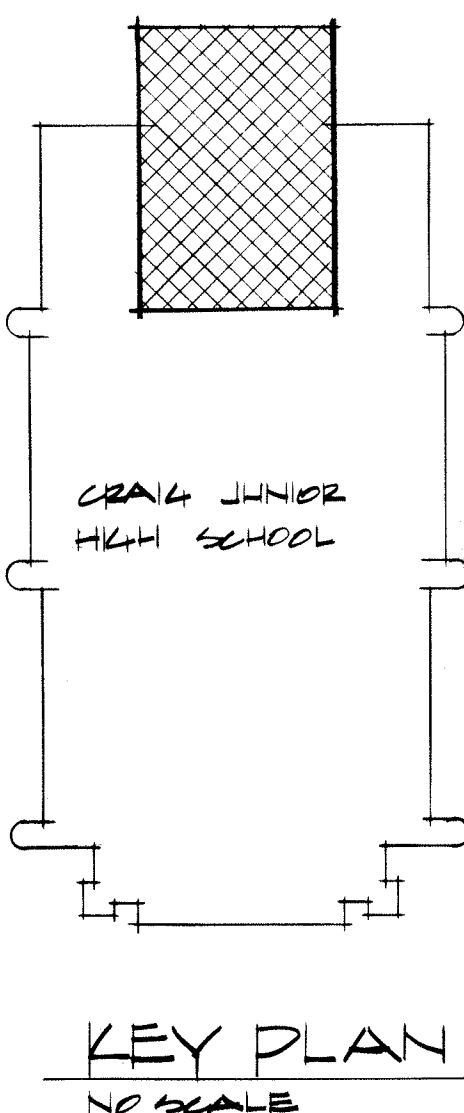

KEY PLAN
NO SCALE

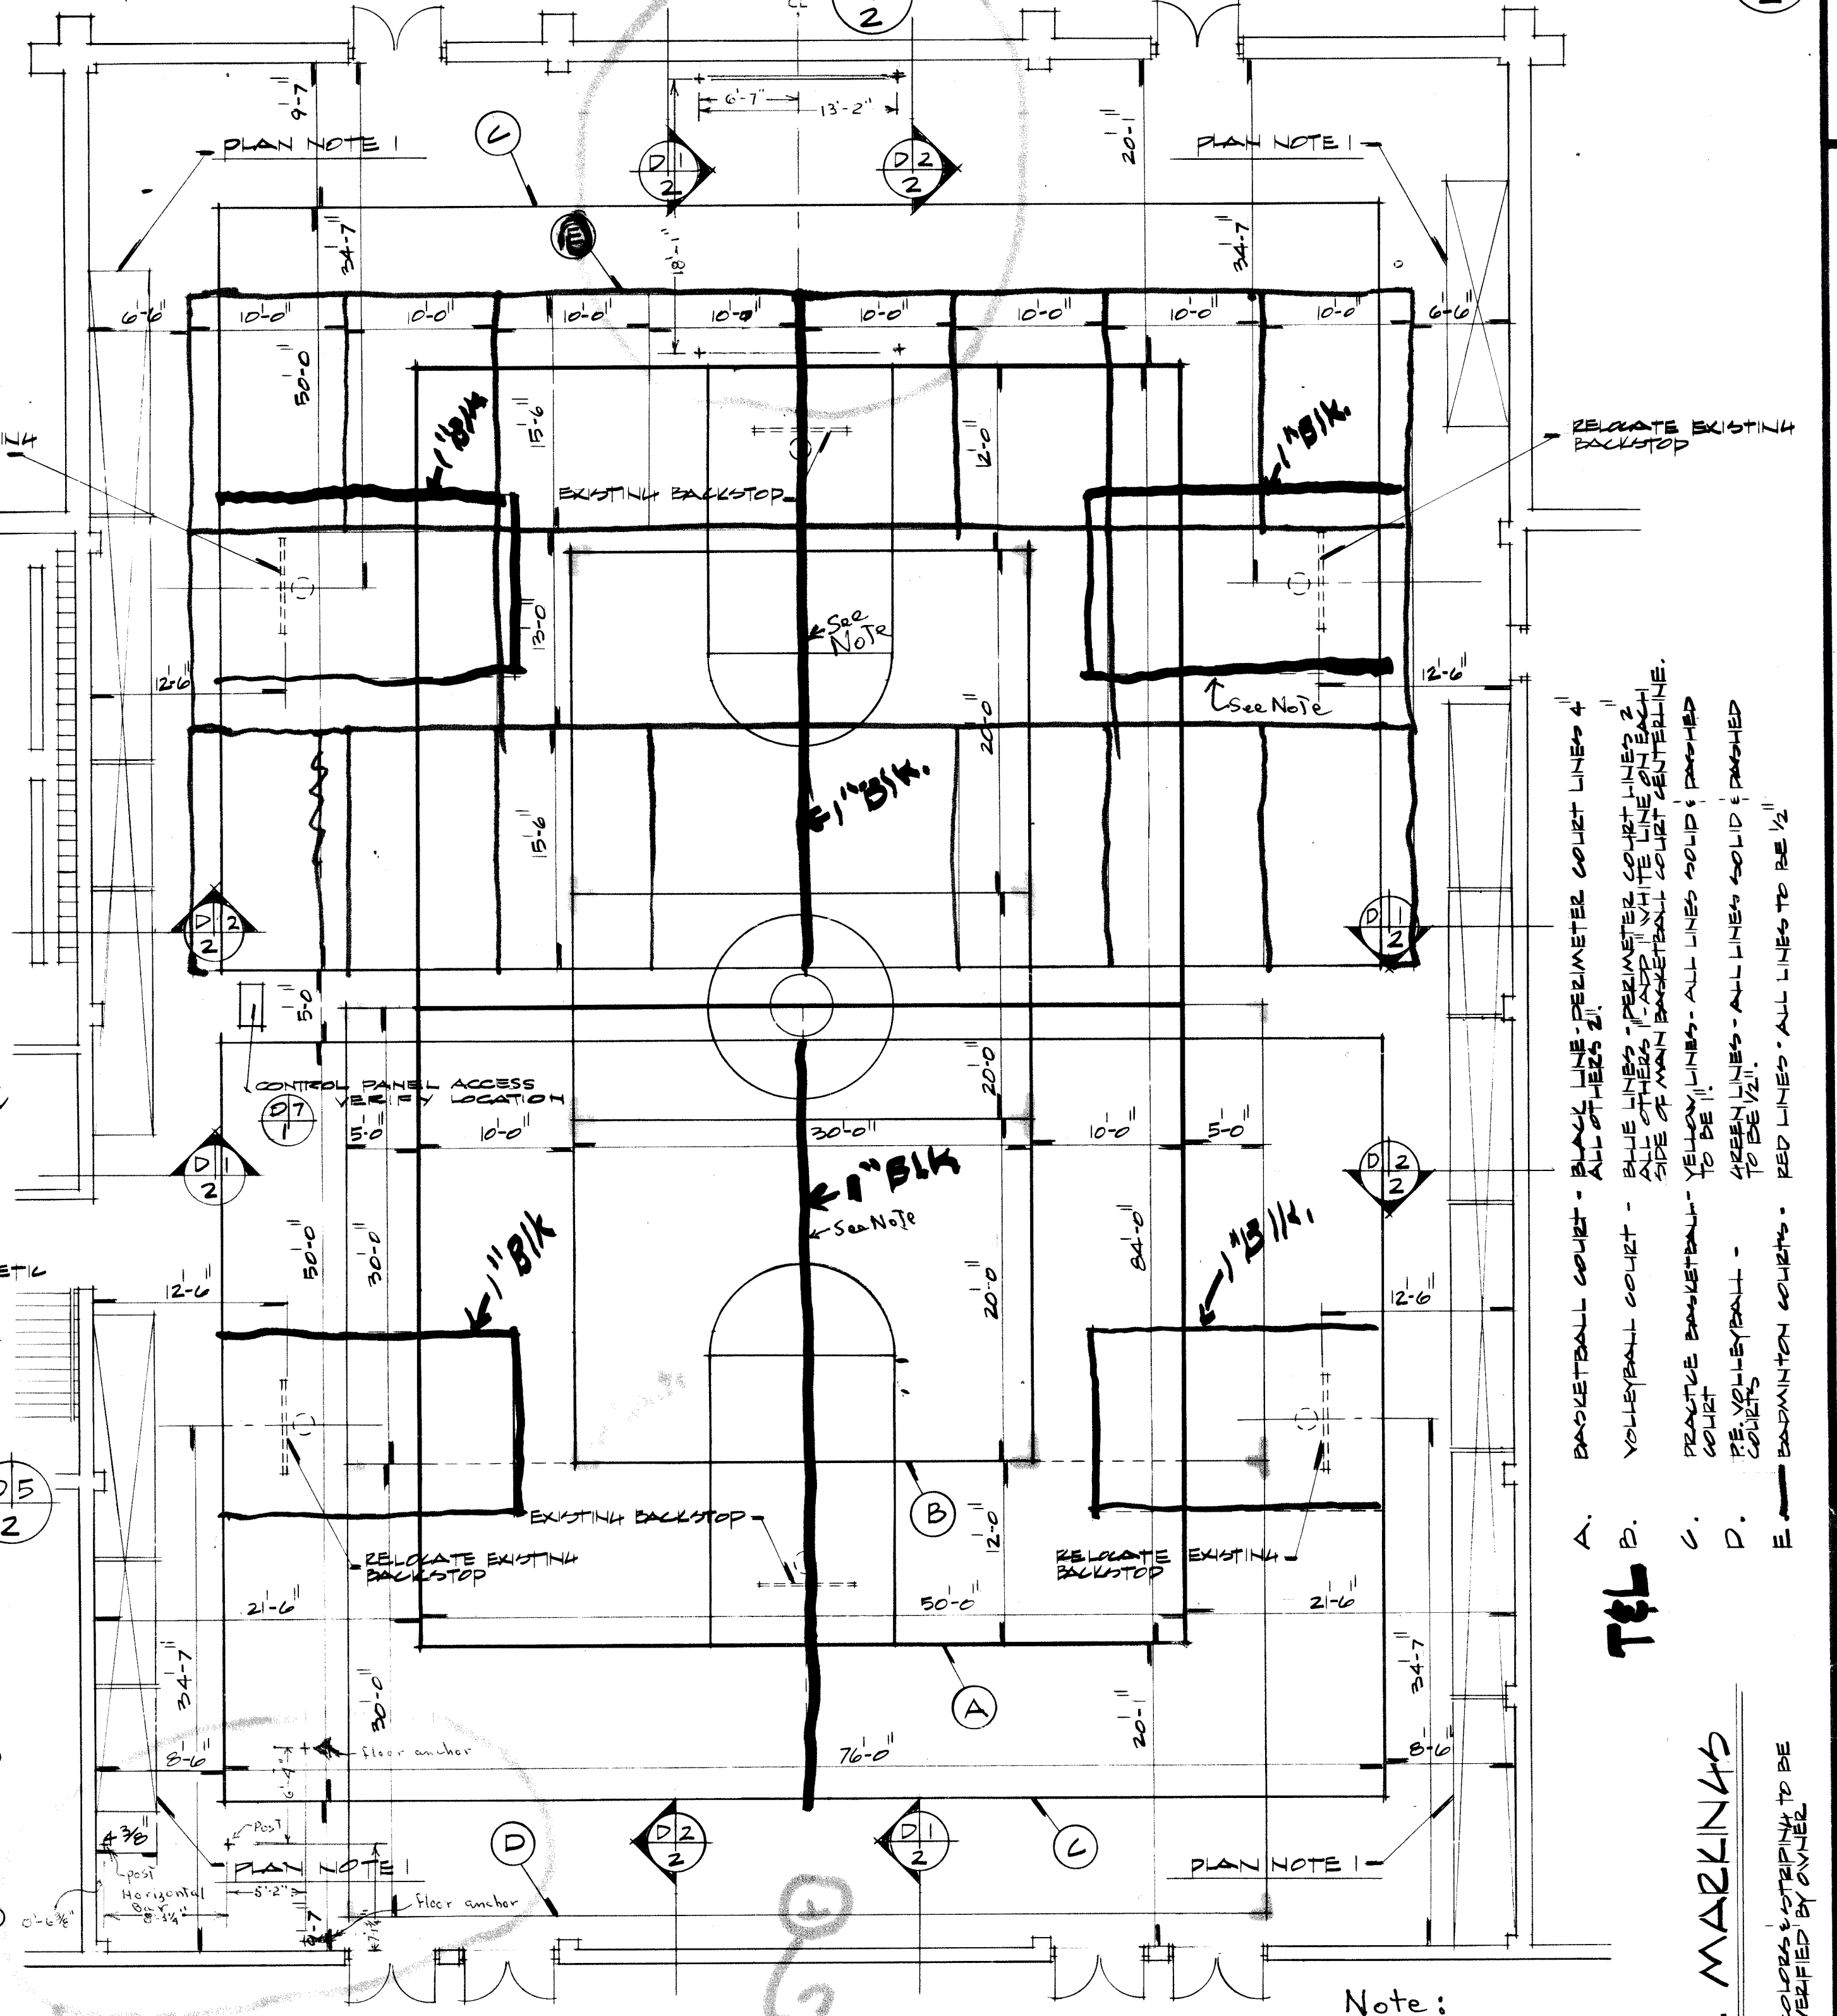

FLOOR PLAN OF EXISTING GYMNASIUM SHOWING
NEW FLOOR AND FLOOR MARKINGS
SCALE: 1/8"=1'-0"

Note:
(As per agreement on 10/23/78
at 13:15 with Fran, Tim
& Joe, Ken & Jack)
1. Use 1" Black centerline
for both practice basketball
courts
2. Use full box at each
goal for both practice basketball
courts - with station lines.
3. Use station lines at both boxes
for main basketball court.

- LEGEND
- A. BASKETBALL COURT - BLACK LINE - PERIMETER COURT LINES 4"
 - B. VOLLEYBALL COURT - BLUE LINES - PERIMETER COURT LINES 2"
 - C. PRACTICE BASKETBALL COURT - ALL OTHERS 1" WHITE LINE - CENTERLINE
 - D. PRACTICE BASKETBALL COURT - ALL OTHERS 1" WHITE LINE - CENTERLINE
 - E. BASKETBALL COURT - ALL OTHERS 1" WHITE LINE - CENTERLINE

NOTE: SOLID LINES TO BE VERIFIED BY OWNER

EVERETT · I · BROWN COMPANY
ARCHITECTS
ENGINEERS
5500 WEST BRADBURY AVENUE · INDIANAPOLIS, INDIANA · 46241
PARK FLETCHER ·

CRAIG JUNIOR HIGH SCHOOL


PROJECT 678	DATE MAY 1, 1978	REVISED
----------------	---------------------	---------

NO. 2
OF 4

CIRCULATING PUMP SCHEDULE							
NO.	SYSTEM SERVED	MODEL NUMBER	SIZE OR MODEL	G. P. M.	FEET HEAD	H. P.	SEE NOTE
1	DOMESTIC HOT WATER RECIRCULATING	BOOSTER	B-1"-HV	10	12	1/6	1, 2, 3
2	DOMESTIC HOT WATER RECIRCULATING	BOOSTER	B-1"-HV	10	12	1/6	1, 2, 3

- NOTES:
- Pump Motor: 115 volts, 1 phase, 60 hertz, 1750 RPM.
 - Pump shall start and stop on 10° temperature variation in return mains.
 - THE MECHANICAL CONTRACTOR SHALL DO ALL ELECTRICAL WIRING REQUIRED TO DISCONNECT EXISTING PUMPS & RECONNECT NEW PUMPS.



- NOTES:
- Connect new piping to existing and provide new valve as shown.
 - The Mechanical Contractor will be responsible for removing and re-installing of all ceiling construction in regard to this work.
 - NEW PIPING SHALL BE INSULATED AND MARKED. SEE SPECIFICATIONS.

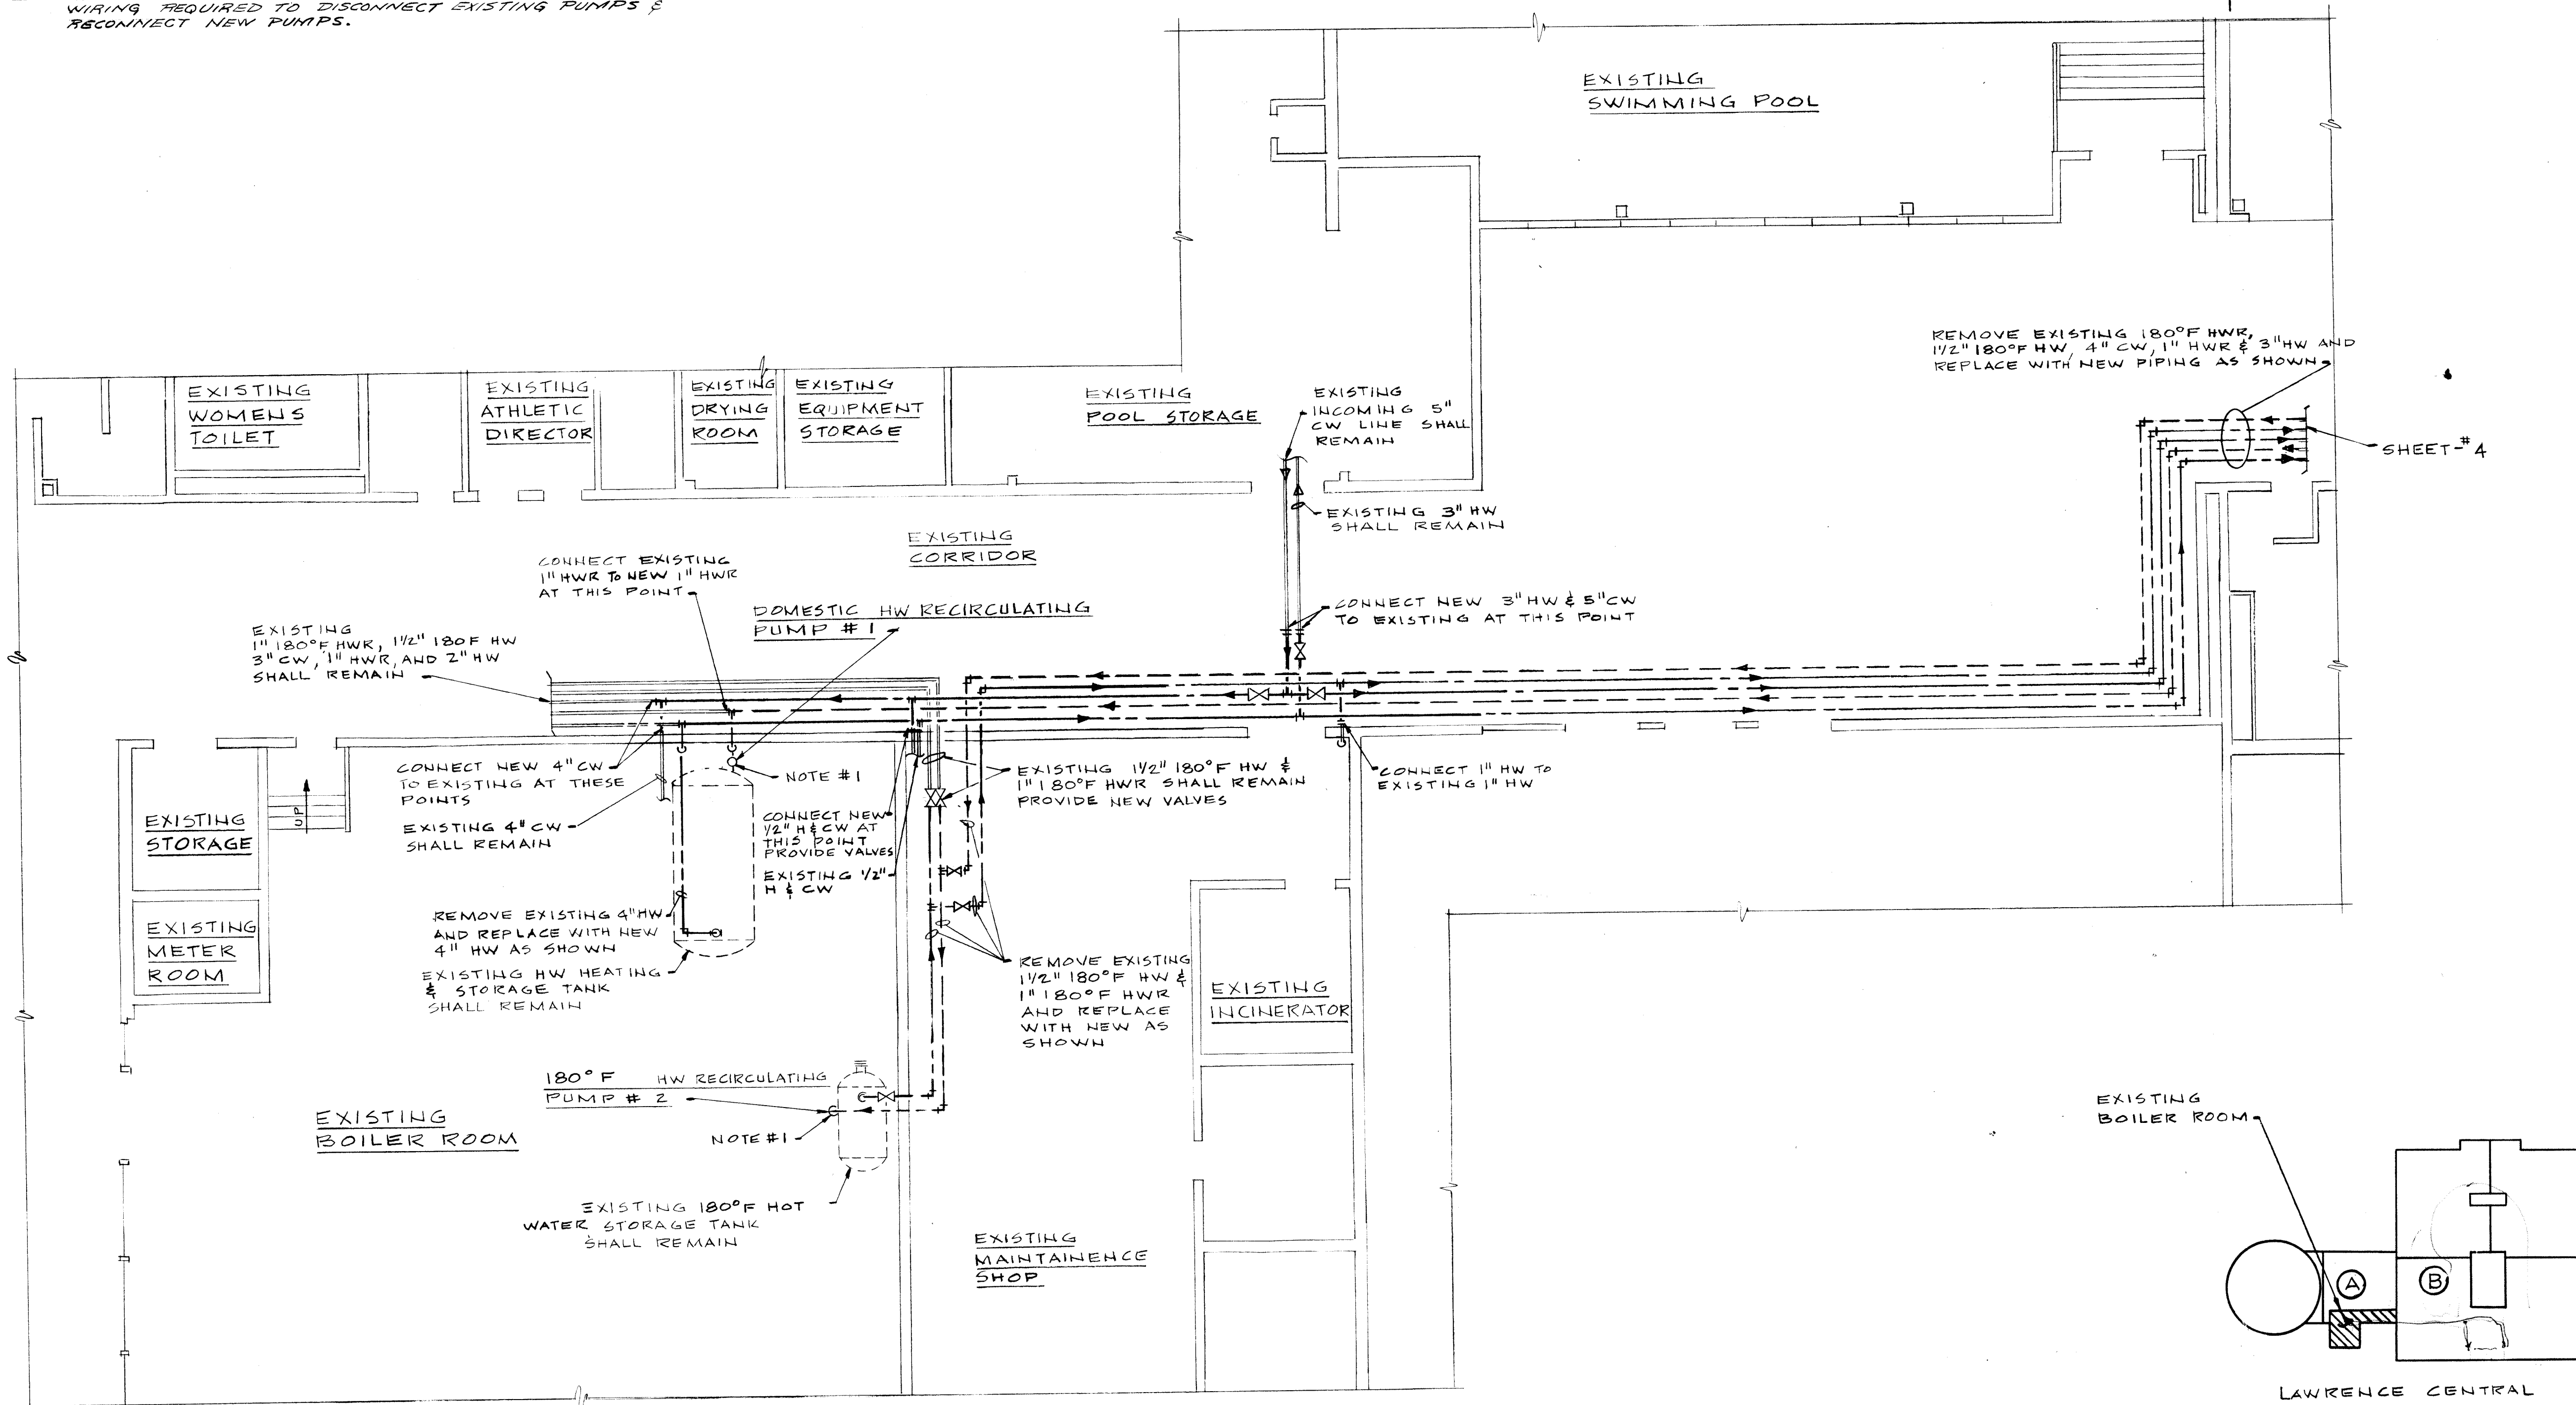

SHEET #4

UNIT "A" LAWRENCE CENTRAL PIPING REPLACEMENT FLOOR PLAN



SCALE: 1/8" = 1'-0"

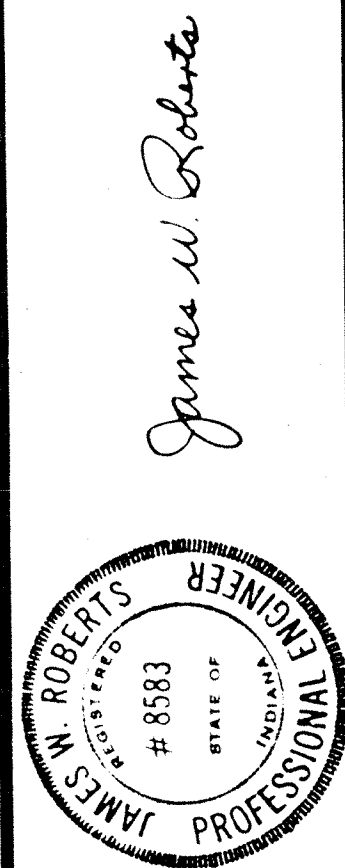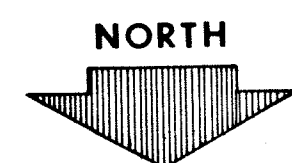

EVERETT · I · BROWN COMPANY
ARCHITECTS
ENGINEERS
· INDIANAPOLIS, INDIANA · 46241
· PARK FLETCHER ·
5500 WEST BRADBURY AVENUE.
LAWRENCE CENTRAL HIGH SCHOOL

PROJECT 678	DATE MAY 1, 1978	REVISED
NO. 3	OF 4	

FIRST FLOOR
KEY PLAN
NO SCALE

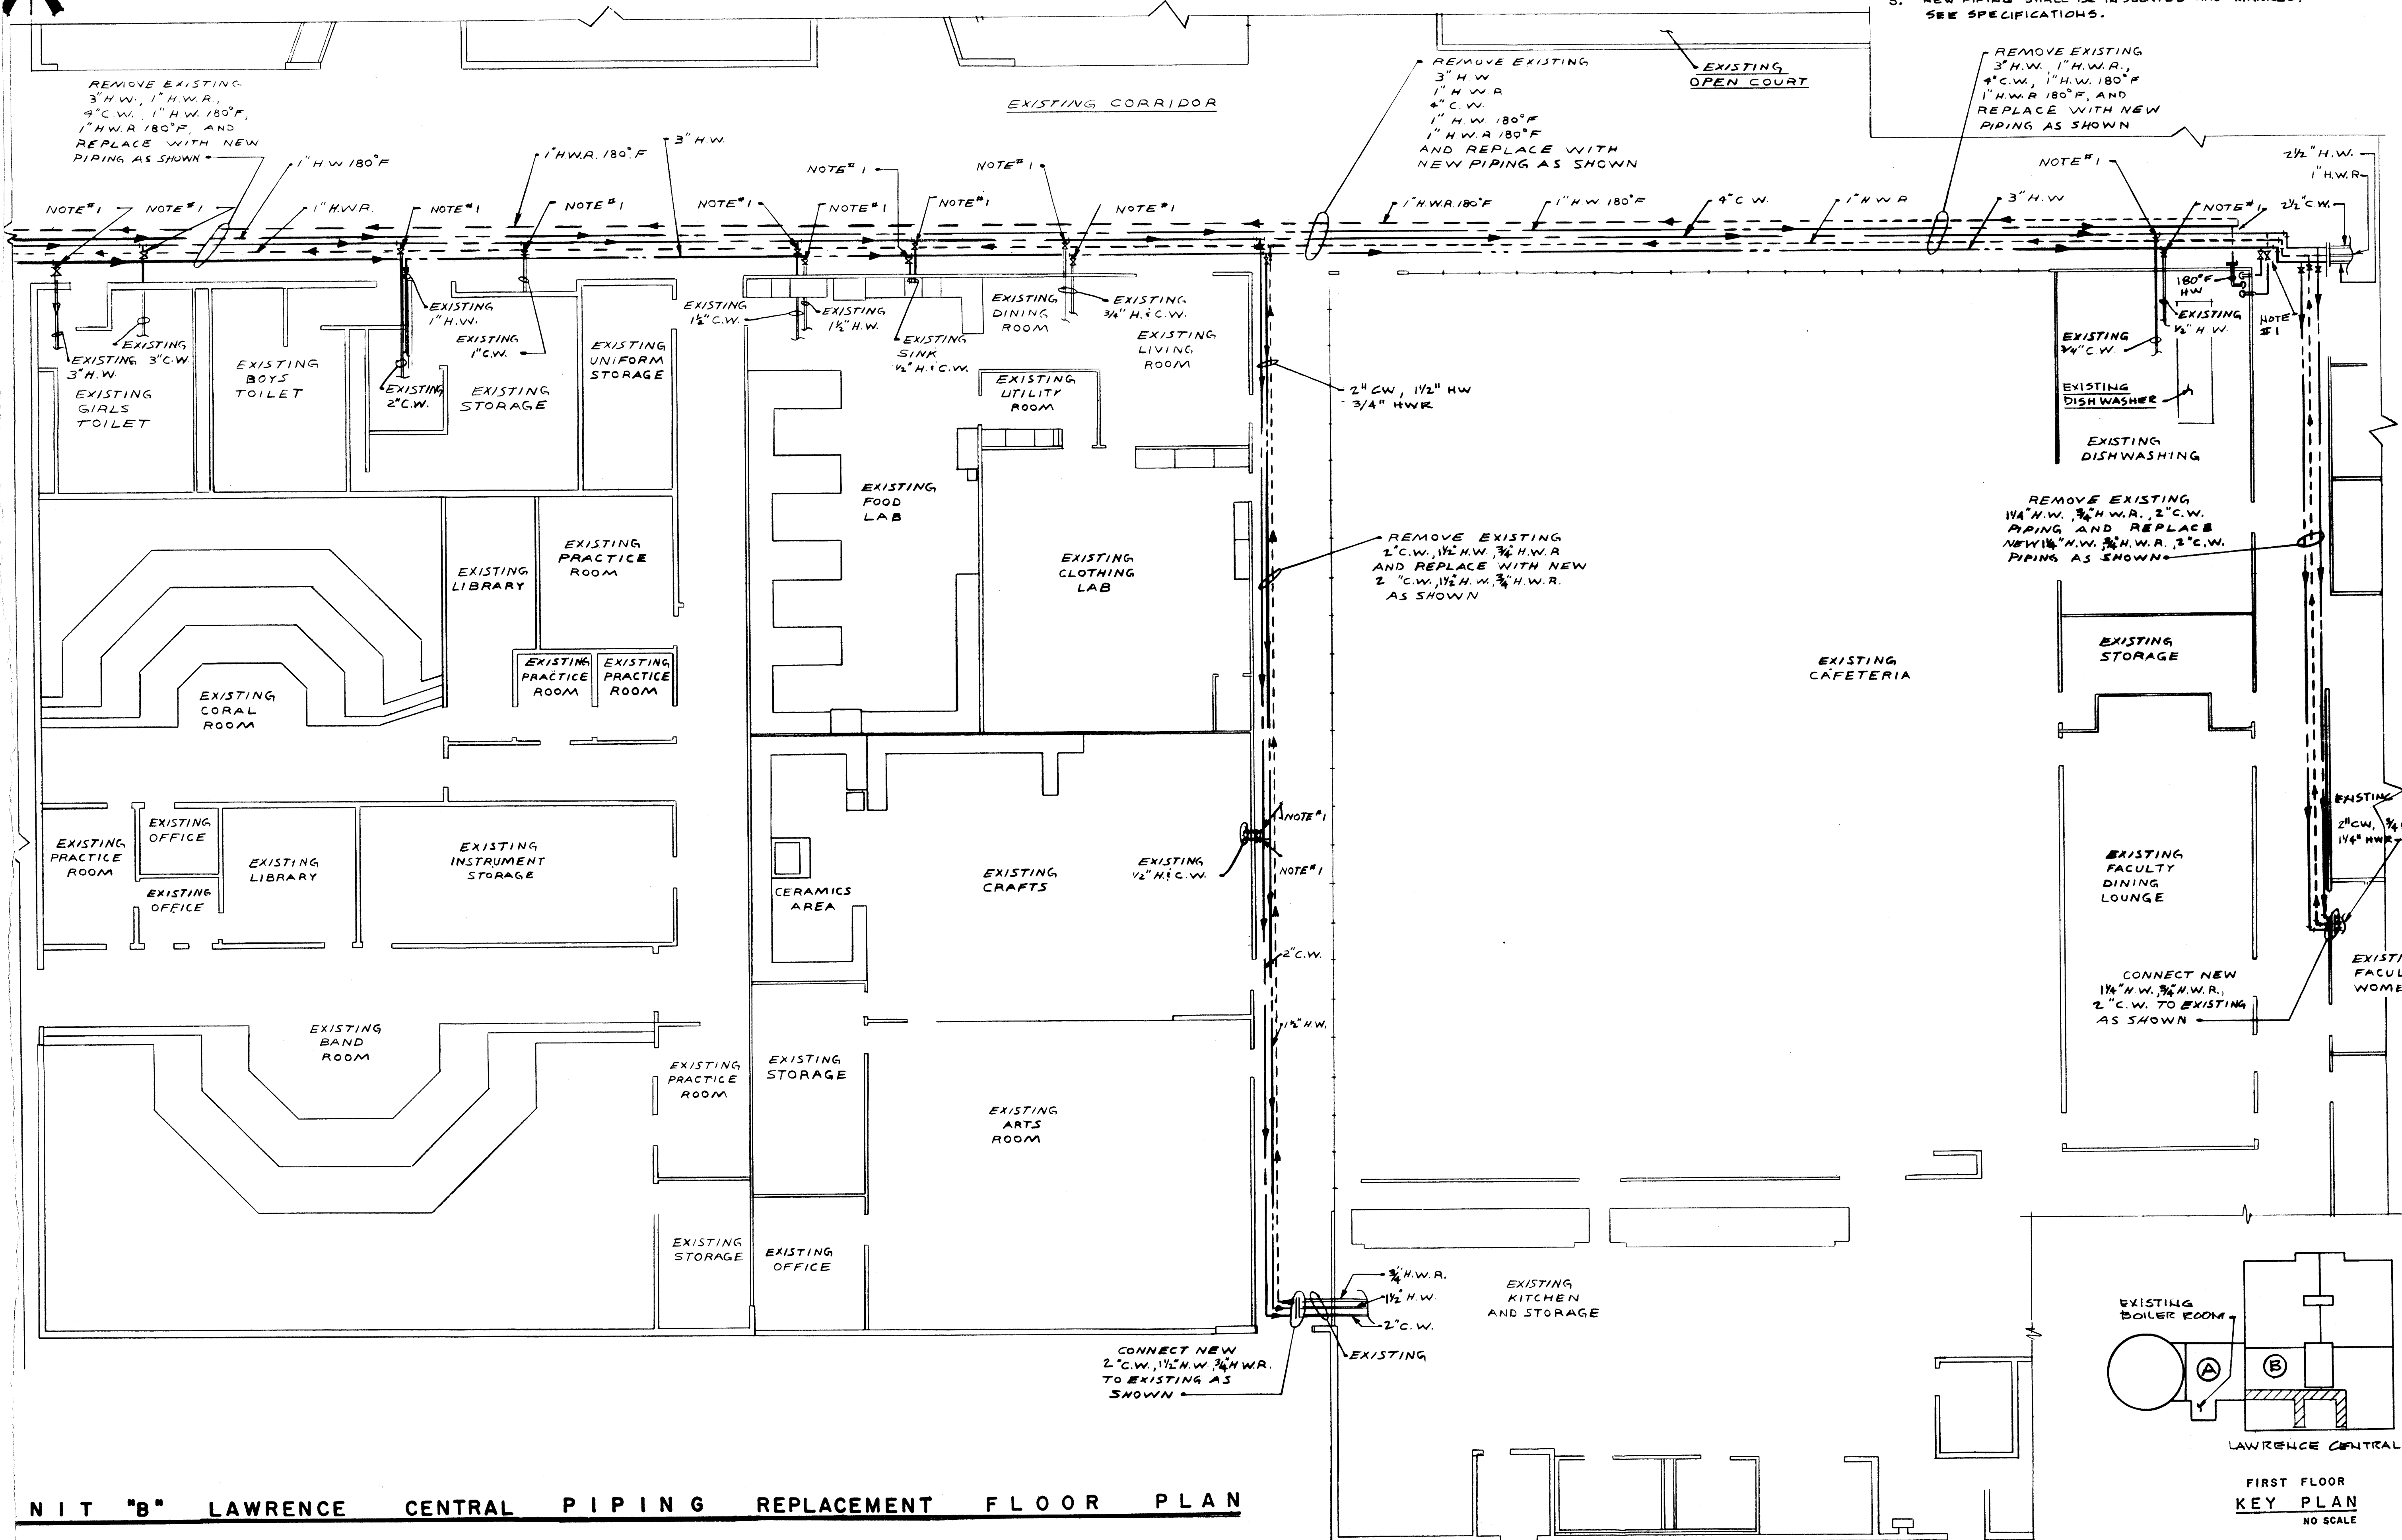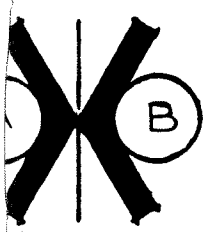

- NOTES:
1. Connect new piping to existing and provide new valve as shown.
 2. The Mechanical Contractor will be responsible for removing and re-installing of all ceiling construction in regard to this work.
 3. NEW PIPING SHALL BE INSULATED AND MARKED. SEE SPECIFICATIONS.

EVERETT · I · BROWN COMPANY

ARCHITECTS
ENGINEERS

· INDIANAPOLIS, INDIANA · 46241

· PARK FLETCHER ·

5500 WEST BRADBURY AVENUE ·

LAWRENCE CENTRAL HIGH SCHOOL


PROJECT 678

DATE MAY 1, 1978

REVISED

NO. 4

OF 4

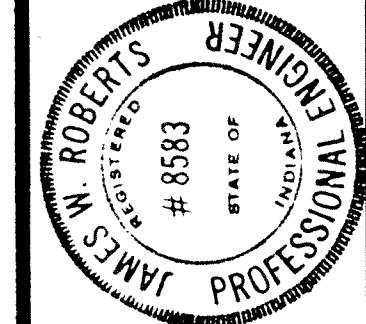


James W. Roberts

PROFESSIONAL ENGINEER

STATE OF INDIANA

PROJECT 678
DATE MAY 1, 1978
REVISED

NIT "B" LAWRENCE CENTRAL PIPING REPLACEMENT FLOOR PLAN

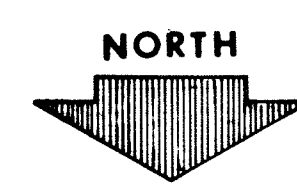

SCALE: 1/8" = 1'-0"

FIRST FLOOR
KEY PLAN
NO SCALE

