


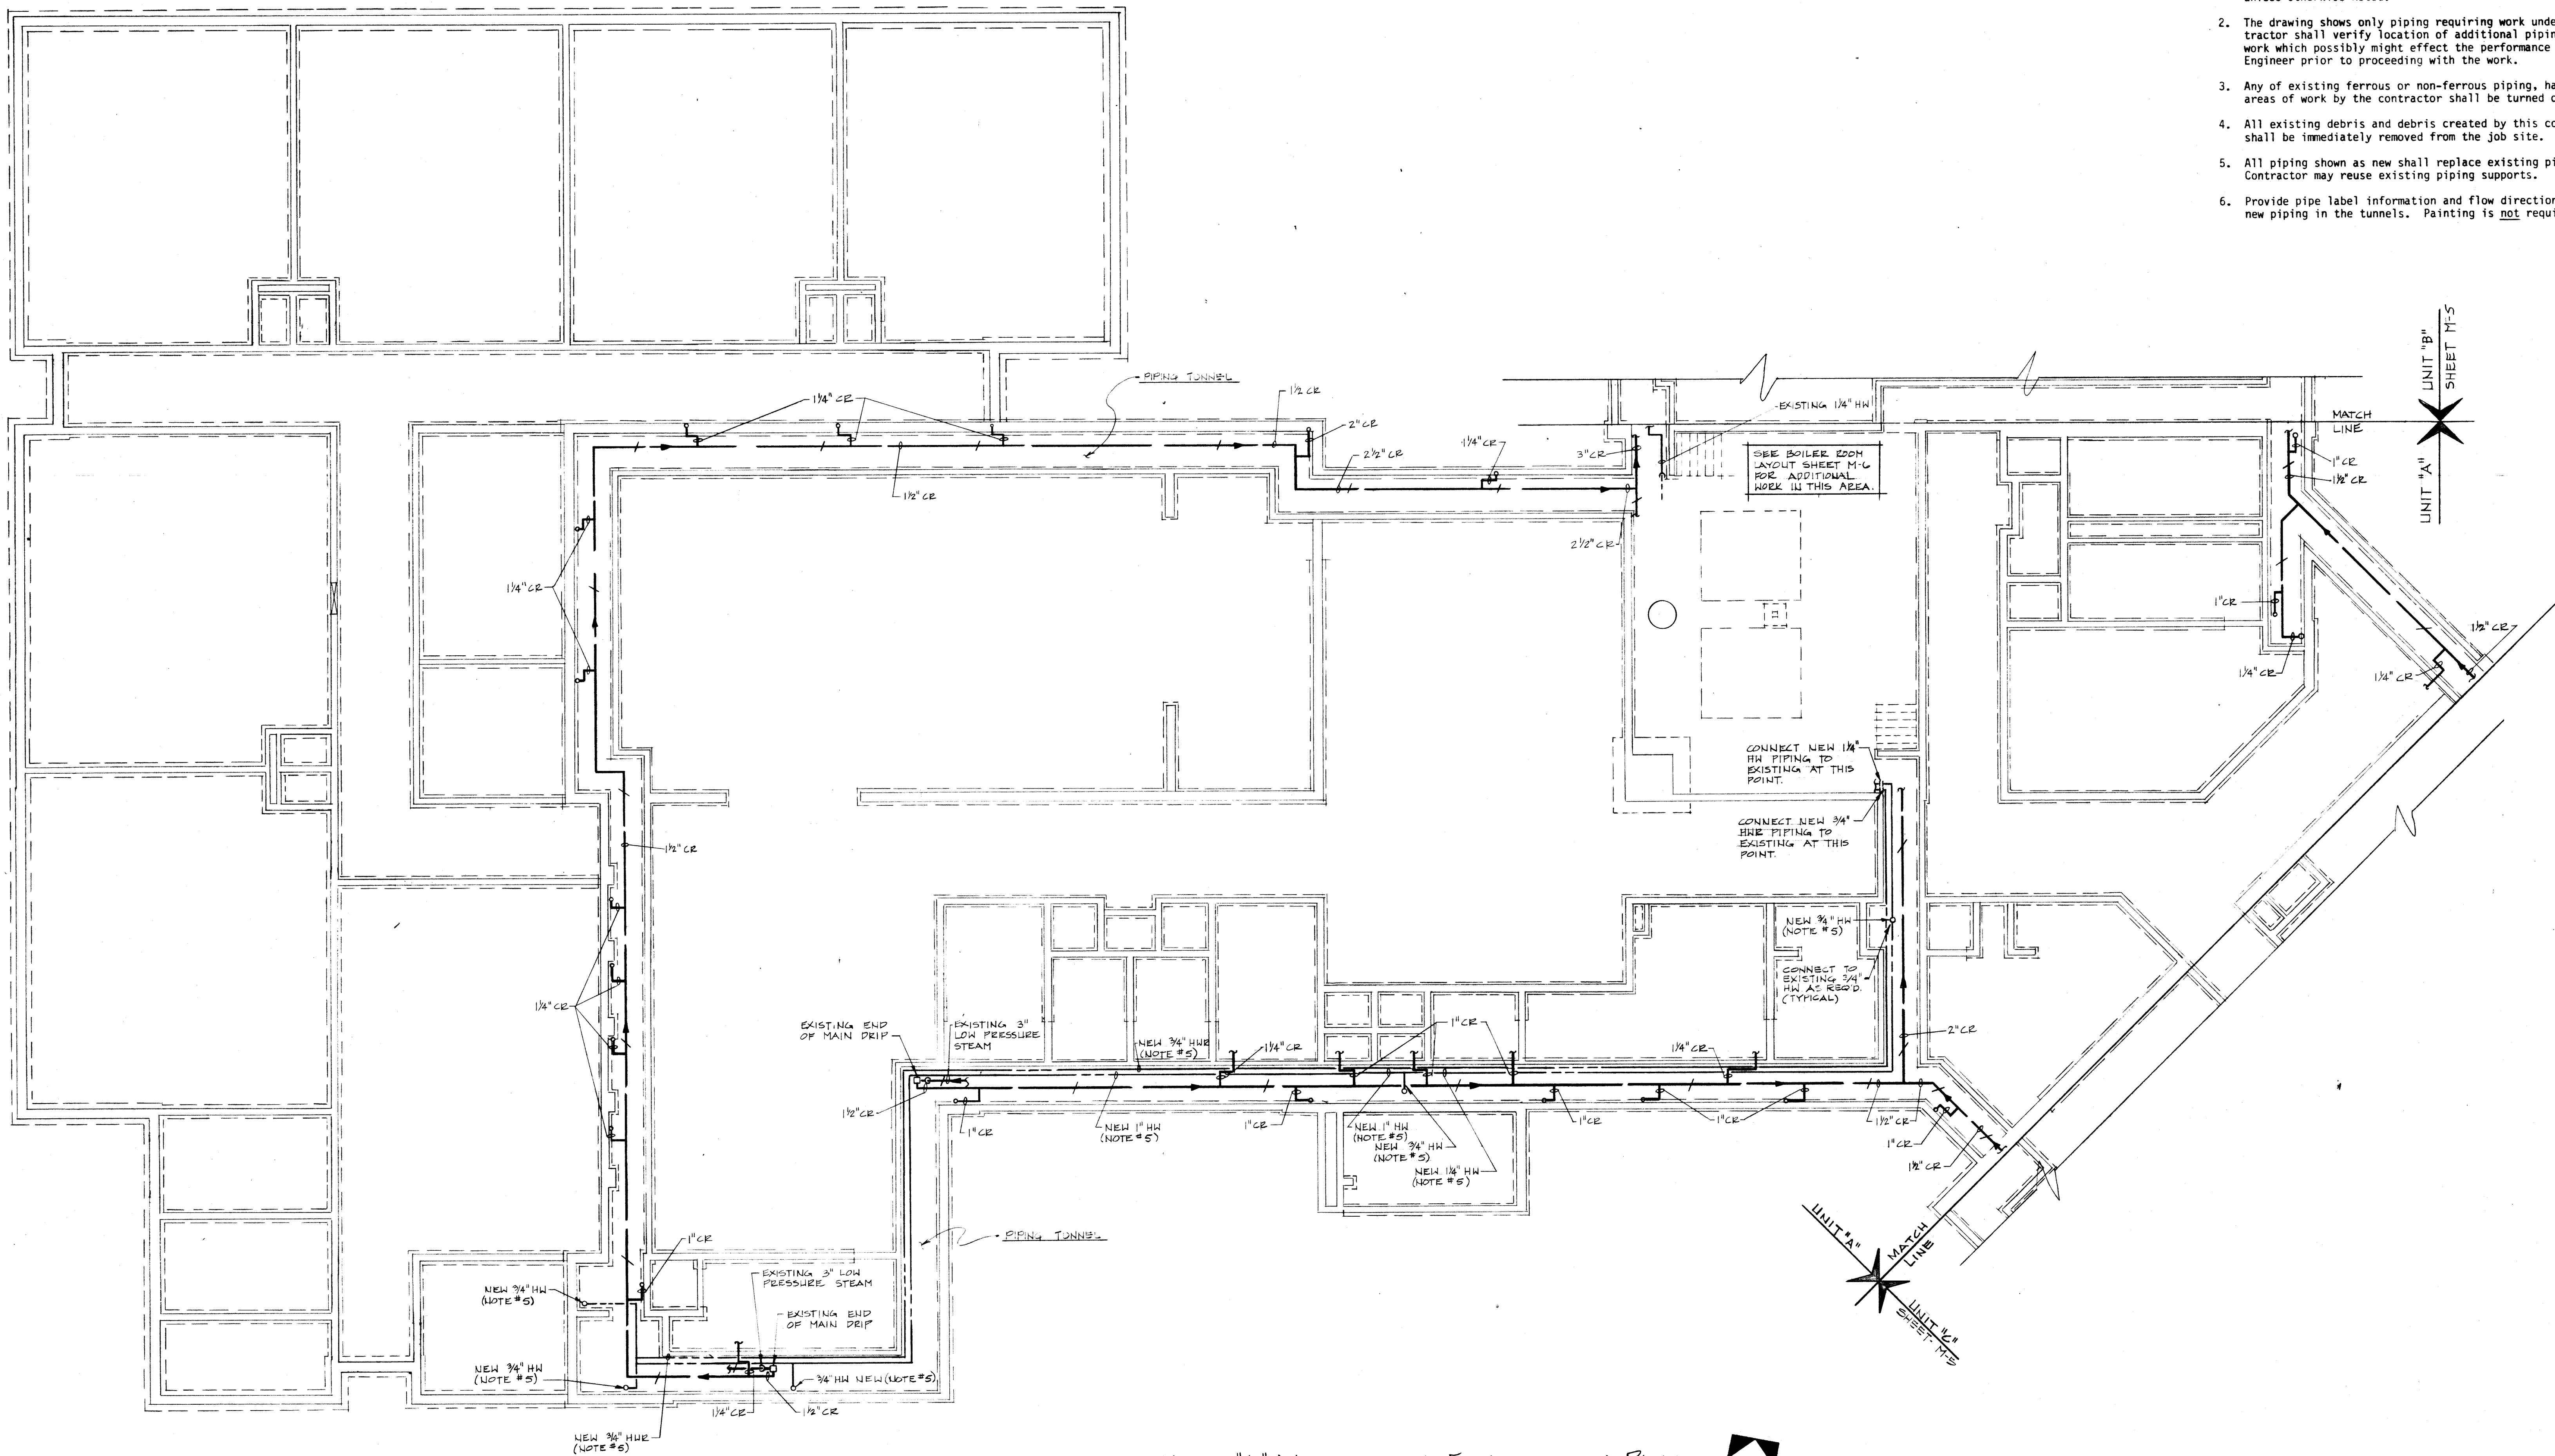

UNIT "A" MECHANICAL FOUNDATION PLAN
SCALE: 1/8"=1'-0"




PLAN NOTES

1. All piping shown is existing and to be insulated as shown in the specifications unless otherwise noted.
2. The drawing shows only piping requiring work under this contract. The Contractor shall verify location of additional piping, etc., in the areas of work which possibly might effect the performance of his works and notify the Engineer prior to proceeding with the work.
3. Any of existing ferrous or non-ferrous piping, hangers, etc. removed from the areas of work by the contractor shall be turned over to the Owner.
4. All existing debris and debris created by this contract in the work areas shall be immediately removed from the job site.
5. All piping shown as new shall replace existing piping in the same location. Contractor may reuse existing piping supports.
6. Provide pipe label information and flow direction arrows on all existing or new piping in the tunnels. Painting is not required.

UNIT "B"
SHEET M-5

UNIT "A"
SHEET M-5

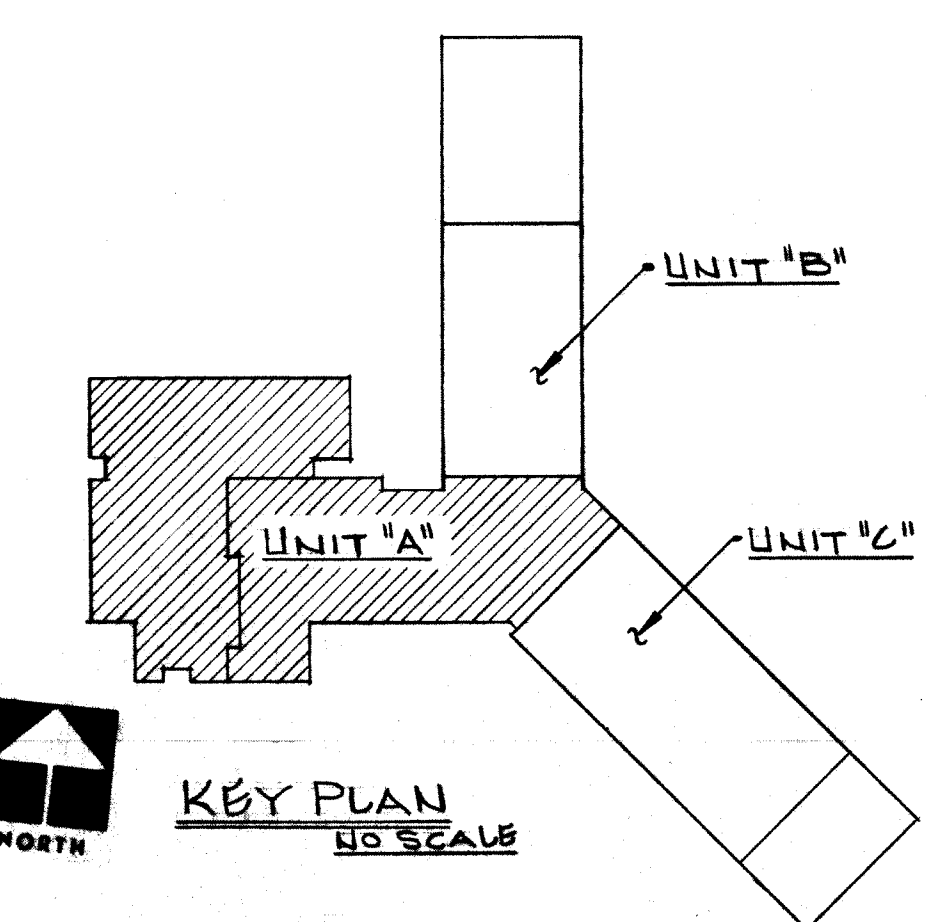

WRIGHT PORTER & LOWE INC.
ARCHITECTS - ENGINEERS
INDIANAPOLIS, INDIANA

COGHILL/OBERLIES & ASSOCIATES
Consulting Engineers
INDIANAPOLIS, INDIANA

UNIT A - TUNNEL PLAN

WRIGHT PORTER & LOWE INC.
ARCHITECTS - ENGINEERS
INDIANAPOLIS, INDIANA

COGHILL/OBERLIES & ASSOCIATES
Consulting Engineers
INDIANAPOLIS, INDIANA

NO.	DATE	DESCRIPTION	COMD. NO.
1	8/20/81		

