



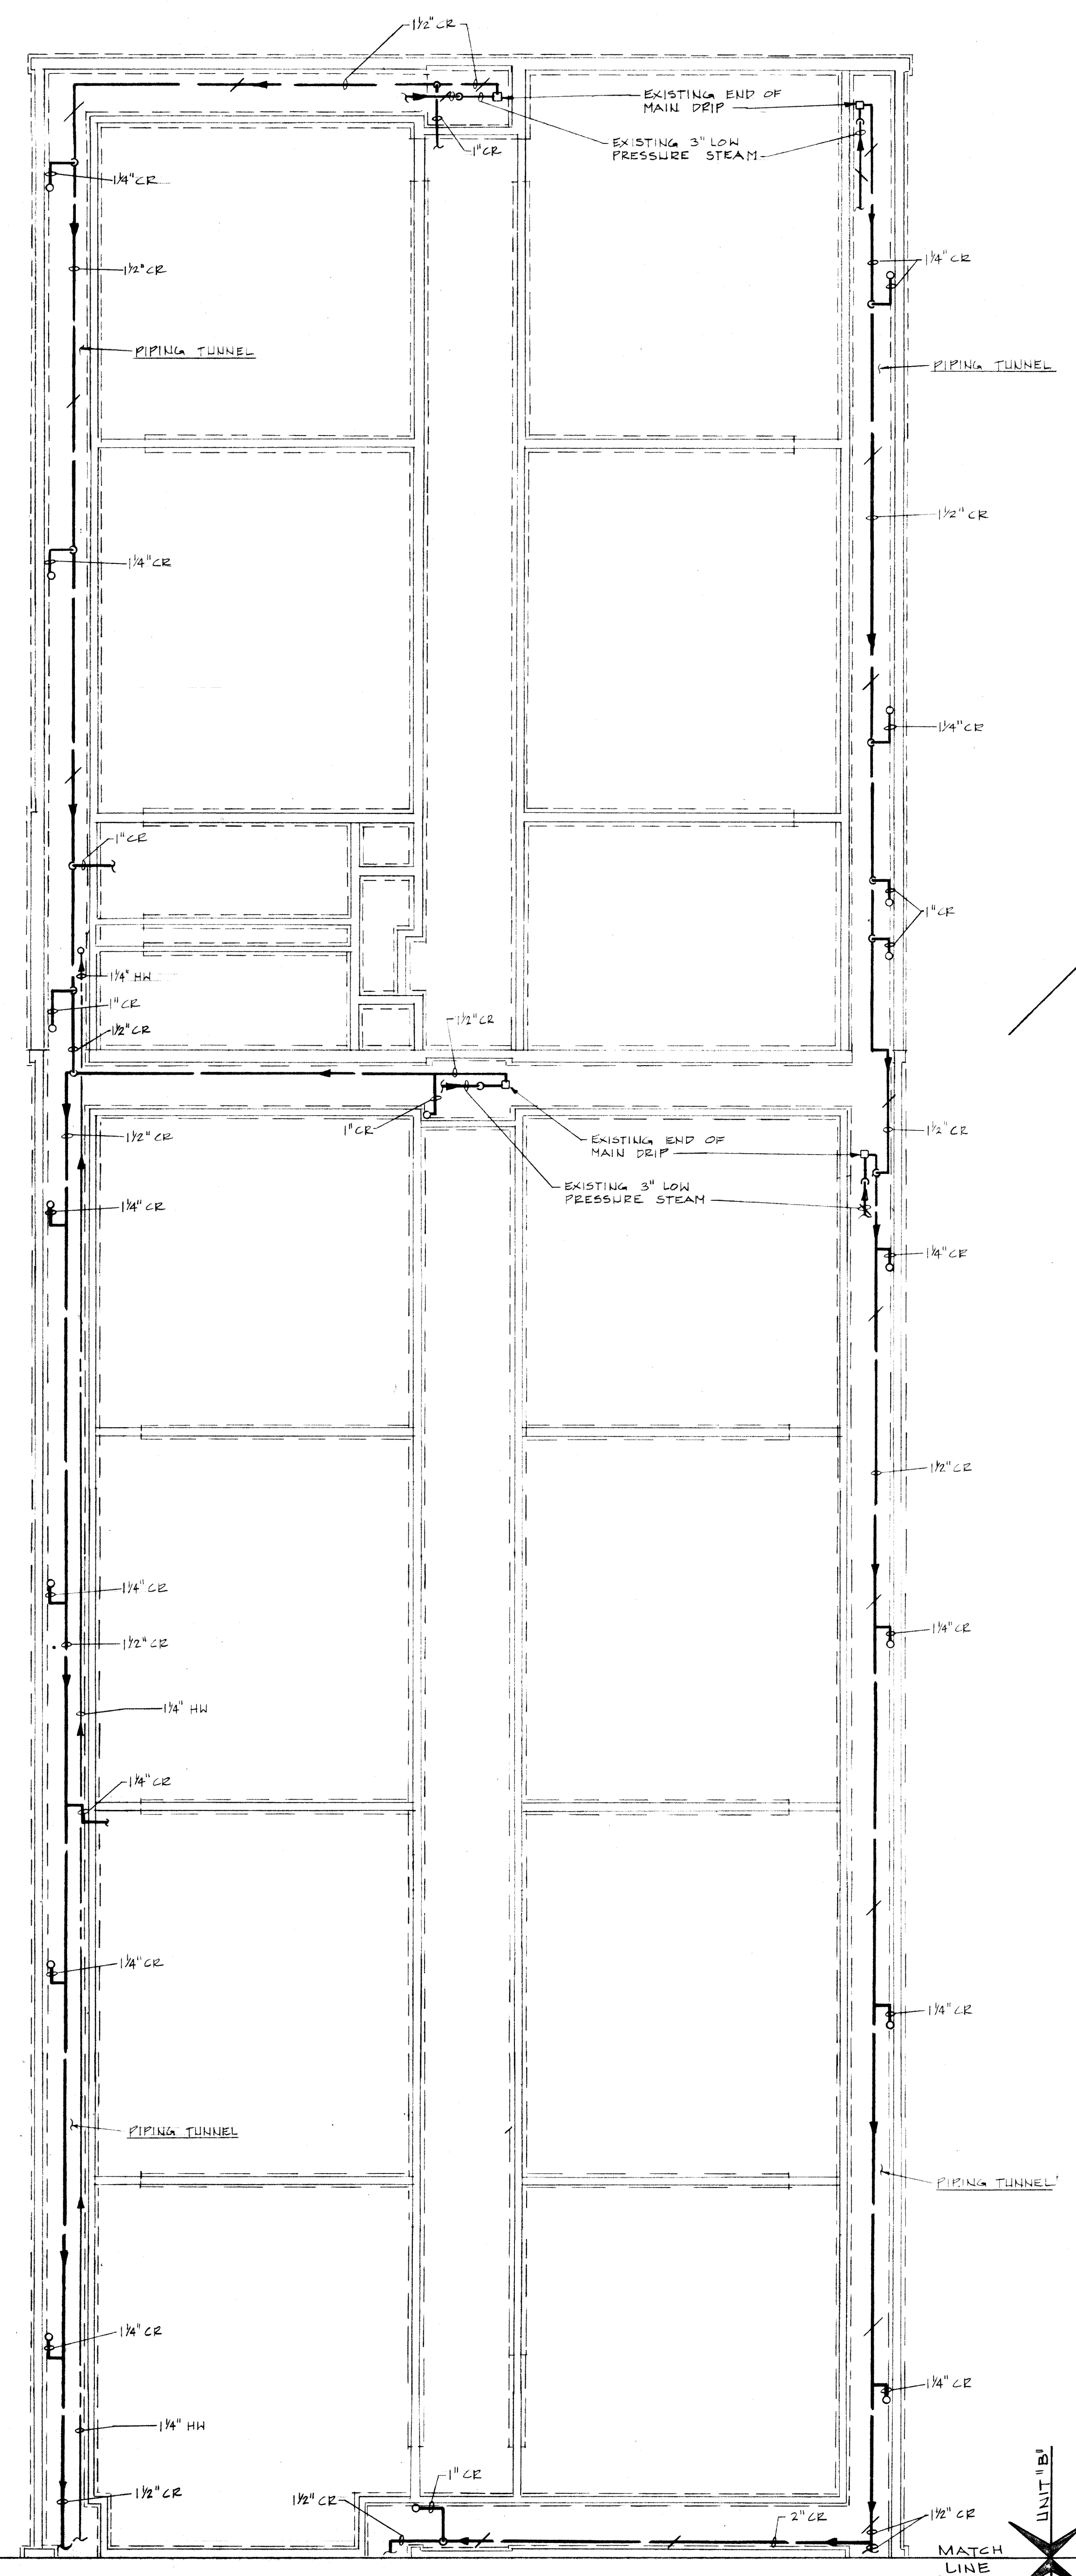


UNIT "B" MECHANICAL FOUNDATION PLAN
SCALE: 1/8"=1'-0"

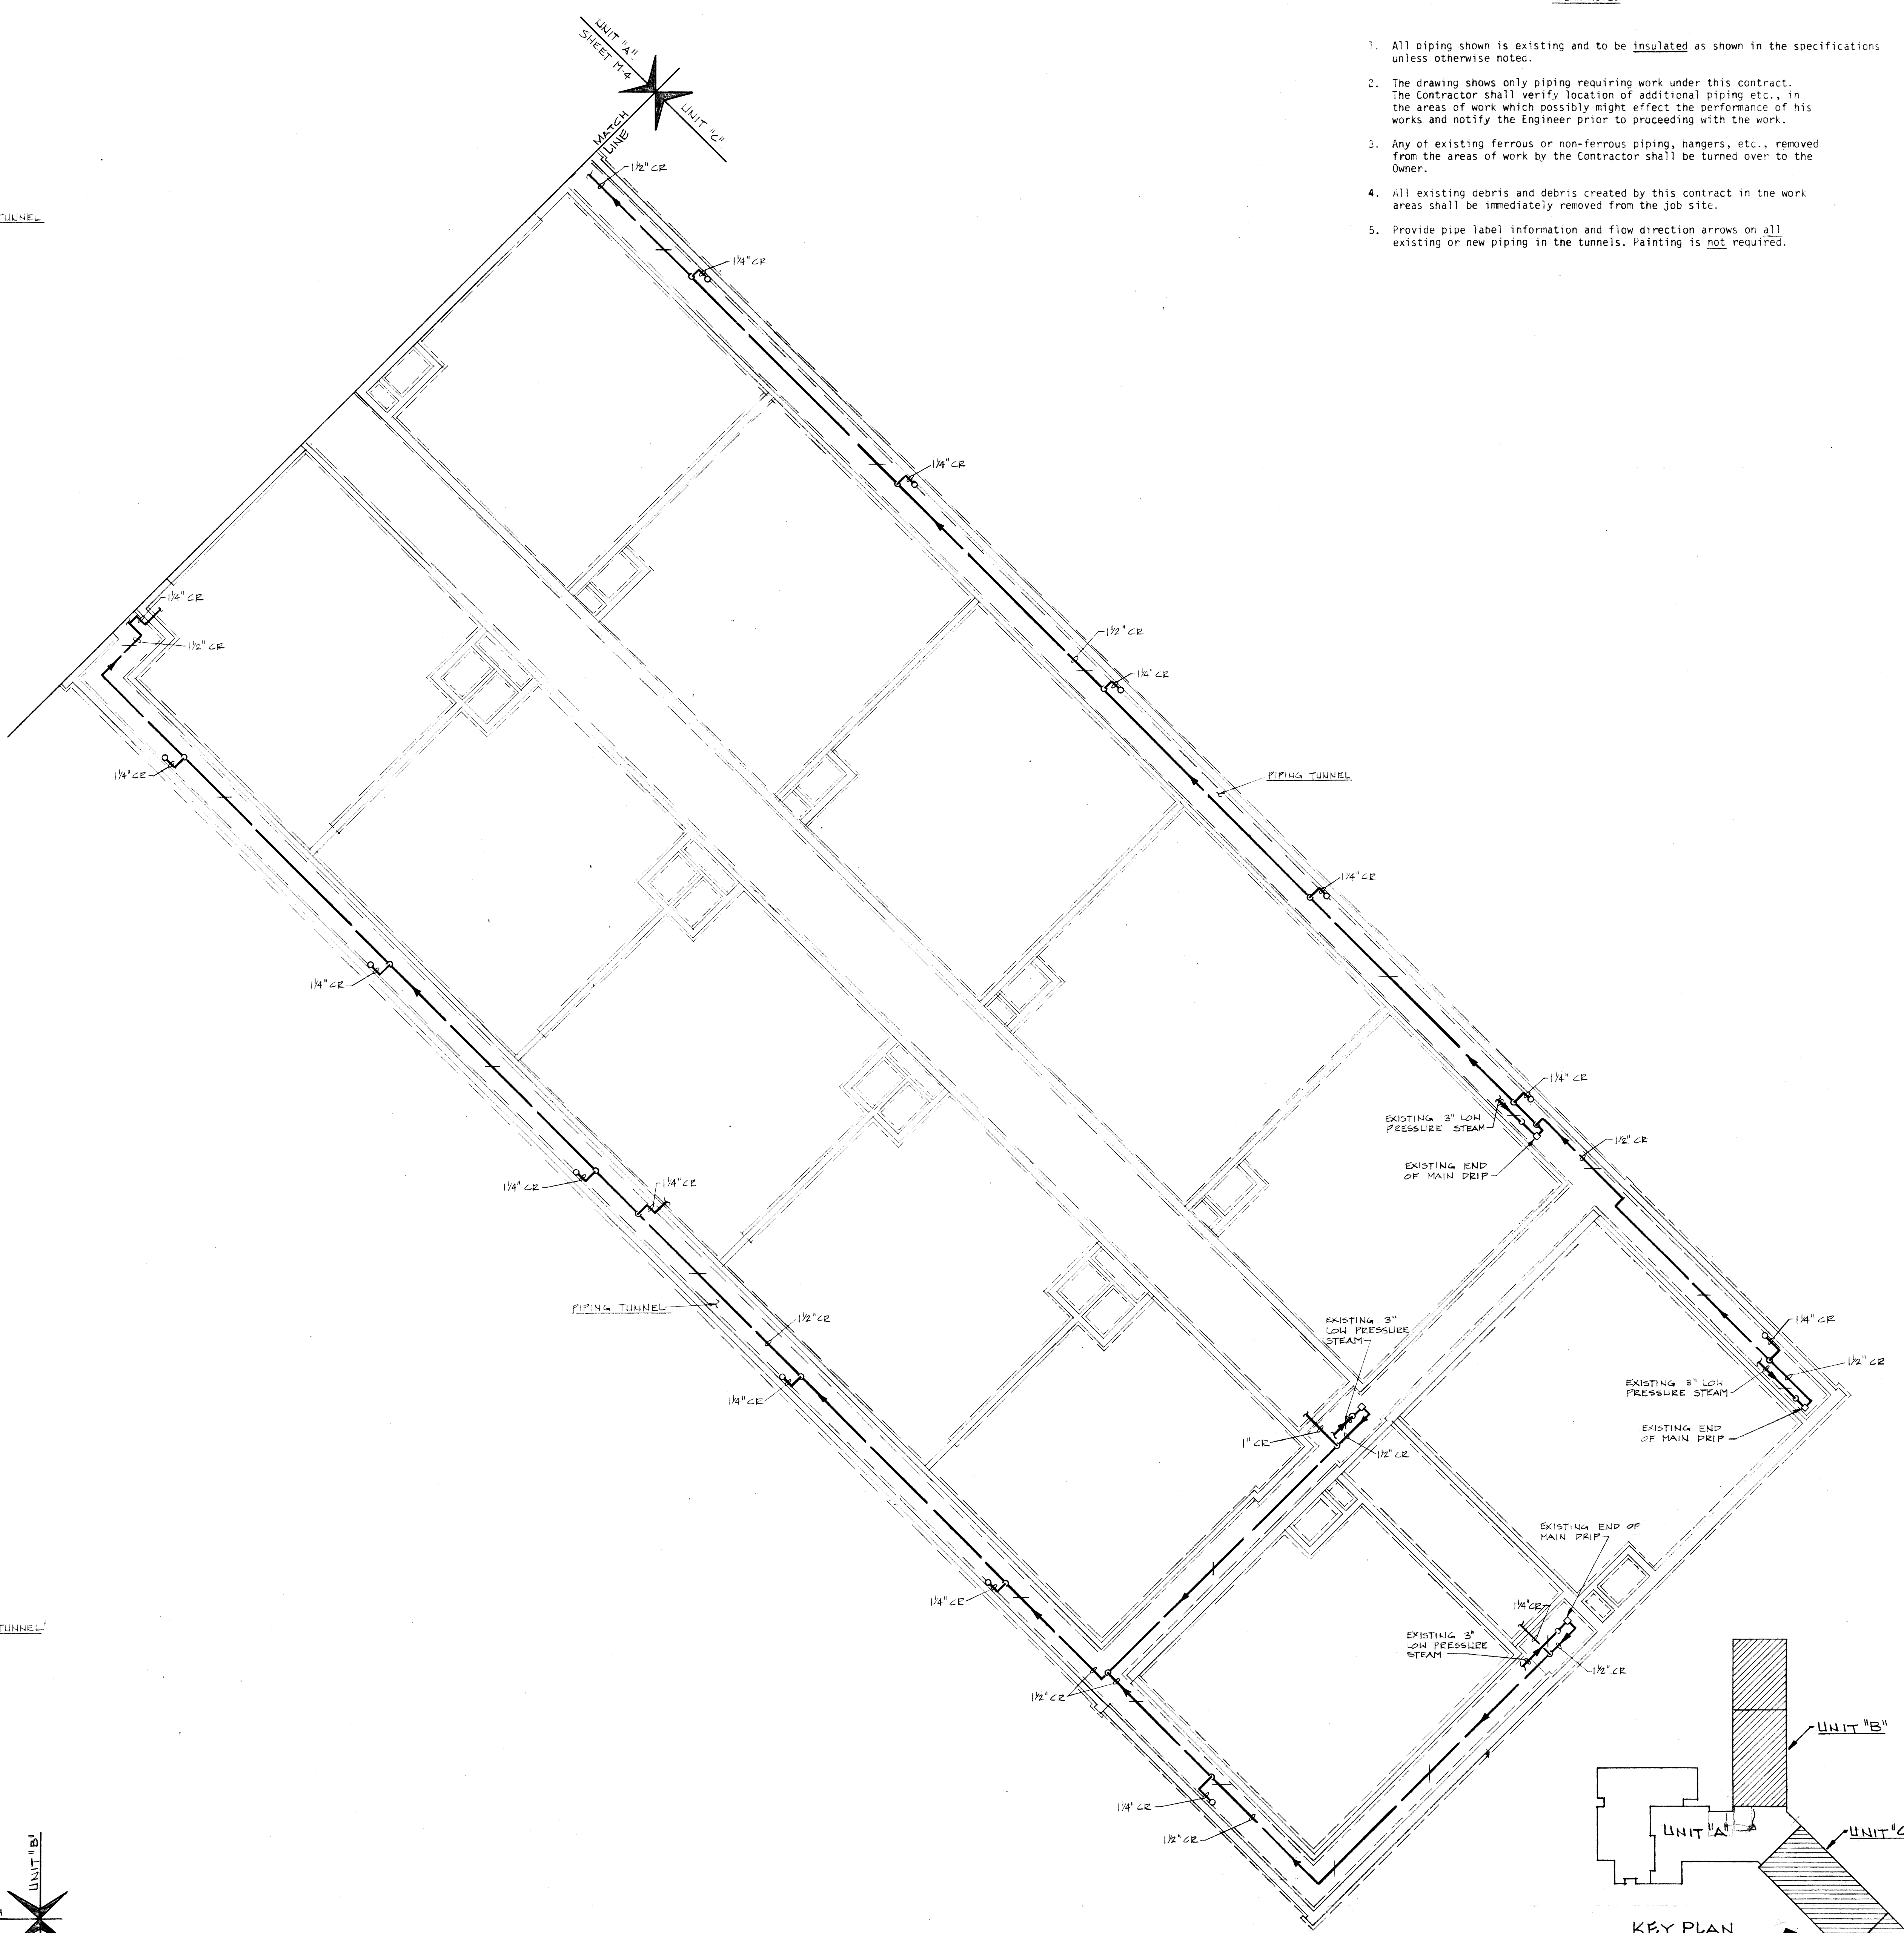

UNIT "C" MECHANICAL FOUNDATION PLAN
SCALE: 1/8"=1'-0"

PLAN NOTES

1. All piping shown is existing and to be insulated as shown in the specifications unless otherwise noted.
2. The drawing shows only piping requiring work under this contract. The Contractor shall verify location of additional piping etc., in the areas of work which possibly might effect the performance of his works and notify the Engineer prior to proceeding with the work.
3. Any of existing ferrous or non-ferrous piping, hangers, etc., removed from the areas of work by the Contractor shall be turned over to the Owner.
4. All existing debris and debris created by this contract in the work areas shall be immediately removed from the job site.
5. Provide pipe label information and flow direction arrows on all existing or new piping in the tunnels. Painting is not required.

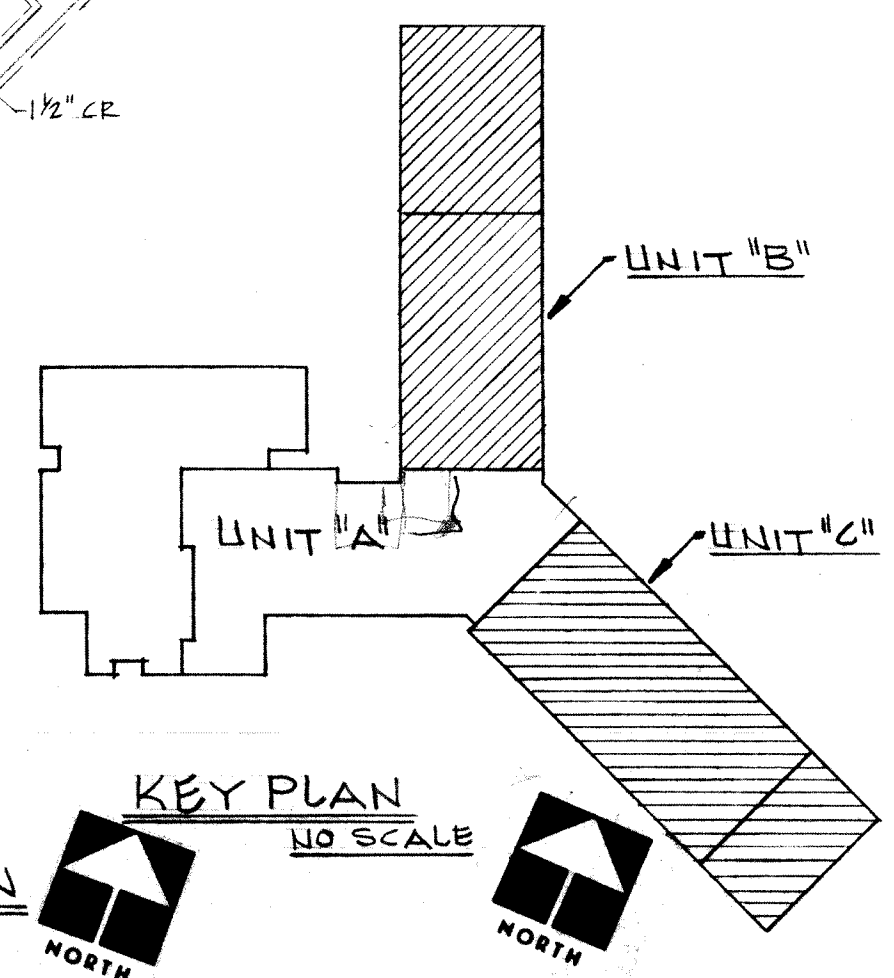

WRIGHT PORTER & LOWE INC.
ARCHITECTS - ENGINEERS
 INDIANAPOLIS, INDIANA

COGILL/OBERLIES & ASSOCIATES
 Consulting Engineers
 INDIANAPOLIS, INDIANA

METROPOLITAN SCHOOL DISTRICT
 OF LAWRENCE TOWNSHIP
 HARRISON HILL ELEMENTARY SCHOOL

UNIT B & C - TUNNEL PLANS

NO.	DATE	REVISIONS	DESCRIPTION	CONTR. NO.	DATE	DATE	DRAWN BY	CHECKED BY	DATE

ENGINEER
J. R. OBERLIES, JR.
No. 19568
STATE OF INDIANA

CERTIFIED BY

SHEET

M-5

of 13