


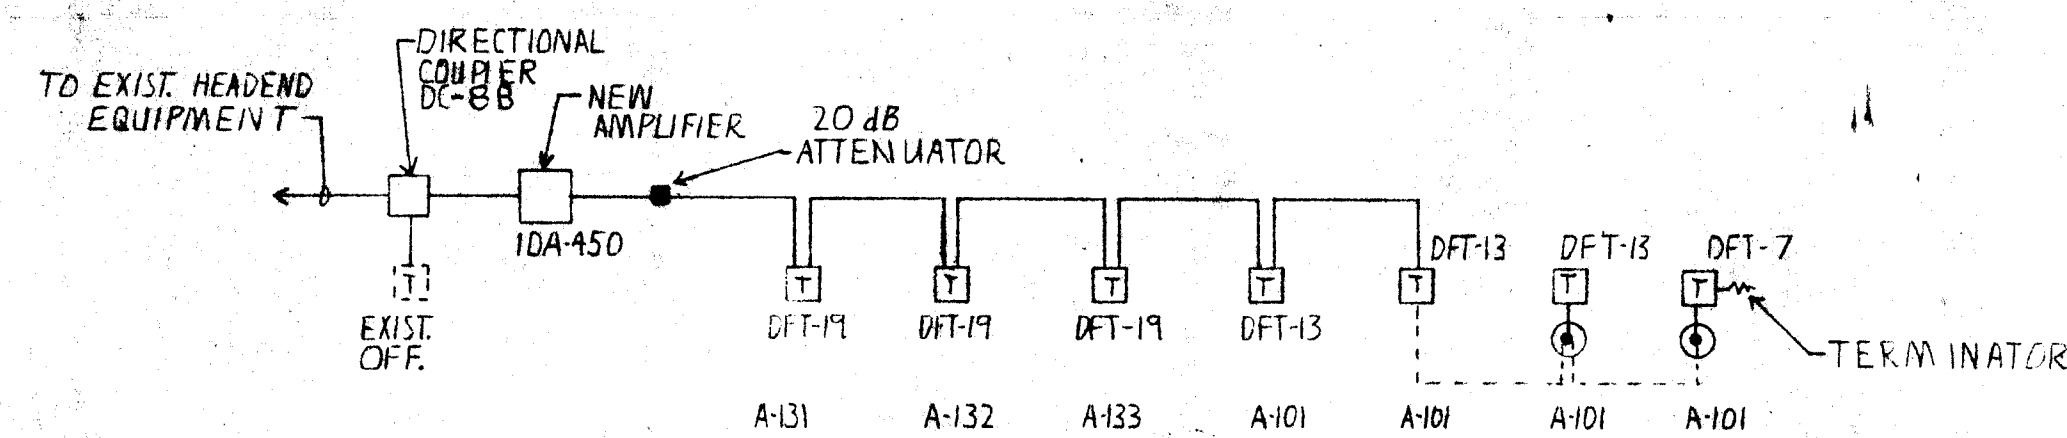


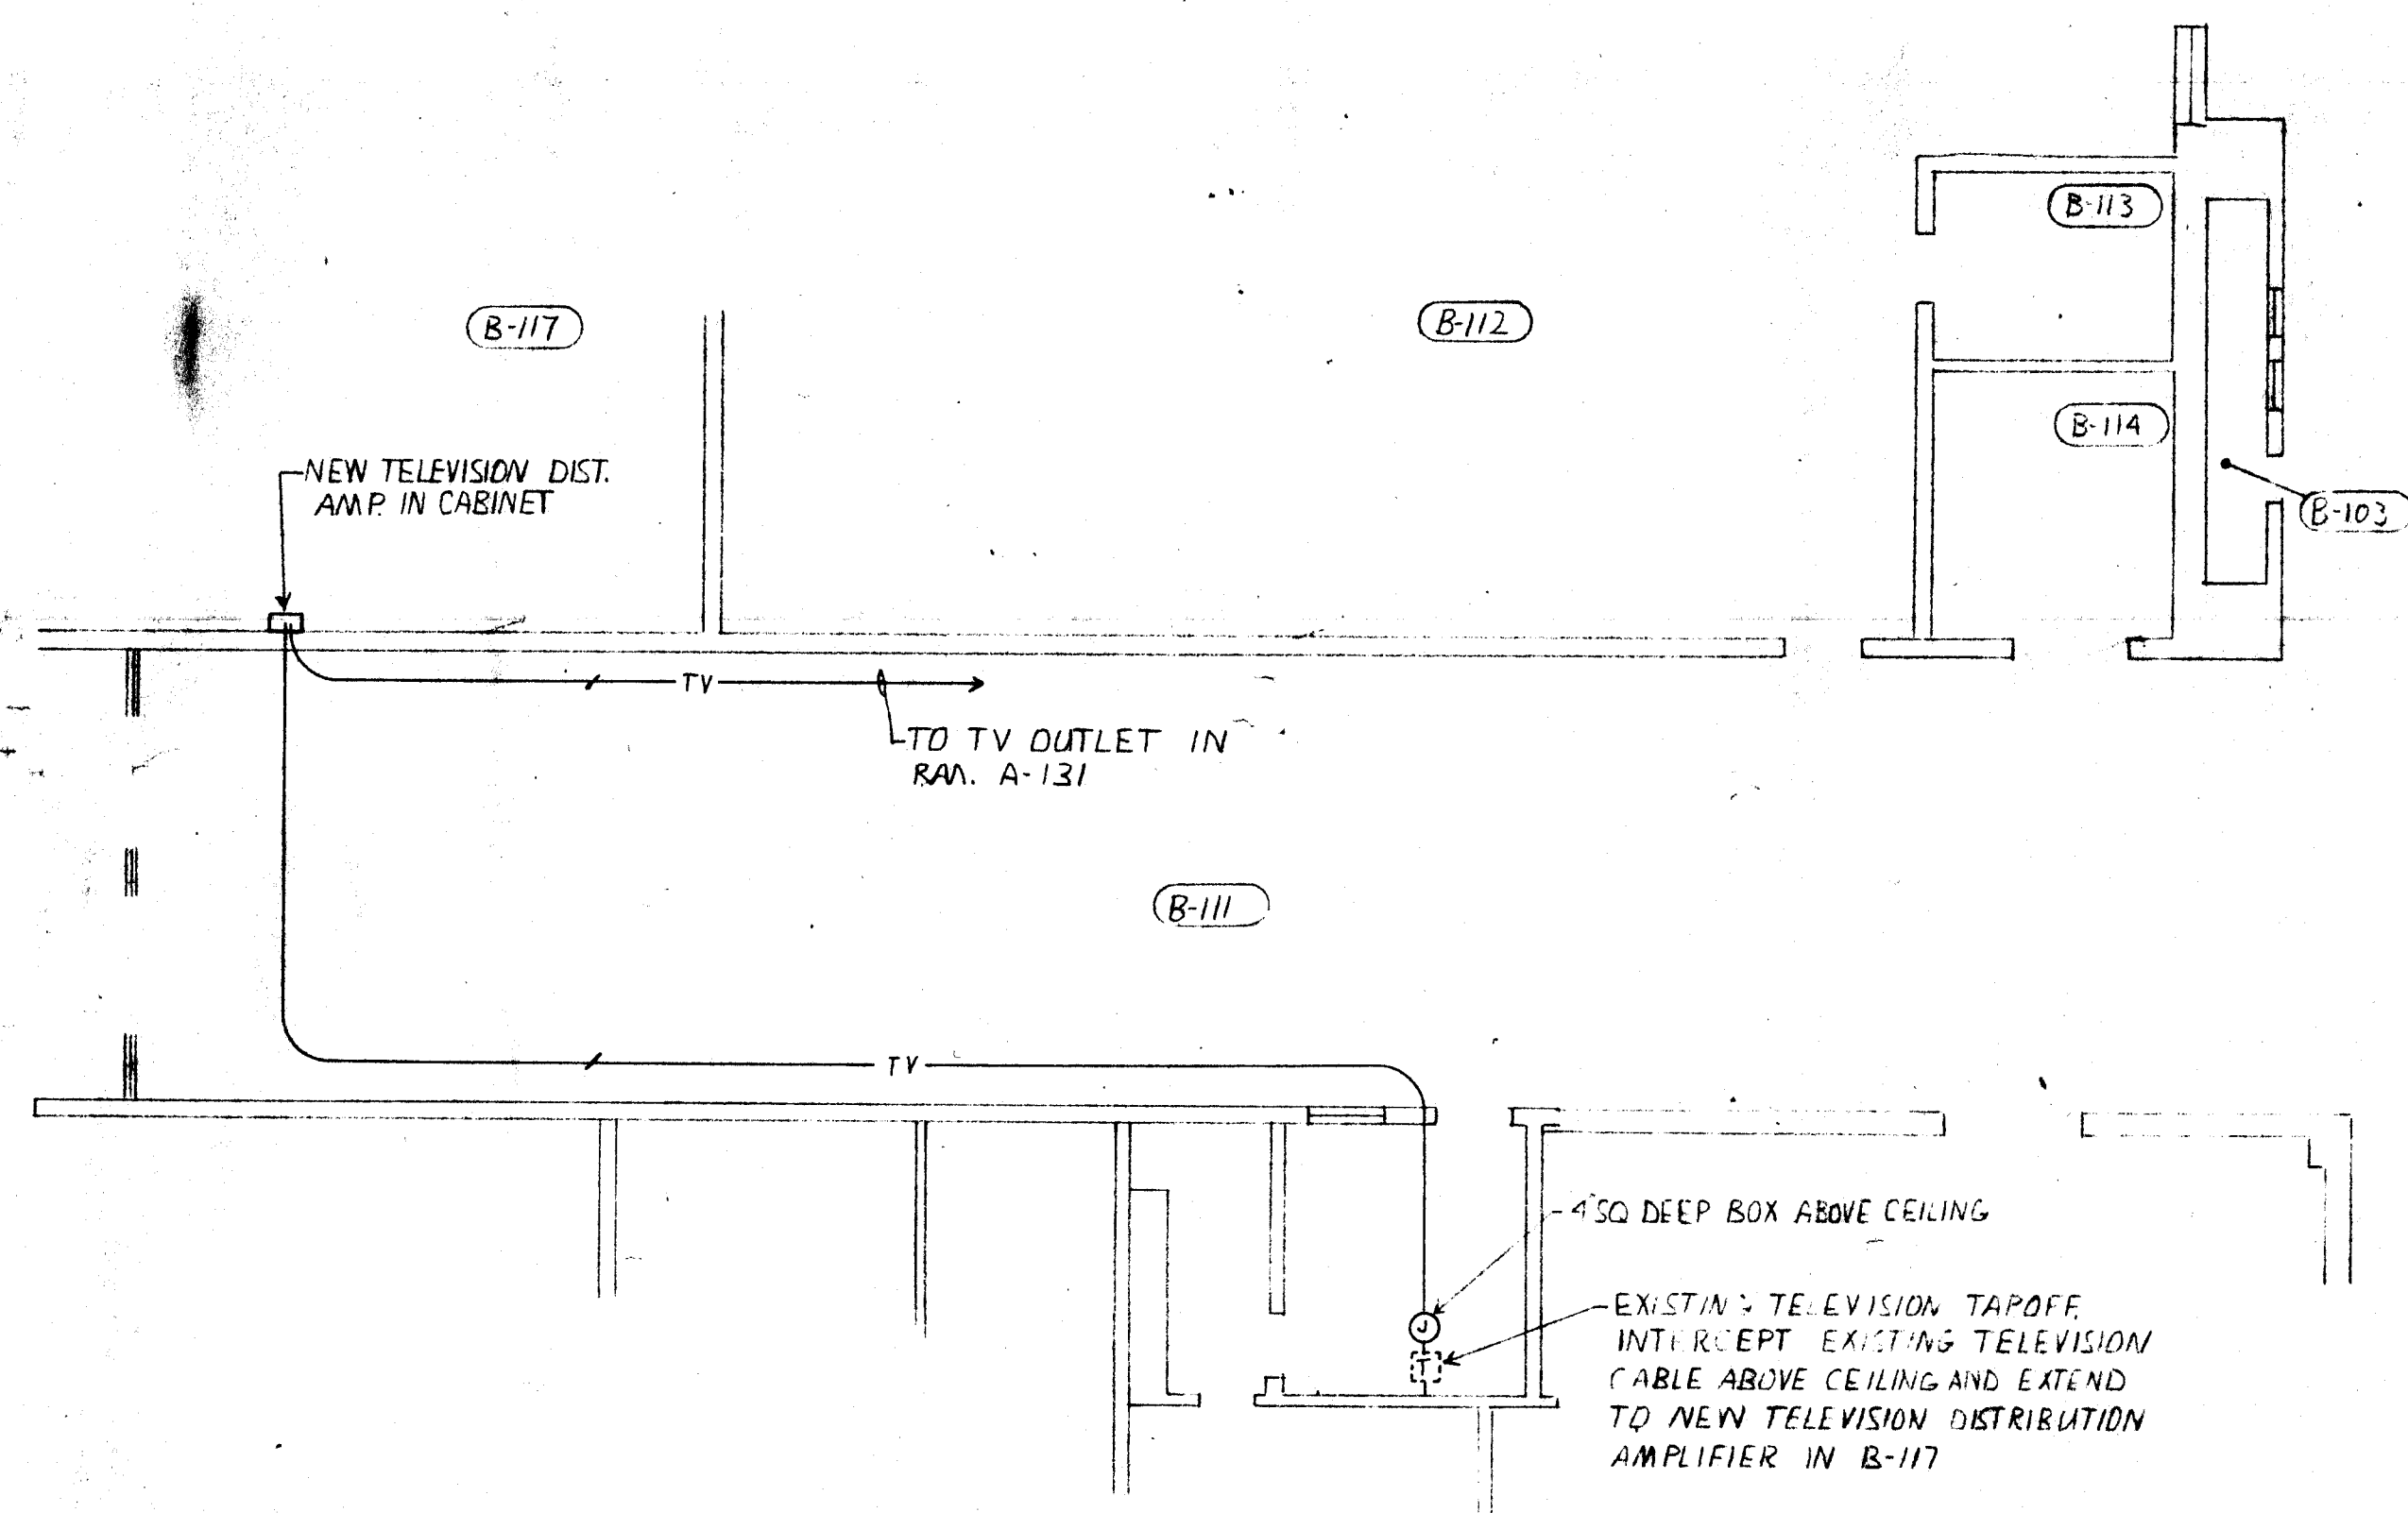


TELEVISION DISTRIBUTION DIAGRAM
N.T.S.





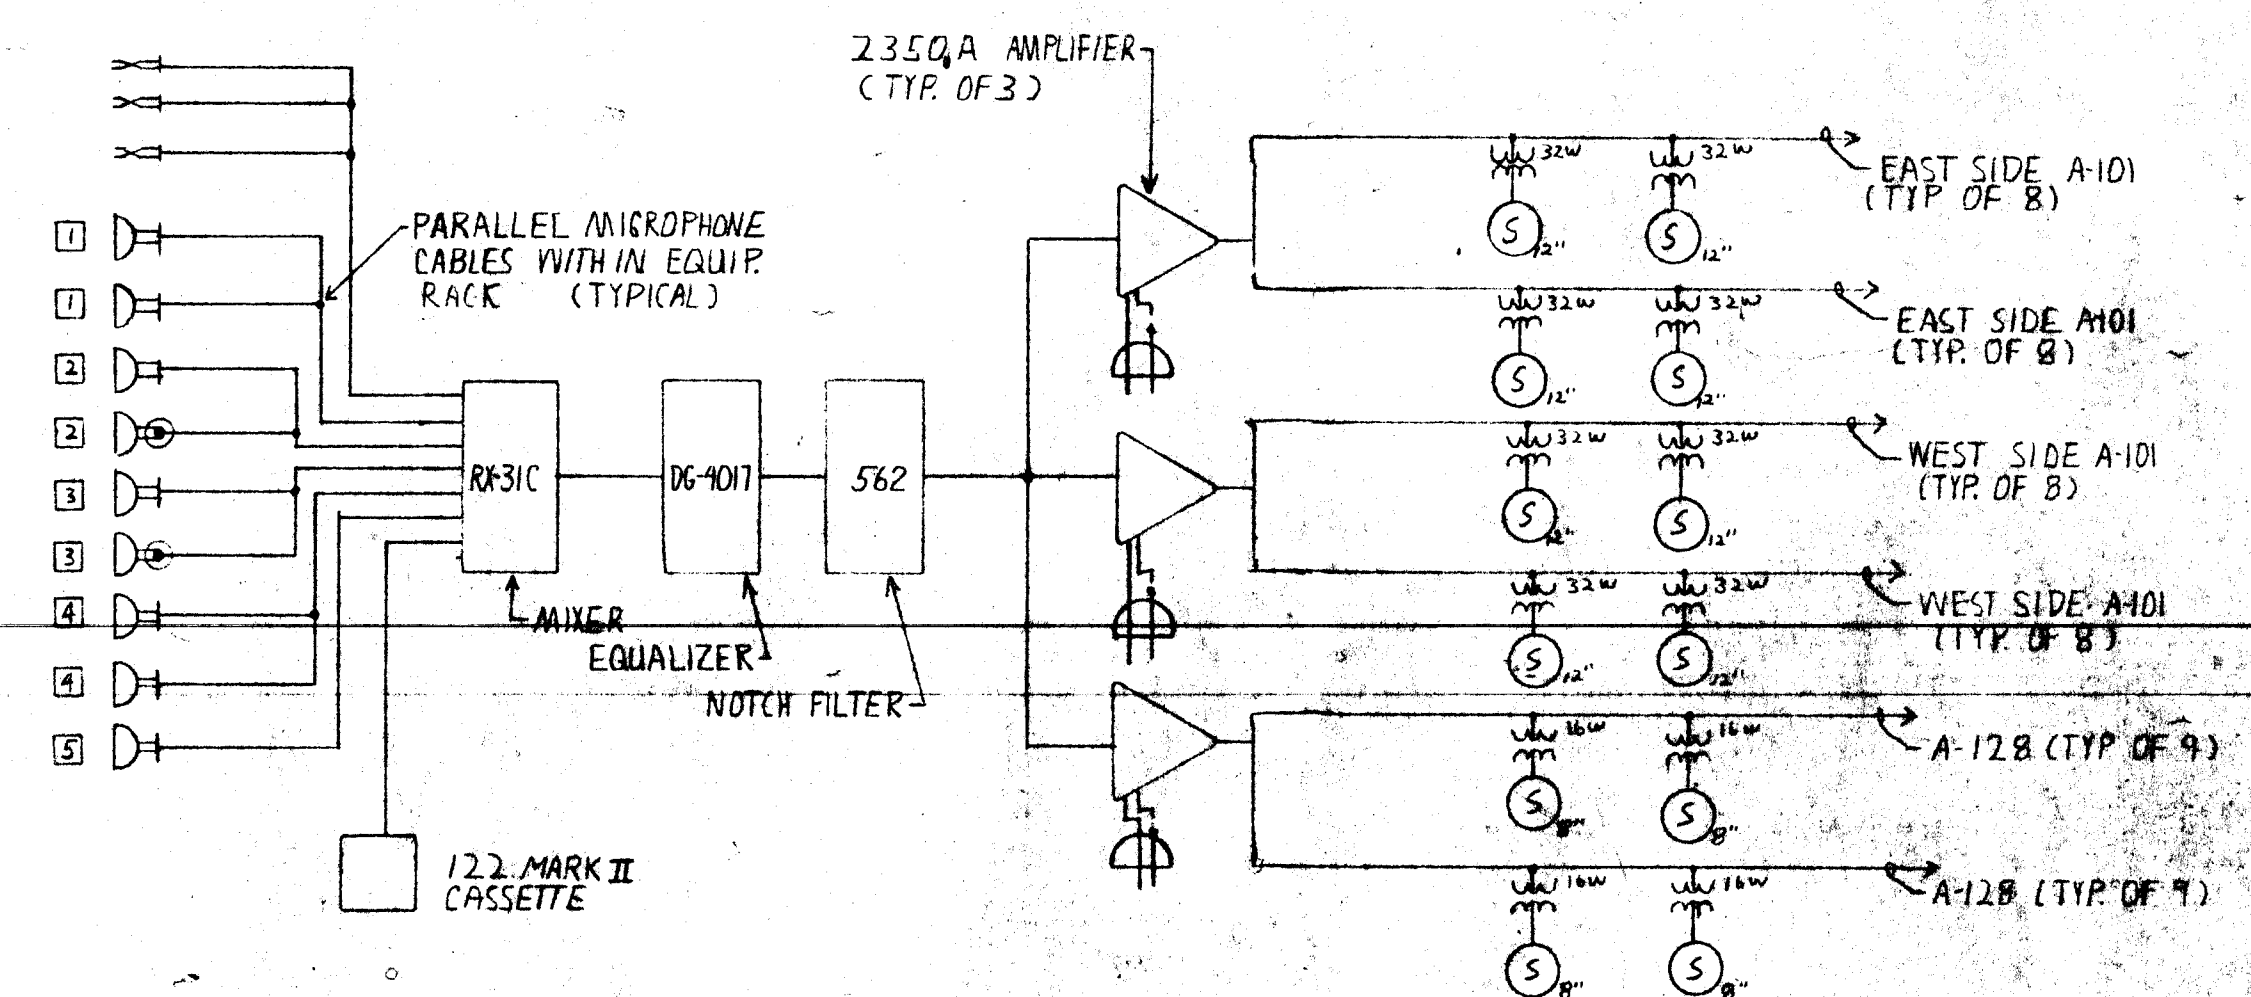


SOUND DISTRIBUTION DIAGRAM
N.T.S.

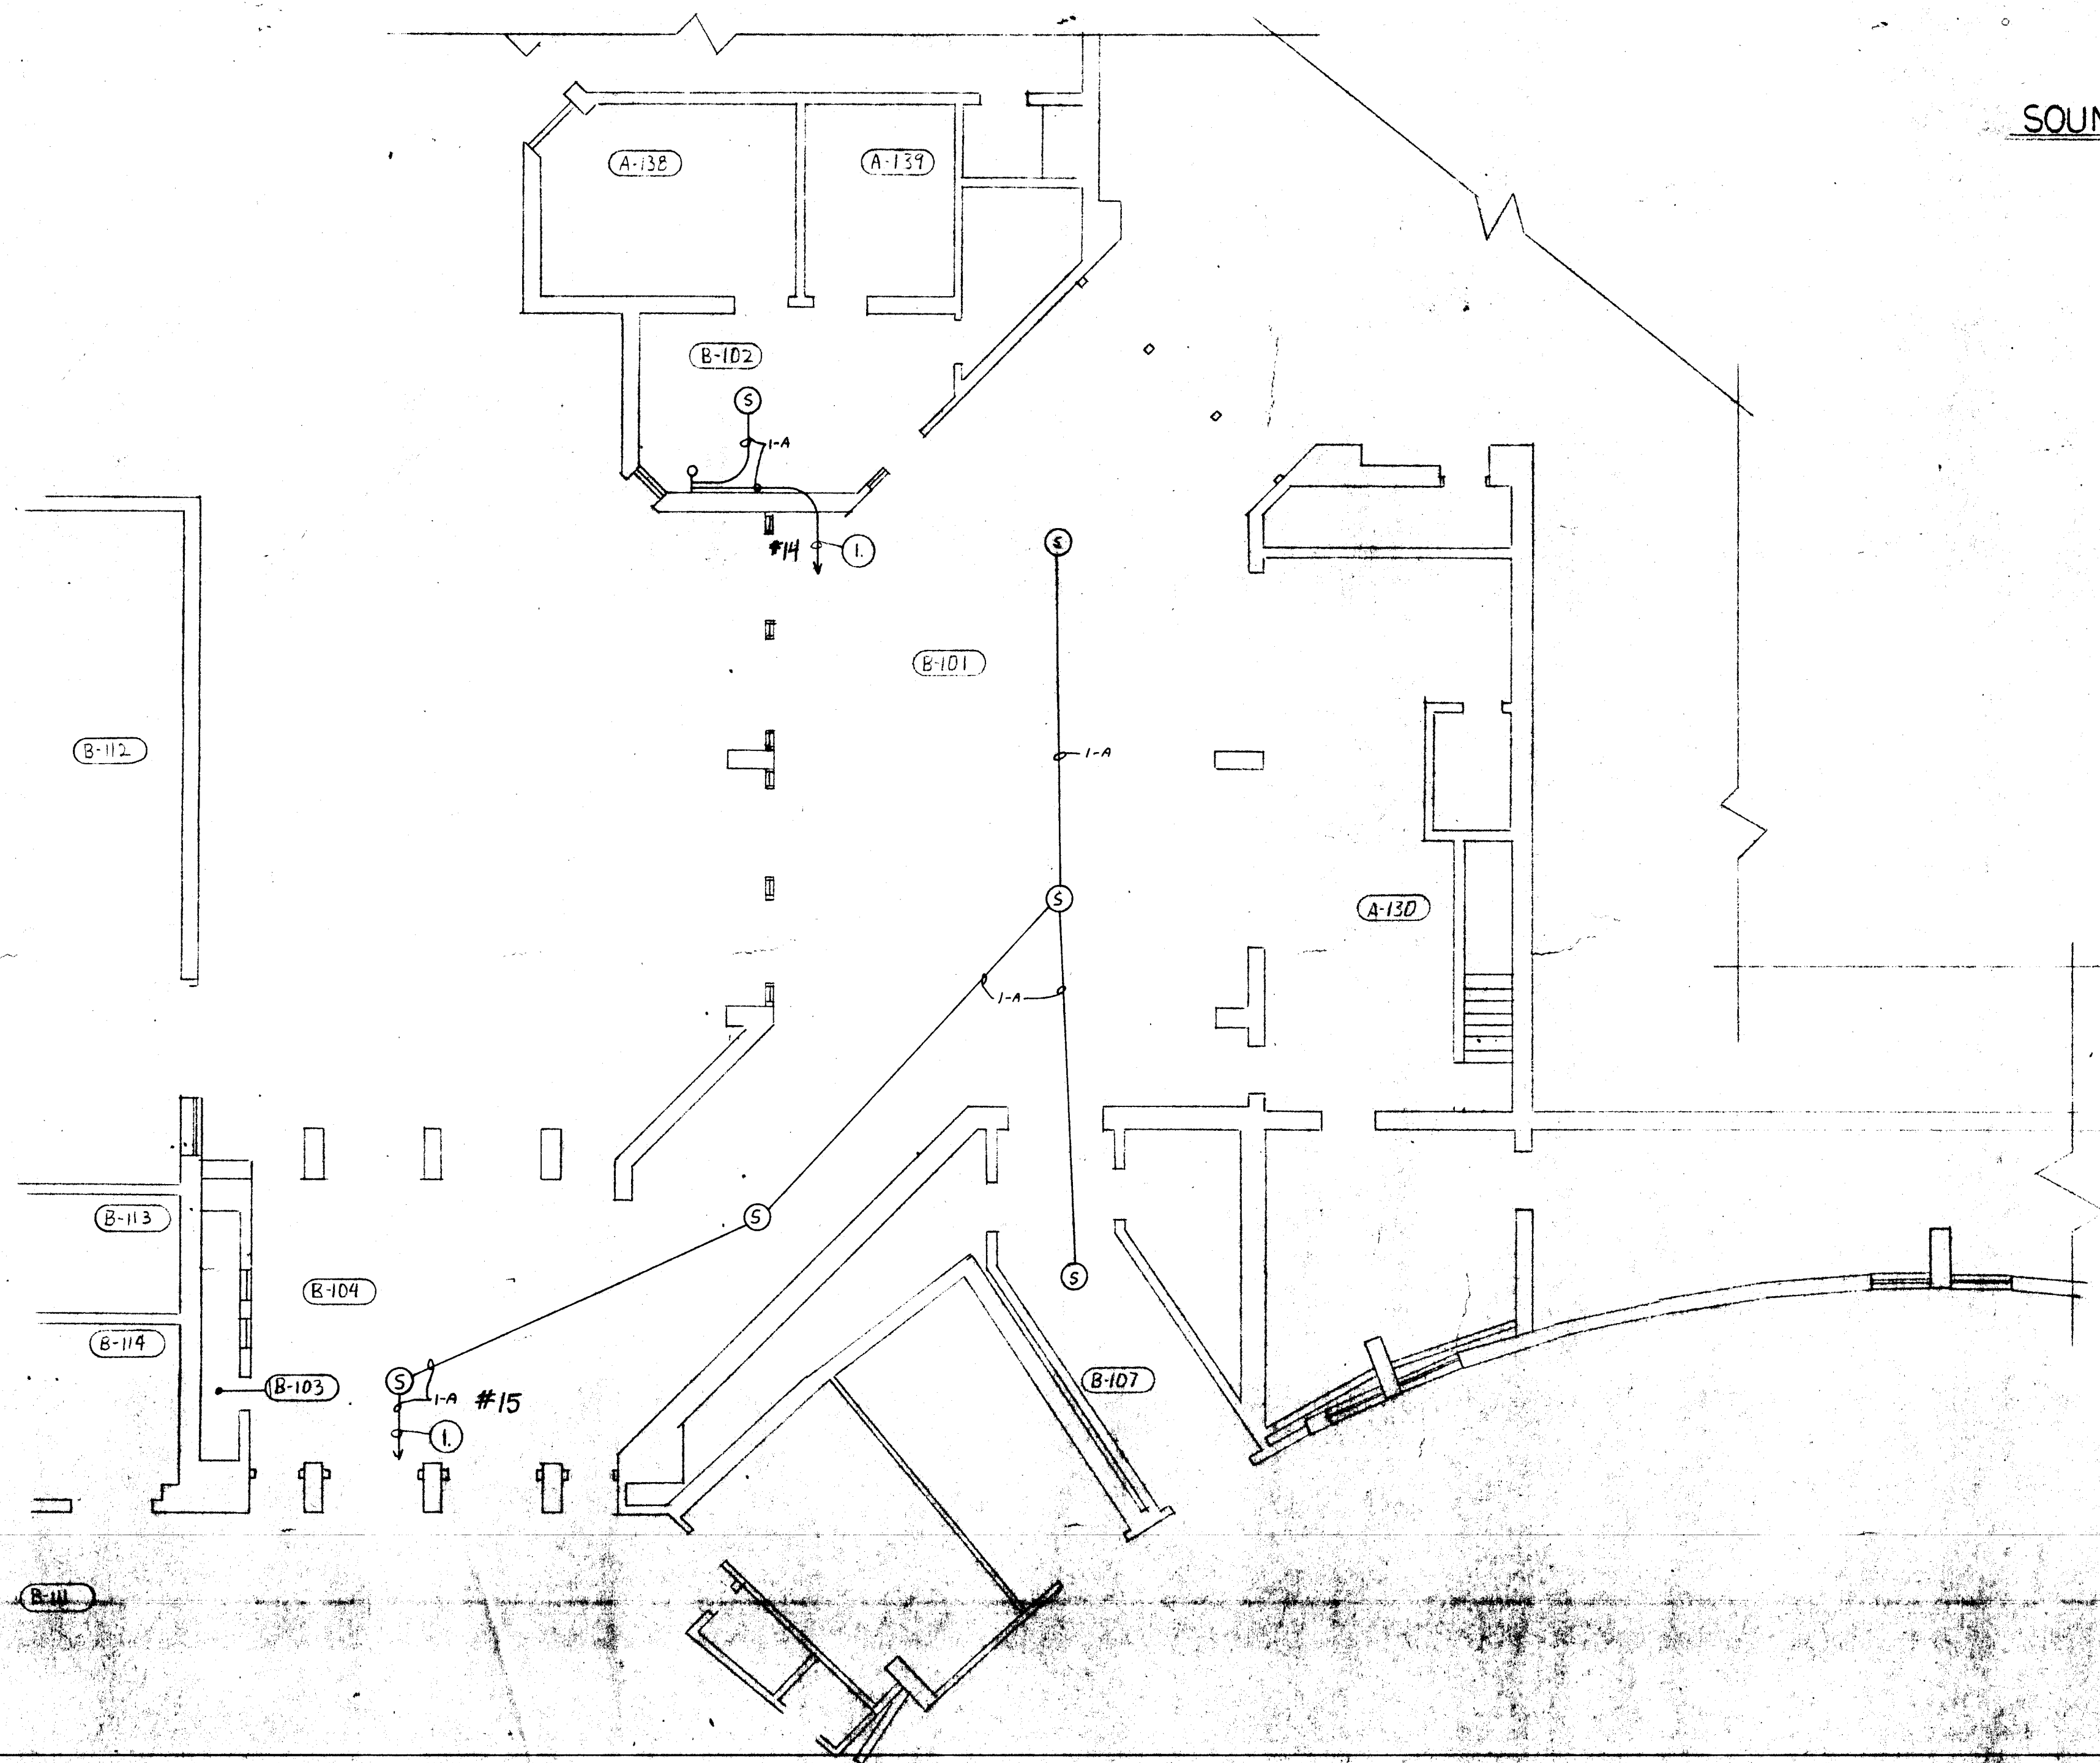

UNIT-B FLOOR PLAN
SCALE: 1/8" = 1'-0"

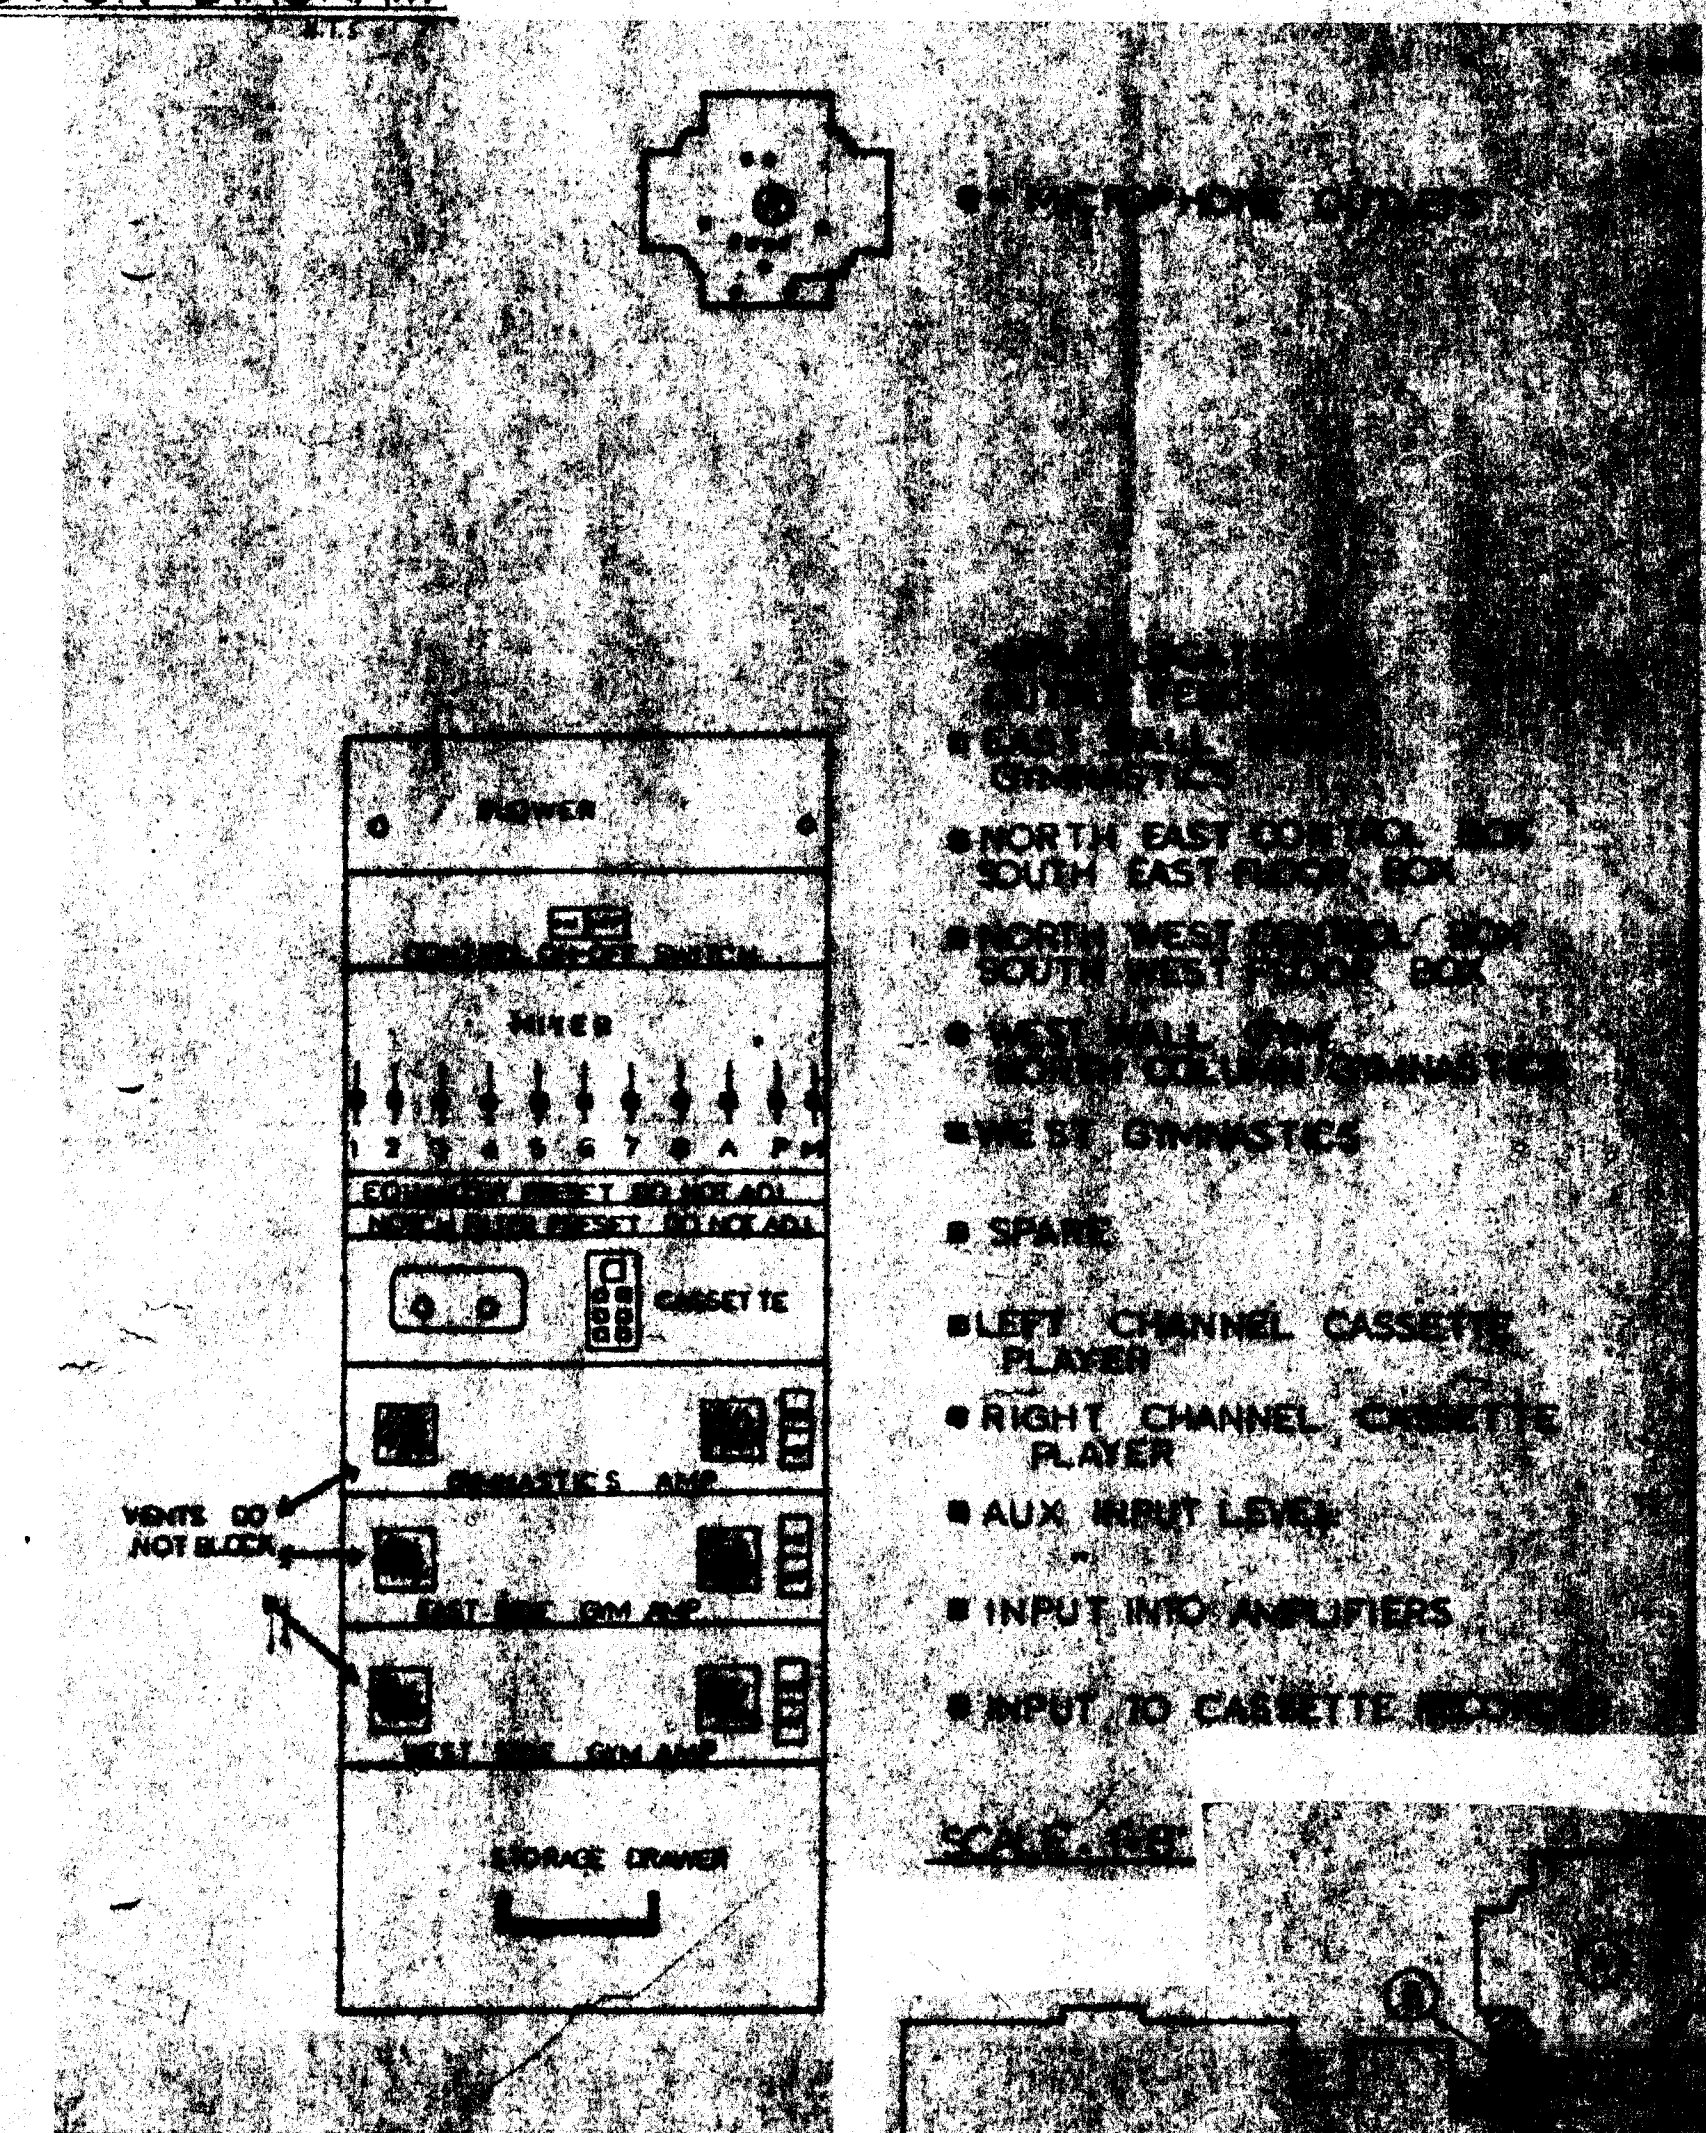

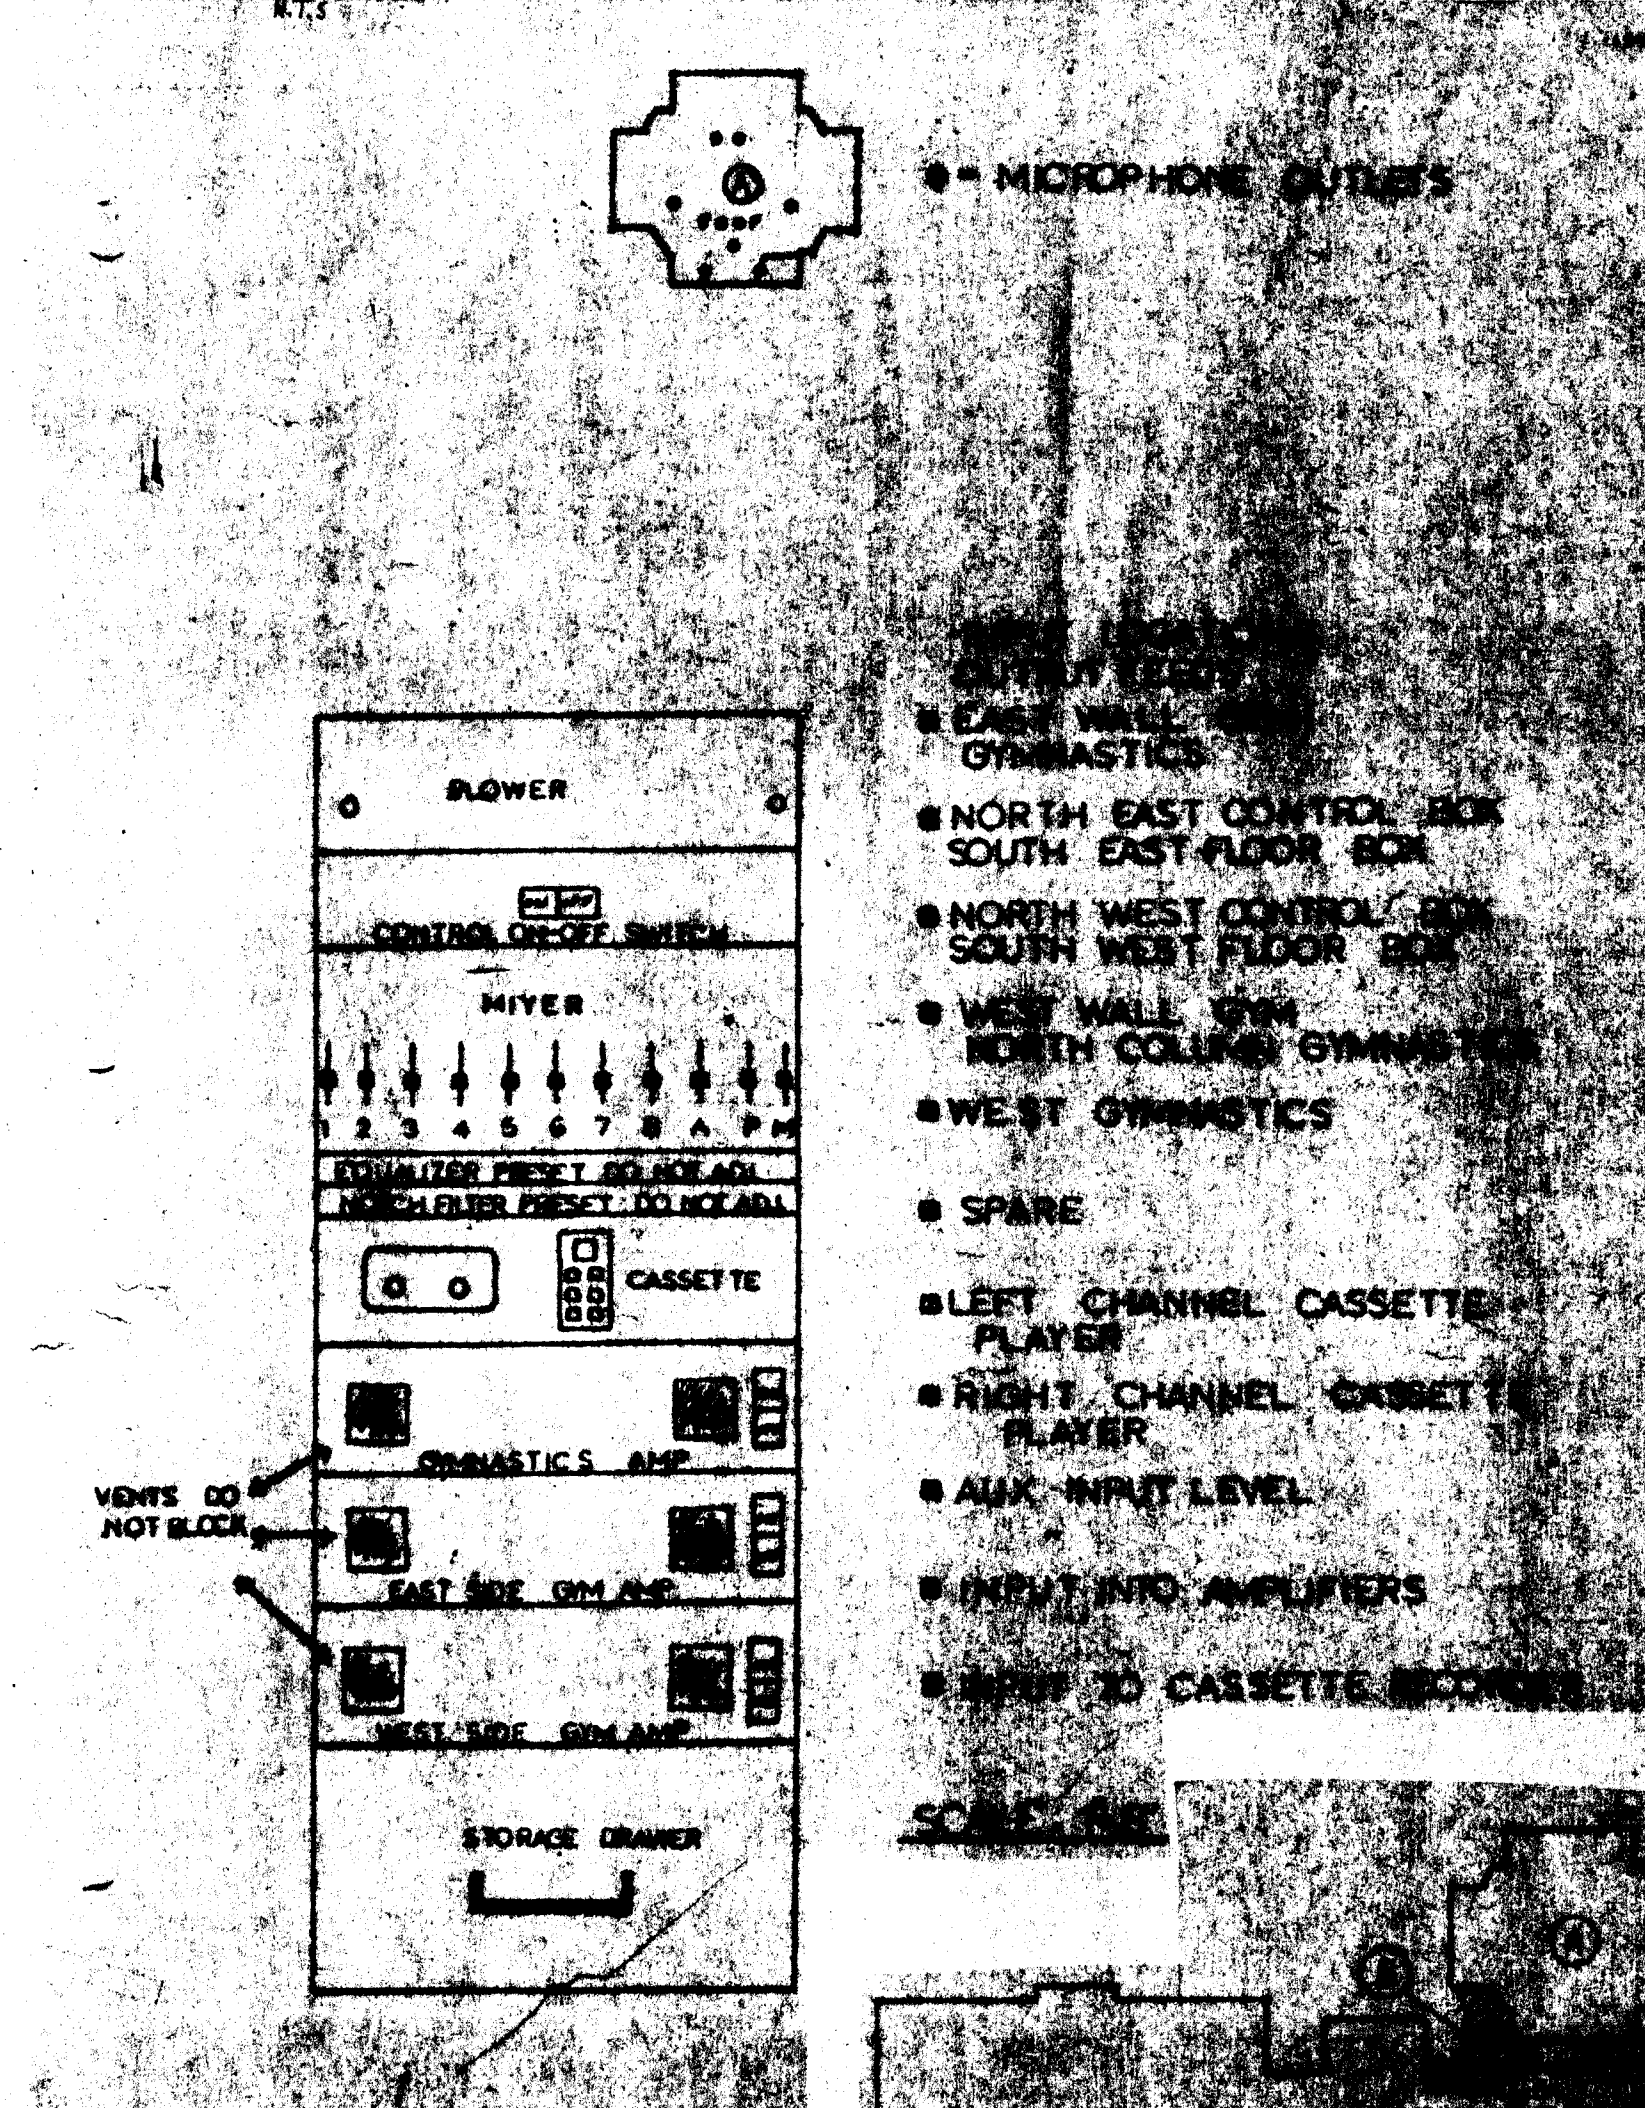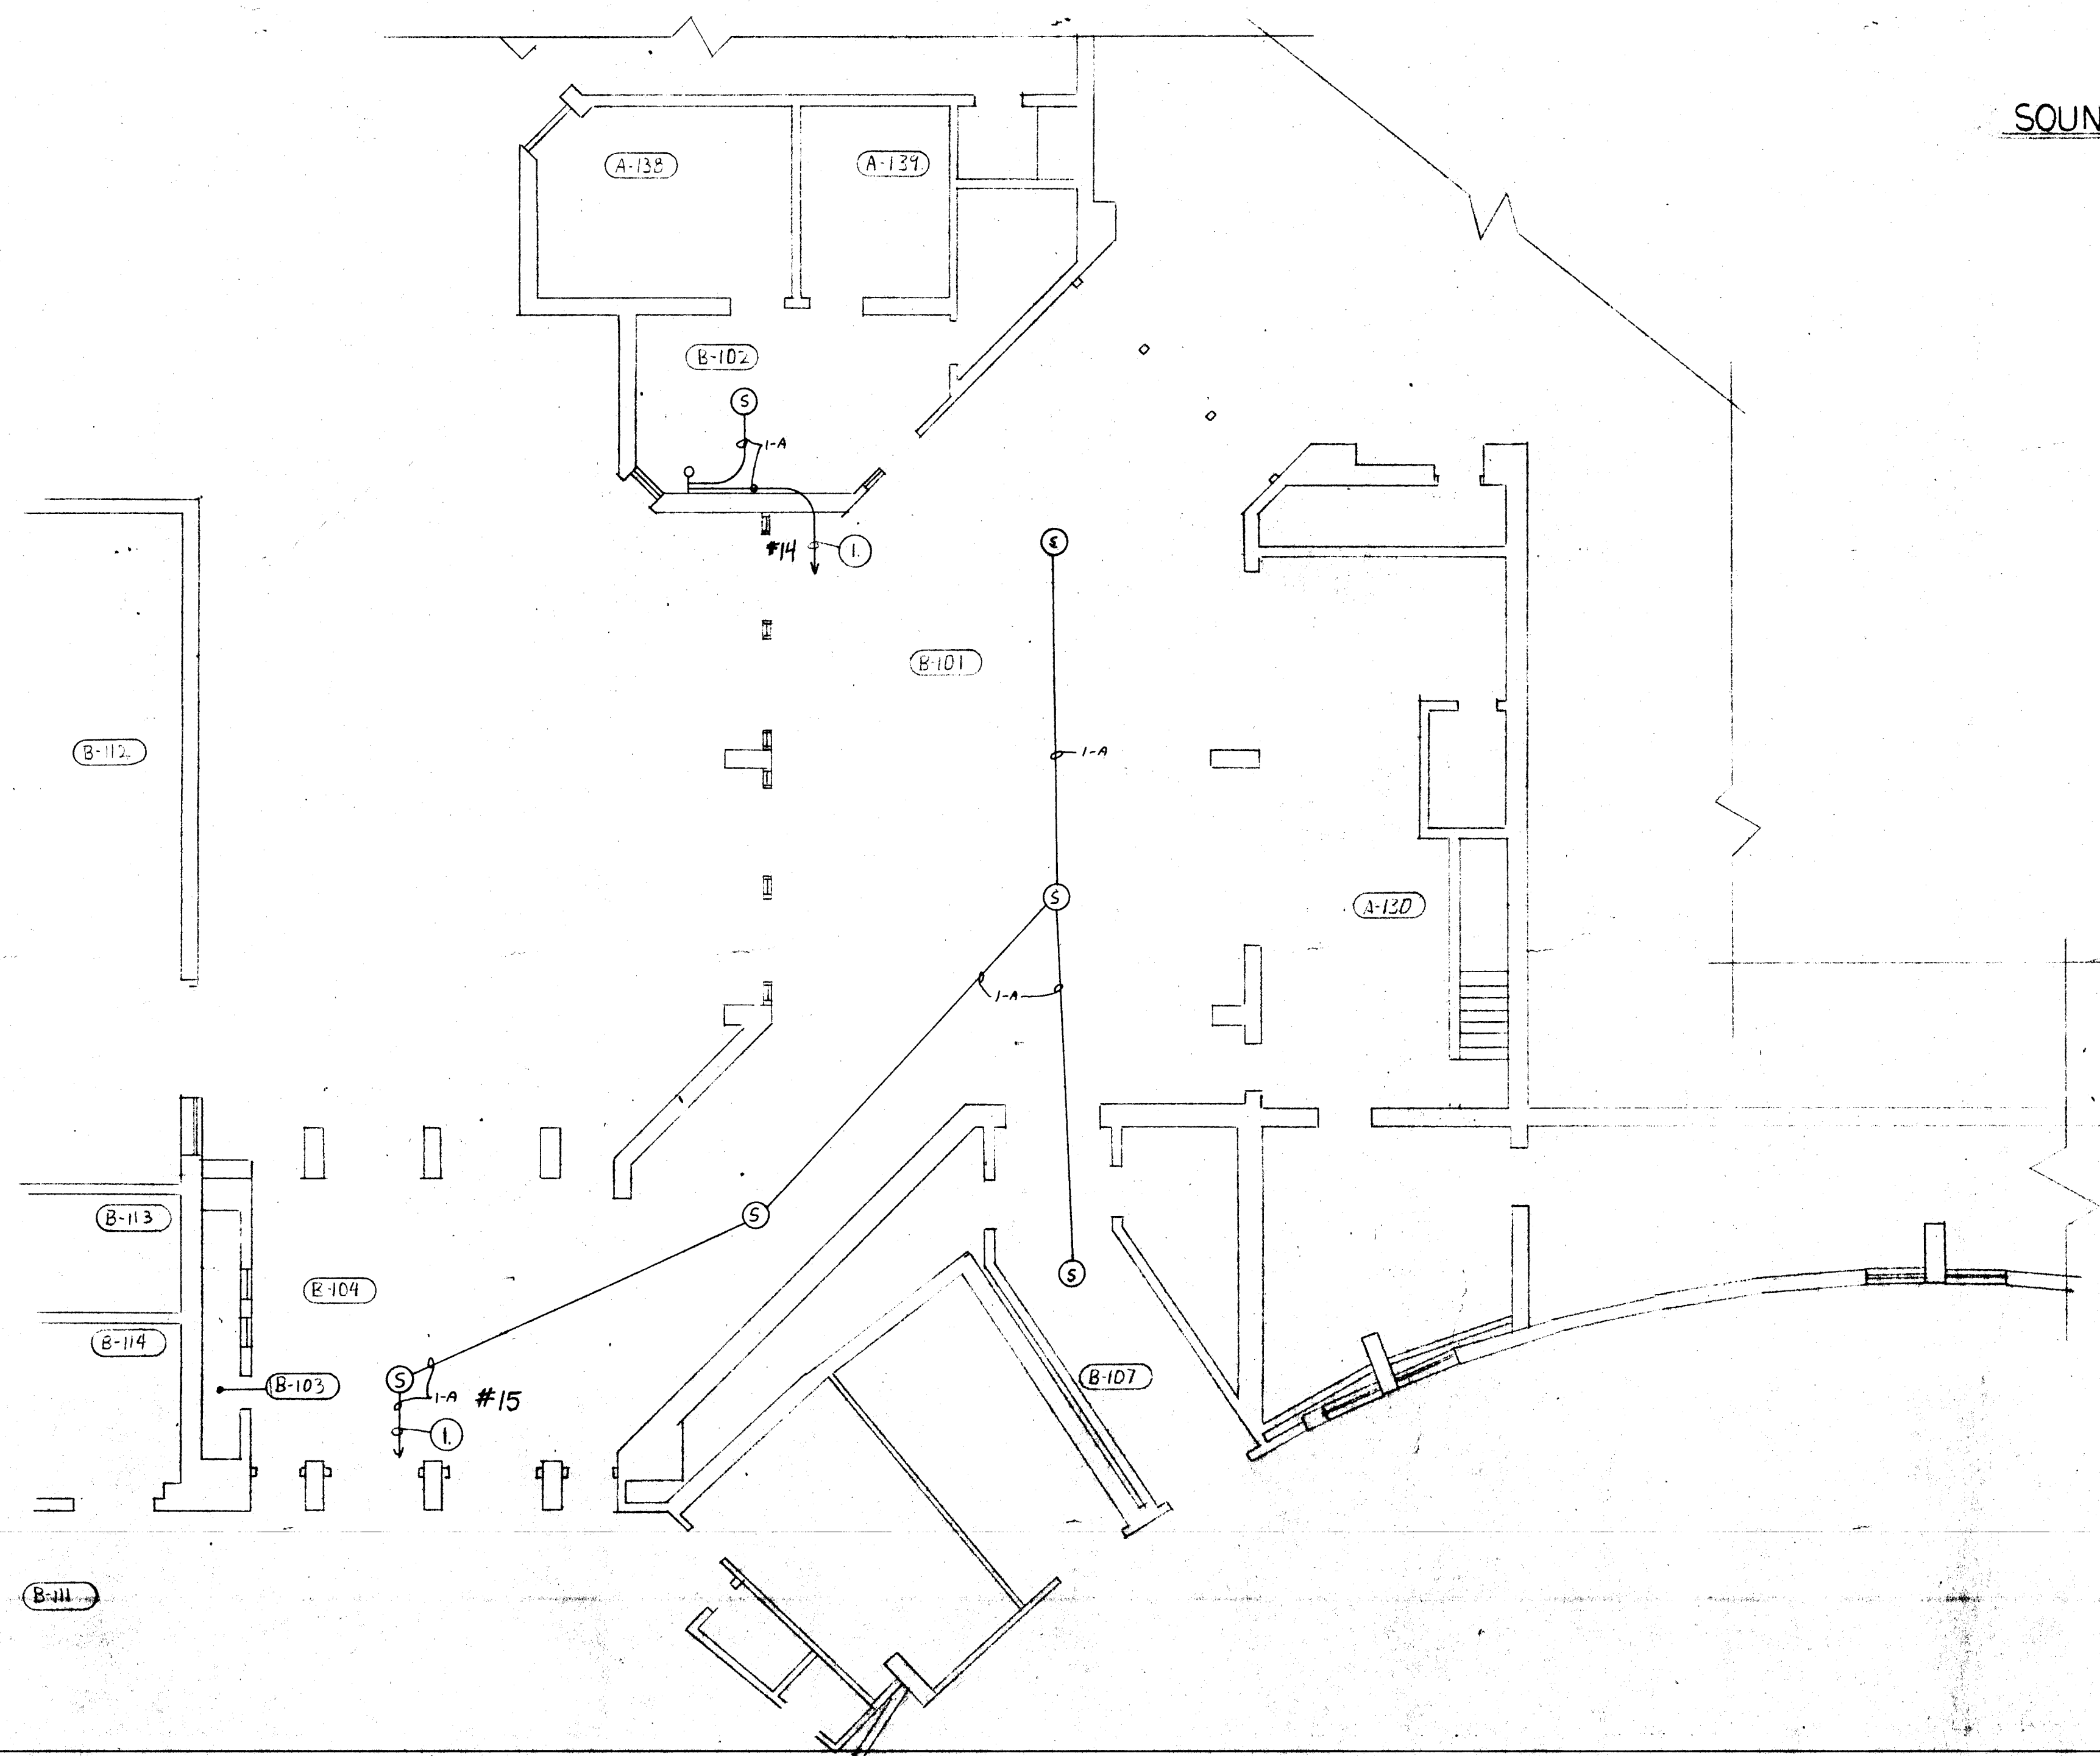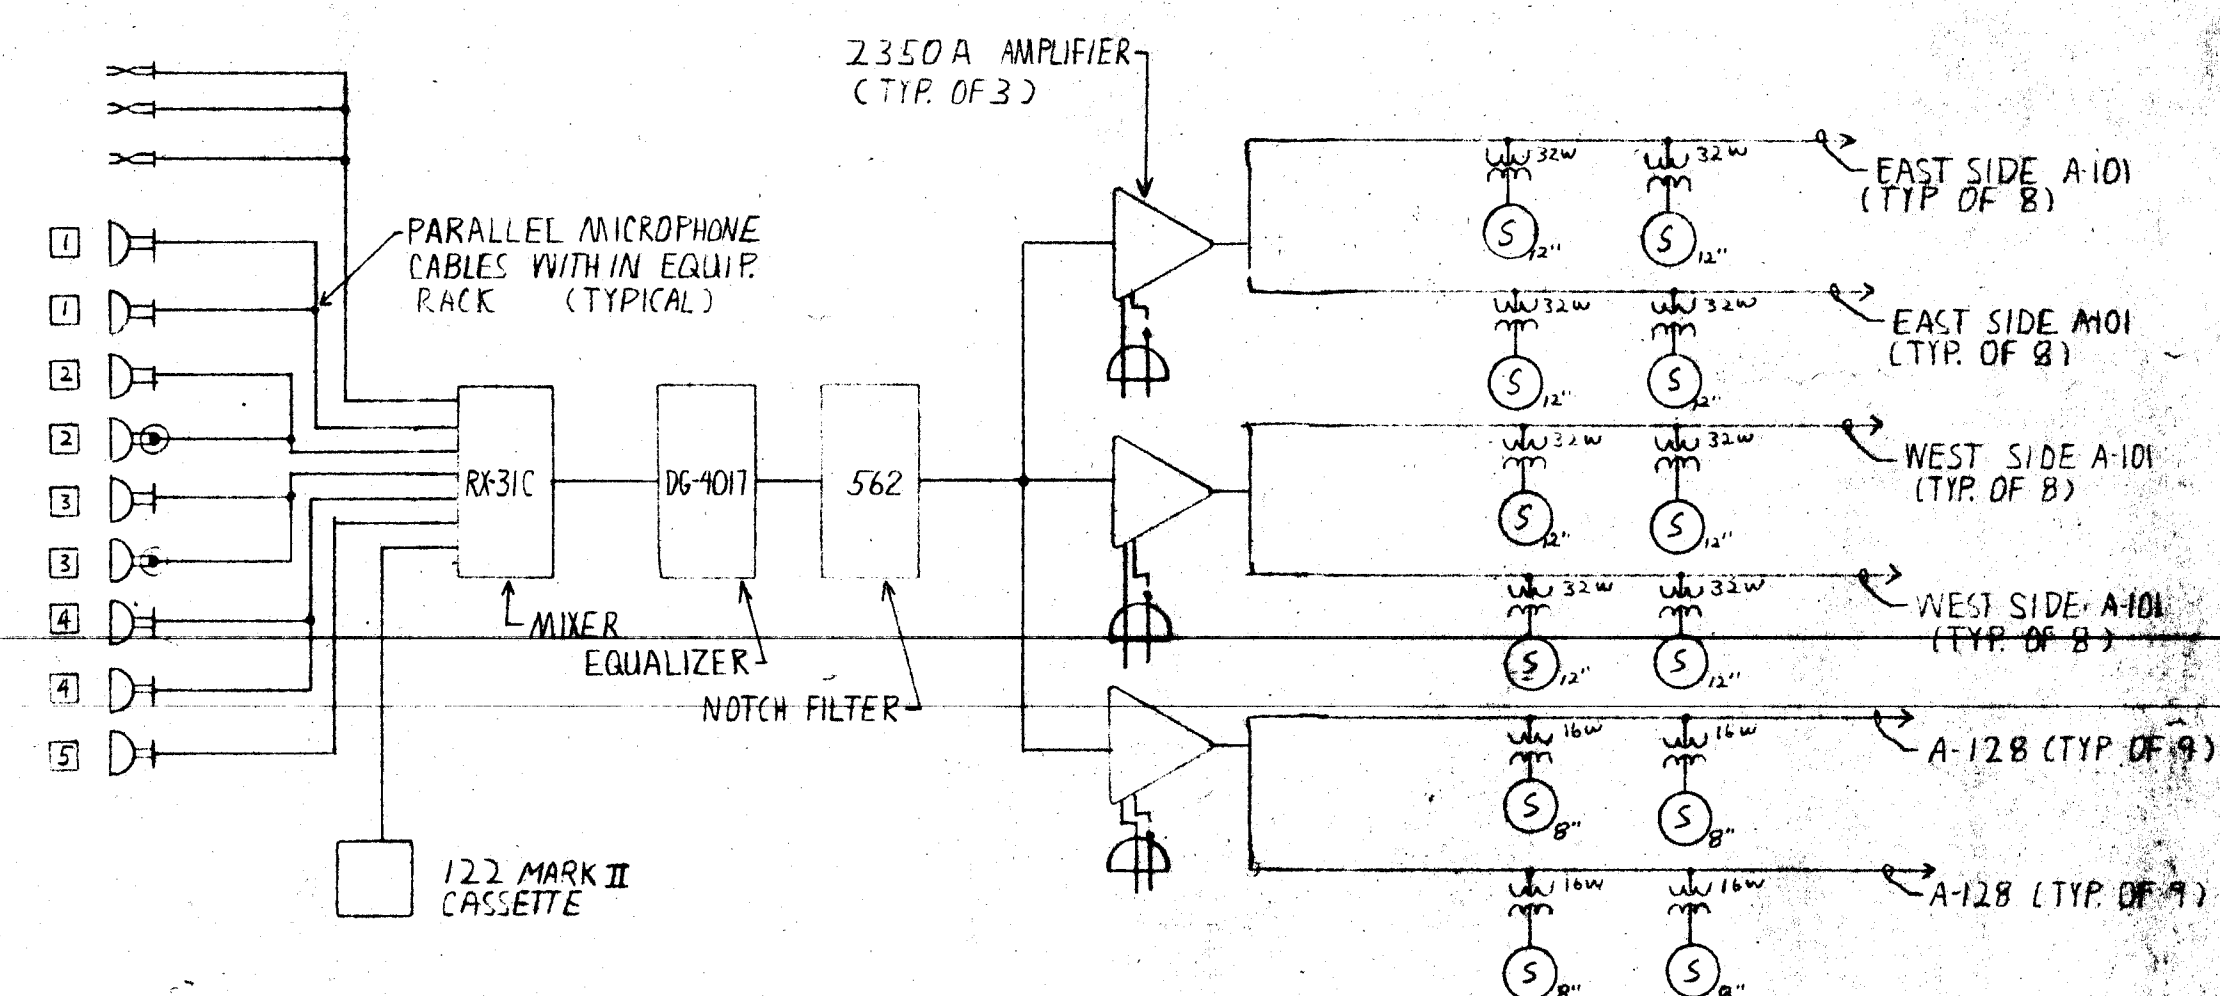
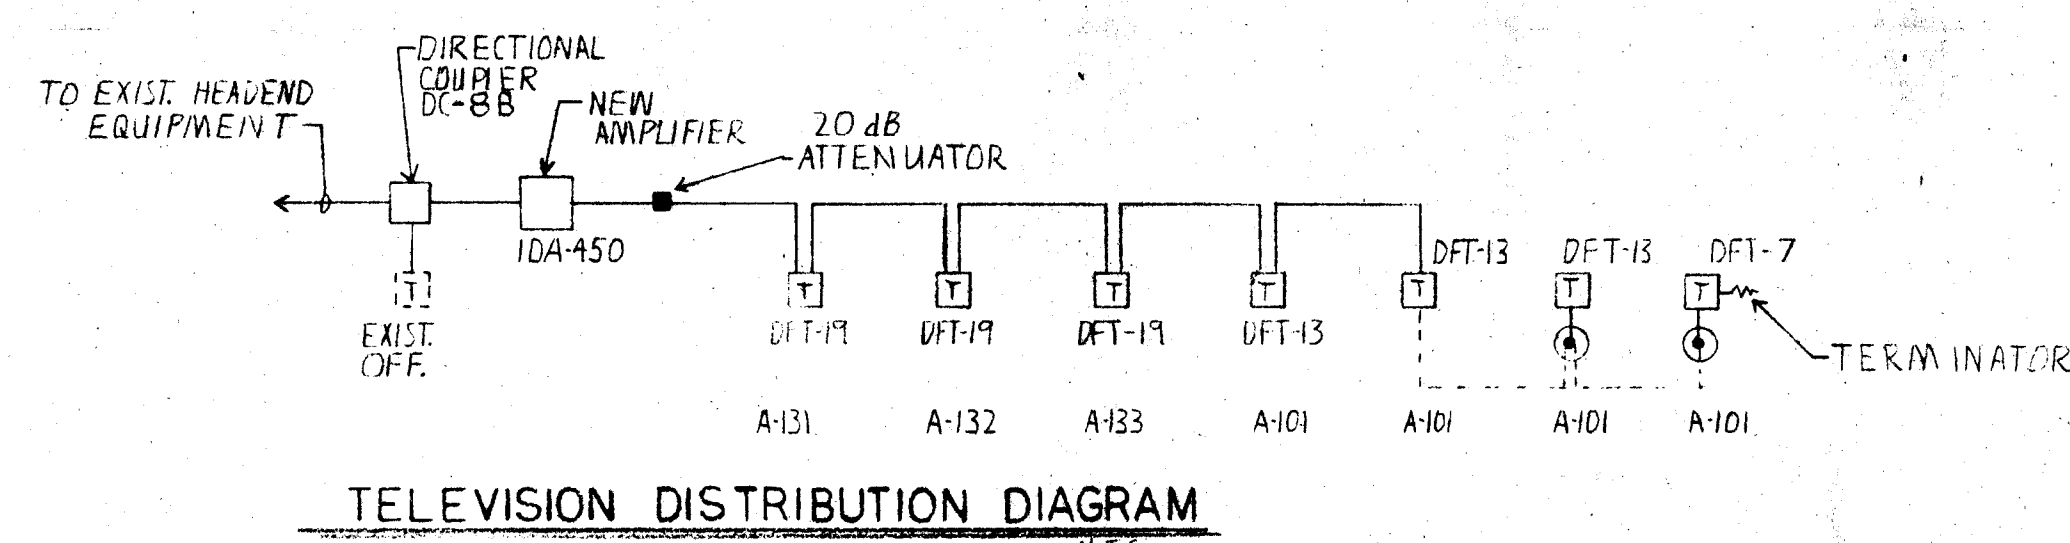
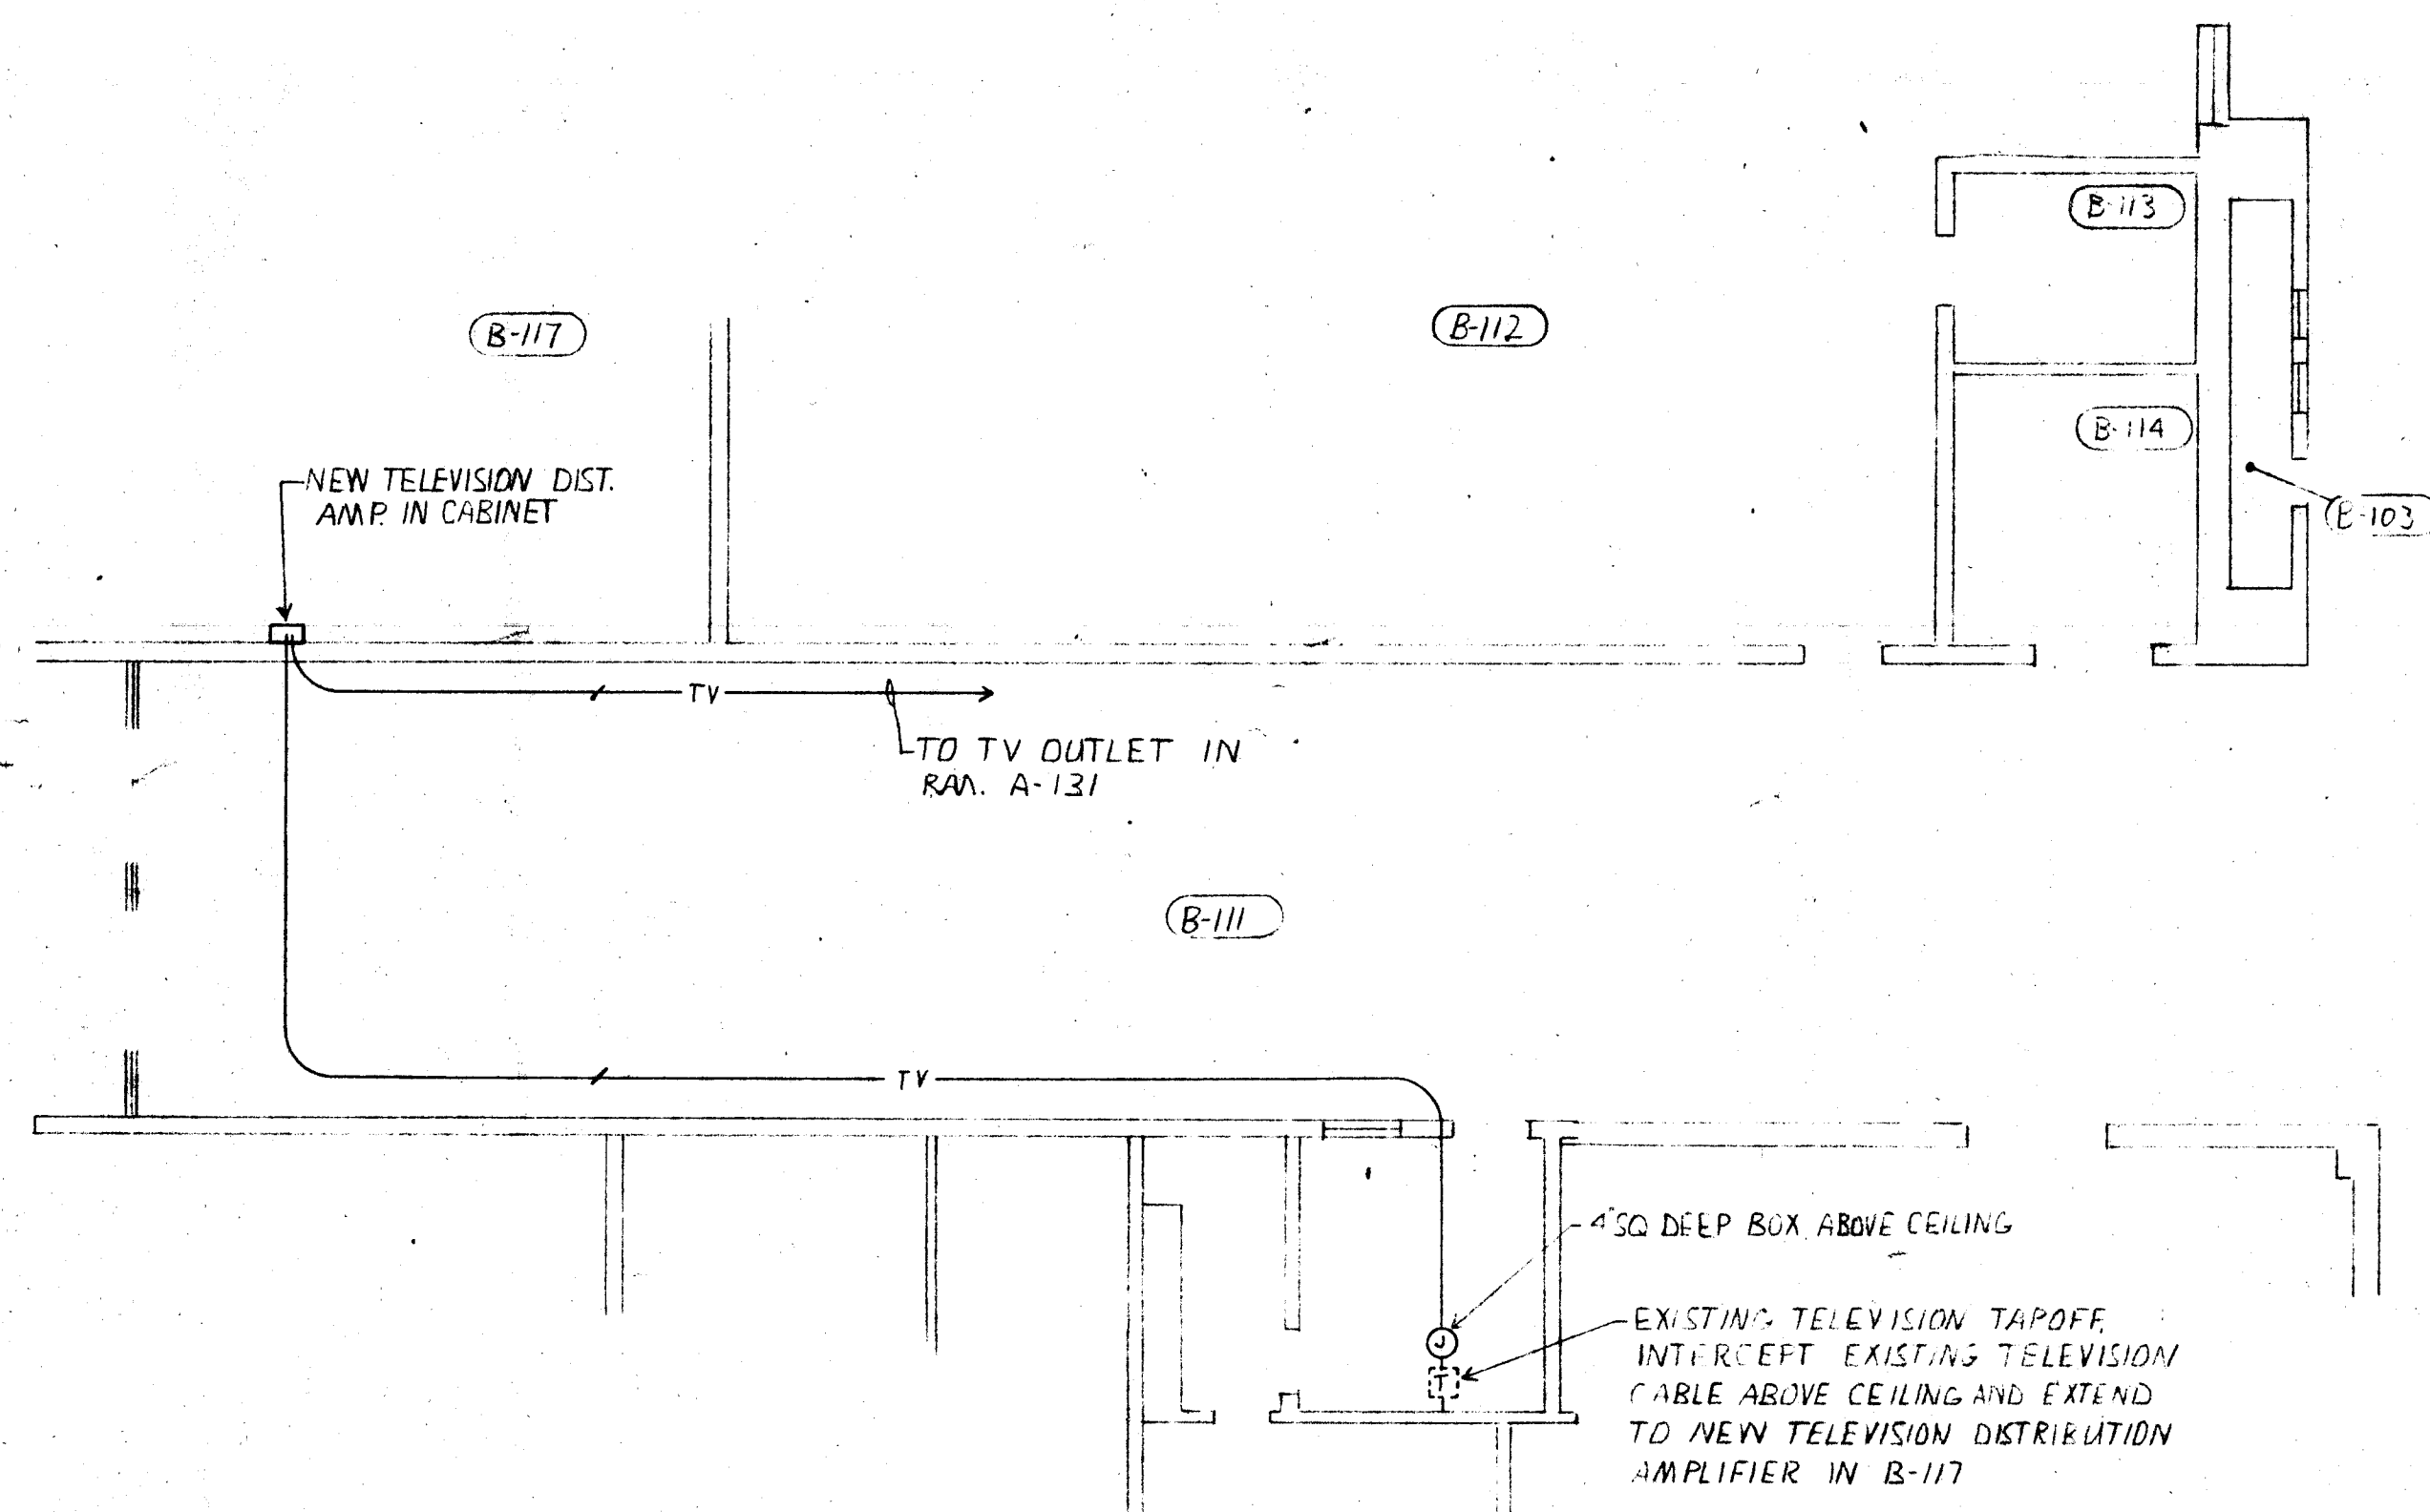


LAWRENCE CENTRAL

INSTRUMENTS

MADE IN U.S.A.

As B-107

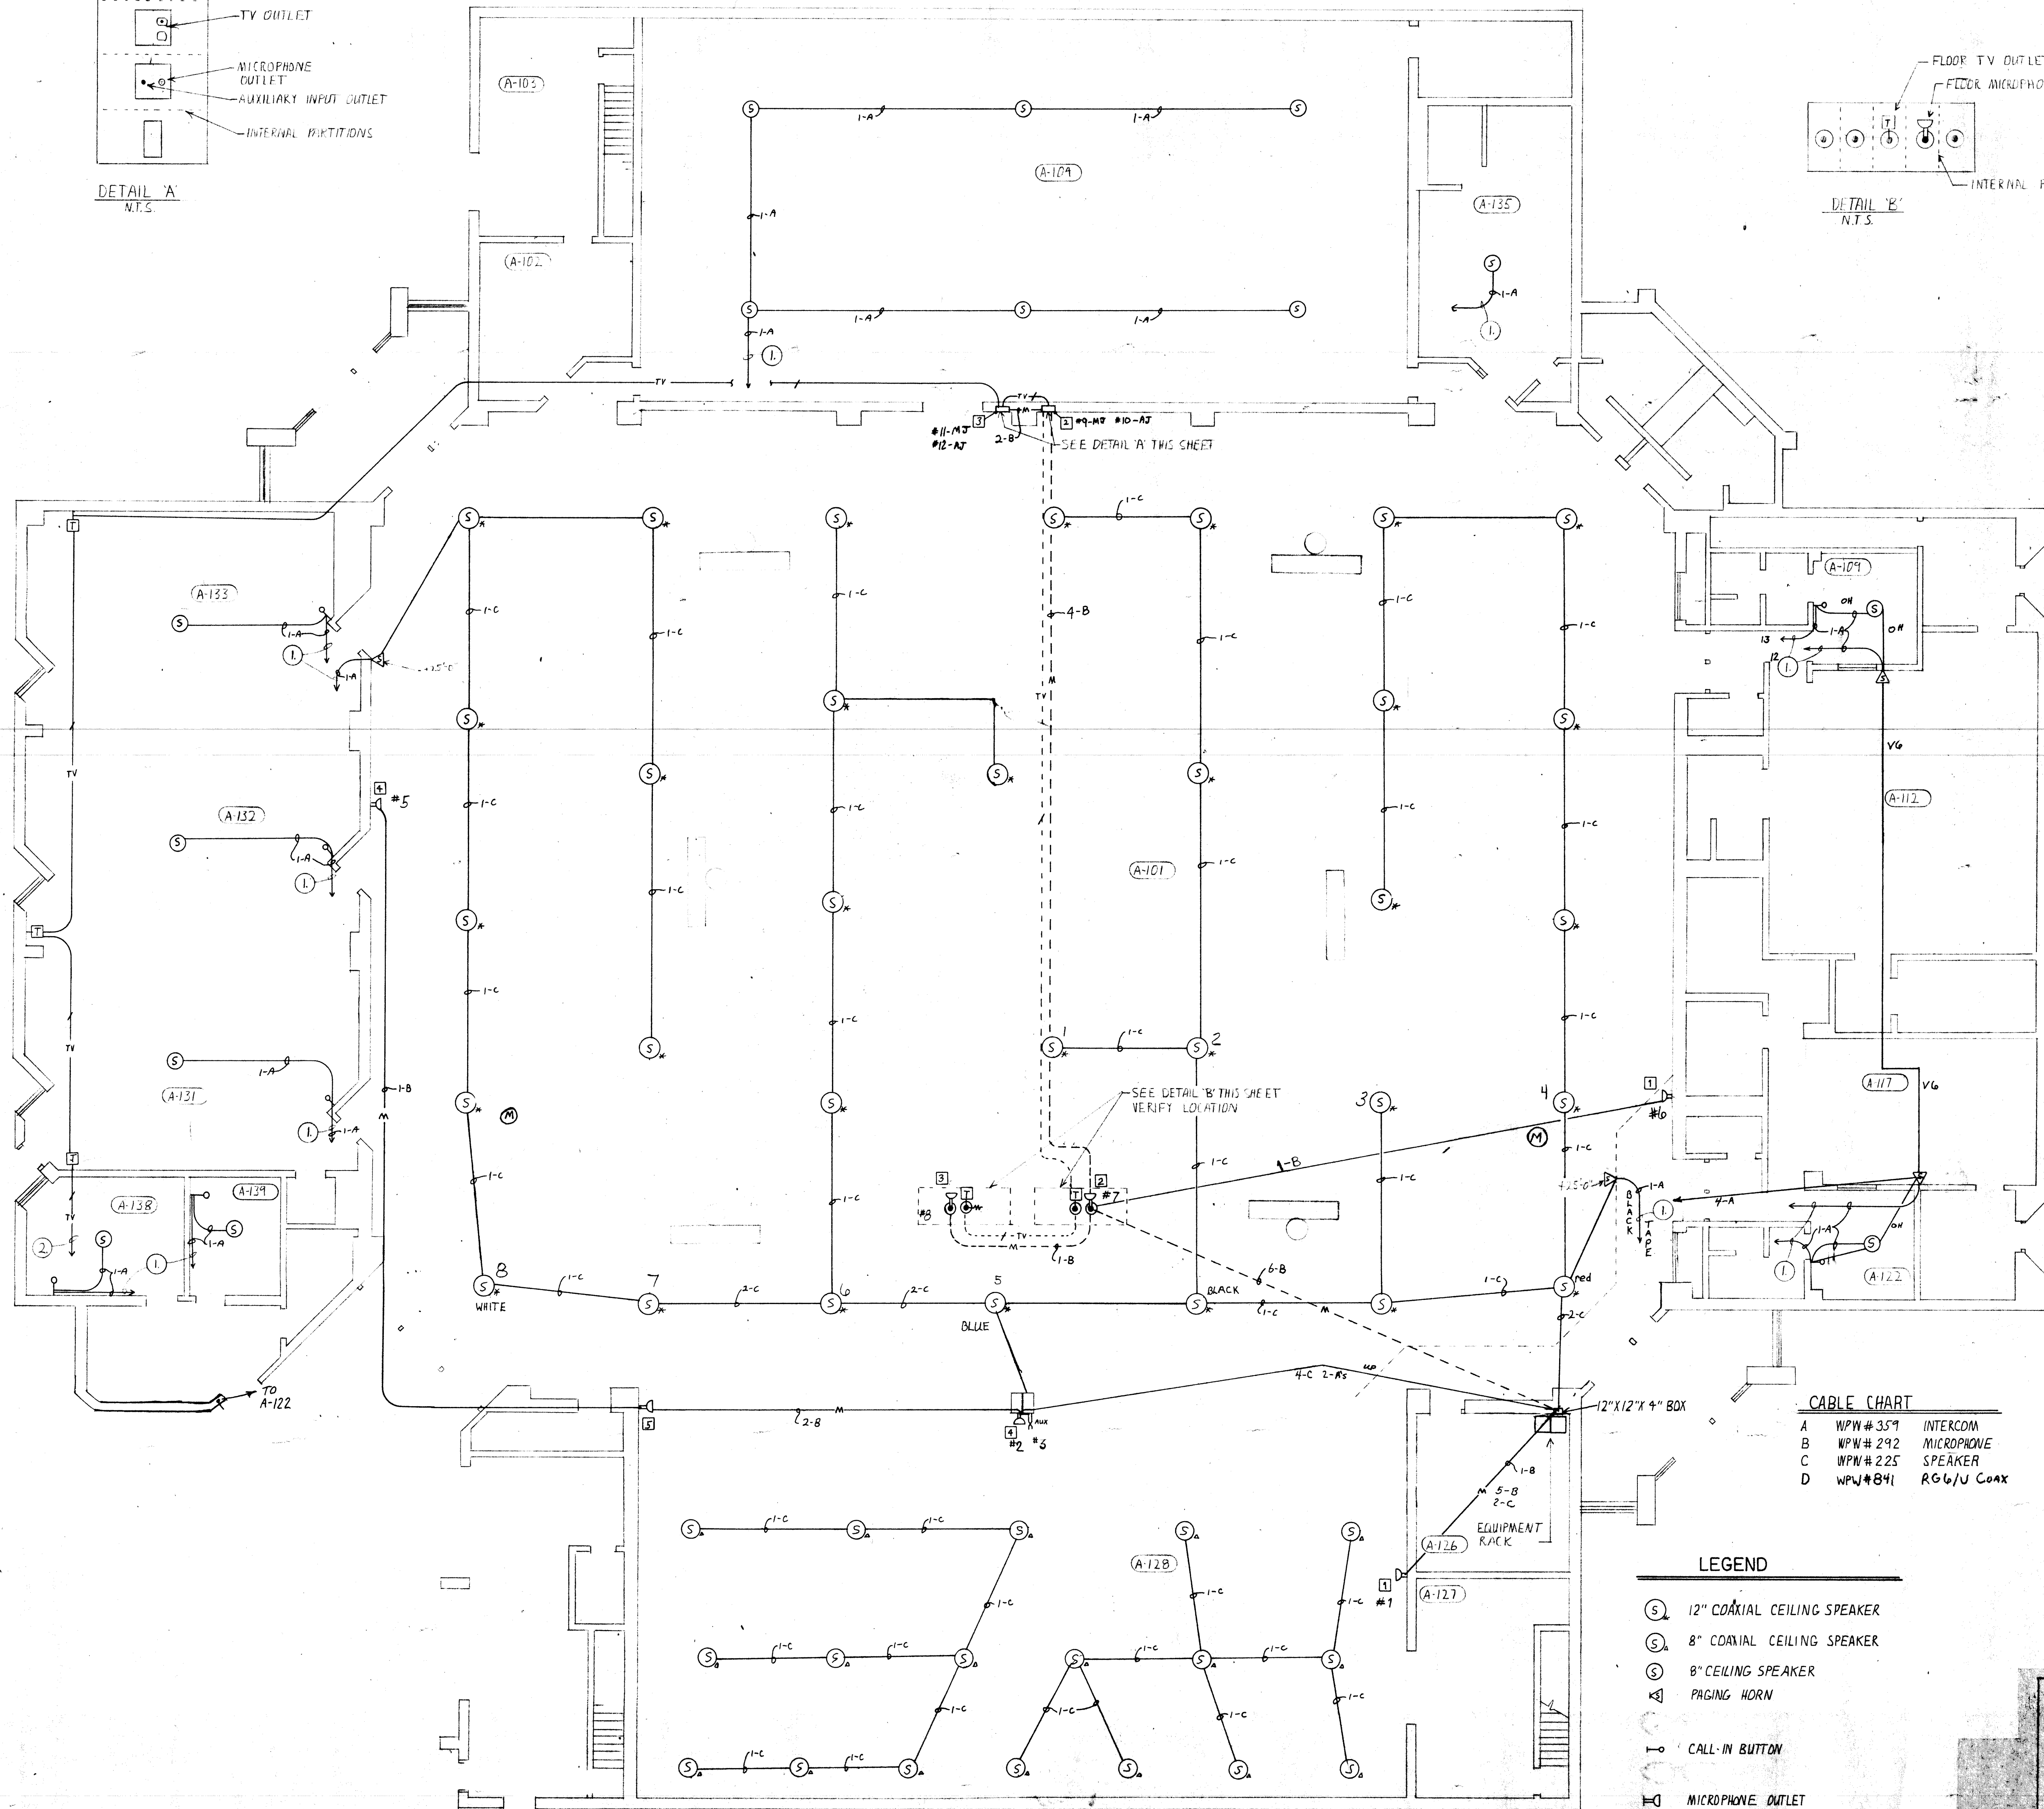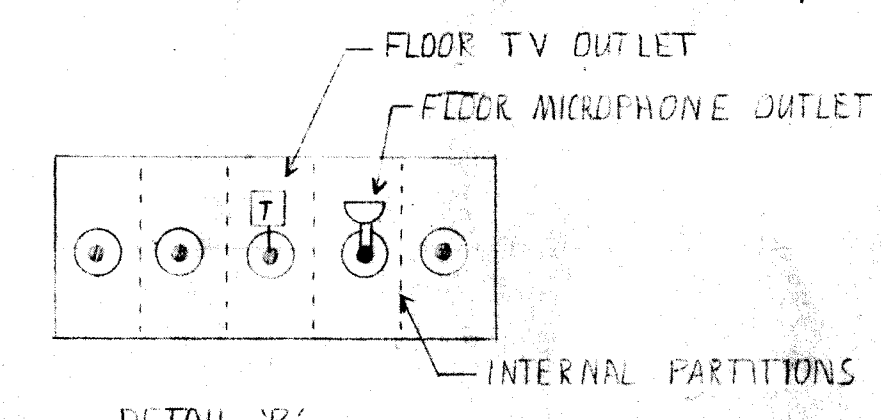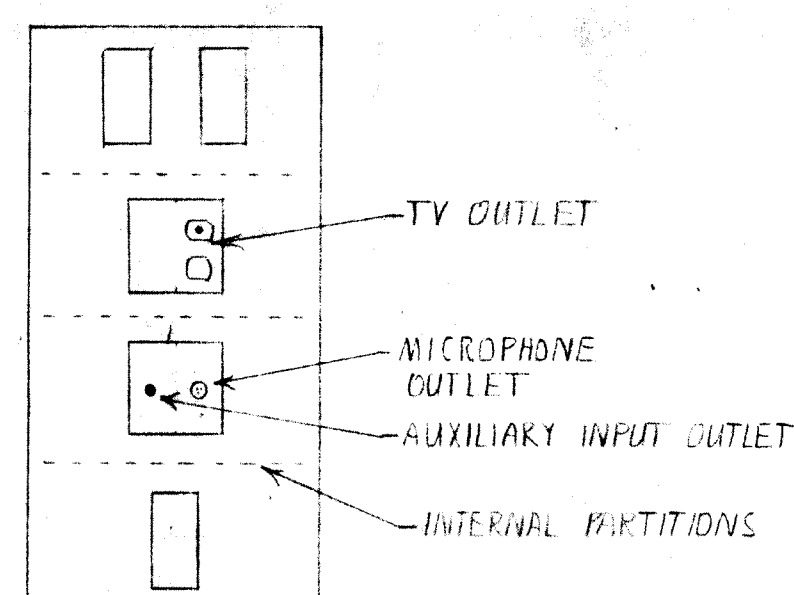

- ① HOME RUN TO SCHOOL INTERCOM CONSOLE
- ② TO T.V. WAP. IN B-117

GENERAL NOTES



1. ALL CABLES OR WIRES SHALL BE FREE OF SPICES BETWEEN DEVICES. ALL CABLES OR WIRES SHALL BE TIGHT AT ALL JUNCTION POINTS AND VERIFIED FREE FROM GROUNDS AND SHORTS.
2. ALL EQUIPMENT AND WIRING SHALL BE INSTALLED IN ACCORDANCE WITH THE REQUIREMENTS OF THE NATIONAL ELECTRIC CODE, NATIONAL STATE AND LOCAL CODES.
3. CONTRACTOR SHALL LEAVE A MINIMUM OF 12" PIGTAILS AT EACH OUTLET, 48" PIGTAILS AT EACH TERMINAL CABINET AND 12" PIGTAILS AT EACH EQUIPMENT RACK, HOUSING OR CONSOLE, UNLESS OTHERWISE SPECIFIED.
4. ALL CABLE SHALL BE IN CONDUIT CONDUIT TO BE INSTALLED AND SIZED BY E.C..




CABLE CHART	
A	WPN # 359 INTERCOM
B	WPN # 292 MICROPHONE
C	WPN # 225 SPEAKER
D	WPN # 841 RG6/U COAX

LEGEND

- ⊙ 12" COAXIAL CEILING SPEAKER
- ⊙ 8" COAXIAL CEILING SPEAKER
- ⊙ 8" CEILING SPEAKER
- ⊙ PAGING HORN
- ⊙ CALL-IN BUTTON
- ⊙ MICROPHONE OUTLET
- ⊙ FLOOR MICROPHONE OUTLET
- ⊙ AUXILIARY INPUT
- ⊙ T.V. OUTLET
- ⊙ FLOOR T.V. OUTLET

 UNIT A FLOOR PLAN
SCALE: 1/8" = 1'-0"

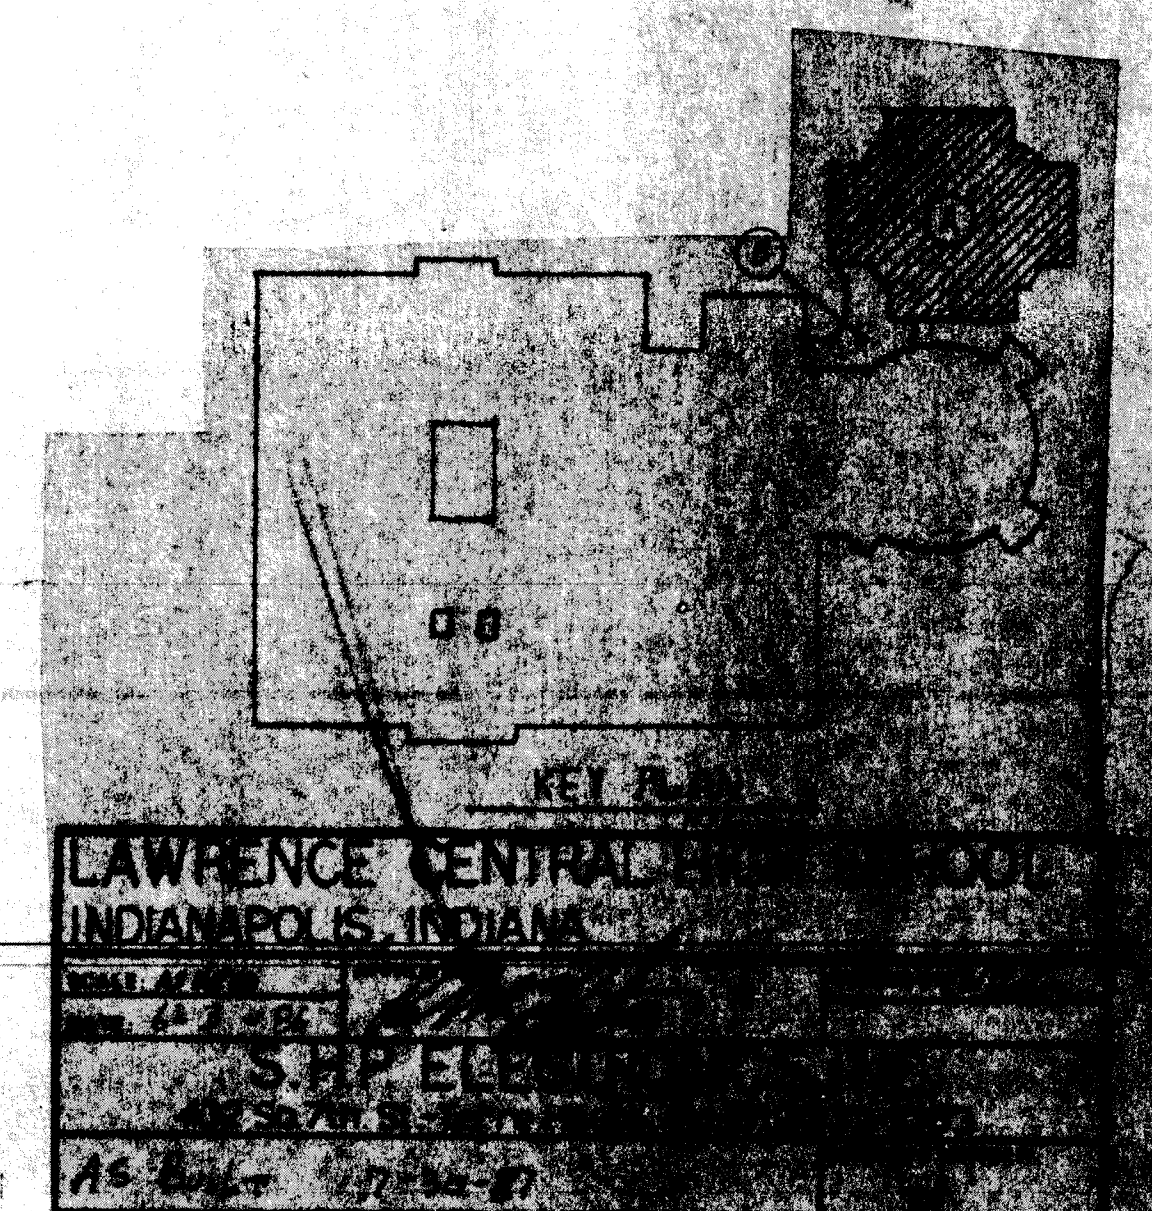

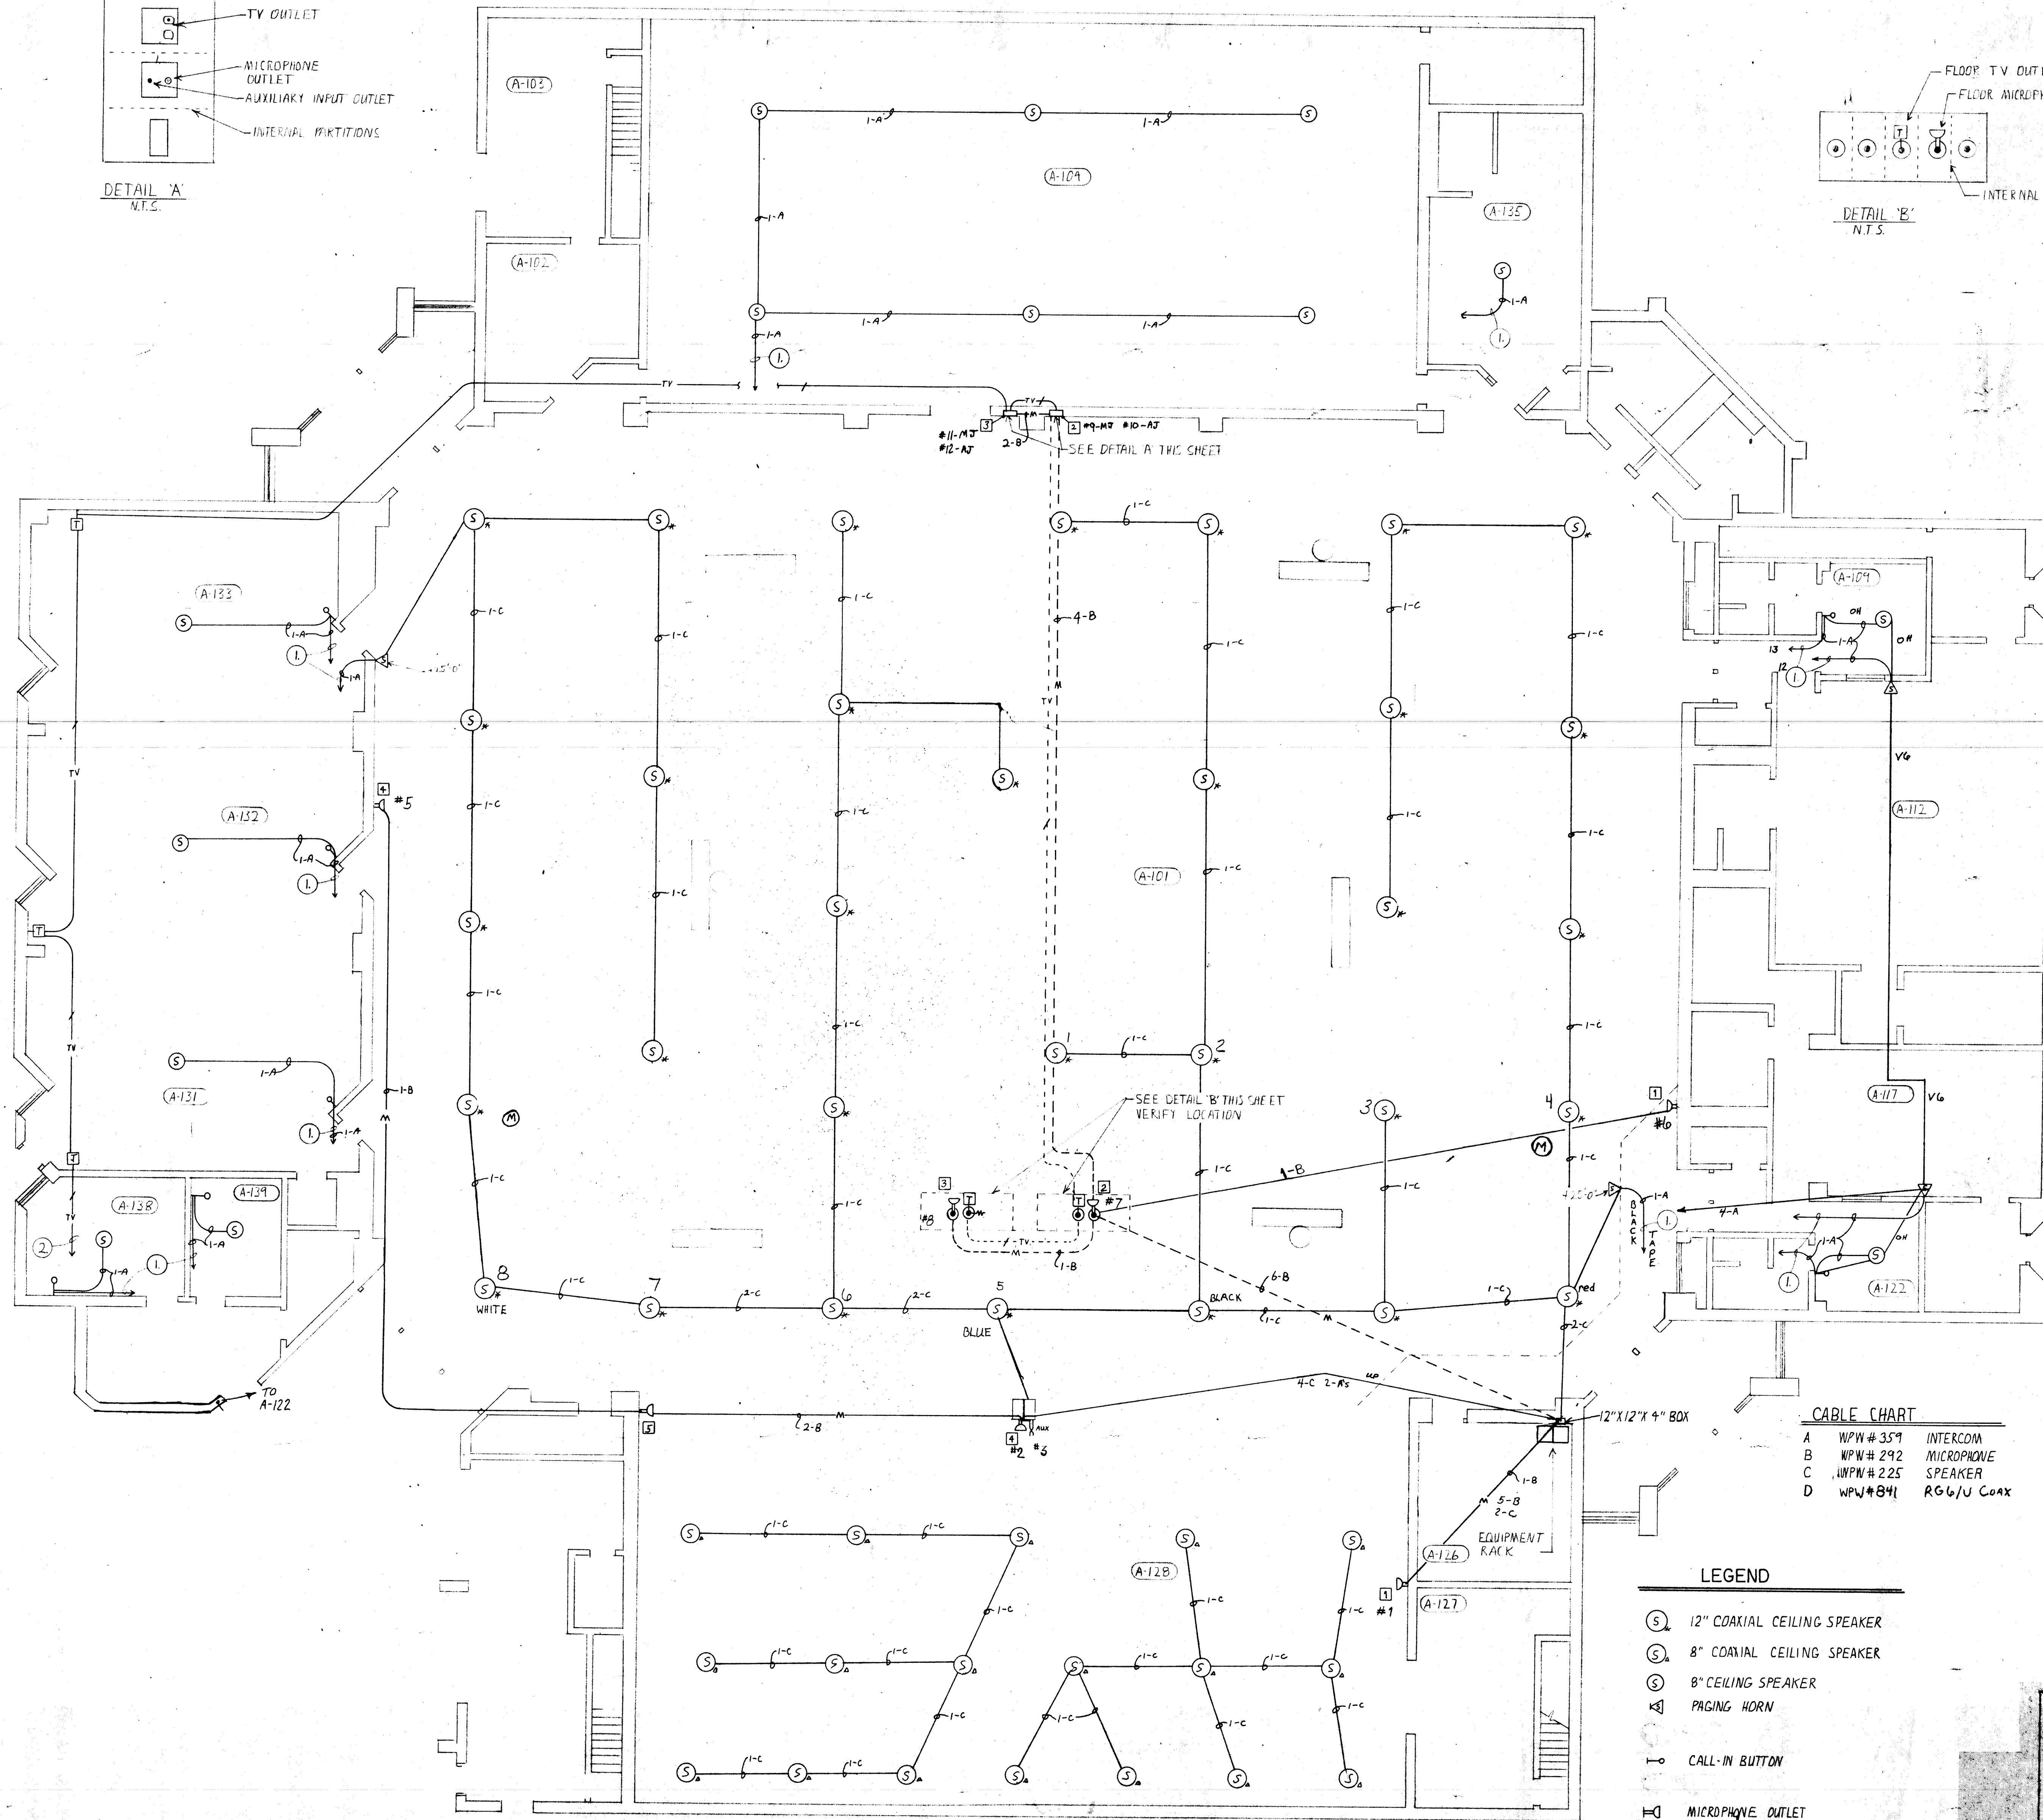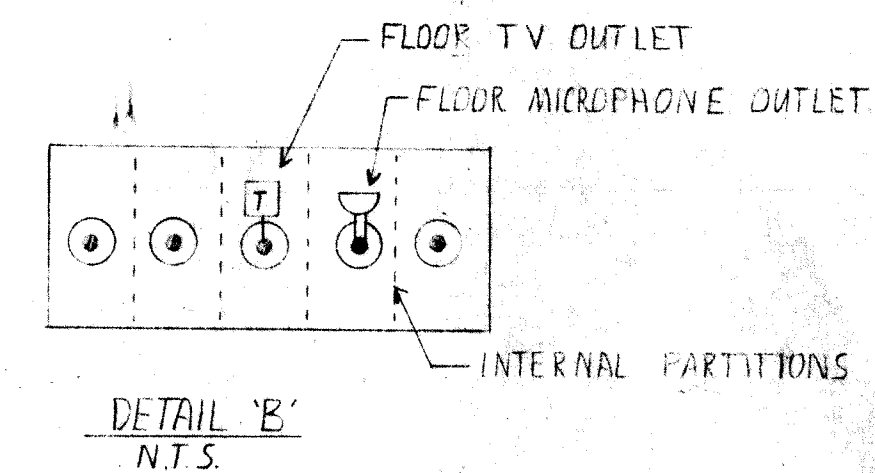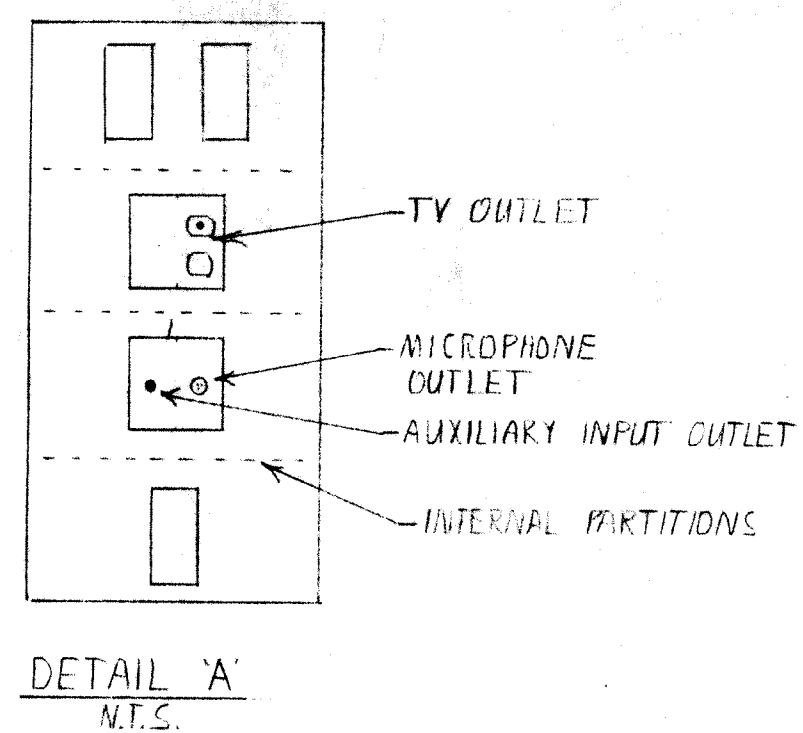

- (1) HOME RUN TO SCHOOL INTERCOM CONSOLE
- (2) TO TV. WAF. IN B-117

GENERAL NOTES

1. ALL CABLES OR WIRES SHALL BE FREE OF SPICES BETWEEN OFFICES. ALL CABLES OR WIRES SHALL BE TAGGED AT ALL JUNCTION POINTS AND VERIFIED FREE FROM GROUNDING AND SHORTS.
2. ALL EQUIPMENT AND WIRING SHALL BE INSTALLED IN ACCORDANCE WITH THE REQUIREMENTS OF THE NATIONAL ELECTRIC CODE, NATIONAL, STATE AND LOCAL CODES.
3. CONTRACTOR SHALL LEAVE A MINIMUM OF 12" PIGTAILS AT EACH OUTLET, 4" PIGTAILS AT EACH TERMINAL CABLE AND 12" PIGTAILS AT EACH EQUIPMENT RACK, HORNINGS OR CONSOLES, UNLESS OTHERWISE SPECIFIED.
4. ALL CABLE SHALL BE IN CONDUIT CONDUIT TO BE INSTALLED AND SIZED BY E.C..

CABLE CHART

A	WPN # 359	INTERCOM
B	WPN # 292	MICROPHONE
C	WPN # 225	SPEAKER
D	WPN # 841	RG6/U Coax

LEGEND

- (S) 12" COAXIAL CEILING SPEAKER
- (S) 8" COAXIAL CEILING SPEAKER
- (S) 8" CEILING SPEAKER
- (H) PAGING HORN
- (I) CALL-IN BUTTON
- (M) MICROPHONE OUTLET
- (F) FLOOR MICROPHONE OUTLET
- (A) AUXILIARY INPUT
- (T) T.V. OUTLET
- (F) FLOOR T.V. OUTLET

UNIT A FLOOR PLAN
SCALE: 1/8" = 1'-0"

