

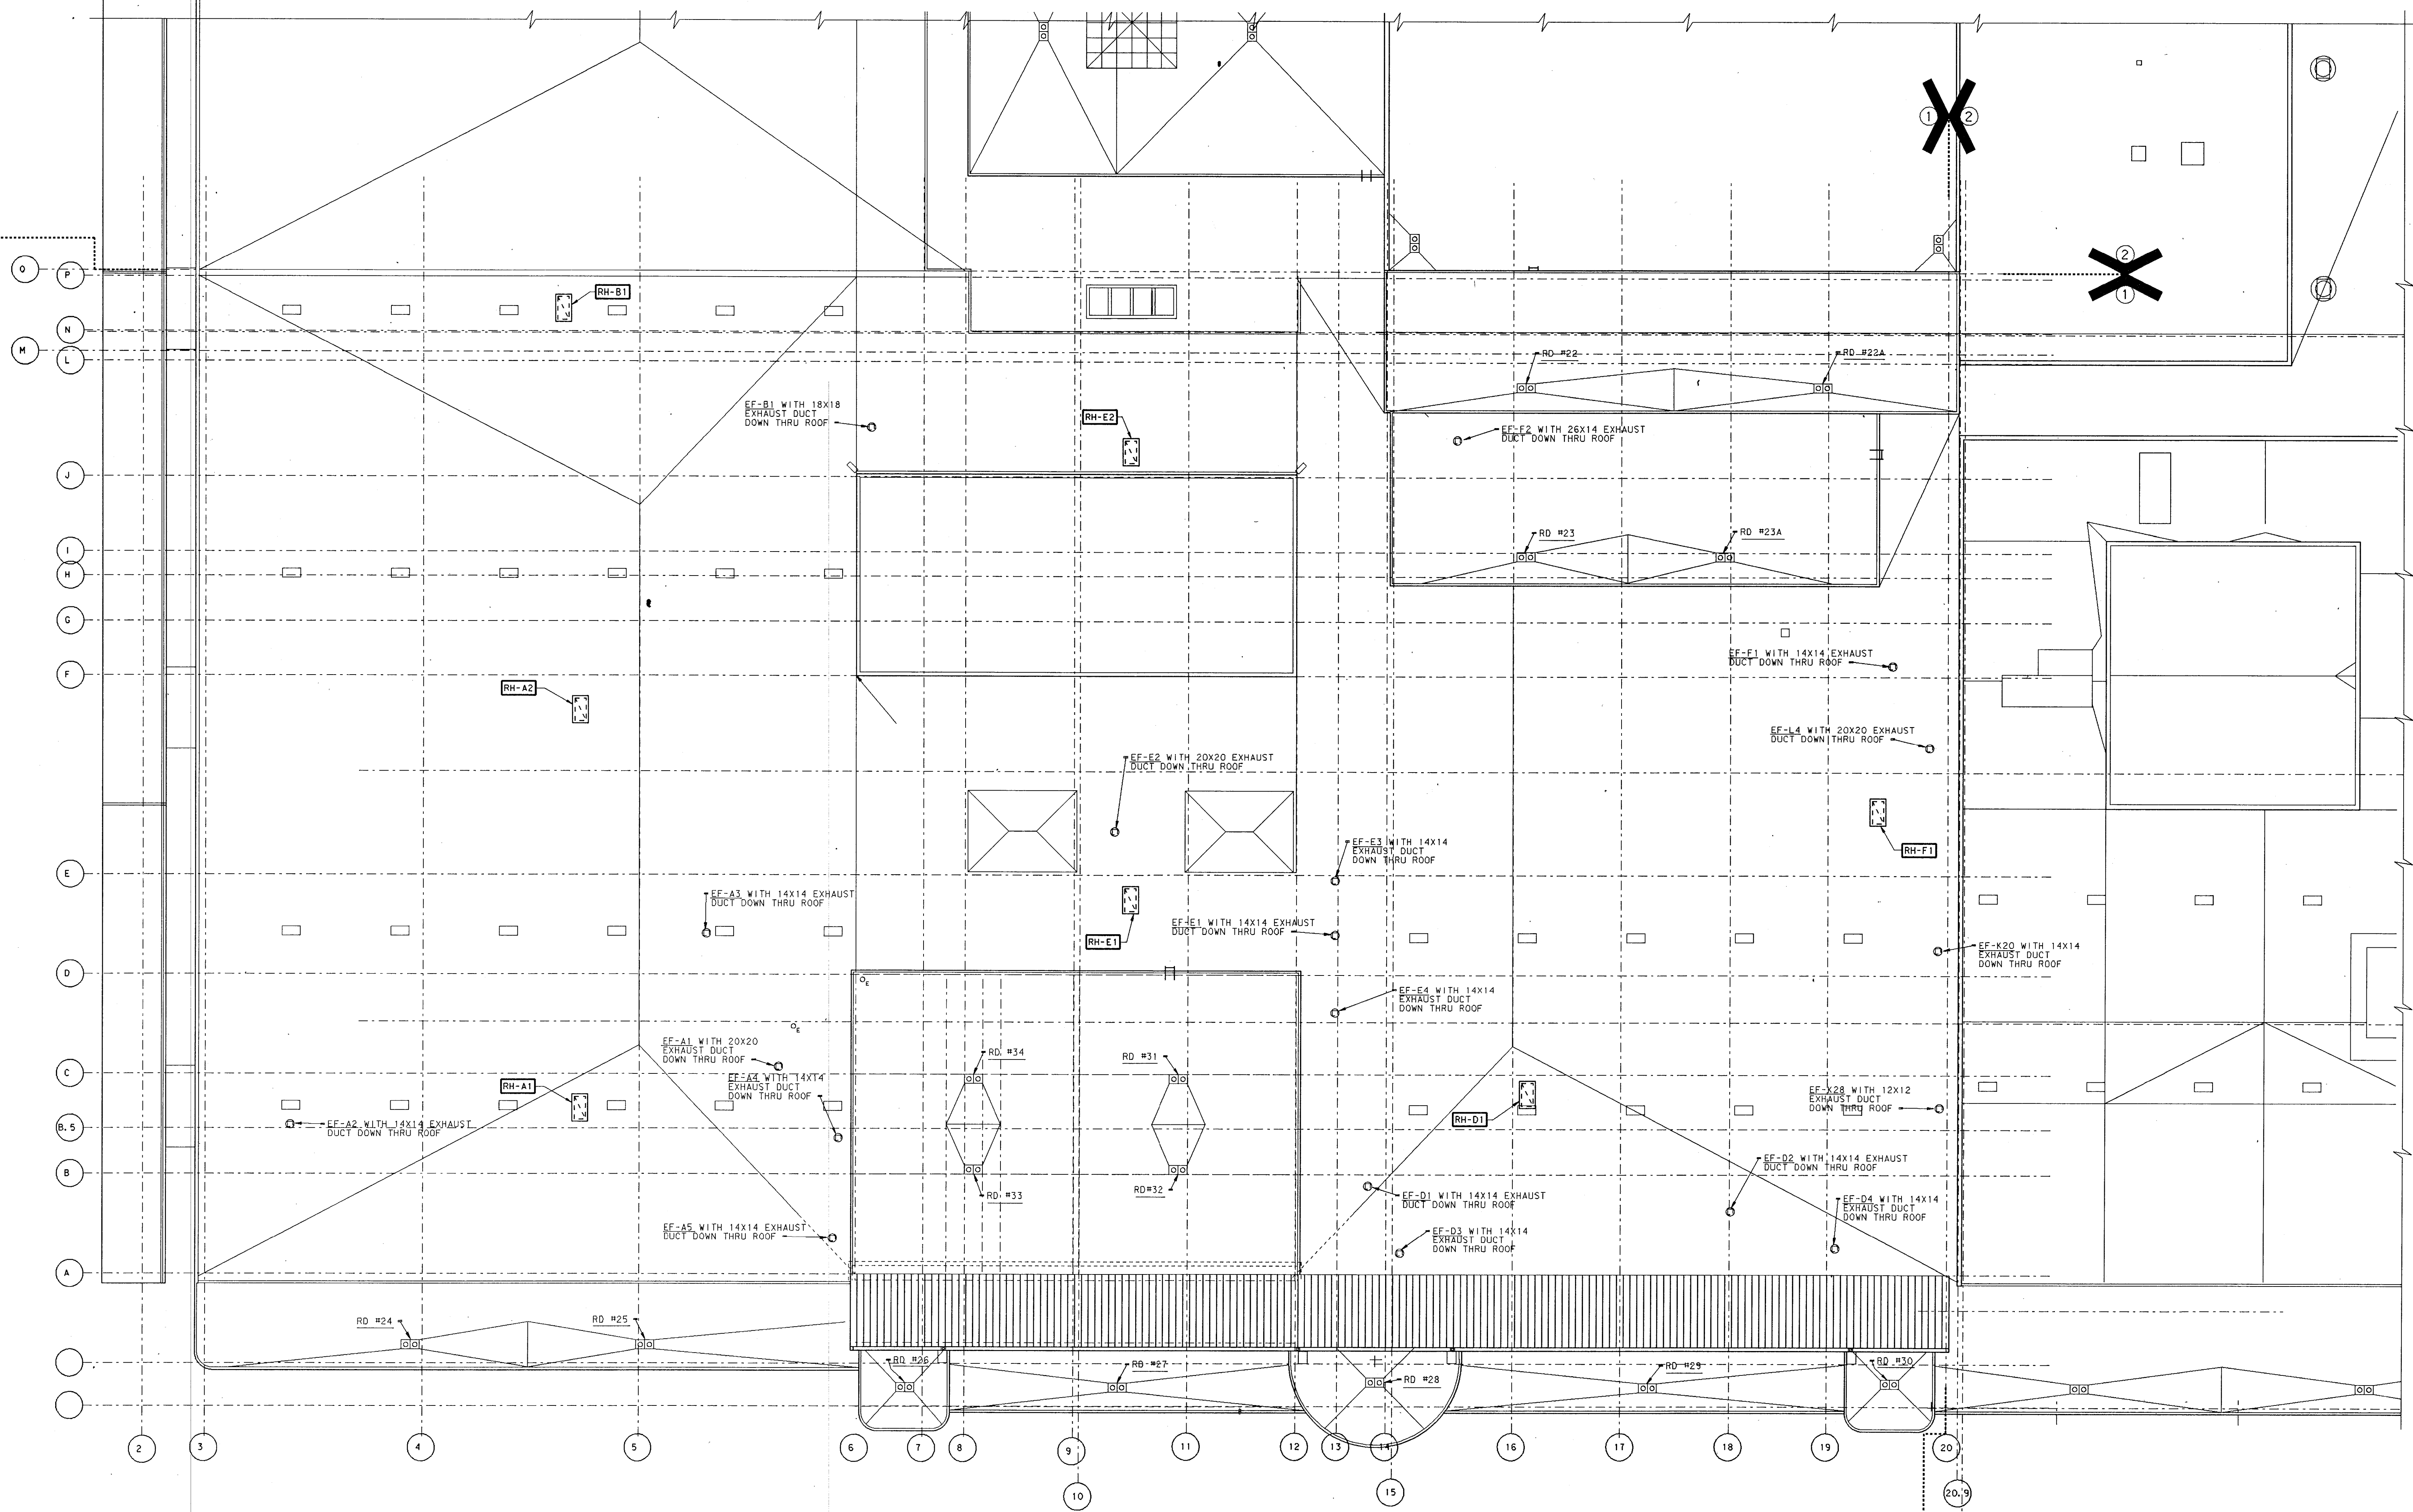


PLAN NOTES:
① SEE SHEETS M0-1 THRU M0-5 FOR GENERAL NOTES, LEGEND, AND SCHEDULES.

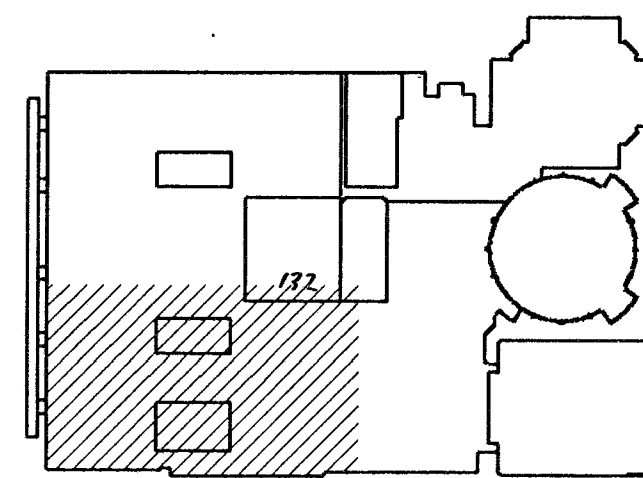

MECHANICAL PARTIAL ROOF PLAN # 1

SCALE: 1/16" = 1'-0"

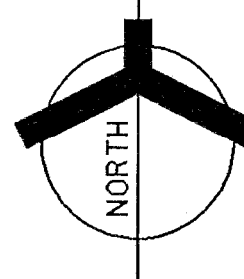

KEY PLAN
NO SCALE

ADDITION TO and RENOVATION OF
LAWRENCE CENTRAL HIGH SCHOOL
for the METROPOLITAN SCHOOL DISTRICT of LAWRENCE TOWNSHIP
MARION COUNTY, INDIANA


EVERETT L. BROWN Company
Architects & Engineers
950 NORTH MERIDIAN STREET
INDIANAPOLIS, INDIANA 46204
(317) 537-7000





PROJECT
871-110
DATE
DEC. 18, 1989
REVISED

NO. M2-1
OF 4

PLAN NOTES:
① SEE SHEETS M0-1 THRU M0-5 FOR GENERAL NOTES, LEGEND, AND SCHEDULES.

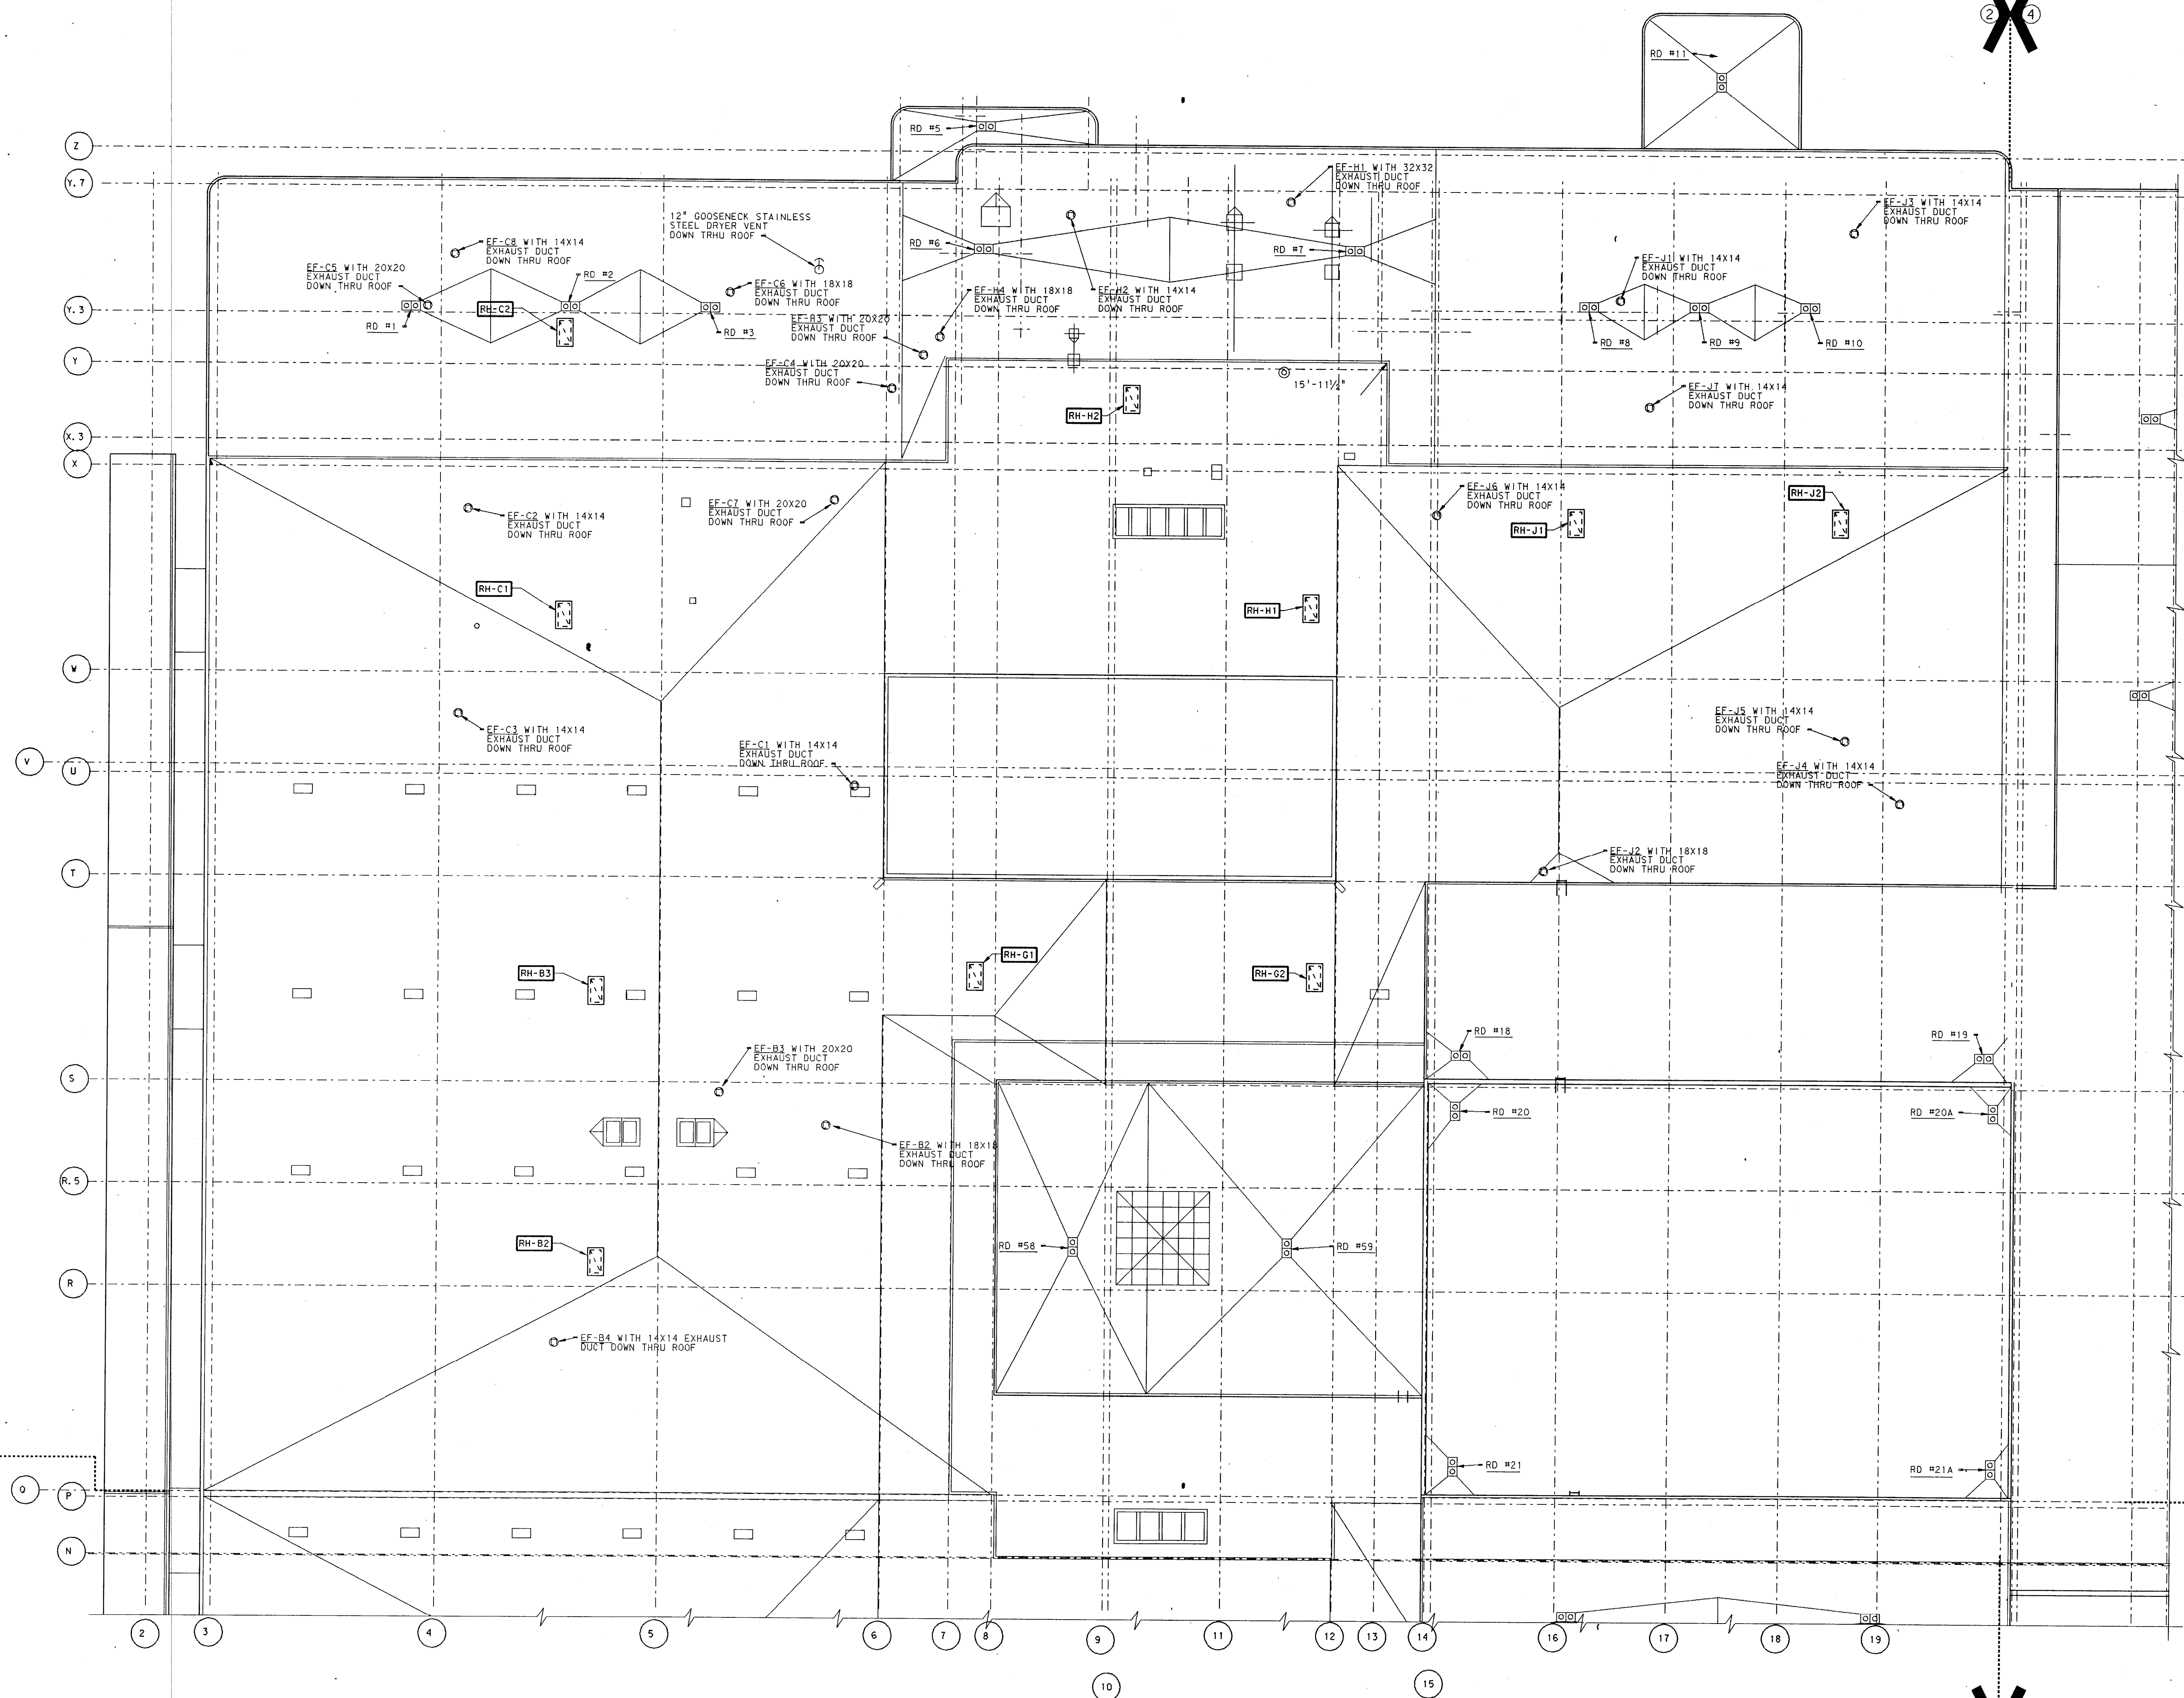

MECHANICAL PARTIAL ROOF PLAN #2
SCALE: 1/16" = 1'-0"

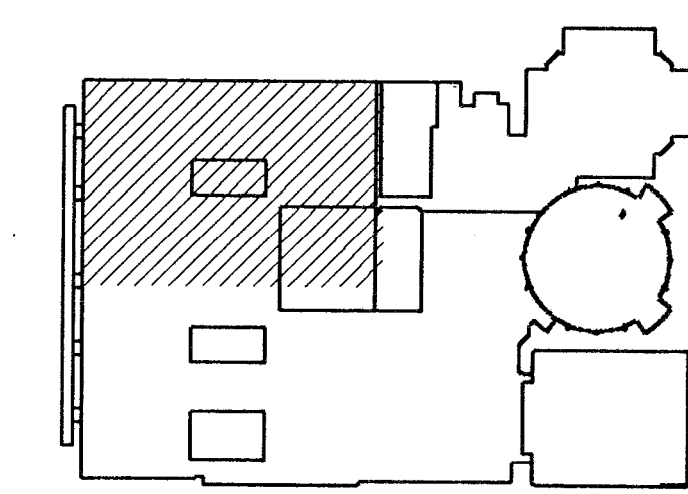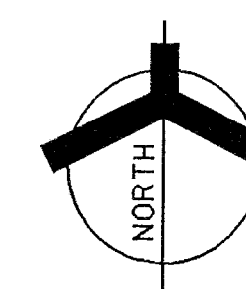


KEY PLAN
NOT TO SCALE

ADDITION TO AND RENOVATION OF
LAWRENCE CENTRAL HIGH SCHOOL
for the METROPOLITAN SCHOOL DISTRICT of LAWRENCE TOWNSHIP
MARION COUNTY, INDIANA

EVERETT I. BROWN Company
Architects & Engineers
950 NORTH MERIDIAN STREET
INDIANAPOLIS, INDIANA 46204
(317) 237-7000



PROJECT
871-110
DATE
DEC. 18, 1989
REVISED

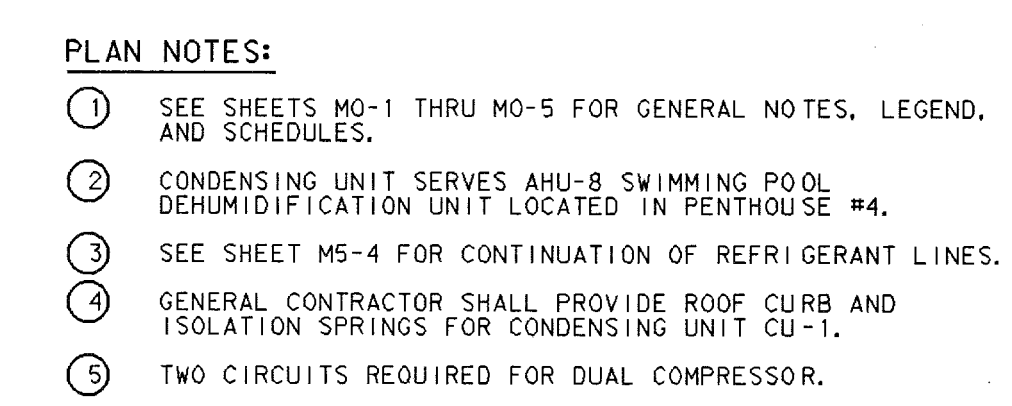

VERETTI, BROWN
Company
Architects & Engineers
950 NORTH MERIDIAN STREET
INDIANAPOLIS, INDIANA 46204
(317) 237-1000

PROJECT
871-110



DATE
DEC. 18, 1989

NO. M2-3
OF 4



Ref.	Title	LOGNO	SHEET	Log. name	LOGNO
Ref. Title	LOGNO	LOGNO	LOGNO	LOGNO	LOGNO
Level	1, 10, 11, 41				
Ref. Title	LOGNO	LOGNO	LOGNO	LOGNO	LOGNO
Level	10, 11, 21, 31, 41				
Ref. Title	LOGNO	LOGNO	LOGNO	LOGNO	LOGNO
Level	10, 11, 21, 31, 41				

ROOF DRAIN SCHEDULE				
ROOF DRAIN NUMBER	SIZE	J. R. SMITH	JOSAM	WADE
RD #2, 5, 9, 11, 14, 15, 16, 16A,	4"	1010	2150	3500
17, 22, 22A, 23, 23A, 24, 25, 26,				
27, 28, 29, 30, 31, 32, 33, 34, 35,				
36, 37, 38, 39, 40, 41, 42, 54				
RD #1, 3, 6, 7, 8, 10, 12, 13, 18,	6"	1010	2150	3500
19, 20, 20A, 21, 21A, 43, 43A, 44,				
45, 46, 47, 48, 49, 50, 51, 52, 56,				
57				
OVERFLOW DRAINS	----	1080	----	----

- ROOF PLAN NOTES
- ALL VENTS NOT OTHERWISE NOTED ARE 3" PLUMBING VENTS.
 - PROVIDE DECK CLAMPS FOR ALL ROOF DRAINS INSTALLED IN METAL DECK, PRECAST CONCRETE, OR SIMILAR ROOF CONSTRUCTION.
 - NO ROOF DRAIN SHALL BE SET WITHOUT PRIOR CONSULTATION WITH THE ARCHITECT'S FIELD REPRESENTATIVE. IN GENERAL, ALL ROOF DRAINS SHALL BE SET ON THE STRUCTURAL DECK AND NOT ON THE ROOF INSULATION.
 - ALL WORK SHOWN ON THIS SHEET IS BY MECHANICAL TRADES UNLESS OTHERWISE NOTED.

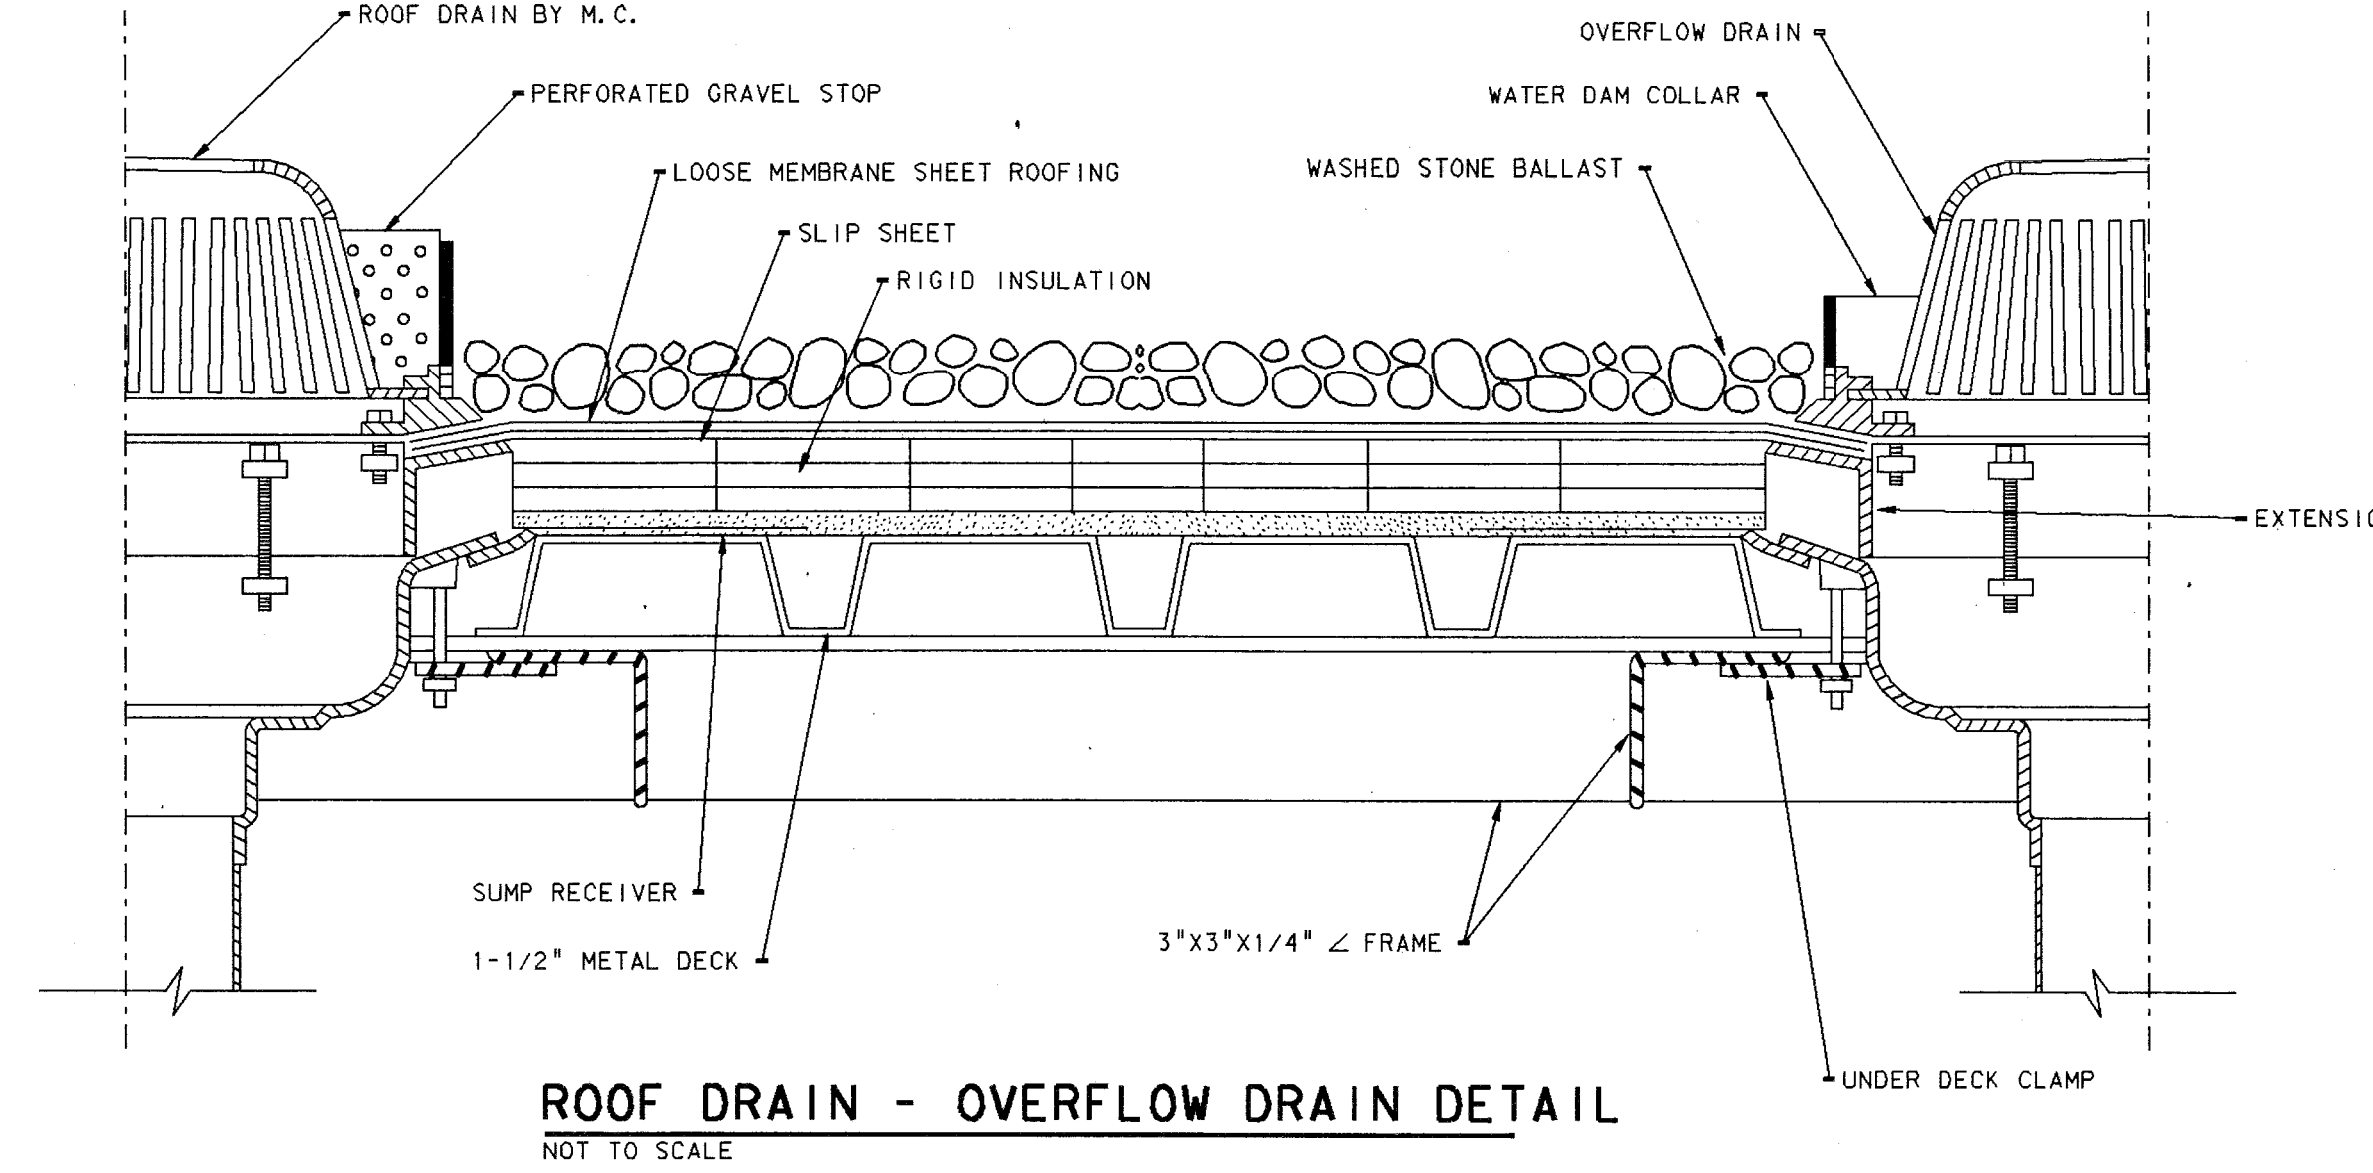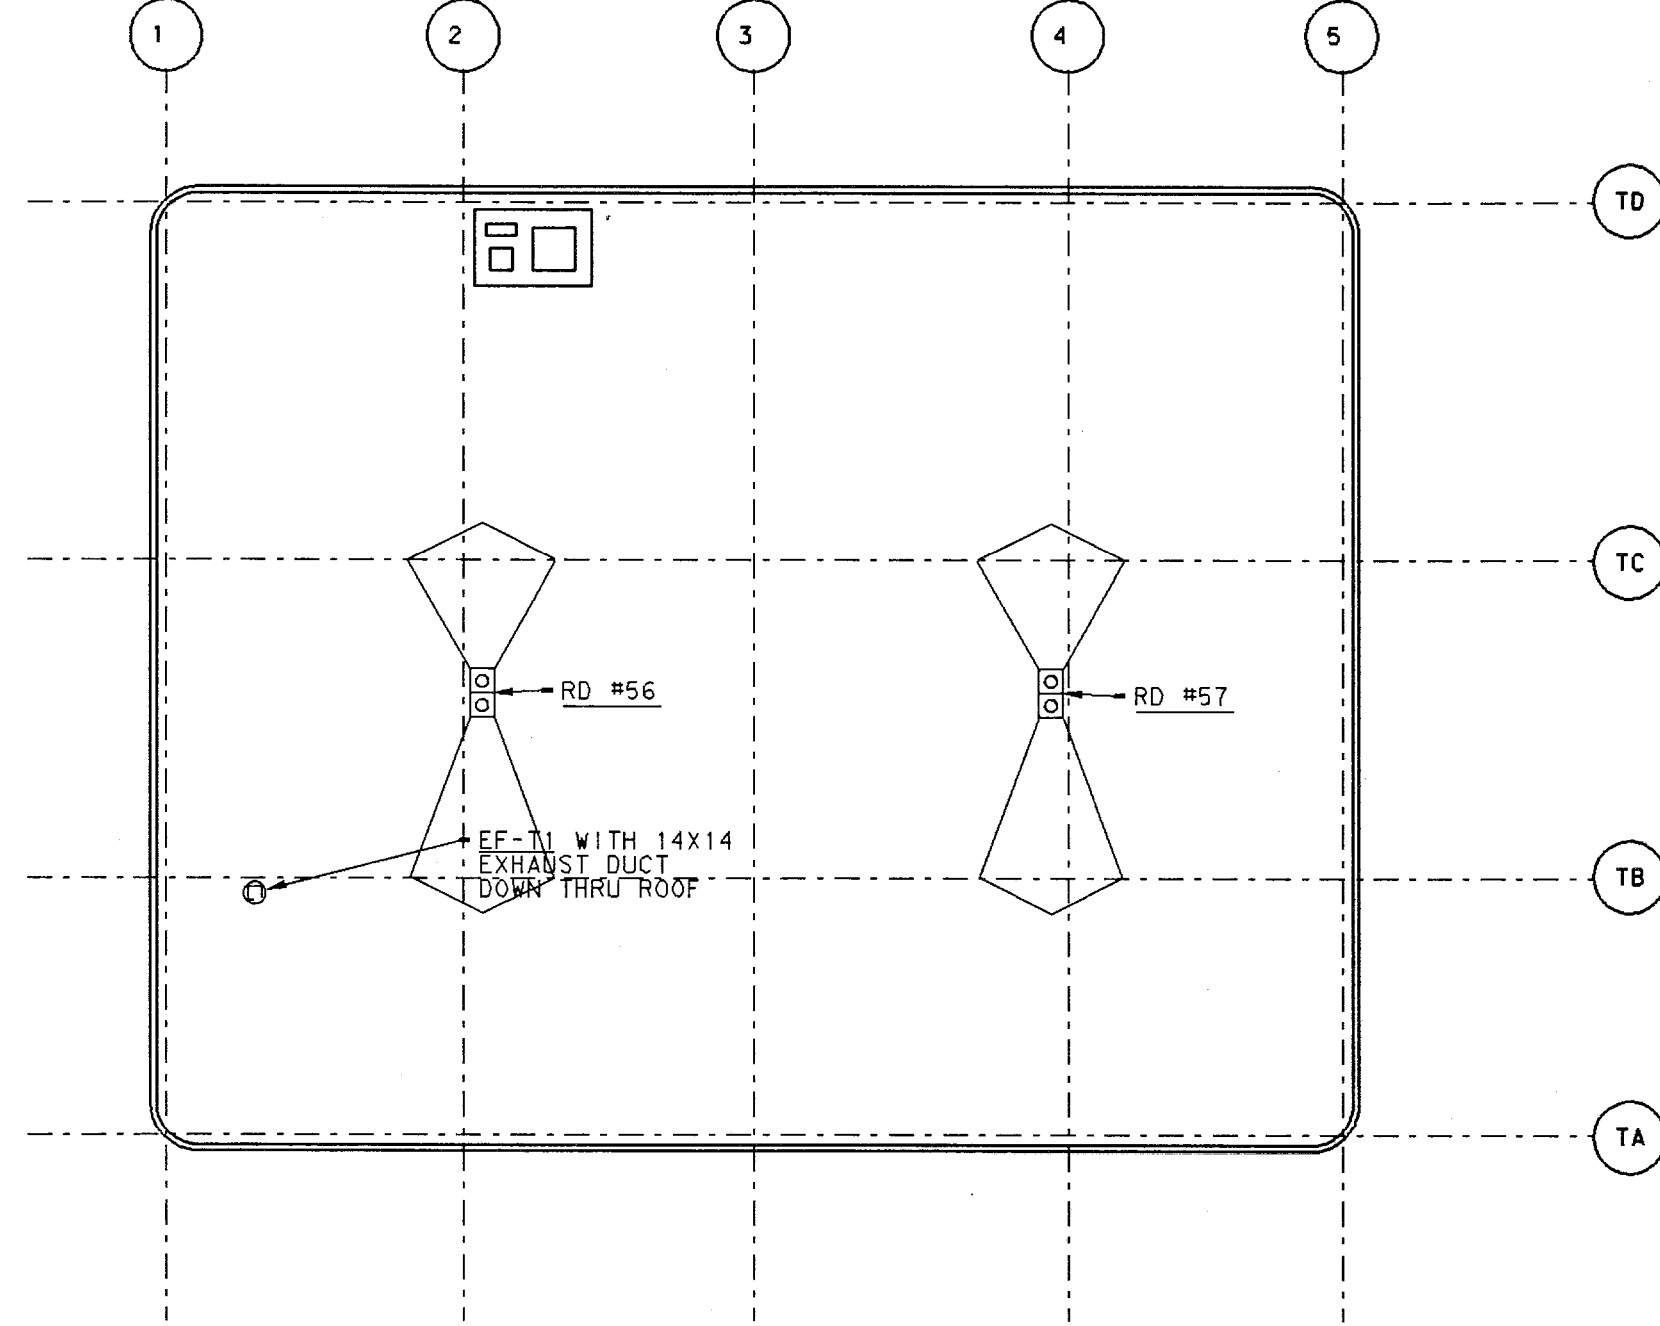

- PLAN NOTES:
- SEE SHEETS MO-1 THRU MO-5 FOR GENERAL NOTES, LEGEND AND SCHEDULES.

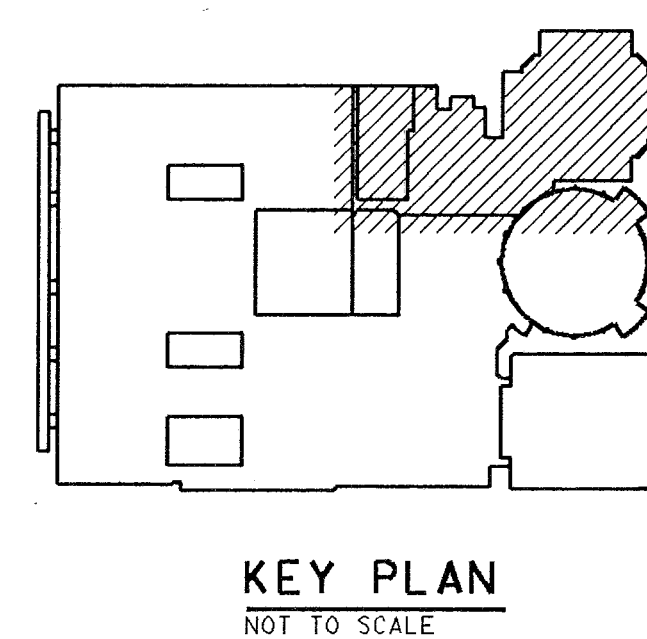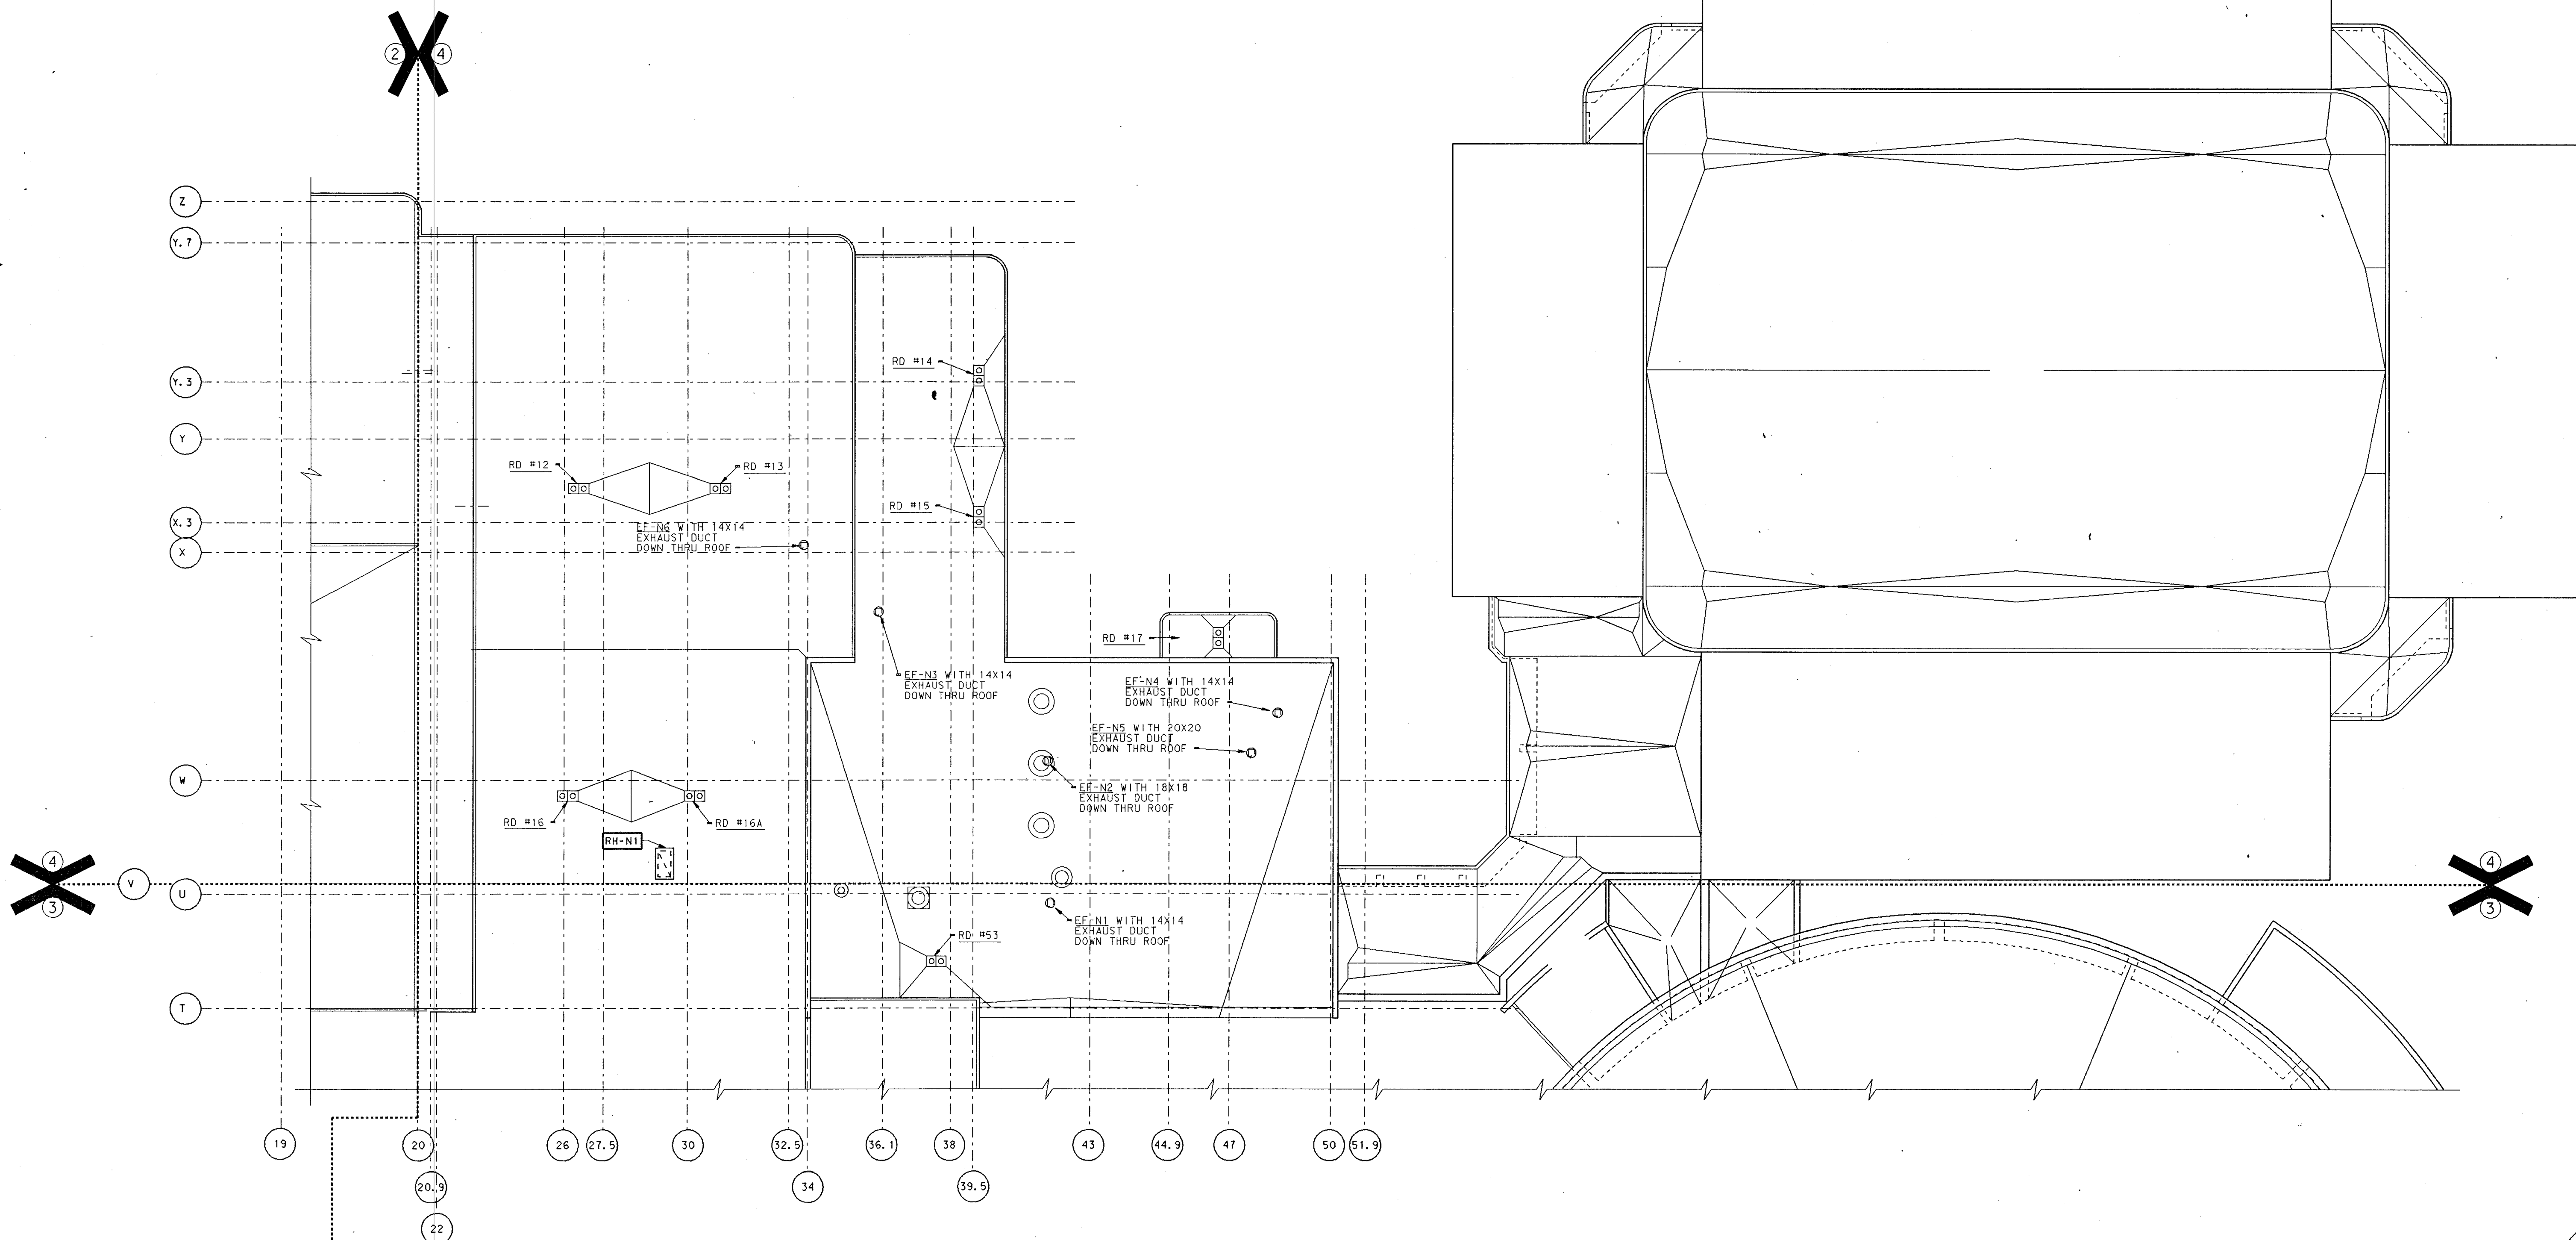

ADDITION TO and RENOVATION OF
LAWRENCE CENTRAL HIGH SCHOOL
for the METROPOLITAN SCHOOL DISTRICT OF LAWRENCE TOWNSHIP
MARION COUNTY, INDIANA

VERETT L. BROWN Company
Architects & Engineers
950 NORTH MERIDIAN STREET
INDIANAPOLIS, INDIANA 46204
(317) 237-7000



PROJECT
871-110
DATE
DEC. 18, 1989
REVISED