


LAWRENCE CENTRAL HIGH SCHOOL



SECOND FLOOR

FIRST FLOOR

tyco / Fire & Security / **SimplexGrinnell**

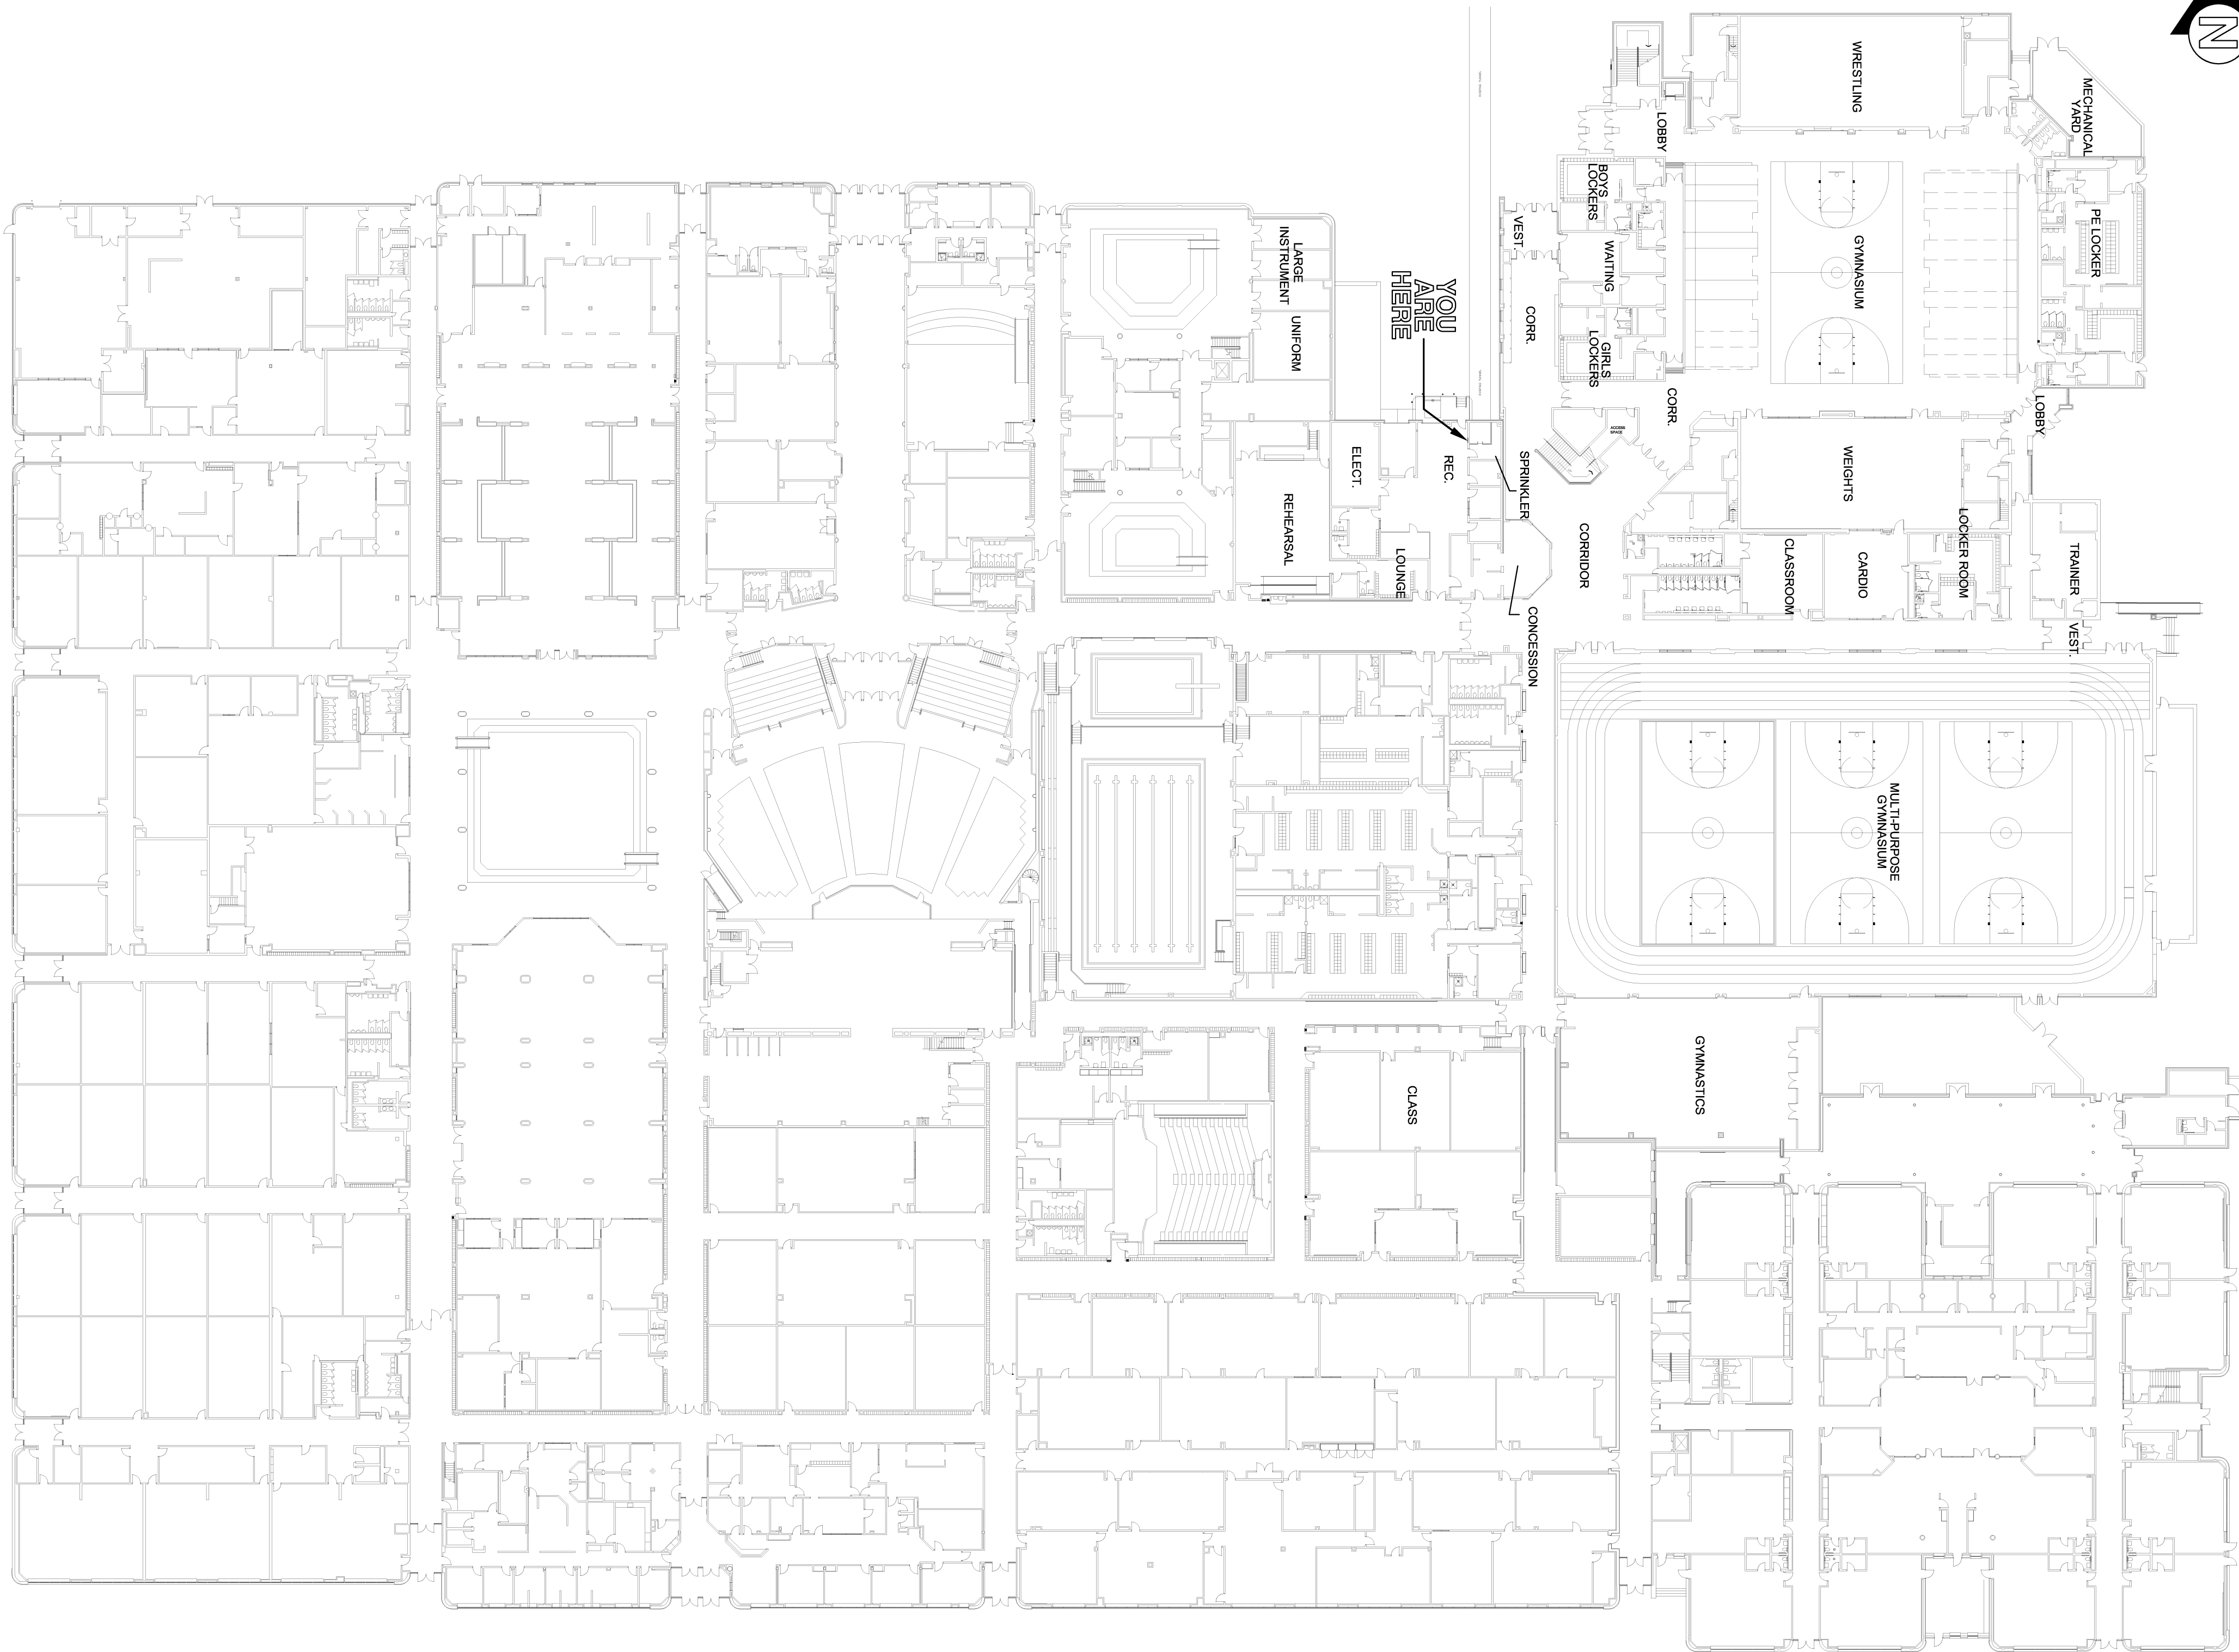

REVISION DESCRIPTION			
ENG	CAD	NO.	DATE

tyco / Fire & Security / **SimplexGrinnell**

11820 PENDLETON PIKE
INDIANAPOLIS, INDIANA 46236
SALES: 317-826-2130
SERVICE: 317-826-2130
FAX: 317-826-2140

©2006 SIMPLEXGRINNELL LP
ALL RIGHTS RESERVED

FIRE ALARM SYSTEM PLAN
GRAPHIC MAP
LAWRENCE CENTRAL HIGH SCHOOL
7300 EAST 56TH STREET
INDIANAPOLIS, IN

DESIGNED BY:	DATE:
DRAWN BY:	DATE:
APPROVED BY:	DATE:
PROJECT NUMBER:	928697603
SHEET TITLE:	LAWRENCE CENTRAL HS-10
SHEET NUMBER:	10