

ADDENDUM NO. 1

July 12, 2021

LOGANPORT FAIRVIEW ELEMENTARY SCHOOL RENOVATIONS **Logansport, IN 46947**

TO: ALL BIDDERS OF RECORD

This Addendum forms a part of and modifies the Bidding Requirements, Contract Forms, Contract Conditions, the Specifications, and the Drawings dated June 18, 2021 by Gibraltar Design. Acknowledge receipt of the Addendum in the space provided on the Bid Form. Failure to do so may subject the Bidder to disqualification.

This Addendum consists of Pages ADD 1-1 through ADD 1-1, and attached Addendum No. 1 from Gibraltar Design dated July 9, 2021, consisting of 5 pages, Specification Section 10 12 00 - Display Cases, and 37 drawing sheets.

A. SPECIFICATION SECTION 00 00 10 - TABLE OF CONTENTS

1. Add:

Specification Section 10 12 00 - Display Cases

B. SPECIFICATION SECTION 01 12 00 - MULTIPLE CONTRACT SUMMARY

1. Paragraph 3.03 Bid Categories

A. BID CATEGORY NO. 1 - GENERAL TRADES

1. Add the following Specification Section:

10 12 00 - Display Cases

ADDENDUM ONE

Addendum One (AD.01) to the drawings and specifications prepared by Gibraltar Design and The Skillman Corporation for **Fairview Elementary School Renovations** for **Logansport Community School Corporation**, Logansport, Indiana.

All Contractors bidding on this project shall read all of the items covered below and shall comply with all of the requirements as set forth, including any necessary refinements or additions generated by this Addendum and required by the intent of the original contract documents. All Contractors shall acknowledge on their bid form that they have received this Addendum, and include the appropriate content of same within their bid proposal.

SPECIFICATIONS

1. Specification Section 08 71 00 Door Hardware

- A. Add door C-235A to hardware set No. 08.
- B. Delete door B-148A from Hardware set No. 08.
- C. Add door B-108A to Hardware set No. 16.
- D. Add door B-294A to hardware set No. 17.
- E. Delete door B-295B from hardware set No. 17.
- F. Delete door B-302A from hardware set No. 19.
- G. Delete doors A-262A and A-269A from hardware set No. 24.
- H. Add doors A-150A, A-262A, A-269A and B-302A to hardware set No. 25.
- I. Delete hardware sets No. 36 and No. 44 in its entirety.
- J. Add hardware sets No. 45 and No. 46 per attache to the Project Manual.

2. Specification Section 10 12 00 Display Cases

- A. Add Specification Section 10 12 00, Display Cases, included in this addendum, to the Project Manual.

DRAWINGS

3. Sheet S-001

- A. Refer to revised full size drawing sheet, included in this addendum, for the following revisions:
 - 1. Remove Detail '2 1/2" Composite Slab' and replace with the "Not Used" tag.
 - 2. Add Detail 1/S-001 for MC1 layout and foundation requirements.

4. Sheet S-104

- A. Refer to revised full size drawing sheet, included in this addendum, for the following revisions:
 - 1. New exterior wall pilaster foundation and footing layout in Unit "A".



5. Sheet S-301

- A. Refer to revised full size drawing sheet, included in this addendum, for the following revisions:

1. Add Detail 19/S-301 for the new opening in existing Rapidex roof System.

6. Sheets AD101, AD102, AD103, AD104, and AD106

- A. Refer to revised full size drawing sheet, included in this addendum, for revisions.

7. Sheets AD105

- A. Add Plan note #2 in Stair EB-298 and Vestibule EB-133.

8. Sheets A-101, A-102, A-104, and A-105

- A. Refer to revised full size drawing sheet, included in this addendum, for revisions.

9. Sheet A-210

- A. Refer to revised full size drawing sheet, included in this addendum, for revisions.

10. Sheets A-401, A-402 and A-403

- A. Refer to revised full size drawing sheet, included in this addendum, for revisions.

11. Sheet A-710

- A. Refer to revised full size drawing sheet, included in this addendum, for revisions.

12. Sheets A-901, A-902, A-903, A-904, A-905 and A-906

- A. Refer to revised full size drawing sheet, included in this addendum, for revisions.

13. Sheet ES101

- A. Change Relay RA-1 noted for the parking lot lights to Relay RA-2.

14. Sheets ED101, ED103, ED104, ED105 and ED106

- A. On Demolition Plan Notes 4, 5 and 6, delete the words "Under Alternate Bid". This work is to be under base bid.

15. Sheet ED102

- A. Demolition Plan Notes. Add Demolition Plan Note 8, which shall read "EXISTING LIGHTING FIXTURE OVER THE SINK AND ASSOCIATED LIGHT SWITCH SHALL REMAIN."
B. In Kindergarten EB128 and EB130, add Demolition Plan Note 8 to the lighting fixture over the sink in this room and associated light switch.
C. Note that the work enclosed within the dashed line is to be bid under an alternate bid.

16. Sheet ED201

- A. Refer to revised full size drawing sheet, included in this addendum, for the following revisions.

1. Modifying Demolition work in Art EA-147 and Classroom EA-148.

17. Sheet ED202

- A. Note that the work enclosed within the dashed line is to be bid under an Alternate Bid.

18. Sheet ED206

- A. In Corridor C-211, delete the demolition Note 6 on the fire alarm system manual pull station, it is to remain.

**19. Sheet E-101**

- A. Refer to revised full size drawing sheet, included in this addendum, for the following revisions.
 - 1. On Plan Notes 4, 5 and 6, delete the words "Under Alternate Bid". This work is to be under base bid.
 - 2. Vestibule A-146
 - a. Replace existing lighting fixture with new Type L-2E lighting fixture.
 - b. Add Plan Notes 1 and 2 to this room.
 - 3. Art A-147. Changing Fixture Types.

20. Sheet E-102

- A. Refer to revised full size drawing sheet, included in this addendum, for the following revisions.
 - 1. Modifying lighting layout in Storage B-129 (Existing To Remain) and Storage B-131.
 - 2. Modifying lighting in renovated locker room areas.
 - 3. Noting that the work enclosed within the dashed line is to be bid under an alternate bid.
 - 4. On Plan Notes 4, 5 and 6, deleting the words "Under Alternate Bid". This work is to be under base bid.

21. Sheet E-103

- A. Refer to revised full size drawing sheet, included in this addendum, for the following revisions.
 - 1. Corridor C-169. Adding lighting fixtures.
 - 2. On Plan Notes 4, 5 and 6, deleting the words "Under Alternate Bid". This work is to be under base bid.

22. Sheet E-104

- A. Refer to revised full size drawing sheet, included in this addendum, for the following revisions.
 - 1. Revised lighting in various areas including the Lobby lighting and Administration area.
 - 2. Adding Canopy lights and Relay.
 - 3. Modifying some Plan Notes.

23. Sheet E-105

- A. Refer to revised full size drawing sheet, included in this addendum, for the following revisions.
 - 1. On Plan Notes 4, 5 and 6, delete the words "Under Alternate Bid". This work is to be under base bid.
 - 2. Stairs B-290 and B-298. Revising lighting in Stairs.

24. Sheet E-106

- A. Refer to revised full size drawing sheet, included in this addendum, for the following revisions.
 - 1. Storage C-234. Adding new lighting fixtures and controls.
 - 2. Toilet C-235. Adding new lighting fixtures and controls.
 - 3. Corridor C-238. Adding additional new lighting fixtures.
 - 4. Adding emergency lights to some of the Classrooms.
 - 5. On Plan Notes 4, 5 and 6, deleting the words "Under Alternate Bid". This work is to be under base bid.

25. Sheet E-201

- A. Refer to revised full size drawing sheet, included in this addendum, for the following revisions.
 - 1. Modifications to the electrical work in Girls A-151, Boys A-152 and Art A-147.

26. Sheet E-202

- A. Refer to revised full size drawing sheet, included in this addendum, for the following revisions.
 - 1. Modifying electrical connections to some of the mechanical equipment.
 - 2. Modifying electrical work in the renovated locker room areas.
 - 3. Note that the work enclosed within the dashed line is to be bid under an alternate bid.

27. Sheet E-204

- A. Refer to revised full size drawing sheet, included in this addendum, for the following revisions.
 - 1. Adding fire alarm system area smoke detectors.
 - 2. Modifying electrical work.

28. Sheet E-206

- A. Refer to revised full size drawing sheet, included in this addendum, for the following revisions.
 - 1. Office C-202, Office C-203, Corridor C-204, Calm C-206 and Speech C-207, adding power receptacles and fire alarm area smoke detectors,
 - 2. Storage C-234, adding power receptacles and fire alarm system area smoke detector.
 - 3. Toilet C-235, adding receptacle and fire alarm system strobe.

29. Sheet E-601

- A. Refer to revised full size drawing sheet, included in this addendum, for the following revisions.
 - 1. Modifying panel schedules, fixture schedule and relay schedule.



30. Sheets E-701 and E-702

- A. Refer to revised full size drawing sheet, included in this addendum, for the following revisions.
 - 1. Revising Existing Power Distribution Diagrams.

Pages 1 through 5, inclusive, Specification Section 10 12 00 and Thirty-Seven (37) full-size Drawings constitutes the total makeup of **Addendum One**.



GIBRALTAR
DESIGN

Y:\20-157 Logansport CSC - Fairview ES Renovations\Specs\AD01.doc

SECTION 10 12 00

DISPLAY CASES

1 General

1.1 Section Includes

- A. Display cases, including factory assembled display case units.
- B. Custom display cases, including factory assembled glass framed door assemblies.

1.2 Related Sections

- A. Section 06 10 00 – Rough Carpentry: For wood blocking and supports.
- B. Section 06 20 00 – Finish Carpentry: For finished wood, and cork for display cases.
- C. Section 08 81 00 – Glazing: For glass shelving.
- D. Section 26 06 20 – Electrical Wiring Systems.

1.3 References

- A. AA - Designation System for Aluminum Finishes.

1.4 Submittals

- A. Submit shop drawings under provisions of Division 1.
 - 1. Indicate locations, dimensions, and details.
 - 2. Include construction details, material descriptions, dimensions of individual components and profiles, and finishes for each type of display case or glass enclosed corkboard indicated.
- B. Submit product data under provisions of Division 1.

1.5 Quality Assurance

- A. Source Limitations: Obtain products through one source from a single manufacturer.

1.6 Delivery, Storage, And Handling

- A. Deliver, store, and protect products under provisions of Division 1.

1.7 Project Conditions

- A. Field Measurements: Verify dimensions by field measurements before fabrication and indicate measurements on Shop Drawings. Coordinate fabrication schedule with construction progress to avoid delaying the Work.

2 Products

2.1 Display Cases and Glass Enclosed Corkboards - Acceptable Manufacturers

- A. Poblocki and Sons, Milwaukee, Wisconsin.
- B. Polyvision Corp., Dixonville, Pennsylvania.
- C. Newline Products, Inc., Plano, Texas.
- D. Basis-of-Design Products:
 - 1. Display Cases: Provide glass framed door assemblies or complete display case assemblies with glass framed doors as indicated on Drawings.
 - a. Heavy Duty Sliding Doors: Poblocki Display Case Series, Model L or I; Polyvision Corp., NA or HDC Series.

2.2 Materials

- A. Aluminum: 6063-T5 aluminum alloy.
- B. Glass: Provide 1/4 inch thick clear laminated safety glass for all doors.
- C. Adhesive: As recommended by manufacturer for substrate conditions indicated.
- D. Finish: AA-C22A31, clear anodized.

2.3 Components

- A. Corkboard: As specified in Section 06 20 00 – Finish Carpentry.
- B. Hardwood Veneer Plywood: As specified in Section 06 20 00 – Finish Carpentry.
- C. Hardwood Veneer Plywood: Manufacturer's standard, 3/4 inch thick.
- D. Glass Shelves: As specified in Section 08 81 00 - Glazing.
- E. Lock: Provide tumbler type lock for each case.
 - 1. Provide two keys for each lock.
 - 2. Key alike for the each building.
- F. Edge Strips: Provide aluminum edge strips for vertical edge of each sliding glass door.

G. Adjustable Shelf Standards and Brackets: Manufactured by Knappe & Vogt.

1. Standards: KV; No. 87.
2. Brackets: KV; No. 187.
3. Rests: Manufacturer's standard type for glass shelving.
4. Finish: Anochrome.

2.4 Fabrication

A. Display Case Frames:

1. Fabricate with hairline miters.
2. Brace by means of internal aluminum angles.
3. Allow no visible welds.
4. Conceal all fasteners when doors are closed.
5. Provide continuous backup member behind door.
6. Provide venting to prevent condensation.
7. Factory glaze all doors.

B. Sliding Doors:

1. Construct doors to eliminate racking and binding.
 - a. Do not use glazing to keep door square and in line.
2. Provide continuous sliding track for door assemblies.

C. Provide complete factory fabricated display cases where indicated.

3 Execution


3.1 Inspection

- A. Verify that surfaces are ready to receive work.
- B. Beginning of installation means acceptance of existing surfaces.

3.2 Installation


- A. Install in accordance with manufacturer's instructions.

END OF SECTION

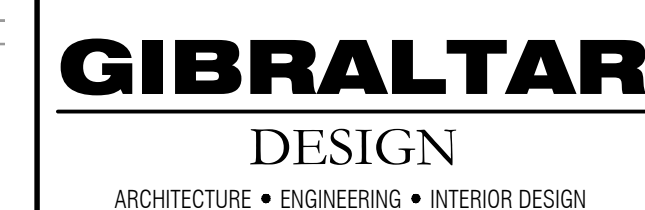

PROJECT
**FAIRVIEW
ELEMENTARY
SCHOOL
RENOVATIONS**

LOGANSPORT COMMUNITY
SCHOOL CORPORATION
LOGANSPORT, INDIANA

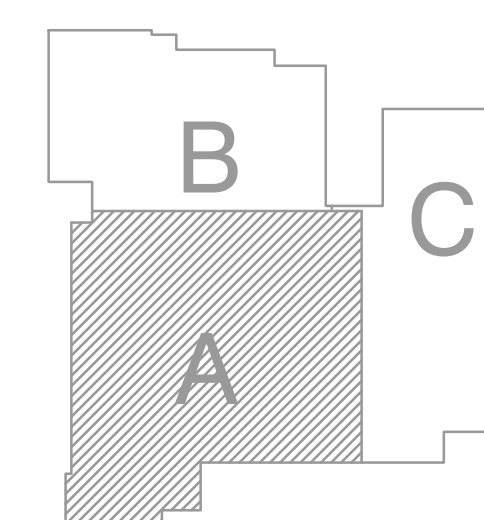

GIBRALTAR DESIGN

9102 N. Meridian St., Ste. 300
Indianapolis, IN 46260
Homepage www.GibraltarDesign.com
Email info@GibraltarDesign.com
Phone 317.580.5777 Fax 317.580.5778

PROJECT 20-157 DATE 06/18/21 COORDINATED BY RM DRAWN BY RM CHECKED BY D.IW	
---	---


COPYRIGHT NOTICE:
THE CONCEPTS, DESIGNS, PLANS, DETAILS, ETC., SHOWN ON THIS DOCUMENT ARE THE PROPERTY OF GIBRALTAR DESIGN AND WERE CREATED FOR USE ON THIS SPECIFIC PROJECT. NONE OF THIS INFORMATION SHALL BE USED BY ANY PERSON OR FIRM FOR ANY PURPOSE WITHOUT THE EXPRESS WRITTEN CONSENT OF GIBRALTAR DESIGN. THE OWNER MAY RETAIN COPIES FOR INFORMATION AND REFERENCE IN CONNECTION ONLY WITH THIS PROJECT.

[illegible]


DRAWING
UNIT "A" PARTIAL FRAMING
AND FOUNDATION PLAN

PROJECT
FAIRVIEW ELEMENTARY SCHOOL
RENOVATIONS

© GIBRALTAR DESIGN
SHEET
S-104

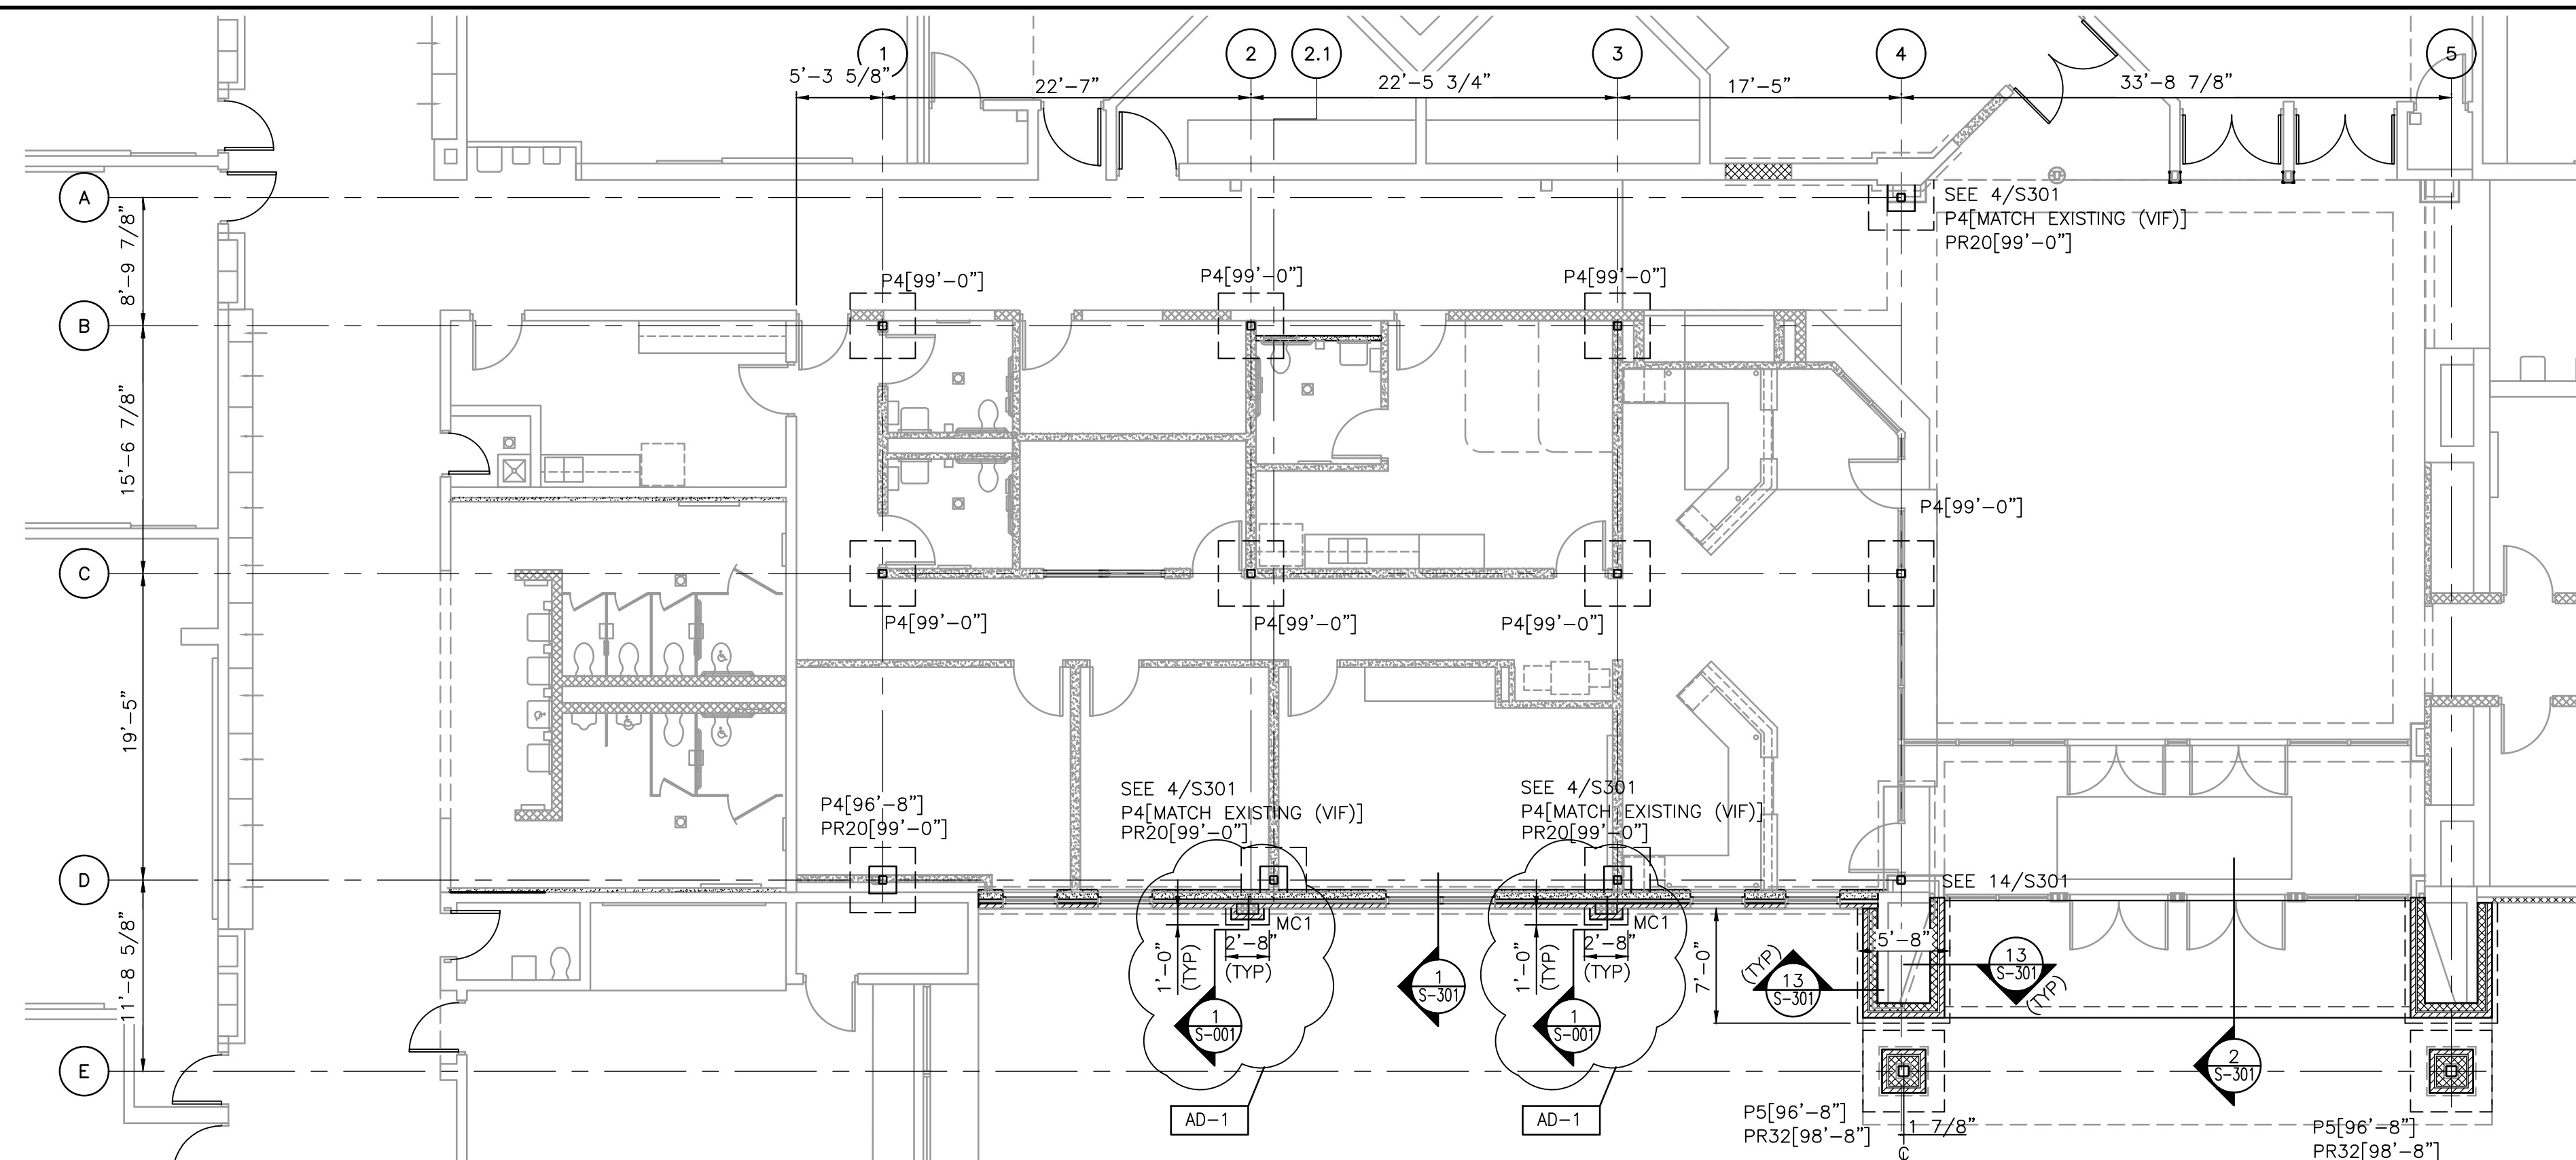


PARTIAL FOUNDATION PLAN - UNIT "A"
SCALE: 1/8" = 1'-0"

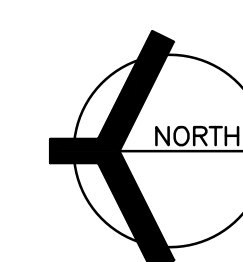


FOUNDATION/SLAB PLAN NOTES

1. SEE SHEET S-001 FOR GENERAL NOTES, STRUCTURAL LEGEND, SCHEDULES AND TYPICAL DETAILS.
2. ALL ELEVATIONS ARE REFERENCED FROM A FINISH FLOOR ELEVATION OF 0'-0" PER AREA. SEE PLAN AND VERIFY WITH ARCHITECTURAL FLOOR PLANS
3. SLAB CONTROL AND CONSTRUCTION JOINTS ARE TO BE LAID OUT PER CONTRACTOR PLANNED SEQUENCE OF COMPLETION. (SEE SPECIFICATION)
4. SEE S-301 FOR FOUNDATION AND FRAMING DETAILS.
5. TOP OF INTERIOR FOOTING IS TYPICALLY 1'-0" BELOW FINISH FLOOR ELEVATION UNLESS OTHERWISE NOTED. (SEE PLAN)

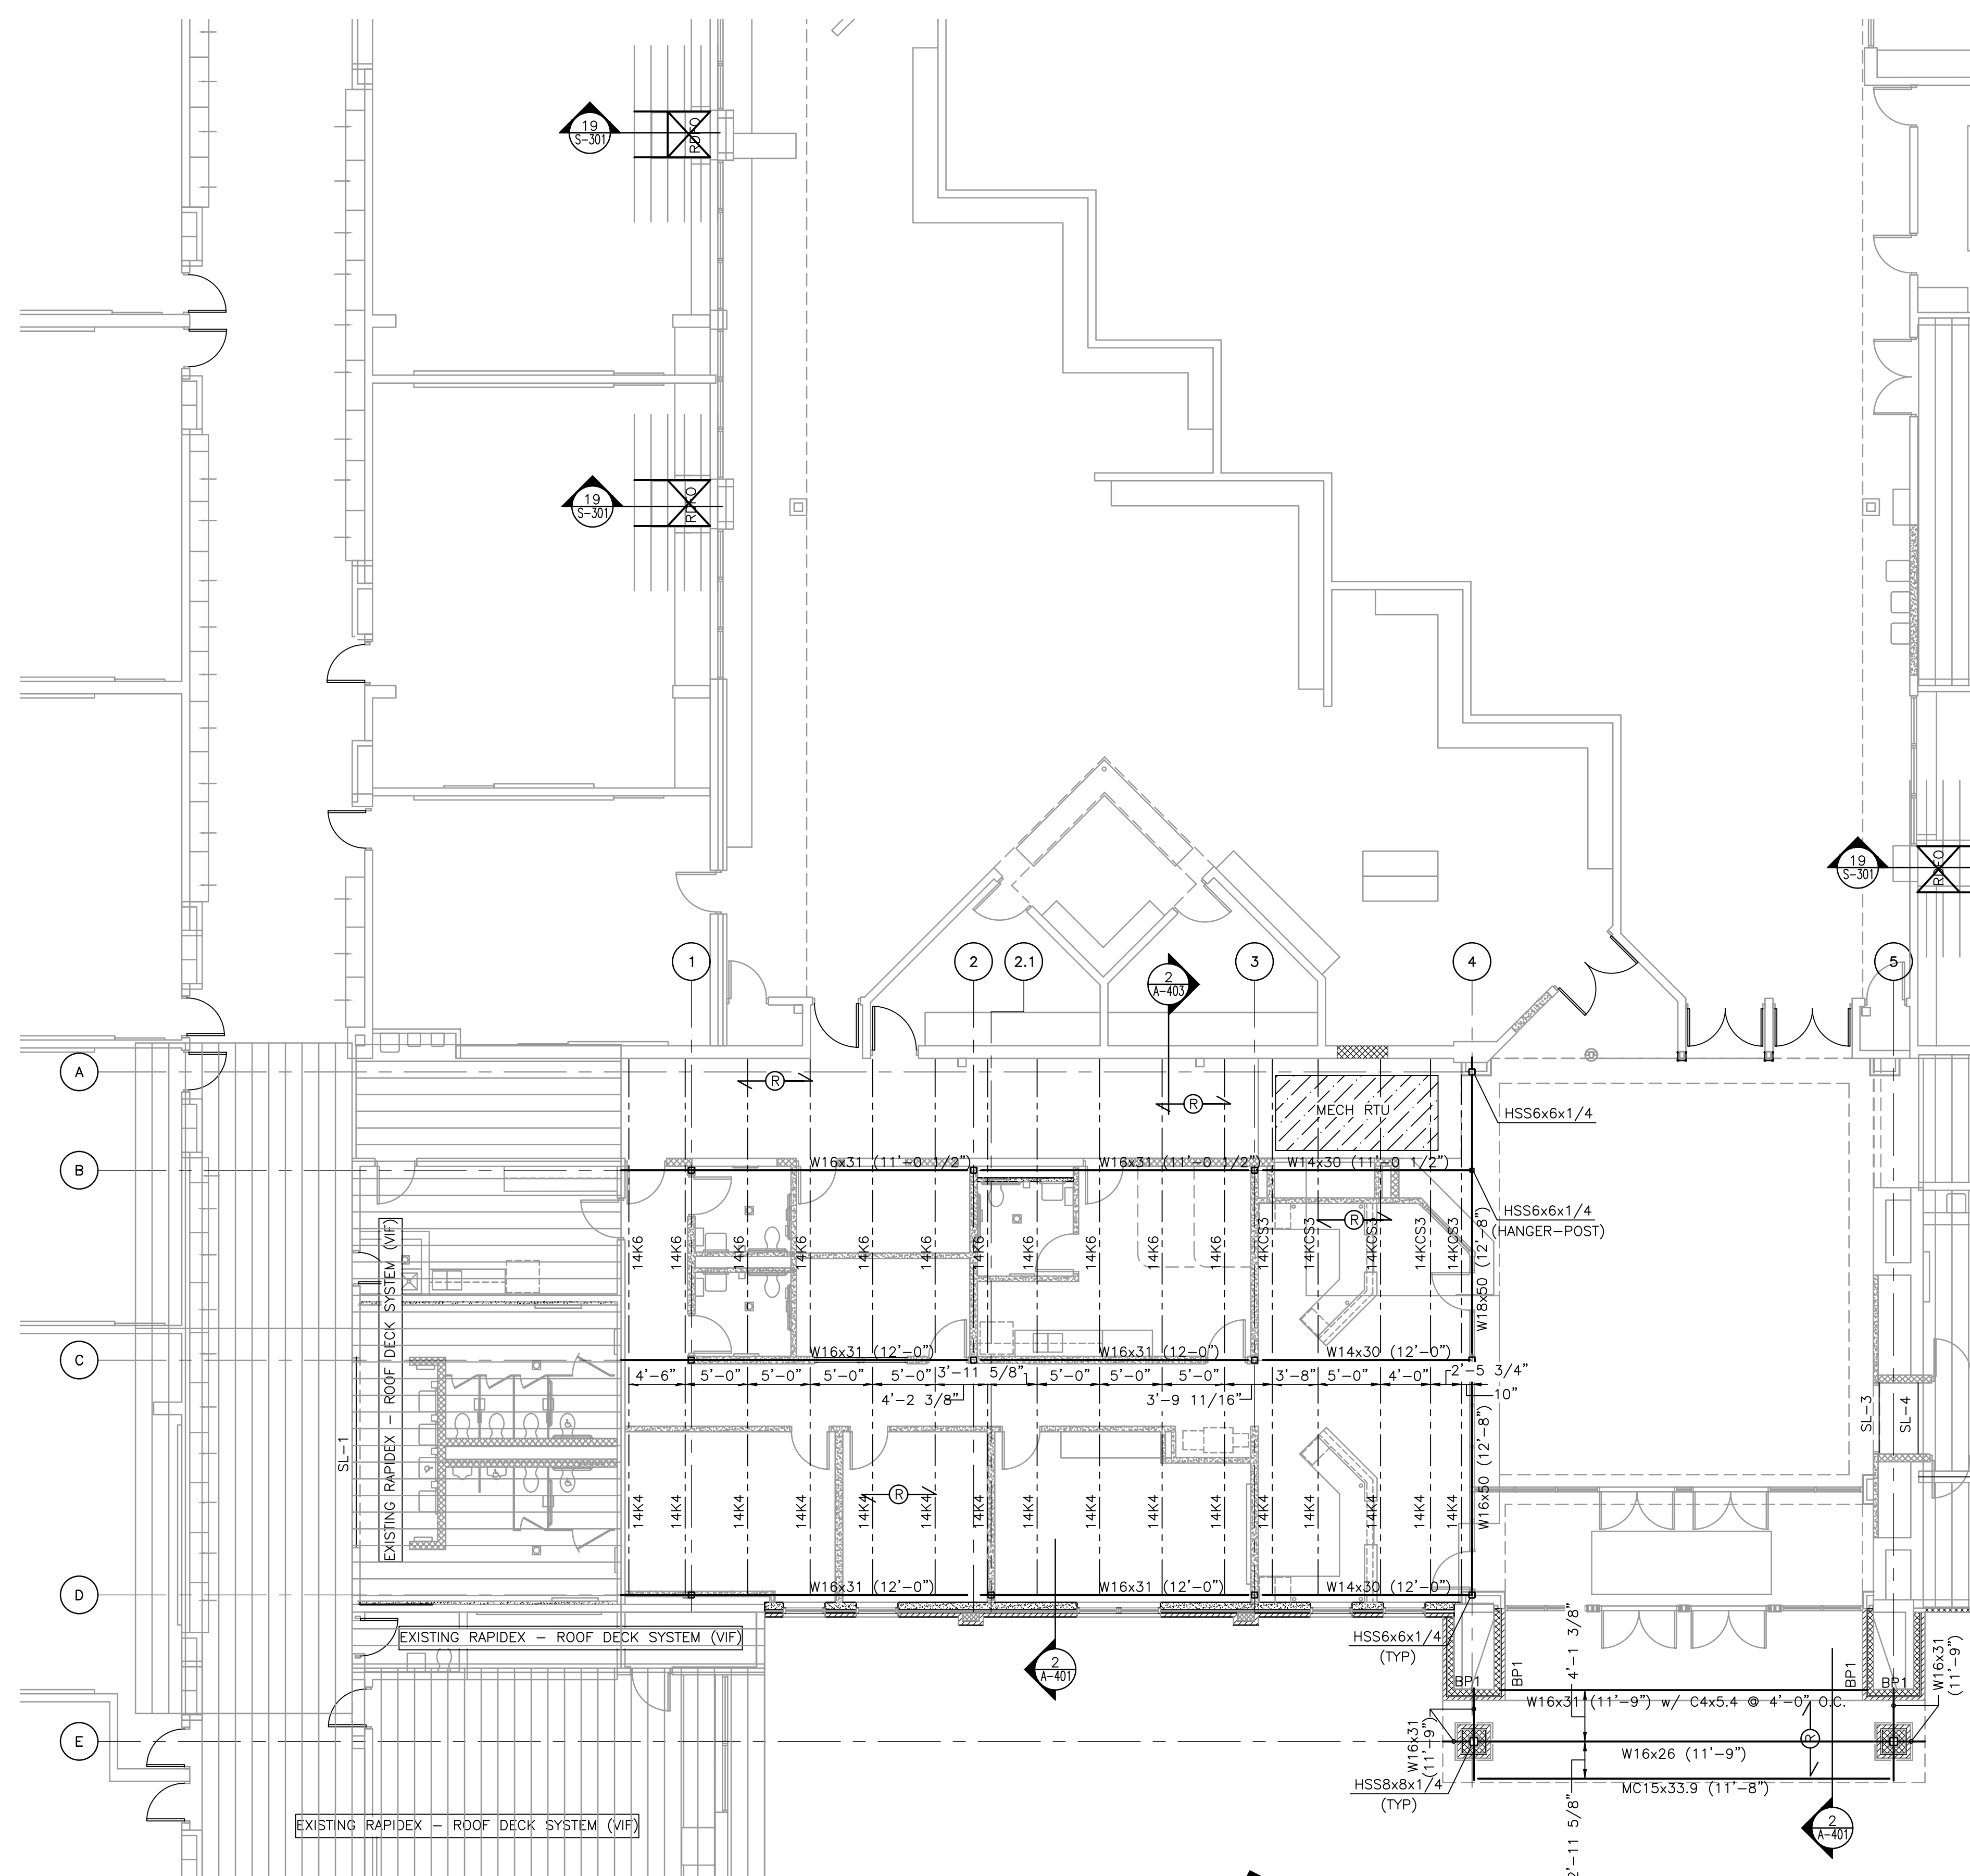


PARTIAL ROOF FRAMING PLAN - UNIT "A"
SCALE: 1/8" = 1'-0"

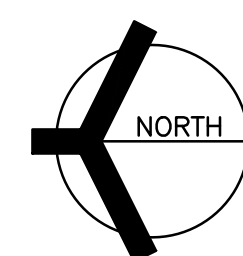

FRAMING PLAN NOTES

1. SEE DRAWING S-001 FOR GENERAL NOTES, STRUCTURAL LEGEND, SCHEDULES AND TYPICAL DETAILS.
2. ALL ELEVATIONS ARE REFERENCED FROM A FINISH FLOOR ELEVATION OF 0'-0" PER AREA. SEE PLAN AND VERIFY WITH ARCHITECTURAL FLOOR PLANS
3. "TEMPORARY BRACING NEEDED UNTIL ROOF METAL DECK DIAPHRAGM INSTALLED."

Thursday, 7/8/2021 - 11:48 AM - LAST SAVED BY:RMALONE
 Y:\20-157 LOGANSPORT CSC - FAIRVIEW ES
 RENOVATIONS\20-157 DRAWINGS\04 STRC\S-104.DWG

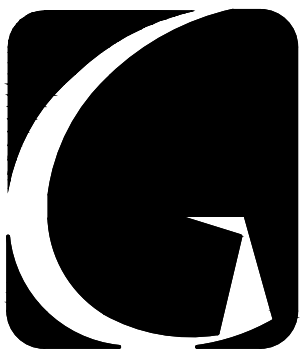

GIBRALTAR
DESIGN
ARCHITECTURE • ENGINEERING • INTERIOR DESIGN

PROJECT
**FAIRVIEW
ELEMENTARY
SCHOOL
RENOVATIONS**

LOGANSPOUT COMMUNITY
SCHOOL CORPORATION
LOGANSPOUT, INDIANA

GIBRALTAR DESIGN

9102 N. Meridian St., Ste. 300
Indianapolis, IN 46260
Homepage: www.GibraltarDesign.com
Email: info@GibraltarDesign.com
Phone: 317.580.5777 Fax: 317.580.5778

PROJECT
20-157
DATE
06/18/21
COORDINATED BY
RM
DRAWN BY
LA
CHECKED BY
RM

COPYRIGHT NOTICE:
THE CONCEPTS, DESIGNS, PLANS, DETAILS, ETC., SHOWN ON THIS DOCUMENT ARE THE PROPERTY OF GIBRALTAR DESIGN AND ARE NOT TO BE REPRODUCED OR TRANSMITTED IN ANY FORM OR BY ANY MEANS, ELECTRONIC OR MECHANICAL, INCLUDING PHOTOCOPYING, RECORDING, OR BY ANY INFORMATION STORAGE AND RETRIEVAL SYSTEM, WITHOUT THE EXPRESS WRITTEN PERMISSION OF GIBRALTAR DESIGN. THE OWNER MAY RETAIN COPIES FOR INFORMATION AND REFERENCE IN CONNECTION ONLY WITH THIS PROJECT.


REVISIONS
MARK DATE ISSUED FOR
AD-1 07/08/21 ADDENDUM NO. 1

DRAWING
**STRUCTURAL SECTIONS
DETAILS**



PROJECT
**FAIRVIEW ELEMENTARY SCHOOL
RENOVATIONS**

© GIBRALTAR DESIGN SHEET


S-301

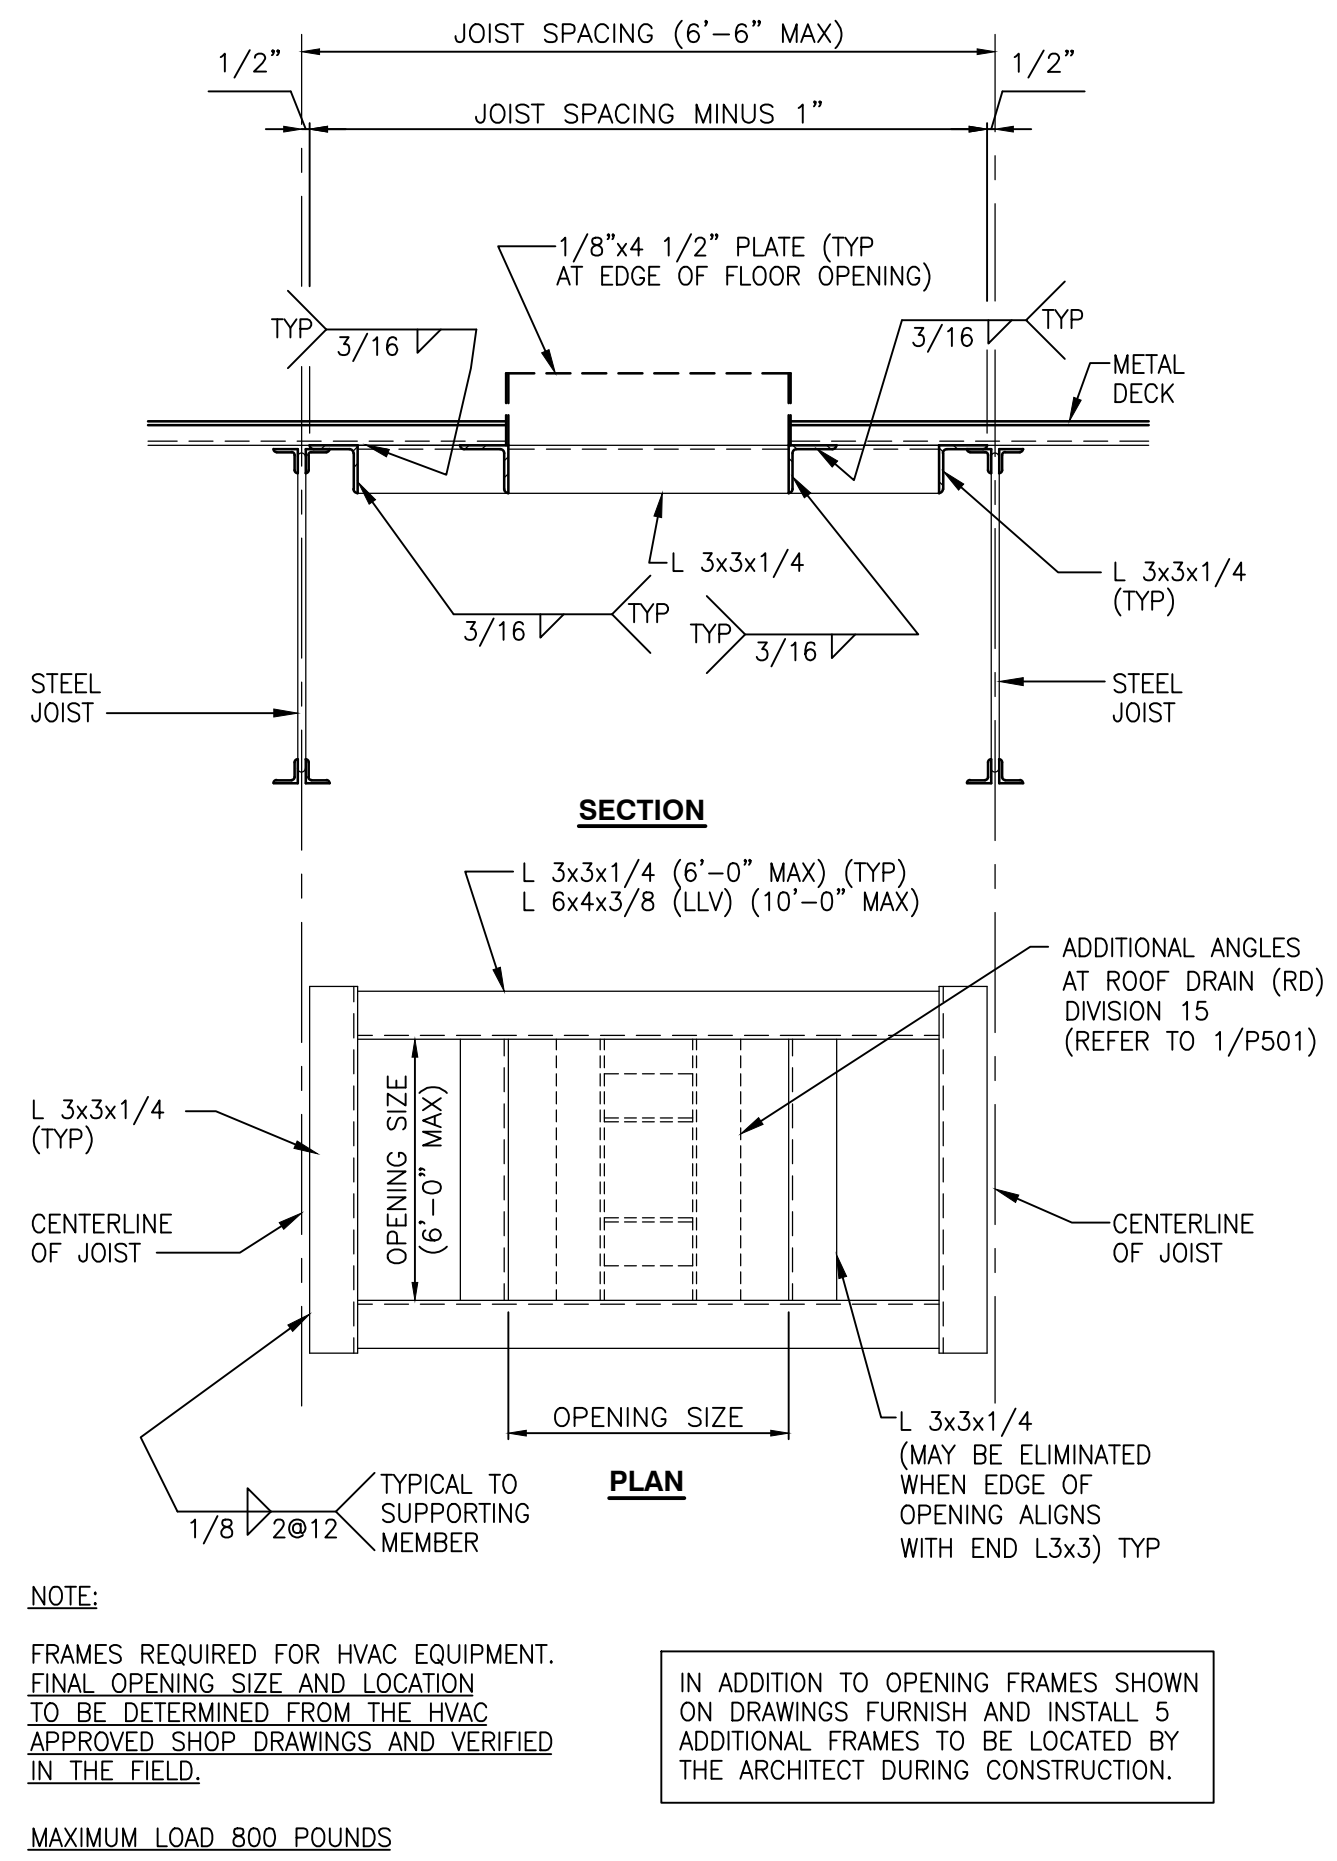


TYPICAL OPENING FRAME (RD) (RO) (RV) (RH) (FO)
SCALE: 1" = 1'-0"

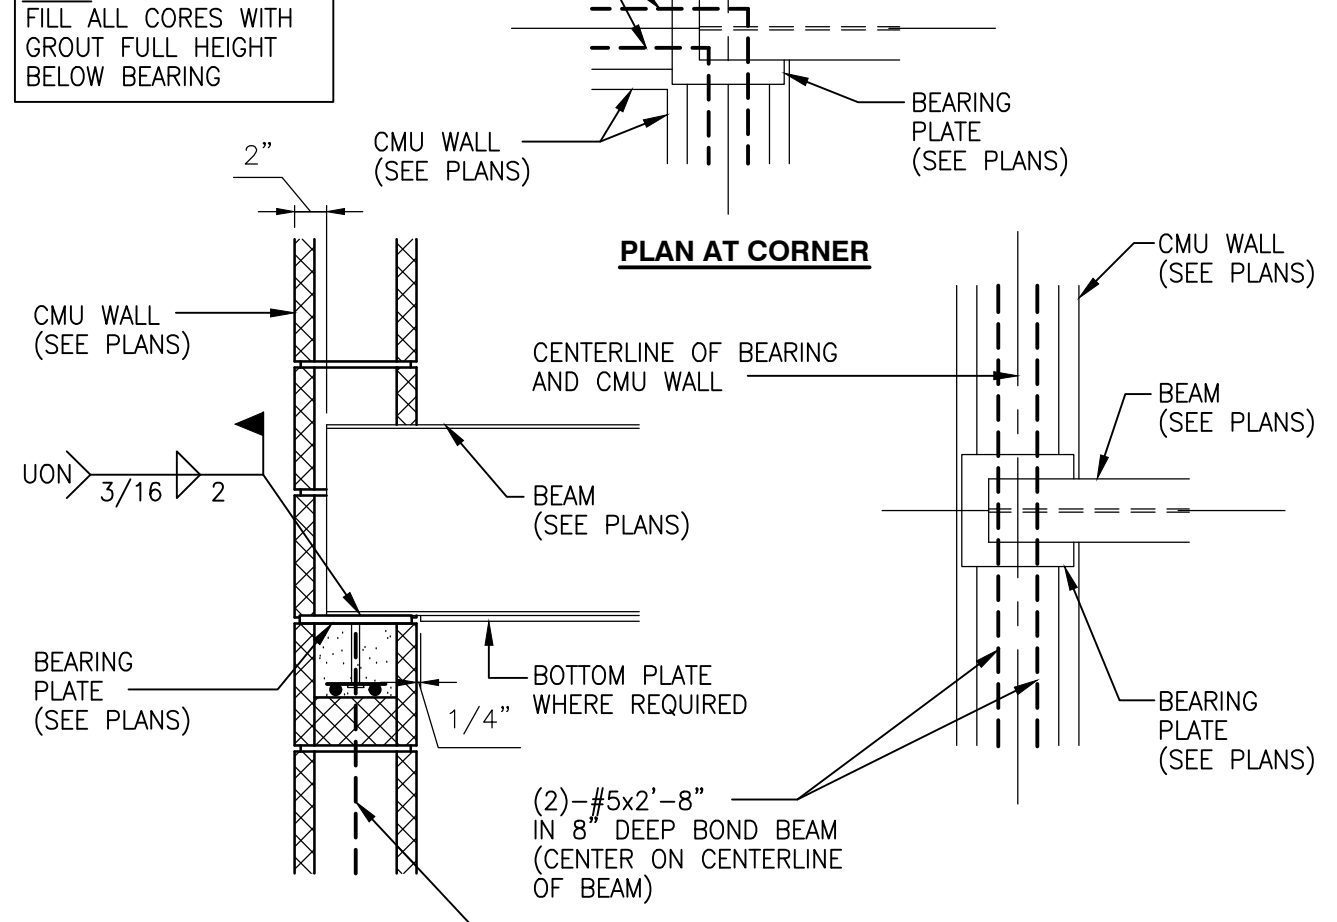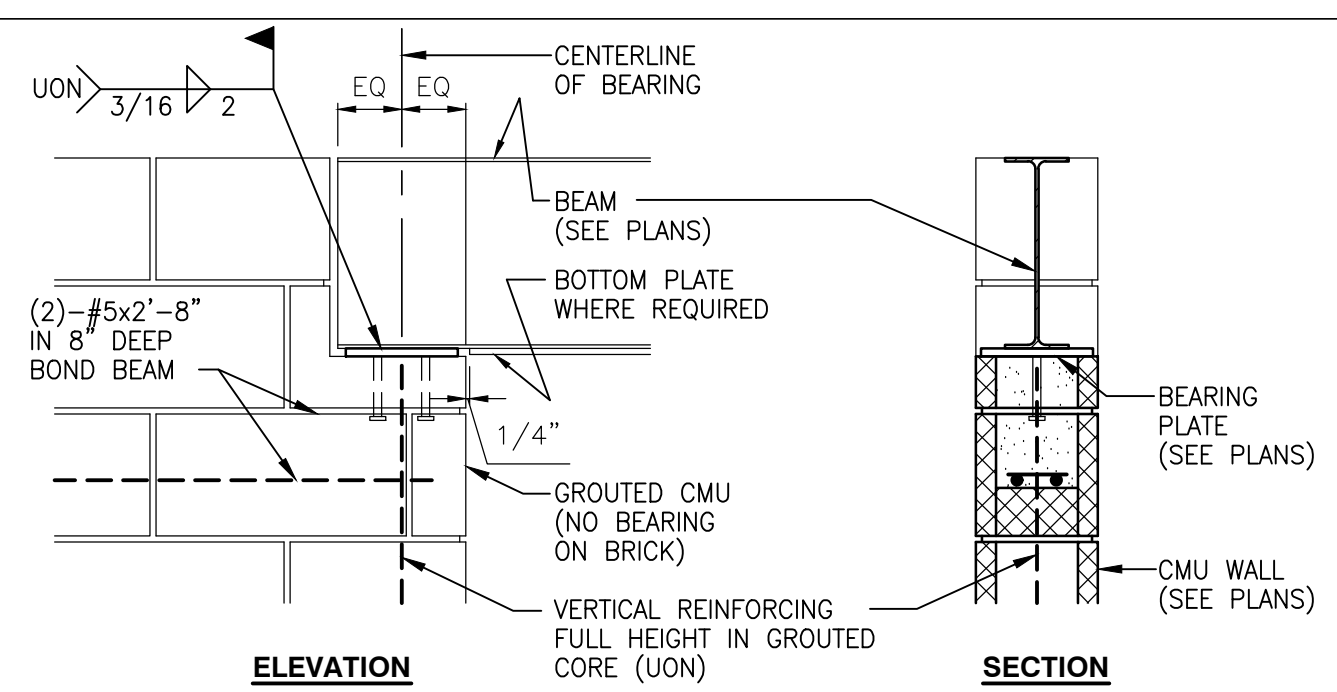


TYPICAL ROOF EDGE SECTION
SCALE: 1" = 1'-0"

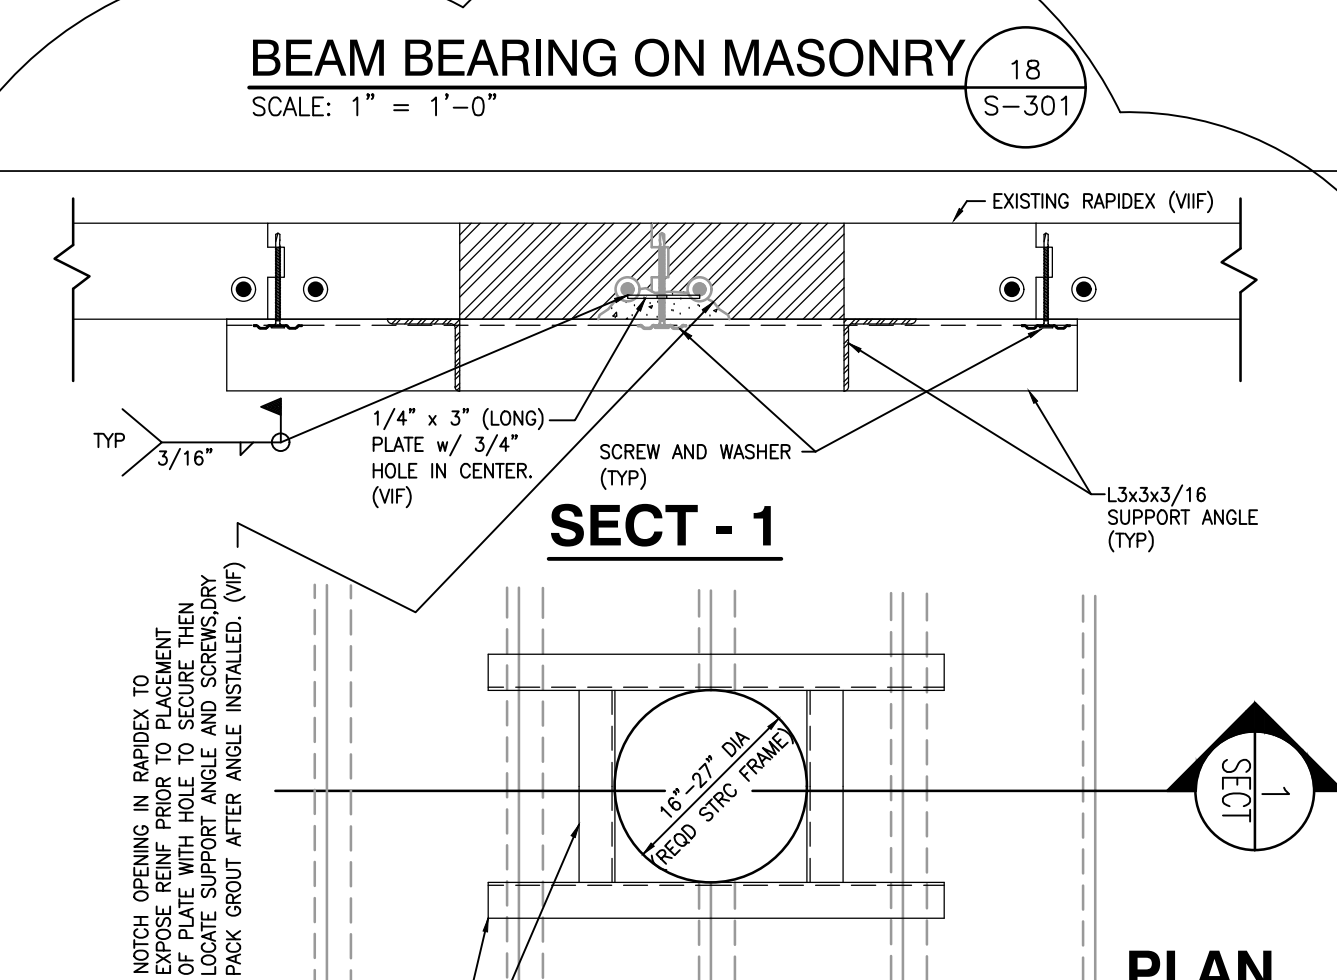


NEW OPENING IN EXISTING RAPIDEX ROOF SYSTEM
SCALE: 1" = 1'-0"

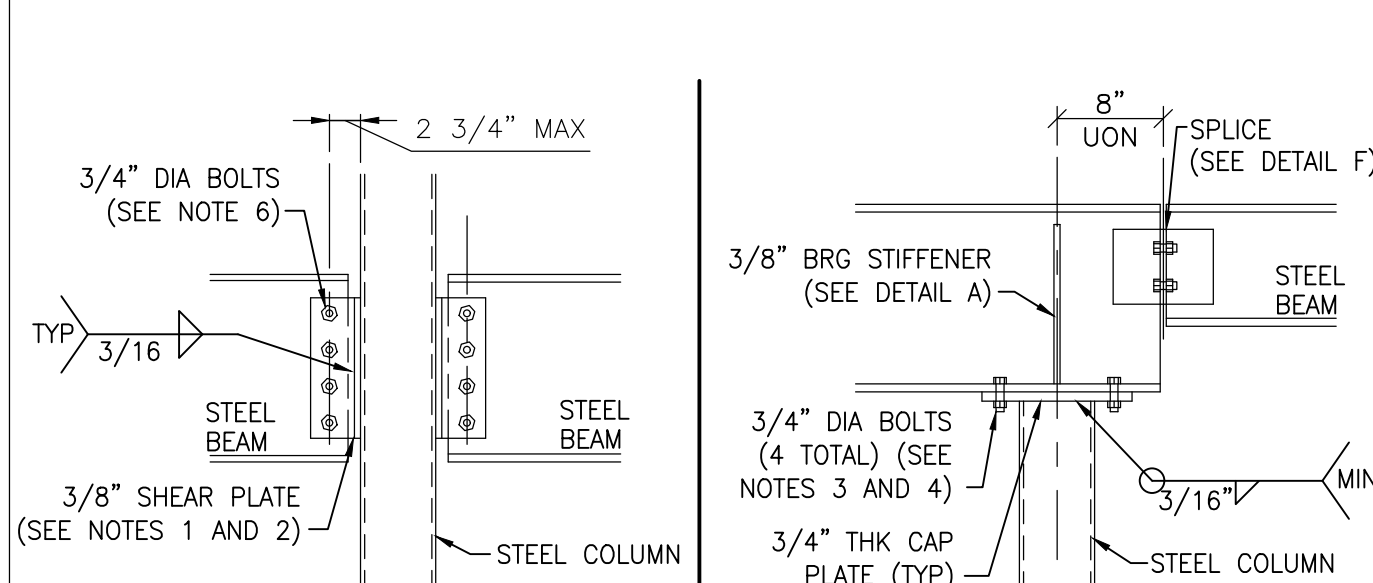


C. SIMPLE BEAM (MID COLUMN)

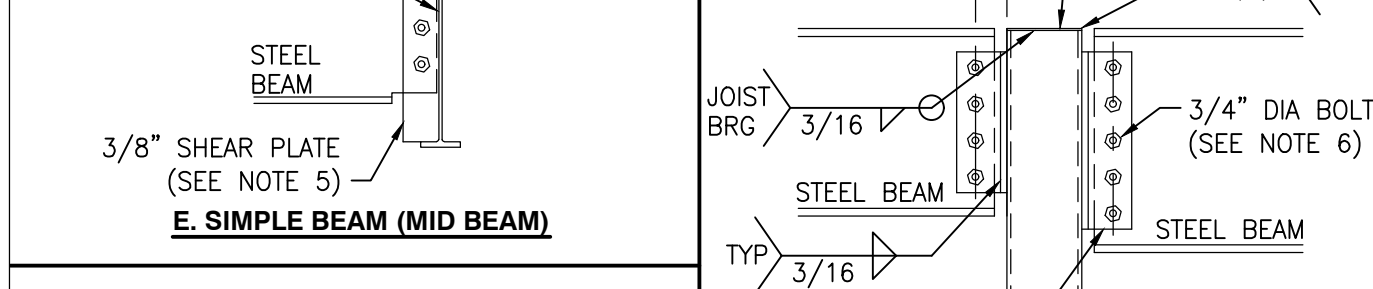


B. SIMPLE BEAM (TOP COLUMN)

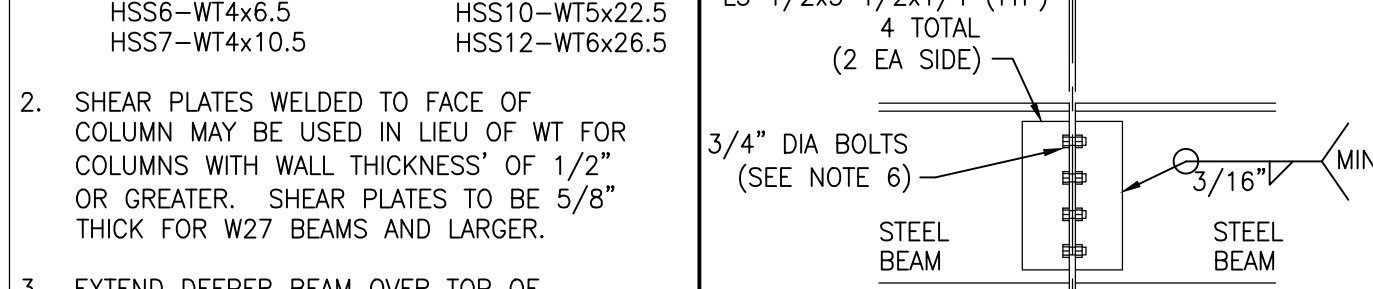


E. SIMPLE BEAM (MID BEAM)

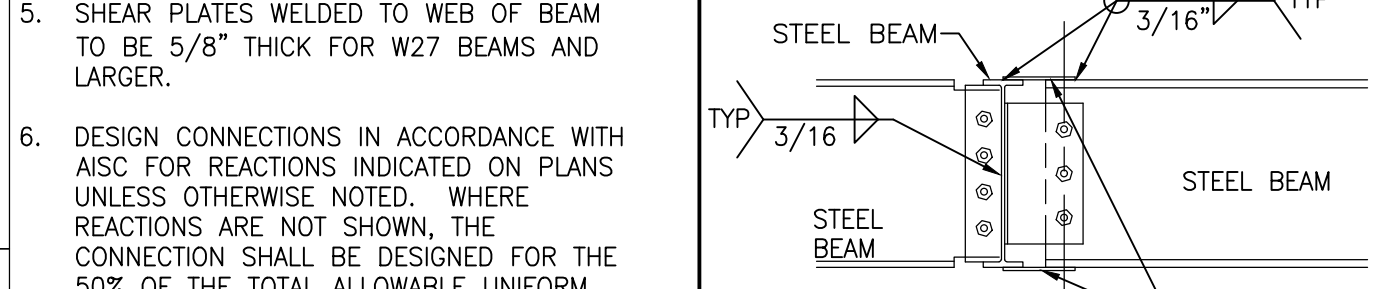


D. SIMPLE BEAM (TOP COLUMN)

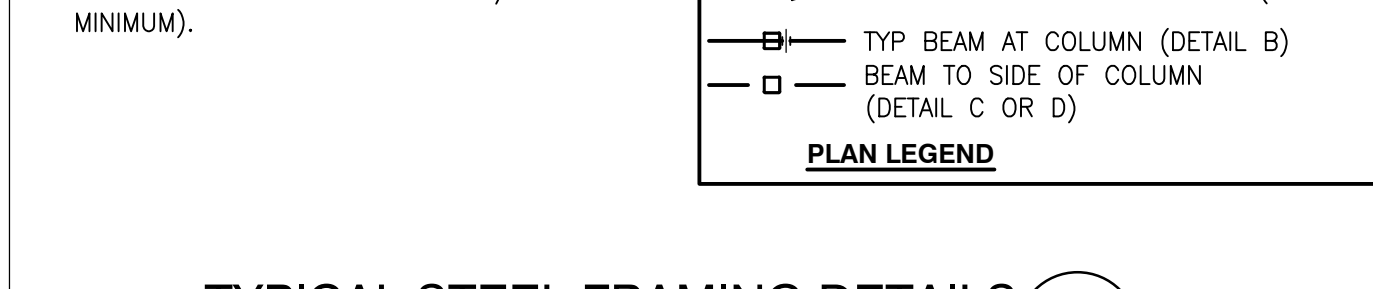


F. TYPICAL BEAM SPLICE

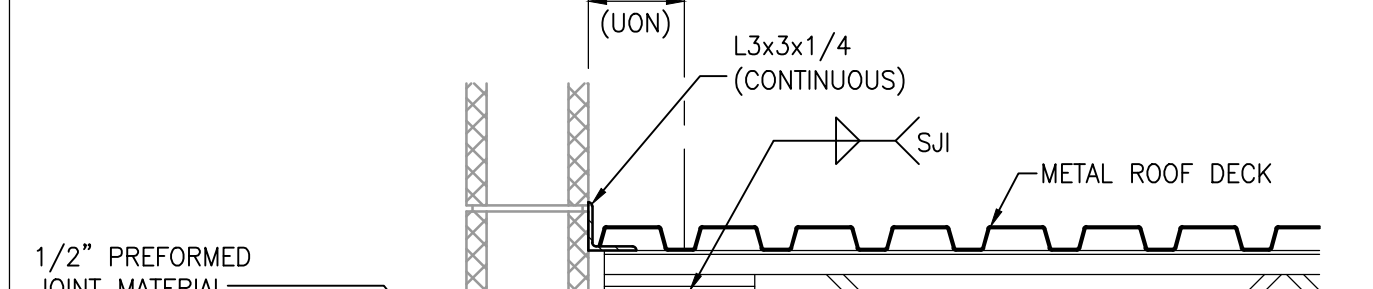


G. MOMENT CONNECTION (MC)

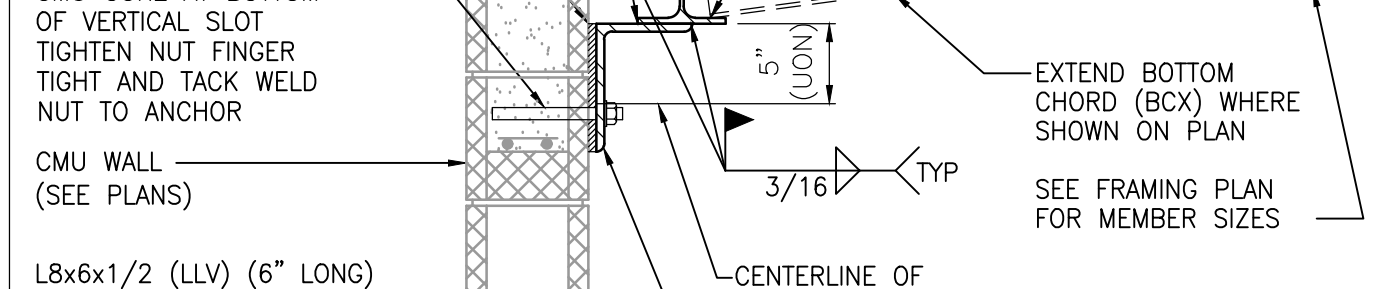


TYPICAL ROOF DECK ATTACHMENT
SCALE: NTS

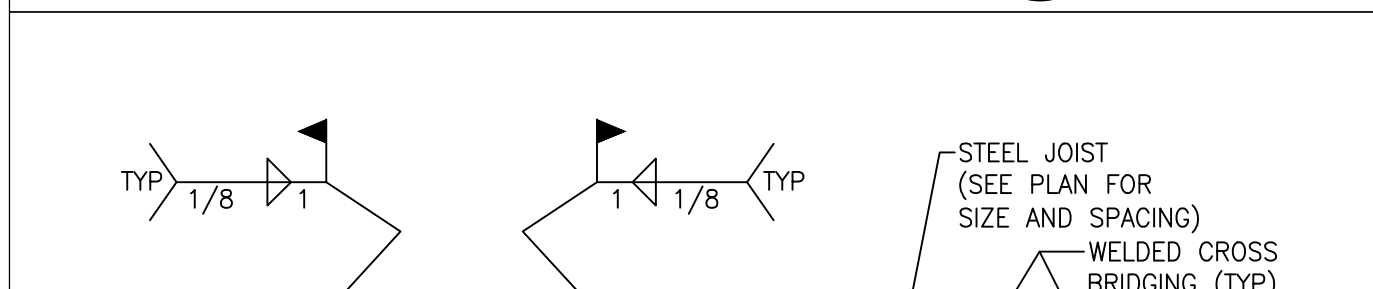


TYPICAL ROOF EDGE SECTION
SCALE: 1" = 1'-0"

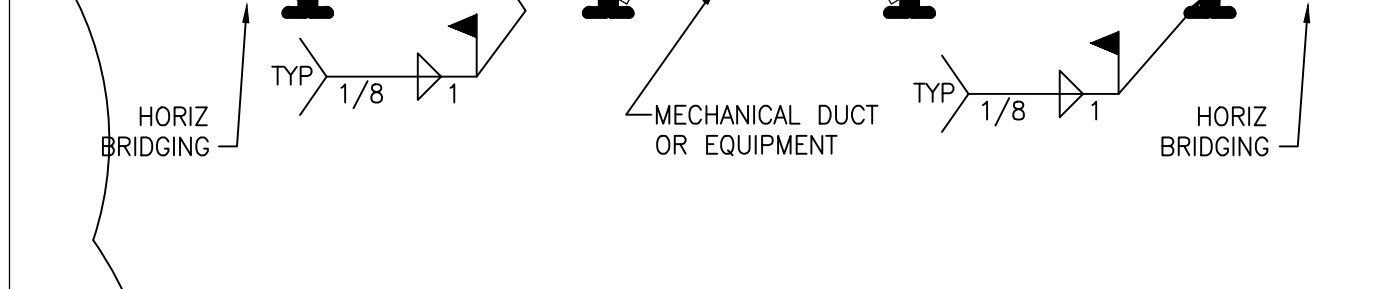


BRIDGING AT MECHANICAL EQUIPMENT
SCALE: NTS

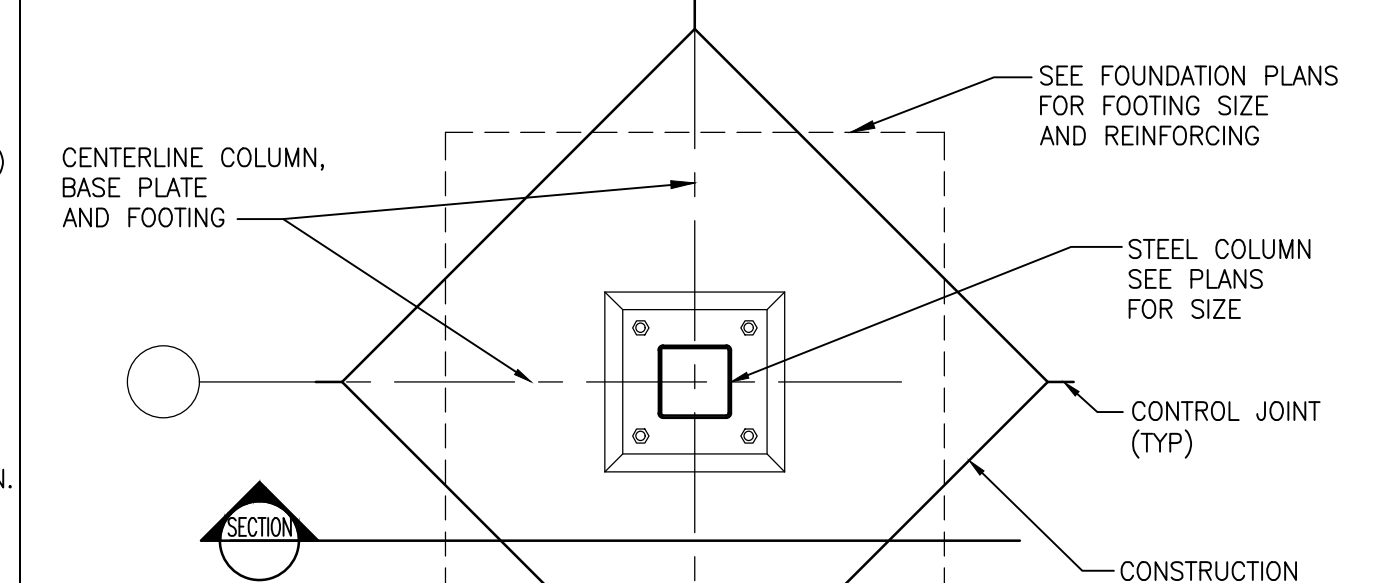


TYPICAL ISOLATED FOOTING
SCALE: NTS

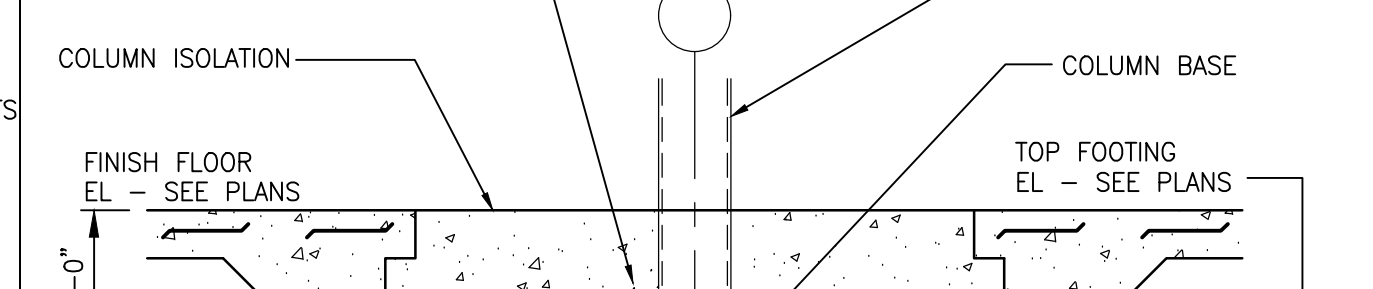


NEW SLAB AT EXISTING FOUNDATION WALL
SCALE: NTS

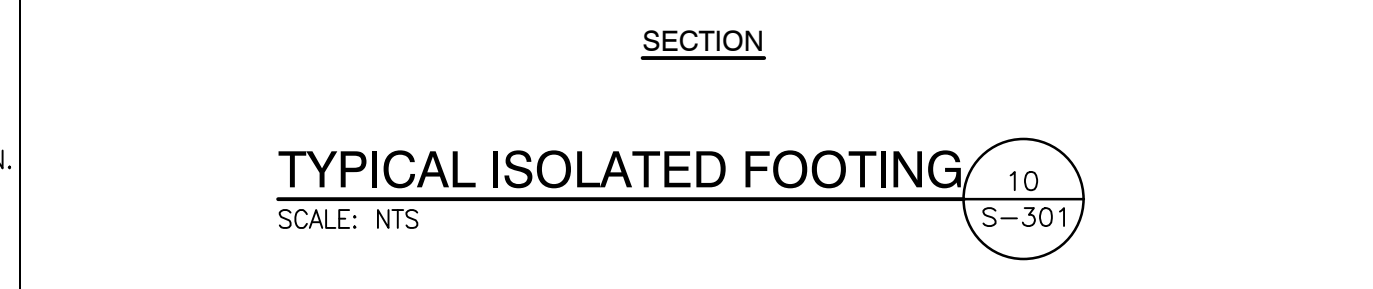


TYPICAL EDGE SUPPORTS
SCALE: NTS

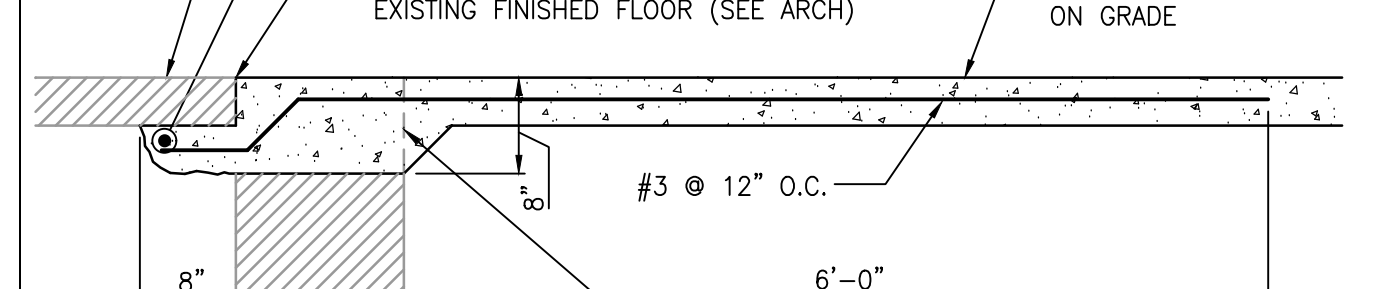


NEW SLAB AT EXISTING FOUNDATION WALL
SCALE: NTS

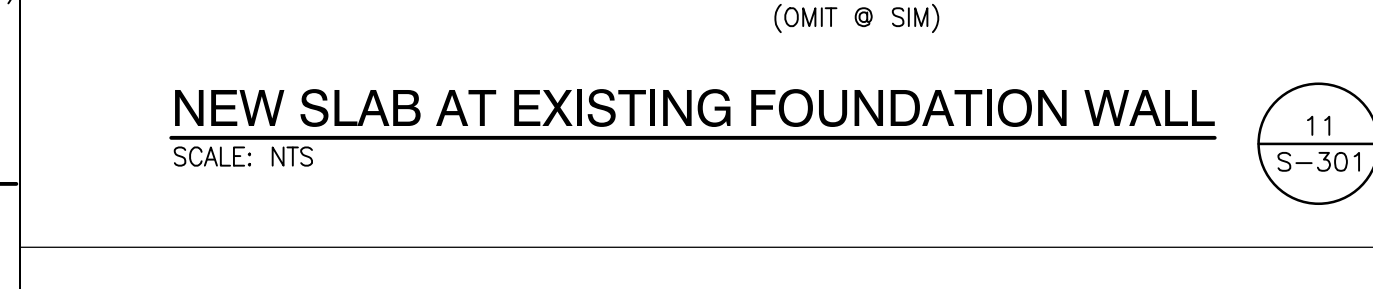


TYPICAL ROOF DECK ATTACHMENT
SCALE: NTS

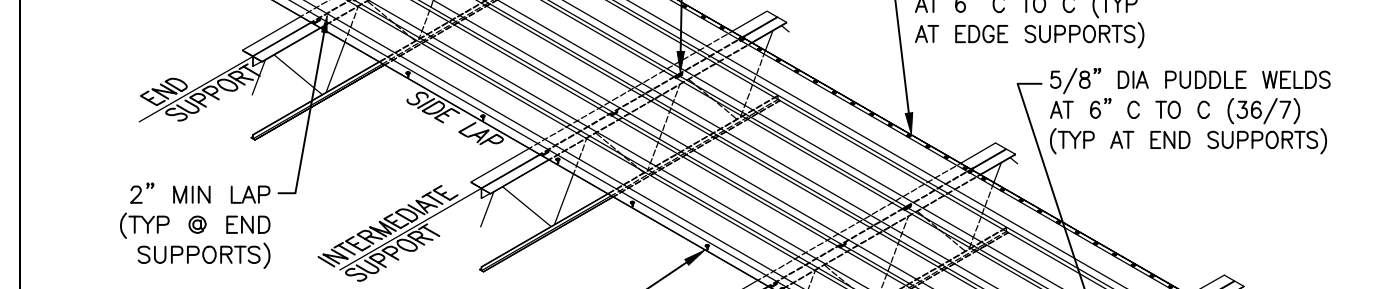


TYPICAL ROOF EDGE SECTION
SCALE: 1" = 1'-0"

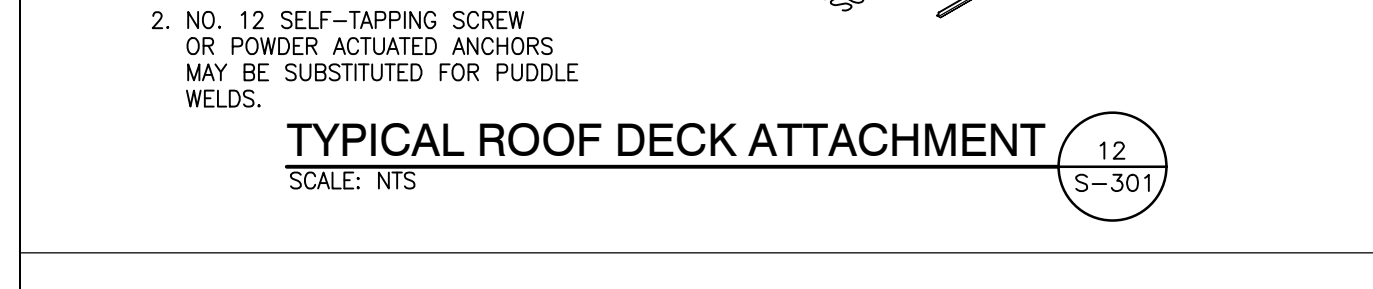


BRIDGING AT MECHANICAL EQUIPMENT
SCALE: NTS

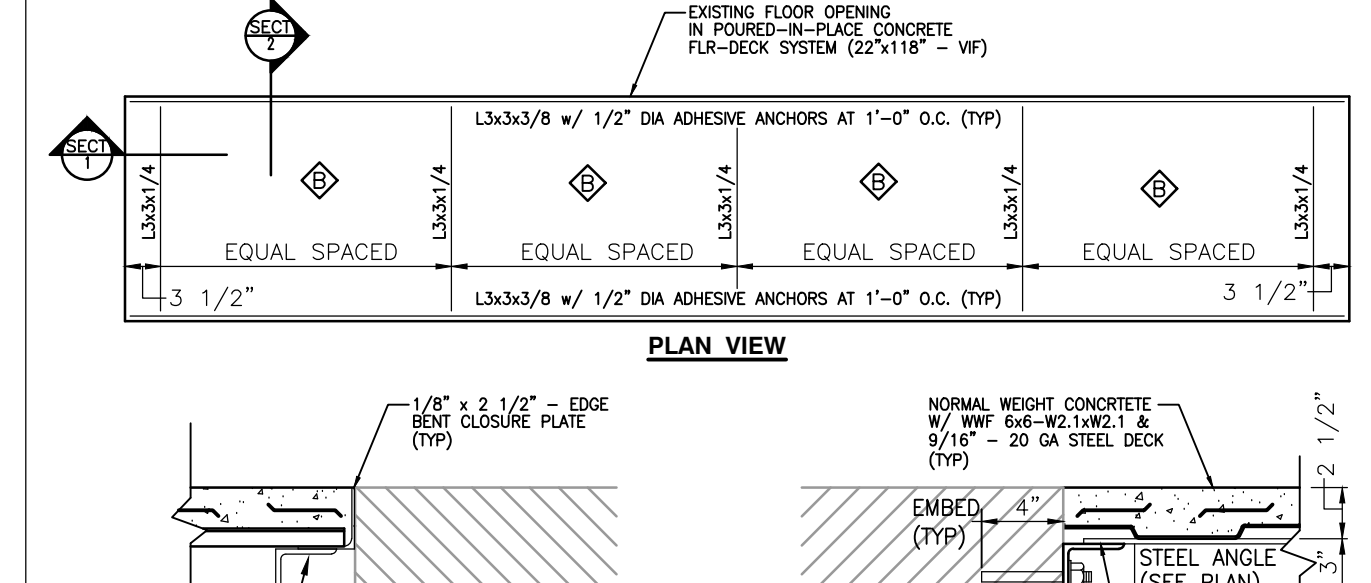


EXISTING FLOOR OPENING FILL-IN FRAME
SCALE: 3/4" = 1'-0"

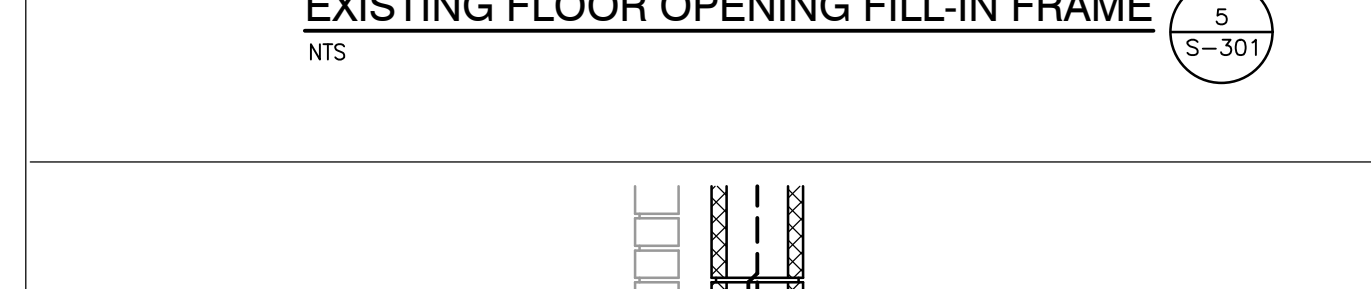


PIPE THROUGH FOUNDATION WALL
SCALE: 3/4" = 1'-0"

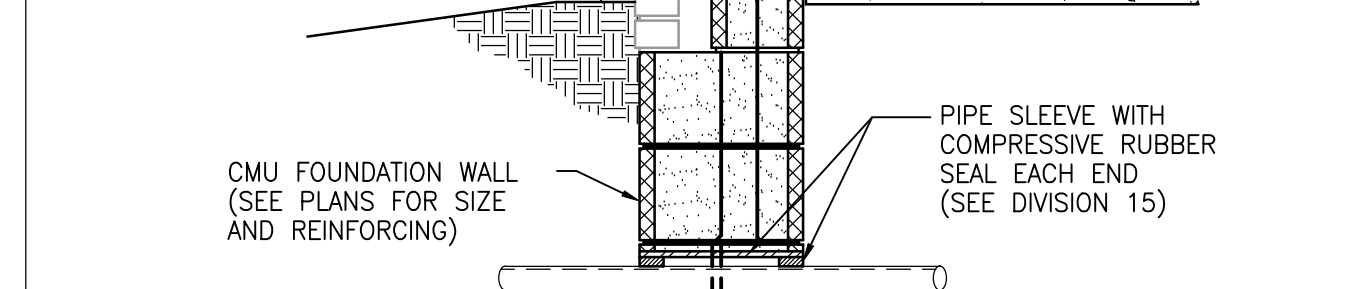


NEW SLAB AT EXISTING FOUNDATION WALL
SCALE: NTS

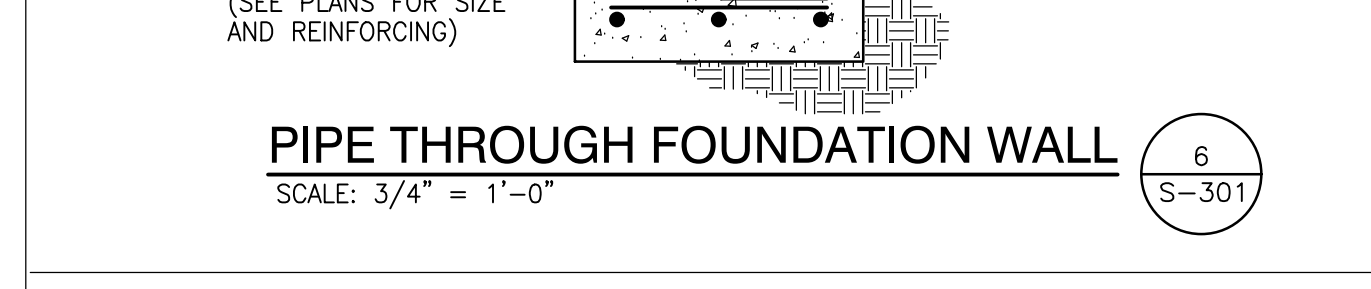


TYPICAL EDGE SUPPORTS
SCALE: NTS

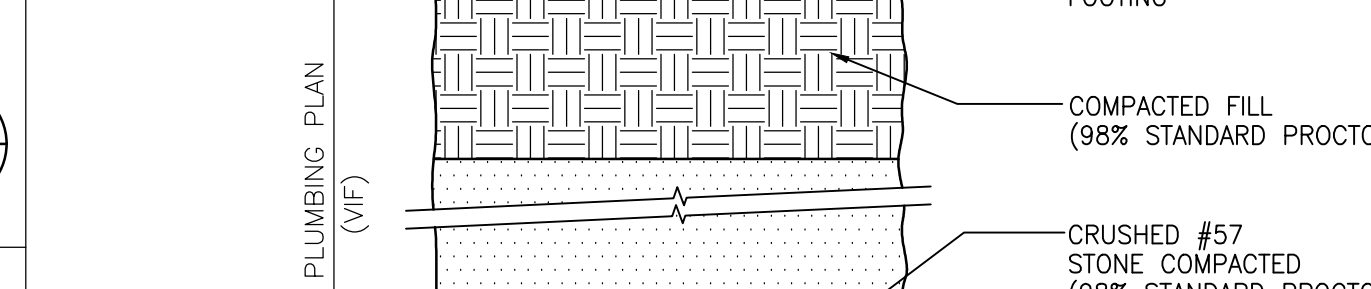


NEW SLAB AT EXISTING FOUNDATION WALL
SCALE: NTS

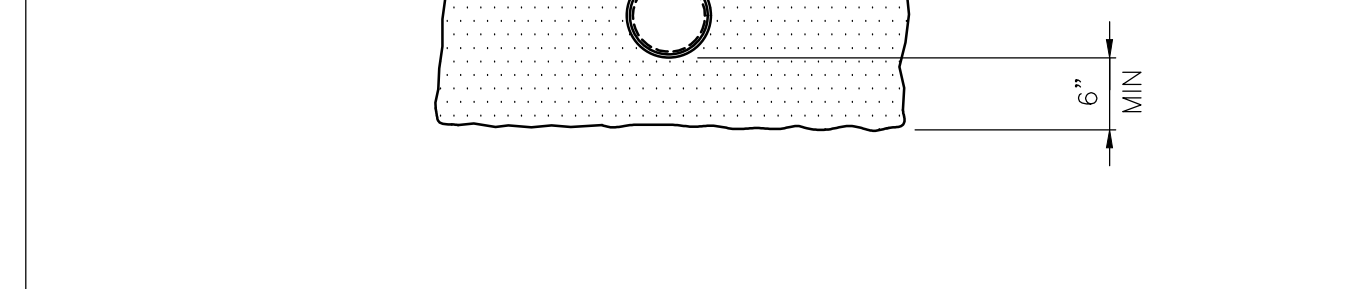


TYPICAL ROOF DECK ATTACHMENT
SCALE: NTS

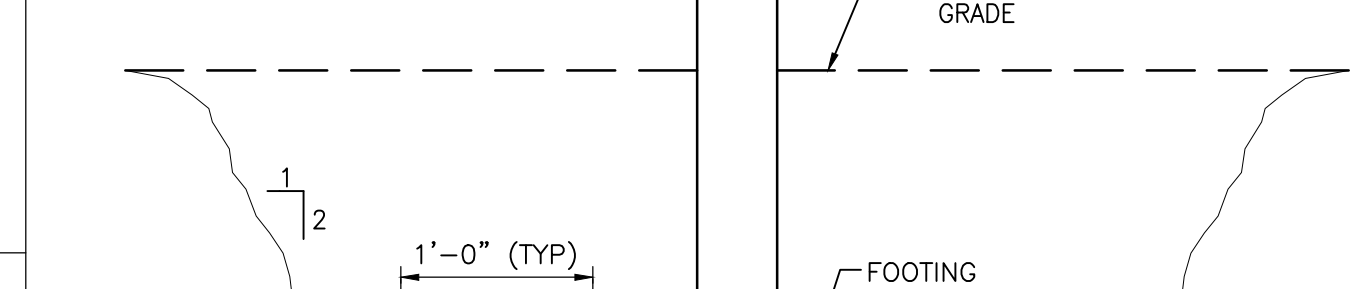

TYPICAL ROOF EDGE SECTION
SCALE: 1" = 1'-0"

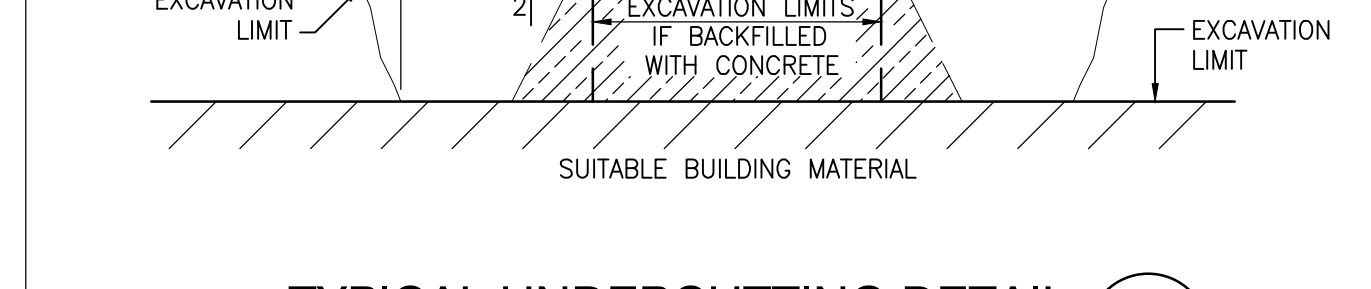


BRIDGING AT MECHANICAL EQUIPMENT
SCALE: NTS

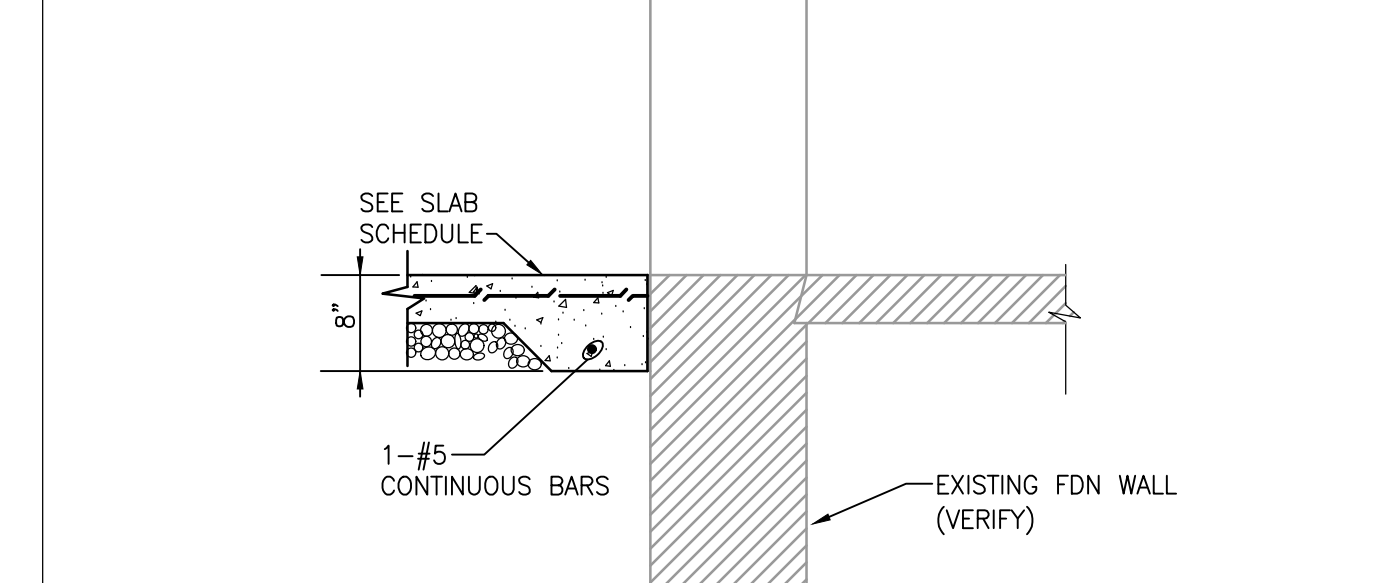


NEW SLAB AT EXISTING FDN WALL
SCALE: 3/4" = 1'-0"




CONCRETE STOOP @ EXISTING
SCALE: 3/4" = 1'-0"

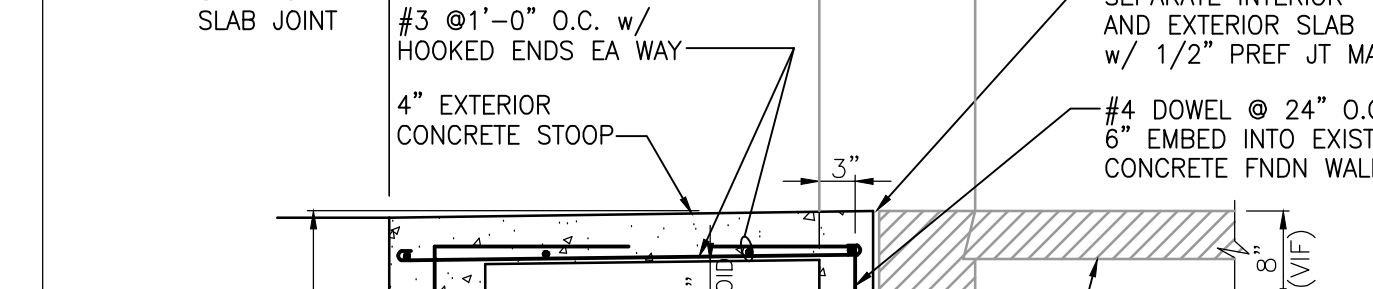


TYPICAL COLUMN BASE
SCALE: NTS

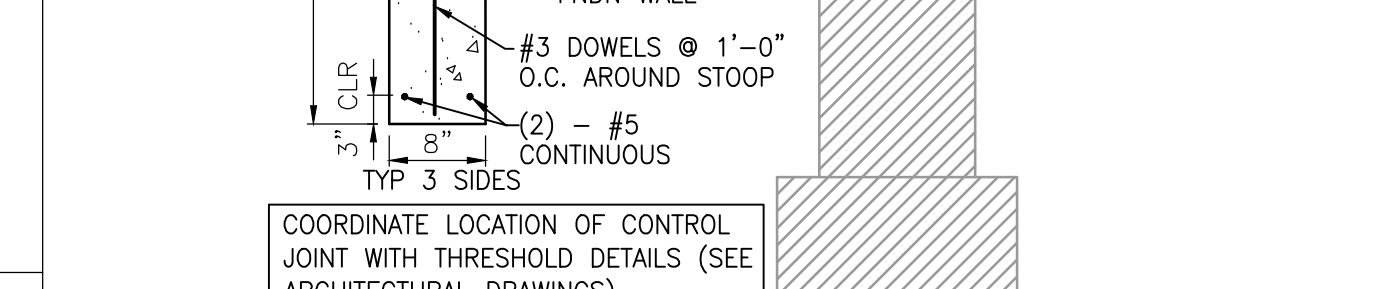


TYPICAL UNDERCUTTING DETAIL
SCALE: 3/4" = 1'-0"

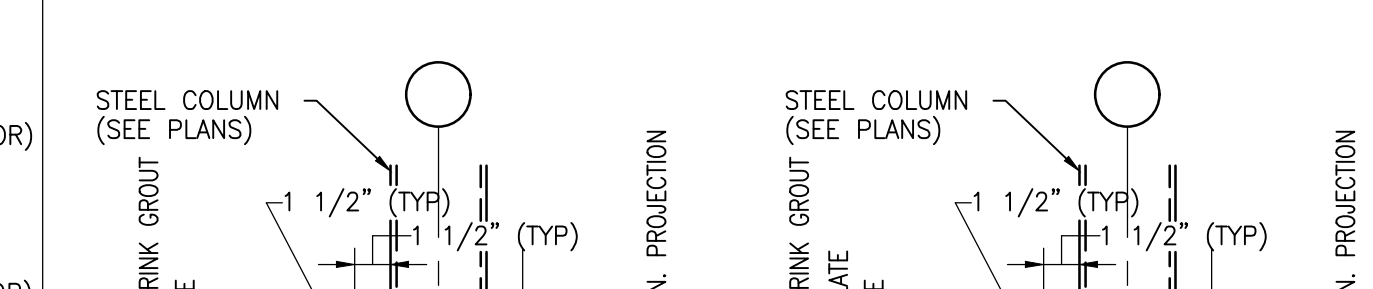


TYPICAL PIER
SCALE: 3/4" = 1'-0"

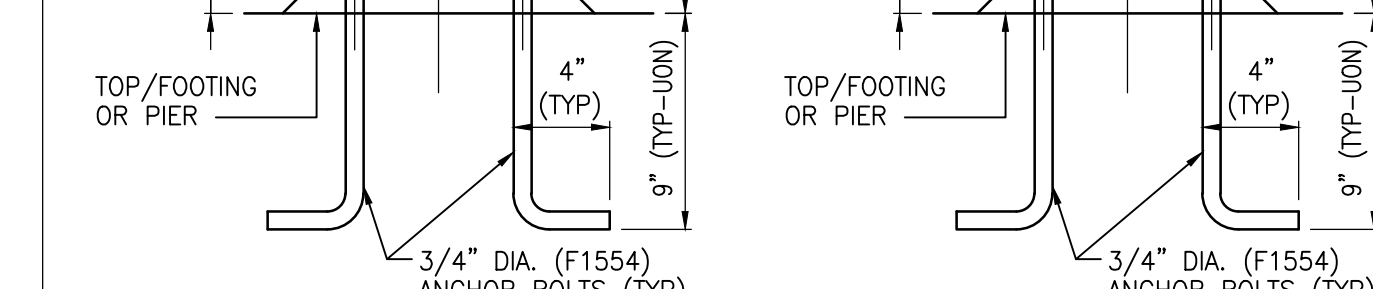


NEW FOOTING @ EXISTING
SCALE: 3/4" = 1'-0"

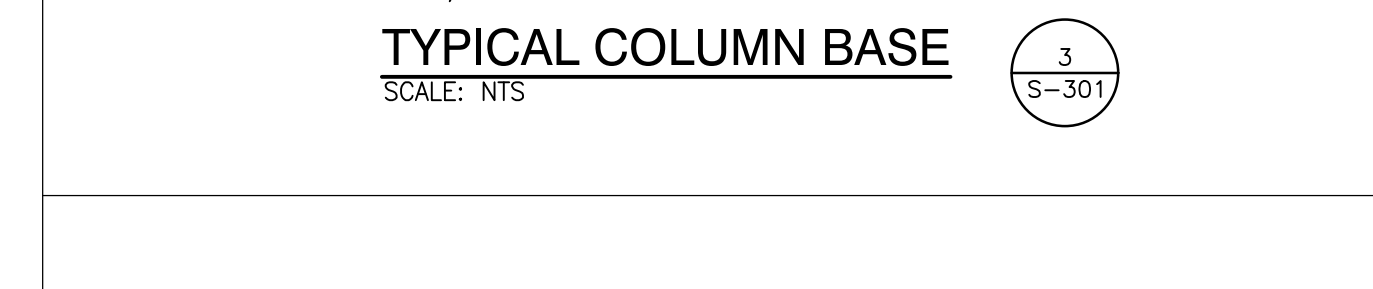


TYPICAL COLUMN BASE
SCALE: NTS

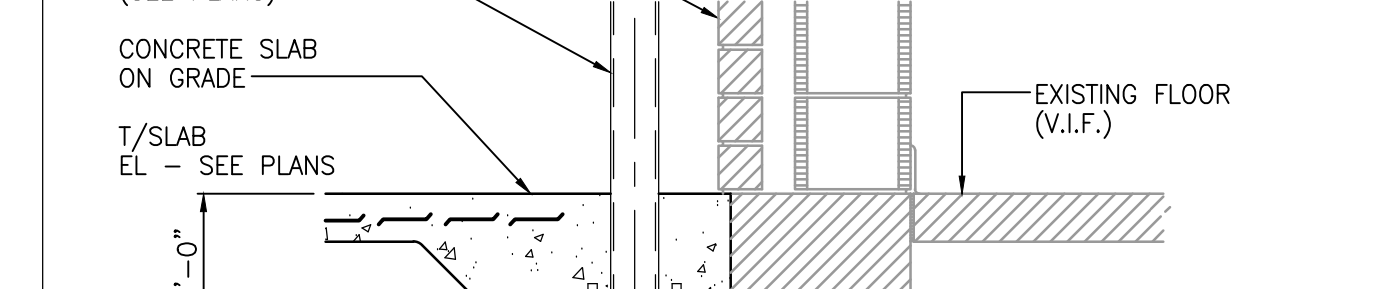

TYPICAL UNDERCUTTING DETAIL
SCALE: 3/4" = 1'-0"

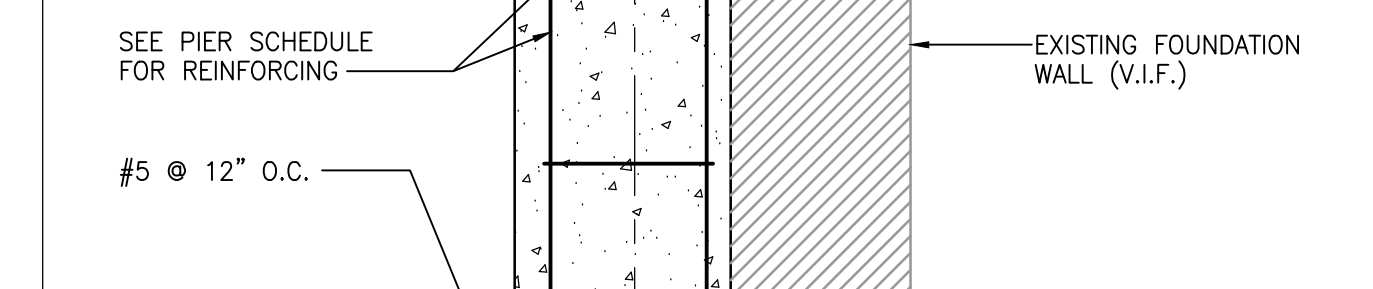


TYPICAL PIER
SCALE: 3/4" = 1'-0"

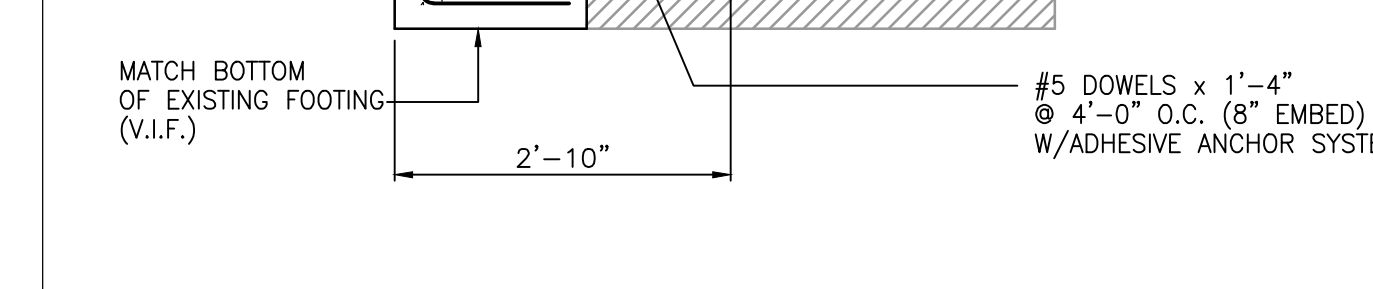

NEW FOOTING @ EXISTING
SCALE: 3/4" = 1'-0"


NEW FOOTING @ EXISTING
SCALE: 3/4" = 1'-0"

Thursday, 7/8/2021 - 5:29 PM - LAST SAVED BY:MMULLEN
Y:\20-157 LOGANSPOORT CSC - FAIRVIEW ES
RENOVATIONS\20-157 DRAWINGS\05 ARCH\AD101.DWG

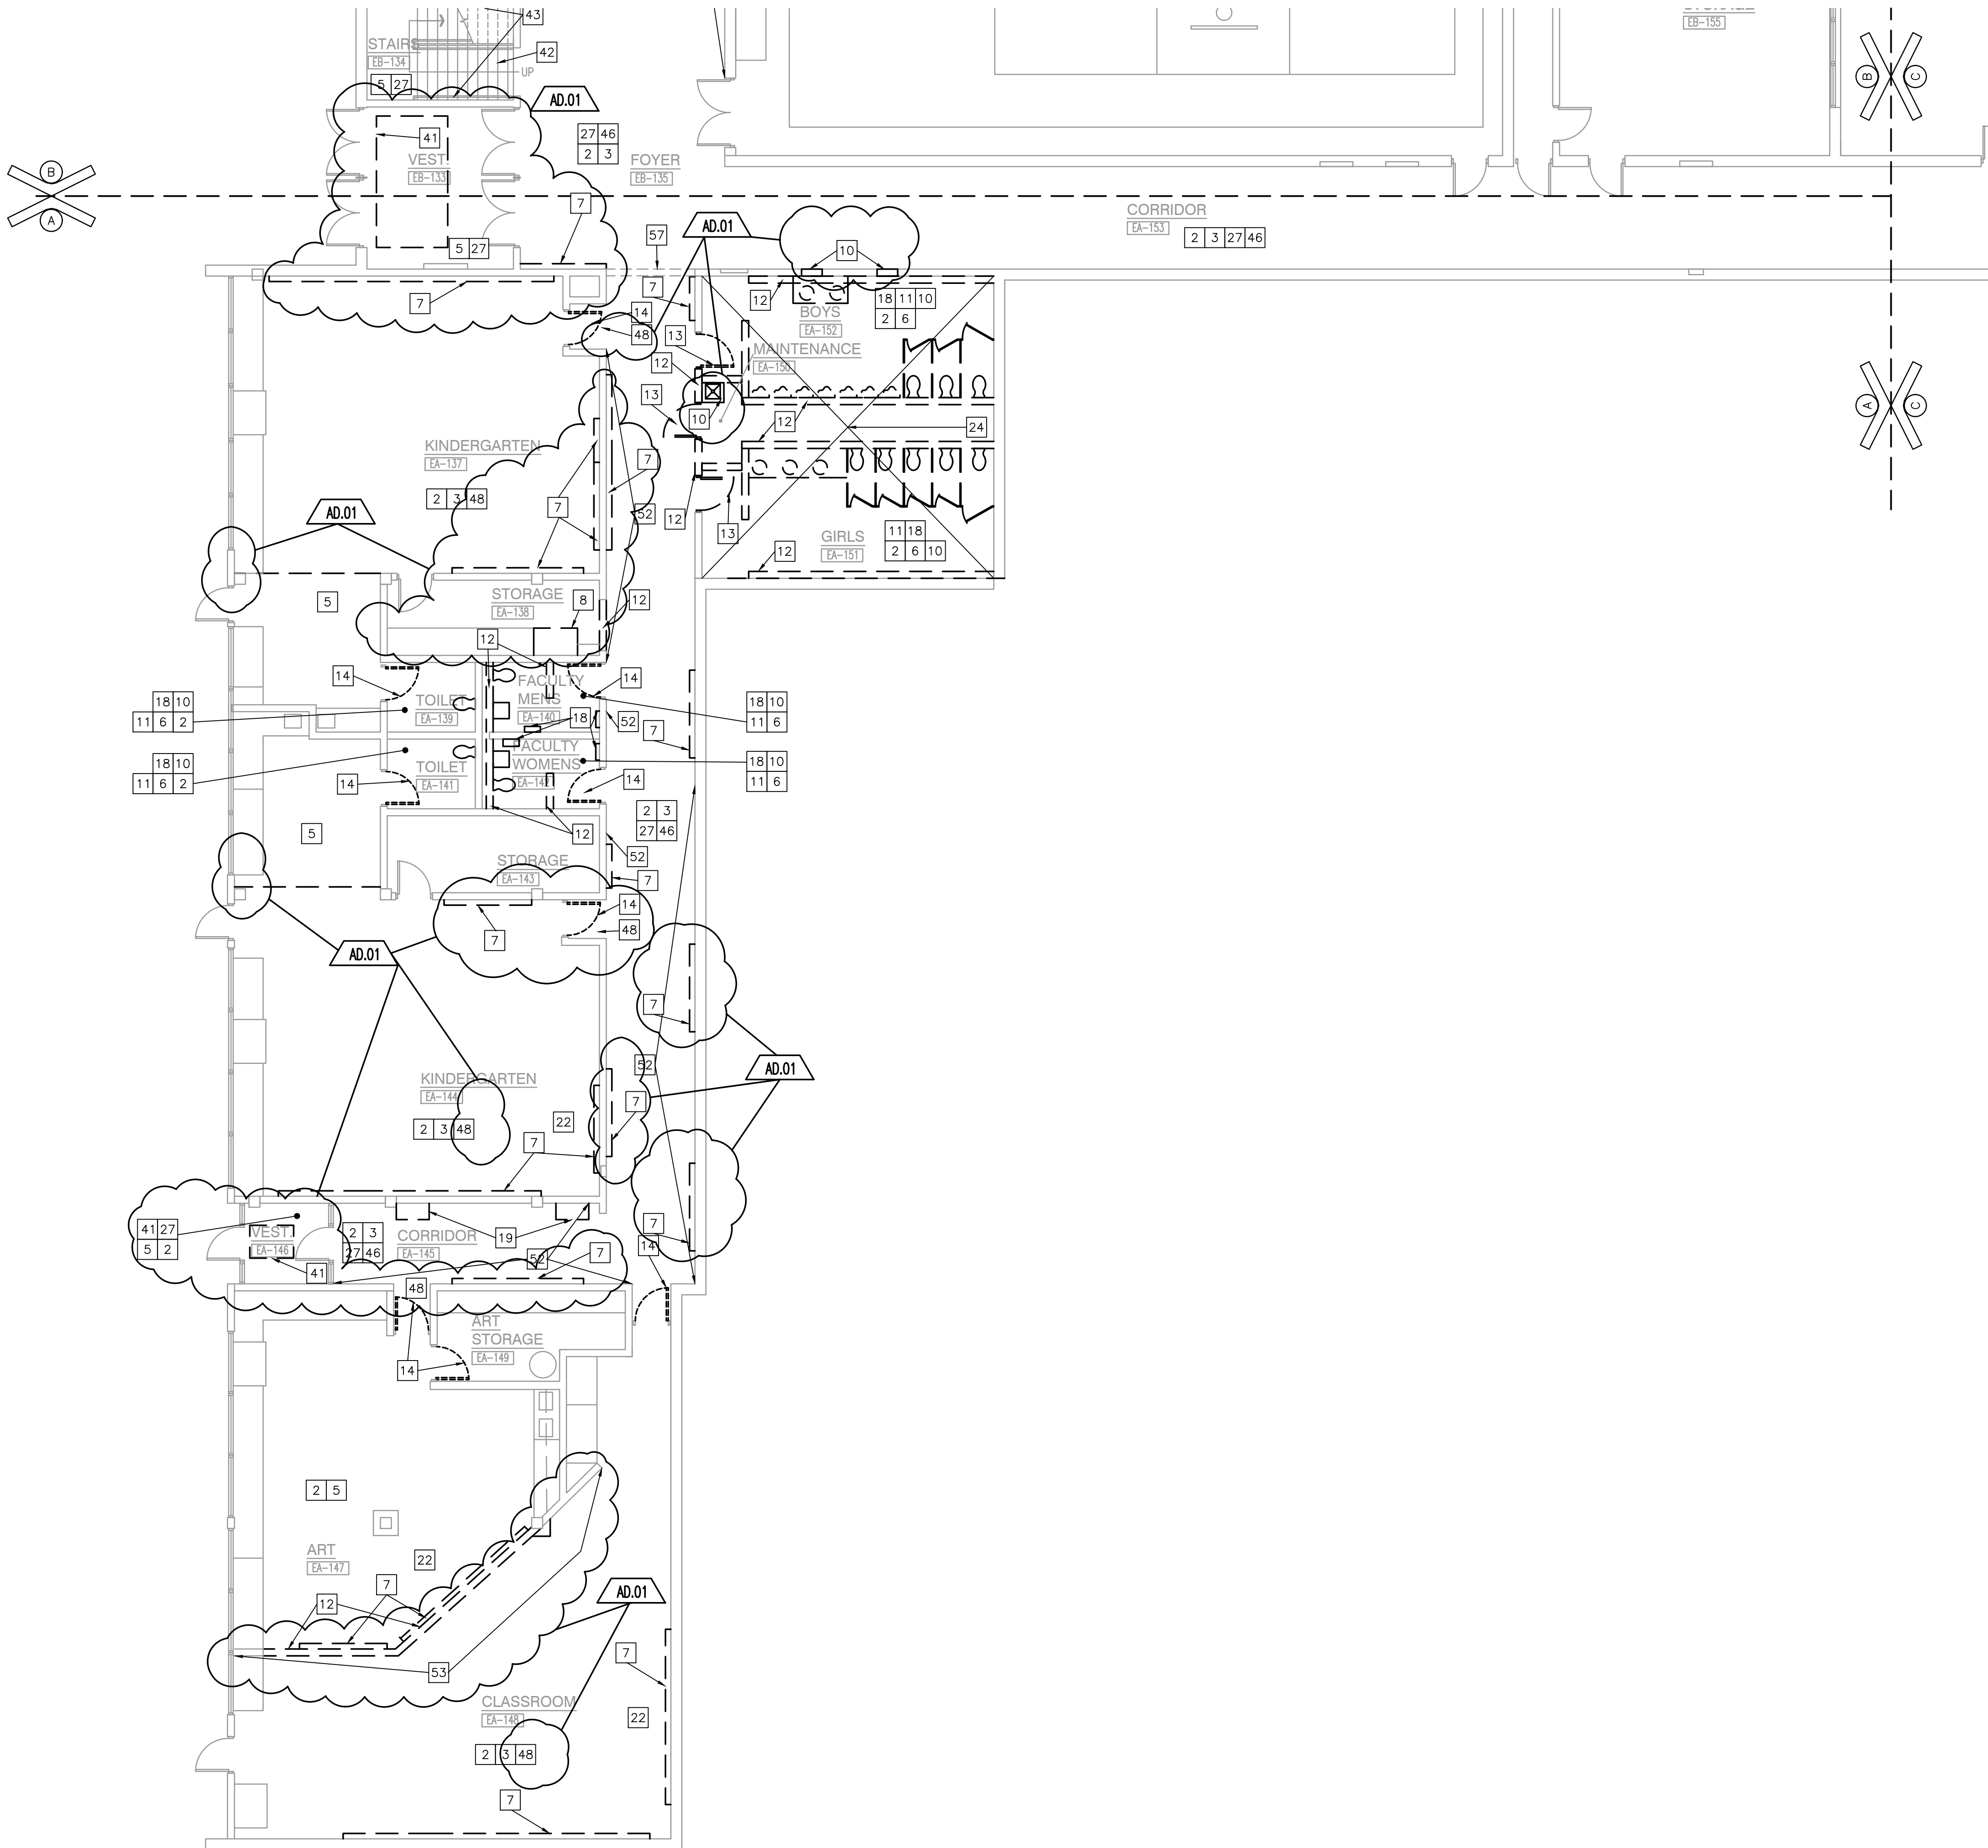

UNIT "A" ARCHITECTURAL LOWER LEVEL DEMOLITION PLAN

SCALE: 1/8" = 1'-0"

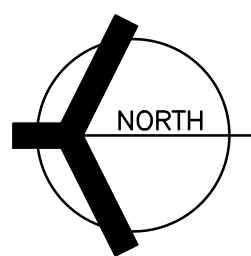

- 33 REMOVE EXISTING DRINKING FOUNTAIN. PREPARE FOR NEW DRINKING FOUNTAIN. SEE PLUMBING DRAWINGS.
- 34 REMOVE ELECTRICAL PANELS. REFER TO ELECTRICAL DRAWINGS.
- 35 REMOVE EXISTING LOCKERS, INCLUDING BASE. PATCH FLOOR AS REQUIRED TO RECEIVE NEW FINISH.
- 36 REMOVE WINDOW IN ITS ENTIRETY.
- 37 REMOVE ALUMINUM STOREFRONT FRAMING, DOORS, AND HARDWARE IN ITS ENTIRETY.
- 38 REMOVE EXISTING UNIT MASONRY, INCLUDING FASCIA/SOFFIT SYSTEM IN ITS ENTIRETY.
- 39 REMOVE EXISTING CONSTRUCTION IN ITS ENTIRETY, INCLUDING CONCRETE SLAB AND ROOFING CONSTRUCTION. REMOVE EXISTING INTERIOR FOUNDATION WALLS TO 8" BELOW NEW FLOOR SLAB ELEVATION.
- 40 REMOVE EXISTING EXTERIOR FOUNDATION WALL AND FOOTING IN ITS ENTIRETY.
- 41 REMOVE EXISTING RECESSED FLOOR MATS IN THEIR ENTIRETY.
- 42 REMOVE EXISTING RUBBER TREADS AND PREPARE FOR NEW TREADS.
- 43 REMOVE EXISTING HANDRAILS AS REQUIRED TO ALLOW FOR NEW WALL FINISHES. REINSTALL IN SAME LOCATION AFTER NEW FINISHES ARE INSTALLED.
- 44 REMOVE EXISTING BRICK FLOOR TILE AND PREPARE FOR NEW FINISH.
- 45 REFER TO STRUCTURAL DRAWINGS FOR EXTENT OF EXCAVATION FOR NEW CONCRETE FOOTINGS.
- 46 REMOVE ALL WALL AND CEILING MOUNTED ROOM SIGNAGE FROM CORRIDOR.
- 47 ALTERNATE.
- 48 REMOVE EXISTING WALLCOVERING, PREPARE AS REQUIRED TO RECEIVE NEW FINISH.
- 49 REMOVE EXISTING FIRE TUBE RADIATOR, PREPARE AS REQUIRED TO RECEIVE NEW FINISH.
- 50 REMOVE EXISTING STAINLESS STEEL CORNER GUARD AND ONE LAYER OF EXISTING GYPSUM BOARD FULL HEIGHT.
- 51 REMOVE CARPET STAIR TREAD, INCLUDING BASE AND RUBBER NOSING, IN ITS ENTIRETY. PREPARE FLOOR FOR NEW FINISHES.
- 52 REMOVE WALL TACK STRIPS IN THEIR ENTIRETY. PREPARE WALLS FOR NEW FINISHES.
- 53 REMOVE FLOOR TO CEILING WALL CARPETING IN ITS ENTIRETY. PREPARE FLOOR FOR NEW FINISHES.
- 54 EXISTING WOODEN BENCH AND ALL SUPPORTS IN THEIR ENTIRETY. PREPARE FLOOR FOR NEW FINISHES.
- 55 REMOVE EXISTING SAFETY WAINSCOT IN ITS ENTIRETY. PREPARE WALLS FOR NEW FINISHES.
- 56 REMOVE EXISTING WALL CERAMIC TILE. PREPARE WALL FOR NEW FINISHES.
- 57 EXISTING EXPANSION JOINT TO REMAIN.
- 58 REMOVE FIN TUBE RADIATION INCLUDING METAL ENCLOSURE.

GENERAL DEMOLITION NOTES:

- A. FOR GENERAL PROJECT NOTES, MATERIAL INDICATIONS LEGEND, SYMBOL LEGEND, ABBREVIATIONS, ETC., REFER TO GI SERIES SHEETS.
- B. UNLESS NOTED OTHERWISE ON THIS SHEET, THE GENERAL CONTRACTOR IS RESPONSIBLE FOR ALL DEMOLITION AND REMOVAL WORK INDICATED ON THIS SHEET.
- C. CONTRACTORS ENCOUNTERING EXISTING MATERIAL WHICH IS SUSPECTED OF CONTAINING ASBESTOS SHALL STOP WORK IMMEDIATELY AND NOTIFY THE OWNER AND THE OWNERS REPRESENTATIVE.
- D. BOLD DASHED LINES INDICATE EXISTING ITEMS TO BE REMOVED UNLESS OTHERWISE NOTED. THE CONTRACTOR SHALL BE RESPONSIBLE FOR FIELD VERIFYING THE EXTENT OF DEMOLITION WORK PRIOR TO BIDDING AND FOR COORDINATING THE EXTENT OF DEMOLITION WITH THE INSTALLATION OF NEW SYSTEMS.
- E. EACH CONTRACTOR SHALL BE RESPONSIBLE FOR ALL DEMOLITION APPLICABLE TO THEIR SCOPE OF WORK AND AS REQUIRED FOR INSTALLATION OF NEW WORK WHETHER OR NOT IT IS SPECIFICALLY INDICATED OR NOTED IN THESE DOCUMENTS.
- F. REMOVE ALL ITEMS AND FINISHES MADE OBSOLETE BY NEW CONSTRUCTION. VERIFY ITEMS DEEMED OBSOLETE WITH ARCHITECT PRIOR TO REMOVAL. REFER TO NEW CONSTRUCTION DRAWINGS FOR DEMOLITION REQUIRED NOT SHOWN ON DEMOLITION PLANS.
- G. EACH CONTRACTOR SHALL BE RESPONSIBLE FOR OFF SITE REMOVAL OF ALL DEMOLITION MATERIALS AND/OR ITEMS UNLESS NOTED OTHERWISE OR DIRECTED BY THE OWNER.
- H. PRIOR TO STARTING DEMOLITION, CONSTRUCT DUST CONTROL BARRIERS AS REQUIRED TO PREVENT THE SPREAD OF DUST INTO SURROUNDING AREAS (WHERE APPLICABLE).
- I. WHERE BUILDING EGRESS IS REQUIRED TO PASS THROUGH DEMOLITION AREAS, PROVIDE APPROVED BARRIERS, ETC. TO ENSURE SAFETY OF THE PUBLIC.
- J. RELOCATED ITEMS SHALL BE CLEANED AND PLACED IN STORAGE, PER OWNERS' DIRECTION, UNTIL ITEMS ARE READY TO BE INSTALLED. IF ITEMS ARE DAMAGED DURING DEMOLITION OR RELOCATION, THEY SHALL BE REPAIRED OR REPLACED WITH NEW ITEMS AS APPROVED.
- K. DEMOLITION SHALL BE PERFORMED WITHOUT DAMAGE TO EXISTING CONSTRUCTION TO REMAIN. WHERE SUCH DAMAGE OCCURS, PATCH, REPAIR, OR RESTORE WALLS, FLOORS, CEILING, ETC. NEATLY TO MATCH EXISTING ADJACENT SURFACE. PROVIDE SHORING, BRACING, OR SUPPORT AS REQUIRED TO PREVENT MOVEMENT OR SETTLEMENT OF EXISTING STRUCTURES.
- L. EACH CONTRACTOR IS RESPONSIBLE FOR CUTTING, PATCHING, AND DISCONNECTING OF ITEMS APPLICABLE TO THEIR SCOPE OF WORK. WHERE EXISTING SERVICES ARE ABANDONED, CAP AT LEAST 1" BEHIND NEW FINISHES AND/OR EXISTING SURFACE AND PATCH AS REQUIRED TO RECEIVE NEW FINISHES OR MATCH EXISTING FINISH.
- M. ON WALLS THAT ARE TO RECEIVE NEW FINISHES, REMOVE AND REINSTALL EXISTING EQUIPMENT TO REMAIN AS REQUIRED FOR INSTALLATION OF NEW FINISHES.
- N. WHERE WALLS OR BULKHEADS ARE REMOVED, PATCH FLOORS, CEILINGS, AND ADJACENT WALLS AS REQUIRED TO MATCH EXISTING OR RECEIVE NEW FINISHES WHERE APPLICABLE. WHERE EXISTING DUCTWORK, PIPING, OR EQUIPMENT IS REMOVED, PATCH OPENINGS AND/OR SURFACES AS REQUIRED TO MATCH ADJACENT SURFACES OR RECEIVE NEW FINISHES WHERE APPLICABLE. REFER TO ALL DEMOLITION DRAWINGS FOR EXTENT OF ITEMS TO BE REMOVED.
- O. OVER CUT NEW OPENINGS IN EXISTING WALL AS REQUIRED FOR NEW CONSTRUCTION. PATCH AND REPAIR WALLS AS REQUIRED TO MATCH EXISTING. WHERE APPLICABLE, TOOTH NEW MASONRY INTO EXISTING MASONRY.
- P. ALL EQUIPMENT AND FURNITURE WHICH ARE CONSIDERED LOOSE FURNISHING SHALL BE REMOVED BY THE OWNER PRIOR TO DEMOLITION.
- Q. MASONRY WALLS TO BE REMOVED SHALL BE REMOVED TO A POINT 2" MINIMUM BELOW THE EXISTING FLOOR SLAB UNLESS SETTING ON A SLAB OR SPECIFICALLY NOTED OTHERWISE. PATCH WITH NEW CONCRETE TO BE FLUSH WITH THE EXISTING FLOOR SLAB.
- R. EACH CONTRACTOR SHALL BE RESPONSIBLE FOR GENERAL REVIEW OF DEMOLITION NOTES AND GENERAL DEMOLITION NOTES AS THEY APPLY TO THEIR SCOPE OF WORK.
- S. THE OWNER SHALL RESERVE THE RIGHT TO CLAIM ANY MATERIALS THAT ARE BEING DEMOLISHED PRIOR TO THE CONTRACTOR DISPOSING OF THEM OFF SITE.
- T. REFER TO THE STRUCTURAL, MECHANICAL, PLUMBING, ELECTRICAL AND TECHNOLOGY DOCUMENTS FOR COMPLETE SCOPE OF DEMOLITION WORK.
- U. "FLOORING" DENOTES FLOOR COVERING MATERIALS INCLUDING BACKING, ADHESIVES, AND BASES DOWN TO BUT EXCLUSIVE OF FLOOR SLABS AND STRUCTURAL MATERIALS UNLESS NOTED OTHERWISE.
- V. DEMOLITION IS TO FOLLOW ESTABLISHED CONSTRUCTION SEQUENCE. REFER TO SPECIFICATIONS AND DRAWINGS FOR REQUIREMENTS AND SPECIAL CONDITIONS.
- W. WHERE APPLICABLE SALVAGE EXISTING MASONRY (FACE BRICK, GLAZED CMU, FACING TILE) AS REQUIRED FOR PATCHING AND INFILL IN RENOVATED AREAS WHERE INDICATED. DISCARD UNUSED PORTION OFF SITE.

DEMOLITION PLAN NOTES:

(ALL PLAN NOTES MAY NOT BE INDICATED ON THIS SHEET.)

- 1 REMOVE SHELVING IN ITS ENTIRETY.
- 2 REMOVE ACOUSTICAL BOARD CEILING SYSTEM IN ITS ENTIRETY.
- 3 REMOVE CARPET FLOORING SYSTEM, INCLUDING BASE, IN ITS ENTIRETY. PREPARE FLOOR FOR NEW FINISHES.
- 4 REMOVE FREE STANDING TACKABLE PARTITION. PATCH AND REPAIR FLOOR AS REQUIRED TO ACCEPT NEW FINISHES.
- 5 REMOVE VCT/SHEET VINYL FLOORING SYSTEM, INCLUDING BASE, IN ITS ENTIRETY. PREPARE FLOOR FOR NEW FINISHES.
- 6 REMOVE CERAMIC OR PORCELAIN TILE FLOORING SYSTEM, INCLUDING BASE, IN ITS ENTIRETY. PREPARE FLOOR FOR NEW FINISHES.
- 7 REMOVE TACK BOARD, MARKER BOARD OR CHALKBOARD IN THEIR ENTIRETY. PATCH WALL AS REQUIRED TO RECEIVE NEW FINISHES.
- 8 REMOVE CASEWORK IN ITS ENTIRETY. PATCH AND REPAIR WALL AND FLOOR AS REQUIRED TO ACCEPT NEW FINISHES.
- 9 REMOVE METAL STUD AND PLASTER/GYPSUM BOARD WALL IN ITS ENTIRETY. PATCH AND REPAIR ADJACENT WALL AND FLOOR AS REQUIRED TO ACCEPT NEW FINISHES.
- 10 REMOVE PLUMBING FIXTURE IN ITS ENTIRETY. CUT AND CAP LINE BELOW WALL OR FLOOR SURFACE. UNLESS OTHERWISE NOTED ON PLUMBING DRAWINGS. PATCH AND REPAIR FLOOR AND/OR WALL AS REQUIRED TO ACCEPT NEW FINISHES.
- 11 REMOVE TOILET AND PARTITIONS IN THEIR ENTIRETY.
- 12 REMOVE MASONRY WALL (AS REQUIRED FOR NEW CONSTRUCTION.) PATCH AND REPAIR FLOOR AND WALL AS REQUIRED TO ACCEPT NEW FINISHES.
- 13 REMOVE HOLLOW METAL DOOR, FRAME AND HARDWARE IN ITS ENTIRETY.
- 14 REMOVE DOOR AND HARDWARE. HOLLOW METAL FRAME TO REMAIN.
- 15 REMOVE METAL STUD AND PLASTER BULKHEAD IN ITS ENTIRETY. PATCH AND REPAIR WALL AS REQUIRED TO RECEIVE NEW FINISHES.
- 16 REMOVE METAL STUD AND GYPSUM BOARD BULKHEAD IN ITS ENTIRETY. PATCH AND REPAIR WALL AS REQUIRED FOR NEW FINISHES.
- 17 REMOVE EXISTING METAL SURROUND AS REQUIRED FOR NEW CONSTRUCTION.
- 18 REMOVE TOILET ACCESSORIES AND TURN OVER TO THE OWNER.
- 19 REMOVE EXISTING MOVABLE STORAGE UNIT IN ITS ENTIRETY.
- 20 REMOVE PLASTER SOFFIT AS REQUIRED FOR NEW CONSTRUCTION.
- 21 REMOVE EXISTING FLOOR DRAIN. REFER TO PLUMBING DRAWINGS.
- 22 REMOVE PROJECTOR. TURN OVER TO OWNER.
- 23 EXISTING STEEL COLUMN TO REMAIN.
- 24 REMOVE CONCRETE SLAB IN ITS ENTIRETY.
- 25 REMOVE CEILING MOUNTED T.V. IN ITS ENTIRETY. TURN OVER TO OWNER.
- 26 REMOVE MECHANICAL UNIT. MAKE READY TO RECEIVE NEW FINISHES. REFER TO MECHANICAL DRAWINGS.
- 27 REMOVE CARPET WAINSCOT AND TRIM IN ITS ENTIRETY. PREPARE WALL FOR NEW FINISHES.
- 28 REMOVE EXISTING DISPLAY CASE. PATCH WALL AS REQUIRED TO RECEIVE NEW FINISHES.
- 29 REMOVE MASONRY BRICK (AS REQUIRED FOR NEW CONSTRUCTION.) REPAIR WALL AS REQUIRED TO ACCEPT NEW FINISHES.
- 30 REMOVE CEILING MOUNTED MECHANICAL UNIT IN ITS ENTIRETY. REFER TO MECHANICAL DRAWINGS.
- 31 REMOVE FIRE EXTINGUISHER. TURN OVER TO OWNER. PATCH AND REPAIR WALL AS REQUIRED TO RECEIVE NEW FINISHES.
- 32 REMOVE MECHANICAL PIPING. PATCH CONCRETE FLOOR AS REQUIRED TO RECEIVE NEW FINISHES. REFER TO STRUCTURAL DRAWINGS FOR FLOOR PATCH.




GIBRALTAR
DESIGN

ARCHITECTURE • ENGINEERING • INTERIOR DESIGN

PROJECT

FAIRVIEW ELEMENTARY SCHOOL RENOVATIONS

LOGANSPOORT COMMUNITY
SCHOOL CORPORATION
LOGANSPOORT, INDIANA

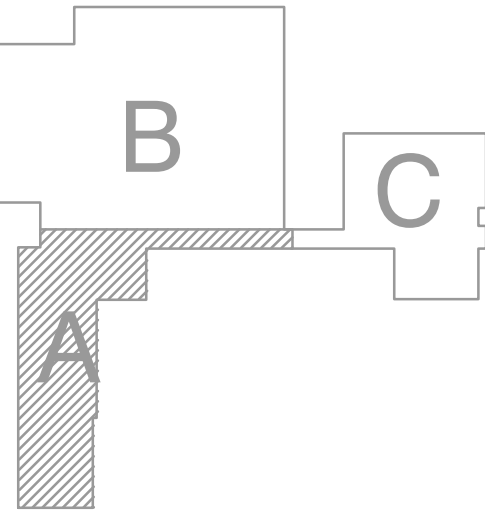

GIBRALTAR DESIGN

9102 N. Meridian St., Ste. 300
Indianapolis, IN 46260
Homepage www.GibraltarDesign.com
Email info@GibraltarDesign.com
Phone 317.580.5777 Fax 317.580.5778

PROJECT

20-157

DATE

06/18/21

COORDINATED BY

DJW

DRAWN BY

MMM

CHECKED BY

DJW

REGISTERED

NO. 19600171

STATE OF INDIANA

ARCHITECT

COPYRIGHT NOTICE:

THE CONCEPTS, DESIGNS, PLANS, DETAILS, ETC., SHOWN ON THIS DOCUMENT ARE THE PROPERTY OF GIBRALTAR DESIGN AND WERE CREATED FOR USE ON THIS SPECIFIC PROJECT. NONE OF THIS INFORMATION SHALL BE USED BY ANY PERSON OR FIRM FOR ANY PURPOSE WITHOUT THE EXPRESS WRITTEN CONSENT OF GIBRALTAR DESIGN. THE OWNER MAY RETAIN COPIES FOR INFORMATION AND REFERENCE IN CONNECTION ONLY WITH THIS PROJECT.

REVISIONS

MARK DATE ISSUED FOR

AD.01 7/9/21 AD.01

DRAWING

UNIT "A" ARCHITECTURAL

LOWER LEVEL DEMOLITION

PLAN

PROJECT

FAIRVIEW ELEMENTARY SCHOOL

RENOVATIONS

© GIBRALTAR DESIGN

SHEET


A

AD101

LOGANSPORT COMMUNITY
SCHOOL CORPORATION
LOGANSPORT, INDIANA

LOGANSPORT COMMUNITY
SCHOOL CORPORATION
LOGANSPORT, INDIANA



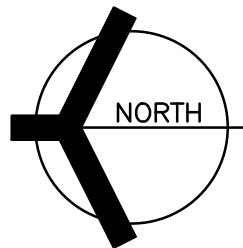

SCALE: 1/8" = 1'-0"

- 33 REMOVE EXISTING DRINKING FOUNTAIN. PREPARE FOR NEW DRINKING FOUNTAIN. SEE PLUMBING DRAWINGS.
- 34 REMOVE ELECTRICAL PANELS. REFER TO ELECTRICAL DRAWINGS.
- 35 REMOVE EXISTING LOCKERS, INCLUDING BASE. PATCH FLOOR AS REQUIRED TO RECEIVE NEW FINISH.
- 36 REMOVE WINDOW IN ITS ENTIRETY.
- 37 REMOVE ALUMINUM STOREFRONT FRAMING, DOORS, AND HARDWARE IN ITS ENTIRETY.
- 38 REMOVE EXISTING UNIT MASONRY, INCLUDING FASCIA/SOFFIT SYSTEM IN ITS ENTIRETY.
- 39 REMOVE EXISTING CONSTRUCTION IN ITS ENTIRETY, INCLUDING CONCRETE SLAB AND ROOFING CONSTRUCTION. REMOVE EXISTING INTERIOR FOUNDATION WALLS TO 8" BELOW NEW FLOOR SLAB ELEVATION.
- 40 REMOVE EXISTING EXTERIOR FOUNDATION WALL AND FOOTING IN ITS ENTIRETY.
- 41 REMOVE EXISTING RECESSED FLOOR MATS IN THEIR ENTIRETY.
- 42 REMOVE EXISTING RUBBER TREADS AND PREPARE FOR NEW TREADS.
- 43 REMOVE EXISTING HANDRAILS AS REQUIRED TO ALLOW FOR NEW WALL FINISHES. REINSTALL IN SAME LOCATION AFTER NEW FINISHES ARE INSTALLED.
- 44 REMOVE EXISTING BRICK FLOOR TILE AND PREPARE FOR NEW FINISH.
- 45 REFER TO STRUCTURAL DRAWINGS FOR EXTENT OF EXCAVATION FOR NEW CONCRETE FOOTINGS.
- 46 REMOVE ALL WALL AND CEILING MOUNTED ROOM SIGNAGE FROM CORRIDOR. ALTERNATE.
- 47 REMOVE EXISTING WALLCOVERING, PREPARE AS REQUIRED TO RECIEVE NEW FINISH.
- 49 REMOVE EXISTING FIRE TUBE RADIATOR, PREPARE AS REQUIRED TO RECIEVE NEW FINISH.
- 50 REMOVE EXISTING STAINLESS STEEL CORNER GUARD AND ONE LAYER OF EXISTING GYPSUM BOARD FULL HEIGHT.
- 51 REMOVE CARPET STAIR TREAD, INCLUDING BASE AND RUBBER NOSING, IN ITS ENTIRETY. PREPARE FLOOR FOR NEW FINISHES.
- 52 REMOVE WALL TACK STRIPS IN THEIR ENTIRETY. PREPARE WALLS FOR NEW FINISHES.
- 53 REMOVE FLOOR TO CEILING WALL CARPETING IN ITS ENTIRETY. PREPARE WALLS FOR NEW FINISHES.
- 54 EXISTING WOODEN BENCH AND ALL SUPPORTS IN THIER ENTIRETY. PREPARE FLOOR FOR NEW FINISHES.
- 55 REMOVE EXISTING SAFETY WAINSCOT IN ITS ENTIRETY. PREPARE WALLS FOR NEW FINISHES.
- 56 REMOVE EXISTING WALL CERAMIC TILE. PREPARE WALL FOR NEW FINISHES.
- 57 EXISTING EXPANSION JOINT TO REMAIN.
- 58 REMOVE FIN TUBE RADIATION INCLUDING METAL ENCLOSURE.


GENERAL DEMOLITION NOTES:

- A. FOR GENERAL PROJECT NOTES, MATERIAL INDICATIONS LEGEND, SYMBOL LEGEND, ABBREVIATIONS, ETC., REFER TO G1 SERIES SHEETS.
- B. UNLESS NOTED OTHERWISE ON THIS SHEET, THE GENERAL CONTRACTOR IS RESPONSIBLE FOR ALL DEMOLITION AND REMOVAL WORK INDICATED ON THIS SHEET.
- C. CONTRACTORS ENCOUNTERING EXISTING MATERIAL WHICH IS SUSPECTED OF CONTAINING ASBESTOS SHALL STOP WORK IMMEDIATELY AND NOTIFY THE OWNER AND THE OWNERS REPRESENTATIVE.
- D. BOLD DASHED LINES INDICATE EXISTING ITEMS TO BE REMOVED UNLESS OTHERWISE NOTED. THE CONTRACTOR SHALL BE RESPONSIBLE FOR FIELD VERIFYING THE EXTENT OF DEMOLITION WORK PRIOR TO BIDDING AND FOR COORDINATING THE EXTENT OF DEMOLITION WITH THE INSTALLATION OF NEW SYSTEMS.
- E. EACH CONTRACTOR SHALL BE RESPONSIBLE FOR ALL DEMOLITION APPLICABLE TO THEIR SCOPE OF WORK AND AS REQUIRED FOR INSTALLATION OF NEW WORK WHETHER OR NOT IT IS SPECIFICALLY INDICATED OR NOTED IN THESE DOCUMENTS.
- F. REMOVE ALL ITEMS AND FINISHES MADE OBSOLETE BY NEW CONSTRUCTION. VERIFY ITEMS DEEMED OBSOLETE WITH ARCHITECT PRIOR TO REMOVAL. REFER TO NEW CONSTRUCTION DRAWINGS FOR DEMOLITION REQUIRED NOT SHOWN ON DEMOLITION PLANS.
- G. EACH CONTRACTOR SHALL BE RESPONSIBLE FOR OFF SITE REMOVAL OF ALL DEMOLITION MATERIALS AND/OR ITEMS UNLESS NOTED OTHERWISE OR DIRECTED BY THE OWNER.
- H. PRIOR TO STARTING DEMOLITION, CONSTRUCT DUST CONTROL BARRIERS AS REQUIRED TO PREVENT THE SPREAD OF DUST INTO SURROUNDING AREAS (WHERE APPLICABLE).
- I. WHERE BUILDING EGRESS IS REQUIRED TO PASS THROUGH DEMOLITION AREAS, PROVIDE APPROVED BARRIERS, ETC. TO ENSURE SAFETY OF THE PUBLIC.
- J. RELOCATED ITEMS SHALL BE CLEANED AND PLACED IN STORAGE, PER OWNERS' DIRECTION, UNTIL ITEMS ARE READY TO BE INSTALLED. IF ITEMS ARE DAMAGED DURING DEMOLITION OR RELOCATION, THEY SHALL BE REPAIRED OR REPLACED WITH NEW ITEMS AS APPROVED.
- K. DEMOLITION SHALL BE PERFORMED WITHOUT DAMAGE TO EXISTING CONSTRUCTION TO REMAIN. WHERE SUCH DAMAGE OCCURS, PATCH, REPAIR, OR RESTORE WALLS, FLOORS, CEILING, ETC. NEATLY TO MATCH EXISTING ADJACENT SURFACE. PROVIDE SHORING, BRACING, OR SUPPORT AS REQUIRED TO PREVENT MOVEMENT OR SETTLEMENT OF EXISTING STRUCTURES.
- L. EACH CONTRACTOR IS RESPONSIBLE FOR CUTTING, PATCHING, AND DISCONNECTION OF ITEMS APPLICABLE TO THEIR SCOPE OF WORK. WHERE EXISTING SERVICES ARE ABANDONED, CAP AT LEAST 1" BEHIND NEW FINISHES AND/OR EXISTING SURFACE AND PATCH AS REQUIRED TO RECEIVE NEW FINISHES OR MATCH EXISTING FINISH.
- M. ON WALLS THAT ARE TO RECEIVE NEW FINISHES, REMOVE AND REINSTALL EXISTING EQUIPMENT TO REMAIN AS REQUIRED FOR INSTALLATION OF NEW FINISHES.
- N. WHERE WALLS OR BULKHEADS ARE REMOVED, PATCH FLOORS, CEILINGS, AND ADJACENT WALLS AS REQUIRED TO MATCH EXISTING OR RECEIVE NEW FINISHES WHERE APPLICABLE. WHERE EXISTING DUCTWORK, PIPING, OR EQUIPMENT IS REMOVED, PATCH OPENINGS AND/OR SURFACES AS REQUIRED TO MATCH ADJACENT SURFACES OR RECEIVE NEW FINISHES WHERE APPLICABLE. REFER TO ALL DEMOLITION DRAWINGS FOR EXTENT OF ITEMS TO REMOVED.
- O. OVER CUT NEW OPENINGS IN EXISTING WALL AS REQUIRED FOR NEW CONSTRUCTION. PATCH AND REPAIR WALLS AS REQUIRED TO MATCH EXISTING. WHERE APPLICABLE, TOOTH NEW MASONRY INTO EXISTING MASONRY.
- P. ALL EQUIPMENT AND FURNITURE WHICH ARE CONSIDERED LOOSE FURNISHING SHALL BE REMOVED BY THE OWNER PRIOR TO DEMOLITION.
- Q. MASONRY WALLS TO BE REMOVED SHALL BE REMOVED TO A POINT 2" MINIMUM BELOW THE EXISTING FLOOR SLAB UNLESS SETTING ON A SLAB OR SPECIFICALLY NOTED OTHERWISE. PATCH WITH NEW CONCRETE TO BE FLUSH WITH THE EXISTING FLOOR SLAB.
- R. EACH CONTRACTOR SHALL BE RESPONSIBLE FOR GENERAL REVIEW OF DEMOLITION NOTES AND GENERAL DEMOLITION NOTES AS THEY APPLY TO THEIR SCOPE OF WORK.
- S. THE OWNER SHALL RESERVE THE RIGHT TO CLAIM ANY MATERIALS THAT ARE BEING DEMOLISHED PRIOR TO THE CONTRACTOR DISPOSING OF THEM OFF SITE.
- T. REFER TO THE STRUCTURAL, MECHANICAL, PLUMBING, ELECTRICAL AND TECHNOLOGY DOCUMENTS FOR COMPLETE SCOPE OF DEMOLITION WORK.
- U. "FLOORING" DENOTES FLOOR COVERING MATERIALS INCLUDING BACKING, ADHESIVES, AND BASES DOWN TO BUT EXCLUSIVE OF FLOOR SLABS AND STRUCTURAL MATERIALS UNLESS NOTED OTHERWISE.
- V. DEMOLITION IS TO FOLLOW ESTABLISHED CONSTRUCTION SEQUENCE. REFER TO SPECIFICATIONS AND DRAWINGS FOR REQUIREMENTS AND SPECIAL CONDITIONS.
- W. WHERE APPLICABLE SALVAGE EXISTING MASONRY (FACE BRICK, GLAZED CMU, FACING TILE) AS REQUIRED FOR PATCHING AND INFILL IN RENOVATED AREAS WHERE INDICATED. DISCARD UNUSED PORTION OFF SITE.

DEMOLITION PLAN NOTES:



(ALL PLAN NOTES MAY NOT BE INDICATED ON THIS SHEET.)

- 1 REMOVE SHELVING IN ITS ENTIRETY.
- 2 REMOVE ACOUSTICAL BOARD CEILING SYSTEM IN ITS ENTIRETY.
- 3 REMOVE CARPET FLOORING SYSTEM, INCLUDING BASE, IN ITS ENTIRETY. PREPARE FLOOR FOR NEW FINISHES.
- 4 REMOVE FREE STANDING TACKABLE PARTITION. PATCH AND REPAIR FLOOR AS REQUIRED TO ACCEPT NEW FINISHES.
- 5 REMOVE VCT/SHEET VINYL FLOORING SYSTEM, INCLUDING BASE, IN ITS ENTIRETY. PREPARE FLOOR FOR NEW FINISHES.
- 6 REMOVE CERAMIC OR PORCELAIN TILE FLOORING SYSTEM, INCLUDING BASE, IN ITS ENTIRETY. PREPARE FLOOR FOR NEW FINISHES.
- 7 REMOVE TACK BOARD, MARKER BOARD OR CHALKBOARD IN THEIR ENTIRETY. PATCH WALL AS REQUIRED TO RECEIVE NEW FINISHES.
- 8 REMOVE CASEWORK IN ITS ENTIRETY. PATCH AND REPAIR WALL AND FLOOR AS REQUIRED TO ACCEPT NEW FINISHES.
- 9 REMOVE METAL STUD AND PLASTER/GYPSUM BOARD WALL IN ITS ENTIRETY. PATCH AND REPAIR ADJACENT WALL AND FLOOR AS REQUIRED TO ACCEPT NEW FINISHES.
- 10 REMOVE PLUMBING FIXTURE IN ITS ENTIRETY. CUT AND CAP LINE BELOW WALL OR FLOOR SURFACE. UNLESS OTHERWISE NOTED ON PLUMBING DRAWINGS. PATCH AND REPAIR FLOOR AND/OR WALL AS REQUIRED TO ACCEPT NEW FINISHES.
- 11 REMOVE TOILET AND PARTITIONS IN THEIR ENTIRETY.
- 12 REMOVE MASONRY WALL (AS REQUIRED FOR NEW CONSTRUCTION.) PATCH AND REPAIR FLOOR AND WALL AS REQUIRED TO ACCEPT NEW FINISHES.
- 13 REMOVE HOLLOW METAL DOOR, FRAME AND HARDWARE IN ITS ENTIRETY.
- 14 REMOVE DOOR AND HARDWARE. HOLLOW METAL FRAME TO REMAIN.
- 15 REMOVE METAL STUD AND PLASTER BULKHEAD IN ITS ENTIRETY. PATCH AND REPAIR WALL AS REQUIRED TO RECEIVE NEW FINISHES.
- 16 REMOVE METAL STUD AND GYPSUM BOARD BULKHEAD IN ITS ENTIRETY. PATCH AND REPAIR WALL AS REQUIRED FOR NEW FINISHES.
- 17 REMOVE EXISTING METAL SURROUND AS REQUIRED FOR NEW CONSTRUCTION.
- 18 REMOVE TOILET ACCESSORIES AND TURN OVER TO THE OWNER.
- 19 REMOVE EXISTING MOVABLE STORAGE UNIT IN ITS ENTIRETY.
- 20 REMOVE PLASTER SOFFIT AS REQUIRED FOR NEW CONSTRUCTION.
- 21 REMOVE EXISTING FLOOR DRAIN. REFER TO PLUMBING DRAWINGS.
- 22 REMOVE PROJECTOR. TURN OVER TO OWNER.
- 23 EXISTING STEEL COLUMN TO REMAIN.
- 24 REMOVE CONCRETE SLAB IN ITS ENTIRETY.
- 25 REMOVE CEILING MOUNTED T.V. IN ITS ENTIRETY. TURN OVER TO OWNER.
- 26 REMOVE MECHANICAL UNIT. MAKE READY TO RECEIVE NEW FINISHES. REFER TO MECHANICAL DRAWINGS.
- 27 REMOVE CARPET WAINSCOT AND TRIM IN ITS ENTIRETY. PREPARE WALL FOR NEW FINISHES.
- 28 REMOVE EXISTING DISPLAY CASE. PATCH WALL AS REQUIRED TO RECEIVE NEW FINISHES.
- 29 REMOVE MASONRY BRICK (AS REQUIRED FOR NEW CONSTRUCTION.) REPAIR WALL AS REQUIRED TO ACCEPT NEW FINISHES.
- 30 REMOVE CEILING MOUNTED MECHANICAL UNIT IN ITS . REFER TO MECHANICAL DRAWINGS.
- 31 REMOVE FIRE EXTINGUISHER. TURN OVER TO OWNER. PATCH AND REPAIR WALL AS REQUIRED TO RECEIVE NEW FINISHES.
- 32 REMOVE MECHANICAL PIPING. PATCH CONCRETE FLOOR AS REQUIRED TO RECEIVE NEW FINISHES. REFER TO STRUCTURAL DRAWINGS FOR FLOOR PATCH.

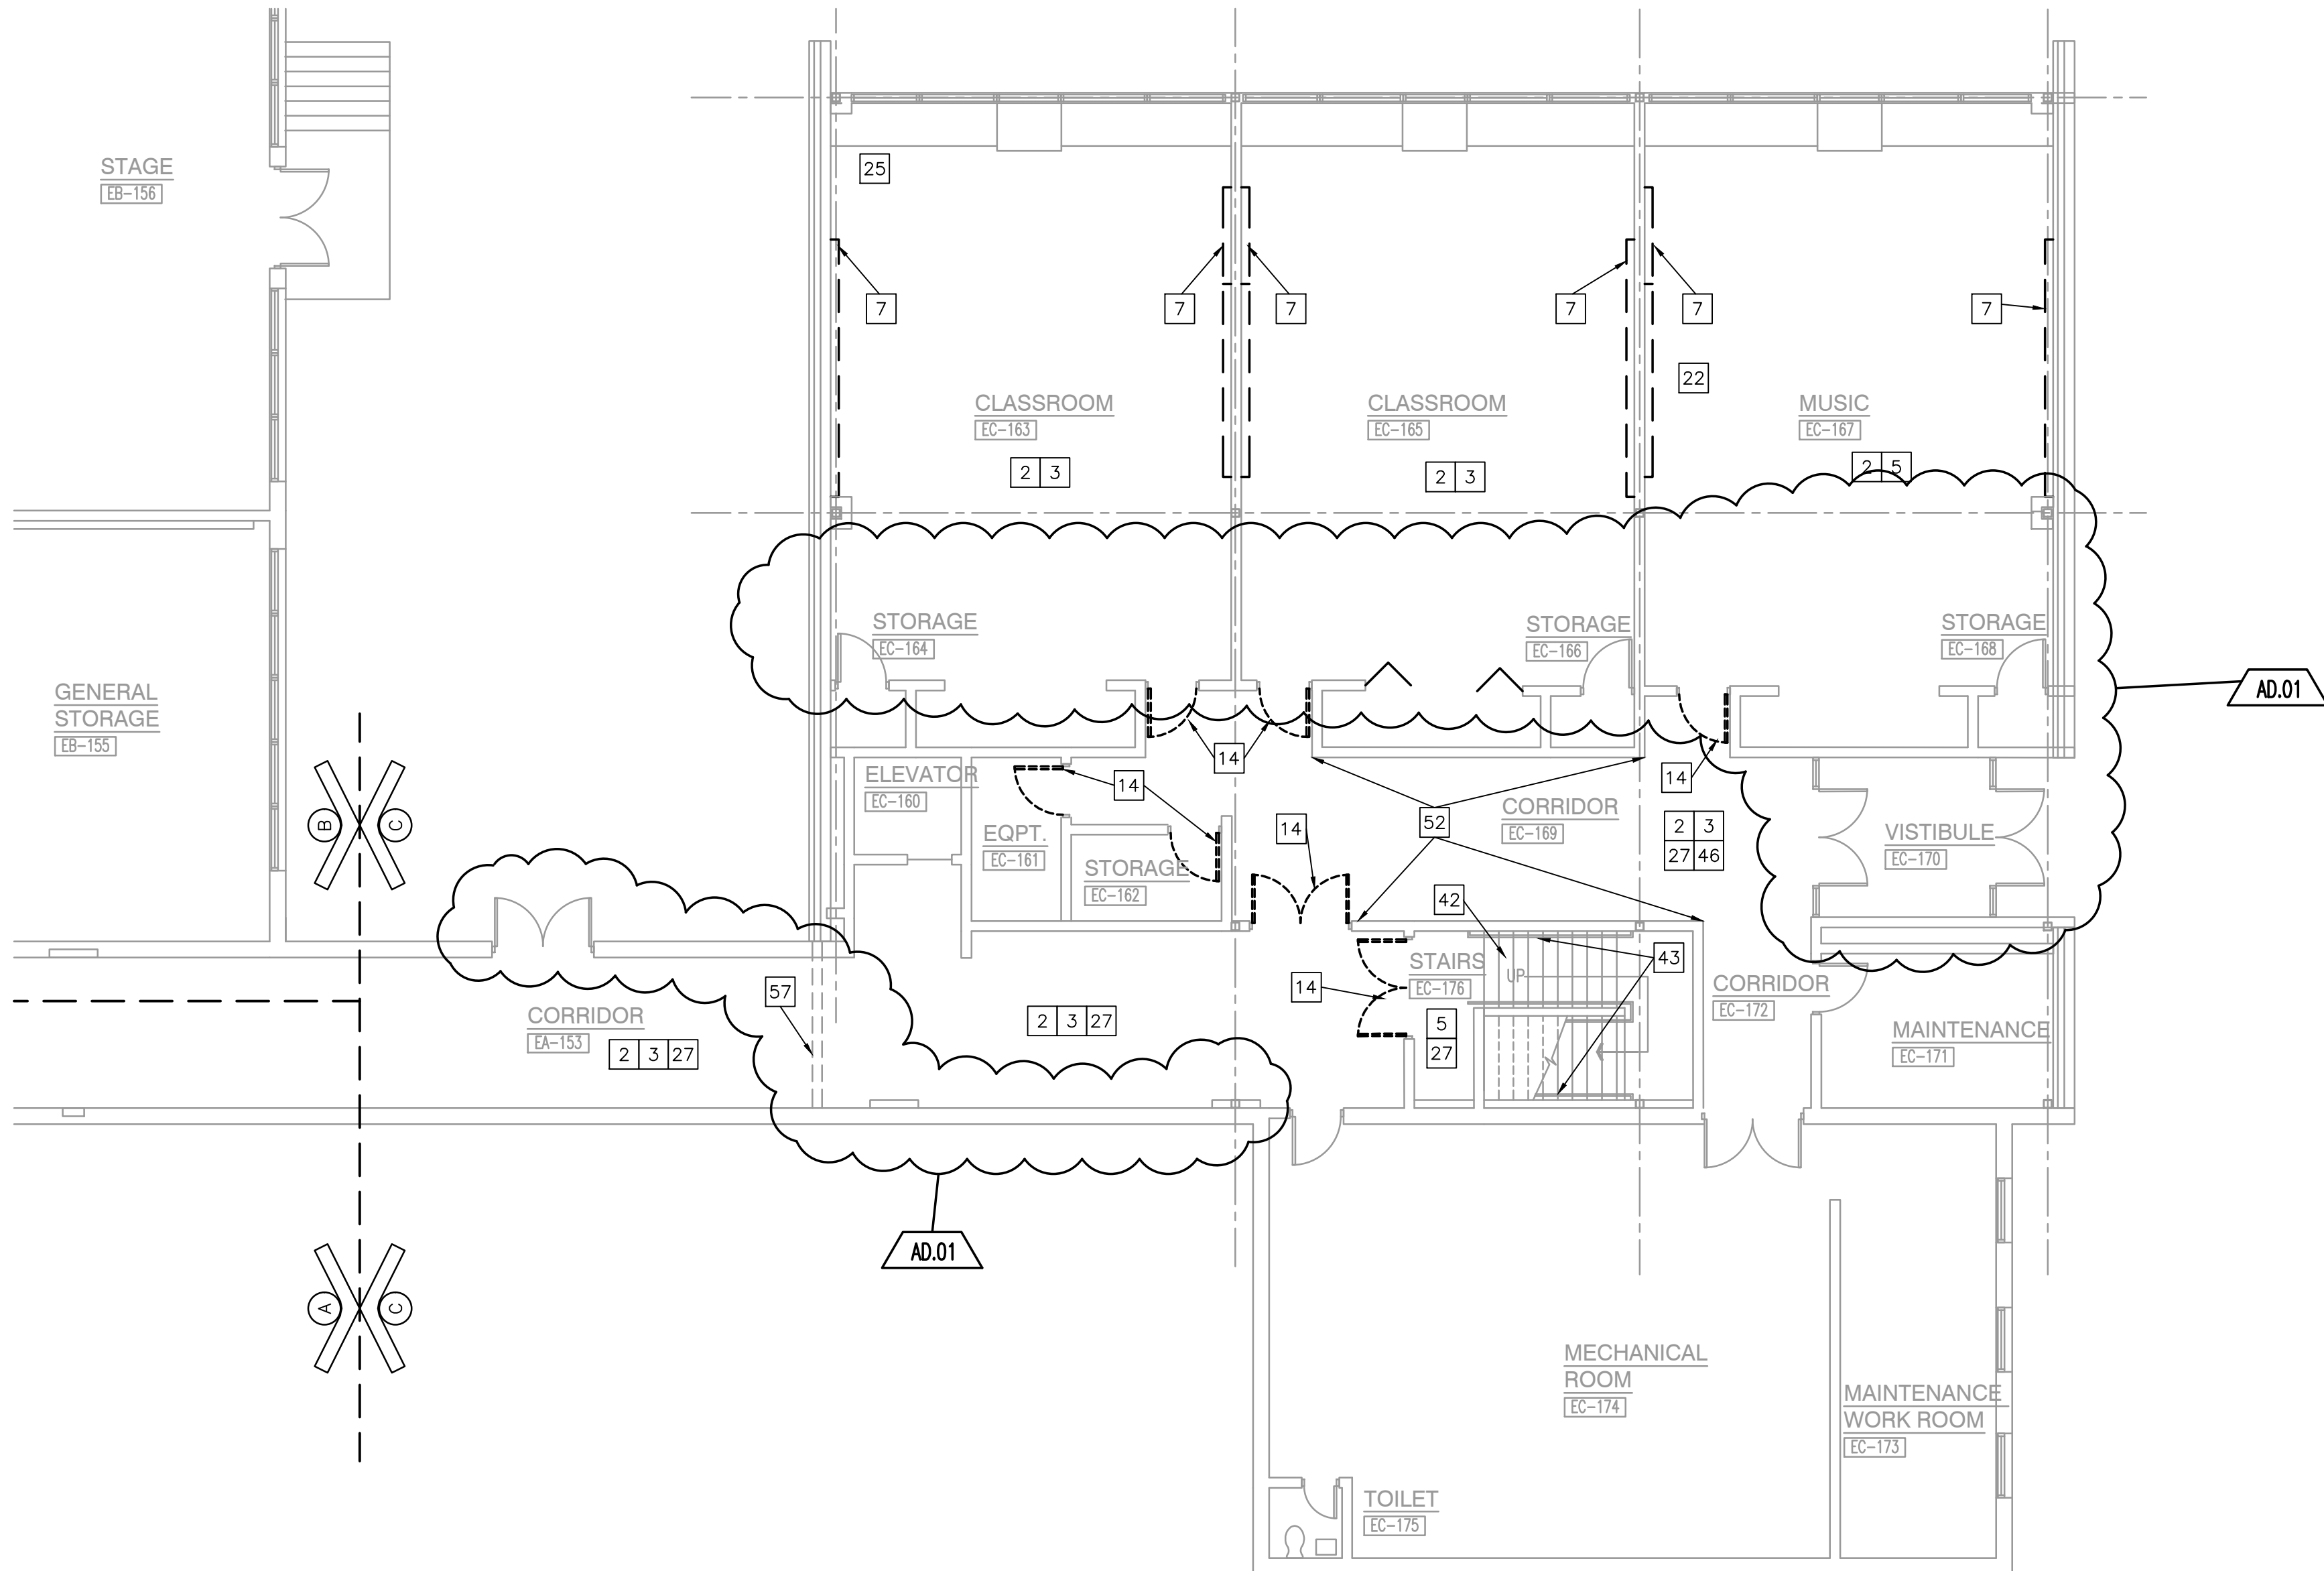

UNIT "C" ARCHITECTURAL LOWER LEVEL FLOOR DEMOLITION PLAN

SCALE: 1/8" = 1'-0"

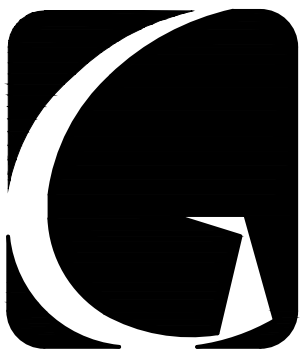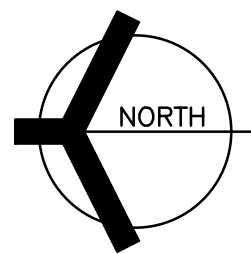

GIBALTAR
DESIGN

ARCHITECTURE • ENGINEERING • INTERIOR DESIGN

PROJECT

**FAIRVIEW
ELEMENTARY
SCHOOL
RENOVATIONS**

LOGANSPOUT COMMUNITY
SCHOOL CORPORATION
LOGANSPOUT, INDIANA

GIBALTAR DESIGN

9102 N. Meridian St., Ste. 300
Indianapolis, IN 46260
Homepage www.GibraltarDesign.com
Email info@GibraltarDesign.com
Phone 317.580.5777 Fax 317.580.5778

PROJECT

20-157

DATE

06/18/21

COORDINATED BY

DJW

DRAWN BY

MMM

CHECKED BY

DJW

COPYRIGHT NOTICE:

THE CONCEPTS, DESIGNS, PLANS, DETAILS, ETC. SHOWN ON THIS DOCUMENT ARE THE PROPERTY OF GIBALTAR DESIGN AND WERE CREATED FOR USE ON THIS SPECIFIC PROJECT. NONE OF THIS INFORMATION SHALL BE USED BY ANY PERSON OR FIRM FOR ANY PURPOSE WITHOUT THE EXPRESS WRITTEN CONSENT OF GIBALTAR DESIGN. THE OWNER MAY RETAIN COPIES FOR INFORMATION AND REFERENCE IN CONNECTION ONLY WITH THIS PROJECT.

REVISIONS

MARK DATE ISSUED FOR

AD.01 7/9/21 AD.01

DRAWING

**UNIT "C" ARCHITECTURAL
LOWER LEVEL DEMOLITION
PLAN**

PROJECT

**FAIRVIEW ELEMENTARY SCHOOL
RENOVATIONS**

© GIBALTAR DESIGN

SHEET

C

AD103

GENERAL DEMOLITION NOTES:

- A. FOR GENERAL PROJECT NOTES, MATERIAL INDICATIONS LEGEND, SYMBOL LEGEND, ABBREVIATIONS, ETC., REFER TO G1 SERIES SHEETS.
- B. UNLESS NOTED OTHERWISE ON THIS SHEET, THE GENERAL CONTRACTOR IS RESPONSIBLE FOR ALL DEMOLITION AND REMOVAL WORK INDICATED ON THIS SHEET.
- C. CONTRACTORS ENCOUNTERING EXISTING MATERIAL WHICH IS SUSPECTED OF CONTAINING ASBESTOS SHALL STOP WORK IMMEDIATELY AND NOTIFY THE OWNER AND THE OWNERS REPRESENTATIVE.
- D. BOLD DASHED LINES INDICATE EXISTING ITEMS TO BE REMOVED UNLESS OTHERWISE NOTED. THE CONTRACTOR SHALL BE RESPONSIBLE FOR FIELD VERIFYING THE EXTENT OF DEMOLITION WORK PRIOR TO BIDDING AND FOR COORDINATING THE EXTENT OF DEMOLITION WITH THE INSTALLATION OF NEW SYSTEMS.
- E. EACH CONTRACTOR SHALL BE RESPONSIBLE FOR ALL DEMOLITION APPLICABLE TO THEIR SCOPE OF WORK AND AS REQUIRED FOR INSTALLATION OF NEW WORK WHETHER OR NOT IT IS SPECIFICALLY INDICATED OR NOTED IN THESE DOCUMENTS.
- F. REMOVE ALL ITEMS AND FINISHES MADE OBSOLETE BY NEW CONSTRUCTION. VERIFY ITEMS DEEMED OBSOLETE WITH ARCHITECT PRIOR TO REMOVAL. REFER TO NEW CONSTRUCTION DRAWINGS FOR DEMOLITION REQUIRED NOT SHOWN ON DEMOLITION PLANS.
- G. EACH CONTRACTOR SHALL BE RESPONSIBLE FOR OFF SITE REMOVAL OF ALL DEMOLITION MATERIALS AND/OR ITEMS UNLESS NOTED OTHERWISE OR DIRECTED BY THE OWNER.
- H. PRIOR TO STARTING DEMOLITION, CONSTRUCT DUST CONTROL BARRIERS AS REQUIRED TO PREVENT THE SPREAD OF DUST INTO SURROUNDING AREAS (WHERE APPLICABLE).
- I. WHERE BUILDING EGRESS IS REQUIRED TO PASS THROUGH DEMOLITION AREAS, PROVIDE APPROVED BARRIERS, ETC. TO ENSURE SAFETY OF THE PUBLIC.
- J. RELOCATED ITEMS SHALL BE CLEANED AND PLACED IN STORAGE, PER OWNERS' DIRECTION, UNTIL ITEMS ARE READY TO BE INSTALLED. IF ITEMS ARE DAMAGED DURING DEMOLITION OR RELOCATION, THEY SHALL BE REPAIRED OR REPLACED WITH NEW ITEMS AS APPROVED.
- K. DEMOLITION SHALL BE PERFORMED WITHOUT DAMAGE TO EXISTING CONSTRUCTION TO REMAIN. WHERE SUCH DAMAGE OCCURS, PATCH, REPAIR, OR RESTORE WALLS, FLOORS, CEILING, ETC. NEATLY TO MATCH EXISTING ADJACENT SURFACE. PROVIDE SHORING, BRACING, OR SUPPORT AS REQUIRED TO PREVENT MOVEMENT OR SETTLEMENT OF EXISTING STRUCTURES.
- L. EACH CONTRACTOR IS RESPONSIBLE FOR CUTTING, PATCHING, AND DISCONNECTION OF ITEMS APPLICABLE TO THEIR SCOPE OF WORK. WHERE EXISTING SERVICES ARE ABANDONED, CAP AT LEAST 1" BEHIND NEW FINISHES AND/OR EXISTING SURFACE AND PATCH AS REQUIRED TO RECEIVE NEW FINISHES OR MATCH EXISTING FINISH.
- M. ON WALLS THAT ARE TO RECEIVE NEW FINISHES, REMOVE AND REINSTALL EXISTING EQUIPMENT TO REMAIN AS REQUIRED FOR INSTALLATION OF NEW FINISHES.
- N. WHERE WALLS OR BULKHEADS ARE REMOVED, PATCH FLOORS, CEILINGS, AND ADJACENT WALLS AS REQUIRED TO MATCH EXISTING OR RECEIVE NEW FINISHES WHERE APPLICABLE. WHERE EXISTING DUCTWORK, PIPING, OR EQUIPMENT IS REMOVED, PATCH OPENINGS AND/OR SURFACES AS REQUIRED TO MATCH ADJACENT SURFACES OR RECEIVE NEW FINISHES WHERE APPLICABLE. REFER TO ALL DEMOLITION DRAWINGS FOR EXTENT OF ITEMS TO BE REMOVED.
- O. OVER CUT NEW OPENINGS IN EXISTING WALL AS REQUIRED FOR NEW CONSTRUCTION. PATCH AND REPAIR WALLS AS REQUIRED TO MATCH EXISTING. WHERE APPLICABLE, TOOTH NEW MASONRY INTO EXISTING MASONRY.
- P. ALL EQUIPMENT AND FURNITURE WHICH ARE CONSIDERED LOOSE FURNISHING SHALL BE REMOVED BY THE OWNER PRIOR TO DEMOLITION.
- Q. MASONRY WALLS TO BE REMOVED SHALL BE REMOVED TO A POINT 2" MINIMUM BELOW THE EXISTING FLOOR SLAB UNLESS SETTING ON A SLAB OR SPECIFICALLY NOTED OTHERWISE. PATCH WITH NEW CONCRETE TO BE FLUSH WITH THE EXISTING FLOOR SLAB.
- R. EACH CONTRACTOR SHALL BE RESPONSIBLE FOR GENERAL REVIEW OF DEMOLITION NOTES AND GENERAL DEMOLITION NOTES AS THEY APPLY TO THEIR SCOPE OF WORK.
- S. THE OWNER SHALL RESERVE THE RIGHT TO CLAIM ANY MATERIALS THAT ARE BEING DEMOLISHED PRIOR TO THE CONTRACTOR DISPOSING OF THEM OFF SITE.
- T. REFER TO THE STRUCTURAL, MECHANICAL, PLUMBING, ELECTRICAL AND TECHNOLOGY DOCUMENTS FOR COMPLETE SCOPE OF DEMOLITION WORK.
- U. "FLOORING" DENOTES FLOOR COVERING MATERIALS INCLUDING BACKING, ADHESIVES, AND BASES DOWN TO BUT EXCLUSIVE OF FLOOR SLABS AND STRUCTURAL MATERIALS UNLESS NOTED OTHERWISE.
- V. DEMOLITION IS TO FOLLOW ESTABLISHED CONSTRUCTION SEQUENCE. REFER TO SPECIFICATIONS AND DRAWINGS FOR REQUIREMENTS AND SPECIAL CONDITIONS.
- W. WHERE APPLICABLE SALVAGE EXISTING MASONRY (FACE BRICK, GLAZED CMU, FACING TILE) AS REQUIRED FOR PATCHING AND INFILL IN RENOVATED AREAS WHERE INDICATED. DISCARD UNUSED PORTION OFF SITE.

DEMOLITION PLAN NOTES:

(ALL PLAN NOTES MAY NOT BE INDICATED ON THIS SHEET.)

- 1 REMOVE SHELVING IN ITS ENTIRETY.
- 2 REMOVE ACoustICAL BOARD CEILING SYSTEM IN ITS ENTIRETY.
- 3 REMOVE CARPET FLOORING SYSTEM, INCLUDING BASE, IN ITS ENTIRETY. PREPARE FLOOR FOR NEW FINISHES.
- 4 REMOVE FREE STANDING TACKABLE PARTITION. PATCH AND REPAIR FLOOR AS REQUIRED TO ACCEPT NEW FINISHES.
- 5 REMOVE VCT/SHEET VINYL FLOORING SYSTEM, INCLUDING BASE, IN ITS ENTIRETY. PREPARE FLOOR FOR NEW FINISHES.
- 6 REMOVE CERAMIC OR PORCELAIN TILE FLOORING SYSTEM, INCLUDING BASE, IN ITS ENTIRETY. PREPARE FLOOR FOR NEW FINISHES.
- 7 REMOVE TACK BOARD, MARKER BOARD OR CHALKBOARD IN THEIR ENTIRETY. PATCH WALL AS REQUIRED TO RECEIVE NEW FINISHES.
- 8 REMOVE CASEWORK IN ITS ENTIRETY. PATCH AND REPAIR WALL AND FLOOR AS REQUIRED TO ACCEPT NEW FINISHES.
- 9 REMOVE METAL STUD AND PLASTER/GYPSUM BOARD WALL IN ITS ENTIRETY. PATCH AND REPAIR ADJACENT WALL AND FLOOR AS REQUIRED TO ACCEPT NEW FINISHES.
- 10 REMOVE PLUMBING FIXTURE IN ITS ENTIRETY. CUT AND CAP LINE BELOW WALL OR FLOOR SURFACE. UNLESS OTHERWISE NOTED ON PLUMBING DRAWINGS. PATCH AND REPAIR FLOOR AND/OR WALL AS REQUIRED TO ACCEPT NEW FINISHES.
- 11 REMOVE TOILET AND PARTITIONS IN THEIR ENTIRETY.
- 12 REMOVE MASONRY WALL (AS REQUIRED FOR NEW CONSTRUCTION.) PATCH AND REPAIR FLOOR AND WALL AS REQUIRED TO ACCEPT NEW FINISHES.
- 13 REMOVE HOLLOW METAL DOOR, FRAME AND HARDWARE IN ITS ENTIRETY.
- 14 REMOVE DOOR AND HARDWARE. HOLLOW METAL FRAME TO REMAIN.
- 15 REMOVE METAL STUD AND PLASTER BULKHEAD IN ITS ENTIRETY. PATCH AND REPAIR WALL AS REQUIRED TO RECEIVE NEW FINISHES.
- 16 REMOVE METAL STUD AND GYPSUM BOARD BULKHEAD IN ITS ENTIRETY. PATCH AND REPAIR WALL AS REQUIRED FOR NEW FINISHES.
- 17 REMOVE EXISTING METAL SURROUND AS REQUIRED FOR NEW CONSTRUCTION.
- 18 REMOVE TOILET ACCESSORIES AND TURN OVER TO THE OWNER.
- 19 REMOVE EXISTING MOVABLE STORAGE UNIT IN ITS ENTIRETY.
- 20 REMOVE PLASTER SOFFIT AS REQUIRED FOR NEW CONSTRUCTION.
- 21 REMOVE EXISTING FLOOR DRAIN. REFER TO PLUMBING DRAWINGS.
- 22 REMOVE PROJECTOR. TURN OVER TO OWNER.
- 23 EXISTING STEEL COLUMN TO REMAIN.
- 24 REMOVE CONCRETE SLAB IN ITS ENTIRETY.
- 25 REMOVE CEILING MOUNTED T.V. IN ITS ENTIRETY. TURN OVER TO OWNER.
- 26 REMOVE MECHANICAL UNIT. MAKE READY TO RECEIVE NEW FINISHES. REFER TO MECHANICAL DRAWINGS.
- 27 REMOVE CARPET WANSOT AND TRIM IN ITS ENTIRETY. PREPARE WALL FOR NEW FINISHES.
- 28 REMOVE EXISTING DISPLAY CASE. PATCH WALL AS REQUIRED TO RECEIVE NEW FINISHES.
- 29 REMOVE MASONRY BRICK (AS REQUIRED FOR NEW CONSTRUCTION.) REPAIR WALL AS REQUIRED TO ACCEPT NEW FINISHES.
- 30 REMOVE CEILING MOUNTED MECHANICAL UNIT IN ITS . REFER TO MECHANICAL DRAWINGS.
- 31 REMOVE FIRE EXTINGUISHER. TURN OVER TO OWNER. PATCH AND REPAIR WALL AS REQUIRED TO RECEIVE NEW FINISHES.
- 32 REMOVE MECHANICAL PIPING. PATCH CONCRETE FLOOR AS REQUIRED TO RECEIVE NEW FINISHES. REFER TO STRUCTURAL DRAWINGS FOR FLOOR PATCH.




GIBRALTAR
DESIGN

ARCHITECTURE • ENGINEERING • INTERIOR DESIGN

PROJECT

**FAIRVIEW
ELEMENTARY
SCHOOL
RENOVATIONS**

LOGANSPOrt COMMUNITY
SCHOOL CORPORATION
LOGANSPOrt, INdIANA

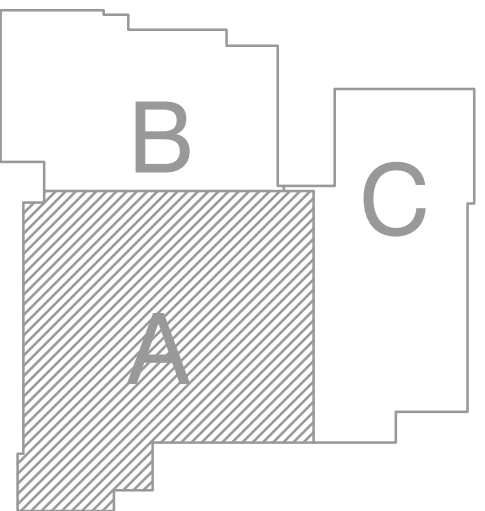

GIBRALTAR DESIGN

9102 N. Meridian St., Ste. 300
Indianapolis, IN 46260
Homepage: www.GibraltarDesign.com
Email: info@GibraltarDesign.com
Phone: 317.580.5777 Fax: 317.580.5778

PROJECT

20-157

DATE

06/18/21

COORDINATED BY

DJW

DRAWN BY

MMM

CHECKED BY

DJW

DATE

06/18/21

COORDINATED BY

DJW

DRAWN BY

MMM

CHECKED BY

DJW

DATE

06/18/21

COORDINATED BY

DJW

DRAWN BY

MMM

CHECKED BY

DJW

DATE

06/18/21

COORDINATED BY

DJW

DRAWN BY

MMM

CHECKED BY

DJW

DATE

06/18/21

COORDINATED BY

DJW

DRAWN BY

MMM

CHECKED BY

DJW

DATE

06/18/21

COORDINATED BY

DJW

DRAWN BY

MMM

CHECKED BY

DJW

DATE

06/18/21

COORDINATED BY

DJW

DRAWN BY

MMM

CHECKED BY

DJW

DATE

06/18/21

COORDINATED BY

DJW

DRAWN BY

MMM

CHECKED BY

DJW

DATE

06/18/21

COORDINATED BY

DJW

DRAWN BY

MMM

CHECKED BY

DJW

DATE

06/18/21

COORDINATED BY

DJW

DRAWN BY

MMM

CHECKED BY

DJW

DATE

06/18/21

COORDINATED BY

DJW

DRAWN BY

MMM

CHECKED BY

DJW

DATE

06/18/21

COORDINATED BY

DJW

DRAWN BY

MMM

CHECKED BY

DJW

DATE

06/18/21

COORDINATED BY

DJW

DRAWN BY

MMM

CHECKED BY

DJW

DATE

06/18/21

COORDINATED BY

DJW

DRAWN BY

MMM

CHECKED BY

DJW

DATE

06/18/21

COORDINATED BY

DJW

DRAWN BY

MMM

CHECKED BY

DJW

DATE

06/18/21

COORDINATED BY

DJW

DRAWN BY

MMM

CHECKED BY

DJW

DATE

06/18/21

COORDINATED BY

DJW

DRAWN BY

MMM

CHECKED BY

DJW

DATE

06/18/21

COORDINATED BY

DJW

DRAWN BY

MMM

CHECKED BY

DJW

DATE

06/18/21

COORDINATED BY

DJW

DRAWN BY

MMM

CHECKED BY

DJW

DATE

06/18/21

COORDINATED BY

DJW

DRAWN BY

MMM

CHECKED BY

DJW

DATE

06/18/21

COORDINATED BY

DJW

DRAWN BY

MMM

CHECKED BY

DJW

DATE

06/18/21

COORDINATED BY

DJW

DRAWN BY

MMM

CHECKED BY

DJW

DATE

06/18/21

COORDINATED BY

DJW

DRAWN BY

MMM

CHECKED BY

DJW

DATE

06/18/21

COORDINATED BY

DJW

DRAWN BY

MMM

CHECKED BY

DJW

DATE

06/18/21

COORDINATED BY

DJW

DRAWN BY

MMM

CHECKED BY

DJW

DATE

06/18/21

COORDINATED BY

DJW

DRAWN BY

MMM

CHECKED BY

DJW

DATE

06/18/21

COORDINATED BY

DJW

DRAWN BY

MMM

CHECKED BY

DJW

DATE

06/18/21

COORDINATED BY

DJW

DRAWN BY

MMM

CHECKED BY

DJW

DATE

06/18/21

COORDINATED BY

DJW

DRAWN BY

MMM

CHECKED BY

DJW

DATE

06/18/21

COORDINATED BY

DJW

DRAWN BY

MMM

CHECKED BY

DJW

DATE

06/18/21

COORDINATED BY

DJW

DRAWN BY

MMM

CHECKED BY

DJW

DATE

06/18/21

GENERAL PLAN NOTES:

- A. FOR GENERAL PROJECT NOTES, MATERIAL INDICATIONS LEGEND, SYMBOL LEGEND, ABBREVIATIONS, ETC., REFER TO GI SERIES SHEETS.
- B. PLAN DIMENSIONS TO MASONRY WALLS ARE TO FACE OF ROUGH MASONRY. PLAN DIMENSIONS TO STUD WALLS ARE TO FACE OF FINISHED GYPSUM BOARD OR PLASTER. PLAN DIMENSIONS TO STUD WALLS WITH CERAMIC TILE FINISH ARE TO THE FACE OF TILE BACKER BOARD.
- C. ALL CMU WALLS THAT DO NOT LAY OUT IN FULL OR HALF LENGTHS SHOULD BE BALANCED SO AS NOT TO HAVE ANY PIECES LESS THAN 4" IN SIZE EXPOSED TO VIEW.
- D. MASONRY WALLS BEARING ON A THICKENED SLAB AT SLAB DEPRESSIONS REQUIRE CUT MASONRY UNITS SO THAT COURSING BEGINS AT THE FLOOR LINE.
- E. THE BASE FIRST FLOOR ELEVATION INDICATED FOR THE PROJECT IS 100'-0". REFER TO SITE PLAN FOR CORRELATION TO USGS DATUM.
- F. HINGE SIDE OF DOOR JAMB AT CMU WALLS SHALL BE LOCATED 8" MINIMUM FROM ADJACENT WALL AND HINGE SIDE OF DOOR JAMB AT GYPSUM BOARD WALLS SHALL BE LOCATED 4" MINIMUM FROM ADJACENT WALL UNLESS NOTED OTHERWISE.
- G. PROVIDE WOOD BLOCKING (OR METAL STRAPPING WHERE APPLICABLE) AS REQUIRED WITHIN METAL STUD WALLS FOR WALL MOUNTED ITEMS.
- H. REFER TO LIFE SAFETY PLANS REGARDING FIRE RATED WALL LOCATIONS AND OTHER CODE INFORMATION.
- I. INTERIOR CMU WALLS ARE TO BE RUNNING BOND UNLESS NOTED OTHERWISE.
- J. WHERE NEW CMU WALLS INTERSECT EXISTING CMU WALLS AT A CORNER OR ARE ALIGNED WITH EXISTING CMU WALLS, TOOTH NEW CMU INTO EXISTING CMU UNLESS NOTED OTHERWISE.
- K. REFER TO FINISH PLANS FOR LOCATION AND EXTENT OF FINISHED FLOOR AND WALL MATERIAL.
- L. ALL EXPOSED CONCRETE MASONRY UNITS (CMU) CORNERS ARE TO BE BULLNOSED, EXCEPT AT MASONRY BULKHEADS AND EXTERIOR WINDOW JAMBS.
- M. REFER TO SHEET A-420 FOR REFERENCES TO ENLARGED TOILET ROOM PLANS AND TOILET ACCESSORIES.
- N. REFER TO DEMOLITION SHEETS FOR ADDITIONAL PATCHING AND REPAIR WORK.

PLAN LEGEND:

- INDICATES MISCELLANEOUS CASEWORK ELEVATION SYMBOL - REFER TO A-700 SERIES DRAWINGS FOR ELEVATIONS AND DETAILS.
- ⬢ INDICATES STOREFRONT, CURTAIN WALL, OR WINDOW SYSTEM. REFER TO A-600 SERIES DRAWINGS FOR ELEVATIONS AND DETAILS.
- ◇ INDICATES WALL TYPES REFER TO G-301 FOR WALL THICKNESS, HEIGHT, AND COMPOSITION.
- X'-X" INDICATES CEILING/BULKHEAD HEIGHT ABOVE FINISHED FLOOR
- (TB) INDICATES 4" HIGH TACK BOARD LENGTH AS INDICATED, REFER TO MOUNTING HEIGHT DRAWING.
- (MB) INDICATES 4" HIGH MARKER BOARD LENGTH AS INDICATED, REFER TO MOUNTING HEIGHT DRAWING.
- △ INDICATES CASEWORK, REFER TO A-710.

PLAN NOTES:

(ALL PLAN NOTES MAY NOT BE INDICATED ON THIS SHEET.)

- 1 MILLWORK.
- 2 FILL OPENING WITH CMU. FINISH SURFACE FLUSH WITH ADJACENT CMU.
- 3 COPIER BY OWNER.
- 4 CUBICAL CURTAIN AND TRACK.
- 5 ELECTRIC WATER COOLER, SEE PLUMBING DRAWINGS.
- 6 REFRIGERATOR BY OWNER.
- 7 MECHANICAL VUV. SEE MECHANICAL DRAWINGS.
- 8 CEILING BULKHEAD REFER TO 900 SERIES DRAWINGS.
- 9 FILL IN OPENING WITH NEW CMU. FINISH FLUSH WITH ADJACENT WALL SURFACE.
- 10 MOP SINK - SEE PLUMBING DRAWINGS.
- 11 PATCH END OF WALL AND PREP FOR NEW FINISH.
- 12 TOILET PARTITION.
- 13 PATCH EXISTING PLUMBING CHASE OPENING.
- 14 ELECTRIC BOTTLE FILL, SEE PLUMBING DRAWINGS.
- 15 FILL OPENING WITH STUD WALL. FINISH SURFACE FLUSH WITH ADJACENT CMU.
- 16 FILL IN RECESS MAT WITH "ARDEX SD-P", SELF DRYING TROWEL-ABLE CONCRETE UNDERLAYMENT.
- 17 ALTERNATE.
- 18 LAMINATE 1/2" GYPSUM BOARD TO CMU WALL.
- 19 INTERIOR LETTERING, REFER TO SPECIFICATION.
- 20 DEDICATION PLAQUE, REFER TO SPECIFICATION.
- 21 DATE STONE, REFER TO SPECIFICATION.
- 22 DISPLAY CASE, SEE
- 23 CONCRETE VOID SLAB - SEE STRUCTURAL.
- 24 FILL IN RECESS AREA WITH TROWABLE CONCRETE UNDERLAYMENT.




GIBRALTAR
DESIGN

ARCHITECTURE • ENGINEERING • INTERIOR DESIGN

PROJECT

**FAIRVIEW
ELEMENTARY
SCHOOL
RENOVATIONS**

LOGANSPORT COMMUNITY
SCHOOL CORPORATION
LOGANSPORT, INDIANA

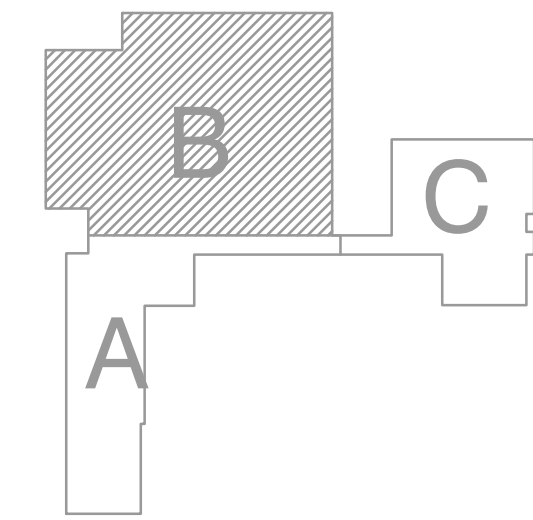

GIBRALTAR DESIGN

9102 N. Meridian St., Ste. 300
Indianapolis, IN 46260
Homepage: www.GibraltarDesign.com
Email: info@GibraltarDesign.com
Phone: 317.580.5777 Fax: 317.580.5778

PROJECT

20-157

DATE

06/18/21

COORDINATED BY

DJW

DRAWN BY

MMM

CHECKED BY

DJW

COPYRIGHT NOTICE:
THE CONCEPTS, DESIGNS, PLANS, DETAILS, ETC., SHOWN ON THIS DOCUMENT ARE THE PROPERTY OF GIBRALTAR DESIGN AND WERE CREATED FOR USE ON THIS SPECIFIC PROJECT. NONE OF THIS INFORMATION SHALL BE USED BY ANY PERSON OR FIRM FOR ANY PURPOSE WITHOUT THE EXPRESS WRITTEN CONSENT OF GIBRALTAR DESIGN. THE OWNER MAY RETAIN COPIES FOR INFORMATION AND REFERENCE IN CONNECTION ONLY WITH THIS PROJECT.

REVISIONS

MARK	DATE	ISSUED FOR
AD.01	7/9/21	AD.01

DRAWING

UNIT "B" ARCHITECTURAL
LOWER LEVEL FLOOR PLAN

PROJECT


FAIRVIEW ELEMENTARY SCHOOL
RENOVATIONS

© GIBRALTAR DESIGN

SHEET


B


A-102

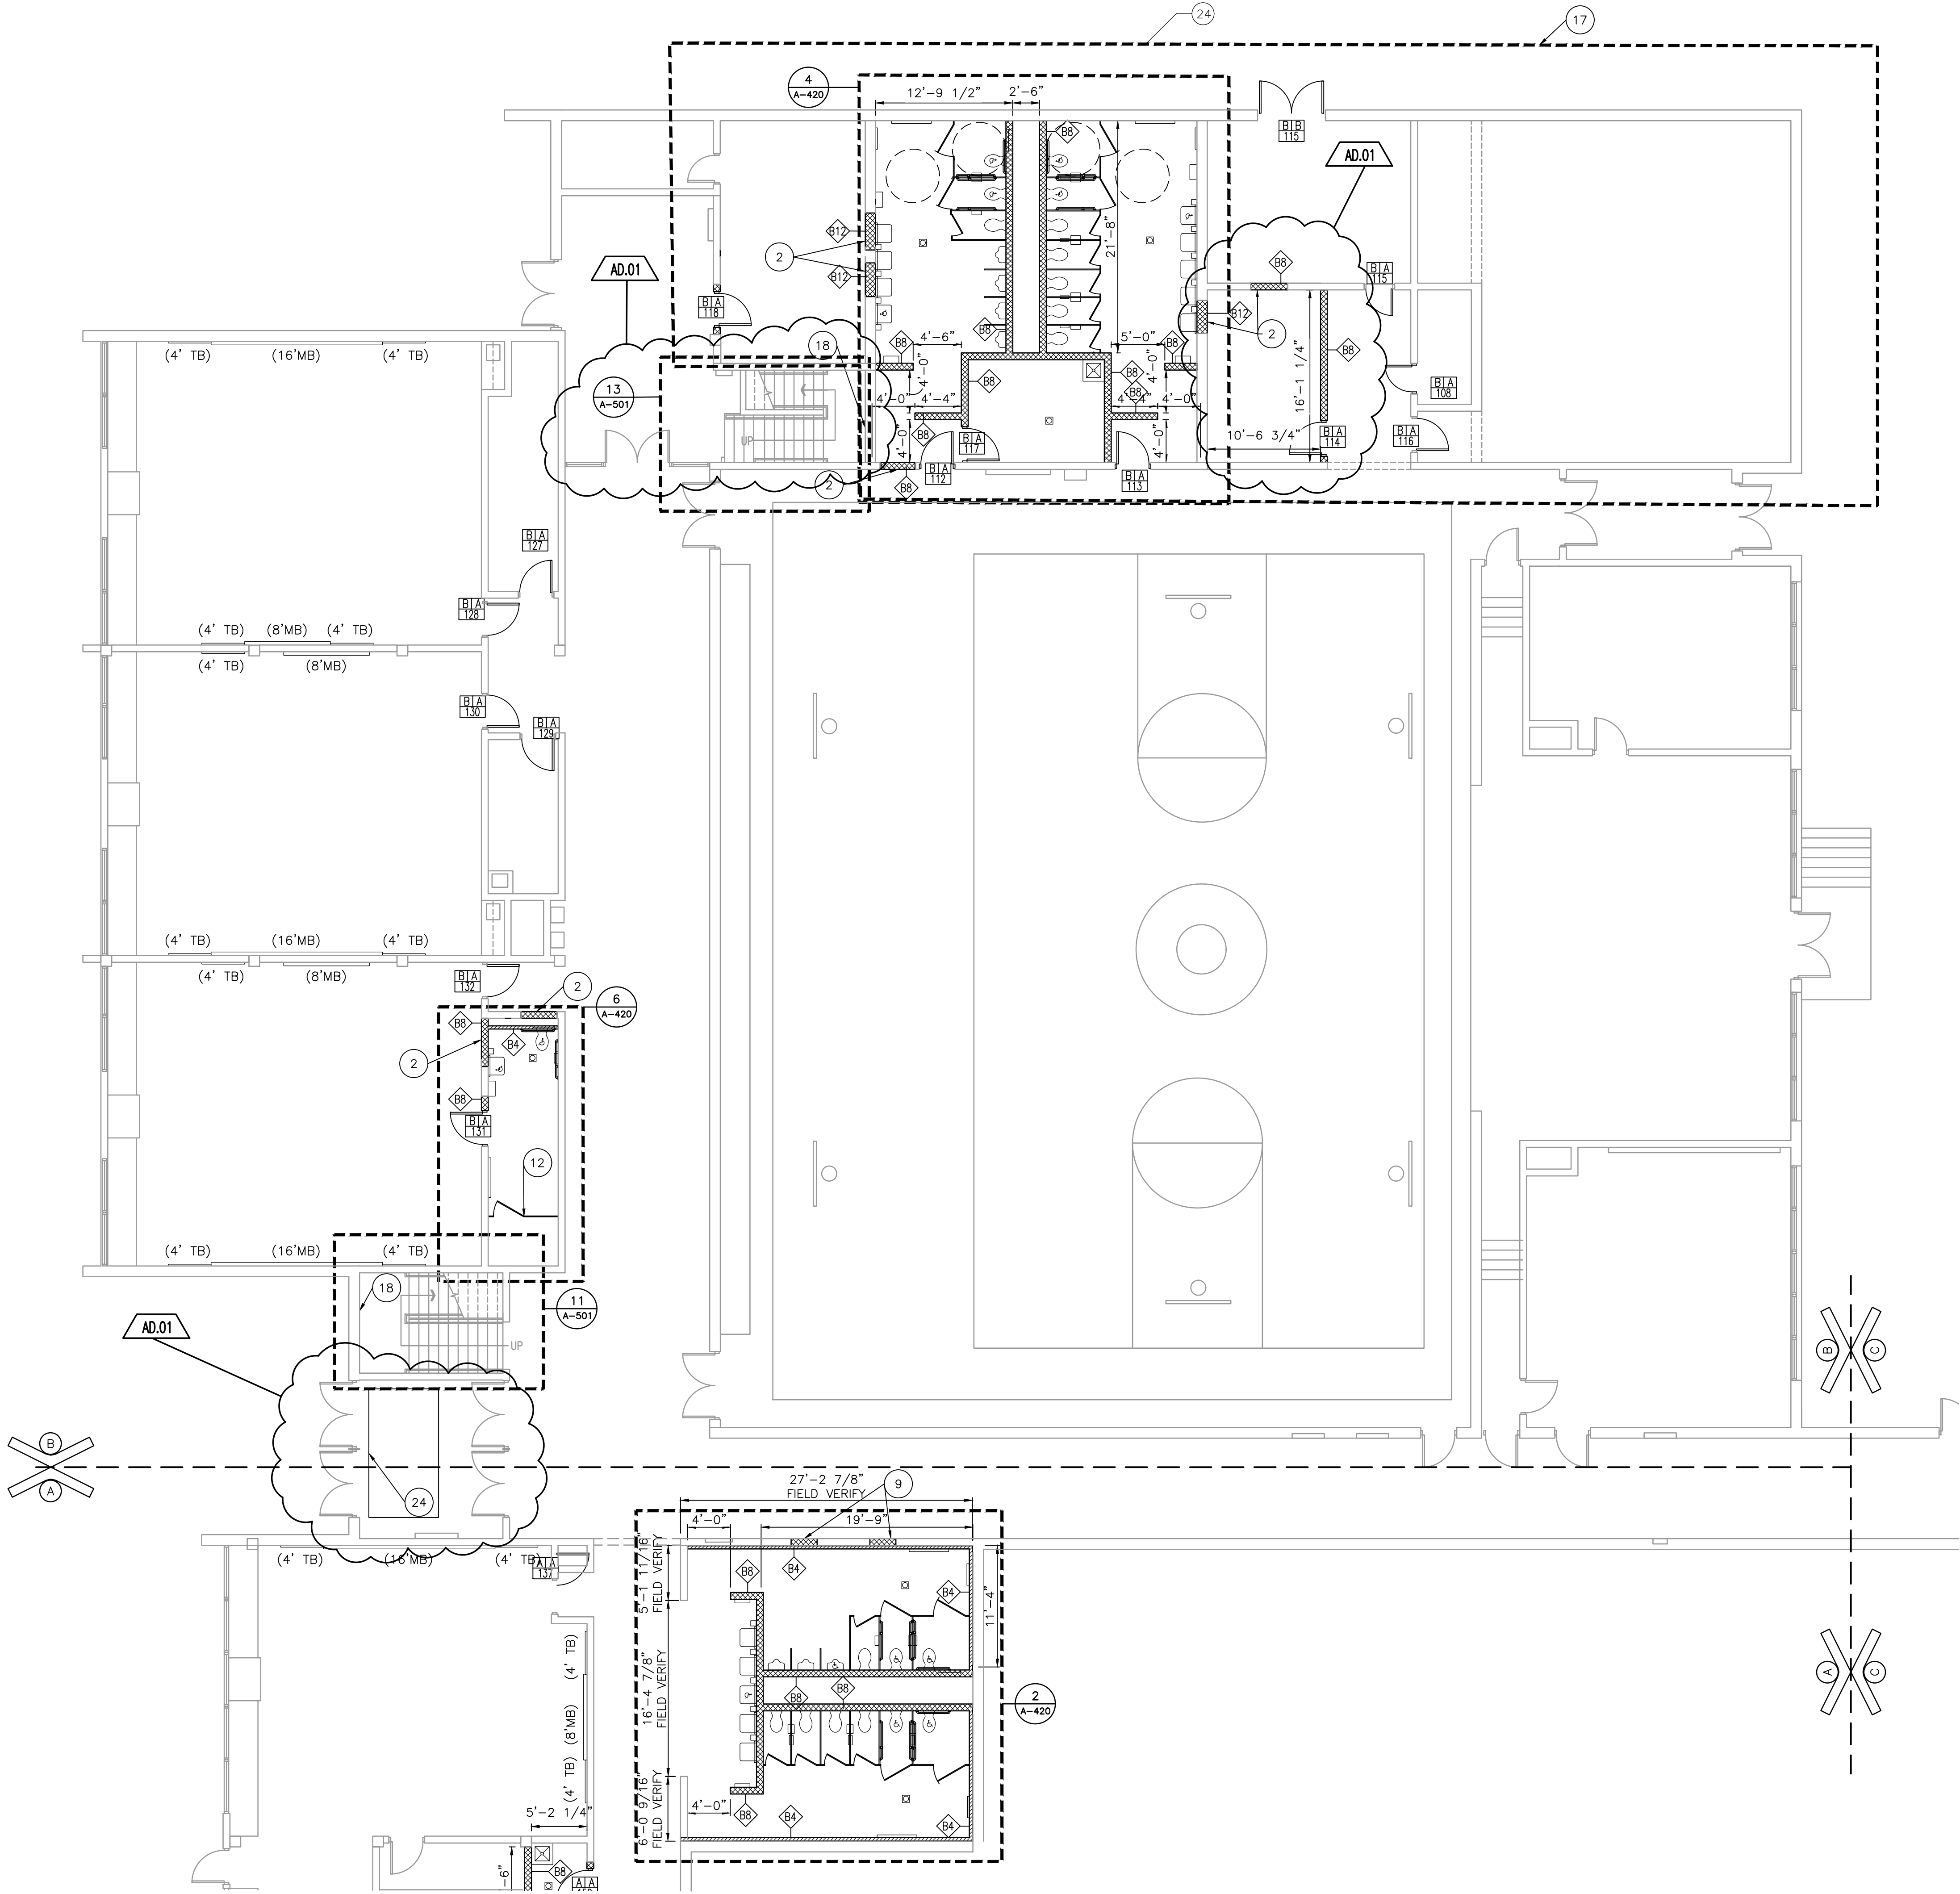

UNIT "B" ARCHITECTURAL LOWER LEVEL FLOOR PLAN

SCALE: 1/8" = 1'-0"

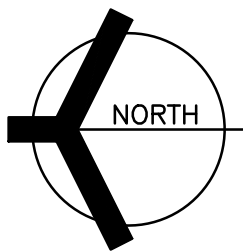

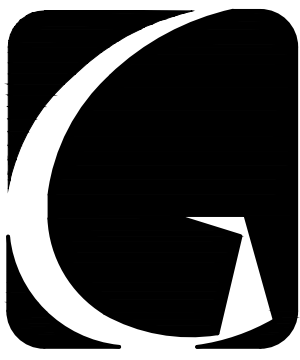


GIBRALTAR
DESIGN

ARCHITECTURE • ENGINEERING • INTERIOR DESIGN

PROJECT

FAIRVIEW ELEMENTARY SCHOOL RENOVATIONS

LOGANSPORT COMMUNITY
SCHOOL CORPORATION
LOGANSPORT, INDIANA

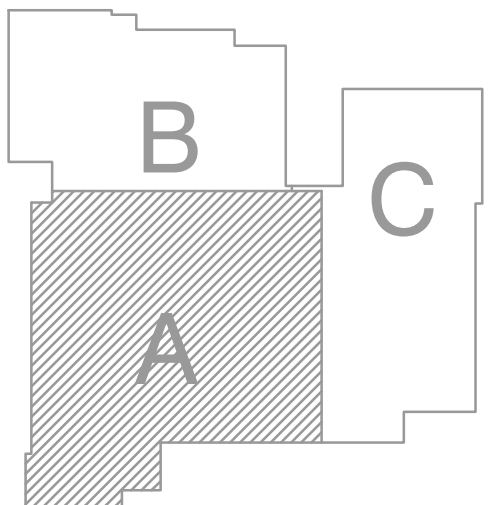

GIBRALTAR DESIGN

9102 N. Meridian St., Ste. 300
Indianapolis, IN 46260
Homepage: www.GibraltarDesign.com
Email: info@GibraltarDesign.com
Phone: 317.580.5777 Fax: 317.580.5778

PROJECT

20-157

DATE

06/18/21

COORDINATED BY

DJW

DRAWN BY

MMM

CHECKED BY

DJW

COPYRIGHT NOTICE:
THE CONCEPTS, DESIGNS, PLANS, DETAILS, ETC., SHOWN ON
THIS DOCUMENT ARE THE PROPERTY OF GIBRALTAR DESIGN AND
WERE CREATED FOR USE ON THIS SPECIFIC PROJECT. NONE OF
THIS INFORMATION SHALL BE USED BY ANY PERSON OR FIRM
FOR ANY PURPOSE WITHOUT THE EXPRESS WRITTEN CONSENT
OF GIBRALTAR DESIGN. THE OWNER MAY RETAIN COPIES FOR
INFORMATION AND REFERENCE IN CONNECTION ONLY WITH THIS
PROJECT.

REVISIONS

MARK DATE ISSUED FOR

AD.01 7/9/21 AD.01

DRAWING

UNIT "A" ARCHITECTURAL

FIRST FLOOR PLAN

PROJECT

FAIRVIEW ELEMENTARY SCHOOL

RENOVATIONS

© GIBRALTAR DESIGN SHEET

A A-104

GENERAL PLAN NOTES:

- FOR GENERAL PROJECT NOTES, MATERIAL INDICATIONS LEGEND, SYMBOL LEGEND, ABBREVIATIONS, ETC., REFER TO G1 SERIES SHEETS.
- PLAN DIMENSIONS TO MASONRY WALLS ARE TO FACE OF ROUGH MASONRY. PLAN DIMENSIONS TO STUD WALLS ARE TO FACE OF FINISHED GYPSUM BOARD OR PLASTER. PLAN DIMENSIONS TO STUD WALLS WITH CERAMIC TILE FINISH ARE TO THE FACE OF TILE BACKER BOARD.
- ALL CMU WALLS THAT DO NOT LAY OUT IN FULL OR HALF LENGTHS SHOULD BE BALANCED SO AS NOT TO HAVE ANY PIECES LESS THAN 4" IN SIZE EXPOSED TO VIEW.
- MASONRY WALLS BEARING ON A THICKENED SLAB AT SLAB DEPRESSIONS REQUIRE CUT MASONRY UNITS SO THAT COURSING BEGINS AT THE FLOOR LINE.
- THE BASE FIRST FLOOR ELEVATION INDICATED FOR THE PROJECT IS 100'-0". REFER TO SITE PLAN FOR CORRELATION TO USGS DATUM.
- HINGE SIDE OF DOOR JAMB AT CMU WALLS SHALL BE LOCATED 8" MINIMUM FROM ADJACENT WALL AND HINGE SIDE OF DOOR JAMB AT GYPSUM BOARD WALLS SHALL BE LOCATED 4" MINIMUM FROM ADJACENT WALL UNLESS NOTED OTHERWISE.
- PROVIDE WOOD BLOCKING (OR METAL STRAPPING WHERE APPLICABLE) AS REQUIRED WITHIN METAL STUD WALLS FOR WALL MOUNTED ITEMS.
- REFER TO LIFE SAFETY PLANS REGARDING FIRE RATED WALL LOCATIONS AND OTHER CODE INFORMATION.
- INTERIOR CMU WALLS ARE TO BE RUNNING BOND UNLESS NOTED OTHERWISE.
- WHERE NEW CMU WALLS INTERSECT EXISTING CMU WALLS AT A CORNER OR ARE ALIGNED WITH EXISTING CMU WALLS, TOOTH NEW CMU INTO EXISTING CMU UNLESS NOTED OTHERWISE.
- REFER TO FINISH PLANS FOR LOCATION AND EXTENT OF FINISHED FLOOR AND WALL MATERIAL.
- ALL EXPOSED CONCRETE MASONRY UNITS (CMU) CORNERS ARE TO BE BULLNOSED, EXCEPT AT MASONRY BULKHEADS AND EXTERIOR WINDOW JAMBS.
- REFER TO SHEET A-420 FOR REFERENCES TO ENLARGED TOILET ROOM PLANS AND TOILET ACCESSORIES.
- REFER TO DEMOLITION SHEETS FOR ADDITIONAL PATCHING AND REPAIR WORK.


PLAN LEGEND:

- INDICATES MISCELLANEOUS CASEWORK ELEVATION SYMBOL - REFER TO A-700 SERIES DRAWINGS FOR ELEVATIONS AND DETAILS.
- INDICATES STOREFRONT, CURTAIN WALL, OR WINDOW SYSTEM. REFER TO A-600 SERIES DRAWINGS FOR ELEVATIONS AND DETAILS.
- INDICATES WALL TYPES REFER TO G-301 FOR WALL THICKNESS, HEIGHT, AND COMPOSITION.
- INDICATES CEILING/BULKHEAD HEIGHT ABOVE FINISHED FLOOR
- (TB) INDICATES 4" HIGH TACK BOARD LENGTH AS INDICATED, REFER TO MOUNTING HEIGHT DRAWING.
- (MB) INDICATES 4" HIGH MARKER BOARD LENGTH AS INDICATED, REFER TO MOUNTING HEIGHT DRAWING.
- INDICATES CASEWORK, REFER TO A-710.

PLAN NOTES:


(ALL PLAN NOTES MAY NOT BE INDICATED ON THIS SHEET.)

- MILLWORK.
- FILL OPENING WITH CMU. FINISH SURFACE FLUSH WITH ADJACENT CMU.
- COPY BY OWNER.
- CUBICAL CURTAIN AND TRACK.
- ELECTRIC WATER COOLER, SEE PLUMBING DRAWINGS.
- REFRIGERATOR BY OWNER.
- MECHANICAL V.U.V. SEE MECHANICAL DRAWINGS.
- CEILING BULKHEAD REFER TO 900 SERIES DRAWINGS.
- FILL IN OPENING WITH NEW CMU. FINISH FLUSH WITH ADJACENT WALL SURFACE.
- MOP SINK - SEE PLUMBING DRAWINGS.
- PATCH END OF WALL AND PREP FOR NEW FINISH.
- TOILET PARTITION.
- PATCH EXISTING PLUMBING CHASE OPENING.
- ELECTRIC BOTTLE FILL, SEE PLUMBING DRAWINGS.
- FILL OPENING WITH STUD WALL. FINISH SURFACE FLUSH WITH ADJACENT WALL.
- FILL IN RECESS MAT WITH "ARDEX SD-P", SELF DRYING TROWEL-ABLE CONCRETE UNDERLAYMENT.
- ALTERNATE.
- LAMINATE 1/2" GYPSUM BOARD TO CMU WALL.
- INTERIOR LETTERING - REFER TO SPECIFICATION.
- DEDICATION PLAQUE, REFER TO SPECIFICATION.
- DATE STONE, REFER TO SPECIFICATION.
- DISPLAY CASE, SEE
- CONCRETE VOID SLAB - SEE STRUCTURAL.
- FILL IN RECESS AREA WITH TROWABLE CONCRETE UNDERLAYMENT.

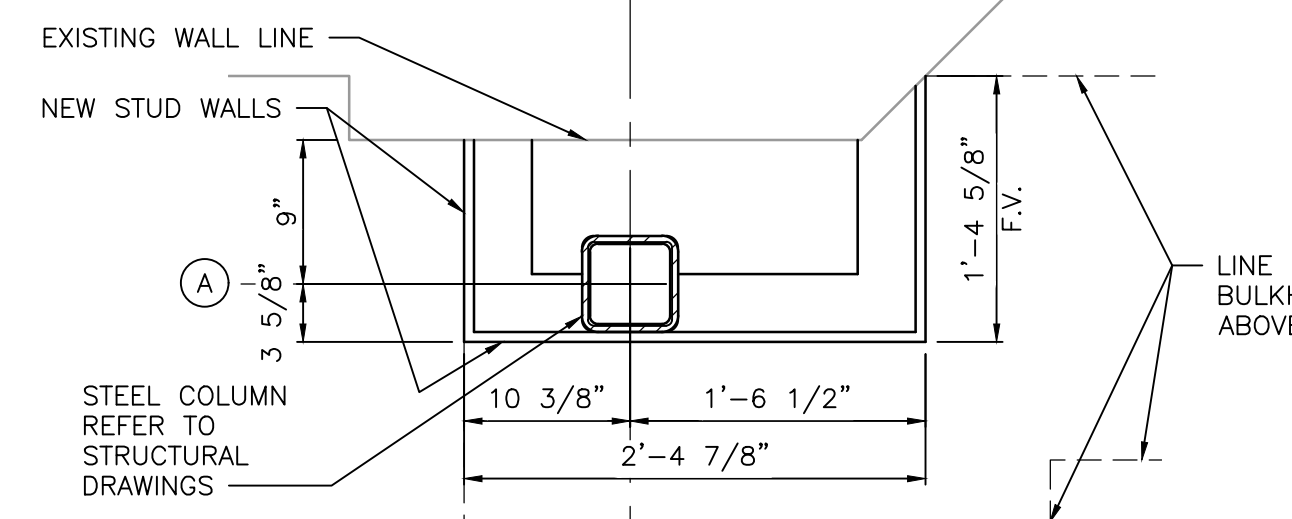


ENLARGED DETAIL

SCALE: 1" = 1'-0"

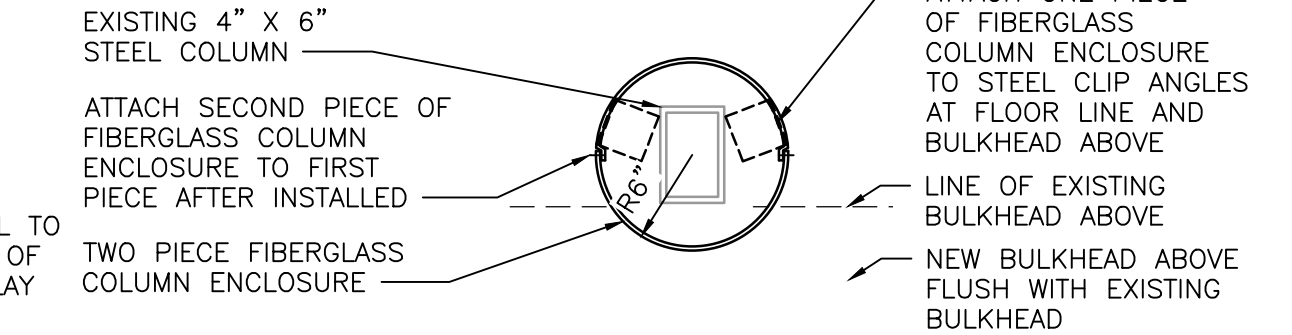

ENLARGED DETAIL

SCALE: 1" = 1'-0"

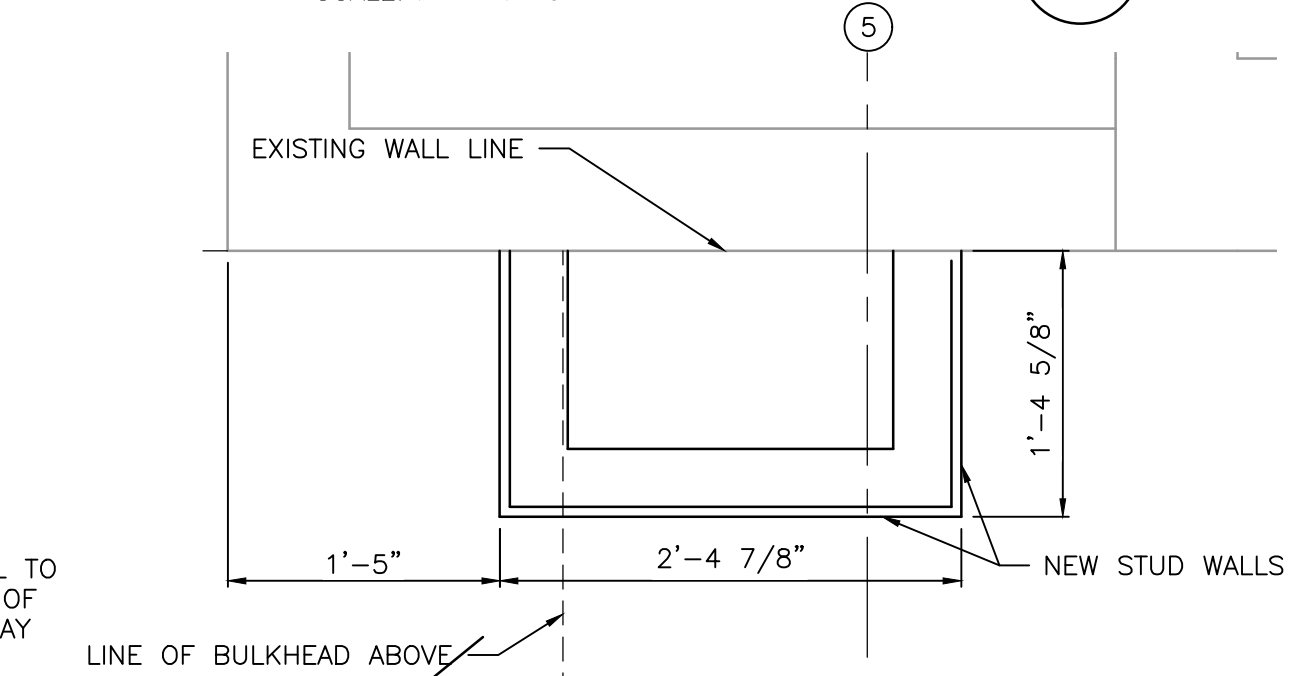

ENLARGED DETAIL

SCALE: 1" = 1'-0"

ENLARGED DETAIL

SCALE: 1" = 1'-0"

ENLARGED DETAIL

SCALE: 1" = 1'-0"

ENLARGED DETAIL


SCALE: 1" = 1'-0"


ENLARGED DETAIL

SCALE: 1" = 1'-0"

UNIT "A" ARCHITECTURAL FIRST FLOOR PLAN

SCALE: 1/8" = 1'-0"

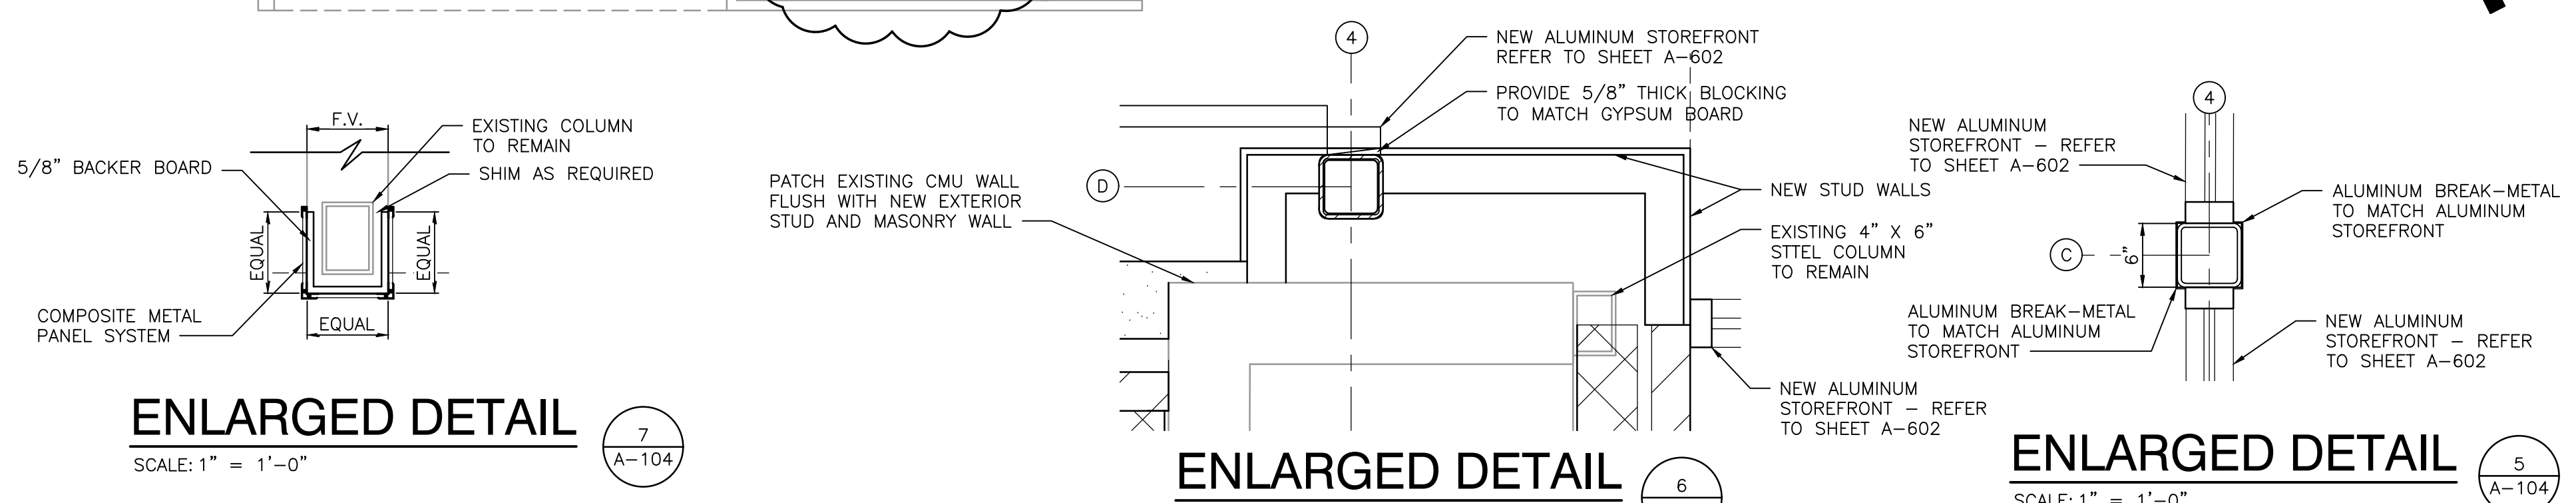


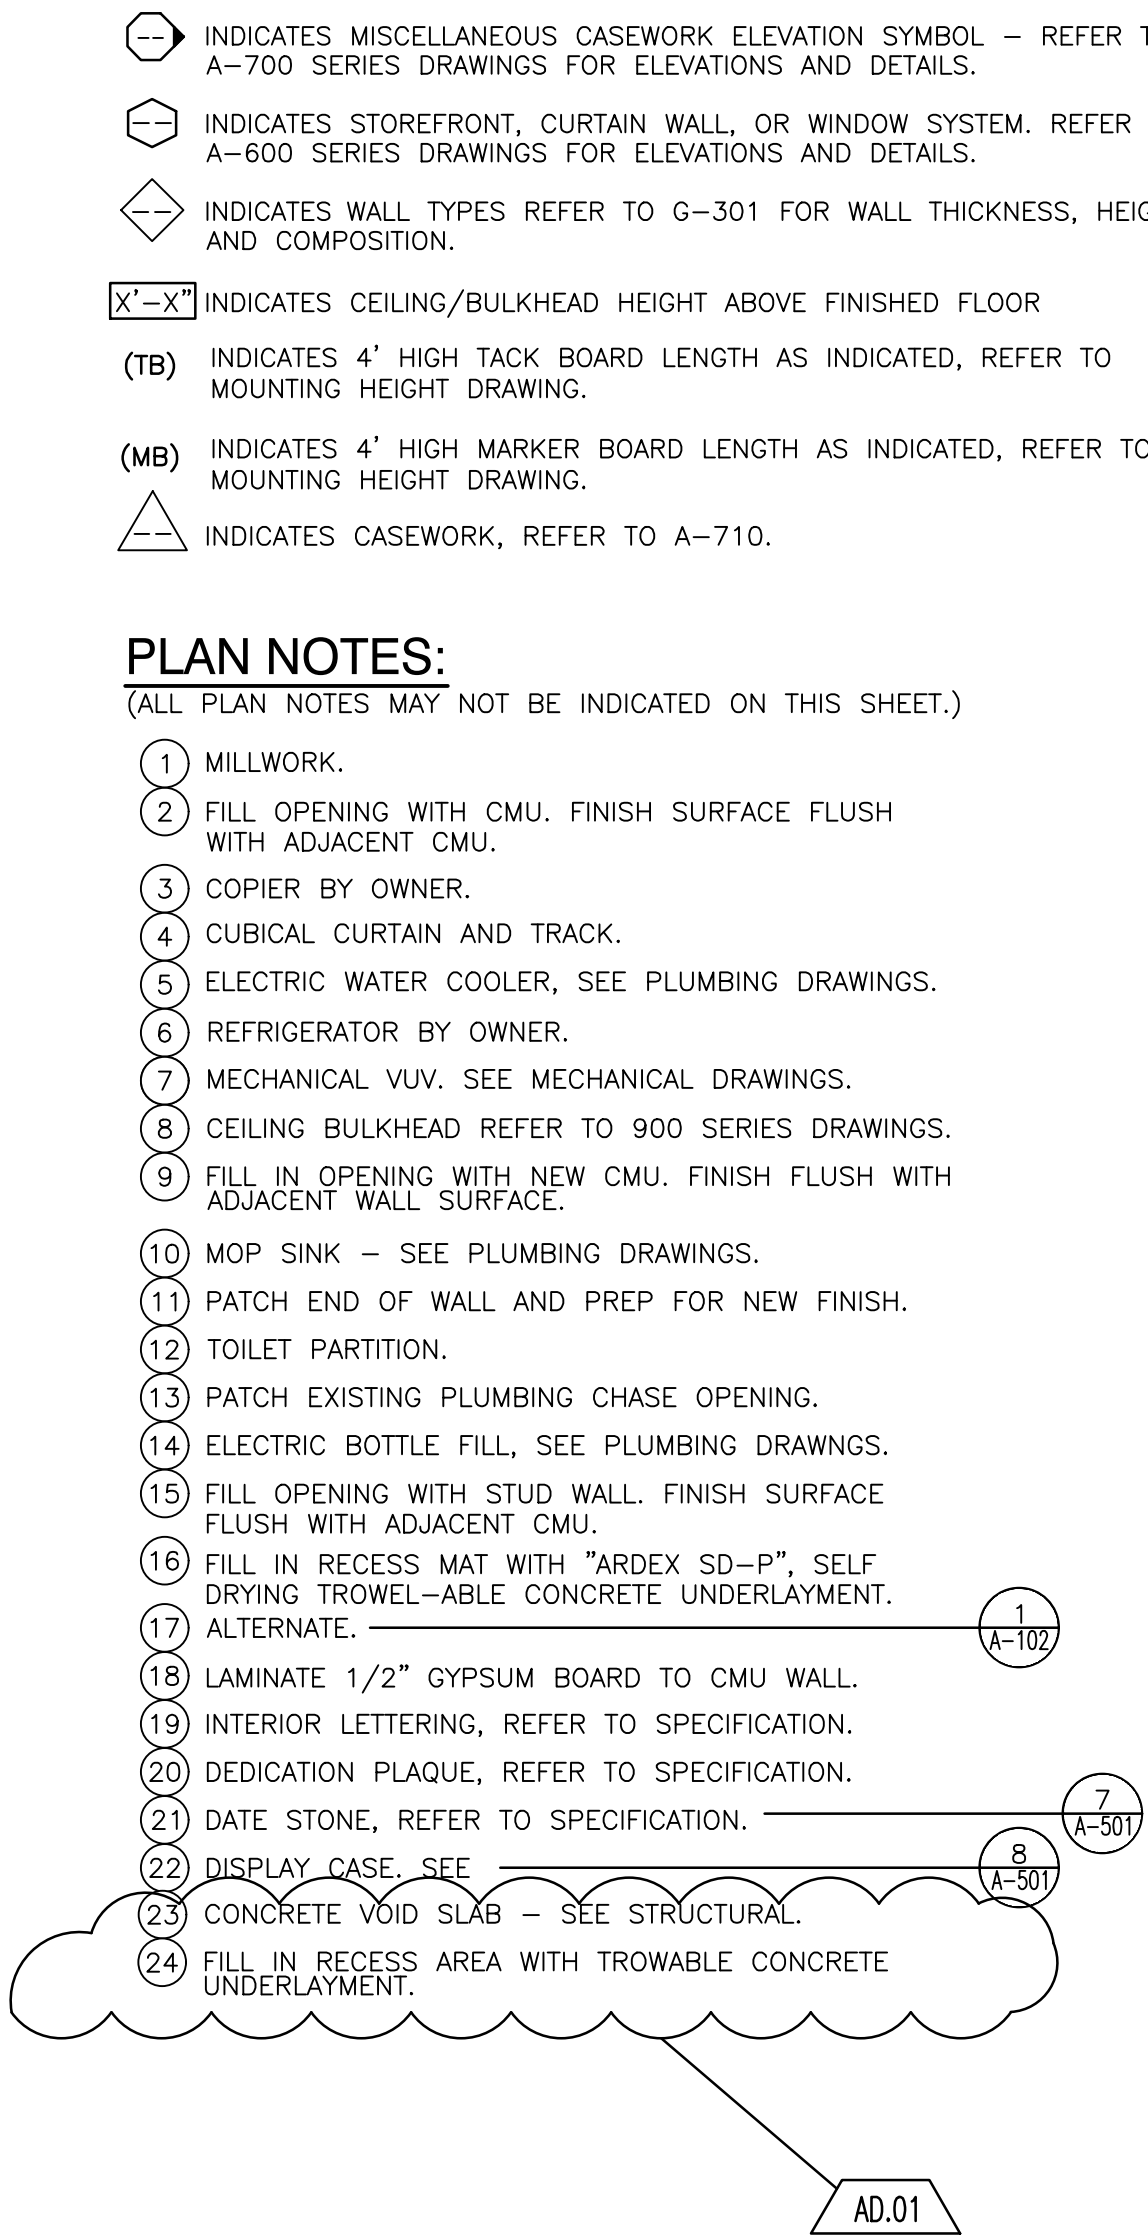


GIBRALTAR DESIGN
B A-105




GIBALTAR
DESIGN
ARCHITECTURE • ENGINEERING • INTERIOR DESIGN

PROJECT
**FAIRVIEW
ELEMENTARY
SCHOOL
RENOVATIONS**
LOGANSPOrt COMMUNITY
SCHOOL CORPORATION
LOGANSPOrt, INDIANA

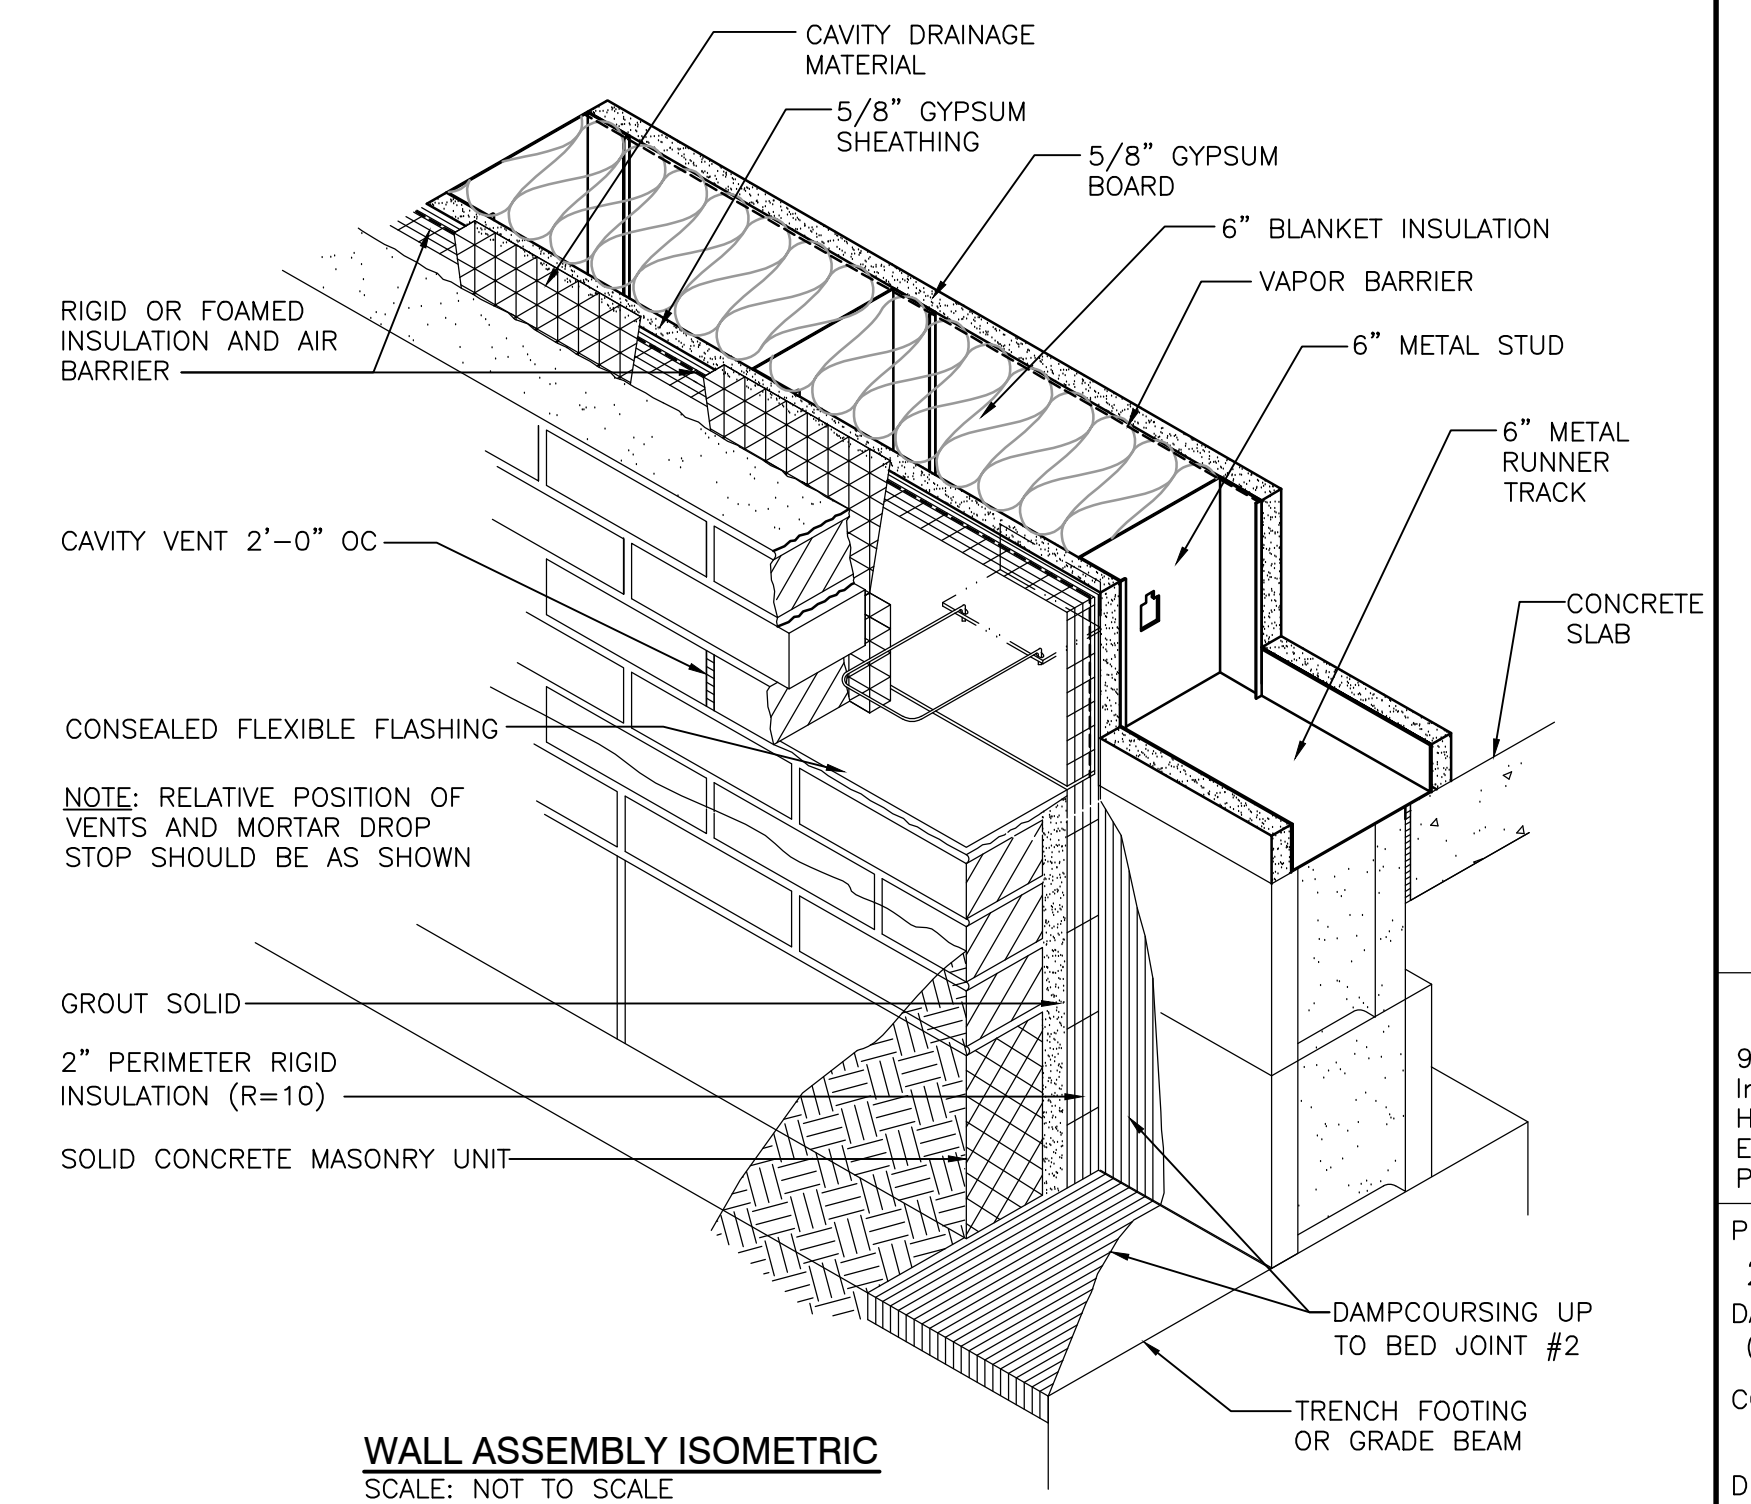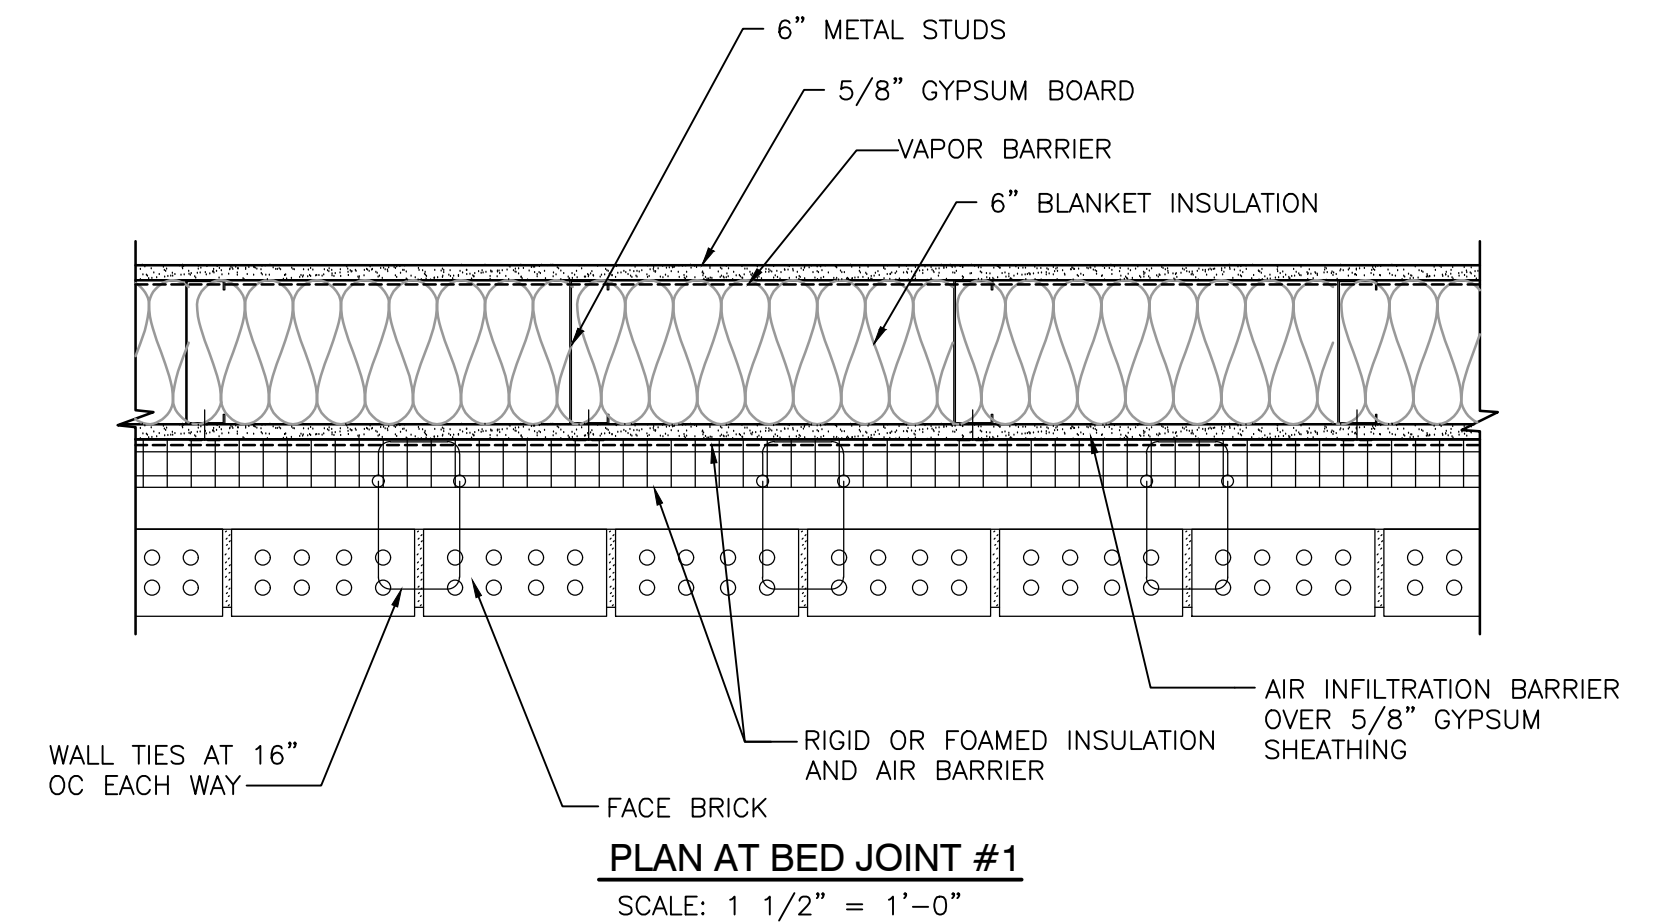

NOTE:
INSTALL CAVITY
VENTS AT TOP OF
CAVITY SPACE

NOTE:
REFER WALL SECTIONS
AND ELEVATIONS FOR
BRICK PATTERNS AND
COLORS

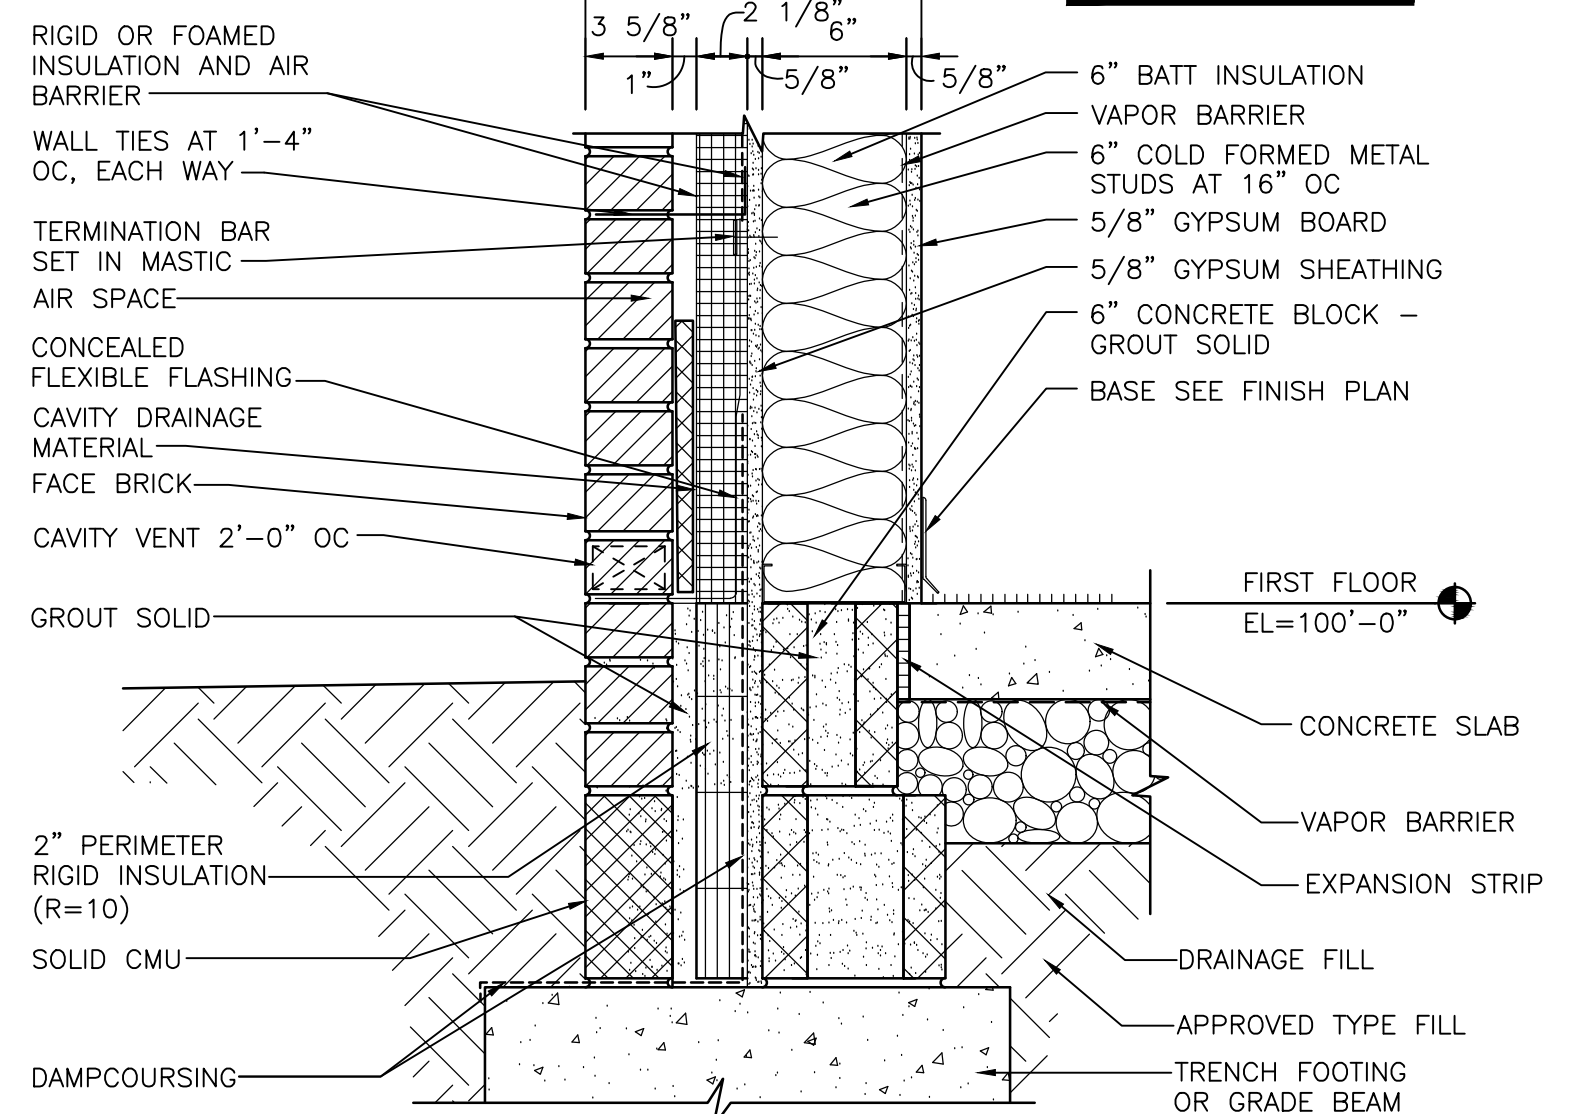

SECTION
SCALE: 1 1/2" = 1'-0"
**TYPICAL EXTERIOR METAL STUD WALL
CONSTRUCTION DETAIL**
SCALE: AS INDICATED

GIBALTAR DESIGN
9102 N. Meridian St., Ste. 300
Indianapolis, IN 46260
Homepage: www.GibraltarDesign.com
Email: info@GibraltarDesign.com
Phone: 317.580.5777 Fax: 317.580.5778

PROJECT
20-157
DATE
06/18/21
COORDINATED BY
DJW
DRAWN BY
KLS
CHECKED BY
DJW



COPYRIGHT NOTICE:
THE CONCEPTS, DESIGNS, PLANS, DETAILS, ETC., SHOWN ON
THIS DOCUMENT ARE THE PROPERTY OF GIBALTAR DESIGN AND
WERE CREATED FOR USE ON THIS SPECIFIC PROJECT. NONE OF
THIS INFORMATION SHALL BE USED BY ANY PERSON OR FIRM
FOR ANY PURPOSE WITHOUT THE EXPRESS WRITTEN CONSENT
OF GIBALTAR DESIGN. THE OWNER MAY RETAIN COPIES FOR
INFORMATION AND REFERENCE IN CONNECTION ONLY WITH THIS
PROJECT.

REVISIONS
MARK DATE ISSUED FOR
AD.01 7/9/21 AD.01


DRAWING
WALL SECTIONS

PROJECT
**FAIRVIEW ELEMENTARY SCHOOL
RENOVATIONS**

DRAWING
A-401

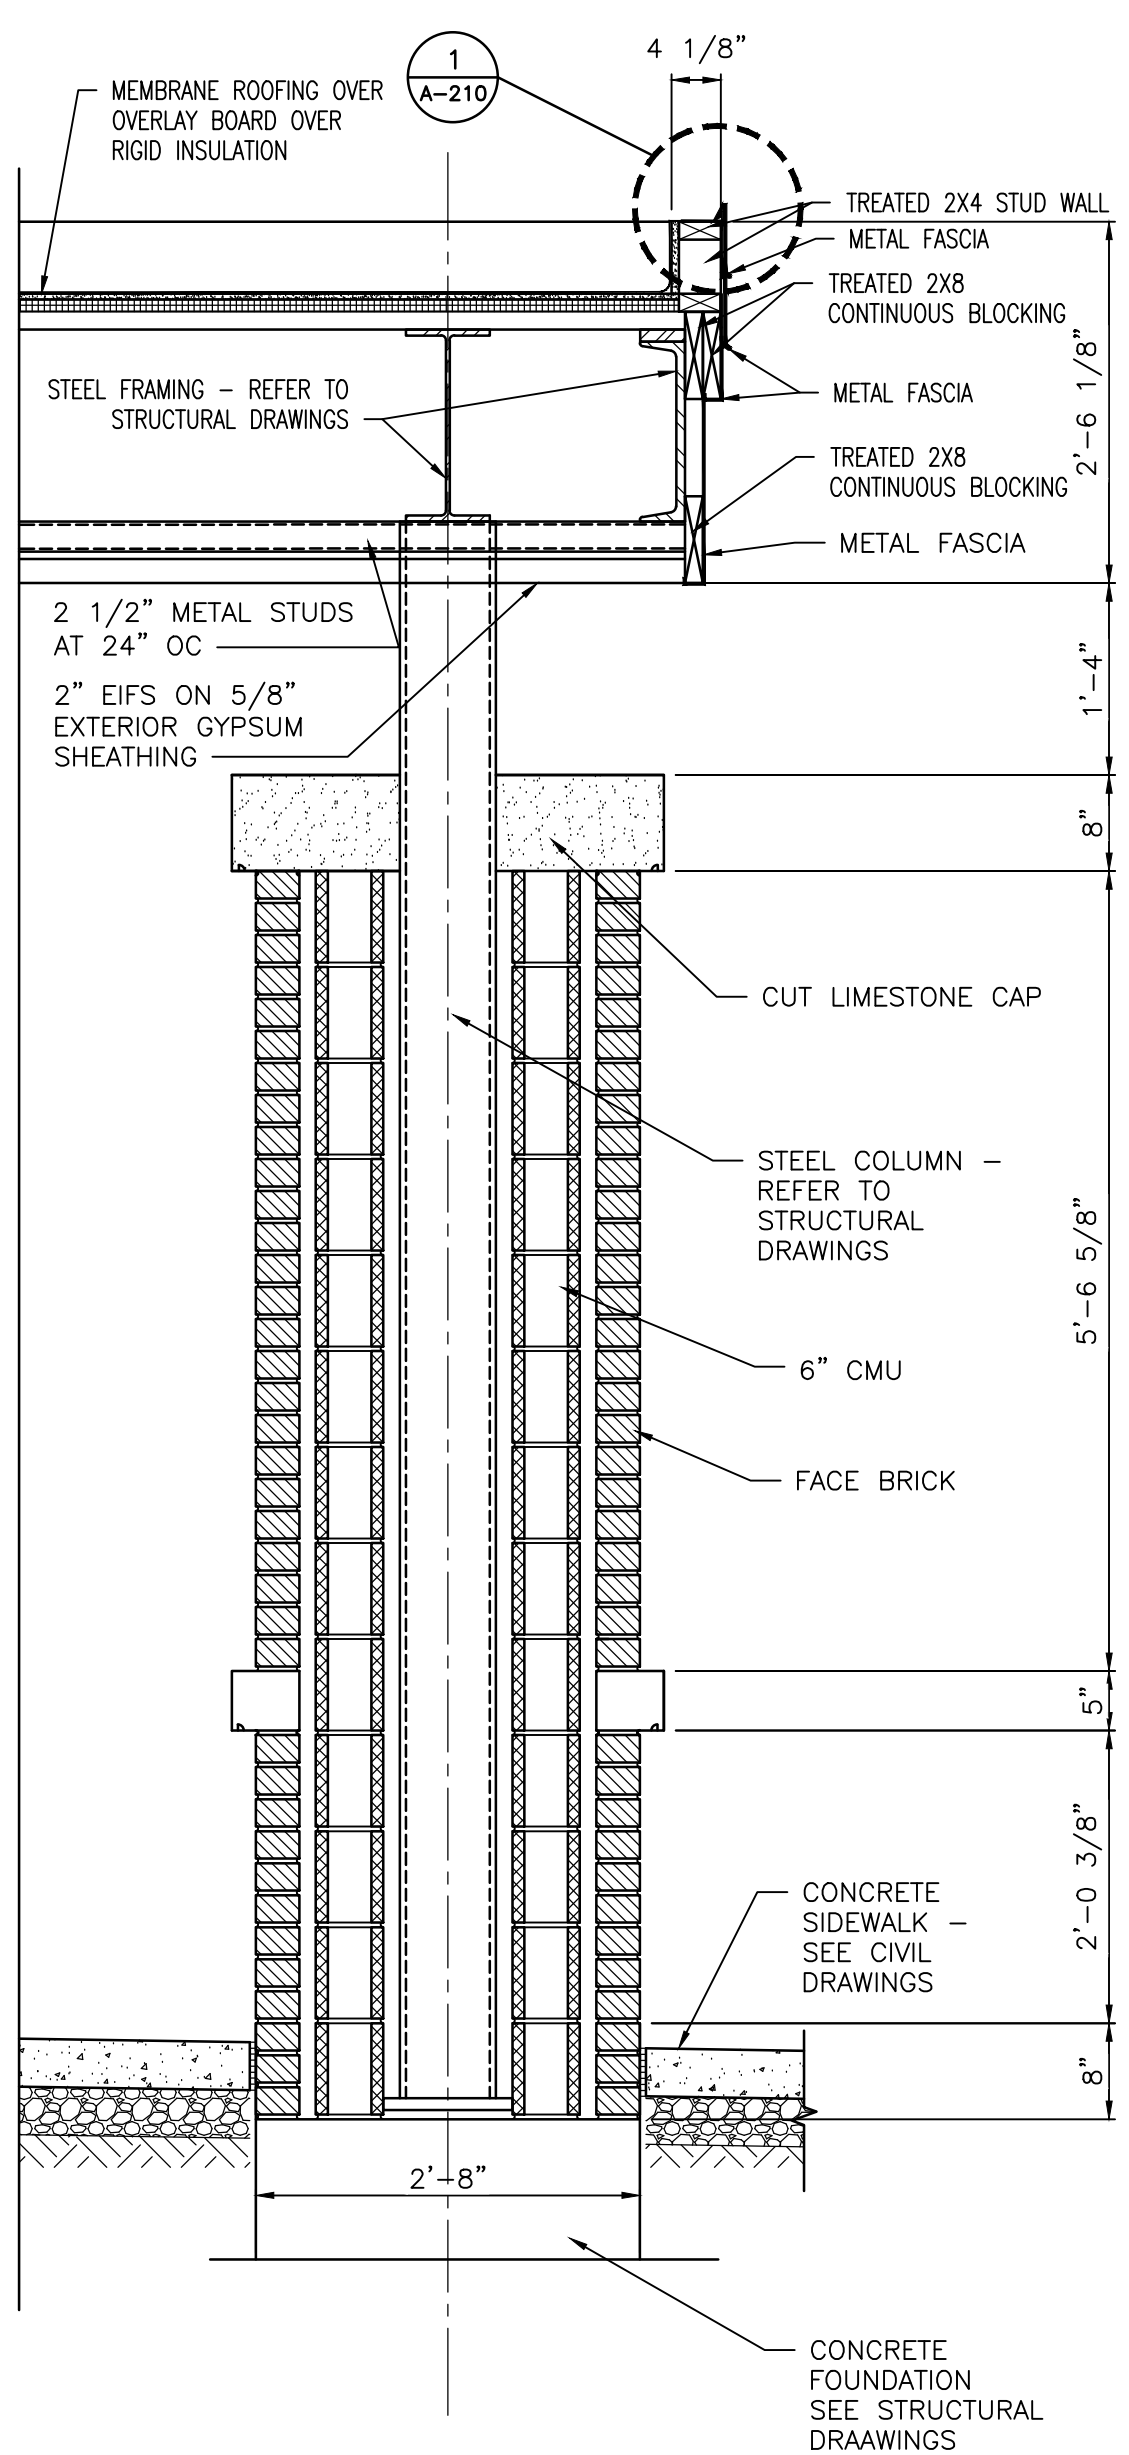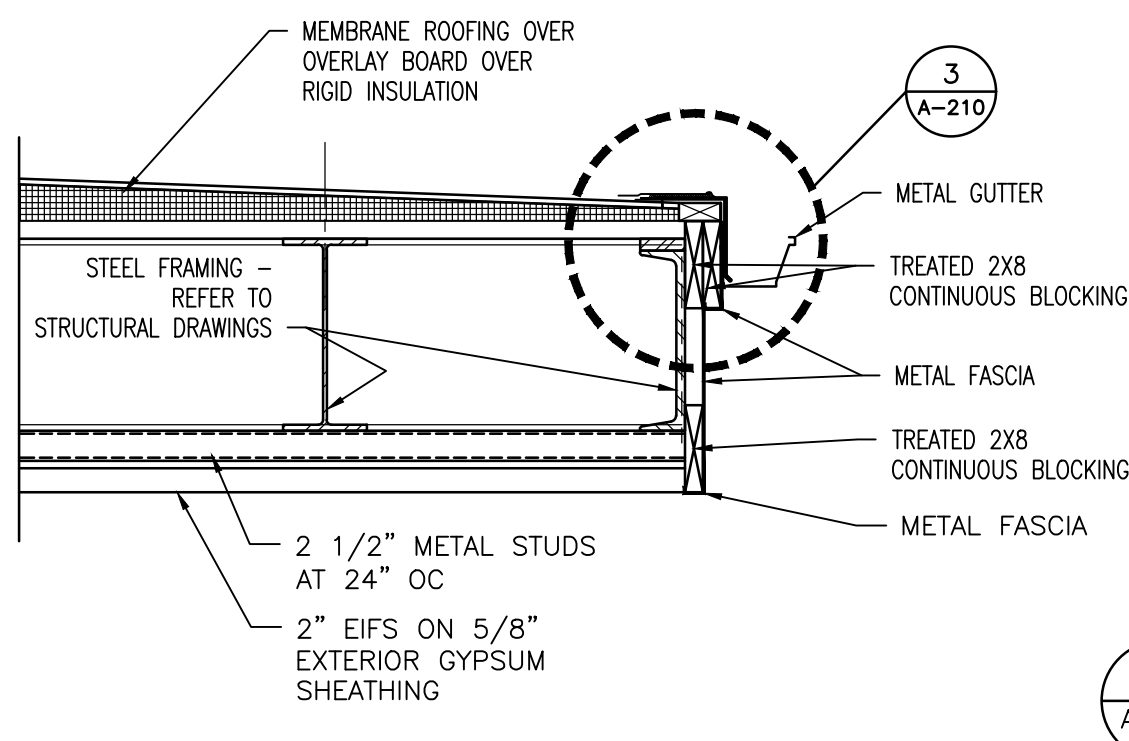

SECTION
SCALE: 3/4" = 1'-0"

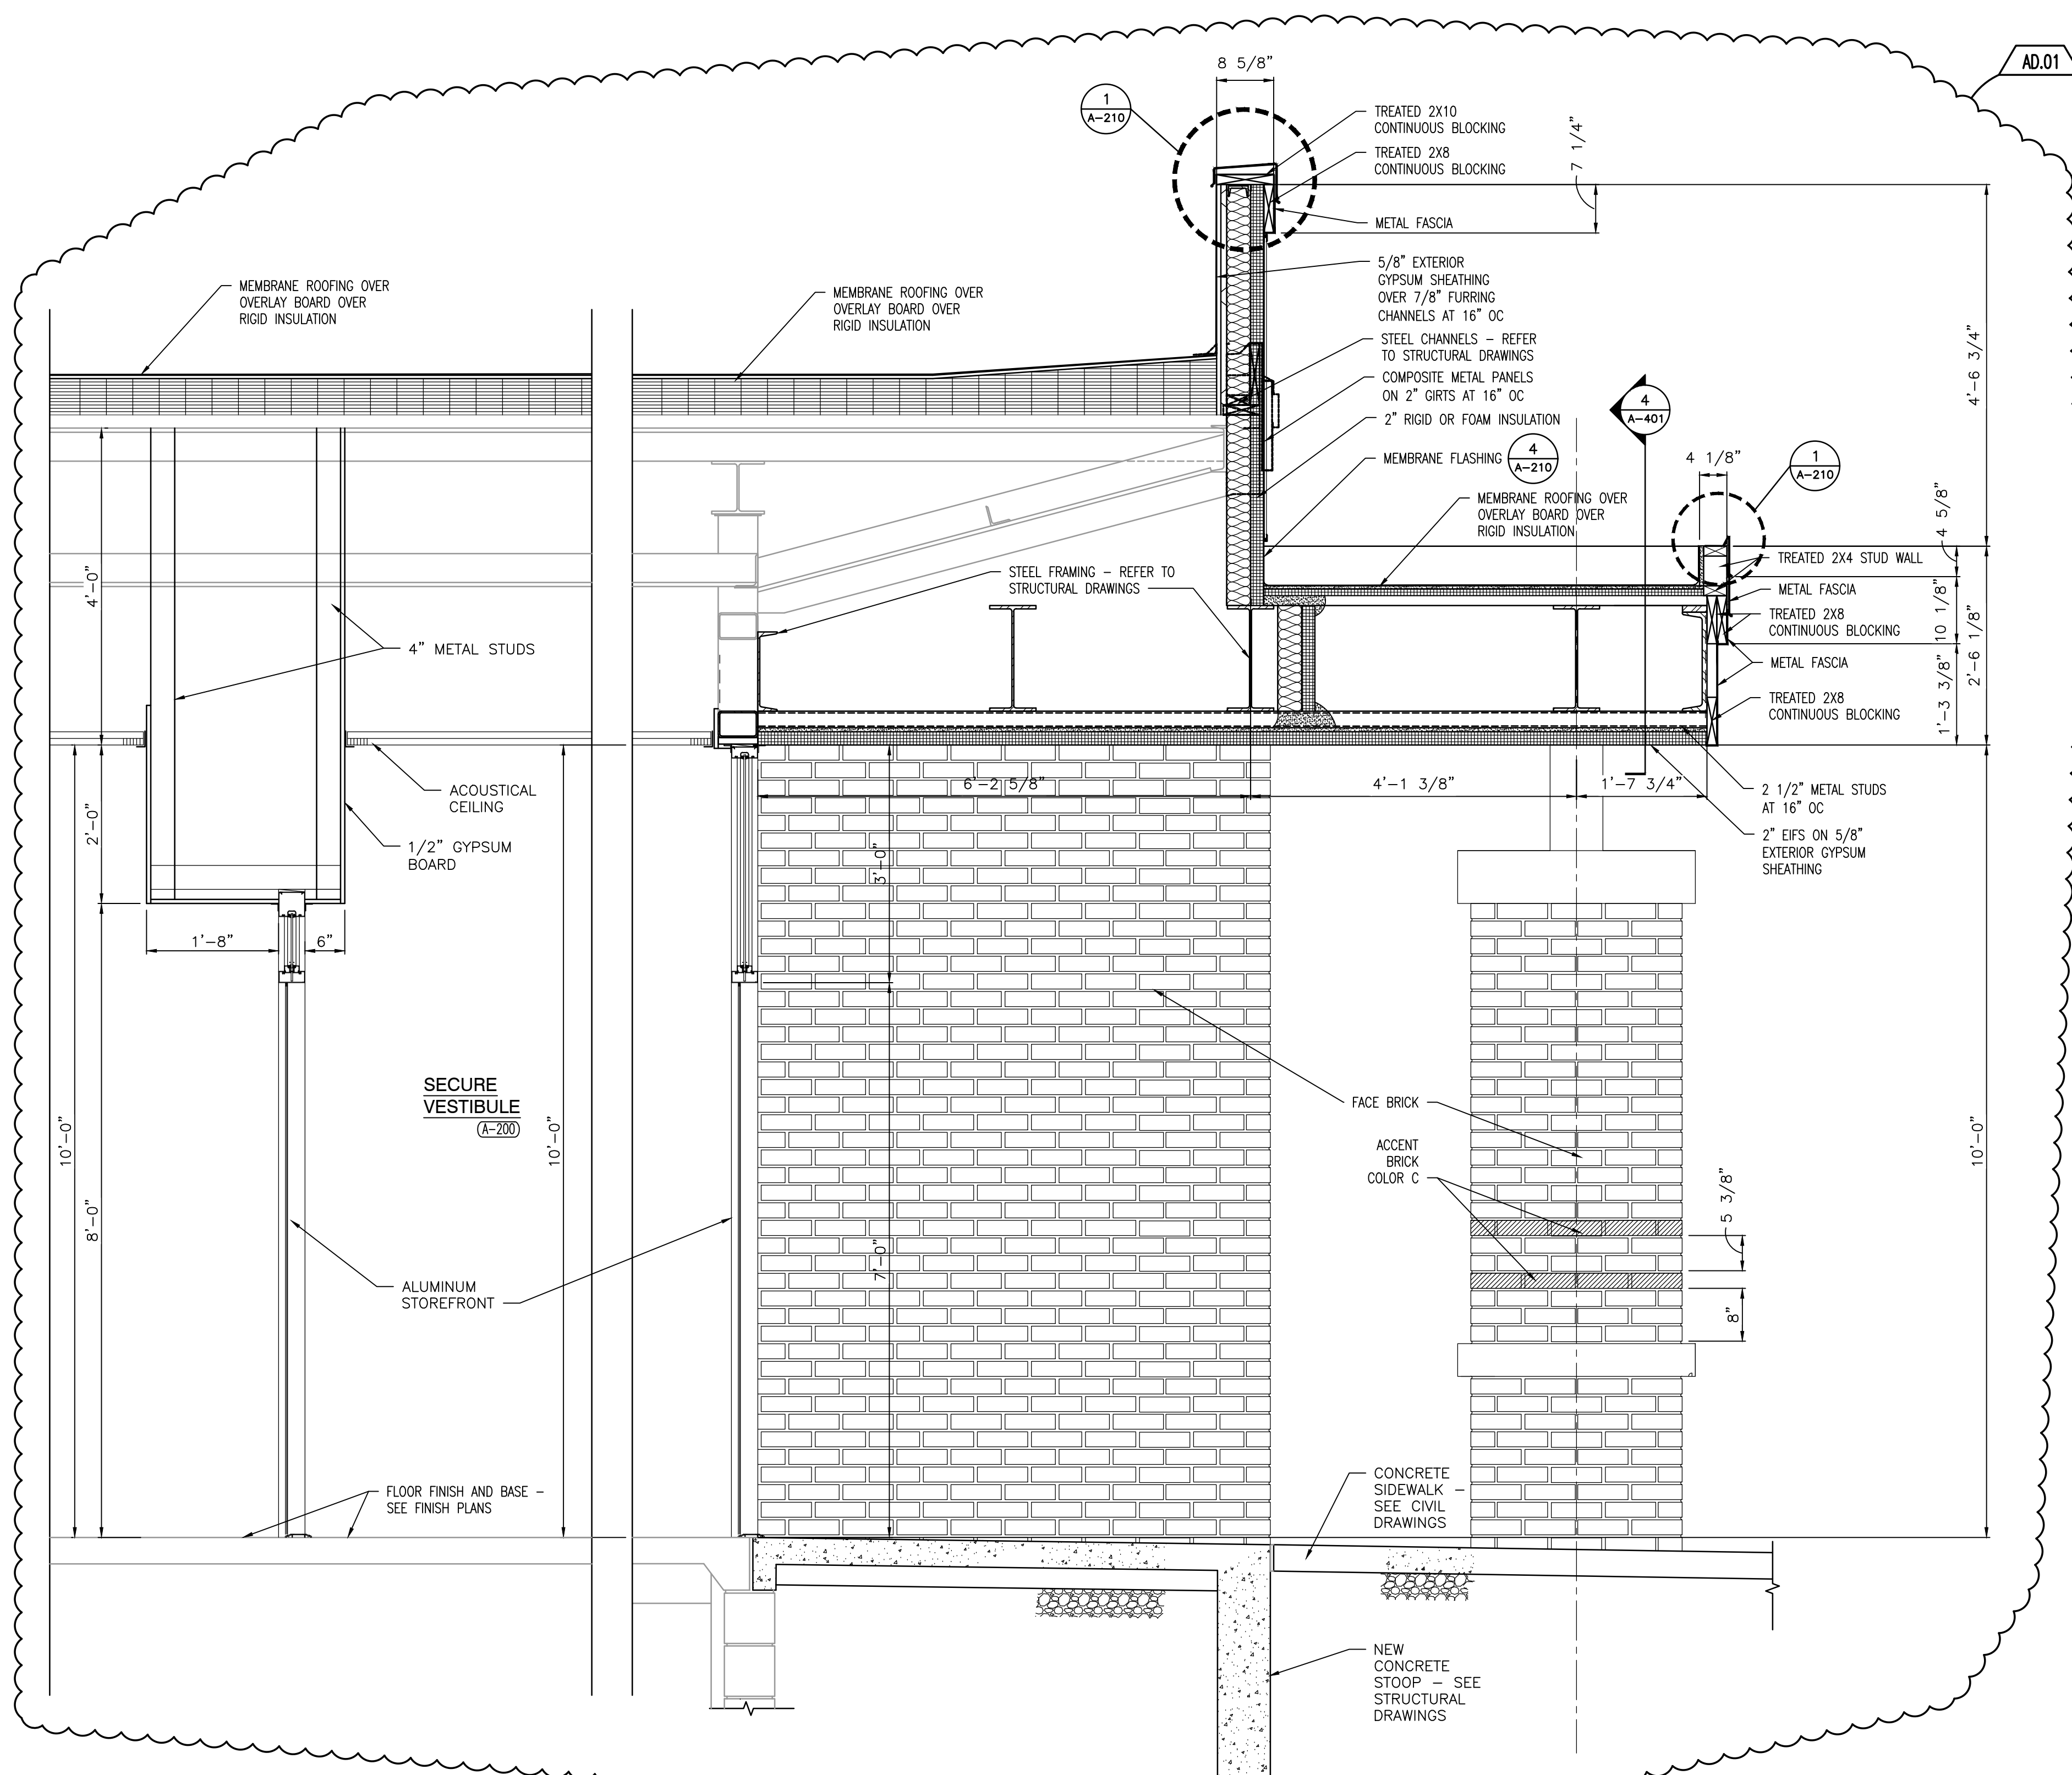

SECTION
SCALE: 3/4" = 1'-0"

2
A-401

Wednesday, 7/7/2021 4:42:33 PM - LAST SAVED BY: HKSCHULTZ
Y:\20-157 LOGANSPOrt CSC - FAIRVIEW ES
RENOVATIONS\20-157 DRAWINGS\05 ARCH\A-401.DWG



GIBALTAR
DESIGN
ARCHITECTURE • ENGINEERING • INTERIOR DESIGN

PROJECT
**FAIRVIEW
ELEMENTARY
SCHOOL
RENOVATIONS**
LOGANSPOrt COMMUNITY
SCHOOL CORPORATION
LOGANSPOrt, INDIANA

GIBALTAR DESIGN

9102 N. Meridian St., Ste. 300
Indianapolis, IN 46260
Homepage: www.GibraltarDesign.com
Email: info@GibraltarDesign.com
Phone: 317.580.5777 Fax: 317.580.5778

PROJECT
20-157
DATE
06/18/21
COORDINATED BY
DJW
DRAWN BY
KLS
CHECKED BY
DJW

COPYRIGHT NOTICE:
THE CONCEPTS, DESIGNS, PLANS, DETAILS, ETC., SHOWN ON
THIS DOCUMENT ARE THE PROPERTY OF GIBALTAR DESIGN AND
WERE CREATED FOR USE ON THIS SPECIFIC PROJECT. NONE OF
THIS INFORMATION SHALL BE USED BY ANY PERSON OR FIRM
FOR ANY PURPOSE WITHOUT THE EXPRESS WRITTEN CONSENT
OF GIBALTAR DESIGN. THE OWNER MAY RETAIN COPIES FOR
INFORMATION AND REFERENCE IN CONNECTION ONLY WITH THIS
PROJECT.


REVISIONS
MARK DATE ISSUED FOR
AD.01 7/9/21 AD.01

DRAWING
WALL SECTIONS

PROJECT
**FAIRVIEW ELEMENTARY SCHOOL
RENOVATIONS**


GIBALTAR DESIGN SHEET

A-402

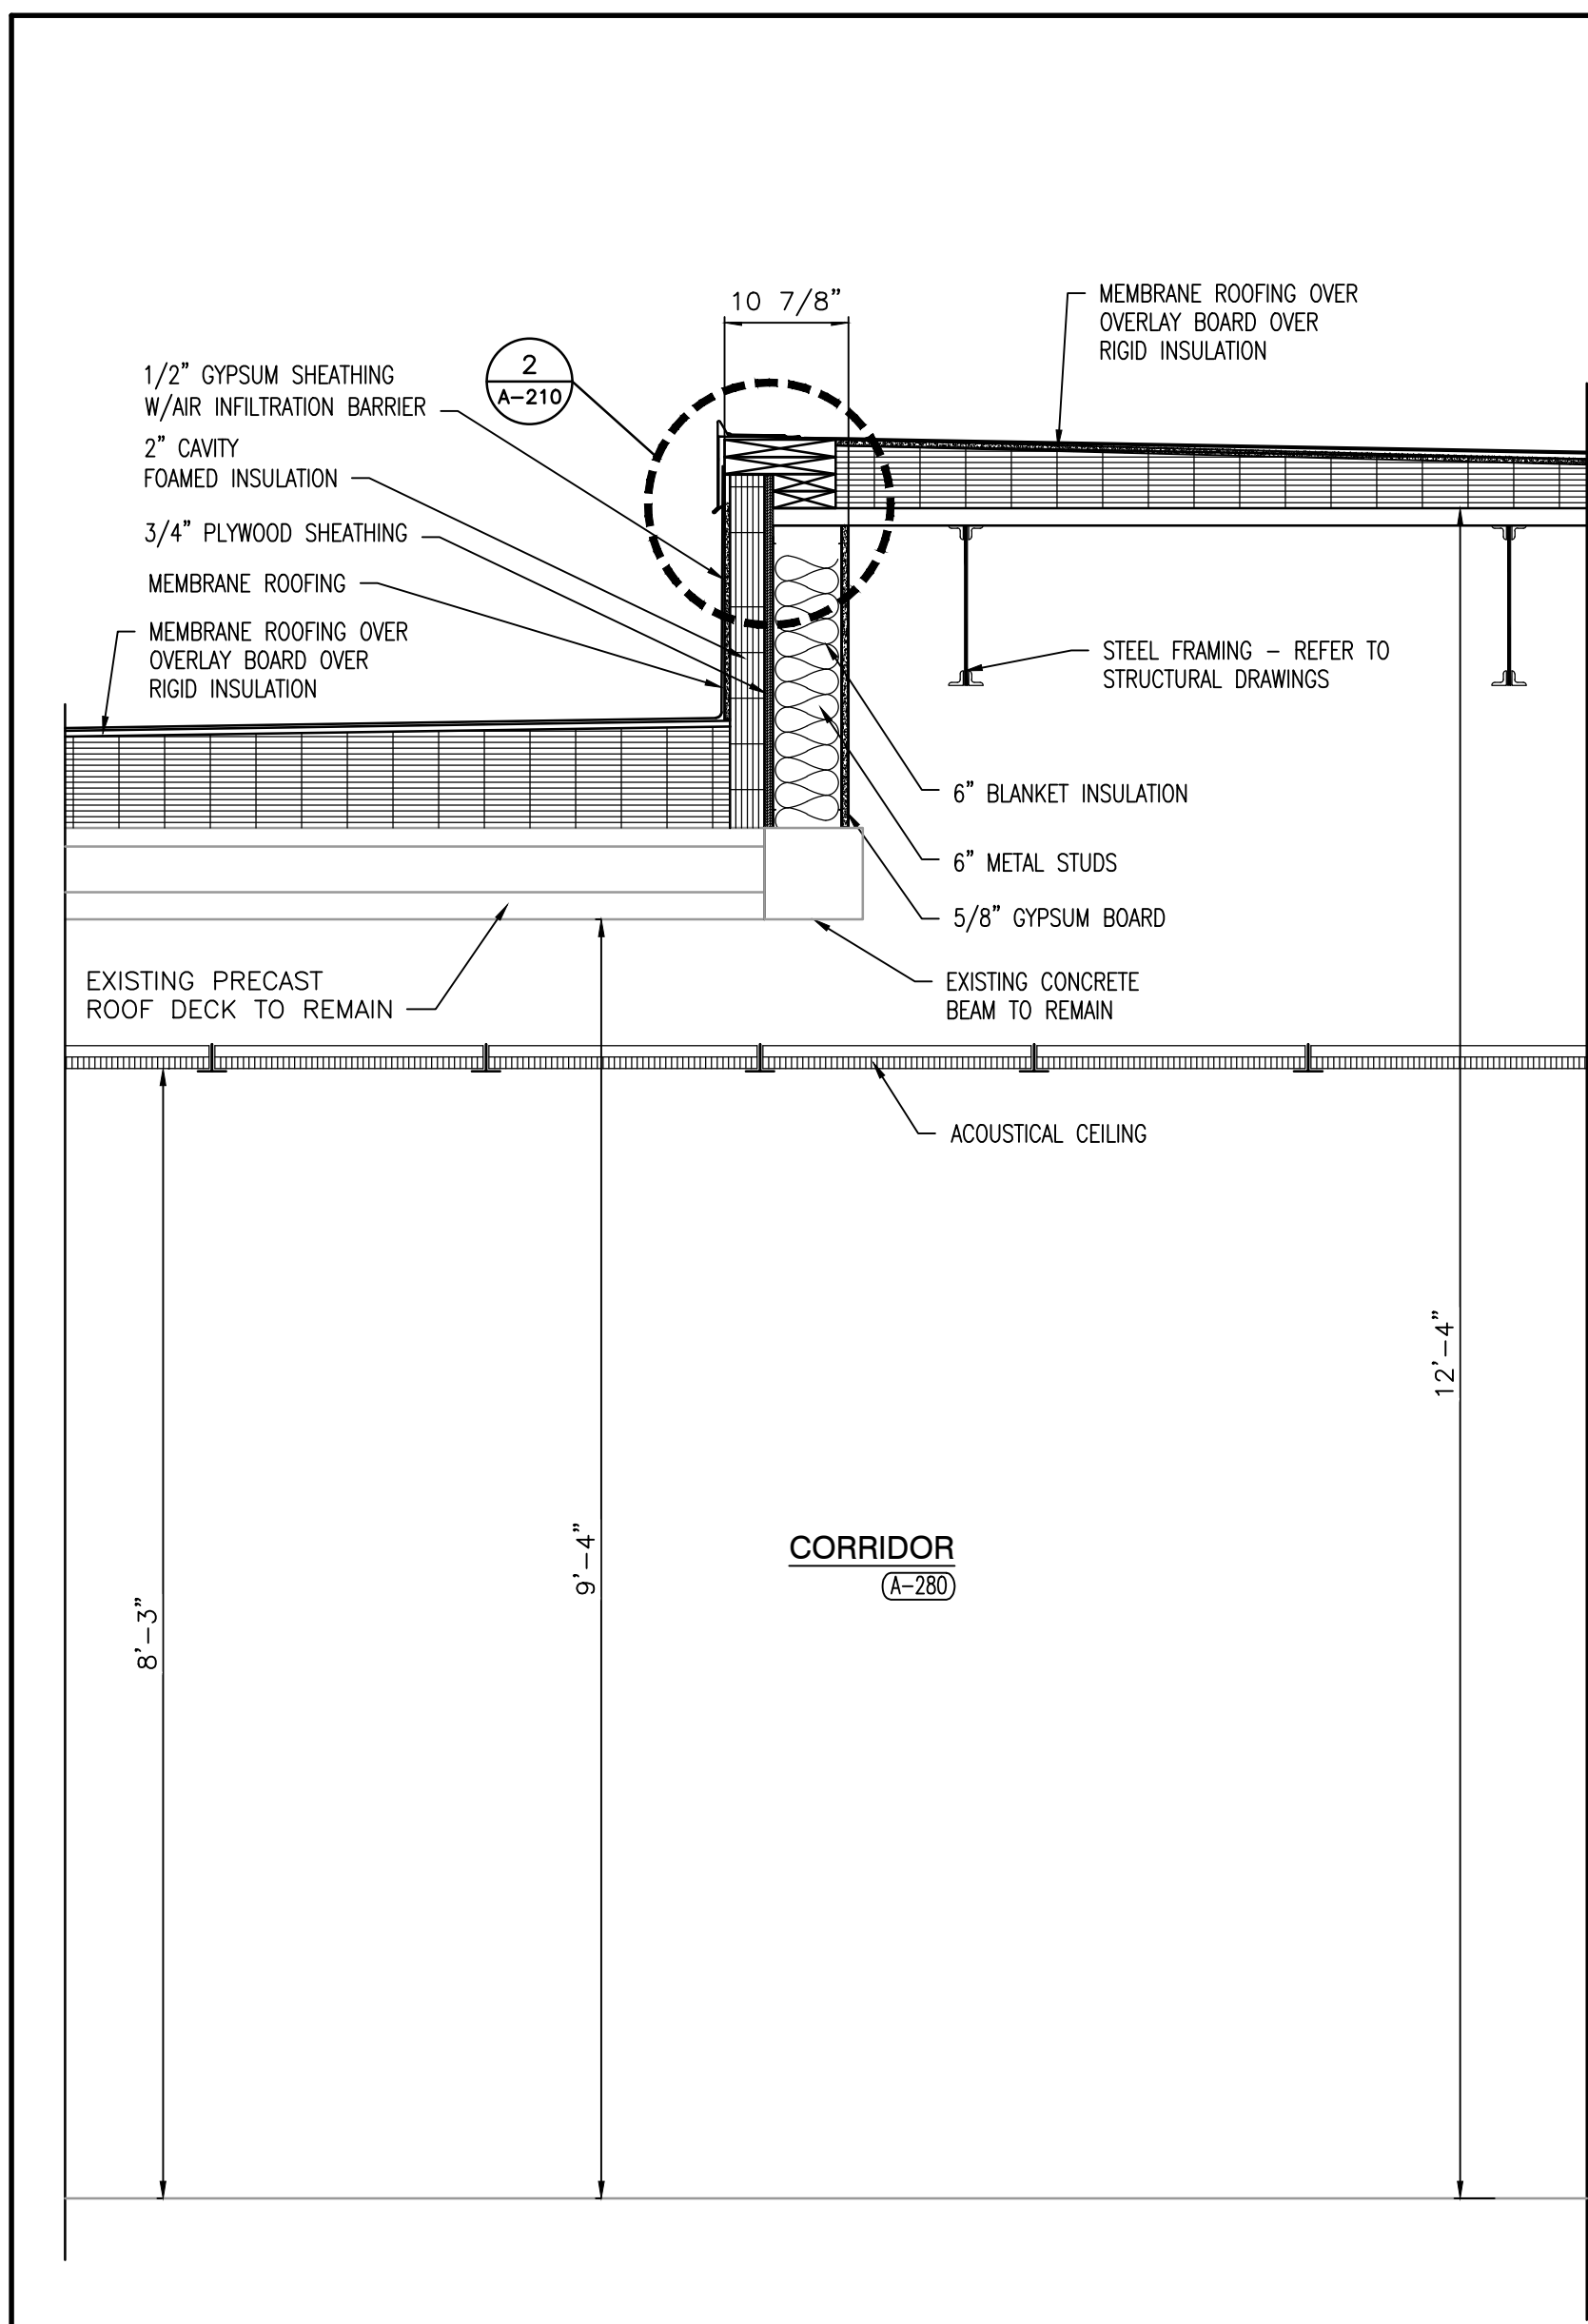


SECTION
SCALE: 3/4" = 1'-0"

8
A-402

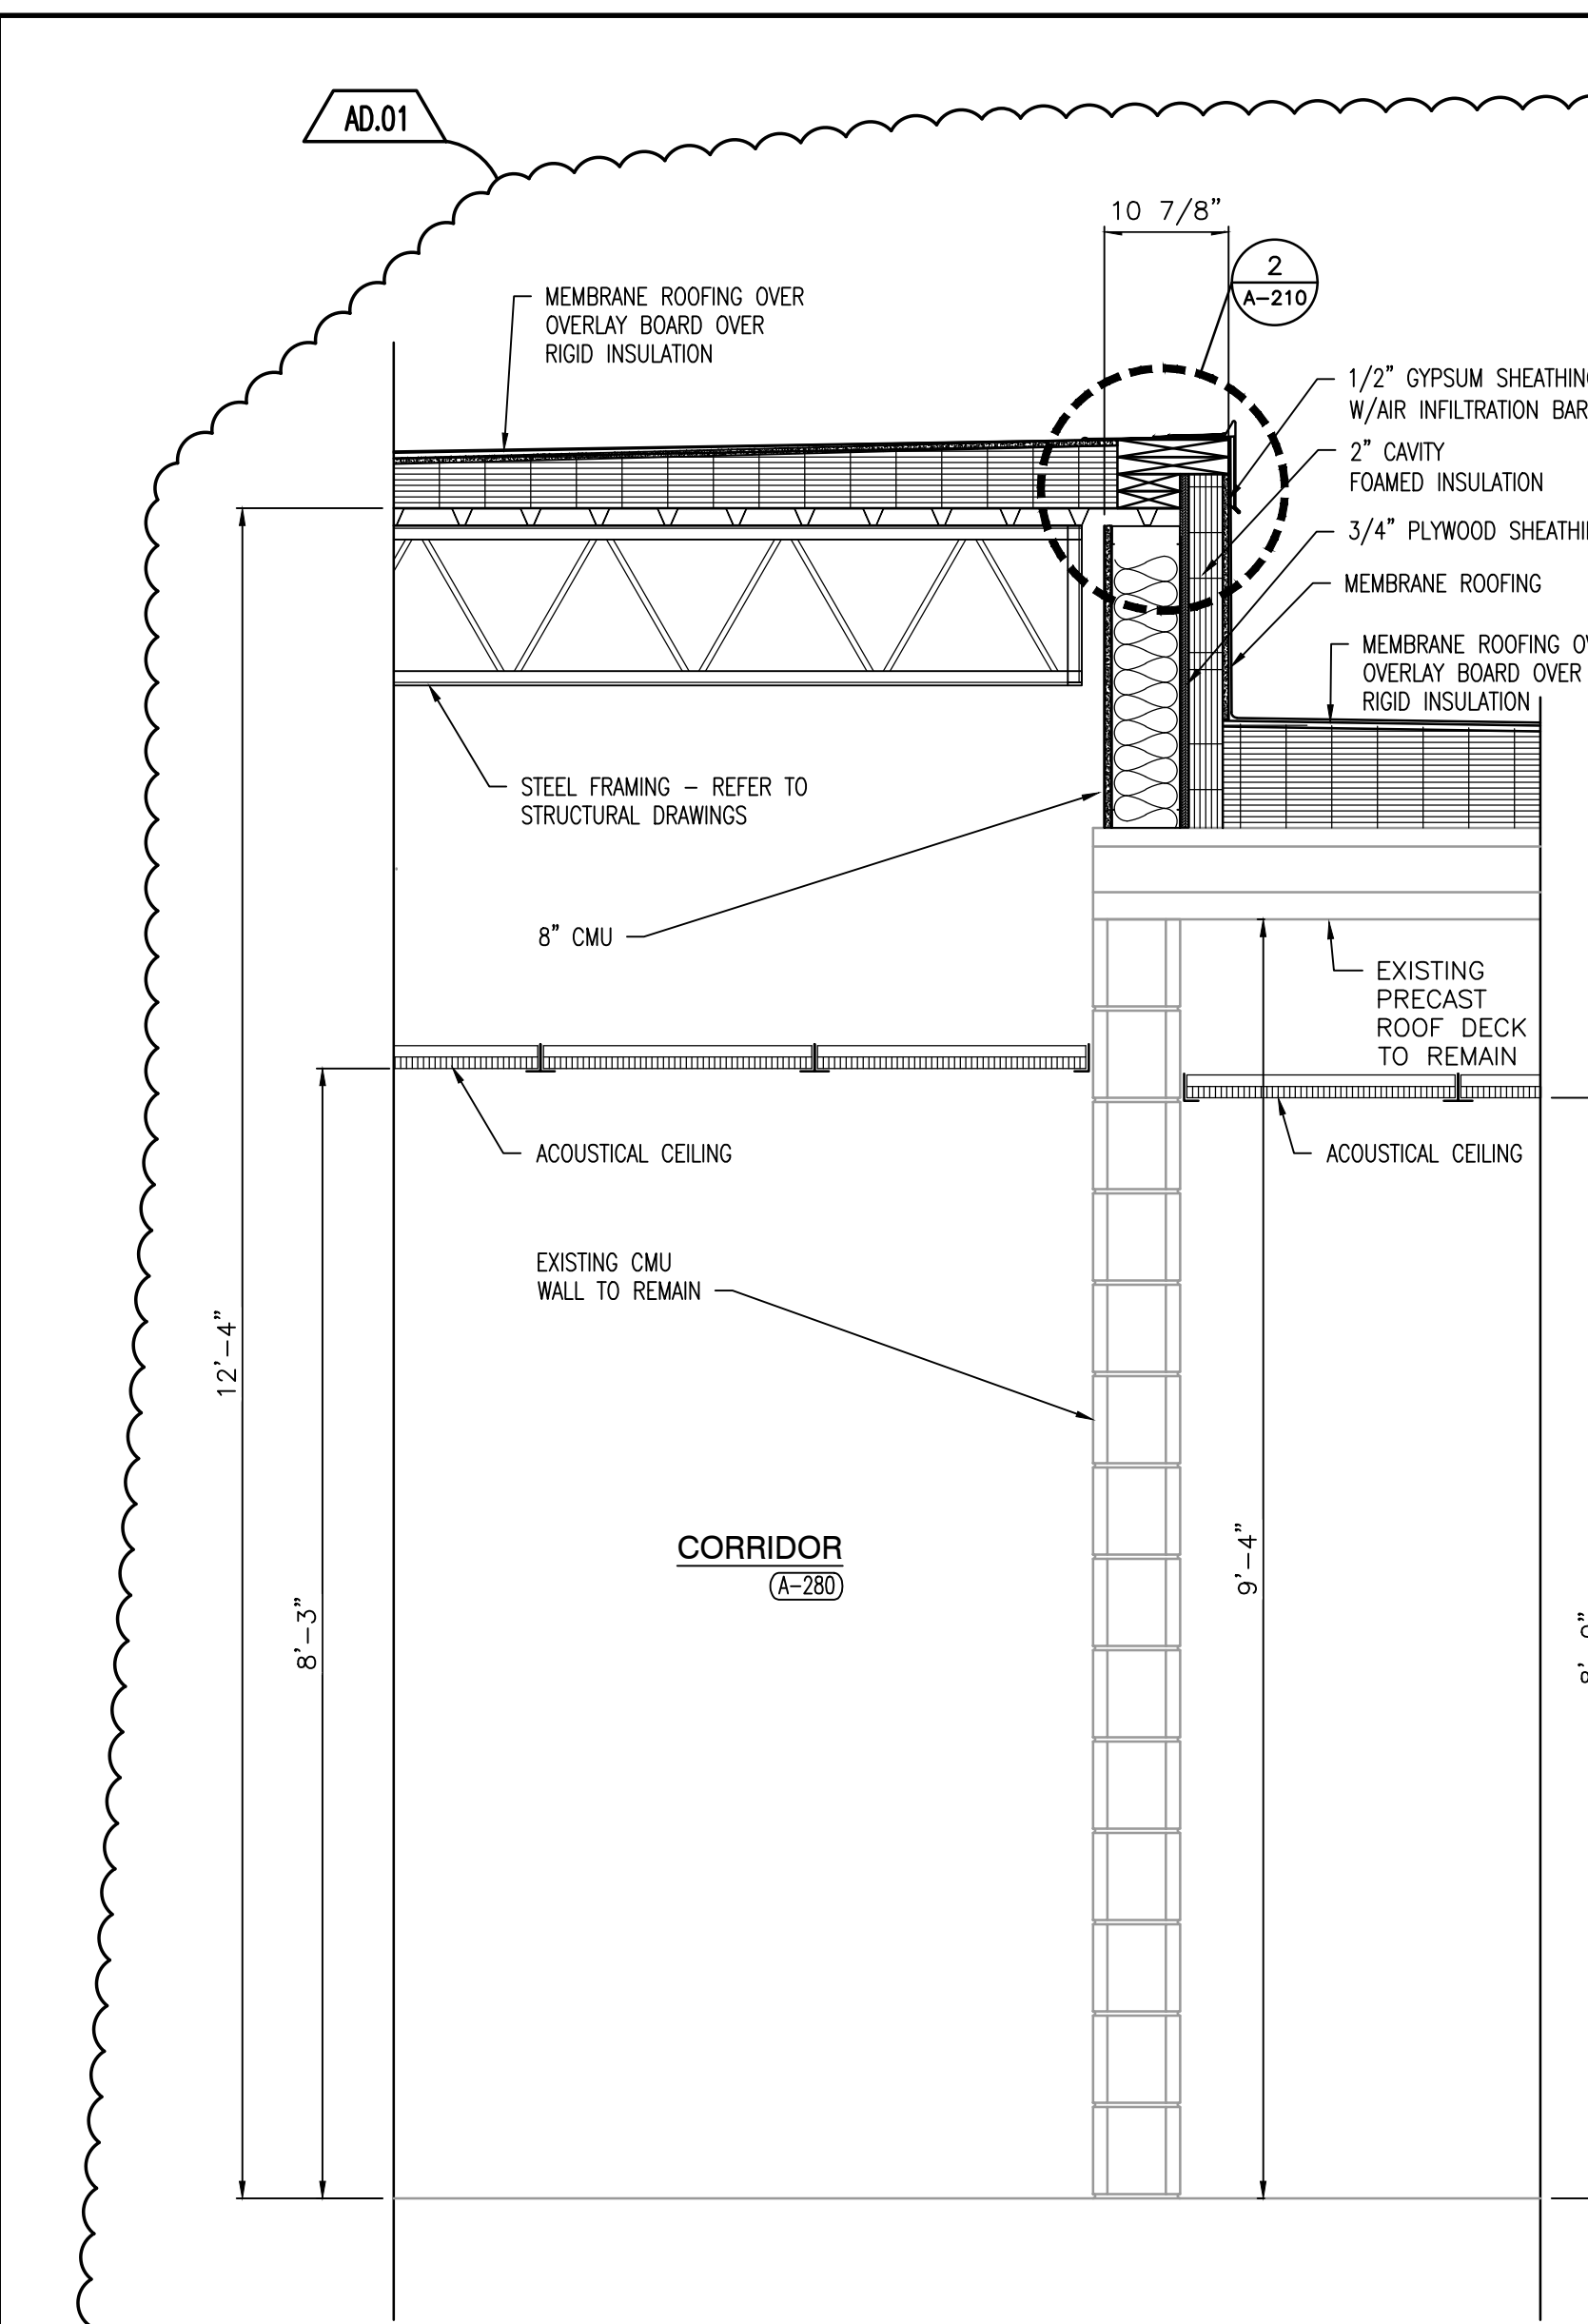


SECTION
SCALE: 3/4" = 1'-0"

7
A-402

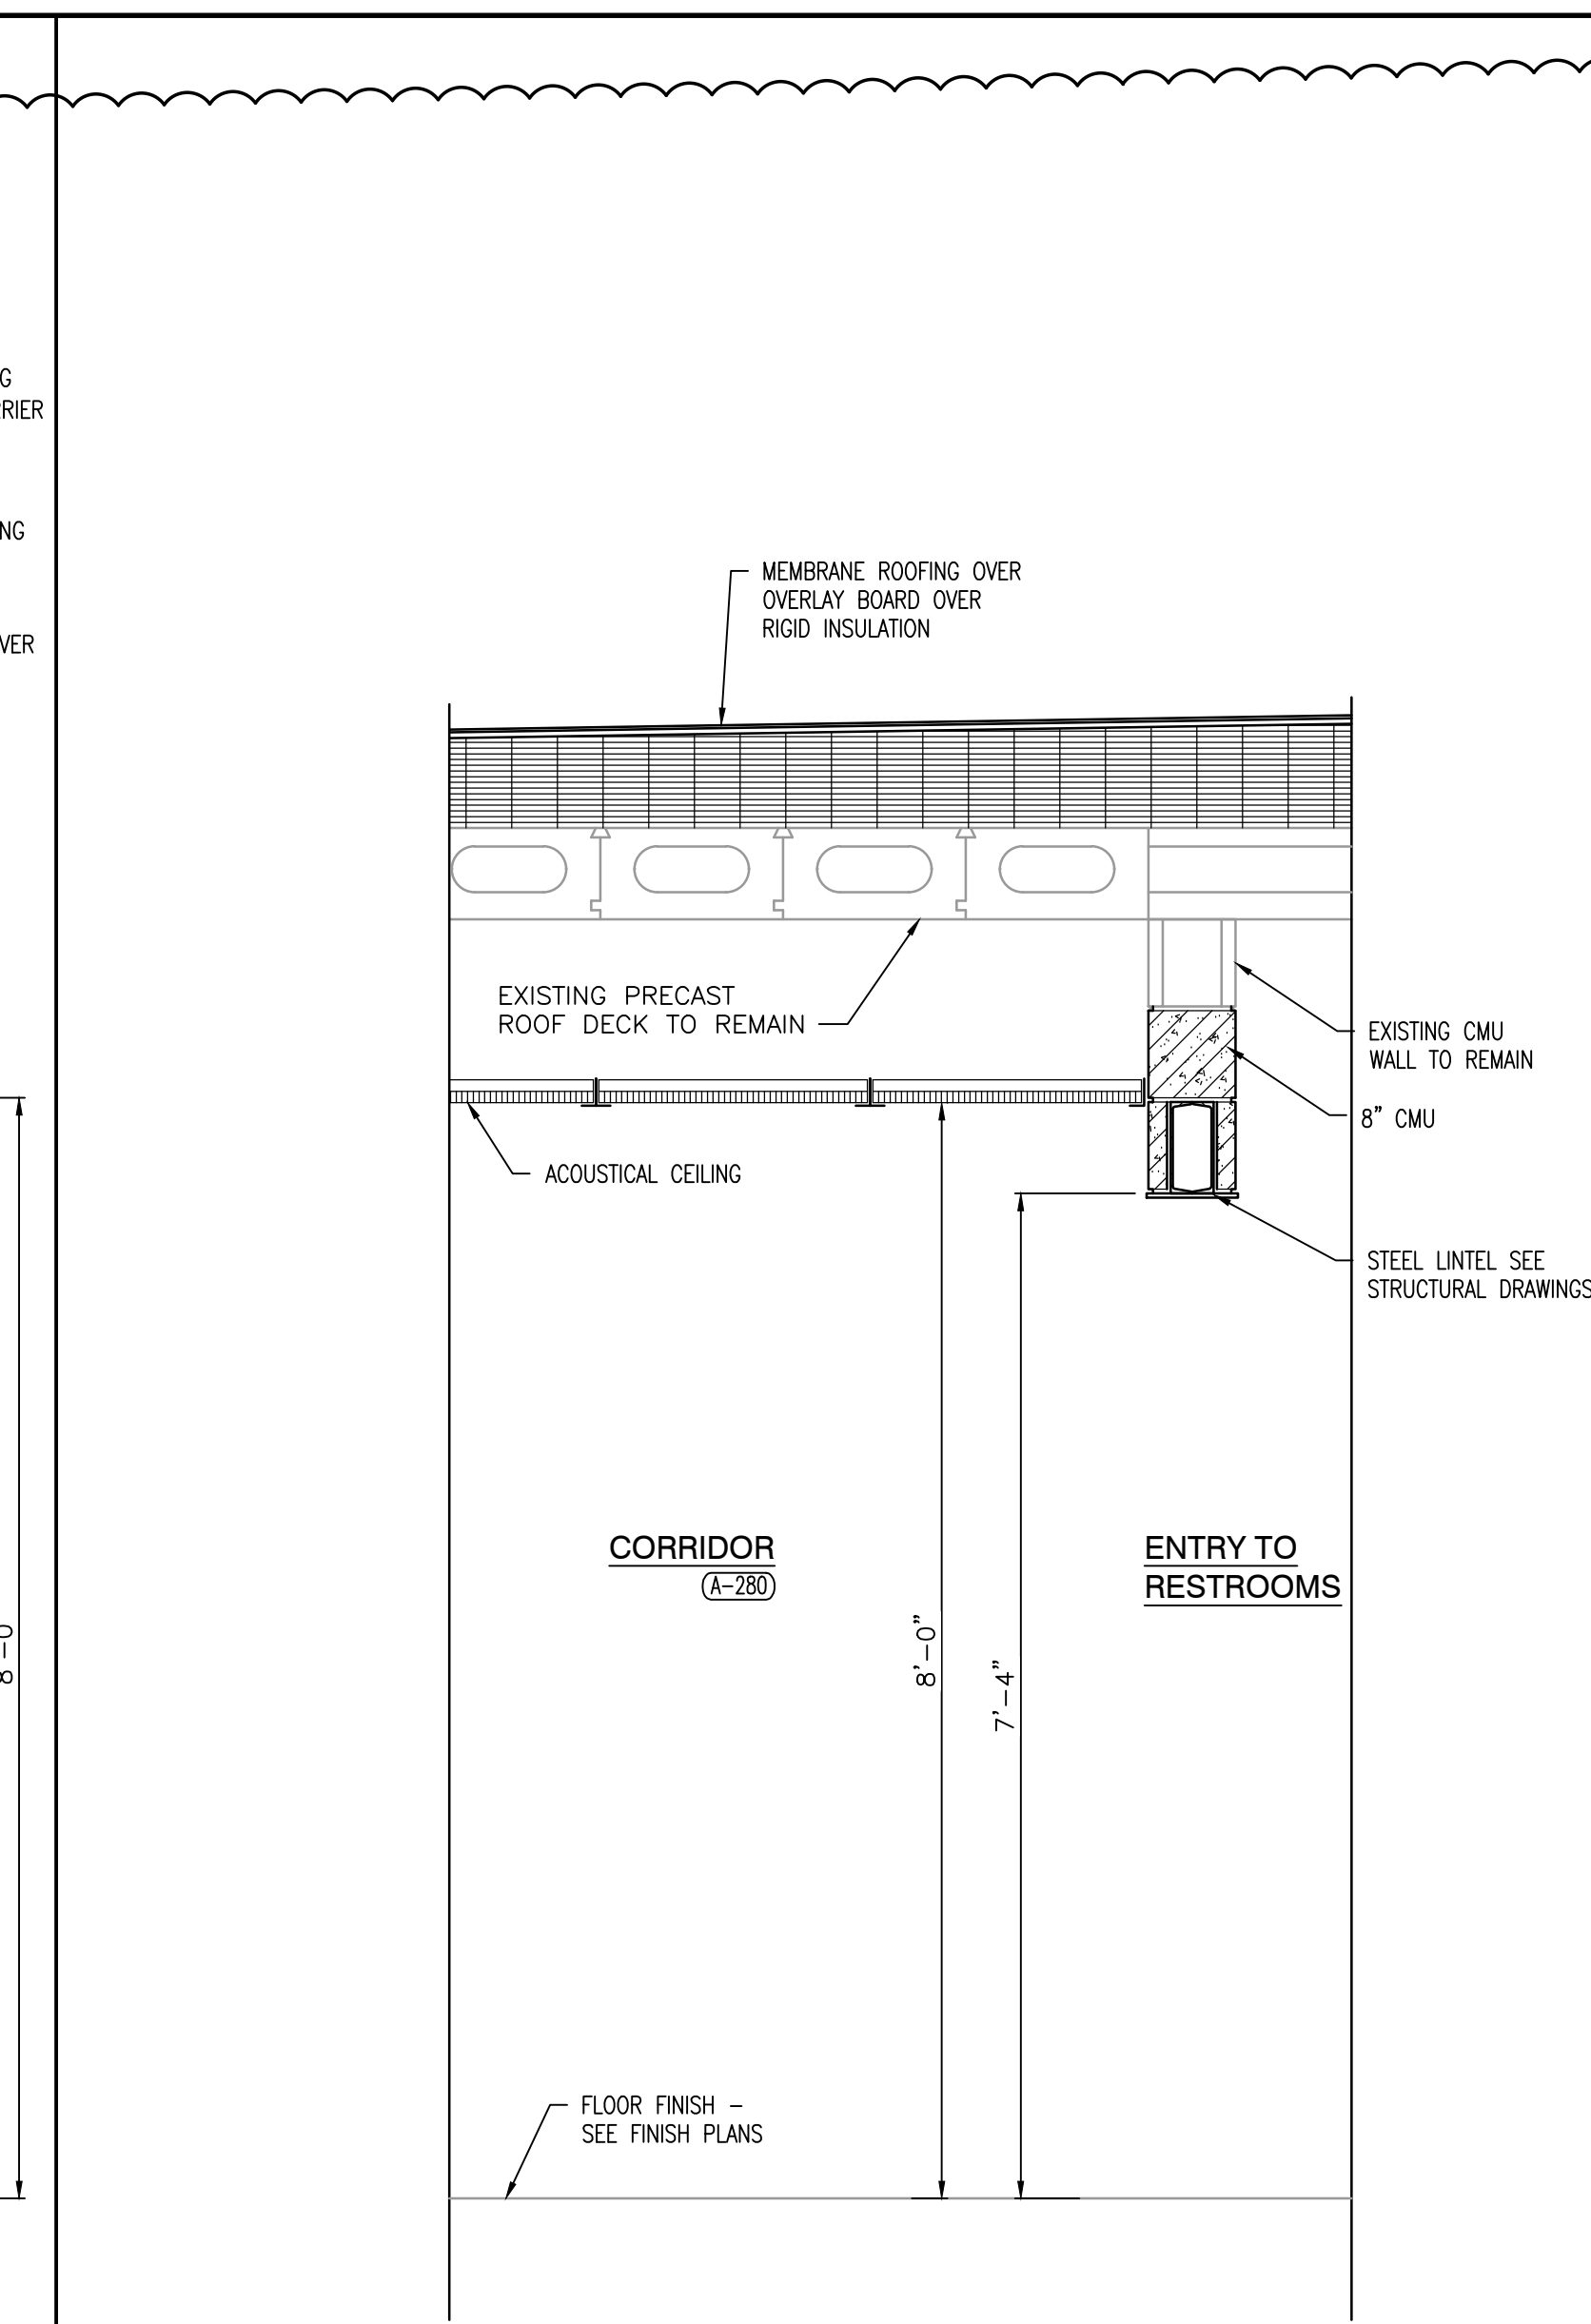


SECTION
SCALE: 3/4" = 1'-0"

6
A-402

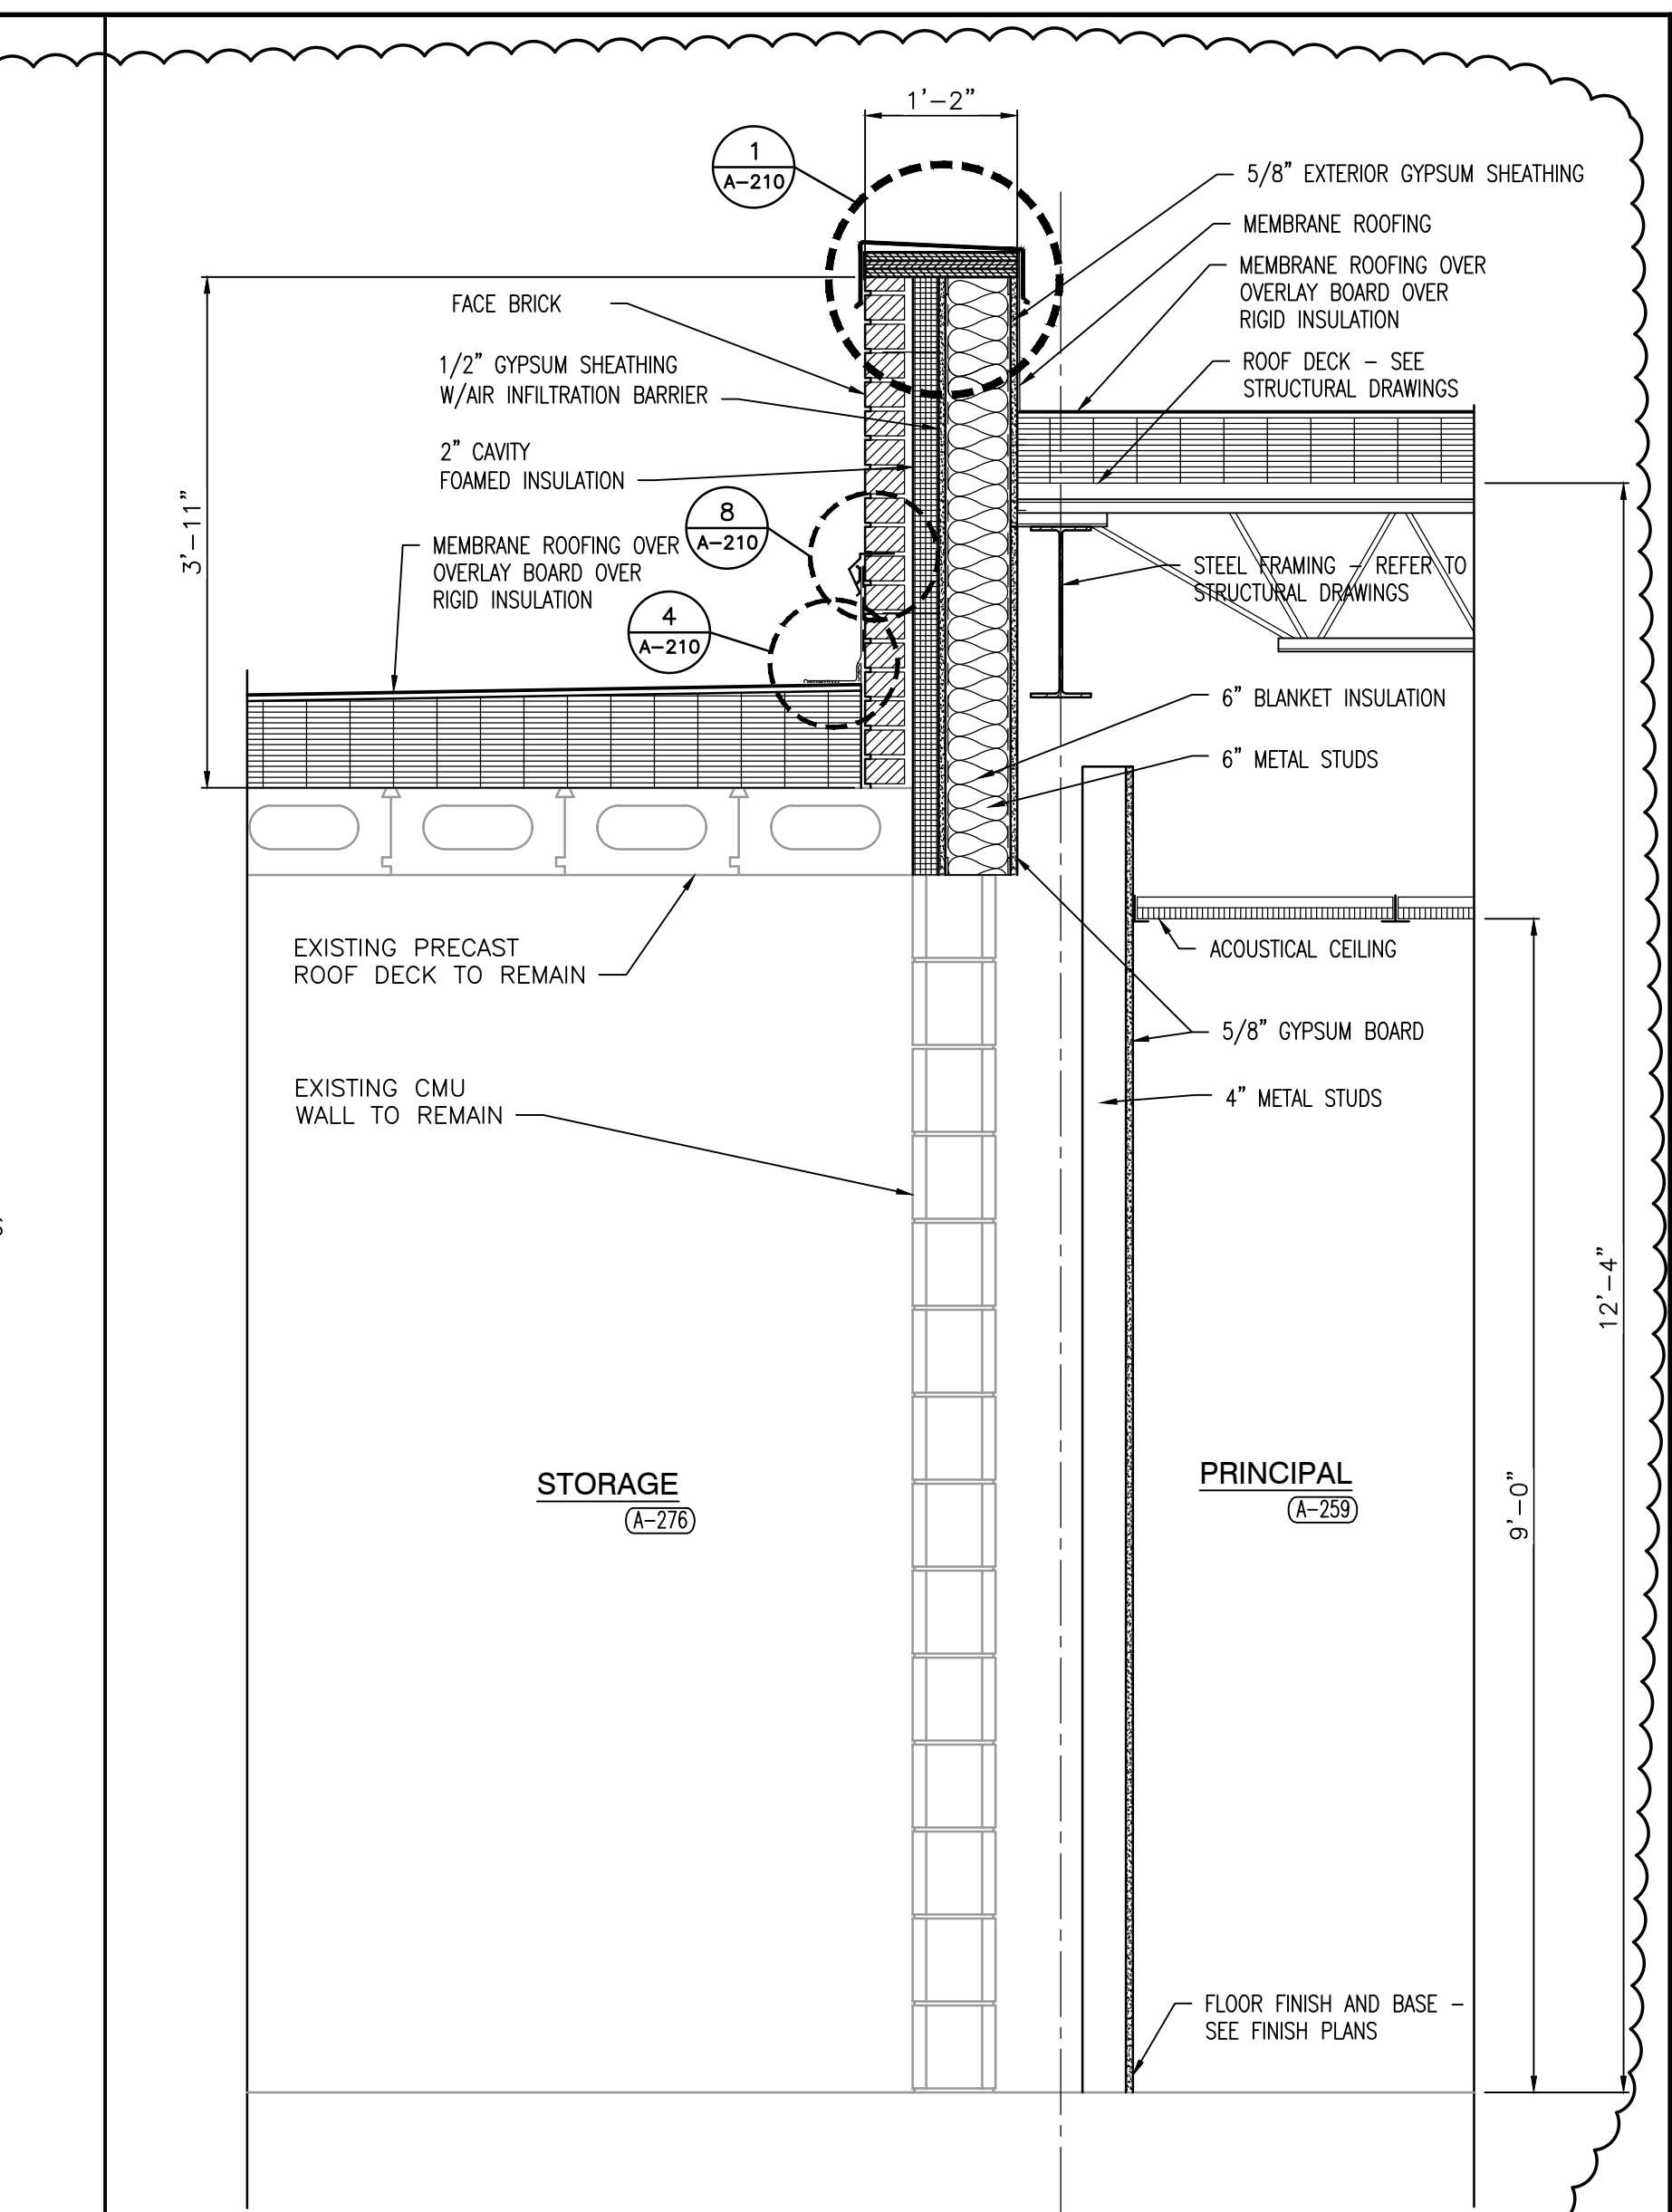


SECTION
SCALE: 3/4" = 1'-0"

5
A-402

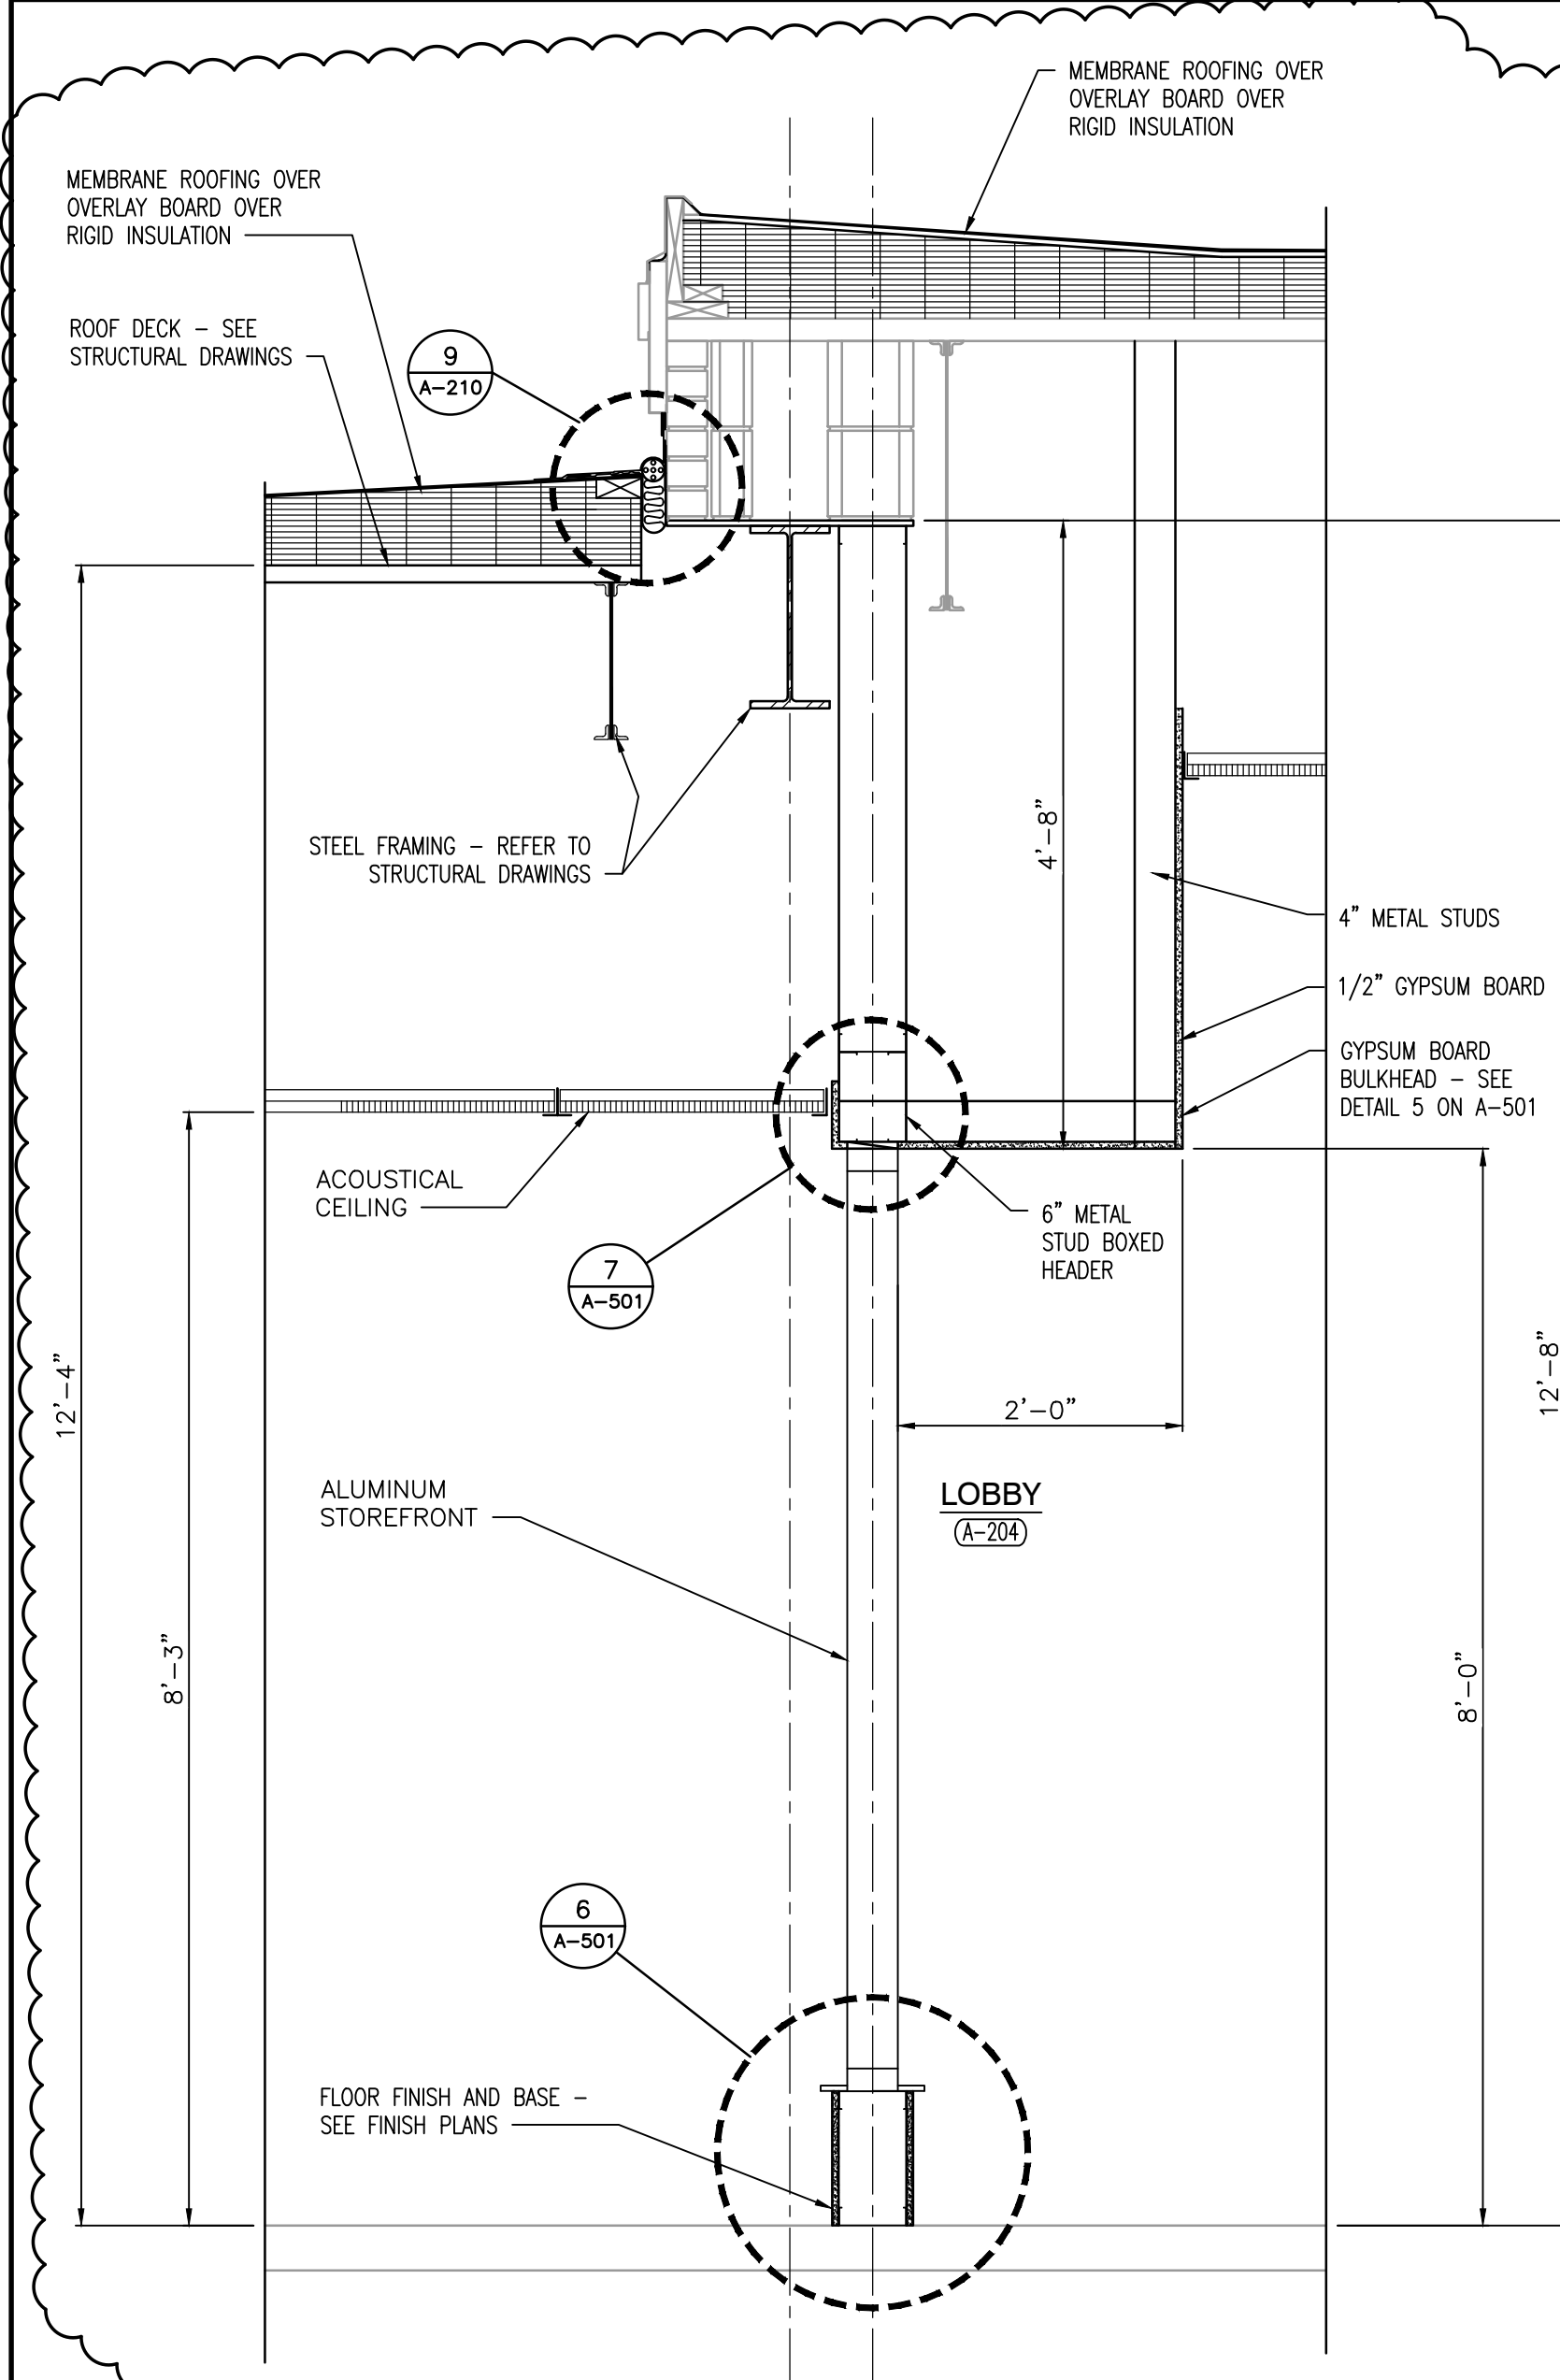


SECTION
SCALE: 3/4" = 1'-0"

4
A-402

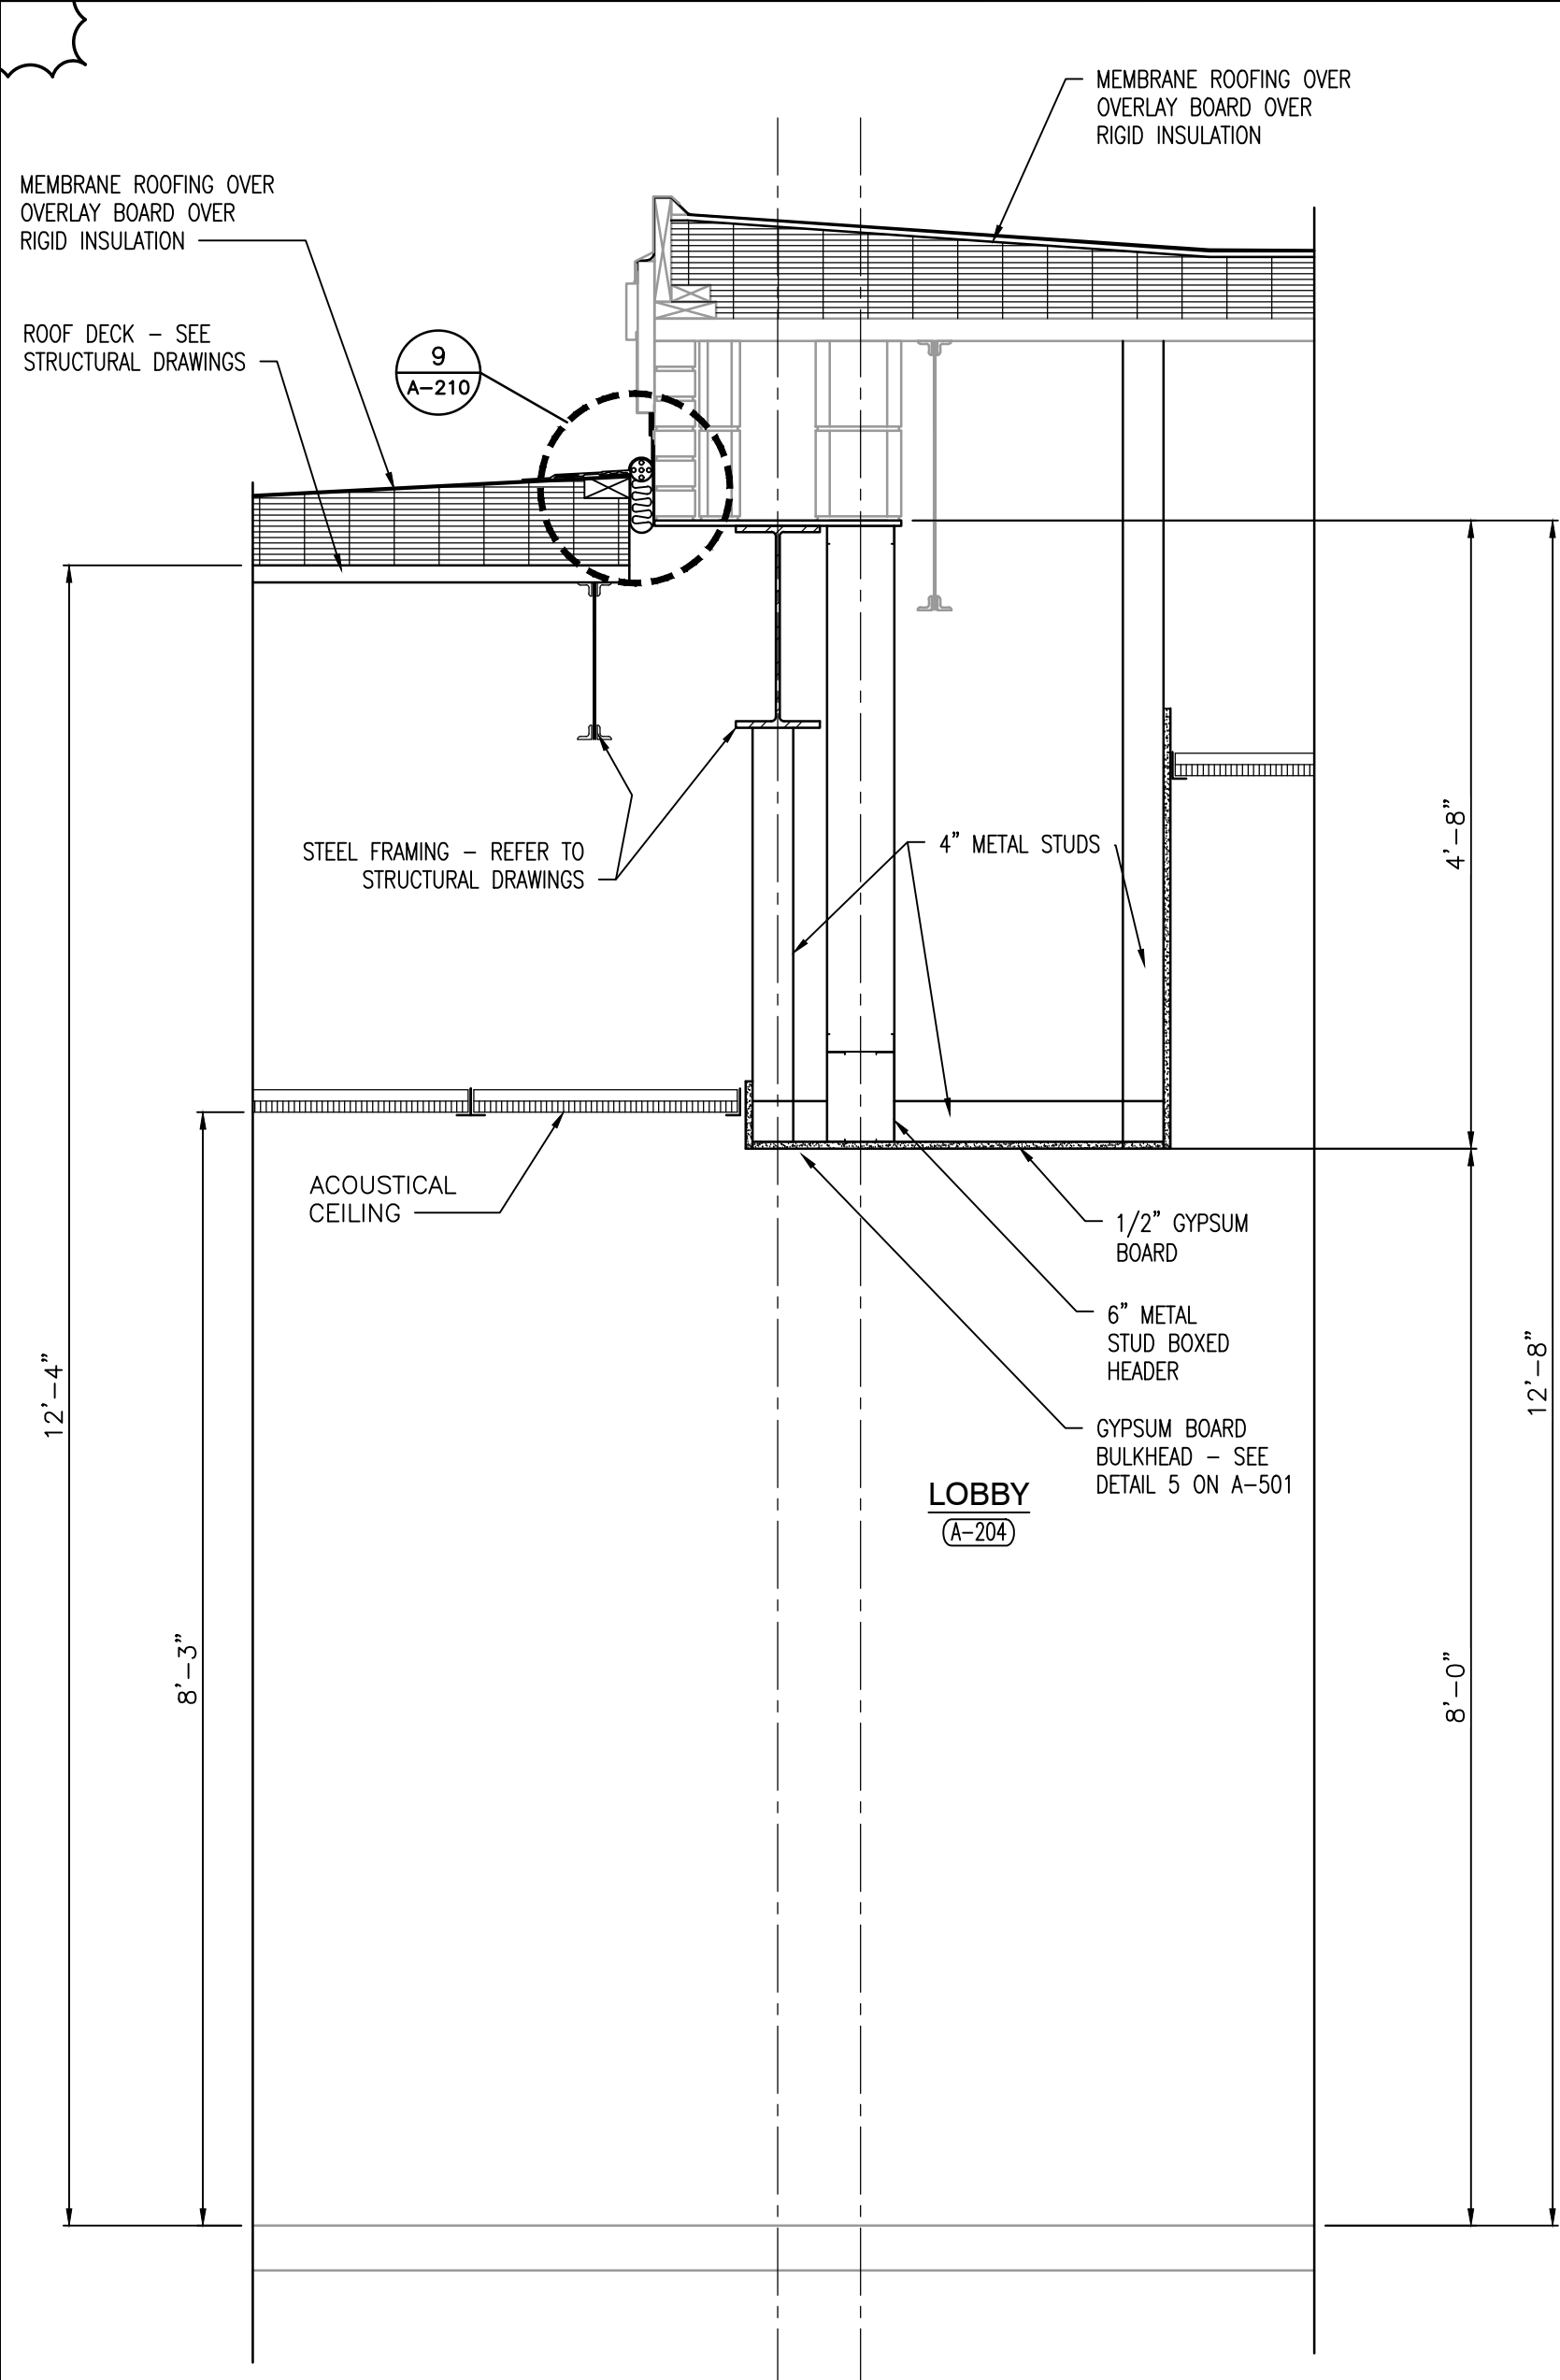


SECTION
SCALE: 3/4" = 1'-0"

3
A-402

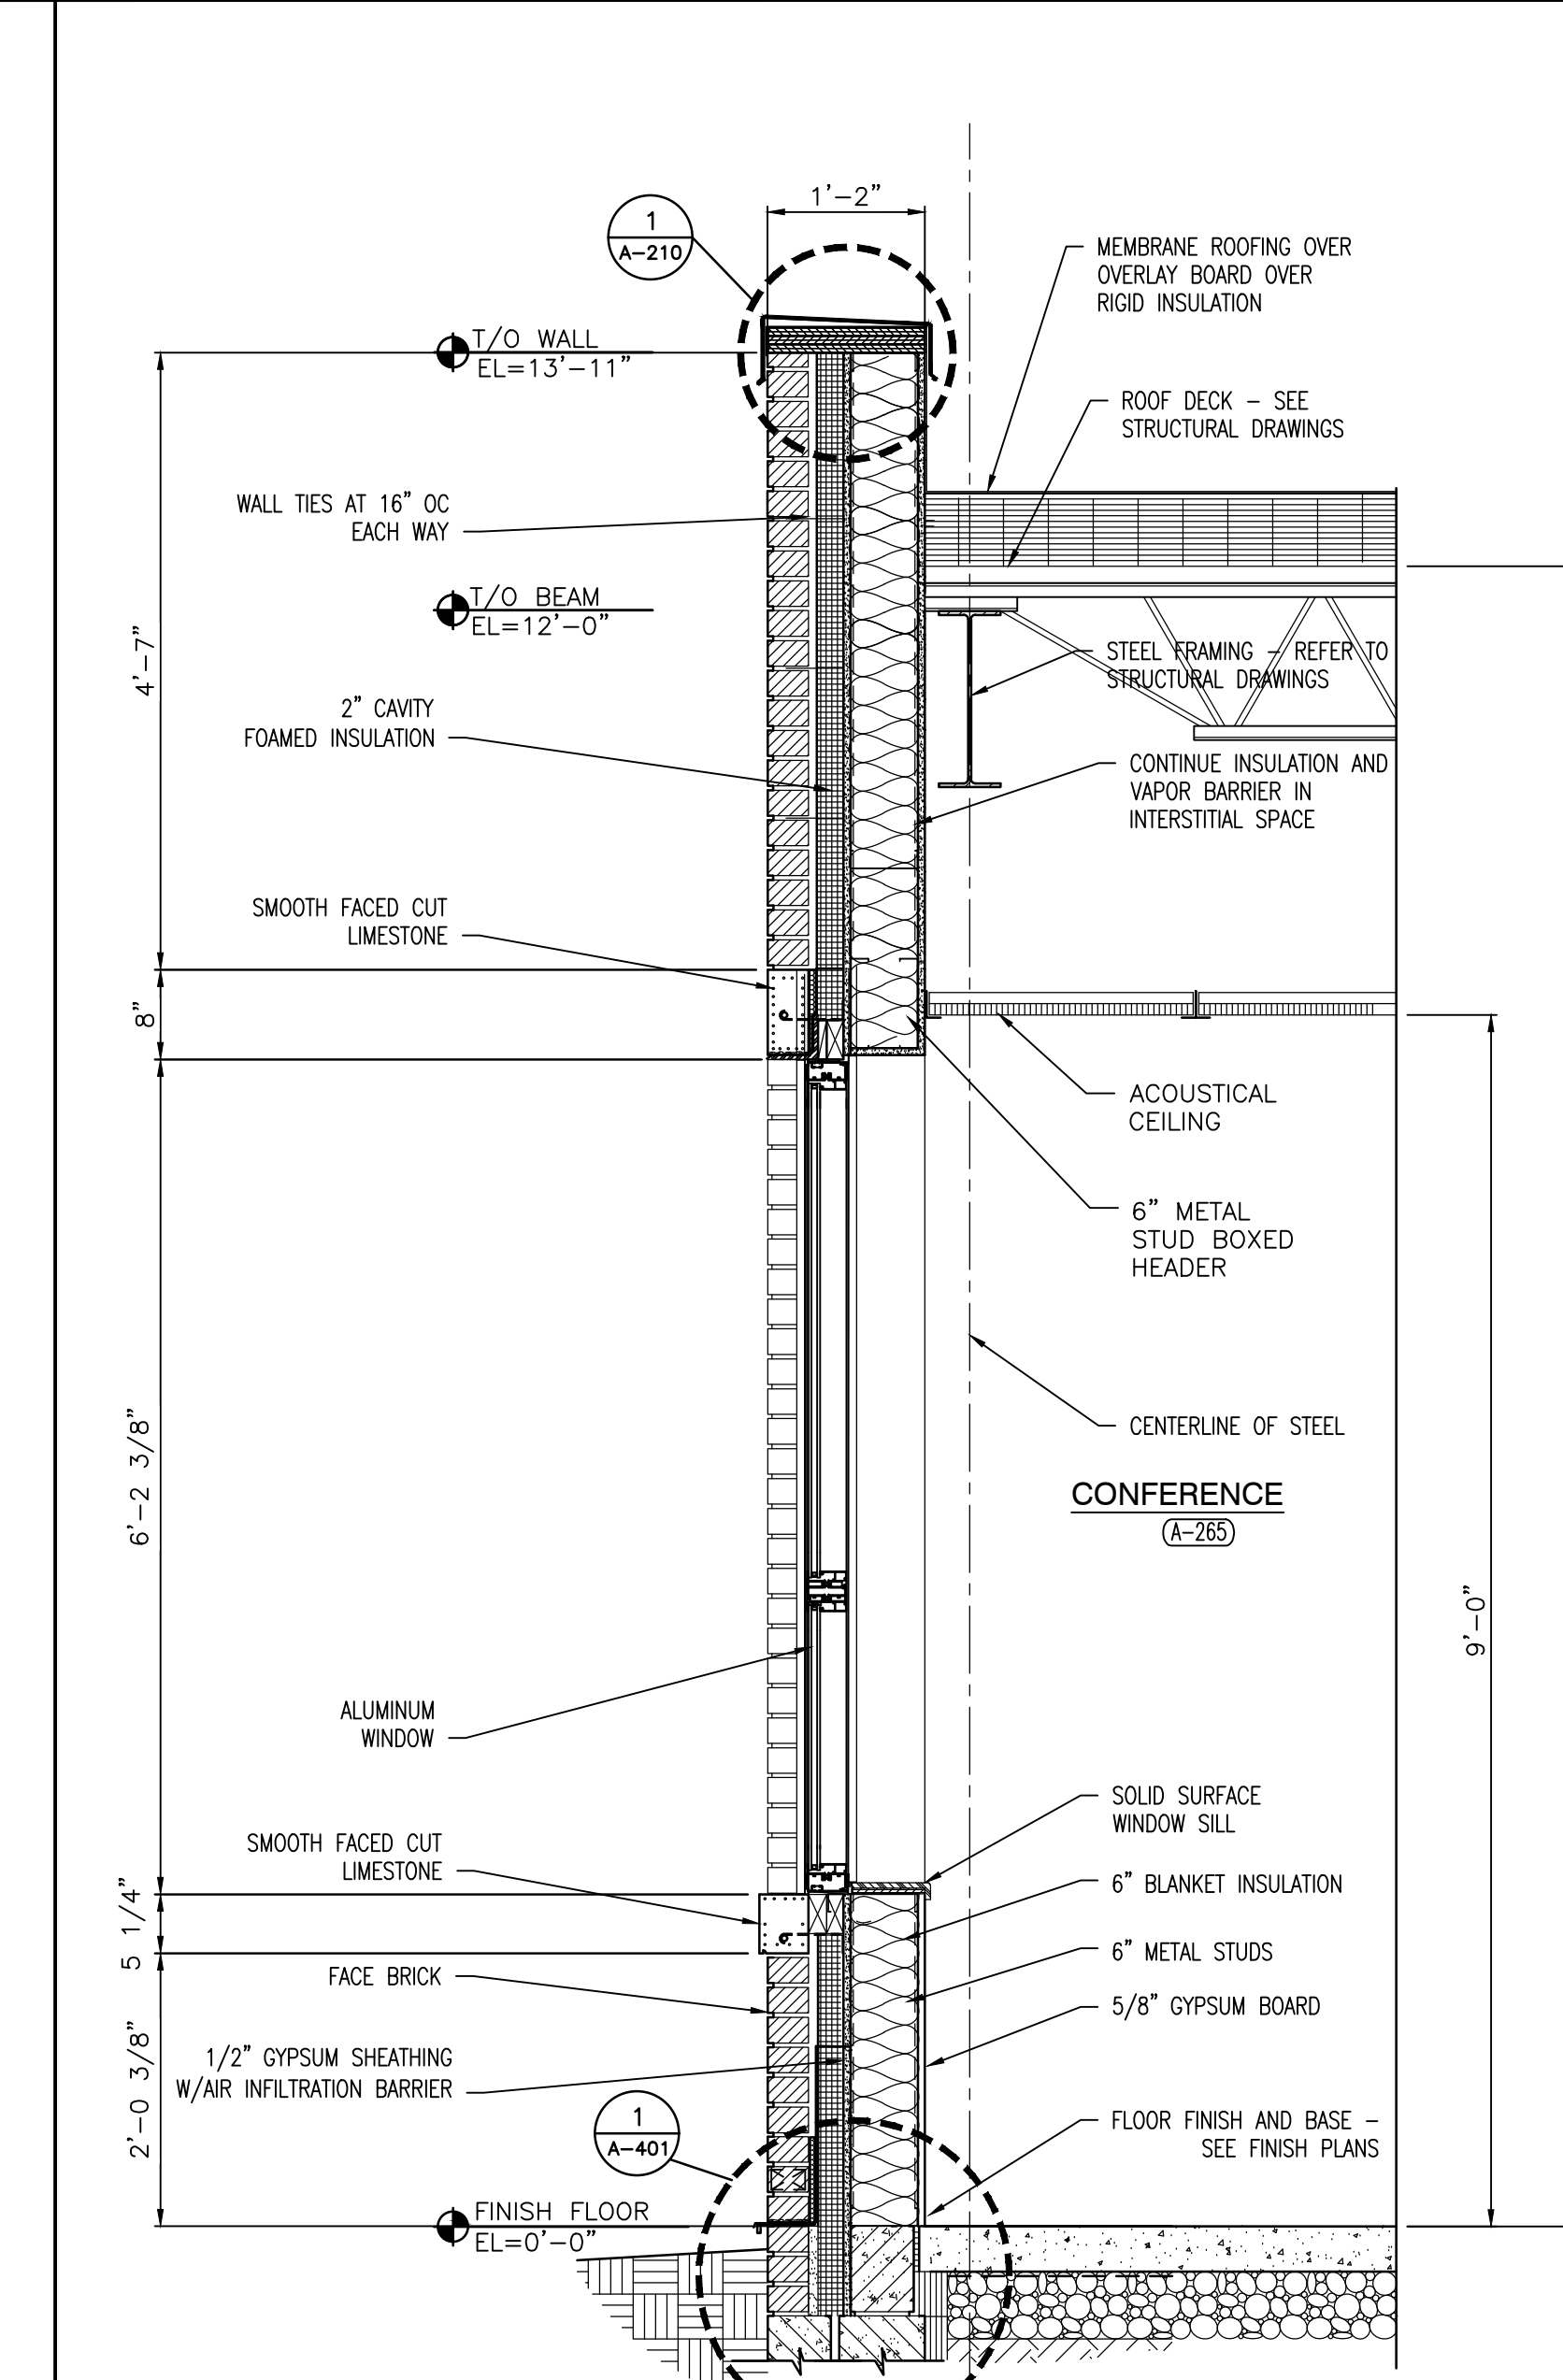


SECTION
SCALE: 3/4" = 1'-0"

2
A-402

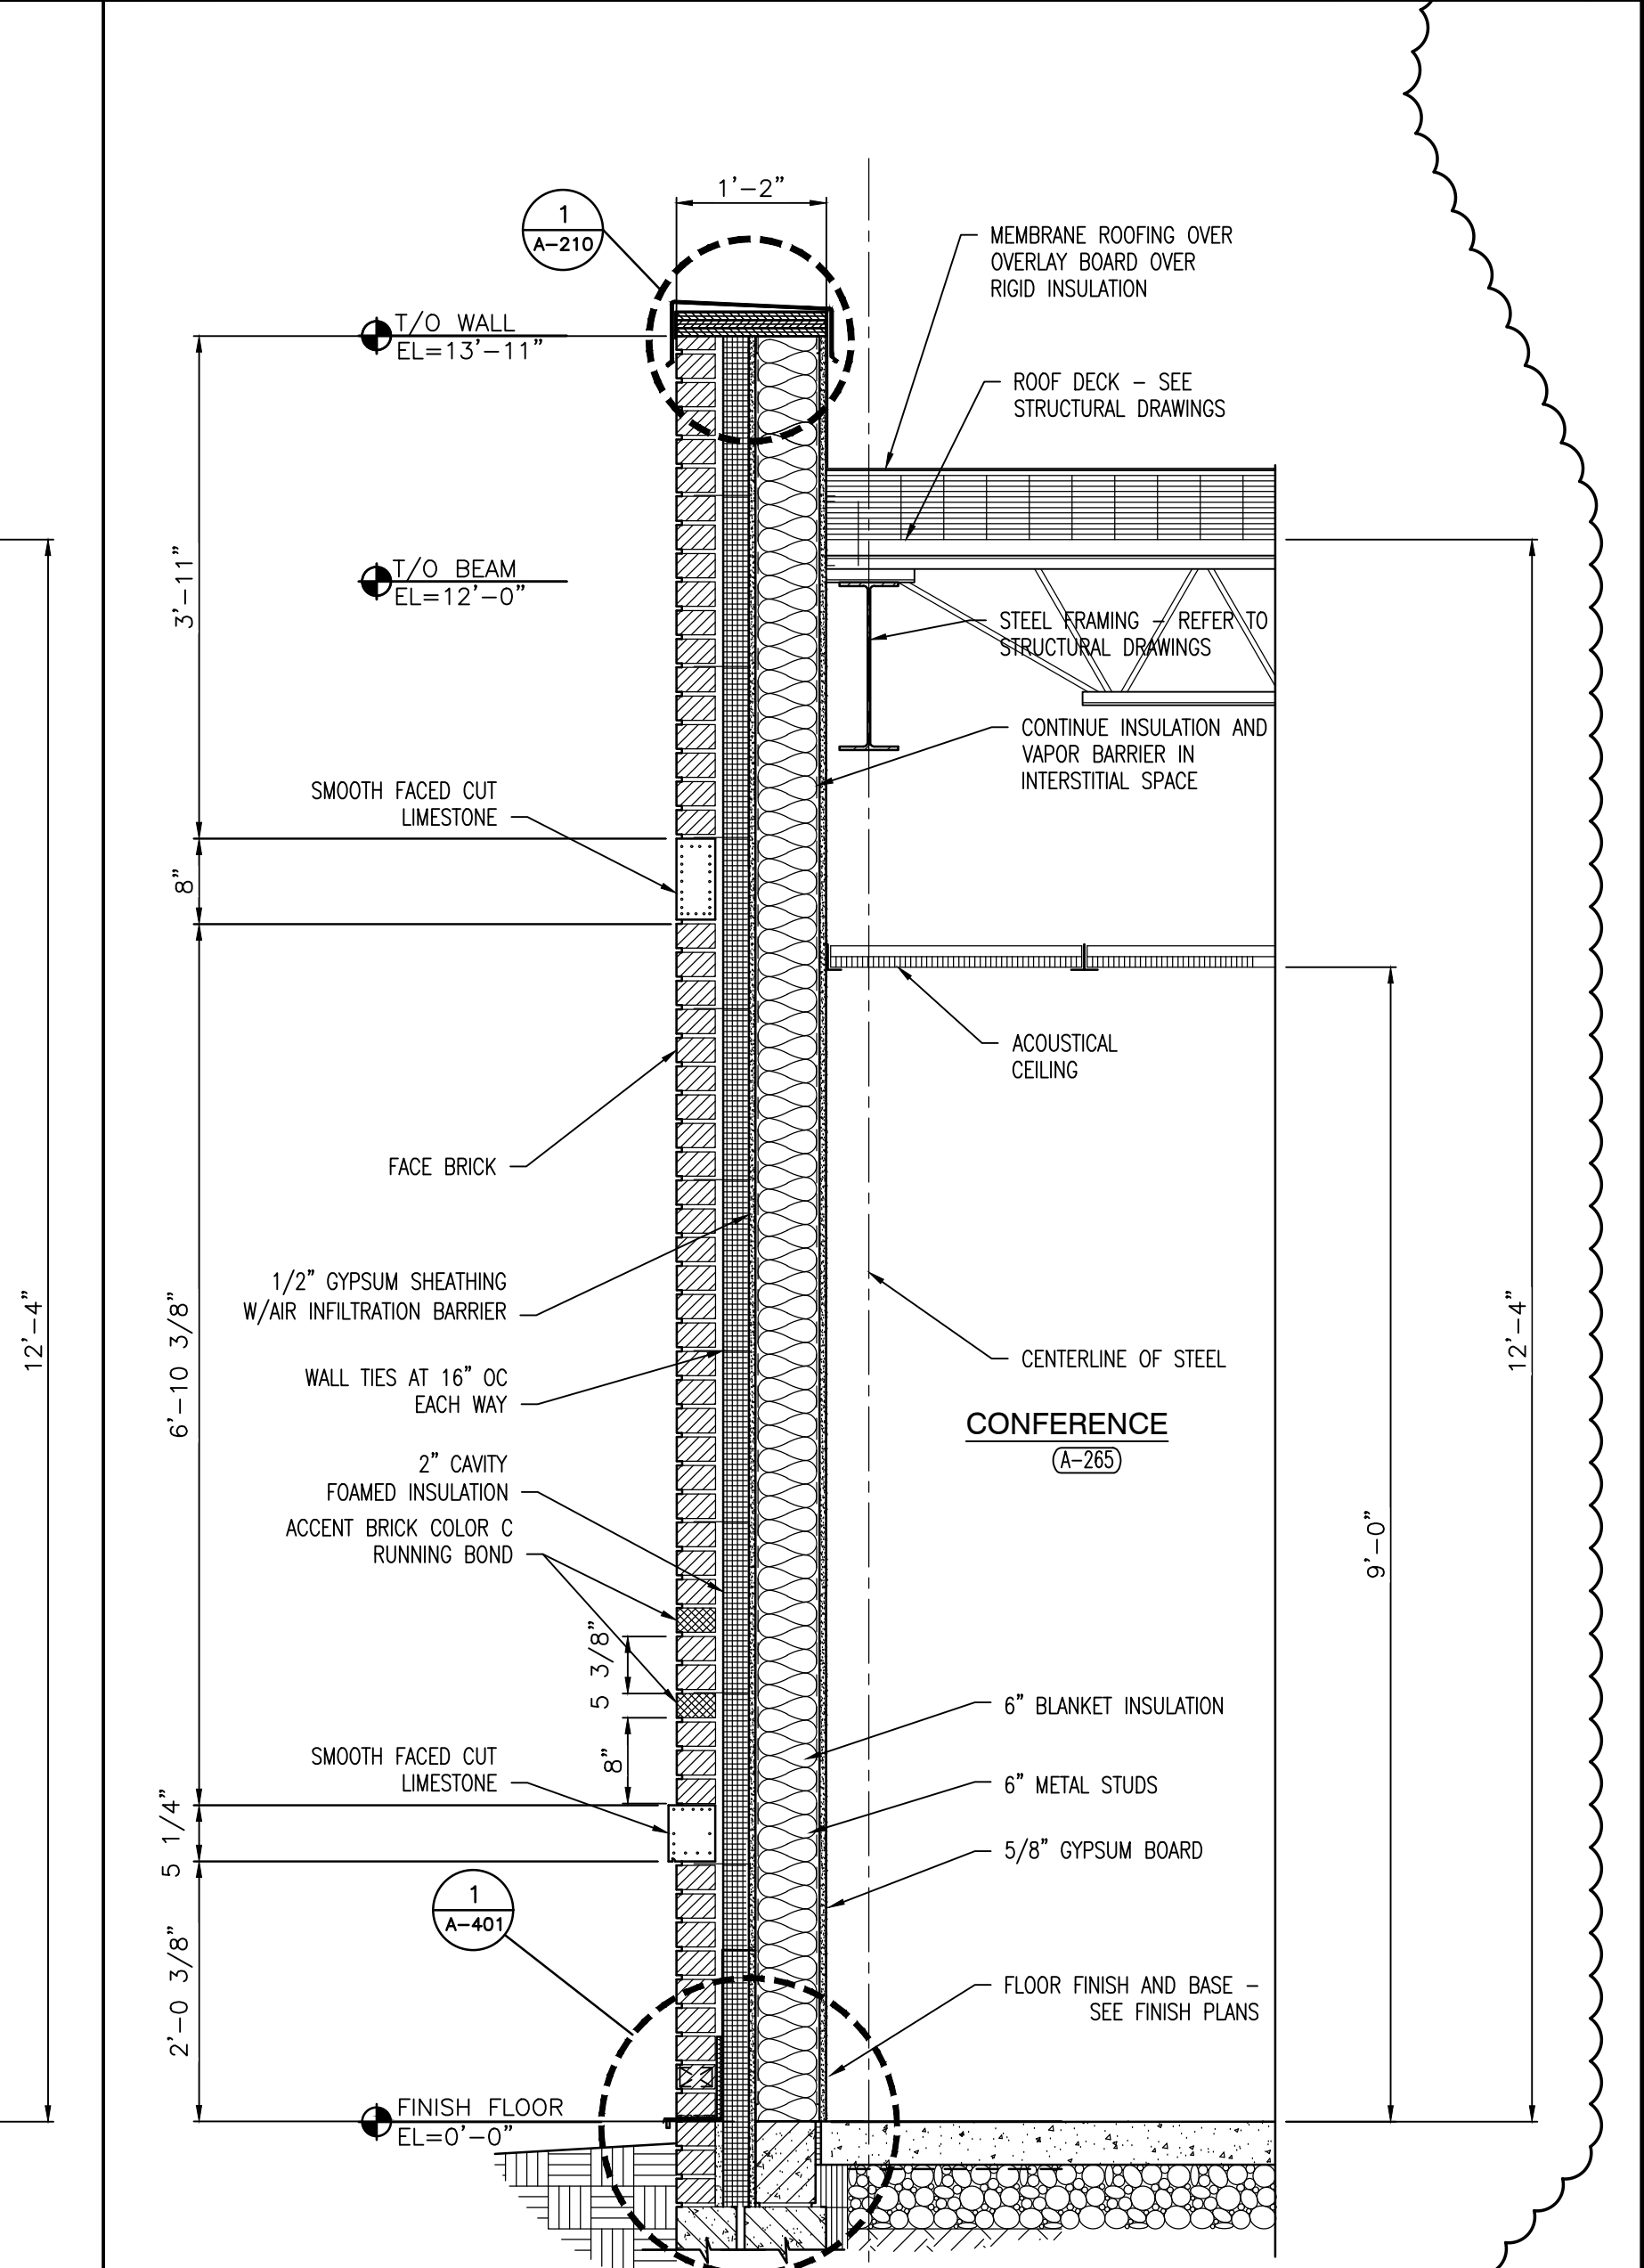

SECTION
SCALE: 3/4" = 1'-0"

1
A-402

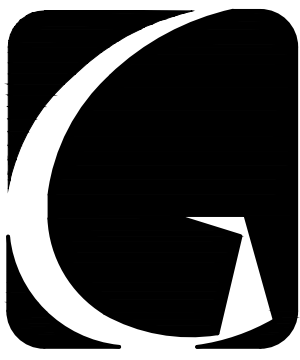


GIBRALTAR
DESIGN
ARCHITECTURE • ENGINEERING • INTERIOR DESIGN

PROJECT
**FAIRVIEW
ELEMENTARY
SCHOOL
RENOVATIONS**

LOGANSPORT COMMUNITY
SCHOOL CORPORATION
LOGANSPORT, INDIANA

GIBRALTAR DESIGN
9102 N. Meridian St., Ste. 300
Indianapolis, IN 46260
Homepage: www.GibraltarDesign.com
Email: info@GibraltarDesign.com
Phone: 317.580.5777 Fax: 317.580.5778

PROJECT
20-157
DATE
06/18/21
COORDINATED BY
DJW
DRAWN BY
KLS
CHECKED BY
DJW

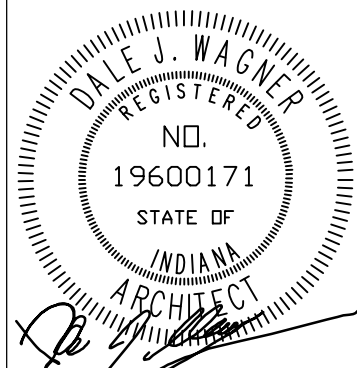

COPYRIGHT NOTICE:
THE CONCEPTS, DESIGNS, PLANS, DETAILS, ETC., SHOWN ON THIS DOCUMENT ARE THE PROPERTY OF GIBRALTAR DESIGN AND WERE CREATED FOR USE ON THIS SPECIFIC PROJECT. NONE OF THIS INFORMATION SHALL BE USED BY ANY PERSON OR FIRM FOR ANY PURPOSE WITHOUT THE EXPRESS WRITTEN CONSENT OF GIBRALTAR DESIGN. THE OWNER MAY RETAIN COPIES FOR INFORMATION AND REFERENCE IN CONNECTION ONLY WITH THIS PROJECT.

REVISIONS		
MARK	DATE	ISSUED FOR
AD.01	7/9/21	AD.01


DRAWING
WALL SECTIONS

PROJECT
**FAIRVIEW ELEMENTARY SCHOOL
RENOVATIONS**

© GIBRALTAR DESIGN


SHEET

A-403

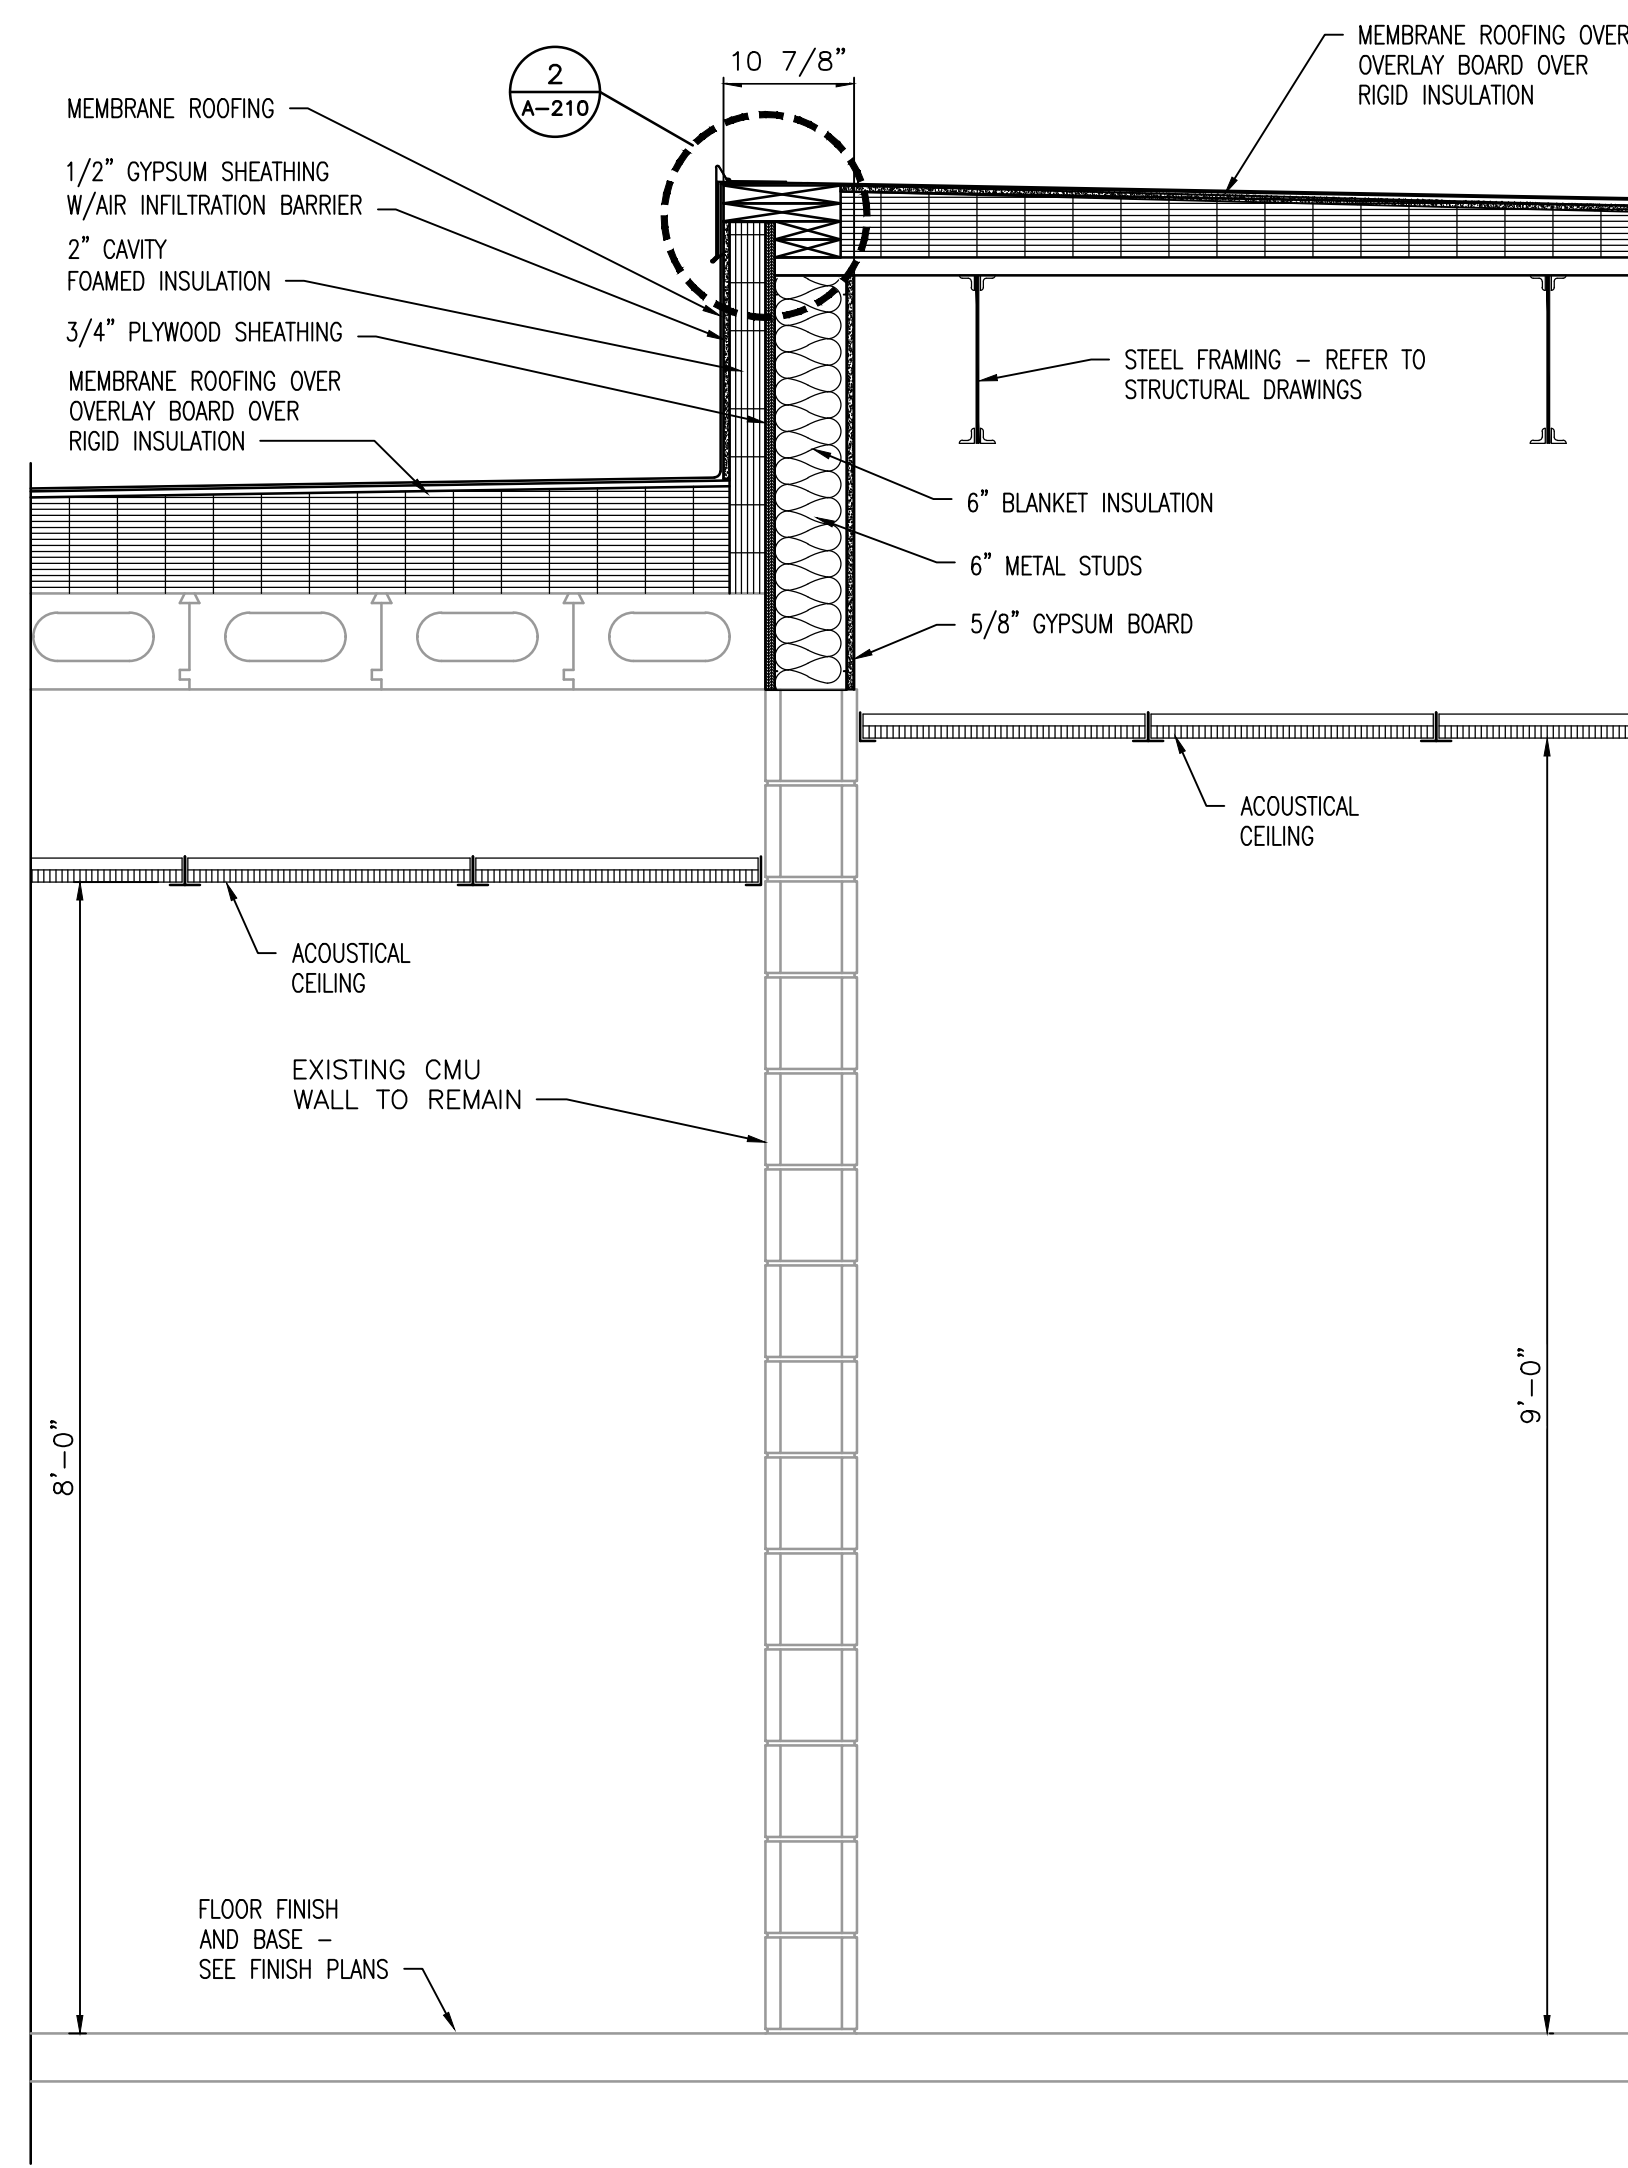


SECTION
SCALE: 3/4" = 1'-0"

4
A-403

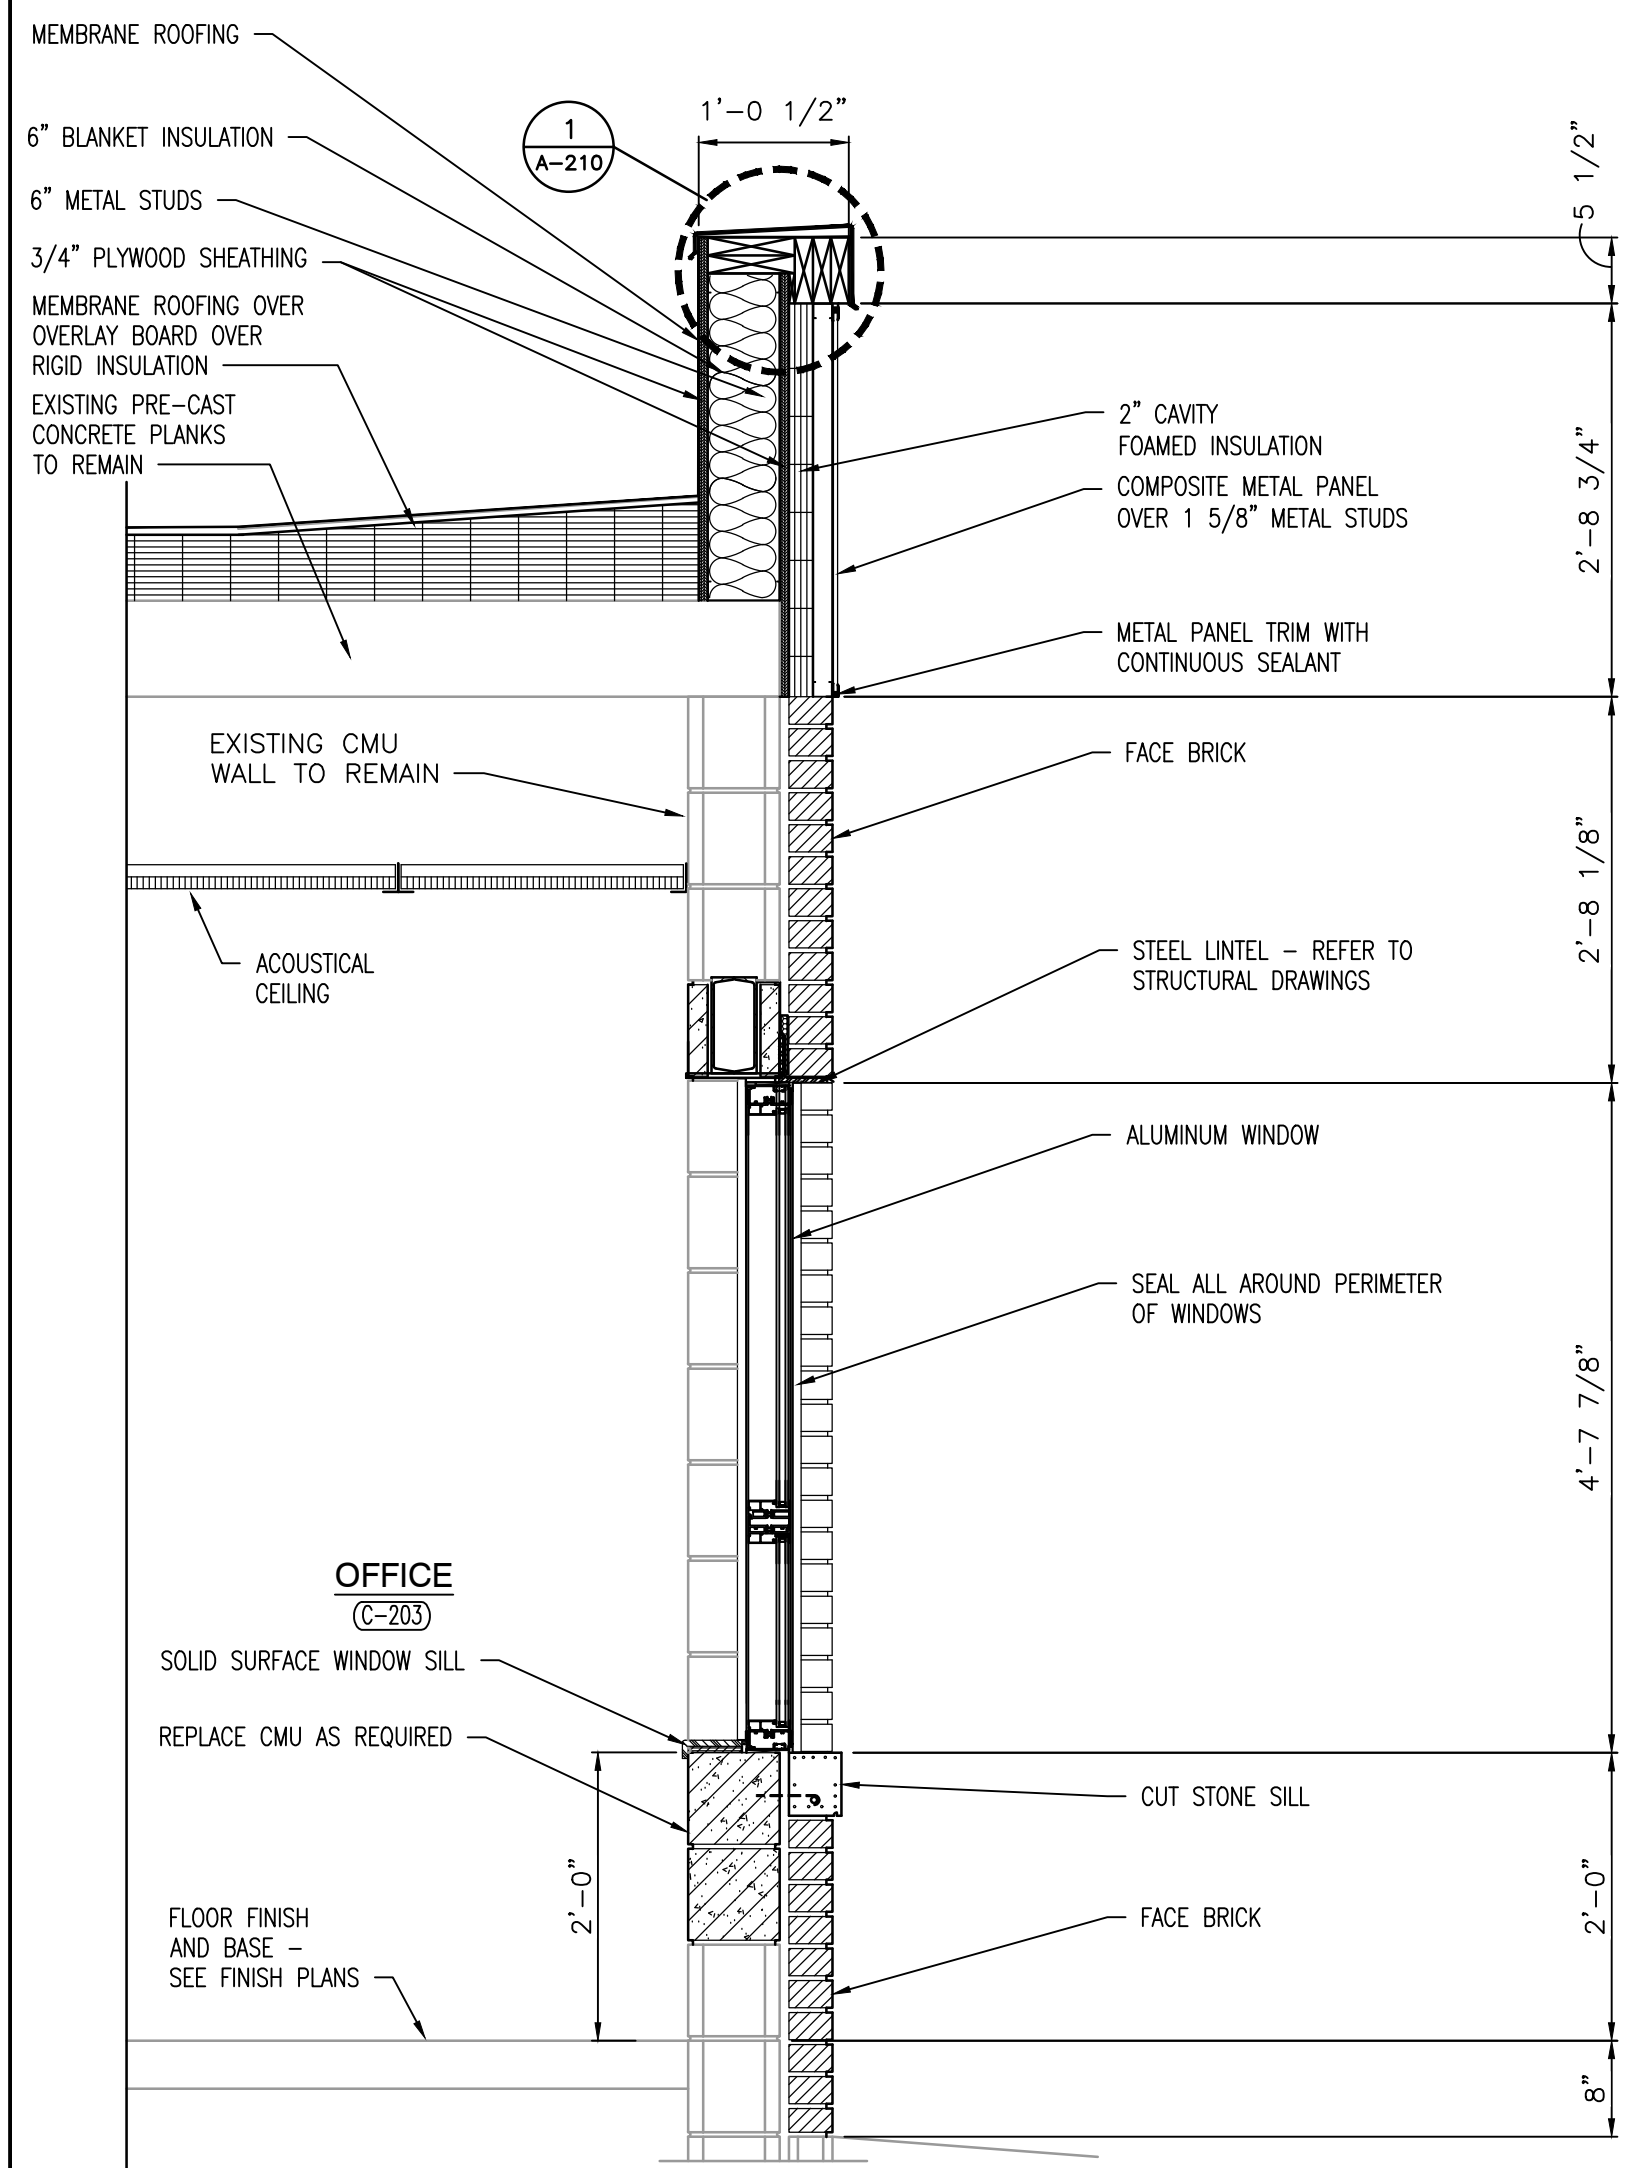


SECTION
SCALE: 3/4" = 1'-0"

6
A-403

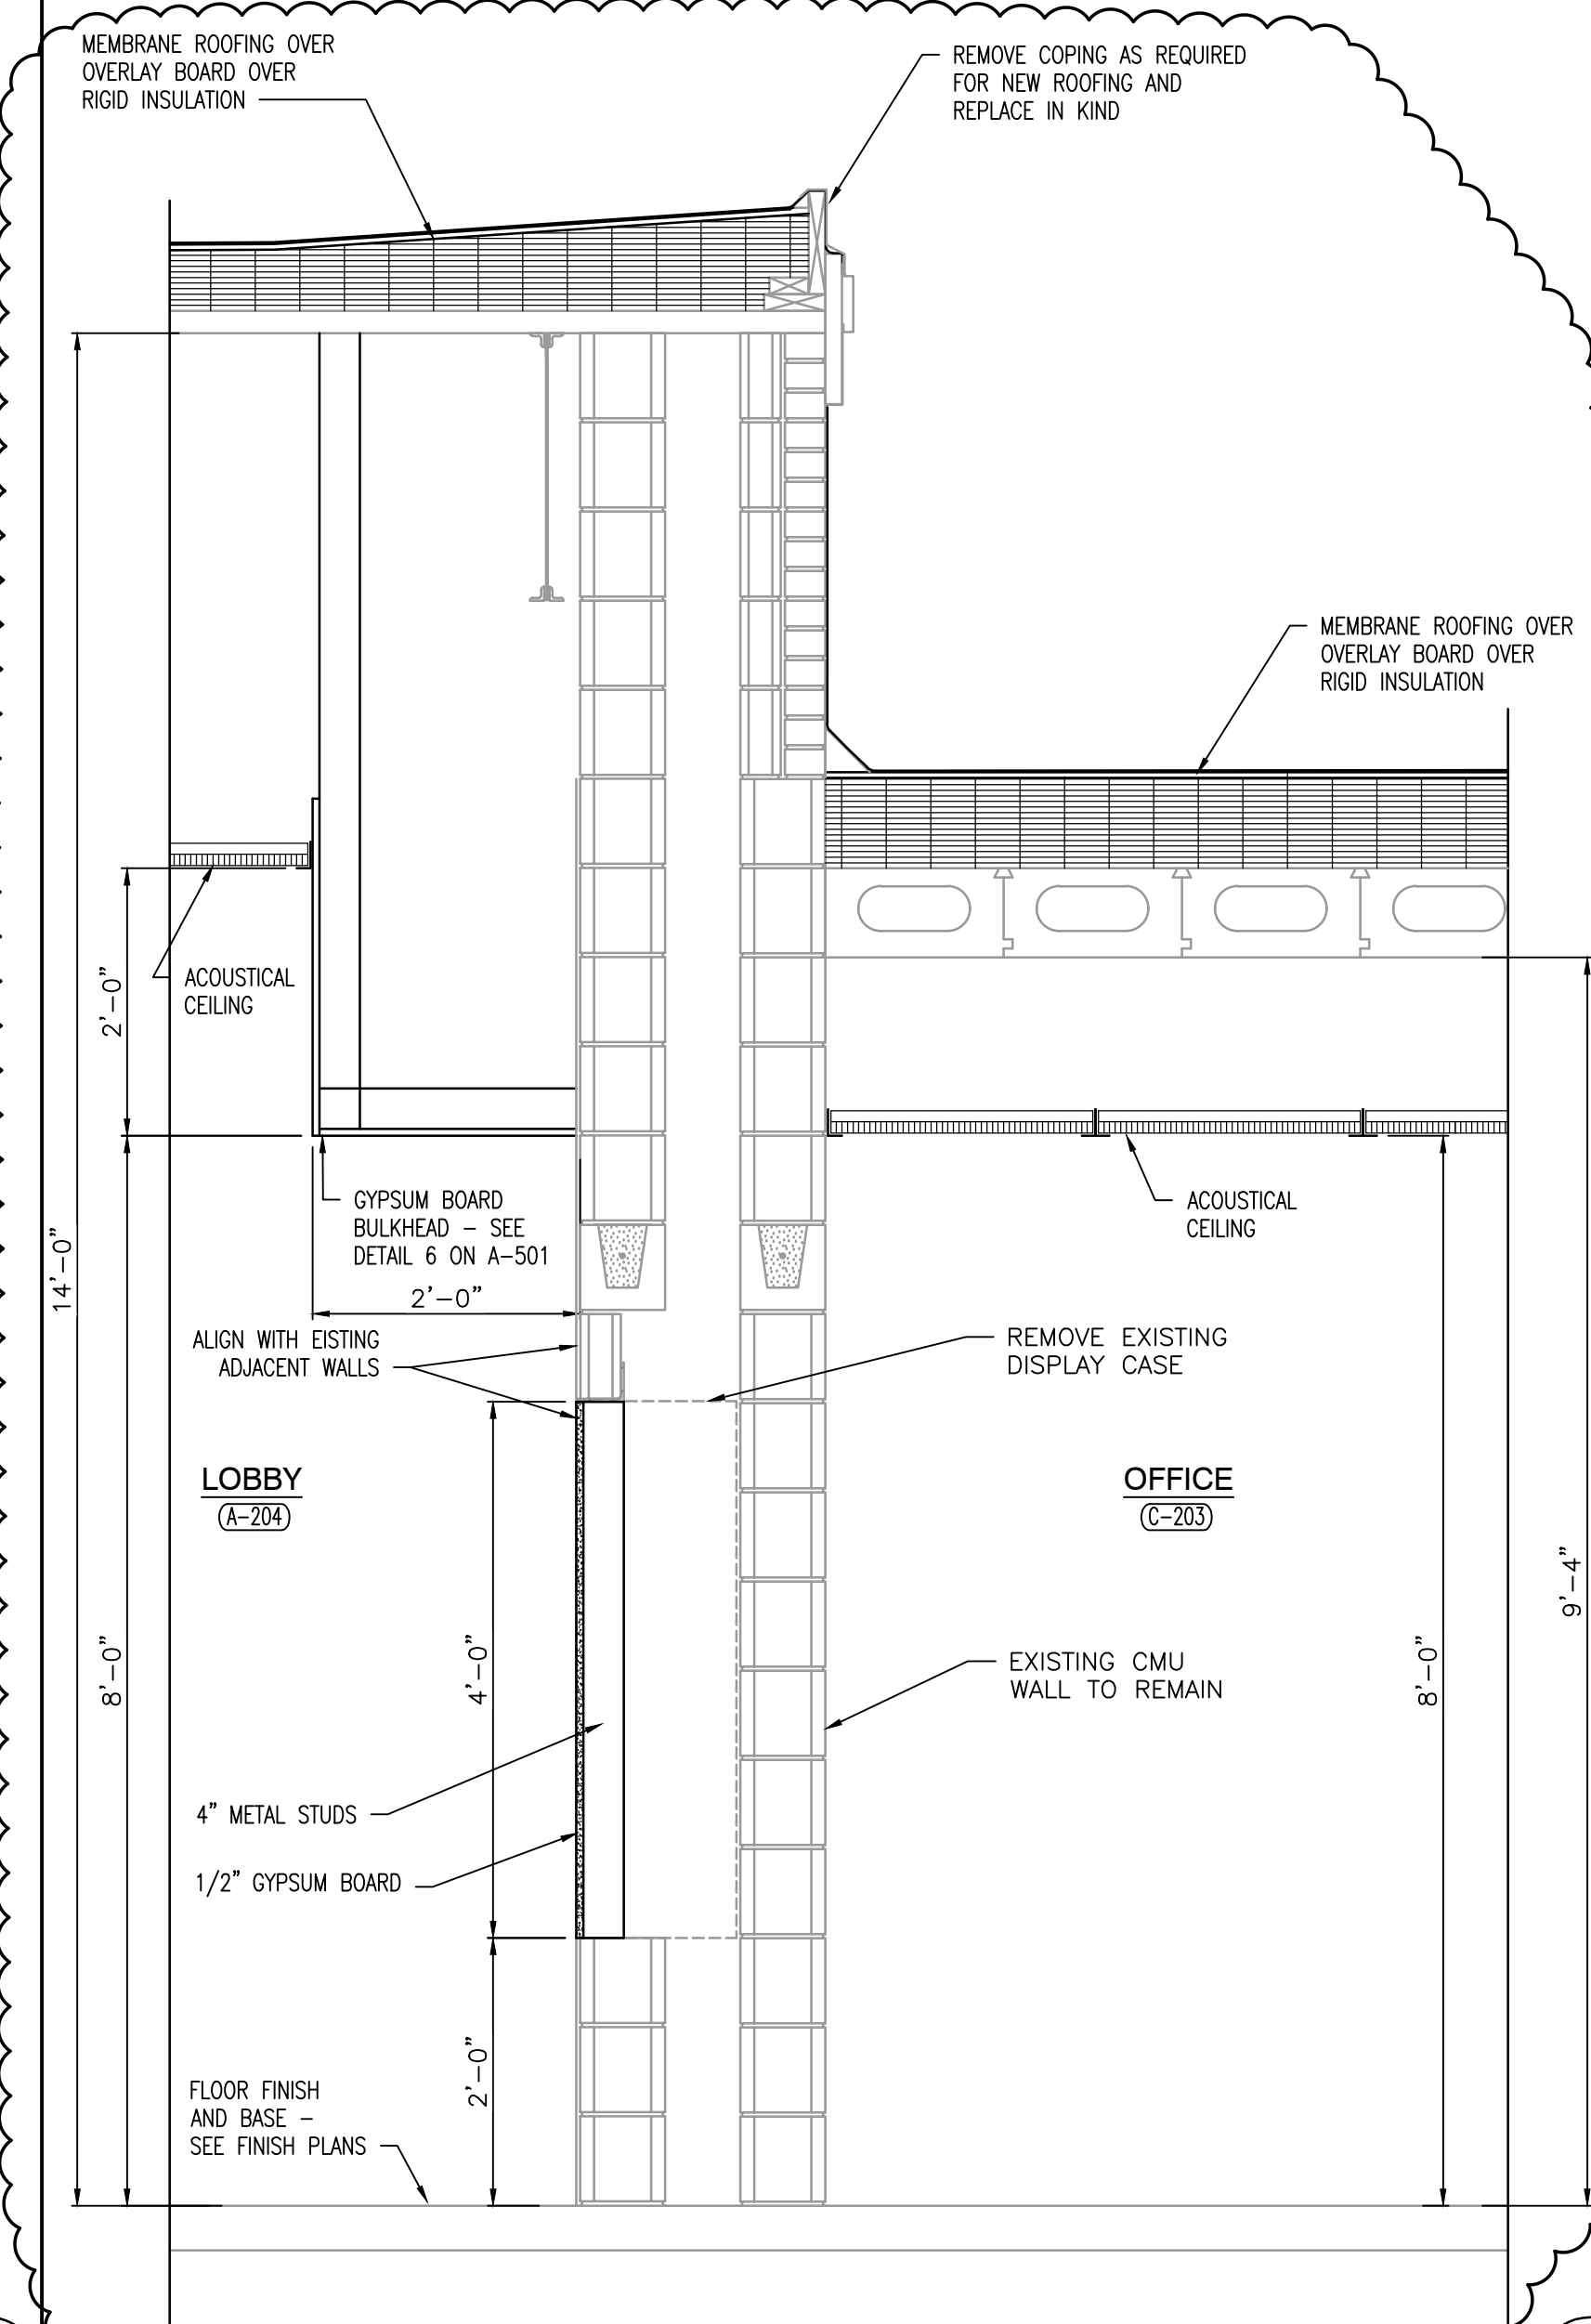


SECTION
SCALE: 3/4" = 1'-0"

5
A-403

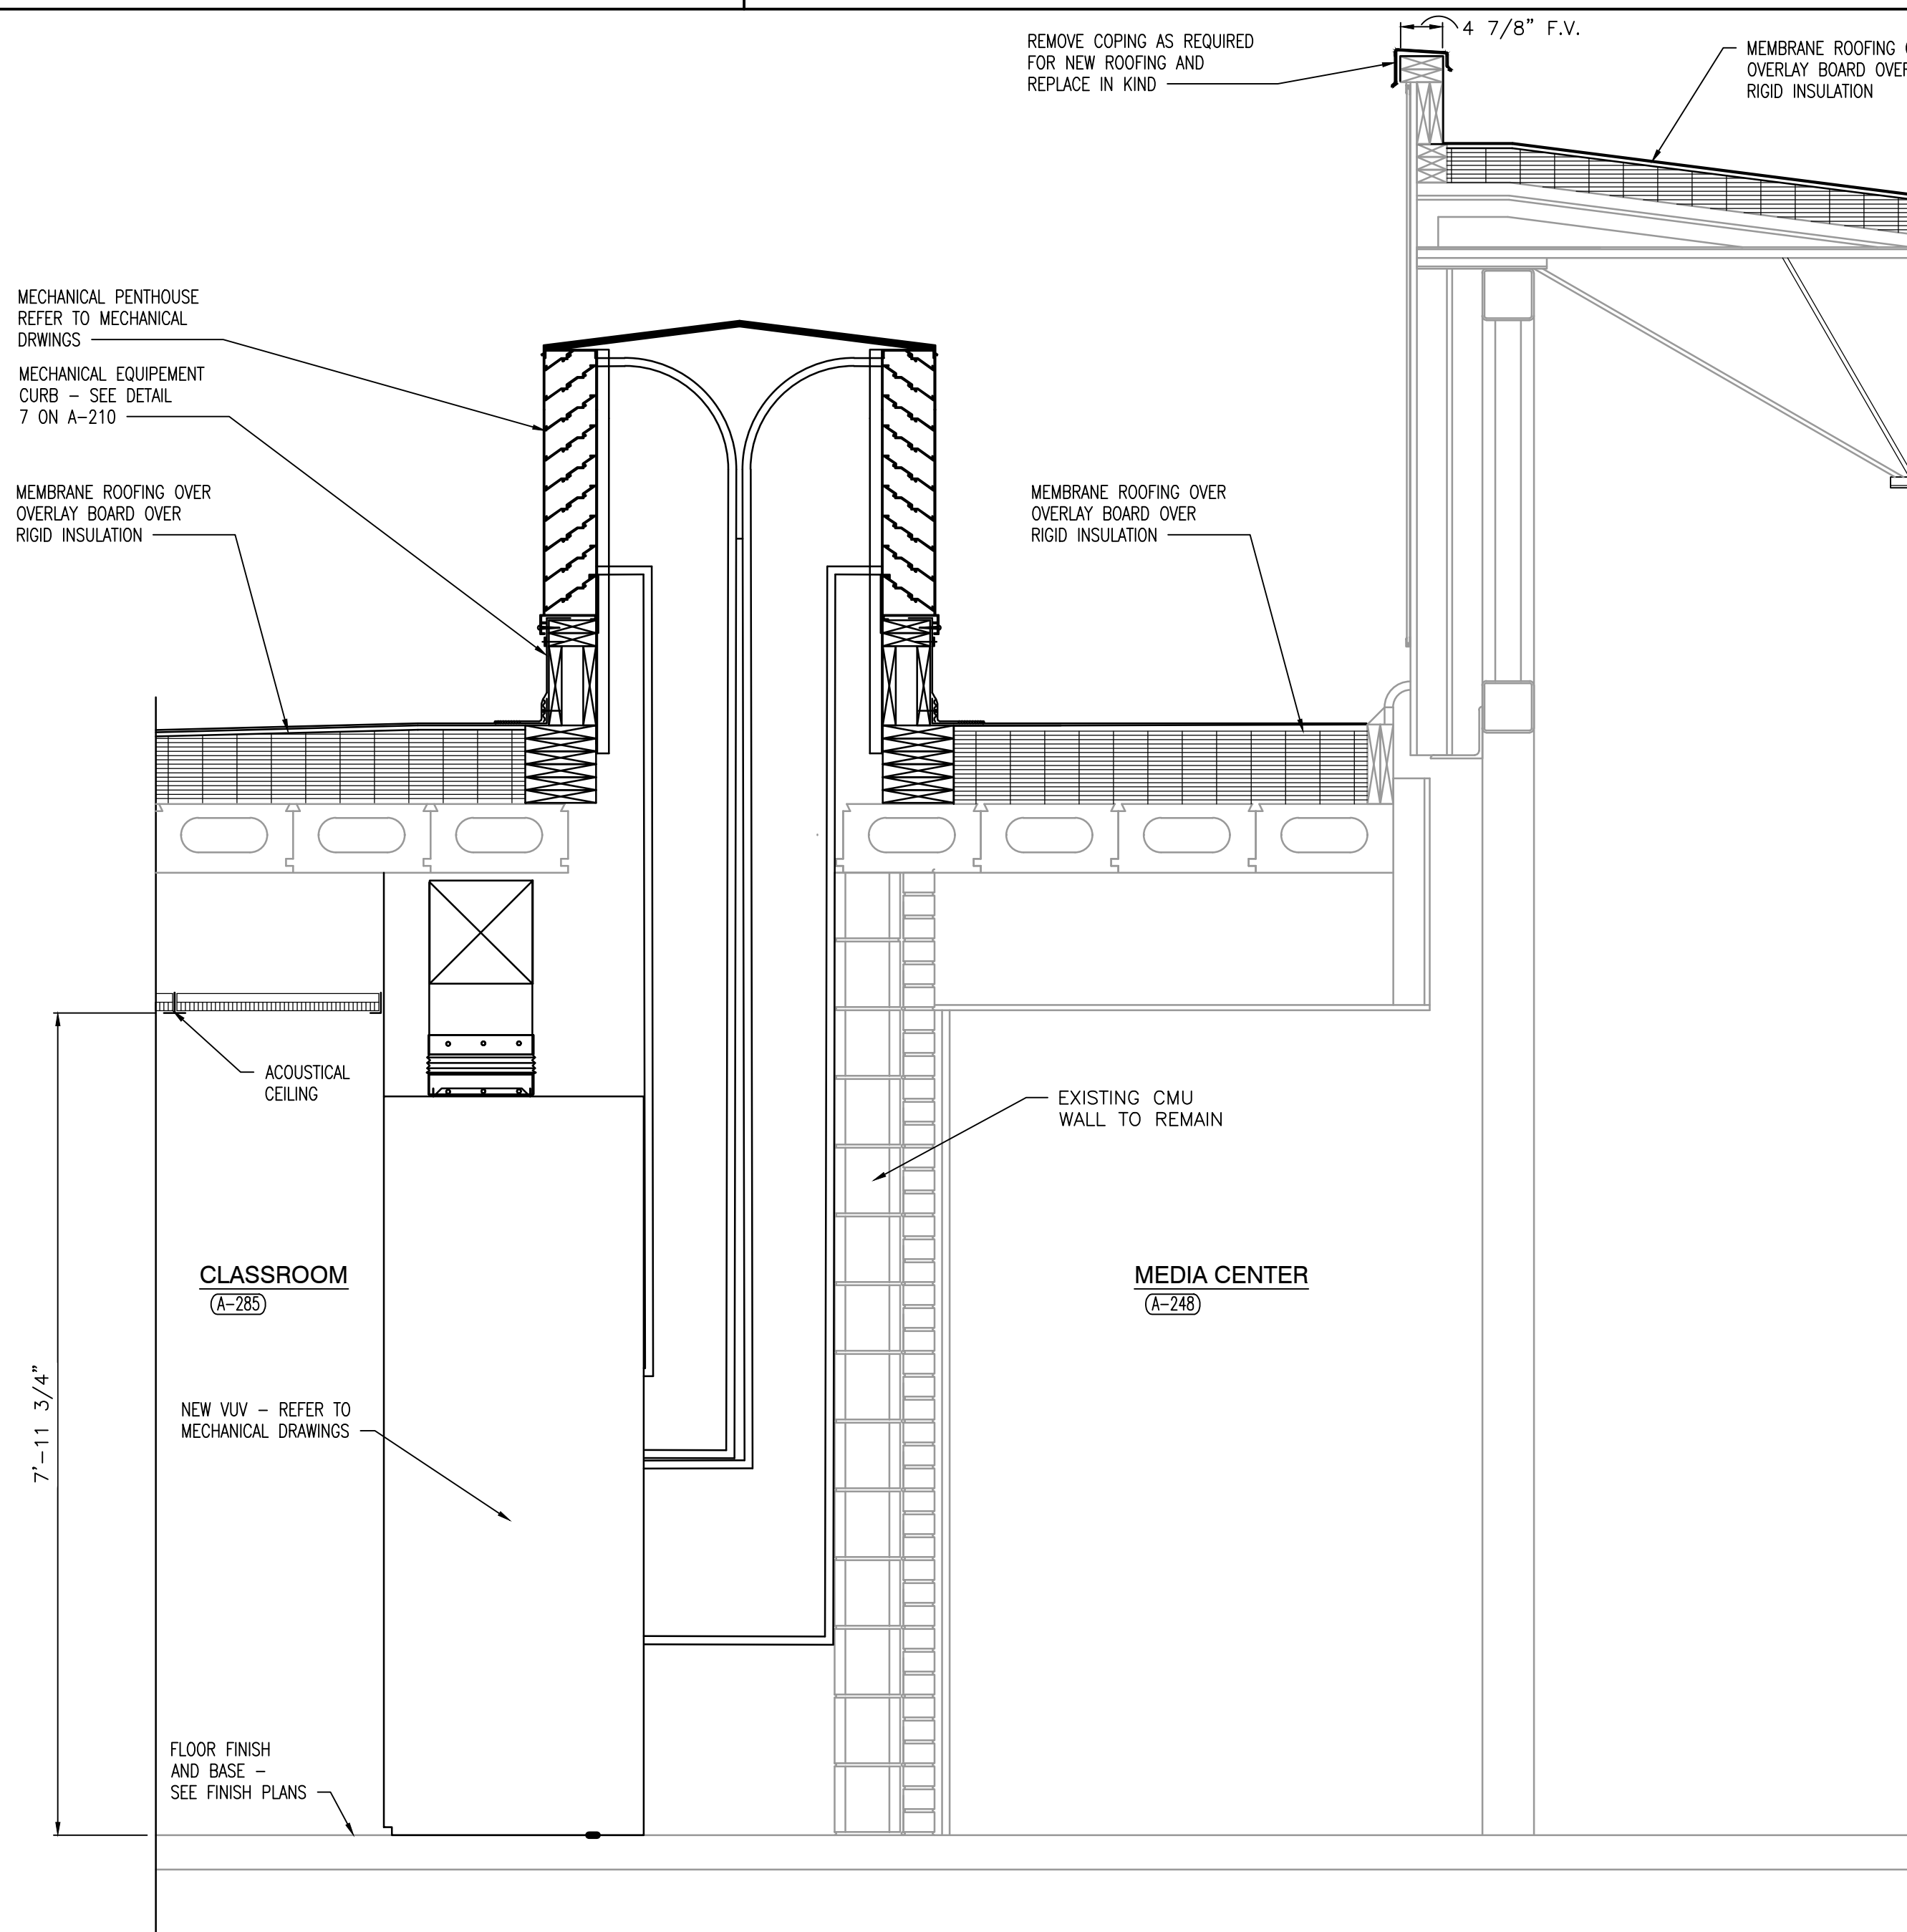


SECTION
SCALE: 3/4" = 1'-0"

3
A-403

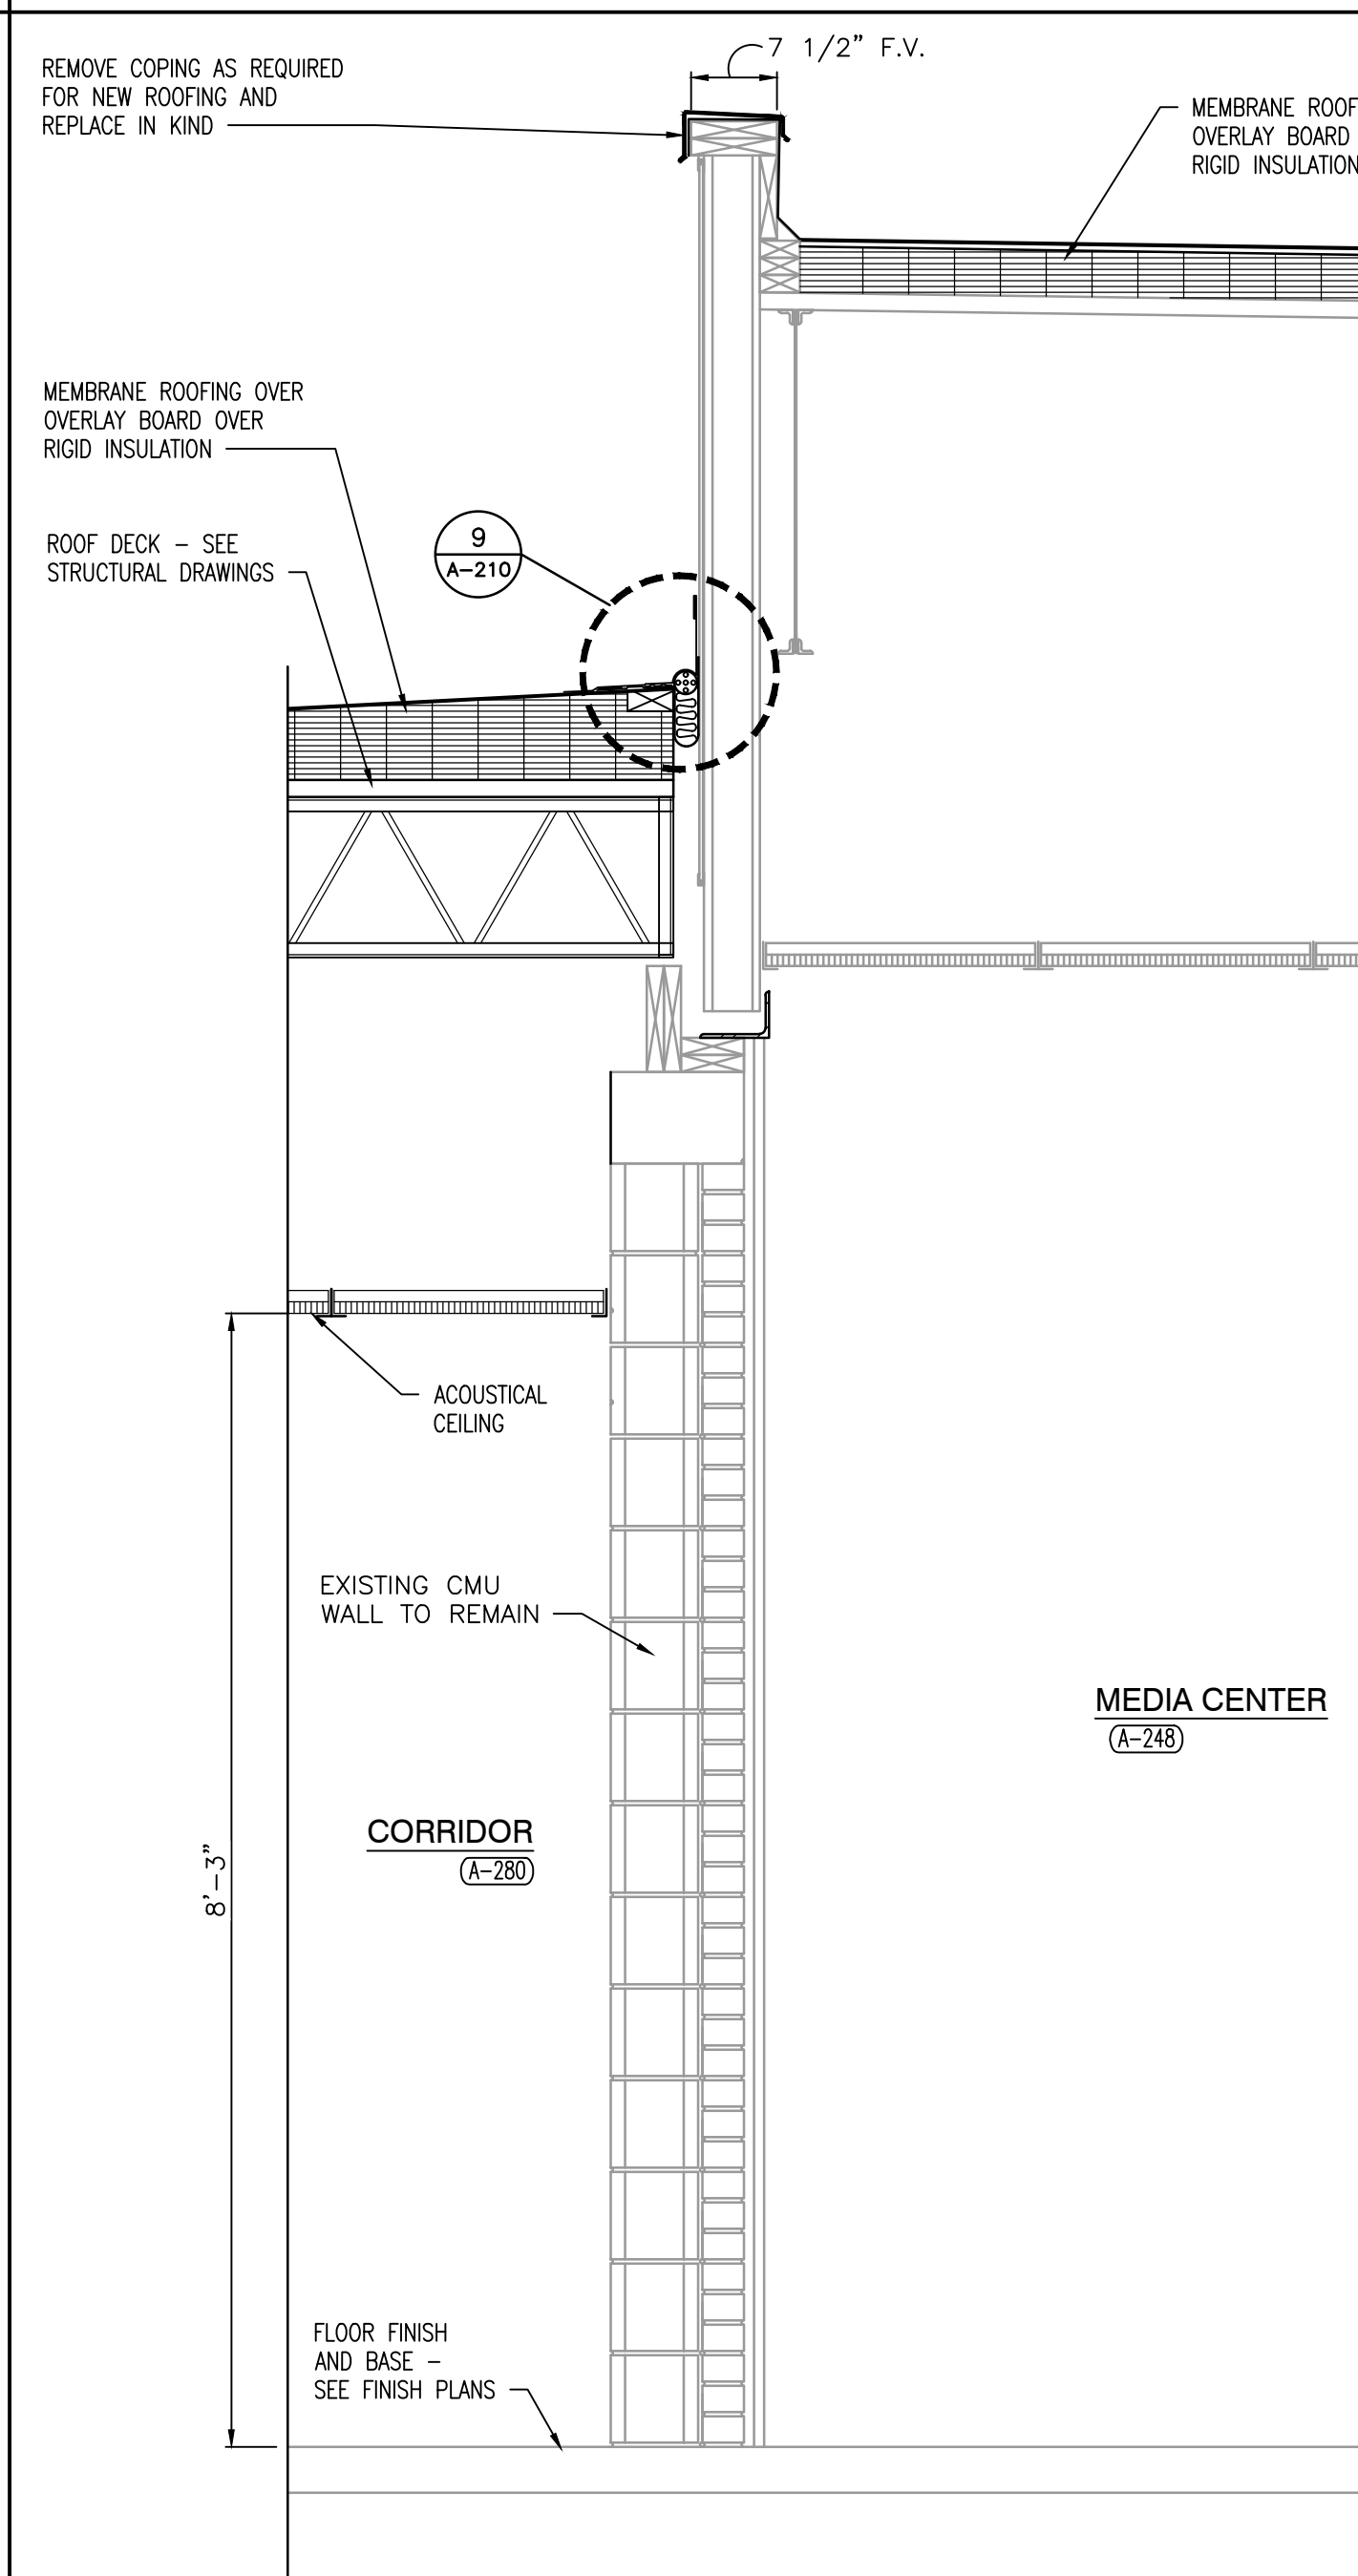


SECTION
SCALE: 3/4" = 1'-0"

2
A-403

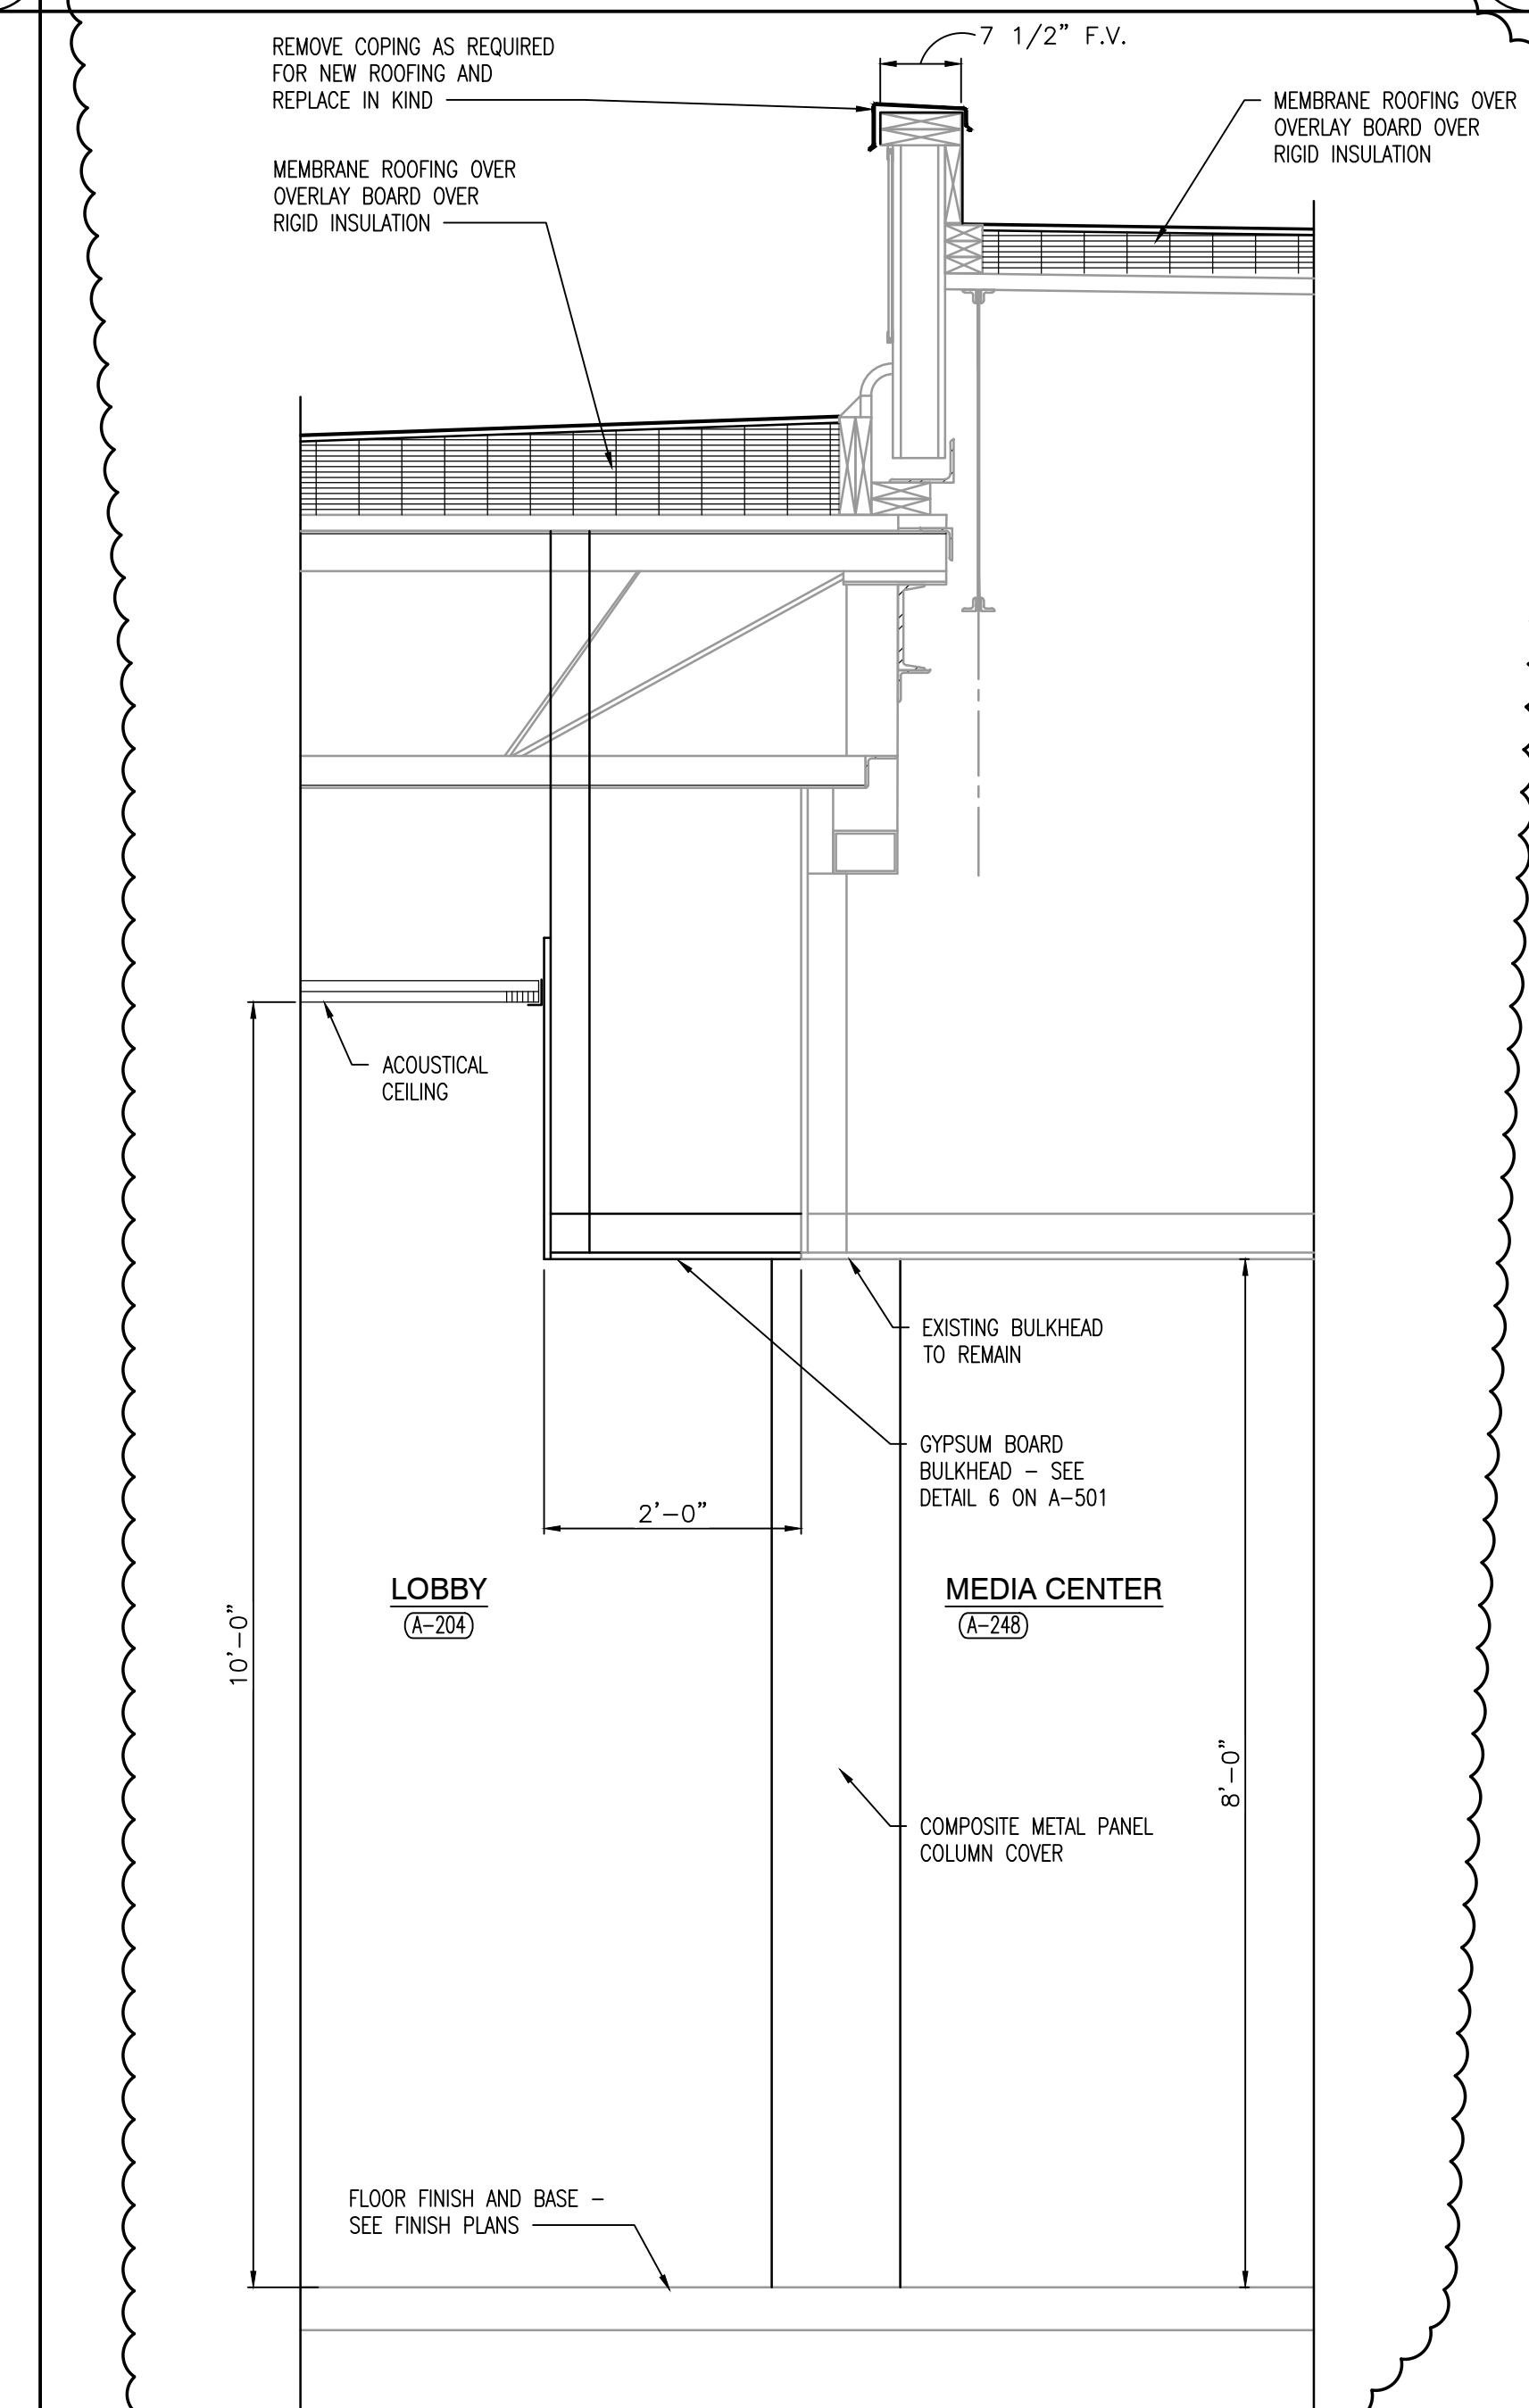

SECTION
SCALE: 3/4" = 1'-0"

1
A-403

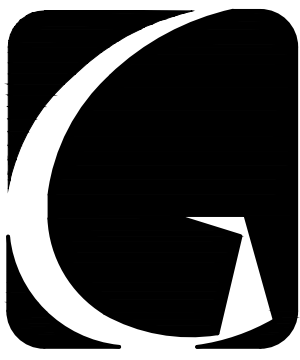

GIBRALTAR
DESIGN

ARCHITECTURE • ENGINEERING • INTERIOR DESIGN

PROJECT

FAIRVIEW ELEMENTARY SCHOOL RENOVATIONS

LOGANSPOUT COMMUNITY
SCHOOL CORPORATION
LOGANSPOUT, INDIANA

PLASTIC LAMINATE CASEWORK SCHEDULE

MARK	CATALOG NUMBER	WIDTH	DESCRIPTION
A	10432	30"	24"D X 32" 2 DOOR 2 DRAWER BASE CABINET
B	10432	33"	24"D X 32" 2 DOOR 2 DRAWER BASE CABINET
C	10432	36"	24"D X 32" 2 DOOR 2 DRAWER BASE CABINET
D	10432	39"	24"D X 32" 2 DOOR 2 DRAWER BASE CABINET
E	10432	42"	24"D X 32" 2 DOOR 2 DRAWER BASE CABINET
F	10432	15"	24"D X 32" 2 DRAWER 1 FILE DRAWER FILING CABINET
G	10479	42"	24"D X 32" 2 DOOR SINK BASE CABINET
H	10479	36"	24"D X 32" 2 DOOR SINK BASE CABINET
J	16129	36"	15"D X 18"H 2 DOOR WALL CABINET
K	16129	36"	15"D X 30"H 2 DOOR WALL CABINET
L	16129	39"	15"D X 30"H 2 DOOR WALL CABINET
M	16120	21"	15"D X 30"H RIGHT HINGE DOOR WALL CABINET
N	16129	42"	15"D X 18"H 2 DOOR WALL CABINET
P	CUSTOM	48"	18"D X 59"H 2 DOOR 6 WIDE LOCKER
Q	18291	21"	14"D X 30"H LEFT HINGE DOOR LOCKABLE NARCOTICS WALL CABINET
R	16129	36"	15"D X 12"H 2 DOOR WALL CABINET
S	CUSTOM	24"	18"D X 59"H 1 DOOR 3 WIDE LOCKER
T	16129	48"	18"D X 25"H 2 DOOR WALL CABINET
U	16121	24"	18"D X 25"H 1 DOOR WALL CABINET

GENERAL NOTES - CASEWORK

- REFERENCE FINISH LEGEND (A-810) FOR FINISH INFORMATION. REFERENCE WRITTEN SPECIFICATIONS AND PLANS FOR ADDITIONAL INFORMATION.
- A. FOR SCHEDULING PURPOSES ONLY, MODEL NUMBERS ARE TAKEN FROM STEVENS INDUSTRIES, INC. (UNLESS NOTED OTHERWISE) AND ARE FOR CABINET REQUIREMENTS ONLY. SEE SPECIFICATIONS FOR CABINET CONSTRUCTION METHODS.
- B. FILLER PANELS, TRIM, AND MOLDING PROVIDED SHALL BE CONTINUOUS AS NECESSARY TO MAKE CASEWORK CONTINUOUS TO ADJACENT PARTITION, CEILING, AND/OR BULKHEAD.
- C. WHERE CASEWORK REQUIRES SHIMMING, ONLY APPROVED METAL SHIMS SHALL BE USED.
- D. CABINETS LOCATED IN FRONT OF A PIPE CHASE SHALL HAVE REMOVABLE BACKS.
- E. ALL BACK SPLASHES AND END SPLASHES SHALL BE 4" HIGH UNLESS OTHERWISE NOTED.
- F. VERIFY ALL CASEWORK DIMENSIONS WITH CASEWORK MANUFACTURER.
- G. 4" HIGH VINYL COVE BASE AT ALL TOE SPACE AREAS AND AT EXPOSED SURFACES AND SIDES OF CABINETS ADJACENT TO TOE SPACES. BY FLOORING CONTRACTOR.
- H. FIELD VERIFY ALL DIMENSIONS.
- J. REFER TO ELECTRICAL DRAWINGS AND SCHEDULES FOR DEVICE TYPES, HEIGHTS AND LOCATIONS.
- K. REFER TO PLUMBING DRAWINGS AND SCHEDULES FOR FIXTURE TYPES AND LOCATIONS.
- L. ALL EXPOSED SURFACES TO BE PLASTIC LAMINATE FINISHED, INCLUDING OPEN INTERIORS OF CABINETS.
- M. ALL ADJOINING CABINETS SHALL BE ALIGNED.
- N. ALL EXPOSED ENDS ARE TO BE FINISHED.
- O. ALL CABINETS TO BE LOCKABLE. KEY ALIKE BY ROOM. EXCEPTION LOCKER CABINET WITHOUT LOCK.
- P. ALL PLASTIC LAMINATE COUNTERTOPS TO HAVE 3MM PVC EDGE.
- Q. ALL WALL AND FULL HEIGHT CABINETS TO RECEIVE PLASTIC LAMINATE SLOPE TOP. UNLESS OTHERWISE NOTED/SCHEDULED.

KEY NOTES - CASEWORK

- LINE OF FINISHED FLOOR
- WALL LINE
- CEILING LINE
- 4" TOE SPACE WITH VINYL BASE
- DOOR
- SLOPED TOP
- 25"D PLASTIC LAMINATE COUNTERTOP WITH 4"H BACKSPLASH AND END SPLASH AT SIDE WALL CONDITIONS
- REFRIGERATOR BY OWNER
- KNEE SPACE
- FINISHED BACK/END PANEL
- PAPER TOWEL DISPENSER (OFCI)
- SOAP DISPENSER (OFCI)
- FILLER PANEL - FINISH TO MATCH FACE OF CABINETS.
- SINK, SEE PLUMBING DRAWINGS

GENERAL NOTES - MILLWORK

- A. REFER TO FINISH LEGEND (A-810) FOR FINISH INFORMATION. REFERENCE WRITTEN SPECIFICATIONS AND PLANS FOR ADDITIONAL INFORMATION.
- B. FILLER PANELS, TRIM, AND MOLDING PROVIDED SHALL BE CONTINUOUS AS NECESSARY TO MAKE CASEWORK CONTINUOUS TO ADJACENT PARTITION, CEILING, AND/OR BULKHEAD.
- C. WHERE CASEWORK REQUIRES SHIMMING, ONLY APPROVED METAL SHIMS SHALL BE USED.
- D. 4" HIGH VINYL COVE BASE AT ALL TOE SPACE AREAS AND AT EXPOSED SURFACES AND SIDES OF CABINETS ADJACENT TO TOE SPACES. BY FLOORING CONTRACTOR.
- E. FIELD VERIFY ALL DIMENSIONS.
- F. REFER TO ELECTRICAL DRAWINGS AND SCHEDULES FOR DEVICE TYPES, HEIGHTS AND LOCATIONS.
- G. ALL EXPOSED SURFACES TO BE PLASTIC LAMINATE FINISHED, INCLUDING OPEN INTERIORS OF CABINETS.
- H. ALL ADJOINING CABINETS SHALL BE ALIGNED.
- I. ALL EXPOSED ENDS ARE TO BE FINISHED.
- J. ALL CABINETS TO BE LOCKABLE. KEY ALIKE BY DESK.
- K. ALL PLASTIC LAMINATE COUNTERTOPS TO HAVE 3MM PVC EDGE.
- L. TRIM BACKSPLASH AND COUNTERTOP FOR WINDOW ALLOWANCE.

GIBRALTAR DESIGN

9102 N. Meridian St., Ste. 300
Indianapolis, IN 46260
Homepage: www.GibraltarDesign.com
Email: info@GibraltarDesign.com
Phone: 317.580.5777 Fax: 317.580.5778

PROJECT

20-157

DATE

06/18/21

COORDINATED BY

DJW

DRAWN BY

EEO, MLM

CHECKED BY

DJW, NAS

COPYRIGHT NOTICE:
THE CONCEPTS, DESIGNS, PLANS, DETAILS, ETC. SHOWN ON THIS DOCUMENT ARE THE PROPERTY OF GIBRALTAR DESIGN AND WERE CREATED FOR USE ON THIS SPECIFIC PROJECT. NONE OF THIS INFORMATION SHALL BE USED BY ANY PERSON OR FIRM FOR ANY PURPOSE WITHOUT THE EXPRESS WRITTEN CONSENT OF GIBRALTAR DESIGN. THE OWNER MAY RETAIN COPIES FOR INFORMATION AND REFERENCE IN CONNECTION ONLY WITH THIS PROJECT.

REVISIONS

MARK

DATE

ISSUED FOR

AD.01 7/9/21 AD.01


DRAWING
CASEWORK ELEVATIONS AND
SCHEDULE; MILLWORK
ENLARGED PLANS AND
DETAILS

PROJECT
FAIRVIEW ELEMENTARY SCHOOL
RENOVATIONS


© GIBRALTAR DESIGN

SHEET


A-710

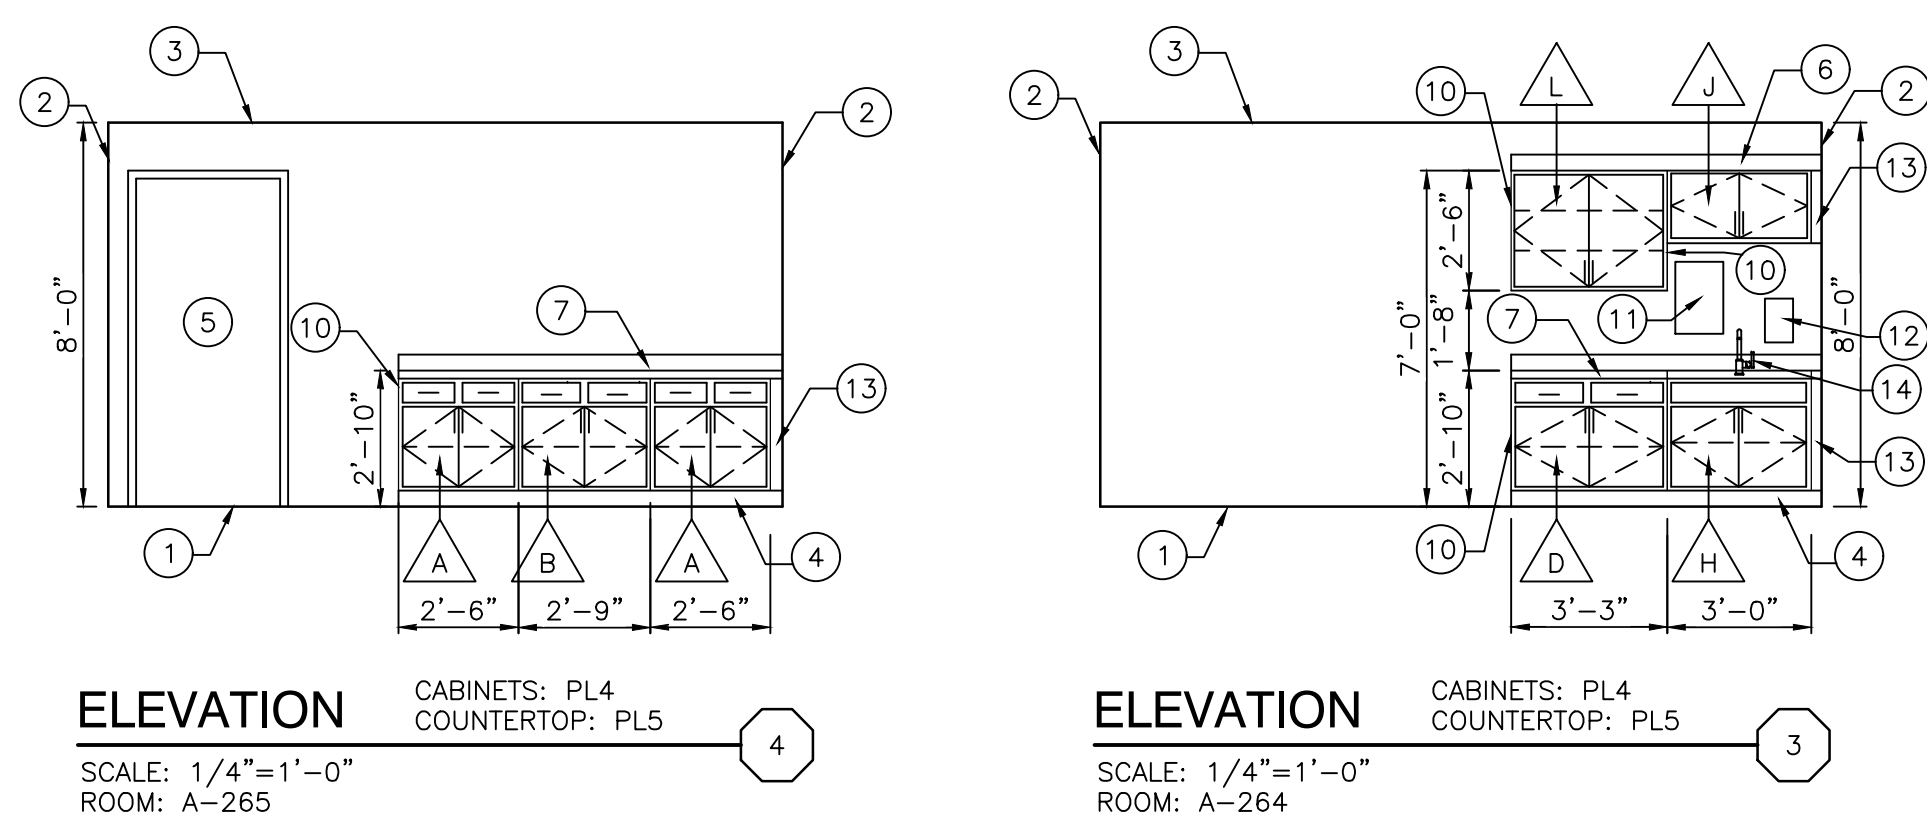


ELEVATION
SCALE: 1/4"=1'-0"
ROOM: A-264
CABINETS: PL4
COUNTERTOP: PL5

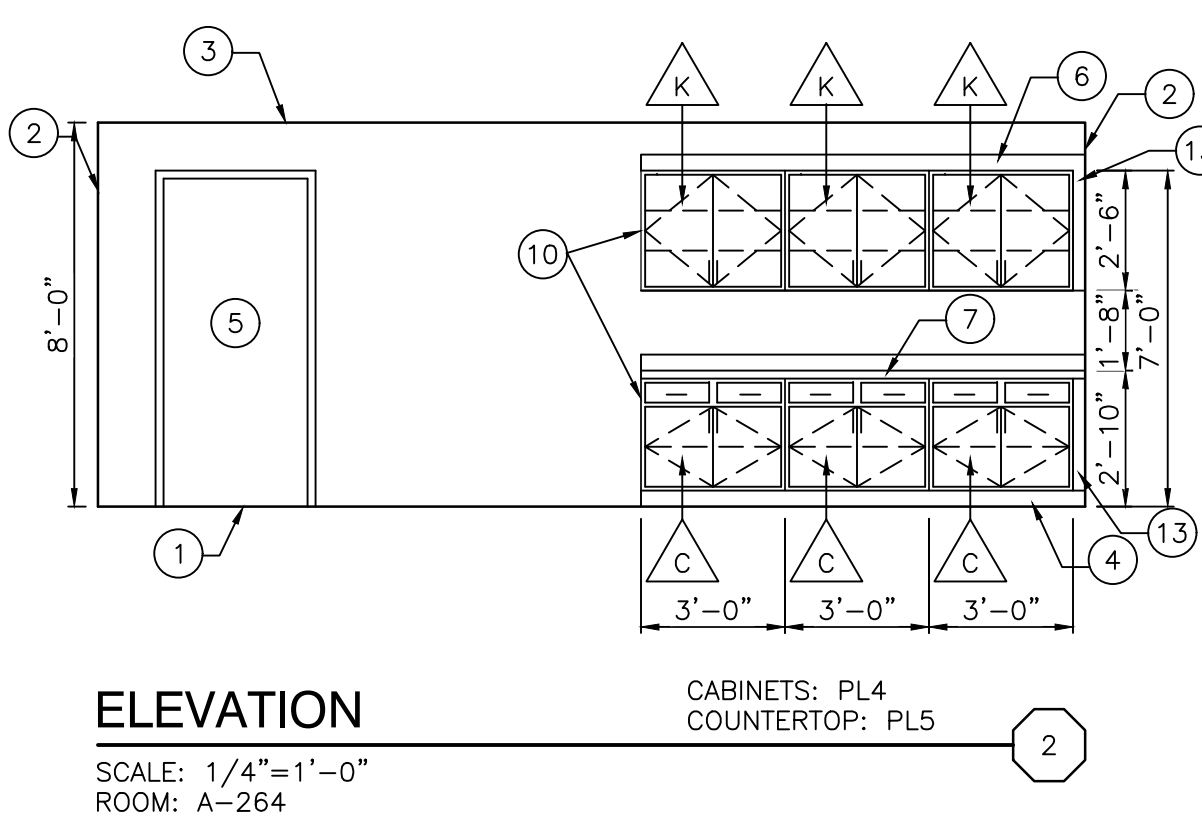


ELEVATION
SCALE: 1/4"=1'-0"
ROOM: A-253
CABINETS: PL4
COUNTERTOP: PL5

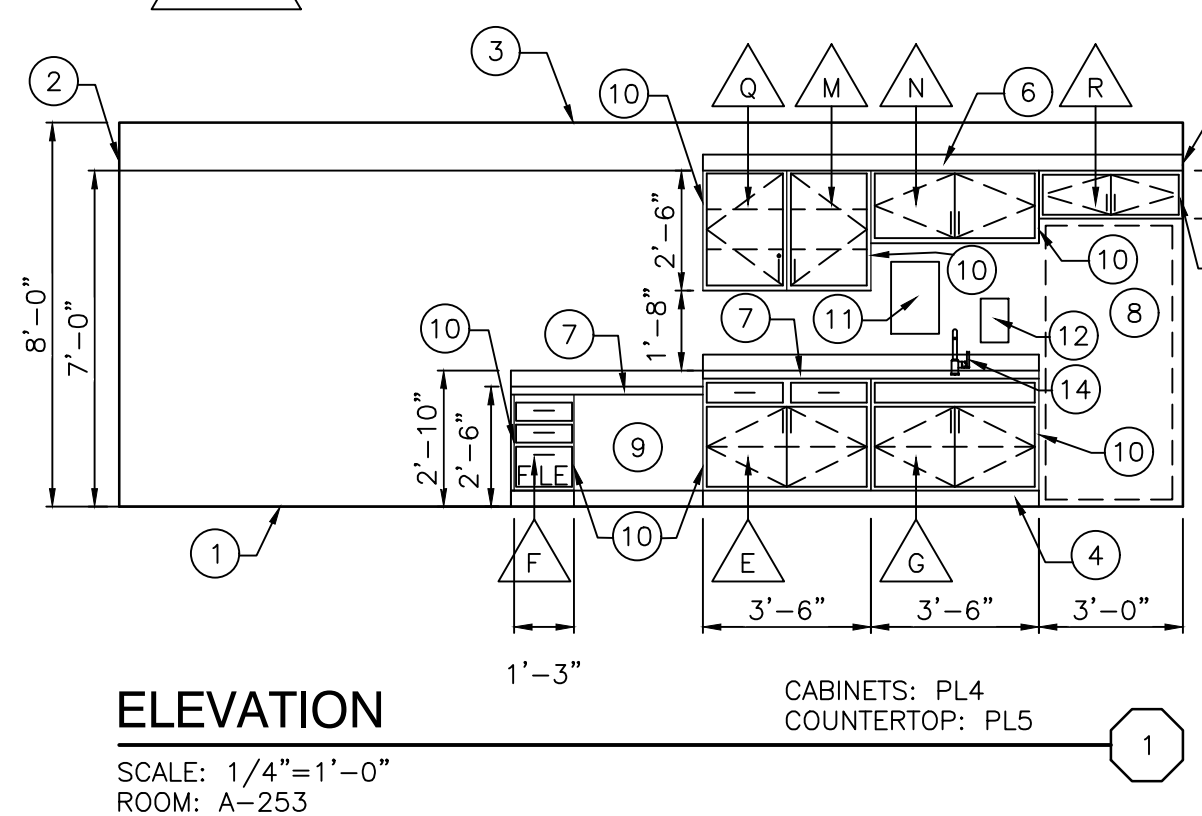


ELEVATION
SCALE: 1/4"=1'-0"
ROOM: A-252
CABINETS: PL4
COUNTERTOP: PL5

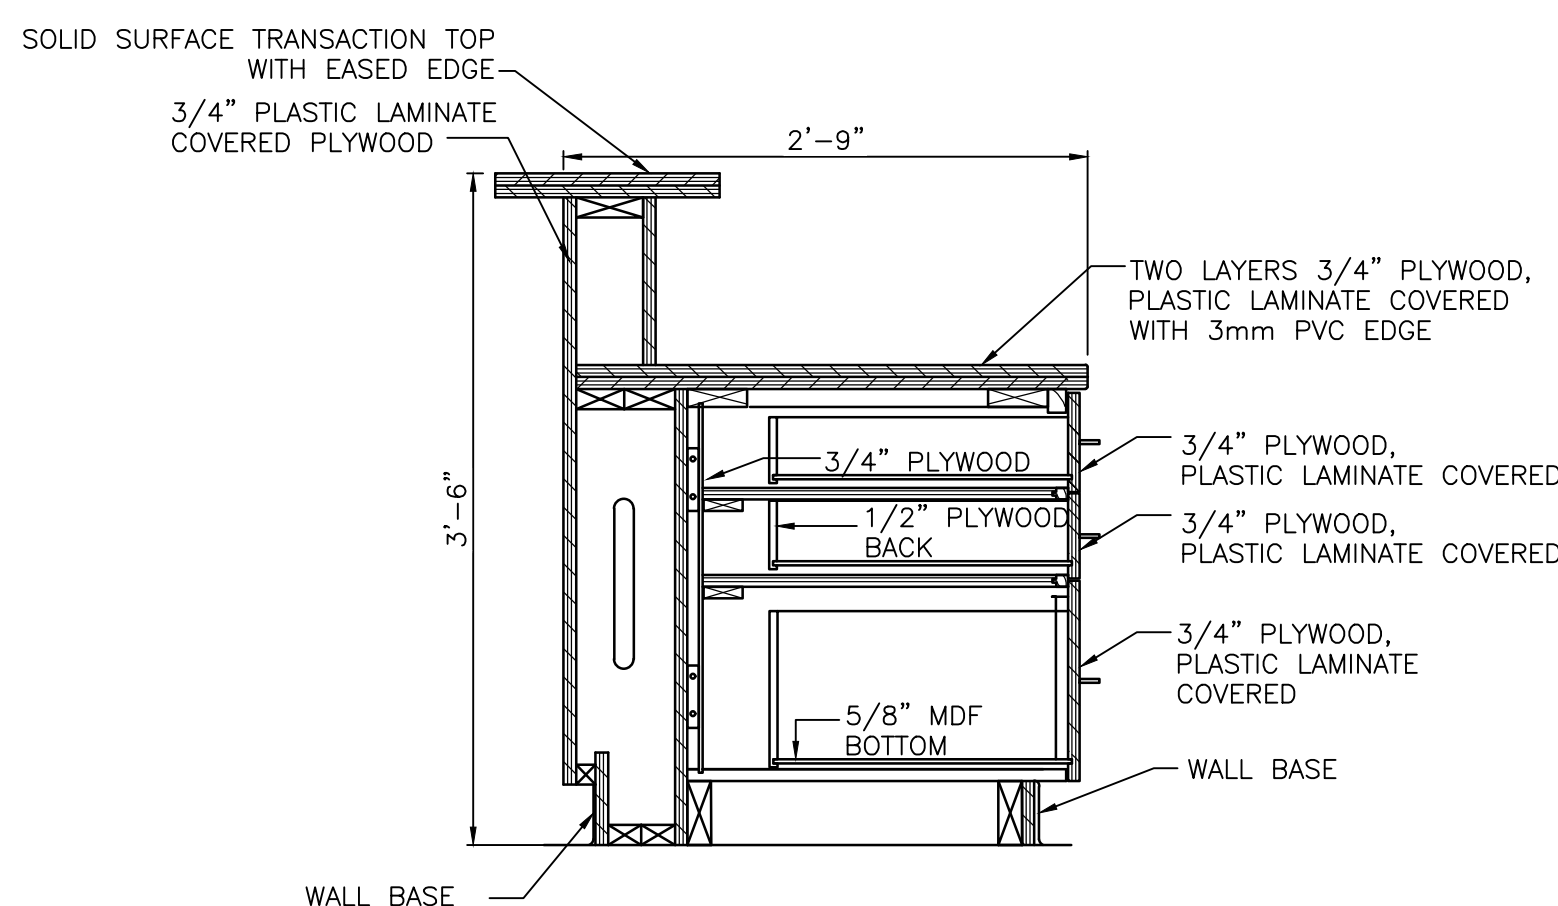


SECTION
SCALE: 1"=1'-0"
ROOM: A-710

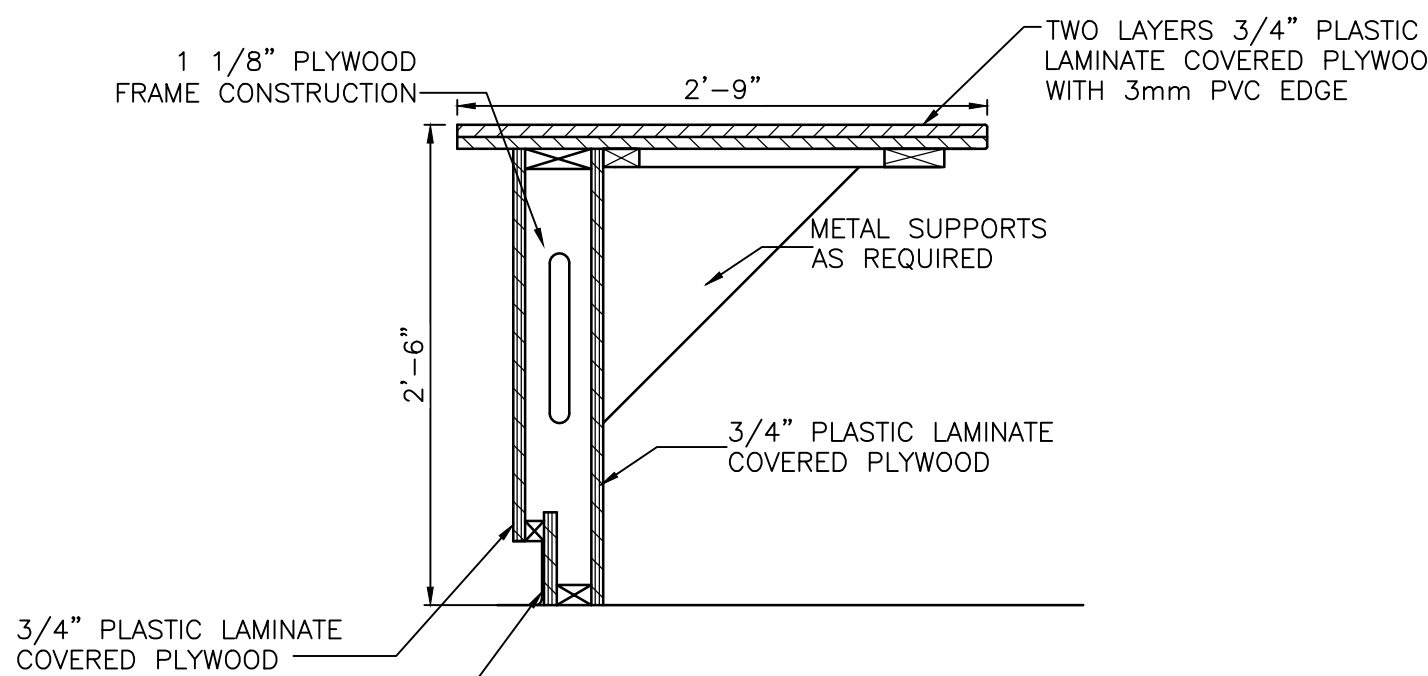


SECTION
SCALE: 1"=1'-0"
ROOM: A-710

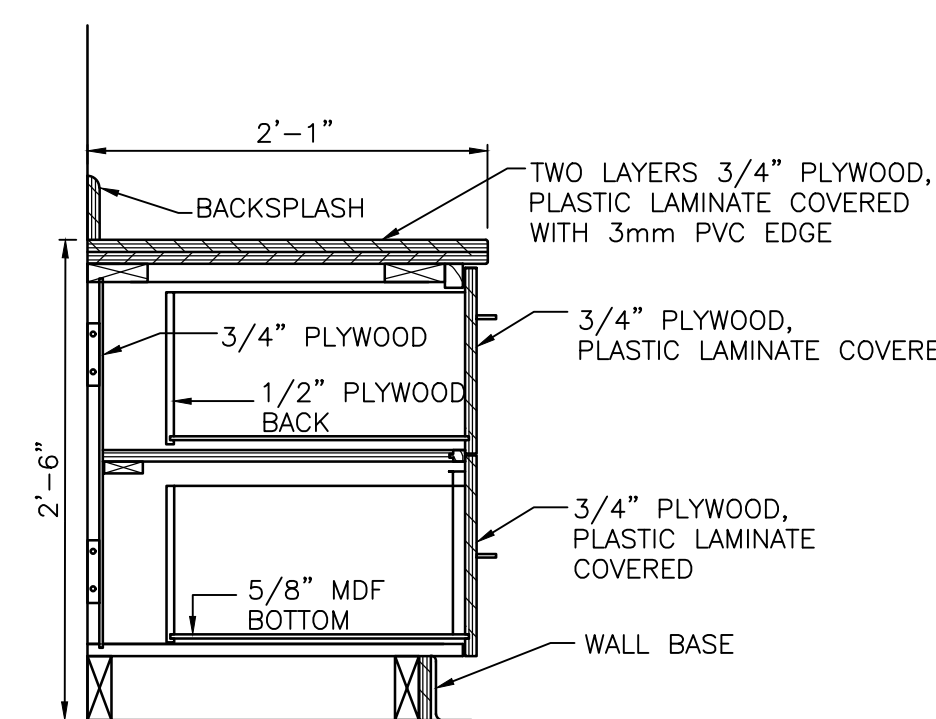


SECTION
SCALE: 1"=1'-0"
ROOM: A-710

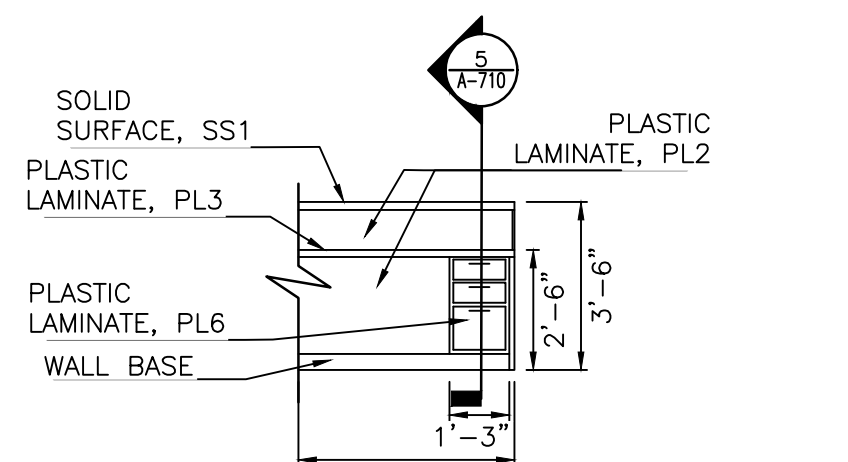


ELEVATION
SCALE: 1/4"=1'-0"
ROOM: A-252

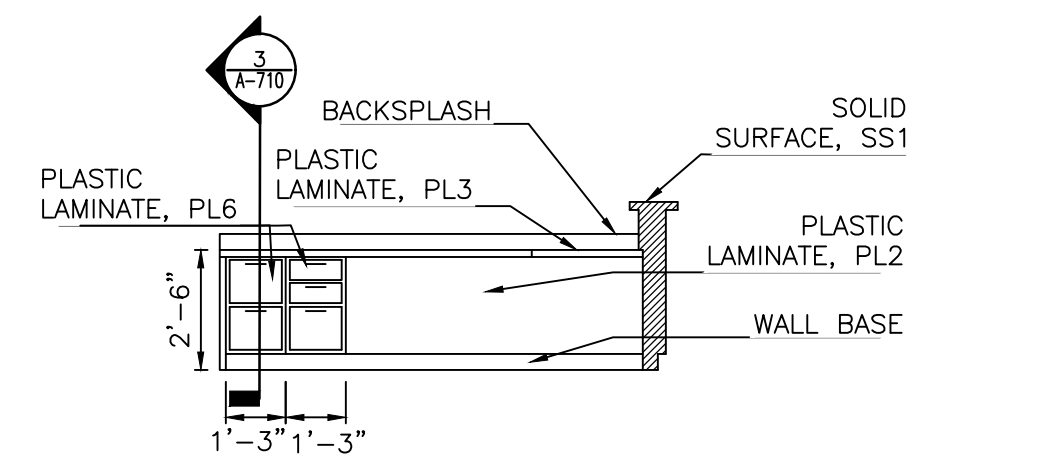


ELEVATION
SCALE: 1/4"=1'-0"
ROOM: A-252

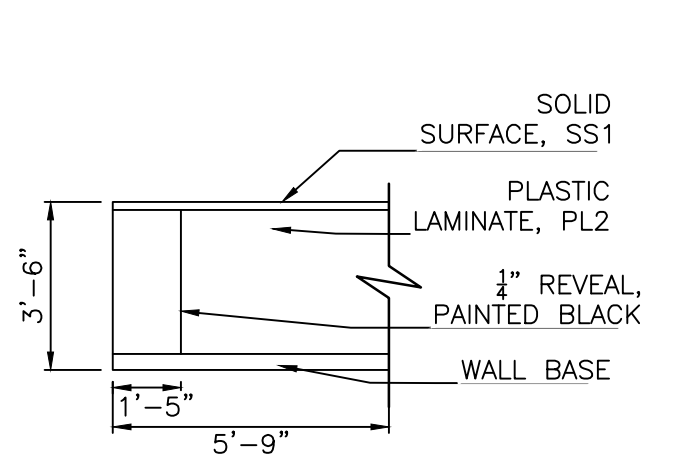


ELEVATION
SCALE: 1/4"=1'-0"
ROOM: A-252

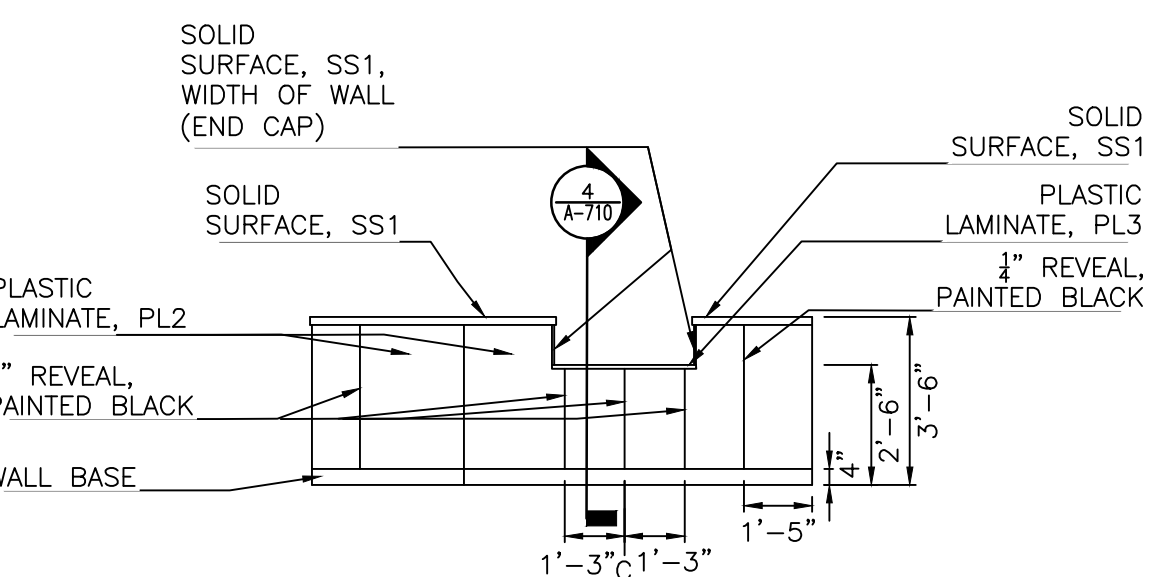


ELEVATION
SCALE: 1/4"=1'-0"
ROOM: A-252

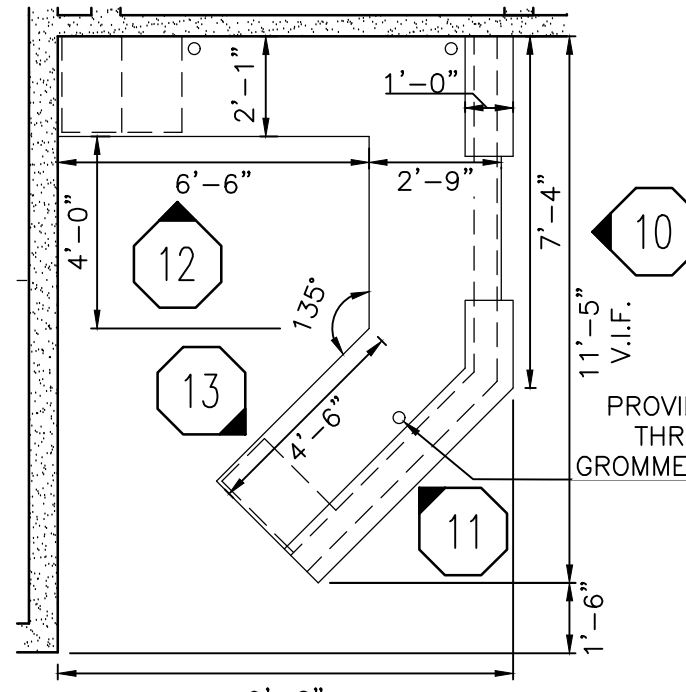


ENLARGED PLAN
SCALE: 1/4"=1'-0"
ROOM: A-252

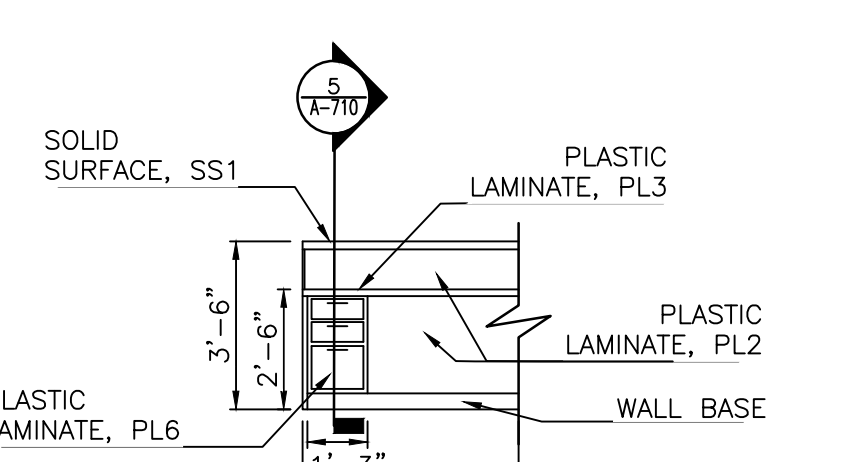


ELEVATION
SCALE: 1/4"=1'-0"
ROOM: A-252

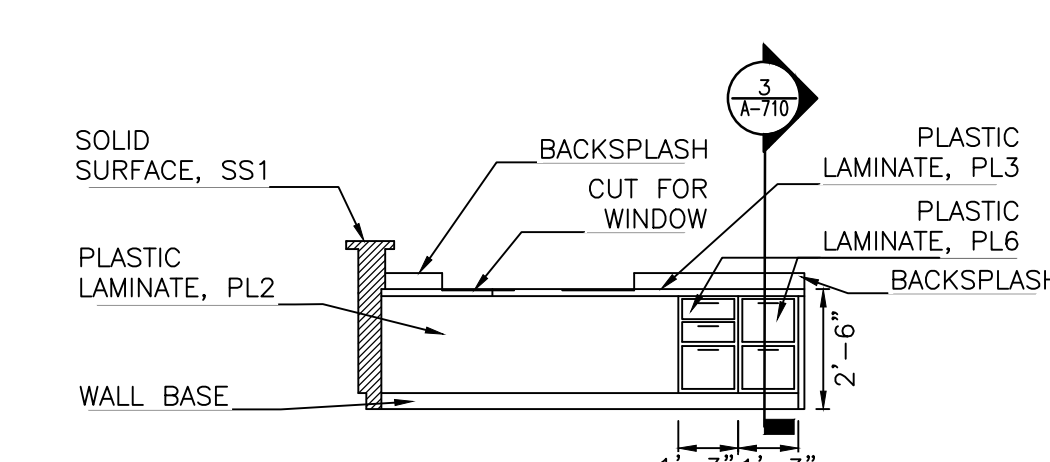


ELEVATION
SCALE: 1/4"=1'-0"
ROOM: A-252

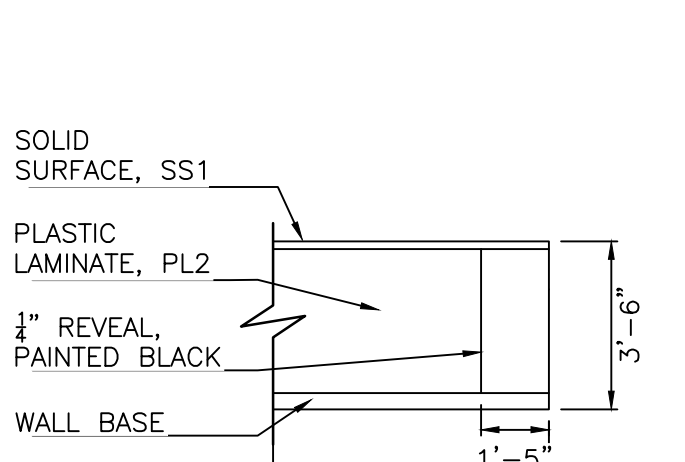

ELEVATION
SCALE: 1/4"=1'-0"
ROOM: A-252

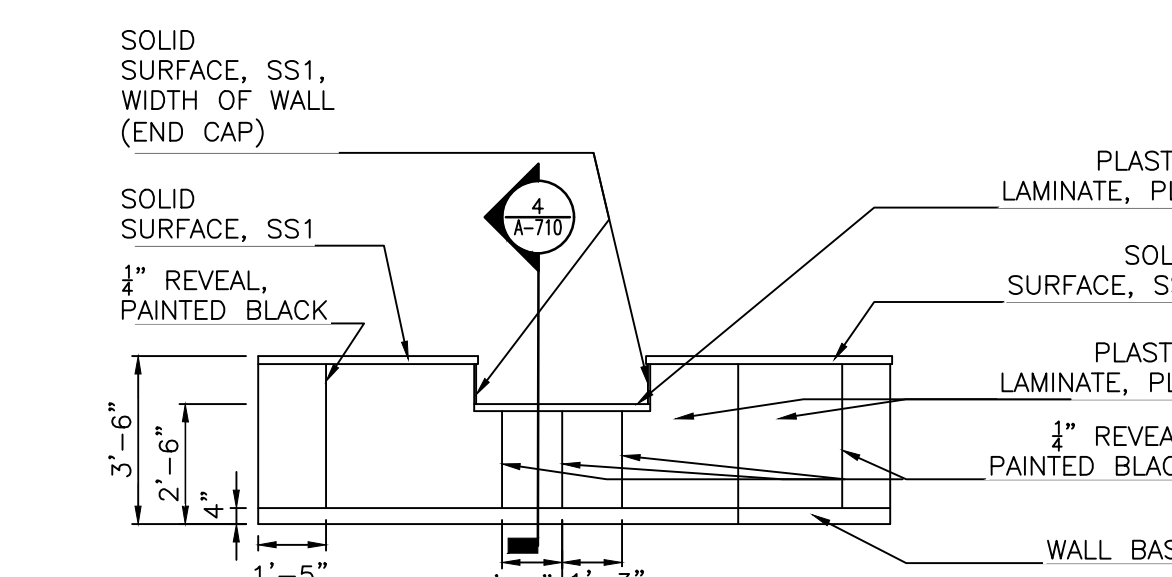

ELEVATION
SCALE: 1/4"=1'-0"
ROOM: A-252

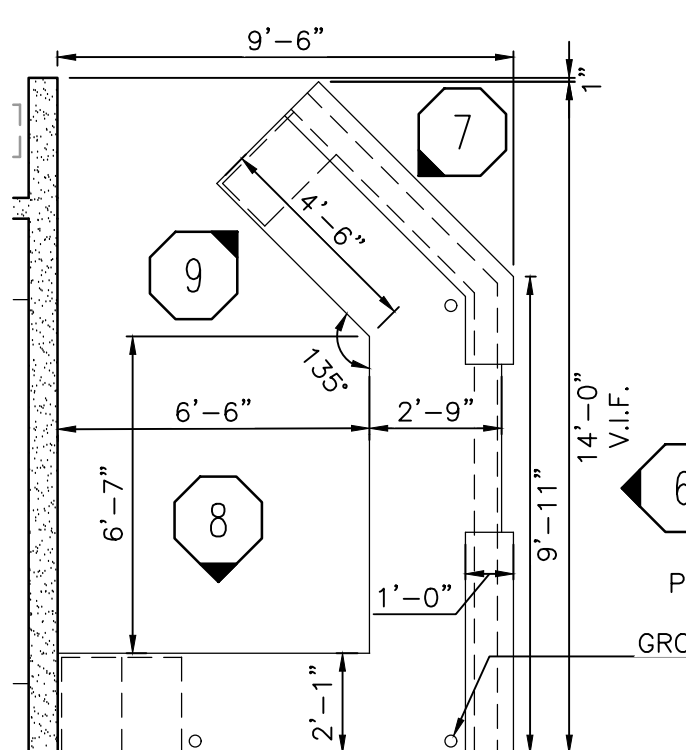

ENLARGED PLAN
SCALE: 1/4"=1'-0"
ROOM: A-252

PROJECT

**FAIRVIEW
ELEMENTARY
SCHOOL
RENOVATIONS**

LOGANSPOUT COMMUNITY
SCHOOL CORPORATION
LOGANSPOUT, INDIANA


- A. FOR GENERAL PROJECT NOTES, MATERIAL INDICATIONS LEGEND, SYMBOL LEGEND, ABBREVIATIONS, ETC., REFER TO GI SERIES SHEETS.
- B. THE ARCHITECTURAL REFLECTED CEILING PLAN GOVERN THE LAYOUT OF ALL CEILING ELEMENTS AND PENETRATIONS.
- C. BULKHEAD FRAMING SHALL BE ATTACHED TO STRUCTURAL SUPPORTS AND NOT THE ROOF DECK.
- D. REFER TO FLOOR PLANS FOR WALL TYPES
- E. REFER TO ELECTRICAL DRAWINGS FOR ADDITIONAL CEILING MOUNTED ELECTRICAL ITEMS.
- F. REFER TO TECHNOLOGY DRAWINGS FOR ADDITIONAL CEILING MOUNTED TECHNOLOGY ITEMS.
- G. REFER TO MECHANICAL DRAWINGS FOR LOCATION OF CEILING DIFFUSERS, REFRIGERANT PIPING, AND CEILING CABINET.

LEGEND


	GYPSUM BOARD BULKHEAD/CEILING		LED LIGHT
	EFS SOFFIT		EXIT LIGHT
	2'-0" x 2'-0" ACST. BD. CEILING ACT 1		1x4 LIGHT FIXTURE
	2'-0" x 2'-0" VINYL FACED CEILING ACT 2		2x4 LIGHT FIXTURE
	4'-0" x 4'-0" ACST. BD. CEILING ACT 3		PENDANT LIGHT FIXTURE
			PENDANT LIGHT FIXTURE
			LINEAR LIGHT FIXTURE
			WALL SCONCE LIGHT FIXTURE
			SUPPLY AIR DIFFUSER
			LINEAR SUPPLY AIR DIFFUSER
			RETURN, EXHAUST AND TRANSFER AIR GRILLE
			CEILING SPEAKER
			OCCUPANCY SENSOR

(ALL PLAN NOTES MAY NOT BE INDICATED ON THIS SHEET.)

- ① GYPSUM BOARD BULKHEAD. ——— ⑤
A-501
- ② 3" W. SOFFIT VENT. LENGTH AS INDICATED.
- ③ GYPSUM BOARD BULKHEAD. ——— ⑥
A-501
- ③ ALIGN CENTERLINE OF GRID WITH CORNER OF CEILING
ORDER TO CENTER LIGHTING IN THE RAISED CEILING.

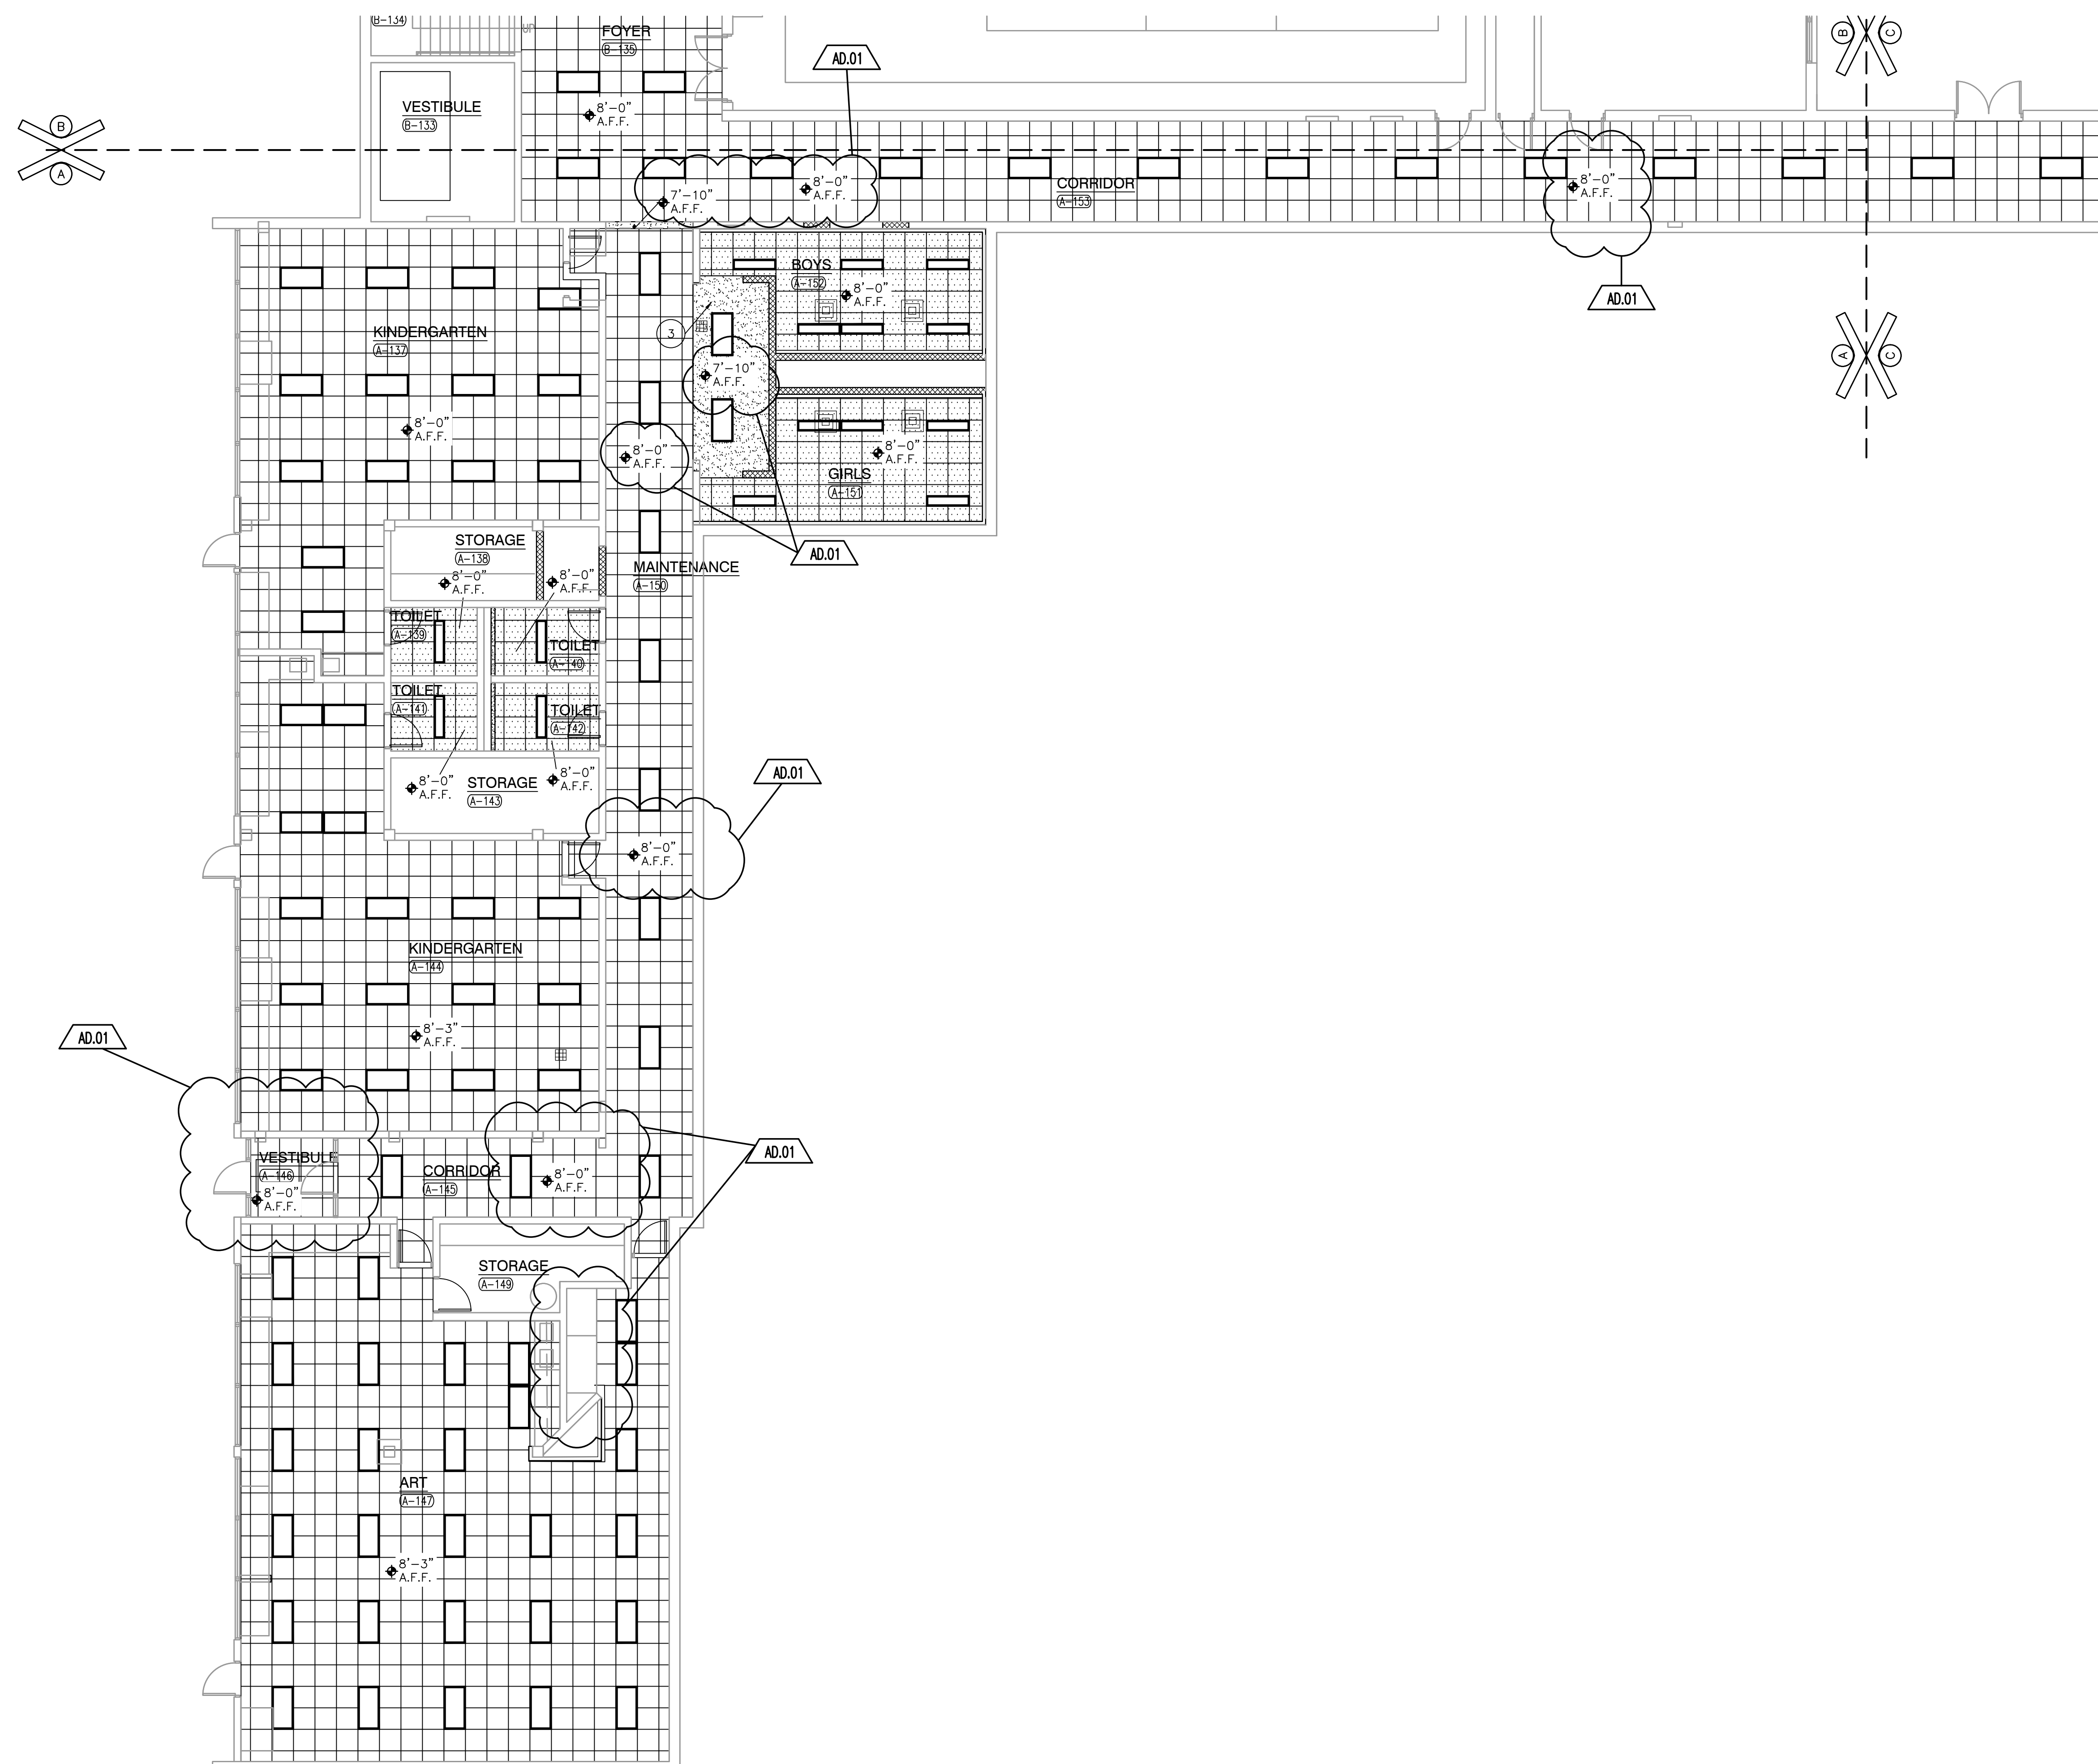

UNIT "A" LOWER LEVEL
REFLECTED CEILING PLAN
SCALE: 1/8" = 1'-0"

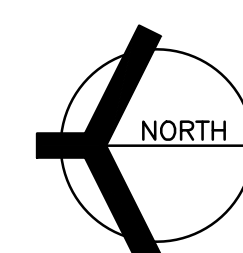

PROJECT 20-157	
DATE 06/18/21	
COORDINATED BY DJW	
DRAWN BY MMM	
CHECKED BY D.J.W	

COPYRIGHT NOTICE:
THE CONCEPTS, DESIGNS, PLANS, DETAILS, ETC., SHOWN ON THIS DOCUMENT ARE THE PROPERTY OF GIBRALTAR DESIGN AND WERE CREATED FOR USE ON THIS SPECIFIC PROJECT. NONE OF THIS INFORMATION SHALL BE USED BY ANY PERSON OR FIRM FOR ANY PURPOSE WITHOUT THE EXPRESS WRITTEN CONSENT OF GIBRALTAR DESIGN. THE OWNER MAY RETAIN COPIES FOR INFORMATION AND REFERENCE IN CONNECTION ONLY WITH THIS PROJECT.

[illegible]

DRAWING
UNIT "A" LOWER LEVEL
REFLECTED CEILING PLAN

PROJECT
FAIRVIEW ELEMENTARY SCHOOL
RENOVATIONS

© GIBRALTAR DESIGN	SHEET
A	A-901

GENERAL REFLECTED CEILING PLAN NOTES:

- A. FOR GENERAL PROJECT NOTES, MATERIAL INDICATIONS, LEGEND, SYMBOL, LEGEND, ABBREVIATIONS, ETC., REFER TO G1 SERIES SHEETS.
- B. THE ARCHITECTURAL REFLECTED CEILING PLAN GOVERN THE LAYOUT OF ALL CEILING ELEMENTS AND PENETRATIONS.
- C. BULKHEAD FRAMING SHALL BE ATTACHED TO STRUCTURAL SUPPORTS AND NOT THE ROOF DECK.
- D. REFER TO FLOOR PLANS FOR WALL TYPES
- E. REFER TO ELECTRICAL DRAWINGS FOR ADDITIONAL CEILING MOUNTED ELECTRICAL ITEMS.
- F. REFER TO TECHNOLOGY DRAWINGS FOR ADDITIONAL CEILING MOUNTED TECHNOLOGY ITEMS.
- G. REFER TO MECHANICAL DRAWINGS FOR LOCATION OF CEILING DIFFUSERS, RETURN AIR GRILLS, AND CEILING CABINET HEATERS.


REFLECTED CEILING PLAN LEGEND:

- GYPSUM BOARD BULKHEAD/CEILING
- LED LIGHT
- EXIT LIGHT
- 1x4 LIGHT FIXTURE
- 2x4 LIGHT FIXTURE
- PENDANT LIGHT FIXTURE
- LINEAR LIGHT FIXTURE
- WALL SCONCE LIGHT FIXTURE
- SUPPLY AIR DIFFUSER
- LINEAR SUPPLY AIR DIFFUSER
- RETURN EXHAUST AND TRANSFER AIR GRILLE
- CEILING SPEAKER
- OCCUPANCY SENSOR
- 2'-0" x 2'-0" ACST. BD. CEILING ACT 1
- 2'-0" x 2'-0" VINYL FACED CEILING ACT 2
- 4'-0" x 4'-0" ACST. BD. CEILING ACT 3

REFLECTED CEILING PLAN NOTES:



(ALL PLAN NOTES MAY NOT BE INDICATED ON THIS SHEET)

- 1 GYPSUM BOARD BULKHEAD. 5
- 2 3" W. SOFFIT VENT. LENGTH AS INDICATED. 6
- 3 GYPSUM BOARD BULKHEAD. 7
- 3 ALIGN CENTERLINE OF GRID WITH CORNER OF CEILING IN ORDER TO CENTER LIGHTING IN THE RAISED CEILING.

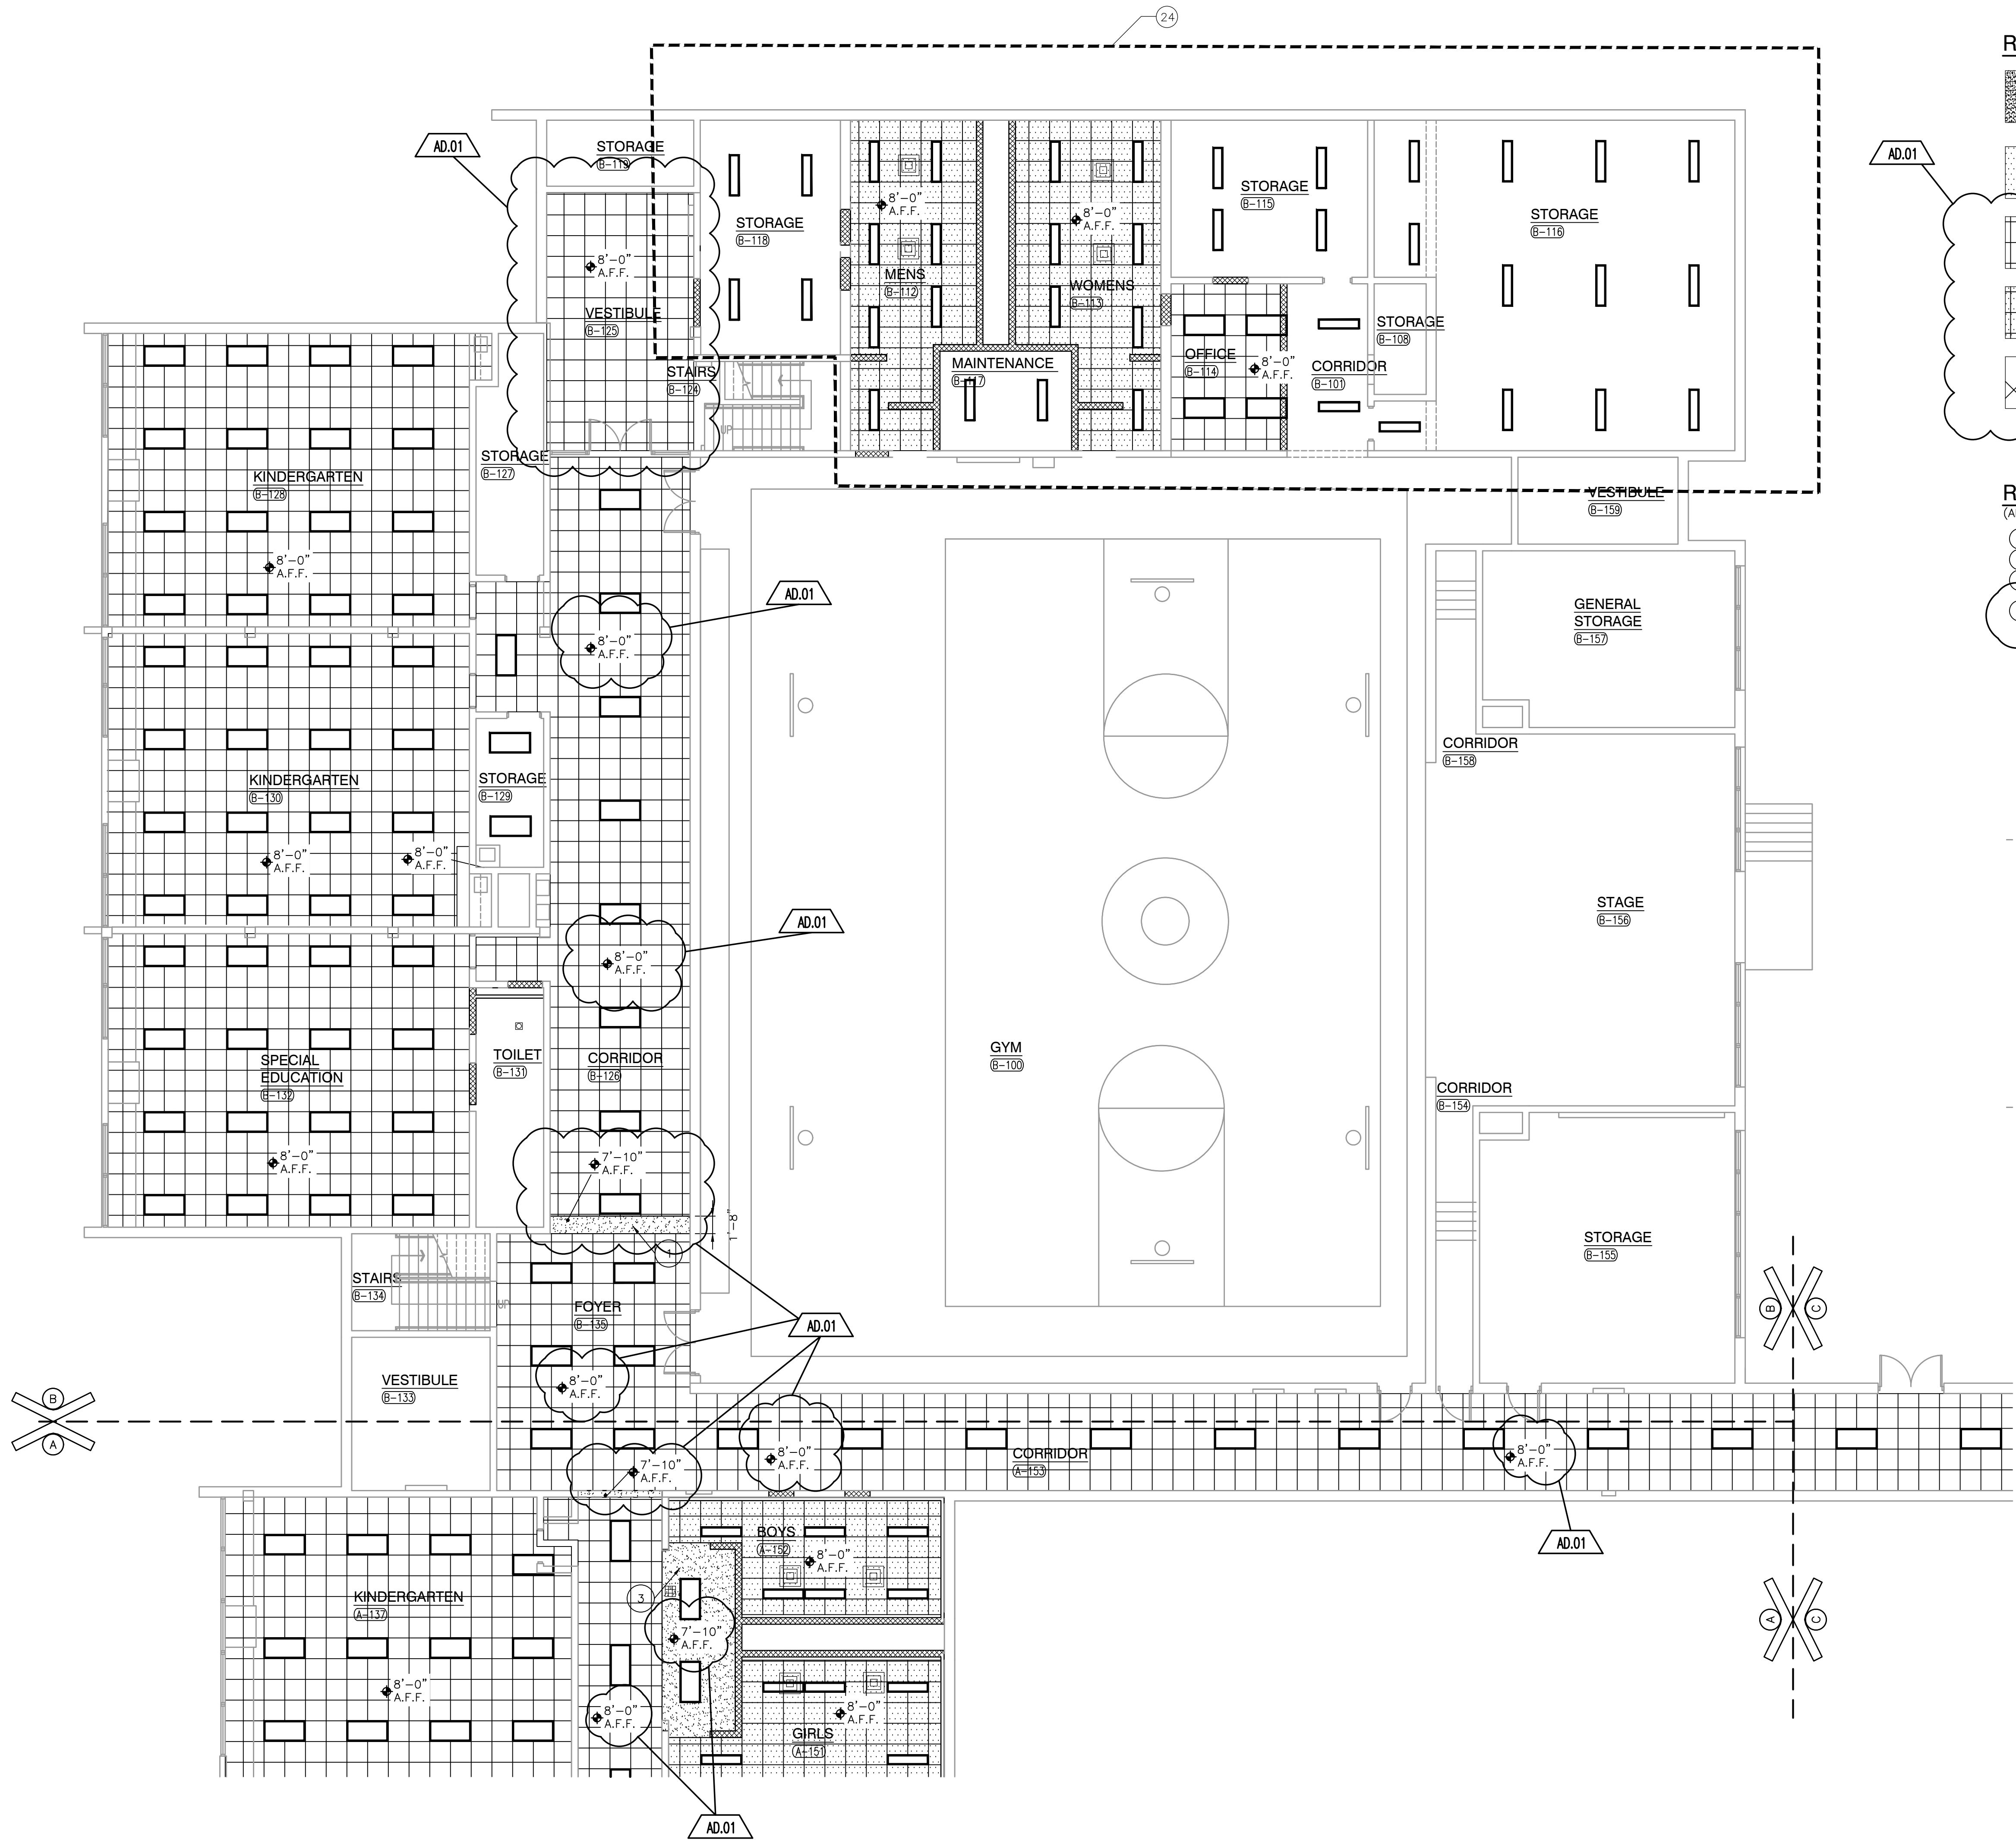

UNIT "B" LOWER LEVEL
REFLECTED CEILING PLAN

SCALE: 1/8" = 1'-0"

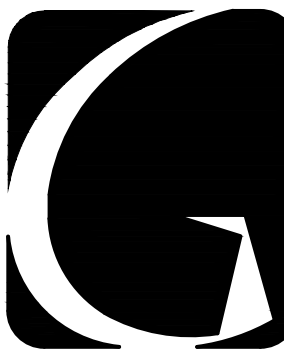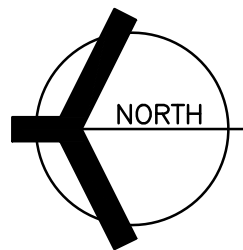

GIBRALTAR
DESIGN
ARCHITECTURE • ENGINEERING • INTERIOR DESIGN

PROJECT
**FAIRVIEW
ELEMENTARY
SCHOOL
RENOVATIONS**

LOGANSPORT COMMUNITY
SCHOOL CORPORATION
LOGANSPORT, INDIANA

GIBRALTAR DESIGN

9102 N. Meridian St., Ste. 300
Indianapolis, IN 46260
Homepage: www.GibraltarDesign.com
Email: info@GibraltarDesign.com
Phone: 317.580.5777 Fax: 317.580.5778

PROJECT
20-157
DATE
06/18/21
COORDINATED BY
DJW
DRAWN BY
MMM
CHECKED BY
DJW

COPYRIGHT NOTICE:
THE CONCEPTS, DESIGNS, PLANS, DETAILS, ETC., SHOWN ON THIS DOCUMENT ARE THE PROPERTY OF GIBRALTAR DESIGN AND WERE CREATED FOR USE ON THIS SPECIFIC PROJECT. NONE OF THIS INFORMATION SHALL BE USED BY ANY PERSON OR FIRM FOR ANY PURPOSE WITHOUT THE EXPRESS WRITTEN CONSENT OF GIBRALTAR DESIGN. THE OWNER MAY RETAIN COPIES FOR INFORMATION AND REFERENCE IN CONNECTION ONLY WITH THIS PROJECT.

REVISIONS
MARK DATE ISSUED FOR
AD.01 7/9/21 AD.01

DRAWING
UNIT "B" LOWER LEVEL
REFLECTED CEILING PLAN

PROJECT
FAIRVIEW ELEMENTARY SCHOOL
RENOVATIONS

© GIBRALTAR DESIGN SHEET
B A-902

GENERAL REFLECTED CEILING PLAN NOTES:

- A. FOR GENERAL PROJECT NOTES, MATERIAL INDICATIONS, LEGEND, SYMBOL, LEGEND, ABBREVIATIONS, ETC., REFER TO G1 SERIES SHEETS.
- B. THE ARCHITECTURAL REFLECTED CEILING PLAN GOVERN THE LAYOUT OF ALL CEILING ELEMENTS AND PENETRATIONS.
- C. BULKHEAD FRAMING SHALL BE ATTACHED TO STRUCTURAL SUPPORTS AND NOT THE ROOF DECK.
- D. REFER TO FLOOR PLANS FOR WALL TYPES
- E. REFER TO ELECTRICAL DRAWINGS FOR ADDITIONAL CEILING MOUNTED ELECTRICAL ITEMS.
- F. REFER TO TECHNOLOGY DRAWINGS FOR ADDITIONAL CEILING MOUNTED TECHNOLOGY ITEMS.
- G. REFER TO MECHANICAL DRAWINGS FOR LOCATION OF CEILING DIFFUSERS, RETURN AIR GRILLS, AND CEILING CABINET HEATERS.


REFLECTED CEILING PLAN LEGEND:

- GYPSUM BOARD BULKHEAD/CEILING
- EFS SOFFIT
- 2'-0" x 2'-0" ACST. BD. CEILING ACT 1
- 2'-0" x 2'-0" VINYL FACED CEILING ACT 2
- 4'-0" x 4'-0" ACST. BD. CEILING ACT 3
- LED LIGHT
- EXIT LIGHT
- 1x4 LIGHT FIXTURE
- 2x4 LIGHT FIXTURE
- PENDANT LIGHT FIXTURE
- LINEAR LIGHT FIXTURE
- WALL SCONCE LIGHT FIXTURE
- SUPPLY AIR DIFFUSER
- LINEAR SUPPLY AIR DIFFUSER
- RETURN, EXHAUST, AND TRANSFER AIR GRILLE
- CEILING SPEAKER
- OCCUPANCY SENSOR

REFLECTED CEILING PLAN NOTES:

(ALL PLAN NOTES MAY NOT BE INDICATED ON THIS SHEET.)


- 1 GYPSUM BOARD BULKHEAD.
- 2 3" W. SOFFIT VENT. LENGTH AS INDICATED.
- 3 GYPSUM BOARD BULKHEAD.
- 3 ALIGN CENTERLINE OF GRID WITH CORNER OF CEILING IN ORDER TO CENTER LIGHTING IN THE RAISED CEILING.

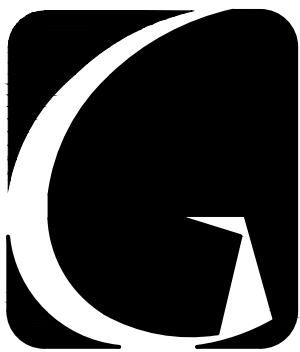

GIBRALTAR
DESIGN
ARCHITECTURE • ENGINEERING • INTERIOR DESIGN

PROJECT
**FAIRVIEW
ELEMENTARY
SCHOOL
RENOVATIONS**


LOGANSPORT COMMUNITY
SCHOOL CORPORATION
LOGANSPORT, INDIANA

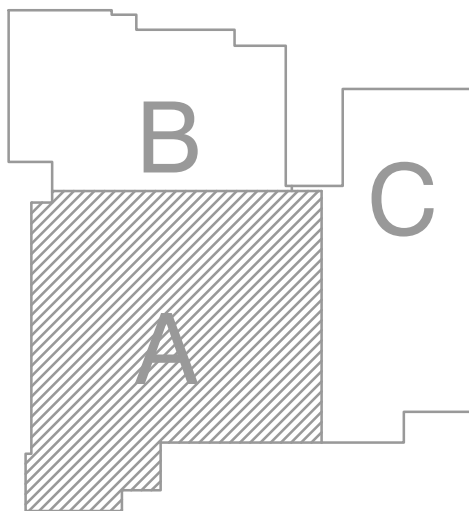

GIBRALTAR DESIGN

9102 N. Meridian St., Ste. 300
Indianapolis, IN 46260
Homepage: www.GibraltarDesign.com
Email: info@GibraltarDesign.com
Phone: 317.580.5777 Fax: 317.580.5778

PROJECT
20-157
DATE
06/18/21
COORDINATED BY
DJW
DRAWN BY
MMM
CHECKED BY
DJW

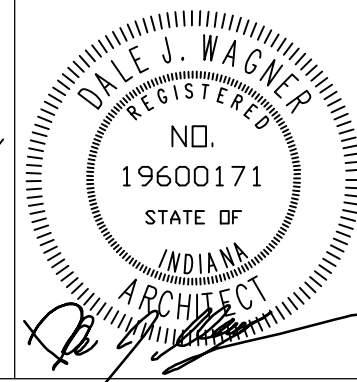

COPYRIGHT NOTICE:
THE CONCEPTS, DESIGNS, PLANS, DETAILS, ETC., SHOWN ON THIS DOCUMENT ARE THE PROPERTY OF GIBRALTAR DESIGN AND WERE CREATED FOR USE ON THIS SPECIFIC PROJECT. NONE OF THIS INFORMATION SHALL BE USED BY ANY PERSON OR FIRM FOR ANY PURPOSE WITHOUT THE EXPRESS WRITTEN CONSENT OF GIBRALTAR DESIGN. THE OWNER MAY RETAIN COPIES FOR INFORMATION AND REFERENCE IN CONNECTION ONLY WITH THIS PROJECT.


REVISIONS

MARK	DATE	ISSUED FOR
AD.01	7/9/21	AD.01

DRAWING
**UNIT "A" FIRST FLOOR
REFLECTED CEILING PLAN**


PROJECT
**FAIRVIEW ELEMENTARY SCHOOL
RENOVATIONS**

© GIBRALTAR DESIGN SHEET
A A-904

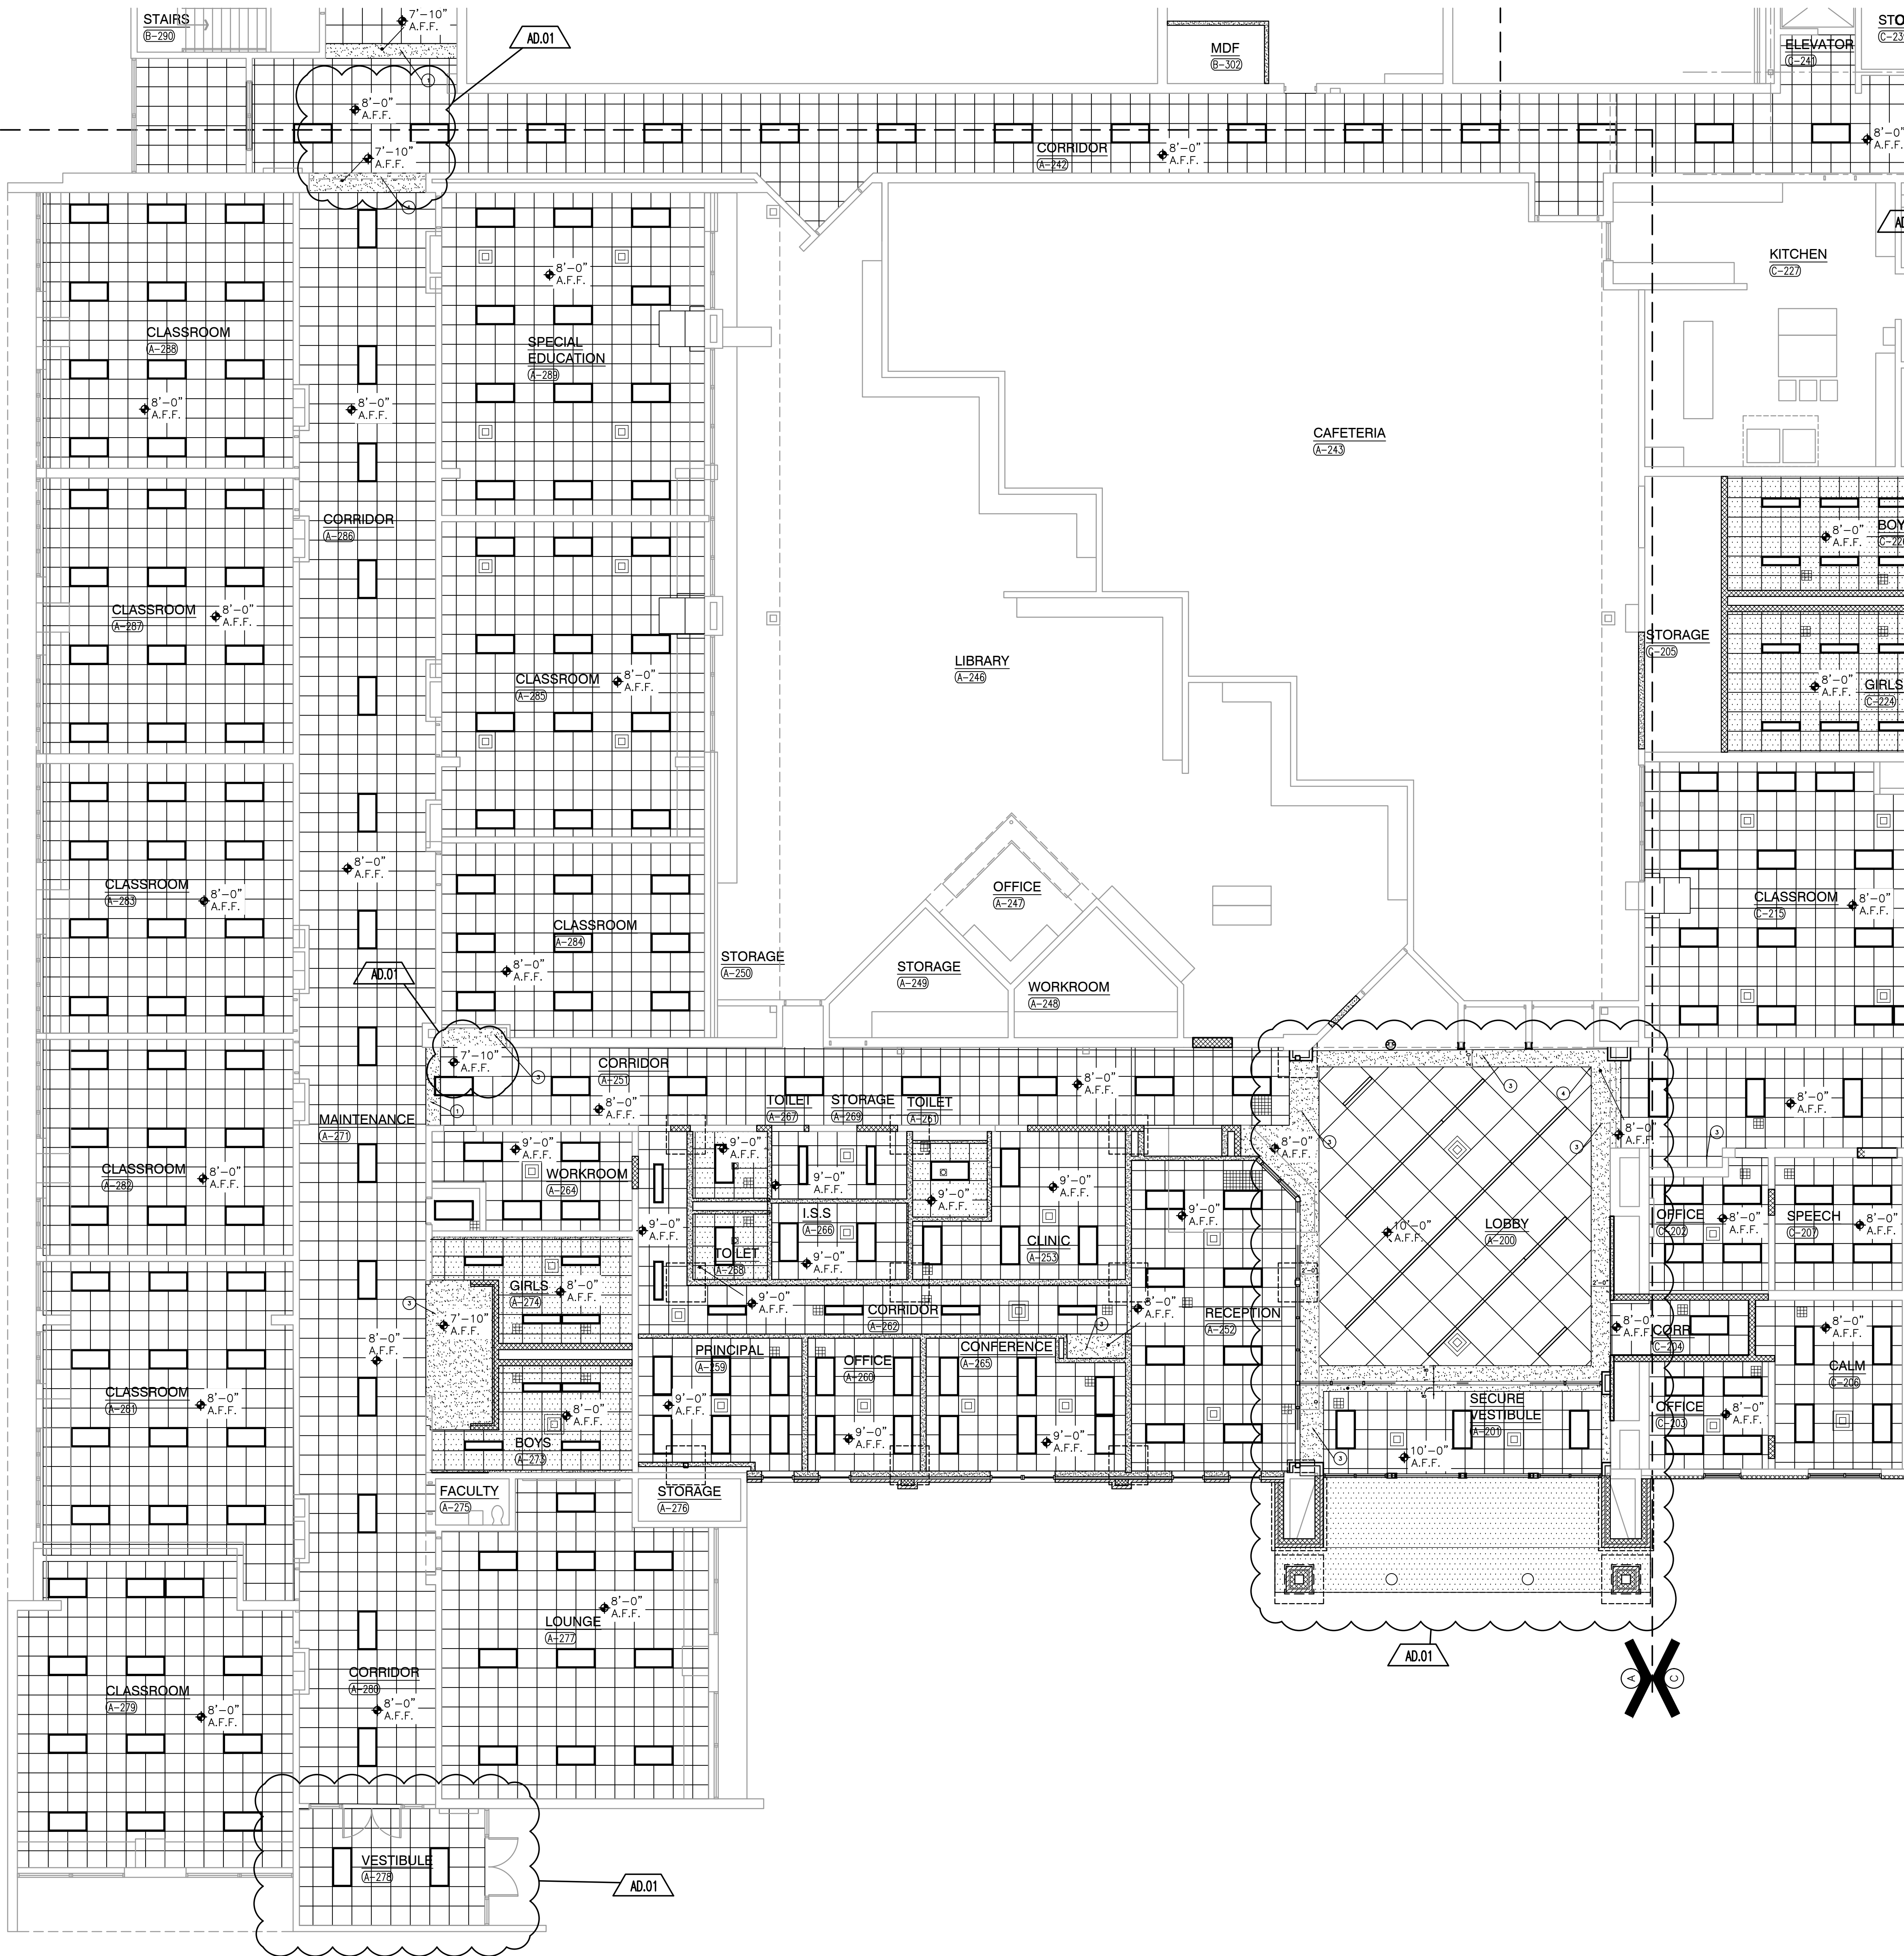

UNIT "A" ARCHITECTURAL FIRST FLOOR PLAN

SCALE: 1/8" = 1'-0"

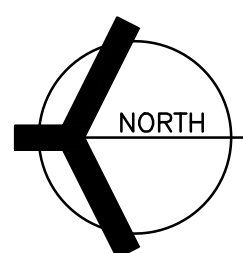

GENERAL REFLECTED CEILING PLAN NOTES:

- A. FOR GENERAL PROJECT NOTES, MATERIAL INDICATIONS, LEGEND, SYMBOL, LEGEND, ABBREVIATIONS, ETC., REFER TO G1 SERIES SHEETS.
- B. THE ARCHITECTURAL REFLECTED CEILING PLAN GOVERN THE LAYOUT OF ALL CEILING ELEMENTS AND PENETRATIONS.
- C. BULKHEAD FRAMING SHALL BE ATTACHED TO STRUCTURAL SUPPORTS AND NOT THE ROOF DECK.
- D. REFER TO FLOOR PLANS FOR WALL TYPES
- E. REFER TO ELECTRICAL DRAWINGS FOR ADDITIONAL CEILING MOUNTED ELECTRICAL ITEMS.
- F. REFER TO TECHNOLOGY DRAWINGS FOR ADDITIONAL CEILING MOUNTED TECHNOLOGY ITEMS.
- G. REFER TO MECHANICAL DRAWINGS FOR LOCATION OF CEILING DIFFUSERS, RETURN AIR GRILLS, AND CEILING CABINET HEATERS.


REFLECTED CEILING PLAN LEGEND:

- GYPSUM BOARD BULKHEAD/CEILING
- EFS SOFFIT
- 2'-0" x 2'-0" ACST. BD. CEILING ACT 1
- 2'-0" x 2'-0" VINYL FACED CEILING ACT 2
- 4'-0" x 4'-0" ACST. BD. CEILING ACT 3
- LED LIGHT
- EXIT LIGHT
- 1x4 LIGHT FIXTURE
- 2x4 LIGHT FIXTURE
- PENDANT LIGHT FIXTURE
- LINEAR LIGHT FIXTURE
- WALL SCONCE LIGHT FIXTURE
- SUPPLY AIR DIFFUSER
- LINEAR SUPPLY AIR DIFFUSER
- RETURN EXHAUST AND TRANSFER AIR GRILLE
- CEILING SPEAKER
- OCCUPANCY SENSOR

REFLECTED CEILING PLAN NOTES:



(ALL PLAN NOTES MAY NOT BE INDICATED ON THIS SHEET.)

- 1 GYPSUM BOARD BULKHEAD. 5
- 2 3" W. SOFFIT VENT. LENGTH AS INDICATED. 6
- 3 GYPSUM BOARD BULKHEAD. 6
- 3 ALIGN CENTERLINE OF GRID WITH CORNER OF CEILING IN ORDER TO CENTER LIGHTING IN THE RAISED CEILING.

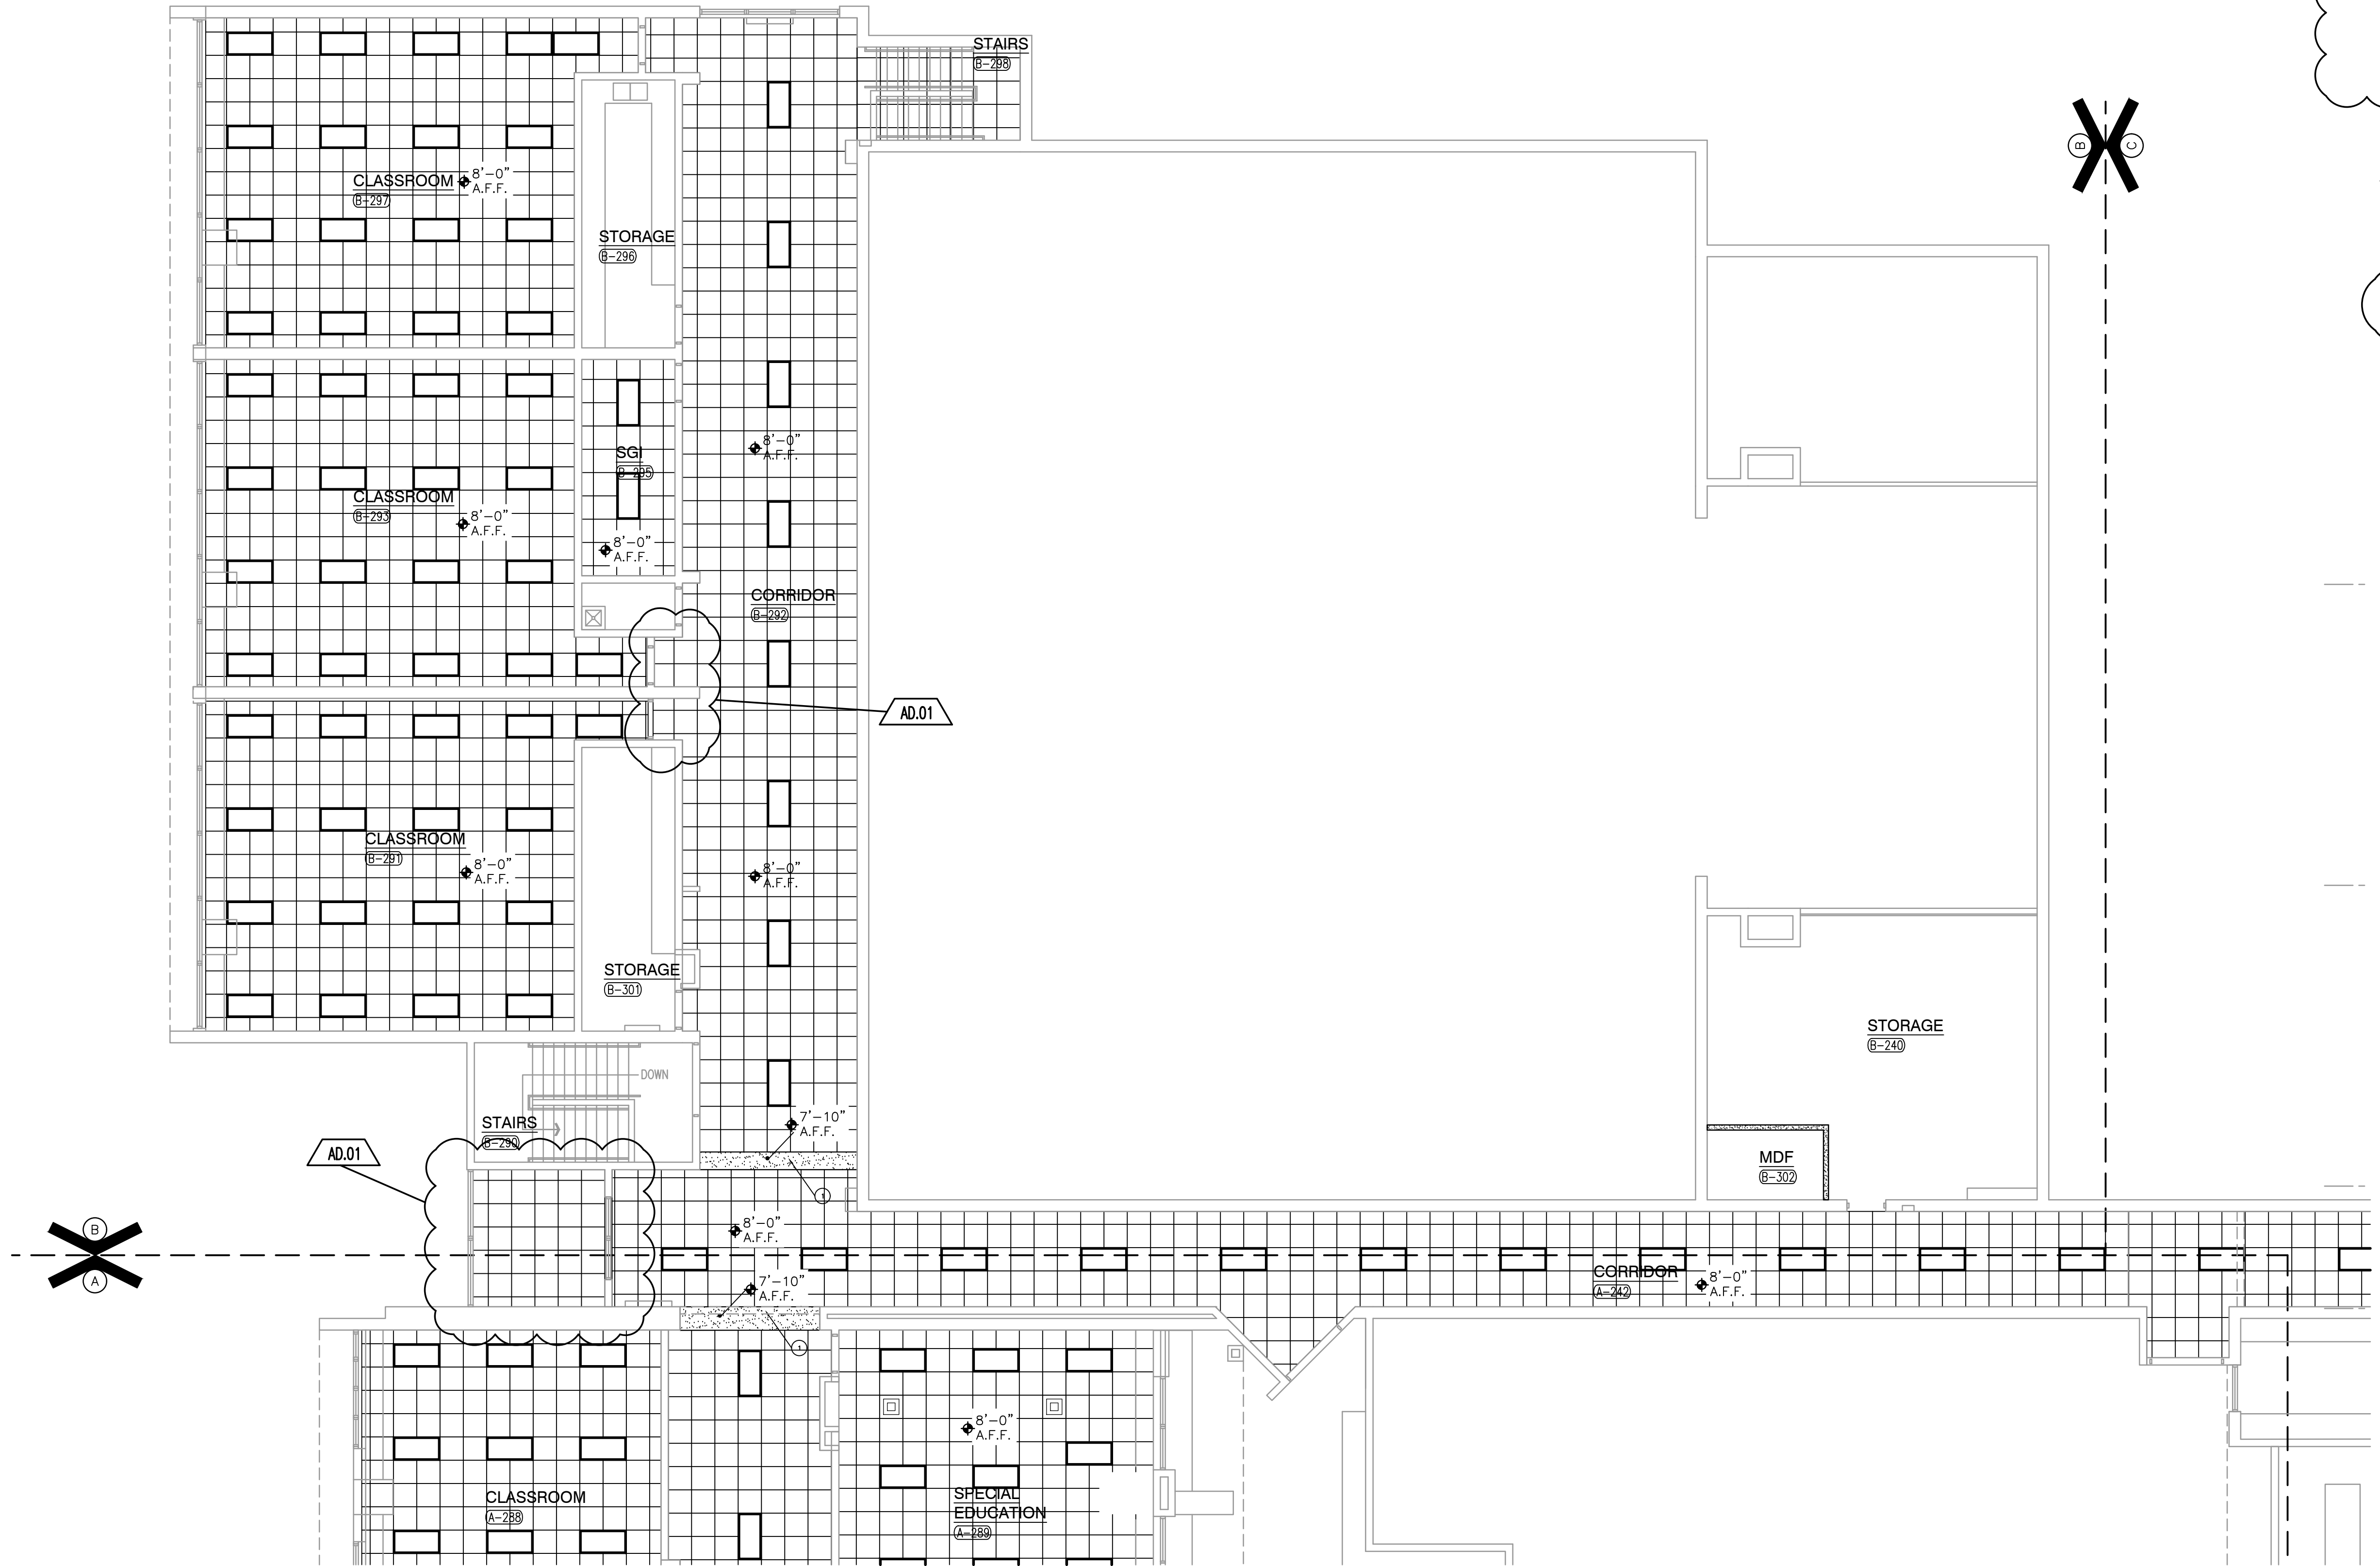

UNIT "B" FIRST FLOOR
REFLECTED CEILING PLAN

SCALE: 1/8" = 1'-0"

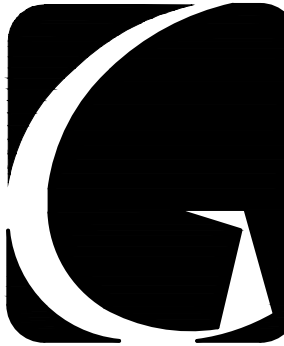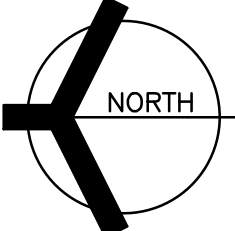


GIBALTAR
DESIGN

ARCHITECTURE • ENGINEERING • INTERIOR DESIGN

PROJECT

**FAIRVIEW
ELEMENTARY
SCHOOL
RENOVATIONS**

LOGANSPORT COMMUNITY
SCHOOL CORPORATION
LOGANSPORT, INDIANA

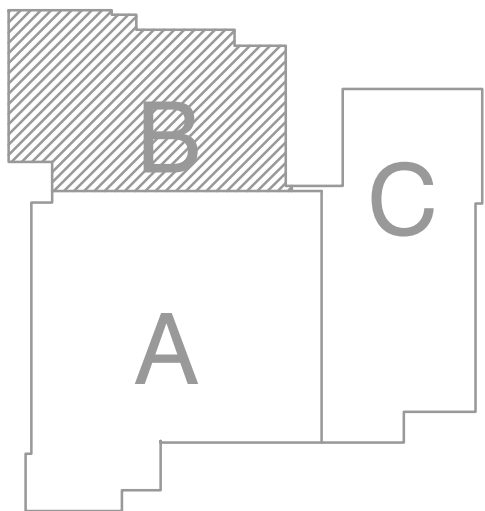

GIBALTAR DESIGN

9102 N. Meridian St., Ste. 300
Indianapolis, IN 46260
Homepage www.GibraltarDesign.com
Email info@GibraltarDesign.com
Phone 317.580.5777 Fax 317.580.5778

PROJECT

20-157

DATE

06/18/21

COORDINATED BY

DJW

DRAWN BY

MMM

CHECKED BY

DJW

COPYRIGHT NOTICE:
THE CONCEPTS, DESIGNS, PLANS, DETAILS, ETC., SHOWN ON THIS DOCUMENT ARE THE PROPERTY OF GIBALTAR DESIGN AND WERE CREATED FOR USE ON THIS SPECIFIC PROJECT. NONE OF THIS INFORMATION SHALL BE USED BY ANY PERSON OR FIRM FOR ANY PURPOSE WITHOUT THE EXPRESS WRITTEN CONSENT OF GIBALTAR DESIGN. THE OWNER MAY RETAIN COPIES FOR INFORMATION AND REFERENCE IN CONNECTION ONLY WITH THIS PROJECT.

REVISIONS

MARK

DATE

ISSUED FOR

AD.01

7/9/21

AD.01

DRAWING

UNIT "B" FIRST FLOOR

REFLECTED CEILING PLAN

PROJECT

FAIRVIEW ELEMENTARY SCHOOL

RENOVATIONS

© GIBALTAR DESIGN

SHEET

B

A-905

 GYPSUM BOARD BULKHEAD/CEILING
 EFS SOFFIT
 2'-0" x 2'-0" ACST. BD. CEILING ACT 1
 2'-0" x 2'-0" VINYL FACED CEILING ACT 2
 4'-0" x 4'-0" ACST. BD. CEILING ACT 3

 LED LIGHT
 EXIT LIGHT
 1x4 LIGHT FIXTURE
 2x4 LIGHT FIXTURE
 PENDANT LIGHT FIXTURE
 PENDANT LIGHT FIXTURE
 LINEAR LIGHT FIXTURE
 WALL SCONCE LIGHT FIXTURE
 SUPPLY AIR DIFFUSER
 LINEAR SUPPLY AIR DIFFUSER
 RETURN, EXHAUST, AND TRANSFER AIR GRILLE
 CEILING SPEAKER
 OCCUPANCY SENSOR

(ALL PLAN NOTES MAY NOT BE INDICATED ON THIS SHEET.)

- ① GYPSUM BOARD BULKHEAD. _____ (5) A-501
- ② 3" W. SOFFIT VENT. LENGTH AS INDICATED. _____
- ③ GYPSUM BOARD BULKHEAD _____ (6) A-501
- ③ ALIGN CENTERLINE OF GRID WITH CORNER OF CEILING ORDER TO CENTER LIGHTING IN THE RAISED CEILING.

LOGANSPORT COMMUNITY
SCHOOL CORPORATION
LOGANSPORT, INDIANA

9102 N. Meridian St., Ste. 300
Indianapolis, IN 46260
Homepage www.GibraltarDesign.com
Email info@GibraltarDesign.com
Phone 317.580.5777 Fax 317.580.5778

COPYRIGHT NOTICE

COPYRIGHT NOTICE:
THE CONCEPTS, DESIGNS, PLANS, DETAILS, ETC. SHOWN ON THIS DOCUMENT ARE THE PROPERTY OF GIBRALTAR DESIGN AND WERE CREATED FOR USE ON THIS SPECIFIC PROJECT. NONE OF THIS INFORMATION SHALL BE USED BY ANY PERSON OR FIRM FOR ANY PURPOSE WITHOUT THE EXPRESS WRITTEN CONSENT OF GIBRALTAR DESIGN. THE OWNER MAY RETAIN COPIES FOR INFORMATION AND REFERENCE IN CONNECTION ONLY WITH THIS PROJECT.

REVISIONS		
MARK	DATE	ISSUED FOR
AD.01	7/9/21	AD.01

DRAWING
UNIT "C" FIRST FLOOR
REFLECTED CEILING PLAN

PROJECT
FAIRVIEW ELEMENTARY SCHOOL
RENOVATIONS


SHEET

A-906

Thursday, 7/8/2021 - 1:27 PM - LAST SAVED BY: CHAMBERS
Y:\20-157 LOGANSPO... FAIRVIEW ES
RENOVATIONS\20-157 DRAWINGS\09 ELEC\E-101.DWG



UNIT "A" LOWER LEVEL ELECTRICAL LIGHTING PLAN
SCALE: 1/8" = 1'-0"

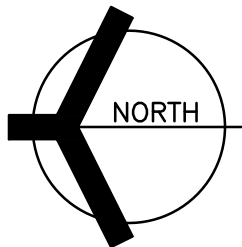

GENERAL NOTES:

1. FOR ADDITIONAL GENERAL ELECTRICAL NOTES, SEE GENERAL ELECTRICAL PROJECT NOTES ON SHEET E-001.
2. PROVIDE AUXILIARY CONTACT IN THE OCCUPANCY SENSORS SERVING THE RESTROOM TO CONTROL THE NEW EXHAUST FANS IN SMALL TOILET ROOMS.
3. CONNECT ALL NIGHT LIGHTS/EMERGENCY LIGHTS AND EXIT SIGNS TO THE LIGHTING CIRCUIT SERVING THE ROOM AHEAD OF ANY CONTROLS.

ELECTRICAL PLAN NOTES:

(THESE NOTES APPLY TO THIS SHEET ONLY)

- 1 REINSTALL EXISTING CEILING MOUNTED DEVICES AND EQUIPMENT IN THIS ROOM INTO THE NEW CEILING.
- 2 CONNECT NEW LIGHTING FIXTURES, SWITCHES AND OCCUPANCY SENSORS IN THIS ROOM TO THE EXISTING CORRIDOR LIGHTING CIRCUIT SERVING THIS ROOM, UNLESS OTHERWISE NOTED. CONNECT NIGHT LIGHT (NL) LIGHTING FIXTURES AND EXIT SIGNS TO THE EXISTING CORRIDOR LIGHTING CIRCUIT SERVING THIS ROOM AHEAD OF ANY CONTROLS.
- 3 CONNECT NEW LIGHTING FIXTURES AND CONTROLS IN THIS ROOM TO THE EXISTING LIGHTING CIRCUIT SERVING THIS ROOM, UNLESS OTHERWISE NOTED.
- 4 CONNECT NEW LIGHTING FIXTURES AND CONTROLS IN THIS ROOM TO THE EXISTING LIGHTING CIRCUIT SERVING THIS ROOM, UNLESS OTHERWISE NOTED.
- 5 REINSTALL EXISTING CEILING MOUNTED DEVICES AND EQUIPMENT IN TO NEW CEILING.
- 6 NOT USED.
- 7 PROVIDE AUXILIARY CONTACT IN THE OCCUPANCY SENSORS SERVING THE RESTROOM TO CONTROL THE NEW EXHAUST FANS.

ROOM LEGEND

ROOM NO.	ROOM NAME
A-137	KINDERGARTEN
A-138	STORAGE
A-139	TOILET
A-140	TOILET
A-141	TOILET
A-142	TOILET
A-143	STORAGE
A-144	KINDERGARTEN
A-145	CORRIDOR
A-146	VESTIBULE
A-147	ART
A-148	NOT USED
A-149	STORAGE
A-150	MAINTENANCE
A-151	GIRLS
A-152	BOYS
A-153	CORRIDOR

PROJECT
FAIRVIEW
ELEMENTARY
SCHOOL
RENOVATIONS
LOGANSPO COMMUNITY
SCHOOL CORPORATION
LOGANSPO, INDIANA

GIBRALTAR DESIGN
9102 N. Meridian St., Ste. 300
Indianapolis, IN 46260
Homepage www.GibraltarDesign.com
Email info@GibraltarDesign.com
Phone 317.580.5777 Fax 317.580.5778

PROJECT
20-157
DATE
06/18/21
COORDINATED BY
PCB
DRAWN BY
PCB/JVC
CHECKED BY
DJW

COPYRIGHT NOTICE:
THE CONCEPTS, DESIGNS, PLANS, DETAILS, ETC., SHOWN ON THIS DOCUMENT ARE THE PROPERTY OF GIBRALTAR DESIGN AND WERE CREATED FOR USE ON THIS SPECIFIC PROJECT. NONE OF THIS INFORMATION SHALL BE USED BY ANY PERSON OR FIRM FOR ANY PURPOSE WITHOUT THE EXPRESS WRITTEN CONSENT OF GIBRALTAR DESIGN. THE OWNER MAY RETAIN COPIES FOR INFORMATION AND REFERENCE IN CONNECTION ONLY WITH THIS PROJECT.

REVISIONS
MARK DATE ISSUED FOR
AD-1 07/08/21 ADDENDUM NO. 1

DRAWING
UNIT "A" LOWER LEVEL
ELECTRICAL LIGHTING PLAN

PROJECT
FAIRVIEW ELEMENTARY SCHOOL
RENOVATIONS

GIBRALTAR DESIGN SHEET
E-101



Thursday, 7/8/2021 - 1:40 PM - LAST SAVED BY: CHAMBERS
Y:\20-157 LOGANSPO... FAIRVIEW ES
RENOVATIONS\20-157 DRAWINGS\09 ELEC\E-103.DWG

GENERAL NOTES:


- FOR ADDITIONAL GENERAL ELECTRICAL NOTES, SEE GENERAL ELECTRICAL PROJECT NOTES ON SHEET E-001.
- CONNECT ALL NIGHT LIGHTS/EMERGENCY LIGHTS AND EXIT SIGNS TO THE LIGHTING CIRCUIT SERVING THE ROOM AHEAD OF ANY CONTROLS.

ELECTRICAL PLAN NOTES:

(THESE NOTES APPLY TO THIS SHEET ONLY)


- REINSTALL EXISTING CEILING MOUNTED DEVICES AND EQUIPMENT IN TO NEW CEILING.
- CONNECT NEW LIGHTING FIXTURES, SWITCHES AND OCCUPANCY SENSORS IN THIS ROOM TO THE EXISTING CORRIDOR LIGHTING CIRCUIT SERVING THIS ROOM, UNLESS OTHERWISE NOTED. CONNECT NIGHT LIGHT (NL) LIGHTING FIXTURES AND EXIT SIGNS TO THE EXISTING CORRIDOR LIGHTING CIRCUIT SERVING THIS ROOM AHEAD OF ANY CONTROLS.
- CONNECT NEW LIGHTING FIXTURES AND CONTROLS IN THIS ROOM TO THE EXISTING LIGHTING CIRCUIT SERVING THIS ROOM, UNLESS OTHERWISE NOTED.
- CONNECT NEW LIGHTING FIXTURES AND CONTROLS IN THIS ROOM TO THE EXISTING LIGHTING CIRCUIT SERVING THIS ROOM, UNLESS OTHERWISE NOTED.
- REINSTALL EXISTING CEILING MOUNTED DEVICES AND EQUIPMENT IN TO NEW CEILING.
- NOT USED.

AD-1

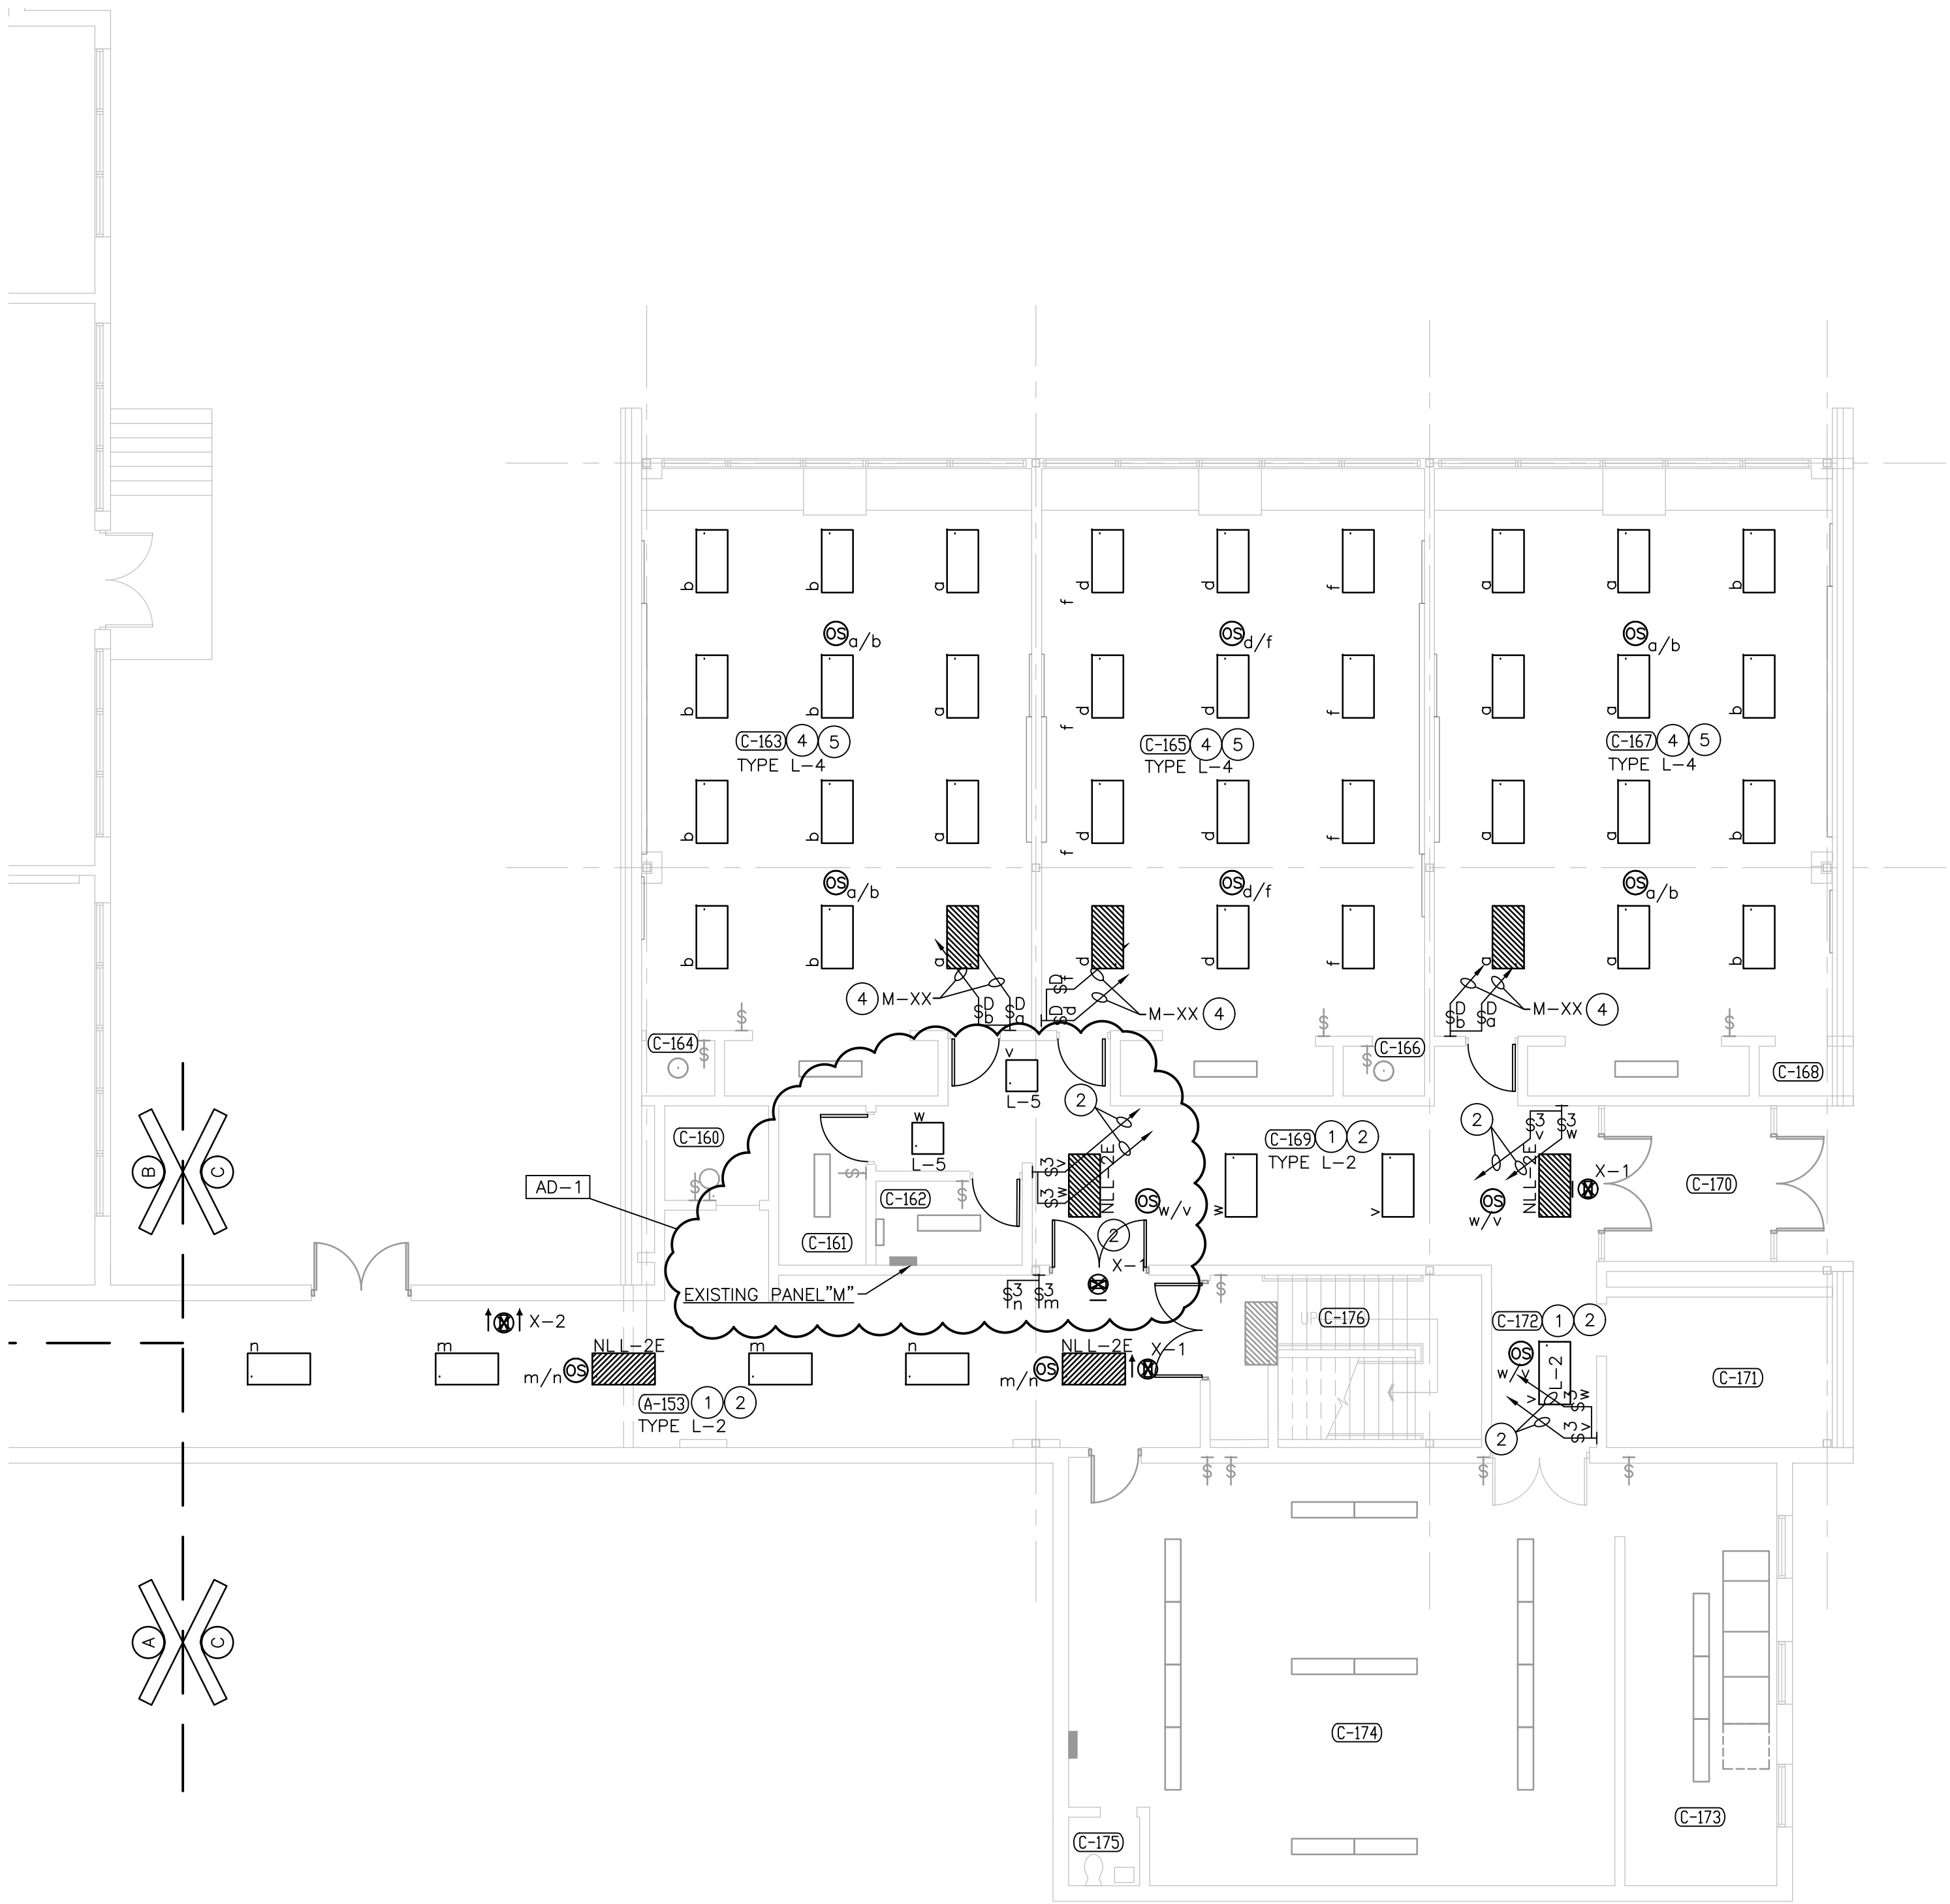


UNIT "C" LOWER LEVEL ELECTRICAL LIGHTING PLAN

SCALE: 1/8" = 1'-0"

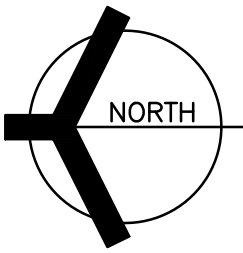

ROOM LEGEND

ROOM NO.	ROOM NAME
C-160	ELEVATOR
C-161	EQUIPMENT
C-162	STORAGE
C-163	STEM
C-164	STORAGE
C-165	FLEX
C-166	STORAGE
C-167	MUSIC
C-168	STORAGE
C-169	CORRIDOR
C-170	VESTIBULE
C-171	MAINTENANCE
C-172	CORRIDOR
C-173	MAINTENANCE
C-174	MECHANICAL
C-175	TOILET
C-176	STAIRS

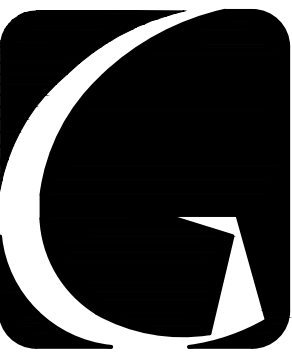

GIBRALTAR DESIGN

ARCHITECTURE • ENGINEERING • INTERIOR DESIGN

PROJECT

FAIRVIEW ELEMENTARY SCHOOL RENOVATIONS

LOGANSPO... COMMUNITY SCHOOL CORPORATION
LOGANSPO... INDIANA

GIBRALTAR DESIGN

9102 N. Meridian St., Ste. 300
Indianapolis, IN 46260
Homepage: www.GibraltarDesign.com
Email: info@GibraltarDesign.com
Phone: 317.580.5777 Fax: 317.580.5778

PROJECT

20-157

DATE

06/18/21

COORDINATED BY

PCB

DRAWN BY

PCB/JVC

CHECKED BY

DJW

COPYRIGHT NOTICE:
THE CONCEPTS, DESIGNS, PLANS, DETAILS, ETC., SHOWN ON THIS DOCUMENT ARE THE PROPERTY OF GIBRALTAR DESIGN AND WERE CREATED FOR USE ON THIS SPECIFIC PROJECT. NONE OF THIS INFORMATION SHALL BE USED BY ANY PERSON OR FIRM FOR ANY PURPOSE WITHOUT THE EXPRESS WRITTEN CONSENT OF GIBRALTAR DESIGN. THE OWNER MAY RETAIN COPIES FOR INFORMATION AND REFERENCE IN CONNECTION ONLY WITH THIS PROJECT.

REVISIONS

MARK	DATE	ISSUED FOR
AD-1	07/08/21	ADDENDUM NO. 1

DRAWING

UNIT "C" LOWER LEVEL ELECTRICAL LIGHTING PLAN

PROJECT

FAIRVIEW ELEMENTARY SCHOOL RENOVATIONS

© GIBRALTAR DESIGN

SHEET

E-103

Thursday, 7/8/2021 - 2:17 PM - LAST SAVED BY: CHAMBERS
Y:\20-157 LOGANSPO... FAIRVIEW ES
RENOVATIONS\20-157 DRAWINGS\09 ELEC\E-104.DWG



GENERAL NOTES:

- FOR ADDITIONAL GENERAL ELECTRICAL NOTES, SEE GENERAL ELECTRICAL PROJECT NOTES ON SHEET E-001.
- PROVIDE AUXILIARY CONTACT IN THE OCCUPANCY SENSORS SERVING THE RESTROOM TO CONTROL THE NEW EXHAUST FANS IN SMALL TOILET ROOMS.
- CONNECT ALL NIGHT LIGHTS/EMERGENCY LIGHTS AND EXIT SIGNS TO THE LIGHTING CIRCUIT SERVING THE ROOM AHEAD OF ANY CONTROLS.

ELECTRICAL PLAN NOTES:

(THESE NOTES APPLY TO THIS SHEET ONLY)

- REINSTALL EXISTING CEILING MOUNTED DEVICES AND EQUIPMENT IN TO NEW CEILING.
- CONNECT NEW LIGHTING FIXTURES, SWITCHES AND OCCUPANCY SENSORS IN THIS ROOM TO THE EXISTING CORRIDOR LIGHTING CIRCUIT SERVING THIS ROOM, UNLESS OTHERWISE NOTED. CONNECT NIGHT LIGHT (NL) LIGHTING FIXTURES AND EXIT SIGNS TO THE EXISTING CORRIDOR LIGHTING CIRCUIT SERVING THIS ROOM AHEAD OF ANY CONTROLS.
- CONNECT NEW LIGHTING FIXTURES AND CONTROLS IN THIS ROOM TO THE EXISTING LIGHTING CIRCUIT SERVING THIS ROOM, UNLESS OTHERWISE NOTED.
- CONNECT NEW LIGHTING FIXTURES AND CONTROLS IN THIS ROOM TO THE EXISTING LIGHTING CIRCUIT SERVING THIS ROOM, UNLESS OTHERWISE NOTED.
- REINSTALL EXISTING CEILING MOUNTED DEVICES AND EQUIPMENT IN TO NEW CEILING.
- NOT USED.
- PROVIDE AUXILIARY CONTACT IN THE OCCUPANCY SENSORS SERVING THE RESTROOM TO CONTROL THE NEW EXHAUST FANS.
- NSI/TORK DZS200BP DIGITAL TIME CLOCK TO SERVE THE NEW CANOPY LIGHTS AND NEW PARKING LOT LIGHTS. (1L1-31). CHANNEL ONE CONTROLS RELAY RA-1 (CANOPY LIGHTS) AND CHANNEL TWO CONTROLS RELAY RA-2 (PARKING LOT LIGHTS)

ROOM LEGEND	
ROOM NO.	ROOM NAME
A-200	LOBBY
A-201	SECURE VESTIBULE
A-202	CORRIDOR
A-203	CAFETERIA
A-204	NOT USED
A-205	NOT USED
A-206	LIBRARY
A-207	OFFICE
A-208	WORKROOM
A-209	STORAGE
A-210	STORAGE
A-211	CORRIDOR
A-212	RECEPTION
A-213	CLINIC
A-214	PRINCIPAL
A-215	OFFICE
A-216	TOILET
A-217	CORRIDOR
A-218	NOT USED
A-219	WORKROOM
A-220	CONFERENCE
A-221	I.S.S.
A-222	TOILET
A-223	TOILET
A-224	STORAGE
A-225	NOT USED
A-226	BOYS
A-227	GIRLS
A-228	FACULTY
A-229	STORAGE
A-230	LOUNGE
A-231	VESTIBULE
A-232	CLASSROOM
A-233	CORRIDOR
A-234	CLASSROOM
A-235	CLASSROOM
A-236	CLASSROOM
A-237	CLASSROOM
A-238	CLASSROOM
A-239	CLASSROOM
A-240	CLASSROOM
A-241	CLASSROOM
A-242	CLASSROOM
A-243	CLASSROOM
A-244	CLASSROOM
A-245	CLASSROOM
A-246	CLASSROOM
A-247	CLASSROOM
A-248	CLASSROOM
A-249	SPECIAL EDUCATION

PROJECT
**FAIRVIEW
ELEMENTARY
SCHOOL
RENOVATIONS**
LOGANSPO COMMUNITY
SCHOOL CORPORATION
LOGANSPO, INDIANA

GIBALTAR DESIGN
9102 N. Meridian St., Ste. 300
Indianapolis, IN 46260
Homepage: www.GibraltarDesign.com
Email: info@GibraltarDesign.com
Phone: 317.580.5777 Fax: 317.580.5778

PROJECT
20-157
DATE
06/18/21
COORDINATED BY
PCB
DRAWN BY
PCB/JVC
CHECKED BY
DJW

COPYRIGHT NOTICE:
THE CONCEPTS, DESIGNS, PLANS, DETAILS, ETC., SHOWN ON THIS DOCUMENT ARE THE PROPERTY OF GIBALTAR DESIGN AND WERE CREATED FOR USE ON THIS SPECIFIC PROJECT. NONE OF THIS INFORMATION SHALL BE USED BY ANY PERSON OR FIRM FOR ANY PURPOSE WITHOUT THE EXPRESS WRITTEN CONSENT OF GIBALTAR DESIGN. THE OWNER MAY RETAIN COPIES FOR INFORMATION AND REFERENCE IN CONNECTION ONLY WITH THIS PROJECT.

REVISIONS
MARK DATE ISSUED FOR
AD-1 07/08/21 ADDENDUM NO. 1

DRAWING
**UNIT "A" FIRST FLOOR
ELECTRICAL LIGHTING PLAN**

PROJECT
**FAIRVIEW ELEMENTARY SCHOOL
RENOVATIONS**

© GIBALTAR DESIGN SHEET
E-104


Thursday, 7/8/2021 - 2:17 PM - LAST SAVED BY: CHAMBERS
Y:\20-157 LOGANSFORT CSC - FAIRVIEW ES
RENOVATIONS\20-157 DRAWINGS\09 ELEC\E-105.DWG



GIBRALTAR
DESIGN
ARCHITECTURE • ENGINEERING • INTERIOR DESIGN

PROJECT
**FAIRVIEW
ELEMENTARY
SCHOOL
RENOVATIONS**

LOGANSFORT COMMUNITY
SCHOOL CORPORATION
LOGANSFORT, INDIANA

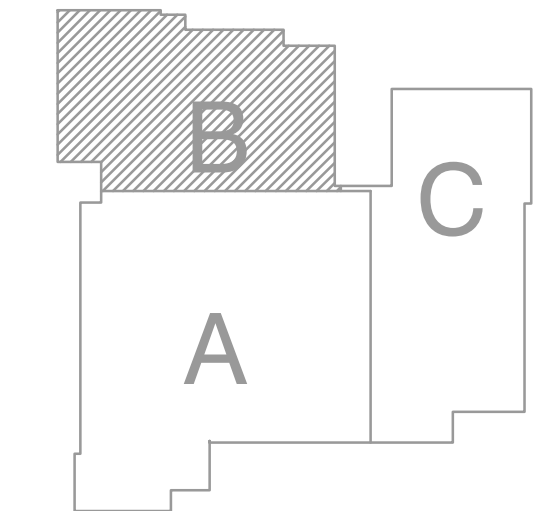


GIBRALTAR DESIGN

9102 N. Meridian St., Ste. 300
Indianapolis, IN 46260
Homepage: www.GibraltarDesign.com
Email: info@GibraltarDesign.com
Phone: 317.580.5777 Fax: 317.580.5778

PROJECT
20-157
DATE
06/18/21

COORDINATED BY
PCB
DRAWN BY
PCB/JVC
CHECKED BY
DJW

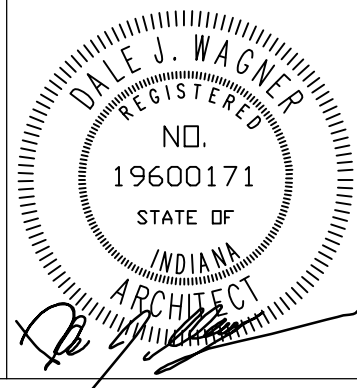

COPYRIGHT NOTICE:
THE CONCEPTS, DESIGNS, PLANS, DETAILS, ETC., SHOWN ON THIS DOCUMENT ARE THE PROPERTY OF GIBRALTAR DESIGN AND WERE CREATED FOR USE ON THIS SPECIFIC PROJECT. NONE OF THIS INFORMATION SHALL BE USED BY ANY PERSON OR FIRM FOR ANY PURPOSE WITHOUT THE EXPRESS WRITTEN CONSENT OF GIBRALTAR DESIGN. THE OWNER MAY RETAIN COPIES FOR INFORMATION AND REFERENCE IN CONNECTION ONLY WITH THIS PROJECT.

REVISIONS

MARK	DATE	ISSUED FOR
AD-1	07/08/21	ADDENDUM NO. 1

DRAWING

**UNIT "B" FIRST FLOOR
ELECTRICAL LIGHTING PLAN**

PROJECT
**FAIRVIEW ELEMENTARY SCHOOL
RENOVATIONS**

© GIBRALTAR DESIGN

SHEET

E-105


GENERAL NOTES:

- FOR ADDITIONAL GENERAL ELECTRICAL NOTES, SEE GENERAL ELECTRICAL PROJECT NOTES ON SHEET E-001.
- PROVIDE AUXILIARY CONTACT IN THE OCCUPANCY SENSORS SERVING THE RESTROOM TO CONTROL THE NEW EXHAUST FANS IN SMALL TOILET ROOMS.
- CONNECT ALL NIGHT LIGHTS/EMERGENCY LIGHTS AND EXIT SIGNS TO THE LIGHTING CIRCUIT SERVING THE ROOM AHEAD OF ANY CONTROLS.

ELECTRICAL PLAN NOTES:


(THESE NOTES APPLY TO THIS SHEET ONLY)

- REINSTALL EXISTING CEILING MOUNTED DEVICES AND EQUIPMENT IN TO NEW CEILING.
- CONNECT NEW LIGHTING FIXTURES, SWITCHES AND OCCUPANCY SENSORS IN THIS ROOM TO THE EXISTING CORRIDOR LIGHTING CIRCUIT SERVING THIS ROOM, UNLESS OTHERWISE NOTED. CONNECT NIGHT LIGHT (NL) LIGHTING FIXTURES AND EXIT SIGNS TO THE EXISTING CORRIDOR LIGHTING CIRCUIT SERVING THIS ROOM AHEAD OF ANY CONTROLS.
- CONNECT NEW LIGHTING FIXTURES AND CONTROLS IN THIS ROOM TO THE EXISTING LIGHTING CIRCUIT SERVING THIS ROOM, UNLESS OTHERWISE NOTED.
- CONNECT NEW LIGHTING FIXTURES AND CONTROLS IN THIS ROOM TO THE EXISTING LIGHTING CIRCUIT SERVING THIS ROOM, UNLESS OTHERWISE NOTED.
- REINSTALL EXISTING CEILING MOUNTED DEVICES AND EQUIPMENT IN TO NEW CEILING.
- NOT USED.

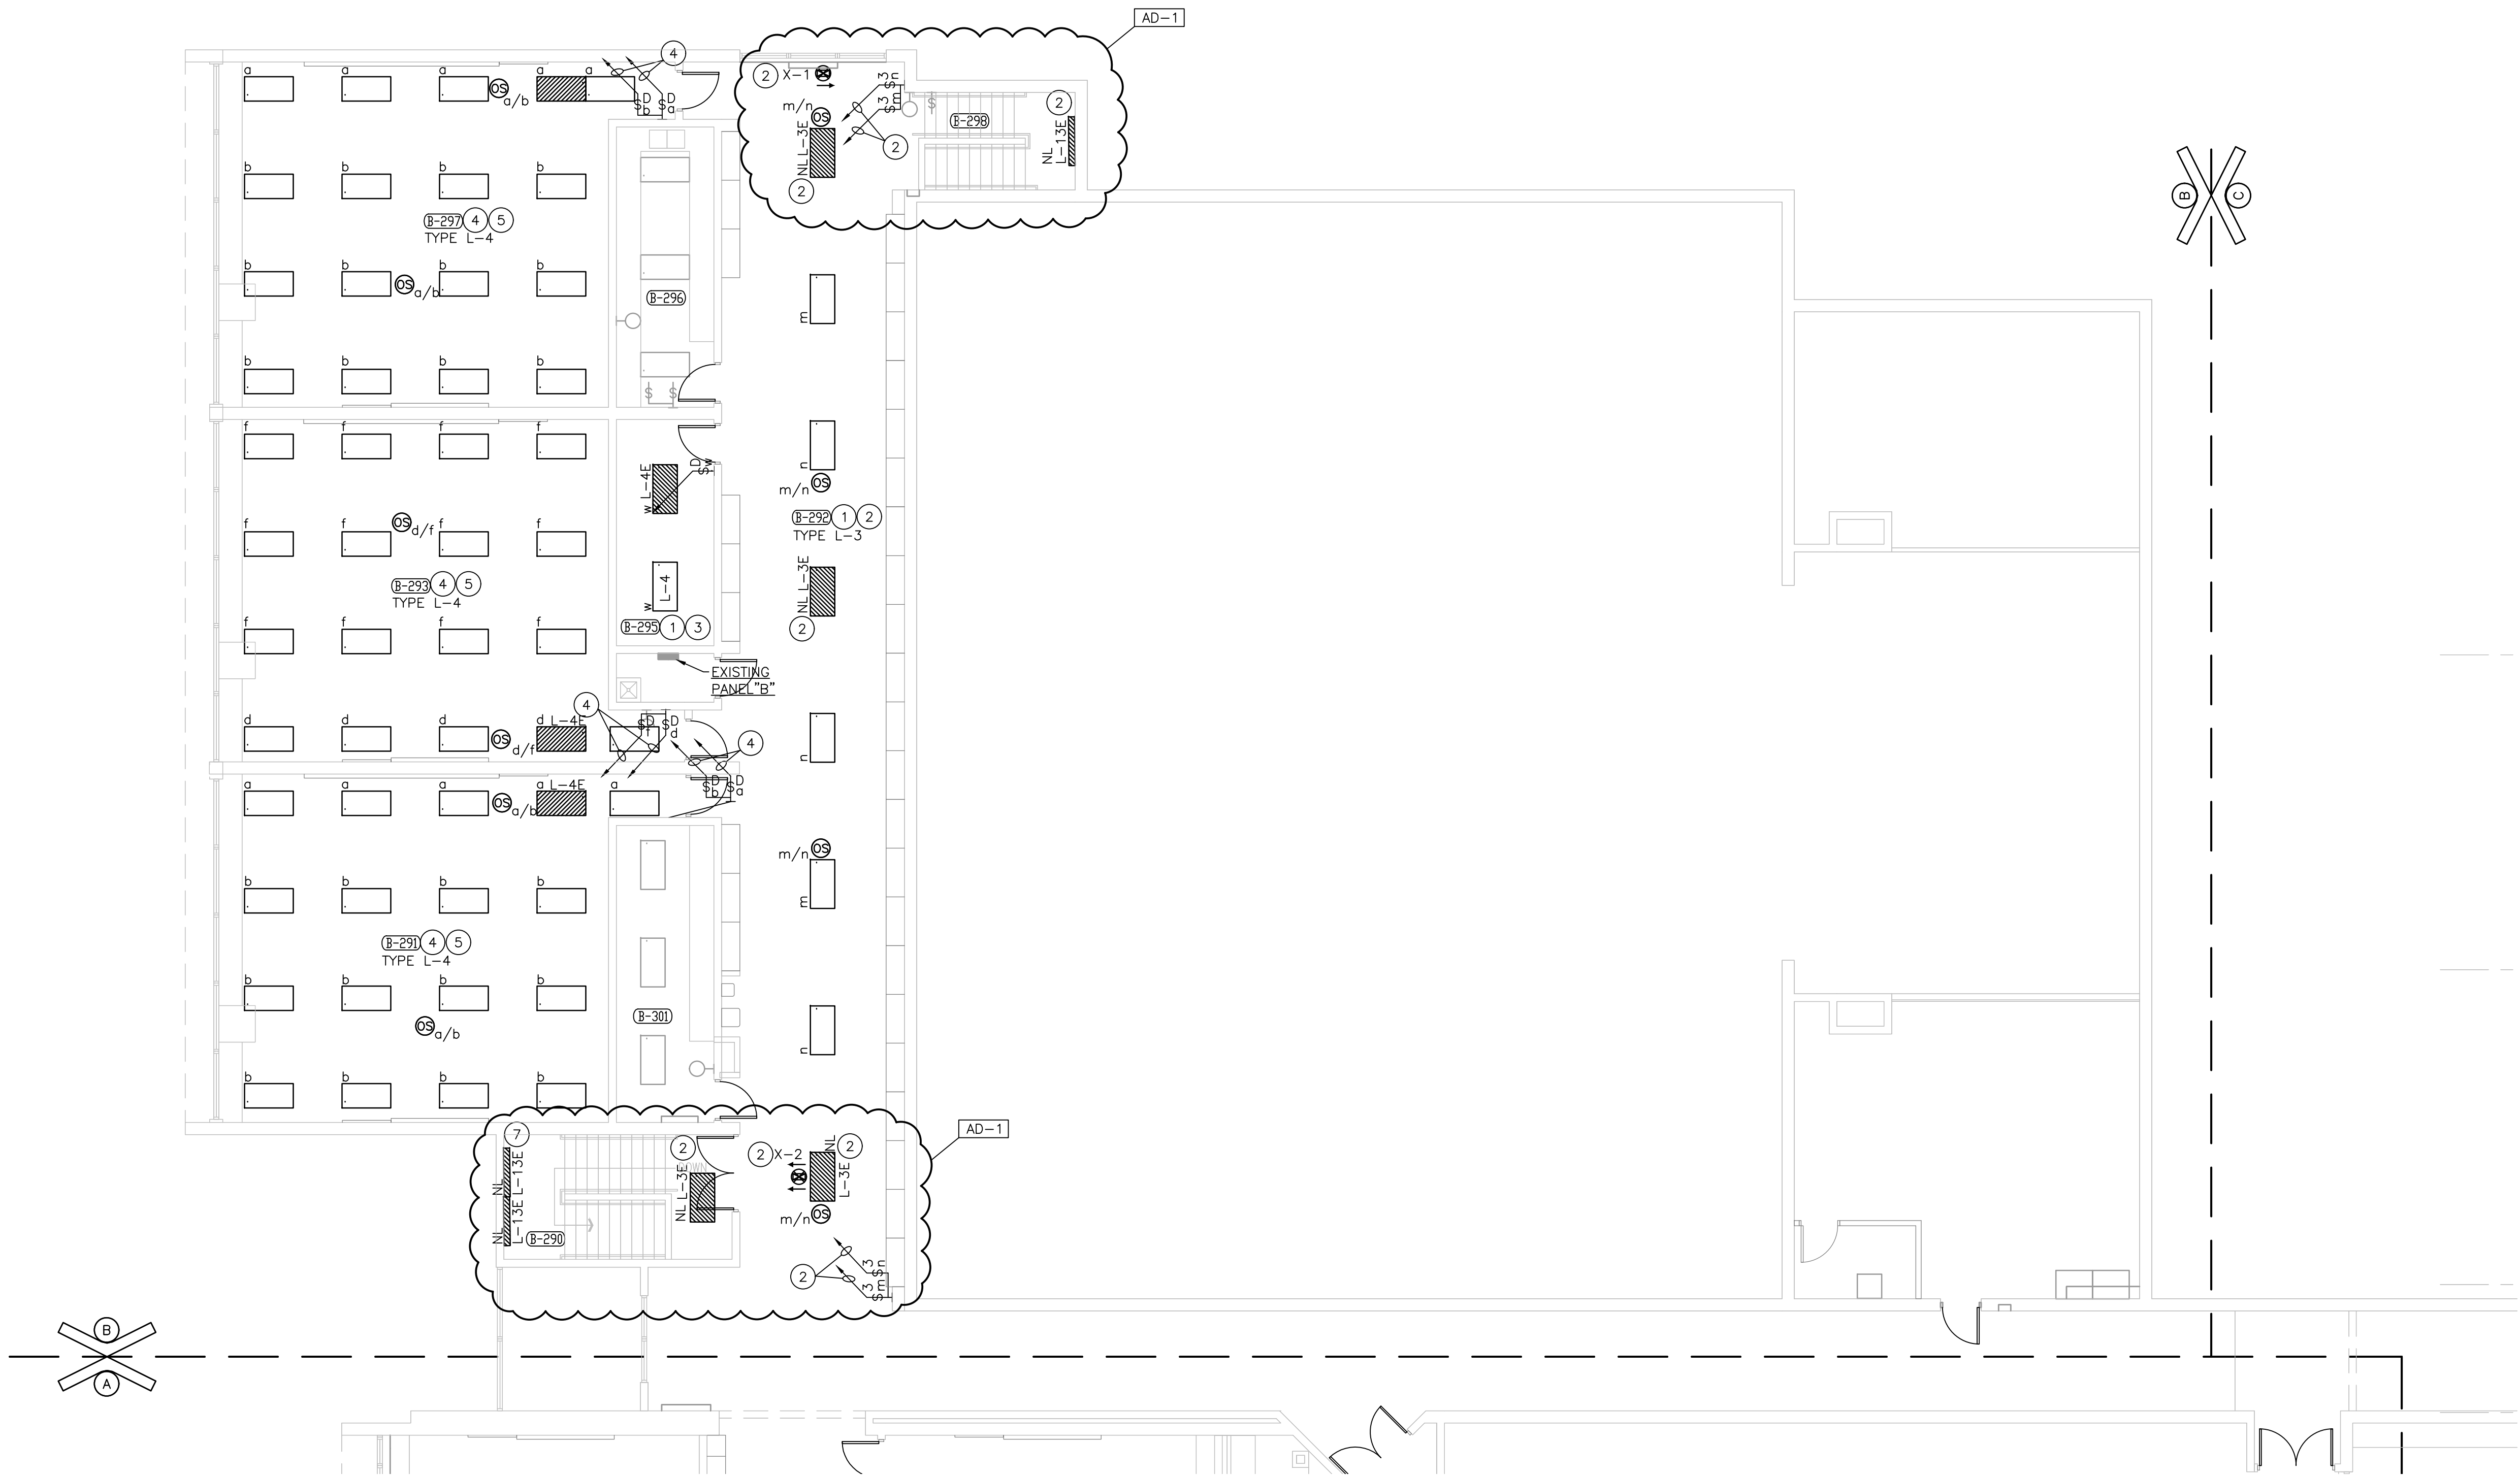

UNIT "B" FIRST FLOOR ELECTRICAL LIGHTING PLAN

SCALE: 1/8" = 1'-0"

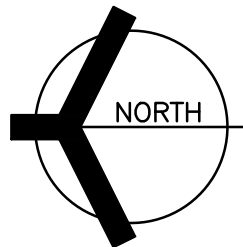

GENERAL NOTES:

1. FOR ADDITIONAL GENERAL ELECTRICAL NOTES, SEE GENERAL ELECTRICAL PROJECT NOTES ON SHEET E-001.
2. PROVIDE ALL OF THE LABOR AND MATERIAL TO PROVIDE THE NECESSARY ROUGH-INS AND RACEWAYS FOR ALL OF THE ACCESS CONTROL, SOUND SYSTEM AND TECHNOLOGY SYSTEMS DEVICES AND EQUIPMENT. SEE TECHNOLOGY DRAWINGS AND SPECIFICATIONS FOR LOCATIONS OF DEVICES, EQUIPMENT AND REQUIREMENTS.

ELECTRICAL PLAN NOTES:


(THESE NOTES APPLY TO THIS SHEET ONLY)

- 1 REINSTALL EXISTING CEILING MOUNTED DEVICES AND EQUIPMENT IN TO NEW CEILING.
- 2 CONNECT NEW EXHAUST FAN TO OCCUPANCY SENSOR SERVING THIS ROOM WITH CIRCUIT INDICATED.
- 3 MODIFY EXISTING PANELBOARD AS NOTED ON THE PANEL SCHEDULE ON THE E-600 SERIES DRAWINGS.
- 4 CONNECT NEW RECEPTACLE TO EXISTING CIRCUIT THAT SERVED RECEPTACLE BEING REMOVED.
- 5 PROVIDE POWER CONNECTION FROM HP-2 ON ROOF.

ROOM LEGEND	
ROOM NO.	ROOM NAME
B-100	GYM
B-101	CORRIDOR
B-112	BOYS
B-113	GIRLS
B-114	OFFICE
B-115	OFFICE
B-116	STORAGE
B-117	MAINTENANCE
B-118	STORAGE
B-119	STORAGE
B-124	STAIR
B-125	VESTIBULE
B-126	CORRIDOR
B-127	STORAGE
B-128	KINDERGARTEN
B-129	STORAGE
B-130	KINDERGARTEN
B-131	STORAGE
B-132	SPECIAL EDUCATION
B-133	VESTIBULE
B-134	STAIRS
B-135	FOYER
B-148	TOILET
B-154	CORRIDOR
B-155	STORAGE
B-156	STAGE
B-157	GENERAL STORAGE
B-158	CORRIDOR
B-159	VESTIBULE

PROJECT
FAIRVIEW
ELEMENTARY
SCHOOL
RENOVATIONS

LOGANSPOrt COMMUNITY
SCHOOL CORPORATION
LOGANSPOrt, INDIANA

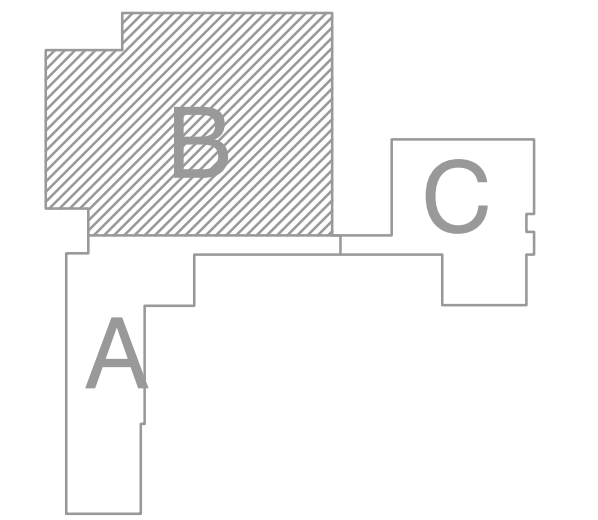

GIBRALTAR DESIGN

9102 N. Meridian St., Ste. 300
Indianapolis, IN 46260
Homepage www.GibraltarDesign.com
Email: info@GibraltarDesign.com
Phone 317.580.5777 Fax 317.580.5778

PROJECT
20-157
DATE
06/18/21
COORDINATED BY
PCB
DRAWN BY
PCB/JVC
CHECKED BY
DJW

PROFESSIONAL ARCHITECT
STATE OF INDIANA
NO. 19600171
DIE J. WAGNER
REGISTERED


COPYRIGHT NOTICE:
THE CONCEPTS, DESIGNS, PLANS, DETAILS, ETC., SHOWN ON THIS DOCUMENT ARE THE PROPERTY OF GIBRALTAR DESIGN AND WERE CREATED FOR USE ON THIS SPECIFIC PROJECT. NONE OF THIS INFORMATION SHALL BE USED BY ANY PERSON OR FIRM FOR ANY PURPOSE WITHOUT THE EXPRESS WRITTEN CONSENT OF GIBRALTAR DESIGN. THE OWNER MAY RETAIN COPIES FOR INFORMATION AND REFERENCE IN CONNECTION ONLY WITH THIS PROJECT.

REVISIONS		
MARK	DATE	ISSUED FOR
AD-1	07/08/21	ADDENDUM NO. 1

DRAWING
UNIT "B" LOWER LEVEL
ELECTRICAL POWER PLAN


PROJECT
FAIRVIEW ELEMENTARY SCHOOL
RENOVATIONS

© GIBRALTAR DESIGN SHEET
E-202

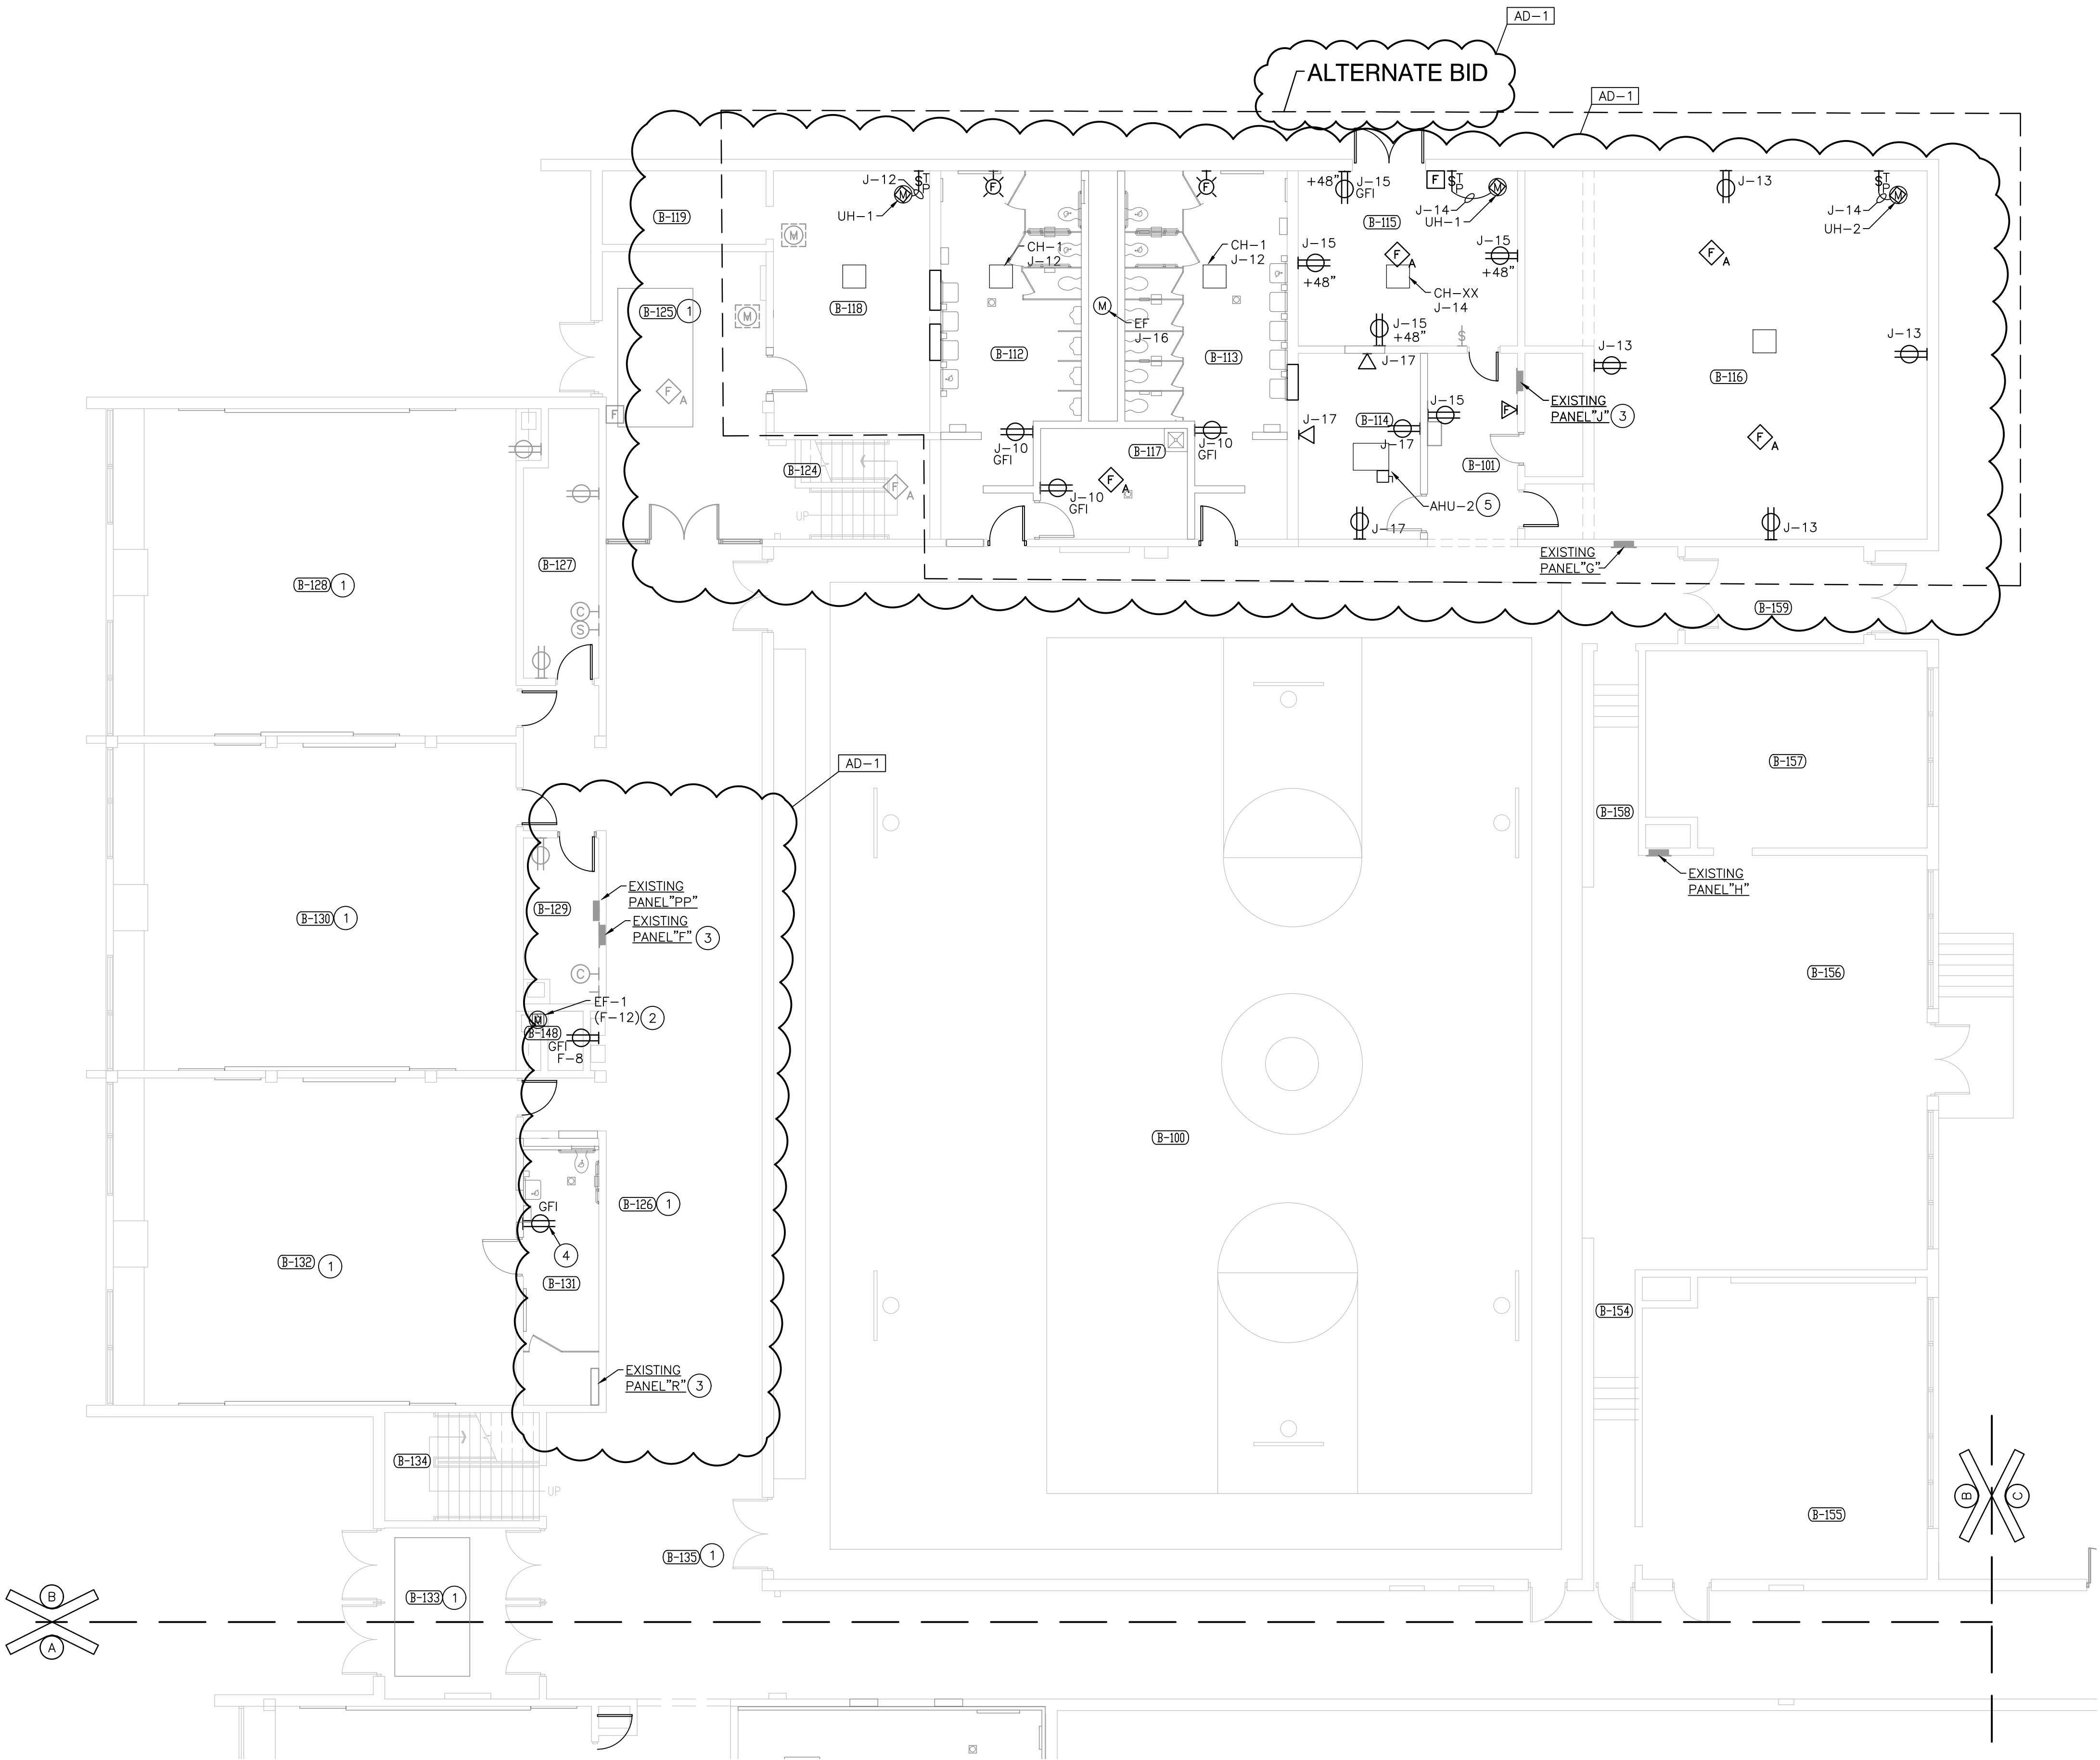

UNIT "B" LOWER LEVEL ELECTRICAL POWER PLAN

SCALE: 1/8" = 1'-0"

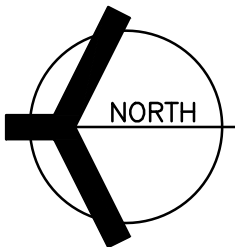

GENERAL NOTES:

1. FOR ADDITIONAL GENERAL ELECTRICAL NOTES, SEE GENERAL ELECTRICAL PROJECT NOTES ON SHEET E-001.
2. PROVIDE ALL OF THE LABOR AND MATERIAL TO PROVIDE THE NECESSARY ROUGH-INS AND RACEWAYS FOR ALL OF THE ACCESS CONTROL, SOUND SYSTEM AND TECHNOLOGY SYSTEMS, DEVICES AND EQUIPMENT. SEE TECHNOLOGY DRAWINGS AND SPECIFICATIONS FOR LOCATIONS OF DEVICES, EQUIPMENT AND REQUIREMENTS.

ELECTRICAL PLAN NOTES:

(THESE NOTES APPLY TO THIS SHEET ONLY)

- 1 REINSTALL EXISTING CEILING MOUNTED DEVICES AND EQUIPMENT IN TO NEW CEILING.
- 2 CONNECT NEW EXHAUST FAN TO OCCUPANCY SENSOR SERVING THIS ROOM WITH CIRCUIT INDICATED.
- 3 MODIFY EXISTING PANELBOARD AS NOTED ON THE PANEL SCHEDULE ON THE E-600 SERIES DRAWINGS.


ROOM LEGEND

ROOM NO.	ROOM NAME
C-201	NOT USED
C-202	OFFICE
C-203	OFFICE
C-204	CORRIDOR
C-205	STORAGE
C-206	CALM
C-207	SPEECH
C-208	CUST. OFFICE
C-209	STORAGE
C-210	NOT USED
C-211	NOT USED
C-212	CLASSROOM
C-213	TOILET
C-214	NOT USED
C-215	CLASSROOM
C-216	TOILET
C-217	MECHANICAL
C-218	TOILET
C-219	CLASSROOM
C-220	TOILET
C-221	CLASSROOM
C-222	TOILET
C-223	NOT USED
C-224	GIRLS
C-225	NOT USED
C-226	BOYS
C-227	KITCHEN
C-228	TOILET
C-229	STORAGE
C-230	CLASSROOM
C-231	TOILET
C-232	TOILET
C-233	STAIRS
C-234	STORAGE
C-235	NOT USED
C-236	CLASSROOM
C-237	CLASSROOM
C-238	CORRIDOR
C-239	STORAGE
C-240	CLASSROOM
C-241	ELEVATOR
C-300	JANITOR

PROJECT

FAIRVIEW
ELEMENTARY
SCHOOL
RENOVATIONS

LOGANSPORT COMMUNITY
SCHOOL CORPORATION
LOGANSPORT, INDIANA

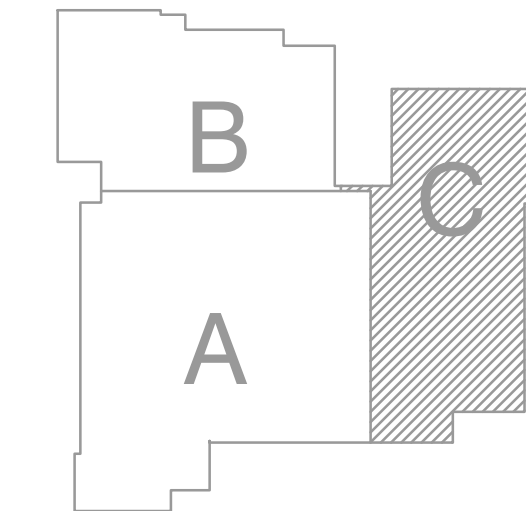

GIBALTAR DESIGN

9102 N. Meridian St., Ste. 300
Indianapolis, IN 46260
Homepage www.GibraltarDesign.com
Email info@GibraltarDesign.com
Phone 317.580.5777 Fax 317.580.5778

PROJECT

20-157

DATE

06/18/21

COORDINATED BY

PCB

DRAWN BY

PCB/JVC

CHECKED BY

DJW

COPYRIGHT NOTICE:
THE CONCEPTS, DESIGNS, PLANS, DETAILS, ETC., SHOWN ON THIS DOCUMENT ARE THE PROPERTY OF GIBALTAR DESIGN AND WERE CREATED FOR USE ON THIS SPECIFIC PROJECT. NONE OF THIS INFORMATION SHALL BE USED BY ANY PERSON OR FIRM FOR ANY PURPOSE WITHOUT THE EXPRESS WRITTEN CONSENT OF GIBALTAR DESIGN. THE OWNER MAY RETAIN COPIES FOR INFORMATION AND REFERENCE IN CONNECTION ONLY WITH THIS PROJECT.

REVISIONS

MARK	DATE	ISSUED FOR
AD-1	07/08/21	ADDENDUM NO. 1

DRAWING

UNIT "C" FIRST FLOOR
ELECTRICAL POWER PLAN

PROJECT

FAIRVIEW ELEMENTARY SCHOOL
RENOVATIONS


© GIBALTAR DESIGN

SHEET

E-206

UNIT "C" FIRST FLOOR ELECTRICAL POWER PLAN

SCALE: 1/8" = 1'-0"

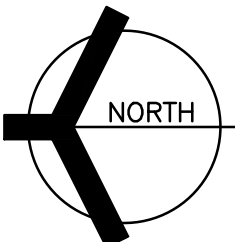

FAIRVIEW ELEMENTARY SCHOOL PANELBOARD SCHEDULE																	
MARK & TYPE				REMARKS													
"FL" - SECTION 1 OF 2				TWO SECTION PANEL - BOTH SECTIONS SAME HEIGHT													
"TYPE" - D NO OR APPROVED EQUAL				BRANCH CIRCUITS SHALL BE CIRCUIT BREAKERS.													
120/200V, 3 PH, 4W				CIRCUIT BREAKERS SHALL HAVE MINIMUM 22,000 AMP INTERRUPTING CAPACITY - TYPE COB-BH													
400 AMP MAIN LUGS																	
NEHA 1																	
SURFACE MOUNTED																	
DESCRIPTION	CIR	POLE	TRIP	LTS	REC	EQUIP	A	B	C	HEAT	A/C	FUTR	POLE	TRIP	CR	DESCRIPTION	
SECTION 1	1	1	20														
180 LIGHTS	3	1	20											1	20	2	A-251 LIGHTS
257,268,273,274 LIGHTS	5	1	20											1	20	4	A-253,261 LIGHTS
264,266,269,271 LIGHTS	7	1	20											1	20	6	A-260,265 LIGHTS
359 LIGHTS	9	1	20											1	20	8	A-277 LIGHTS
SPARE	11	1	20											1	20	10	CANOPY LIGHTS (RA-2)
																12	SPARE
A-261,267,268,269 RECPS	13	1	20	0.54			0.54									14	A-251 RECPS
A-266 RECPS	15	1	20	0.54			0.54		0.54							16	A-251 RECPS
A-264 RECPS	17	1	20	0.36			0.36		0.36							18	A-251 RECPS
A-264 RECPS	19	1	20	0.54			0.54		0.54							20	A-253 RECPS (REFRIGERATOR)
A-273,274 RECPS	21	1	20	0.36			1.50		0.36							22	A-253 RECPS
A-262 RECPS	23	1	20	0.72			0.90		0.36							24	A-253 RECPS
A-259 RECPS	25	1	20	1.50			1.50		0.90							26	A-253 RECPS
A-260 RECPS	27	1	20	1.50			1.50		1.50							28	A-252 RECPS
A-265 RECPS	29	1	20	1.50			1.50		1.50							30	A-262 RECIP (COOPER)
TIMECLOCK AND RELAY RA-1 AND RA-2 CONTROL	31	1	20			1.00	1.00										
SPARE	33	1	20											1	20	32	SPARE
SPARE	35	1	20													34	SPARE
SPARE	37	1	20													36	FPB-VA/V VAV
SPARE	39	1	20													38	FPB-VA/V
SPARE	41	1	20													40	FPB-VA/V
																42	SPARE
TOTAL CONNECTED LOAD (kVA)				4.00	20.40	1.00	8.74	8.60	8.06								
TOTAL DEMAND LOAD (kVA)				4.00	15.20	1.00											

FAIRVIEW ELEMENTARY SCHOOL PANELBOARD SCHEDULE																
MARK & TYPE			REMARKS													
"TL1" - SECTION 2 OF 2 TYPE: SQ D NO OR APPROVED EQUAL 120/208V, 3 PH, 4W 400 AMP MAIN LUGS NEMA 1 SURFACE MOUNTED			TWO SECTION PANEL - BOTH SECTIONS SAME HEIGHT. BRANCH CIRCUITS SHALL BE CIRCUIT BREAKERS. CIRCUIT BREAKERS SHALL HAVE MINIMUM 22,500 AMP INTERRUPTING CAPACITY - TYPE QOB-BH.													
DESCRIPTION	CIR	POLE	TRIP	LTS	REC	EQUIP	A	B	C	HEAT	A/C	FURR	POLE	TRIP	CHR	DESCRIPTION
SPARE	43	1	20											1	20	44 SPARE
SPARE	45	1	20											1	20	46 SPARE
SPARE	47	1	20											1	20	48 SPARE
SPARE	49	1	20											1	20	50 SPARE
SPARE	51	1	20											1	20	52 SPARE
SPARE	53	1	20											1	20	54 SPARE
SPARE	55	1	20											1	20	56 SPARE
SPARE	57	1	20											1	20	58 SPARE
SPARE	59	1	20											1	20	60 SPARE
SPARE	61	1	20											1	20	62 SPARE
SPARE	63	1	20											1	20	64 SPARE
SPARE	65	1	20											1	20	66 SPARE
SPARE	67	1	20											1	20	68 SPARE
SPARE	69	1	20											1	20	70 SPARE
SPARE	71	1	20											1	20	72 SPARE
SPARE	73	1	20											1	20	74 SPARE
SPARE	75	1	20											1	20	76 SPARE
SPARE	77	1	20	2.00				2.00						2	30	78 PARKING LOT LIGHT (RELAY RA-1)
PANEL "LL2"	79	3	100	2.00	1.80		1.80		2.00							79 RTU-A1
	81	/	/		1.98			1.98						3	125	80
	83	/	/		0.54				0.54					/	/	82
		/	/											/	/	84

[illegible][illegible][illegible][illegible]

FAIRVIEW ELEMENTARY SCHOOL LIGHTING FIXTURE SCHEDULE									
TYPE	MANUFACTURERS	VOLTAGE	LIGHT SOURCE	LUMENS	DEGREE K.	WATTAGE	DIMMING	MOUNTING	DESCRIPTION
L-1	METALUX 146R-LD5-40-A125-UNV-L840-CD1-PAF-EQ-CLIP-U COLUMBIA LT174-40MWG-FSA12125-UE-PAF-EQCLIP-EL145D LITHONIA GTL-4-40L-A12125-EZ1-IP840-LATC-PAF-EL145D	120/277	LED	4000 (4045/ 4222/ 3938.5)	4000	38.8/38/ 40.1	NONE	GRID	1X4 RECESSED GRID MOUNTED LED LENS TROFFER TYPE LIGHTING FIXTURE WITH EARTHQUAKE CLIPS, ACRYLIC LENS (0.125 MINIMUM THICKNESS) AND MULTI-VOLT LED DRIVER.
L-1E	METALUX 146R-LD5-40-A125-UNV-L840-CD1-PAF-EQ-CLIP-U-EL14WSD COLUMBIA LT174-40MWG-FSA12125-UE-PAF-EQCLIP-EL145D LITHONIA GTL-4-33L-A12125-EZ1-IP840-LATC-PAF-EL145D	120/277	LED	4000 (4045/ 4222/ 3938.5)	4000	38.8/38/ 40.1	NONE	GRID	1X4 RECESSED GRID MOUNTED LED LENS TROFFER TYPE LIGHTING FIXTURE WITH EARTHQUAKE CLIPS, ACRYLIC LENS (0.125 MINIMUM THICKNESS), MULTI-VOLT LED DRIVER AND INTEGRAL EMERGENCY BATTERY UNIT WITH SELF-DIAGNOSTIC FEATURE.
L-2	METALUX SB24CZ-LD5-30S-UNV-L840-CD1-EQ-CLIP-PAF COLUMBIA LCAT24-40VWG-ED1-U-EQCLIP-PAF LITHONIA 2BLTBAA-30L-ADP-EZ1-IP840-EQCLIP-PAF-EL145D	120/277	LED	3000 (3132/ 3267/3009/ XXXX)	4000	21.6/28/ 23.26/XX	0-10V 1% DIMMING	GRID	2X4 RECESSED GRID MOUNTED DIRECT/INDIRECT LED TYPE LIGHTING FIXTURE WITH EARTHQUAKE CLIPS AND MULTI-VOLT LED DIMMING DRIVER. FIXTURE SHALL BE PROVIDED WITH BOTTOM ACCESS.
L-2E	METALUX SB24CZ-LD5-30S-UNV-L840-CD1-EQ-CLIP-PAF-EL14WSD COLUMBIA LCAT24-40VWG-ED1-U-EQCLIP-PAF-EL145D LITHONIA 2BLTBAA-30L-ADP-EZ1-IP840-EQCLIP-PAF-EL145D	120/277	LED	3000 (3132/ 3267/3009/ XXXX)	4000	21.6/28/ 23.26/XX	0-10V 1% DIMMING	GRID	2X4 RECESSED GRID MOUNTED DIRECT/INDIRECT LED TYPE LIGHTING FIXTURE WITH EARTHQUAKE CLIPS, ACRYLIC LENS (0.125 MINIMUM THICKNESS), MULTI-VOLT LED DIMMING DRIVER AND INTEGRAL EMERGENCY BATTERY UNIT WITH SELF-DIAGNOSTIC FEATURE. FIXTURE SHALL BE PROVIDED WITH BOTTOM ACCESS.
L-3	METALUX SB24CZ-LD5-50S-UNV-L840-CD1-EQ-CLIP-PAF COLUMBIA LCAT24-40MLG-ED1-U-EQCLIP-PAF LITHONIA 2BLT4BA-48L-ADP-EZ1-IP840-EQCLIP-PAF-EL145D	120/277	LED	4800 (5190/ 4990/ 4971.99)	4000	40.7/39/ 38	0-10V 1% DIMMING	GRID	2X4 RECESSED GRID MOUNTED DIRECT/INDIRECT LED TYPE LIGHTING FIXTURE WITH EARTHQUAKE CLIPS AND MULTI-VOLT LED DIMMING DRIVER. FIXTURE SHALL BE PROVIDED WITH BOTTOM ACCESS.
L-3E	METALUX SB24CZ-LD5-50S-UNV-L840-CD1-EQ-CLIP-PAF-EL14WSD COLUMBIA LCAT24-40MLG-ED1-U-EQCLIP-PAF-EL145D LITHONIA 2BLTBAA-48L-ADP-EZ1-IP840-EQCLIP-PAF-EL145D	120/277	LED	4800 (5190/ 4990/ 4971.99)	4000	40.7/39/ 38/XX	0-10V 1% DIMMING	GRID	2X4 RECESSED GRID MOUNTED DIRECT/DIRECT LED TYPE LIGHTING FIXTURE WITH EARTHQUAKE CLIPS, ACRYLIC LENS (0.125 MINIMUM THICKNESS), MULTI-VOLT LED DIMMING DRIVER AND INTEGRAL EMERGENCY BATTERY UNIT WITH SELF-DIAGNOSTIC FEATURE. FIXTURE SHALL BE PROVIDED WITH BOTTOM ACCESS.
L-4	METALUX SB24CZ-LD5-60S-UNV-L840-CD1-EQ-CLIP-PAF COLUMBIA LCAT24-40VLG-ED1-U-EQCLIP-PAF LITHONIA 2BLTBAA-60L-ADP-EZ1-IP840-EQCLIP-PAF-EL145D	120/277	LED	6000 (6221/7321/ 76112)	4000	52.2/59/ 47.59	0-10V 1% DIMMING	GRID	2X4 RECESSED GRID MOUNTED DIRECT/INDIRECT LED TYPE LIGHTING FIXTURE WITH EARTHQUAKE CLIPS AND MULTI-VOLT LED DIMMING DRIVER. FIXTURE SHALL BE PROVIDED WITH BOTTOM ACCESS.
L-4E	METALUX SB24CZ-LD5-60S-UNV-L840-CD1-EQ-CLIP-PAF-EL14WSD COLUMBIA LCAT24-40VLG-ED1-U-EQCLIP-PAF-EL145D LITHONIA 2BLTBAA-60L-ADP-EZ1-IP840-EQCLIP-PAF-EL145D	120/277	LED	6000 (6221/7321/ 76112)	4000	52.2/44/ 47.59	0-10V	GRID	2X4 RECESSED GRID MOUNTED DIRECT/INDIRECT LED TYPE LIGHTING FIXTURE WITH EARTHQUAKE CLIPS, ACRYLIC LENS (0.125 MINIMUM THICKNESS), MULTI-VOLT LED DRIVER AND INTEGRAL EMERGENCY BATTERY UNIT WITH SELF-DIAGNOSTIC FEATURE. FIXTURE SHALL BE PROVIDED WITH BOTTOM ACCESS.
L-5	METALUX 22CZ-LD5-44S-UNV-L840-CD1-EQ-CLIP-PAF COLUMBIA LCAT22-40VLG-ED1-U-EQCLIP-PAF LITHONIA 2BLTBAA-40L-ADP-EZ1-IP840-EQCLIP-PAF-EL145D	120/277	LED	4000 (4091/4466/ 4102)	4000	36.4/39/ 31	0-10V	GRID	2X2 RECESSED GRID MOUNTED DIRECT/INDIRECT LED TYPE LIGHTING FIXTURE WITH EARTHQUAKE CLIPS AND MULTI-VOLT LED DIMMING DRIVER.
L-5E	METALUX 22CZ-LD5-44S-UNV-L840-CD1-EQ-CLIP-PAF COLUMBIA LCAT22-40VLG-ED1-U-EQCLIP-PAF LITHONIA 2BLTBAA-40L-ADP-EZ1-IP840-EQCLIP-PAF-EL145D	120/277	LED	4000 (4091/4466/ 4102)	4000	36.4/39/ 31	0-10V	GRID	2X2 RECESSED GRID MOUNTED DIRECT/INDIRECT LED TYPE LIGHTING FIXTURE WITH EARTHQUAKE CLIPS AND MULTI-VOLT LED DIMMING DRIVER.
L-6	METALUX 246R-LD5-40-A125-CD1-PAF-EQ-CLIP-U-PAF COLUMBIA LT174-40LWG-FSA12125-UE-EQCLIP-PAF LITHONIA 2GTL-4-40L-A12125-EZ1-IP840-EQCLIP-PAF-EL145D	120/277	LED	4000 (4294/ 4334/4505)	4000	34.6/34/ 30.8	0-10V 1% DIMMING	GRID	2X4 RECESSED GRID MOUNTED LED LENS TROFFER TYPE LIGHTING FIXTURE WITH EARTHQUAKE CLIPS, ACRYLIC LENS (0.125 MINIMUM THICKNESS) AND MULTI-VOLT LED DIMMING DRIVER.
L-6E	METALUX 146R-LD5-40-A125-UNV-L840-CD1-PAF-EQ-CLIP-U-EL14WSD COLUMBIA LT174-40LWG-FSA12125-UE-PAF-EQCLIP-EL145D LITHONIA GTL-4-40L-A12125-EZ1-IP840-LATC-PAF-EL145D	120/277	LED	4000 (4294/ 4334/4505)	4000	34.6/34/ 30.8	0-10V 1% DIMMING	GRID	2X4 RECESSED GRID MOUNTED LED LENS TROFFER TYPE LIGHTING FIXTURE WITH EARTHQUAKE CLIPS, ACRYLIC LENS (0.125 MINIMUM THICKNESS), MULTI-VOLT LED DIMMING DRIVER AND INTEGRAL EMERGENCY BATTERY UNIT WITH SELF-DIAGNOSTIC FEATURE.
L-7	METALUX SB24CZ-LD5-30S-UNV-L840-CD1-PAF-EQ-CLIP-U-PAF COLUMBIA LCAT24-40VWG-ED1-U-PAF LITHONIA 2BLTBAA-30L-ADP-EZ1-IP840-PAF	120/277	LED	3000 (3132/ 3267/3009/ XXXX)	4000	21.6/28/ 23.26/XX	0-10V 1% DIMMING	DRYWALL GYP BOARD	2X4 RECESSED MOUNTED FLANGED DIRECT/INDIRECT LED TYPE LIGHTING FIXTURE WITH DRYWALL MOUNTING KIT AND MULTI-VOLT LED DIMMING DRIVER. FIXTURE SHALL BE PROVIDED WITH BOTTOM ACCESS.
L-8	METALUX 22CZ-LD5-44S-UNV-L840-CD1-2F-22W-U-PAF LCA122-40VLG-ED1-U-FK22-PAF LITHONIA 2BLTBAA-24L-ADP-EZ1-IP840-DGA22-PAF	120/277	LED	4000 (4091/4466/ 4102)	4000	36.4/39/ 31	0-10V	DRYWALL GYP BOARD	2X2 RECESSED MOUNTED FLANGEDIRECT/INDIRECT LED TYPE LIGHTING FIXTURE WITH MULTI-VOLT LED DIMMING DRIVER.
L-9	METALUX SXLN-LD1-28-LW COLUMBIA MP54-40HL-CW-EDU-CSHC LITHONIA ZL1D-148-5000LM-FST-MVOLT-40K-80CRI	120/277	LED	2800	33	NONE	SURFACE	4	SURFACE MOUNTED INDUSTRIAL LIGHTING FIXTURE WITH LENSED AND WIDE DISTRIBUTION
L-10E	HALO PD6-30-D010-PD6MA-840-61V-C-EM COLUMBIA LDN6-40-30-106AR-L5S-MVOLT-E210-ELRSD PRESCOLITE LTR-6RD-H-ML-30L-DM1/LTR-6RD-MX-80W-8-80-BSLT-CBST	120/277	LED	2963/ 2033.9	4000	36.4/34.69	0-10V	RECESSED	6" ROUND RECESSED MOUNTED DOWNLIGHT WITH CLEAR ALZAK REFLECTOR, MULTI-VOLT LED DIMMING DRIVER AND INTEGRAL BATTERY UNIT WITH SELF-DIAGNOSTIC FEATURE. UL LISTED FOR DAMP LOCATIONS.
L-11	LUMENWERX VIA3R-HLO-LED-90-750-40-4FT-UNV-D-1-DTR-W PINELITE HP4-R-D-4" TL1750LM/FT-840-F-96LG-120-SC-10%-CL-FE-SW (7 WATTS A FOOT) PINNACLE ARCHITECTURAL LIGHTING EV3D-A-840-4G-U-OL2-1-W	120/277	LED	750/FT	4000	9.9/FT	0-10V	GRID	3" X 6" RECESSED FLANGED MOUNTED LINEAR LIGHTING FIXTURE WITH FROSTED WHITE LENS.
L-12	LUMENWERX VIA3R-HLO-LED-90-1000-40-4FT-UNV-D1-1-TB-W PINELITE HP4-R-D-4" TL1000LM/FT-840-F-96LG-120-SC-10%-CL-FE-SW (10 WATTS A FOOT) PINNACLE ARCHITECTURAL LIGHTING EV3D-A-840-4G-U-OL2-1-W	120/277	LED	1000/FT	4000	9.9/FT	0-10V	GRID	3" X 4" RECESSED GRID MOUNTED LINEAR LIGHTING FIXTURE WITH FROSTED WHITE LENS.
L-12E	LUMENWERX VIA3R-HLO-LED-90-1000-40-4FT-UNV-D1-1EB-TB-W PINELITE HP4-R-D-4" TL1000LM/FT-840-F-96LG-120-SC-10%-CL-FE-SW (10 WATTS A FOOT)-SM PINNACLE ARCHITECTURAL LIGHTING EV3D-A-840-4G-U-OL2-1-W-EM	120/277	LED	1000/FT	4000	9.9/FT	0-10V	GRID	3" X 4" RECESSED GRID MOUNTED LINEAR LIGHTING FIXTURE WITH FROSTED WHITE LENS. PROVIDE WITH INTEGRAL EMERGENCY BATTERY UNIT WITH NI-CAD BATTERY.
L-13E	METALUX 43WLED-LD4-36SL-LW-UNV-L840-HCD1-SXP01-U COLUMBIA ESL-4-40-HLM-FAW-EDU-ELL14-NXOS LITHONIA WL4-40L-EZ1-IP840-MSD7	120/277	LED	5322	4000	42	NONE	WALL	4" WALL MOUNTED LIGHTING FIXTURE WITH 0-10 VOLT NON-DIMMING DRIVER, INTEGRAL OCCUPANCY SENSOR AND INTEGRAL BATTERY UNIT WITH SELF-DIAGNOSTIC UNIT. FIXTURE SHALL BE ILLUMINATED AT 50 PERCENT AT ALL TIMES AND INCREASE TO 100 PERCENT WHEN IT SENSES OCCUPANCY. (STAIRS)
S-1	LUMARK PRV-PA28-740-U-T4W-HSS-CBA LITHONIA DSX1-LED-P4-50K-T4M-MVOLT-RPA-HS-CBA HUBBELL VPL-80L-180-4K7-4F-UNV-AD3-BC-CBA/RTS-8-25-A-1-XXX	UNIV (120/277)	LED	19431/ 14182/ 26575	4000	151/125/ 235	NONE	POLE MOUNTED	POLE ARM MOUNTED LED SITE LIGHTING FIXTURE WITH TYPE IV LIGHT DISTRIBUTION WITH HOUSE SIDE SHIELD MOUNTED ON A 25" -0" ROUND TAPERED STEEL POLE. COLOR AND FINISH TO BE SELECTED BY THE ARCHITECT.
X-1	SURE-LITES CX7IG-SD DUAL LITE SESG-BN-E-I LITHONIA LES1G-ELN-SD	120/277	LED			1	NONE	SURFACE	SURFACE MOUNTED DIE CAST ALUMINUM EXIT SIGN WITH SINGLE STENCIL FACE, GREEN LETTERS (ARROWS AS INDICATED ON DRAWINGS), NI-CAD BATTERY AND SELF-DIAGNOSTICS FEATURE.
X-2	SURE-LITES CX7ZG-SD DUAL LITE SEDG-BN-E-I LITHONIA LES2G-ELN-SD	120/277	LED			1	NONE	SURFACE	SURFACE MOUNTED DIE CAST ALUMINUM EXIT SIGN WITH DOUBLE STENCIL FACE, GREEN LETTERS (ARROWS AS INDICATED ON DRAWINGS), NI-CAD BATTERY AND SELF-DIAGNOSTICS FEATURE.

RELAY SCHEDULE									
MARK & TYPE	ITEM	CONTROLLED CIRCUIT(S)	COIL CTK.	COIL VOLT	ROOM NO	CONTACTS	SELECTOR SWITCH	CONTROL	SEE NOTES
RA-1-ASCO #31822031C	CANOPY LIGHTS	11L-10	11L-31	120	A-269	N.O.	HOA	TIMECLOCK	1,2,4,5,6,7,8
RA-2-ASCO #31822031C	PARKING LOT LIGHTS	11L-76,78	11L-31	120	A-269	N.O.	HOA	TIMECLOCK	1,2,4,5,6,7,8

NOTES:

1. FURNISH NEMA 1 ENCLOSURE WITH HINGED COVER UNLESS OTHERWISE NOTED.
2. ELECTRICALLY HELD.
3. MECHANICALLY HELD.
4. PROVIDE SELECTOR SWITCH IN RELAY ENCLOSURES WITH LOOP AND BRIDLE STRAPS FROM MAIN DEPARTMENT TO HINGED COVER FOR SELECTOR SWITCH.
5. FURNISH FUSE PROTECTION FOR COIL CIRCUIT.
6. ACCESSORY 47 TWO WIRE CONTROLS.
7. ALL RELAYS AND SELECTOR SWITCHES SHALL BE PREPARED BY MANUFACTURER.
8. PROVIDE RELAYS RA-1 AND RA-2 IN SINGLE 5641 ENCLOSURE.



GIBRALTAR
DESIGN
ARCHITECTURE • ENGINEERING • INTERIOR DESIGN

PROJECT
FAIRVIEW
ELEMENTARY
SCHOOL
RENOVATIONS

LOGANSPOUT COMMUNITY
SCHOOL CORPORATION
LOGANSPOUT, INDIANA

GIBRALTAR DESIGN

9102 N. Meridian St., Ste. 300
Indianapolis, IN 46260
Homepage www.GibraltarDesign.com
Email info@GibraltarDesign.com
Phone 317.580.5777 Fax 317.580.5778

PROJECT	
00-157	

PROJECT	00-153
---------	--------

20-157
DATE
06/18/21

COORDINATED
RCR

DRAWN BY
RDB/11/02

PCB/JVC
CHECKED BY
D. J. W.

COPYRIGHT NOTICE:

REVISIONS		
MARK	DATE	ISSUED FOR
AD-1	07/08/21	ADDENDUM NO. 1

DRAWING
ELECTRICAL SCHEDULES

ELECTRICAL SCHEDULES


PROJECT
FAIRVIEW ELEMENTARY SCHOOL

RENOVATIONS	

© GIBALTAR DESIGN SHEET 5 OF 1

E-601

--	--

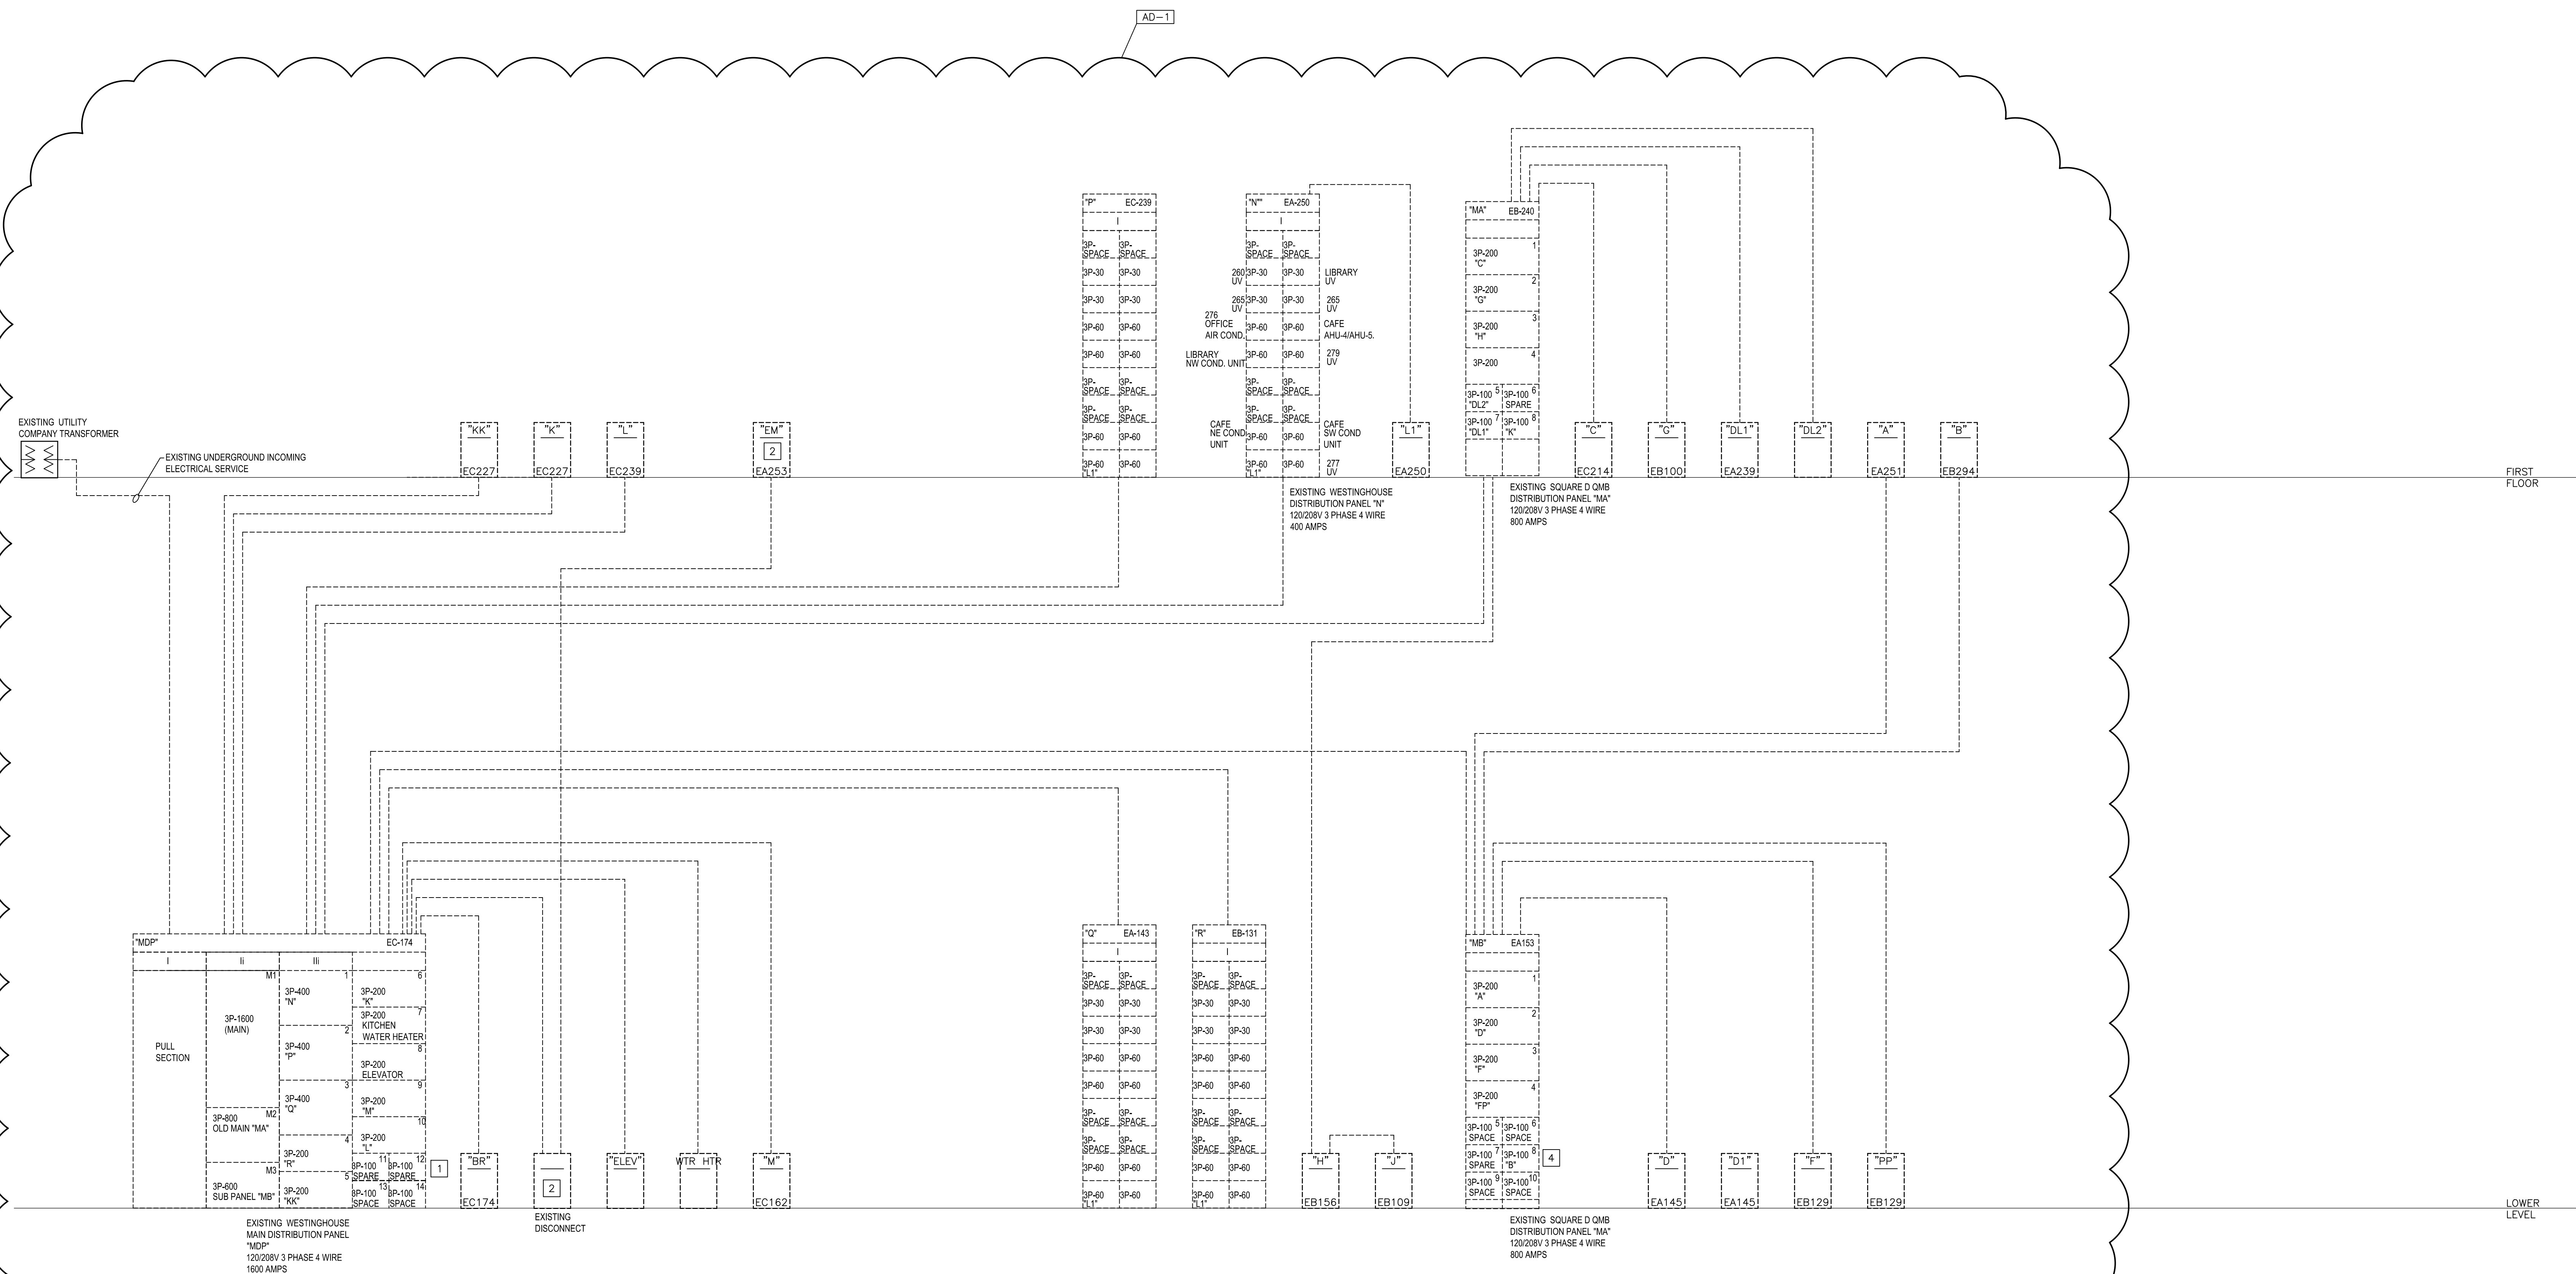

EXISTING PARTIAL ELECTRICAL POWER DISTRIBUTION DIAGRAM

SCALE: NOT TO SCALE

----- EXISTING TO REMAIN UNLESS OTHERWISE NOTED.

_____ NEW

ELECTRICAL DEMOLITION PLAN NOTES:

- 1 PROVIDE ALL LABOR AND MATERIAL TO MODIFY EXISTING MAIN DISTRIBUTION PANELBOARD AND PROVIDE NEW 3P-400 AMP FUSIBLE SWITCH TO SERVE NEW PANEL "1L1".
- 2 REMOVE EXISTING PANEL "EM" AND REMOVE ASSOCIATED FEEDER CONDUIT AND WIRE BACK TO THE SOURCE (DISCONNECT), UNLESS OTHERWISE NOTED. INTERCEPT EXISTING BRANCH CIRCUIT SERVING LIGHTS, WIRING DEVICES, EQUIPMENT, ETC. THAT IS TO REMAIN AND EXTEND TO NEW PANEL "EM". PREPARE DISCONNECT FOR NEW CONDUIT AND WIRE TO THE NEW PANEL "EM".
- 3 REMOVE EXISTING PANEL "B" AND REMOVE ASSOCIATED FEEDER CONDUIT AND WIRE BACK TO THE SOURCE, UNLESS OTHERWISE NOTED. INTERCEPT EXISTING BRANCH CIRCUITS SERVING LIGHTS, WIRING DEVICES, EQUIPMENT, ETC. THAT IS TO REMAIN AND EXTEND TO NEW PANEL "B".
- 4 REPLACE THE EXISTING FUSES IN EXISTING 3P-100 AMP FUSIBLE SWITCH (CIRCUIT B) IN EXISTING DISTRIBUTION PANEL "MA" SERVING EXISTING PANEL "B" WITH NEW 100 AMP FUSES TO SERVE NEW PANEL "B".



GIBRALTAR
DESIGN
ARCHITECTURE • ENGINEERING • INTERIOR DESIGN

PROJECT
**FAIRVIEW
ELEMENTARY
SCHOOL
RENOVATIONS**

LOGANSPORT COMMUNITY
SCHOOL CORPORATION
LOGANSPORT, INDIANA

GIBRALTAR DESIGN
9102 N. Meridian St., Ste. 300
Indianapolis, IN 46260
Homepage www.GibraltarDesign.com
Email info@GibraltarDesign.com
Phone 317.580.5777 Fax 317.580.5778

PROJECT 20-157	
DATE 06/18/21	
COORDINATED BY PCB	
DRAWN BY PCB/JVC	
CHECKED BY DJW	

COPYRIGHT NOTICE:
THE CONCEPTS, DESIGNS, PLANS, DETAILS, ETC, SHOWN ON THIS DOCUMENT ARE THE PROPERTY OF GIBRALTAR DESIGN AND WERE CREATED FOR USE ON THIS SPECIFIC PROJECT. NONE OF THIS INFORMATION SHALL BE USED BY ANY PERSON OR FIRM FOR ANY PURPOSE WITHOUT THE EXPRESS WRITTEN CONSENT OF GIBRALTAR DESIGN. THE OWNER MAY RETAIN COPIES FOR INFORMATION AND REFERENCE IN CONNECTION ONLY WITH THIS

[illegible]

DRAWING

ELECTRICAL POWER
DISTRIBUTION DIAGRAM

PROJECT
FAIRVIEW ELEMENTARY SCHOOL
RENOVATIONS

© GIBRALTAR DESIGN
SHEET
E-701

