


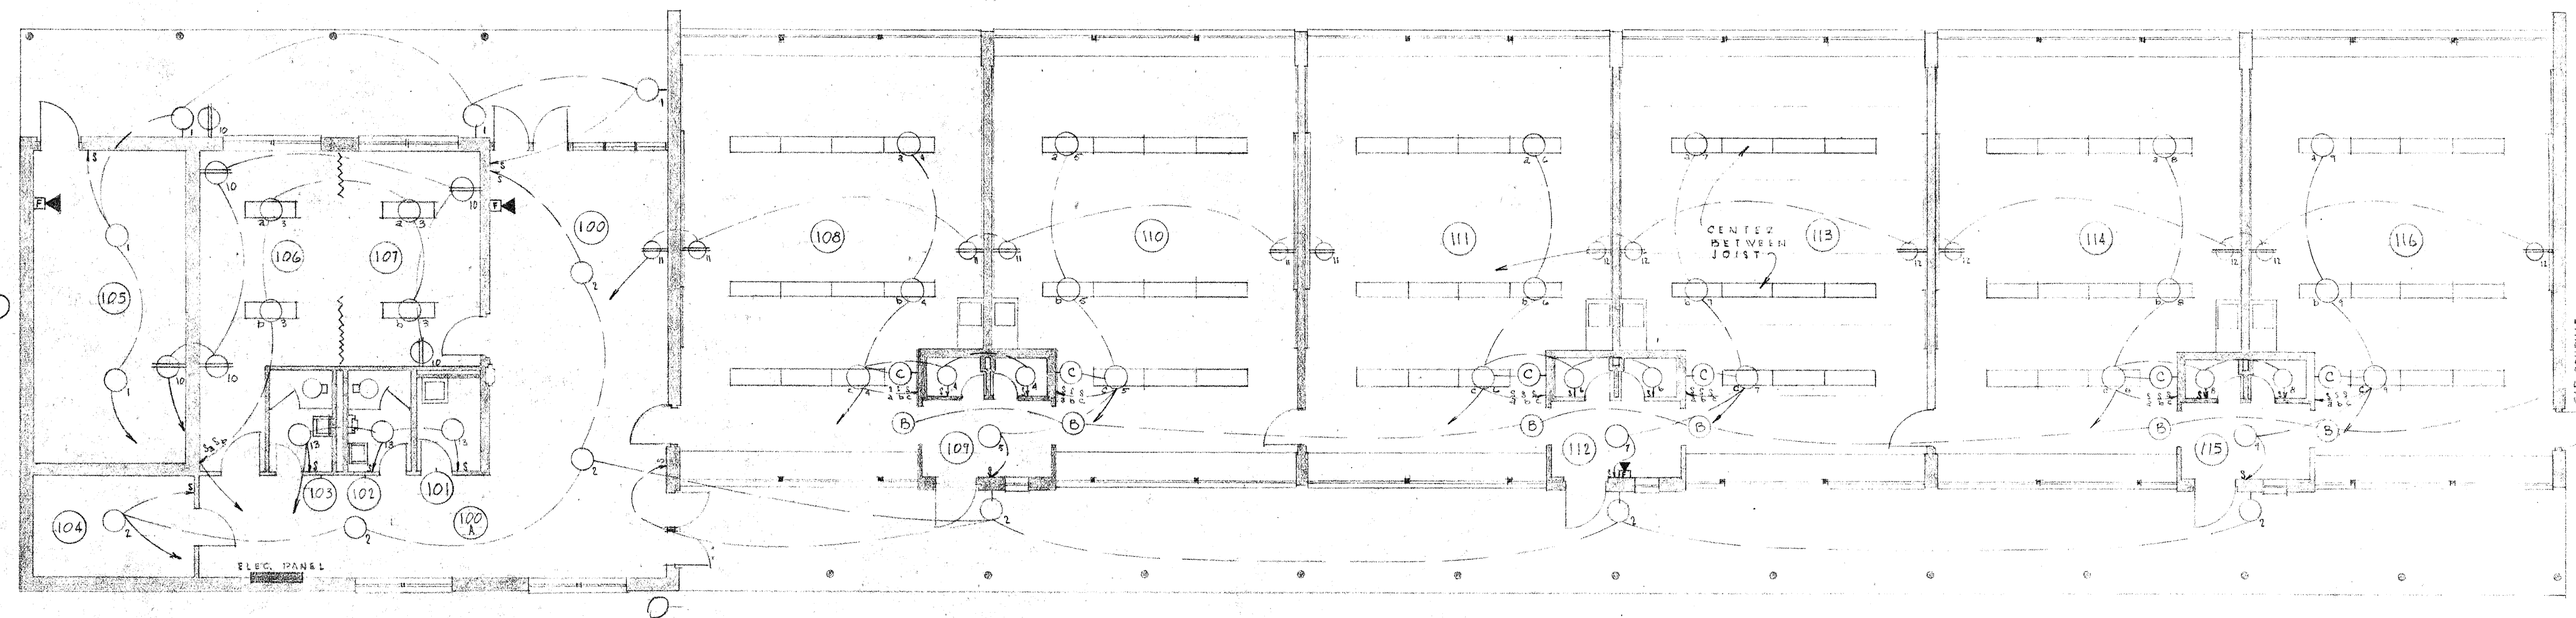

ELECTRICAL PLAN #SCHEDULES		
STAPERT-PRATT-BULTHUIS & SPRAU INC. 474 ACADEMY STREET - KALAMAZOO MICHIGAN - PH. 5-2145		
A R C H I T E C T S		
ELEMENTARY SCHOOL SCHOOL DISTRICT NO. 12 FRACTIONAL OSHTemo, MICHIGAN		
DRAWN BY A.J.W.	DATE OCT. 23, 1958	SHEET NO. E-1
REV.	NO.	
REV.	53-8	

INDEX OF DRAWINGS

- 1 SITE PLAN
- 2 FOUNDATION & FIRST FLOOR PLANS
- 3 ELEVATIONS & DETAILS
- 4 INTERIOR ELEVATIONS & DETAILS
- M1 PLUMBING, HEATING & VENTILATING PLAN
- E1 ELECTRICAL PLAN & SCHEDULE

ABBREVIATIONS



AC.T.	ACOUSTICAL TILE
A.T.	ASPHALT TILE
ADJ.	ADJUSTABLE
ALUM.	ALUMINUM
B.B.	BULLETIN BOARD
BL.	BLOCK
CAB.	CABINET
C.E.M.	CEMENT
CH.BD.	CHALK BOARD
C.BL.	CINDER BLOCK
COL.	COLUMN
CONC.	CONCRETE
C.T.	CERAMIC TILE
DET.	DETAIL
D.F.	DRINKING FOUNTAIN
D.S.	DOWNSPOUT
D.S.B.	DOUBLE STRENGTH "B" QUALITY
E.	ENAMEL
E.F.	EXHAUST FAN
ELEM.	ELEMENTARY
ELEV. - EL.	ELEVATION
E.P.	ELECTRICAL PANEL
EXP.	EXPOSED CONSTRUCTION
F.A.	FIRE ALARM
F.B.	FIRE BRICK
F.D.	FLOOR DRAIN
F.E.	FIRE EXTINGUISHER
GR.	GRILLS
GRD.	GROUND
H.&V.	HORIZONTAL & VERTICAL
HGT.	HEIGHT
H.W.	HARDWARE SET
I.D.	INSIDE DIAMETER
INSUL.	INSULATION
MAT.	MATERIAL
MECH. CONTR.	MECHANICAL CONTRACTOR
MET.	METAL
M.L.D.	MOLDING
N.I.C.	NOT IN CONTRACT
NO.	NUMBER
O.C.	ON CENTER
P.	PAINT
PL.	PLATE
PLYVD.	PLYWOOD
R.	RUBBER
R.D.	ROOF DRAIN
R.M.	ROOM
SH.	SHEET
T.	TOILET
T.B.	TACK BOARD
T.C.	TEACHER'S CLOSET
VENT.	VENTILATOR
W.	WITH
W.D.	WOOD
W.W.M.	WELODED WIRE MESH

MATERIAL INDICATIONS


[Pattern]	FACE BRICK
[Pattern]	CONCRETE
[Pattern]	CINDER BLOCK
[Pattern]	FINISHED WOOD
[Pattern]	ROUGH WOOD
[Pattern]	STRUCTURAL STEEL
[Pattern]	INSULATION
[Pattern]	STONE
[Pattern]	CERAMIC TILE

SYMBOLS


[Symbol]	EXISTING CONTOURS TO REMAIN
[Symbol]	EXISTING CONTOURS TO BE CHANGED
[Symbol]	NEW CONTOURS TO BE ESTABLISHED
[Symbol]	UTILITIES, WIRED (OVERHEAD)
[Symbol]	UTILITIES, (UNDERGROUND)
[Symbol]	GRAVEL SURFACE
[Symbol]	PROPERTY LINE
[Symbol]	EXISTING ELEVATIONS
[Symbol]	NEW ELEVATIONS TO BE ESTABLISHED
[Symbol]	DETAIL NUMBER
[Symbol]	SHEET NUMBER
[Symbol]	DOOR MARK
[Symbol]	FRAME TYPE

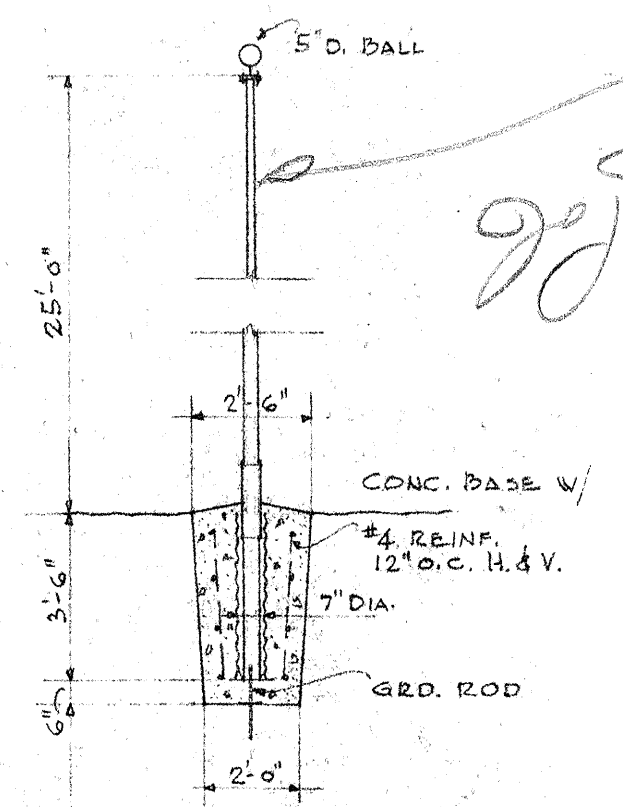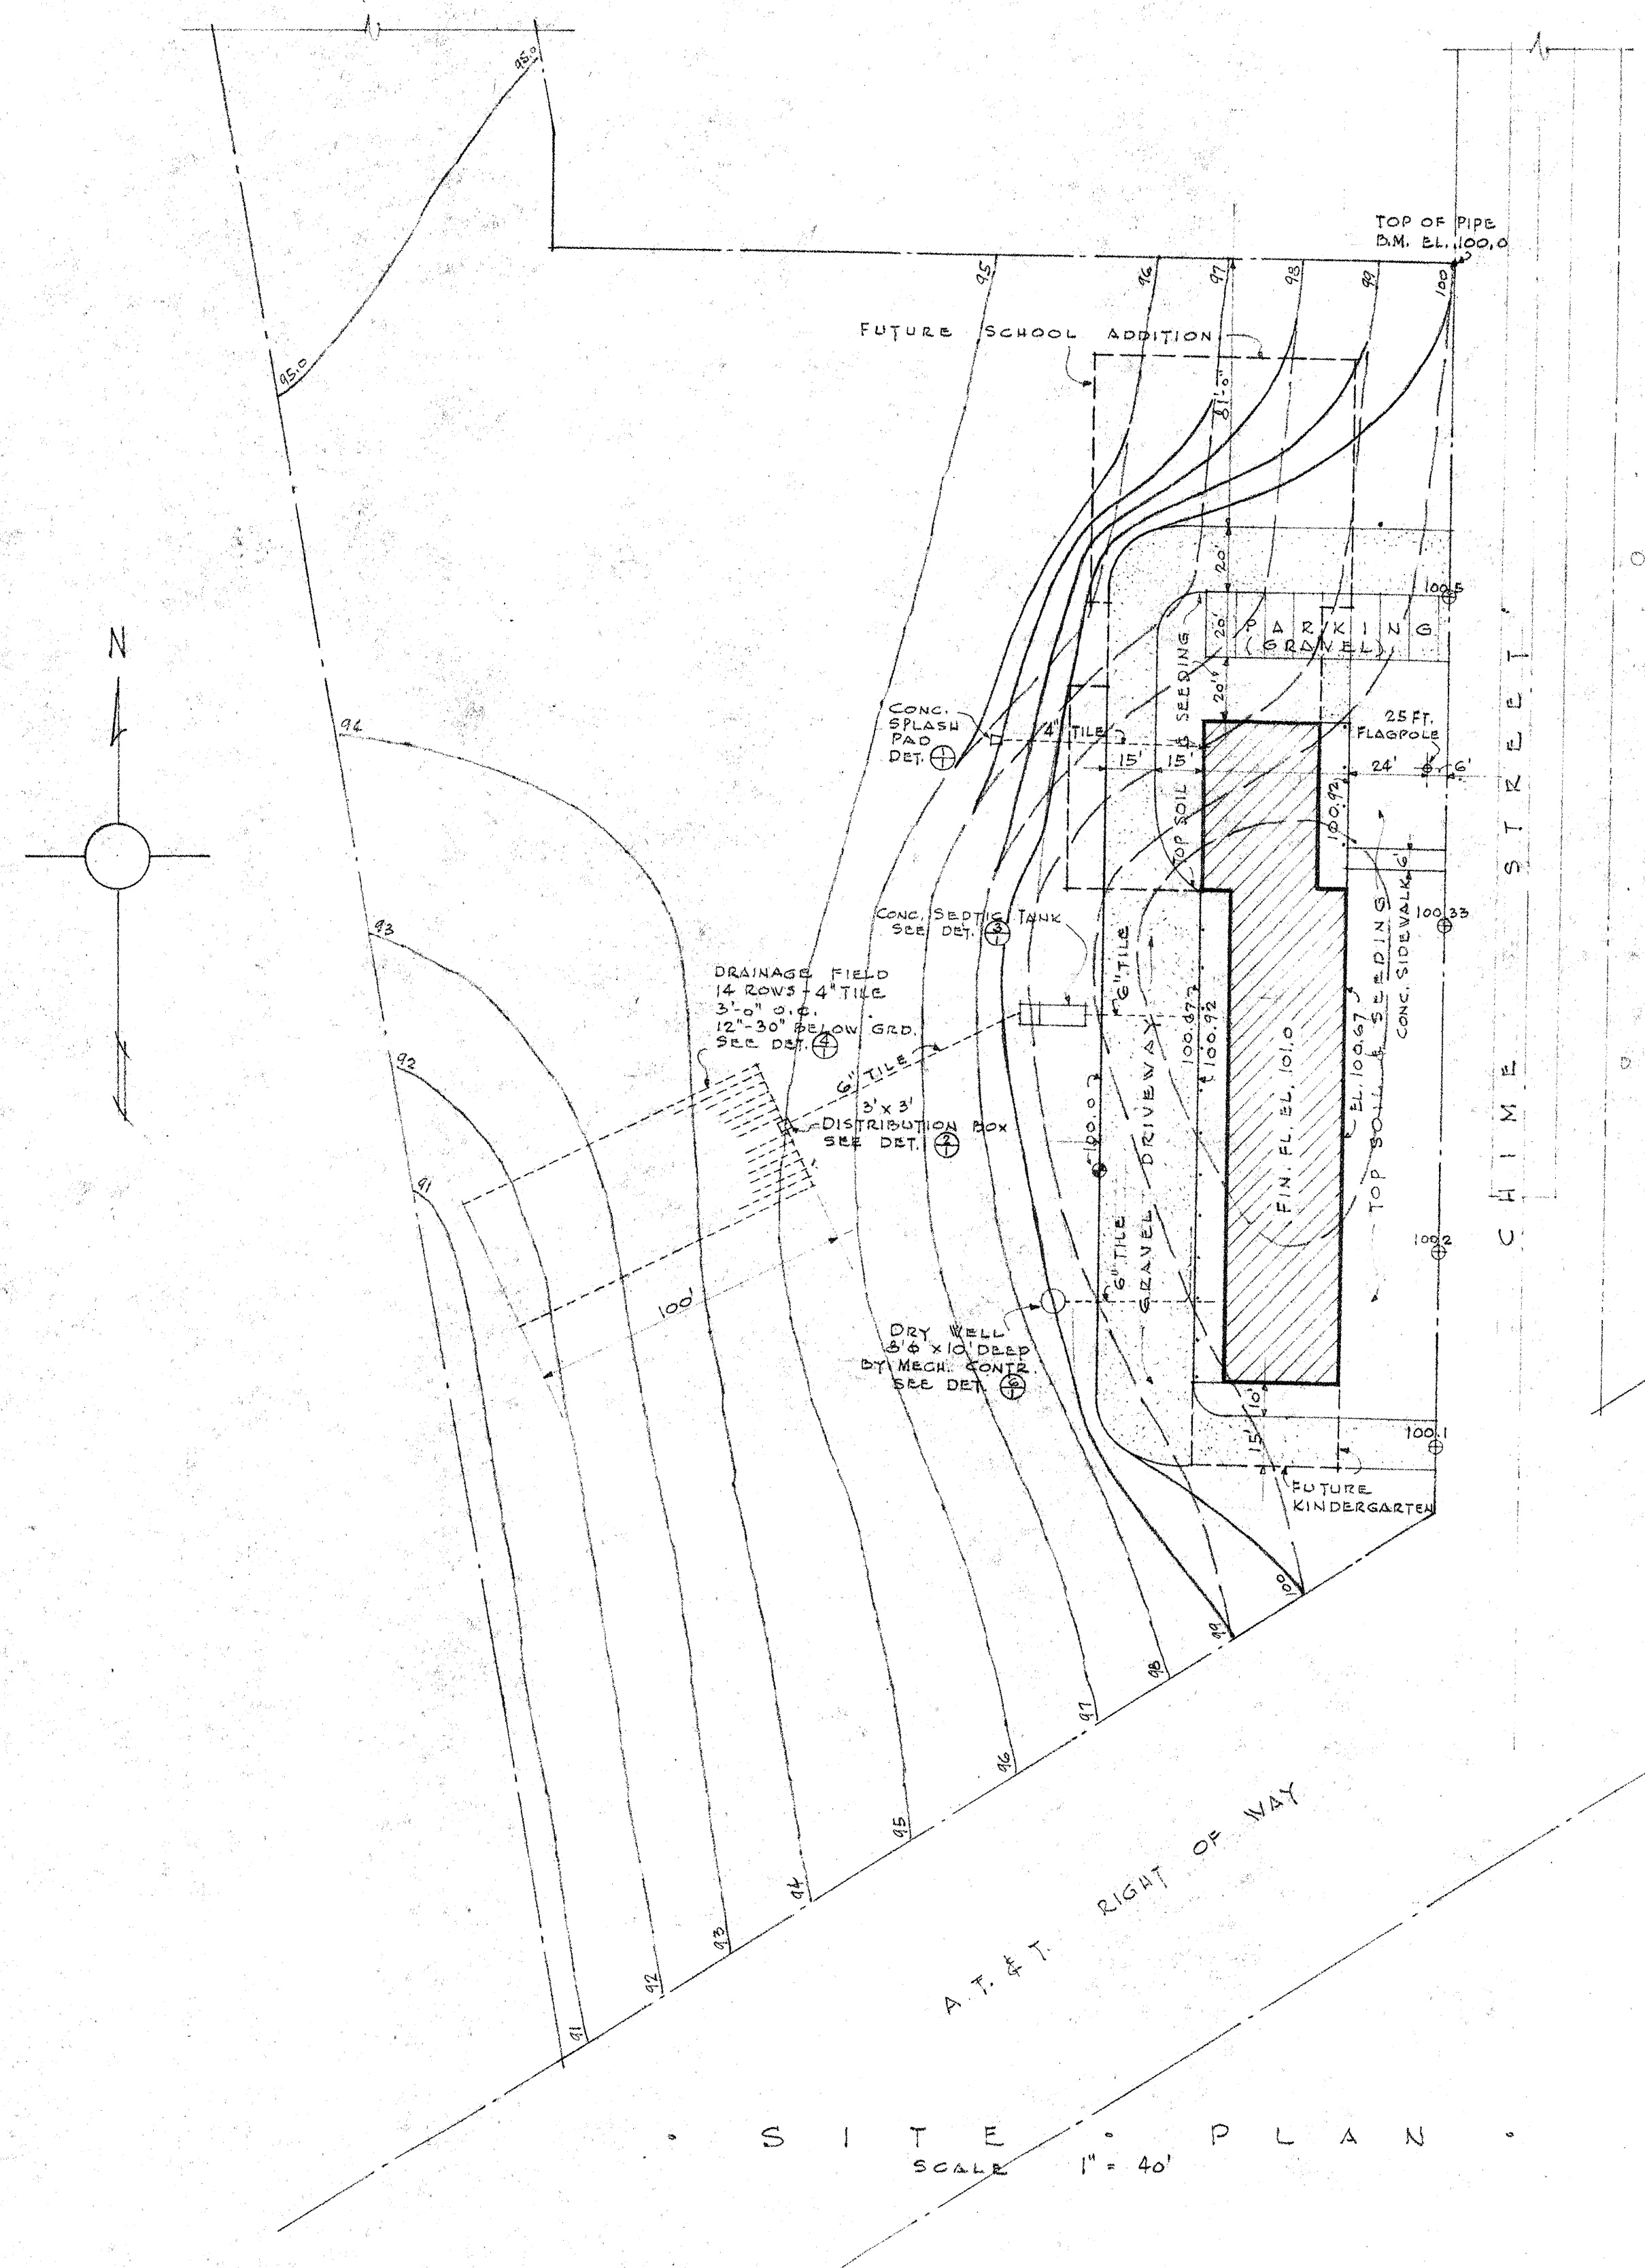


FLAGPOLE
DETAIL
SCALE 1/4" = 1'-0"

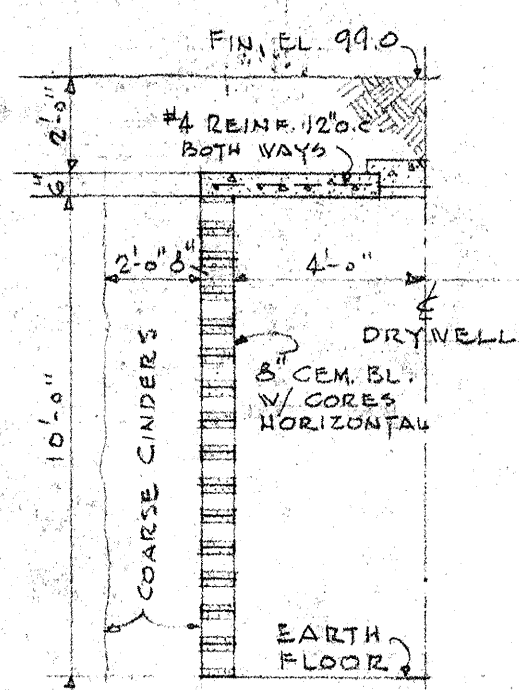


SECTION OF
DRYWELL
SCALE 1/4" = 1'-0"

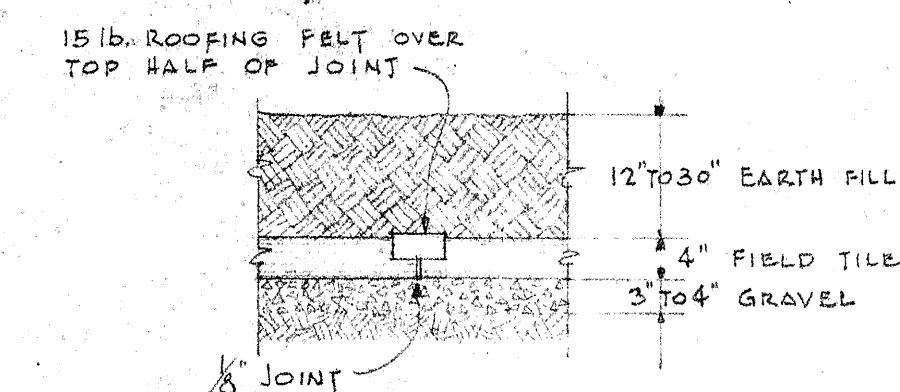


TYPICAL
TILE FIELD
JOINT DET.
SCALE 1/4" = 1'-0"

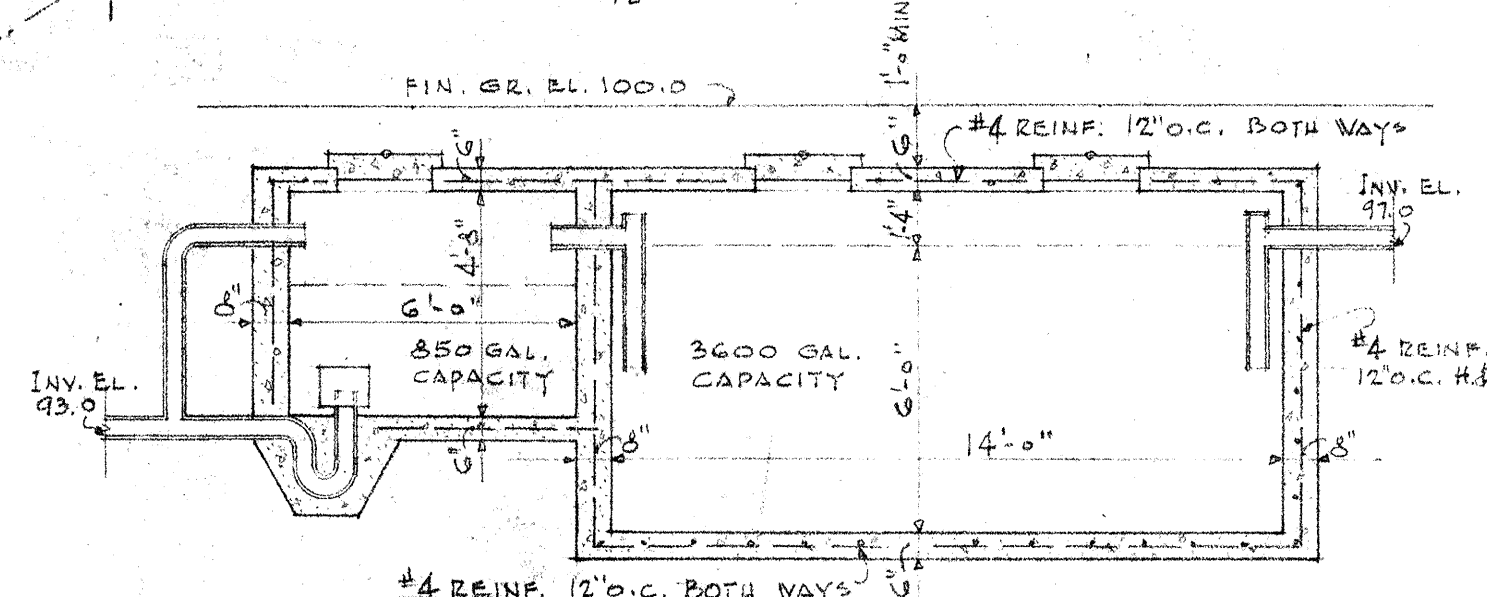

SEPTIC TANK & SIPHON
SCALE 1/4" = 1'-0"

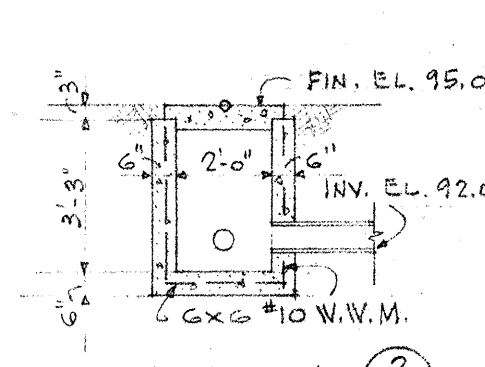

SECTION
DISTRIBUTION
BOX
SCALE 1/4" = 1'-0"


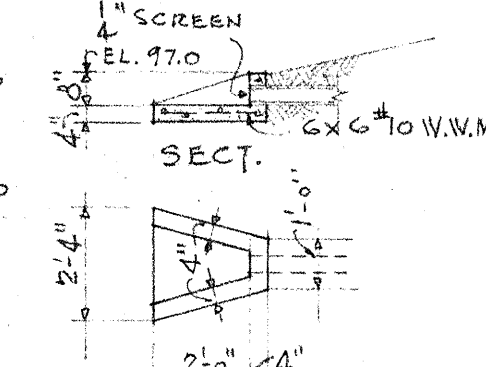


CONCRETE
SPLASH PAD
SCALE 1/4" = 1'-0"

BOARD OF EDUCATION
SCHOOL DISTRICT NO. 12 FRACTIONAL
KALAMAZOO COUNTY
OSHTEMO - MICHIGAN



ELEMENTARY - SCHOOL OSHTEMO - MICHIGAN

STAPERT - PRATT - BULTHUIS & SPRAU INC. 474 ACADEMY STREET - KALAMAZOO, MICHIGAN - PH. 5-2145		
ARCHITECTS		
DRAWN BY - A.K.B.	DATE - OCT. 1953	SHEET NO. 1

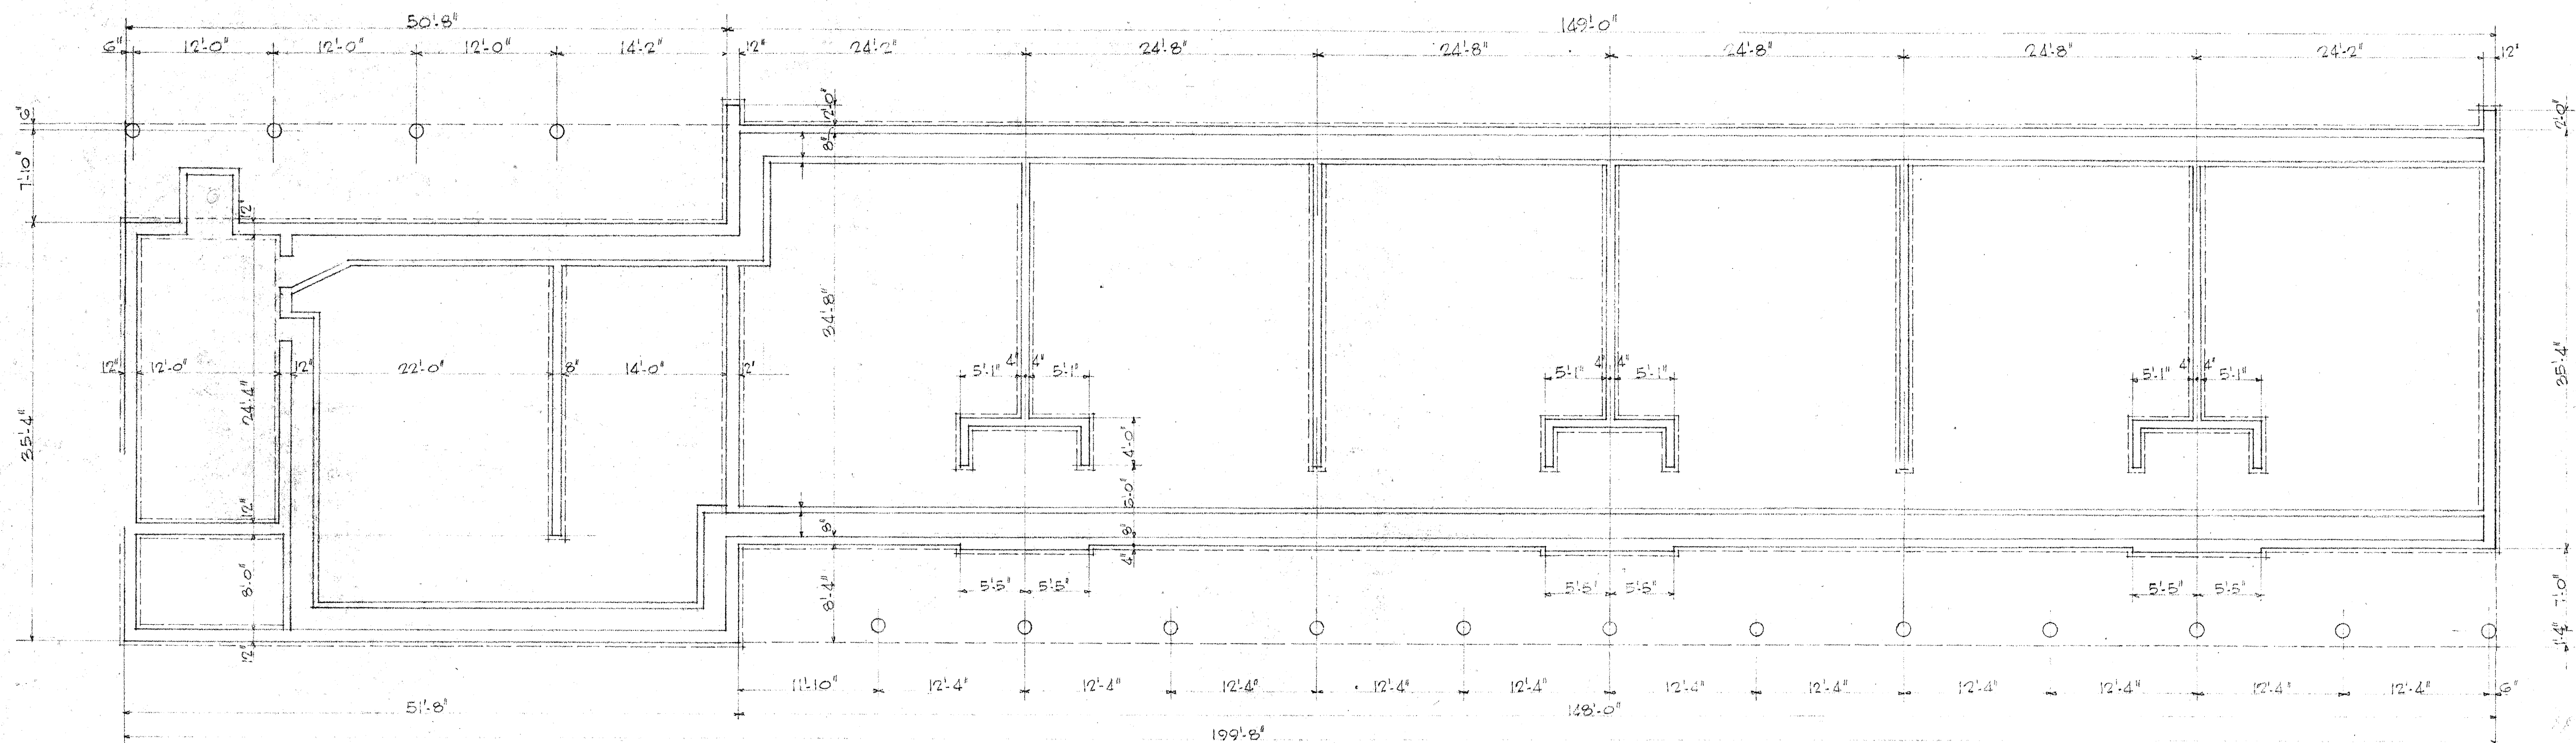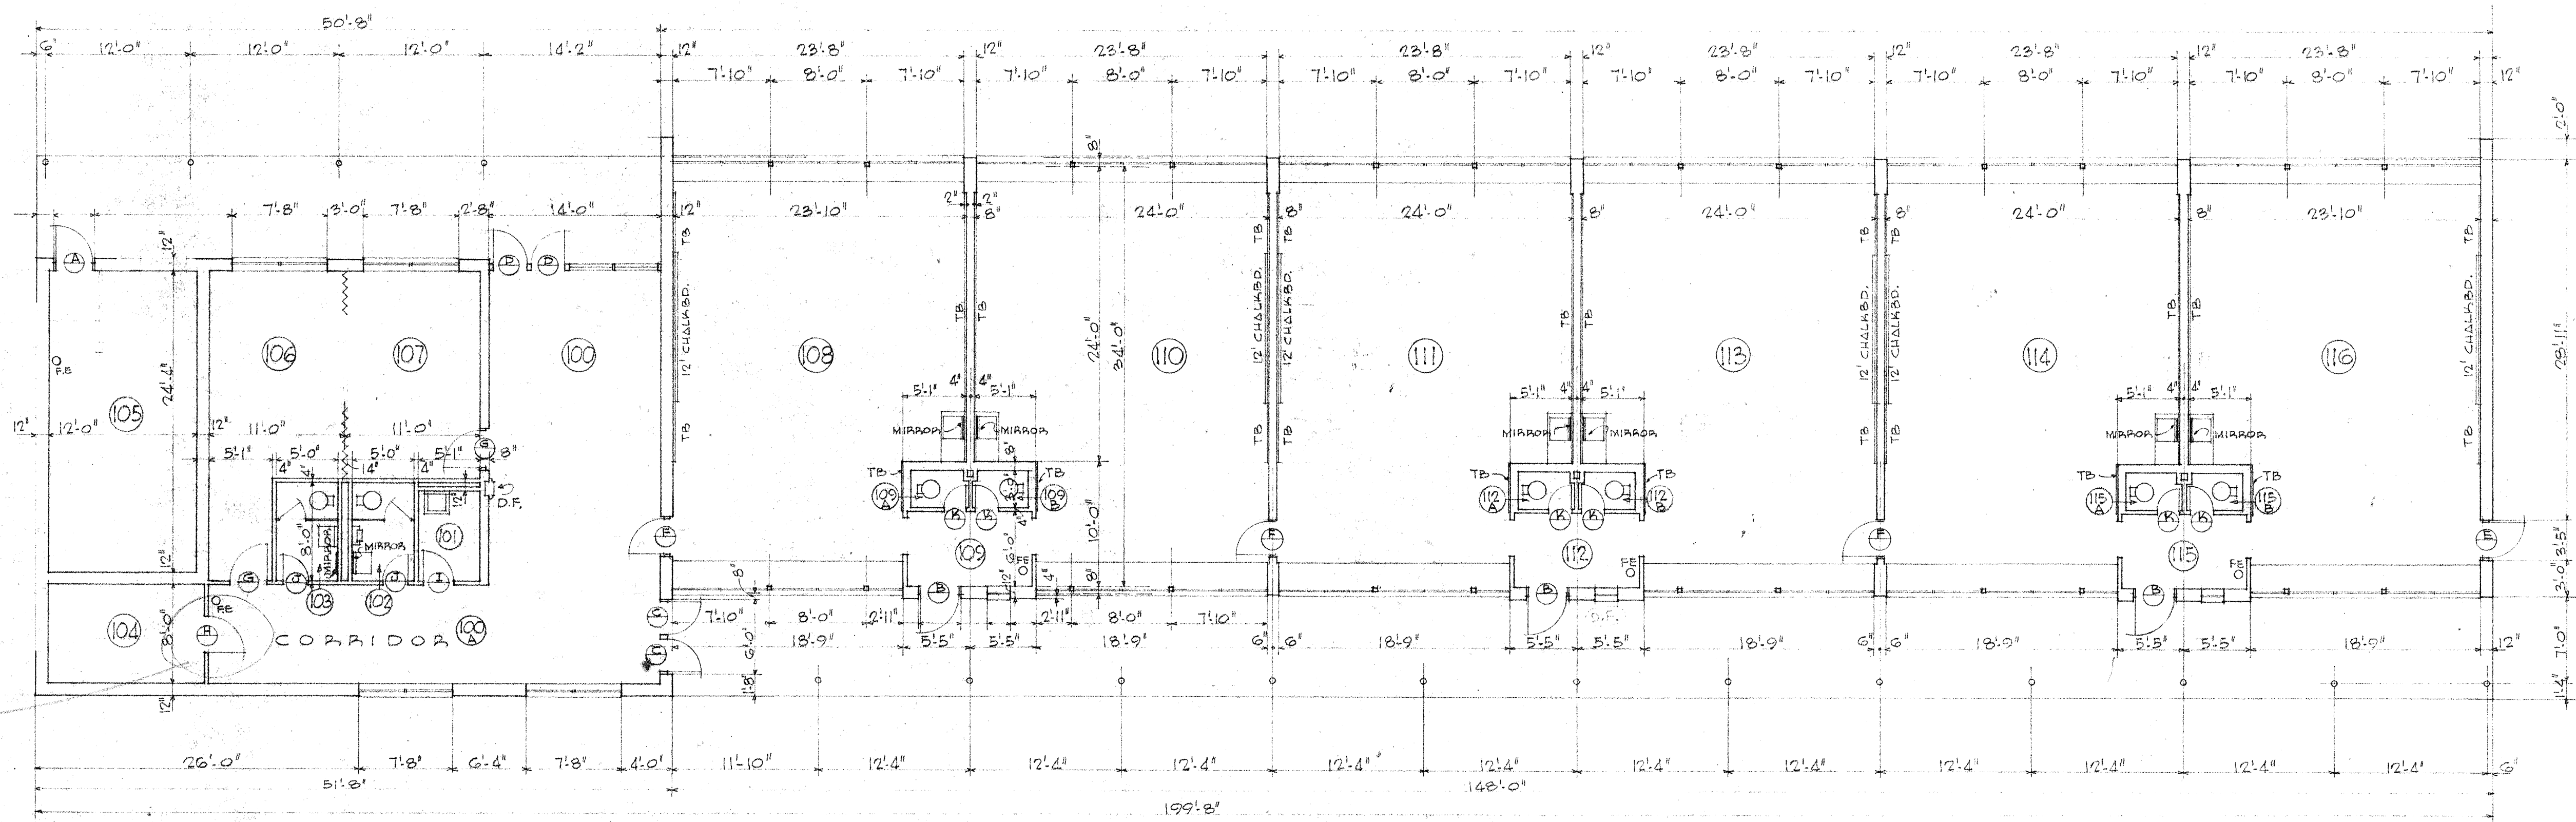

DOOR SCHEDULE.

MARK	TYPE	SIZE	MATL	REMARKS
A	1	3'-0" x 7'-0" x 13'-4"	WOOD	1/4" PL. GLASS
B	2	3'-0" x 7'-0" x 13'-4"	"	"
C	3	2'-8" x 7'-0" x 13'-4"	"	"
D	4	2'-8" x 7'-0" x 13'-4"	"	"
E	2	3'-0" x 7'-0" x 13'-4"	METAL	"
F	2	3'-0" x 7'-0" x 13'-4"	WOOD	DSB. GLASS
G	2	3'-0" x 7'-0" x 13'-4"	"	"
H	6	3'-0" x 7'-0" x 13'-4"	"	"
I	5	2'-8" x 7'-0" x 13'-4"	"	"
J	7	2'-4" x 7'-0" x 13'-4"	"	OBSCURE GL.
K	7	1'-10" x 7'-0" x 13'-4"	"	"

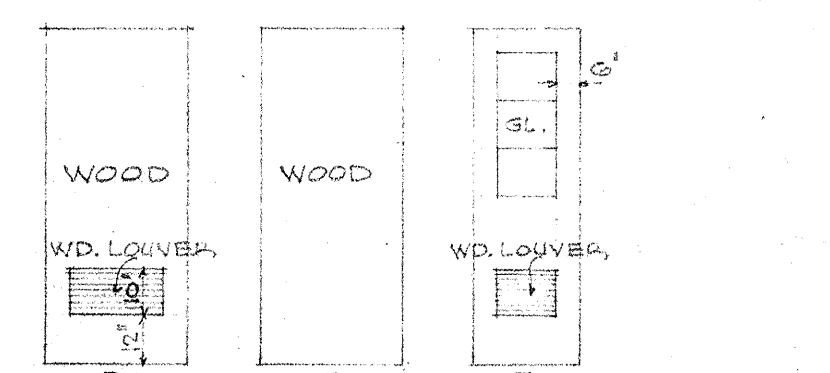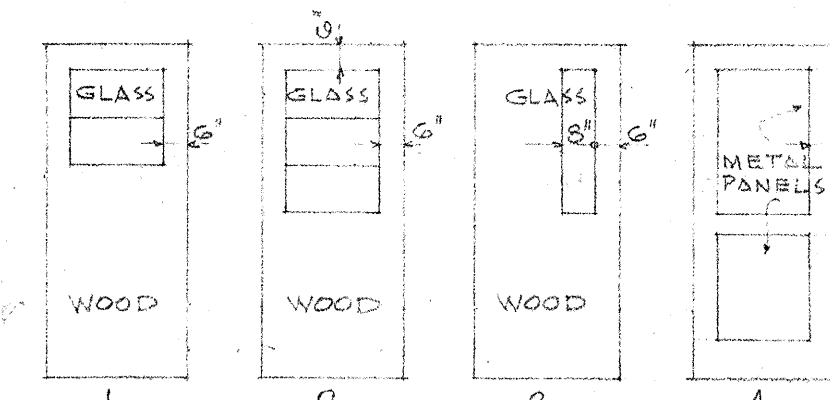

DOOR TYPES.

FOUNDATION & FIRST FLOOR PLANS

STAPERT - PRATT - BULTHUIS & SPRAU INC.
474 ACADEMY STREET - KALAMAZOO, MICHIGAN - PH. 5-2145
ARCHITECTS
ELEMENTARY SCHOOL
SCHOOL DISTRICT NO. 12 FRACTIONAL
OSHTIMO TOWNSHIP
KALAMAZOO MICHIGAN

DRAWN BY	P	DATE	OCTOBER 23, 1953	SHEET NO.	2
REV.		JOB NO.	53-3		
REV.					

INTERIOR FINISH SCHEDULE.

RM. NO.	RM. DESIGNATION	FLOOR		BASE		WALL		CEILING		REMARKS
		MAT.	FIN.	MAT.	FIN.	MAT.	FIN.	MAT.	FIN.	
100	LOBBY	AT	WAX	P		C.B.L.	P	ACT.	8'-7"	
100-A	CORRIDOR	AT	WAX	P		C.B.L.	P	ACT.	8'-7"	
101	JANITOR. CLOS.	CEM.				C.B.L.	P	EXP.	10'-0"	
102	MALE TOILET	CT		CT		C.B.L.	P	ACT.	8'-0"	
103	FEMALE TOILET	CT		CT		C.B.L.	P	ACT.	8'-0"	
104	STORAGE	CEM.		CT		C.B.L.	P	EXP.	10'-0"	
105	BOILER ROOM	CEM.				CEM. BR.	P	EXP.	12'-4"	
106	TEACHERS	AT	WAX	P		C.B.L.	P	ACT.	8'-5"	
107	OFFICE	AT	WAX	P		C.B.L.	P	ACT.	8'-5"	
108	CLASSROOM	AT	WAX	P		C.B.L.	P	EXP.	10'-0"	
109	VESTIBULE	CT		CT		C.B.L.	P	ACT.	8'-0"	
109-A	TOILET	CT		CT		C.B.L.	P	ACT.	8'-0"	
109-B	TOILET	CT		CT		C.B.L.	P	ACT.	8'-0"	
110	CLASSROOM	AT	WAX	P		C.B.L.	P	EXP.	10'-0"	
111	"	AT	WAX	P		C.B.L.	P	EXP.	10'-0"	
112	VESTIBULE	CT		CT		C.B.L.	P	ACT.	8'-0"	
112-A	TOILET	CT		CT		C.B.L.	P	ACT.	8'-0"	
112-B	TOILET	CT		CT		C.B.L.	P	ACT.	8'-0"	
113	CLASSROOM	AT	WAX	P		C.B.L.	P	EXP.	10'-0"	
114	"	AT	WAX	P		C.B.L.	P	EXP.	10'-0"	
115	VESTIBULE	CT		CT		C.B.L.	P	ACT.	8'-0"	
115-A	TOILET	CT		CT		C.B.L.	P	ACT.	8'-0"	
115-B	TOILET	CT		CT		C.B.L.	P	ACT.	8'-0"	
116	CLASSROOM	AT	WAX	P		C.B.L.	P	EXP.	10'-0"	

