



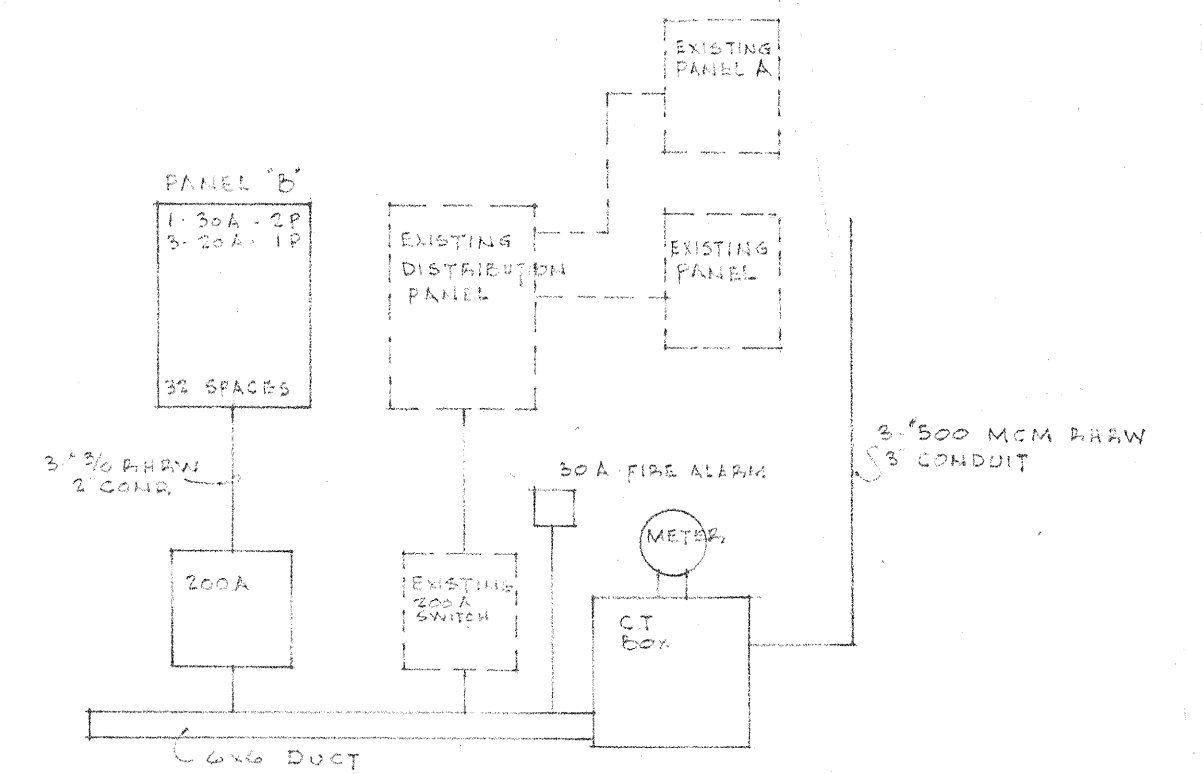


ELECTRICAL SERVICE

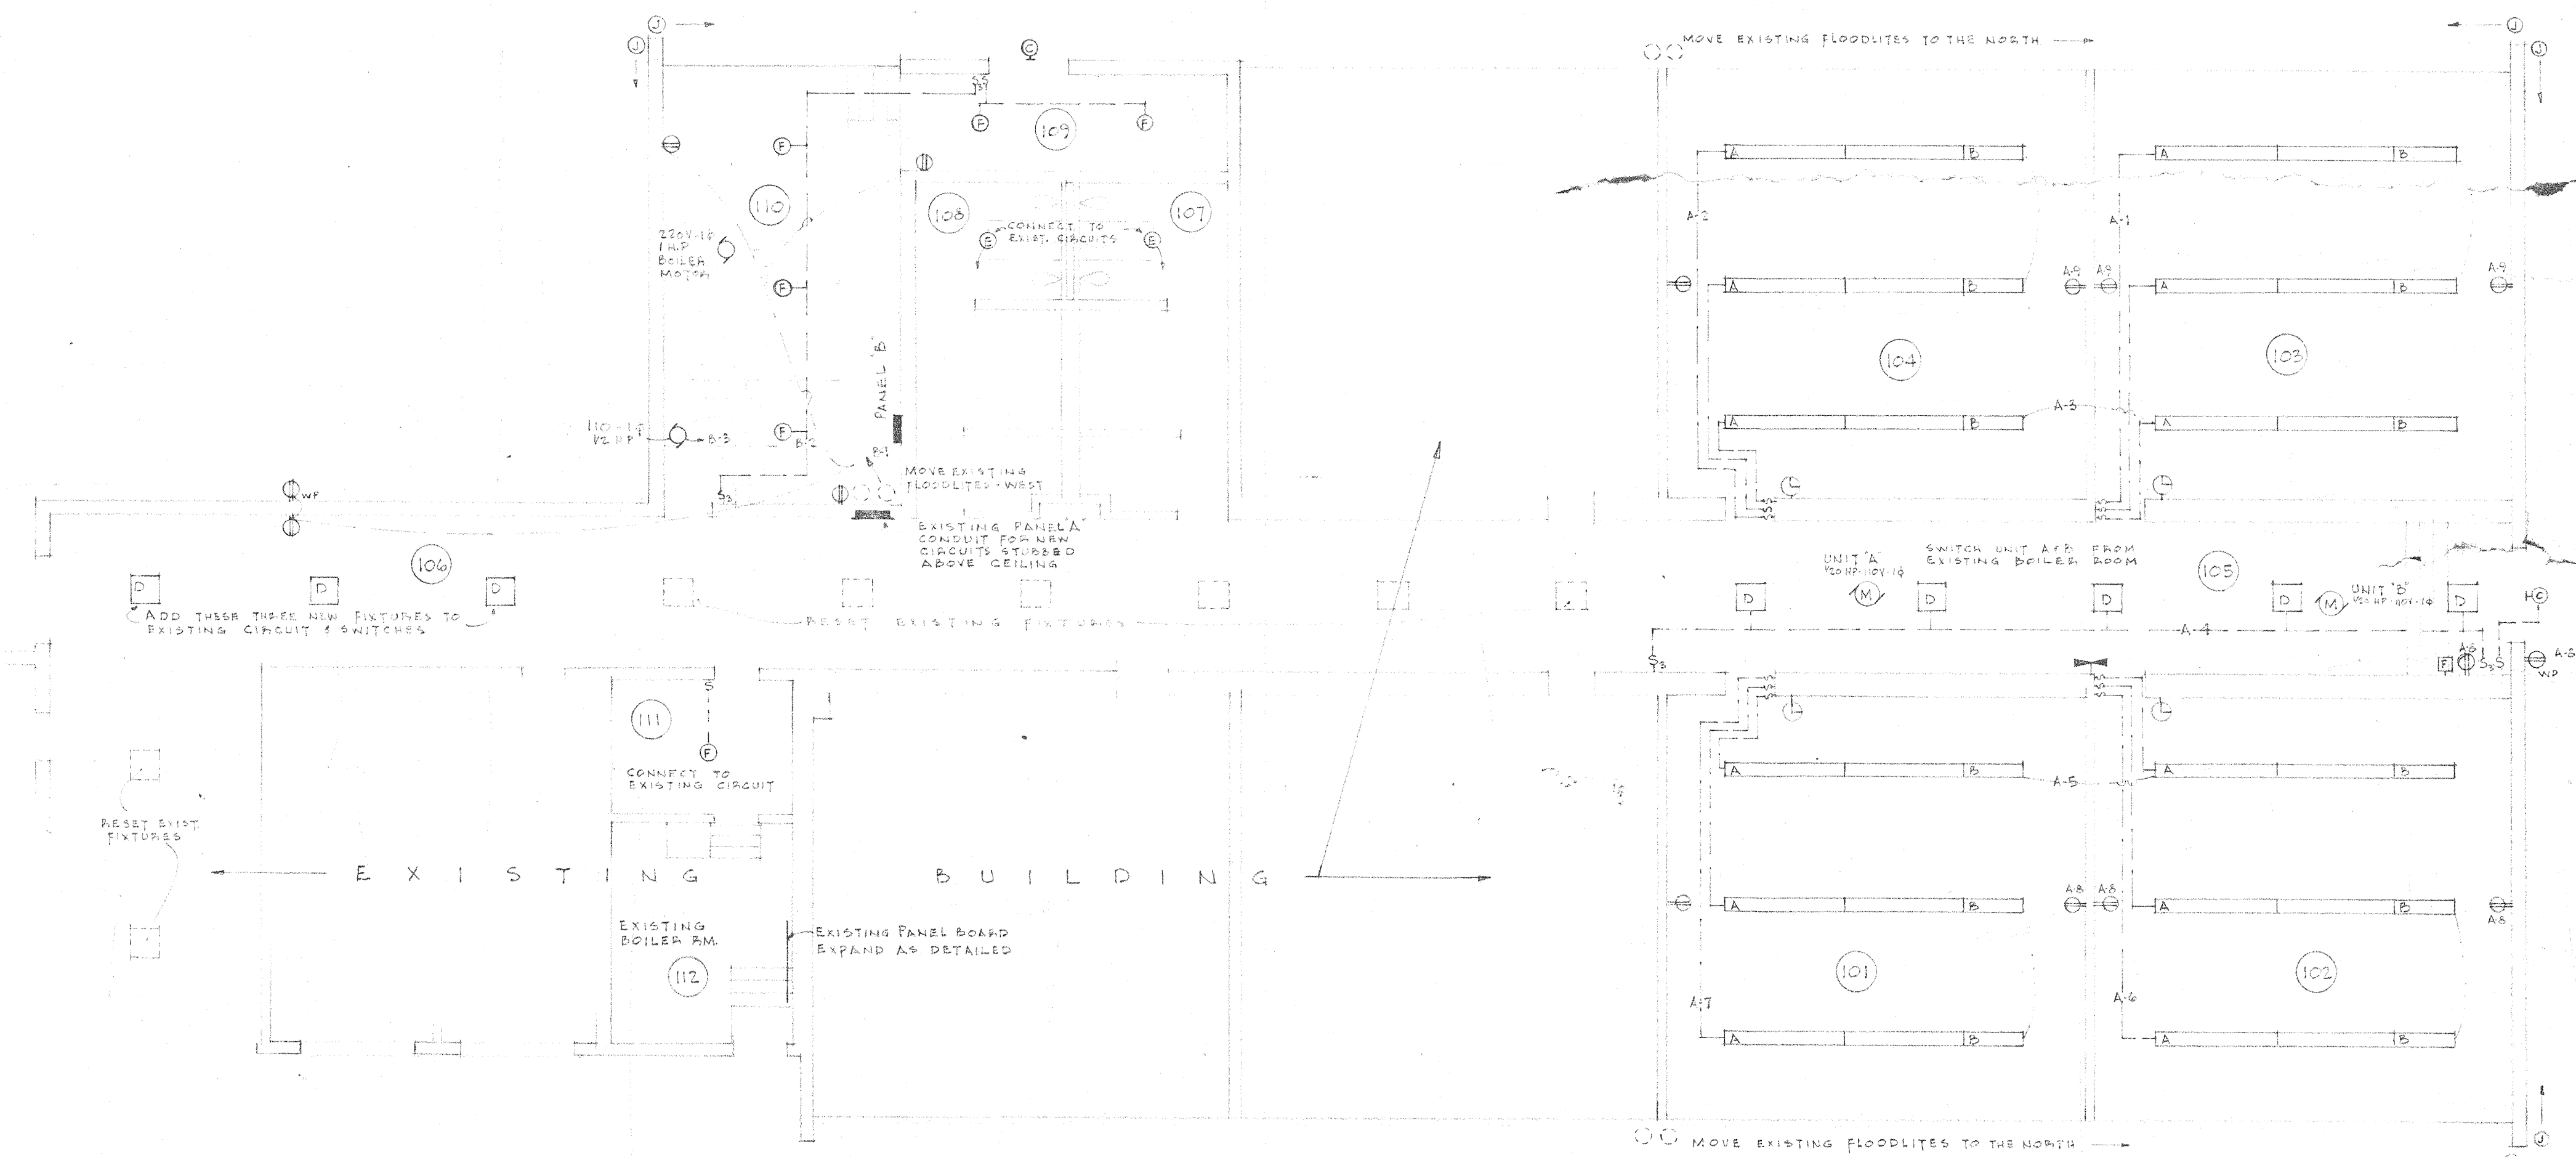

ELECTRICAL PLAN V8-110


ELECTRICAL SYMBOLS					
	FLUORESCENT FIXTURE		CLOCK & OUTLET		SWITCH SINGLE POLE
	INCANDESCENT FIXTURE		MOTOR		SWITCH 3-WAY
	RECESSED FIXTURE		FIRE STATION		SWITCH WITH PILOT
	110 V DUPLEX OUTLET		FIRE HORN		SWITCH LINE
	WATER-PROOF OUTLET		PANEL		CIRCUIT LINE

G. E. HEKEMA ARCHITECT		3-22-61	
PROPOSED ADDITION		6105	
OSHTEMO ELEM. SCHOOL			

 


	HAND VALVE
	MODULATING VALVE
	THERMOSTAT
	CHECK VALVE


G. E. DIEKEMA ARCHITECT 311 WOODWARD AVENUE KALAMAZOO, MICHIGAN	
D-40-02 PROPOSED ADDITION FOR OSHTEMO ELEM SCHOOL	REVISIONS DATE 3-22-61 JOB NO. 1-105 SHEET NO. M-1

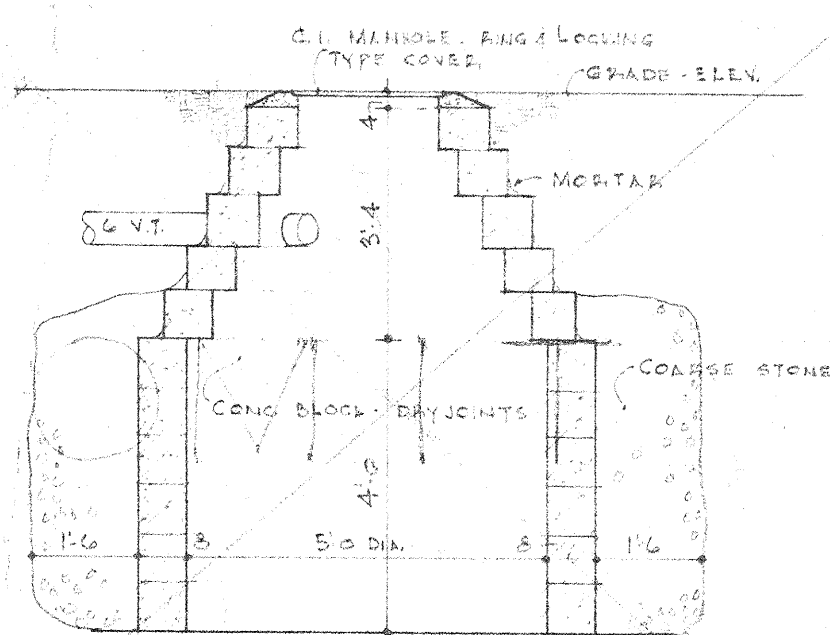


DRYWELL DETAIL
BY GEN. CONTR.

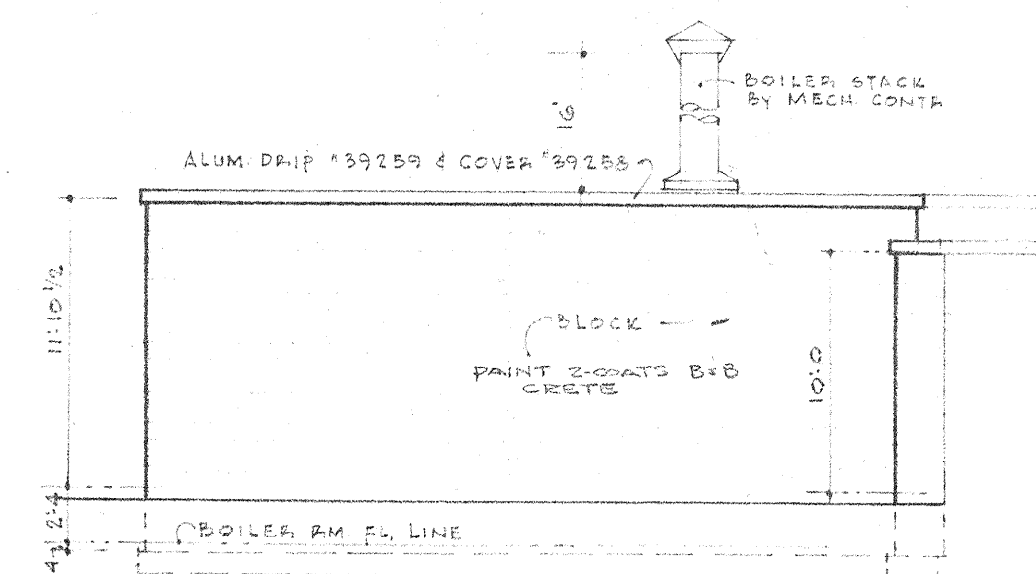


SOUTH ELEVATION 1/8" = 1'-0"

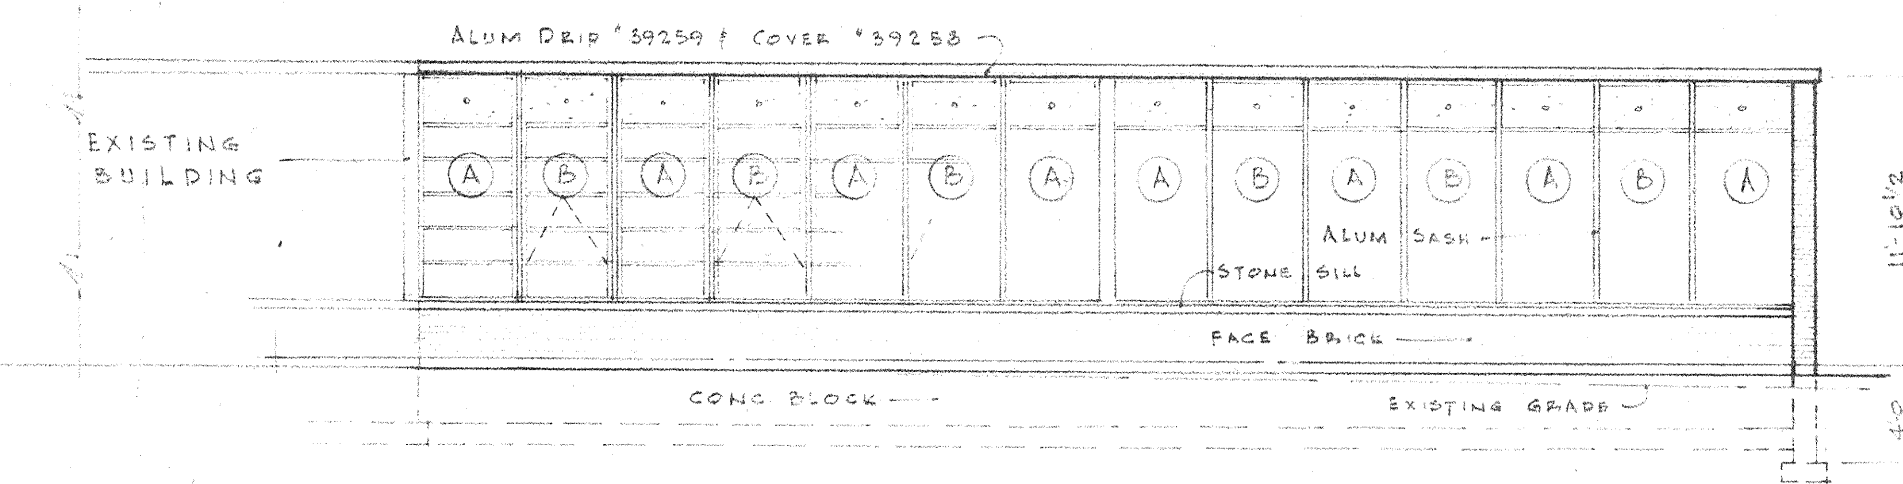


EAST ELEVATION 1/8" = 1'-0"

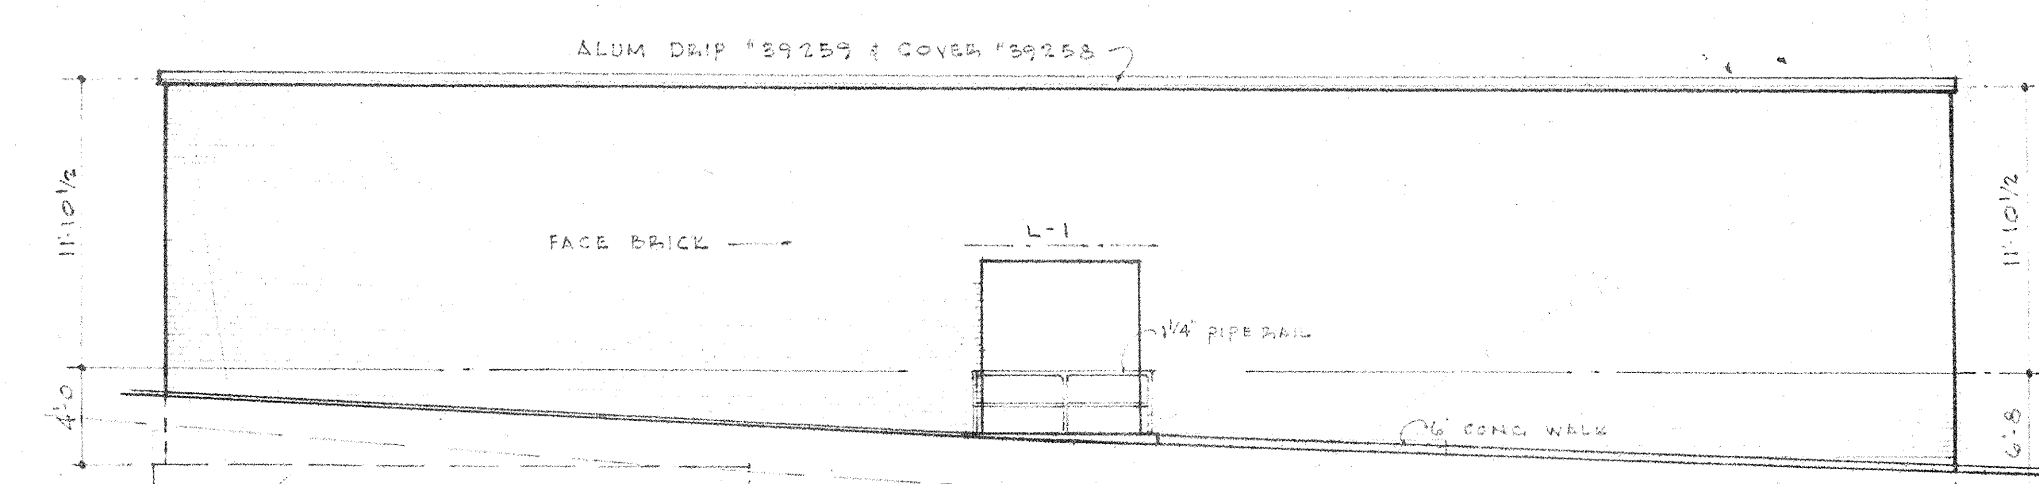


NORTH ELEVATION 1/8" = 1'-0"

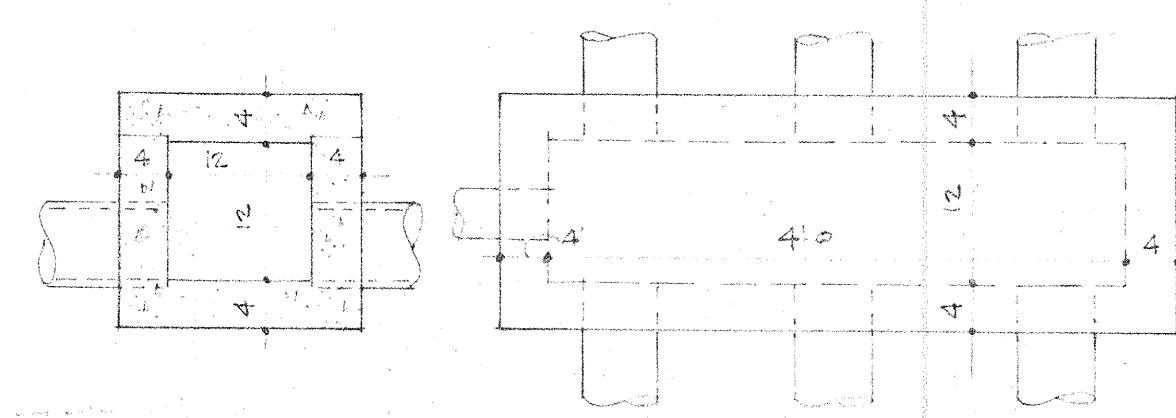


SECTION DISTRIBUTION BOX

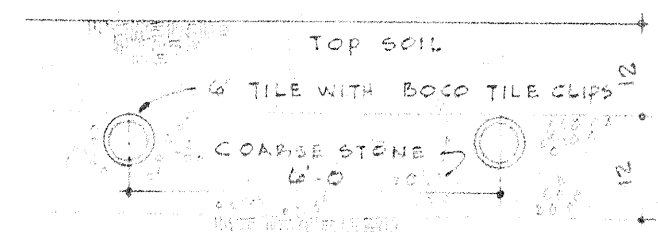

TILE FIELD

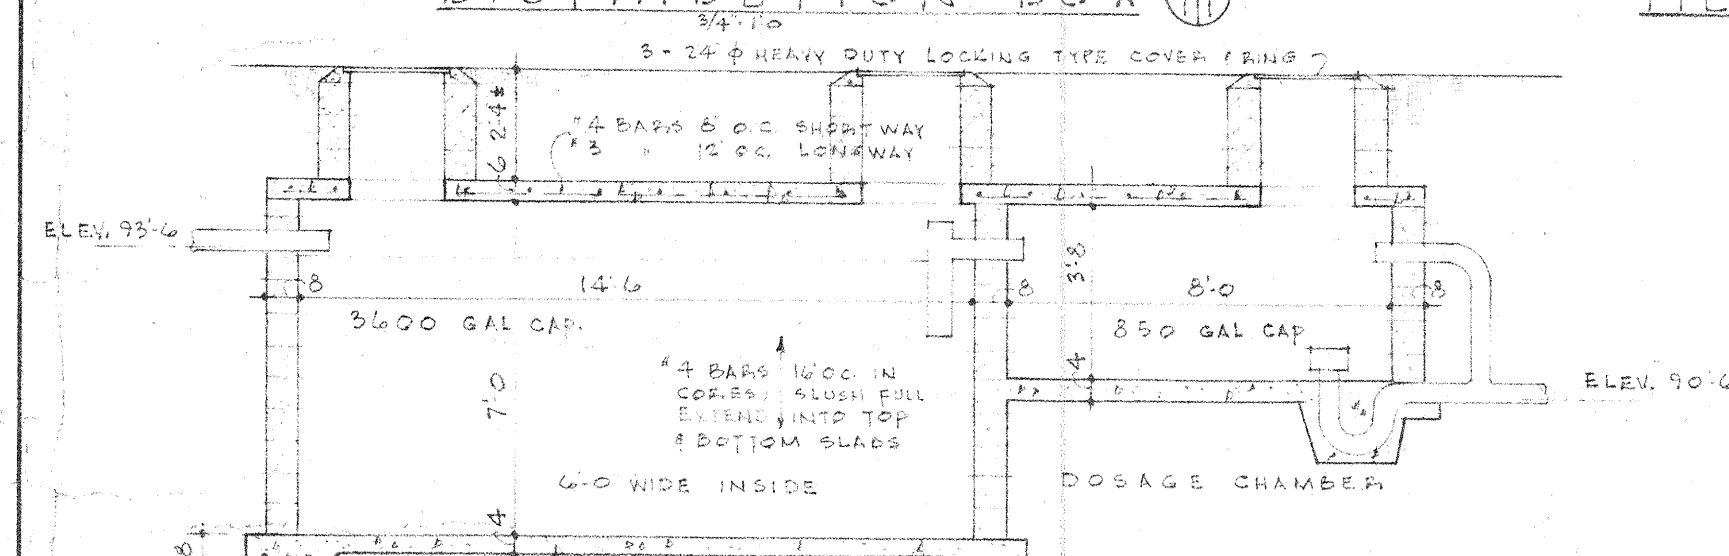


SEPTIC TANK

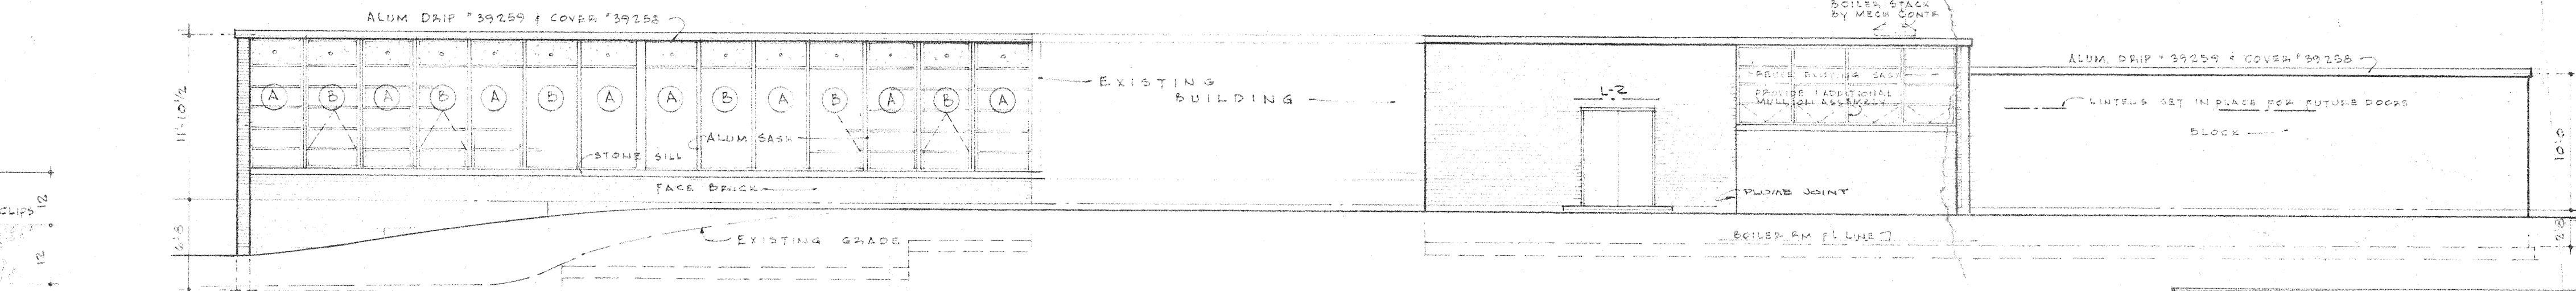


WEST ELEVATION 1/8" = 1'-0"


SASH SCHEDULE		
MARK	SIZE	REMARKS
A	3'0" x 9'2 1/2"	FIXED
B	3'0" x 9'2 1/2"	VENT

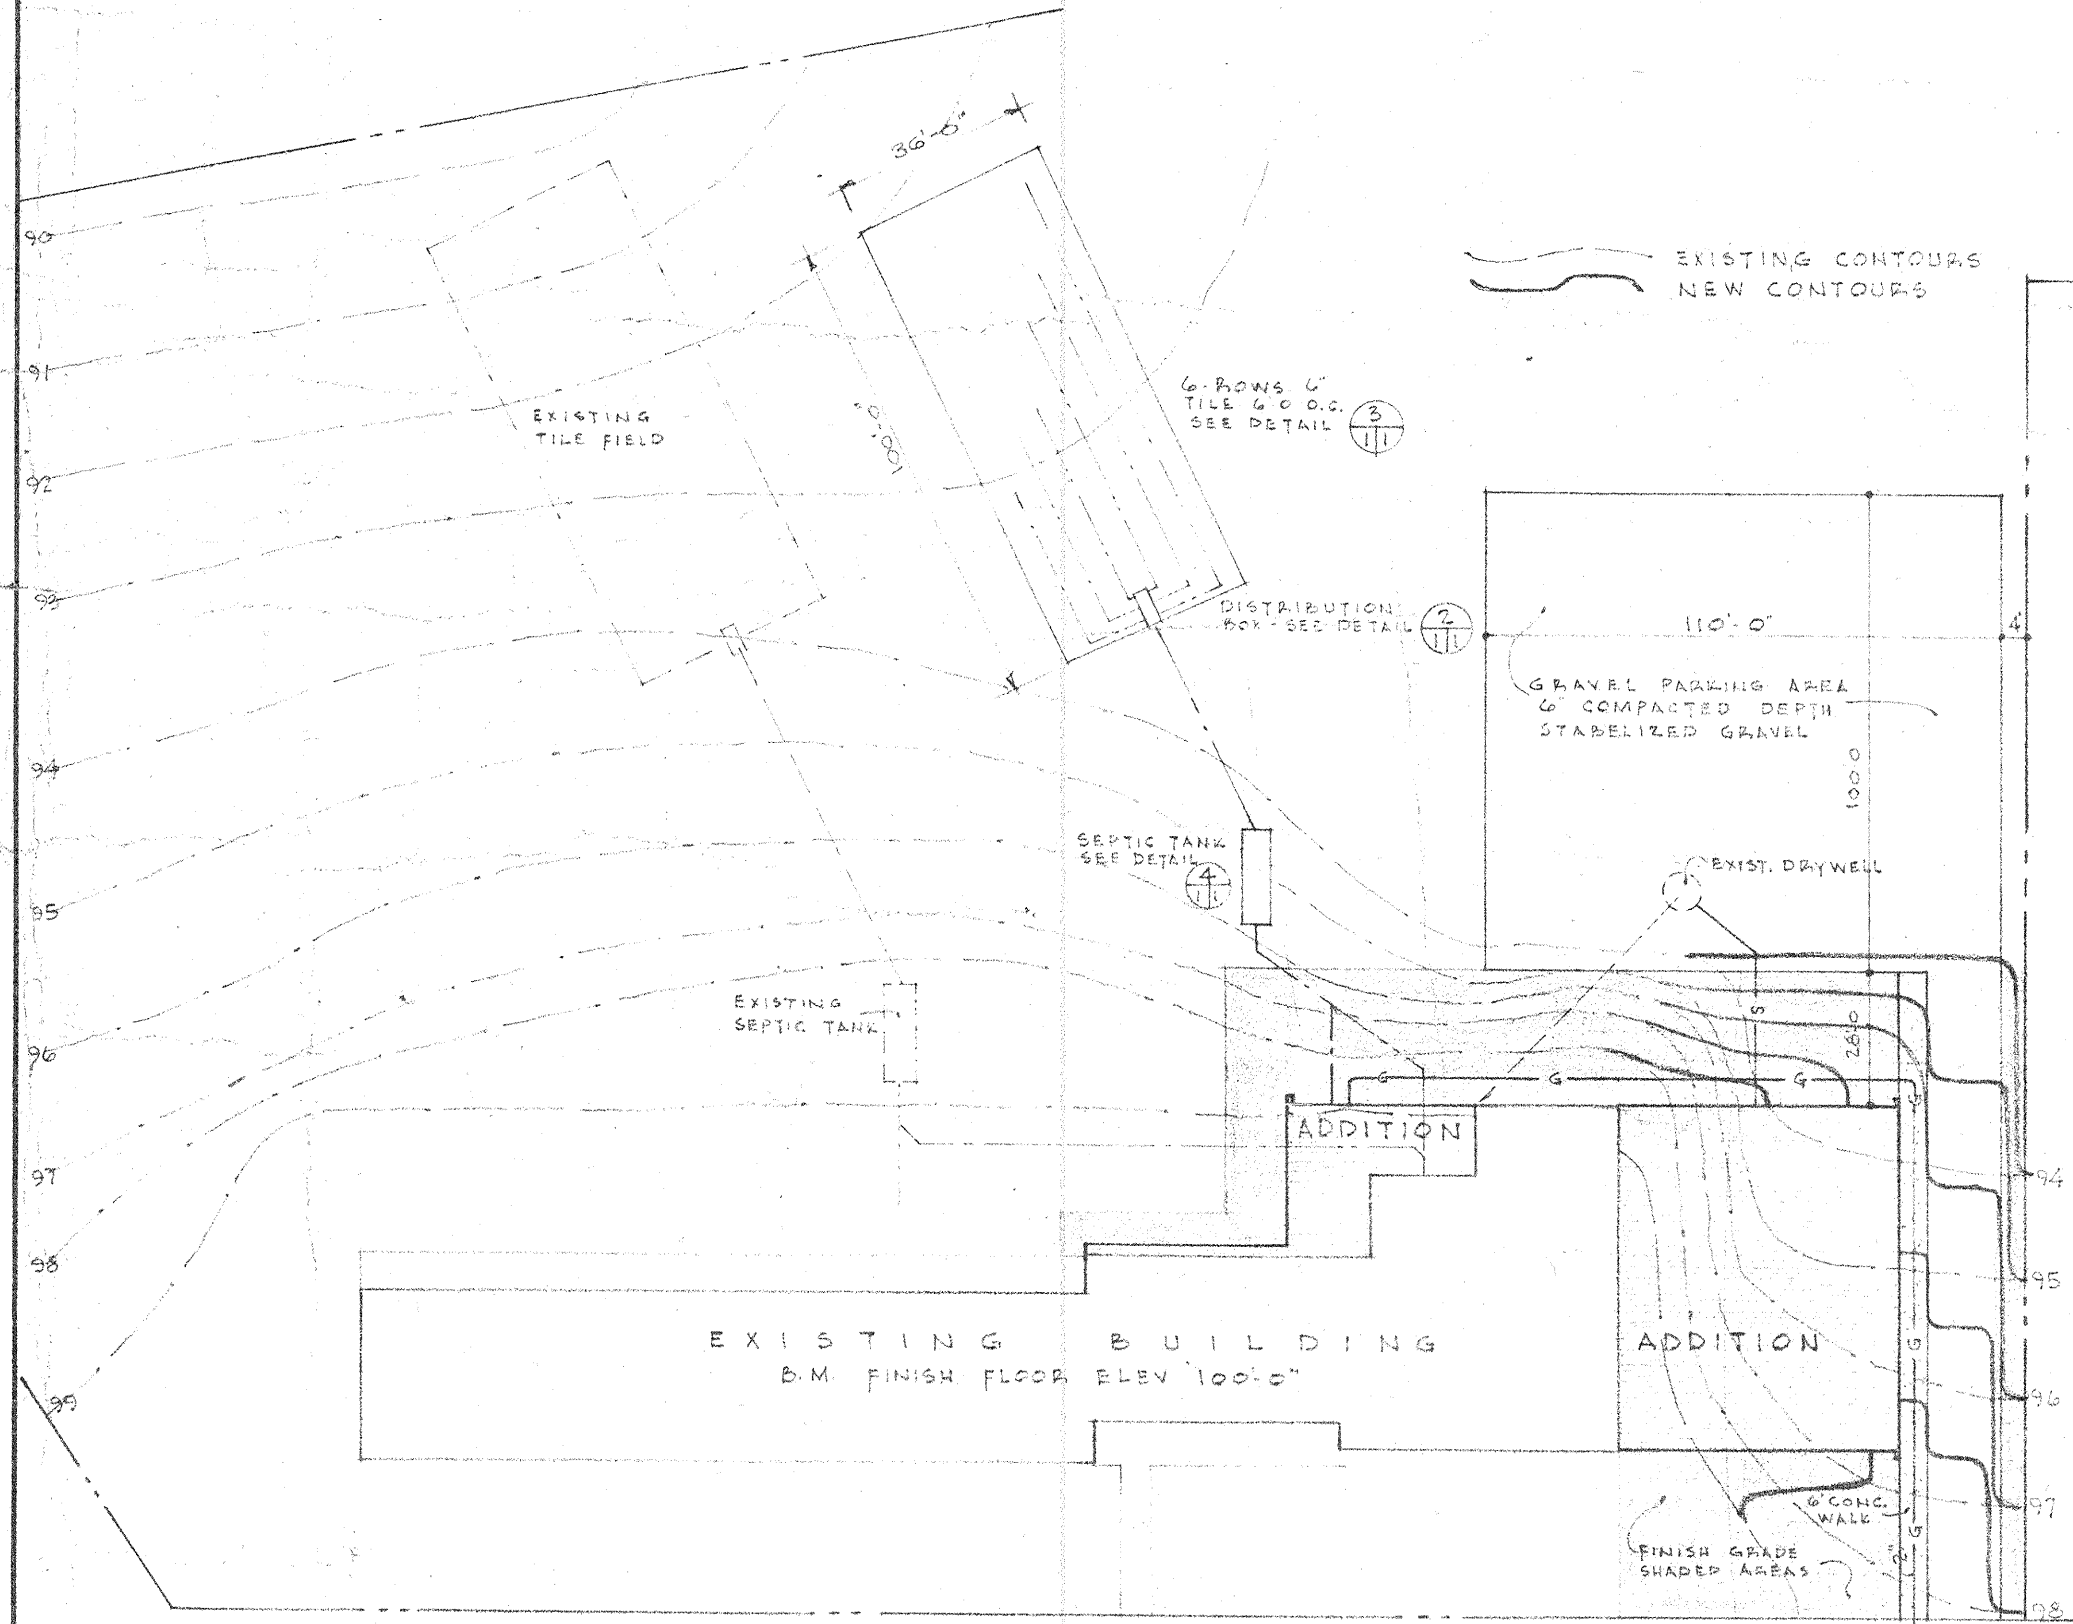

PLOT PLAN 1" = 40'-0" NORTH

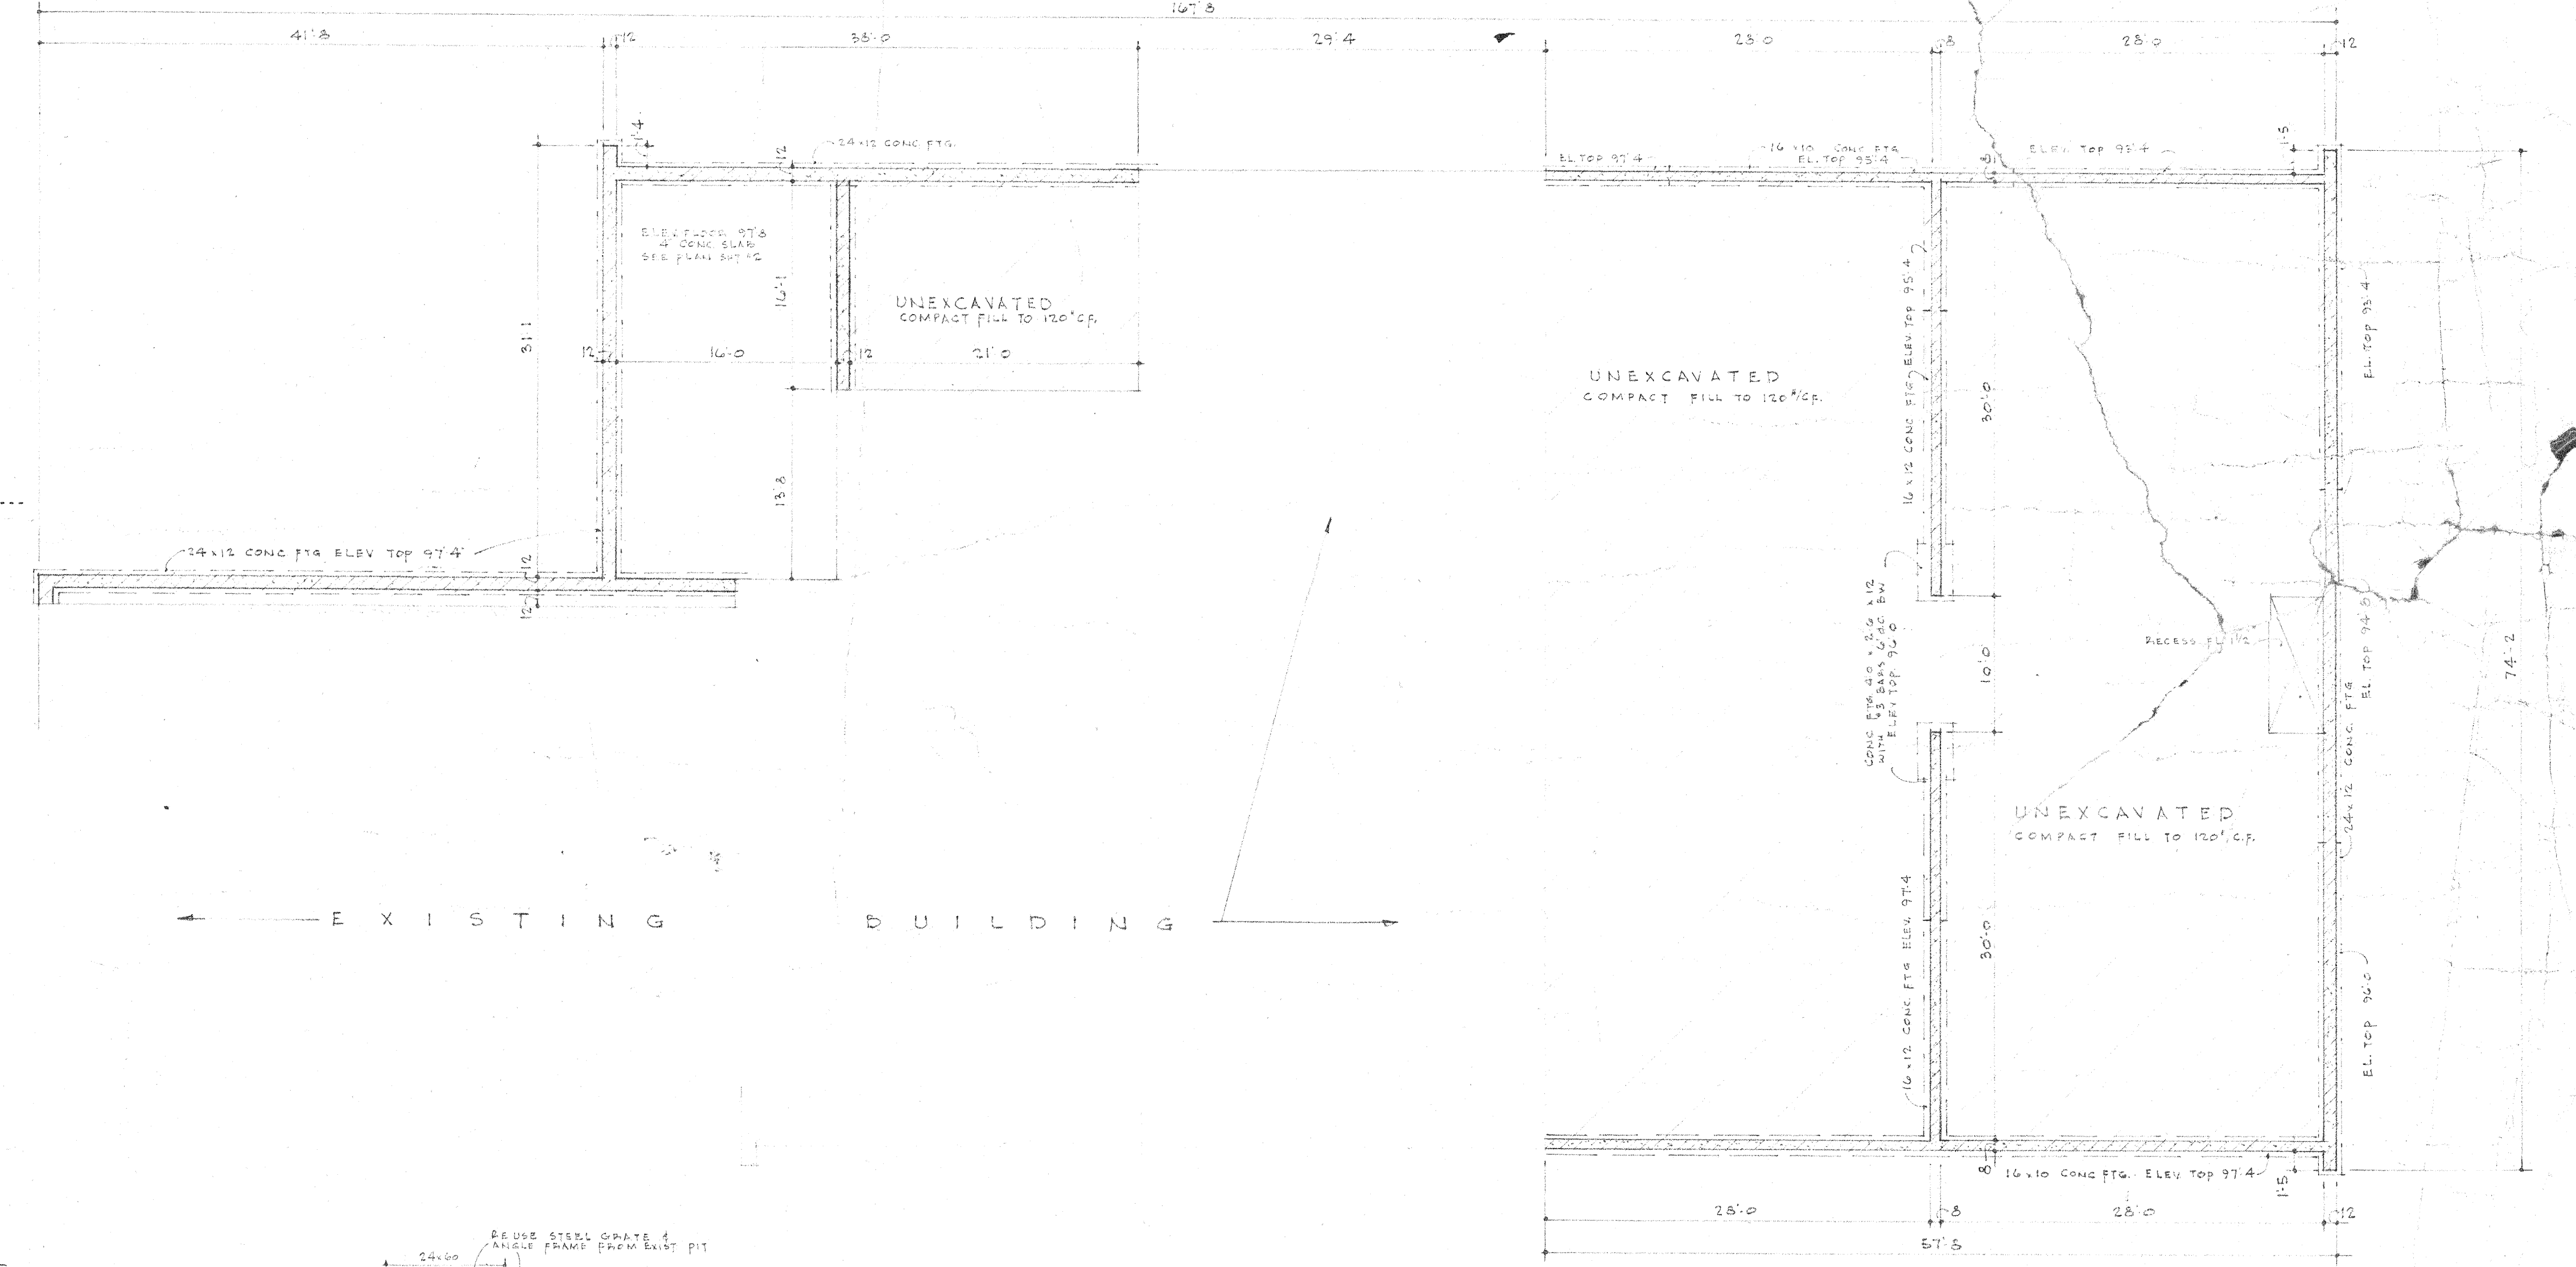




FOUNDATION PLAN 1/8" = 1'-0"

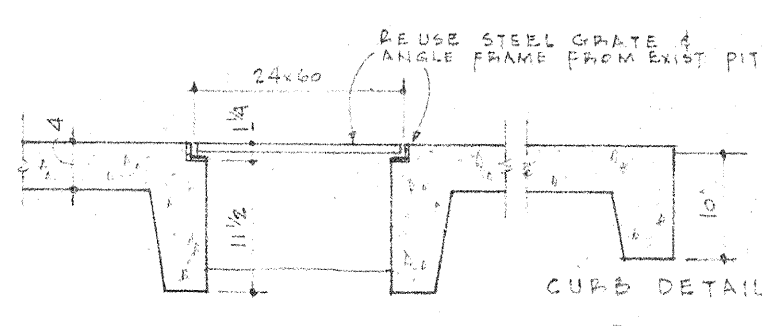

SCRAPE PIT

DRAWING SCHEDULE					
	1	2	3	M	E
COMPLETE	✓	✓	✓	✓	✓
GENERAL	✓	✓	✓	✓	✓
MECHANICAL	✓	✓	✓	✓	✓
ELECTRICAL	✓	✓	✓	✓	✓








E. LIEKEMA ARCHITECT 1 W. GARDNER AVENUE CHICAGO, ILL.		PROPOSED ADDITION FOR OSHTIMO ELEM. SCHOOL		3-22-61 16105
--	--	--	--	------------------

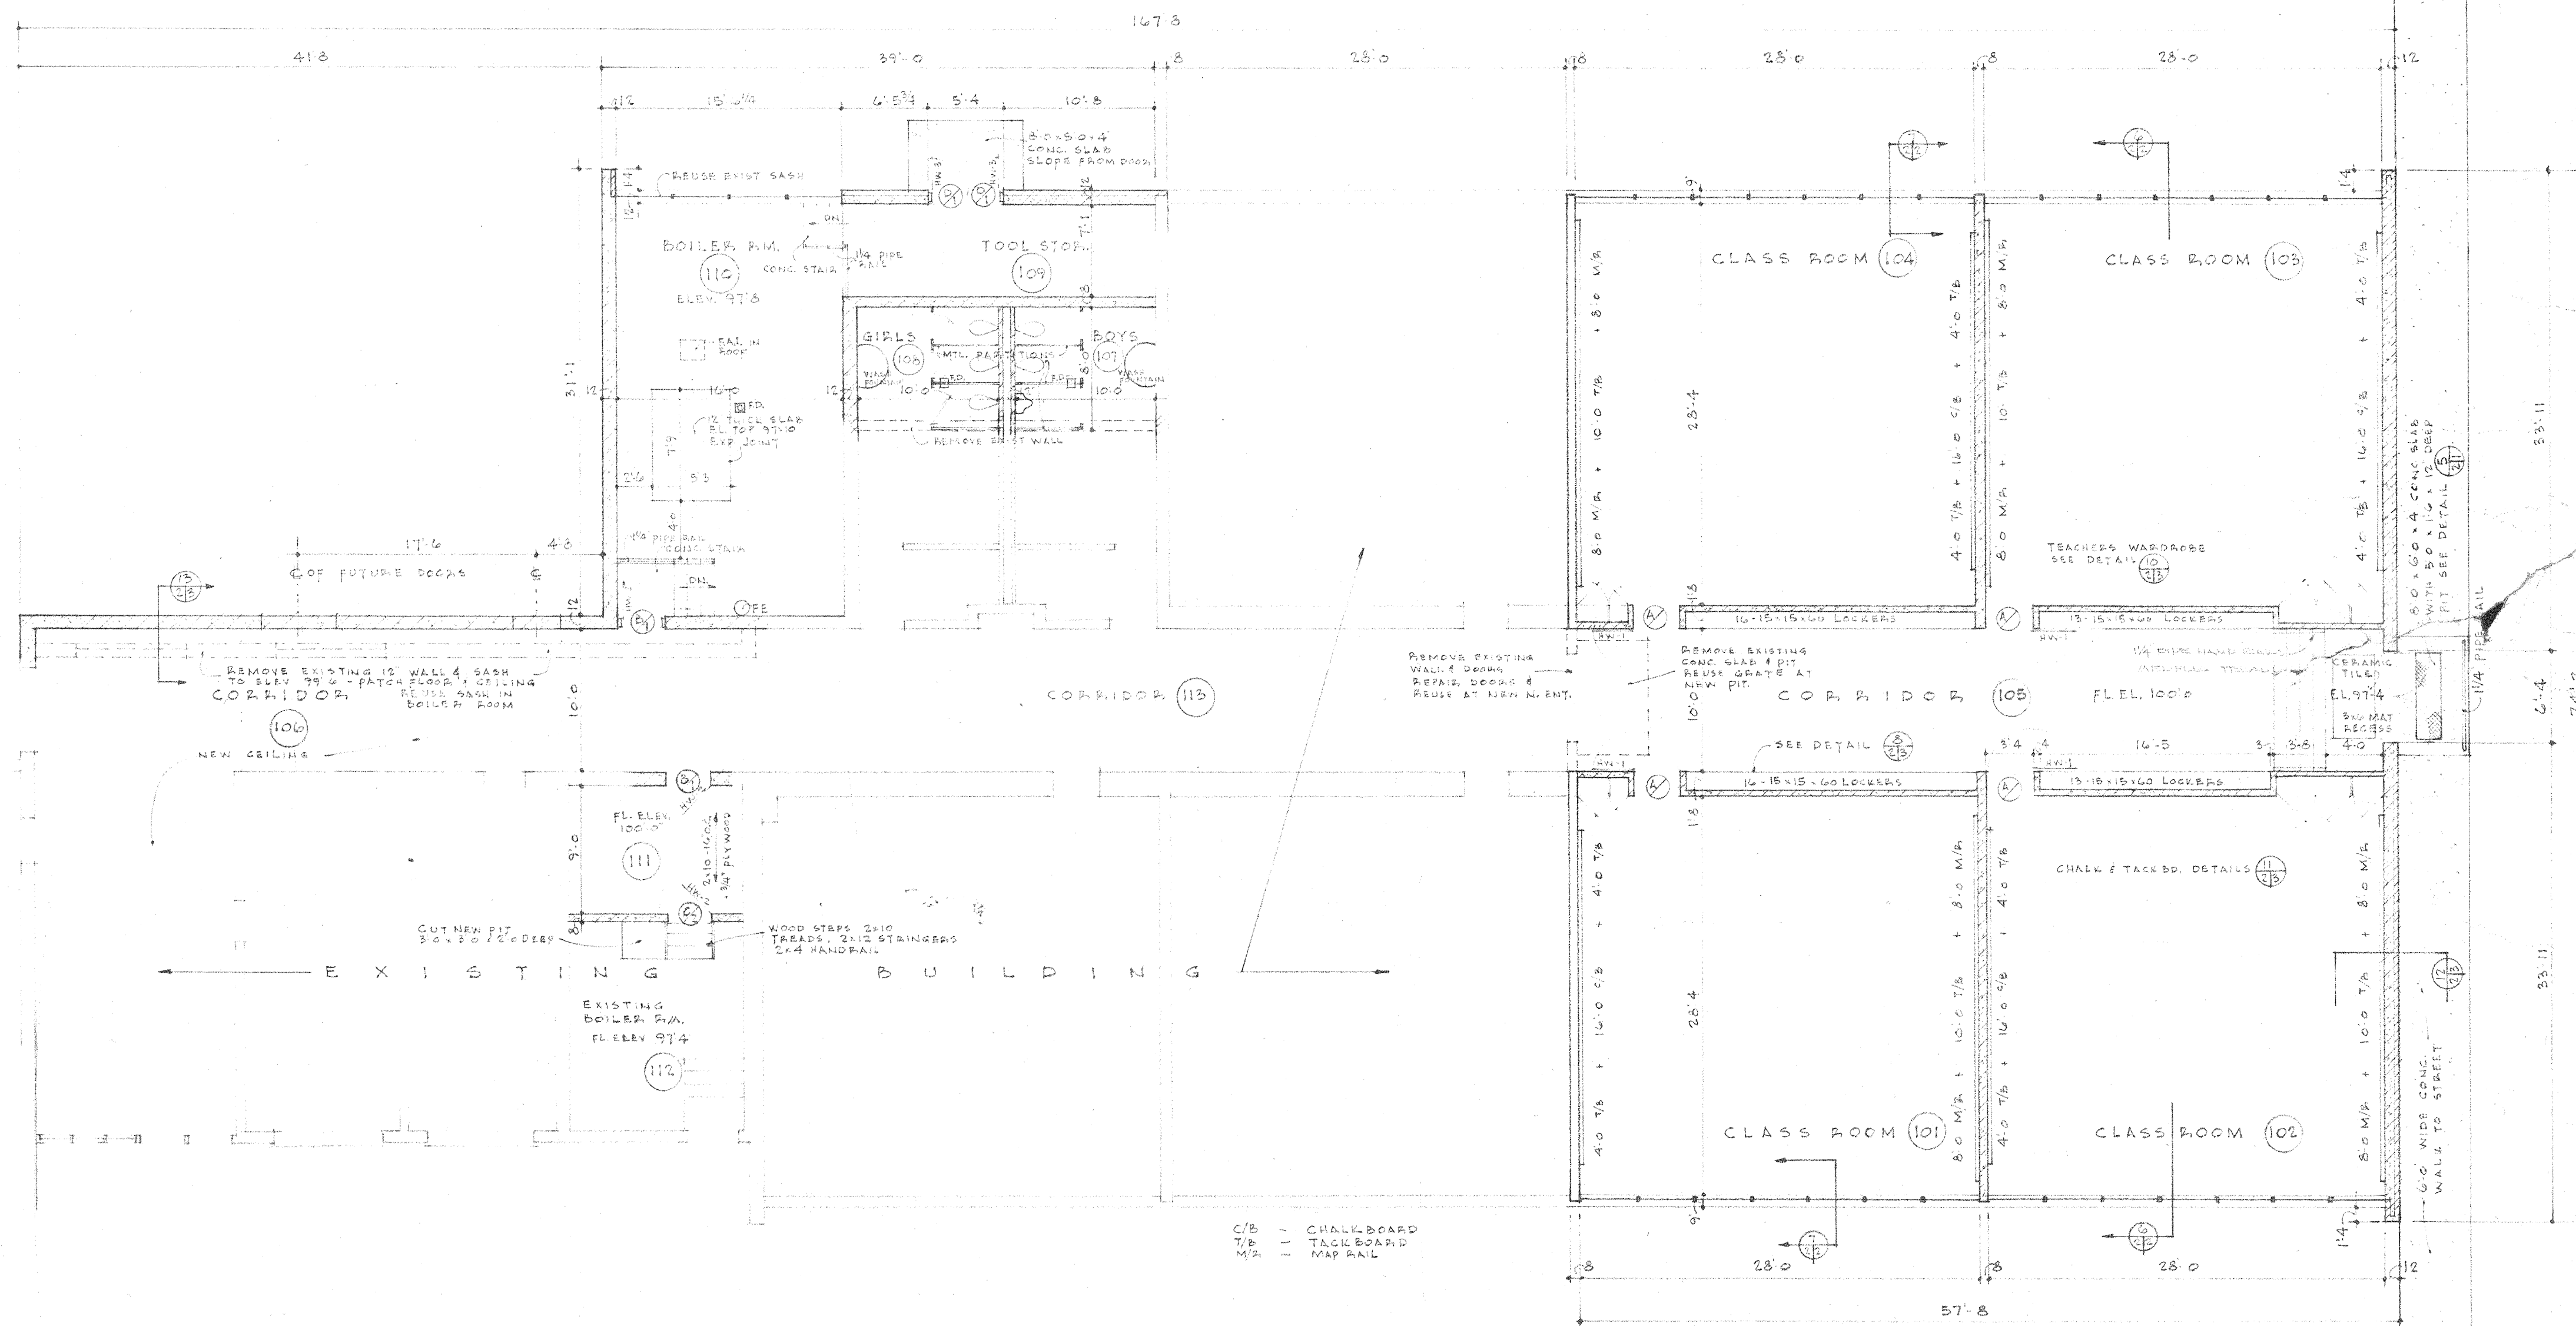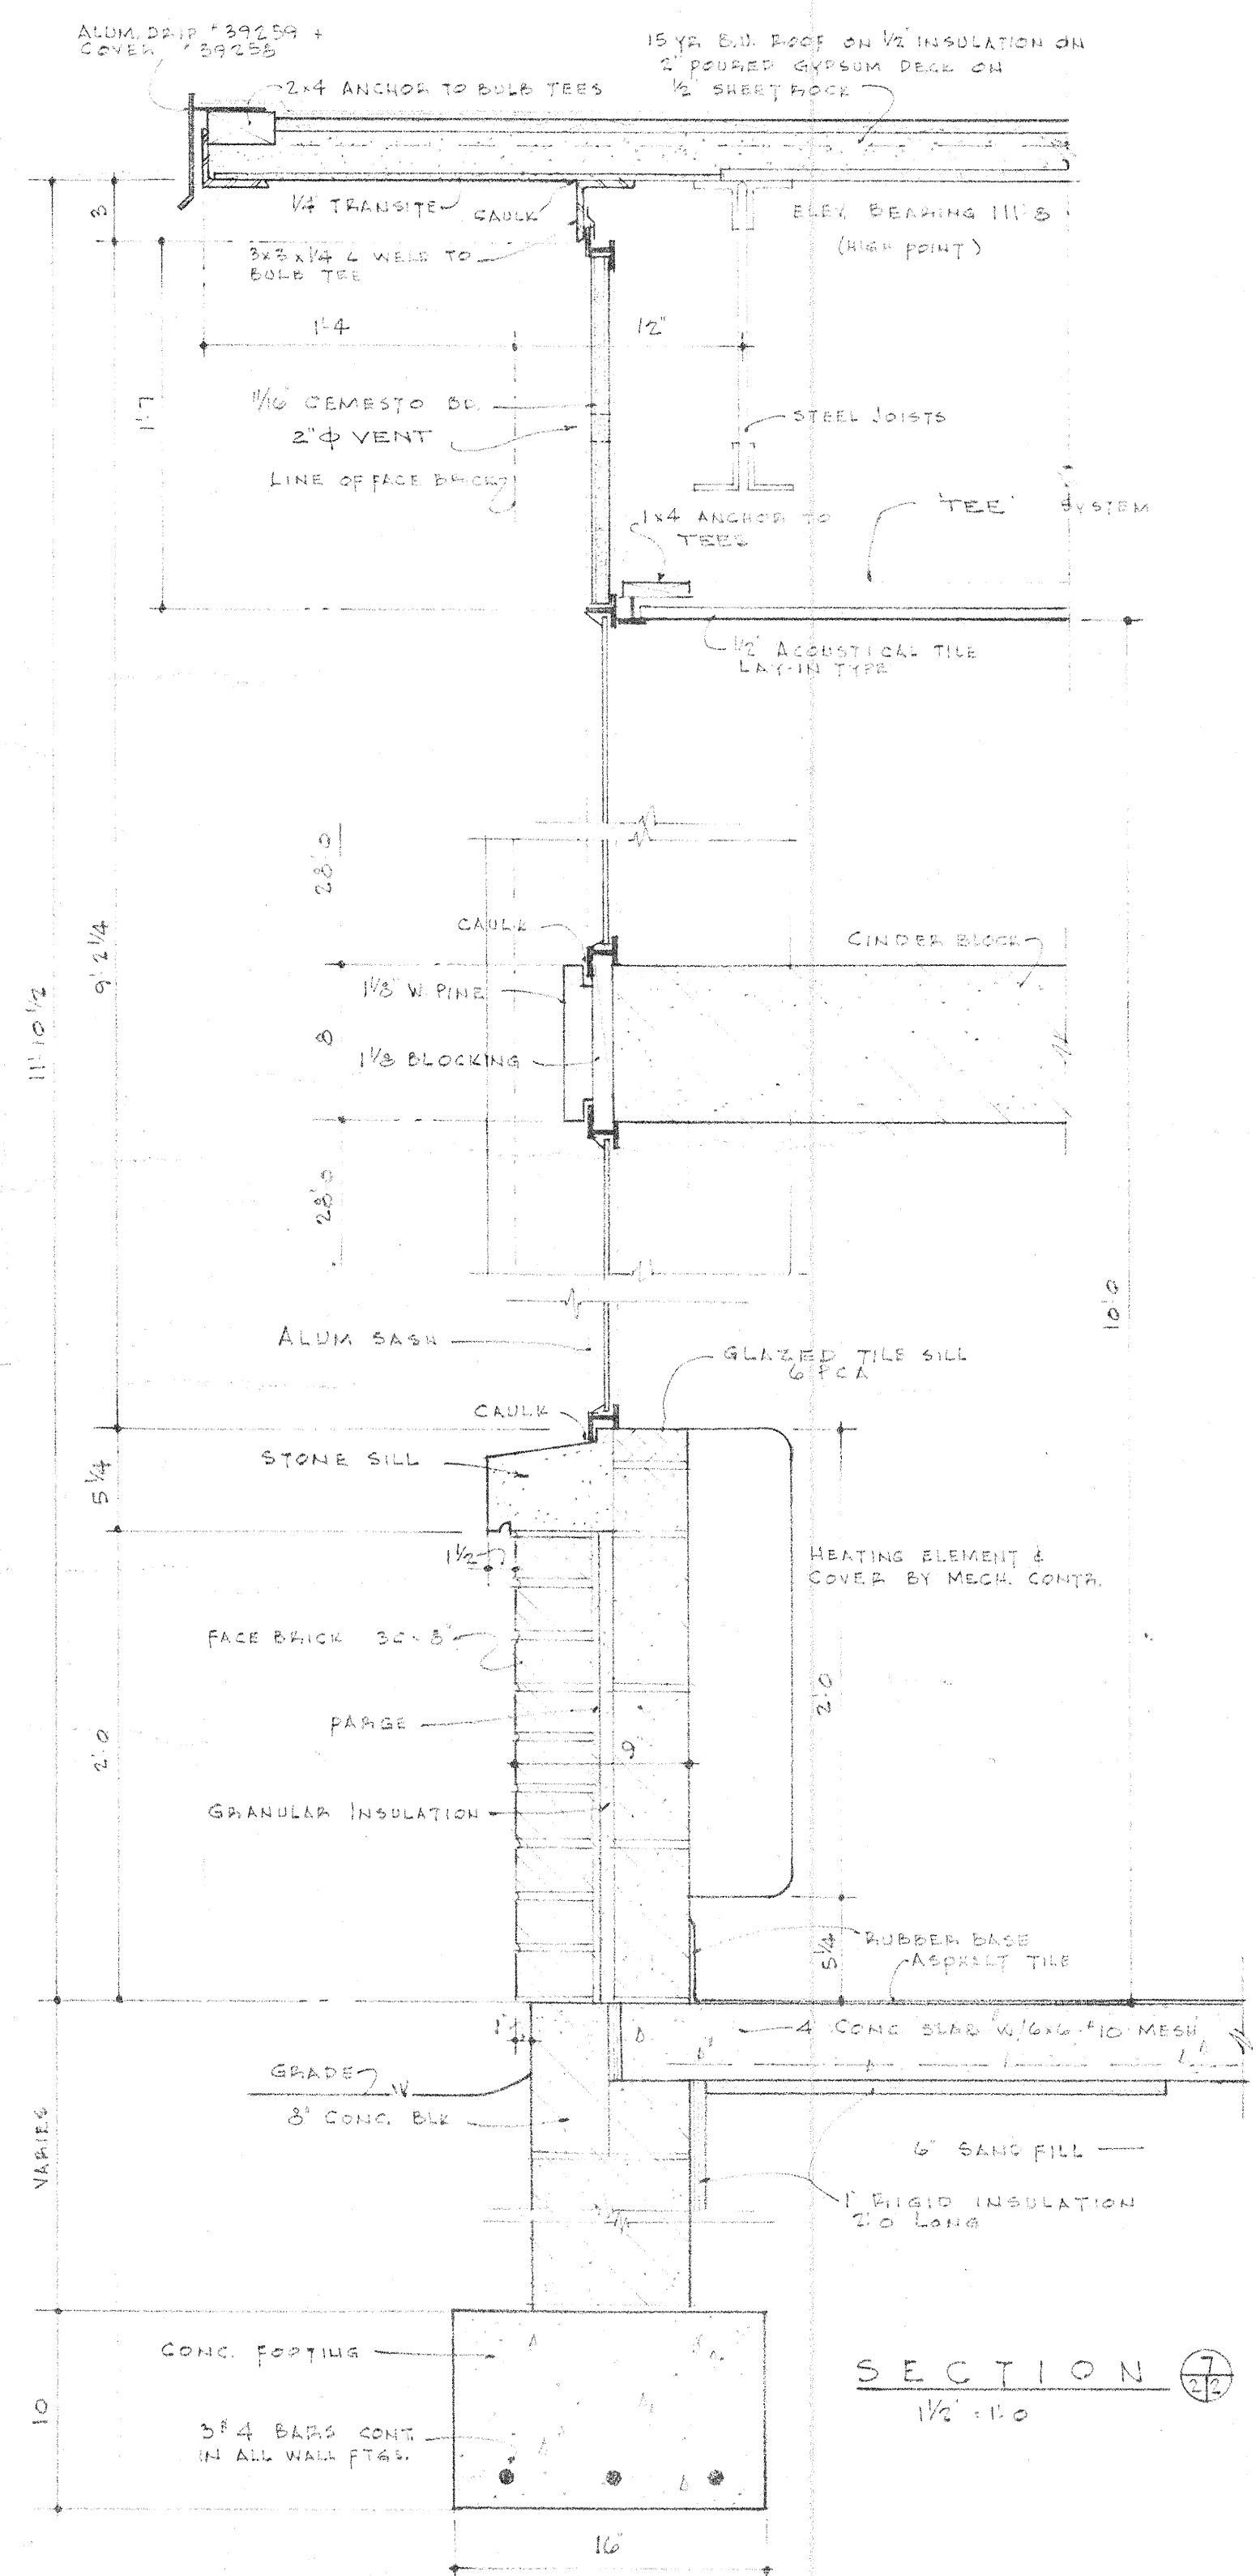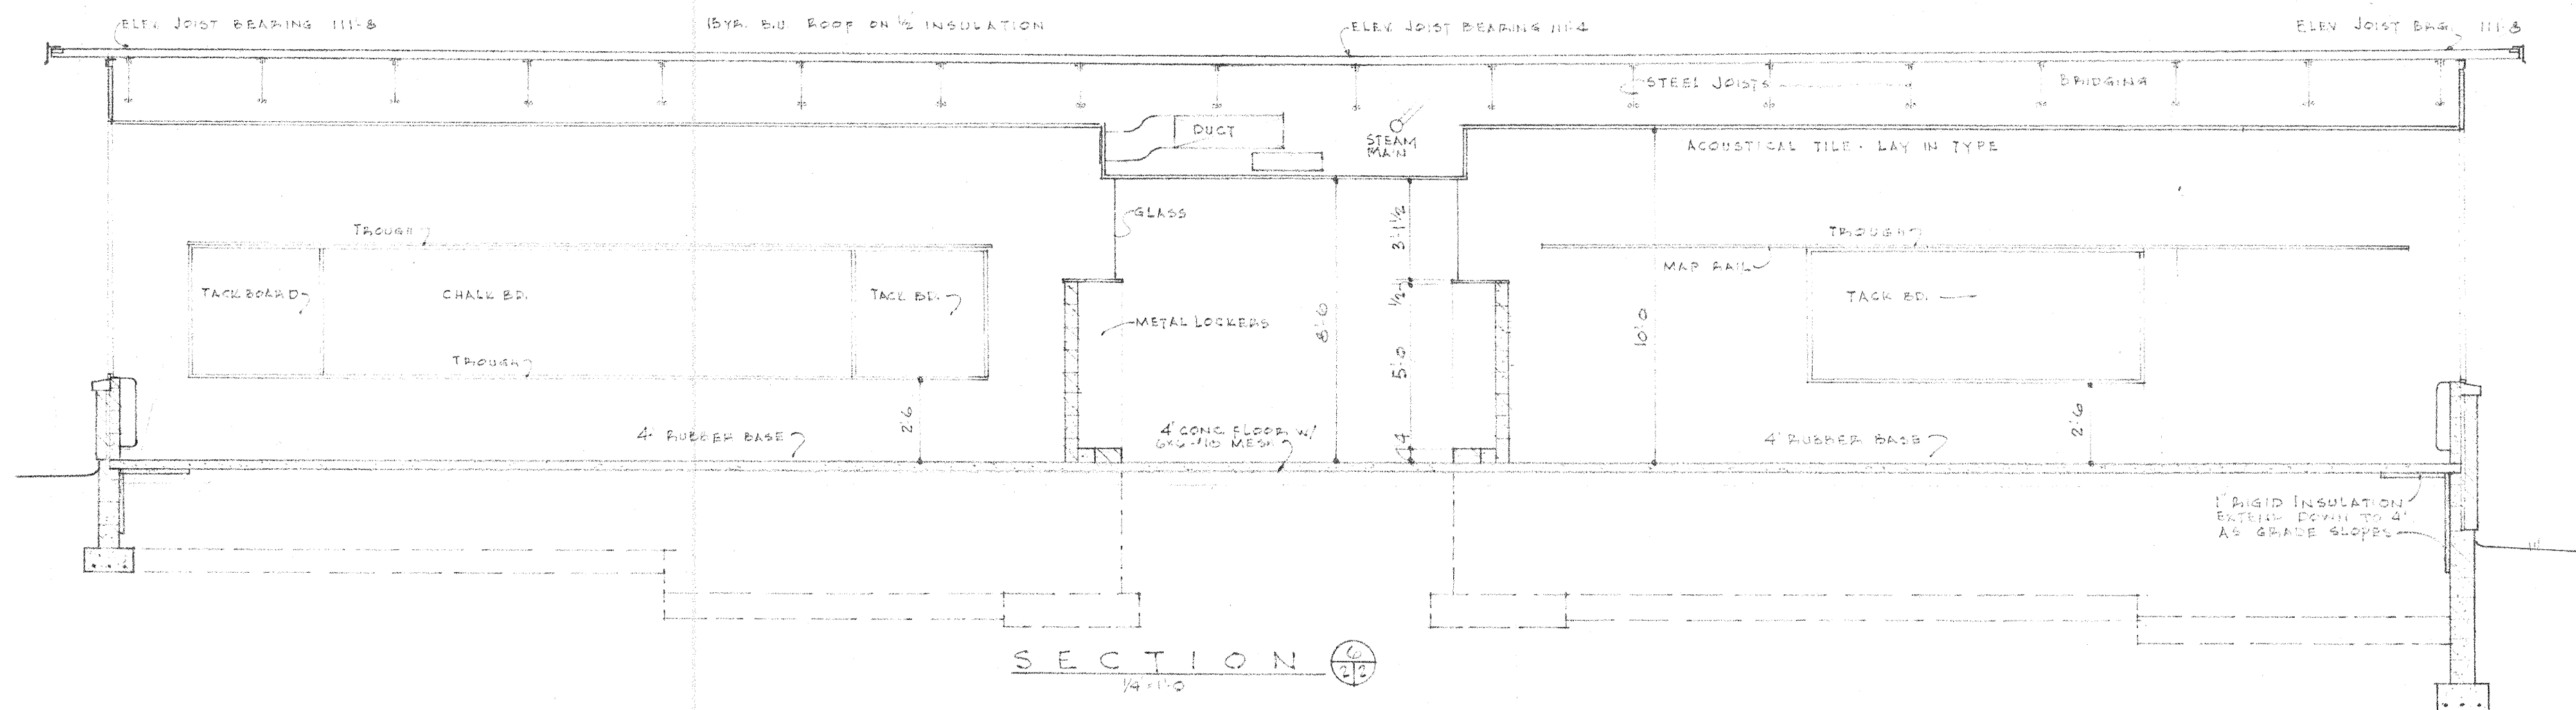

ROOM	NAME	FLOOR	BASE	WAINSCOT	WALLS	CEILING	DOORS	TRIM	REMARKS
101	CLASS RM								
102	CLASS RM								
103	CLASS RM								
104	CLASS RM								
105	CORRIDOR								
106	BOILER RM								
107	TOOL STORAGE								
108	GIRLS TOILET								
109	EXIST. BOILER RM								
110	STORAGE								
111	EXIST. BOILER RM								
112	CORRIDOR								

MARK	SIZE	TYPE	MATERIAL	REMARKS
A	3'0" x 7'0"	I	WOOD	
B	3'0" x 7'0"	II	GLASS - WOOD	
C	3'0" x 7'0"	II	GLASS - METAL	
D	2'6" x 7'0"	II	HOLLOW METAL	

OSHTEMO ELEM. SCHOOL PROPOSED ADDITION FOR OSHTEMO ELEM. SCHOOL		3-22-61 6:05	25
---	--	-----------------	----

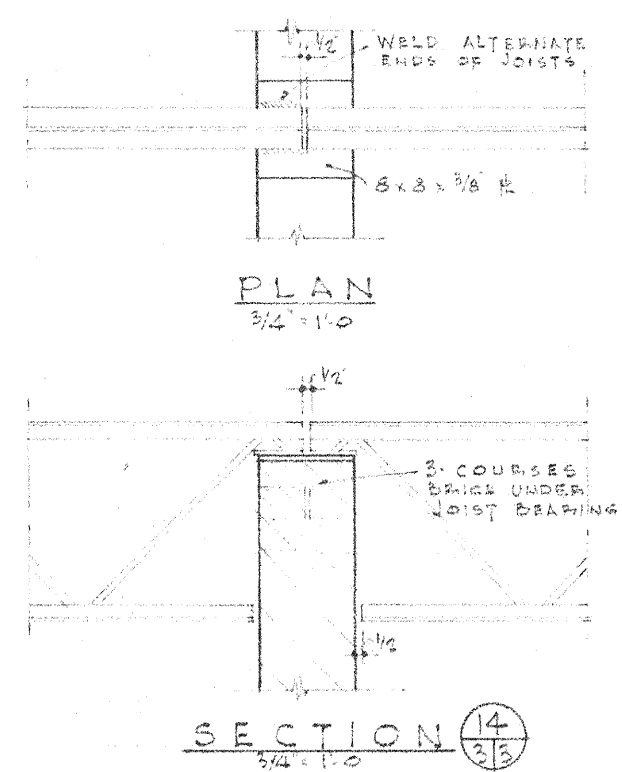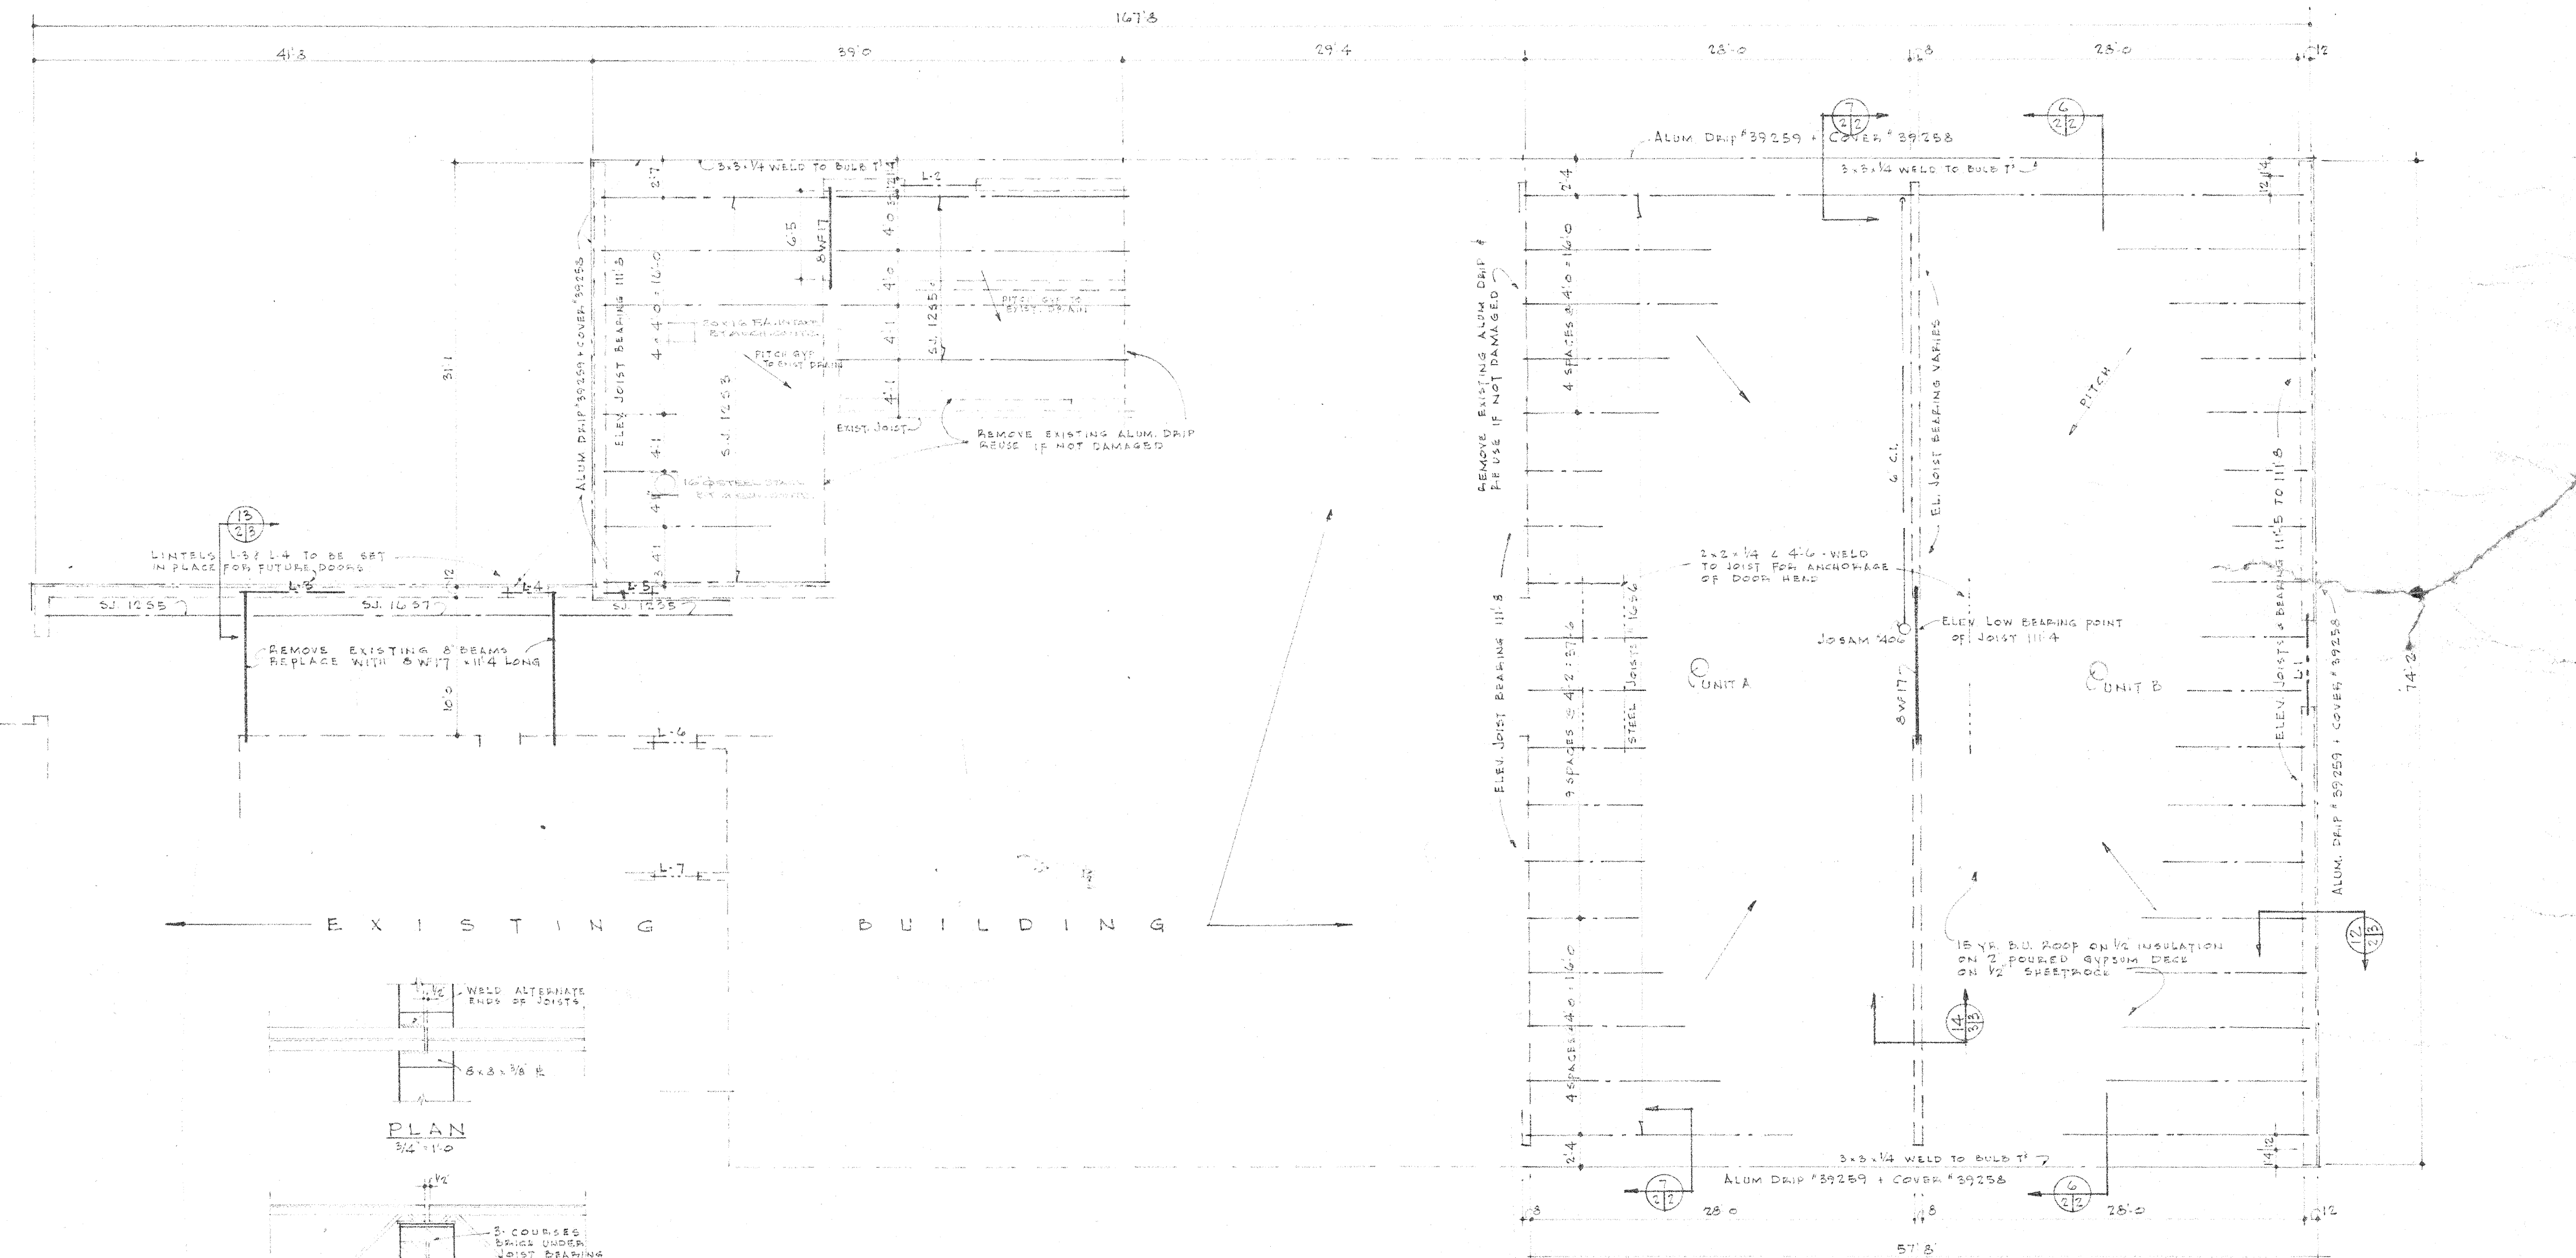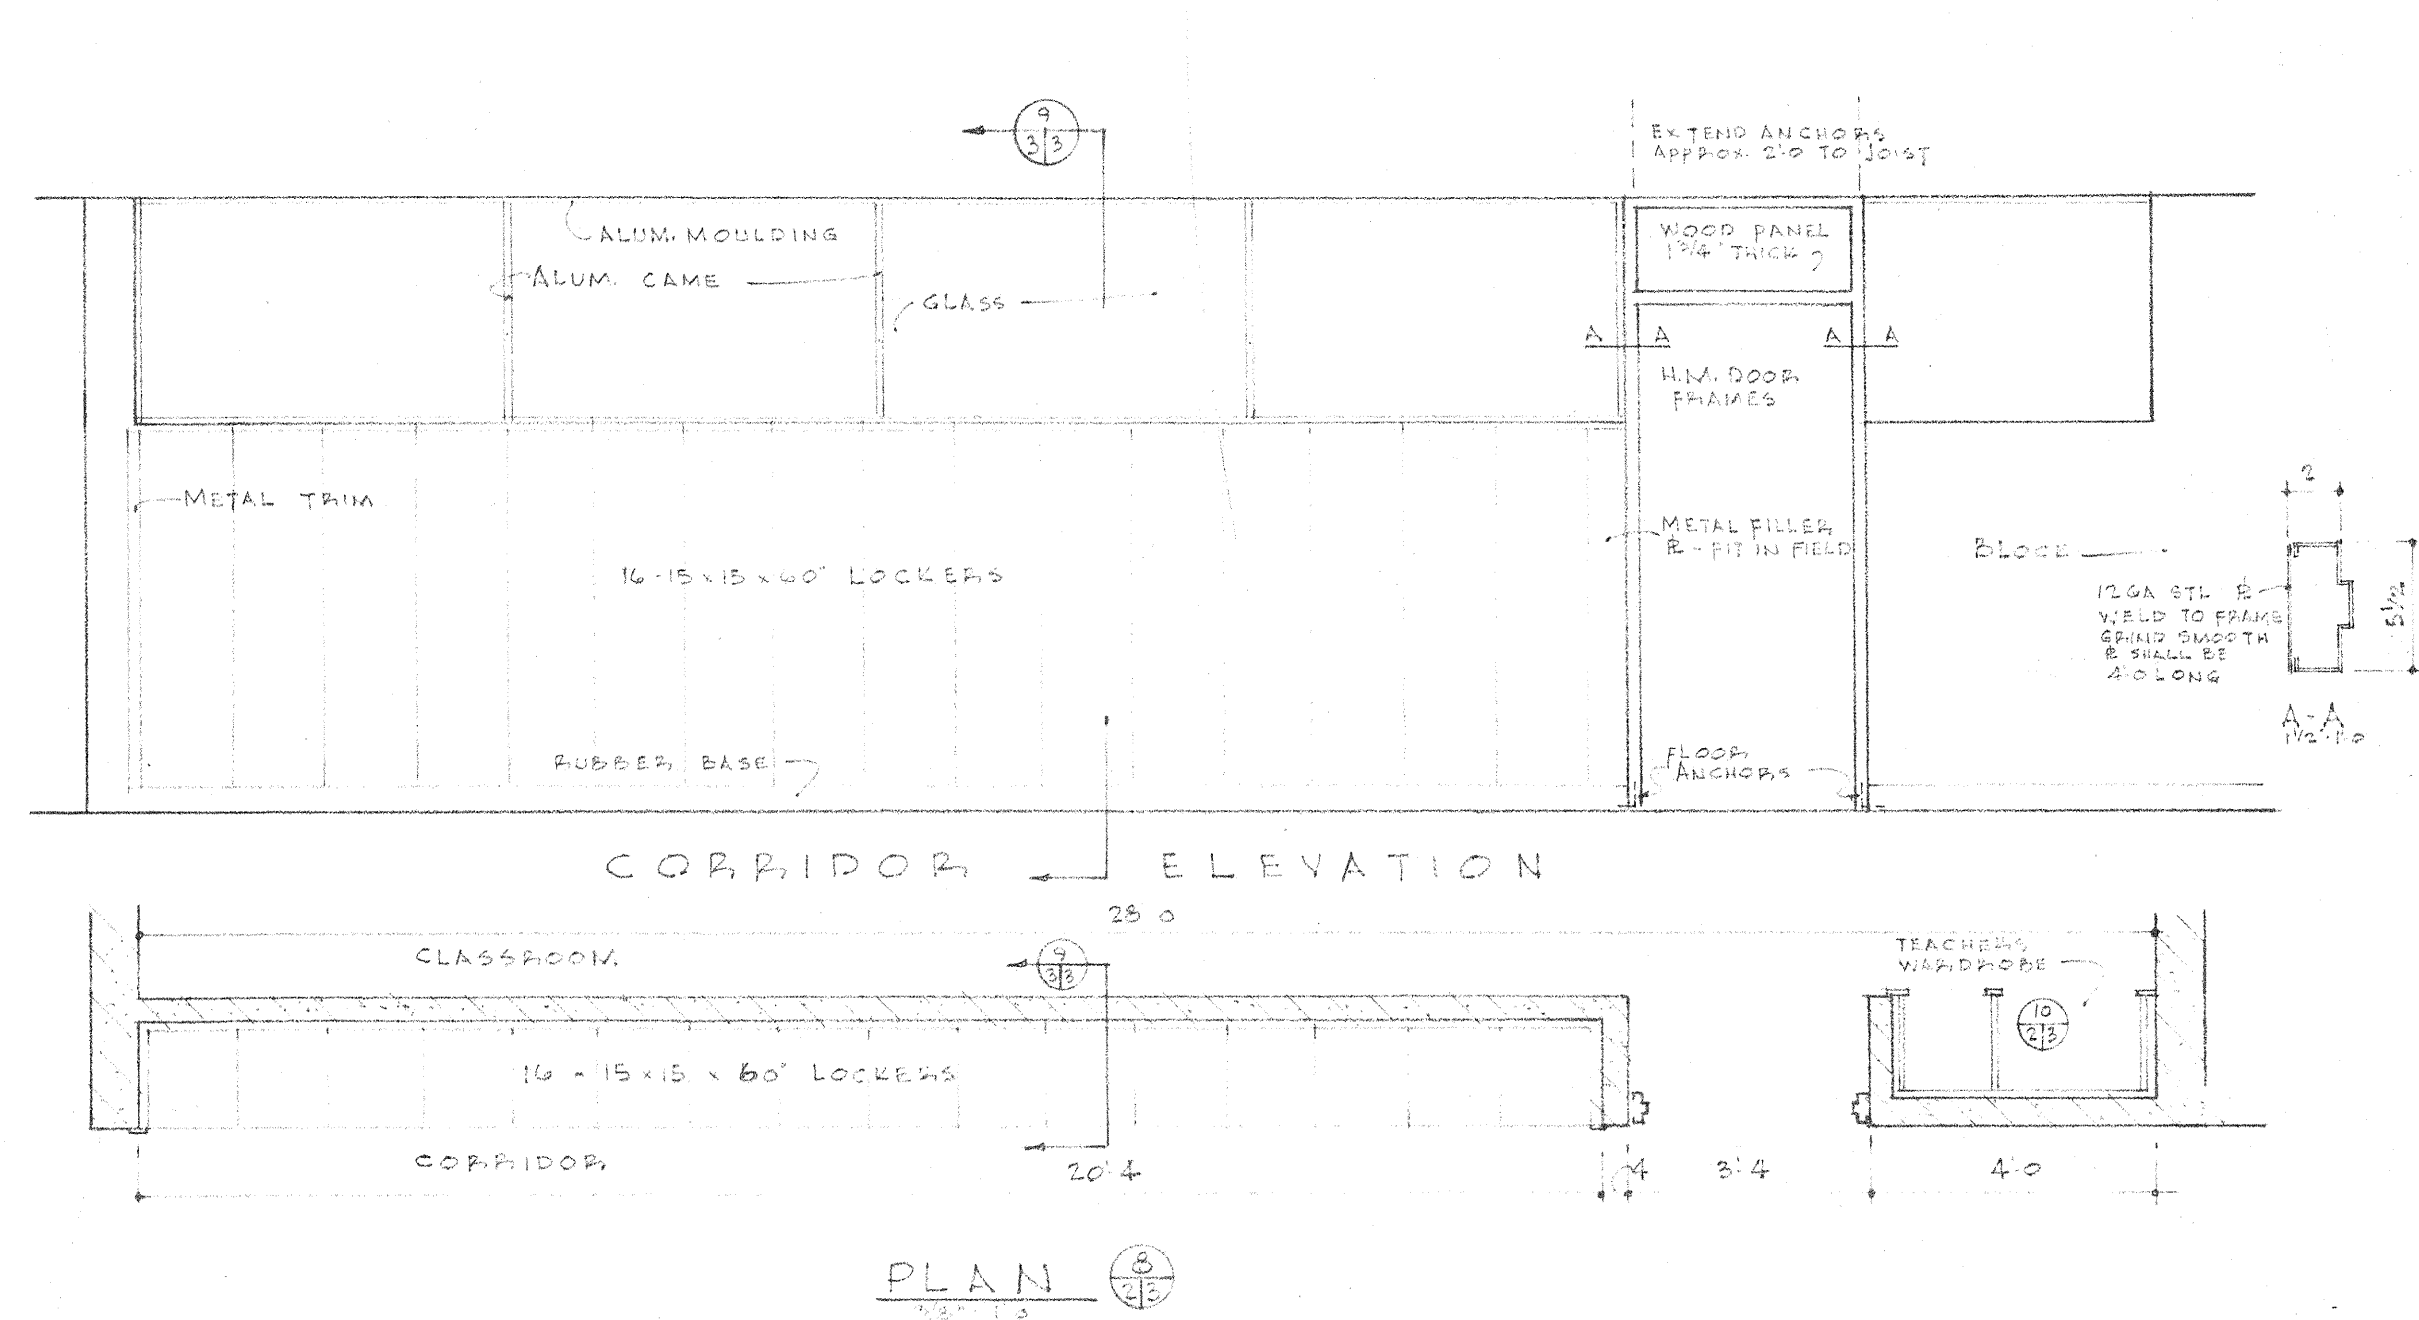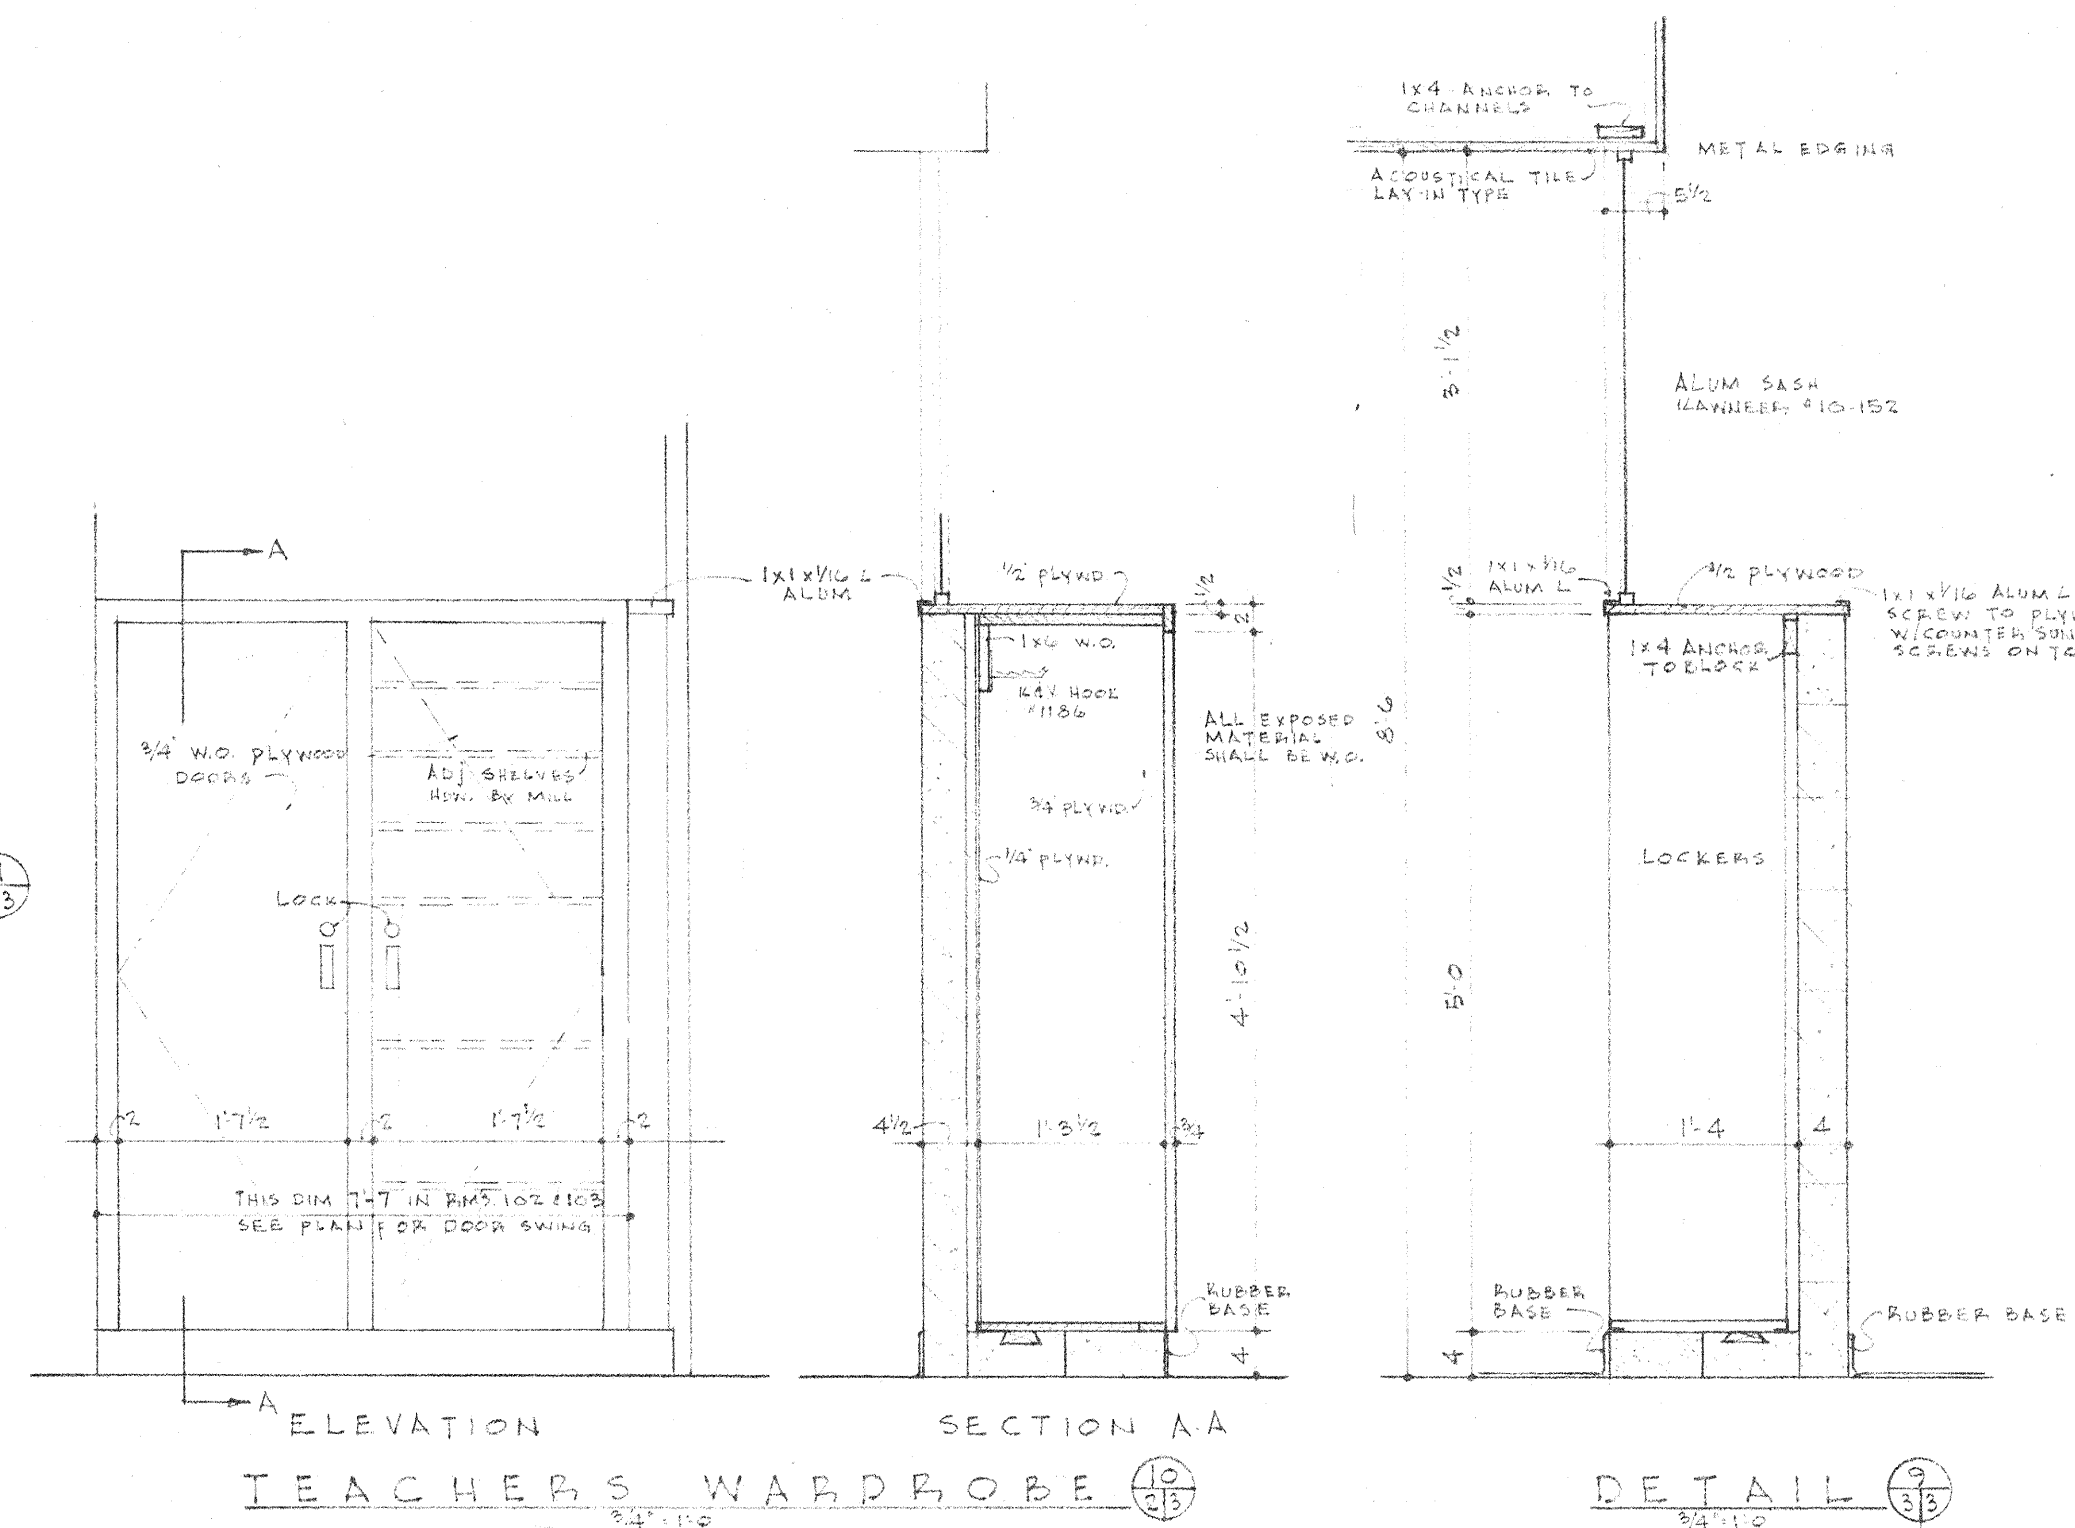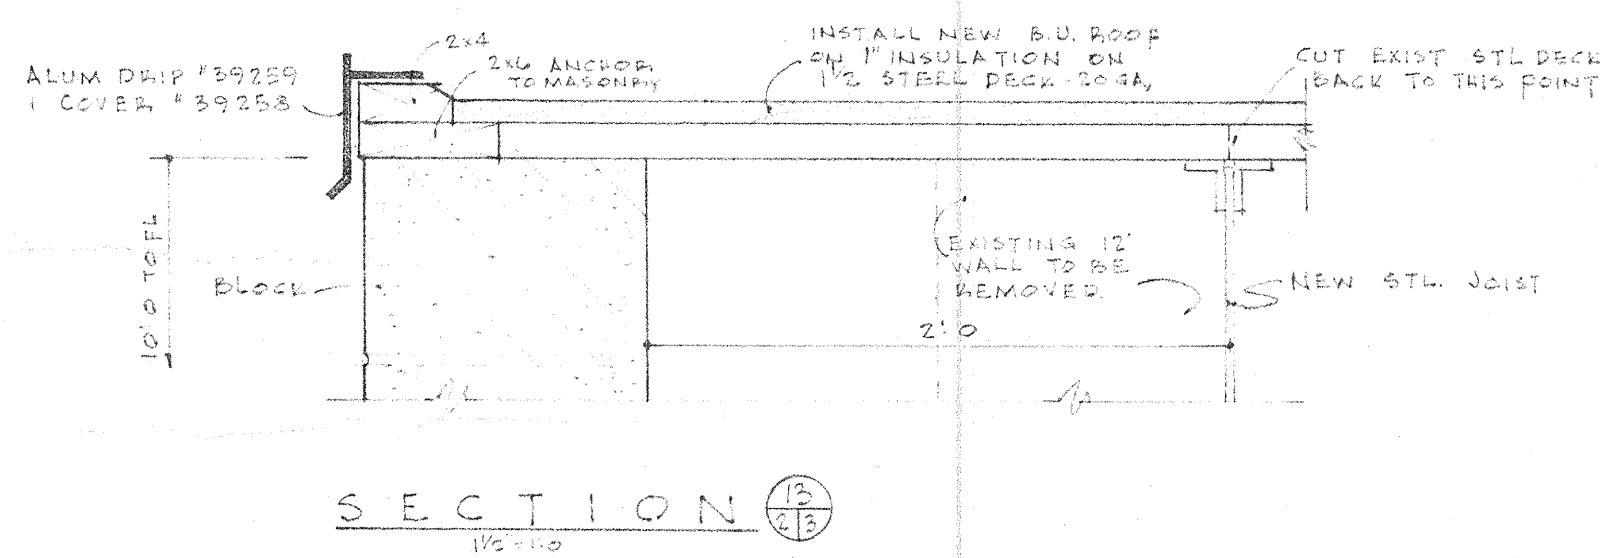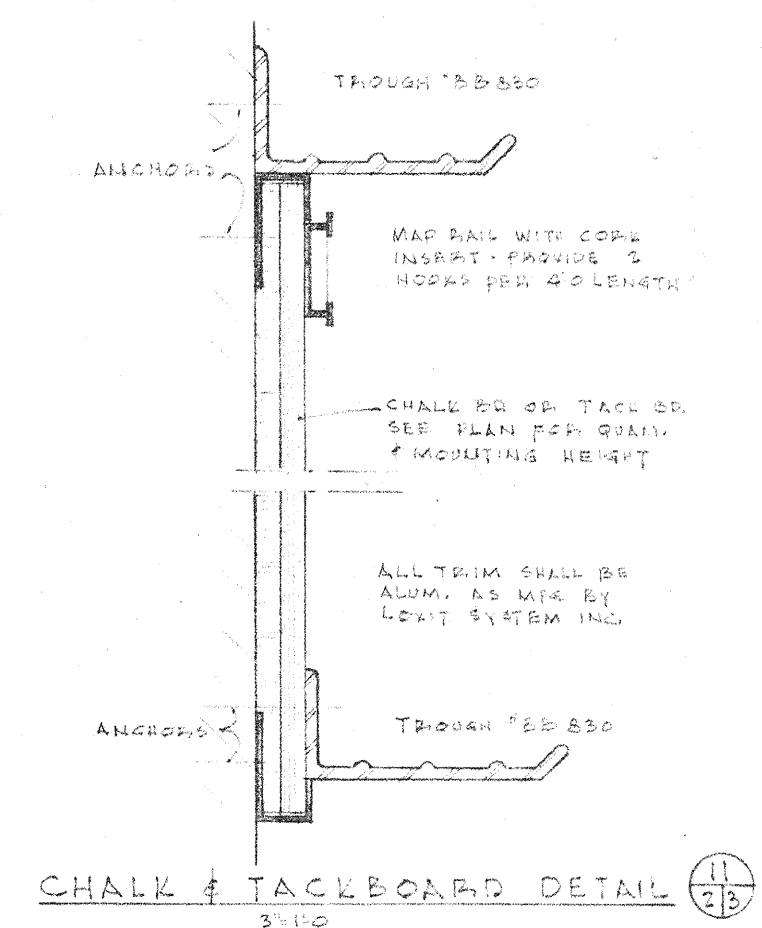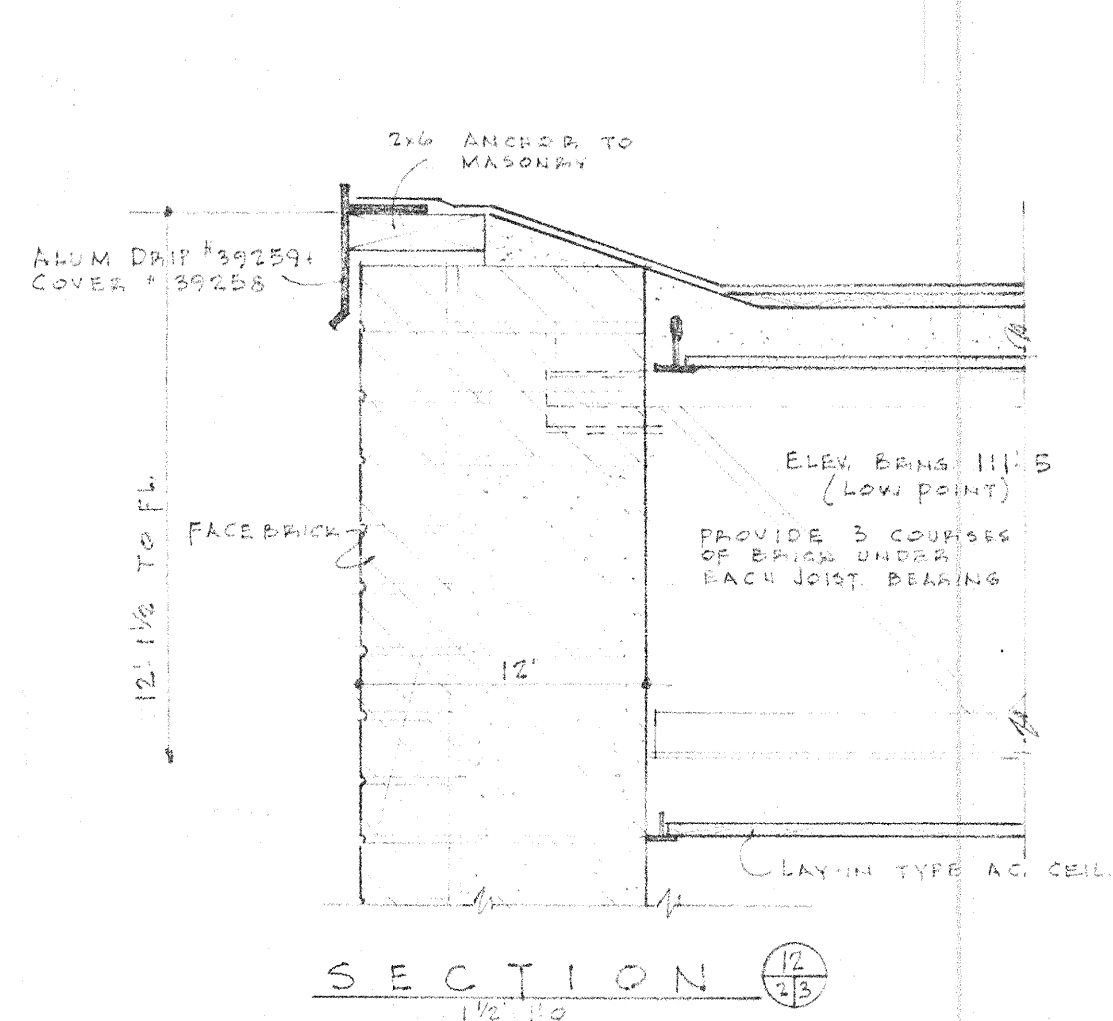

LINTEL SCHEDULE					G. LIEKEMA ARCHITECT		
MARK	SIZE	LENGTH	WALL THICKNESS		PROPOSED ADDITION		
L1	8" W/12" x 10" B	7'8"	12"	1	OSHTMO ELEM. SCHOOL		
L2	8" W/12" x 10" B	6'8"	12"	1	3-22-61		
L3	8" W/12" x 10" B	4'8"	12"	1	6105		
L4	8" W/12" x 10" B	4'8"	12"	1			
L5	8" W/12" x 10" B	4'8"	12"	1			
L6	8" W/12" x 10" B	4'8"	12"	1			
L7	8" W/12" x 10" B	4'8"	12"	1			
L8	8" W/12" x 10" B	4'8"	12"	1			
L9	8" W/12" x 10" B	4'8"	12"	1			