



FINISH SCHEDULE											
ROOM	NAME	FLOOR	BASE	WAINSCOT	WALLS	CEILING	DOORS	TRIM	REMARKS		
101	CORRIDOR								PAINT WD PARTITION AT EAST END		
102	CORRIDOR										
103	CLASS RM.										
104	CLASS RM.										
105	CLASS RM.										
106	WASH RM.										
107	BOYS										
108	GIRLS										
109	WASH RM.										


DOOR SCHEDULE											
MARK	SIZE	TYPE	DOOR	FRAME	JAMB	HEAD	REMARKS				
1	36" x 70" 1/4"	A	H.M.	H.M.	I	2	ERM MOLLION				
2	36" x 70" 1/4"	B	W.D.	H.M.	I	3					
3	36" x 70" 1/4"	C	W.D.	H.M.	II	1					
4	36" x 70" 1/4"	D	H.M.	H.M.	II	1	S. L. L. L.				

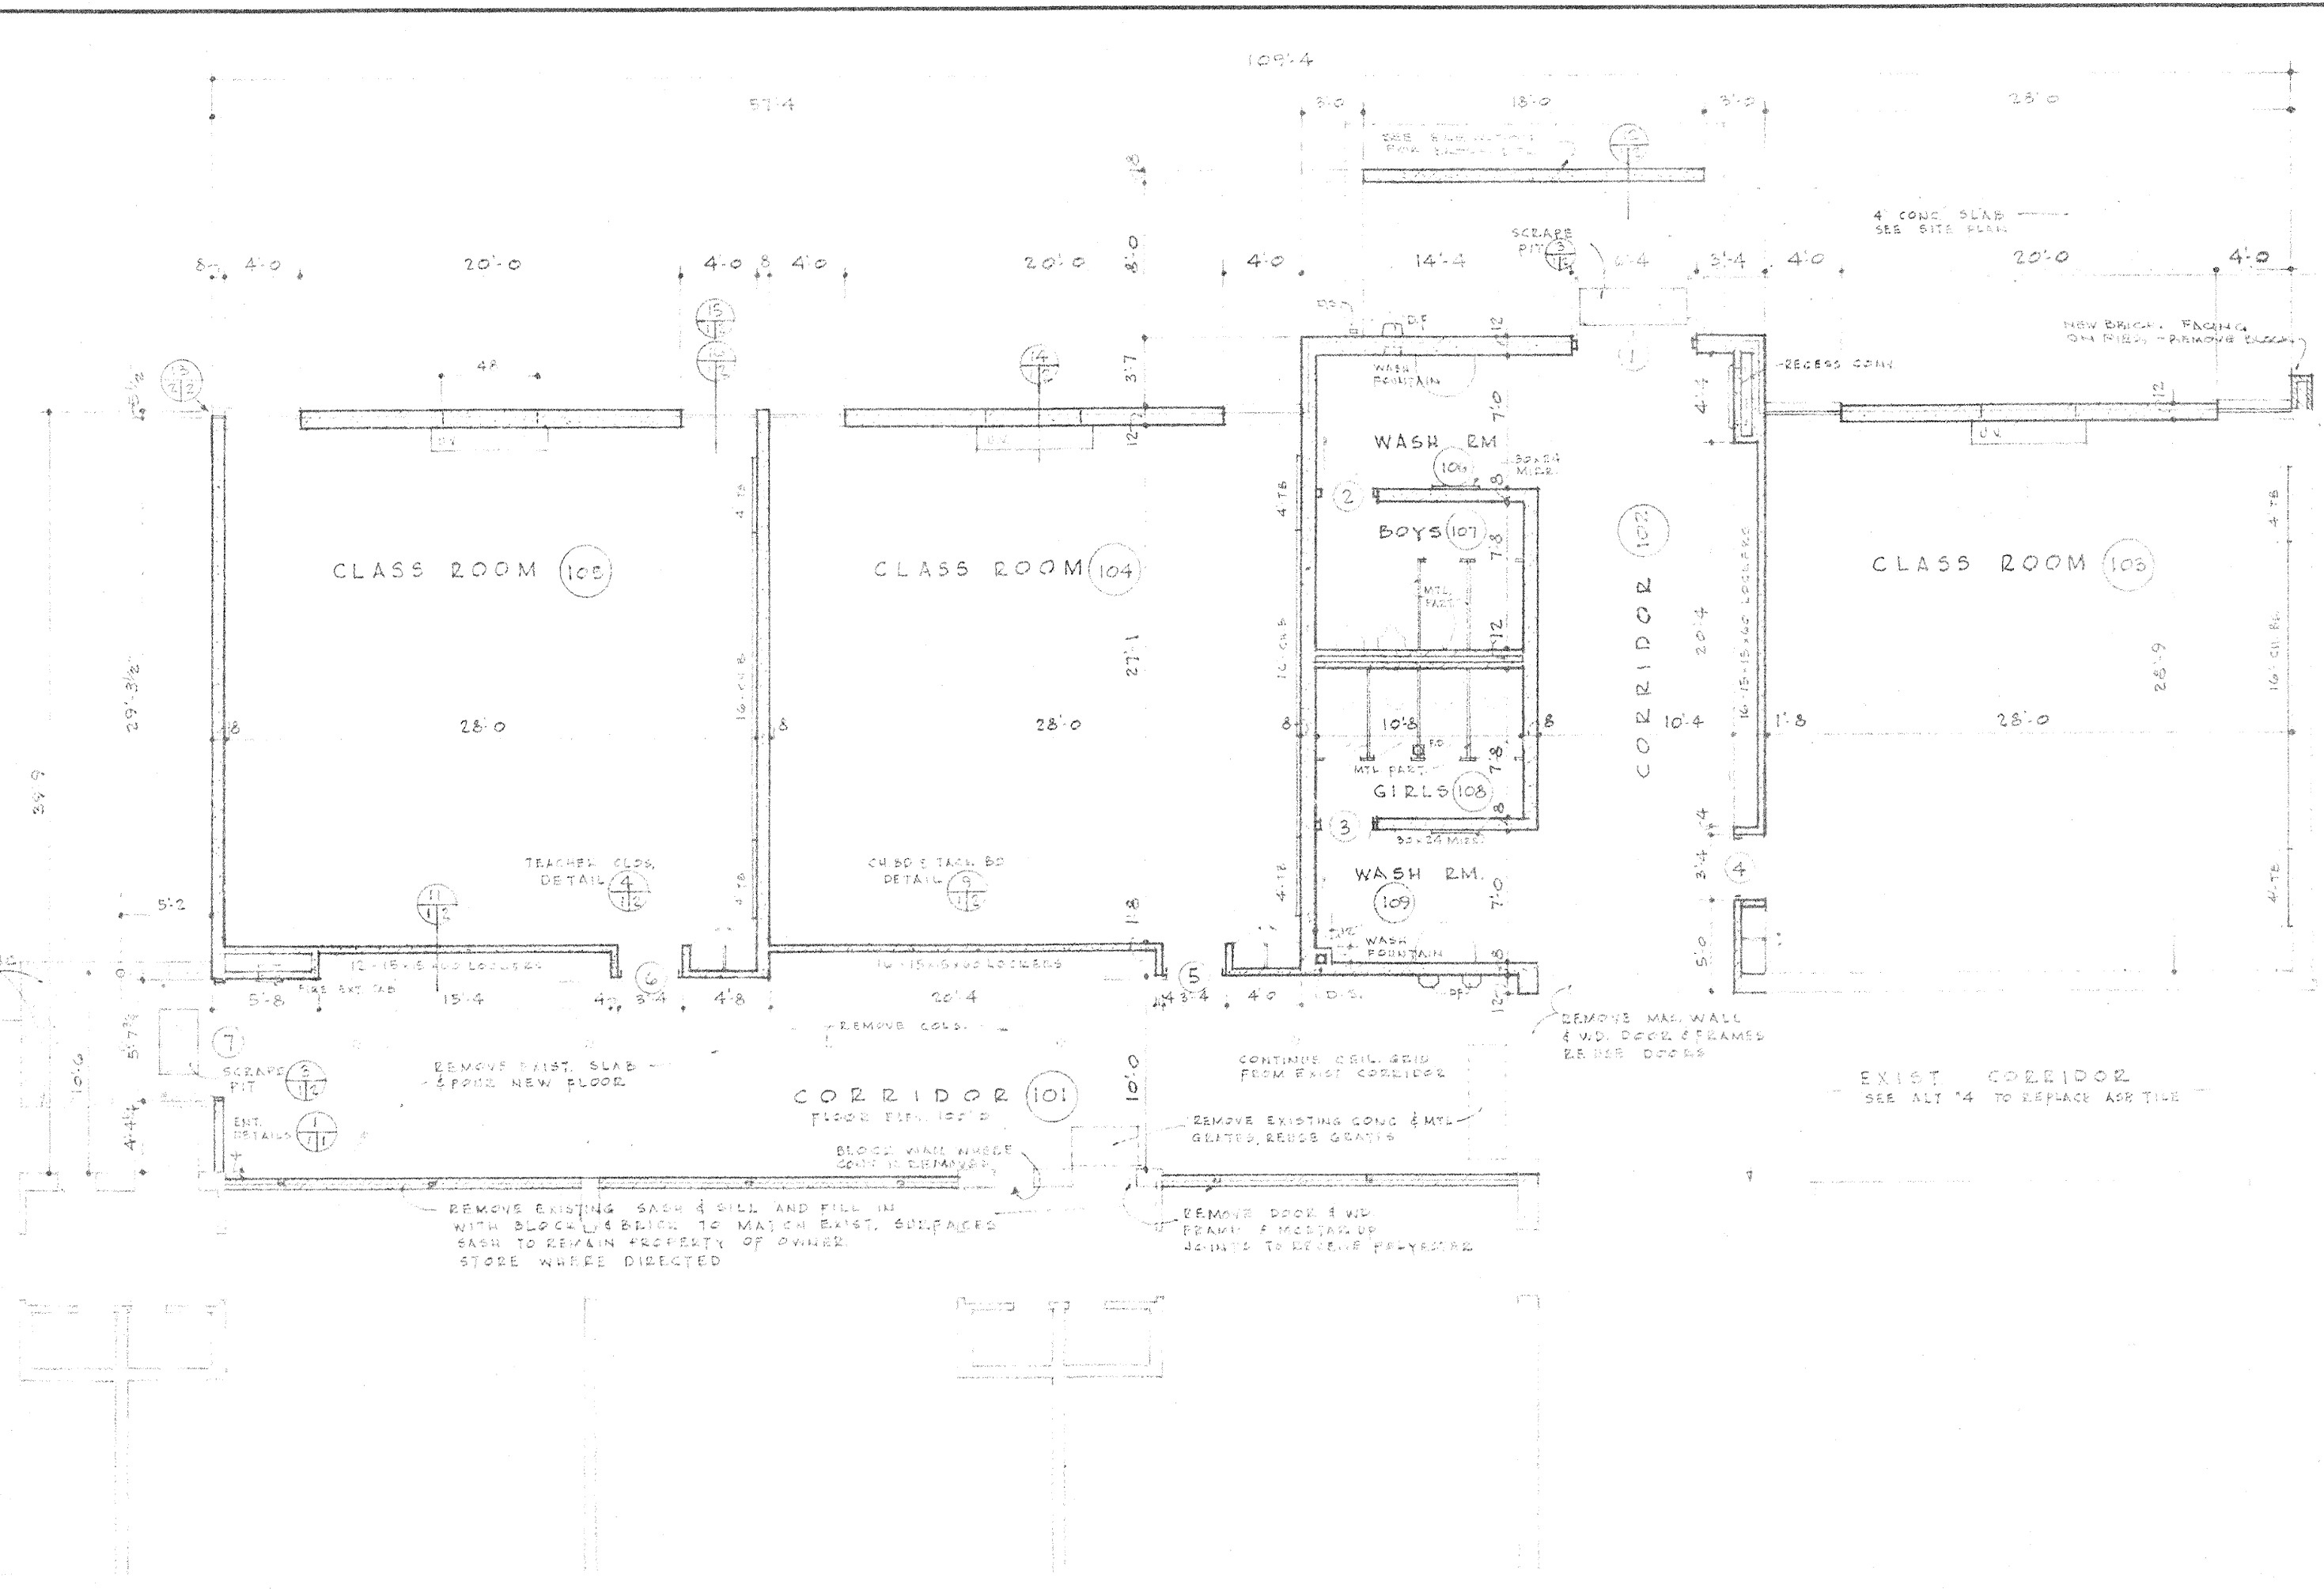


FLOOR PLAN 1/8" = 1'-0"

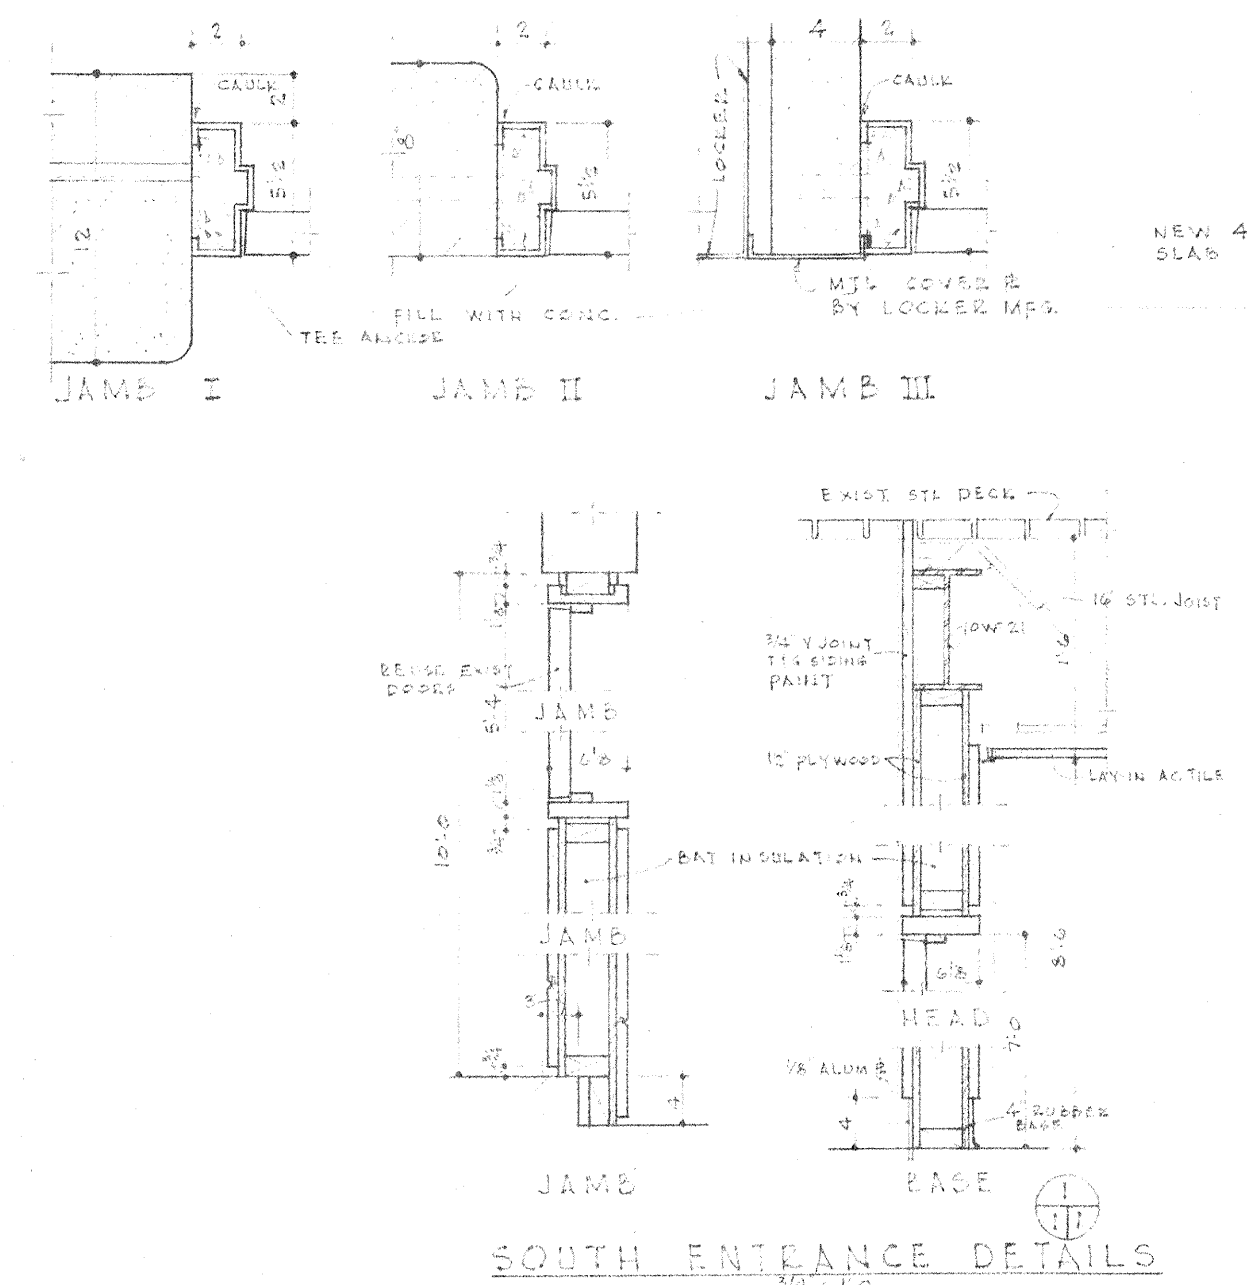


SOUTH ENTRANCE DETAILS 1/8" = 1'-0"

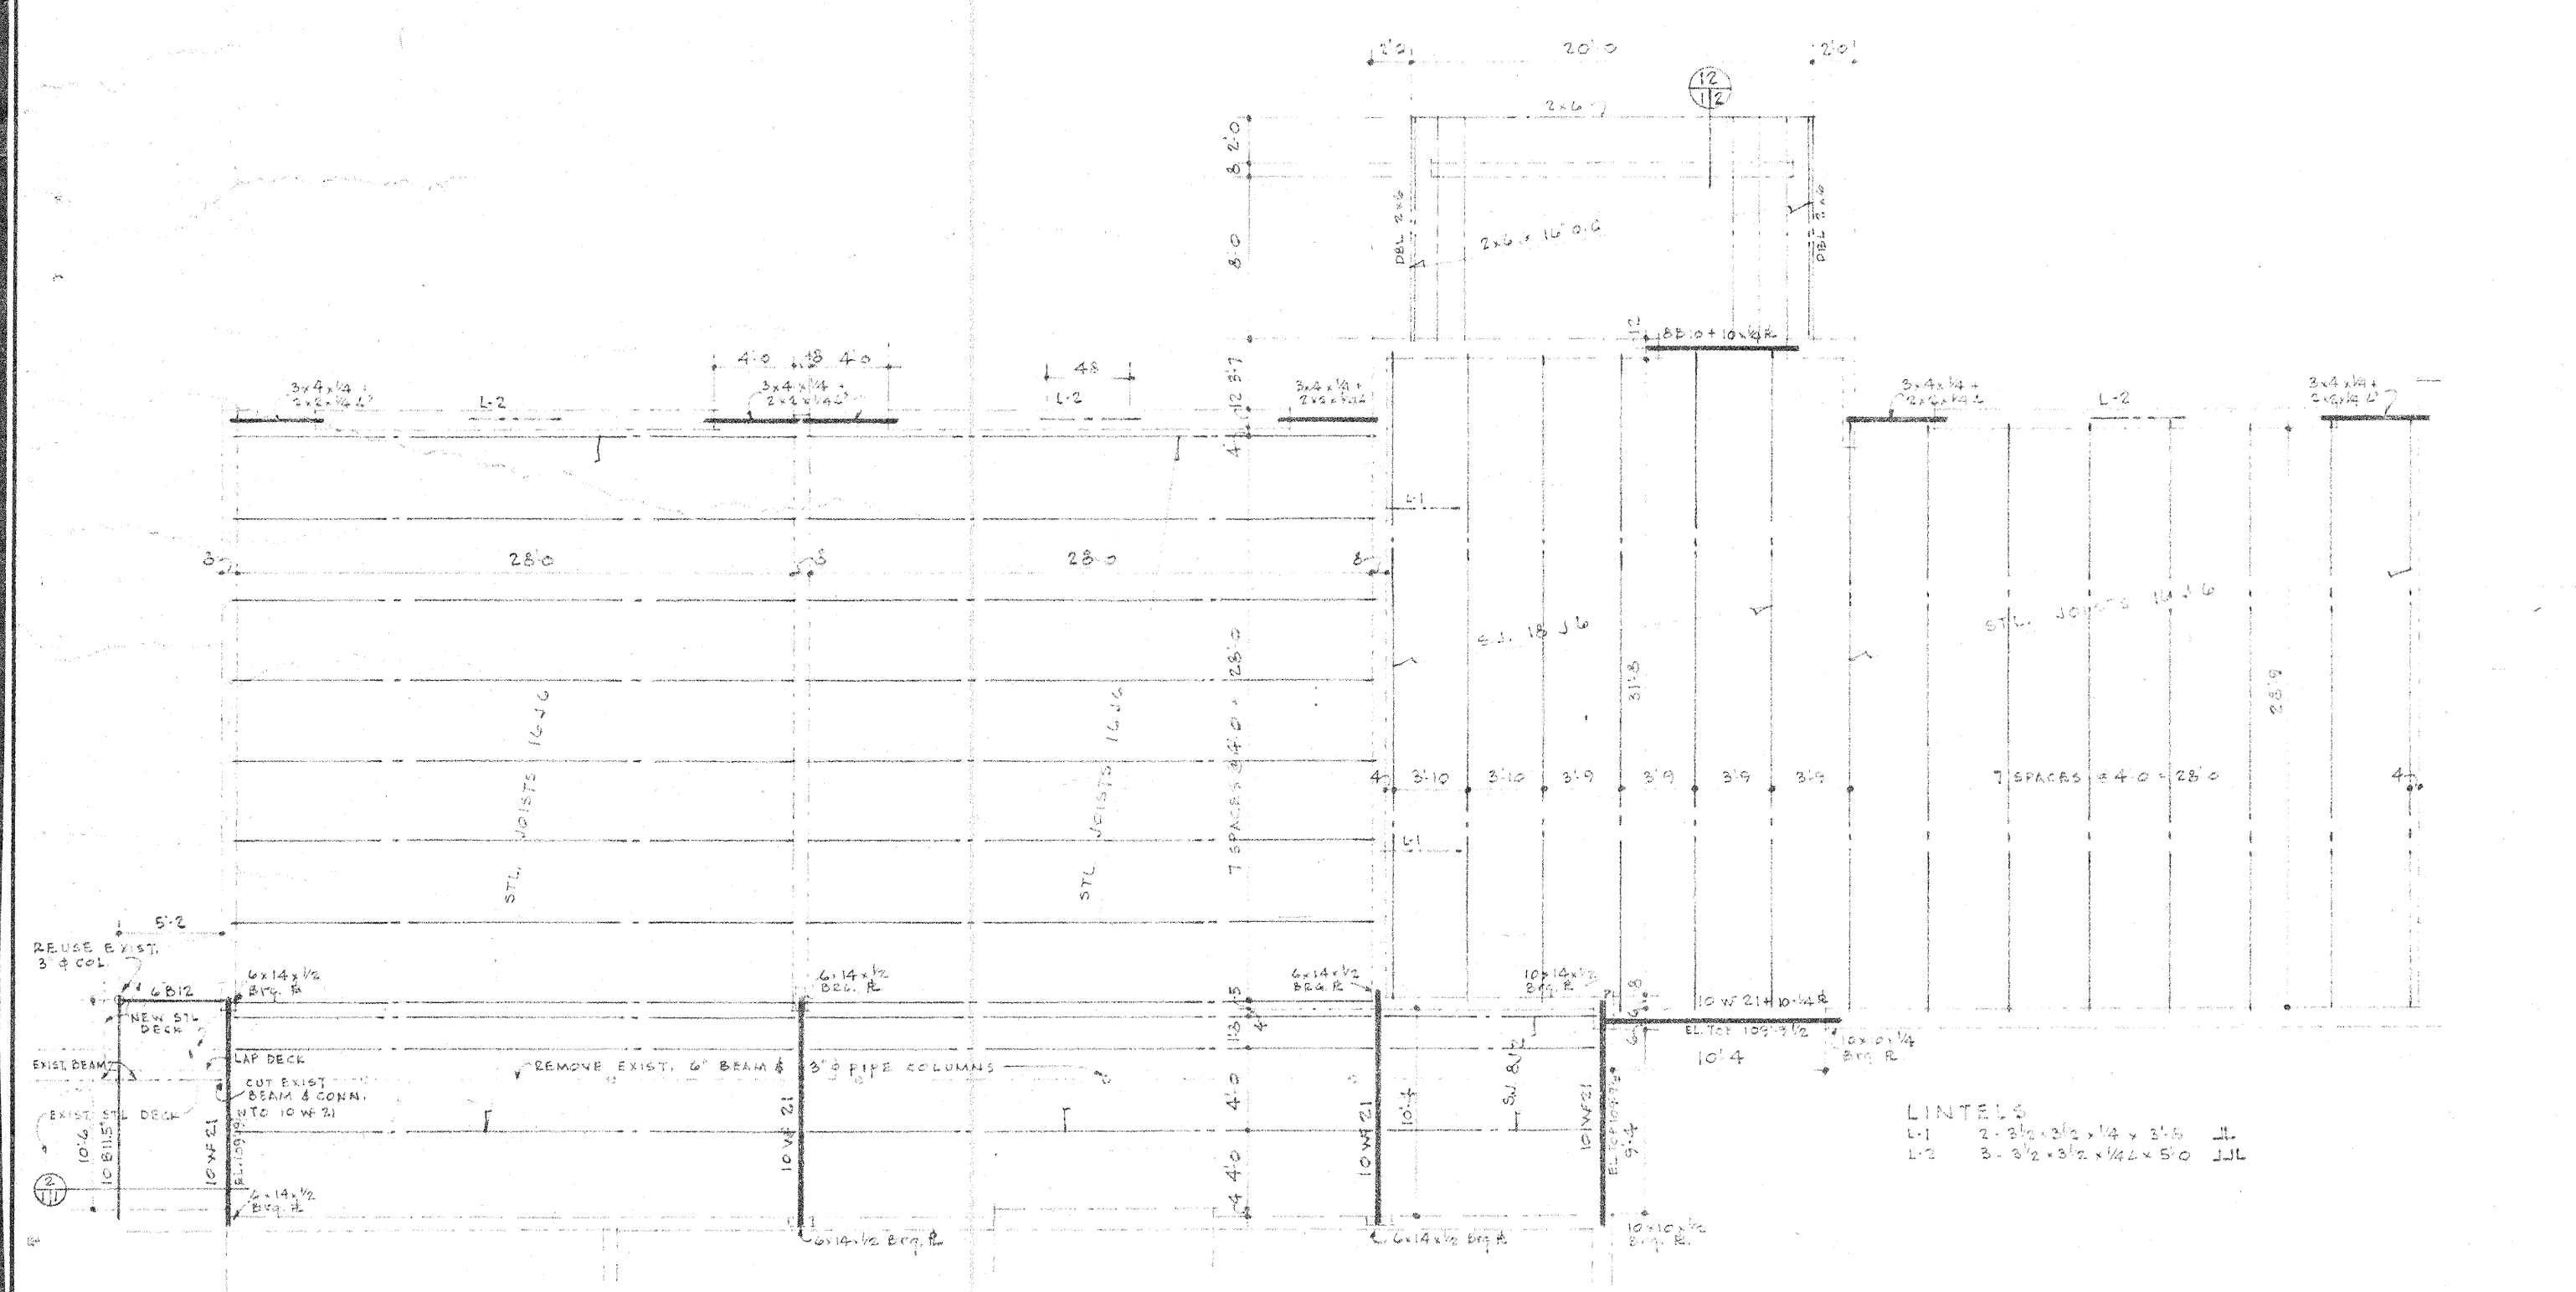


STRUCTURAL FRAMING PLAN 1/8" = 1'-0"

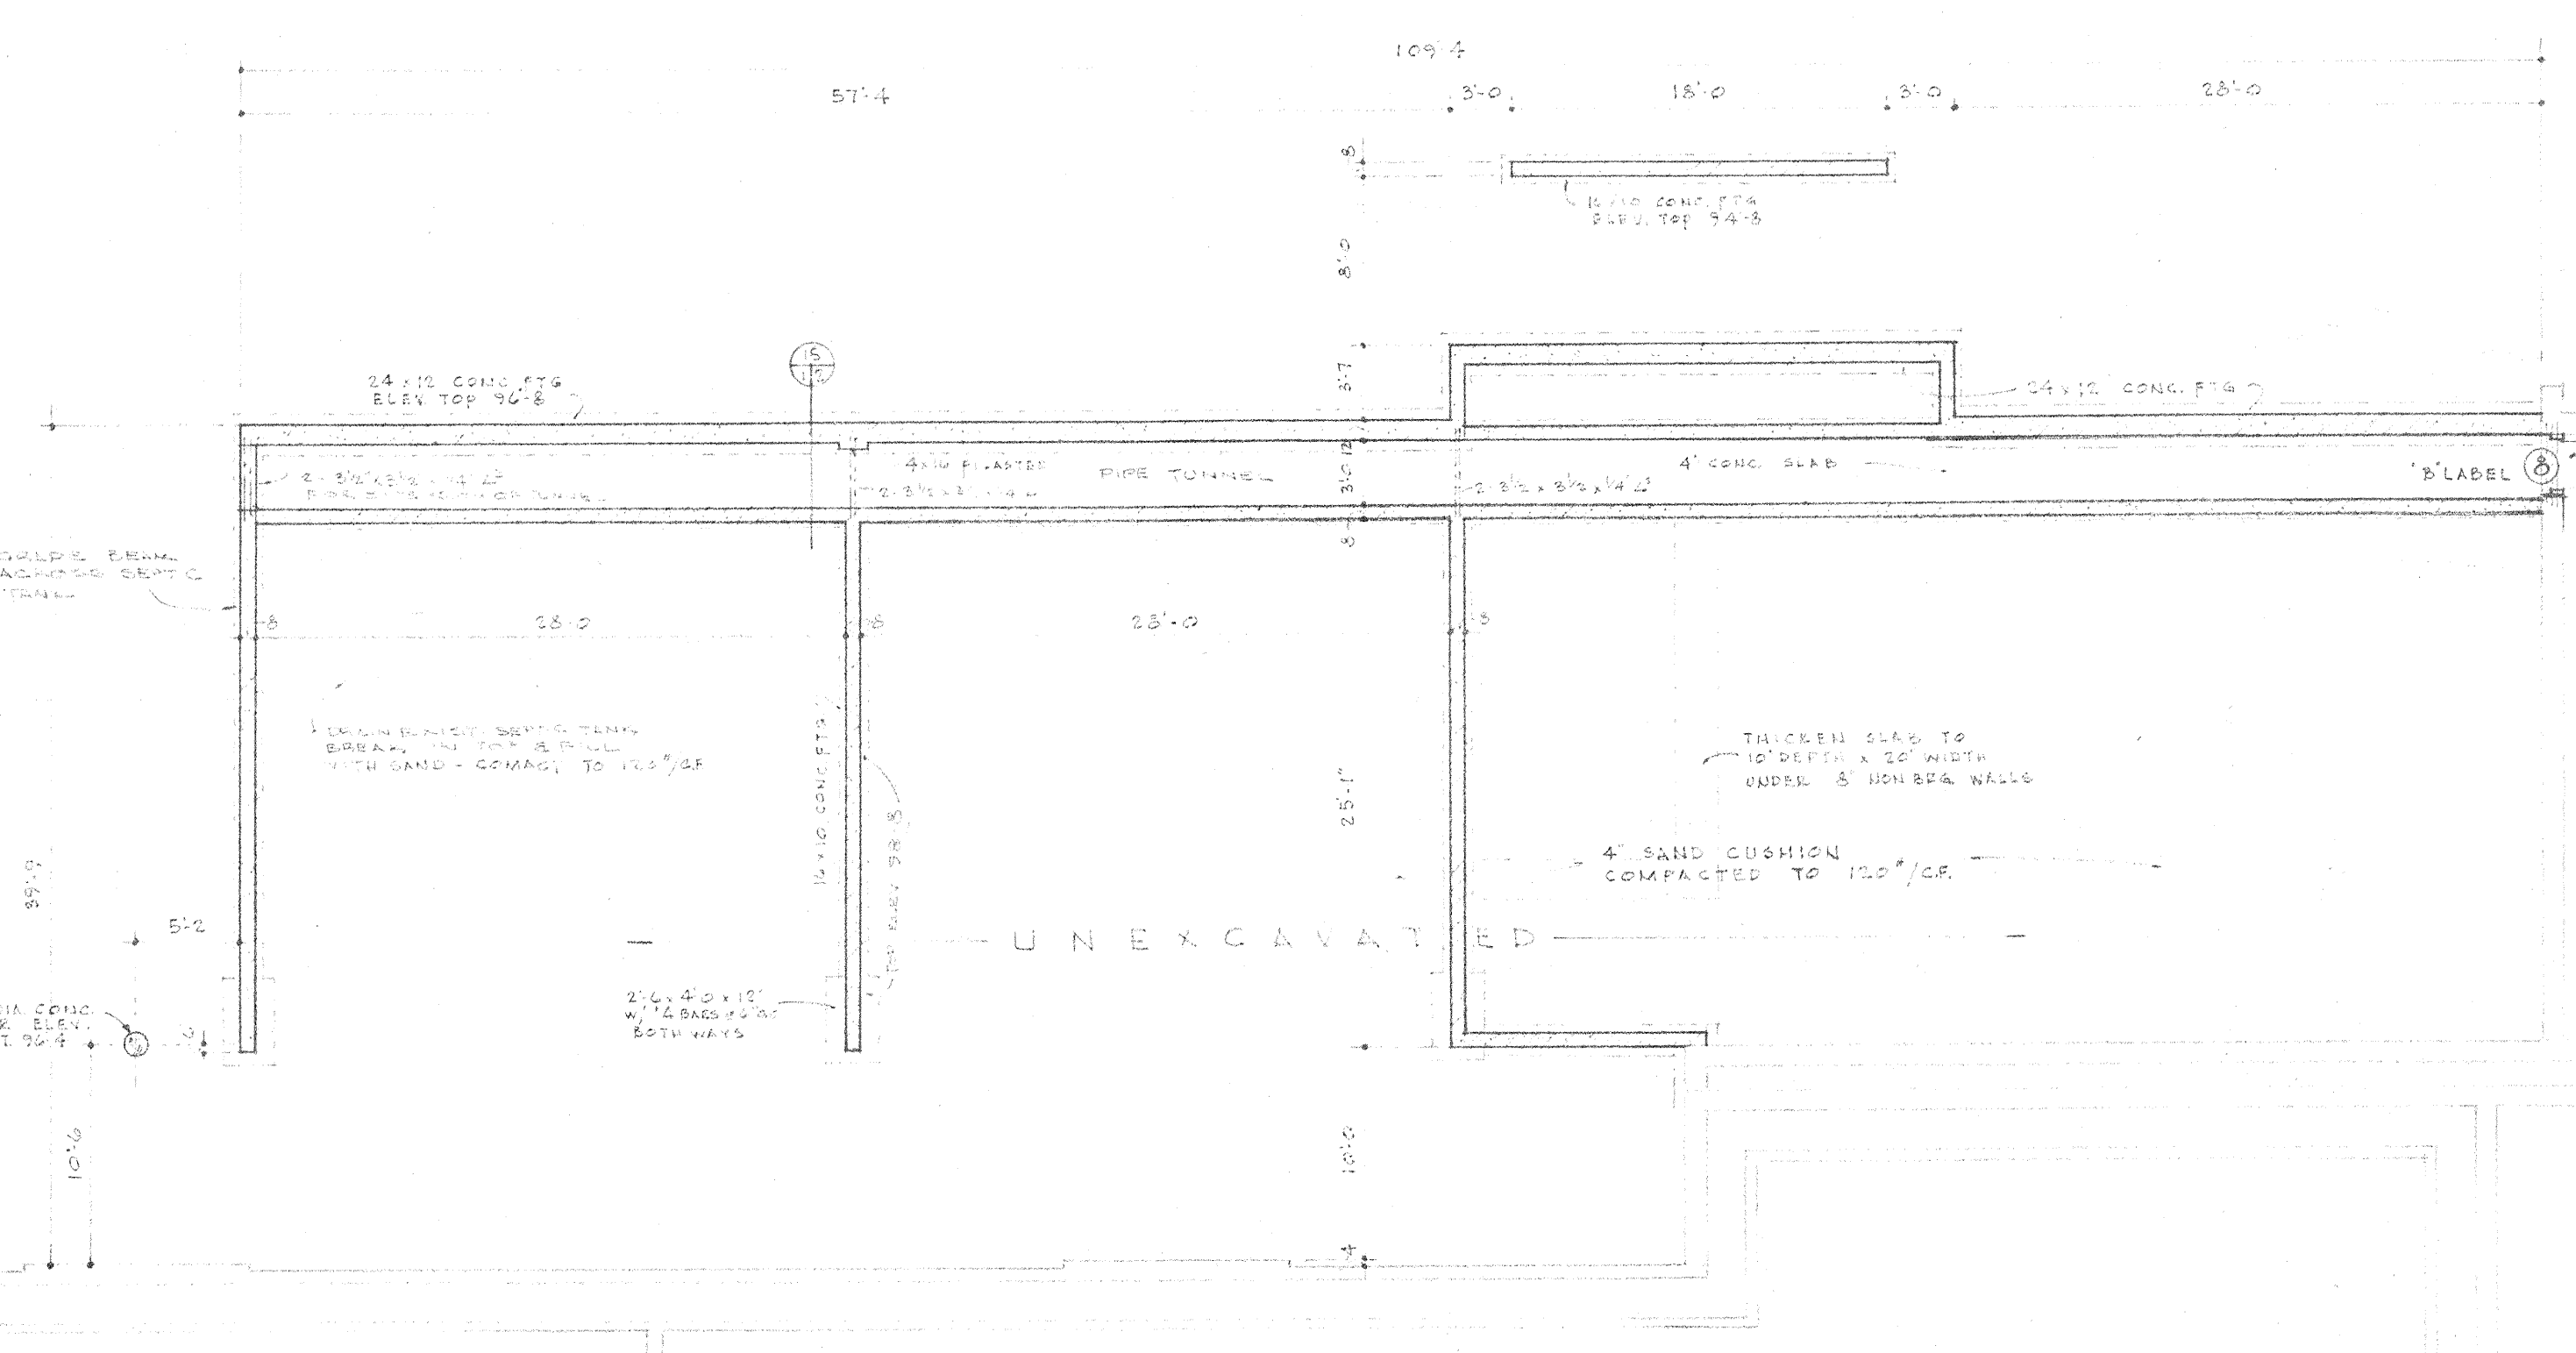

FOUNDATION PLAN 1/8" = 1'-0"

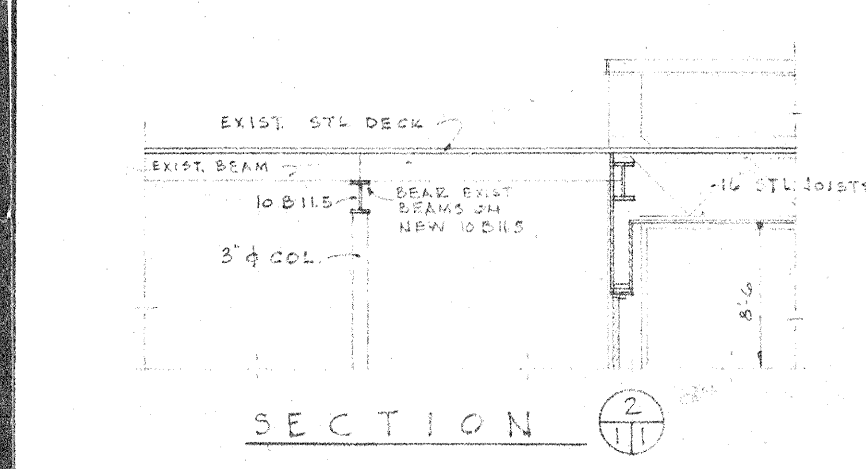

SECTION 1/8" = 1'-0"

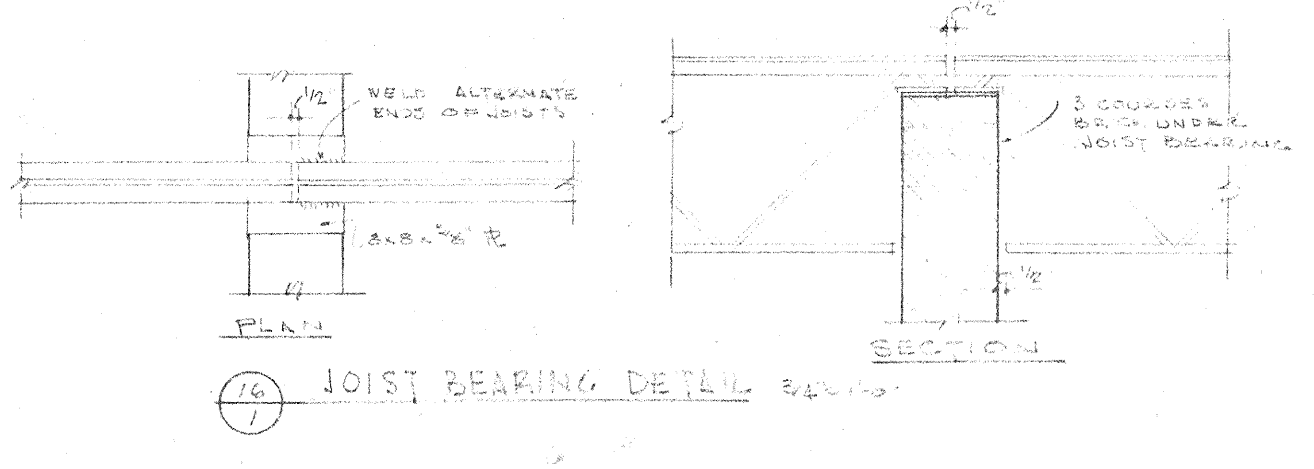


JOIST BEARING DETAIL 1/8" = 1'-0"

G.E. DIEKEMA, AIA
architect


211 WOODWARD AVENUE • KALAMAZOO, MICHIGAN

DRAWN BY JST	PROJECT PROPOSED ADDITION TO OSHTEMO ELEMENTARY SCHOOL	JOB NO. 6216	SHEET NO. 1
CHECKED BY JST	DATE 1-21-65		

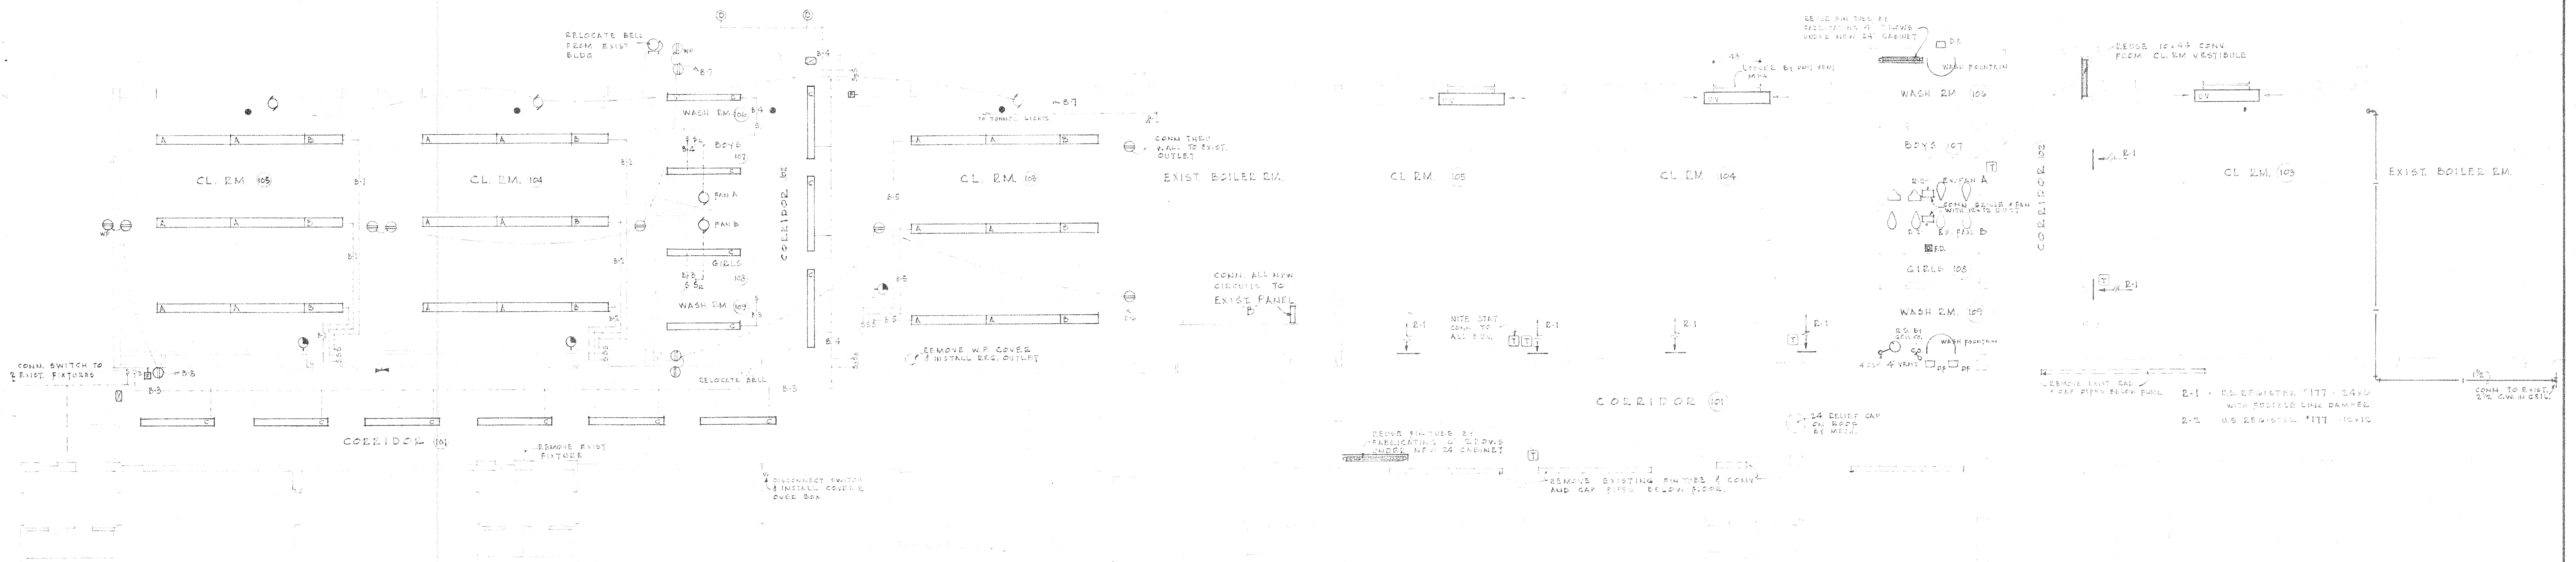


NOTE: EXTEND EXIST. FIRE ALARM SYSTEM TO NEW EQUIP. SHOWN
CONNECT NEW EXIT LIGHTS TO EXISTING EXIT LIGHT CIRCUIT.

ELECTRICAL FLOOR PLAN 1/8"=1'-0"

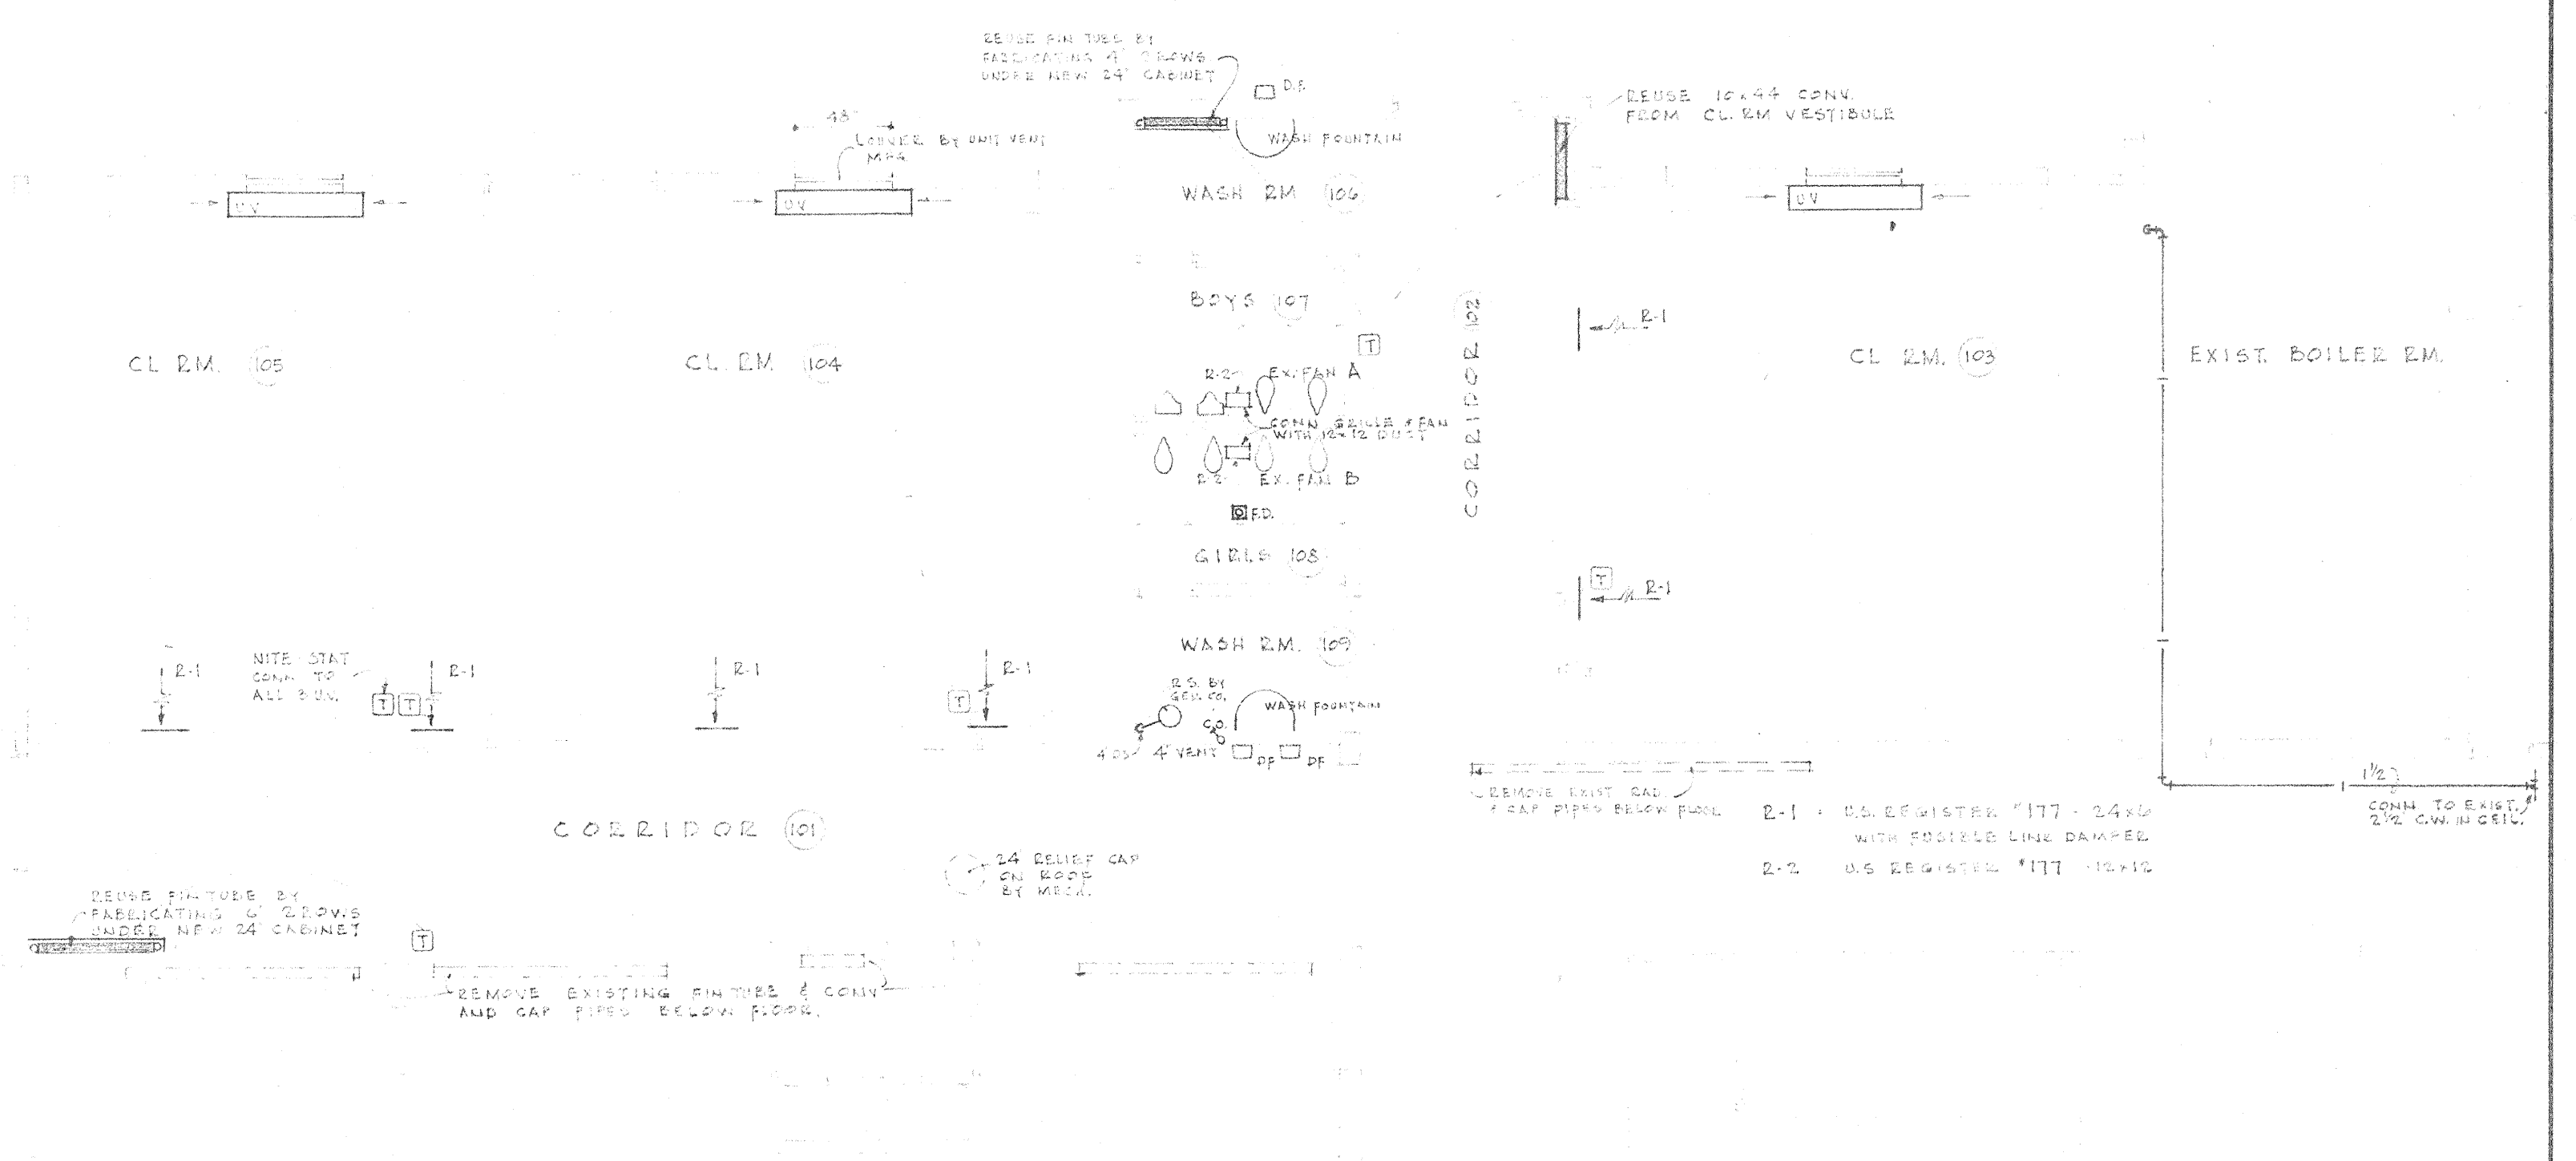

MECHANICAL FLOOR PLAN 1/8"=1'-0"

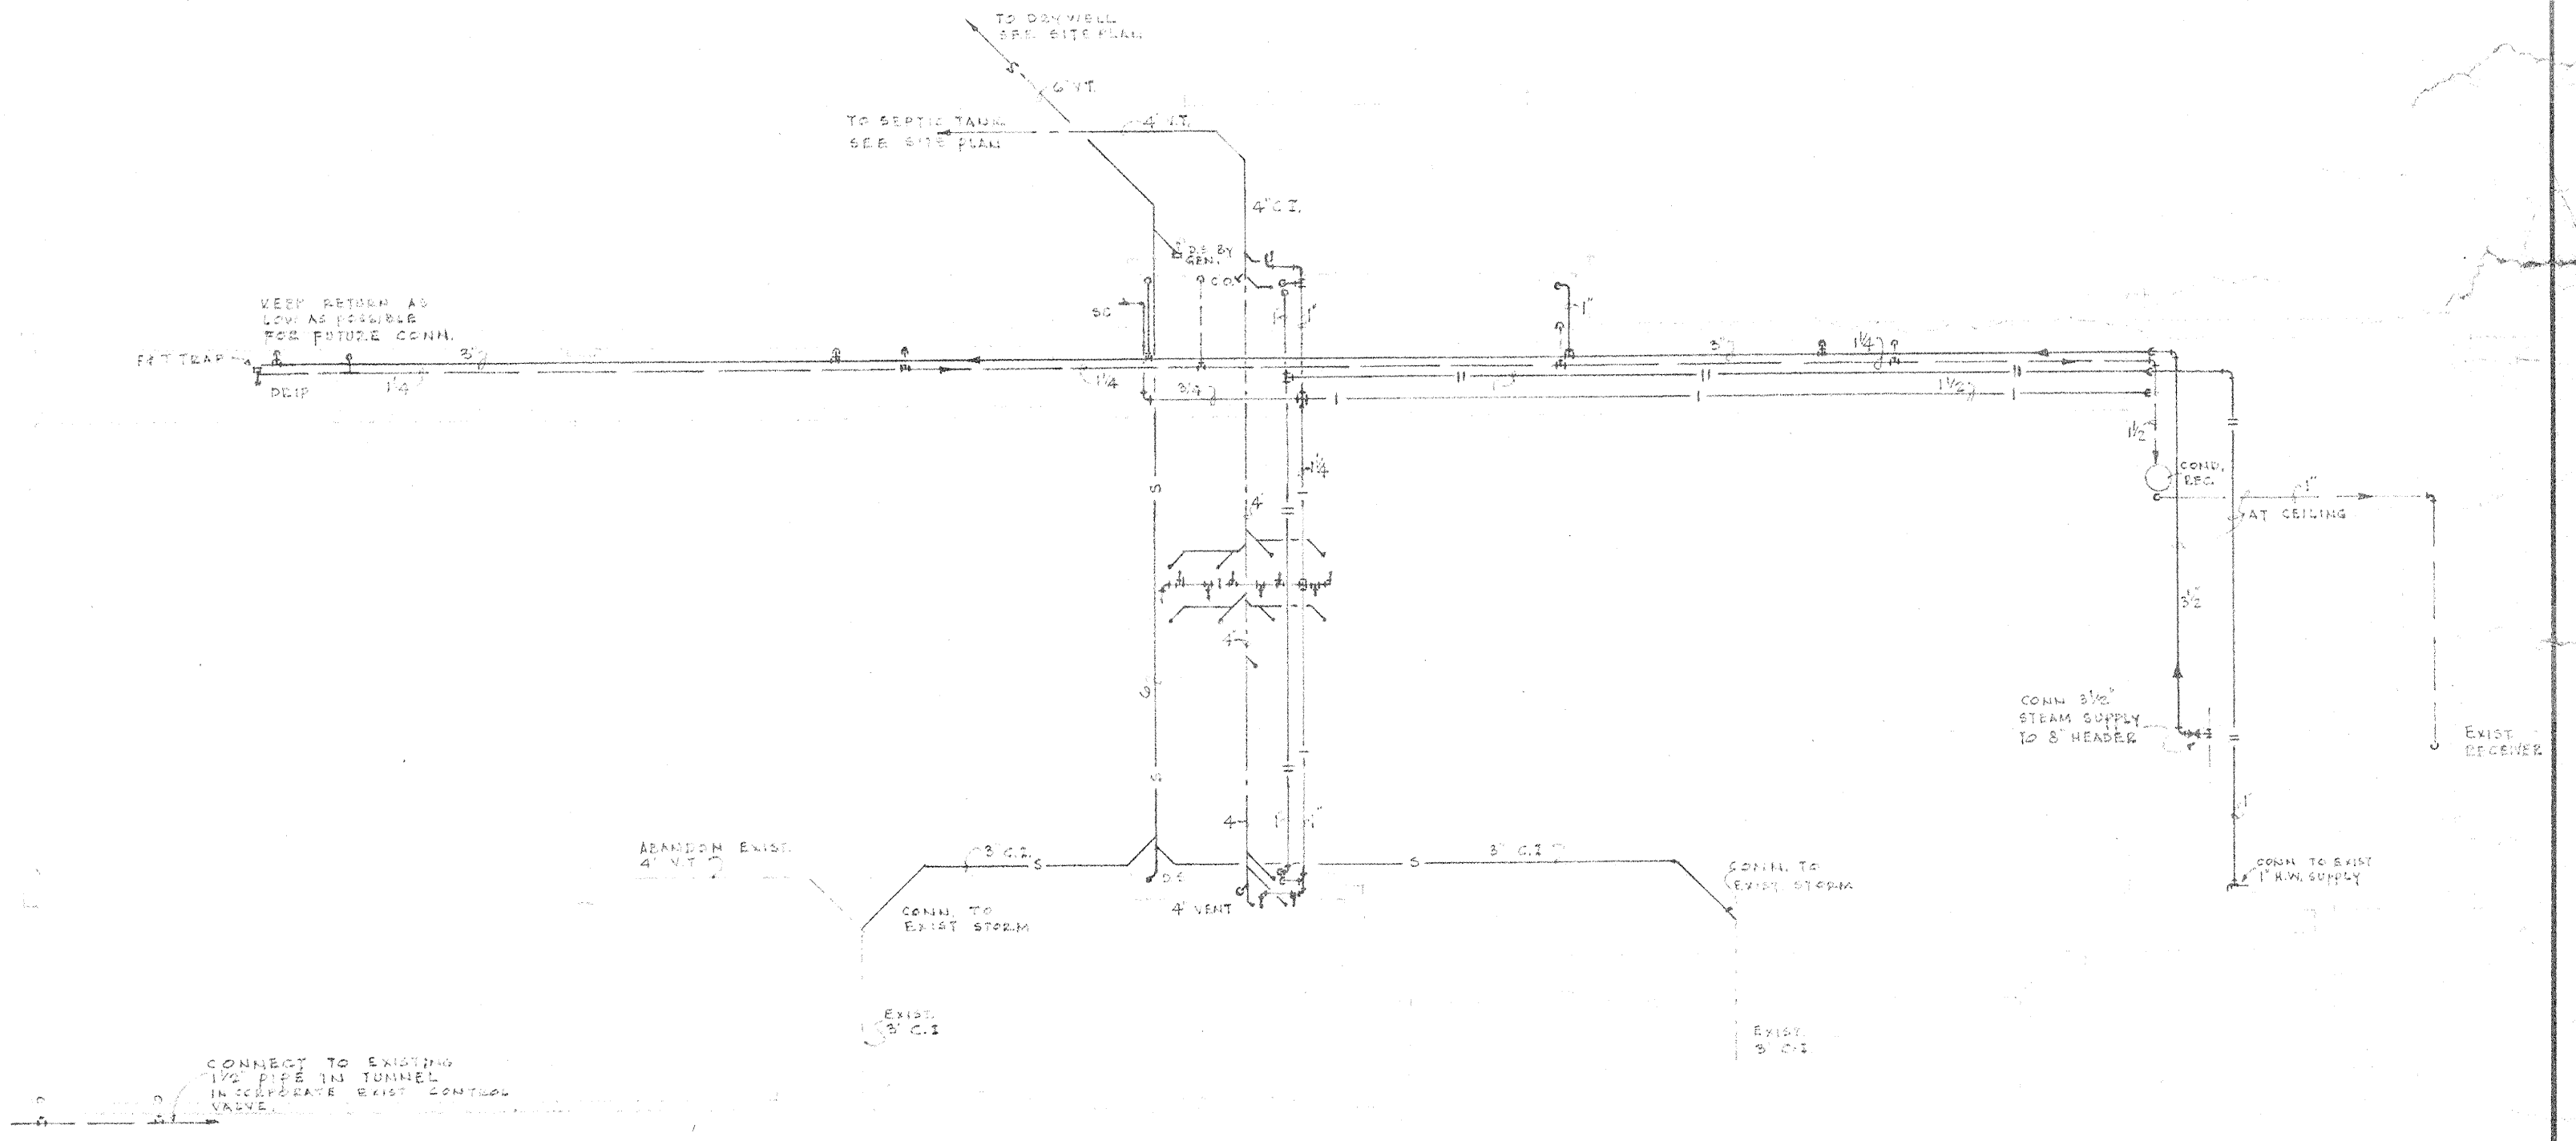

MECHANICAL FOUNDATION PLAN 1/8"=1'-0"

ELECTRICAL SYMBOLS				MECHANICAL SYMBOLS			
	PANEL & CIRCUIT NO.		SWITCH		DOM. COLD WATER		STEAM SUPPLY
	SWITCH LINE		3-WAY SWITCH		DOM. HOT WATER		STEAM RETURN
	CIRCUIT LINE		KEY SWITCH		STORM SEWER		RADIATION
	110 DUPLEX OUTLET		CLOCK		SANITARY SEWER		ROOF SUMP
	FLUORESCENT FIXTURE		MOTOR		CLEAN OUT		THERMOSTAT
	INCANDESCENT FIXTURE		TUNNEL LIGHT - PORCELAIN SOCKET 75W.		BILL COOK		
	FIRE STATION		SWITCH WITH PILOT LIGHT		FLOOR DRAIN		

G.E. DIEKEMA, AIA
architect
211 WOODWARD AVENUE • KALAMAZOO, MICHIGAN

DRAWN BY JED	PROJECT PROPOSED ADDITION TO OSHTemo ELEMENTARY SCHOOL	JOB NO. 10210	SHEET NO. 3
CHECKED BY JED	DATE 1-21-65		